
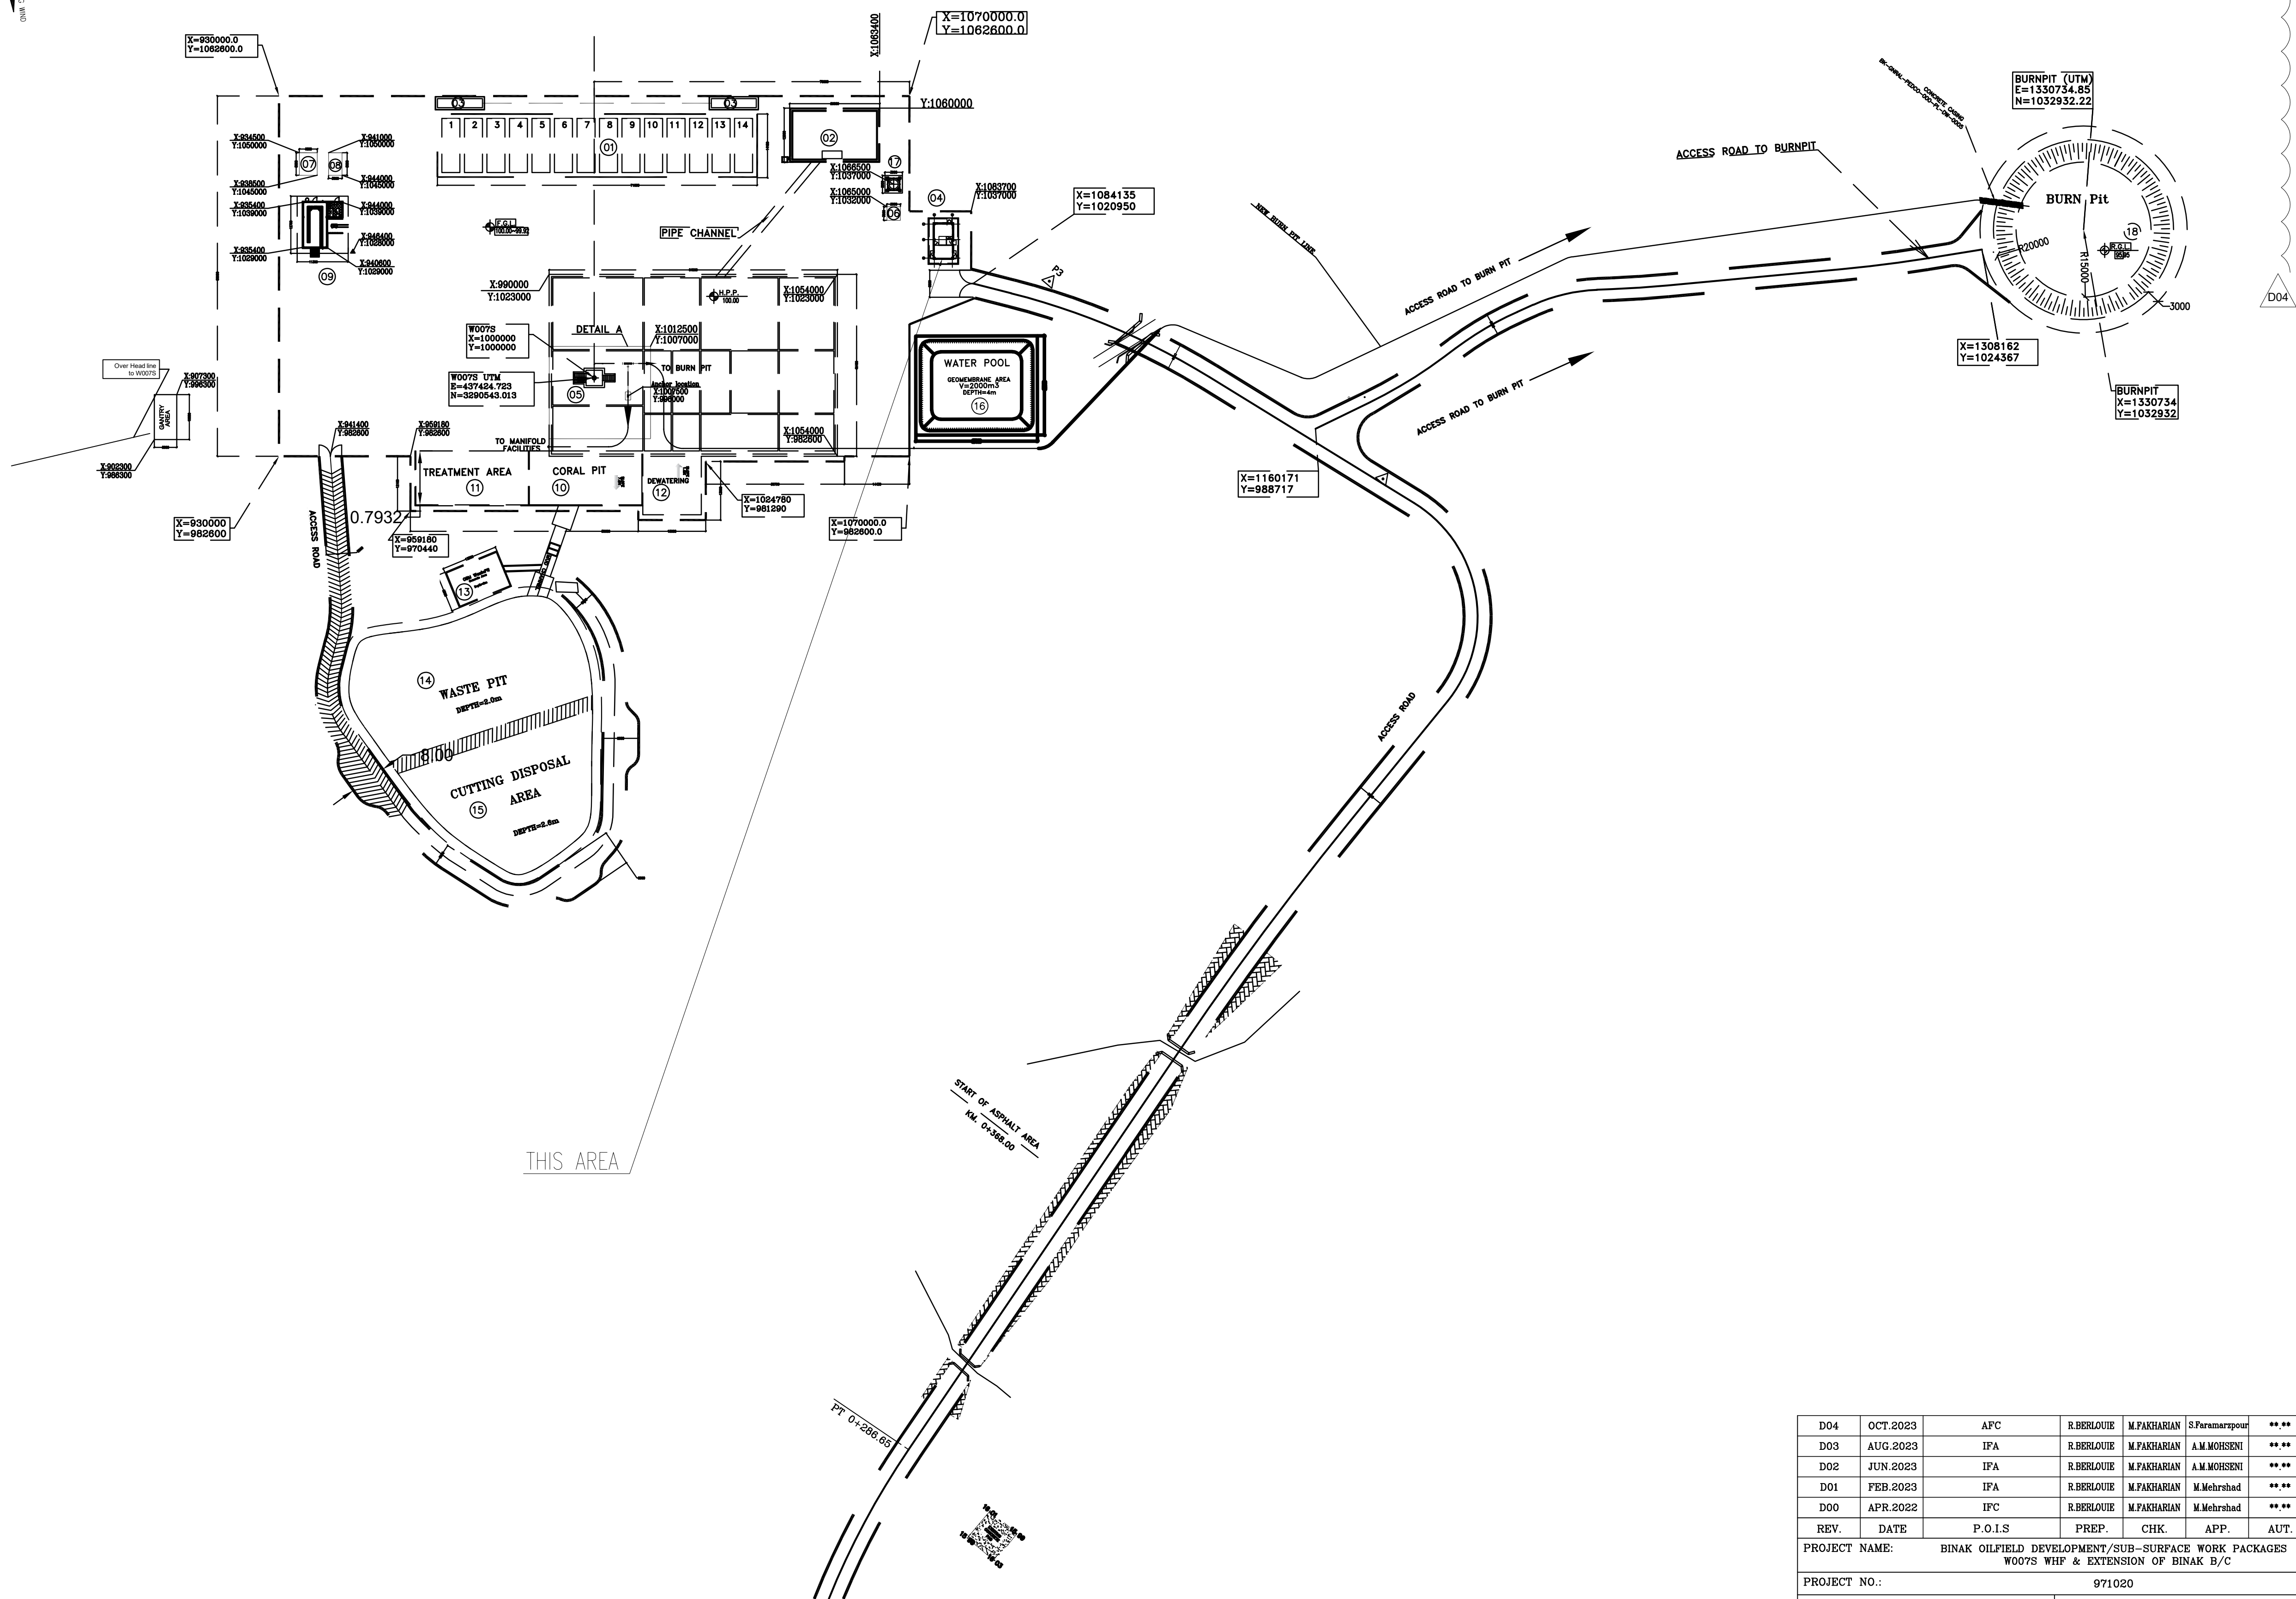


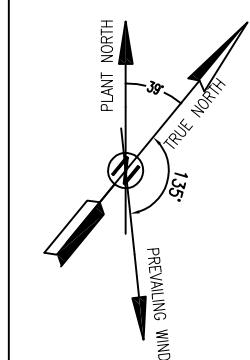

1 LOCATION PLAN
N.T.S

NOTES

- 1- DIMENSIONS ARE IN "mm" AND ELEVATIONS IN "m" UNLESS SPECIFIED .
- 2- ALL DIMENSIONS AND ELEVATIONS SHALL BE CHECKED BY THE CONTRACTOR PRIOR TO CONSTRUCTION.
- 3- CONTRACTOR SHALL COMPARE ALL ARCHITECTURAL, MECHANICAL, ELECTRICAL, PIPING AND STRUCTURAL DRAWINGS AND IN CASE OF ANY CONFLICTS OR DISCREPANCY, INFORM THE ENGINEER.
- 4- SLAB ON GRADE SHALL BE CONSTRUCTED AFTER EXECUTION OF CABLE TRENCH & EQUIPMENTS FOUNDATION.
- 5- ALL MATERIALS ARE SELECTED FROM THE HIGHEST QUALITY AND SHALL BE APPROVED BY THE CLIENT.
- 6- FOR COORDINATE REFER TO FINISH GRADING DOCUMENTS.
- 7) REFERENCE COORDINATES E=1000.000 , N=1000.000 REFER TO X=437425 , Y=3290543 UTM.
- 8) FINISH GRADING LEVEL (W007S) ELEVATION : +26.00 (MEAN SEA LEVEL)
+26.05 m (GLOBAL) = ±0.00 (LOCAL)
- 9) ALL EXTERNAL OPENINGS (WINDOWS AND DOORS) SHALL BE FIRE PROOF.
- 10) DOUBLE GLAZED WINDOW WITH 24mm REINFORCED GLASS AND 6mm GAS FILLED GAP.
- 11) WC DOORS SHALL BE WATERPROOF ABS TYPE WITH CLOSER MECHANISM.
- 12) KNAUF GYPSUM BOARD TILES (60*60) cm (REGULAR 9.5 mm THICKNESS) WITH (1063).
- 13) KNAUF PVC-COATED GYPSUM BOARD TILES (60*60)-(REGULAR 9.5mm THICKNESS) WITH (1063)-(PVC THICKNESS 0.35mm).

LEGEND


- | | | | |
|--|---|--|---------------|
| | BRICK WALL | | BRICK FACING |
| | ANTI-ACID CERAMIC | | CEMENT SAND |
| | TOVENAN COURSE | | BLOCKAGE |
| | POLYETHYLENE SHEET | | LEAN CONCRETE |
| | REINFORCED CONCRETE
ACCORDING TO STR.DWG | | TERRAZZO TILE |
| | CHEQUERED PLATE TRENCH CAP | | |
| | HOT DEEP GALVANIZED SHEET | | |
| | SOFT SAND | | |

- | | | | |
|----------|------------------------|--------|-------------------|
| F.F.L. | FINISHED FLOOR | T.O.B. | TOP OF BEAM |
| T.O.W.A. | TOP OF WALKWAY | B.O.C. | BOTTOM OF CAGE |
| T.O.P. | TOP OF PARAPET | T.O.S. | TOP OF SLAB |
| T.O.C. | TOP OF CAGE | B.O.S. | BOTTOM OF SLEEVE |
| T.O.D. | TOP OF DOOR | T.O.F. | TOP OF FOUNDATION |
| F.G.L. | FINISHED GRADING LEVEL | | |



REFERENCE DRAWING

REFERENCE DRAWING	DRG. No.
STANDARD DRAWING FOR ARCHITECTURAL DETAILS	BK-GNRL-PEDCO-000-AR-DW-0001
STANDARD DETAILS FOR LADDER & SAFETY CAGE	BK-GNRL-PEDCO-000-ST-DW-0009
PLOT PLAN DRAWING - W007S	BK-W007S-PEDCO-110-PI-PY-0002
FOUNDATION DRAWING FOR SECURITY BUILDING FOR WELL PADS - W007S	BK-W007S-PEDCO-110-ST-DW-0008
STRUCTURAL DRAWING FOR SECURITY BUILDING FOR WELL PADS - W007S	BK-W007S-PEDCO-110-ST-DW-0009
HVAC SYSTEM LAYOUT FOR SECURITY BUILDING - W007S	BK-W007S-PEDCO-110-HV-PY-0003
PLUMBING & SEWAGE PIPING LAYOUT FOR SECURITY BUILDING - W007S	BK-W007S-PEDCO-110-HV-PY-0004
LIGHTING & SMALL POWER LAYOUT FOR SECURITY BUILDING OF WELL PADS	BK-SIGRL-PEDCO-110-EL-PY-0005


KEY PLAN

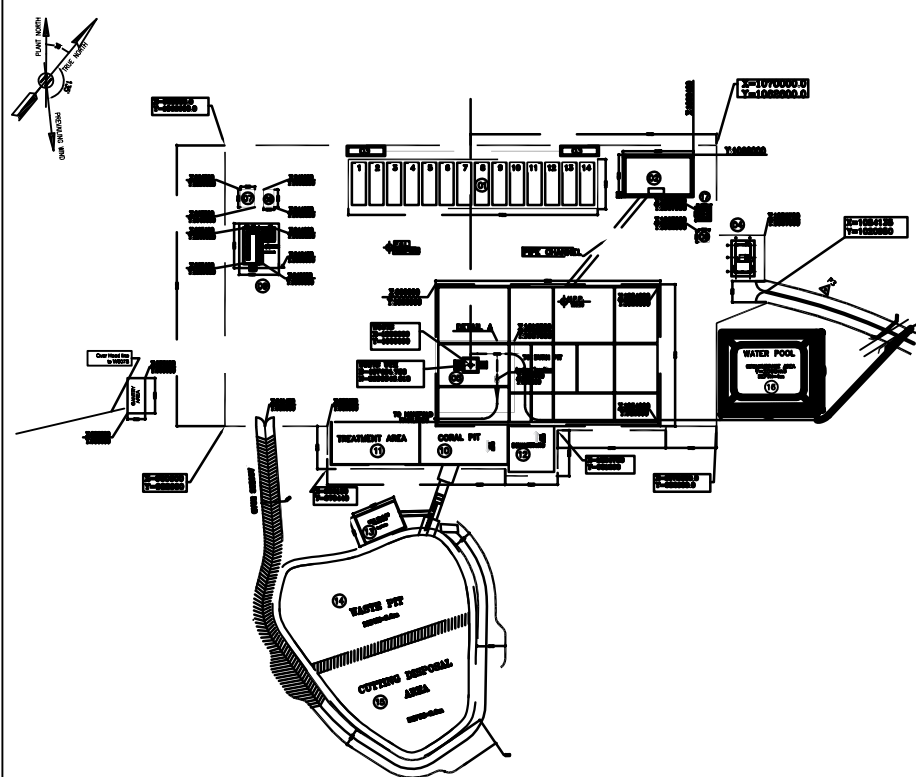


D04	OCT.2023	APC	R.BERLOUIE	M.PAKHARIAN	S.Paramaripour	** **																						
D03	AUG.2023	IFA	R.BERLOUIE	M.PAKHARIAN	A.M.MOHSSENI	** **																						
D02	JUN.2023	IFA	R.BERLOUIE	M.PAKHARIAN	A.M.MOHSSENI	** **	***	*****	** **	*** **	** **	*** **	*** **	*** **	*** **													
D01	FEB.2023	IFA	R.BERLOUIE	M.PAKHARIAN	M.Mehrshad	** **																						
D00	APR.2022	IPC	R.BERLOUIE	M.PAKHARIAN	M.Mehrshad	** **																						
REV.	DATE	P.O.I.S	PREP.	CHK.	APP.	AUT.	REV.	DESCRIPTION	BY	DATE	BY	DATE	REV.	APPR.														
PROJECT NAME:							THE ORIGINAL AND ALL COPIES OF THIS DRAWING TOGETHER WITH THE COPYRIGHT THEREIN ARE THE SOLE PROPERTY OF N.I.S.O.C./ FIELDS																					
PROJECT NO.:							BINAK OILFIELD DEVELOPMENT/SUB-SURFACE WORK PACKAGES W007S WHF & EXTENSION OF BINAK B/C																					
EPC CONTRACTOR:							PETROIRAN DEVELOPMENT COMPANY																					
HIRGAN ENERGY - DESIGN & INSPECTION COMPANIES							NO CONSTRUCTION PERMITTED UNLESS DRAWING APPROVED																					
DRAWING TITLE:							APPROVED FOR CONSTRUCTION																					
ARCHITECTURAL DRAWING FOR SECURITY BUILDING OF WELL PADS - W007S							BY:																					
SCALE							SIZE		DRAWING NO.		SHEET NO.		REV.		BUDGET REF.		LOCATION		SIZE		CLASS		SERIAL NO.		SHEET		REVISION	
AS SHOWN							A1		BK-W007S-PEDCO-110-AR-DW-0004		01 OF 11		D04		053-073-9184		F		4		B		708045		01 OF 11		D04	

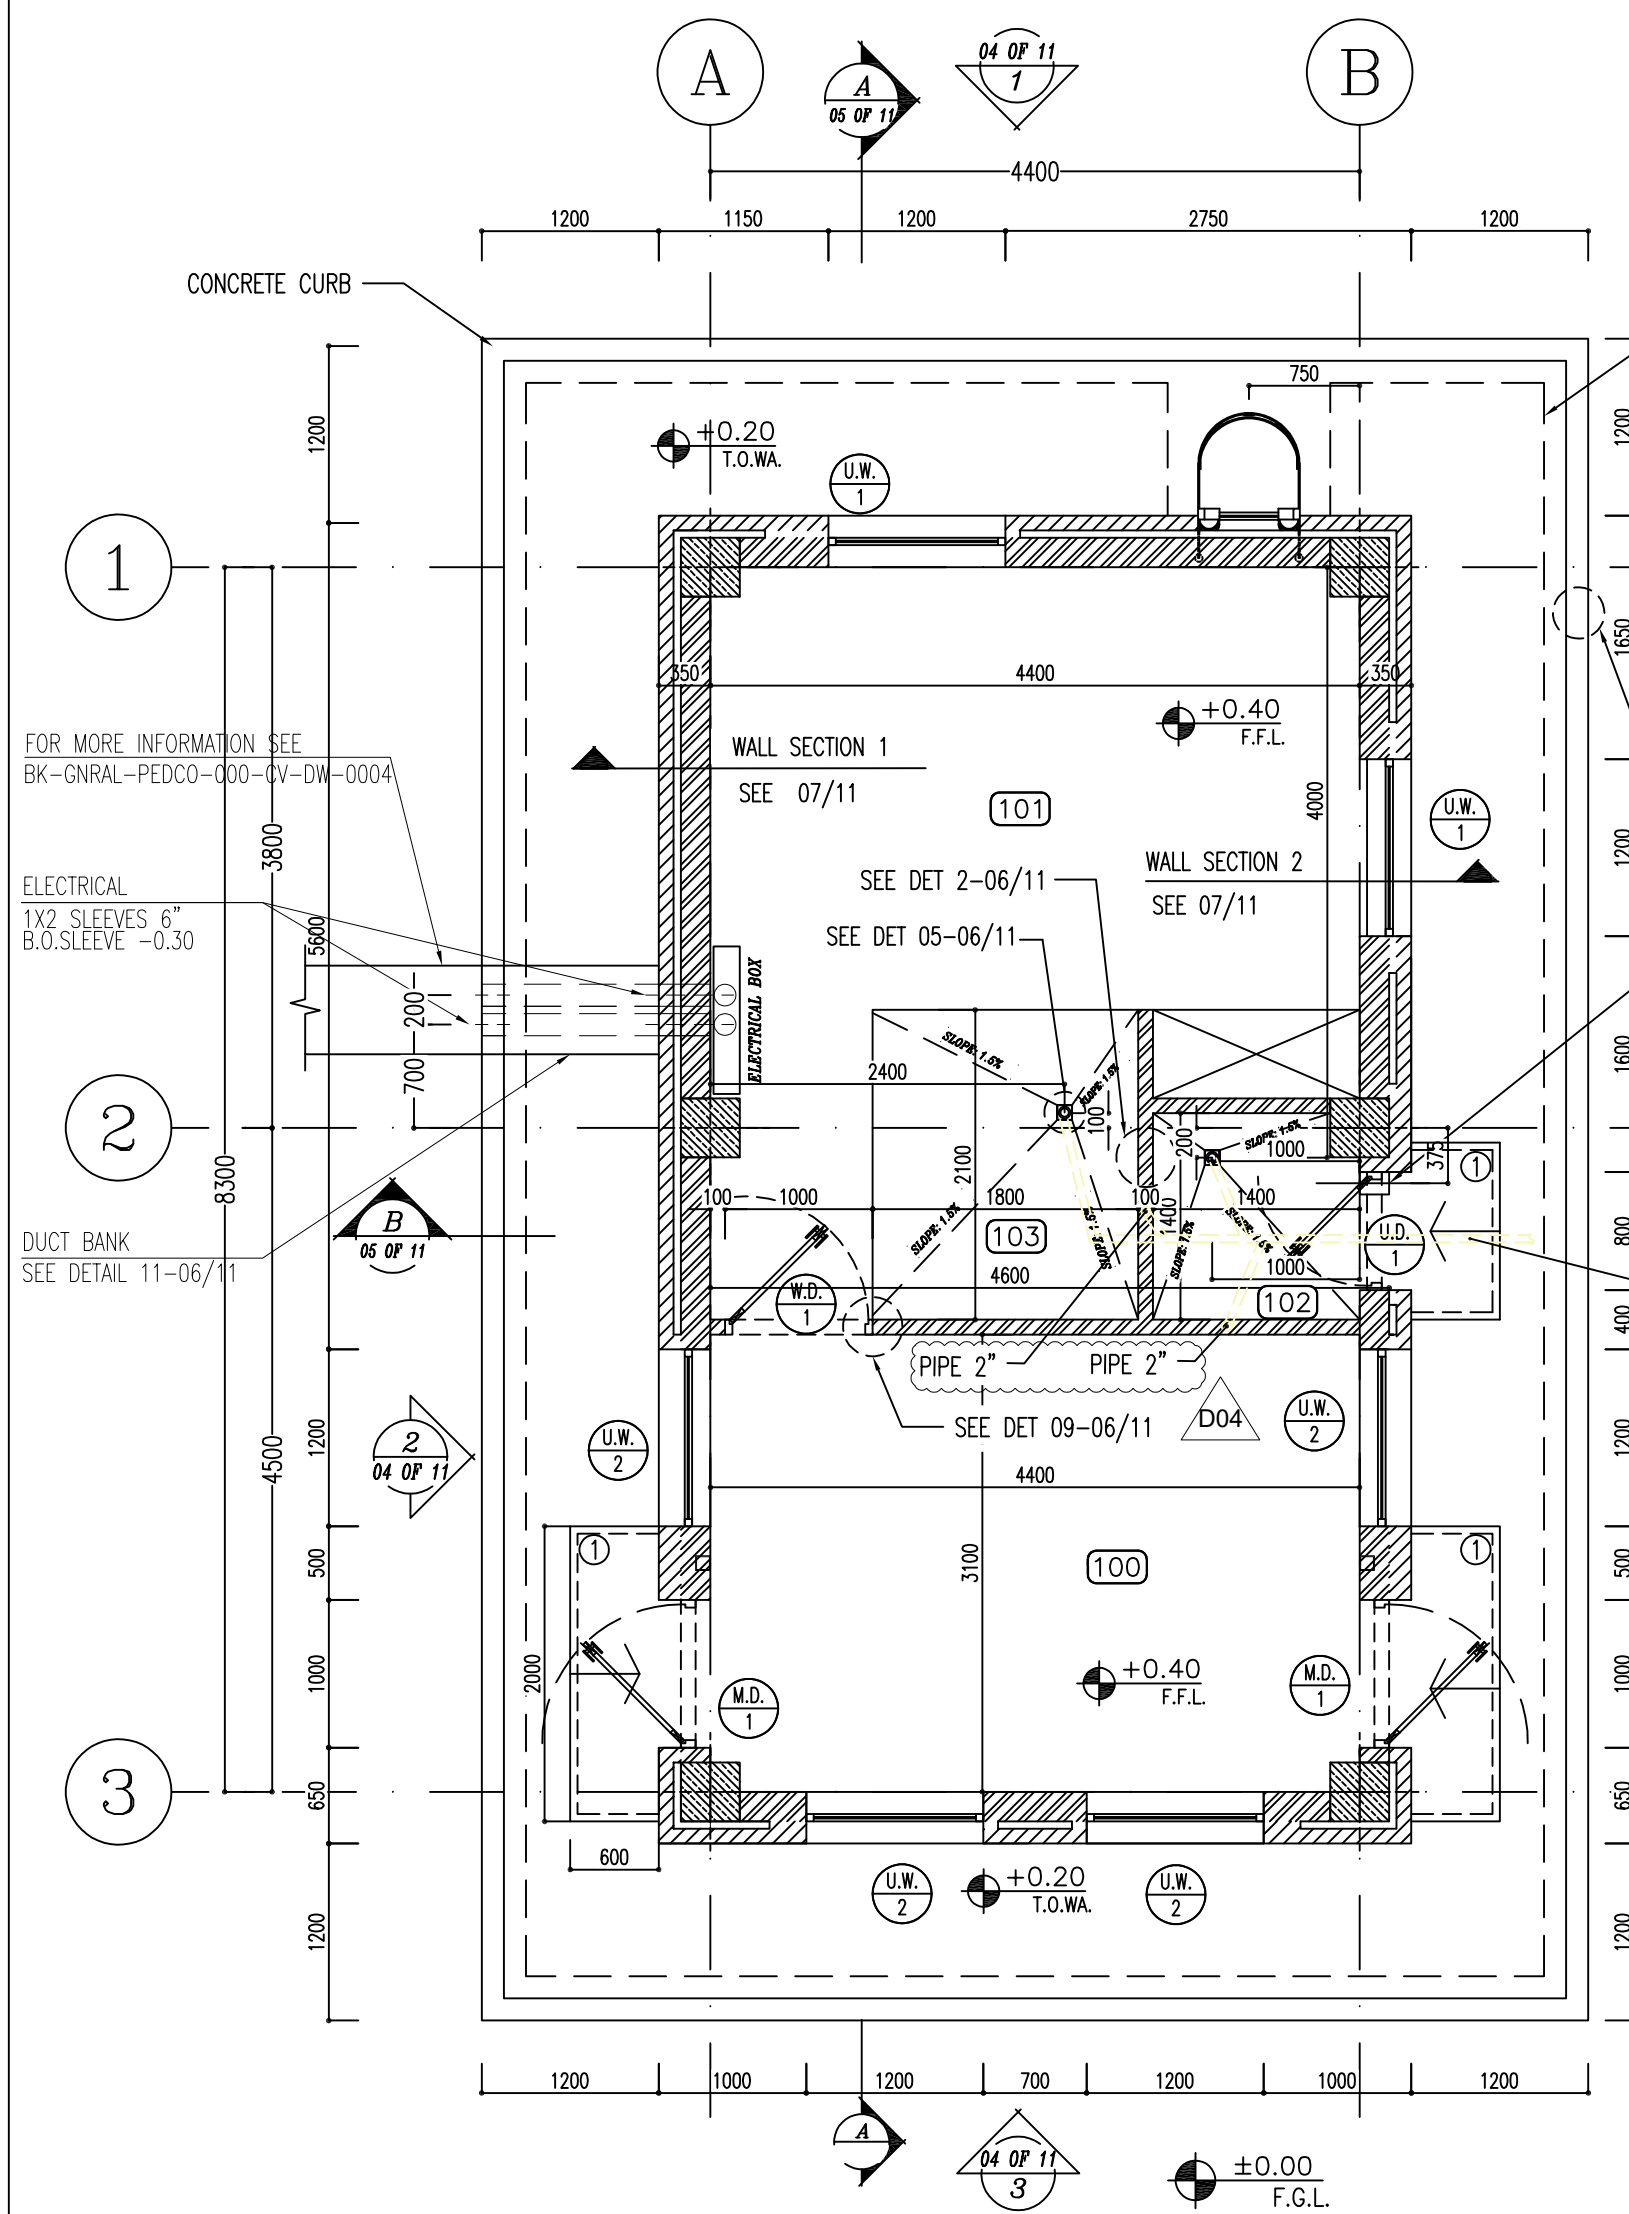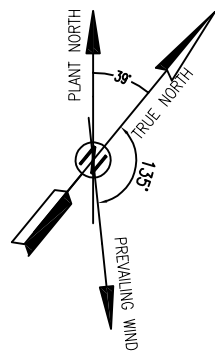

SC.1:50 2 DIMENSION PLAN

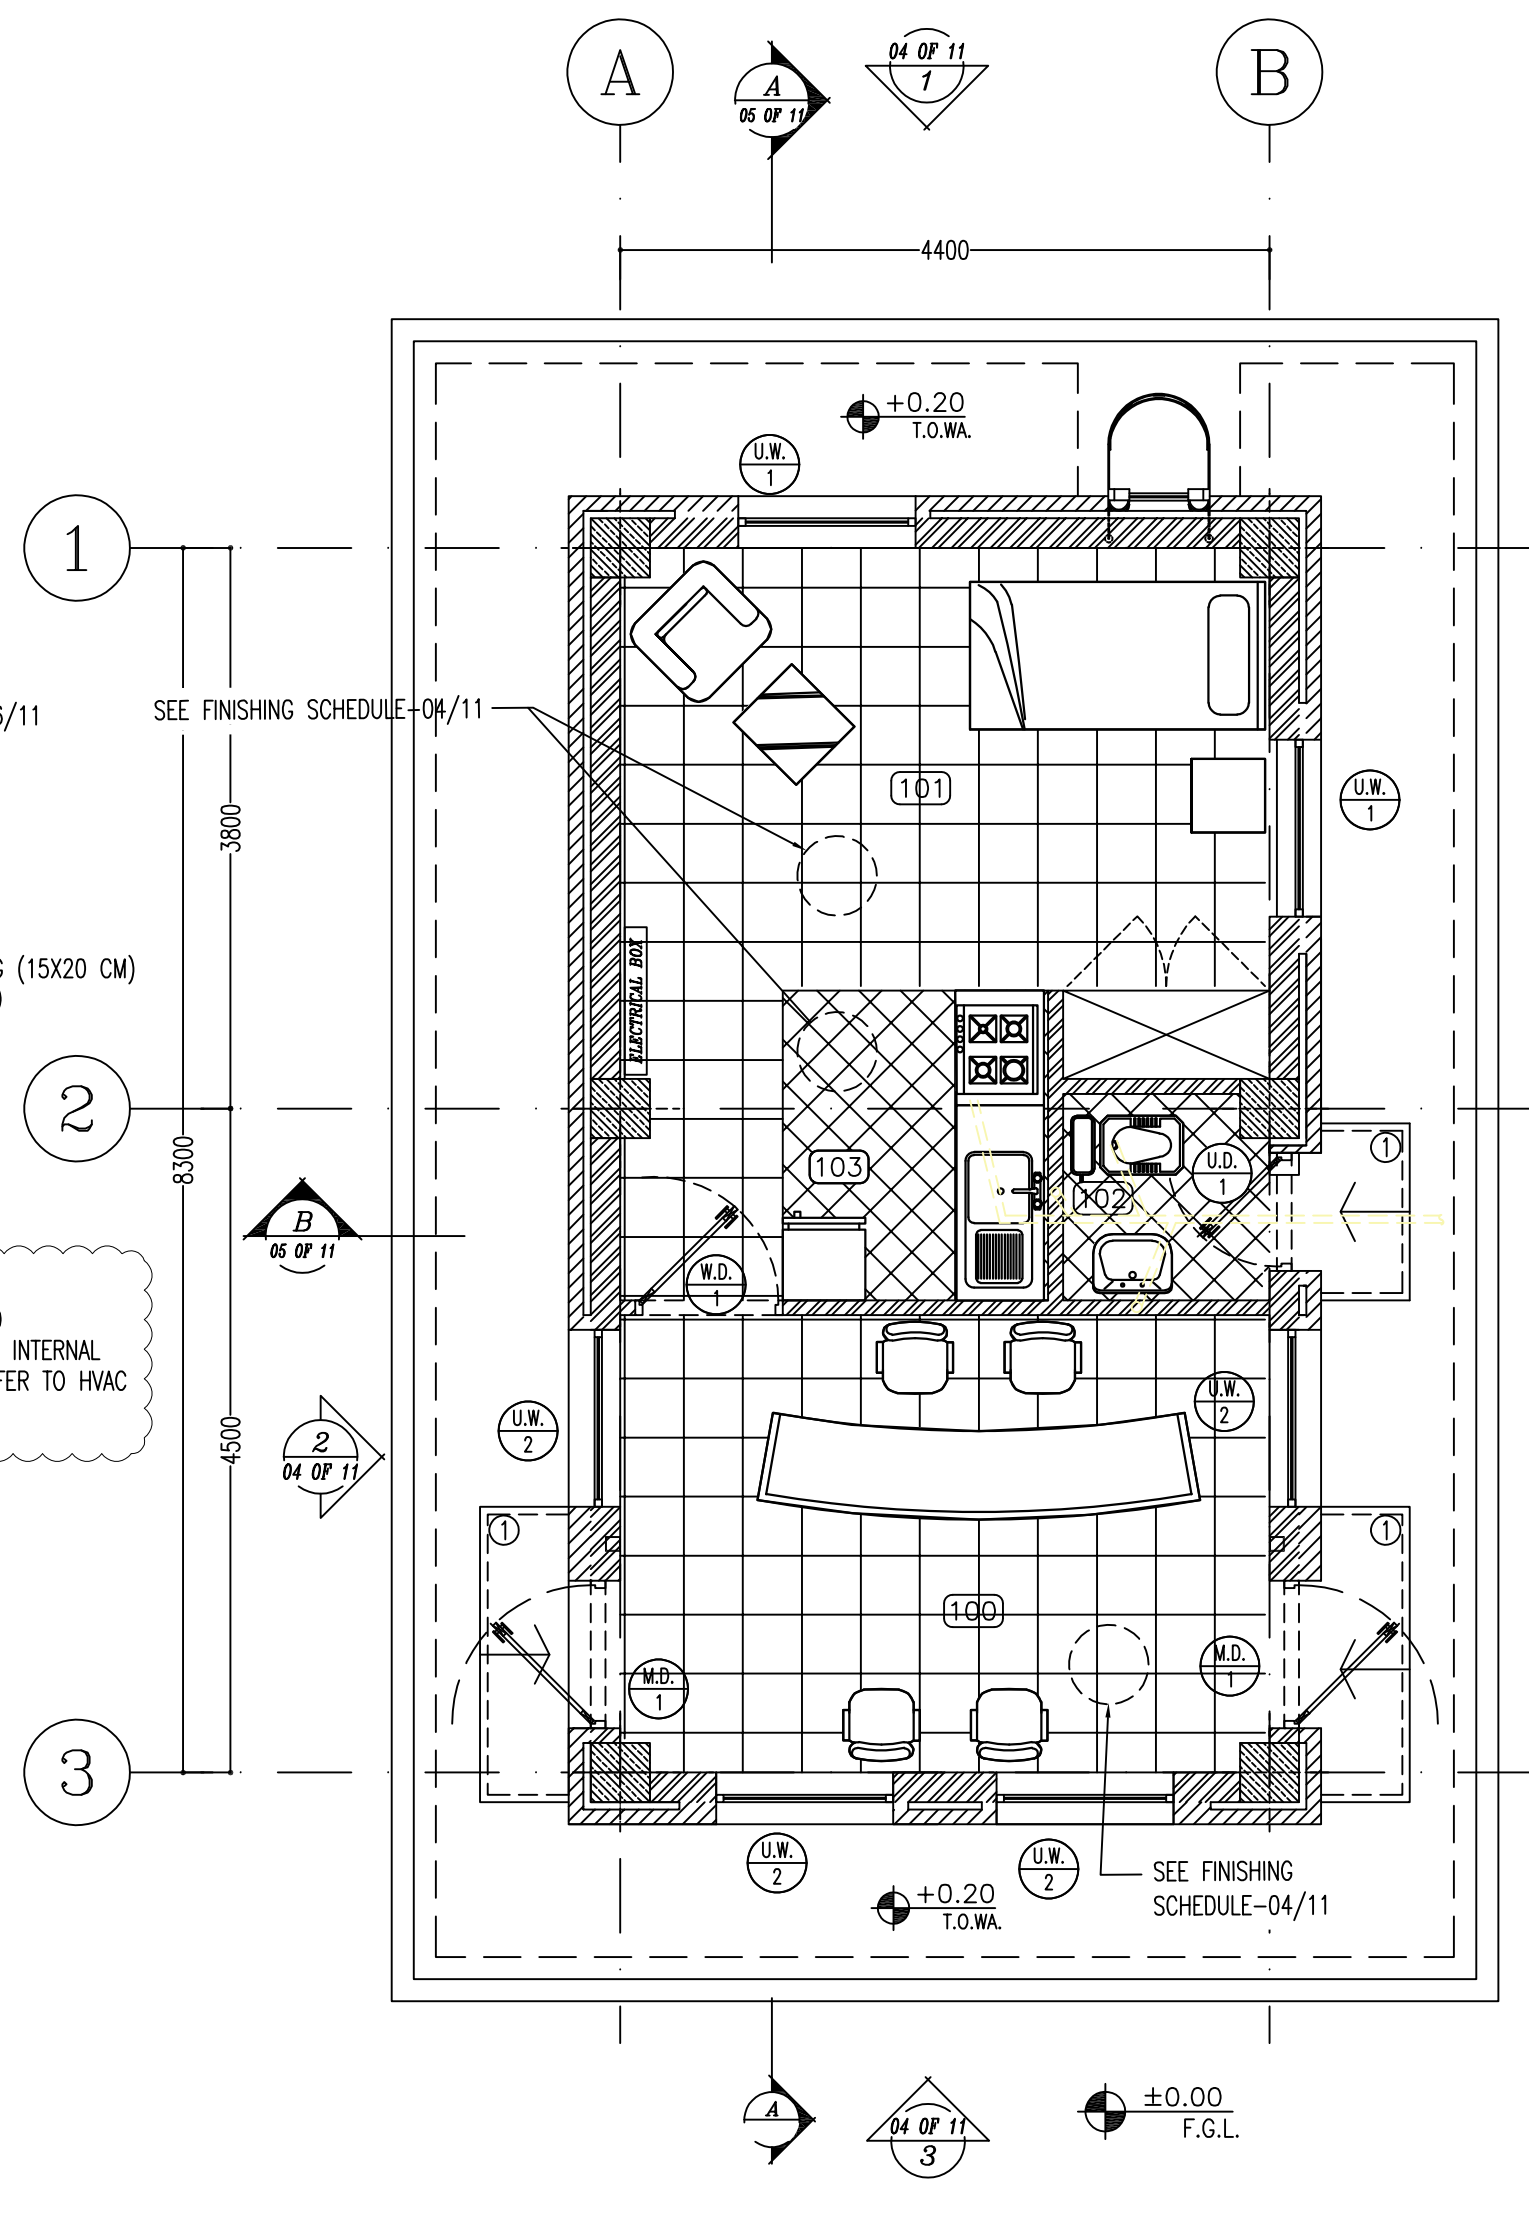

SC.1:50 3 FURNITURE & FLOORING PLAN

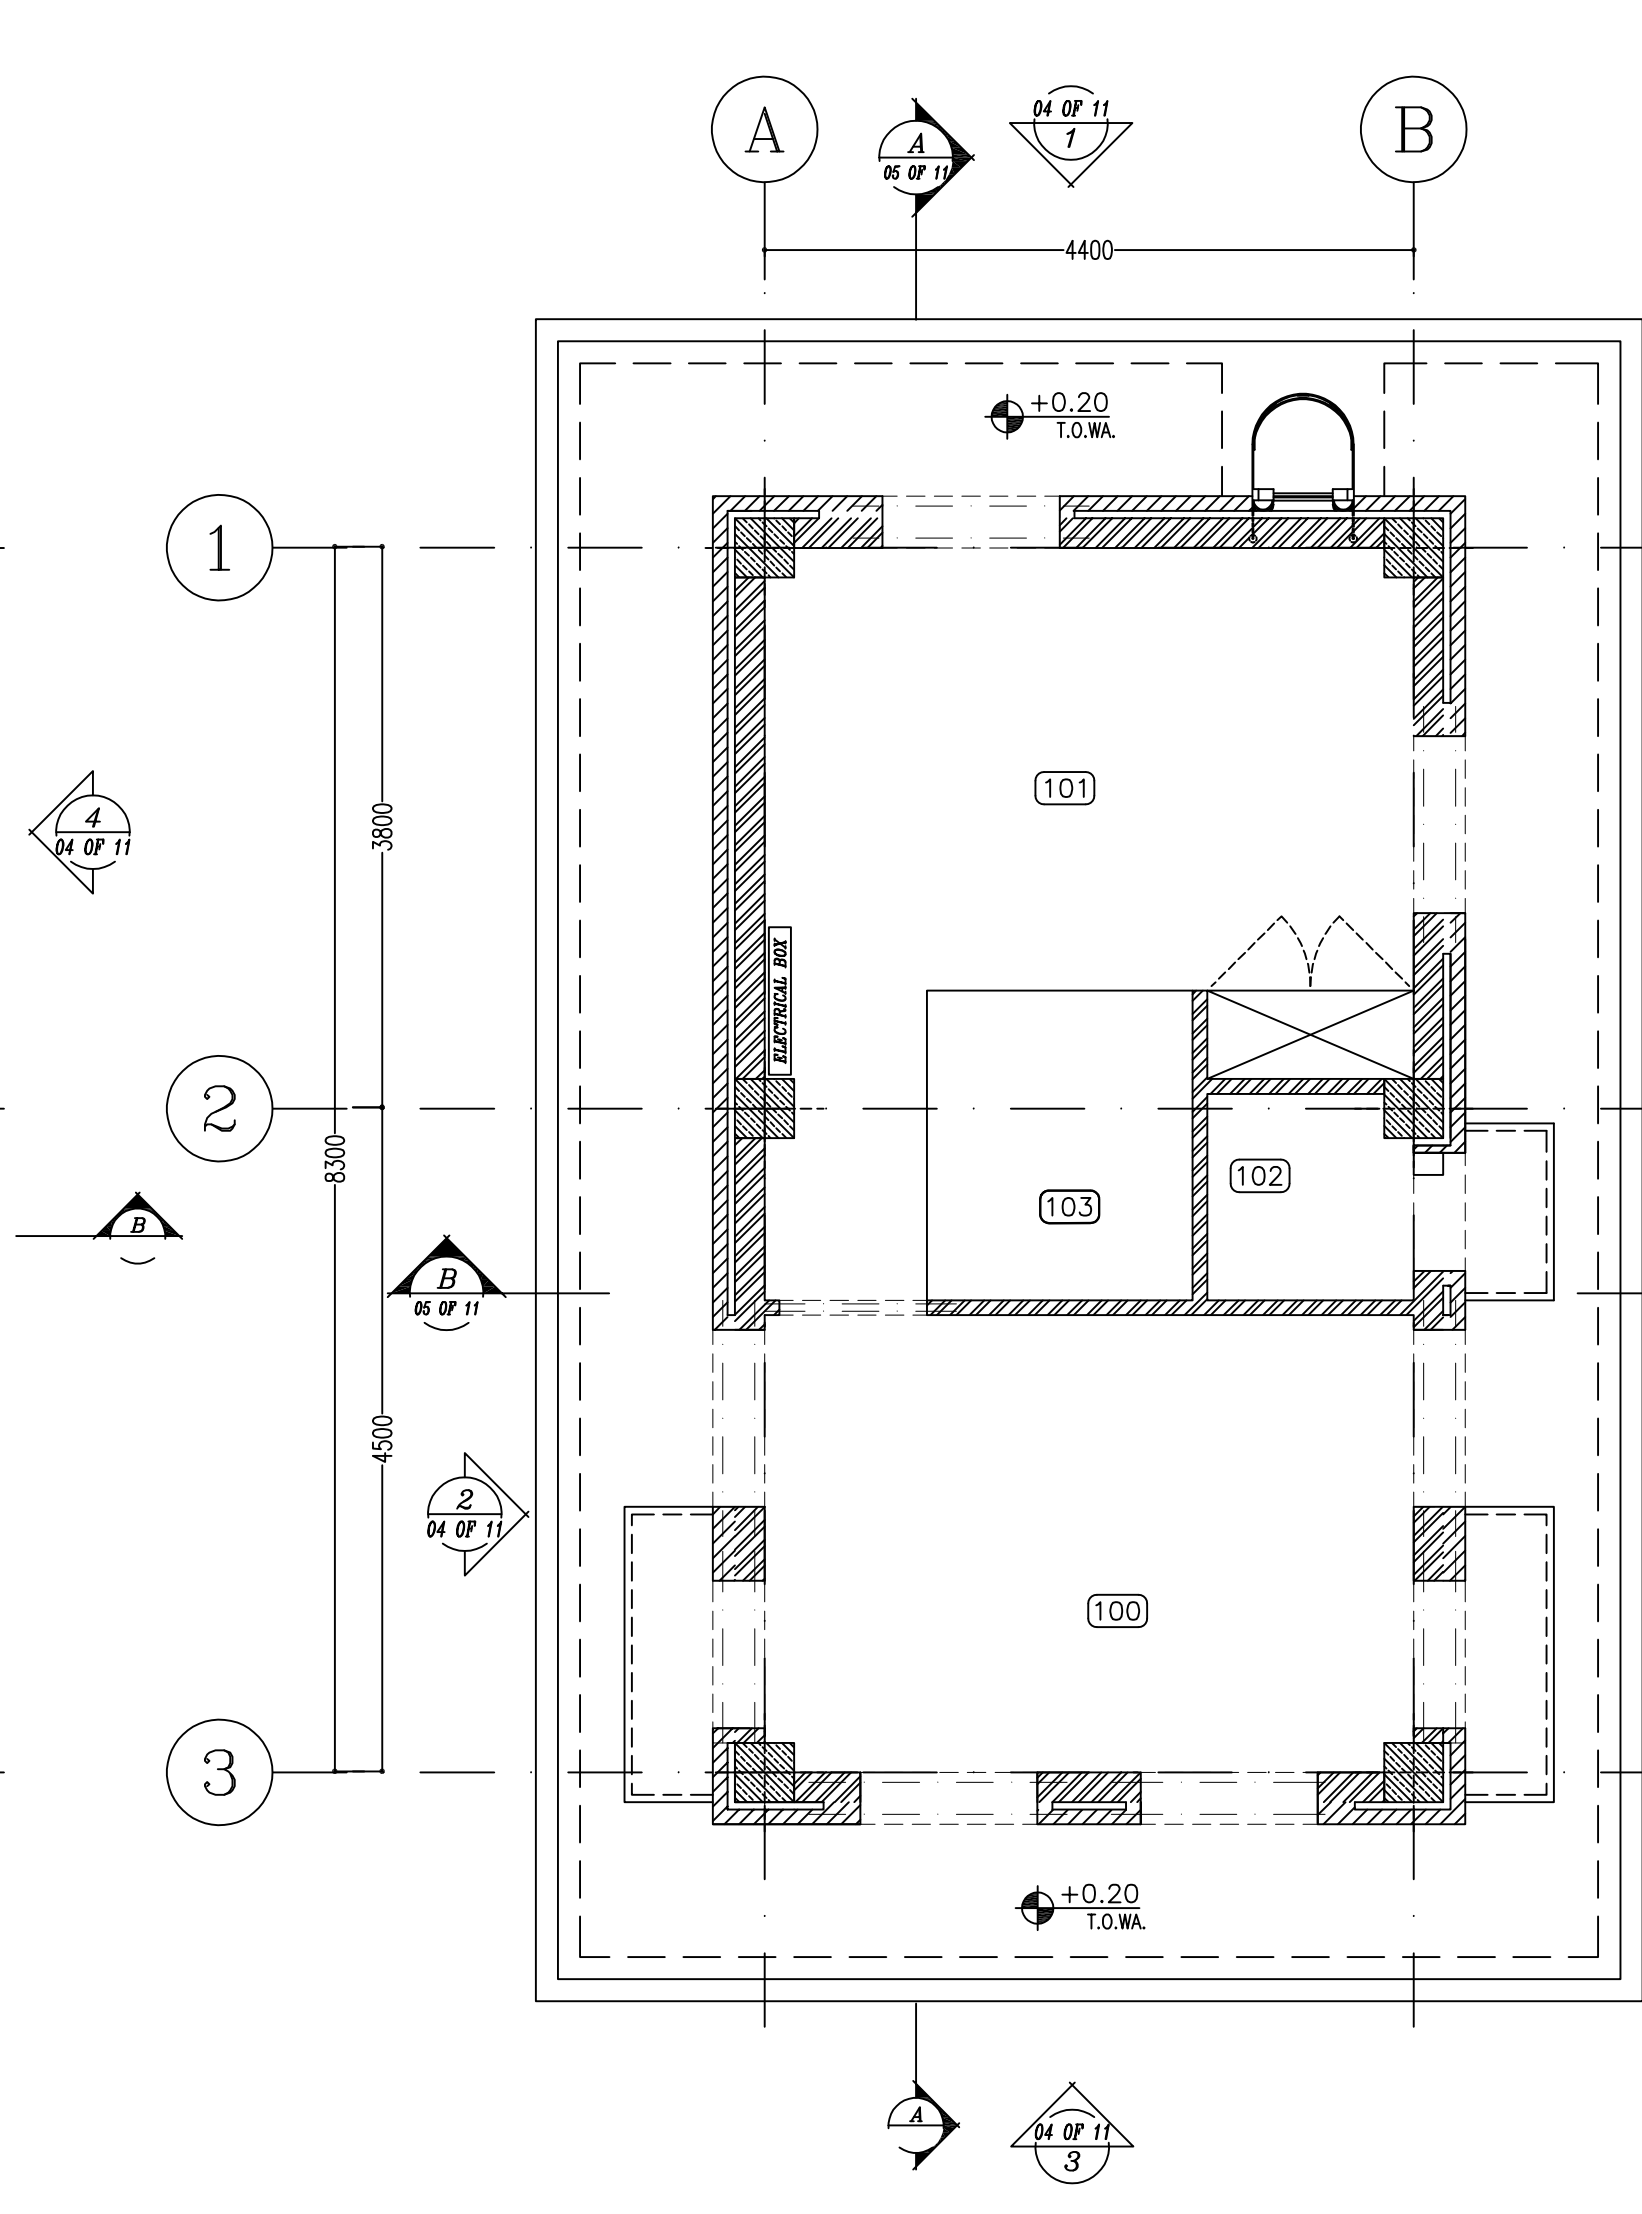


SC.1:50 4 LINTEL PLAN

- NOTES
- 1- DIMENSIONS ARE IN "mm" AND ELEVATIONS IN "m" UNLESS SPECIFIED .
 - 2- ALL DIMENSIONS AND ELEVATIONS SHALL BE CHECKED BY THE CONTRACTOR PRIOR TO CONSTRUCTION.
 - 3- CONTRACTOR SHALL COMPILE ALL ARCHITECTURAL, MECHANICAL, ELECTRICAL, PIPING AND STRUCTURAL DRAWINGS AND IN CASE OF ANY CONFLICTS OR DISCREPANCY, INFORM THE ENGINEER.
 - 4- SLAB ON GRADE SHALL BE CONSTRUCTED AFTER EXECUTION OF CABLE TRENCH & EQUIPMENTS FOUNDATION.
 - 5- ALL MATERIALS ARE SELECTED FROM THE HIGHEST QUALITY AND SHALL BE APPROVED BY THE CLIENT.
 - 6- FOR COORDINATE REFER TO FINISH GRADING DOCUMENTS.
 - 7) REFERENCE COORDINATES E=1000.000 , N=1000.000 REFER TO X=437425 , Y=3290543 UTM.
 - 8) FINISH GRADING LEVEL (W007S) ELEVATION : +26.00 (MEAN SEA LEVEL) +26.05 m (GLOBAL) = ±0.00 (LOCAL)
 - 9) ALL EXTERNAL OPENINGS (WINDOWS AND DOORS) SHALL BE FIRE PROOF.
 - 10) DOUBLE GLAZED WINDOW WITH 246mm REINFORCED GLASS AND 6mm GAS FILLED GAP.
 - 11) WC DOORS SHALL BE WATERPROOF ABS TYPE WITH CLOSER MECHANISM.
 - 12) KNAUF GYPSUM BOARD TILES (60*60) cm (REGULAR 9.5 mm THICKNESS) WITH (1063).
 - 13) KNAUF PVC-COATED GYPSUM BOARD TILES (60*60)-(REGULAR 9.5mm THICKNESS) WITH (1063)-(PVC THICKNESS 0.35mm).

- LEGEND
- | | | | |
|--|--|--|---------------|
| | BRICK WALL | | BRICK FACING |
| | ANTI-ACID CERAMIC | | CEMENT SAND |
| | TOVENAN COURSE | | BLOCKAGE |
| | POLYETHYLENE SHEET | | LEAN CONCRETE |
| | REINFORCED CONCRETE ACCORDING TO STR.DWG | | TERRAZZO TILE |
| | CHEQUERED PLATE TRENCH CAP | | |
| | HOT DEEP GALVANIZED SHEET | | |
| | SOFT SAND | | |



- | | | | |
|----------|------------------------|--------|-------------------|
| F.F.L. | FINISHED FLOOR | T.O.B. | TOP OF BEAM |
| T.O.W.A. | TOP OF WALKWAY | B.O.C. | BOTTOM OF CAGE |
| T.O.P. | TOP OF PARAPET | T.O.S. | TOP OF SLAB |
| T.O.C. | TOP OF CAGE | B.O.S. | BOTTOM OF SLEEVE |
| T.O.D. | TOP OF DOOR | T.O.F. | TOP OF FOUNDATION |
| F.G.L. | FINISHED GRADING LEVEL | | |

REFERENCE DRAWING	DRG. No.
STANDARD DRAWING FOR ARCHITECTURAL DETAILS	BK-GNRL-PEDCO-000-AR-DW-0001
STANDARD DETAILS FOR LADDER & SAFETY CAGE	BK-GNRL-PEDCO-000-ST-DW-0009
PLOT PLAN DRAWING - W007S	BK-W007S-PEDCO-110-PI-PY-0002
FOUNDATION DRAWING FOR SECURITY BUILDING FOR WELL PADS - W007S	BK-W007S-PEDCO-110-ST-DW-0008
STRUCTURAL DRAWING FOR SECURITY BUILDING FOR WELL PADS - W007S	BK-W007S-PEDCO-110-ST-DW-0009
HVAC SYSTEM LAYOUT FOR SECURITY BUILDING - W007S	BK-W007S-PEDCO-110-HV-PY-0003
PLUMBING & SEWAGE PIPING LAYOUT FOR SECURITY BUILDING - W007S	BK-W007S-PEDCO-110-HV-PY-0004
LIGHTING & SMALL POWER LAYOUT FOR SECURITY BUILDING OF WELL PADS	BK-SISGR-PEDCO-110-EL-PY-0005

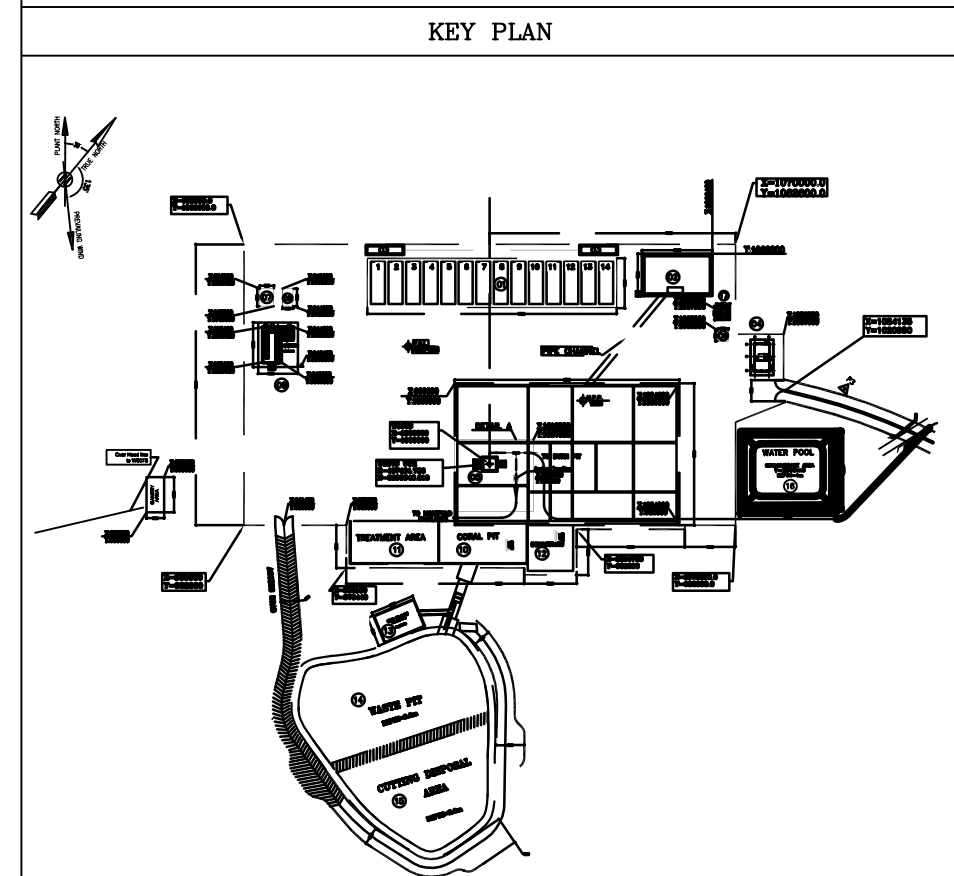


100	SECURITY GUARD ROOM
101	RESTING AREA
102	WC
103	PANTRY

D04	OCT.2023	APC	R.BERLOUIE	M.PAKHARIAN	S.Paramarspour	***									
D03	AUG.2023	IFA	R.BERLOUIE	M.PAKHARIAN	A.M.MOHSSENI	***									
D02	JUN.2023	IFA	R.BERLOUIE	M.PAKHARIAN	A.M.MOHSSENI	***	***	*****	***	*****	***	*****			
D01	FEB.2023	IFA	R.BERLOUIE	M.PAKHARIAN	M.Mehrshad	***									
D00	APR.2022	IPC	R.BERLOUIE	M.PAKHARIAN	M.Mehrshad	***									
REV.	DATE	P.O.I.S	PREP.	CHK.	APP.	AUT.	REV.	DESCRIPTION	BY	DATE	BY	DATE	REV.	APPR.	
PROJECT NAME: BINAK OILFIELD DEVELOPMENT/SUB-SURFACE WORK PACKAGES W007S WHF & EXTENSION OF BINAK B/C							THE ORIGINAL AND ALL COPIES OF THIS DRAWING TOGETHER WITH THE COPYRIGHT THEREIN ARE THE SOLE PROPERTY OF N.I.S.O.C./ FIELDS								
PROJECT NO.: 971020							BINAK OILFIELD DEVELOPMENT SUB-SURFACE WORK PACKAGES W007S WHF & EXTENSION OF BINAK B/C								
EPC CONTRACTOR: HIRGAN ENERGY - DESIGN & INSPECTION COMPANIES							PETROIRAN DEVELOPMENT COMPANY								
DRAWING TITLE: ARCHITECTURAL DRAWING FOR SECURITY BUILDING OF WELL PADS - W007S PLANS							NO CONSTRUCTION PERMITTED UNLESS DRAWING APPROVED								
SCALE SIZE DRAWING NO. SHEET NO. REV.							APPROVED FOR CONSTRUCTION BY: DATE:								
AS SHOWN	A1	BK-W007S-PEDCO-110-AR-DW-0004	02 OF 11	D04	BUDGET REF.	LOCATION	SIZE	CLASS	SERIAL NO.	SHEET	REVISION				
					053-073-9184	F	4	B	708045	02 OF 11	D04				

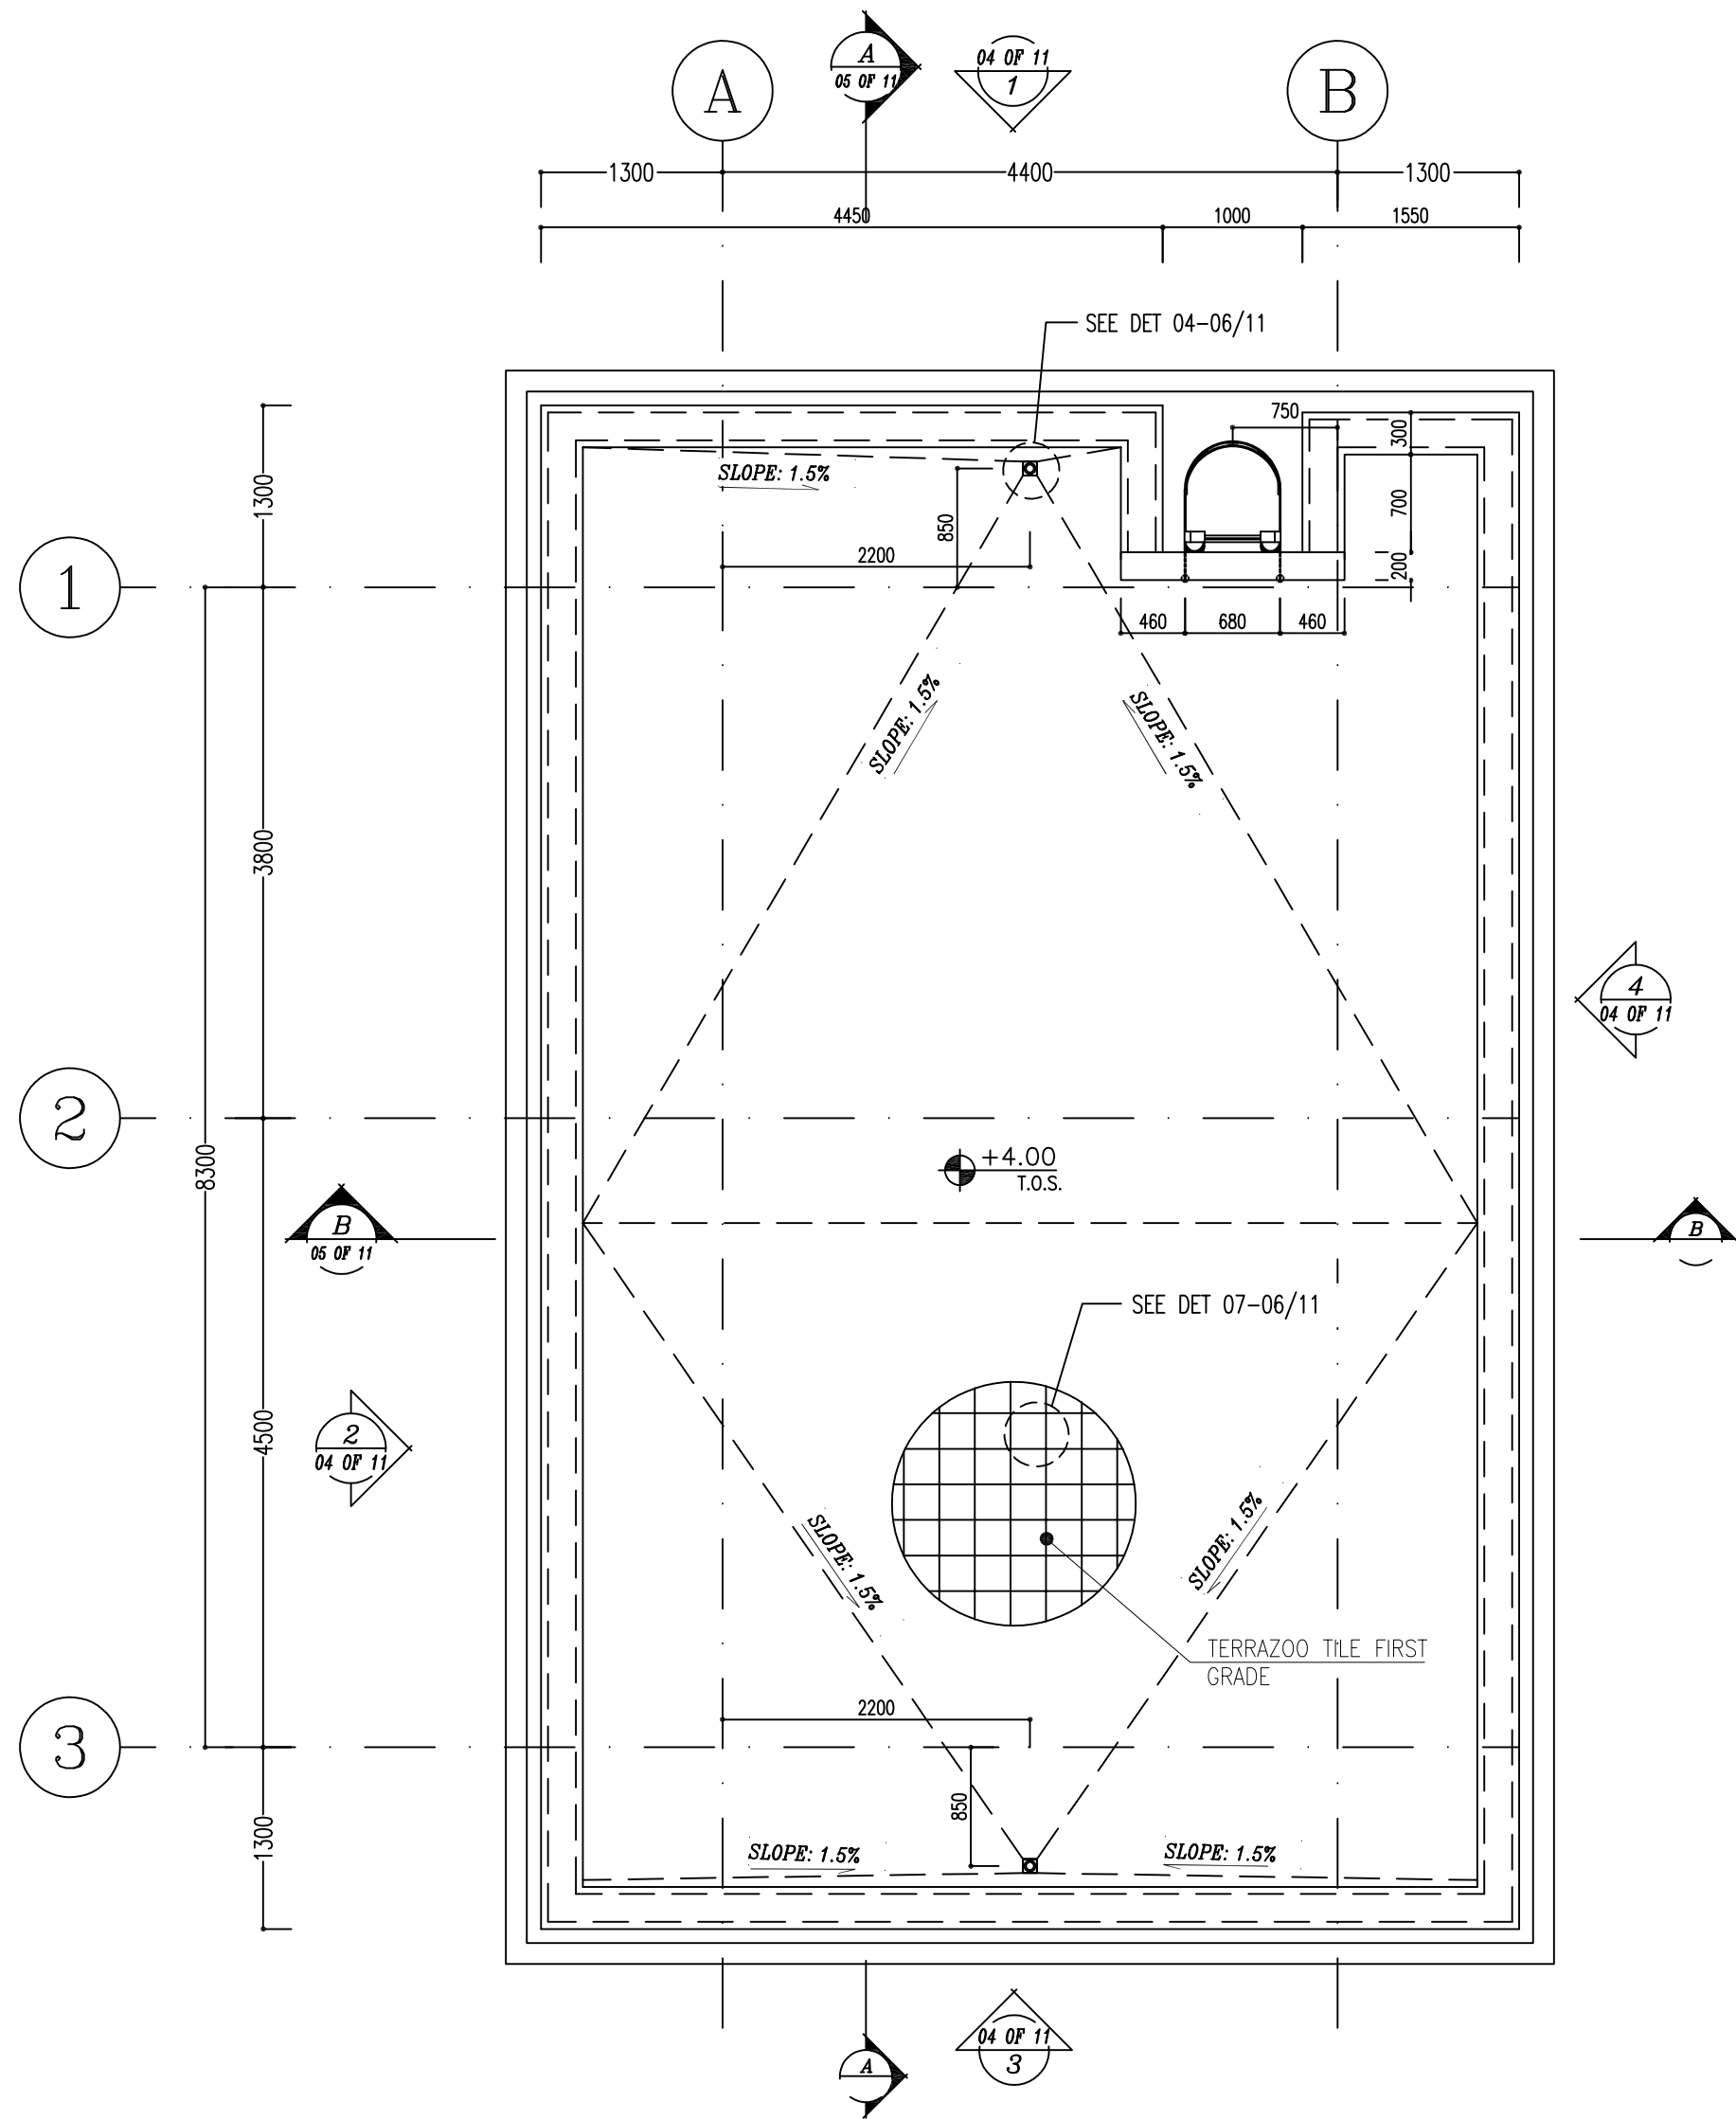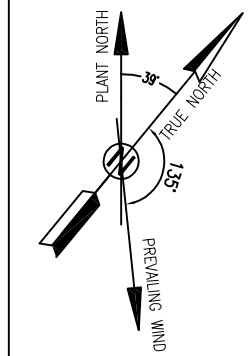


SC.1:50 5 ROOF PLAN

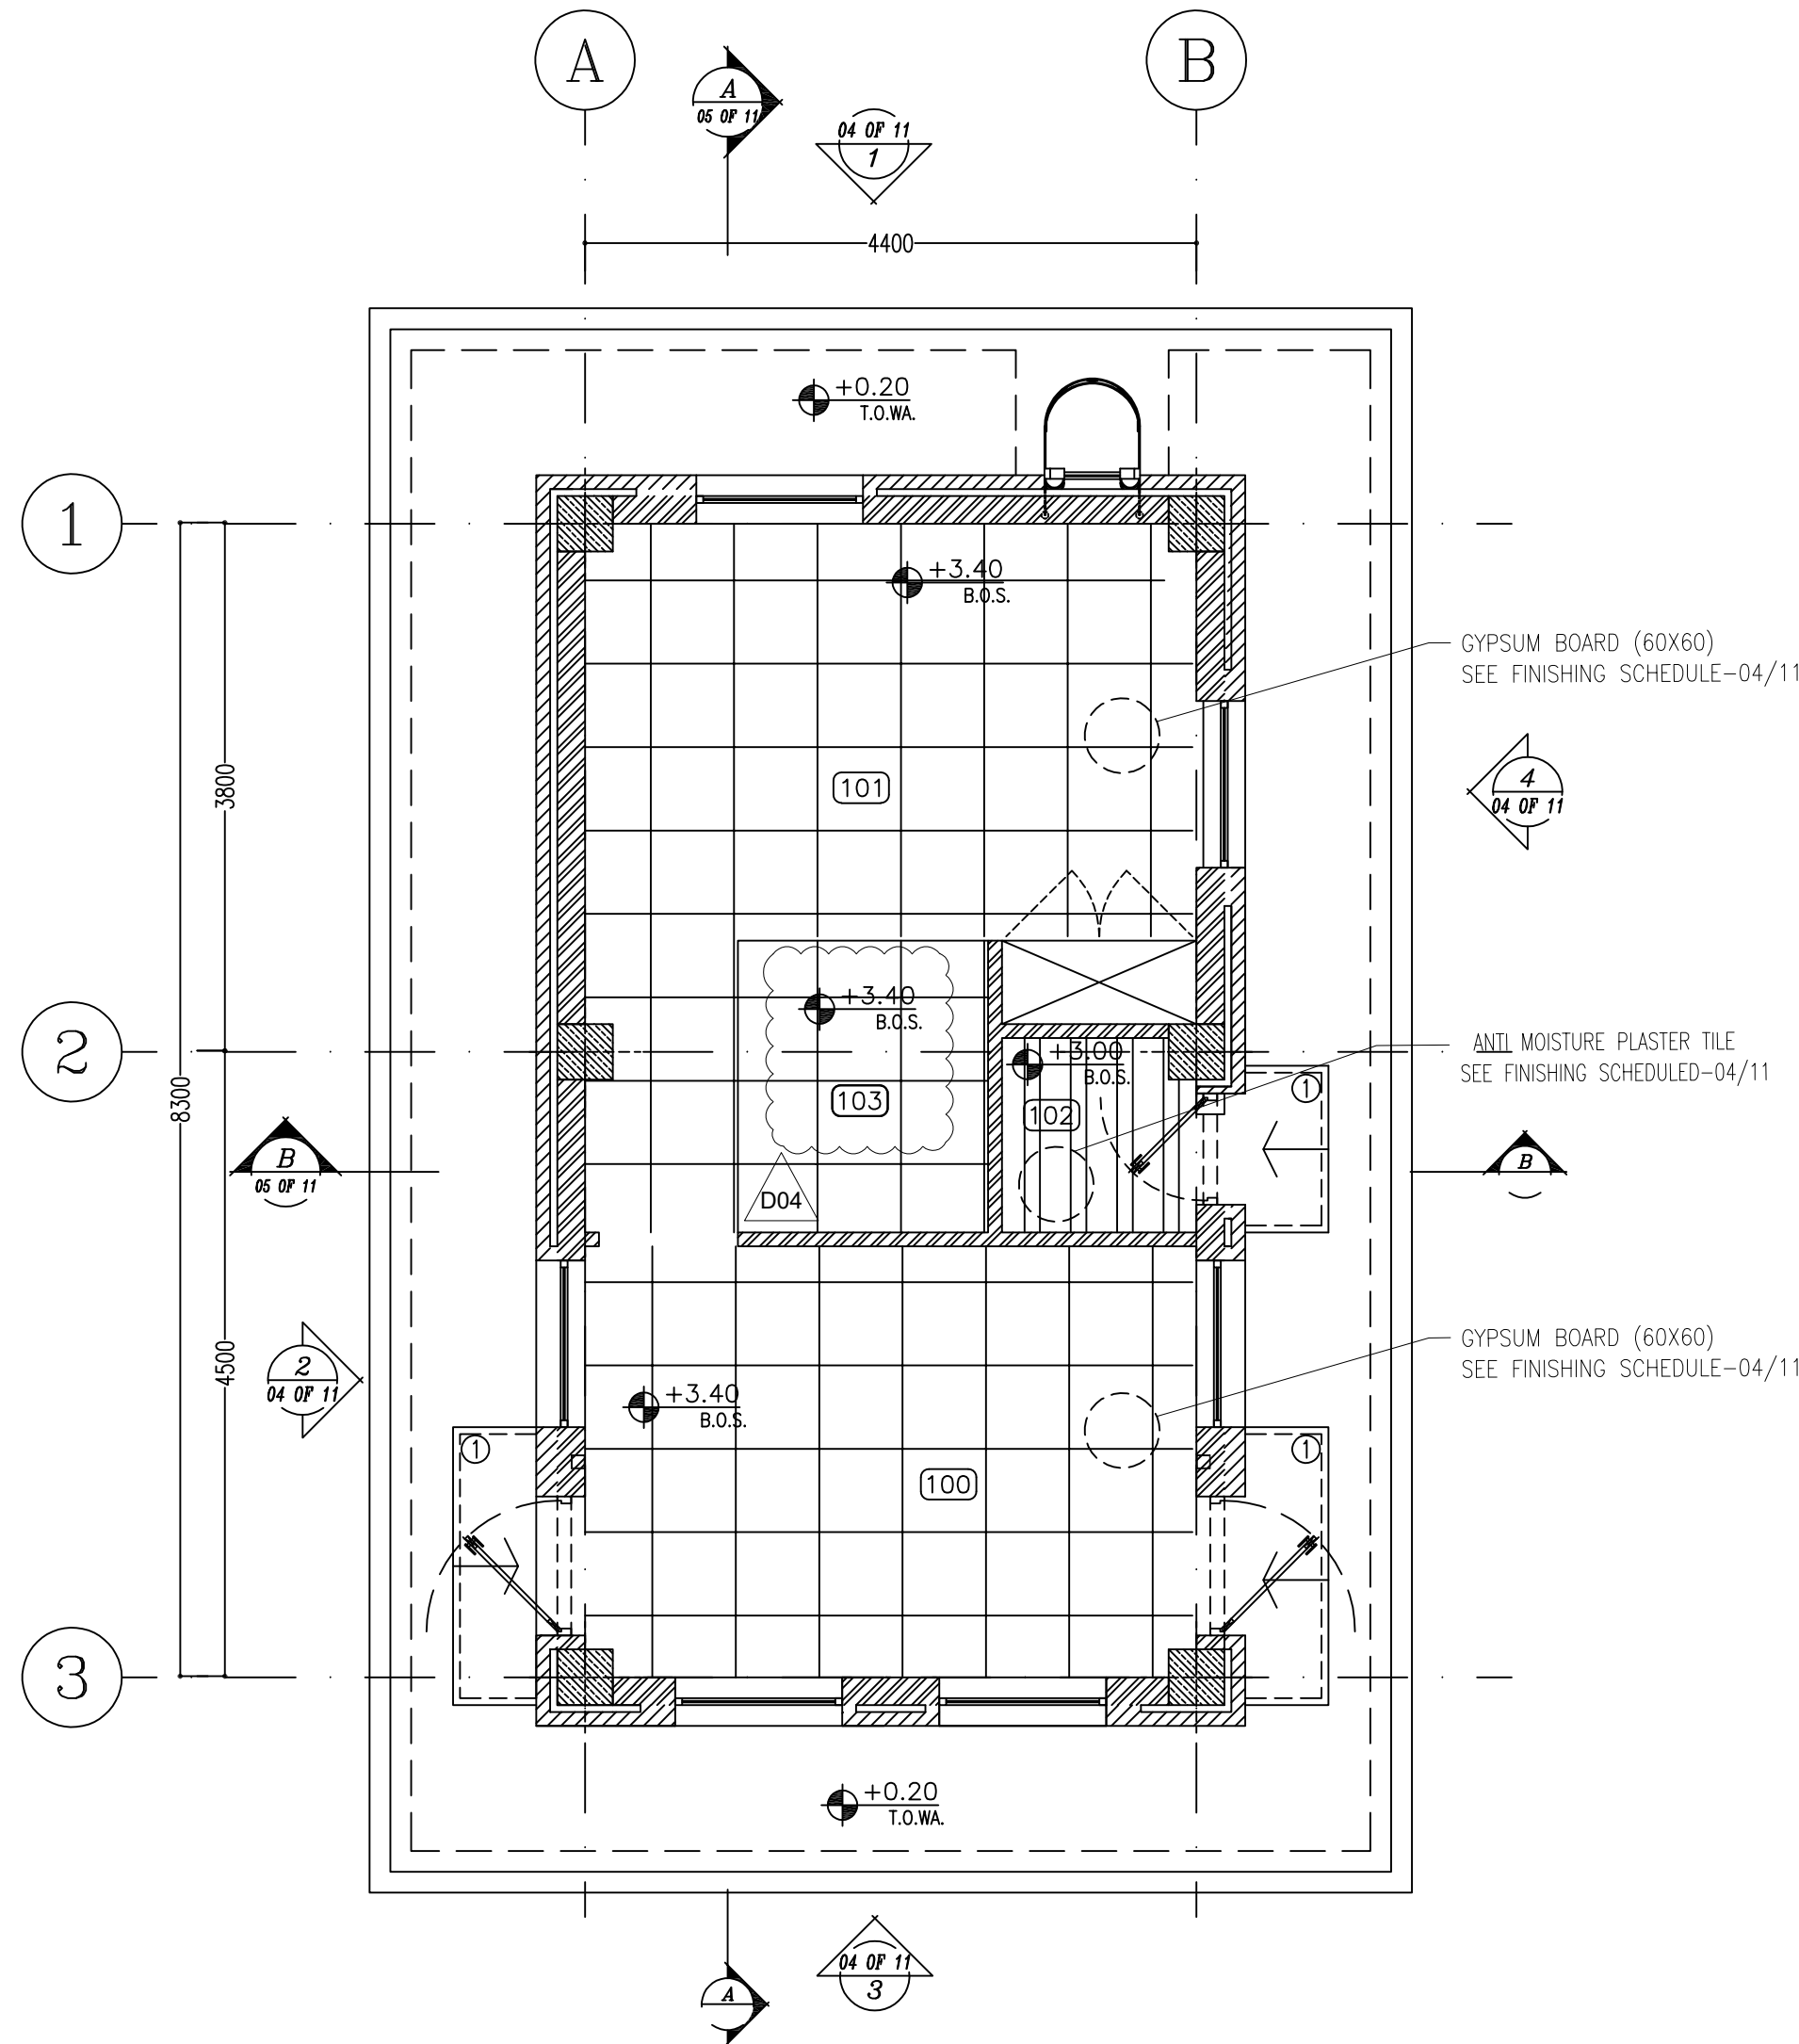


SC.1:50 6 SUSPENDED CEILING PLAN

100	SECURITY GUARD ROOM
101	RESTING AREA
102	WC
103	PANTRY


D04	OCT.2023	APC	R.BERLOUIE	M.PAKHARIAN	S.Paramaripour	** **									
D03	AUG.2023	IFA	R.BERLOUIE	M.PAKHARIAN	A.M.MOHSSENI	** **									
D02	JUN.2023	IFA	R.BERLOUIE	M.PAKHARIAN	A.M.MOHSSENI	** **	***	*****	** **	*** **	** **	*** **	*** **	*** **	*** **
D01	FEB.2023	IFA	R.BERLOUIE	M.PAKHARIAN	M.Mehrshad	** **									
D00	APR.2022	IPC	R.BERLOUIE	M.PAKHARIAN	M.Mehrshad	** **									
REV.	DATE	P.O.I.S	PREP.	CHK.	APP.	AUT.	REV.	DESCRIPTION	BY	DATE	BY	DATE	BY	DATE	DATE
PROJECT NAME: BINAK OILFIELD DEVELOPMENT/SUB-SURFACE WORK PACKAGES							THE ORIGINAL AND ALL COPIES OF THIS DRAWING TOGETHER WITH THE COPYRIGHT THEREIN ARE THE SOLE PROPERTY OF N.I.S.O.C./ FIELDS								
PROJECT NO.: 971020							BINAK OILFIELD DEVELOPMENT SUB-SURFACE WORK PACKAGES W007S WHF & EXTENSION OF BINAK B/C								
EPC CONTRACTOR: HIRGAN ENERGY - DESIGN & INSPECTION COMPANIES							NO CONSTRUCTION PERMITTED UNLESS DRAWING APPROVED								
EPD/EPC CONTRACTOR (GC): PETROIRAN DEVELOPMENT COMPANY							APPROVED FOR CONSTRUCTION								
DRAWING TITLE: ARCHITECTURAL DRAWING FOR SECURITY BUILDING OF WELL PADS - W007S							BY: DATE:								
SCALE	SIZE	DRAWING NO.			SHEET NO.	REV.	BUDGET REF.	LOCATION	SIZE	CLASS	SERIAL NO.	SHEET	REVISION		
AS SHOWN	A1	BK-W007S-PEDCO-110-AR-DW-0004			03 OF 11	D04	053-073-9184	F	4	B	708045	03 OF 11	D04		

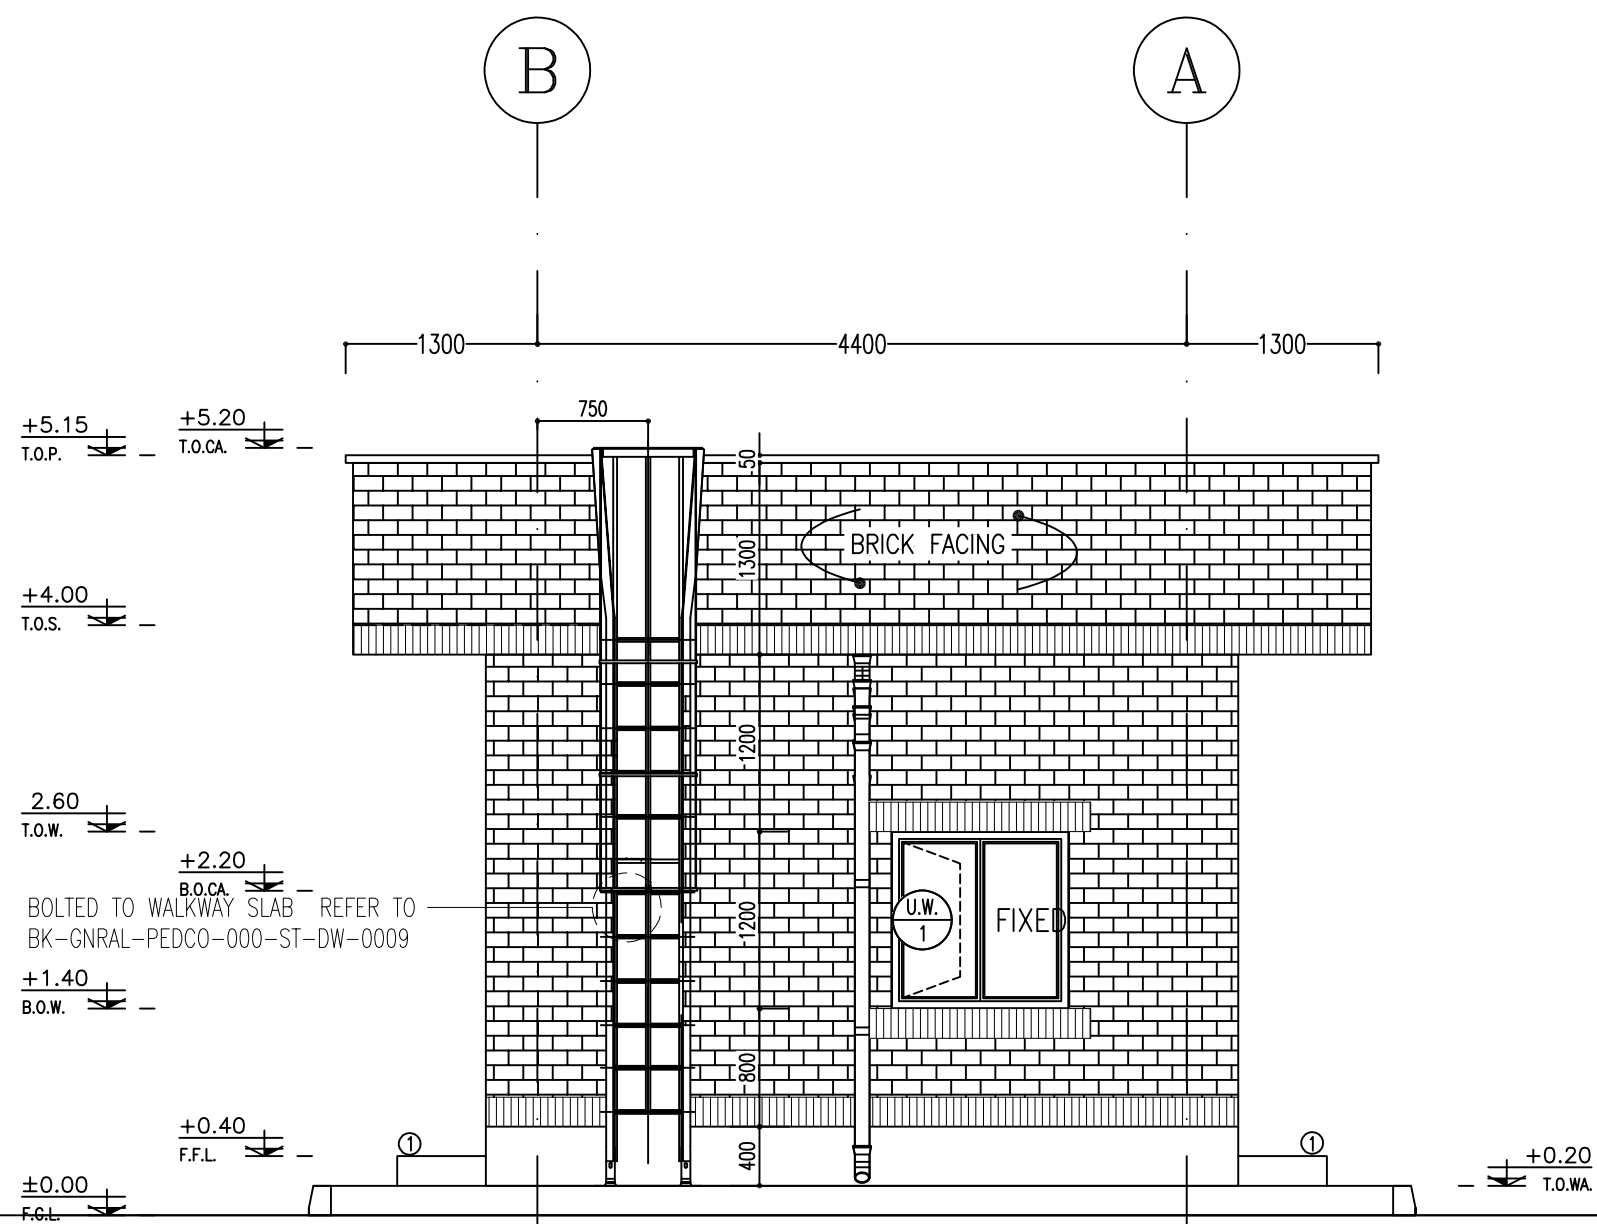


1 ELEVATION
SC.1:50 01 OF 11

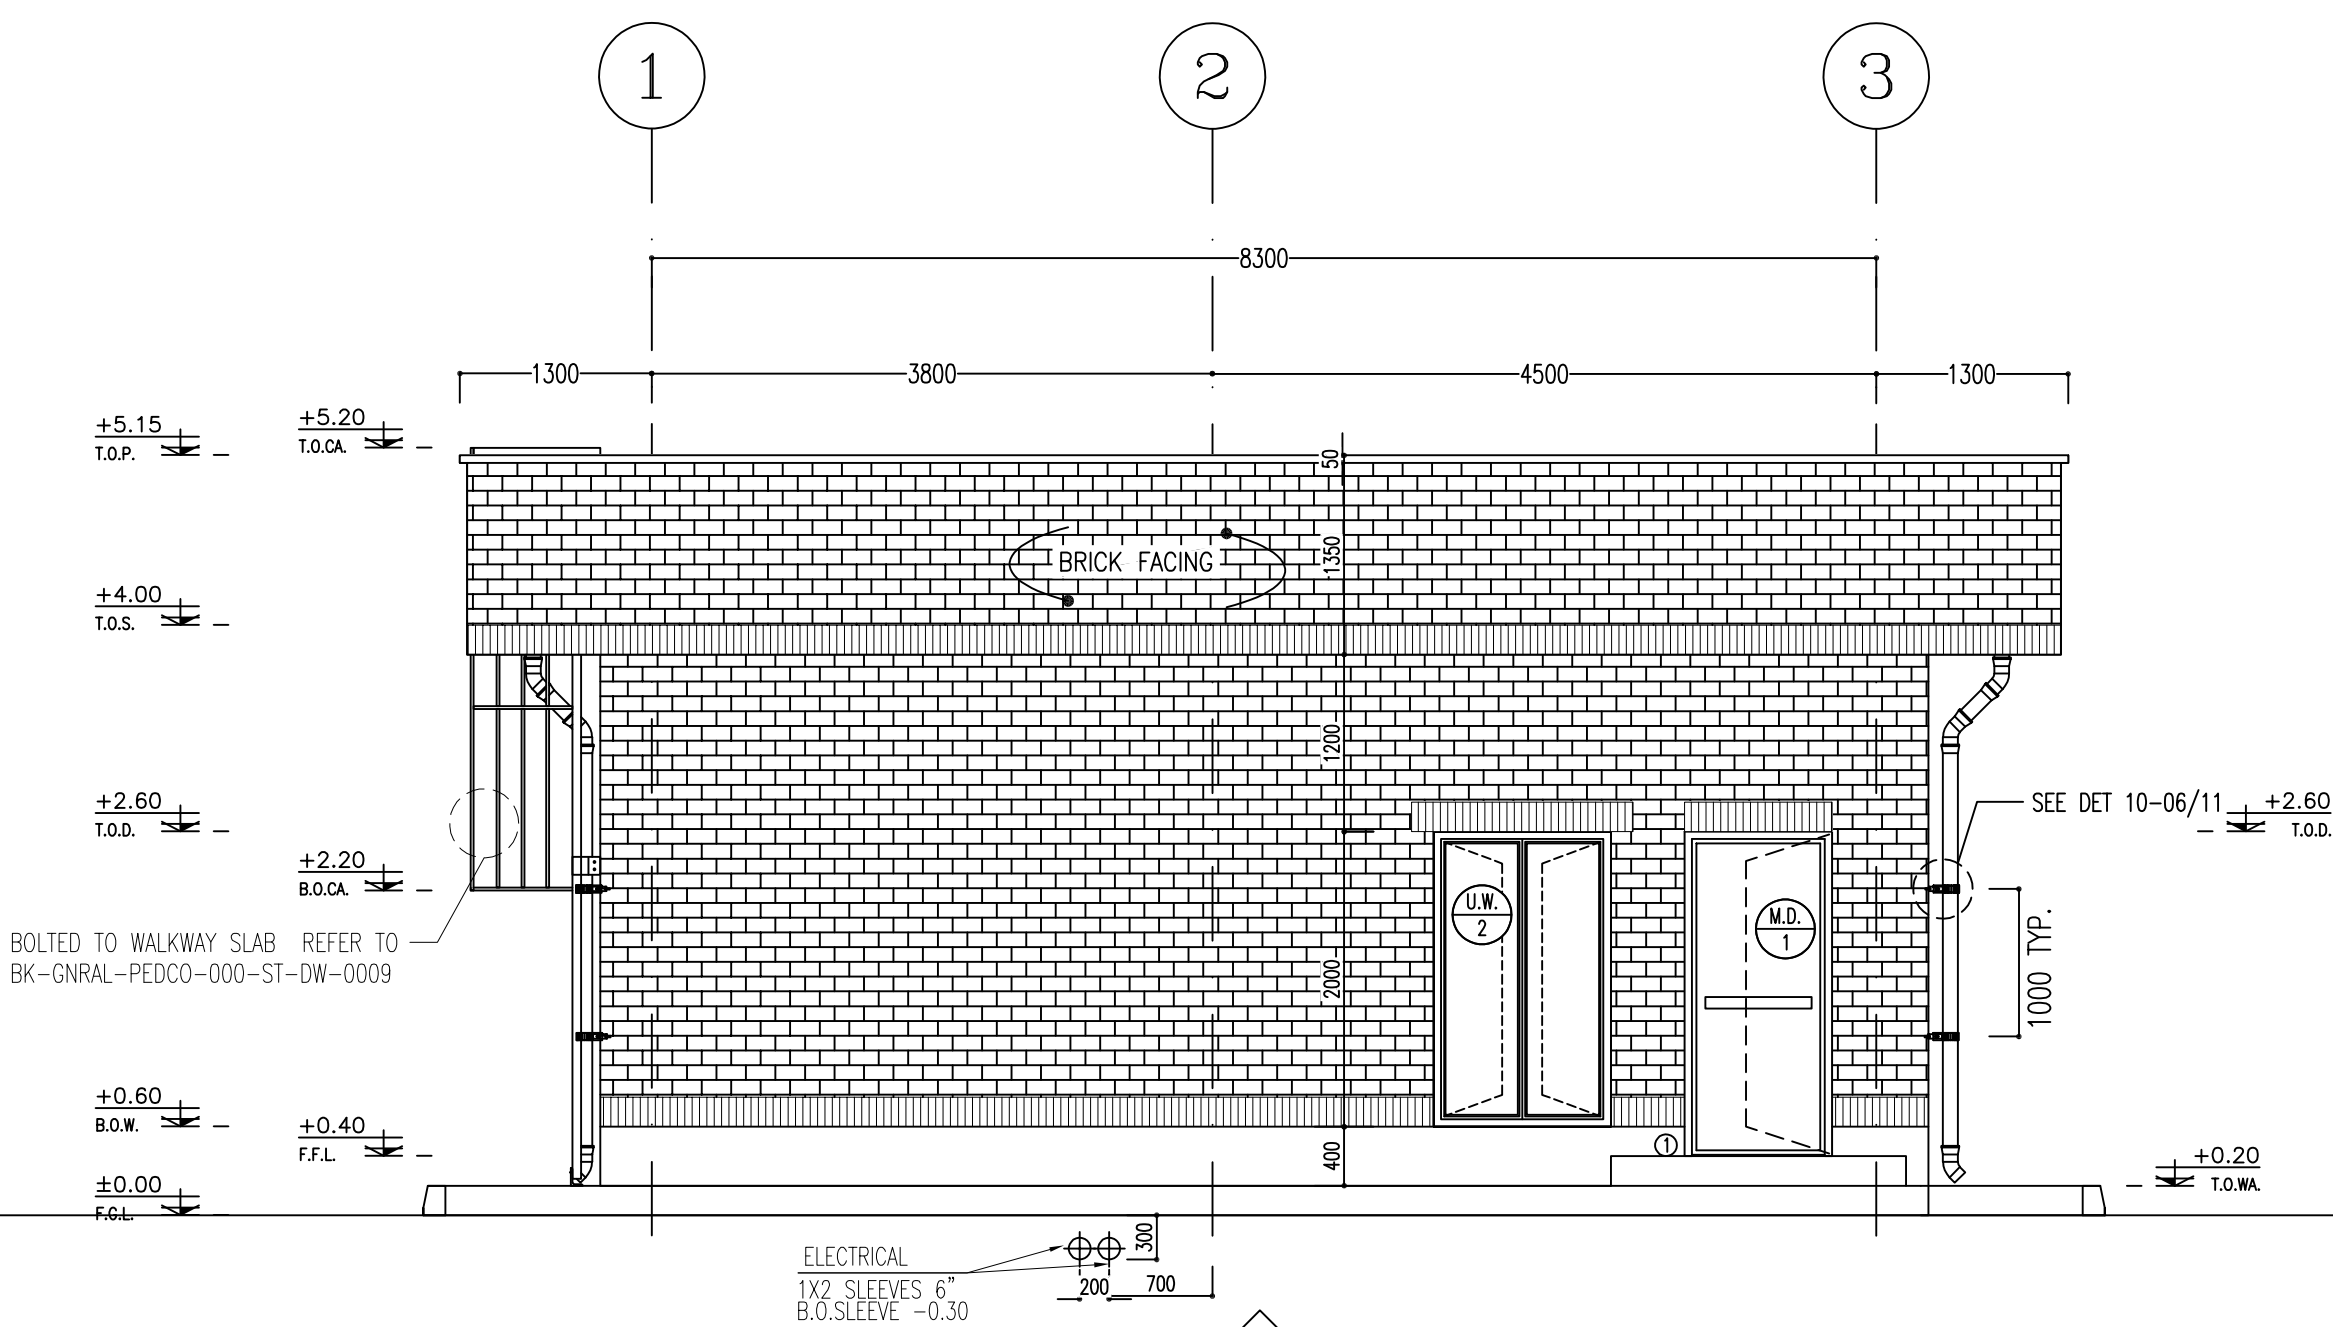

2 ELEVATION
SC.1:50 01 OF 11

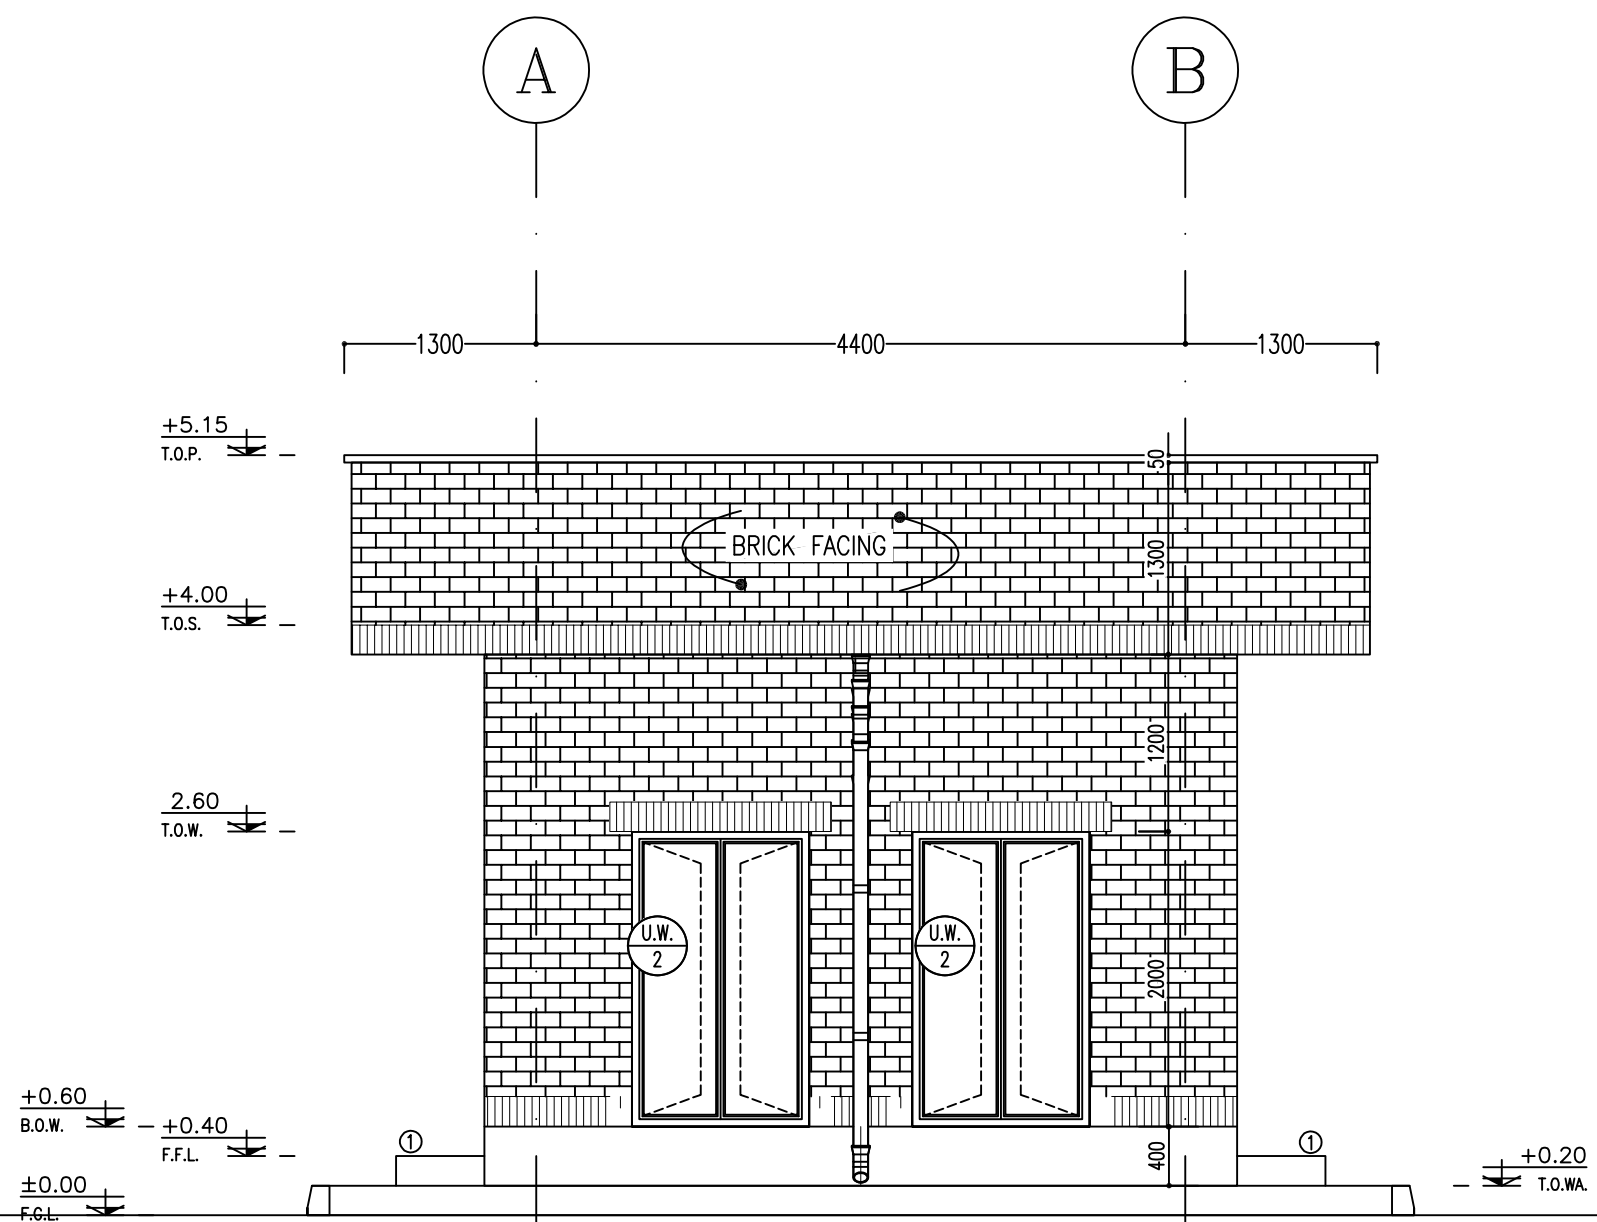

3 ELEVATION
SC.1:50 01 OF 11

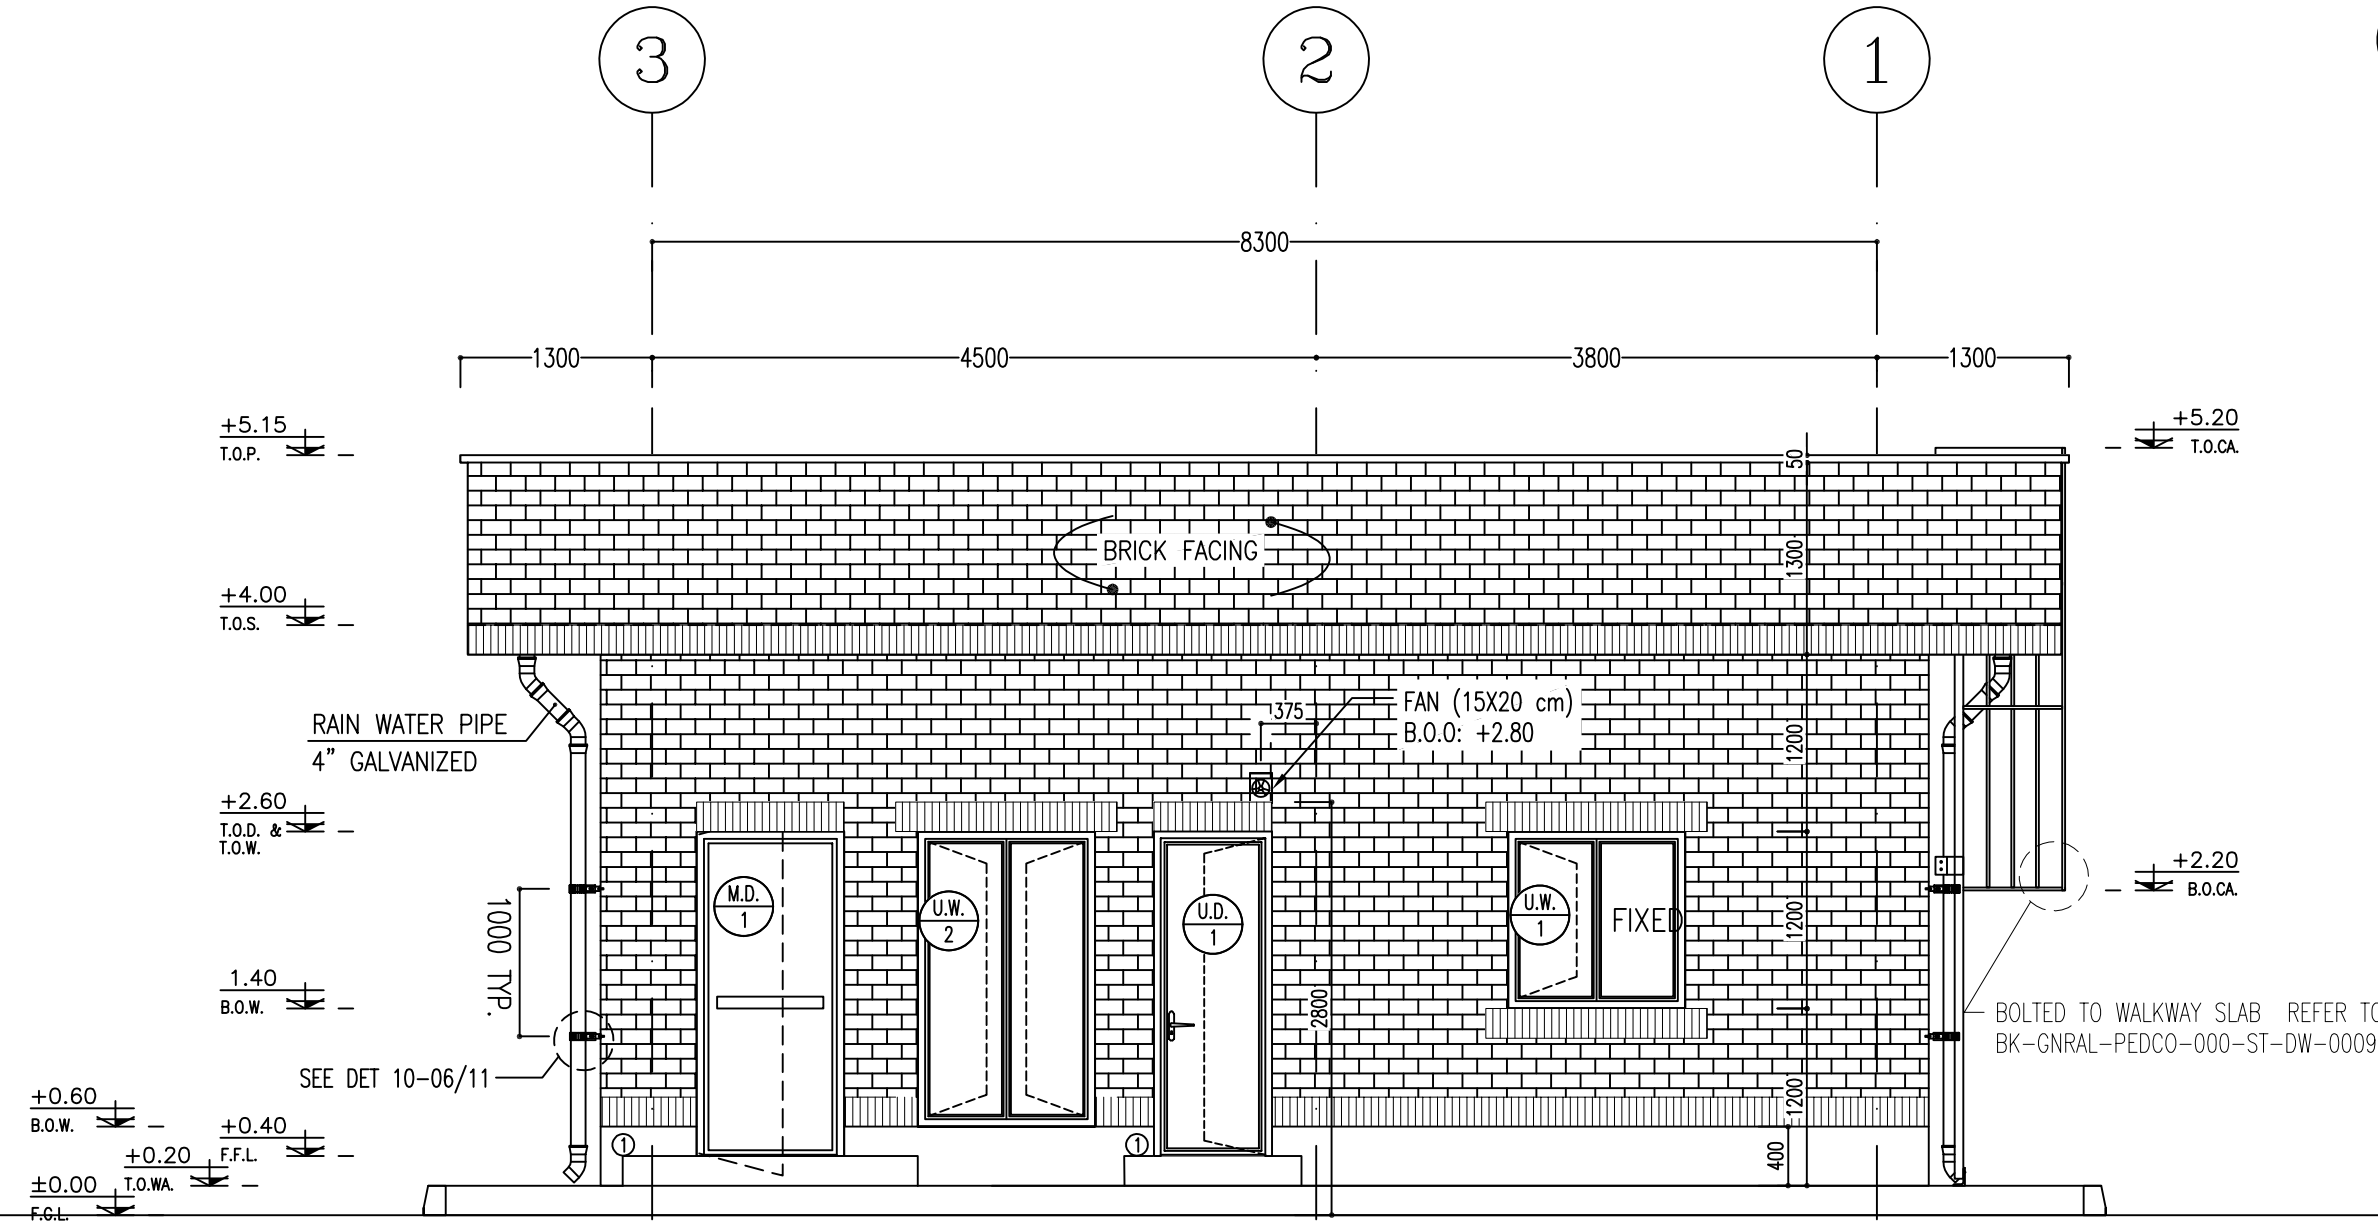


4 ELEVATION
SC.1:50 01 OF 11

- NOTES
- 1- DIMENSIONS ARE IN "mm" AND ELEVATIONS IN "m" UNLESS SPECIFIED .
 - 2- ALL DIMENSIONS AND ELEVATIONS SHALL BE CHECKED BY THE CONTRACTOR PRIOR TO CONSTRUCTION.
 - 3- CONTRACTOR SHALL COMPARE ALL ARCHITECTURAL, MECHANICAL, ELECTRICAL, PIPING AND STRUCTURAL DRAWINGS AND IN CASE OF ANY CONFLICTS OR DISCREPANCY, INFORM THE ENGINEER.
 - 4- SLAB ON GRADE SHALL BE CONSTRUCTED AFTER EXECUTION OF CABLE TRENCH & EQUIPMENTS FOUNDATION.
 - 5- ALL MATERIALS ARE SELECTED FROM THE HIGHEST QUALITY AND SHALL BE APPROVED BY THE CLIENT.
 - 6- FOR COORDINATE REFER TO FINISH GRADING DOCUMENTS.
 - 7) REFERENCE COORDINATES E=1000.000 , N=1000.000 REFER TO X=457425 , Y=3290543 UTM.
 - 8) FINISH GRADING LEVEL (W007S) ELEVATION : +26.00 (MEAN SEA LEVEL) ±26.05 m (GLOBAL) = ±0.00 (LOCAL)
 - 9) ALL EXTERNAL OPENINGS (WINDOWS AND DOORS) SHALL BE FIRE PROOF.
 - 10) DOUBLE GLAZED WINDOW WITH 246mm REINFORCED GLASS AND 6mm GAS FILLED GAP.
 - 11) WC DOORS SHALL BE WATERPROOF ABS TYPE WITH CLOSER MECHANISM.
 - 12) KNAUF GYPSUM BOARD TILES (60*60) cm (REGULAR 9.5 mm THICKNESS) WITH (1063).
 - 13) KNAUF PVC-COATED GYPSUM BOARD TILES (60*60)-(REGULAR 9.5mm THICKNESS) WITH (1063)-(PVC THICKNESS 0.35mm).


LEGEND	
	BRICK WALL
	BRICK FACING
	ANTI-ACID CERAMIC
	TOVENAN COURSE
	POLYETHYLENE SHEET
	REINFORCED CONCRETE ACCORDING TO STR.DWG
	CHEQUERED PLATE TRENCH CAP
	HOT DEEP GALVANIZED SHEET
	SOFT SAND
	CEMENT SAND
	BLOCKAGE
	LEAN CONCRETE
	TERRAZZO TILE

F.F.L.	FINISHED FLOOR	T.O.B.	TOP OF BEAM
T.O.W.A.	TOP OF WALKWAY	B.O.C.	BOTTOM OF CAGE
T.O.P.	TOP OF PARAPET	T.O.S.	TOP OF SLAB
T.O.C.	TOP OF CAGE	B.O.S.	BOTTOM OF SLEEVE
T.O.D.	TOP OF DOOR	T.O.F.	TOP OF FOUNDATION
F.G.L.	FINISHED GRADING LEVEL		


REFERENCE DRAWING	DRG. No.
STANDARD DRAWING FOR ARCHITECTURAL DETAILS	BK-GNRL-PEDCO-000-AR-DW-0001
STANDARD DETAILS FOR LADDER & SAFETY CAGE	BK-GNRL-PEDCO-000-ST-DW-0009
PLOT PLAN DRAWING - W007S	BK-W007S-PEDCO-110-PI-PY-0002
FOUNDATION DRAWING FOR SECURITY BUILDING FOR WELL PADS - W007S	BK-W007S-PEDCO-110-ST-DW-0008
STRUCTURAL DRAWING FOR SECURITY BUILDING FOR WELL PADS - W007S	BK-W007S-PEDCO-110-ST-DW-0009
HVAC SYSTEM LAYOUT FOR SECURITY BUILDING - W007S	BK-W007S-PEDCO-110-HV-PY-0003
PLUMBING & SEWAGE PIPING LAYOUT FOR SECURITY BUILDING - W007S	BK-W007S-PEDCO-110-HV-PY-0004
LIGHTING & SMALL POWER LAYOUT FOR SECURITY BUILDING OF WELL PADS	BK-SISGR-PEDCO-110-BL-PY-0005

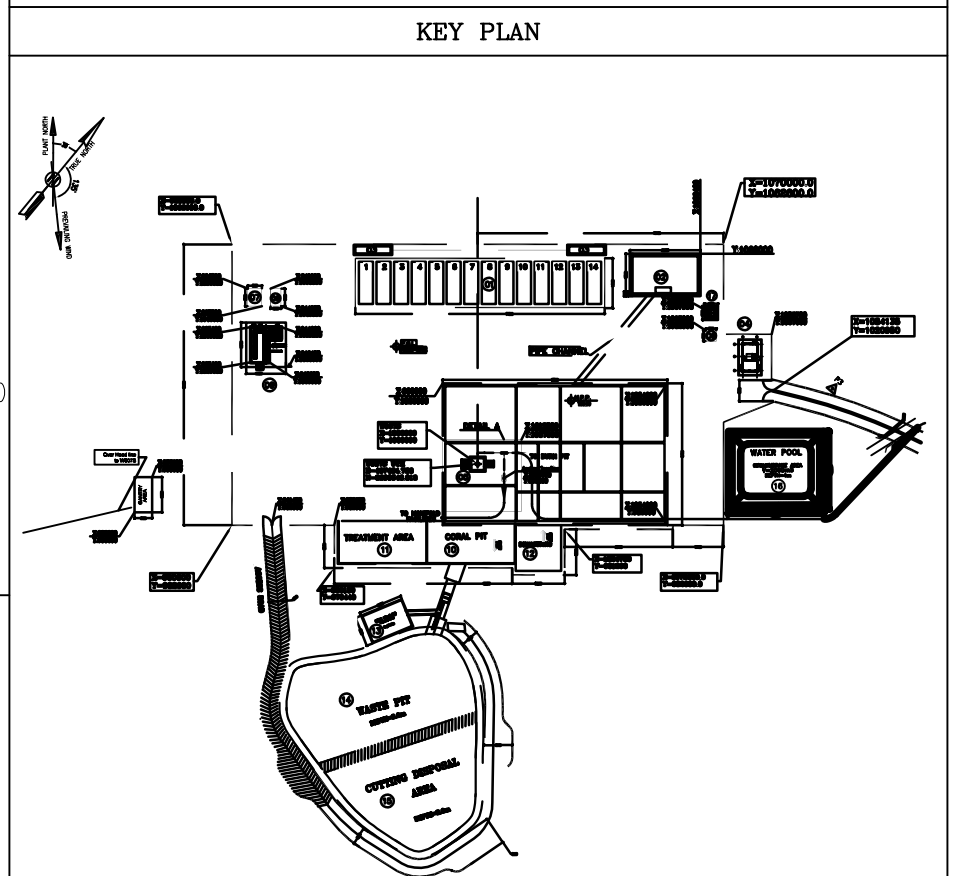


D04	OCT.2023	AFC	R.BERLOUIE	M.PAKHARIAN	S.Paramaripour	***									
D03	AUG.2023	IFA	R.BERLOUIE	M.PAKHARIAN	A.M.MOHSSENI	***									
D02	JUN.2023	IFA	R.BERLOUIE	M.PAKHARIAN	A.M.MOHSSENI	***	***	*****	***	*****	***	*****	***	*****	
D01	FEB.2023	IFA	R.BERLOUIE	M.PAKHARIAN	M.Mehrshad	***									
D00	APR.2022	IPC	R.BERLOUIE	M.PAKHARIAN	M.Mehrshad	***									
REV.	DATE	P.O.I.S	PREP.	CHK.	APP.	AUT.	REV.	DESCRIPTION	BY	DATE	BY	DATE	REV.	APPR.	
PROJECT NAME:							املا و کلیه نسخ این نقشه و این اقتباس متعلق به شرکت ملی مناطق نفت خیز جنوب میباشد.								
PROJECT NO.:							THE ORIGINAL AND ALL COPIES OF THIS DRAWING TOGETHER WITH THE COPYRIGHT THEREIN ARE THE SOLE PROPERTY OF N.I.S.O.C./ FIELDS								
EPC CONTRACTOR:							BINAK OILFIELD DEVELOPMENT SUB-SURFACE WORK PACKAGES W007S WHF & EXTENSION OF BINAK B/C								
 															
HIRGAN ENERGY - DESIGN & INSPECTION COMPANIES							PETROIRAN DEVELOPMENT COMPANY								
							DRAWING TITLE:								
							NO CONSTRUCTION PERMITTED UNLESS DRAWING APPROVED								
							APPROVED FOR CONSTRUCTION								
							BY:								
							DATE:								
SCALE	SIZE	DRAWING NO.				SHEET NO.	REV.	BUDGET REF.	LOCATION	SIZE	CLASS	SERIAL NO.	SHEET	REVISION	
AS SHOWN	A1	BK-W007S-PEDCO-110-AR-DW-0004				04 OF 11	D04	053-073-9184	F	4	B	708045	04 OF 11	D04	

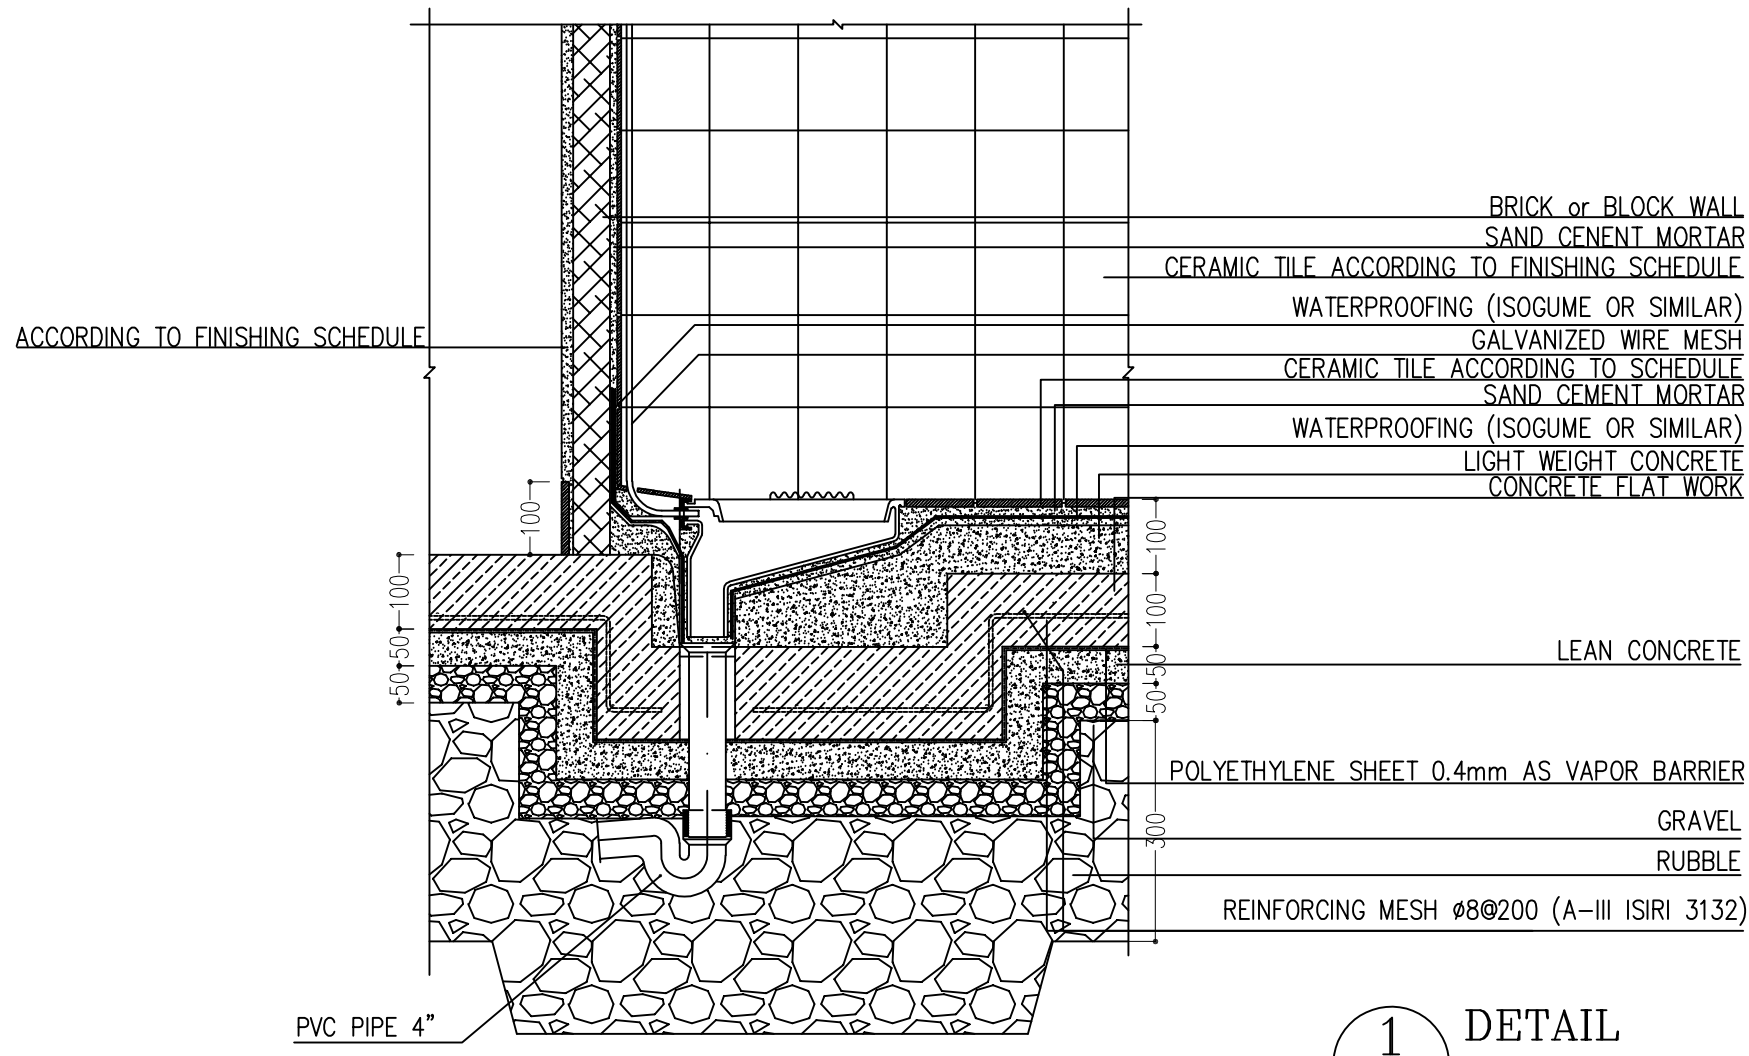


1
SC. 1:10
DETAIL

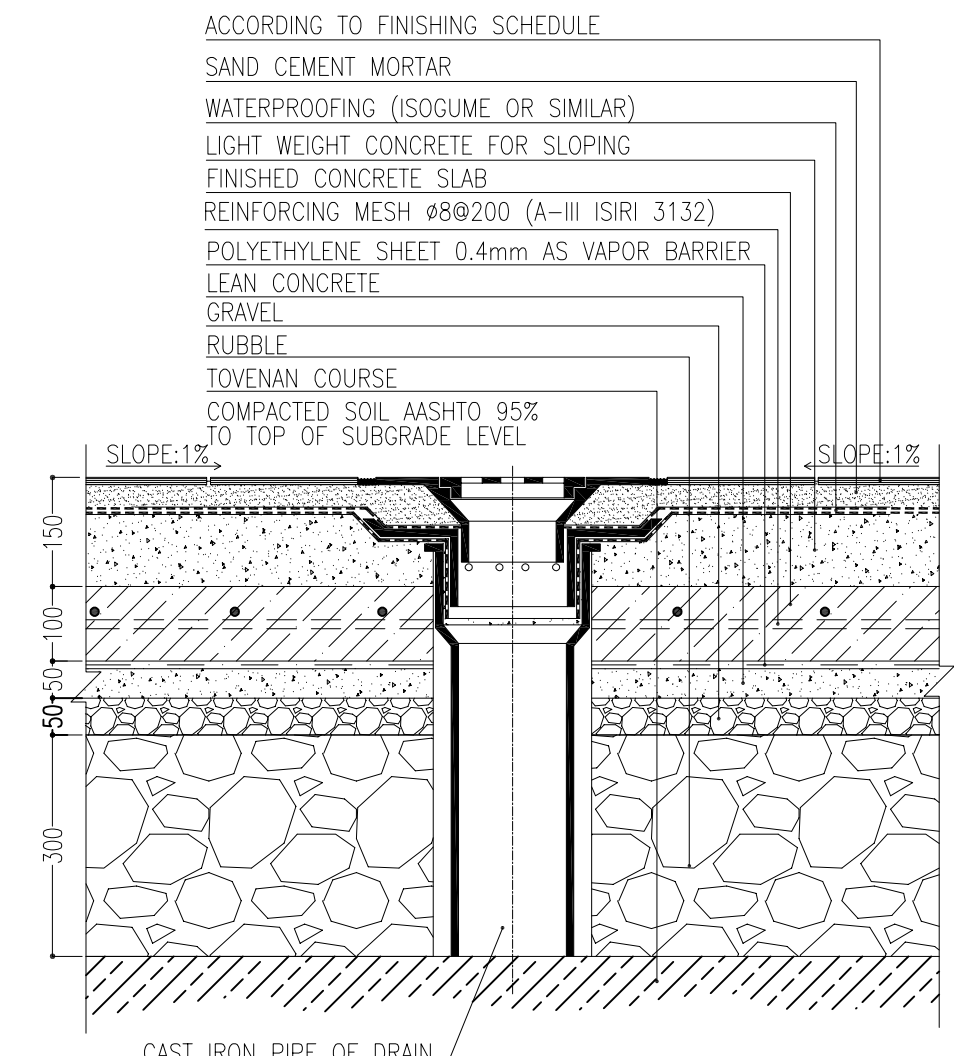


5
SC. 1:10
DETAIL

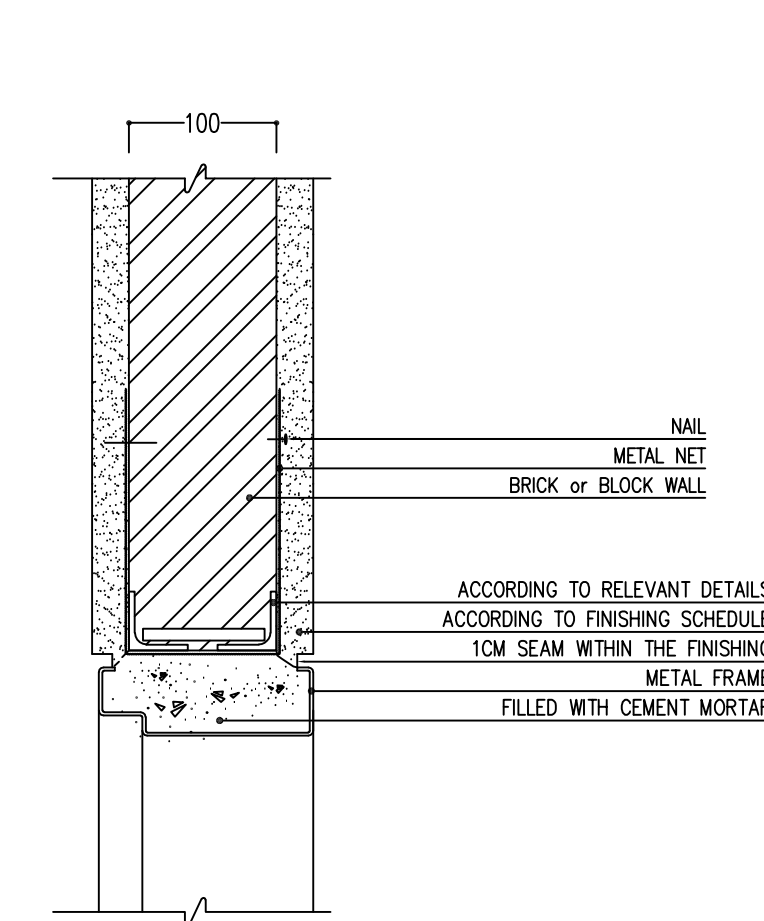


9
SC. 1:10
DETAIL

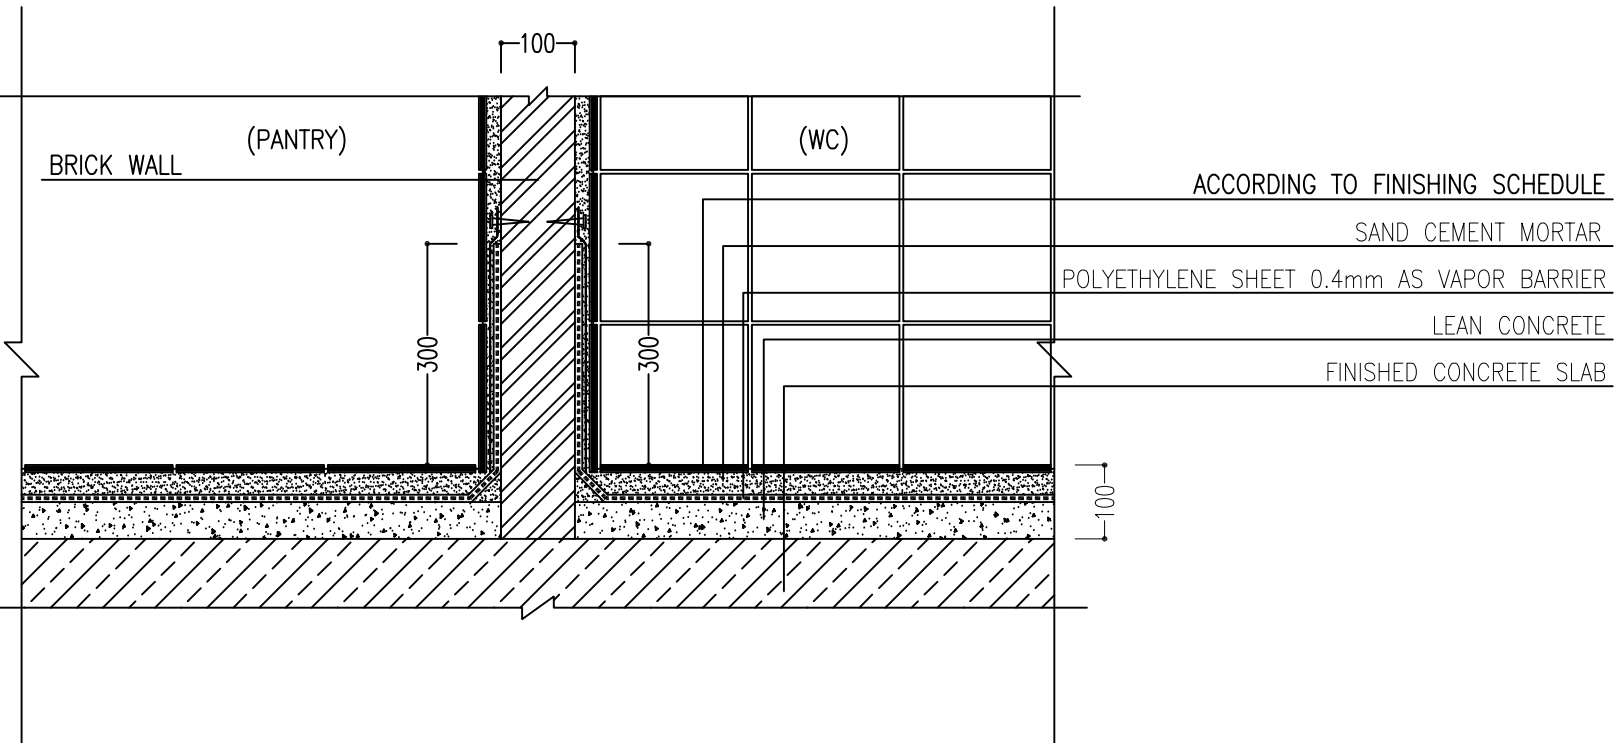


2
SC. 1:10
DETAIL

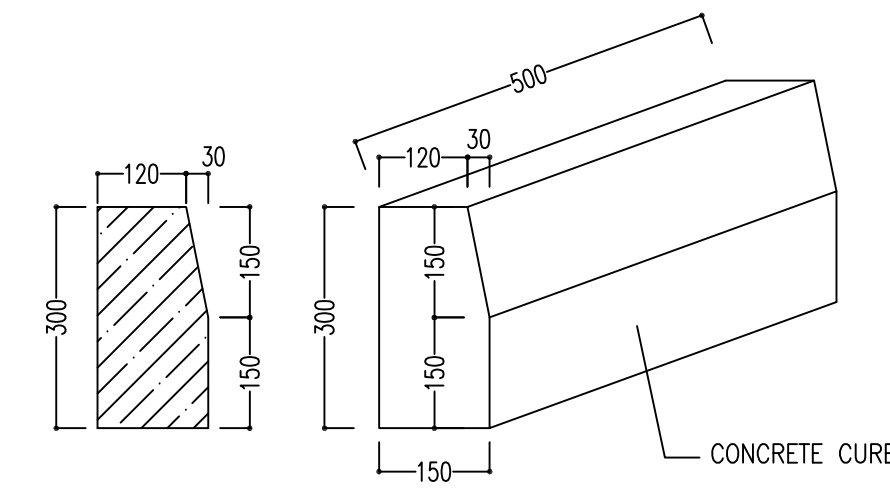


6
SC. 1:10
DETAIL

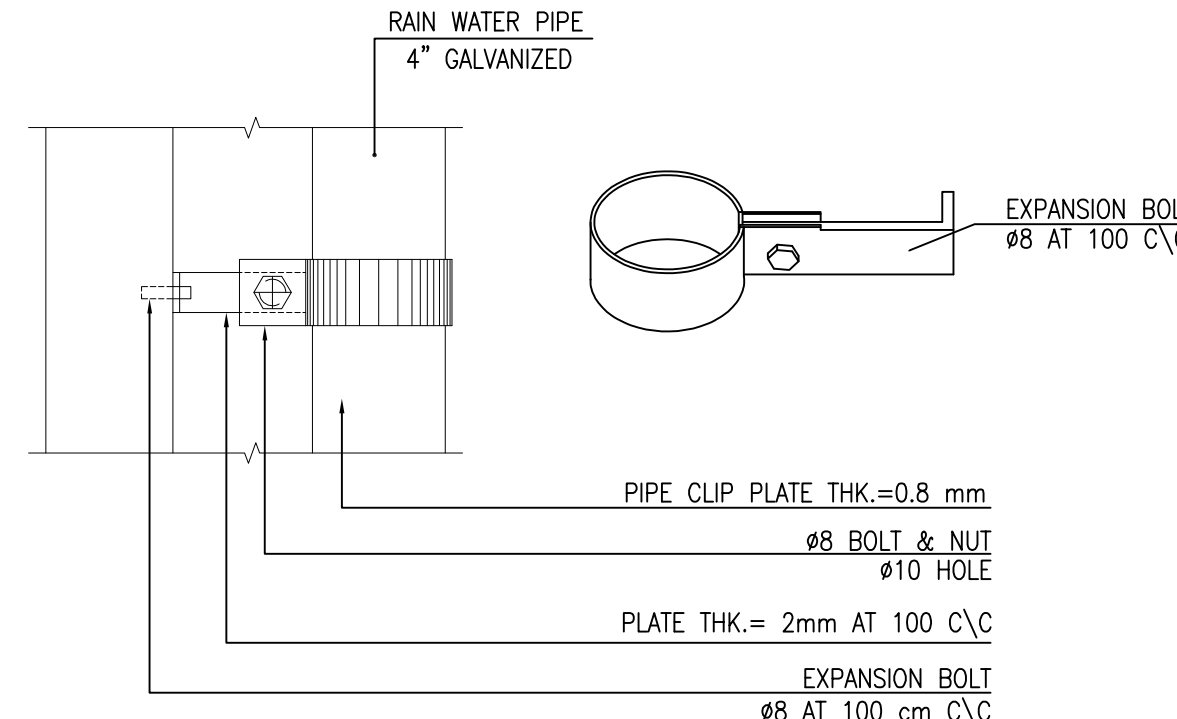


10
SC. 1:5
DETAIL

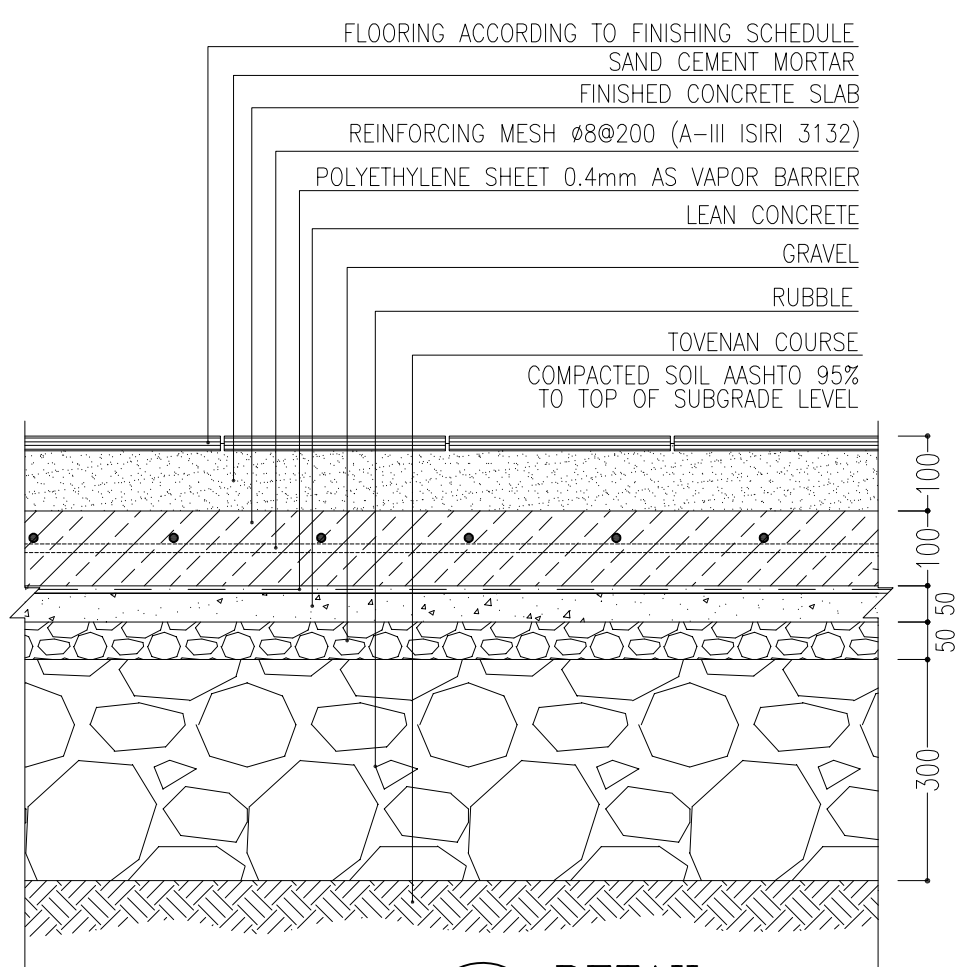


3
SC. 1:10
DETAIL

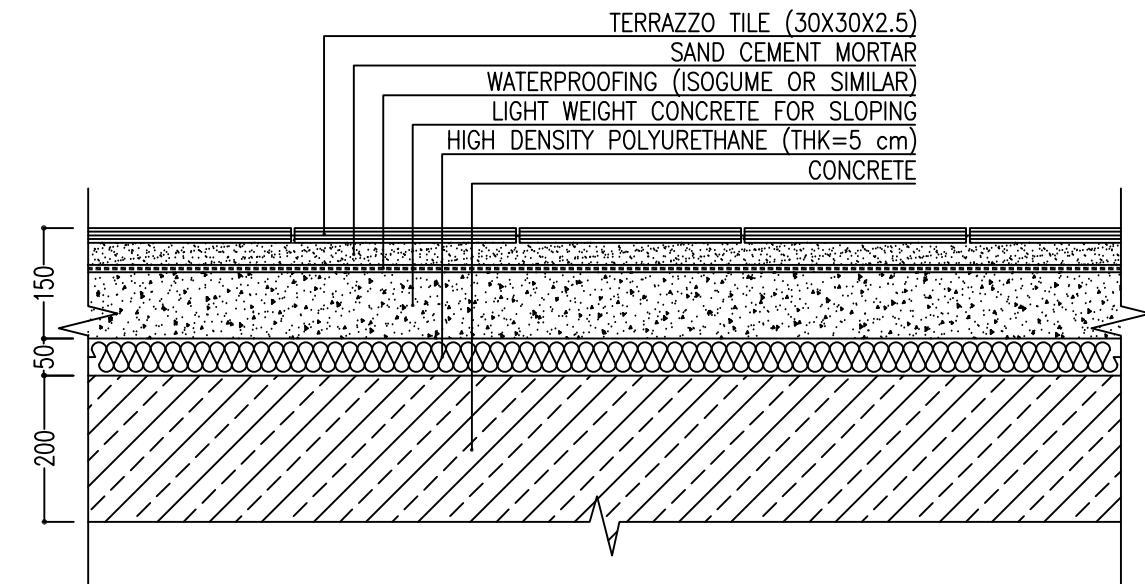


7
SC. 1:10
DETAIL

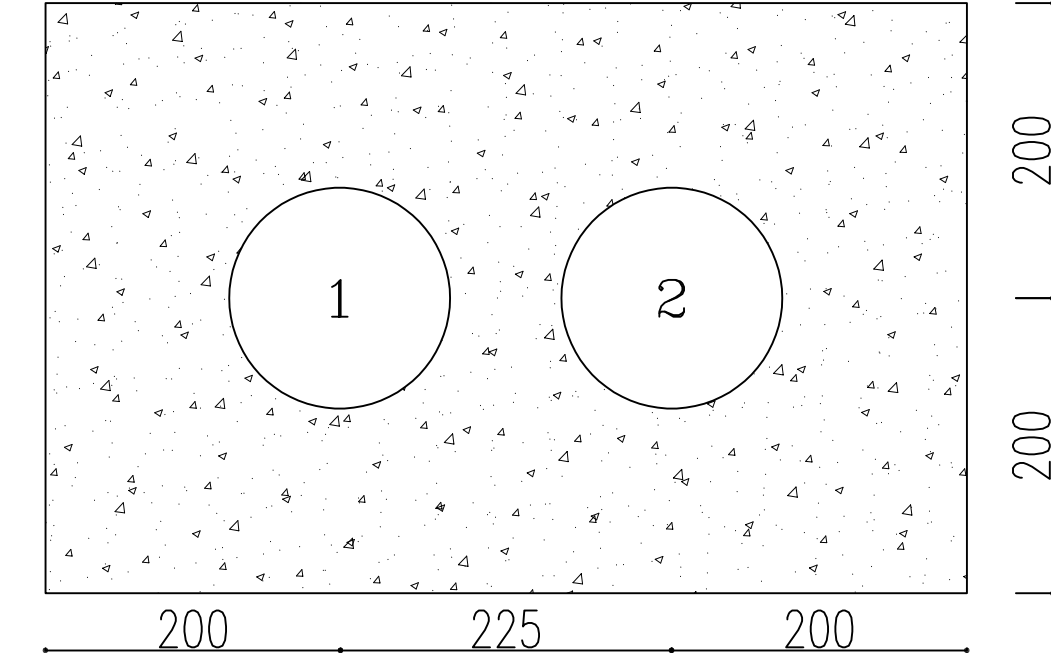

11
N.T.S
DETAIL

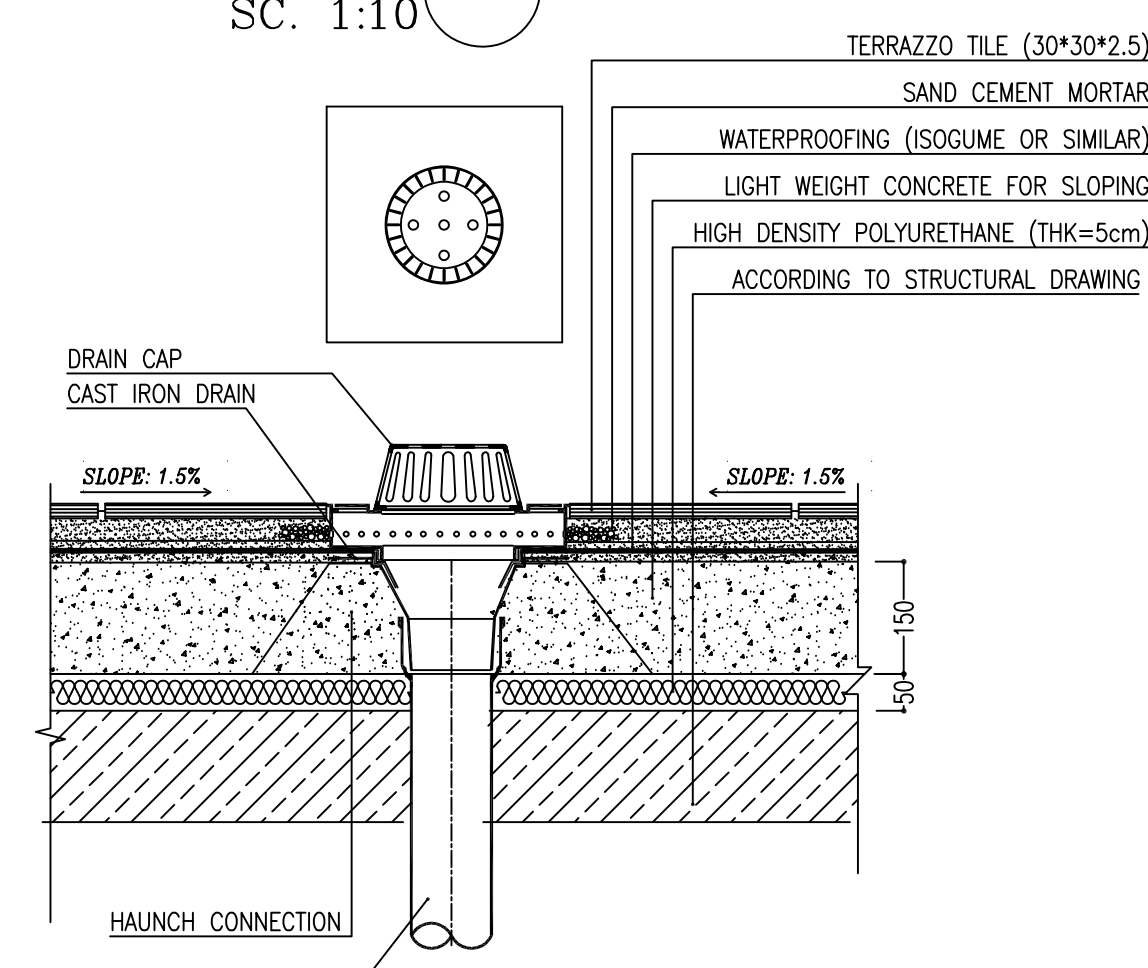

4
SC. 1:10
DETAIL

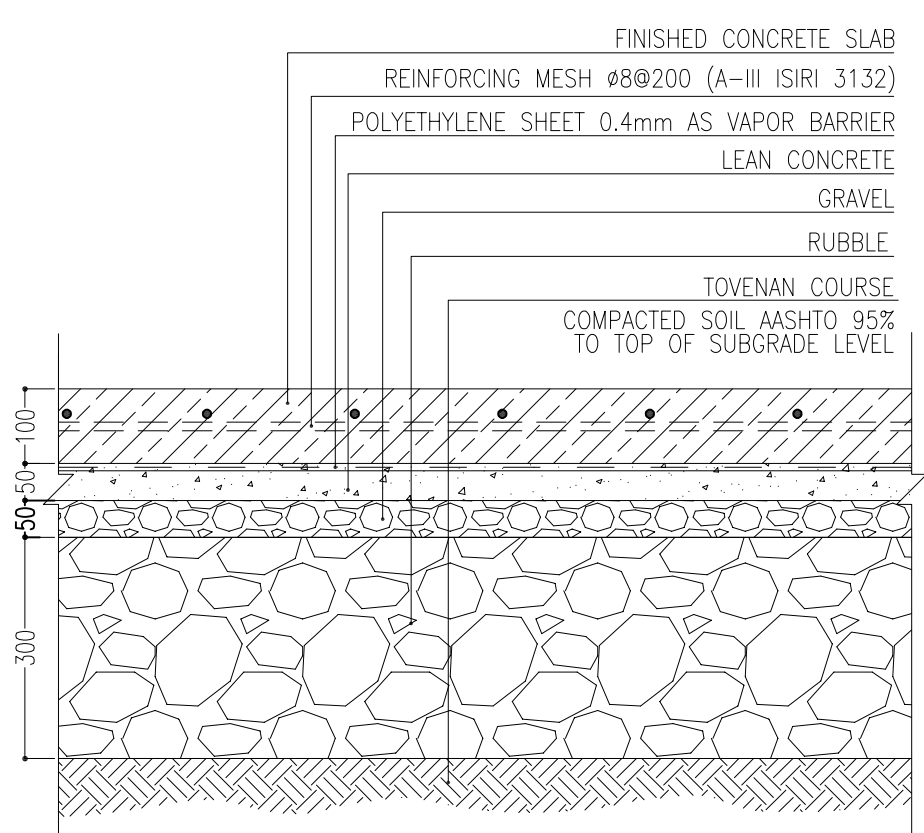


8
SC. 1:10
DETAIL

- NOTES
- 1- DIMENSIONS ARE IN "mm" AND ELEVATIONS IN "m" UNLESS SPECIFIED .
 - 2- ALL DIMENSIONS AND ELEVATIONS SHALL BE CHECKED BY THE CONTRACTOR PRIOR TO CONSTRUCTION.
 - 3- CONTRACTOR SHALL COMPARE ALL ARCHITECTURAL, MECHANICAL, ELECTRICAL, PIPING AND STRUCTURAL DRAWINGS AND IN CASE OF ANY CONFLICTS OR DISCREPANCY, INFORM THE ENGINEER.
 - 4- SLAB ON GRADE SHALL BE CONSTRUCTED AFTER EXECUTION OF CABLE TRENCH & EQUIPMENTS FOUNDATION.
 - 5- ALL MATERIALS ARE SELECTED FROM THE HIGHEST QUALITY AND SHALL BE APPROVED BY THE CLIENT.
 - 6- FOR COORDINATE REFER TO FINISH GRADING DOCUMENTS.
 - 7) REFERENCE COORDINATES E=1000,000 , N=1000,000 REFER TO X=437425 , Y=3290543 UTM.
 - 8) FINISH GRADING LEVEL (W007S) ELEVATION : +26.00 (MEAN SEA LEVEL) +26.05 m (GLOBAL) = ±0.00 (LOCAL)
 - 9) ALL EXTERNAL OPENINGS (WINDOWS AND DOORS) SHALL BE FIRE PROOF.
 - 10) DOUBLE GLAZED WINDOW WITH 24mm REINFORCED GLASS AND 6mm GAS FILLED GAP.
 - 11) WC DOORS SHALL BE WATERPROOF ABS TYPE WITH CLOSER MECHANISM.
 - 12) KNAUF GYPSUM BOARD TILES (60*60) cm (REGULAR 9.5 mm THICKNESS) WITH (1063).
 - 13) KNAUF PVC-COATED GYPSUM BOARD TILES (60*60)-(REGULAR 9.5mm THICKNESS) WITH (1063)-(PVC THICKNESS 0.35mm).



- LEGEND
- | | |
|---|---------------|
| BRICK WALL | BRICK FACING |
| ANTI-ACID CERAMIC | CEMENT SAND |
| TOVENAN COURSE | BLOCKAGE |
| POLYETHYLENE SHEET | LEAN CONCRETE |
| REINFORCED CONCRETE
ACCORDING TO STR.DWG | TERRAZZO TILE |
| CHEQUERED PLATE TRENCH CAP | |
| HOT DEEP GALVANIZED SHEET | |
| SOFT SAND | |

- | | | | |
|----------|------------------------|--------|-------------------|
| F.F.L. | FINISHED FLOOR | T.O.B. | TOP OF BEAM |
| T.O.W.A. | TOP OF WALKWAY | B.O.C. | BOTTOM OF CAGE |
| T.O.P. | TOP OF PARAPET | T.O.S. | TOP OF SLAB |
| T.O.C. | TOP OF CAGE | B.O.S. | BOTTOM OF SLEEVE |
| T.O.D. | TOP OF DOOR | T.O.F. | TOP OF FOUNDATION |
| F.G.L. | FINISHED GRADING LEVEL | | |

REFERENCE DRAWING	DRG. No.
STANDARD DRAWING FOR ARCHITECTURAL DETAILS	BK-GNRL-PEDCO-000-AR-DW-0001
STANDARD DETAILS FOR LADDER & SAFETY CAGE	BK-GNRL-PEDCO-000-ST-DW-0009
PLOT PLAN DRAWING - W007S	BK-W007S-PEDCO-110-PI-PY-0002
FOUNDATION DRAWING FOR SECURITY BUILDING FOR WELL PADS - W007S	BK-W007S-PEDCO-110-ST-DW-0008
STRUCTURAL DRAWING FOR SECURITY BUILDING FOR WELL PADS - W007S	BK-W007S-PEDCO-110-ST-DW-0009
HVAC SYSTEM LAYOUT FOR SECURITY BUILDING - W007S	BK-W007S-PEDCO-110-HV-PY-0003
PLUMBING & SEWAGE PIPING LAYOUT FOR SECURITY BUILDING - W007S	BK-W007S-PEDCO-110-HV-PY-0004
LIGHTING & SMALL POWER LAYOUT FOR SECURITY BUILDING OF WELL PADS	BK-SISGR-PEDCO-110-BL-PY-0005

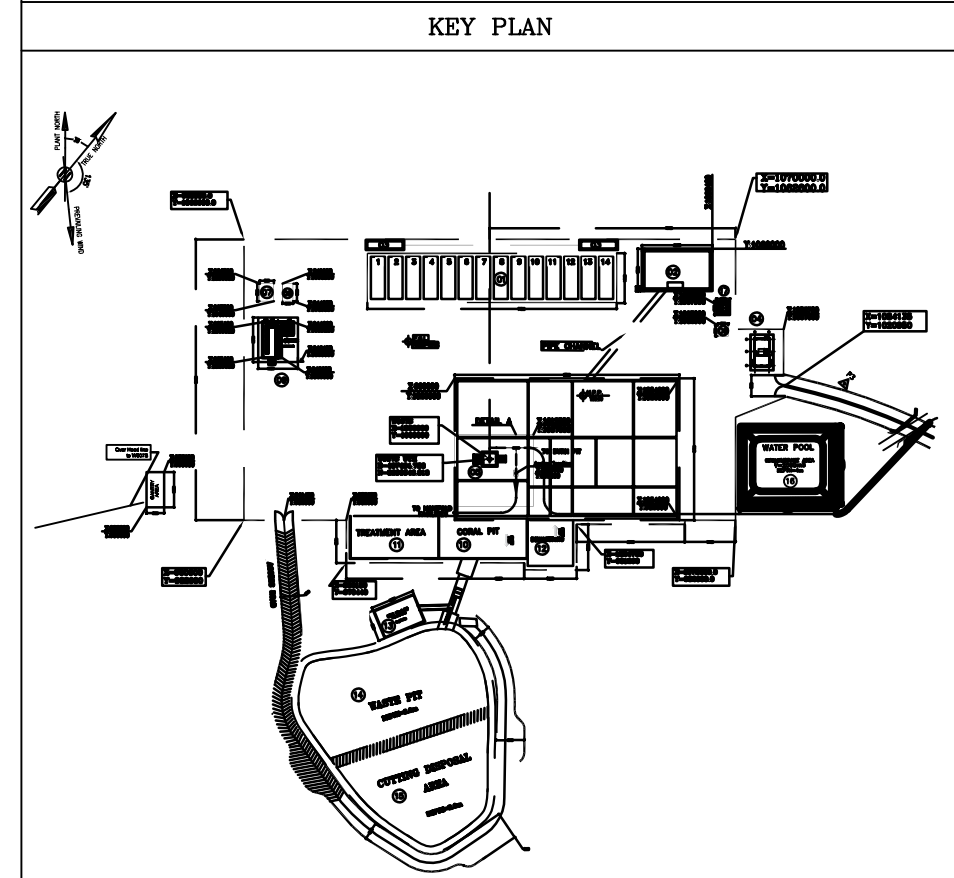

D04	OCT.2023	APC	R.BERLOUIE	M.FAKHARIAN	S.Paramarispour	** **									
D03	AUG.2023	IFA	R.BERLOUIE	M.FAKHARIAN	A.M.MOHSSENI	** **									
D02	JUN.2023	IFA	R.BERLOUIE	M.FAKHARIAN	A.M.MOHSSENI	** **	***	*****	** **	*** **	** **	*** **	*** **	*** **	*** **
D01	FEB.2023	IFA	R.BERLOUIE	M.FAKHARIAN	M.Mehrshad	** **									
D00	APR.2022	IPC	R.BERLOUIE	M.FAKHARIAN	M.Mehrshad	** **									
REV.	DATE	P.O.I.S	PREP.	CHK.	APP.	AUT.									
PROJECT NAME: BINAK OILFIELD DEVELOPMENT/SUB-SURFACE WORK PACKAGES W007S WHF & EXTENSION OF BINAK B/C															
PROJECT NO.: 971020															
EPC CONTRACTOR: HIRGAN ENERGY							EPD/EPC CONTRACTOR (GC): PETROIRAN DEVELOPMENT COMPANY								
DRAWING TITLE: ARCHITECTURAL DRAWING FOR SECURITY BUILDING OF WELL PADS - W007S DETAILS							NO CONSTRUCTION PERMITTED UNLESS DRAWING APPROVED								
SCALE AS SHOWN							APPROVED FOR CONSTRUCTION								
SIZE A1							BY:								
DRAWING NO. BK-W007S-PEDCO-110-AR-DW-0004							DATE:								
SHEET NO. 06 OF 11							BUDGET REF. LOCATION								
REV. D04							SIZE CLASS								
B053-073-9184							SERIAL NO. 708045								
							SHEET REVISION								
							06 OF 11 D04								

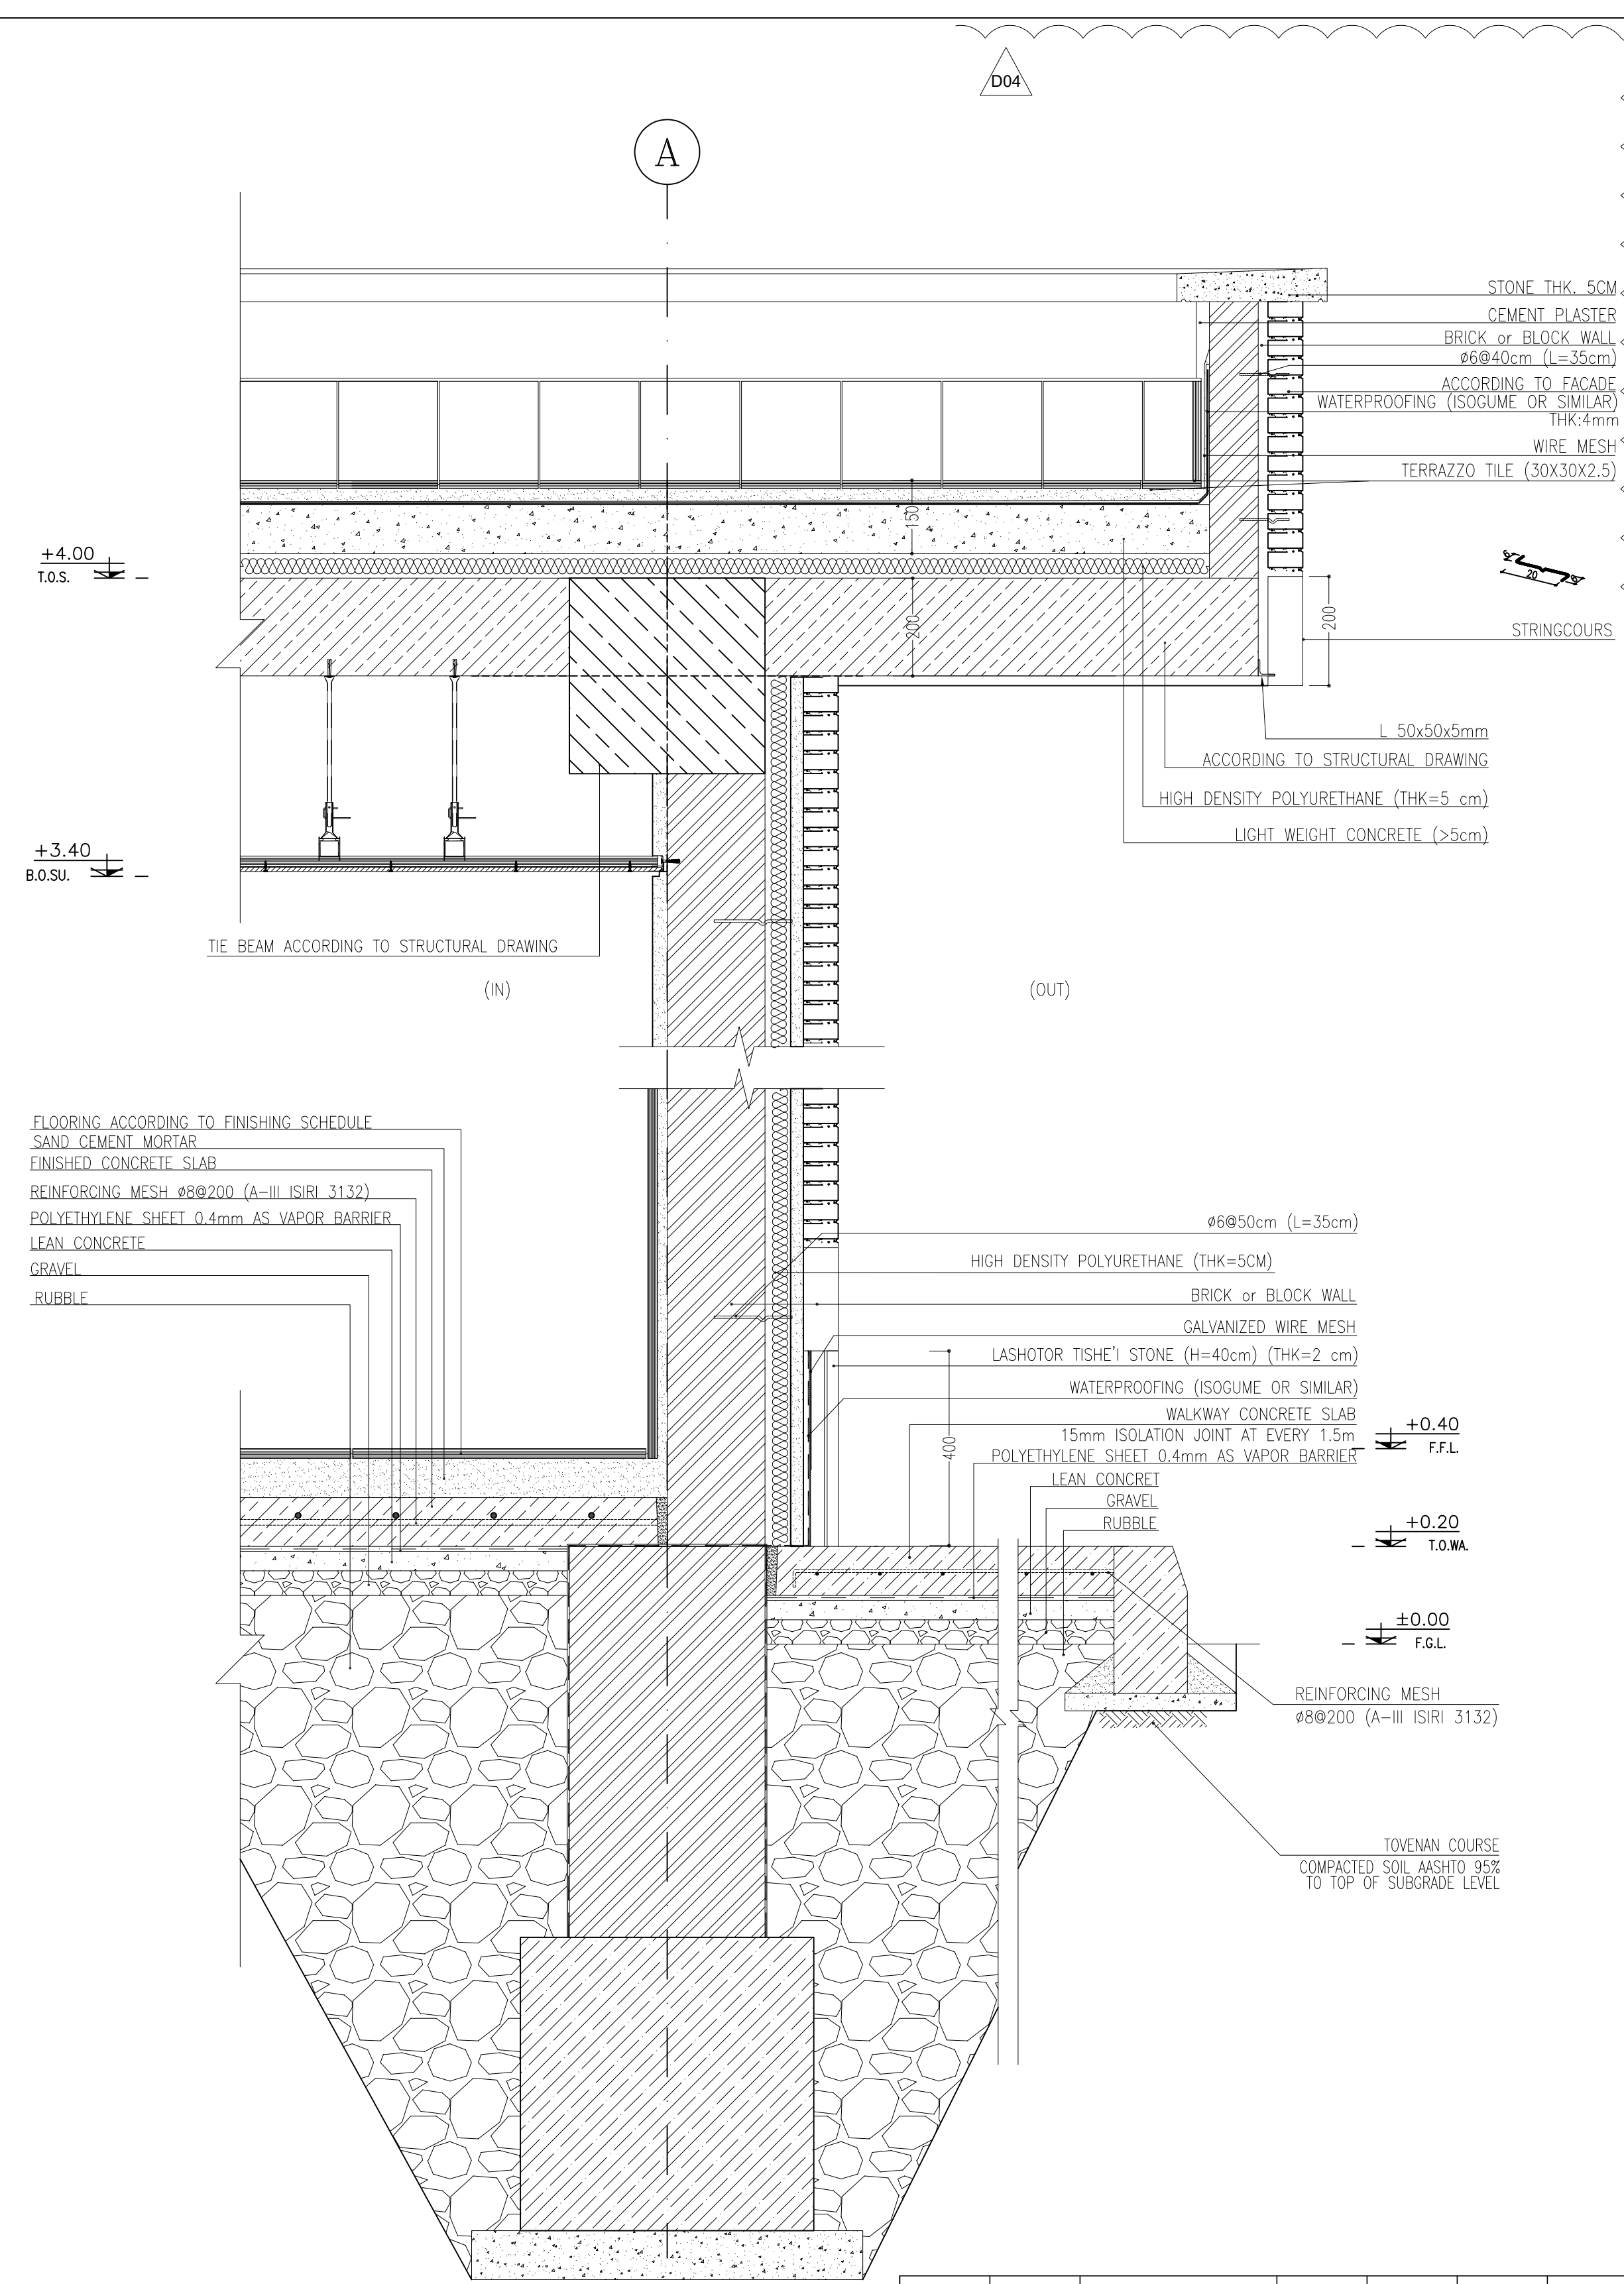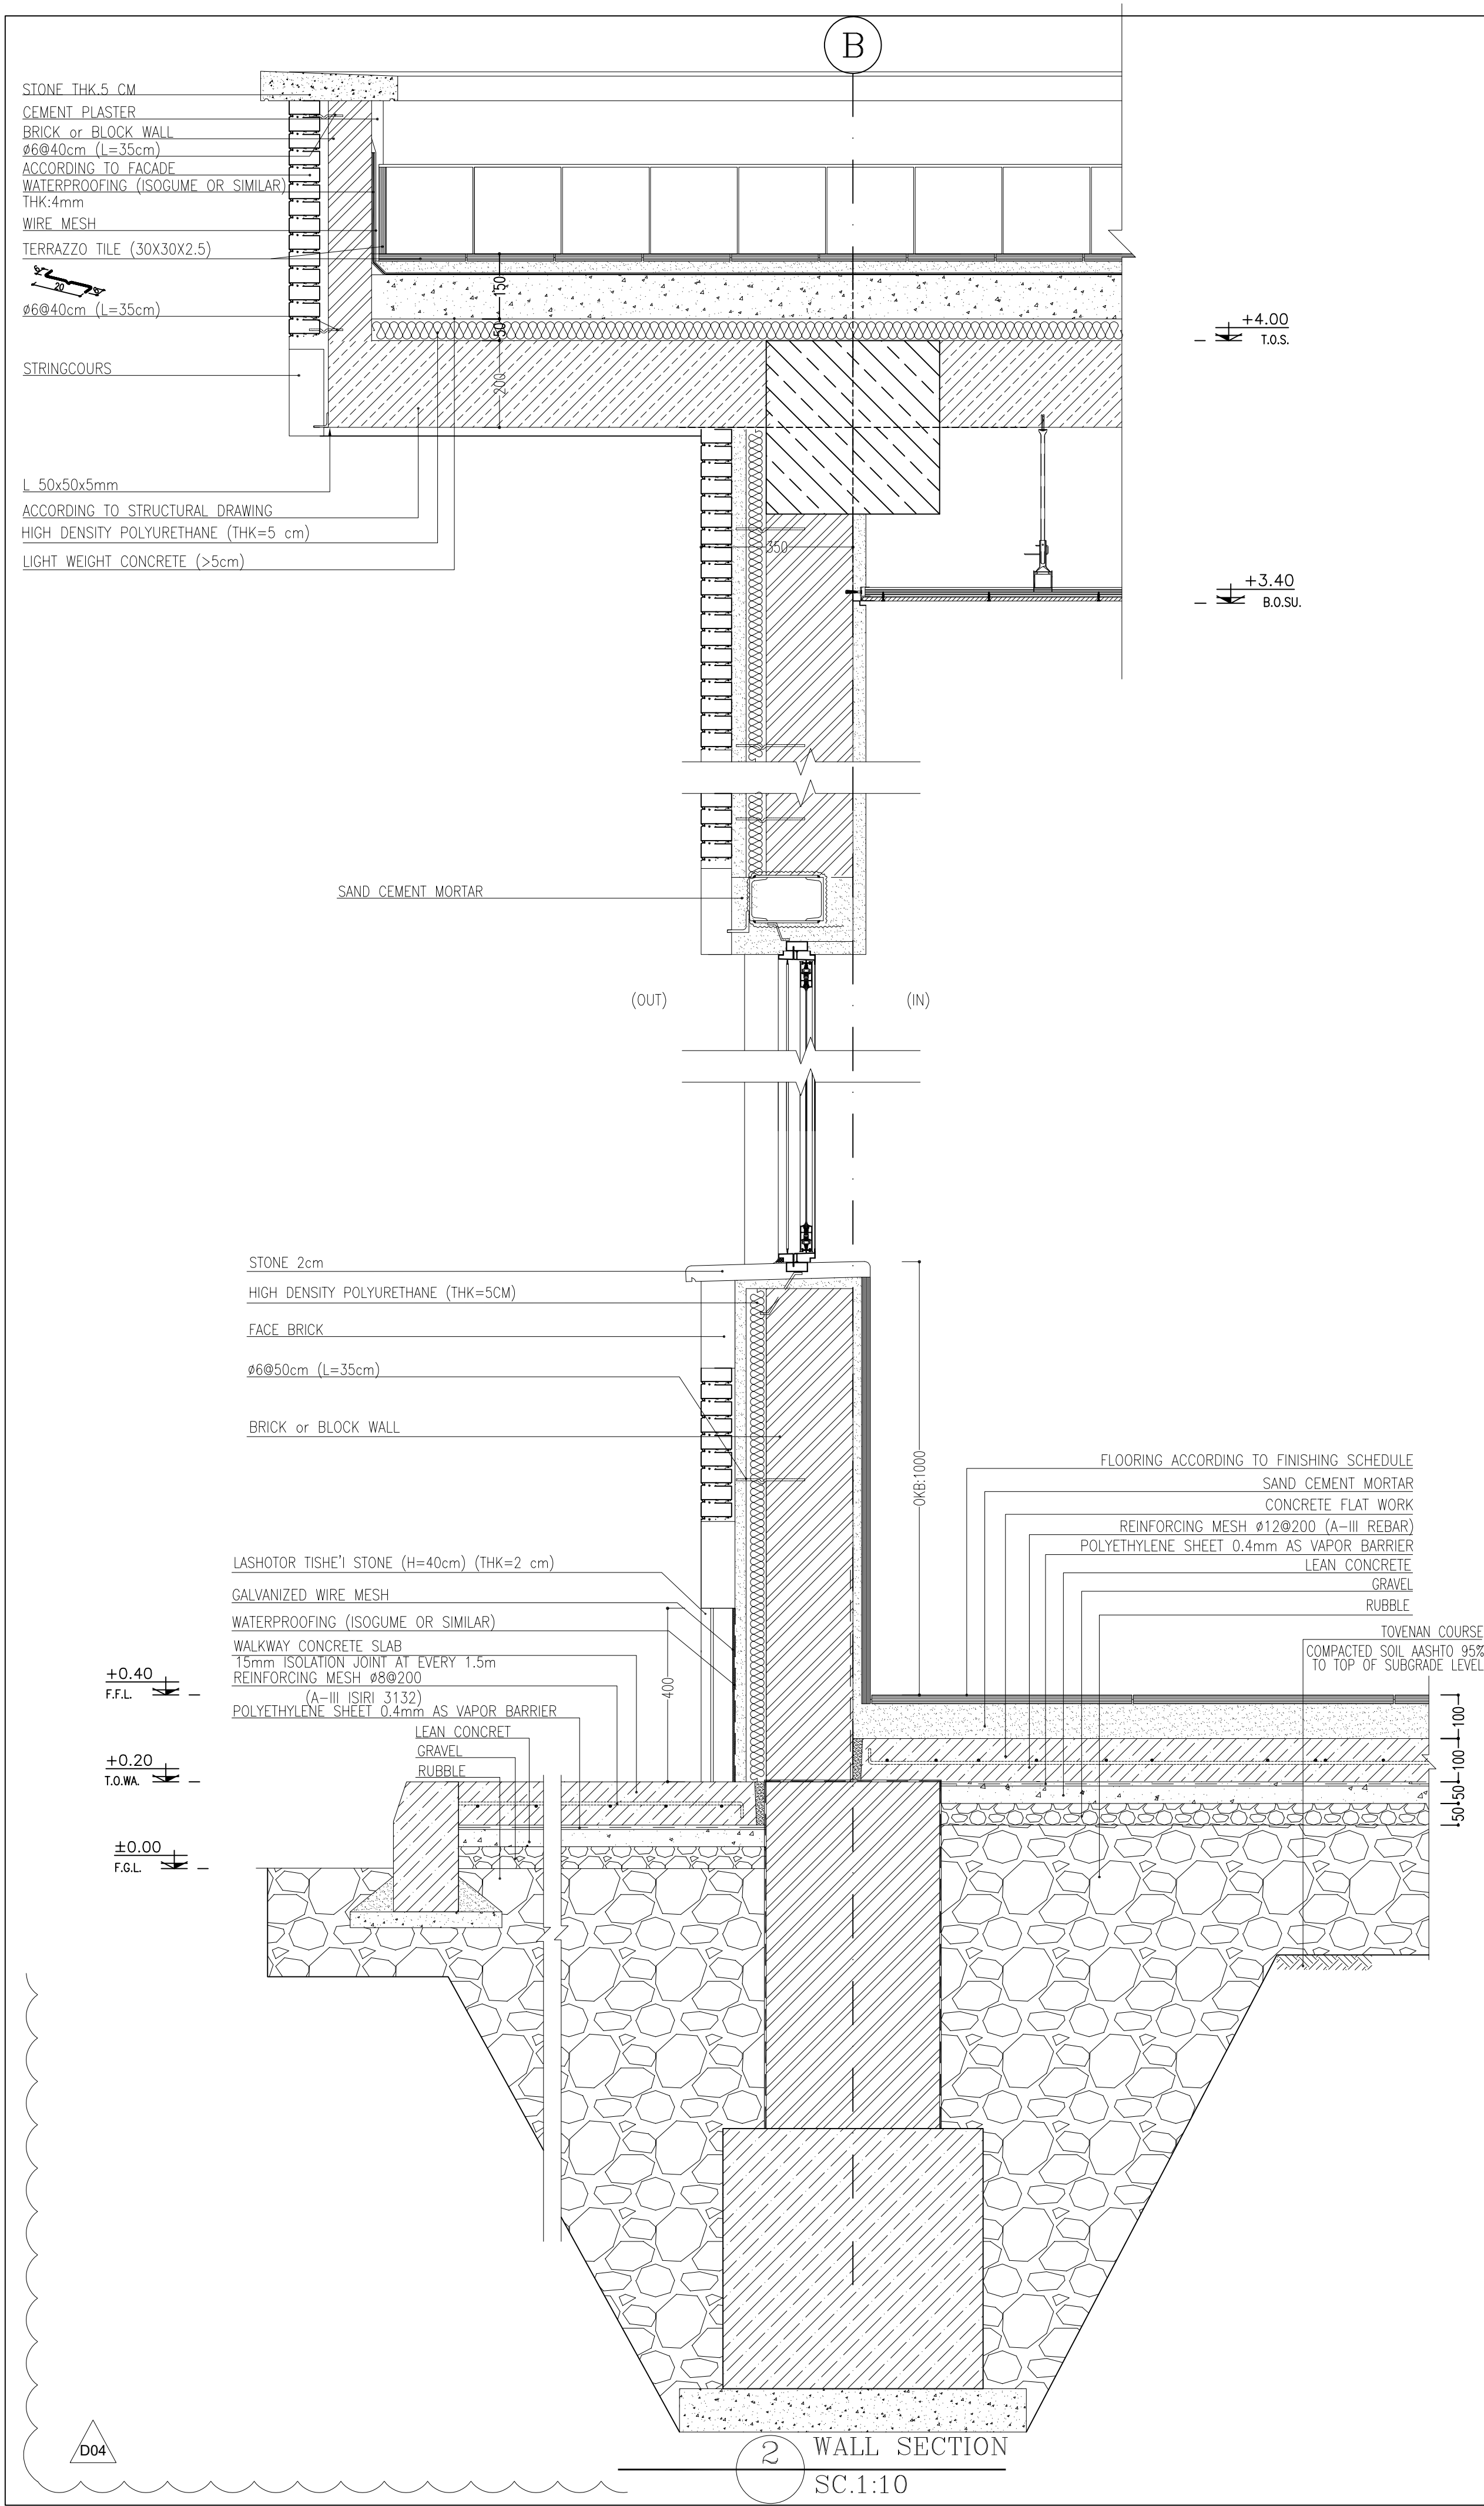

1 WALL SECTION
SC.1:10

NOTES


- 1- DIMENSIONS ARE IN "mm" AND ELEVATIONS IN "m" UNLESS SPECIFIED .
- 2- ALL DIMENSIONS AND ELEVATIONS SHALL BE CHECKED BY THE CONTRACTOR PRIOR TO CONSTRUCTION.
- 3- CONTRACTOR SHALL COMPARE ALL ARCHITECTURAL, MECHANICAL, ELECTRICAL, PIPING AND STRUCTURAL DRAWINGS AND IN CASE OF ANY CONFLICTS OR DISCREPANCY, INFORM THE ENGINEER.
- 4- SLAB ON GRADE SHALL BE CONSTRUCTED AFTER EXECUTION OF CABLE TRENCH & EQUIPMENTS FOUNDATION.
- 5- ALL MATERIALS ARE SELECTED FROM THE HIGHEST QUALITY AND SHALL BE APPROVED BY THE CLIENT.
- 6- FOR COORDINATE REFER TO FINISH GRADING DOCUMENTS.
- 7) REFERENCE COORDINATES E=1000.000 , N=1000.000 REFER TO X=437425 , Y=3290543 UTM.
- 8) FINISH GRADING LEVEL (W007S) ELEVATION : +26.00 (MEAN SEA LEVEL) ±26.05 m (GLOBAL) = ±0.00 (LOCAL)
- 9) ALL EXTERNAL OPENINGS (WINDOWS AND DOORS) SHALL BE FIRE PROOF.
- 10) DOUBLE GLAZED WINDOW WITH 246mm REINFORCED GLASS AND 6mm GAS FILLED GAP.
- 11) WC DOORS SHALL BE WATERPROOF ABS TYPE WITH CLOSER MECHANISM.
- 12) KNAUF GYPSUM BOARD TILES (60*60) cm (REGULAR 9.5 mm THICKNESS) WITH (1063).
- 13) KNAUF PVC-COATED GYPSUM BOARD TILES (60*60)-(REGULAR 9.5mm THICKNESS) WITH (1063)-(PVC THICKNESS 0.35mm).

LEGEND

BRICK WALL	BRICK FACING
ANTI-ACID CERAMIC	CEMENT SAND
TOVENAN COURSE	BLOCKAGE
POLYETHYLENE SHEET	LEAN CONCRETE
REINFORCED CONCRETE ACCORDING TO STR.DWG	TERRAZZO TILE
CHEQUERED PLATE TRENCH CAP	
HOT DEEP GALVANIZED SHEET	
SOFT SAND	


F.F.L. FINISHED FLOOR T.O.B. TOP OF BEAM
T.O.WA. TOP OF WALKWAY B.O.C. BOTTOM OF CAGE
T.O.P. TOP OF PARAPET T.O.S. TOP OF SLAB
T.O.C. TOP OF CAGE B.O.S. BOTTOM OF SLEEVE
T.O.D. TOP OF DOOR T.O.F. TOP OF FOUNDATION
F.G.L. FINISHED GRADING LEVEL

REFERENCE DRAWING	DRG. No.
STANDARD DRAWING FOR ARCHITECTURAL DETAILS	BK-GNRL-PEDCO-000-AR-DW-0001
STANDARD DETAILS FOR LADDER & SAFETY CAGE	BK-GNRL-PEDCO-000-ST-DW-0009
PLOT PLAN DRAWING - W007S	BK-W007S-PEDCO-110-PI-PY-0002
FOUNDATION DRAWING FOR SECURITY BUILDING FOR WELL PADS - W007S	BK-W007S-PEDCO-110-ST-DW-0008
STRUCTURAL DRAWING FOR SECURITY BUILDING FOR WELL PADS - W007S	BK-W007S-PEDCO-110-ST-DW-0009
HVAC SYSTEM LAYOUT FOR SECURITY BUILDING - W007S	BK-W007S-PEDCO-110-HV-PY-0003
PLUMBING & SEWAGE PIPING LAYOUT FOR SECURITY BUILDING - W007S	BK-W007S-PEDCO-110-HV-PY-0004
LIGHTING & SMALL POWER LAYOUT FOR SECURITY BUILDING OF WELL PADS	BK-SIGRL-PEDCO-110-EL-PY-0005

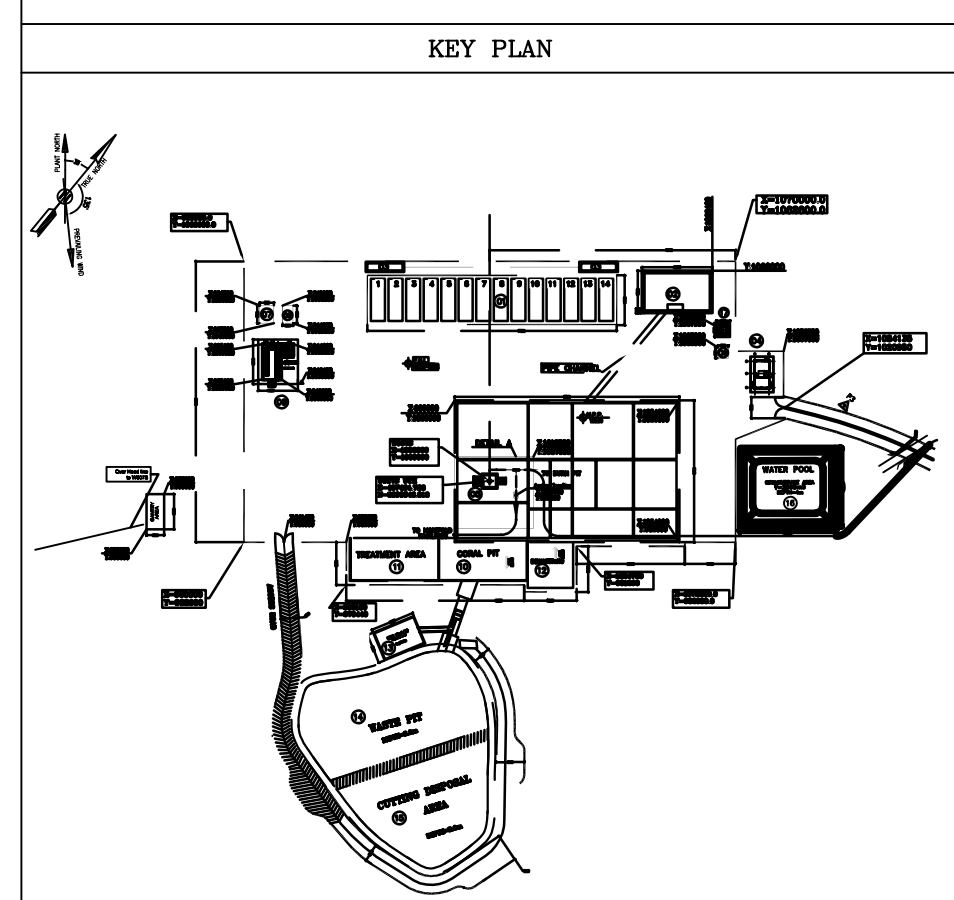


D04	OCT.2023	APC	R.BERLOUIE	M.PAKHARIAN	S.Paramaripour	** **
D03	AUG.2023	IFA	R.BERLOUIE	M.PAKHARIAN	A.M.MOHSSENI	** **
D02	JUN.2023	IFA	R.BERLOUIE	M.PAKHARIAN	A.M.MOHSSENI	** **
D01	FEB.2023	IFA	R.BERLOUIE	M.PAKHARIAN	M.Mehrshad	** **
D00	APR.2022	IPC	R.BERLOUIE	M.PAKHARIAN	M.Mehrshad	** **
REV.	DATE	P.O.I.S	PREP.	CHK.	APP.	AUT.
PROJECT NAME: BINAK OILFIELD DEVELOPMENT/SUB-SURFACE WORK PACKAGES W007S WHF & EXTENSION OF BINAK B/C						
PROJECT NO.:			971020			
EPC CONTRACTOR:			EPD/EPC CONTRACTOR (GC):			
 HIRGAN ENERGY - DESIGN & INSPECTION COMPANIES			 PETROIRAN DEVELOPMENT COMPANY			
DRAWING TITLE: ARCHITECTURAL DRAWING FOR SECURITY BUILDING OF WELL PADS - W007S DETAILS						
SCALE	SIZE	DRAWING NO.			SHEET NO.	RE
AS SHOWN	A1	BK-W007S-PEDCO-110-AR-DW-0004			07 OF 11	DC

REV.	DESCRIPTION	BY	DATE	BY	DATE
REV.	DESCRIPTION	BY	DATE	BY	DATE
THE ORIGINAL AND ALL COPIES OF THIS DRAWING TOGETHER WITH THE COPYRIGHT THEREIN ARE THE SOLE PROPERTY OF N.I.S.O.C./ FIELDS					
BINAK OILFIELD DEVELOPMENT SUB-SURFACE WORK PACKAGES W007S WHF & EXTENSION OF BINAK B/C					
DATE	SCALE	DRAWING BY	CHECKED BY	PROJECT ENG.	
NO CONSTRUCTION PERMITTED UNLESS DRAWING APPROVED					
APPROVED FOR CONSTRUCTION		BY:	DATE:		
SCALE	SIZE	DRAWING NO.	SHEET NO.	REV.	BUDGET REF.
AS SHOWN	A1	BK-W007S-PEDCO-110-AR-DW-0004	07 OF 11	D04	053-073-9184


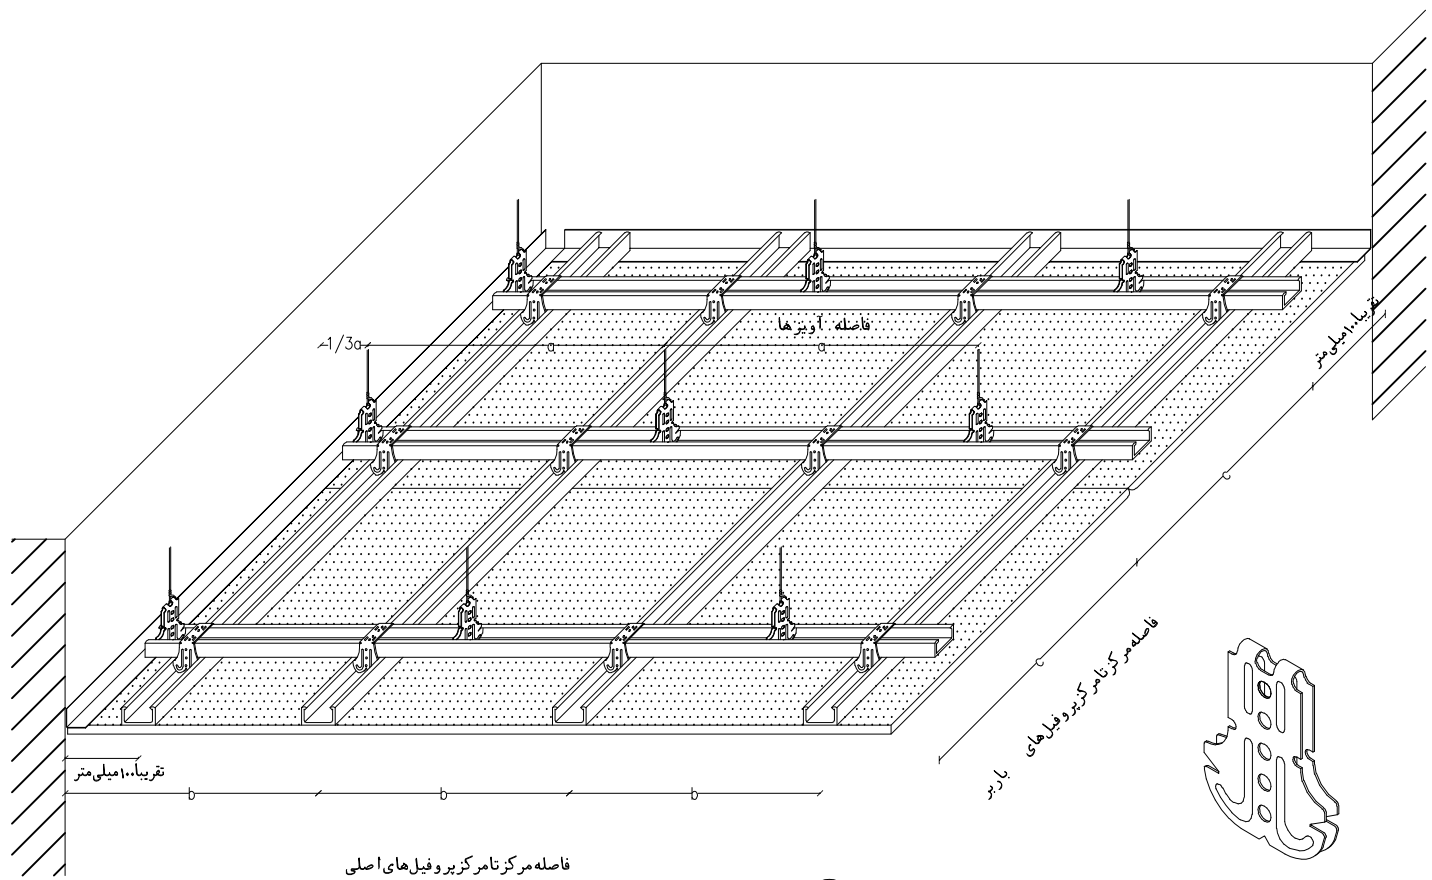


انبار دهانه های صنعتی روکشدار کپسول مختلف (mm)			
نوع صفحه روکشدار کپسول	ضخامت mm	لایه گذاری عبور سازه ها	فاصله بین رویش های متقاطع به میلی متر
منحرفه مسطح	12.5 15 18	500 550 600	400


فواصل در زیر سازی فلزی (میلیمتر)			
فاصله آویزها	900	750	600
فاصله مرکز نام مرکز بر روی دیوارهای باریک	1000	750	600

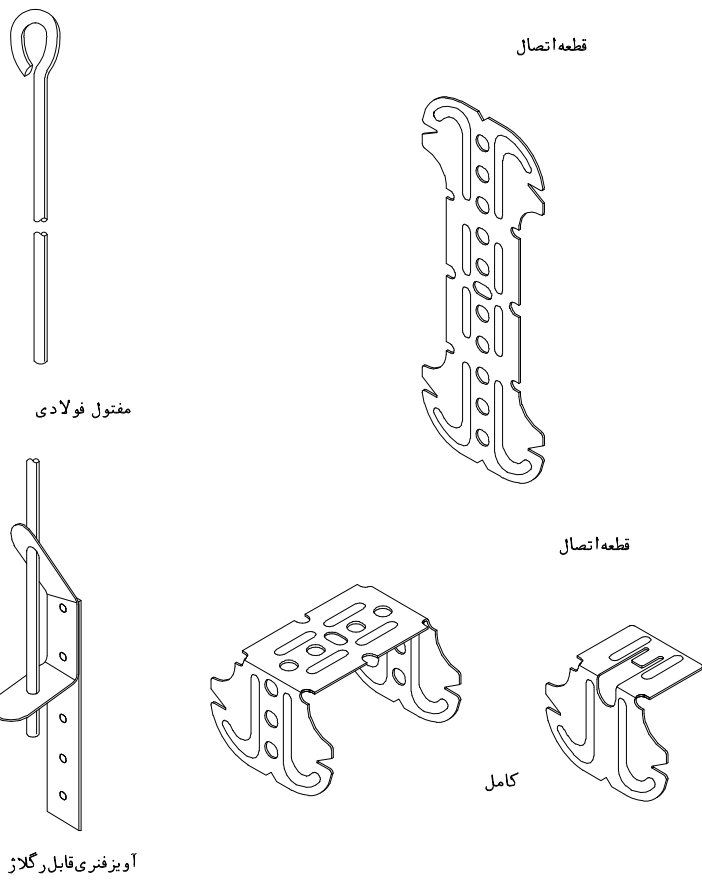

DETAIL FALSE ROOF
SC. N.T.S

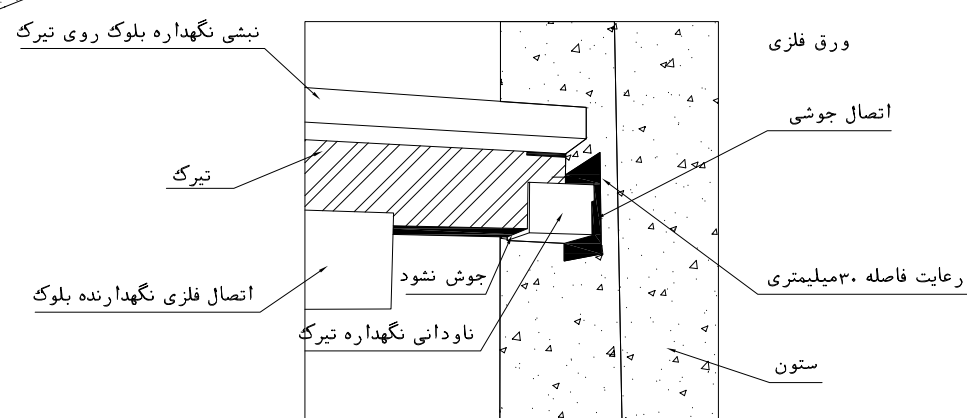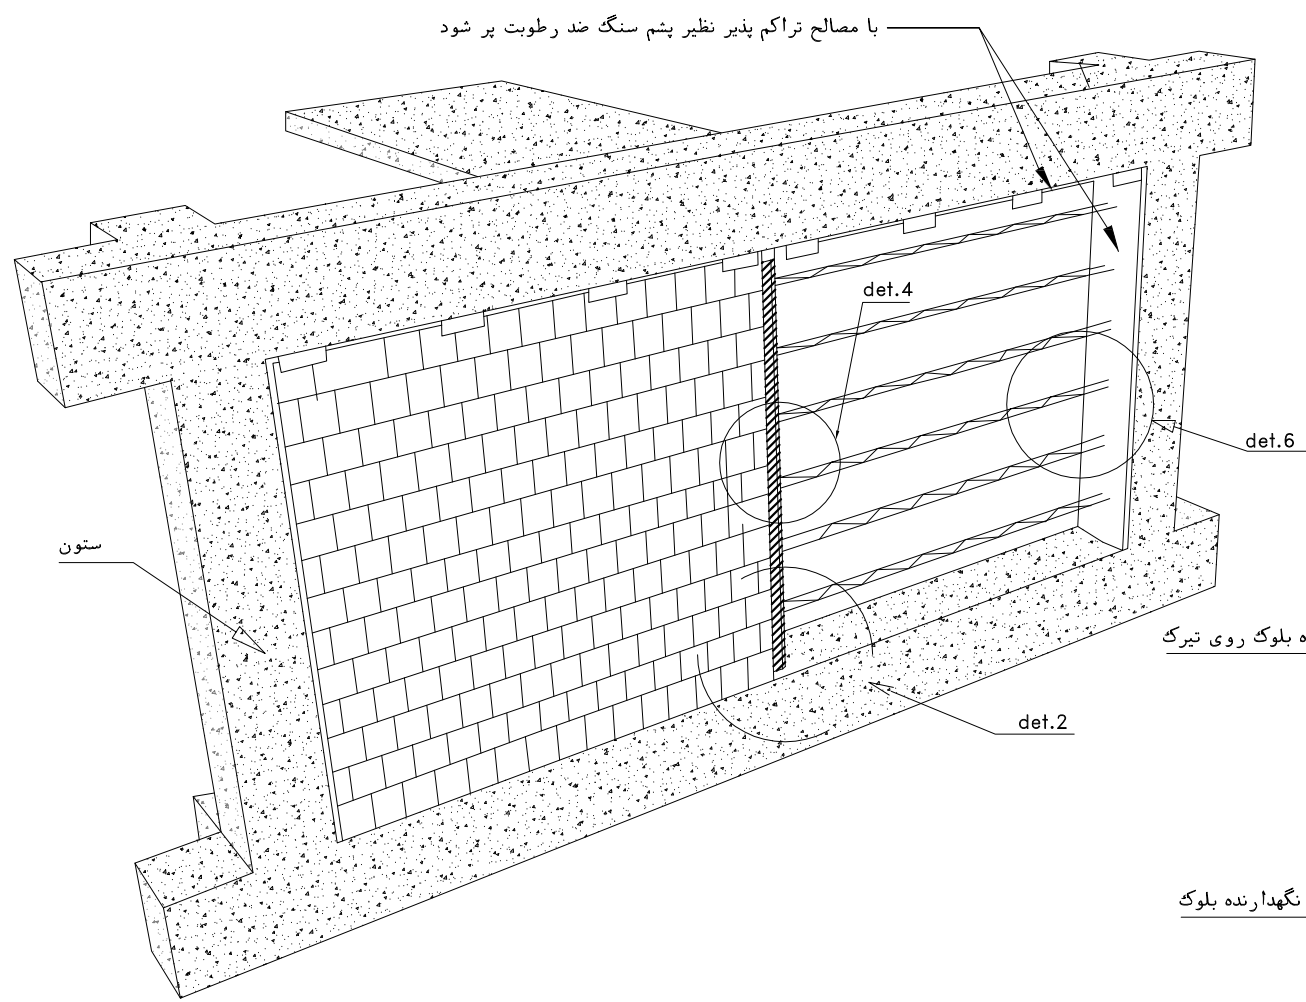




جزئیات انصال تیرک به ستون بتنی
def.1

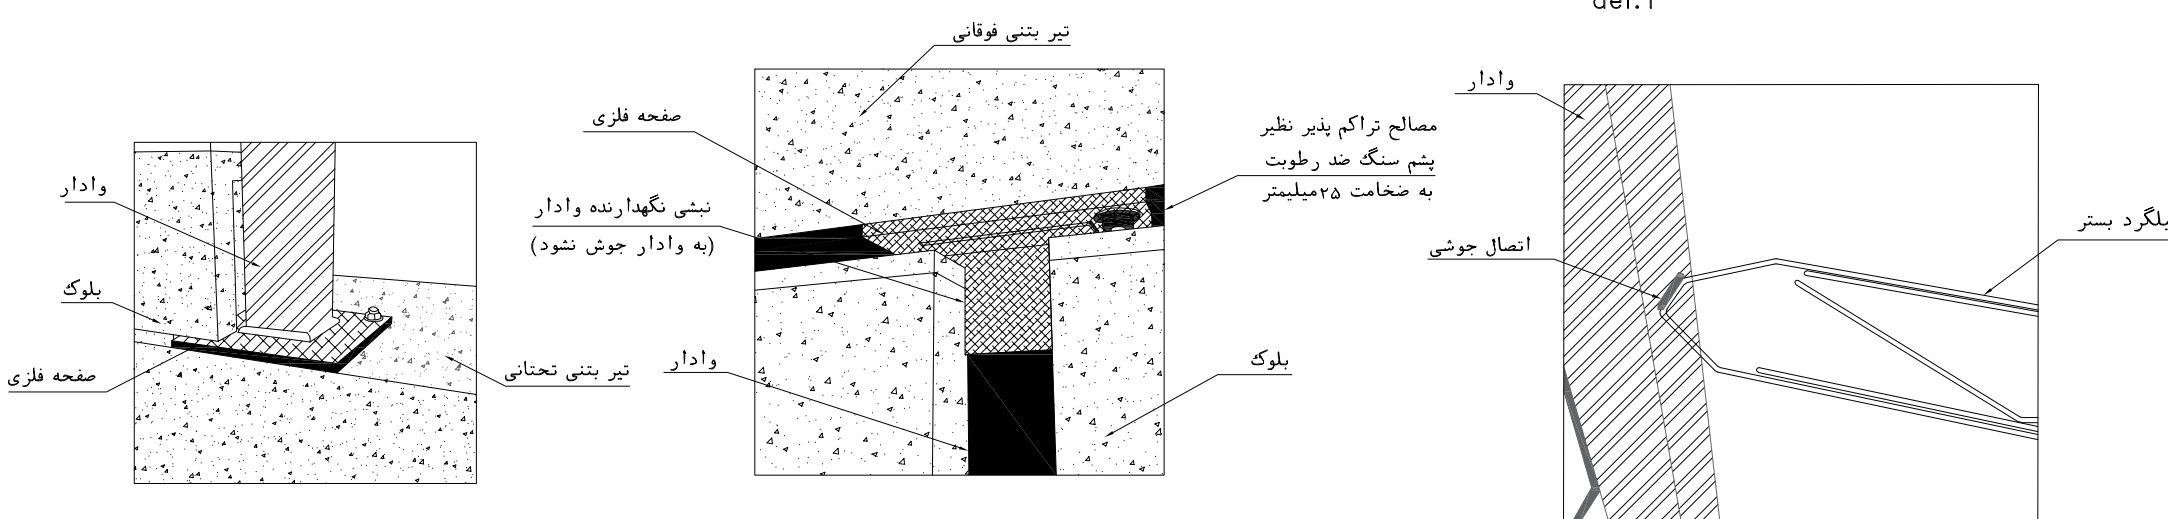



جزئیات انصال وادار میانی روی تیر تحتانی
def.2

جزئیات انصال وادار به زیر تیر فوقانی
def.3


جزئیات انصال میلگرد بستر به وادار
def.4

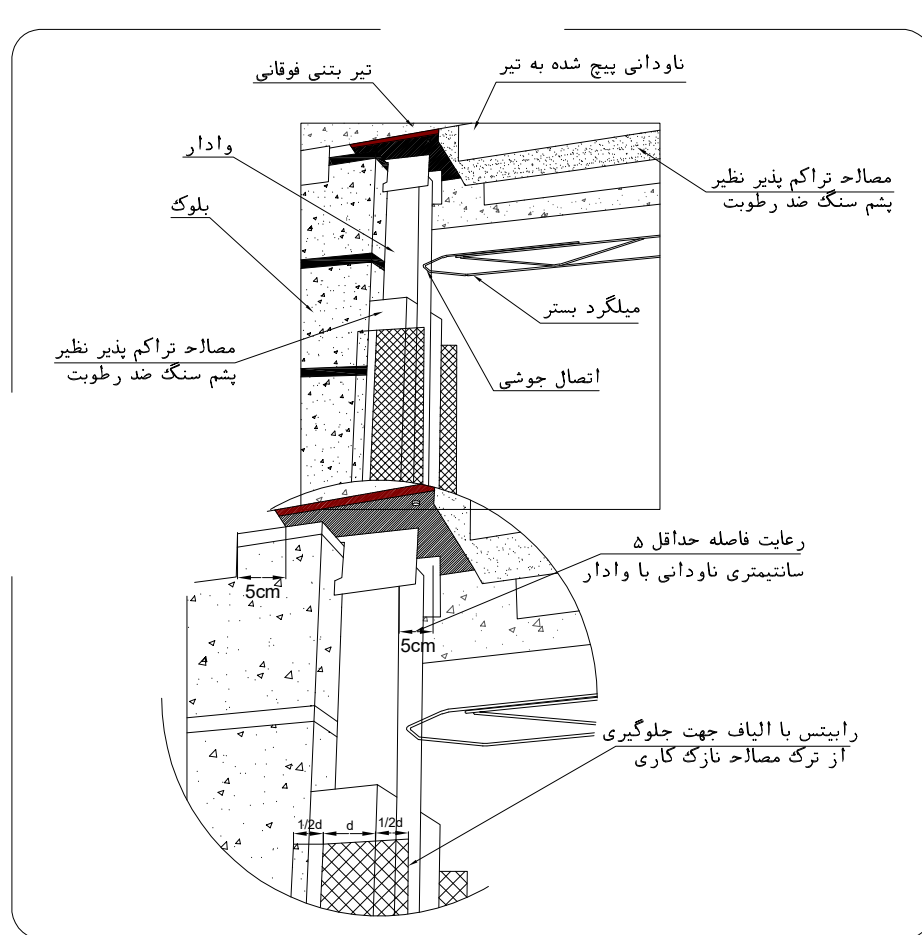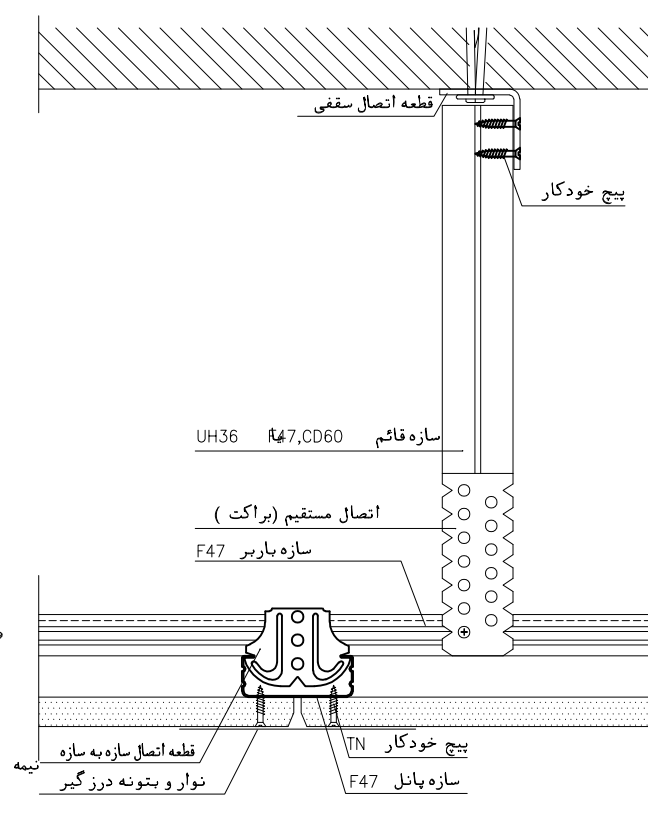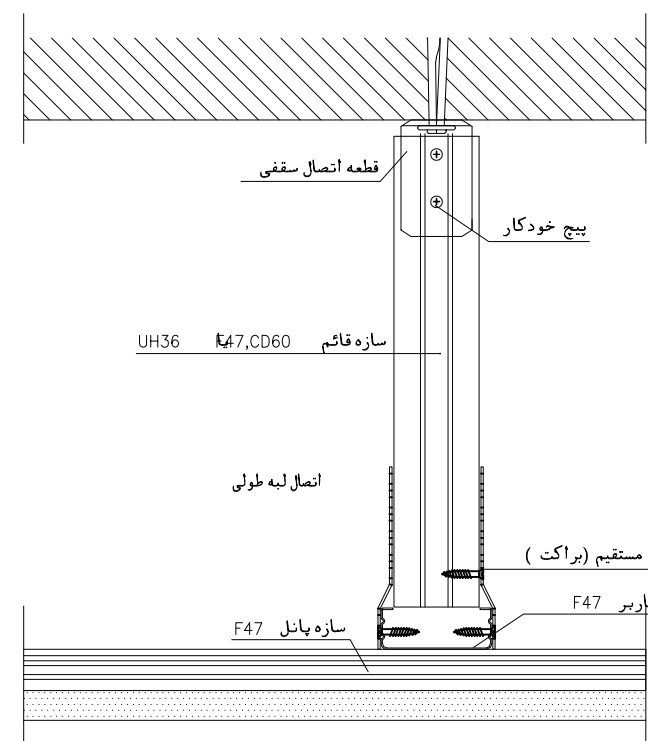

اجرای عایق پشم سنگ و مش الیاف یا رابینس بر روی وادار

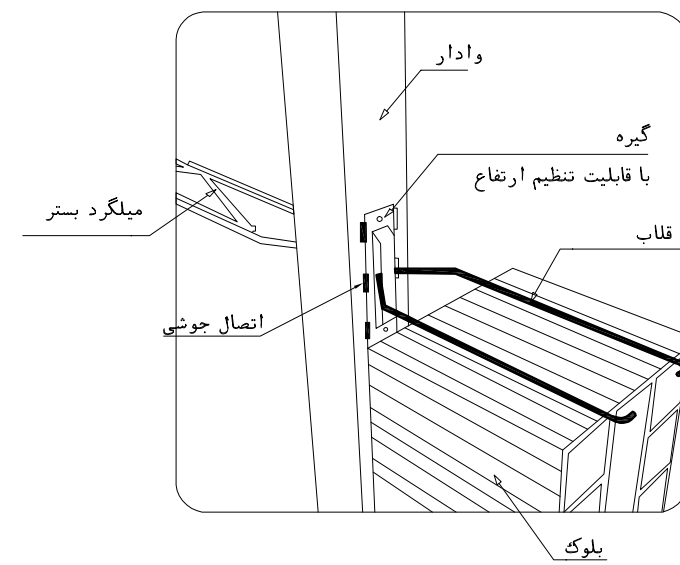
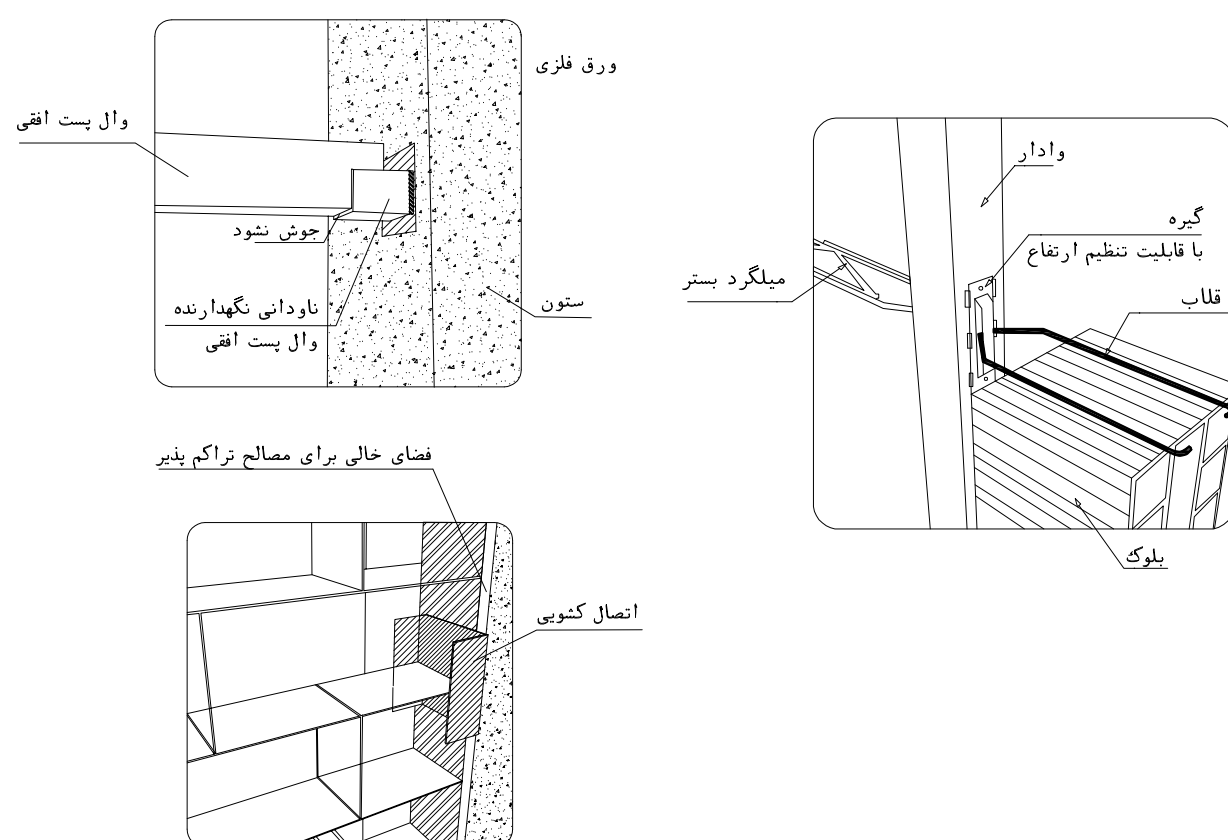


میلگرد بستر در فاصله بین وادارها و اتصال آن به وادار

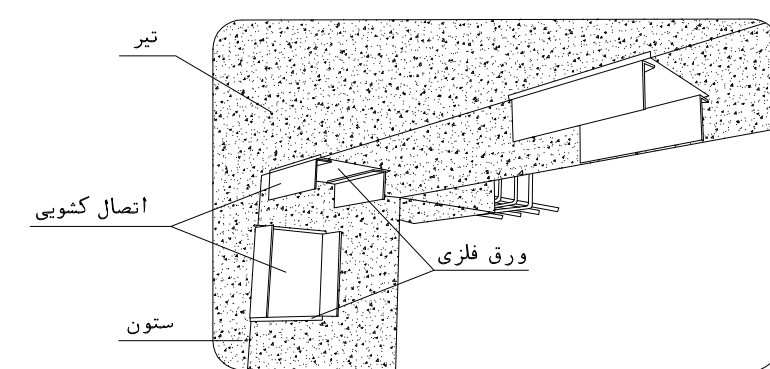


NOTES	
1- DIMENSIONS ARE IN "mm" AND ELEVATIONS IN "m" UNLESS SPECIFIED . 2- ALL DIMENSIONS AND ELEVATIONS SHALL BE CHECKED BY THE CONTRACTOR PRIOR TO CONSTRUCTION. 3- CONTRACTOR SHALL COMPARE ALL ARCHITECTURAL, MECHANICAL, ELECTRICAL, PIPING AND STRUCTURAL DRAWINGS AND IN CASE OF ANY CONFLICTS OR DISCREPANCY, INFORM THE ENGINEER. 4- SLAB ON GRADE SHALL BE CONSTRUCTED AFTER EXECUTION OF CABLE TRENCH & EQUIPMENTS FOUNDATION. 5- ALL MATERIALS ARE SELECTED FROM THE HIGHEST QUALITY AND SHALL BE APPROVED BY THE CLIENT. 6- FOR COORDINATE REFER TO FINISH GRADING DOCUMENTS. 7) REFERENCE COORDINATES E=1000.000 , N=1000.000 REFER TO X=437425 , Y=3290543 UTM. 8) FINISH GRADING LEVEL (W007S) ELEVATION : +26.00 (MEAN SEA LEVEL) ±26.05 m (GLOBAL) = ±0.00 (LOCAL) 9) ALL EXTERNAL OPENINGS (WINDOWS AND DOORS) SHALL BE FIRE PROOF. 10) DOUBLE GLAZED WINDOW WITH 246mm REINFORCED GLASS AND 6mm GAS FILLED GAP. 11) WC DOORS SHALL BE WATERPROOF ABS TYPE WITH CLOSER MECHANISM. 12) KNAUF GYPSUM BOARD TILES (60*60) cm (REGULAR 9.5 mm THICKNESS) WITH (1063). 13) KNAUF PVC-COATED GYPSUM BOARD TILES (60*60)-(REGULAR 9.5mm THICKNESS) WITH (1063)-(PVC THICKNESS 0.35mm).	
LEGEND	
BRICK WALL	BRICK FACING
ANTI-ACID CERAMIC	CEMENT SAND
TOVENAN COURSE	BLOCKAGE
POLYETHYLENE SHEET	LEAN CONCRETE
REINFORCED CONCRETE ACCORDING TO STR.DWG	TERRAZZO TILE
CHEQUERED PLATE TRENCH CAP	
HOT DEEP GALVANIZED SHEET	
SOFT SAND	
F.F.L. FINISHED FLOOR	T.O.B. TOP OF BEAM
T.O.W.A. TOP OF WALKWAY	B.O.C. BOTTOM OF CAGE
T.O.P. TOP OF PARAPET	T.O.S. TOP OF SLAB
T.O.C. TOP OF CAGE	B.O.S. BOTTOM OF SLEEVE
T.O.D. TOP OF DOOR	T.O.F. TOP OF FOUNDATION
F.G.L. FINISHED GRADING LEVEL	


REFERENCE DRAWING	DRG. No.
STANDARD DRAWING FOR ARCHITECTURAL DETAILS	BK-GNRL-PEDCO-000-AR-DW-0001
STANDARD DETAILS FOR LADDER & SAFETY CAGE	BK-GNRL-PEDCO-000-ST-DW-0009
PLOT PLAN DRAWING - W007S	BK-W007S-PEDCO-110-PI-PY-0002
FOUNDATION DRAWING FOR SECURITY BUILDING FOR WELL PADS - W007S	BK-W007S-PEDCO-110-ST-DW-0008
STRUCTURAL DRAWING FOR SECURITY BUILDING FOR WELL PADS - W007S	BK-W007S-PEDCO-110-ST-DW-0009
HVAC SYSTEM LAYOUT FOR SECURITY BUILDING - W007S	BK-W007S-PEDCO-110-HV-PY-0003
PLUMBING & SEWAGE PIPING LAYOUT FOR SECURITY BUILDING - W007S	BK-W007S-PEDCO-110-HV-PY-0004
LIGHTING & SMALL POWER LAYOUT FOR SECURITY BUILDING OF WELL PADS	BK-SIGRL-PEDCO-110-BL-PY-0005

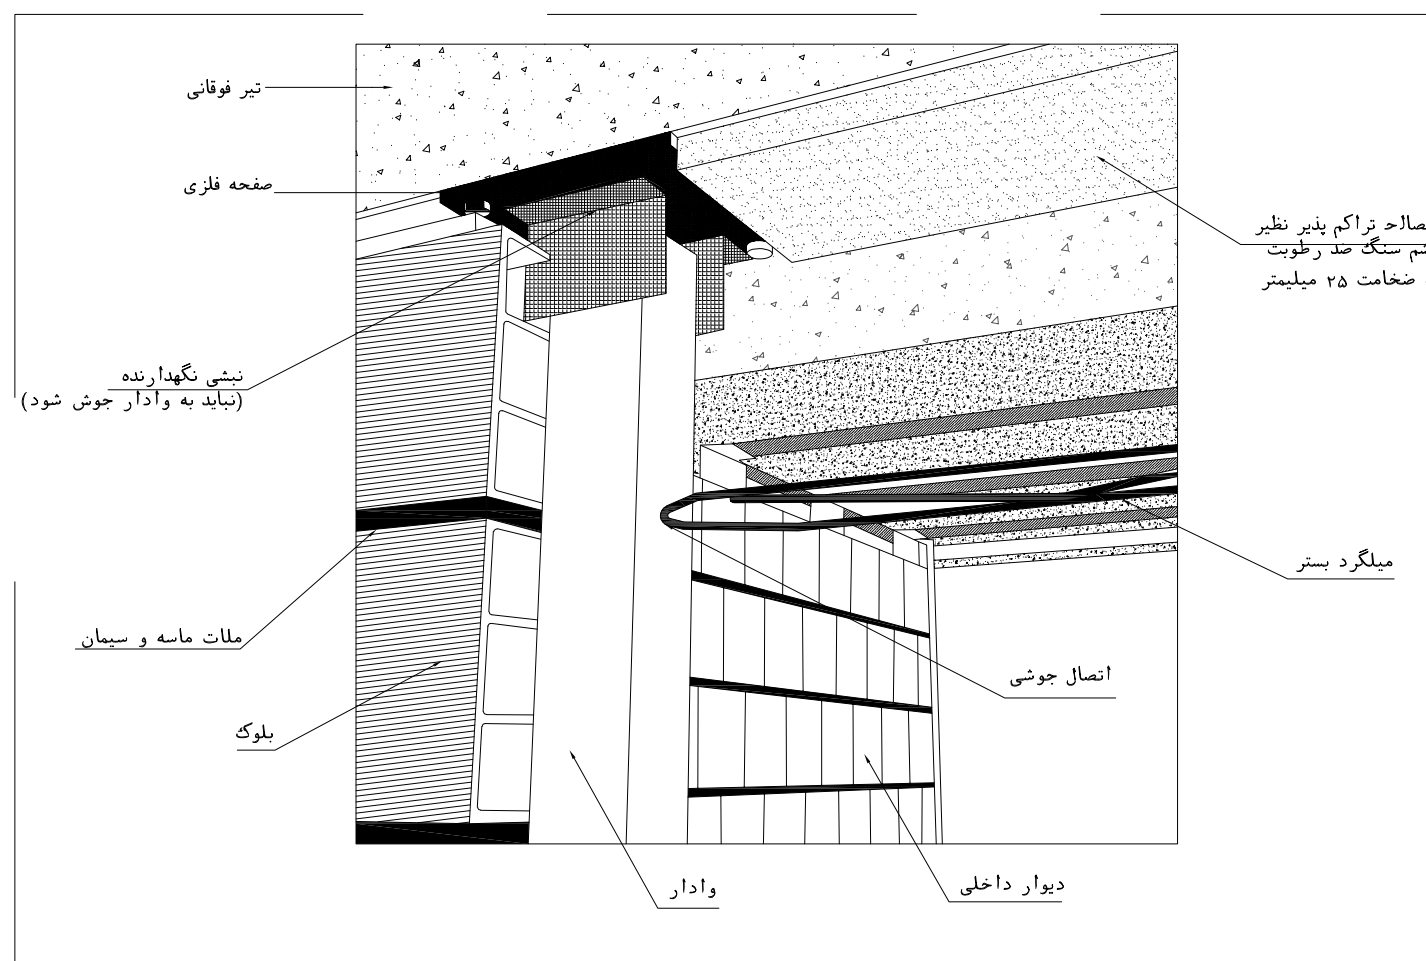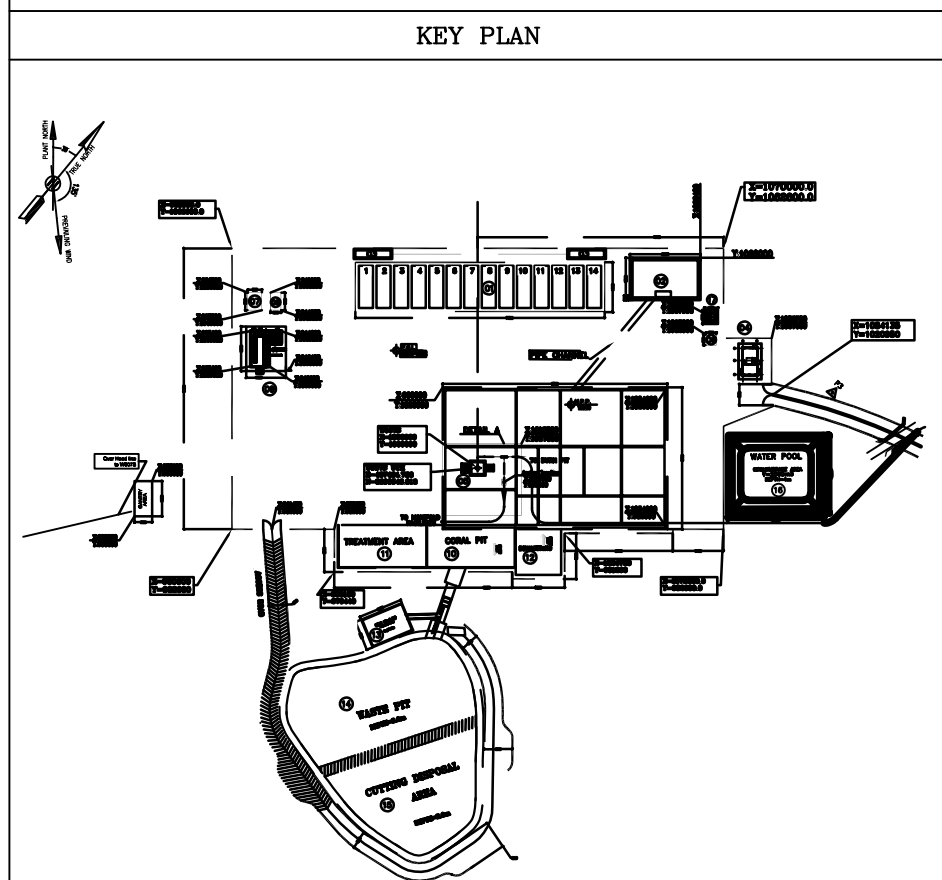

الف-به صورت اتصال کنویبی با استفاده از نشی

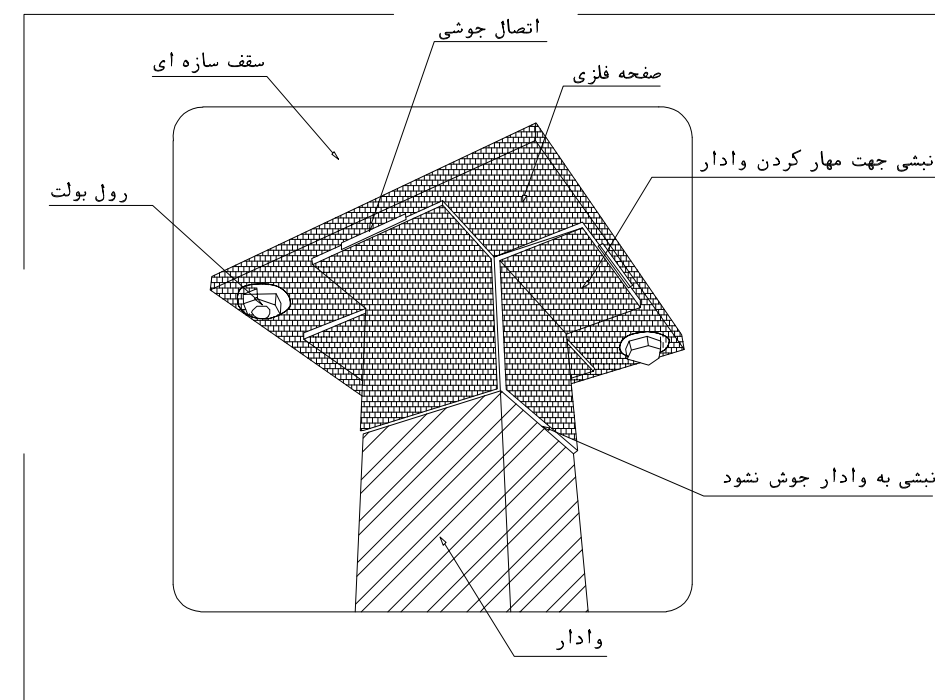







انصال وادار انتهایی در دیوار های خارج از قاب به صورت نلکوبی

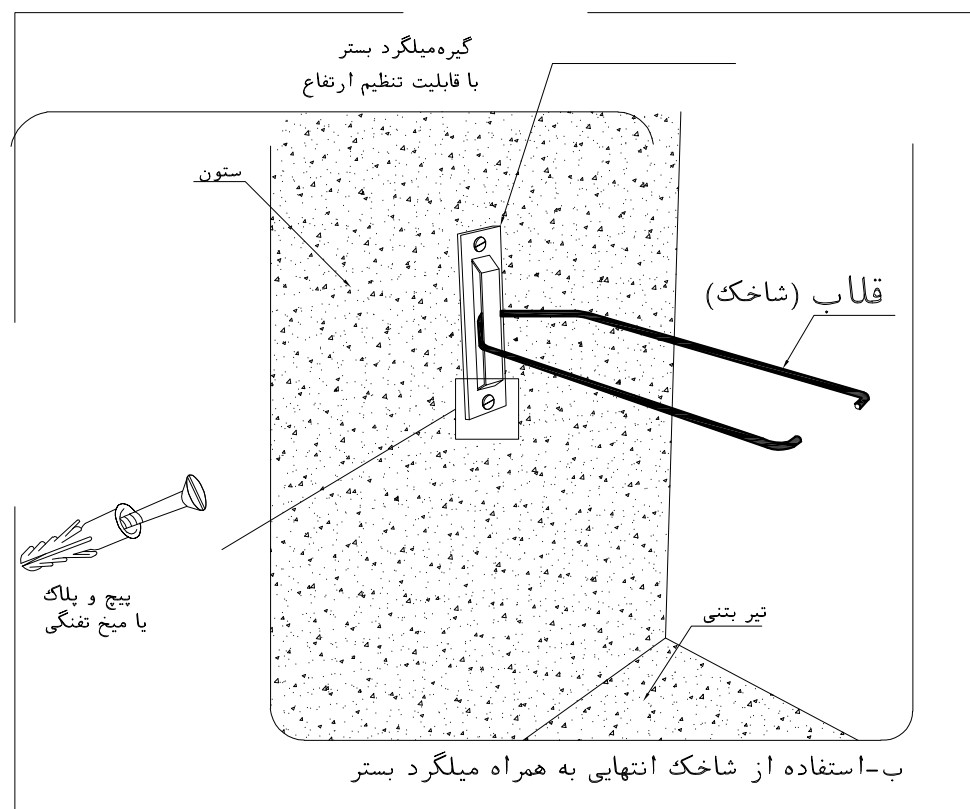

روش های مهار دیوار به ستون جهت نیروی خارج از صفحه


D04	OCT.2023	APC	R.BERLOUE	M.FAKHARIAN	S.Paranarspour	**
D03	AUG.2023	IFA	R.BERLOUE	M.FAKHARIAN	A.M.MOHSSENI	**
D02	JUN.2023	IFA	R.BERLOUE	M.FAKHARIAN	A.M.MOHSSENI	**
D01	FEB.2023	IFA	R.BERLOUE	M.FAKHARIAN	M.Mehrshad	**
D00	APR.2022	IPC	R.BERLOUE	M.FAKHARIAN	M.Mehrshad	**
REV.	DATE	P.O.I.S	PREP.	CHK.	APP.	AU
PROJECT NAME: BINAK OILFIELD DEVELOPMENT/SUB-SURFACE WORK PACKAGE W007S WHF & EXTENSION OF BINAK B/C						
PROJECT NO.:			971020			
EPC CONTRACTOR:			EPD/EPC CONTRACTOR (GC):			
 HIRGAN ENERGY - DESIGN & INSPECTION COMPANIES			 PETROIRAN DEVELOPMENT COMPANY			
DRAWING TITLE: ARCHITECTURAL DRAWING FOR SECURITY BUILDING OF WELL PADS - W007S DETAILS						
SCALE	SIZE	DRAWING NO.			SHEET NO.	R
AS SHOWN	A1	BK-W007S-PEDCO-110-AR-DW-0004			08 OF 11	D

DATE	SCALE	DRAWING BY	CHECKED BY	PROJECT ENG.
NO CONSTRUCTION PERMITTED UNLESS DRAWING APPROVED				
APPROVED FOR CONSTRUCTION		BY:	DATE:	
SCALE	SIZE	CLASS	SERIAL NO.	SHEET
AS SHOWN	A1	BK-W007S-PEDCO-110-AR-DW-0004	08 OF 11	D04

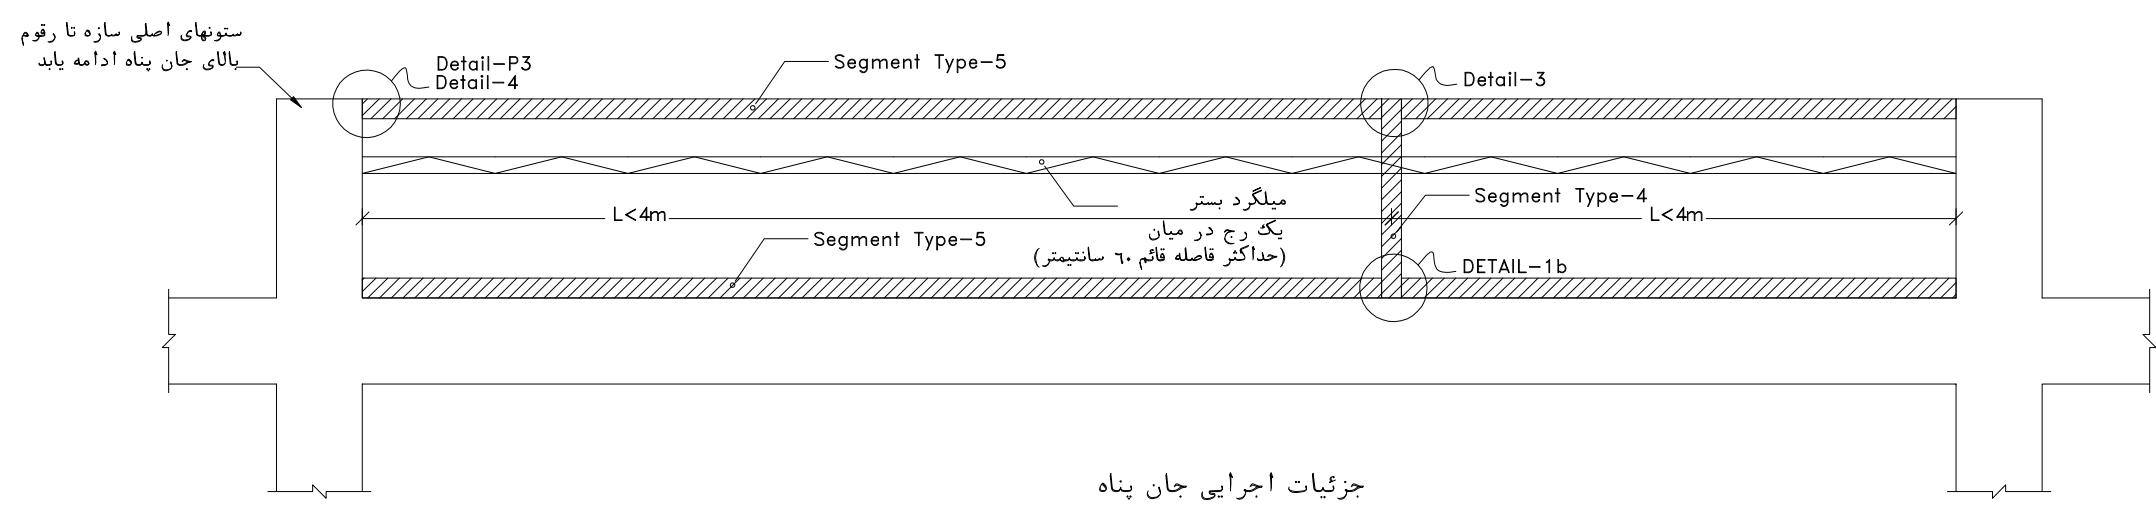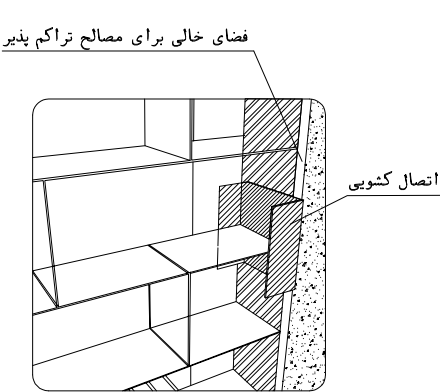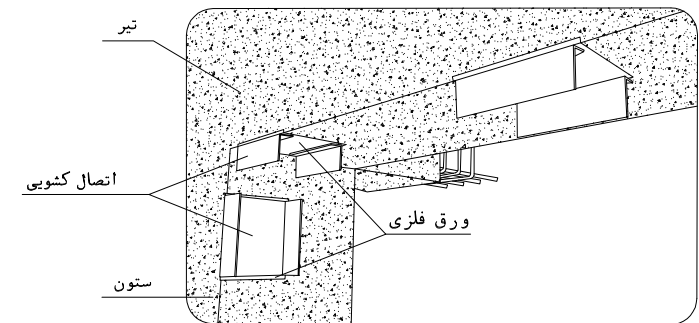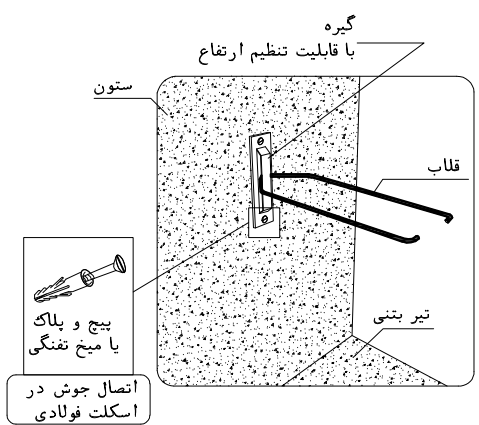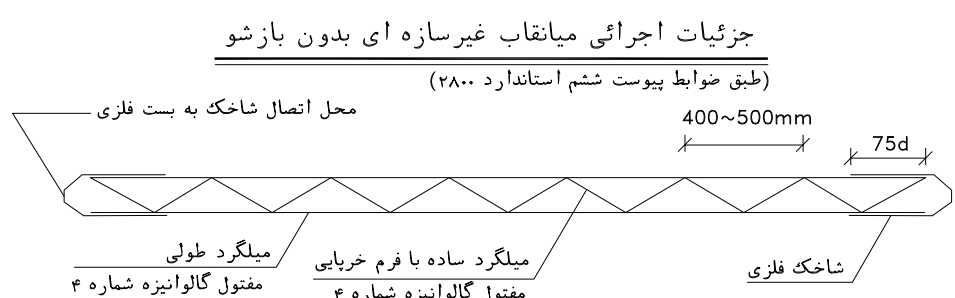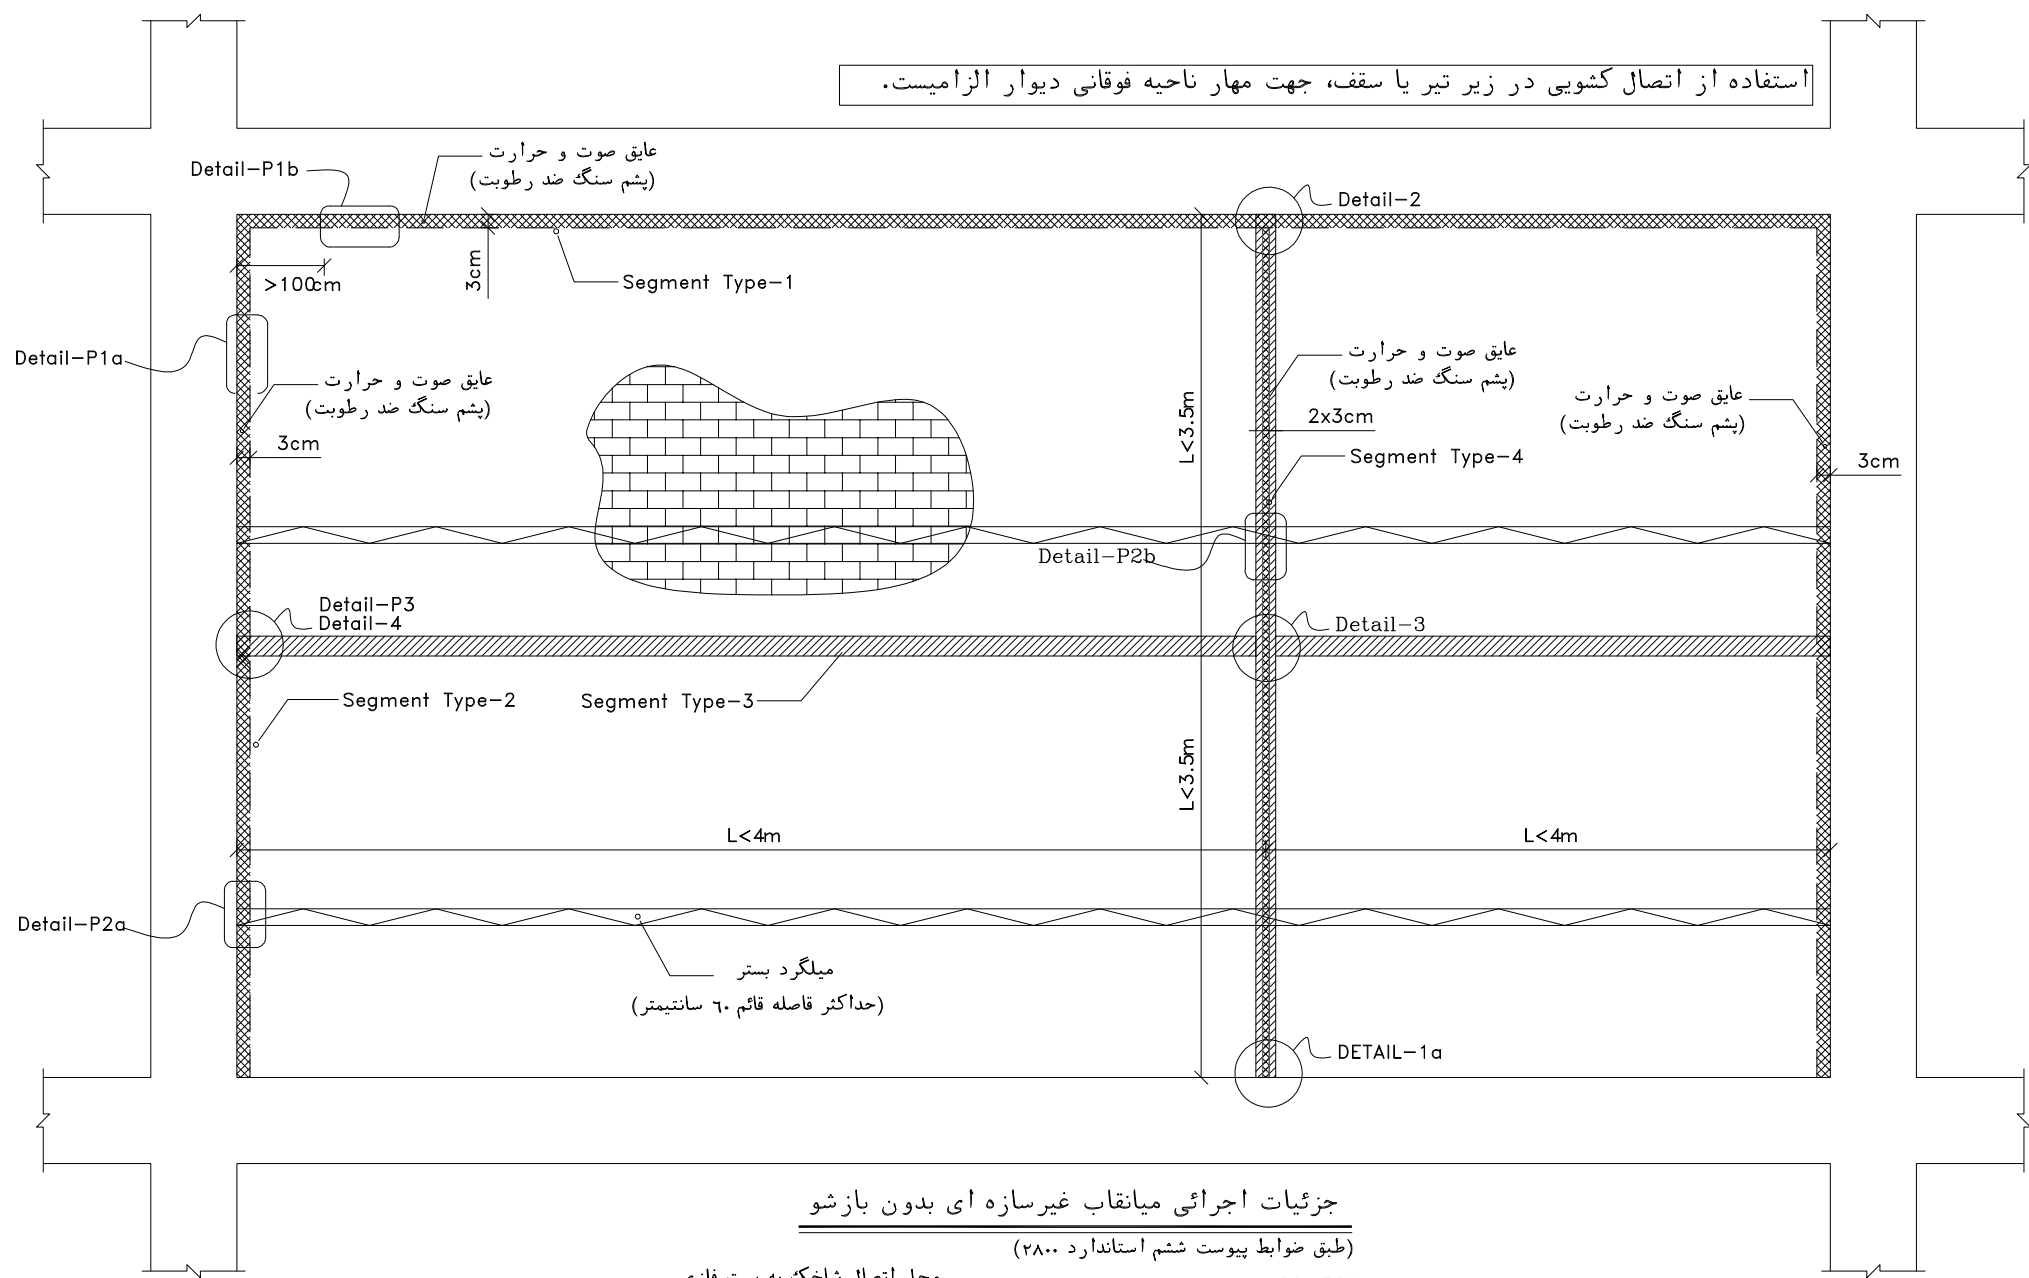

جزئیات اجرایی جان پناه
(طبق ضوابط پیوست ششم استاندارد ۲۸۰۰)


در صورتیکه ستونهای پیرامونی تا تراز جانبیه
Segment Type-4 از ۱۴م استفاده شود.
در حداکثر فاصله قائم ۶۰ سانتیمتر

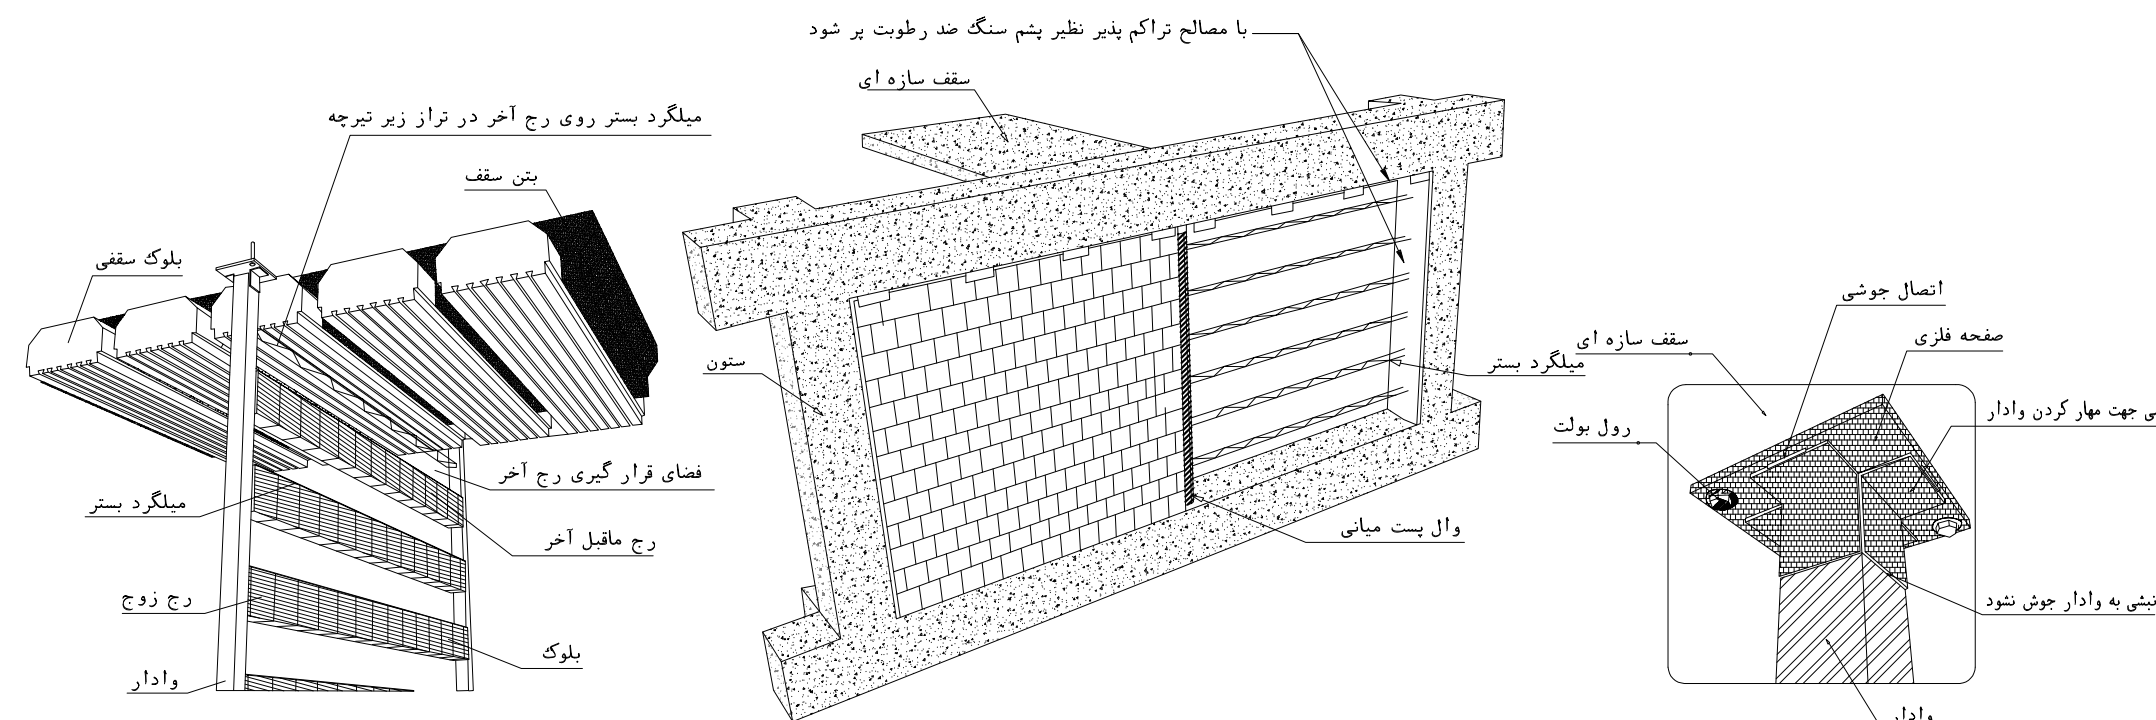


دیوار مسلح شده به میلگرد بستر(دیوارهای خارج از قاب)

دیوار مسلح شده به میلگرد بستر(دیوار داخل قاب)


اتصال وادار انتهایی در دیوار های خارج از قاب
به صورت تلسکوپی

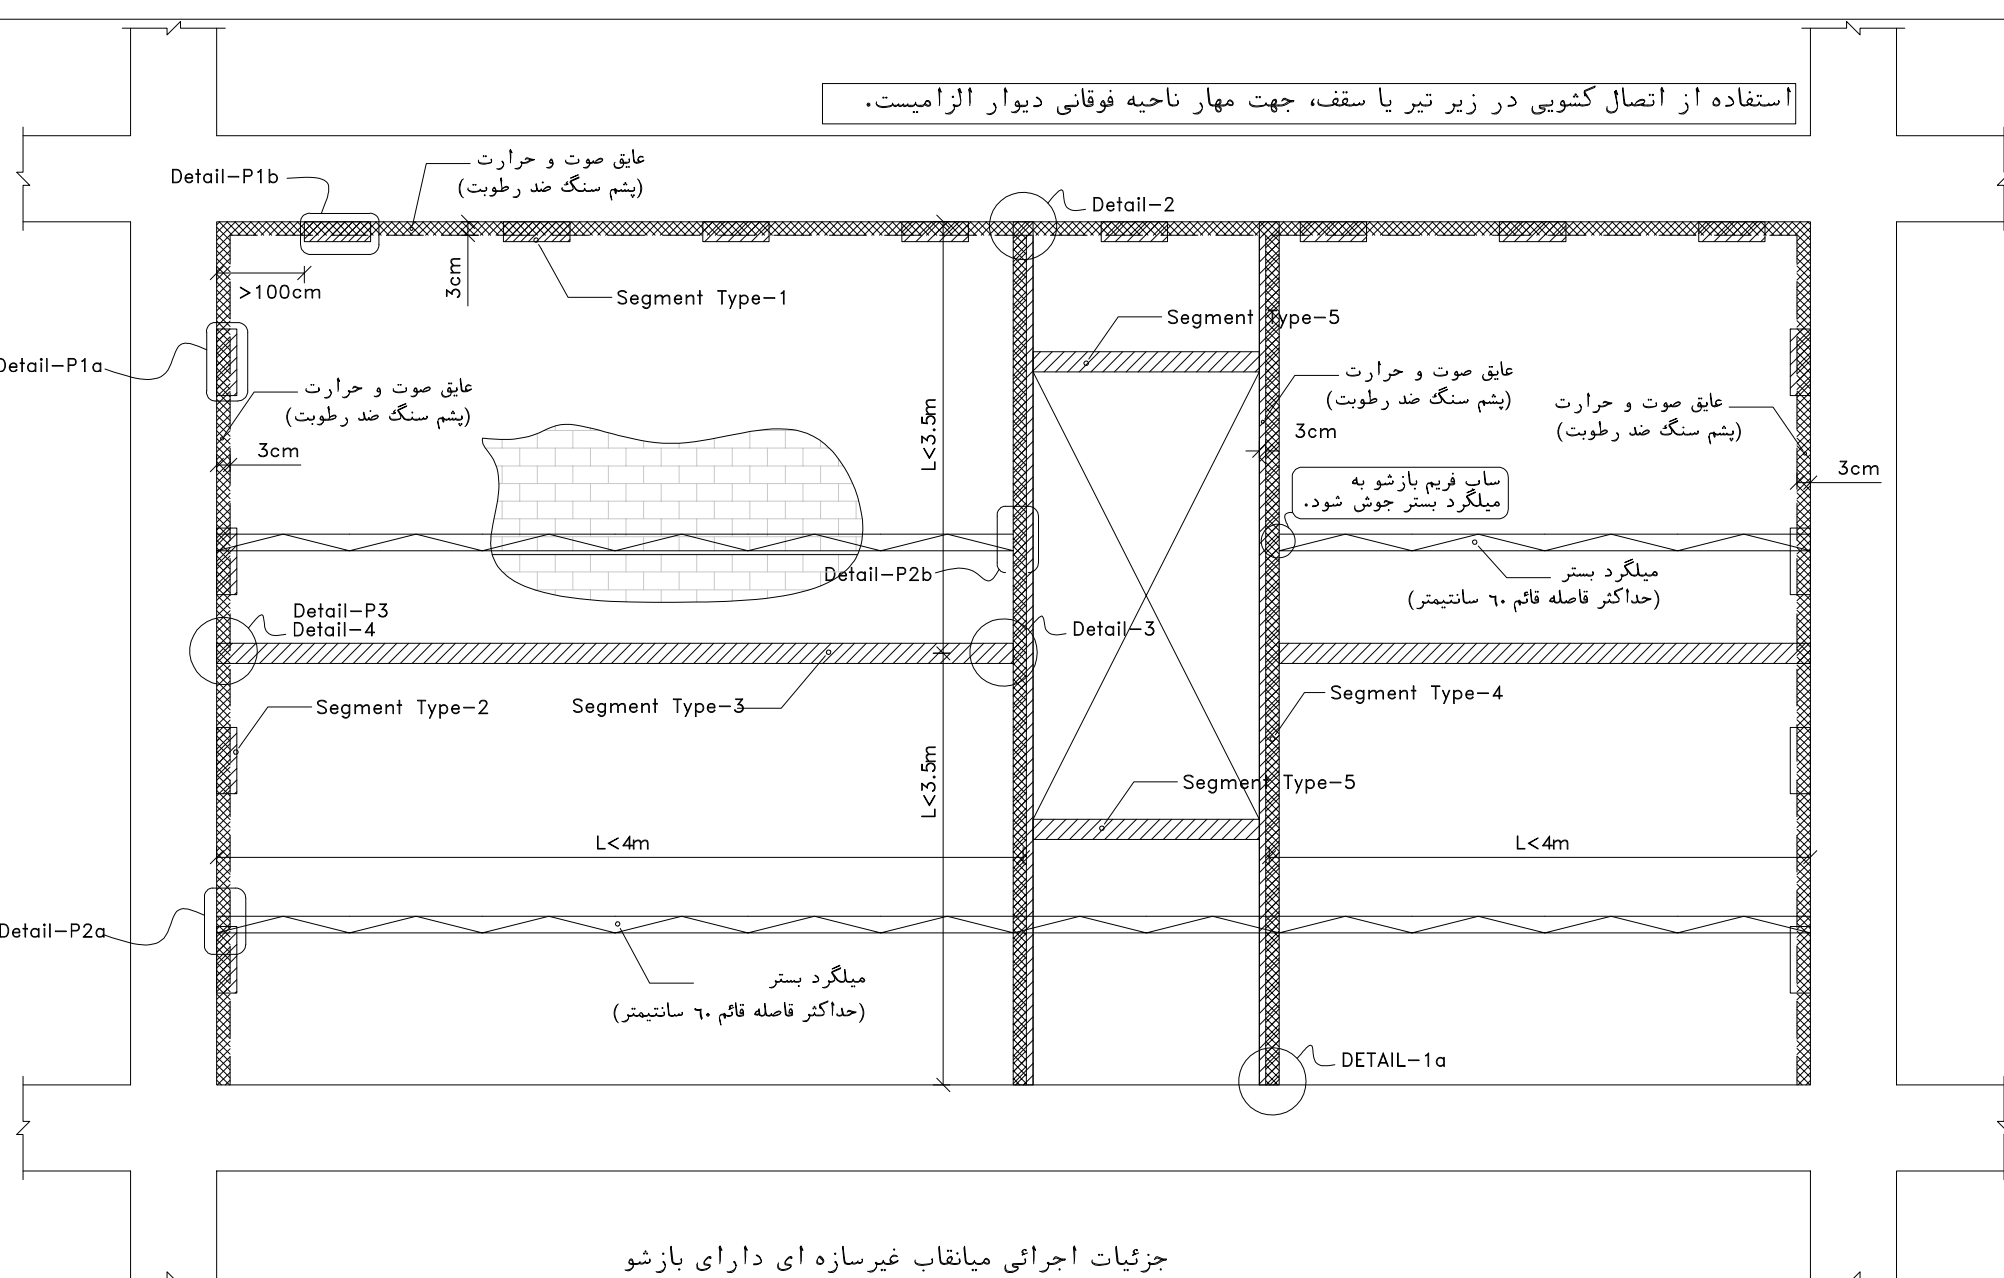


جزئیات اجرایی میانقاب غیرسازه ای دارای بازشو
(طبق ضوابط پیوست ششم استاندارد ۲۸۰۰)

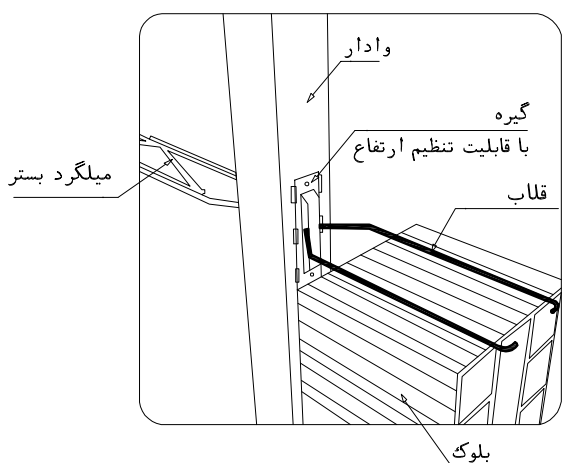


DETAIL-P2b

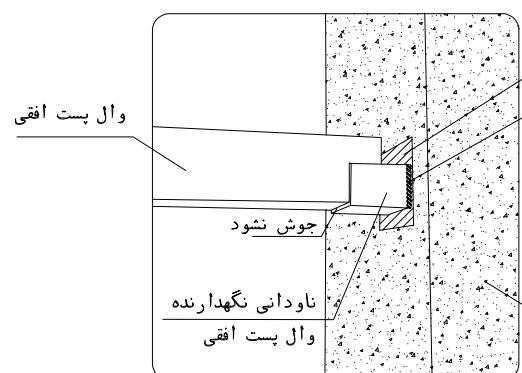

DETAIL-P3

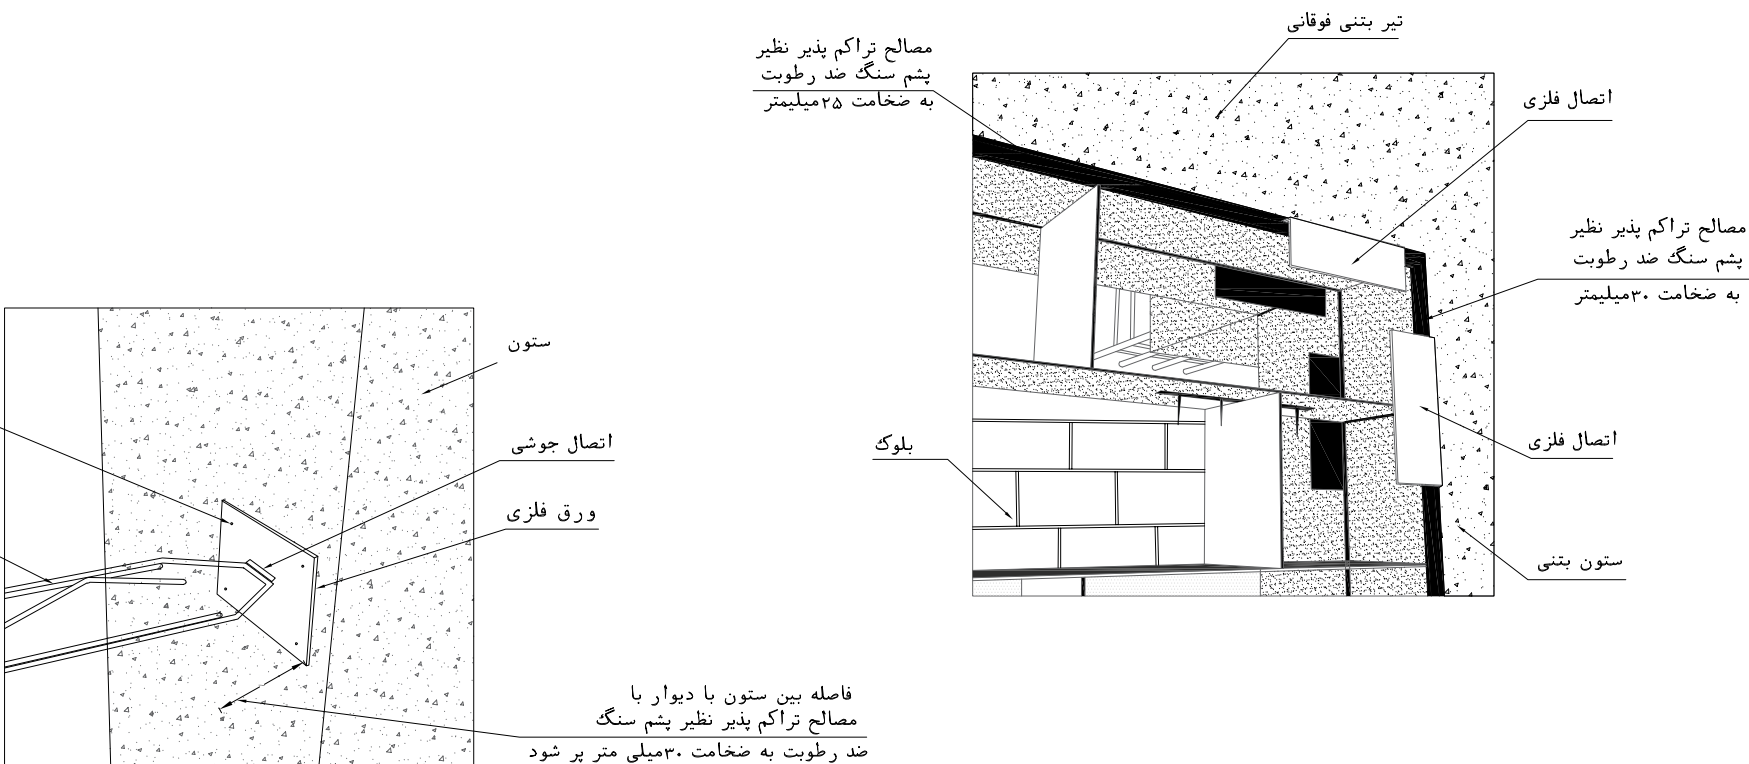


جزئیات اتصال میلگرد بستر به ستون بتنی
det.6

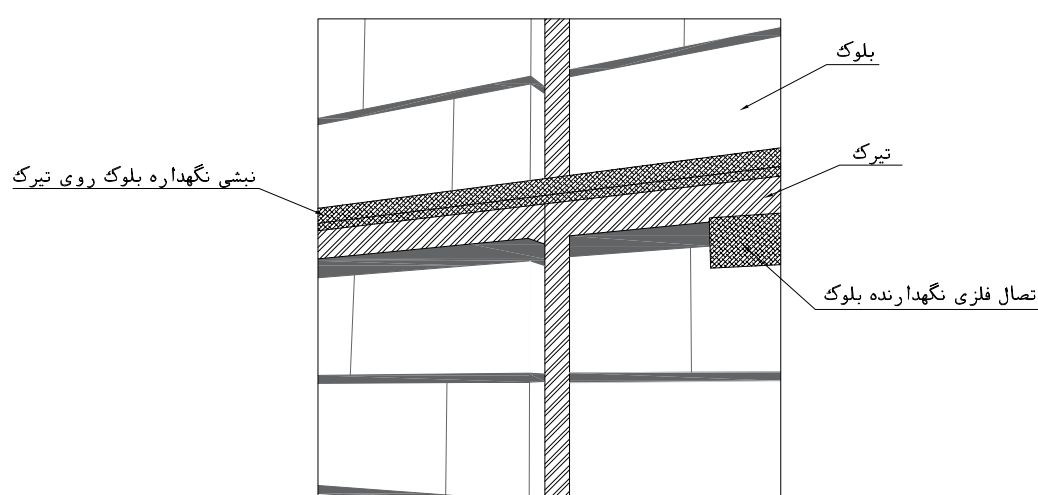

جزئیات اتصال تیرک به وادار








NOTES	
1- DIMENSIONS ARE IN "mm" AND ELEVATIONS IN "m" UNLESS SPECIFIED . 2- ALL DIMENSIONS AND ELEVATIONS SHALL BE CHECKED BY THE CONTRACTOR PRIOR TO CONSTRUCTION. 3- CONTRACTOR SHALL COMPARE ALL ARCHITECTURAL, MECHANICAL, ELECTRICAL, PIPING AND STRUCTURAL DRAWINGS AND IN CASE OF ANY CONFLICTS OR DISCREPANCY, INFORM THE ENGINEER. 4- SLAB ON GRADE SHALL BE CONSTRUCTED AFTER EXECUTION OF CABLE TRENCH & EQUIPMENTS FOUNDATION. 5- ALL MATERIALS ARE SELECTED FROM THE HIGHEST QUALITY AND SHALL BE APPROVED BY THE CLIENT. 6- FOR COORDINATE REFER TO FINISH GRADING DOCUMENTS. 7) REFERENCE COORDINATES E=1000,000 , N=1000,000 REFER TO X=437425 , Y=3290543 UTM. 8) FINISH GRADING LEVEL (W007S) ELEVATION : +26.00 (MEAN SEA LEVEL) +26.05 m (GLOBAL) = ±0.00 (LOCAL) 9) ALL EXTERNAL OPENINGS (WINDOWS AND DOORS) SHALL BE FIRE PROOF. 10) DOUBLE GLAZED WINDOW WITH 246mm REINFORCED GLASS AND 6mm GAS FILLED GAP. 11) WC DOORS SHALL BE WATERPROOF ABS TYPE WITH REGULAR MECHANISM. 12) KNAUF GYPSUM BOARD TILES (60*60) cm (REGULAR 9.5 mm THICKNESS) WITH (1063). 13) KNAUF PVC-COATED GYPSUM BOARD TILES (60*60)-(REGULAR 9.5mm THICKNESS) WITH (1063)-(PVC THICKNESS 0.35mm).	
LEGEND	
	BRICK WALL
	BRICK FACING
	ANTI-ACID CERAMIC
	CEMENT SAND
	TOVENAN COURSE
	BLOCKAGE
	POLYETHYLENE SHEET
	LEAN CONCRETE
	REINFORCED CONCRETE ACCORDING TO STR.DWG
	CHEQUERED PLATE TRENCH CAP
	HOT DEEP GALVANIZED SHEET
	SOFT SAND
F.F.L.	FINISHED FLOOR
T.O.B.	TOP OF BEAM
T.O.W.A.	TOP OF WALKWAY
B.O.C.	BOTTOM OF CAGE
T.O.P.	TOP OF PARAPET
T.O.S.	TOP OF SLAB
T.O.C.	TOP OF CAGE
B.O.S.	BOTTOM OF SLEEVE
T.O.D.	TOP OF DOOR
T.O.F.	TOP OF FOUNDATION
F.G.L.	FINISHED GRADING LEVEL

REFERENCE DRAWING	DRG. No.
STANDARD DRAWING FOR ARCHITECTURAL DETAILS	BK-GNRL-PEDCO-000-AR-DW-0001
STANDARD DETAILS FOR LADDER & SAFETY CAGE	BK-GNRL-PEDCO-000-ST-DW-0009
PLOT PLAN DRAWING - W007S	BK-W007S-PEDCO-110-PI-PY-0002
FOUNDATION DRAWING FOR SECURITY BUILDING FOR WELL PADS - W007S	BK-W007S-PEDCO-110-ST-DW-0008
STRUCTURAL DRAWING FOR SECURITY BUILDING FOR WELL PADS - W007S	BK-W007S-PEDCO-110-ST-DW-0009
HVAC SYSTEM LAYOUT FOR SECURITY BUILDING - W007S	BK-W007S-PEDCO-110-HV-PY-0003
PLUMBING & SEWAGE PIPING LAYOUT FOR SECURITY BUILDING - W007S	BK-W007S-PEDCO-110-HV-PY-0004
LIGHTING & SMALL POWER LAYOUT FOR SECURITY BUILDING OF WELL PADS	BK-SISGR-PEDCO-110-BL-PY-0005


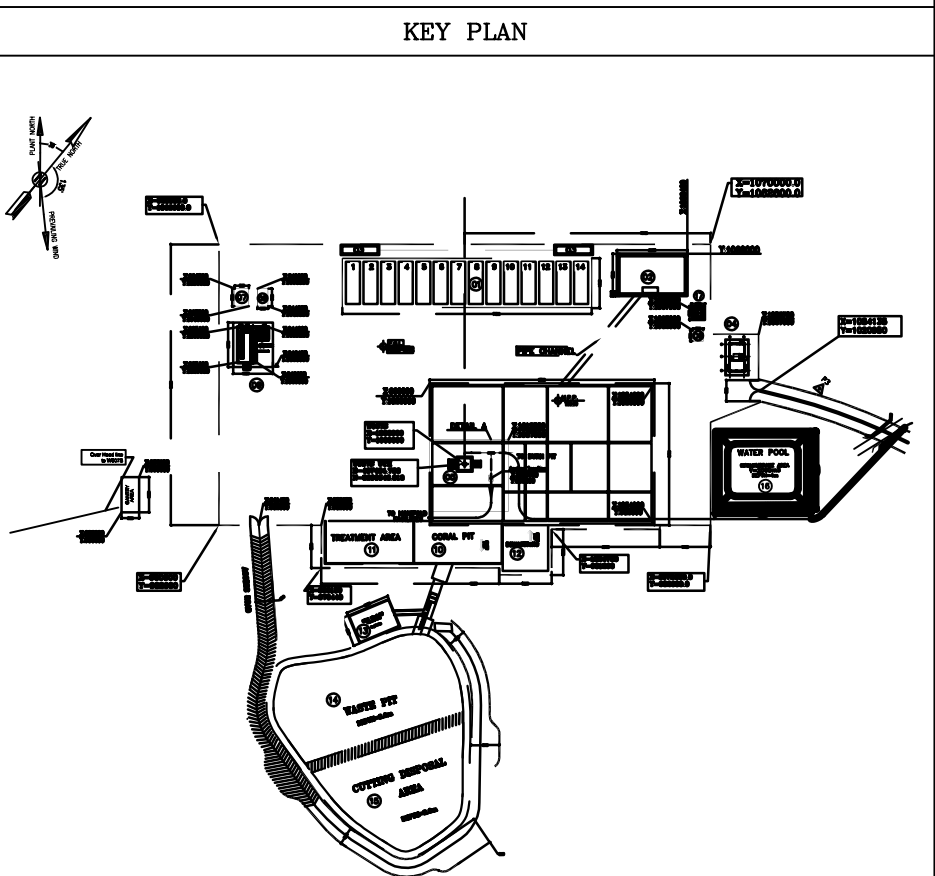


D04	OCT.2023	APC	R.BERLOUIE	M.FAKHARHAN	S.Paranarspour	** **
D03	AUG.2023	IFA	R.BERLOUIE	M.FAKHARHAN	A.M.MOHSSENI	** **
D02	JUN.2023	IFA	R.BERLOUIE	M.FAKHARHAN	A.M.MOHSSENI	** **
D01	FEB.2023	IFA	R.BERLOUIE	M.FAKHARHAN	M.Mehrshad	** **
D00	APR.2022	IPC	R.BERLOUIE	M.FAKHARHAN	M.Mehrshad	** **
REV.	DATE	P.O.I.S	PREP.	CHK.	APP.	AUT.
PROJECT NAME: BINAK OILFIELD DEVELOPMENT/SUB-SURFACE WORK PACKAGES W007S WHF & EXTENSION OF BINAK B/C						
PROJECT NO.: 971020						
EPC CONTRACTOR:			EPD/EPC CONTRACTOR (GC):			
 HIRGAN ENERGY - DESIGN & INSPECTION COMPANIES			 PETROIRAN DEVELOPMENT COMPANY			
DRAWING TITLE: ARCHITECTURAL DRAWING FOR SECURITY BUILDING OF WELL PADS - W007S DETAILS						
SCALE	SIZE	DRAWING NO.			SHEET NO.	REV.
AS SHOWN	A1	BK-W007S-PEDCO-110-AR-DW-0004			09 OF 11	D04



***	*****	*** **	*** ****	*** **	*** ****	
REV.	DESCRIPTION	BY	DATE	BY	DATE	
		CHECKED		REV. APPR.		
اصل و کلیه نسخ این نقشه و حق اقبالی متعلق به شرکت ملی مناطق نفت خیز جنوب میباشد.						
THE ORIGINAL AND ALL COPIES OF THIS DRAWING TOGETHER WITH THE COPYRIGHT THEREIN ARE THE SOLE PROPERTY OF N.I.S.O.C./ FIELDS						
BINAK OILFIELD DEVELOPMENT SUB-SURFACE WORK PACKAGES W007S WHF & EXTENSION OF BINAK B/C						
DATE	SCALE	DRAWING BY	CHECKED BY	PROJECT ENG.		
NO CONSTRUCTION PERMITTED UNLESS DRAWING APPROVED						
APPROVED FOR CONSTRUCTION			BY:	DATE:		
BUDGET REF.	LOCATION	SIZE	CLASS	SERIAL NO.	SHEET	REVISION
053-073-9184	F	4	B	708045	09 OF 11	D04

 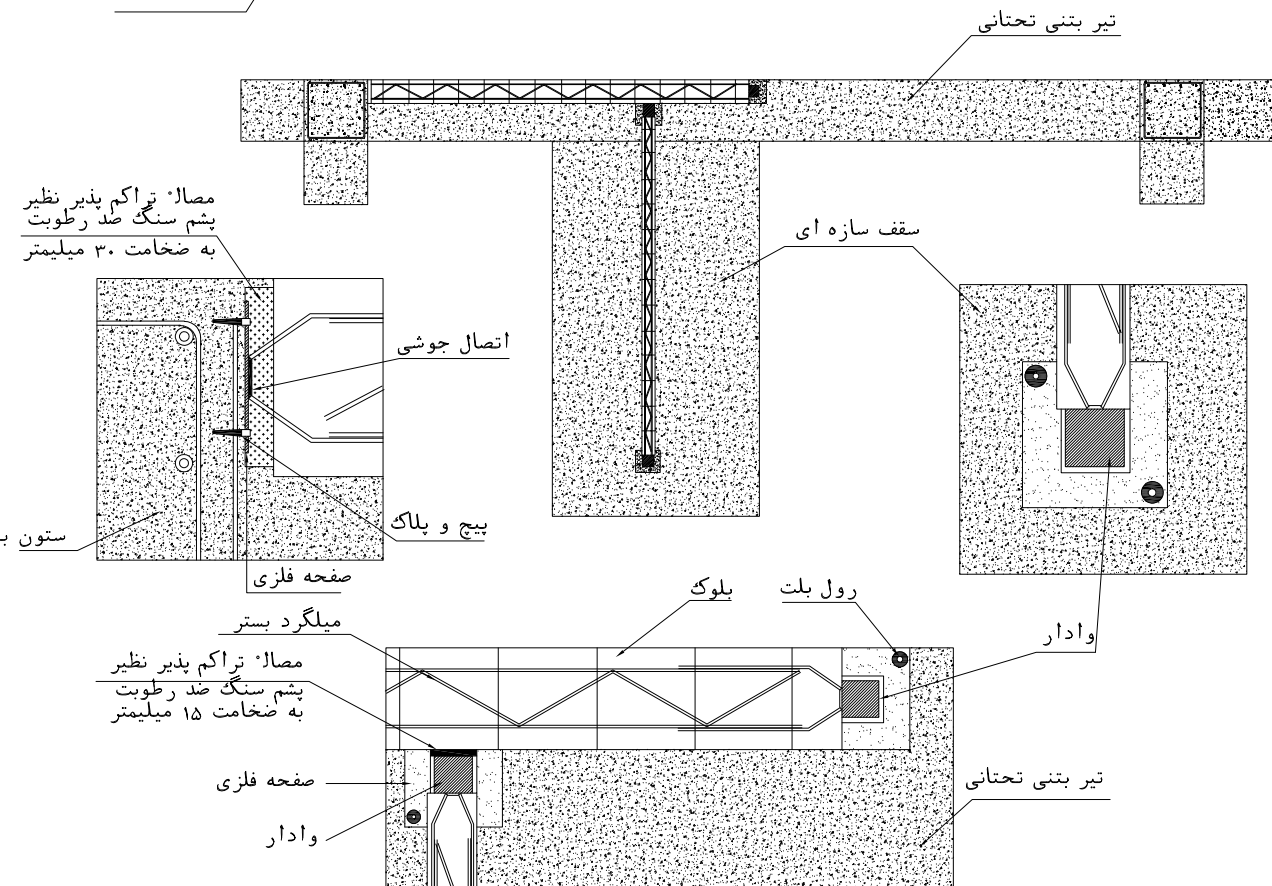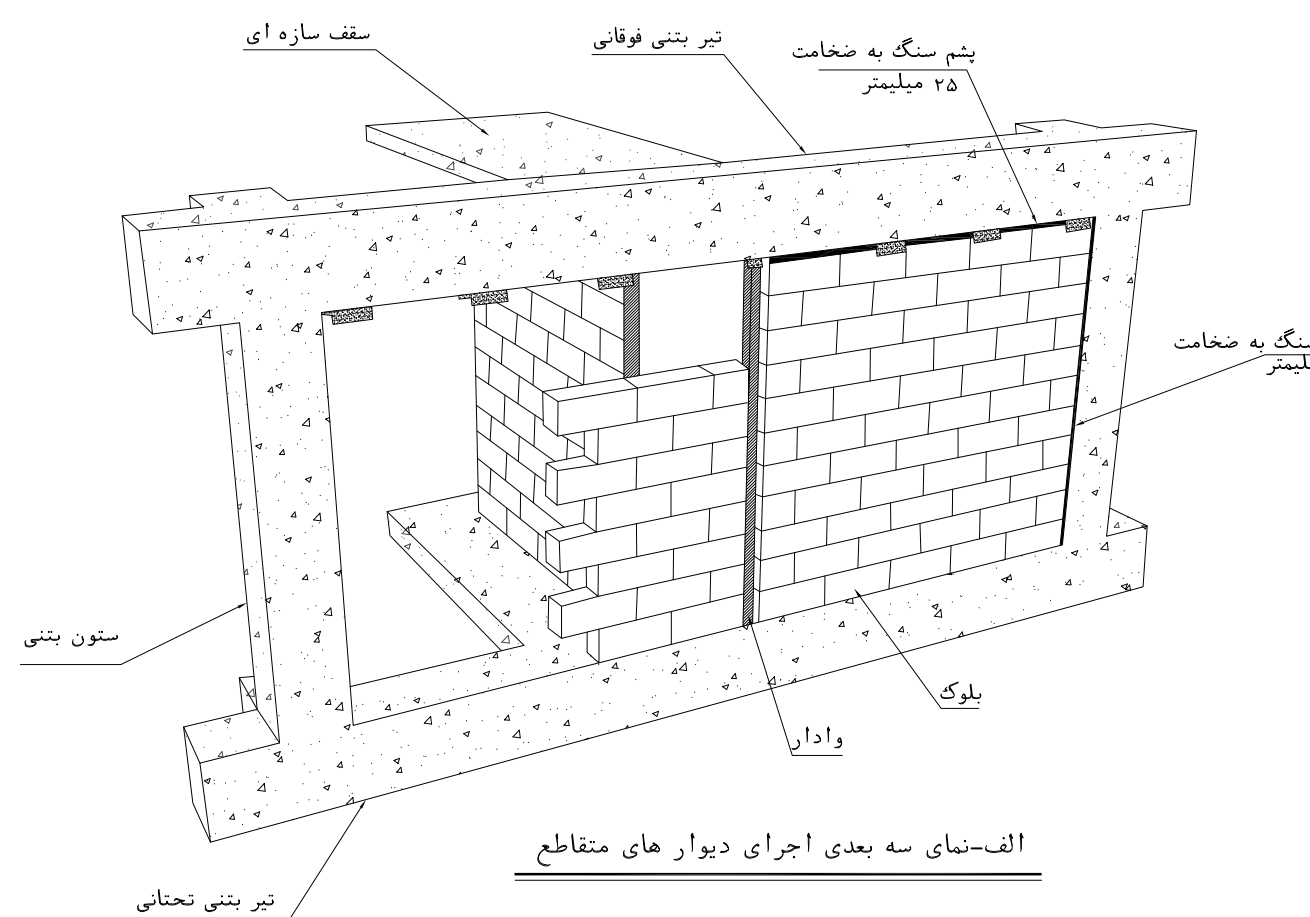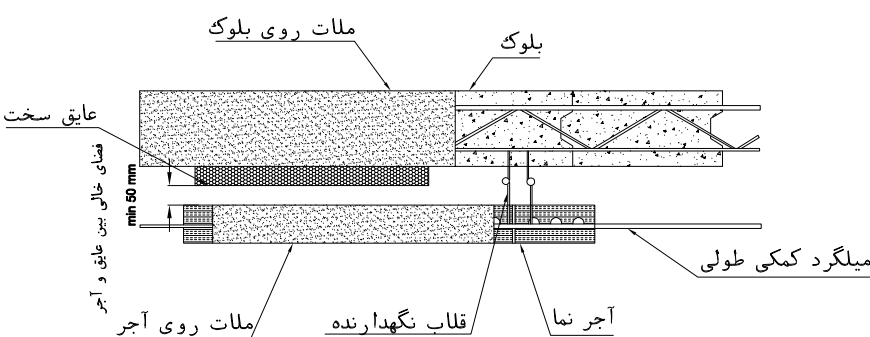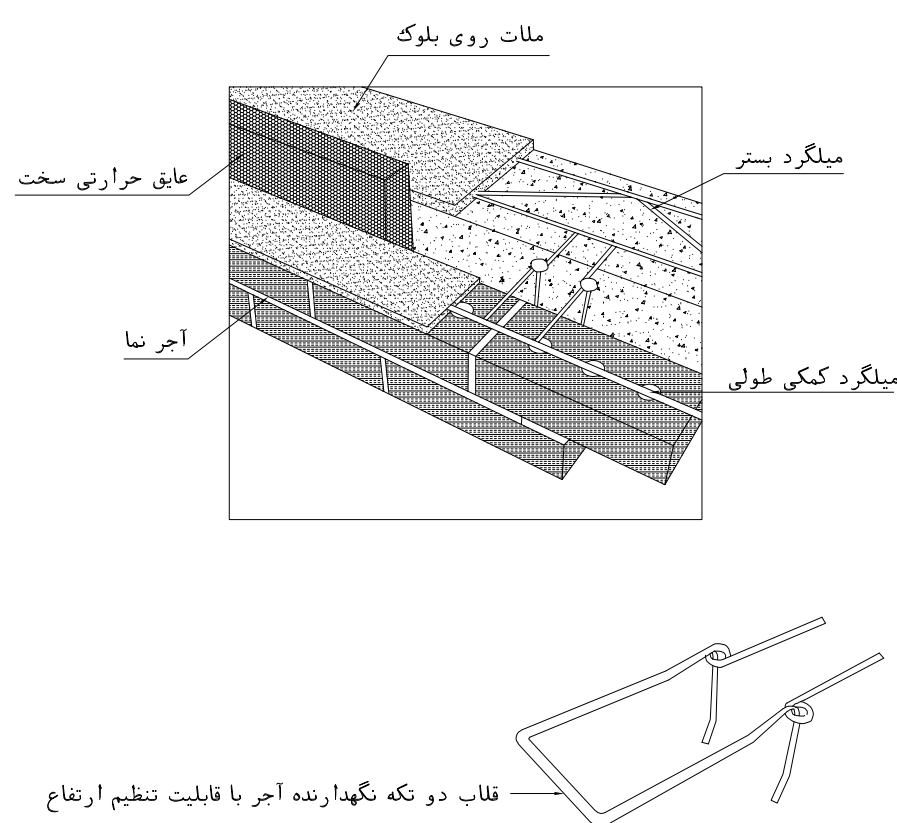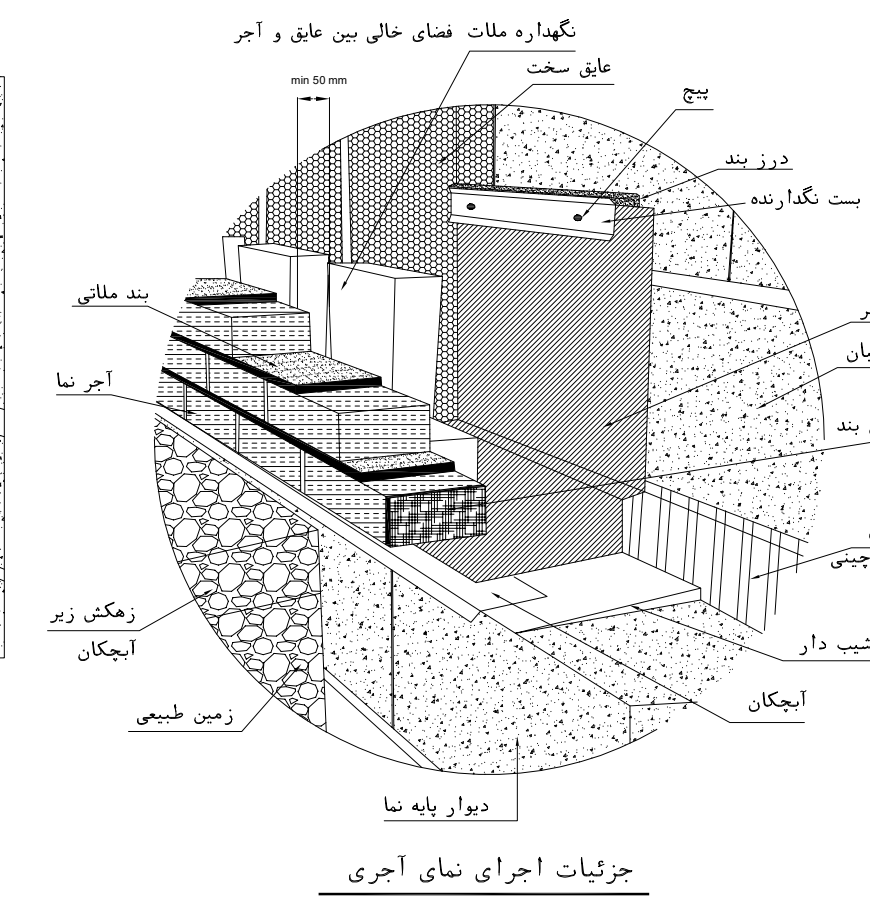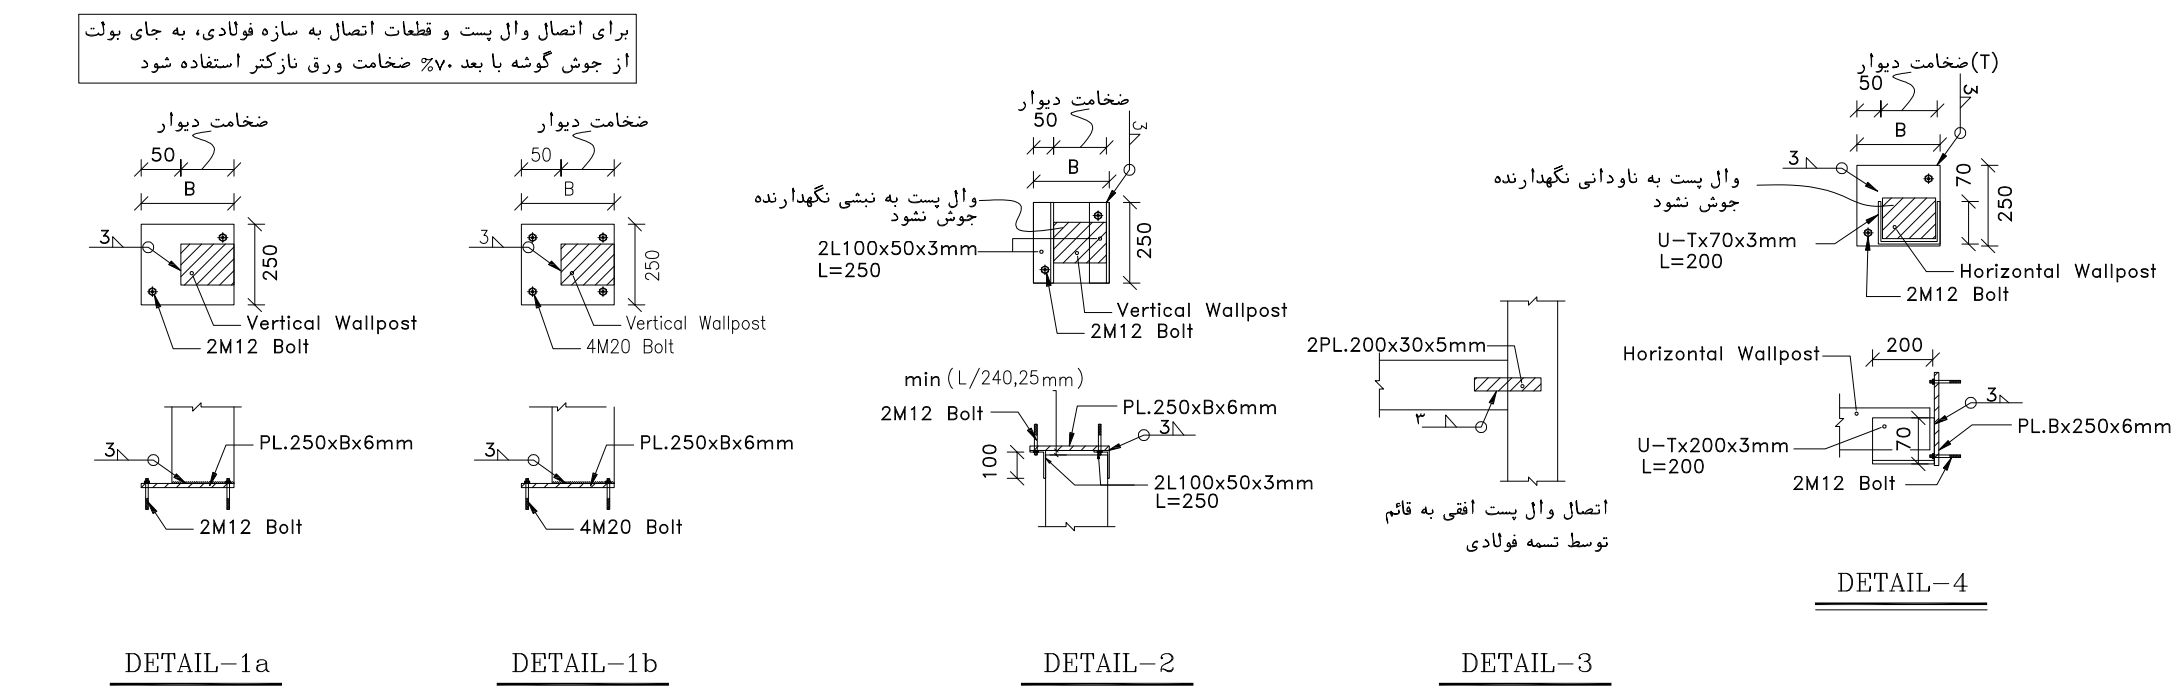

ب - اجرای دیوار متقاطع از پلان

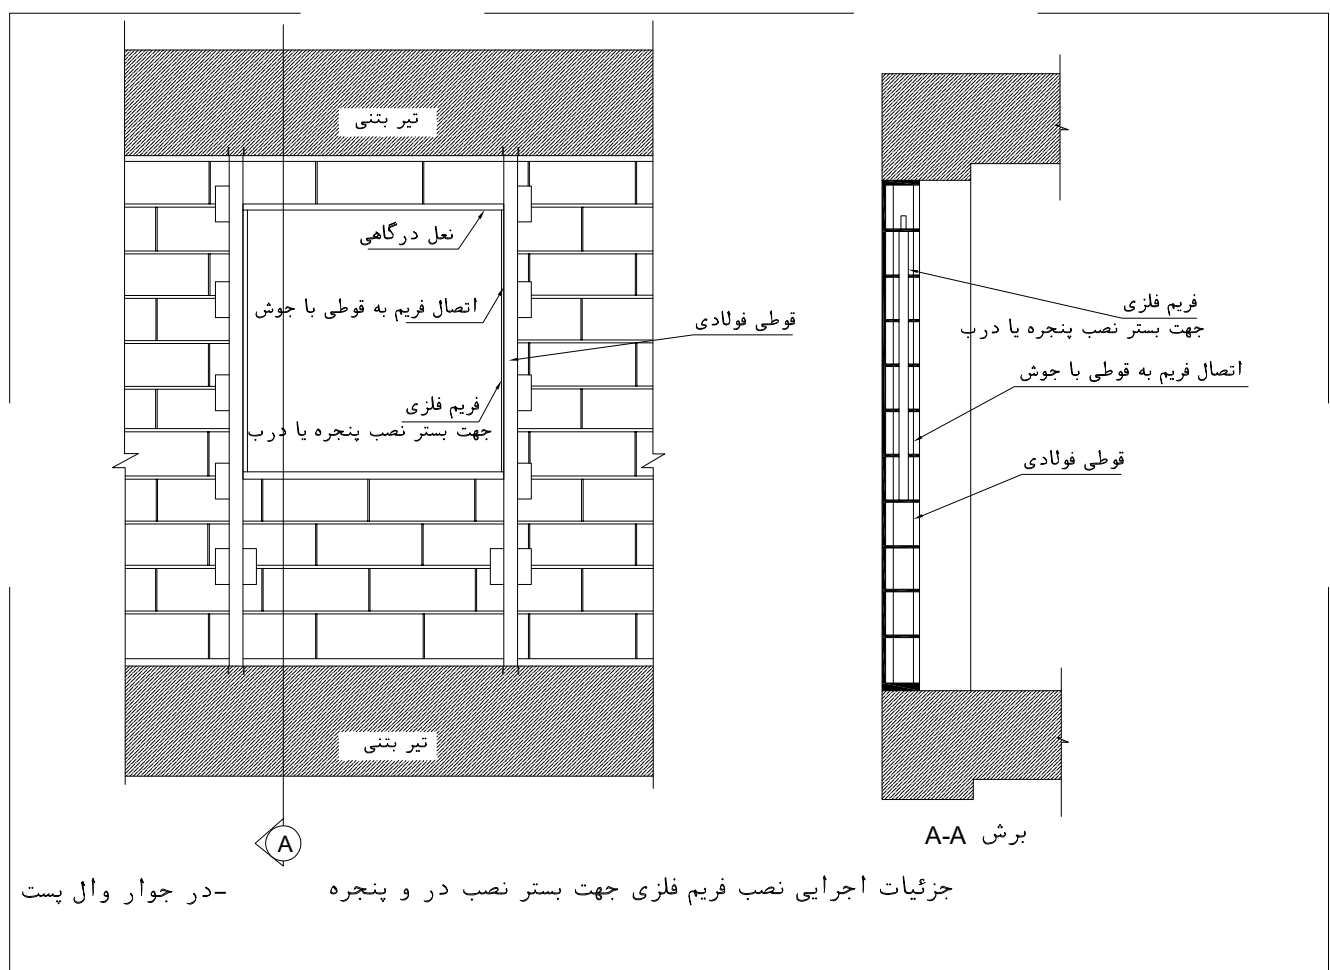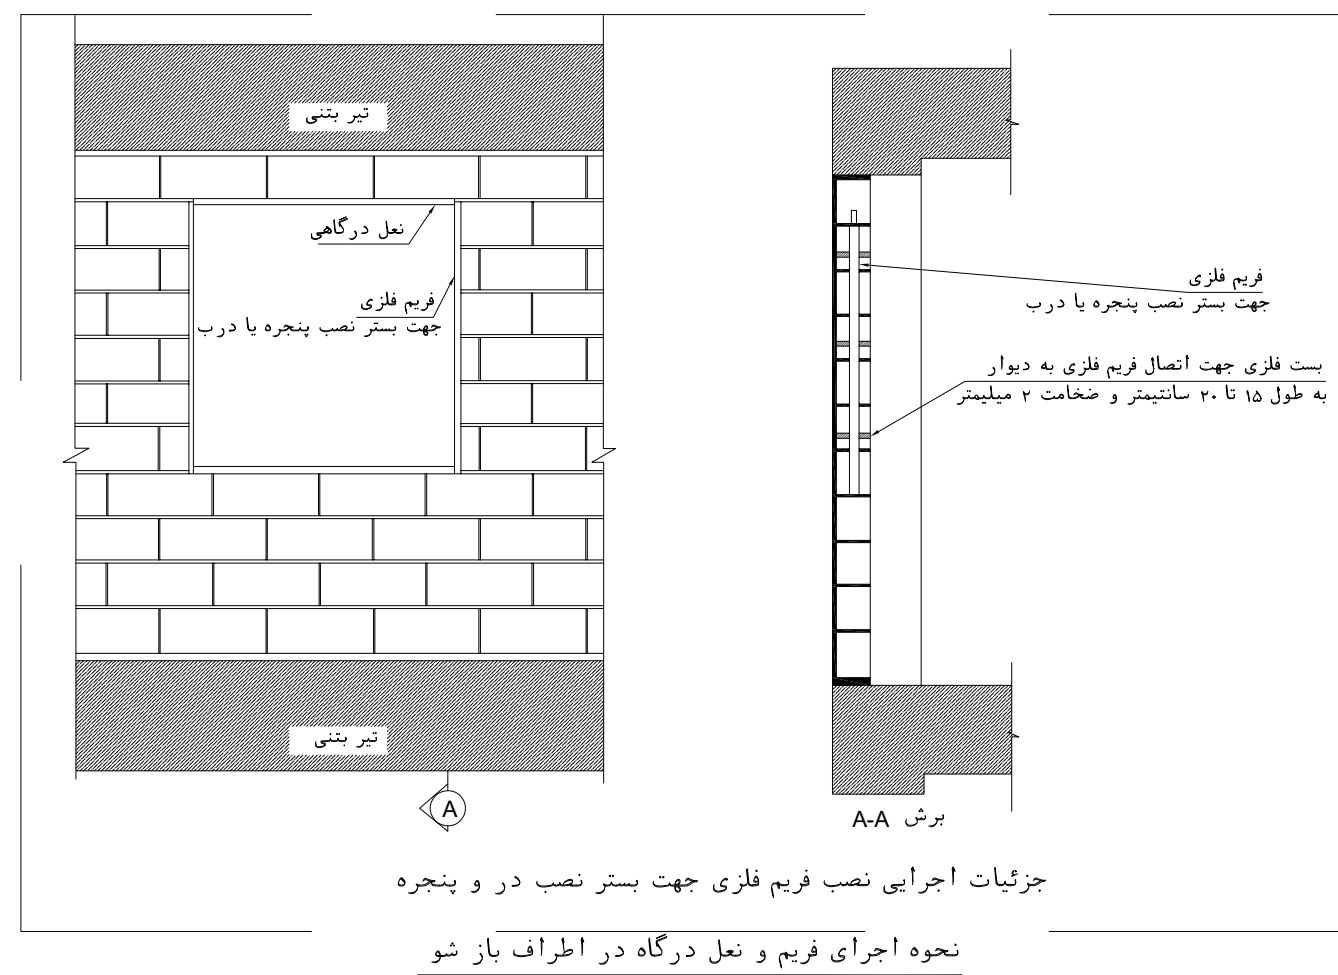


  نحوه اجرای وادار در دو طرف باز شو در صورت نیاز

NOTES			
1-	DIMENSIONS ARE IN "mm" AND ELEVATIONS IN "m" UNLESS SPECIFIED.		
2-	ALL DIMENSIONS AND ELEVATIONS SHALL BE CHECKED BY THE CONTRACTOR PRIOR TO CONSTRUCTION.		
3-	CONTRACTOR SHALL COMPARE ALL ARCHITECTURAL, MECHANICAL, ELECTRICAL, PIPING AND STRUCTURAL DRAWINGS AND IN CASE OF ANY CONFLICTS OR DISCREPANCY, INFORM THE ENGINEER.		
4-	SLAB ON GRADE SHALL BE CONSTRUCTED AFTER EXECUTION OF CABLE TRENCH & EQUIPMENTS FOUNDATION.		
5-	ALL MATERIALS ARE SELECTED FROM THE HIGHEST QUALITY AND SHALL BE APPROVED BY THE CLIENT.		
6-	FOR COORDINATE REFER TO FINISH GRADING DOCUMENTS.		
7-	REFERENCE COORDINATES E=1000.000 , N=1000.000 REFER TO X=457425 , Y=5290543 UTM.		
8-	FINISH GRADING LEVEL (WOOD'S) ELEVATION : +26.00 (MEAN SEA LEVEL) +26.05 m (GLOBAL) = ±0.00 (LOCAL)		
9-	ALL EXTERNAL OPENINGS (WINDOWS AND DOORS) SHALL BE FIRE PROOF.		
10-	DOUBLE GLAZED WINDOW WITH 2*6mm REINFORCED GLASS AND 6mm GAS FILLED GAP.		
11-	WC DOORS SHALL BE WATERPROOF ABS TYPE WITH CLOSER MECHANISM.		
12-	KNAUF GYPSUM BOARD TILES (60*60 cm (REGULAR 9.5 mm THICKNESS) WITH (1063).		
13-	KNAUF PVC-COATED GYPSUM BOARD TILES (60*60)-(REGULAR 9.5mm THICKNESS) WITH (1063)-(PVC THICKNESS 0.55mm).		
LEGEND			
	BRICK WALL		BRICK FACING
	ANTI-ACID CERAMIC		CEMENT SAND
	TOVENAN COURSE		BLOCKAGE
	POLYETHYLENE SHEET		LEAN CONCRETE
	REINFORCED CONCRETE ACCORDING TO STR.DWG		TERRAZZO TILE
	CHEQUERED PLATE TRENCH CAP		
	HOT DEEP GALVANIZED SHEET		
	SOFT SAND		
F.F.L.	FINISHED FLOOR	T.O.B.	TOP OF BEAM
T.O.W.A.	TOP OF WALKWAY	B.O.C.	BOTTOM OF CAUSEWAY
T.O.P.	TOP OF PARAPET	T.O.S.	TOP OF SLAB
T.O.C.	TOP OF CAGE	B.O.S.	BOTTOM OF SLEEVE
T.O.D.	TOP OF DOOR	T.O.F.	TOP OF FOUNDATION
F.G.L.	FINISHED GRADING LEVEL		

REFERENCE DRAWING	DRG. No.
STANDARD DRAWING FOR ARCHITECTURAL DETAILS	BK-GNRL-PRCDO-000-AR-DW-0001
STANDARD DETAILS FOR LADDER & SAFETY CAGE	BK-GNRL-PRCDO-000-ST-DW-0009
PLOT PLAN DRAWING - W007S	BK-W007S-PRCDO-110-PI-PY-0002
FOUNDATION DRAWING FOR SECURITY BUILDING FOR WELL PADS - W007S	BK-W007S-PRCDO-110-ST-DW-0008
STRUCTURAL DRAWING FOR SECURITY BUILDING FOR WELL PADS - W007S	BK-W007S-PRCDO-110-ST-DW-0009
HVAC SYSTEM LAYOUT FOR SECURITY BUILDING - W007S	BK-W007S-PRCDO-110-HV-PY-0002
PLUMBING & SEWAGE PIPING LAYOUT FOR SECURITY BUILDING - W007S	BK-W007S-PRCDO-110-HV-PY-0004
LIGHTING & SMALL POWER LAYOUT FOR SECURITY BUILDING OF WELL PADS	BK-SGRGL-PRCDO-110-EL-PY-0005

KEY PLAN

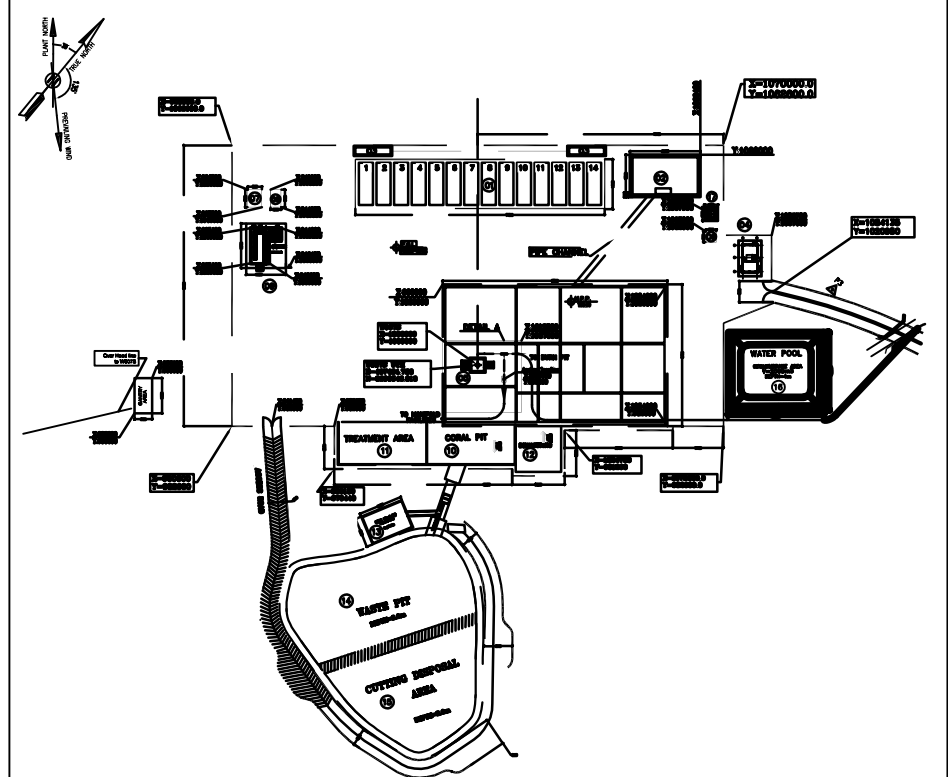

D04	OCT.2023	APC	R.BERLOUIE	M.PAKHARIAN	S.Paranarpour	**
D03	AUG. 2023	IPA	R.BERLOUIE	M.PAKHARIAN	A.M.MOHSINI	**
D02	JUN.2023	IPA	R.BERLOUIE	M.PAKHARIAN	A.M.MOHSINI	**
D01	FEB.2023	IPA	R.BERLOUIE	M.PAKHARIAN	M.Mehrshad	**
D00	APR.2022	IPC	R.BERLOUIE	M.PAKHARIAN	M.Mehrshad	**
REV.	DATE	P.O.I.S	PREP.	CHK.	APP.	AUT.

اصل و کليه نسخ اين نقشه و حق اقتباس متعلق به شرکت ملی مناطق نفت خيز جنوب مي باشد.


THE ORIGINAL AND ALL COPIES OF THIS DRAWING TOGETHER WITH
THE COPYRIGHT THEREIN ARE THE SOLE PROPERTY OF
N.I.S.O.C./ FIELDS

EPC CONTRACTOR:   HIRGAN ENERGY – DESIGN & INSPECTION COMPANIES	EPD/EPC CONTRACTOR (GC):   PETROIRAN DEVELOPMENT COMPANY
---	--

BINAK OILFIELD DEVELOPMENT
SUB-SURFACE WORK PACKAGES
W007S WHF & EXTENSION OF BINAK B/C

DRAWING TITLE:
ARCHITECTURAL DRAWING FOR SECURITY BUILDING OF WELL PADS - W007S
DETAILS


NO CONSTRUCTION PERMITTED UNLESS DRAWING APPROVED						
APPROVED FOR CONSTRUCTION				BY:	DATE:	
BUDGET REF.	LOCATION	SIZE	CLASS	SERIAL NO.	SHEET	REVISION
053-073-9184	F	4	B	708045	10 OF 11	D04

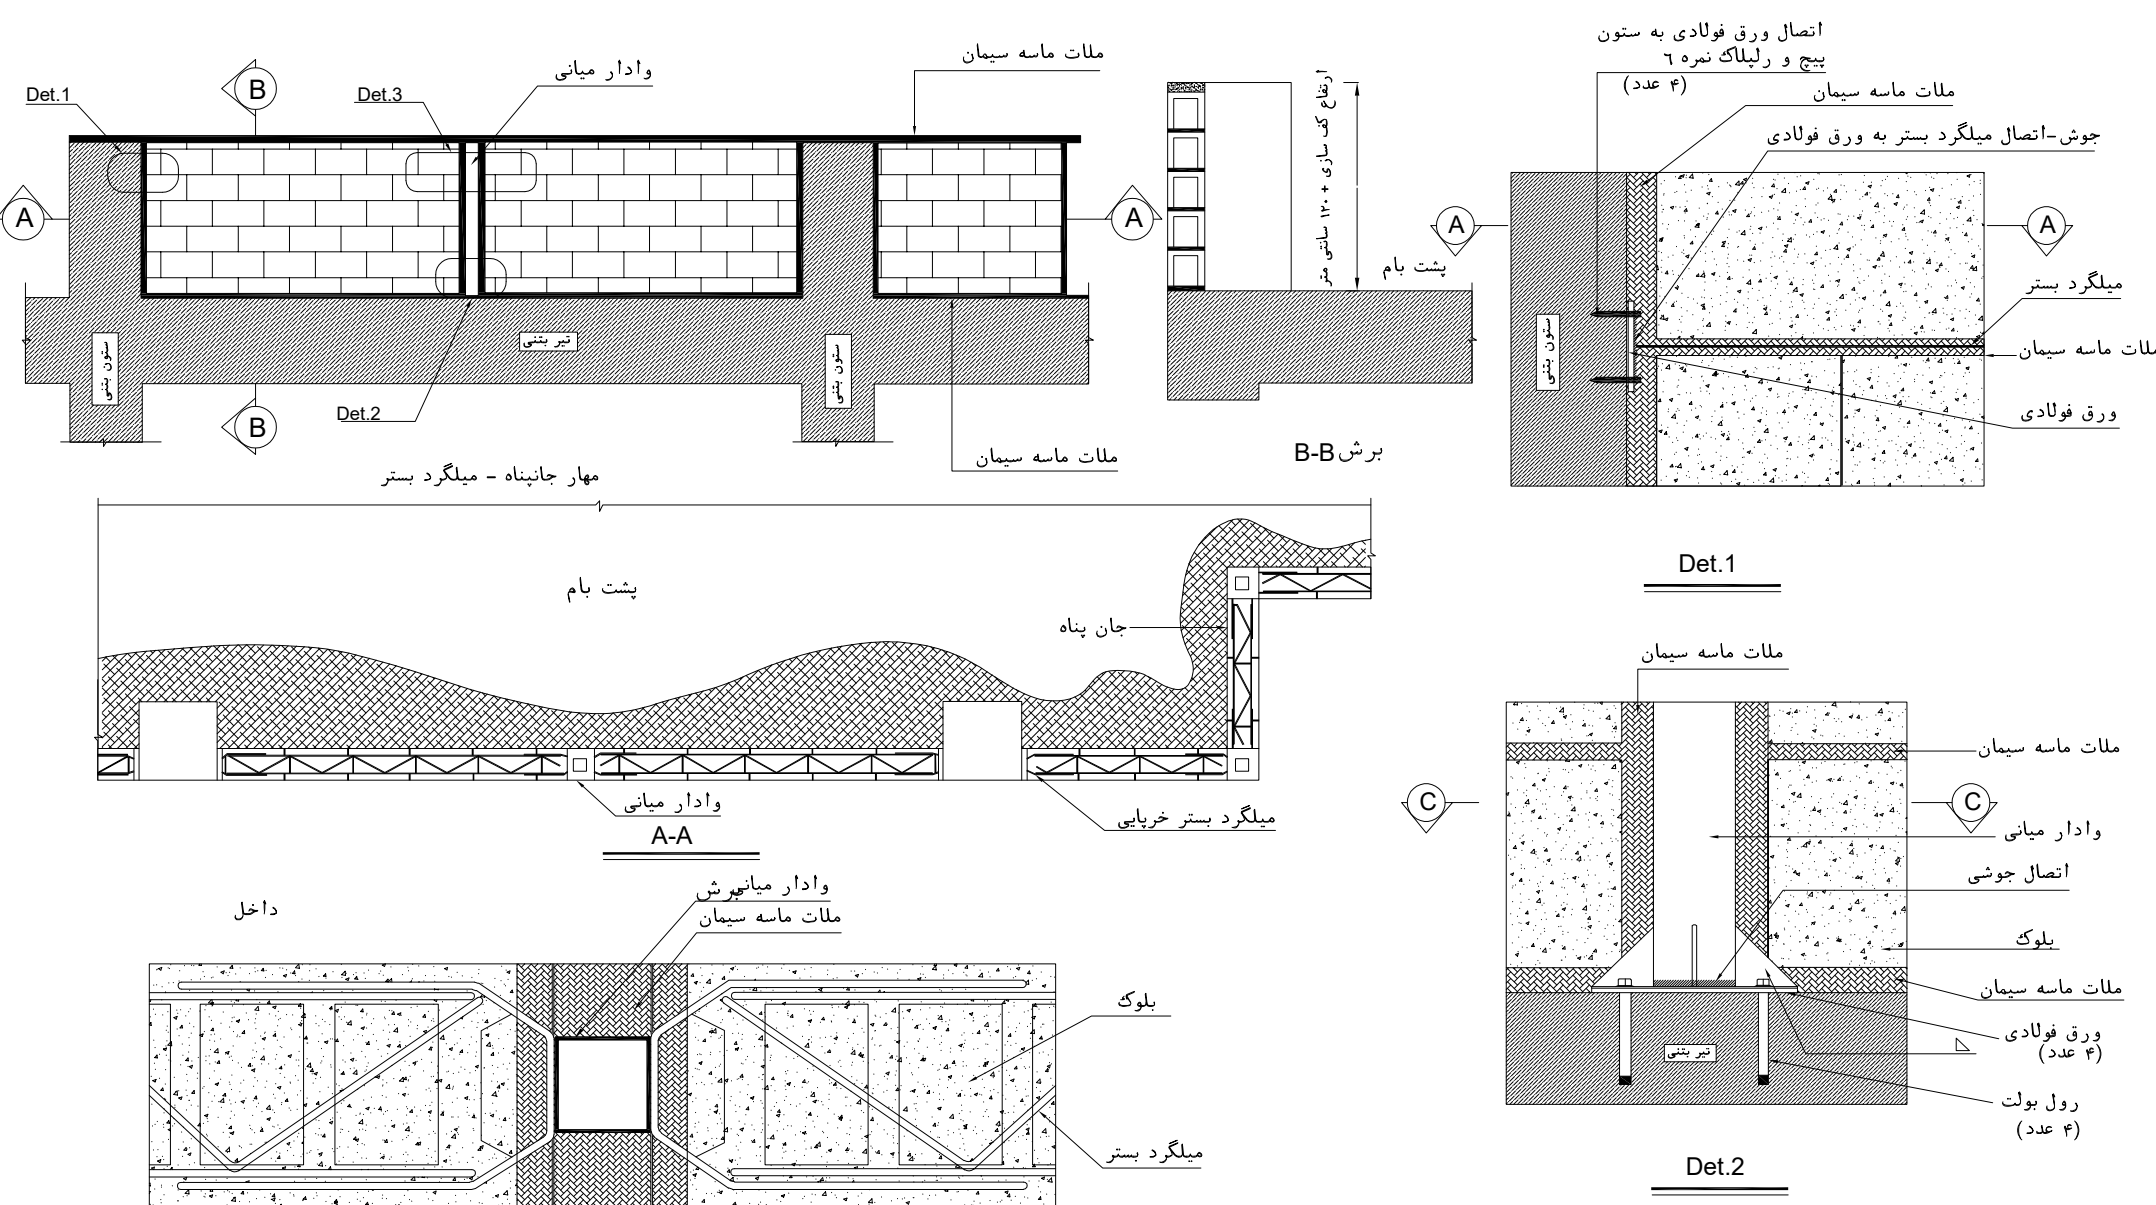

SECTION A-A


Det.3

نحوه مهار جان پناه غیر مسلح بنایی
ورق فولادی مستطیلاری تیر بنی
رول بولت مشهور
اتصال وادر میانی به ورق با جوش

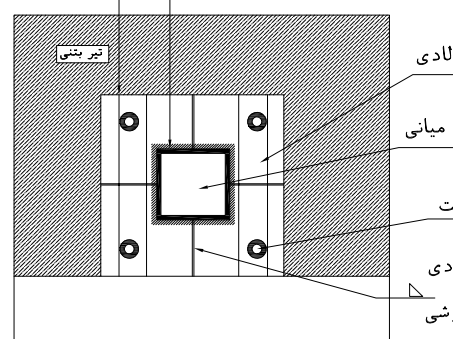


SECTION C-C

Det.2

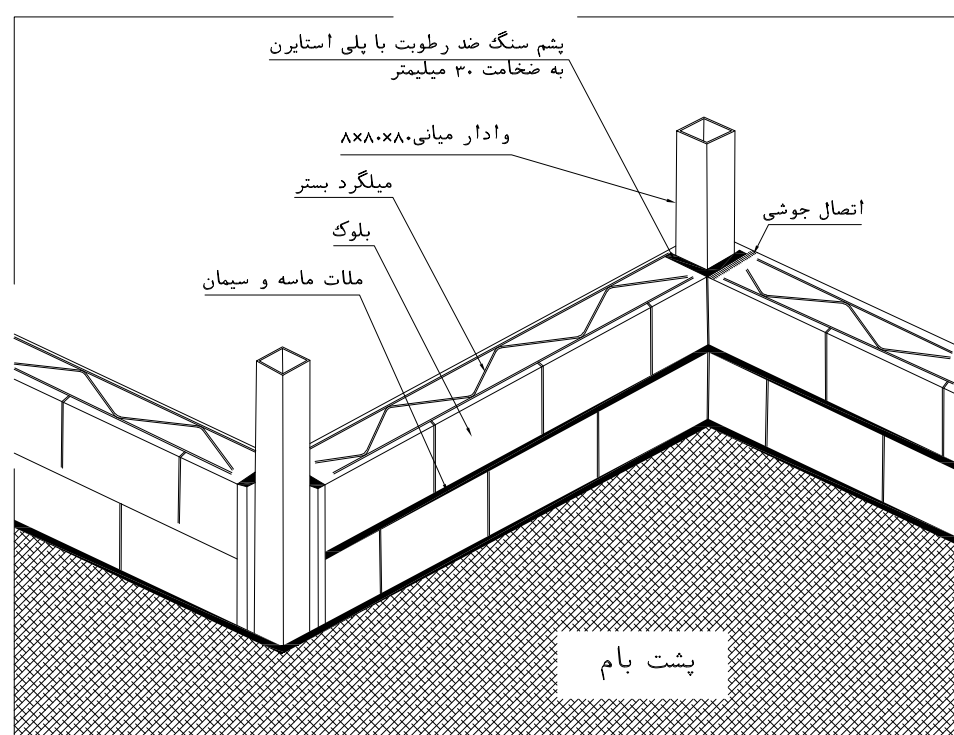


Perspective

مهار جان پناه بنایی توسط وادر افزای

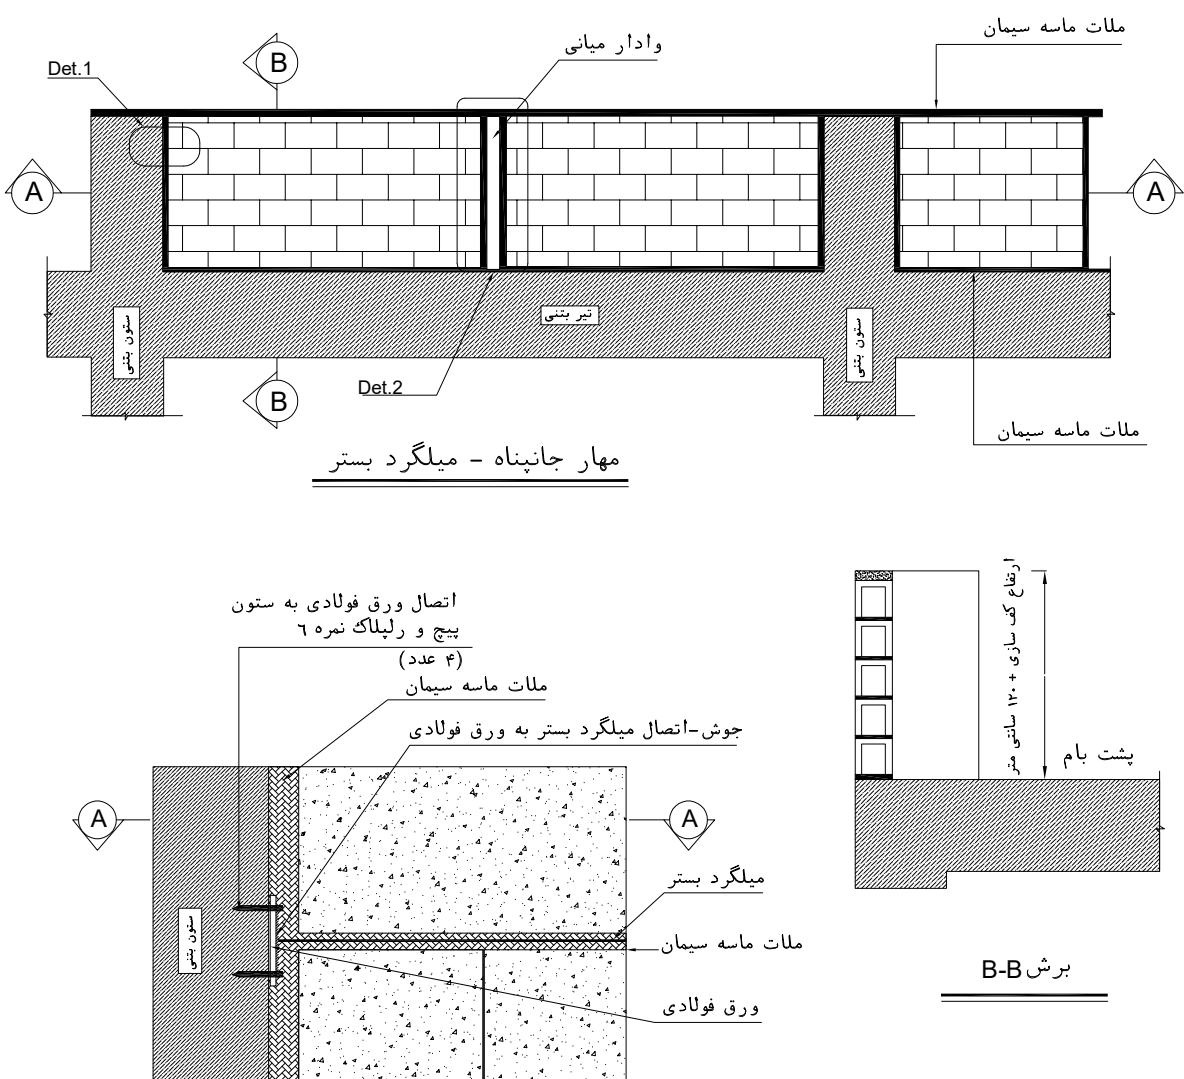


Det.1

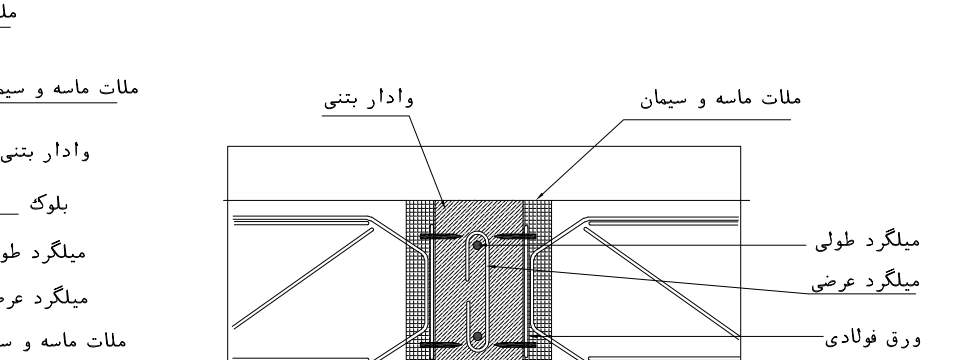


SECTION C-C

Det.2


جزئیات اجرایی اتصال جان پناه با وادر بنی

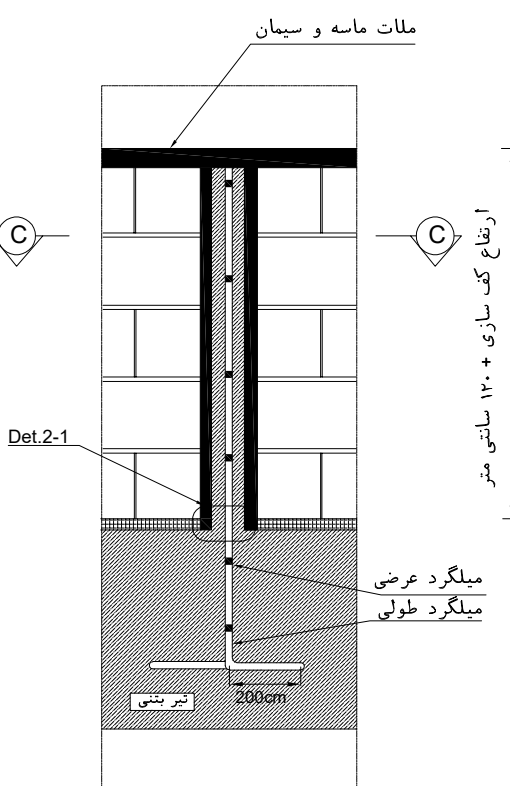



Det.2

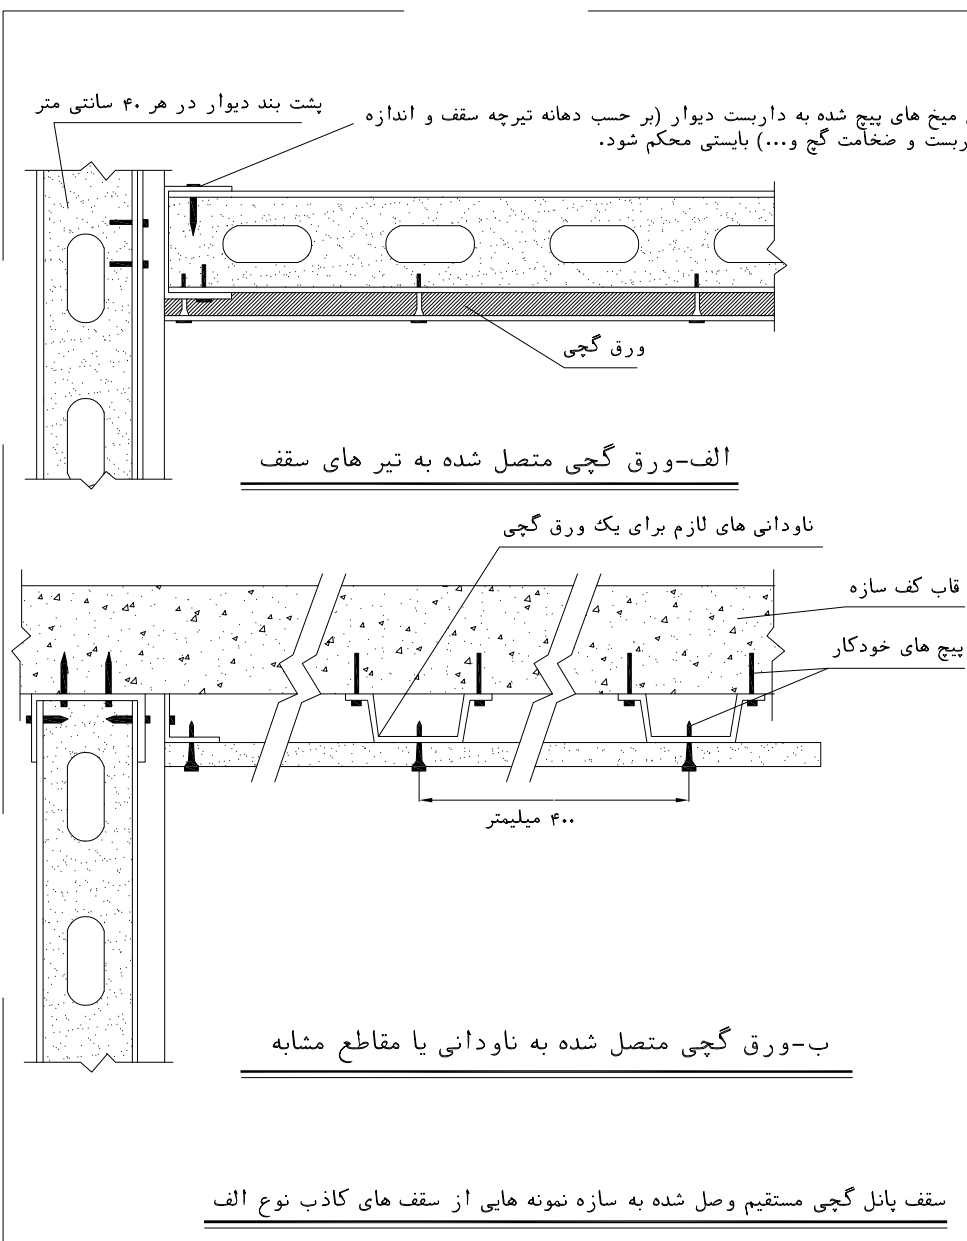

الف-ورق گچی متصل شده به تیر های سقف

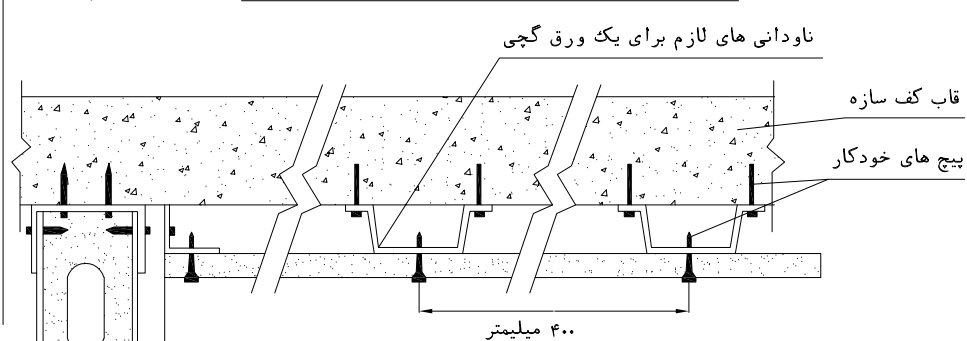


ب-ورق گچی متصل شده به ناودانی یا مقاطع مشابه

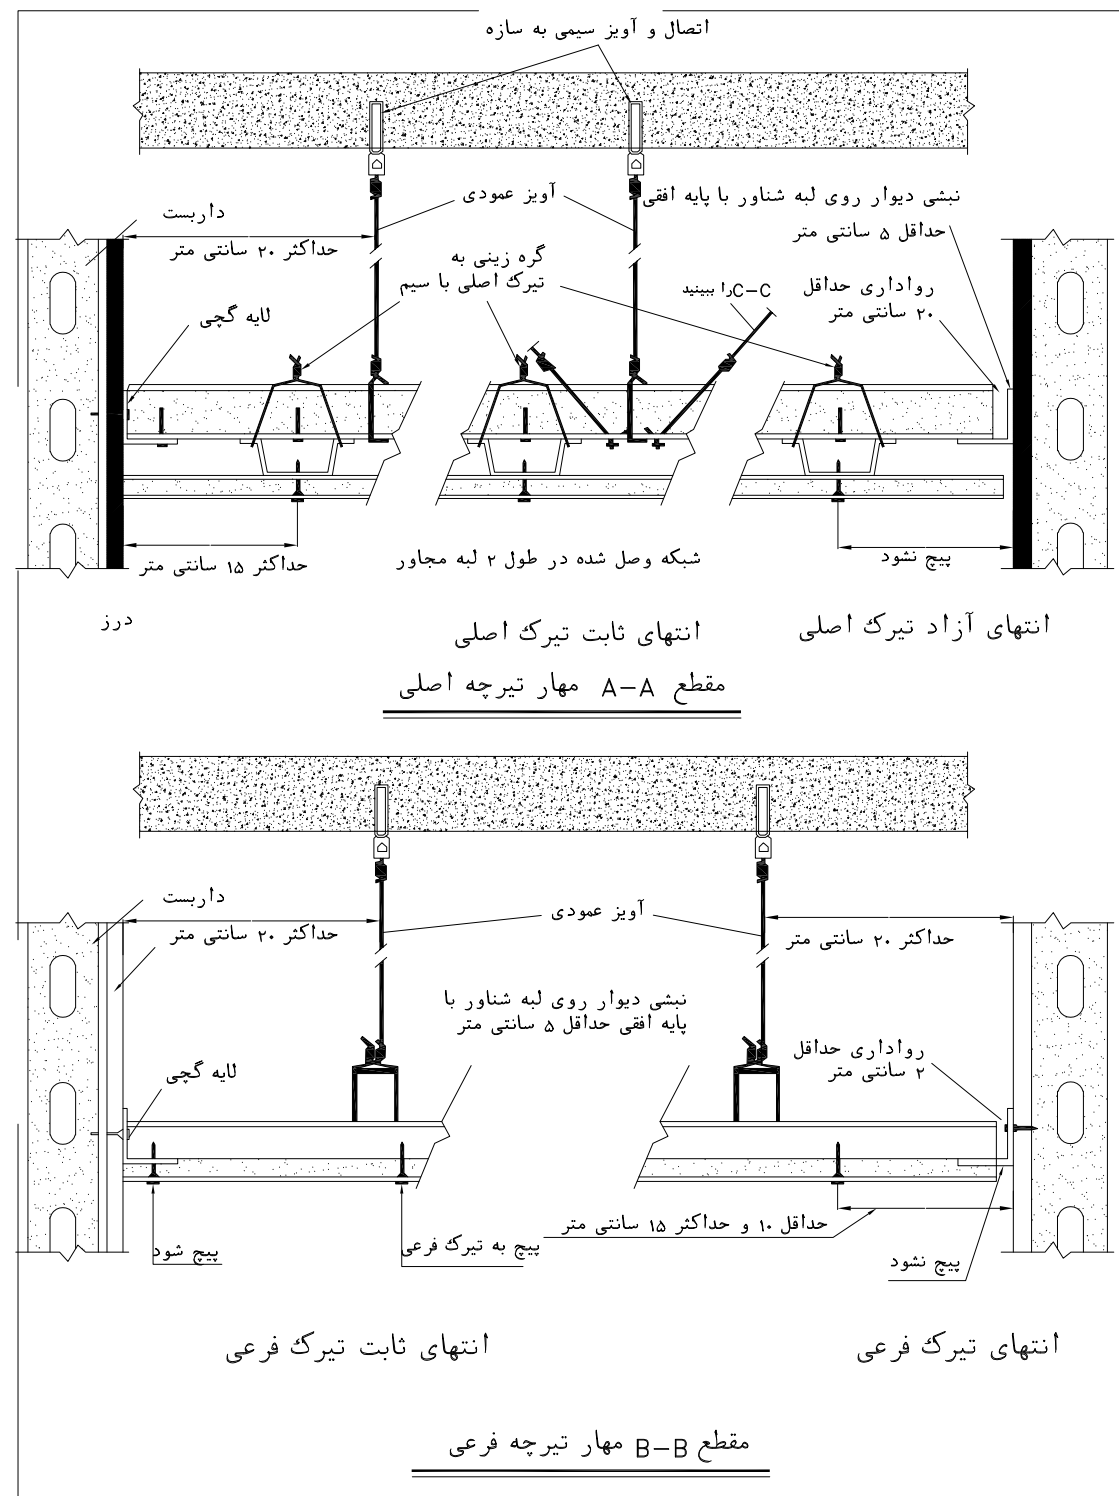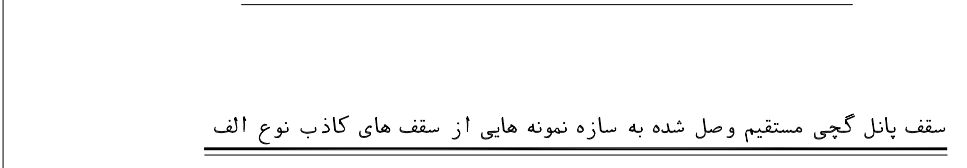


انتهای آزاد تیرک اصلی

مقطع A-A مهار تیرچه اصلی

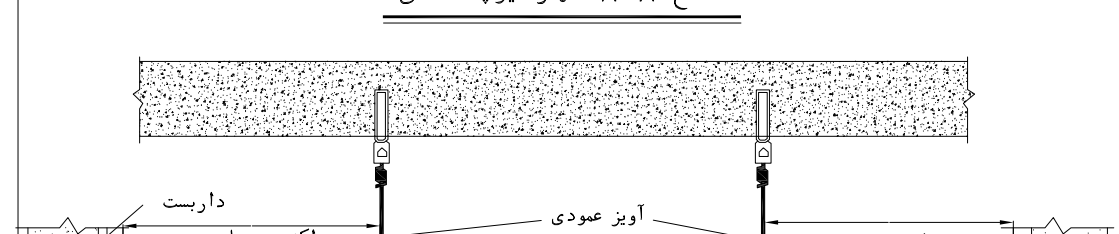

انتهای تیرک فرعی

مقطع B-B مهار تیرچه فرعی

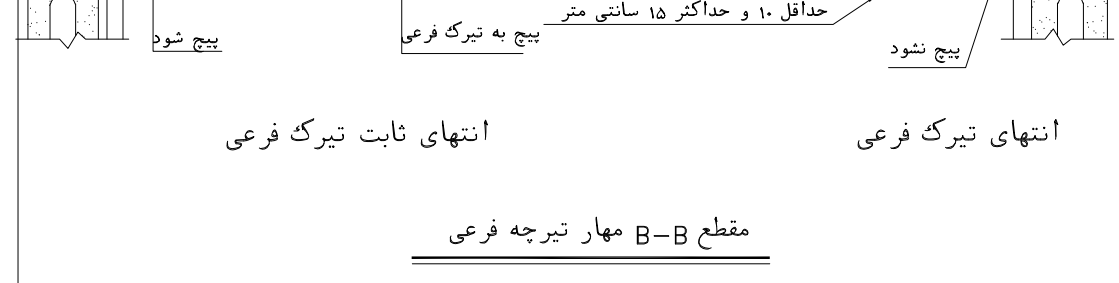

NOTES

- 1- DIMENSIONS ARE IN "mm" AND ELEVATIONS IN "m" UNLESS SPECIFIED .
- 2- ALL DIMENSIONS AND ELEVATIONS SHALL BE CHECKED BY THE CONTRACTOR PRIOR TO CONSTRUCTION.
- 3- CONTRACTOR SHALL COMPARE ALL ARCHITECTURAL, MECHANICAL, ELECTRICAL, PIPING AND STRUCTURAL DRAWINGS AND IN CASE OF ANY CONFLICTS OR DISCREPANCY, INFORM THE ENGINEER.
- 4- SLAB ON GRADE SHALL BE CONSTRUCTED AFTER EXECUTION OF CABLE TRENCH & EQUIPMENTS FOUNDATION.
- 5- ALL MATERIALS ARE SELECTED FROM THE HIGHEST QUALITY AND SHALL BE APPROVED BY THE CLIENT.
- 6- FOR COORDINATE REFER TO FINISH GRADING DOCUMENTS.
- 7) REFERENCE COORDINATES E=1000.000 , N=1000.000 REFER TO X=437425 , Y=3290543 UTM.
- 8) FINISH GRADING LEVEL (W007S) ELEVATION : +26.00 (MEAN SEA LEVEL)
+26.05 m (GLOBAL) = ±0.00 (LOCAL)
- 9) ALL EXTERNAL OPENINGS (WINDOWS AND DOORS) SHALL BE FIRE PROOF.
- 10) DOUBLE GLAZED WINDOW WITH 246mm REINFORCED GLASS AND 6mm GAS FILLED GAP.
- 11) WC DOORS SHALL BE WATERPROOF ABS TYPE WITH CLOSER MECHANISM.
- 12) KNAUF GYPSUM BOARD TILES (60*60) cm (REGULAR 9.5 mm THICKNESS) WITH (1063).
- 13) KNAUF PVC-COATED GYPSUM BOARD TILES (60*60)-(REGULAR 9.5mm THICKNESS) WITH (1063)-(PVC THICKNESS 0.35mm).

LEGEND


	BRICK WALL		BRICK FACING
	ANTI-ACID CERAMIC		CEMENT SAND
	TOVENAN COURSE		BLOCKAGE
	POLYETHYLENE SHEET		LEAN CONCRETE
	REINFORCED CONCRETE ACCORDING TO STR.DWG		TERRAZZO TILE
	CHEQUERED PLATE TRENCH CAP		
	HOT DEEP GALVANIZED SHEET		
	SOFT SAND		

F.F.L.	FINISHED FLOOR	T.O.B.	TOP OF BEAM
T.O.W.A.	TOP OF WALKWAY	B.O.C.	BOTTOM OF CAGE
T.O.P.	TOP OF PARAPET	T.O.S.	TOP OF SLAB
T.O.C.	TOP OF CAGE	B.O.S.	BOTTOM OF SLEEVE
T.O.D.	TOP OF DOOR	T.O.F.	TOP OF FOUNDATION
F.G.L.	FINISHED GRADING LEVEL		

REFERENCE DRAWING

STANDARD DRAWING FOR ARCHITECTURAL DETAILS	DRG. No.
STANDARD DRAWING FOR LADDER & SAFETY CAGE	BK-GNRL-PEDCO-000-AR-DW-0001
STANDARD DRAWING FOR LADDER & SAFETY CAGE	BK-GNRL-PEDCO-000-ST-DW-0009
PLOT PLAN DRAWING - W007S	BK-W007S-PEDCO-110-PI-PY-0002
FOUNDATION DRAWING FOR SECURITY BUILDING FOR WELL PADS - W007S	BK-W007S-PEDCO-110-ST-DW-0008
STRUCTURAL DRAWING FOR SECURITY BUILDING FOR WELL PADS - W007S	BK-W007S-PEDCO-110-ST-DW-0009
HVAC SYSTEM LAYOUT FOR SECURITY BUILDING - W007S	BK-W007S-PEDCO-110-HV-PY-0003
PLUMBING & SEWAGE PIPING LAYOUT FOR SECURITY BUILDING - W007S	BK-W007S-PEDCO-110-HV-PY-0004
LIGHTING & SMALL POWER LAYOUT FOR SECURITY BUILDING OF WELL PADS	BK-SIGRL-PEDCO-110-BL-PY-0005

KEY PLAN

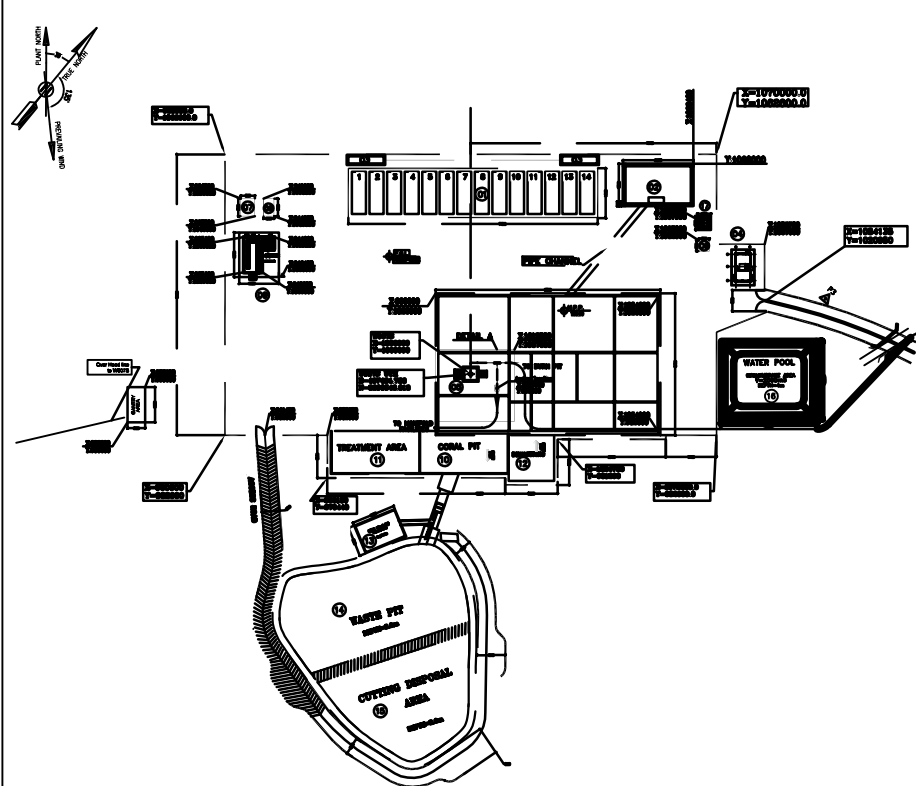

D04	OCT.2023	APC	R.BERLOUJE	M.FAKHARIAN	S.Paramarspour	** **																		
D03	AUG.2023	IFA	R.BERLOUJE	M.FAKHARIAN	A.M.MOHSSENI	** **																		
D02	JUN.2023	IFA	R.BERLOUJE	M.FAKHARIAN	A.M.MOHSSENI	** **	***	*****	** **	*** ****	** **	*****	** **	*****	** **	*****	** **	*****	** **					
D01	FEB.2023	IFA	R.BERLOUJE	M.FAKHARIAN	M.Mehrshad	** **	REV.	DESCRIPTION	BY	DATE	BY	DATE	BY	DATE	BY	DATE	BY	DATE	BY					
D00	APR.2022	IPC	R.BERLOUJE	M.FAKHARIAN	M.Mehrshad	** **			CHECKED				REV. APPR.											
REV.	DATE	P.O.I.S	PREP.	CHK.	APP.	AUT.	اصل و کلیه نسخ این نقشه و حق افشای متعلق به شرکت این مناطق نفت خیز جنوب می باشد.																	
PROJECT NAME:							BINAK OILFIELD DEVELOPMENT/SUB-SURFACE WORK PACKAGES W007S WHF & EXTENSION OF BINAK B/C							 THE ORIGINAL AND ALL COPIES OF THIS DRAWING TOGETHER WITH THE COPYRIGHT THEREIN ARE THE SOLE PROPERTY OF N.I.S.O.C./ FIELDS										
PROJECT NO.:							971020																	
EPC CONTRACTOR:							EPD/EPC CONTRACTOR (GC):							BINAK OILFIELD DEVELOPMENT SUB-SURFACE WORK PACKAGES W007S WHF & EXTENSION OF BINAK B/C										
  HIRGAN ENERGY – DESIGN & INSPECTION COMPANIES							 PETROIRAN DEVELOPMENT COMPANY																	
							DATE							SCALE										
							DRAWING BY							CHECKED BY										
							PROJECT EN																	
DRAWING TITLE:							NO CONSTRUCTION PERMITTED UNLESS DRAWING APPROVED																	
ARCHITECTURAL DRAWING FOR SECURITY BUILDING OF WELL PADS – W007S DETAILS							APPROVED FOR CONSTRUCTION							BY: DATE:										
SCALE		SIZE		DRAWING NO.			SHEET NO.		REV.		BUDGET REF.		LOCATION		SIZE		CLASS		SERIAL NO.		SHEET		REVISION	
AS SHOWN		A1		BK-W007S-PEDCO-110-AR-DW-0004			11 OF 11		D04		053-073-9184		F		4		B		708045		11 OF 11		D04	