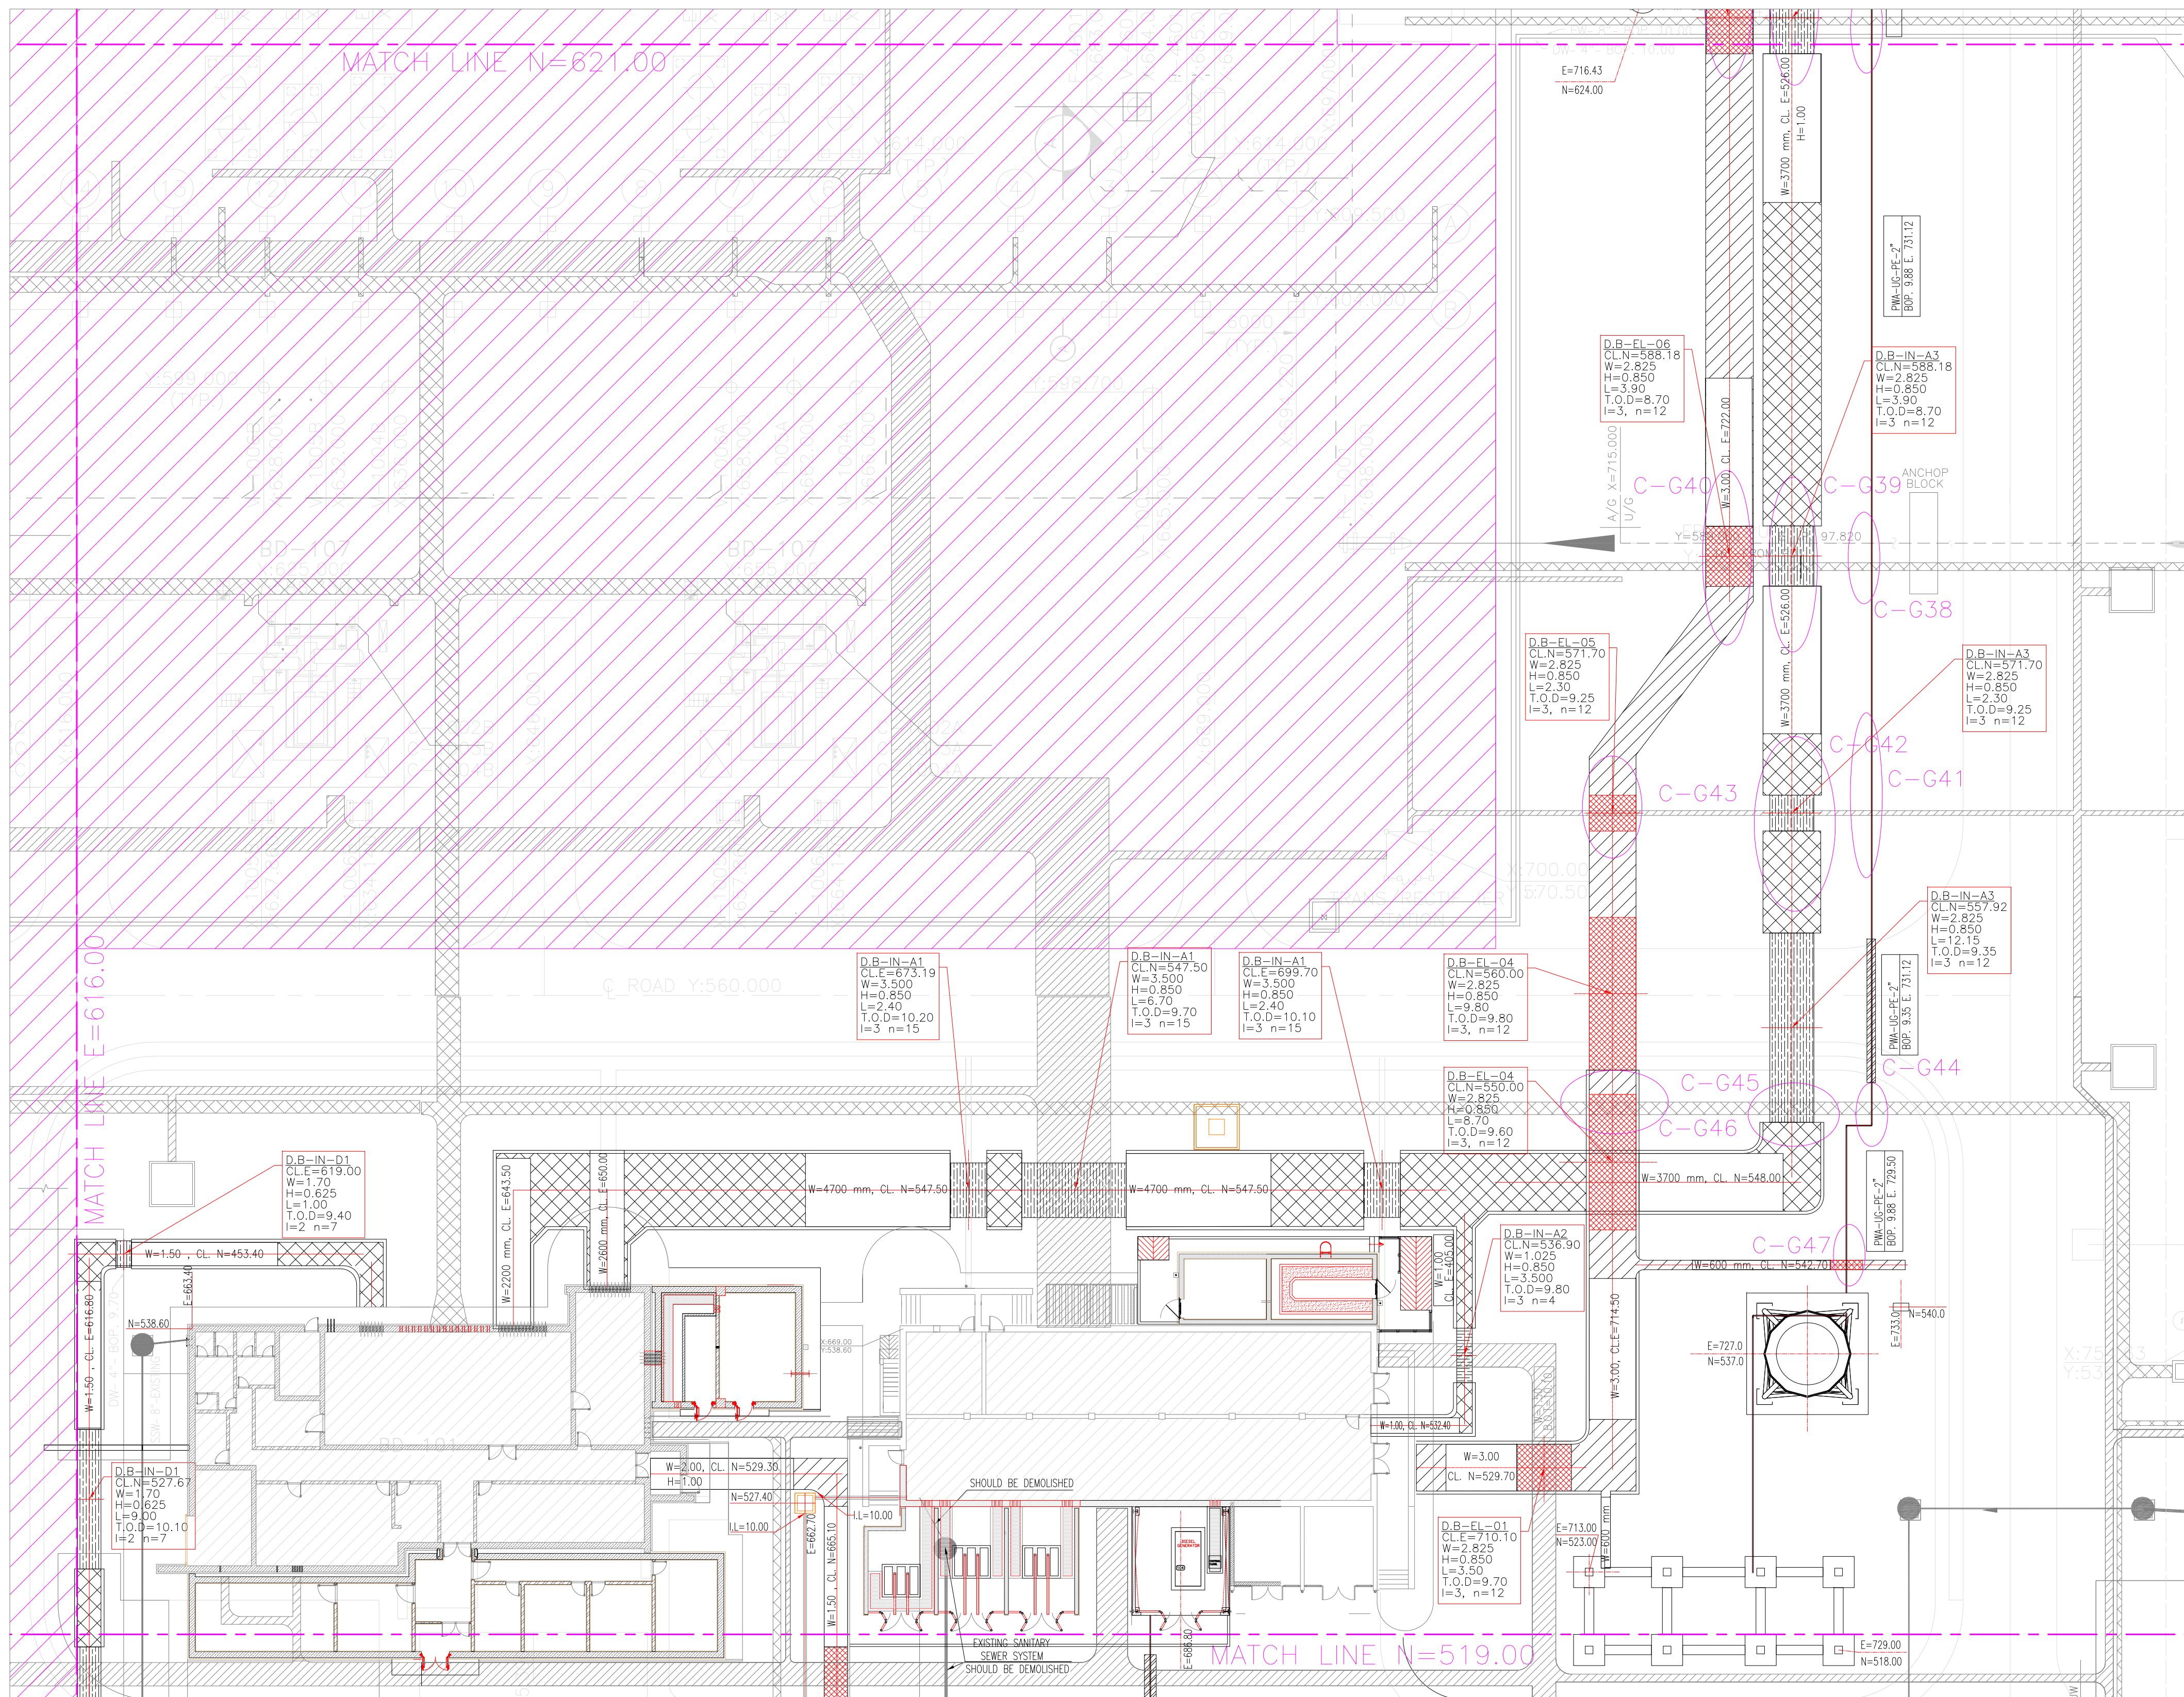
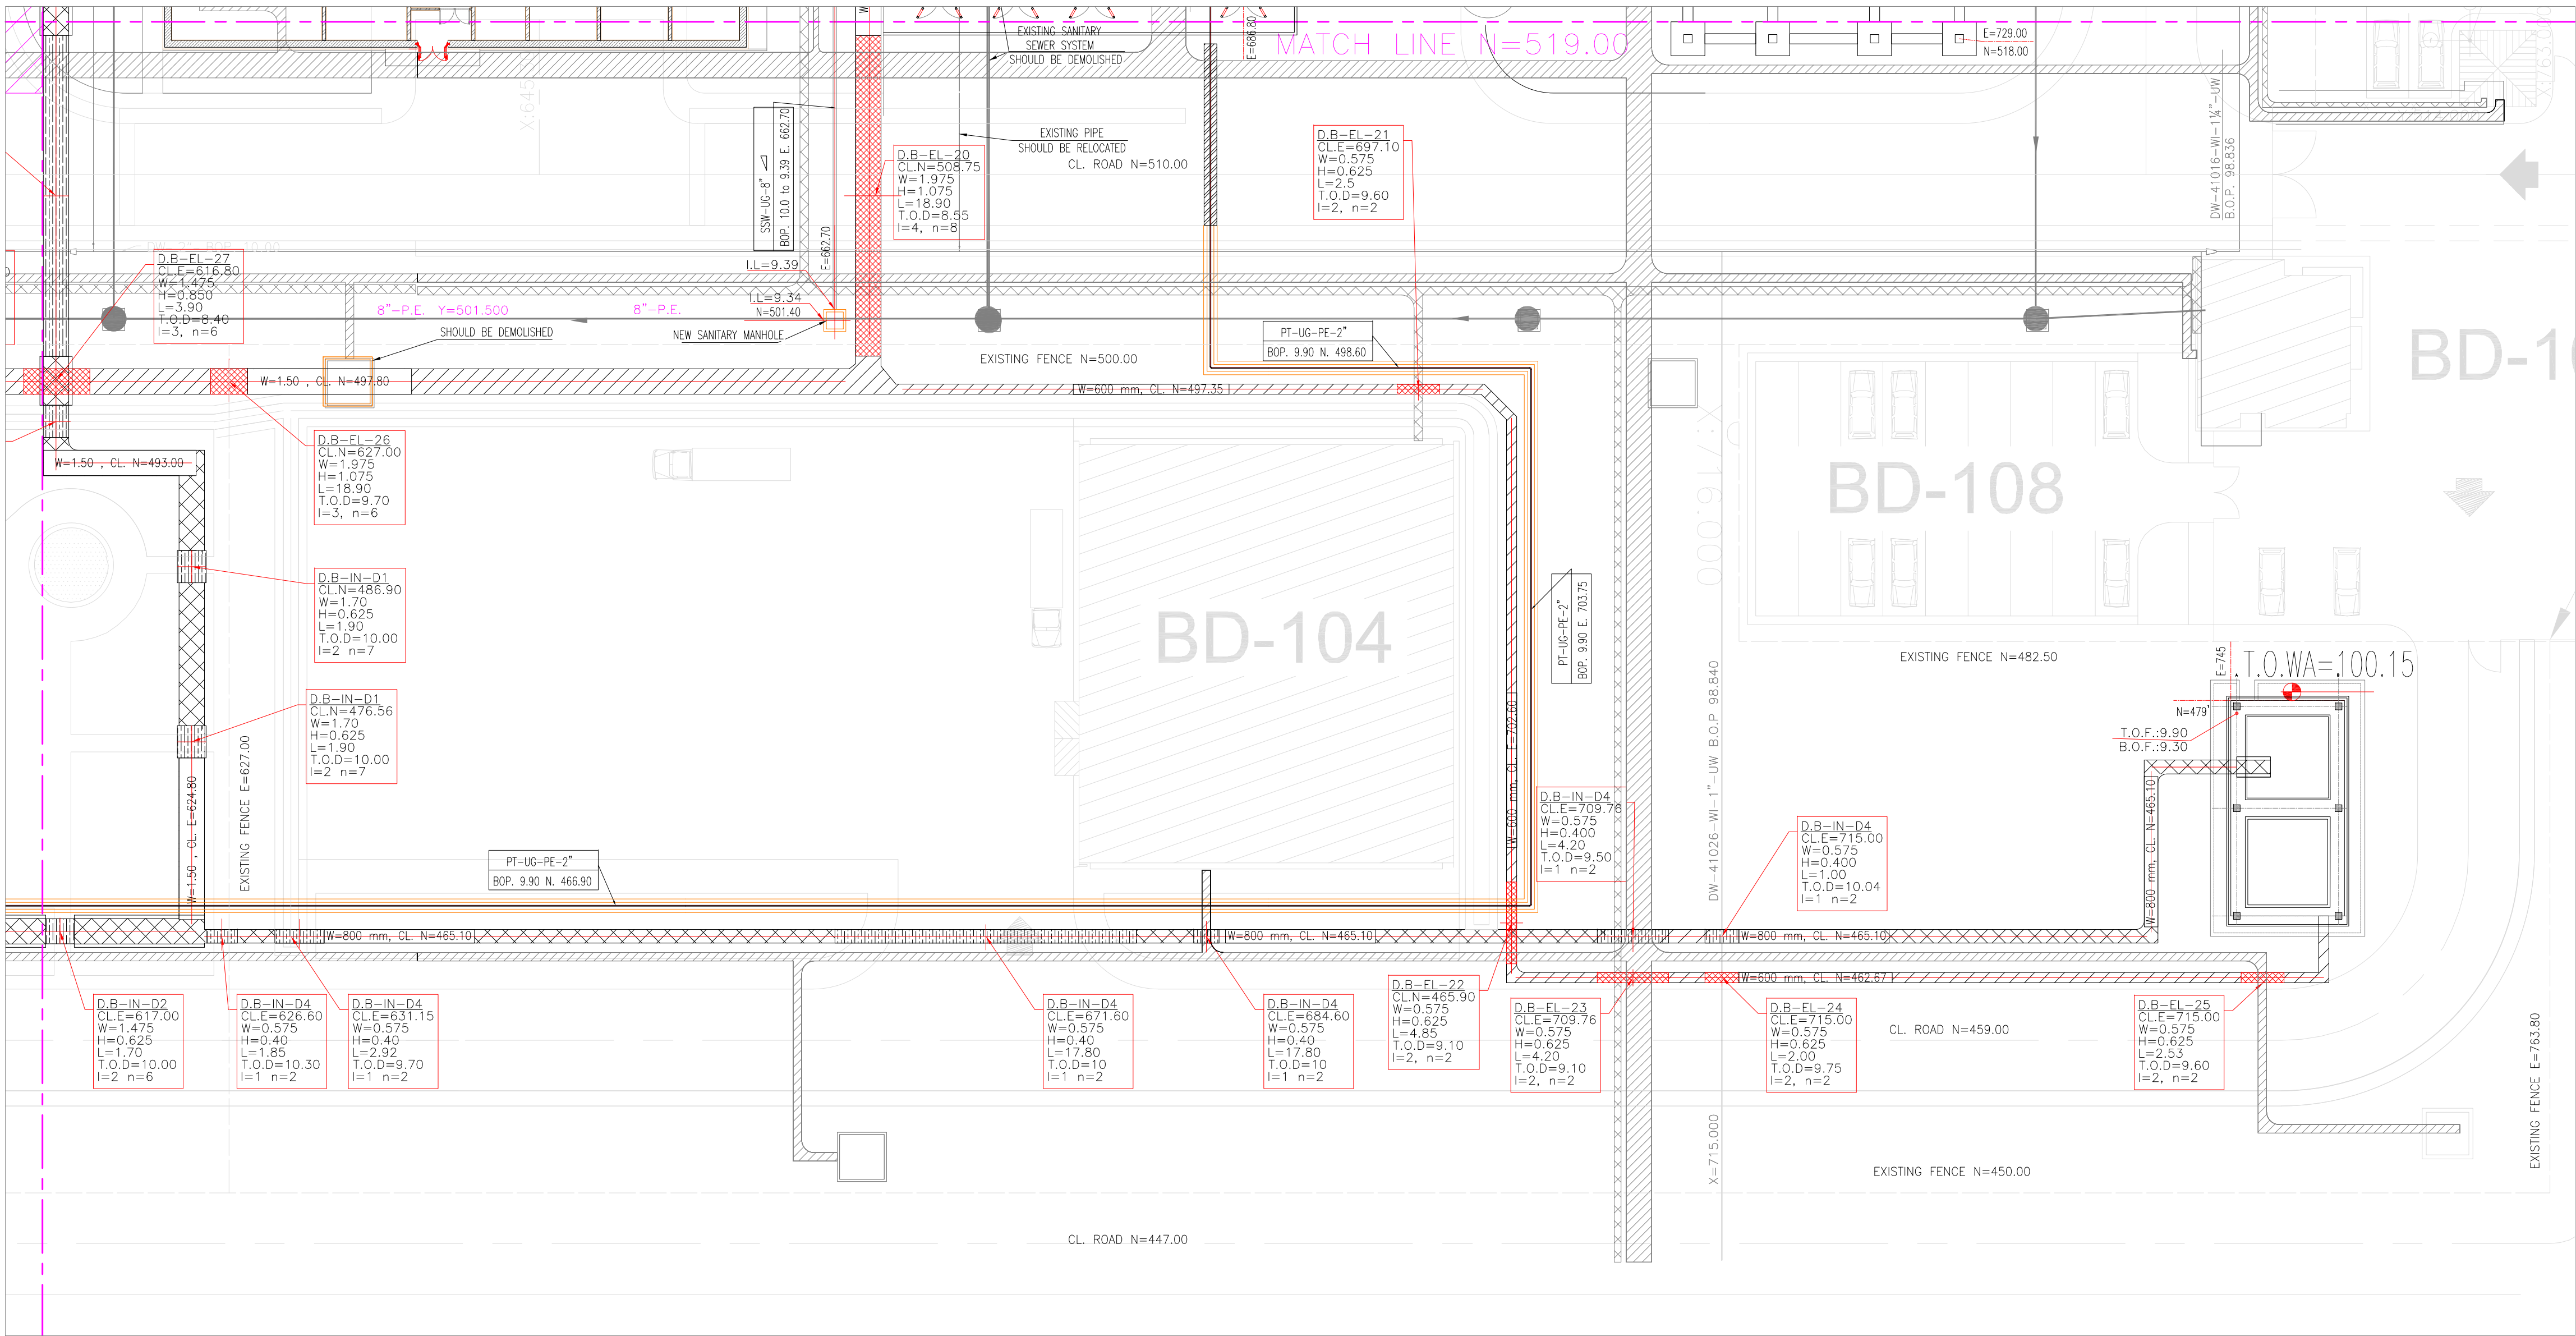
[illegible]

 
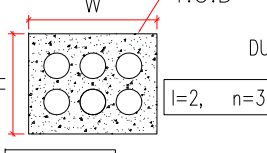
 
 
 
 
 
 
 
 
[illegible]



SC.1:250

[illegible]

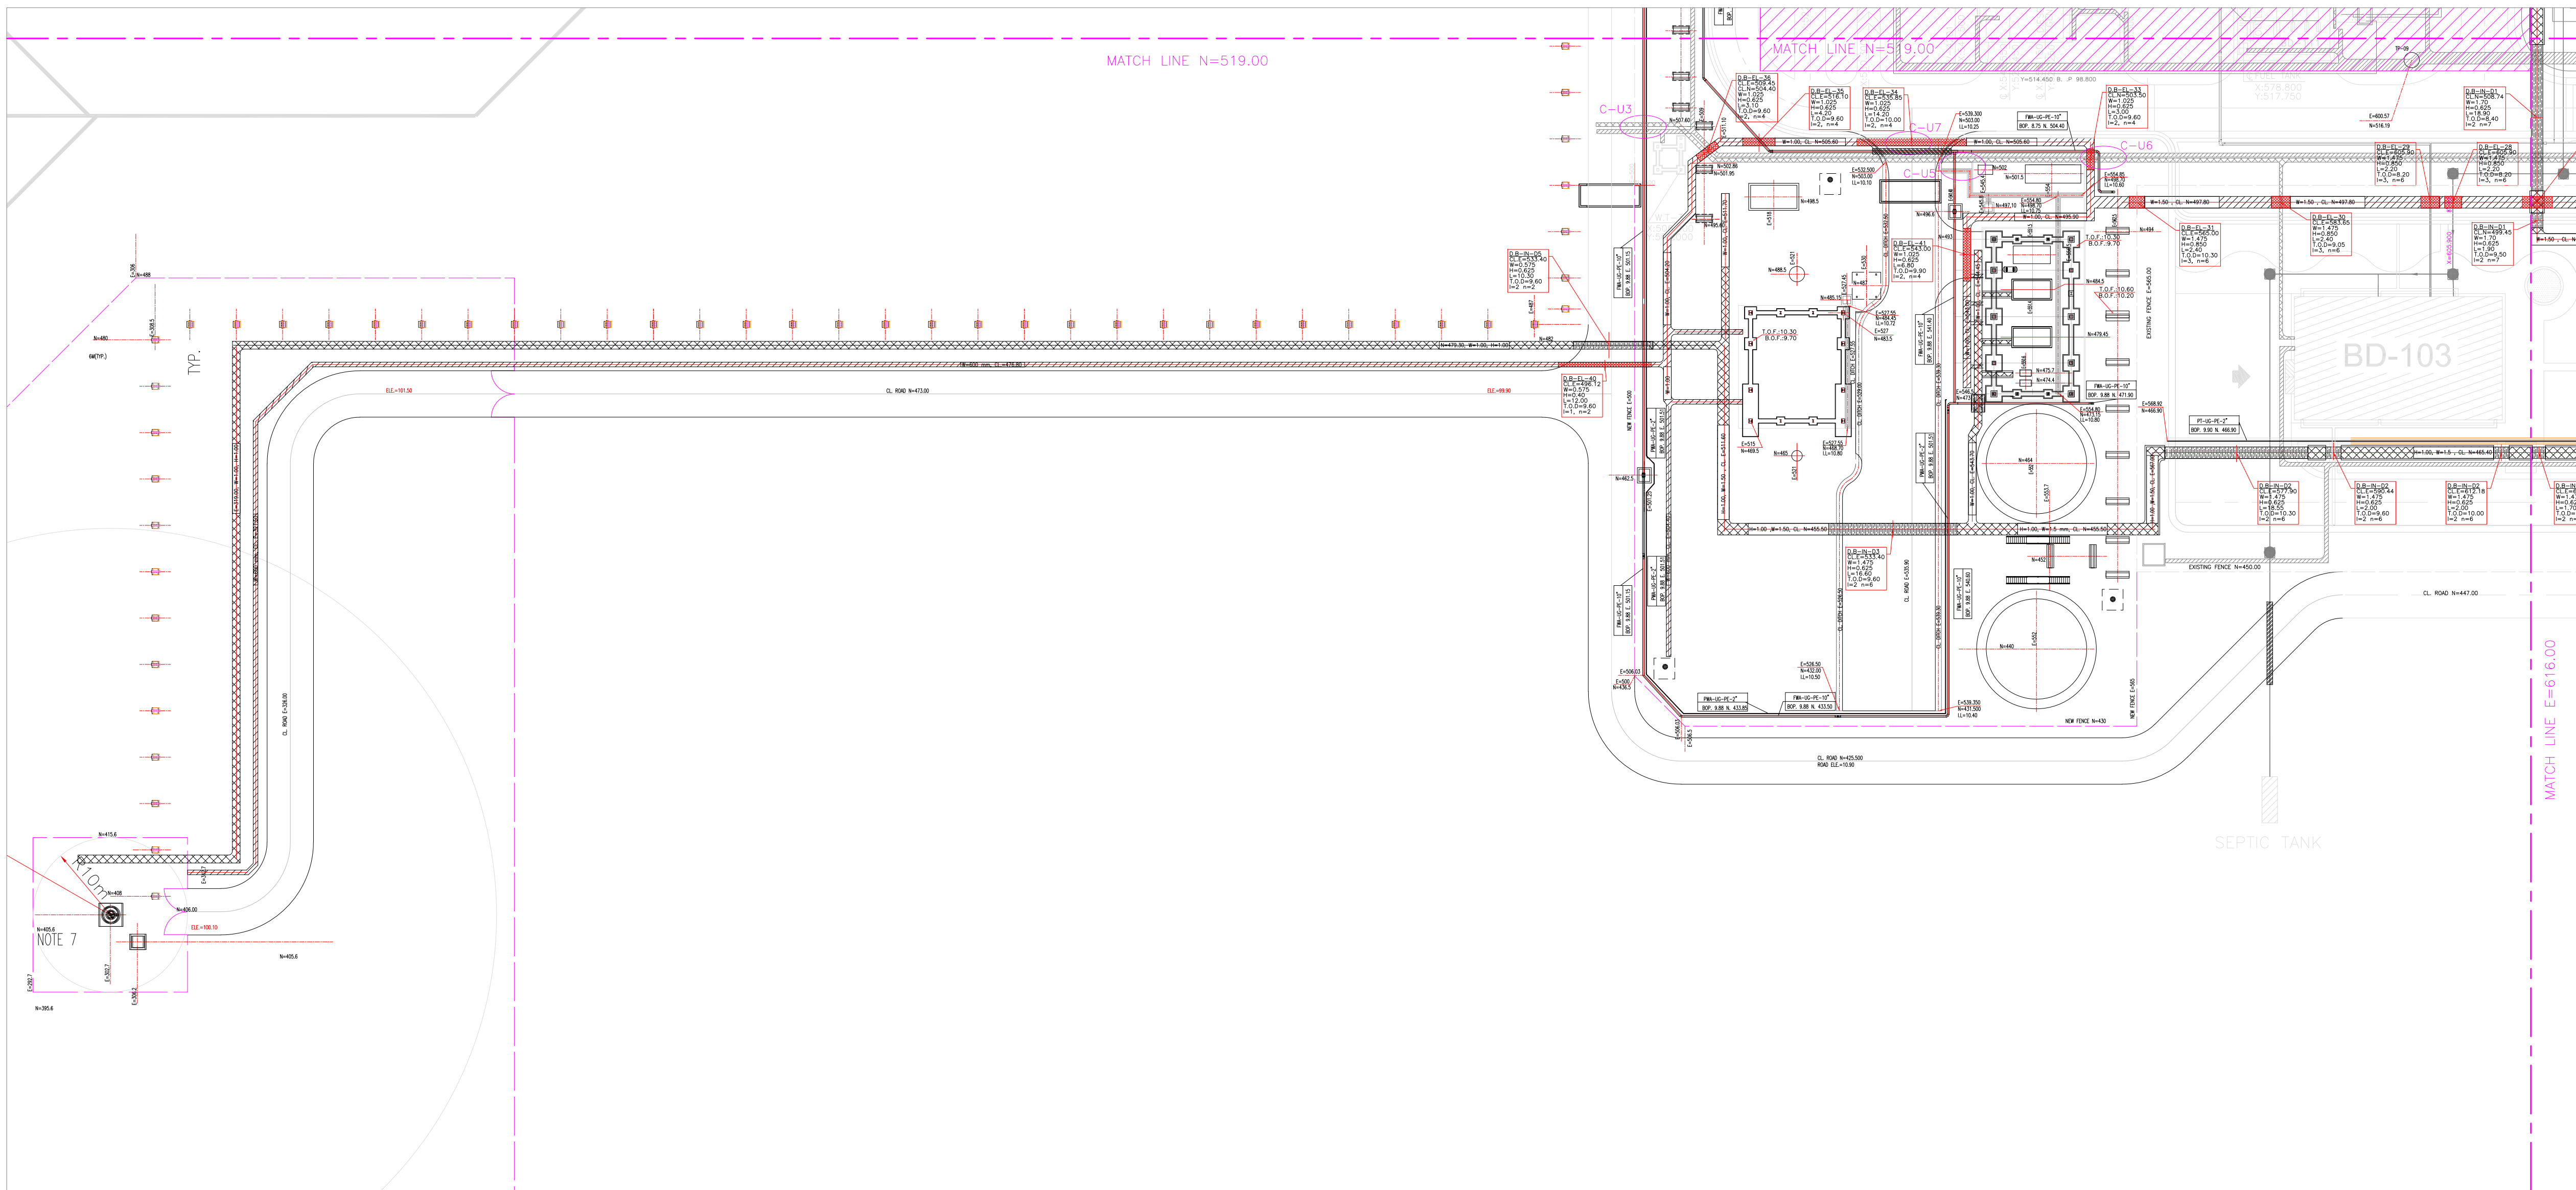
NOTES																			
1.	ALL COORDINATES AND ELEVATIONS ARE IN METERS.																		
2.	ALL COORDINATES ARE IN LOCAL SYSTEM., WITH REFERENCE TO SITE LOCAL DATUM POINT.																		
	<table> <tr> <th>LOCAL</th><th>UTM</th></tr> <tr> <td>E=500.000</td><td>E=437384.709</td></tr> <tr> <td>A N=500.000</td><td>N=3289737.469</td></tr> <tr> <td>E=485.337</td><td>E=437245.830</td></tr> <tr> <td>B1 N=788.941</td><td>N=3289991.269</td></tr> <tr> <td>Z=12.170</td><td>ELEV.=12.17</td></tr> <tr> <td>E=798.452</td><td>E=437704.660</td></tr> <tr> <td>B2 N=382.283</td><td>N=3289761.280</td></tr> <tr> <td>Z=13.410</td><td>ELEV.=13.41</td></tr> </table>	LOCAL	UTM	E=500.000	E=437384.709	A N=500.000	N=3289737.469	E=485.337	E=437245.830	B1 N=788.941	N=3289991.269	Z=12.170	ELEV.=12.17	E=798.452	E=437704.660	B2 N=382.283	N=3289761.280	Z=13.410	ELEV.=13.41
LOCAL	UTM																		
E=500.000	E=437384.709																		
A N=500.000	N=3289737.469																		
E=485.337	E=437245.830																		
B1 N=788.941	N=3289991.269																		
Z=12.170	ELEV.=12.17																		
E=798.452	E=437704.660																		
B2 N=382.283	N=3289761.280																		
Z=13.410	ELEV.=13.41																		
3.	ALL ELEVATION REFERENCES IS MEAN SEA LEVEL.																		
4.	ALL DIMENSIONS ARE IN MILLIMETERS UNLESS STATED OTHERWISE.																		

	FIRE SHED		GRAVITY PIPE SLOPE INDICATOR
	DUCT BANK		NEW PIPE
	BERRIED ELECTRICAL TRENCH		DELUGE VALVE
	BERRIED INSTRUMENT TRENCH		BEARING SLAB
	CONCRETE ELECTRICAL TRENCH		NEW DUCT BANK
	CONCRETE INSTRUMENT TRENCH		FOUNDATION
	EXISTING ELECTRICAL TRENCH		CROSSING POINTS
	EXISTING INSTRUMENT TRENCH		SANITARY MANHOLE
	GRAVITY PIPE IN EL, FW, UC		VALVE PIT
	GRAVITY PIPE IN EL, FW, UC		LIGHTING TOWER
	GRAVITY PIPE IN EL, FW, UC		GRAVITY PIPE IN EL, FW, UC
	GRAVITY PIPE IN EL, FW, UC		GRAVITY PIPE IN EL, FW, UC
	GRAVITY PIPE IN EL, FW, UC		GRAVITY PIPE IN EL, FW, UC
	GRAVITY PIPE IN EL, FW, UC		GRAVITY PIPE IN EL, FW, UC

REFERENCE DRAWING	DRG. No.
SPECIFICATION FOR ROAD & PAVING	BK-GNRAL-PEDCO-000-CV-SP-0002
STANDARD DRAWING FOR ROADS	BK-GNRAL-PEDCO-000-CV-DW-0003
STANDARD DRAWING FOR PAVINGS	BK-GNRAL-PEDCO-000-CV-DW-0035
UNIT PLOT PLAN DRAWING	BK-GCS-PEDCO-120-PI-PY-0001
ROUGH GRADING PLAN & DETAILS	BK-GCS-PEDCO-120-CV-PY-0007
SHANK NEW COMPRESSOR GAS STATION PLOT PLAN (BASIC PACKAGE)	1560-BK-NCS-PI-DWG-0001
DIKE WALL DRAWING FOR LEAN GLYCOL STORAGE TANK (TK-2102)	BK-GCS-PEDCO-120-ST-DW-0033
FOUNDATION DRAWING FOR GLYCOL SUMP PIT (SU-2101)	BK-GCS-PEDCO-120-ST-DW-0035
PARALE ELECTRICAL CABLE ROUTE & SECTION LAYOUT	BK-GCS-PEDCO-120-EL-PY-0005
INSTRUMENT/FAG CABLE TRENCH/ROUTE LAYOUT DRAWING	BK-GCS-PEDCO-120-IN-PY-0004
UG PIPING PLAN	BK-GCS-PEDCO-120-PI-DW-0005
ROAD, PAVING AND PLANT FINISH GRADING LAYOUT & SECTIONS	BK-GCS-PEDCO-120-CV-PY-0005

KEY PLAN

The map shows the Dnieper River at the top. A north arrow points upwards, labeled 'TRUE NORTH' and 'N'. The site is located south of the river, near a bridge. Key features labeled include 'CLINE', 'FLARE', 'BK. GCS', 'POWER STATION', and 'WELTY' (likely a well or water source). A yellow line indicates a path or boundary. The area is divided into several rectangular plots.



SC.1:250

[illegible]

3. ALL ELEVATION REFERENCES IS MEAN SEA LEVEL.
4. ALL DIMENSIONS ARE IN MILLIMETERS UNLESS STATED OTHERWISE.

Figure 1: Symbols for the layout of the sewerage system. The figure includes a grid of symbols for various components: Duct Bank (top left), Fire Shed (top right), Gravity Pipe Slope Indicator (top right), Berried Electrical Trench (middle left), Berried Instrument Trench (middle left), Concrete Electrical Trench (middle left), Concrete Instrument Trench (middle left), Existing Electrical Trench (middle left), Existing Instrument Trench (middle left), D.B. Bottom of Pipe (bottom left), D.B. Top of Trench (bottom left), D.B. Top of Duct Bank (bottom left), D.B. Bottom of Foundation (bottom left), Gravity Pipe Instrument (bottom right), Fire Water Under Ground (bottom right), Polyethylene Sanitary Pipe (bottom right), Sanitary Manhole (middle right), Valve Pit (middle right), and Lighting Tower (middle right). Each symbol is accompanied by a brief description.

REFERENCE	DRAWING	DRG. No.
SPECIFICATION FOR ROAD & PAVING	BK-GNRL-PEDCO-000-CV-SP-0002	
STANDARD DRAWING FOR ROADS	BK-GCS-PEDCO-000-CV-DW-0003	
STANDARD DRAWING FOR PAVINGS	BK-GNRL-PEDCO-000-CV-DW-0035	
PILOT PLAN DRAWING	BK-GCS-PEDCO-120-PI-PY-0001	
ROUGH GRADING PLAN & DETAILS	BK-GCS-PEDCO-120-CV-PY-0007	
SHAK NIP COMPRESSOR GAS STATION PLOT PLAN (BASIC PACKAGE)	1560-BK-NCS-PI-DWG-0001	
POUR WALL DRAWING FOR LEAN GLYCOL STORAGE TANK (TK-2102)	BK-GCS-PEDCO-120-ST-DW-0033	
FOUNDATION DRAWING FOR GLYCOL SUMP PIT (SU-2101)	BK-GCS-PEDCO-120-ST-DW-0035	
PARALLEL ELECTRICAL CABLE ROUTE & SECTION LAYOUT	BK-GCS-PEDCO-120-EL-PY-0005	
INSTRUMENT/FAG CABLE TRENCH/ROUTE LAYOUT DRAWING	BK-GCS-PEDCO-120-IN-PY-0004	
UG PIPING PLAN	BK-GCS-PEDCO-120-PI-DW-0005	
ROAD, PAVING AND PLANT FINISH GRADING LAYOUT & SECTIONS	BK-GCS-PEDCO-120-CV-PY-0005	

Crossing	F.G EL	NEW FW		NEW POTABLE		ELE. TRENCH or ELE. Duct Bank			INS. TRENCH or INS.Duct Bank			CIVIL TRENCH			EXISTING PIPE			EXISTING PIPE			CIVIL TRENCH			ELE. TRENCH or ELE. Duct Bank			FOUNDATION	
		B.O.P	T.O.P	B.O.P	T.O.P	TOP	BOTTOM	TYPE	TOP	BOTTOM	TYPE	TOP	BOTTOM	TYPE	B.O.P	T.O.P	TYPE	B.O.P	T.O.P	TYPE	TOP	BOTTOM	TYPE	TOP	BOTTOM	TYPE	B.O.F	T.O.F
C-U1	10.9	9.9	10.15	9.9	9.95	-	-	-	-	-	-	-	-	-	9.18	9.38	EXIST	-	-	-	-	-	-	-	-	-	-	-
C-U2	10.9	9.9	10.15	-	-	-	-	-	-	-	-	-	-	-	9.18	9.38	EXIST	-	-	-	-	-	-	-	-	-	-	-
C-U3	10.9	9.9	10.15	9.9	9.95	10.5	10.05	EXIST	10.05	9.8	EXIST	-	-	-	-	-	-	-	-	-	-	-	-	-	-	-	-	-
C-U4	10.9	9.15	9.35	-	-	-	-	-	-	-	-	FG	9.65	EXIST	-	-	-	-	-	-	-	-	-	-	-	-	-	-
C-U5	10.95	8.75	9	-	-	-	-	-	9.55	9.3	EXIST	FG	10.5	New	-	-	-	-	-	-	-	-	-	9.55	9.3	EXIST	-	-
C-U6	11	8.75	9	-	-	-	-	-	9.55	9.3	Exist	-	-	-	-	-	-	-	-	-	-	-	-	9.55	9.3	Exist	-	-
C-U7	10.9	9.4	9.7	-	-	-	-	-	-	-	-	FG	10.05	New	-	-	-	-	-	-	FG	9.9	NEW	-	-	-	-	-
C-G1	10.9	9.9	10.15	-	-	-	-	-	-	-	-	FG	9.7	Exist	-	-	-	-	-	-	FG	9.74	Exist	9.55	9.2	Exist	-	-
C-G2	10.9	9.9	10.15	-	-	-	-	-	-	-	-	10.84	10.4	New	-	-	-	-	-	-	10.84	10.4	New	-	-	-	-	-
C-G3	10.9	9.9	10.15	-	-	-	-	-	-	-	-	10.84	10.4	New	-	-	-	-	-	-	10.84	10.4	New	10.5	10.25	Exist	-	-
C-G4	10.9	9.9	10.15	-	-	-	-	-	-	-	-	10.84	10.4	New	-	-	-	-	-	-	10.84	10.4	New	10.5	10.25	Exist	-	-
C-G5	10.9	9.9	10.15	-	-	-	-	-	-	-	-	10.84	10.4	New	-	-	-	-	-	-	10.84	10.4	New	-	-	-	-	-
C-G6	10.9	9.9	10.15	-	-	-	-	-	-	-	-	10.84	10.4	New	-	-	-	-	-	-	10.84	10.4	New	10.5	10.25	Exist	-	-
C-G7	10.9	9.9	10.15	-	-	9.6	8.525	New	9.6	8.525	New	-	-	-	-	-	-	-	-	-	-	-	-	10.5	10.25	Exist	-	-
C-G8	10.9	9.9	10.15	9.3	9.35	-	-	-	-	-	-	-	-	-	-	-	-	-	-	-	11.05	10.46	Exist	10.02	9.7	Exist	-	-
C-G9	10.9	9.9	10.15	-	-	-	-	-	-	-	-	10.84	10.4	New	-	-	-	-	-	-	10.84	10.4	New	-	-	-	-	-
C-G10	10.9	9.9	10.15	-	-	-	-	-	-	-	-	10.84	10.4	New	-	-	-	-	-	-	10.84	10.4	New	-	-	-	-	-
C-G11	10.9	9.9	10.15	-	-	-	-	-	-	-	-	10.84	10.4	New	-	-	-	-	-	-	10.84	10.4	New	-	-	-	-	-
C-G12	10.9	9.9	10.15	-	-	-	-	-	-	-	-	11.05	9.93	Exist	-	-	-	-	-	-	11.05	9.96	Exist	-	-	-	-	-
C-G13	10.9	-	-	9.9	9.95	-	-	-	-	-	-	FG	9.7	Exist	-	-	-	-	-	-	FG	9.74	Exist	9.55	9.2	Exist	-	-
C-G14	10.9	-	-	9.9	9.95	-	-	-	-	-	-	10.84	10.4	New	-	-	-	-	-	-	-	-	-	-	-	-	-	-
C-G15	10.9	-	-	9.9	9.95	-	-	-	-	-	-	10.84	10.4	New	-	-	-	-	-	-	-	-	-	10.5	10.25	Exist	-	-
C-G16	10.9	-	-	9.9	9.95	-	-	-	-	-	-	10.84	10.4	New	-	-	-	-	-	-	-	-	-	10.5	10.25	Exist	-	-
C-G17	10.9	-	-	9.9	9.95	-	-	-	-	-	-	10.84	10.4	New	-	-	-	-	-	-	-	-	-	-	-	-	-	-
C-G18	10.9	-	-	9.9	9.95	-	-	-	-	-	-	10.84	10.4	New	-	-	-	-	-	-	-	-	-	10.5	10.25	Exist	-	-
C-G19	10.9	-	-	9.9	9.95	9.6	8.525	New	9.6	8.525	New	-	-	-	-	-	-	-	-	-	-	-	-	9.4	8.325	Exist	-	-
C-G20	10.9	9.88	10.13	-	-	-	-	-	-	-	-	10.84	10.4	New	-	-	-	-	-	-	10.84	10.4	New	-	-	-	-	-
C-G21	11.2	-	-	-	-	-	-	-	-	-	-	-	-	-	-	-	-	-	-	-	-	-	-	-	-	-	-	9.6
C-G22	11.2	-	-	-	-	-	-	-	-	-	-	-	-	-	-	-	-	-	-	-	-	-	-	-	-	-	-	9.6
C-G23	11.2	-	-	-	-	-	-	-	-	-	-	-	-	-	-	-	-	-	-	-	-	-	-	-	-	-	-	9.6
C-G24	10.97	-	-	-	-	9.7	9.2	NEW	FG	10	NEW	-	-	-	-	-	-	-	-	-	-	-	-	-	-	-	-	-
C-G25	10.95	-	-	-	-	9.65	9.15	NEW	FG	9.95	NEW	-	-	-	-	-	-	-	-	-	-	-	-	-	-	-	-	-
C-G26	10.95	-	-	-	-	9.65	9.15	NEW	FG	9.95	NEW	-	-	-	-	-	-	-	-	-	-	-	-	-	-	-	-	-
C-G27	10.95	-	-	-	-	9.65	9.15	NEW	FG	9.95	NEW	-	-	-	-	-	-	-	-	-	-	-	-	-	-	-	-	-
C-G28	10.95	-	-	-	-	9.65	9.15	NEW	FG	9.95	NEW	-	-	-	-	-	-	-	-	-	-	-	-	-	-	-	-	-
C-G29	10.95	-	-	-	-	9.65	9.15	NEW	FG	9.95	NEW	-	-	-	-	-	-	-	-	-	-	-	-	-	-	-	-	-
C-G30	10.95	-	-	-	-	9.65	9.15	NEW	FG	9.95	NEW	-	-	-	-	-	-	-	-	-	-	-	-	-	-	-	-	-
C-G31	11.13	-	-	-	-	10.35	9.73	NEW	-	-	-	11.13	10.45	NEW	-	-	-	-	-	-	-	-	-	-	-	-	-	9.6
C-G32	11.13	-	-	-	-	10.35	9.73	NEW	-	-	-	11.13	10.5	NEW	-	-	-	-	-	-	-	-	-	-	-	-	-	9.6
C-G33	11.13	-	-	-	-	10.35	9.73	NEW	-	-	-	11.13	10.55	NEW	-	-	-	-	-	-	-	-	-	-	-	-	-	9.6
C-G34	11	-	-	-	-	9.7	9.2	NEW	FG	10	NEW	-	-	-	-	-	-	-	-	-	-	-	-	-	-	-	-	-
C-G35	10.9	-	-	9.9	9.95	-	-	-	-	-	-	-	-	-	10.2	10	EXIST	9.28	9.18	EXIST	-	-	-	10.03	9.63	EXIST	-	-
C-G36	10.9	-	-	-	-	-	-	-	9.1	-	NEW	-	-	-	10.2	10	EXIST	9.28	9.18	EXIST	-	-	-	10.03	9.63	EXIST	-	-
C-G37	10.9	-	-	-	-	9.1	-	NEW	-	-	-	-	-	-	10.2	10	EXIST	9.28	9.18	EXIST	-	-	-	10.03	9.63	EXIST	-	-
C-G38	10.87	-	-	9.9	9.95	-	-	-	-	-	-	-	-	-	9.42	9.02	EXIST	-	-	-	-	-	-	10.03	9.63	EXIST	-	-
C-G39	10.87	-	-	-	-	-	-	-	8.9	-	NEW	-	-	-	9.42	9.02	EXIST	-	-	-	-	-	-	10.03	9.63	EXIST	-	-
C-G40	10.87	-	-	-	-	8.9	-	NEW	-	-	-	-	-	-	9.42	9.02	EXIST	-	-	-	-	-	-	10.03	9.63	EXIST	-	-
C-G41	10.9	-	-	9.9	9.95	-	-	-	-	-	-	-	-	-	-	-	-	-	-	-	-	-	-	10.8	10.55	EXIST	-	-
C-G42	10.9	-	-	-	-	-	-	-	10.25	FG	NEW	-	-	-	-	-	-	-	-	-	-	-	-	10.8	10.55	EXIST	-	-
C-G43	10.9	-	-	-	-	10.25	FG	NEW	-	-	-	-	-	-	-	-	-	-	-	-	-	-	-	10.8	10.55	EXIST	-	-
C-G44	10.9	-	-	9.35	9.4	-	-	-	-	-	-	FG	10.2	EXIST	-	-	-	-	-	-	-	-	-	10.05	9.65	EXIST	-	-
C-G45	10.9	-	-	-	-	9.55	FG	NEW	-	-	-	FG	10.2	EXIST	-	-	-	-	-	-	-	-	-	10.05	9.65	EXIST	-	-
C-G46	10.9	-	-	-	-	-	-	-	9.55	FG	NEW	FG	10.2	EXIST	-	-	-	-	-	-	-	-	-	10.05	9.65	EXIST	-	-
C-G47	10.9	-	-	9.9	9.95	9.3	8.8	NEW	-	-	-	-	-	-	-	-	-	-	-	-	-	-	-	-	-	-	-	-
C-U4	10.9	9.15	9.35	-	-	-	-	-	-	-	-	FG	9.65	EXIST	-	-	-	-	-	-	-	-	-	-	-	-	-	-

NOTES

1. ALL COORDINATES AND ELEVATIONS ARE IN METERS.
2. ALL COORDINATES ARE IN LOCAL SYSTEM., WITH REFERENCE TO SITE LOCAL DATUM POINT.

	LOCAL	UTM
	E=500.000	E=437384.709
A	N=500.000	N=3289737.469
	E=485.337	E=437245.830
B1	N=788.941	N=3289991.269
	Z=12.170	ELEV.=12.17
	E=798.452	E=437704.660
B2	N=382.283	N=3289761.280
	Z=13.410	ELEV.=13.41

3. ALL ELEVATION REFERENCES IS MEAN SEA LEVEL.
4. ALL DIMENSIONS ARE IN MILLIMETERS UNLESS STATED OTHERWISE.

REFERENCE DRAWING	DRG. No.
SPECIFICATION FOR ROAD & PAVING	BK-GNRL-PEDCO-000-CV-SP-0002
STANDARD DRAWING FOR ROADS	BK-GNRL-PEDCO-000-CV-DW-0003
STANDARD DRAWING FOR PAVINGS	BK-GNRL-PEDCO-000-CV-DW-0035
UNIT PLOT PLAN DRAWING	BK-GCS-PEDCO-120-PI-PY-0001
ROUGH GRADING PLAN & DETAILS	BK-GCS-PEDCO-120-CV-PY-0007
BINKA NEW COMPRESSOR GAS STATION PLOT PLAN (BASIC PACKAGE)	1560-BK-NCS-PI-DWG-0001
FOUR WALL DRAWING FOR LEAN GLYCOL STORAGE TANK (TK-2102)	BK-GCS-PEDCO-120-ST-DW-0033
POUNDING DRAWING FOR GLYCOL SUMP PIT (SU-2101)	BK-GCS-PEDCO-120-ST-DW-0035
AREA ELECTRICAL CABLE ROUTE & SECTION LAYOUT	BK-GCS-PEDCO-120-EL-PY-0005
INSTRUMENT/F&G CABLE TRENCH/ROUTE LAYOUT DRAWING	BK-GCS-PEDCO-120-IN-PY-0004
UG PIPING PLAN	BK-GCS-PEDCO-120-PI-DW-0005
ROAD, PAVING AND PLANT FINISH GRADING LAYOUT & SECTIONS	BK-GCS-PEDCO-120-CV-PY-0005

KEY PLAN					
***	*****	** **	*** ****	** **	*** ****
REV.	DESCRIPTION	BY	DATE	BY	DATE
		CHECKED		REV. APPR.	
اصل و کلیه نسخ این نقشه و حق اقتباس متعلق به شرکت ملی مناطق نفت خیز جنوب میباشد.					
 THE ORIGINAL AND ALL COPIES OF THIS DRAWING TOGETHER WITH THE COPYRIGHT THEREIN ARE THE SOLE PROPERTY OF N.I.S.O.C./ FIELDS					
BINAK OILFIELD DEVELOPMENT GENERAL					
DATE	SCALE	DRAWING BY	CHECKED BY	PROJECT ENG.	
NO CONSTRUCTION PERMITTED UNLESS DRAWING APPROVED					
APPROVED FOR CONSTRUCTION		BY:		DATE:	
BUDGET REF.	LOCATION	SIZE CLASS	SERIAL NO.	SHEET	REVISION
053-073-9184	F	4 S	709113	6	DOI