


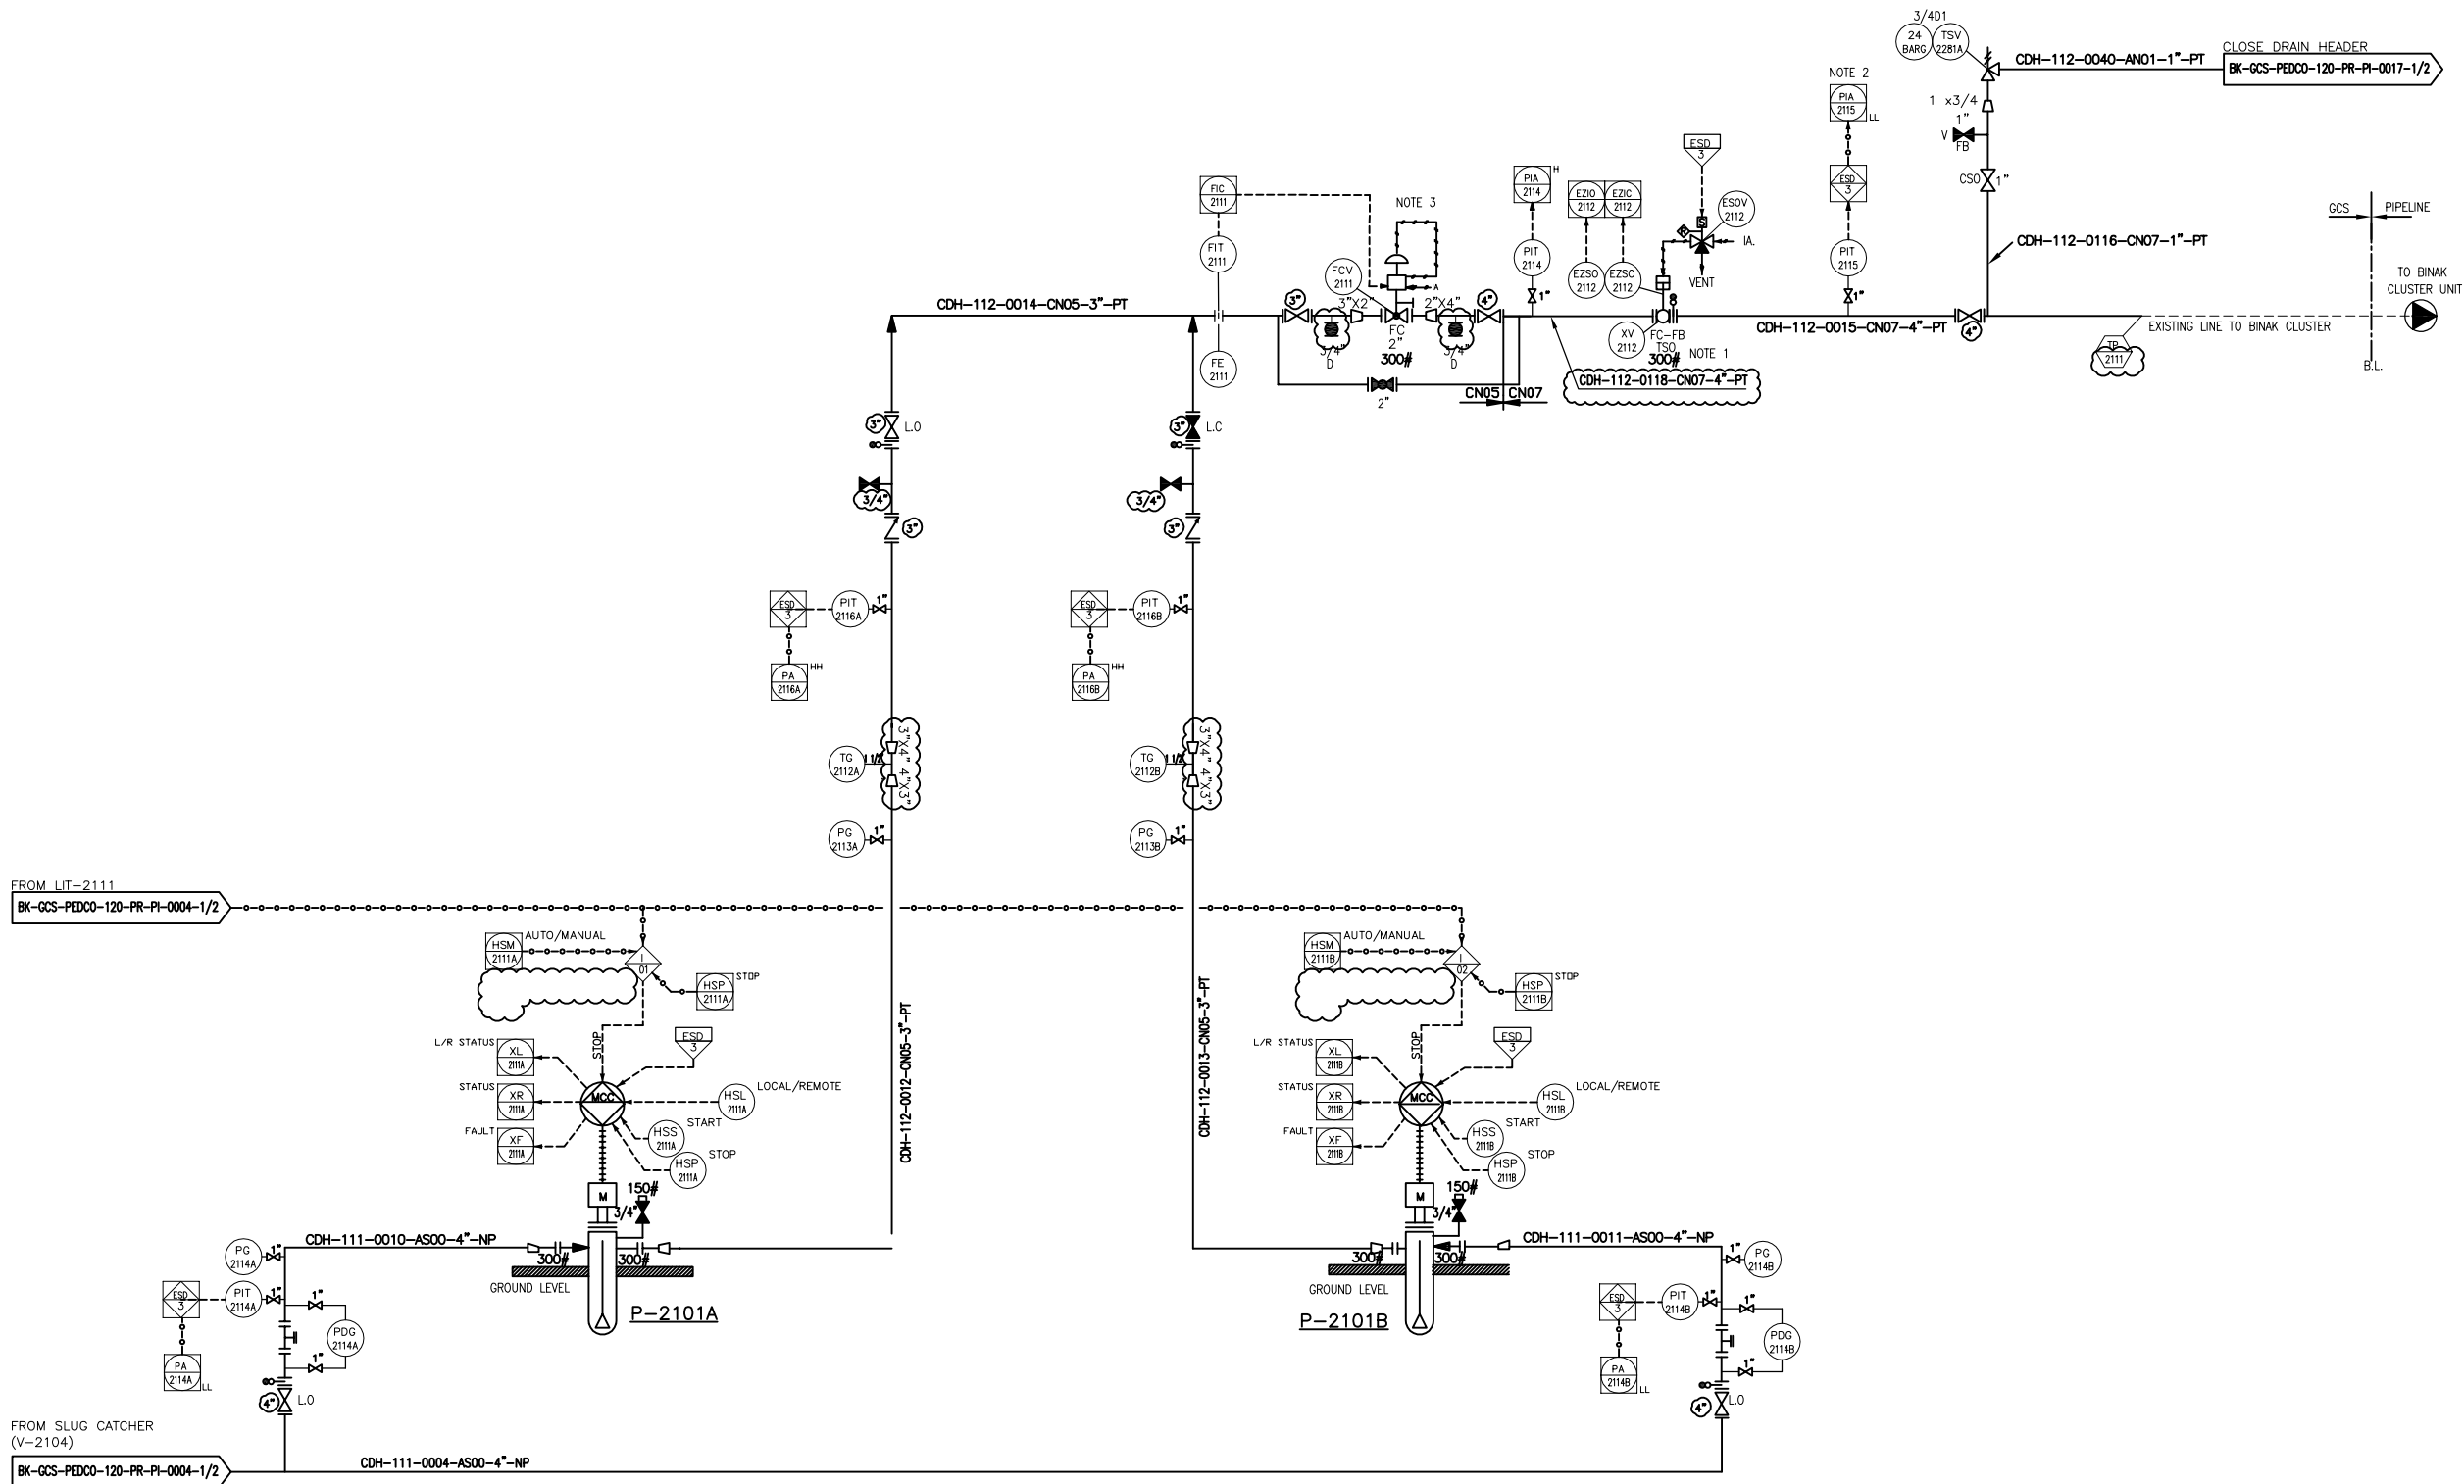

- NOTES**
- 1- THE ESD VALVE SHOULD WORK AS FIRE ZONE ISOLATION DURING EMERGENCY CONDITION.
 - 2- LOW LOW ALARM OF PIA-2115 SHALL BE INHIBITE FOR A FEW SECOND (VIA ESD LOGIC) FOR START UP.
 - 3- CONTROL VALVE SIZING WILL BE FINALIZED BY VENDOR.
 - 4- ALL DRAIN LINE SHALL BE CONNECTED TO CLOSED DRAIN HEADER.

LEGEND	
REFERENCE DRAWING	DRG. No.
Process Flow Diagram	BK-GCS-PEDCO-120-PR-PF-0001
Symbol & Legend For PFD and P&ID	BK-GCS-PEDCO-120-PR-PI-0001

KEY PLAN	

D08	MAR.2024	IPA	MARYAPAR	M.PAKHMAN	S.PAKHMANPOUR	00.00
D07	SEP.2023	IPA	MARYAPAR	M.PAKHMAN	A.M.MOHESEN	00.00
D06	APR.2023	IPA	MARYAPAR	M.PAKHMAN	M.MEHRSHAD	00.00
D05	DEC.2022	IPA	MARYAPAR	M.PAKHMAN	M.MEHRSHAD	00.00
D04	AUG.2022	IPA	MARYAPAR	M.PAKHMAN	M.MEHRSHAD	00.00
D03	JUN.2022	IPA	MARYAPAR	M.PAKHMAN	M.MEHRSHAD	00.00
D02	MAR.2022	IPA	MARYAPAR	M.PAKHMAN	M.MEHRSHAD	00.00
D01	JAN.2022	IPA	MARYAPAR	M.PAKHMAN	M.MEHRSHAD	00.00
D00	SEP.2021	IPC	MARYAPAR	M.PAKHMAN	M.MEHRSHAD	00.00
REV.	DATE	P.O.I.S	PREP.	CHK.	APP.	AUT.

PROJECT NAME:		BINAK OILFIELD DEVELOPMENT/SURFACE FACILITIES GAS COMPRESSOR STATION	
PROJECT NO.:		971020	
EPC CONTRACTOR:		EPD/EPC CONTRACTOR (GC):	
 HIRGAN ENERGY - DESIGN & INSPECTION COMPANIES		  PETROIRAN DEVELOPMENT COMPANY	



THE ORIGINAL AND ALL COPIES OF THIS DRAWING TOGETHER WITH
THE COPYRIGHT THEREIN ARE THE SOLE PROPERTY OF
N.I.S.O.C. / FIELDS

**BINAK OILFIELD DEVELOPMENT
SURFACE FACILITIES
GAS COMPRESSOR STATION**

DATE	SCALE	DRAWING BY	CHECKED BY	PROJECT ENG.

NO CONSTRUCTION PERMITTED UNLESS DRAWING APPROVED

APPROVED FOR CONSTRUCTION			BY:	DATE:	
BUDGET REF.	LOCATION	SIZE CLASS	SERIAL NO.	SHEET	REVISION
053-073-9184	F	2 A	708782	2 OF 2	D08

P-2101 A/B
SLUG PUMPS

RATED CAPACITY : 11 m³/hr
DEFF. PRESS. : 14 bar
TRIM LINE : TRM-P-2101-0508-CN05-PT
TRIM LINE : TRM-P-2101-0505-AS00-NP

(VENDOR TITLE BLOCK)**