


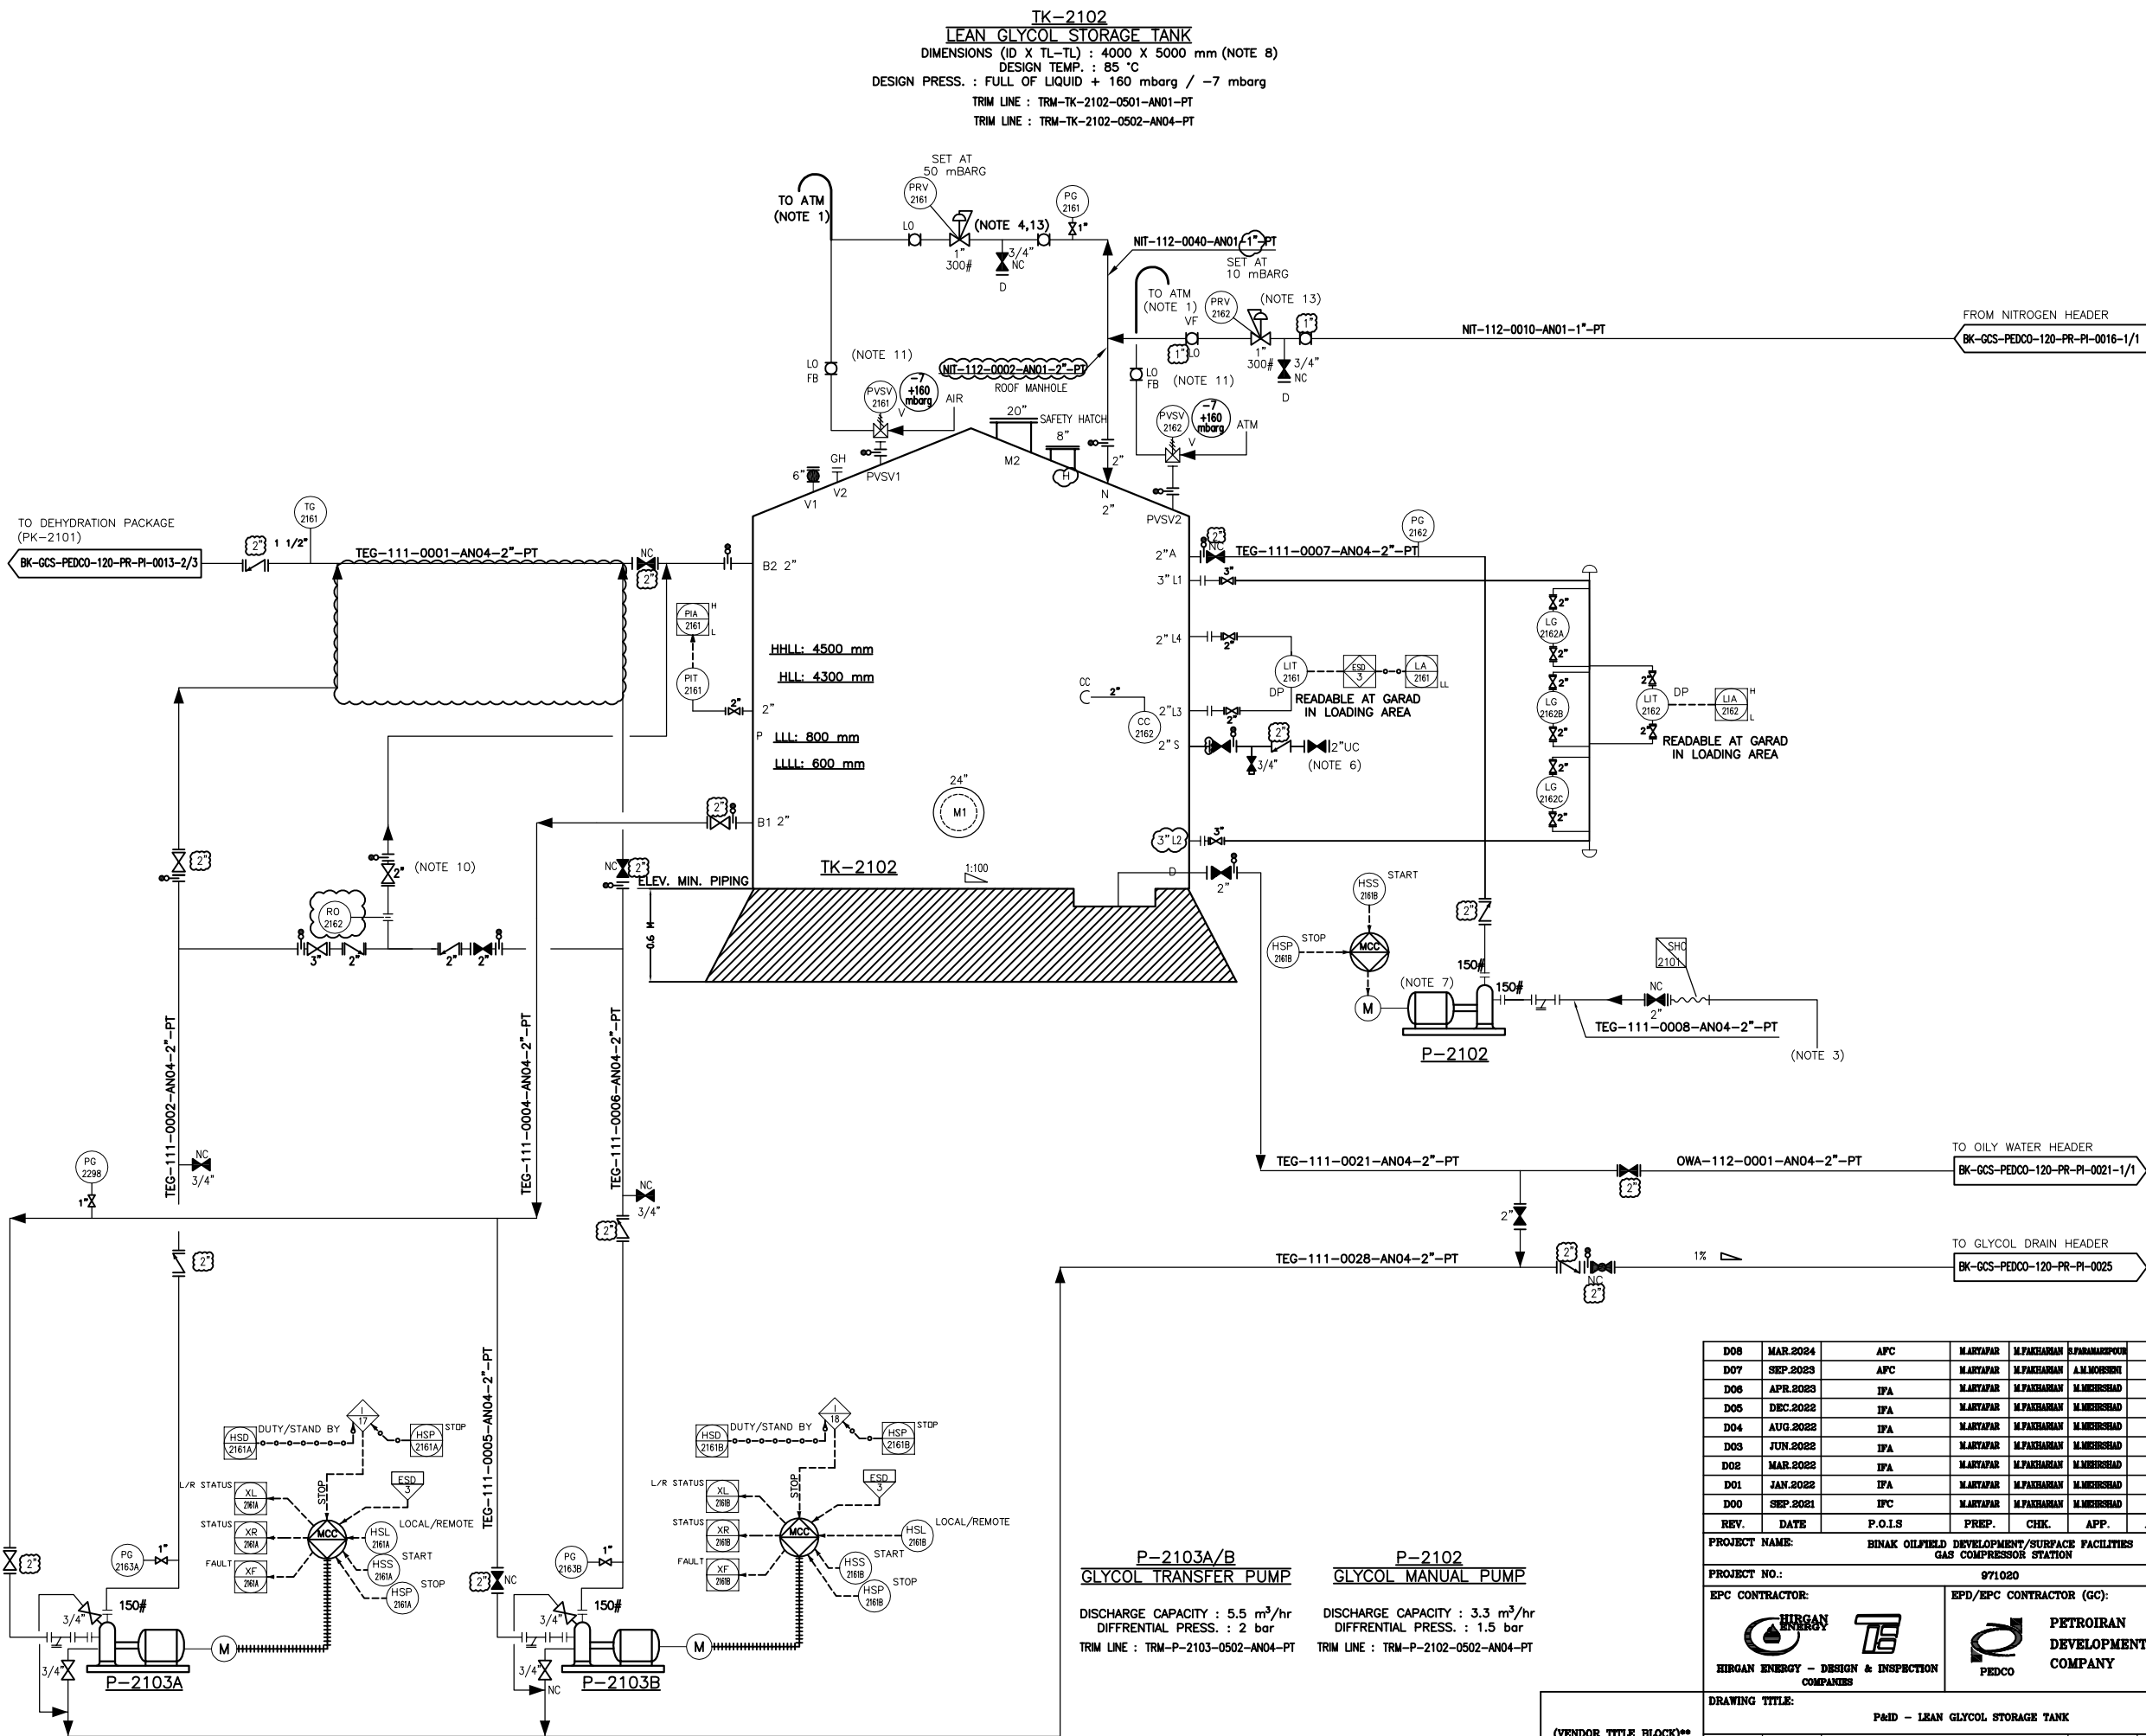

- NOTES
- 1- VENT TO ATMOSPHERE AT SAFE LOCATION FOR PERSONNEL PROTECTION.
 - 2- MIN. FLOW RECYCLE.
 - 3- BARREL DIP PIPE FOR LOADING OF FRESH GLYCOL.
 - 4- GAS-BLANKETING SYSTEM WAS SIZED FOR WORST CASE OF PUMPING IN/OUT OF TANK.
 - 5- DRAIN DURING TANK MAINTENANCE.
 - 6- PURGE CONNECTION.
 - 7- TEG MANUAL PUMP FOR GLYCOL LOADING.
 - 8- TANK DIMENSION WILL BE FINALIZED AFTER RECEIVING DEHYDRATION PACKAGE VENDOR DATA.
 - 9- DELETED.
 - 10- MINIMUM FLOW RECYCLE.
 - 11- PVS1 SHALL BE CALCULATED AND PROVIDED BY TANK VENDOR.
 - 12- PARTIAL STROKE DEVICE TO BE CONSIDERED FOR ALL ESDV'S ACTIVATED BY ESD 1,0.
 - 13- CONTROL VALVE SIZING WILL BE FINALIZED BY VENDOR.
 - 14- ALL DRAIN LINE SHALL BE CONNECTED TO CLOSED DRAIN HEADER.

LEGEND

V: BY TANK VENDOR

REFERENCE DRAWING	DRG. No.
Process Flow Diagram	BK-GCS-PEDCO-120-PR-PF-0001
Symbol & Legend For PFD and P&ID	BK-GCS-PEDCO-120-PR-PI-0001

KEY PLAN

REV.	DATE	P.O.I.S	PREP.	CHK.	APP.	AUT.
D08	MAR.2024	APC	MARYAPAR	M.PAKHSHAN	S.PANAHPOUR	00.00
D07	SEP.2023	APC	MARYAPAR	M.PAKHSHAN	A.M.MOHESEN	00.00
D06	APR.2023	IFA	MARYAPAR	M.PAKHSHAN	M.MOHESEN	00.00
D05	DEC.2022	IFA	MARYAPAR	M.PAKHSHAN	M.MOHESEN	00.00
D04	AUG.2022	IFA	MARYAPAR	M.PAKHSHAN	M.MOHESEN	00.00
D03	JUN.2022	IFA	MARYAPAR	M.PAKHSHAN	M.MOHESEN	00.00
D02	MAR.2022	IFA	MARYAPAR	M.PAKHSHAN	M.MOHESEN	00.00
D01	JAN.2022	IFA	MARYAPAR	M.PAKHSHAN	M.MOHESEN	00.00
D00	SEP.2021	IPC	MARYAPAR	M.PAKHSHAN	M.MOHESEN	00.00

PROJECT NAME: BINAK OILFIELD DEVELOPMENT/SURFACE FACILITIES GAS COMPRESSOR STATION

PROJECT NO.: 971020

EPC CONTRACTOR: HIRGAN ENERGY & DESIGN & INSPECTION COMPANIES

EPD/EPC CONTRACTOR (GC): PETROIRAN DEVELOPMENT COMPANY

DATE: SCALE: DRAWING BY: CHECKED BY: PROJECT ENG.

NO CONSTRUCTION PERMITTED UNLESS DRAWING APPROVED

APPROVED FOR CONSTRUCTION BY: DATE:

BUDGET REF.	LOCATION	SIZE	CLASS	SERIAL NO.	SHEET	REVISION
053-073-0184	F	2	A	706792	1 OF 1	D08