

NOTES

- 1- REMOTE LEVEL INDICATION LOCATE AT GRADE OF UNLOADING AREA IS REQUESTED (BY LIT VENDOR).
- 2- DIESEL PUMP TO BE INSTALLED UNDER SHELTER OR EQUIVALENT TO PROTECT AGAINST SOLAR RADATION.
- 3- DELETED.
- 4- DELETED.
- 5- DELETED.
- 6- PARTIAL STROKE DEVICE TO BE CONSIDERED FOR ALL ESD'S ACTIVATED BY ESD 1.0.

GENERAL NOTE

LEGEND

REFERENCE DRAWING		DRG. No.
Utility Piping Diagram		BK-GCS-PEDOC-120-PR-P-0001
Symbol & Legend For PFD & P&ID		BK-GCS-PEDOC-150-PR-P-0001

KEY PLAN

DO6	MAR.2024	APC	U/REVISE	U/REVIEWED	U/REVISION	DO6	DO6
DO7	OCT.2023	IPA	U/REVISE	U/REVIEWED	U/REVISION	DO7	DO7
DO6	APR.2023	IPA	U/REVISE	U/REVIEWED	U/REVISION	DO6	DO6
DO5	DEC.2022	IPA	U/REVISE	U/REVIEWED	U/REVISION	DO5	DO5
DO4	AUG.2022	IPA	U/REVISE	U/REVIEWED	U/REVISION	DO4	DO4
DO3	JUN.2022	IPA	U/REVISE	U/REVIEWED	U/REVISION	DO3	DO3
DO2	MAR.2022	IPA	U/REVISE	U/REVIEWED	U/REVISION	DO2	DO2
DO1	JAN.2022	IPA	U/REVISE	U/REVIEWED	U/REVISION	DO1	DO1
DO0	OCT.2021	IPC	U/REVISE	U/REVIEWED	U/REVISION	DO0	DO0
REV.	DATE	FOUS	PREP.	CHK.	APP.	AUT.	

PROJECT NAME: BINAQ OILFIELD DEVELOPMENT/SURFACE FACILITIES
PROJECT NO.: 971020
EPC CONTRACTOR: BINAQ
SUBFACE FACILITIES
GAS COMPRESSOR STATION
N.I.S.O.C./ FIELDS

BINAQ OILFIELD DEVELOPMENT SURFACE FACILITIES GAS COMPRESSOR STATION			
DATE	SCALE	DRAWING BY	CHECKED BY


NO CONSTRUCTION PERMITTED UNLESS DRAWING APPROVED			
APPROVED FOR CONSTRUCTION	BY:	DATE:	
BUDGET REP. LOCATION SIZE CLASS	SERIAL NO.	SHEET	REVISION
DO6-075-0164	P	2	A

PK-2206
DIESEL GENERATOR PACKAGE

DESIGN DUTY: 500 KVA

V-2206
DIESEL OIL DRUM

DIMENSION (D X TL-TL): 2300 X 6000 mm
NOMINAL CAPACITY:28.11 m³
DESIGN TEMP.: 85 °C
DESIGN PRESS.: ATM + FULL OF WATER
TRIM LINE: TRM-V-2107-0501-AN01-PT

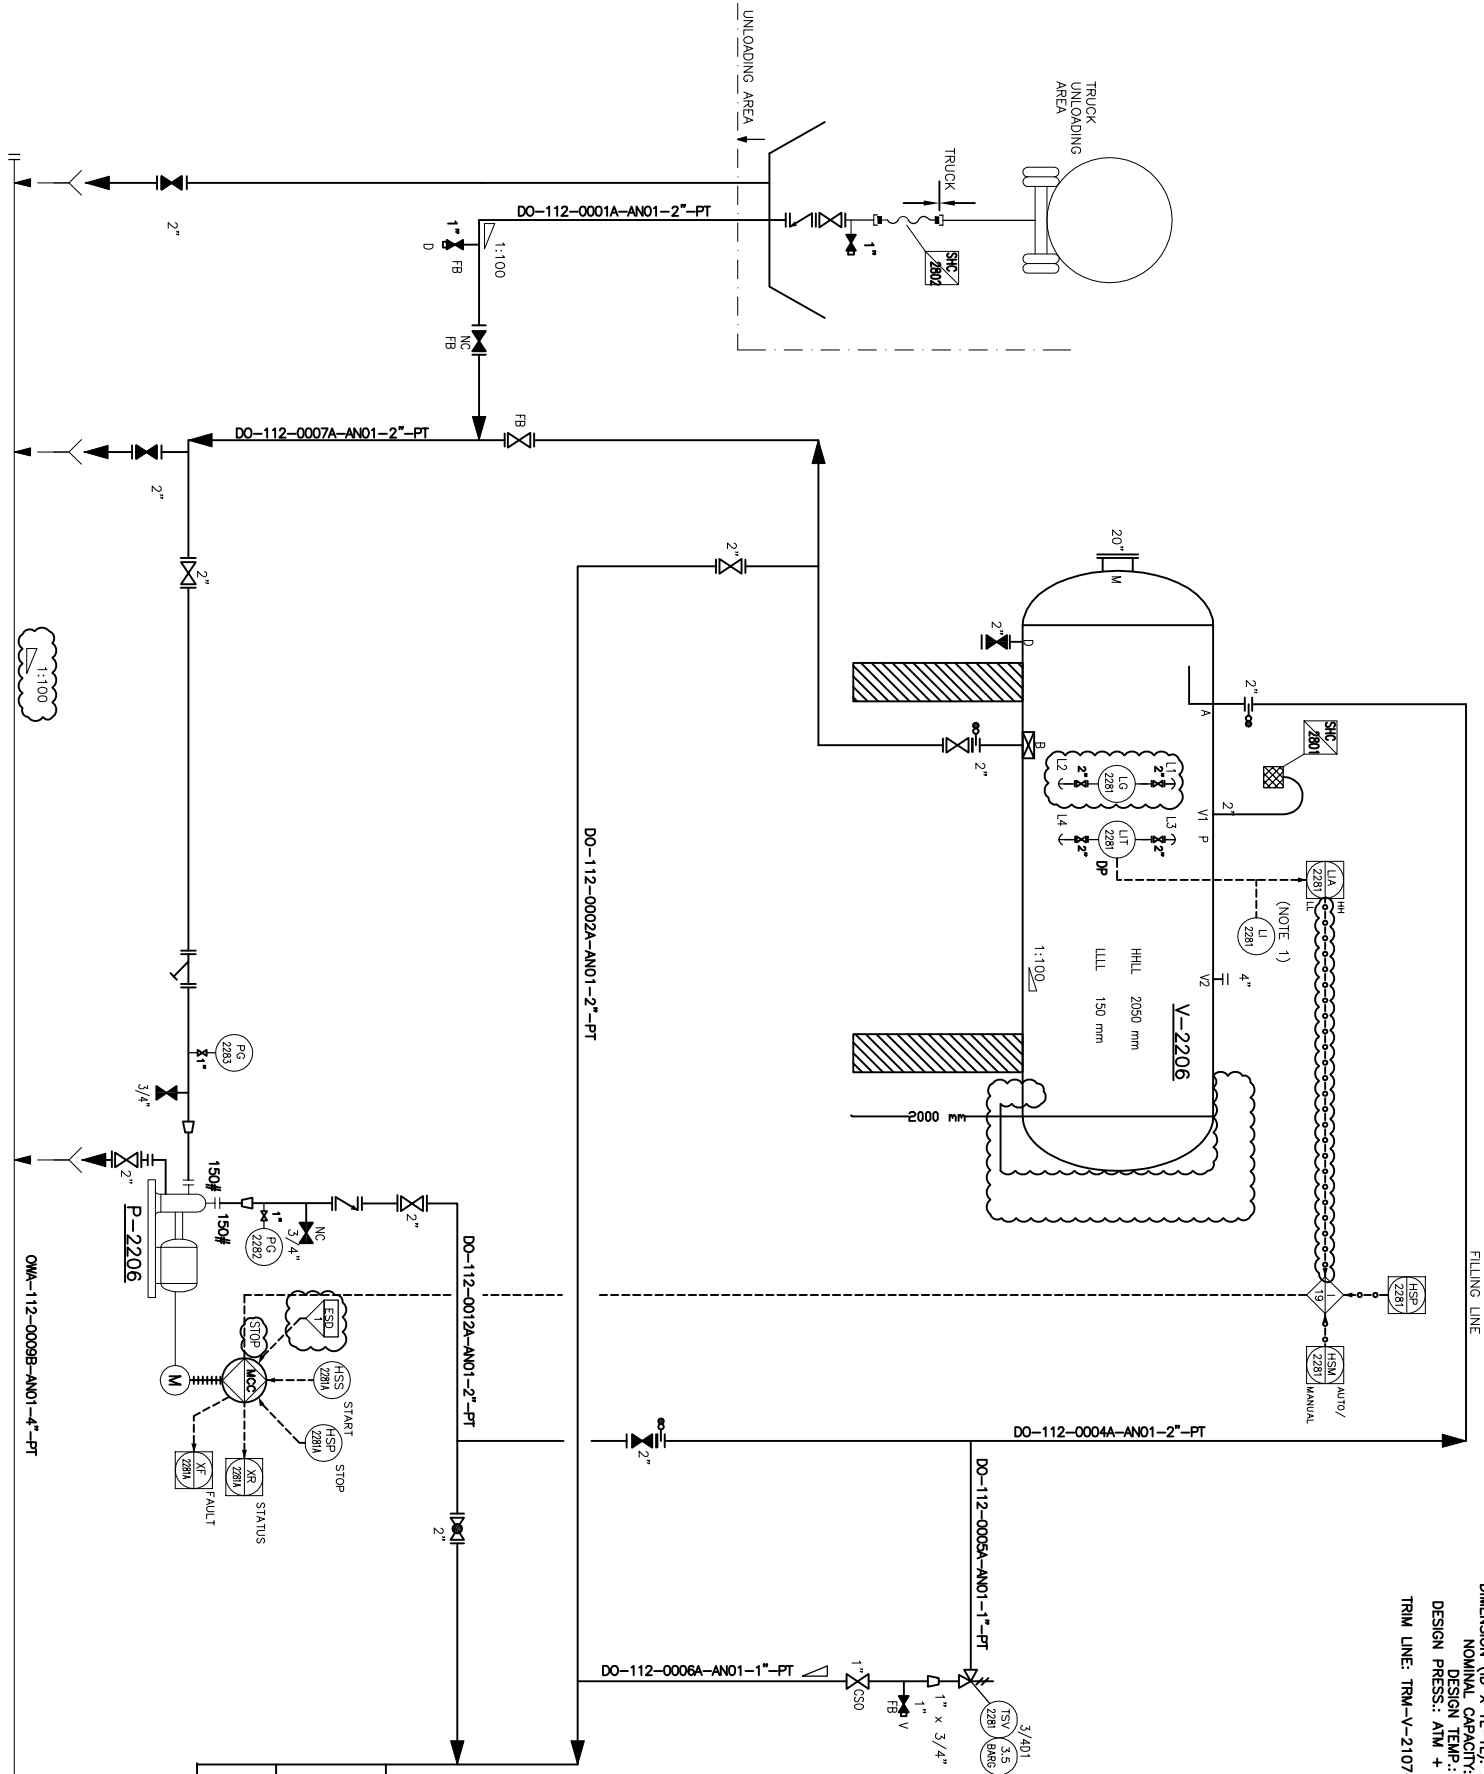

P-2206 (NOTE 2)
FIRE WATER DIESEL PUMP

RATED CAPACITY: 5.5 m³/hr
DIFFERENTIAL PRESS.: 2 bar
TRIM LINE: TRM-P-P-2206-0501-AN01-PT

(VENDOR TITLE BLOCK)**			
SCALE	SIZE	DRAWING NO.	SHEET NO.
NS	A3	BK-GCS-PEDOC-120-PR-P-0003	1 OF 1