
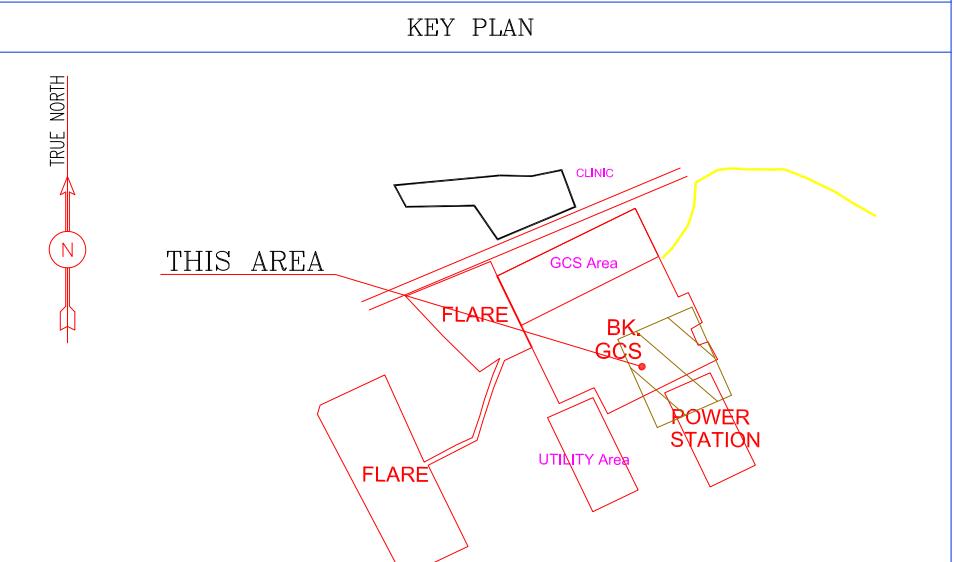
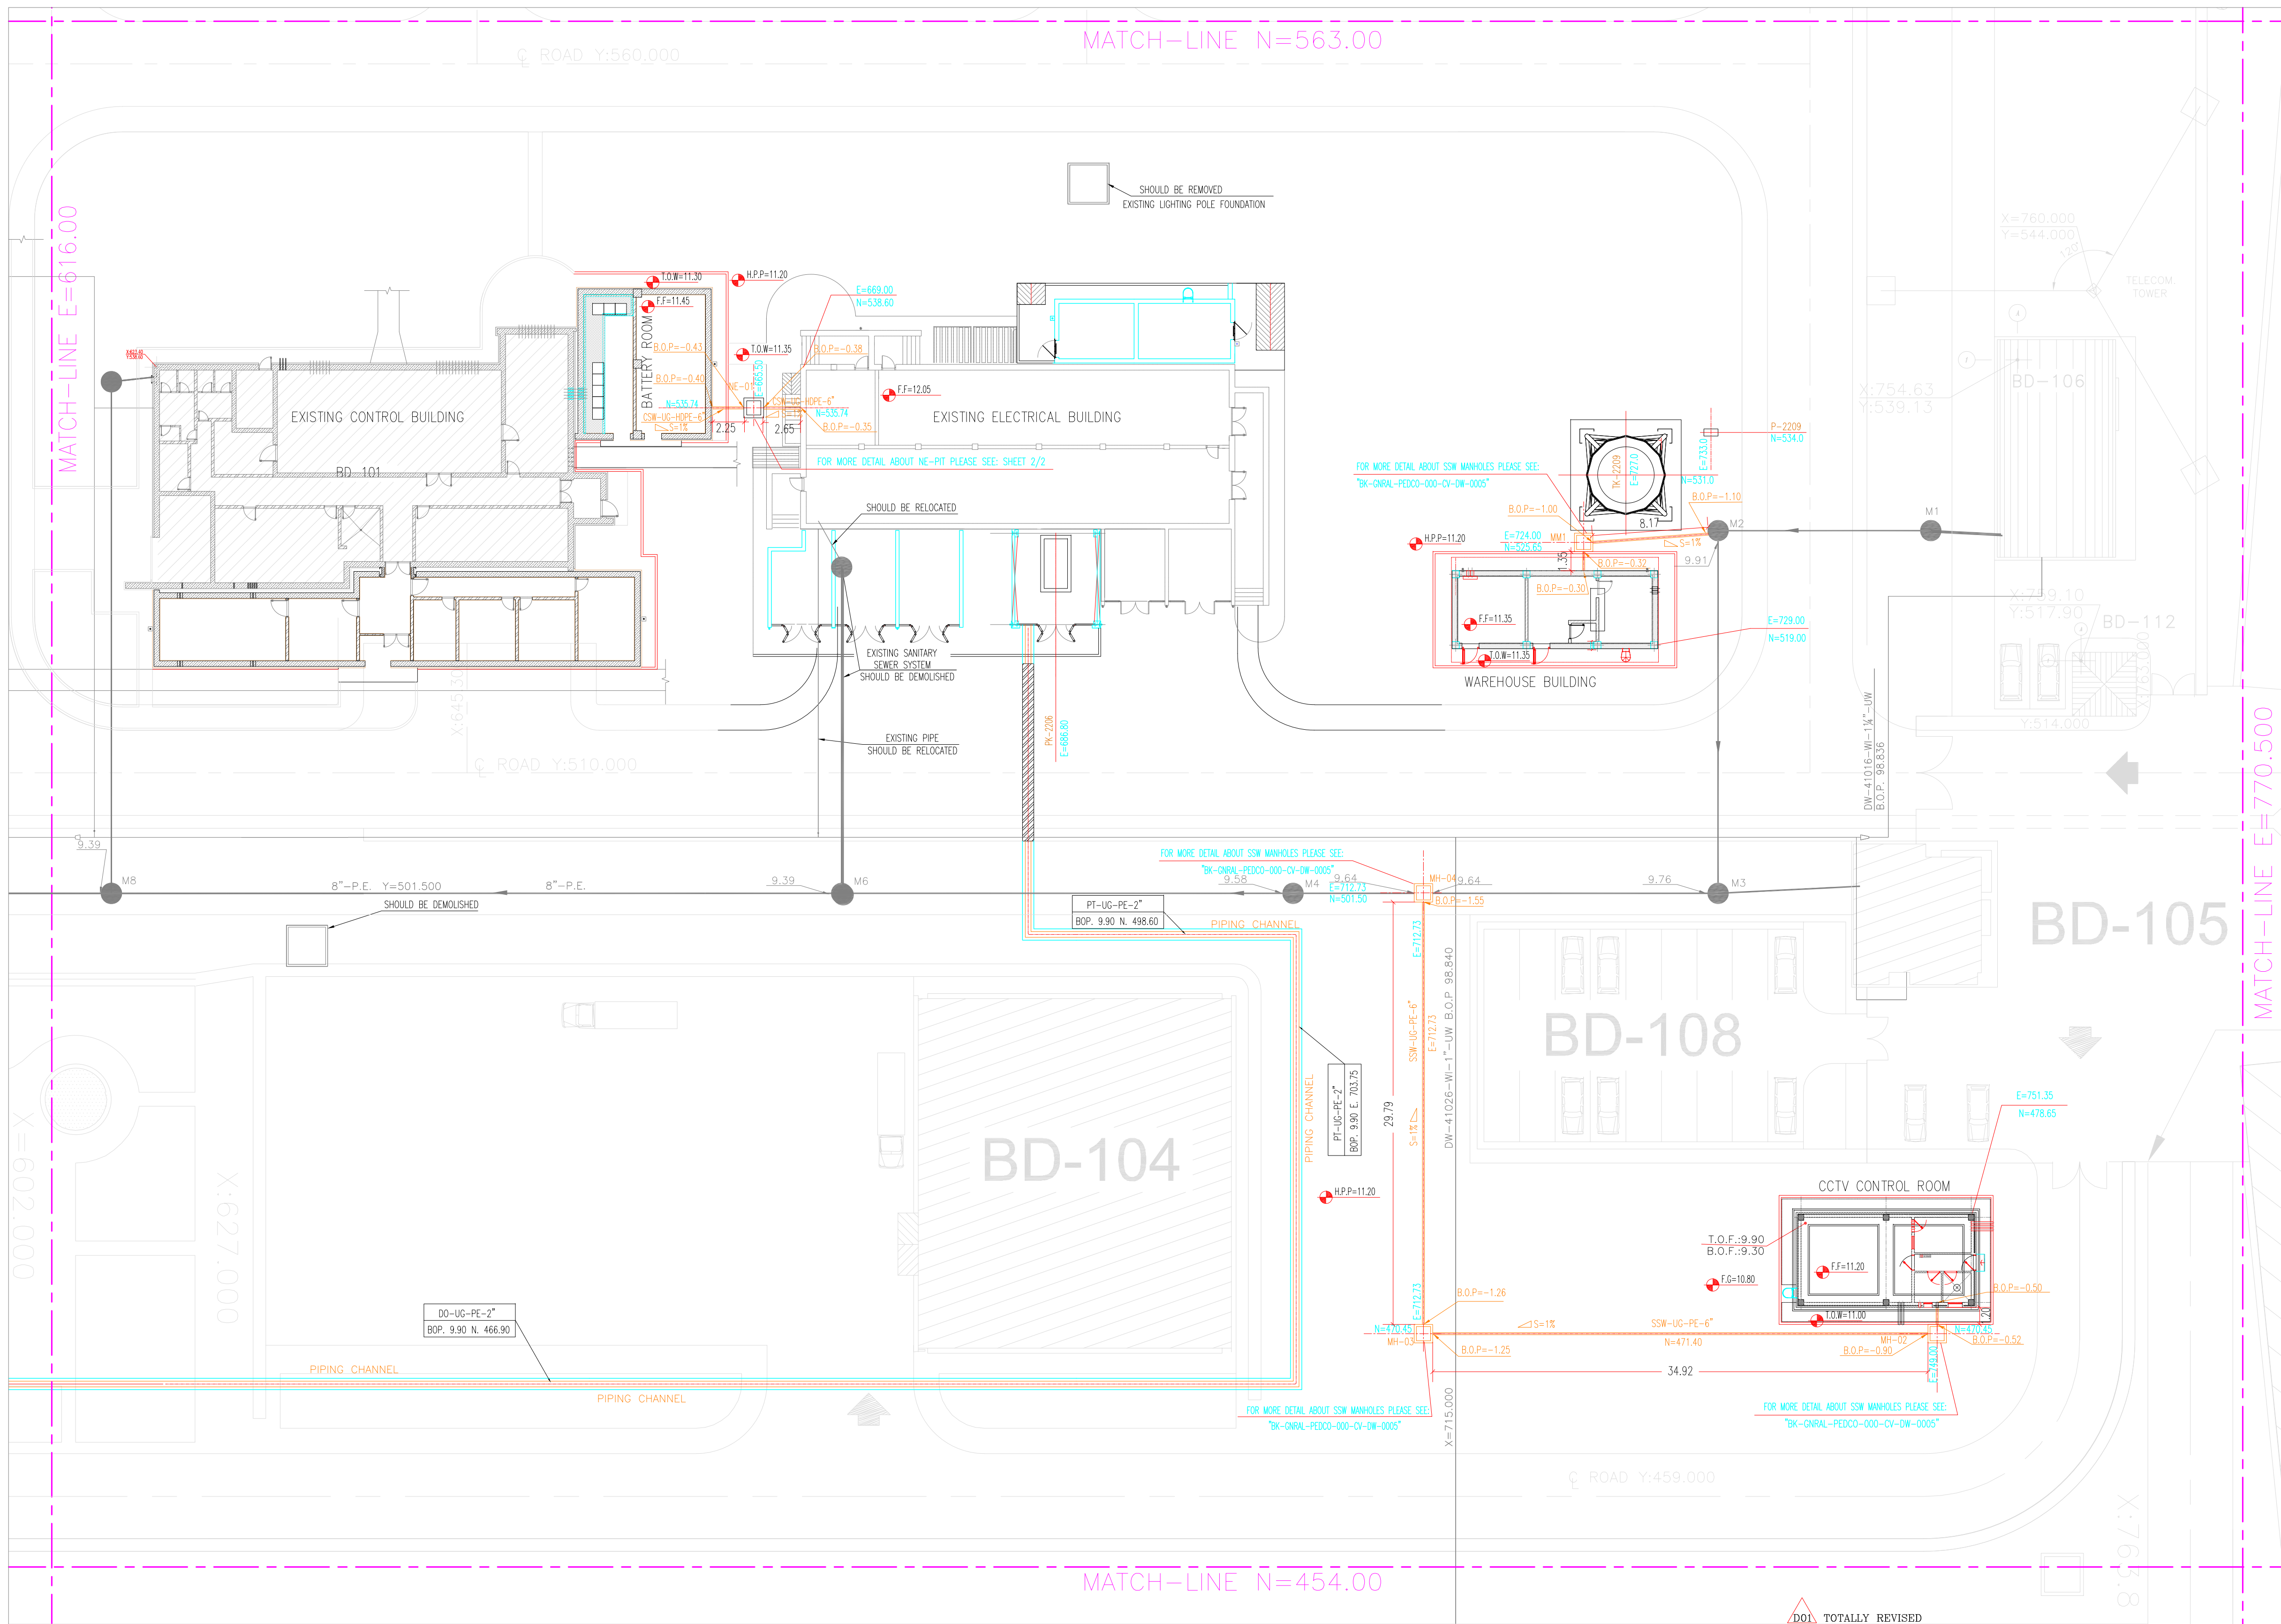
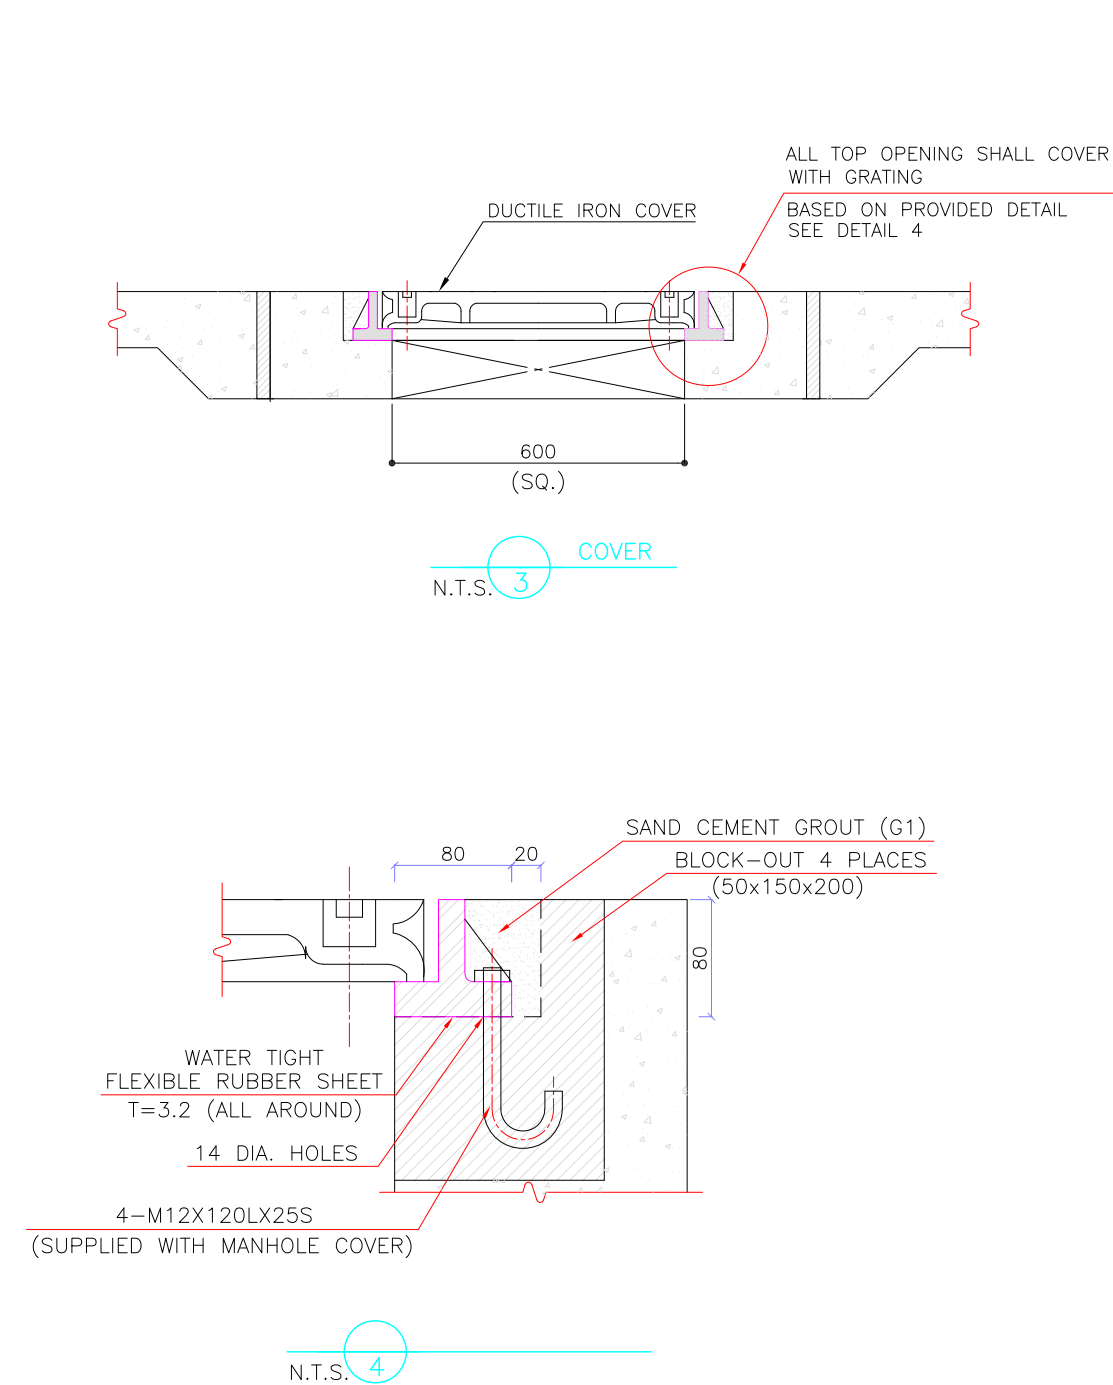
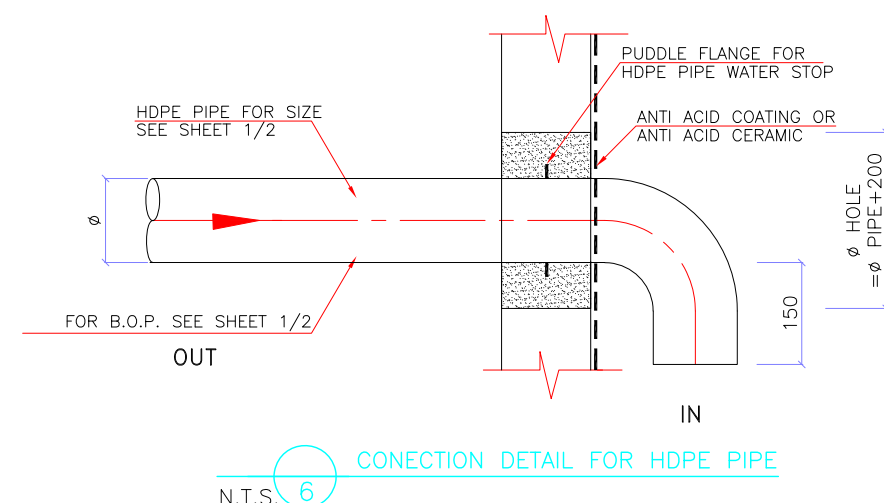
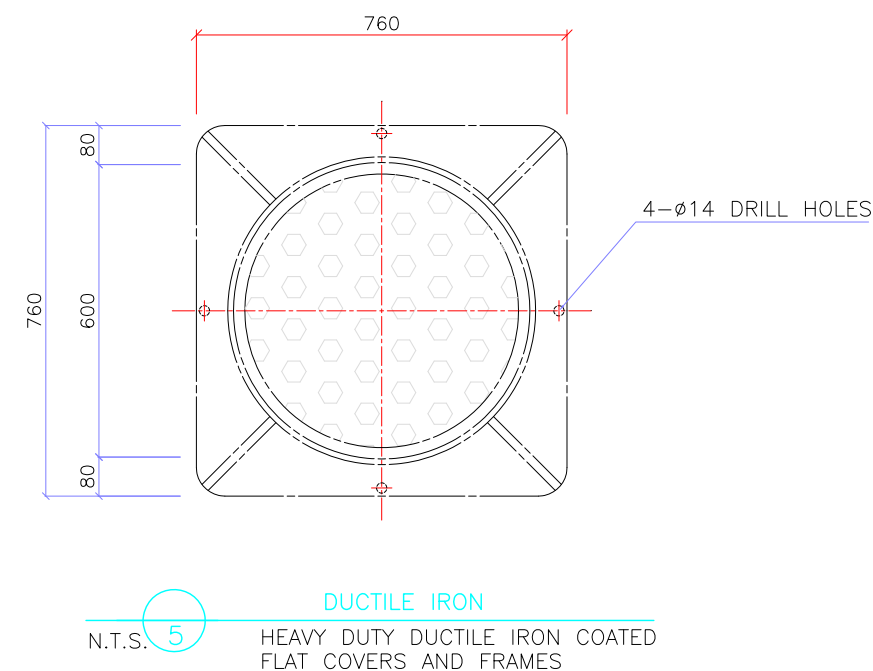
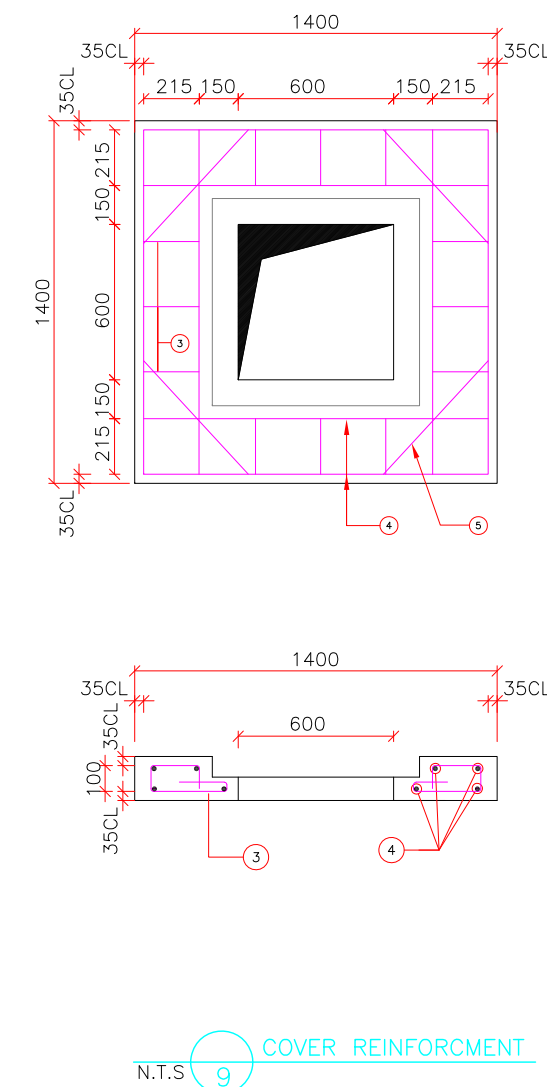
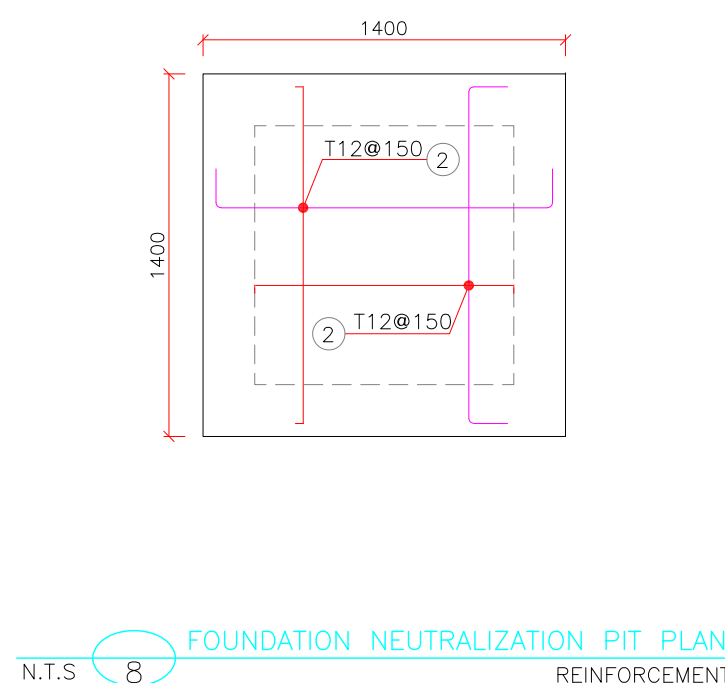


[illegible]

[illegible]

LEGEND			
B.O.P	BOTTOM OF PIPE	T.O.F	TOP OF FOUNDATION
T.O.W	TOP OF WALKWAY	B.O.F	BOTTOM OF FOUNDATION
F.F	FINISHED FLOOR	H.P.P	HIGH POINT OF PAVING
MH	MANHOLE	H.D.P.E	HIGH DENSITY POLYETHYLENE SHEET
DW	DRINKING WATER		
NE	NEUTRALIZATION PIT		
G.R.A	GRAVITY PIPE		
S.S	SANITARY SEWER WATER		
S.U	SUMP		
U.G	UNDER GROUND		
UPVC	U-PVC PIPE		
S.W	SANITARY PIPE		
P.E	POLYETHYLENE		
CSA	CHEMICAL SEWER WATER		

REFERENCE DRAWING	DRG. No.
UNIT PLOT PLAN DRAWING	BK-GCS-PEDCO-120-PI-PY-0001
PLANT UNDERGROUND COMPOSITE LAYOUT	BK-GCS-PEDCO-120-CV-PY-0006
PLUMBING & SEWAGE PIPING LAYOUT FOR CONTROL BUILDING	BK-GCS-PEDCO-120-HV-PY-0001
UNIT PLOT PLAN DRAWING	BK-GCS-PEDCO-120-PI-PY-0001
STANDARD DRAWING FOR CIVIL UNDERGROUND CROSSING	BK-GNRL-PEDCO-000-CV-DW-0008
STANDARD DRAWING FOR MANHOLES	BK-GNRL-PEDCO-000-CV-DW-0005
ROAD, PAVING AND PLANT FINISH GRADING LAYOUT & SECTIONS	BK-GCS-PEDCO-120-CV-PY-0006
STANDARD DRAWING FOR CIVIL UNDERGROUND CROSSING	BK-GNRL-PEDCO-000-CV-DW-0008
ARCHITECTURAL DETAIL DRAWING FOR GCS WAREHOUSE	BK-GCS-PEDCO-120-AR-DW-0011
ARCHITECTURAL DRAWING FOR CCTV CONTROL ROOM	BK-GCS-PEDCO-120-AR-DW-0011
ARCHITECTURAL DETAIL DRAWING FOR EXTENSION OF EXISTING CONTROL BUILDING	BK-GNRL-PEDCO-000-CV-DW-0008
PLUMBING & SEWAGE PIPING LAYOUT FOR EXTENSION OF EXISTING CONTROL BUILDING	BK-GCS-PEDCO-120-HV-PY-0015
PLUMBING & SEWAGE PIPING LAYOUT FOR CCTV CONTROL ROOM	BK-GCS-PEDCO-120-HV-PY-0001

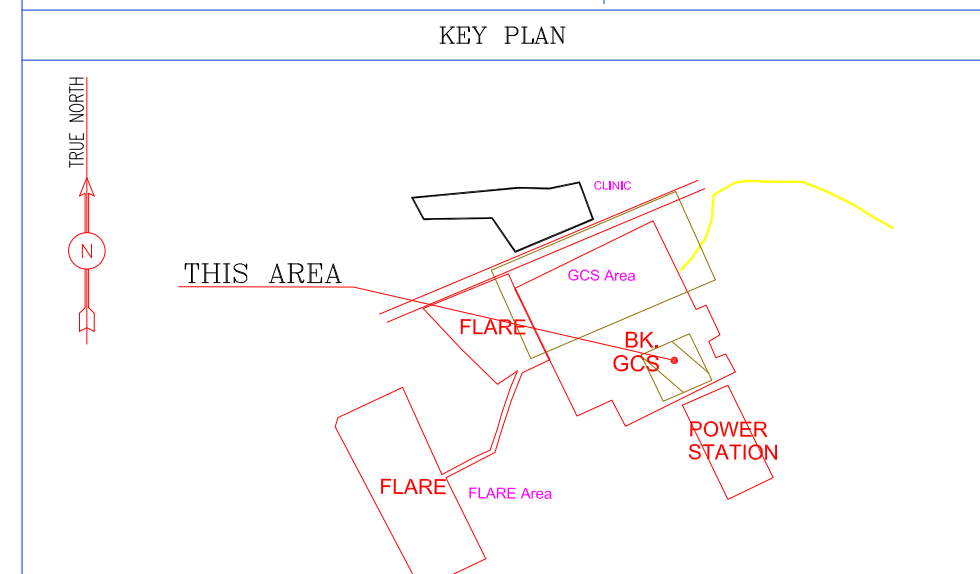

 D01 TOTALLY REVISED

EPC CONTRACTOR:										EPD/EPC CONTRACTOR (GC):										BINAK OILFIELD DEVELOPMENT GENERAL									
 HIRGAN ENERGY - DESIGN & INSPECTION COMPANIES																				 PETROIRAN DEVELOPMENT COMPANY									
DRAWING TITLE:										NO CONSTRUCTION PERMITTED UNLESS DRAWING APPROVED																			
SITE SEWERAGE SYSTEM LAYOUT & DETAILS										APPROVED FOR CONSTRUCTION										BY: DATE:									
SCALE		SIZE		DRAWING NO.				SHEET NO.		REV.		BUDGET REF.		LOCATION		SIZE		CLASS		SERIAL NO.		SHEET		REVISION					
1/250		A1		BK-GCS-PEDCO-120-CV-PY-0001				02 OF 02		D01		053-073-9184		F		4		S		709108		5		D01					