
 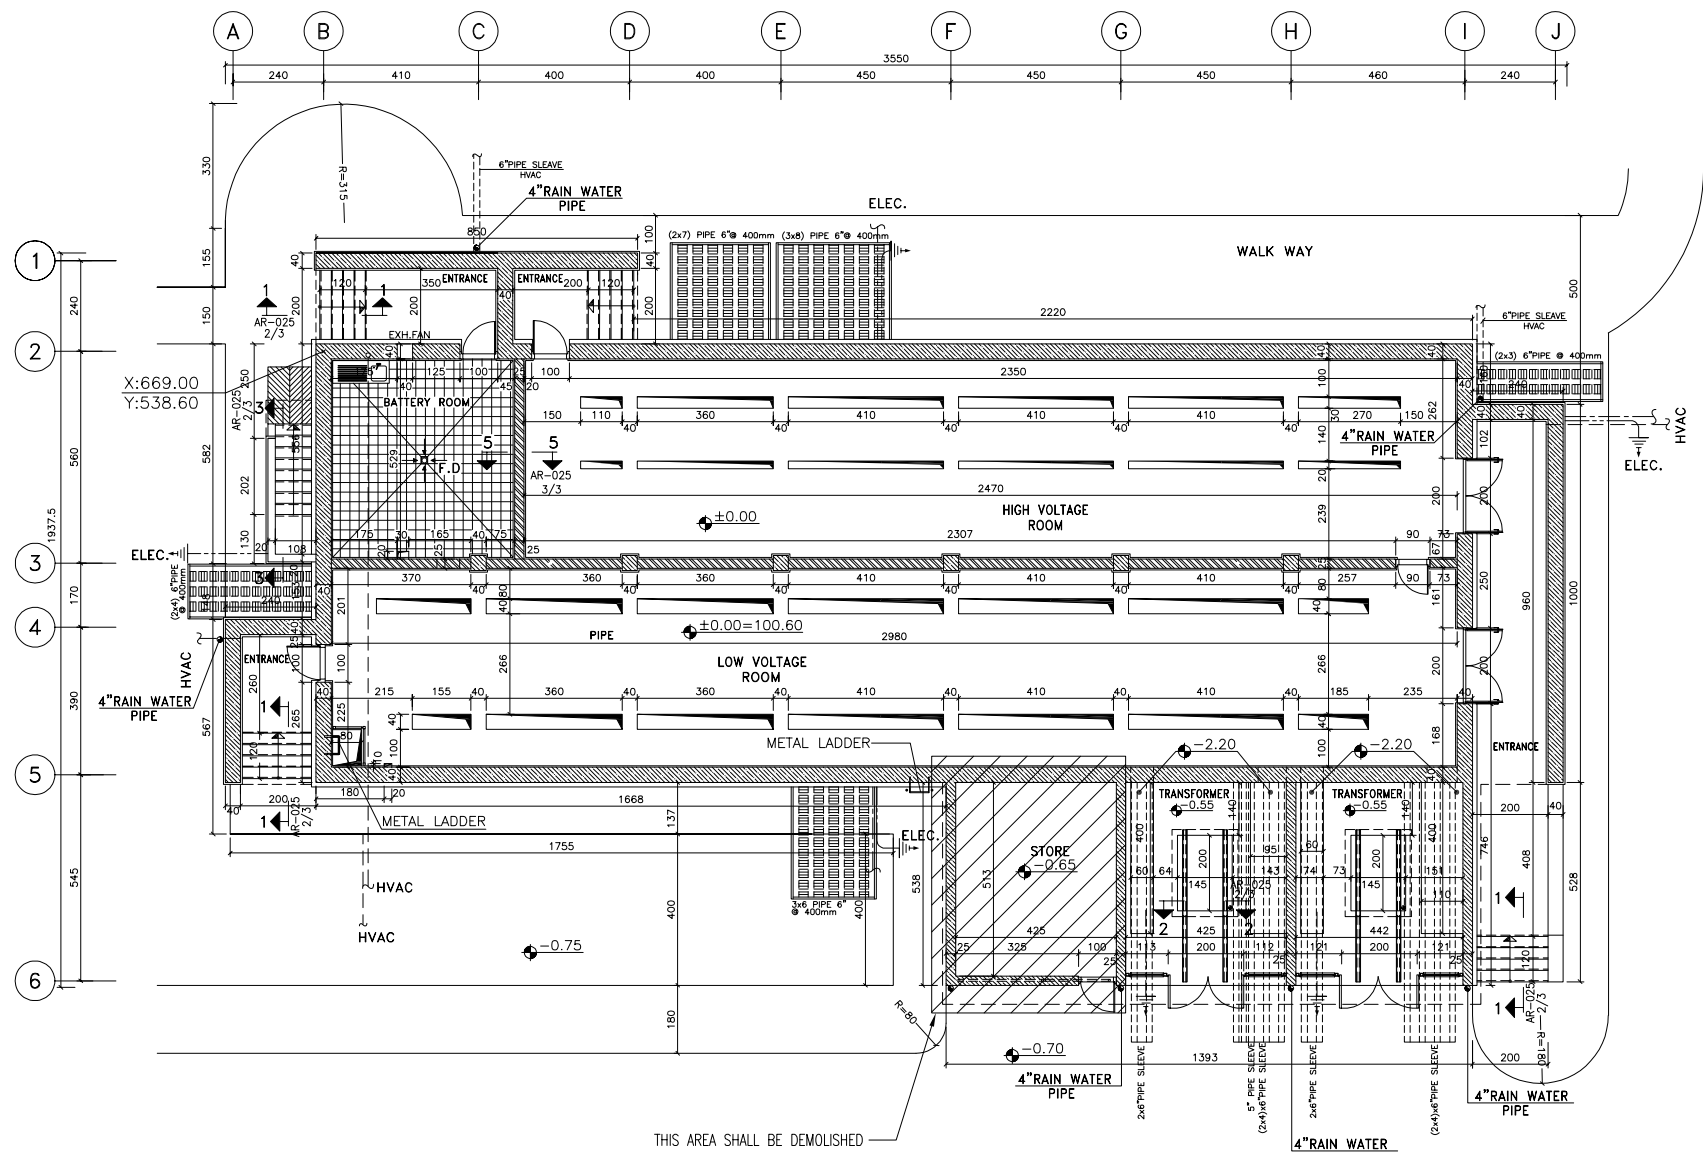





SC.1:100 1 EXISTING PLAN

- NOTES
1. ALL DIMENSIONS ARE IN CENTIMETER & ALL ELEVATIONS ARE IN METER.
 2. ALL DIMENSIONS AND ELEVATIONS SHALL BE CHECKED BY THE CONTRACTOR PRIOR TO CONSTRUCTION.
 3. CONTRACTOR SHALL COMPARE ALL ARCHITECTURAL, MECHANICAL, ELECTRICAL, PIPING AND STRUCTURAL DRAWINGS AND IN CASE OF ANY CONFLICTS OR DISCREPANCY, INFORM THE ENGINEER.
 4. ALL MATERIALS ARE SELECTED FROM THE HIGHEST QUALITY AND MUST BE APPROVED BY THE CLIENT.
 5. ALL OPENINGS FOR PIPING/CABLEING AND HVAC OPENINGS SHALL BE CONSIDERED AS PER RELATED DRAWINGS BEFORE CONSTRUCTION.
 6. ARCHITECTURAL DETAIL DESIGN WILL BE REVISED BASED ON APPROVED STRUCTURAL DRAWINGS.
 7. ELEVATION CODE : LOCAL ±0.0m CORRESPONDS TO GLOBAL +11.10m

LEGEND			
LEAN CONCRETE			
REINFORCED CONCRETE			
PRESSED BRICK			
STONE			
EXPANSION JOINT FILLER (PLASTOFOAM)			
TERRAZZO TILES FOR ROOF - 30x30cm			
BLOCKAGE			
F.F.L.	FINISHED FLOOR	B.O.P.	BOTTOM OF PIT
T.O.WA	TOP OF WALKWAY	F.G.L.	FINISH GRADING LEVEL
T.O.P.	TOP OF PARAPET	T.O.T.	TOP OF TRENCH
T.O.FOU.	TOP OF FOUNDATION	C.O.S.	CENTER OF SLEEVE
M.D	METAL DOOR	B.O.S.	BOTTOM OF SLEEVE
T.O.R.	TOP OF ROOF	B.O.O.	BOTTOM OF OPENING
T.O.D.	TOP OF DOOR	B.O.T.	BOTTOM OF TRENCH
B.O.Cg.	BOTTOM OF CAGE	B.O.P.	BOTTOM OF PIT
T.O.Cg.	TOP OF CAGE	R.H.P.	ROOF HIGHEST POINT
B.O.G.	BOTTOM OF GUTTER	R.L.P.	ROOF LOWEST POINT
T.O.Cg.	TOP OF CAGE	N.G.R.	NEUTRAL GROUND RESISTOR
M.D.	METAL DOOR	B.P.D.	BLAST-PROOF DOOR
T.O.S.	TOP OF SLAB	F.D.	FENCE DOOR



REFERENCE DRAWING	DRG. No.
STANDARD DRAWING FOR ARCHITECTURAL DETAILS	BK-GNRL-PEDCO-000-AR-DW-0001
SITE SEWAGEAGE SYSTEM LAYOUT & DETAILS	BK-GCS-PEDCO-120-CV-PY-0001
CABLE TRENCH AND DUCT BANK LAYOUT	BK-GCS-PEDCO-120-CV-PY-0002
ELECTRICAL CABLE ROUTE & SECTION LAYOUT FOR BUILDING & SHED	BK-GCS-PEDCO-120-EL-PY-0006
FOUNDATION DRAWING FOR EXTENSION OF EXISTING ELECT. BUILDING	BK-GCS-PEDCO-120-ST-DW-0003
STRUCTURAL DRAWING FOR EXTENSION OF EXISTING ELECT. BUILDING	BK-GCS-PEDCO-120-ST-DW-0004
STANDARD DETAILS FOR LADDER & SAFETY CAGE	BK-GNRL-PEDCO-000-ST-DW-0009
ELECTRICAL EQUIPMENT ARRANGEMENT LAYOUT FOR BUILDING	BK-GCS-PEDCO-120-ST-BE-PY-0008
UNIT PLAN LAYOUT DRAWING	BK-GCS-PEDCO-120-PI-PY-0001

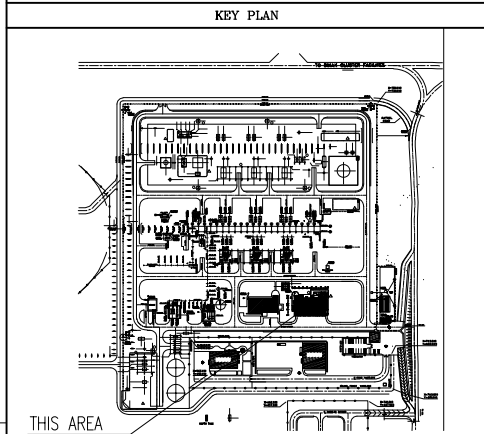

D07	MAR. 2024	APC	R.BERLOUIR	M.PAKHARIAN	S.Parmarspour	** **
D06	NOV. 2023	APC	R.BERLOUIR	M.PAKHARIAN	S.Parmarspour	** **
D05	SEP. 2023	APC	R.BERLOUIR	M.PAKHARIAN	A.M.MOHSSENI	** **
D04	AUG. 2023	IPA	R.BERLOUIR	M.PAKHARIAN	A.M.MOHSSENI	** **
D03	MAY. 2023	IPA	R.BERLOUIR	M.PAKHARIAN	A.M.MOHSSENI	** **
D02	AUG. 2022	IPA	R.BERLOUIR	M.PAKHARIAN	M.MEHRSHAD	** **
D01	APR. 2022	IPA	R.BERLOUIR	M.PAKHARIAN	M.MEHRSHAD	** **
D00	JAN. 2022	IPC	R.BERLOUIR	M.PAKHARIAN	M.MEHRSHAD	** **

PROJECT NAME:		BINAK OILFIELD DEVELOPMENT/SURFACE FACILITIES GAS COMPRESSOR STATION			
PROJECT NO.:		971020			
EPC CONTRACTOR:		EPD/EPC CONTRACTOR (GC):			
 HIRGAN ENERGY - DESIGN & INSPECTION COMPANIES		 PETROIRAN DEVELOPMENT COMPANY			
DRAWING TITLE:		ARCHITECTURAL DETAIL DRAWING FOR EXTENSION OF EXISTING ELECT. BUILDING EXISTING PLAN			
SCALE	SIZE	DRAWING NO.		SHEET NO.	REV.
AS SHOWN	A1	BK-GCS-PEDCO-120-AR-DW-0002		01 OF 15	D07

THE ORIGINAL AND ALL COPIES OF THIS DRAWING TOGETHER WITH THE COPYRIGHT THEREIN ARE THE SOLE PROPERTY OF N.I.S.O.C./ FIELDS					
BINAK OILFIELD DEVELOPMENT SURFACE FACILITIES GAS COMPRESSOR STATION					
DATE	SCALE	DRAWING BY	CHECKED BY	PROJECT ENG.	
NO CONSTRUCTION PERMITTED UNLESS DRAWING APPROVED					
APPROVED FOR CONSTRUCTION			BY:	DATE:	
BUDGET REF.	LOCATION	SIZE CLASS	SERIAL NO.	SHEET	REVISION
AS SHOWN	A1	BK-GCS-PEDCO-120-AR-DW-0002	01 OF 15	D07	

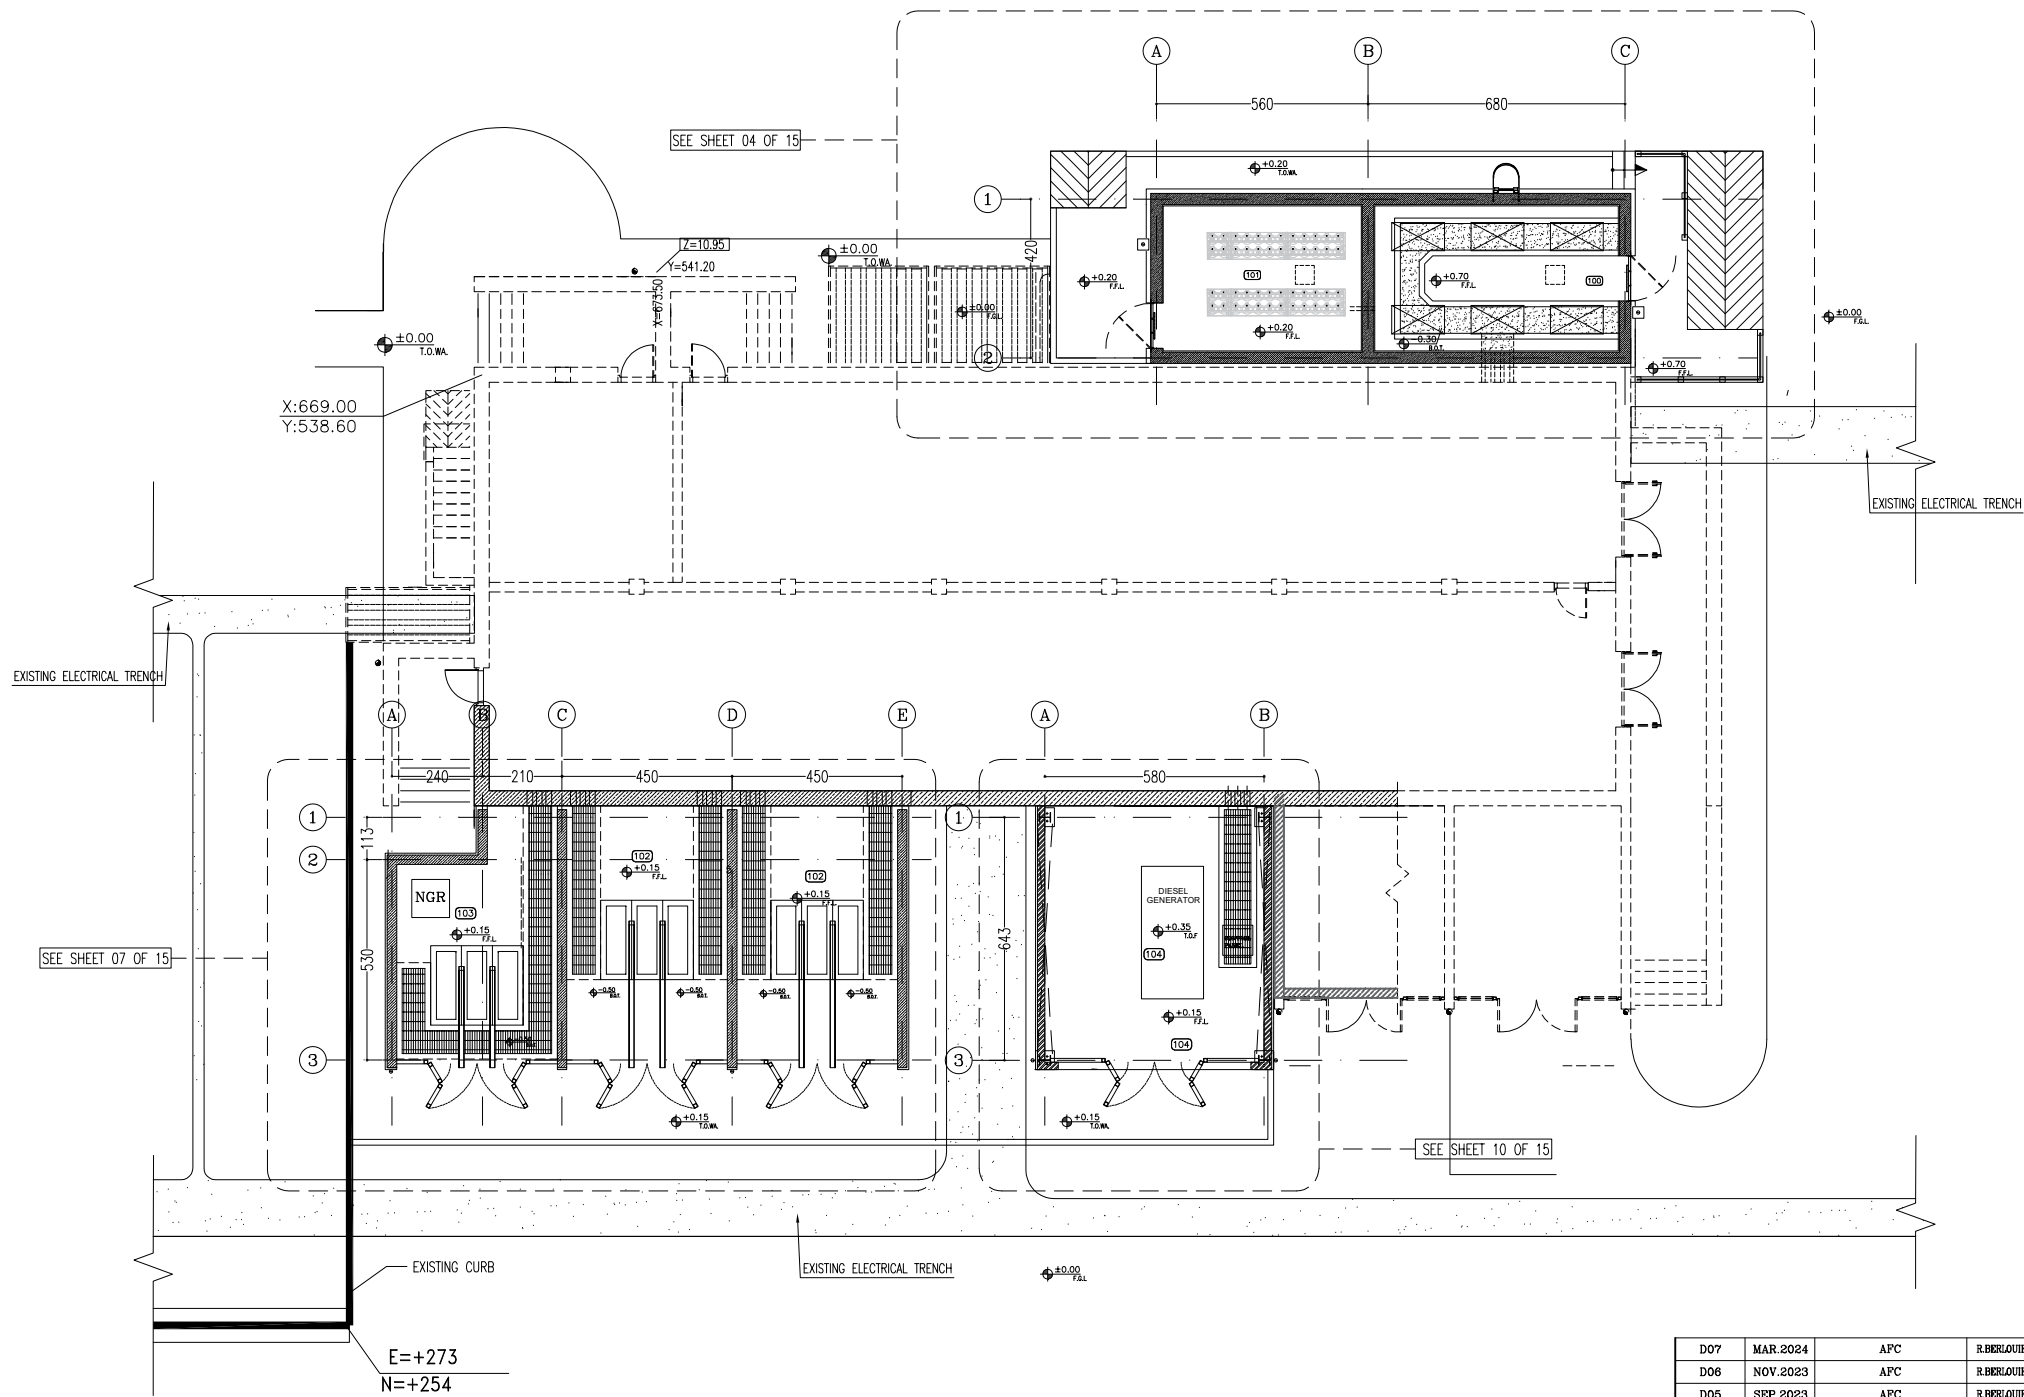 

SPACE TAG NUMBER


- 100 CAPACITOR BANK
- 101 CO2 ROOM
- 102 TRANSFORMER ROOM
- 103 FIRE-FIGHTING PUMP TRANSFORMER ROOM
- 104 DIESEL ROOM

SC.1:100 2 PLAN

- NOTES
1. ALL DIMENSIONS ARE IN CENTIMETER & ALL ELEVATIONS ARE IN METER.
 2. ALL DIMENSIONS AND ELEVATIONS SHALL BE CHECKED BY THE CONTRACTOR PRIOR TO CONSTRUCTION.
 3. CONTRACTOR SHALL COMPARE ALL ARCHITECTURAL, MECHANICAL, ELECTRICAL, PIPING AND STRUCTURAL DRAWINGS AND IN CASE OF ANY CONFLICTS OR DISCREPANCY, INFORM THE ENGINEER.
 4. ALL MATERIALS ARE SELECTED FROM THE HIGHEST QUALITY AND MUST BE APPROVED BY THE CLIENT.
 5. ALL OPENINGS FOR PIPING/CABLING AND HVAC OPENINGS SHALL BE CONSIDERED AS PER RELATED DRAWINGS BEFORE CONSTRUCTION.
 6. ARCHITECTURAL DETAIL DESIGN WILL BE REVISED BASED ON APPROVED STRUCTURAL DRAWINGS.
 7. ELEVATION CODE : LOCAL ±0.0m CORRESPONDS TO GLOBAL +11.10m

LEGEND			
LEAN CONCRETE			
REINFORCED CONCRETE			
PRESSED BRICK			
STONE			
EXPANSION JOINT FILLER (PLASTOFOAM)			
TERRAZZO TILES FOR ROOF - 30x30cm			
BLOCKAGE			
F.F.L.	FINISHED FLOOR	B.O.P.	BOTTOM OF PIT
T.O.WA	TOP OF WALKWAY	F.G.L.	FINISH GRADING LEVEL
T.O.P.	TOP OF PARAPET	T.O.T.	TOP OF TRENCH
T.O.FOU.	TOP OF FOUNDATION	C.O.S.	CENTER OF SLEEVE
M.D	METAL DOOR	B.O.S.	BOTTOM OF SLEEVE
T.O.R.	TOP OF ROOF	B.O.O.	BOTTOM OF OPENING
T.O.D.	TOP OF DOOR	B.O.T.	BOTTOM OF TRENCH
B.O.Co.	BOTTOM OF CAGE	B.O.P.	BOTTOM OF PIT
T.O.Co.	TOP OF CAGE	R.H.P.	ROOF HIGHEST POINT
B.O.G.	BOTTOM OF GUTTER	R.L.P.	ROOF LOWEST POINT
T.O.Co.	TOP OF CAGE	N.G.R.	NEUTRAL GROUND RESISTOR
M.D.	METAL DOOR	B.P.D.	BLAST-PROOF DOOR
T.O.S.	TOP OF SLAB	F.D.	FENCE DOOR

REFERENCE DRAWING	DRG. No.
STANDARD DRAWING FOR ARCHITECTURAL DETAILS	BK-GNRL-PEDCO-000-AR-DW-0001
SITE SEWAGE SYSTEM LAYOUT & DETAILS	BK-GCS-PEDCO-120-CV-PY-0001
CABLE TRENCH AND DUCT BANK LAYOUT	BK-GCS-PEDCO-120-CV-PY-0002
ELECTRICAL CABLE ROUTE & SECTION LAYOUT FOR BUILDING & SHED	BK-GCS-PEDCO-120-EL-PY-0006
FOUNDATION DRAWING FOR EXTENSION OF EXISTING ELECT. BUILDING	BK-GCS-PEDCO-120-ST-DW-0003
STRUCTURAL DRAWING FOR EXTENSION OF EXISTING ELECT. BUILDING	BK-GCS-PEDCO-120-ST-DW-0004
STANDARD DETAILS FOR LADDER & SAFETY CAGE	BK-GNRL-PEDCO-000-ST-DW-0009
ELECTRICAL EQUIPMENT ARRANGEMENT LAYOUT FOR BUILDING	BK-GCS-PEDCO-120-ST-BL-PY-0008
UNIT LAYOUT PLAN DRAWING	BK-GCS-PEDCO-120-PI-PY-0001

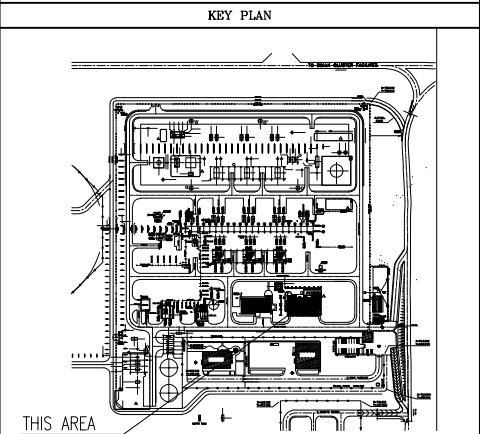

D07	MAR. 2024	APC	R.BERLOUIR	M.PAKHARIAN	S.Parmaragpour	** **
D06	NOV. 2023	APC	R.BERLOUIR	M.PAKHARIAN	S.Parmaragpour	** **
D05	SEP. 2023	APC	R.BERLOUIR	M.PAKHARIAN	A.M.MOHSENI	** **
D04	AUG. 2023	IPA	R.BERLOUIR	M.PAKHARIAN	A.M.MOHSENI	** **
D03	MAY. 2023	IPA	R.BERLOUIR	M.PAKHARIAN	A.M.MOHSENI	** **
D02	AUG. 2022	IPA	R.BERLOUIR	M.PAKHARIAN	M.MEHRSHAD	** **
D01	APR. 2022	IPA	R.BERLOUIR	M.PAKHARIAN	M.MEHRSHAD	** **
D00	JAN. 2022	IPC	R.BERLOUIR	M.PAKHARIAN	M.MEHRSHAD	** **
REV.	DATE	P.O.I.S	PREP.	CHK.	APP.	AUT.

PROJECT NAME: BINAK OILFIELD DEVELOPMENT/SURFACE FACILITIES GAS COMPRESSOR STATION

PROJECT NO.: 971020



EPC CONTRACTOR:	EPD/EPC CONTRACTOR (GC):
 HIRGAN ENERGY - DESIGN & INSPECTION COMPANIES	 PETROIRAN DEVELOPMENT COMPANY

DRAWING TITLE: ARCHITECTURAL DETAIL DRAWING FOR EXTENSION OF EXISTING ELECT. BUILDING PLANS

SCALE	SIZE	DRAWING NO.	SHEET NO.	REV.
AS SHOWN	A1	BK-GCS-PEDCO-120-AR-DW-0002	02 OF 15	D07


اسم و کلیه نسخ این نقشه و حق اقتباس متعلق به شرکت ملی مناطق نفت خیز جنوب می باشد.
THE ORIGINAL AND COPIES OF THIS DRAWING TOGETHER WITH THE COPYRIGHT THEREIN ARE THE SOLE PROPERTY OF N.I.S.O.C./ FIELDS

BINA OILFIELD DEVELOPMENT SURFACE FACILITIES GAS COMPRESSOR STATION				
DATE	SCALE	DRAWING BY	CHECKED BY	PROJECT ENG.
NO CONSTRUCTION PERMITTED UNLESS DRAWING APPROVED				
APPROVED FOR CONSTRUCTION		BY:		DATE:
BUDGET REF.	LOCATION	SIZE CLASS	SERIAL NO.	SHEET
AS SHOWN	A1	BK-GCS-PEDCO-120-AR-DW-0002	02 OF 15	D07

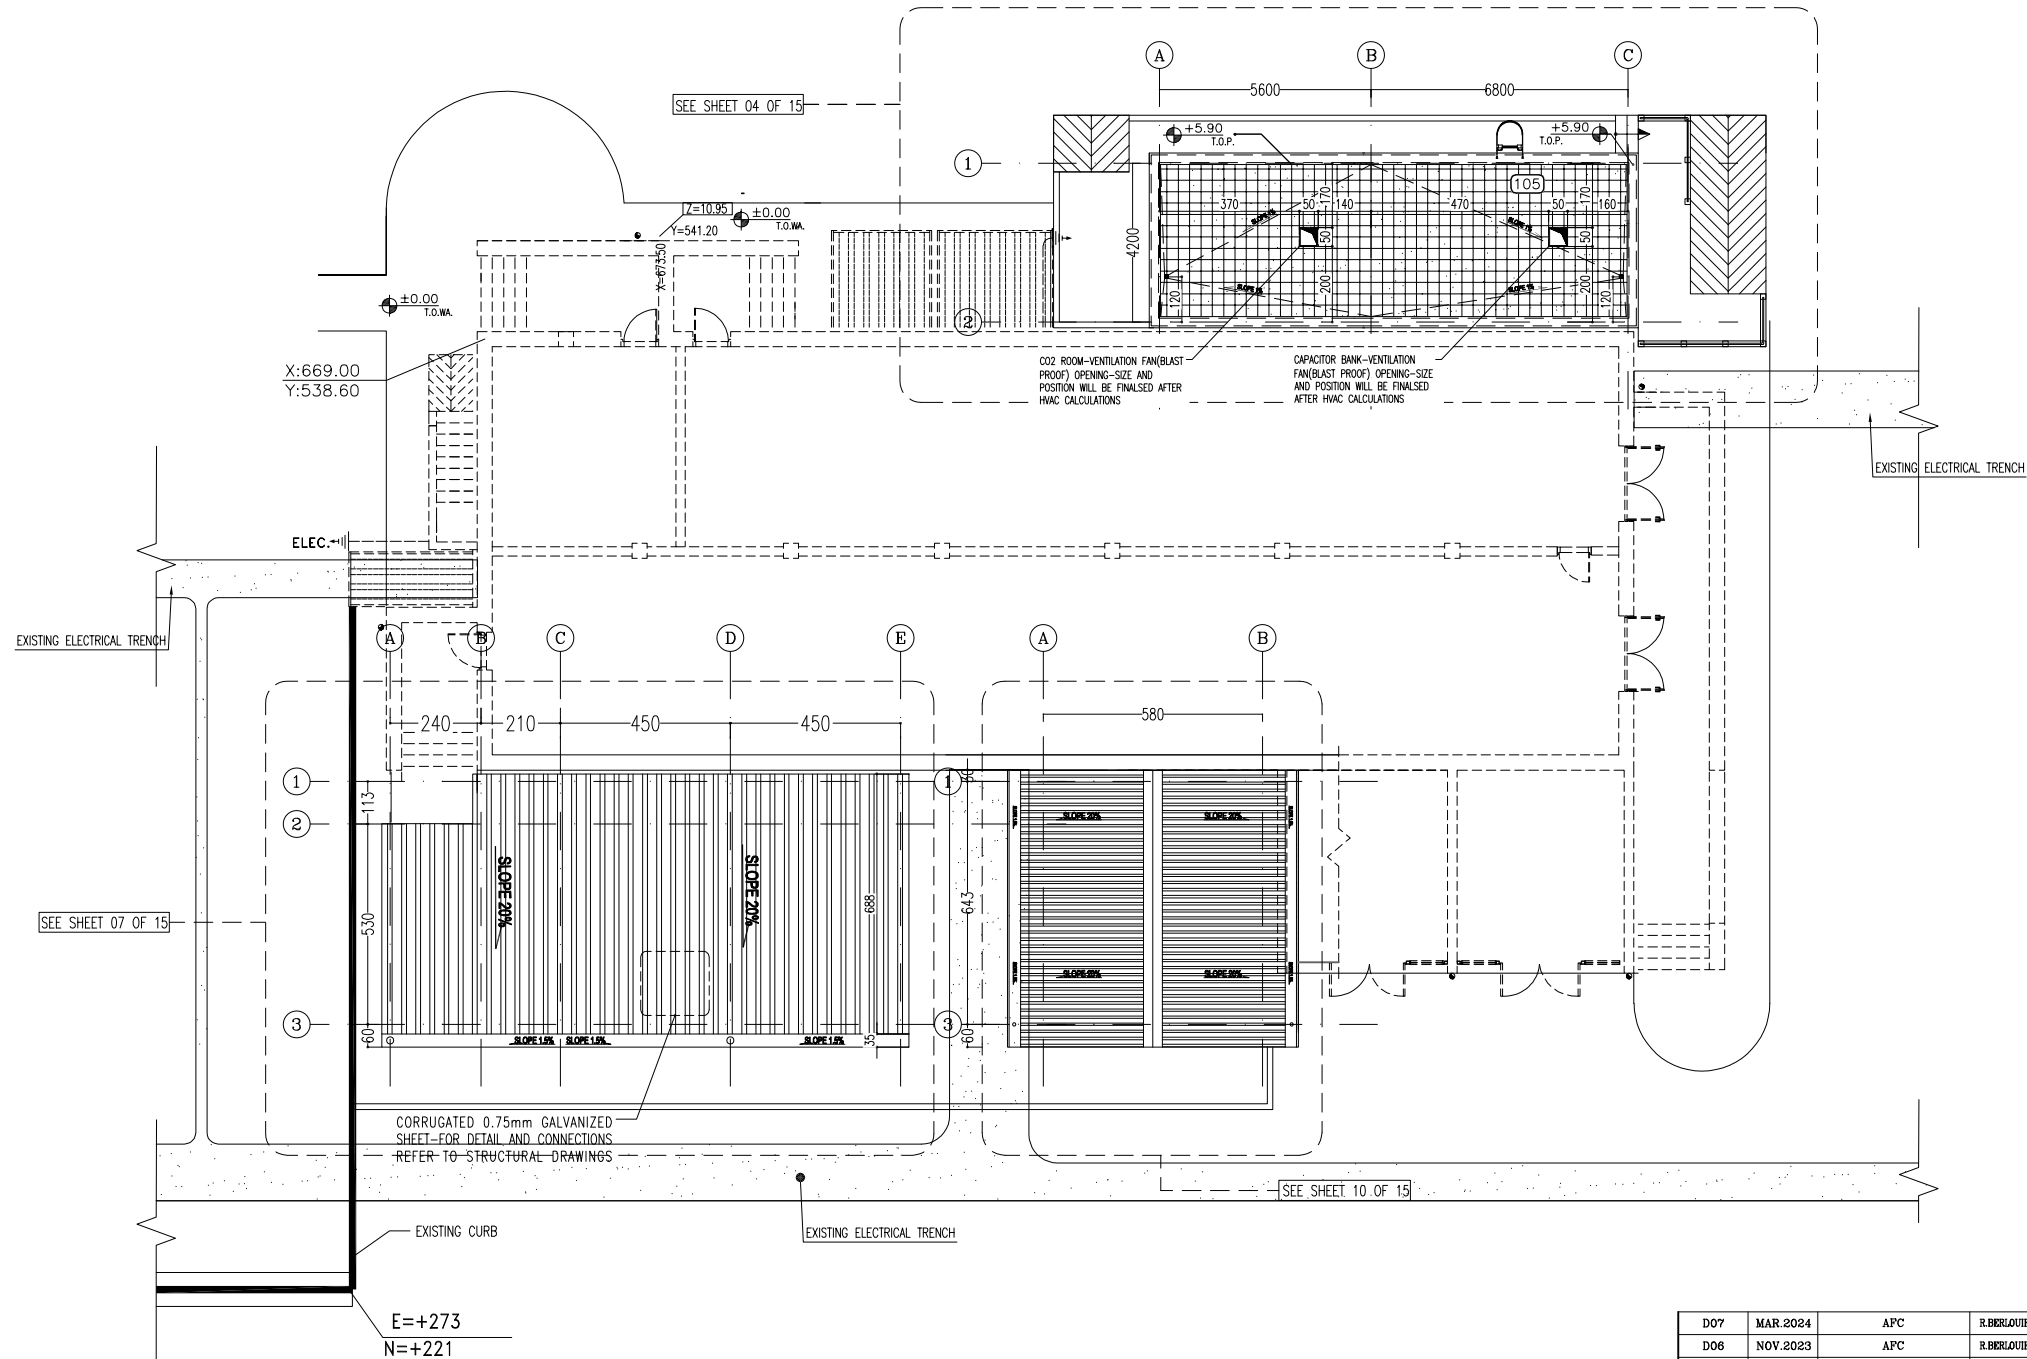 


SC.1:100 3 ROOF PLAN

D07	MAR. 2024	APC	R.BERLOUI	M.PAKHARIAN	S.Parmaragpour	** **
D06	NOV. 2023	APC	R.BERLOUI	M.PAKHARIAN	S.Parmaragpour	** **
D05	SEP. 2023	APC	R.BERLOUI	M.PAKHARIAN	A.M.MOHSENI	** **
D04	AUG. 2023	IPA	R.BERLOUI	M.PAKHARIAN	A.M.MOHSENI	** **
D03	MAY. 2023	IPA	R.BERLOUI	M.PAKHARIAN	A.M.MOHSENI	** **
D02	AUG. 2022	IPA	R.BERLOUI	M.PAKHARIAN	M.MEHRSHAD	** **
D01	APR. 2022	IPA	R.BERLOUI	M.PAKHARIAN	M.MEHRSHAD	** **
D00	JAN. 2022	IPC	R.BERLOUI	M.PAKHARIAN	M.MEHRSHAD	** **
REV.	DATE	P.O.I.S	PREP.	CHK.	APP.	AUT.


 
PROJECT NAME:		BINAK OILFIELD DEVELOPMENT/SURFACE FACILITIES GAS COMPRESSOR STATION			
PROJECT NO.:		971020			
EPC CONTRACTOR:		EPD/EPC CONTRACTOR (GC):			
 HIRGAN ENERGY - DESIGN & INSPECTION COMPANIES		  PEDCO		 PETROIRAN DEVELOPMENT COMPANY	
DRAWING TITLE:		ARCHITECTURAL DETAIL DRAWING FOR EXTENSION OF EXISTING ELECT. BUILDING ROOF PLANS			
SCALE	SIZE	DRAWING NO.		SHEET NO.	REV
AS SHOWN	A1	BK-GCS-PEDCO-120-AR-DW-0002		03 OF 15	D07

NOTES			
1. ALL DIMENSIONS ARE IN CENTIMETER & ALL ELEVATIONS ARE IN METER. 2. ALL DIMENSIONS AND ELEVATIONS SHALL BE CHECKED BY THE CONTRACTOR PRIOR TO CONSTRUCTION. 3. CONTRACTOR SHALL COMPARE ALL ARCHITECTURAL, MECHANICAL, ELECTRICAL, PIPING AND STRUCTURAL DRAWINGS AND IN CASE OF ANY CONFLICTS OR DISCREPANCY, INFORM THE ENGINEER. 4. ALL MATERIALS ARE SELECTED FROM THE HIGHEST QUALITY AND MUST BE APPROVED BY THE CLIENT. 5. ALL OPENINGS FOR PIPING/CABLING AND HVAC OPENINGS SHALL BE CONSIDERED AS PER RELATED DRAWINGS BEFORE CONSTRUCTION. 6. ARCHITECTURAL DETAIL DESIGN WILL BE REVISED BASED ON APPROVED STRUCTURAL DRAWINGS. 7. ELEVATION CODE : LOCAL ±0.0m CORRESPONDS TO GLOBAL +11.10m			
LEGEND			
LEAN CONCRETE			
REINFORCED CONCRETE			
PRESSED BRICK			
STONE			
EXPANSION JOINT FILLER (PLASTOFOAM)			
TERRAZZO TILES FOR ROOF - 30x30cm			
BLOCKAGE			
F.F.L.	FINISHED FLOOR	B.O.P.	BOTTOM OF PIT
T.O.WA	TOP OF WALKWAY	F.G.L.	FINISH GRADING LEVEL
T.O.P.	TOP OF PARAPET	T.O.T.	TOP OF TRENCH
T.O.FOU.	TOP OF FOUNDATION	C.O.S.	CENTER OF SLEEVE
M.D	METAL DOOR	B.O.S.	BOTTOM OF SLEEVE
T.O.R.	TOP OF ROOF	B.O.O.	BOTTOM OF OPENING
T.O.D.	TOP OF DOOR	B.O.T.	BOTTOM OF TRENCH
B.O.Co.	BOTTOM OF CAGE	B.O.P.	BOTTOM OF PIT
T.O.Co.	TOP OF CAGE	R.H.P.	ROOF HIGHEST POINT
B.O.G.	BOTTOM OF GUTTER	R.L.P.	ROOF LOWEST POINT
T.O.Co.	TOP OF CAGE	N.G.R.	NEUTRAL GROUND RESISTOR
M.D.	METAL DOOR	B.P.D.	BLAST-PROOF DOOR
T.O.S.	TOP OF SLAB	F.D.	FENCE DOOR

REFERENCE DRAWING	DRG. No.
STANDARD DRAWING FOR ARCHITECTURAL DETAILS	BK-GNRL-PEDCO-000-AR-DW-0001
SITE SEWAGE SYSTEM LAYOUT & DETAILS	BK-GCS-PEDCO-120-CV-PY-0001
CABLE TRENCH AND DUCT BANK LAYOUT	BK-GCS-PEDCO-120-CV-PY-0002
ELECTRICAL CABLE ROUTE & SECTION LAYOUT FOR BUILDING & SHED	BK-GCS-PEDCO-120-EL-PY-0006
FOUNDATION DRAWING FOR EXTENSION OF EXISTING ELECT. BUILDING	BK-GCS-PEDCO-120-ST-DW-0003
STRUCTURAL DRAWING FOR EXTENSION OF EXISTING ELECT. BUILDING	BK-GCS-PEDCO-120-ST-DW-0004
STANDARD DETAILS FOR LADDER & SAFETY CAGE	BK-GNRL-PEDCO-000-ST-DW-0009
ELECTRICAL EQUIPMENT ARRANGEMENT LAYOUT FOR BUILDING	BK-GCS-PEDCO-120-ST-BE-PY-0008
UNIT PLOT PLAN DRAWING	BK-GCS-PEDCO-120-PI-PY-0001

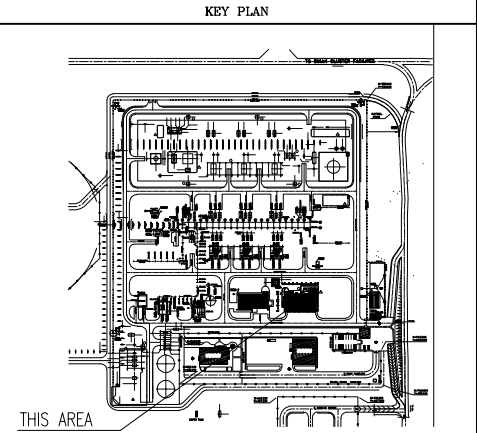

																																																																																																																																																																																																																																																																																																																																																																																																																																																																																																																																																																																																																																																																																																																																																																																																																																																																																																																																																																																																																																																																																																																																																																																																																																																																																																																																																																																																																					</
--	--	----

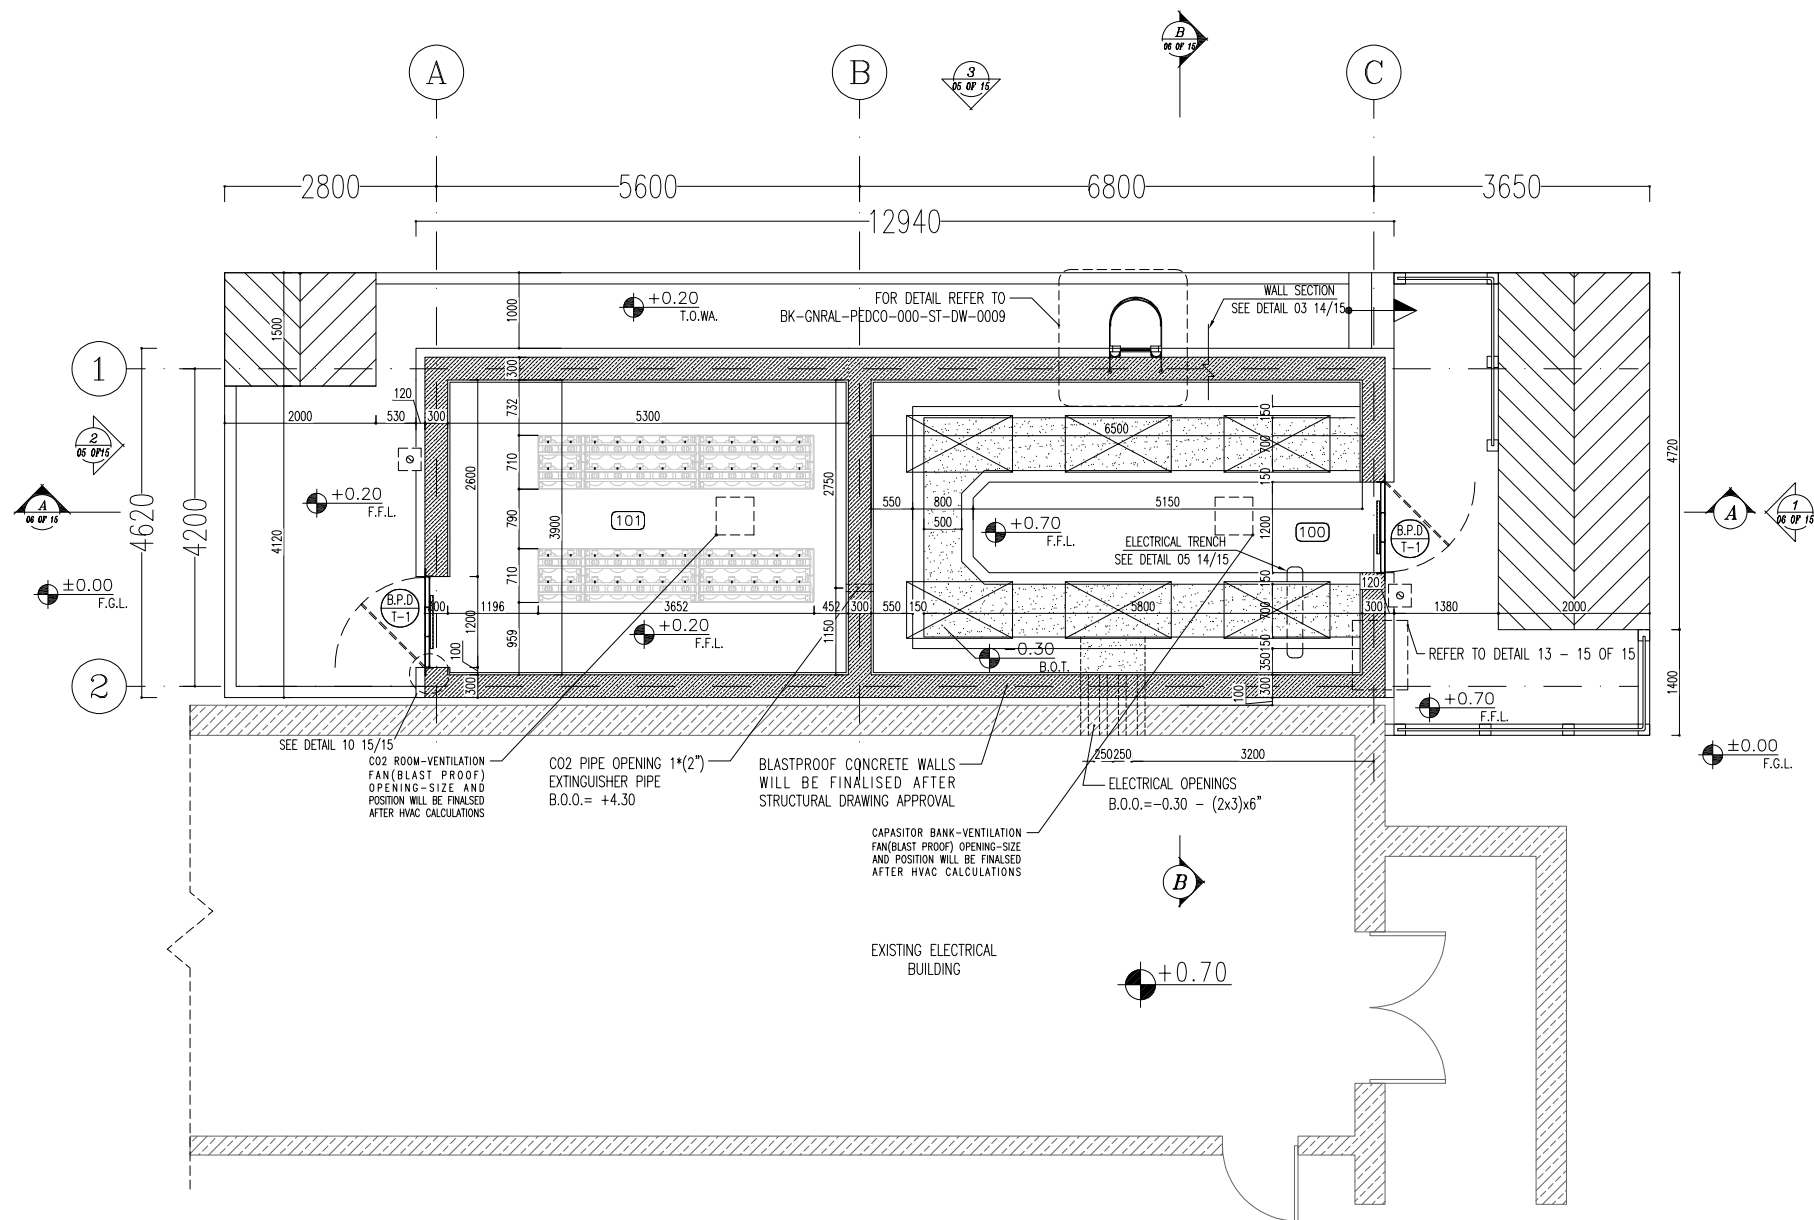 

SC.1:50 4 CAPACITOR BANK AND CO2 ROOM PLAN

SPACE TAG	AREA
100	32m ²
101	25m ²
102	32m ² + 32m ²
103	29m ²
104	27m ²
TOTAL	174m ²

SPACE TAG NUMBER

- 100 CAPACITOR BANK
- 101 CO2 ROOM
- 102 TRANSFORMER ROOM
- 103 FIRE-FIGHTING PUMP TRANSFORMER ROOM
- 104 DIESEL ROOM


- NOTES
1. ALL DIMENSIONS ARE IN CENTIMETER & ALL ELEVATIONS ARE IN METER.
 2. ALL DIMENSIONS AND ELEVATIONS SHALL BE CHECKED BY THE CONTRACTOR PRIOR TO CONSTRUCTION.
 3. CONTRACTOR SHALL COMPARE ALL ARCHITECTURAL, MECHANICAL, ELECTRICAL, PIPING AND STRUCTURAL DRAWINGS AND IN CASE OF ANY CONFLICTS OR DISCREPANCY, INFORM THE ENGINEER.
 4. ALL MATERIALS ARE SELECTED FROM THE HIGHEST QUALITY AND MUST BE APPROVED BY THE CLIENT.
 5. ALL OPENINGS FOR PIPING/CABLING AND HVAC OPENINGS SHALL BE CONSIDERED AS PER RELATED DRAWINGS BEFORE CONSTRUCTION.
 6. ARCHITECTURAL DETAIL DESIGN WILL BE REVISED BASED ON APPROVED STRUCTURAL DRAWINGS.
 7. ELEVATION CODE : LOCAL ±0.0m CORRESPONDS TO GLOBAL +11.10m

LEGEND

LEAN CONCRETE	
REINFORCED CONCRETE	
PRESSED BRICK	
STONE	
EXPANSION JOINT FILLER (PLASTOFOAM)	
TERRAZZO TILES FOR ROOF - 30x30cm	
BLOCKAGE	
F.F.L. FINISHED FLOOR	B.O.P. BOTTOM OF PIT
T.O.WA. TOP OF WALKWAY	F.G.L. FINISH GRADING LEVEL
T.O.P. TOP OF PARAPET	T.O.T. TOP OF TRENCH
T.O.FOU. TOP OF FOUNDATION	C.O.S. CENTER OF SLEEVE
M.D. METAL DOOR	B.O.S. BOTTOM OF SLEEVE
T.O.R. TOP OF ROOF	B.O.O. BOTTOM OF OPENING
T.O.D. TOP OF DOOR	B.O.T. BOTTOM OF TRENCH
B.O.Co. BOTTOM OF CAGE	B.O.P. BOTTOM OF PIT
T.O.Co. TOP OF CAGE	R.H.P. ROOF HIGHEST POINT
B.O.G. BOTTOM OF GUTTER	R.L.P. ROOF LOWEST POINT
T.O.Co. TOP OF CAGE	N.G.R. NEUTRAL GROUND RESISTOR
M.D. METAL DOOR	B.P.D. BLAST-PROOF DOOR
T.O.S. TOP OF SLAB	F.D. FENCE DOOR

REFERENCE DRAWING	DRG. No.
STANDARD DRAWING FOR ARCHITECTURAL DETAILS	BK-GNRL-PEDCO-000-AR-DW-0001
SITE SEWAGE SYSTEM LAYOUT & DETAILS	BK-GCS-PEDCO-120-CV-PY-0001
CABLE TRENCH AND DUCT BANK LAYOUT	BK-GCS-PEDCO-120-CV-PY-0002
ELECTRICAL CABLE ROUTE & SECTION LAYOUT FOR BUILDING & SHELTER	BK-GCS-PEDCO-120-EL-PY-0006
FOUNDATION DRAWING FOR EXTENSION OF EXISTING ELECT. BUILDING	BK-GCS-PEDCO-120-ST-DW-0003
STRUCTURAL DRAWING FOR EXTENSION OF EXISTING ELECT. BUILDING	BK-GCS-PEDCO-120-ST-DW-0004
STANDARD DETAILS FOR LADDER & SAFETY CAGE	BK-GNRL-PEDCO-000-ST-DW-0009
ELECTRICAL EQUIPMENT ARRANGEMENT LAYOUT FOR BUILDING	BK-GCS-PEDCO-120-ST-BE-PY-0008
UNIT LAYOUT PLAN DRAWING	BK-GCS-PEDCO-120-PI-PY-0001

KEY PLAN

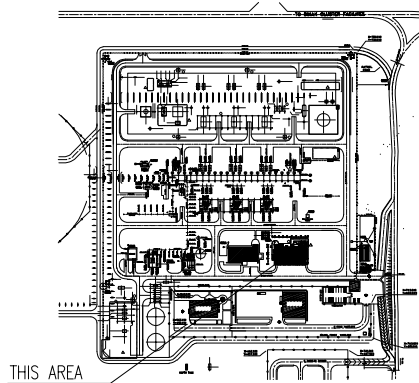

D07	MAR. 2024	APC	R.BERLOUIR	M.PAKHARIAN	S.Paramarapour	** **
D06	NOV. 2023	APC	R.BERLOUIR	M.PAKHARIAN	S.Paramarapour	** **
D05	SEP. 2023	APC	R.BERLOUIR	M.PAKHARIAN	A.M.MOHSSENI	** **
D04	AUG. 2023	IPA	R.BERLOUIR	M.PAKHARIAN	A.M.MOHSSENI	** **
D03	MAY. 2023	IPA	R.BERLOUIR	M.PAKHARIAN	A.M.MOHSSENI	** **
D02	AUG. 2022	IPA	R.BERLOUIR	M.PAKHARIAN	M.MEHRSHAD	** **
D01	APR. 2022	IPA	R.BERLOUIR	M.PAKHARIAN	M.MEHRSHAD	** **
D00	JAN. 2022	IPC	R.BERLOUIR	M.PAKHARIAN	M.MEHRSHAD	** **
REV.	DATE	P.O.I.S	PREP.	CHK.	APP.	AUT.

PROJECT NAME: BINAK OILFIELD DEVELOPMENT/SURFACE FACILITIES GAS COMPRESSOR STATION

PROJECT NO.: 971020

EPC CONTRACTOR:	EPD/EPC CONTRACTOR (GC):

DRAWING TITLE: ARCHITECTURAL DETAIL DRAWING FOR EXTENSION OF EXISTING ELECT. BUILDING PLAN

SCALE	SIZE	DRAWING NO.	SHEET NO.	REV.
AS SHOWN	A1	BK-GCS-PEDCO-120-AR-DW-0002	04 OF 15	D07

THE ORIGINAL AND ALL COPIES OF THIS DRAWING TOGETHER WITH THE COPYRIGHT THEREIN ARE THE SOLE PROPERTY OF N.I.S.O.C./ FIELDS

BINAK OILFIELD DEVELOPMENT SURFACE FACILITIES GAS COMPRESSOR STATION				
DATE	SCALE	DRAWING BY	CHECKED BY	PROJECT ENG.



NO CONSTRUCTION PERMITTED UNLESS DRAWING APPROVED


APPROVED FOR CONSTRUCTION				BY:	DATE:
BUDGET REF.	LOCATION	SIZE CLASS	SERIAL NO.	SHEET	REVISION
053-073-9184	F	4	B	709100	04 OF 15 D07

NOTES

1. ALL DIMENSIONS ARE IN CENTIMETER & ALL ELEVATIONS ARE IN METER.
2. ALL DIMENSIONS AND ELEVATIONS SHALL BE CHECKED BY THE CONTRACTOR PRIOR TO CONSTRUCTION.
3. CONTRACTOR SHALL COMPARE ALL ARCHITECTURAL, MECHANICAL, ELECTRICAL, PIPING AND STRUCTURAL DRAWINGS AND IN CASE OF ANY CONFLICTS OR DISCREPANCY, INFORM THE ENGINEER.
4. ALL MATERIALS ARE SELECTED FROM THE HIGHEST QUALITY AND MUST BE APPROVED BY THE CLIENT.
5. ALL OPENINGS FOR PIPING/CABLING AND HVAC OPENINGS SHALL BE CONSIDERED AS PER RELATED DRAWINGS BEFORE CONSTRUCTION.
6. ARCHITECTURAL DETAIL DESIGN WILL BE REVISED BASED ON APPROVED STRUCTURAL DRAWINGS.
7. ELEVATION CODE : LOCAL ±0.0m CORRESPONDS TO GLOBAL +11.10m

  LEGEND


LEAN CONCRETE	
REINFORCED CONCRETE	
PRESSED BRICK	
STONE	
EXPANSION JOINT FILLER (PLASTOFOAM)	
TERRAZZO TILES FOR ROOF - 30x30cm	
BLOCKAGE	
F.F.L. FINISHED FLOOR	B.O.P. BOTTOM OF PIT
T.O.WA. TOP OF WALKWAY	F.G.L. FINISH GRADING LEVEL
T.O.P. TOP OF PARAPET	T.O.T. TOP OF TRENCH
T.O.FOU. TOP OF FOUNDATION	C.O.S. CENTER OF SLEEVE
M.D. METAL DOOR	B.O.S. BOTTOM OF SLEEVE
T.O.R. TOP OF ROOF	B.O.O. BOTTOM OF OPENING
T.O.D. TOP OF DOOR	B.O.T. BOTTOM OF TRENCH
B.O.Cg. BOTTOM OF CAGE	B.O.P. BOTTOM OF PIT
T.O.Cg. TOP OF CAGE	R.H.P. ROOF HIGHEST POINT
B.O.G. BOTTOM OF GUTTER	R.L.P. ROOF LOWEST POINT
T.O.Cg. TOP OF CAGE	N.G.R. NEUTRAL GROUND RESISTOR
M.D. METAL DOOR	B.P.D. BLAST-PROOF DOOR
T.O.S. TOP OF SLAB	F.D. FENCE DOOR

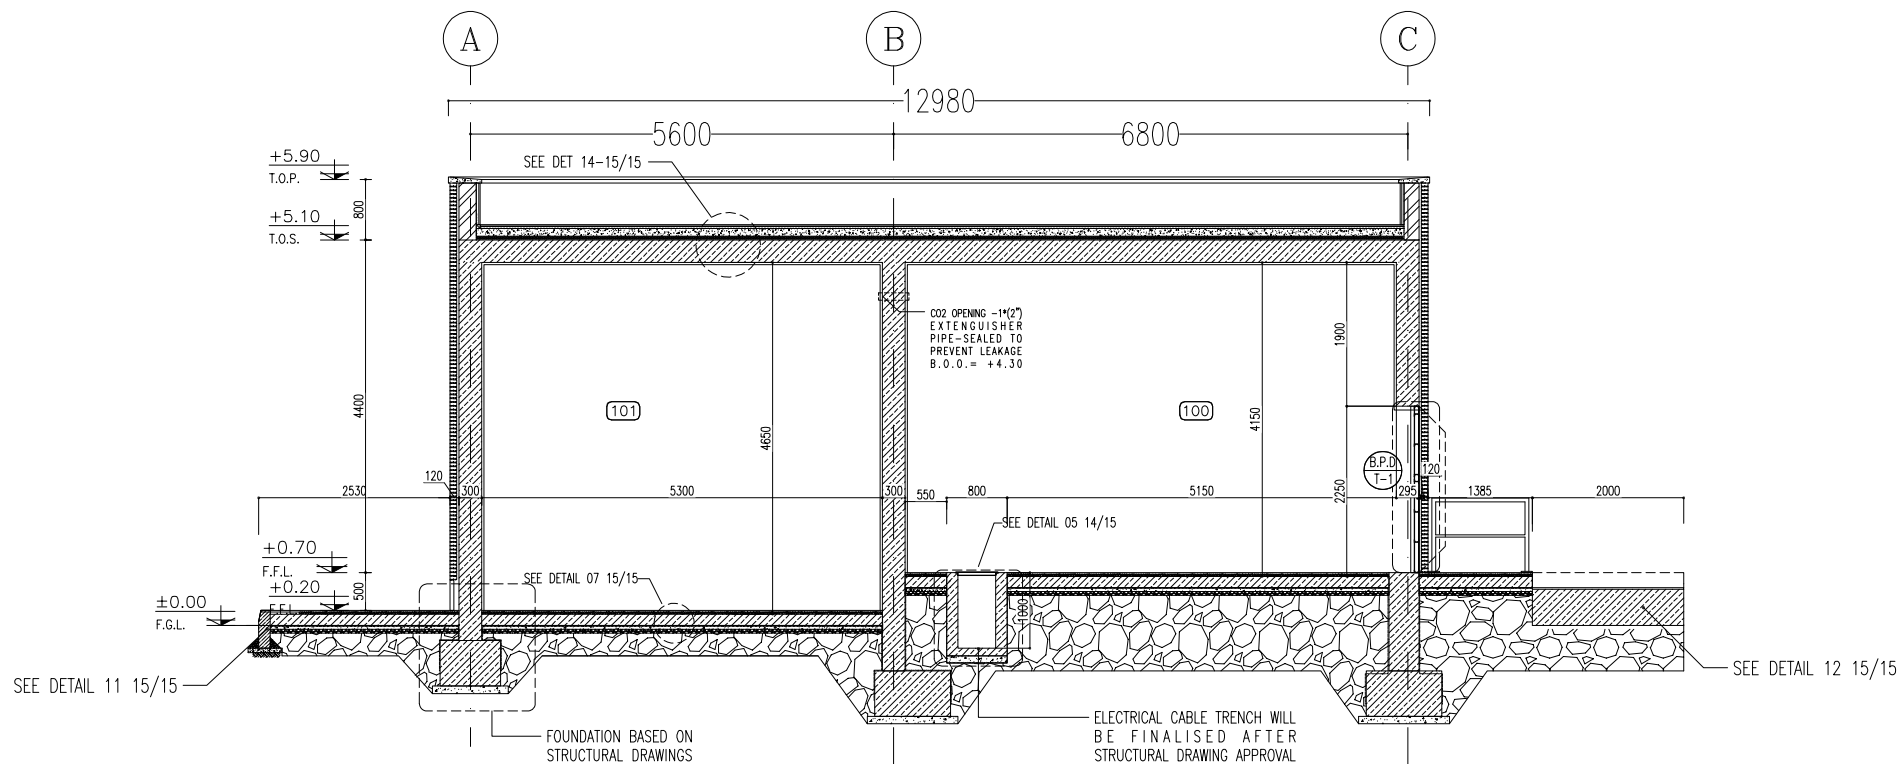

SECTION A

SC.1:50

04 OF 115

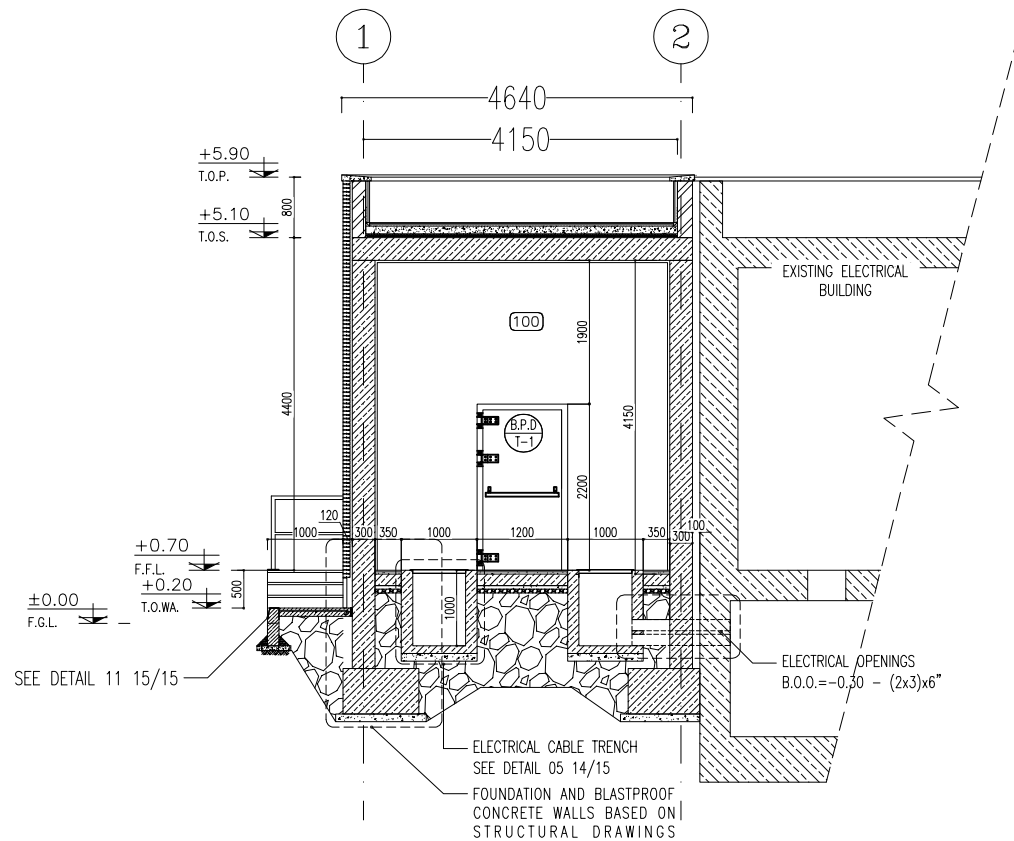

SECTION B


SC.1:50

04 OF 15

SPACE TAG NUMBER

- 100 CAPACITOR BANK
- 101 CO2 ROOM
- 102 TRANSFORMER ROOM
- 103 FIRE-FIGHTING PUMP TRANSFORMER ROOM
- 104 DIESEL ROOM

KEY PLAN

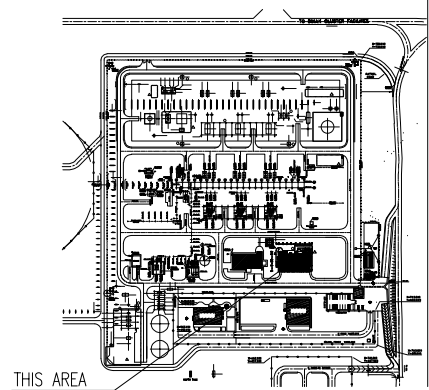

D07	MAR. 2024	APC	R.BERLOUIR	M.PAKHARIAN	S.Parmarapour	** **
D06	NOV. 2023	APC	R.BERLOUIR	M.PAKHARIAN	S.Parmarapour	** **
D05	SEP. 2023	APC	R.BERLOUIR	M.PAKHARIAN	A.M.MOHSSENI	** **
D04	AUG. 2023	IPA	R.BERLOUIR	M.PAKHARIAN	A.M.MOHSSENI	** **
D03	MAY. 2023	IPA	R.BERLOUIR	M.PAKHARIAN	A.M.MOHSSENI	** **
D02	AUG. 2022	IPA	R.BERLOUIR	M.PAKHARIAN	M.MEHRSHAD	** **
D01	APR. 2022	IPA	R.BERLOUIR	M.PAKHARIAN	M.MEHRSHAD	** **
D00	JAN. 2022	IPC	R.BERLOUIR	M.PAKHARIAN	M.MEHRSHAD	** **
REV.	DATE	P.O.I.S	PREP.	CHK.	APP.	AUT.

PROJECT NAME: BINAK OILFIELD DEVELOPMENT/SURFACE FACILITIES GAS COMPRESSOR STATION

PROJECT NO.: 971020

EPC CONTRACTOR:	EPD/EPC CONTRACTOR (GC):
 HIRGAN ENERGY - DESIGN & INSPECTION COMPANIES	 PETROIRAN DEVELOPMENT COMPANY



DRAWING TITLE: ARCHITECTURAL DETAIL DRAWING FOR EXTENSION OF EXISTING ELECT. BUILDING SECTIONS

SCALE	SIZE	DRAWING NO.	SHEET NO.	REV.
AS SHOWN	A1	BK-GCS-PEDCO-120-AR-DW-0002	06 OF 15	D07

اخذ و کلیه نسخ این نقشه و حق اقتباس متعلق به شرکت ملی مناطق نفت خیز جنوب می باشد.

THE ORIGINAL AND ALL COPIES OF THIS DRAWING TOGETHER WITH THE COPYRIGHT THEREIN ARE THE SOLE PROPERTY OF N.I.S.O.C./ FIELDS

BINAK OILFIELD DEVELOPMENT SURFACE FACILITIES GAS COMPRESSOR STATION				
DATE	SCALE	DRAWING BY	CHECKED BY	PROJECT ENG.
NO CONSTRUCTION PERMITTED UNLESS DRAWING APPROVED				
APPROVED FOR CONSTRUCTION		BY:	DATE:	
BUDGET REF.	LOCATION	SIZE CLASS	SERIAL NO.	SHEET REVISION
AS SHOWN	A1	BK-GCS-PEDCO-120-AR-DW-0002	06 OF 15	D07

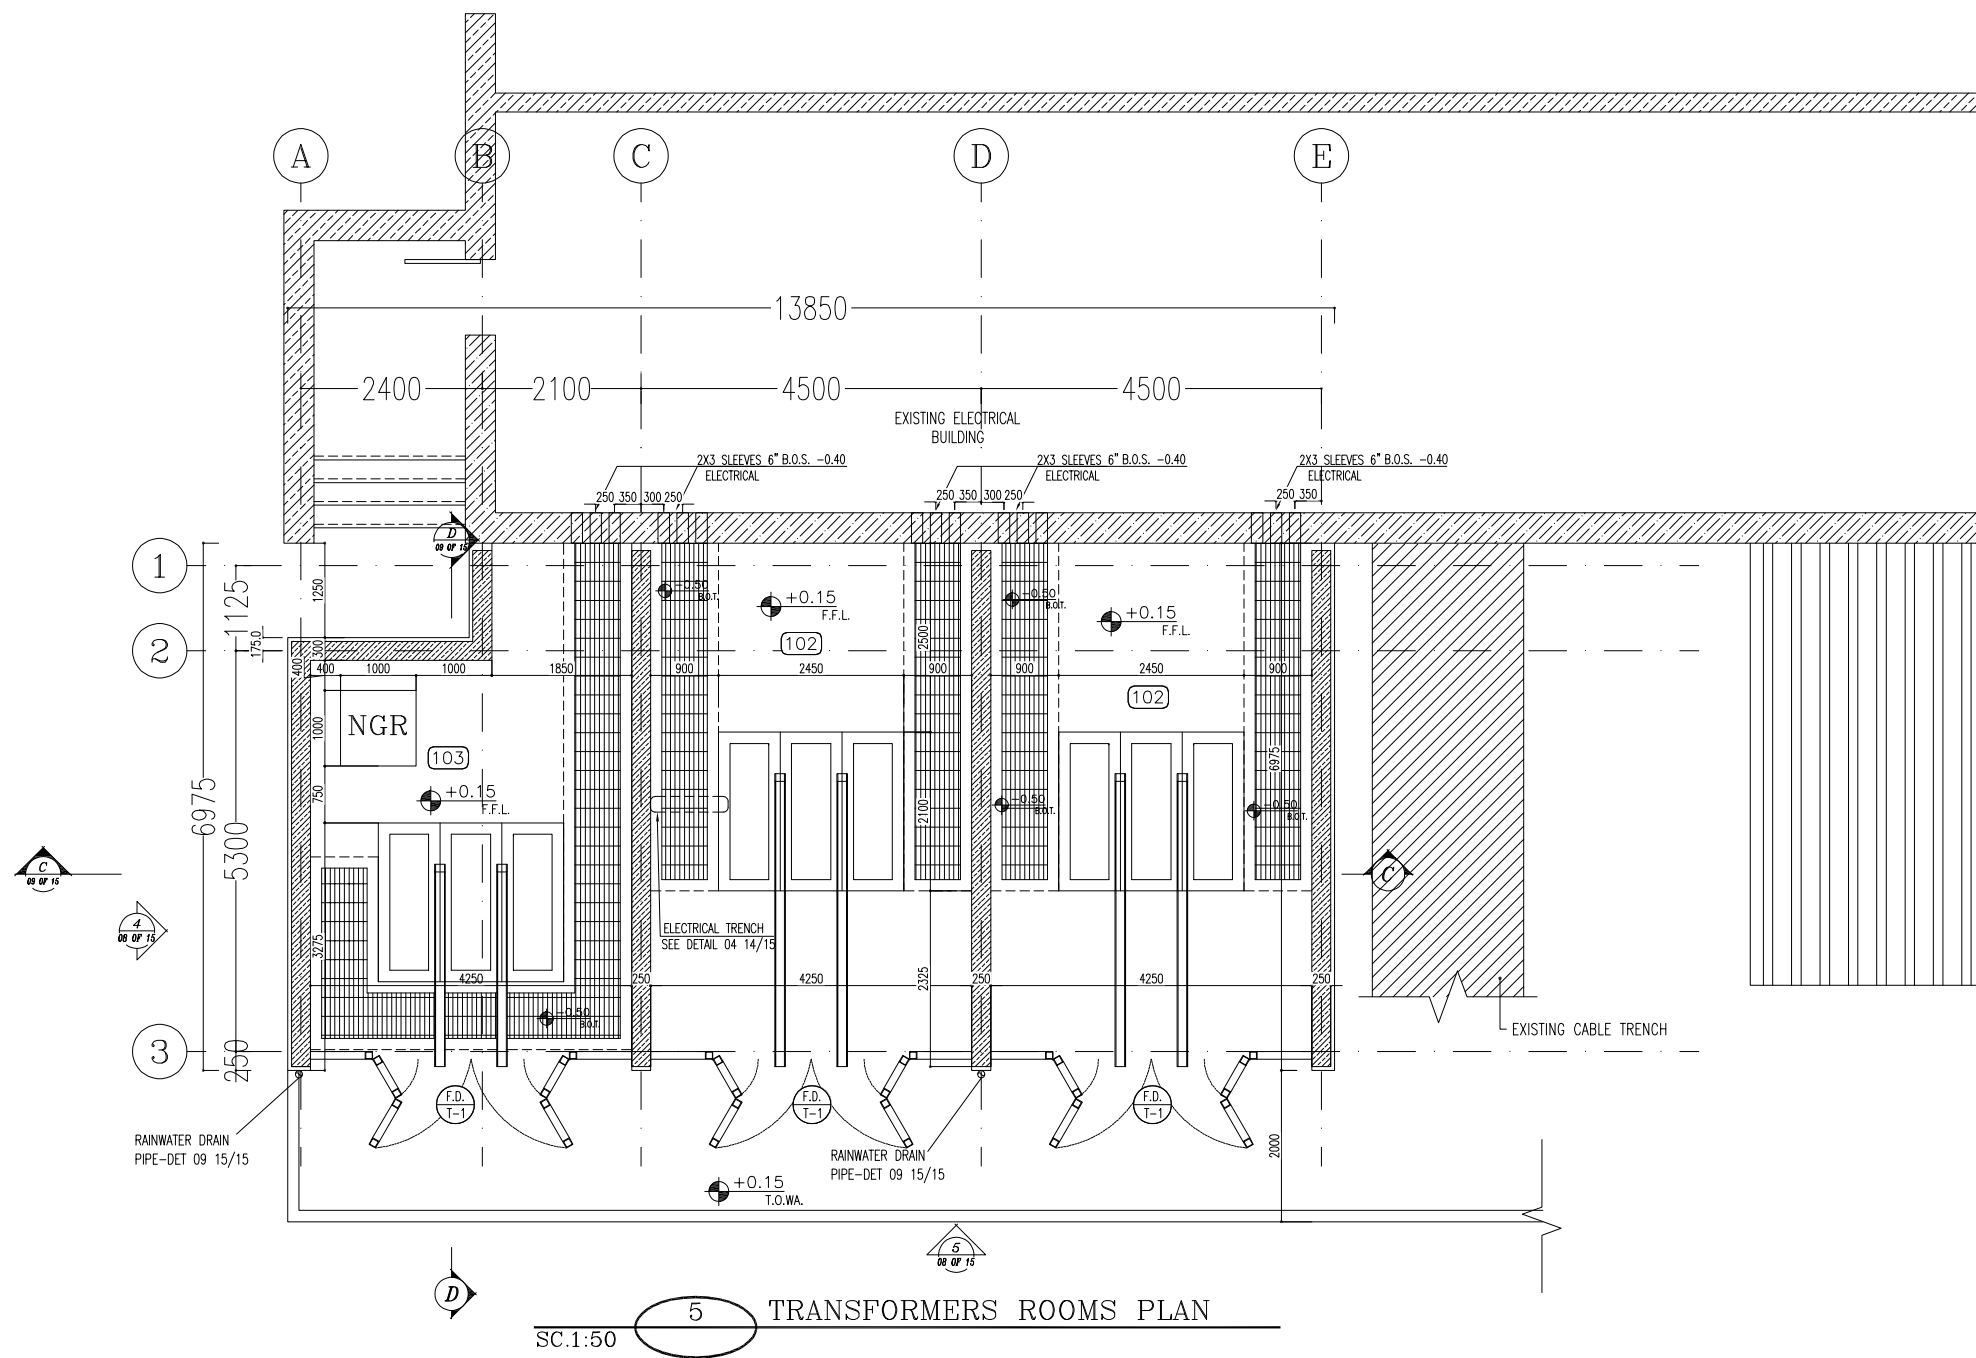 


SPACE TAG NUMBER

- 100 CAPACITOR BANK
- 101 CO2 ROOM
- 102 TRANSFORMER ROOM
- 103 FIRE-FIGHTING PUMP TRANSFORMER ROOM
- 104 DIESEL ROOM

- NOTES
1. ALL DIMENSIONS ARE IN CENTIMETER & ALL ELEVATIONS ARE IN METER.
 2. ALL DIMENSIONS AND ELEVATIONS SHALL BE CHECKED BY THE CONTRACTOR PRIOR TO CONSTRUCTION.
 3. CONTRACTOR SHALL COMPARE ALL ARCHITECTURAL, MECHANICAL, ELECTRICAL, PIPING AND STRUCTURAL DRAWINGS AND IN CASE OF ANY CONFLICTS OR DISCREPANCY, INFORM THE ENGINEER.
 4. ALL MATERIALS ARE SELECTED FROM THE HIGHEST QUALITY AND MUST BE APPROVED BY THE CLIENT.
 5. ALL OPENINGS FOR PIPING/CABLING AND HVAC OPENINGS SHALL BE CONSIDERED AS PER RELATED DRAWINGS BEFORE CONSTRUCTION.
 6. ARCHITECTURAL DETAIL DESIGN WILL BE REVISED BASED ON APPROVED STRUCTURAL DRAWINGS.
 7. ELEVATION CODE : LOCAL ±0.0m CORRESPONDS TO GLOBAL +11.10m

- LEGEND
- | | |
|-------------------------------------|--|
| LEAN CONCRETE | |
| REINFORCED CONCRETE | |
| PRESSED BRICK | |
| STONE | |
| EXPANSION JOINT FILLER (PLASTOFOAM) | |
| TERRAZZO TILES FOR ROOF - 30x30cm | |
| BLOCKAGE | |
- | | | | |
|----------|-------------------|--------|-------------------------|
| F.F.L. | FINISHED FLOOR | B.O.P. | BOTTOM OF PIT |
| T.O.WA | TOP OF WALKWAY | F.G.L. | FINISH GRADING LEVEL |
| T.O.P. | TOP OF PARAPET | T.O.T. | TOP OF TRENCH |
| T.O.FOU. | TOP OF FOUNDATION | C.O.S. | CENTER OF SLEEVE |
| M.D | METAL DOOR | B.O.S. | BOTTOM OF SLEEVE |
| T.O.R. | TOP OF ROOF | B.O.O. | BOTTOM OF OPENING |
| T.O.D. | TOP OF DOOR | B.O.T. | BOTTOM OF TRENCH |
| B.O.Cg. | BOTTOM OF CAGE | B.O.P. | BOTTOM OF PIT |
| T.O.Cg. | TOP OF CAGE | R.H.P. | ROOF HIGHEST POINT |
| B.O.G. | BOTTOM OF GUTTER | R.L.P. | ROOF LOWEST POINT |
| T.O.Cg. | TOP OF CAGE | N.G.R. | NEUTRAL GROUND RESISTOR |
| M.D. | METAL DOOR | B.P.D. | BLAST-PROOF DOOR |
| T.O.S. | TOP OF SLAB | F.D. | FENCE DOOR |



REFERENCE DRAWING	DRG. No.
STANDARD DRAWING FOR ARCHITECTURAL DETAILS	BK-GNRL-PEDCO-000-AR-DW-0001
SITE SEWAGE SYSTEM LAYOUT & DETAILS	BK-GCS-PEDCO-120-CV-PY-0001
CABLE TRENCH AND DUCT BANK LAYOUT	BK-GCS-PEDCO-120-CV-PY-0002
ELECTRICAL CABLE ROUTE & SECTION LAYOUT FOR BUILDING & SHED	BK-GCS-PEDCO-120-EL-PY-0006
FOUNDATION DRAWING FOR EXTENSION OF EXISTING ELECT. BUILDING	BK-GCS-PEDCO-120-ST-DW-0003
STRUCTURAL DRAWING FOR EXTENSION OF EXISTING ELECT. BUILDING	BK-GCS-PEDCO-120-ST-DW-0004
STANDARD DETAILS FOR LADDER & SAFETY CAGE	BK-GNRL-PEDCO-000-ST-DW-0009
ELECTRICAL EQUIPMENT ARRANGEMENT LAYOUT FOR BUILDING	BK-GCS-PEDCO-120-ST-BL-PY-0008
UNIT PLOT PLAN DRAWING	BK-GCS-PEDCO-120-PI-PY-0001

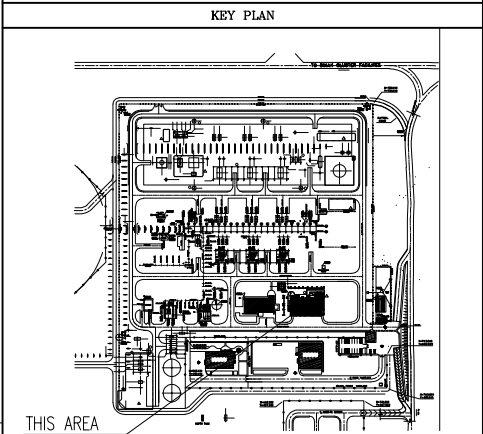

D07	MAR. 2024	APC	R.BERLOUIR	M.PAKHARIAN	S.Paramaragpour	** **
D06	NOV. 2023	APC	R.BERLOUIR	M.PAKHARIAN	S.Paramaragpour	** **
D05	SEP. 2023	APC	R.BERLOUIR	M.PAKHARIAN	A.M.MOHSSENI	** **
D04	AUG. 2023	IPA	R.BERLOUIR	M.PAKHARIAN	A.M.MOHSSENI	** **
D03	MAY. 2023	IPA	R.BERLOUIR	M.PAKHARIAN	A.M.MOHSSENI	** **
D02	AUG. 2022	IPA	R.BERLOUIR	M.PAKHARIAN	M.MEHRSHAD	** **
D01	APR. 2022	IPA	R.BERLOUIR	M.PAKHARIAN	M.MEHRSHAD	** **
D00	JAN. 2022	IPC	R.BERLOUIR	M.PAKHARIAN	M.MEHRSHAD	** **

REV.	DATE	P.O.I.S	PREP.	CHK.	APP.	AUT.
REV.	DESCRIPTION	BY	DATE	BY	DATE	REV. APPR.

PROJECT NAME: BINAK OILFIELD DEVELOPMENT/SURFACE FACILITIES GAS COMPRESSOR STATION					
PROJECT NO.:		971020			
EPC CONTRACTOR:		EPD/EPC CONTRACTOR (GC):			
 HIRGAN ENERGY - DESIGN & INSPECTION COMPANIES		 PEDCO		 PETROIRAN DEVELOPMENT COMPANY	
DRAWING TITLE: ARCHITECTURAL DETAIL DRAWING FOR EXTENSION OF EXISTING ELECT. BUILDING PLAN					
SCALE	SIZE	DRAWING NO.		SHEET NO.	REV.
AS SHOWN	A1	BK-GCS-PEDCO-120-AR-DW-0002		07 OF 15	D07

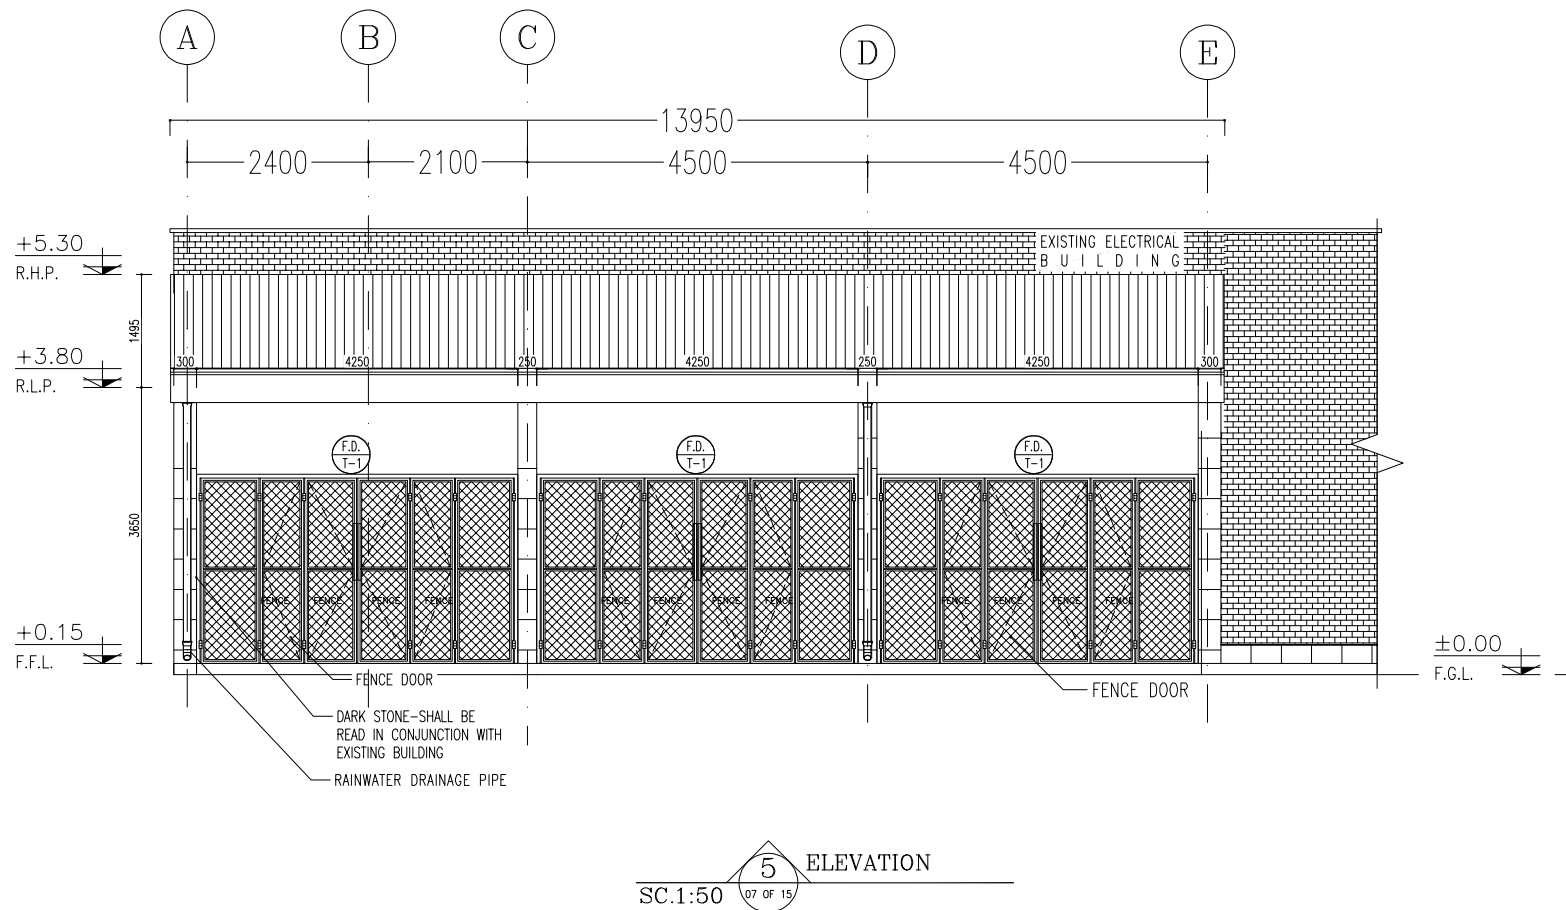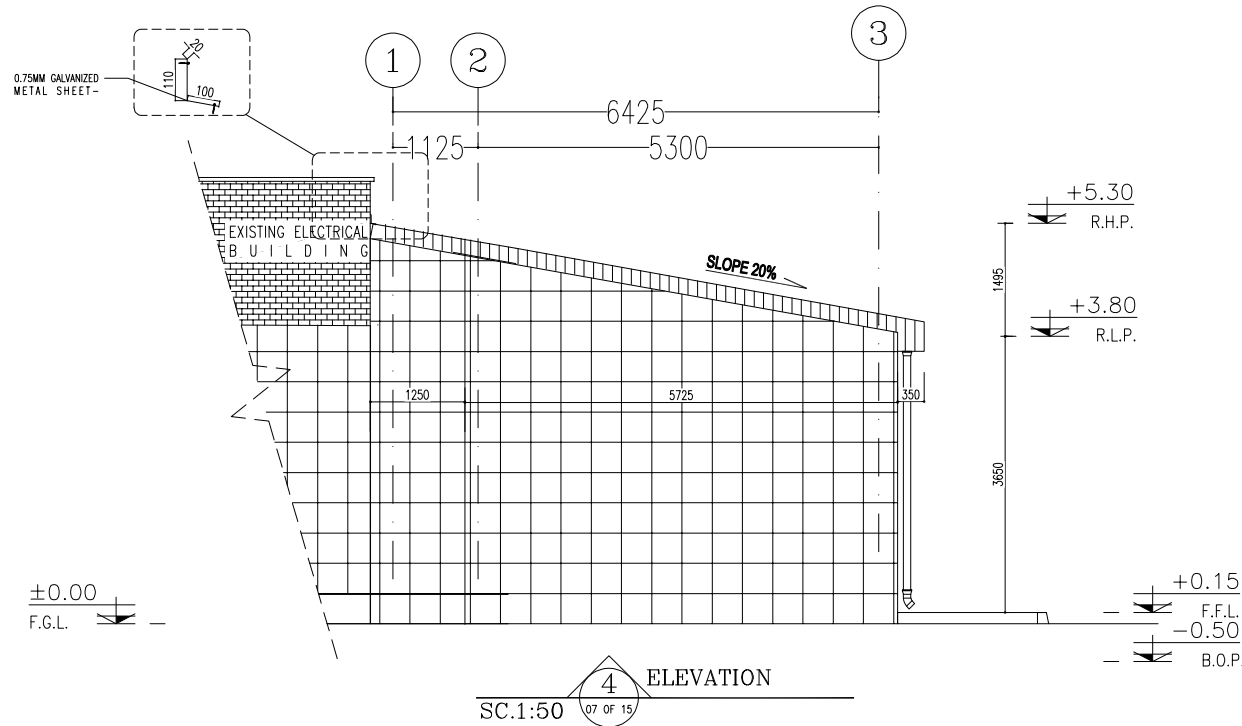


SPACE TAG NUMBER



- 100 CAPACITOR BANK
- 101 CO2 ROOM
- 102 TRANSFORMER ROOM
- 103 FIRE-FIGHTING PUMP TRANSFORMER ROOM
- 104 DIESEL ROOM

NOTES			
1. ALL DIMENSIONS ARE IN CENTIMETER & ALL ELEVATIONS ARE IN METER.			
2. ALL DIMENSIONS AND ELEVATIONS SHALL BE CHECKED BY THE CONTRACTOR PRIOR TO CONSTRUCTION.			
3. CONTRACTOR SHALL COMPARE ALL ARCHITECTURAL, MECHANICAL, ELECTRICAL, PIPING AND STRUCTURAL DRAWINGS AND IN CASE OF ANY CONFLICTS OR DISCREPANCY, INFORM THE ENGINEER.			
4. ALL MATERIALS ARE SELECTED FROM THE HIGHEST QUALITY AND MUST BE APPROVED BY THE CLIENT.			
5. ALL OPENINGS FOR PIPING/CABLING AND HVAC OPENINGS SHALL BE CONSIDERED AS PER RELATED DRAWINGS BEFORE CONSTRUCTION.			
6. ARCHITECTURAL DETAIL DESIGN WILL BE REVISED BASED ON APPROVED STRUCTURAL DRAWINGS.			
7. ELEVATION CODE : LOCAL ±0.0m CORRESPONDS TO GLOBAL +11.10m			
LEGEND			
LEAN CONCRETE			
REINFORCED CONCRETE			
PRESSED BRICK			
STONE			
EXPANSION JOINT FILLER (PLASTOFOAM)			
TERRAZZO TILES FOR ROOF - 30x30cm			
BLOCKAGE			
F.F.L.	FINISHED FLOOR	B.O.P.	BOTTOM OF PIT
T.O.WA	TOP OF WALKWAY	F.G.L.	FINISH GRADING LEVEL
T.O.P.	TOP OF PARAPET	T.O.T.	TOP OF TRENCH
T.O.FOU.	TOP OF FOUNDATION	C.O.S.	CENTER OF SLEEVE
M.D	METAL DOOR	B.O.S.	BOTTOM OF SLEEVE
T.O.R.	TOP OF ROOF	B.O.O.	BOTTOM OF OPENING
T.O.D.	TOP OF DOOR	B.O.T.	BOTTOM OF TRENCH
B.O.Co.	BOTTOM OF CAGE	B.O.P.	BOTTOM OF PIT
T.O.Co.	TOP OF CAGE	R.H.P.	ROOF HIGHEST POINT
B.O.G.	BOTTOM OF GUTTER	R.L.P.	ROOF LOWEST POINT
T.O.Co.	TOP OF CAGE	N.G.R.	NEUTRAL GROUND RESISTOR
M.D.	METAL DOOR	B.P.D.	BLAST-PROOF DOOR
T.O.S.	TOP OF SLAB	F.D.	FENCE DOOR

REFERENCE DRAWING	DRG. No.
STANDARD DRAWING FOR ARCHITECTURAL DETAILS	BK-GNRL-PEDCO-000-AR-DW-0001
SITE SEWAGE SYSTEM LAYOUT & DETAILS	BK-GCS-PEDCO-120-CV-PY-0001
CABLE TRENCH AND DUCT BANK LAYOUT	BK-GCS-PEDCO-120-CV-PY-0002
ELECTRICAL CABLE ROUTE & SECTION LAYOUT FOR BUILDING & SHELTER	BK-GCS-PEDCO-120-EL-PY-0006
FOUNDATION DRAWING FOR EXTENSION OF EXISTING ELECT. BUILDING	BK-GCS-PEDCO-120-ST-DW-0003
STRUCTURAL DRAWING FOR EXTENSION OF EXISTING ELECT. BUILDING	BK-GCS-PEDCO-120-ST-DW-0004
STANDARD DETAILS FOR LADDER & SAFETY CAGE	BK-GNRL-PEDCO-000-ST-DW-0009
ELECTRICAL EQUIPMENT ARRANGEMENT LAYOUT FOR BUILDING	BK-GCS-PEDCO-120-ST-BE-PY-0008
UNIT FLOOR PLAN DRAWING	BK-GCS-PEDCO-120-PI-PY-0001

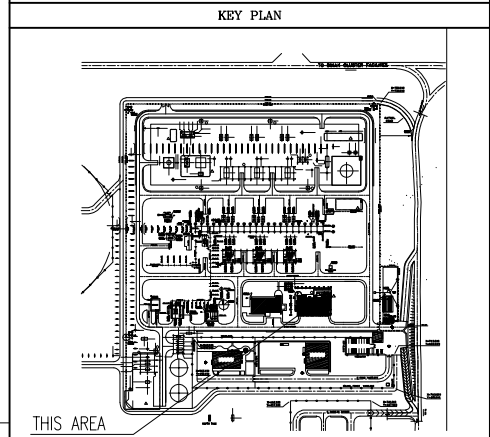

D07	MAR. 2024	APC	R.BERLOUBE	M.PAKHARIAN	S.Parmaragpour	** **	THIS AREA				[REDACTED]								
D06	NOV. 2023	APC	R.BERLOUBE	M.PAKHARIAN	S.Parmaragpour	** **													
D05	SEP. 2023	APC	R.BERLOUBE	M.PAKHARIAN	A.M.MOHSSENI	** **													
D04	AUG. 2023	IPA	R.BERLOUBE	M.PAKHARIAN	A.M.MOHSSENI	** **													
D03	MAY. 2023	IPA	R.BERLOUBE	M.PAKHARIAN	A.M.MOHSSENI	** **													
D02	AUG. 2022	IPA	R.BERLOUBE	M.PAKHARIAN	M.MEHRSHAD	** **	***	*****	** **	*** ****	** **	*** ****							
D01	APR. 2022	IPA	R.BERLOUBE	M.PAKHARIAN	M.MEHRSHAD	** **	REV.	DESCRIPTION	BY	DATE	BY	DATE							
D00	JAN. 2022	IPC	R.BERLOUBE	M.PAKHARIAN	M.MEHRSHAD	** **			CHECKED		REV. APPR.								
REV.		DATE	P.O.I.S	PREP.	CHK.	APP.	AUT.								اصل و کلیه نسخ این نقشه و حق امتیاز متعلق به شرکت ملی مناطق نفت خیز جنوب می باشد.				
PROJECT NAME:		BINAK OILFIELD DEVELOPMENT/SURFACE FACILITIES GAS COMPRESSOR STATION													 THE ORIGINAL AND ALL COPIES OF THIS DRAWING TOGETHER WITH THE COPYRIGHT THEREIN ARE THE SOLE PROPERTY OF N.I.S.O.C./ FIELDS				
PROJECT NO.:		971020																	
EPC CONTRACTOR:			EPD/EPC CONTRACTOR (GC):													BINAK OILFIELD DEVELOPMENT SURFACE FACILITIES GAS COMPRESSOR STATION			
																			
HIRGAN ENERGY - DESIGN & INSPECTION COMPANIES			PEDCO																
DRAWING TITLE:		ARCHITECTURAL DETAIL DRAWING FOR EXTENSION OF EXISTING ELECT. BUILDING ELEVATIONS													NO CONSTRUCTION PERMITTED UNLESS DRAWING APPROVED				
SCALE		SIZE	DRAWING NO.			SHEET NO.	REV.	APPROVED FOR CONSTRUCTION			BY:		DATE:						
AS SHOWN		A1	BK-GCS-PEDCO-120-AR-DW-0002			08 OF 15	D07	563-073-9184			F	4	B	709100	08 OF 15	D07			
SIZE		CLASS			SERIAL NO.		SHEET		REVISION										
B																			

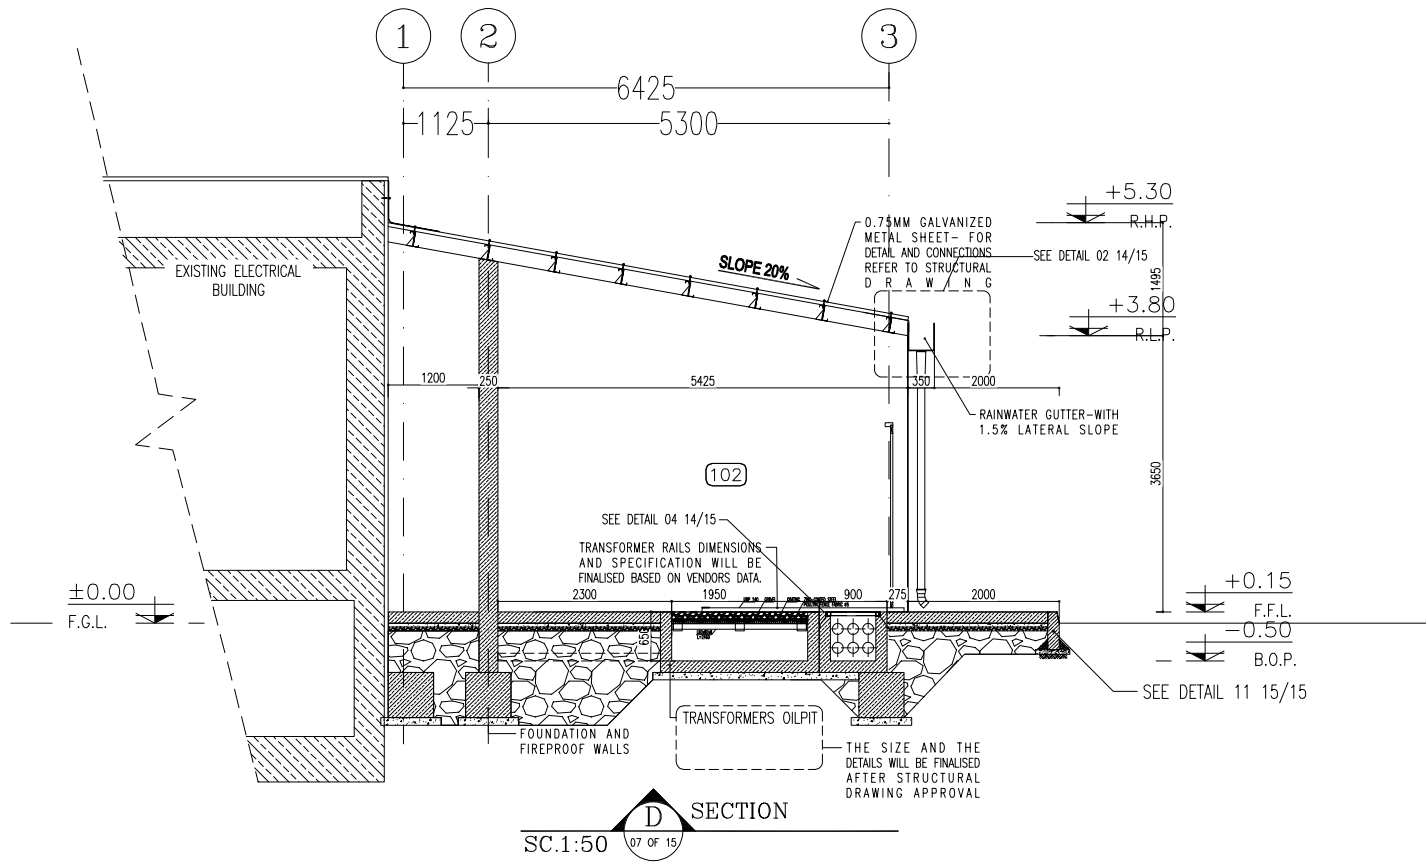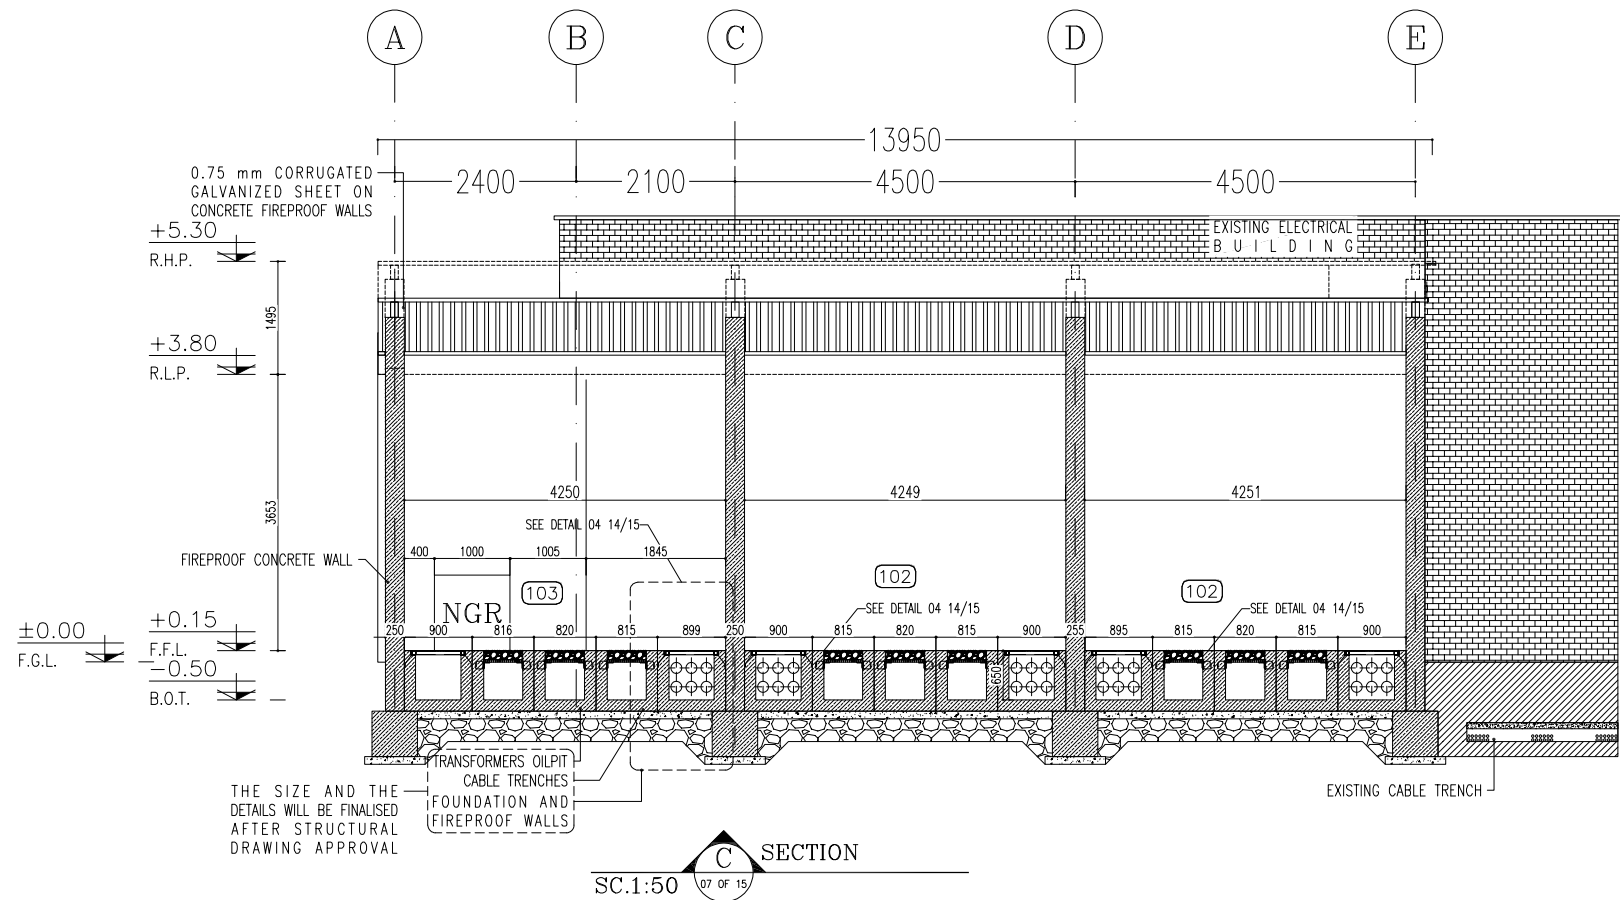


SPACE TAG NUMBER

- (100) CAPACITOR BANK
- (101) CO2 ROOM
- (102) TRANSFORMER ROOM
- (103) FIRE-FIGHTING PUMP TRANSFORMER ROOM
- (104) DIESEL ROOM



NOTES			
1. ALL DIMENSIONS ARE IN CENTIMETER & ALL ELEVATIONS ARE IN METER.			
2. ALL DIMENSIONS AND ELEVATIONS SHALL BE CHECKED BY THE CONTRACTOR PRIOR TO CONSTRUCTION.			
3. CONTRACTOR SHALL COMPARE ALL ARCHITECTURAL, MECHANICAL, ELECTRICAL, PIPING AND STRUCTURAL DRAWINGS AND IN CASE OF ANY CONFLICTS OR DISCREPANCY, INFORM THE ENGINEER.			
4. ALL MATERIALS ARE SELECTED FROM THE HIGHEST QUALITY AND MUST BE APPROVED BY THE CLIENT.			
5. ALL OPENINGS FOR PIPING/CABLING AND HVAC OPENINGS SHALL BE CONSIDERED AS PER RELATED DRAWINGS BEFORE CONSTRUCTION.			
6. ARCHITECTURAL DETAIL DESIGN WILL BE REVISED BASED ON APPROVED STRUCTURAL DRAWINGS.			
7. ELEVATION CODE : LOCAL ±0.0m CORRESPONDS TO GLOBAL +11.10m			
LEGEND			
LEAN CONCRETE			
REINFORCED CONCRETE			
PRESSED BRICK			
STONE			
EXPANSION JOINT FILLER (PLASTOFOAM)			
TERRAZZO TILES FOR ROOF - 30x30cm			
BLOCKAGE			
F.F.L.	FINISHED FLOOR	B.O.P.	BOTTOM OF PIT
T.O.WA	TOP OF WALKWAY	F.G.L.	FINISH GRADING LEVEL
T.O.P.	TOP OF PARAPET	T.O.T.	TOP OF TRENCH
T.O.FOU.	TOP OF FOUNDATION	C.O.S.	CENTER OF SLEEVE
M.D	METAL DOOR	B.O.S.	BOTTOM OF SLEEVE
T.O.R.	TOP OF ROOF	B.O.O.	BOTTOM OF OPENING
T.O.D.	TOP OF DOOR	B.O.T.	BOTTOM OF TRENCH
B.O.Cg.	BOTTOM OF CAGE	B.O.P.	BOTTOM OF PIT
T.O.Cg.	TOP OF CAGE	R.H.P.	ROOF HIGHEST POINT
B.O.G.	BOTTOM OF GUTTER	R.L.P.	ROOF LOWEST POINT
T.O.Cg.	TOP OF CAGE	N.G.R.	NEUTRAL GROUND RESISTOR
M.D.	METAL DOOR	B.P.D.	BLAST-PROOF DOOR
T.O.S.	TOP OF SLAB	F.D.	FENCE DOOR

REFERENCE DRAWING	DRG. No.
STANDARD DRAWING FOR ARCHITECTURAL DETAILS	BK-GNRL-PEDCO-000-AR-DW-0001
SITE SEWAGE SYSTEM LAYOUT & DETAILS	BK-GCS-PEDCO-120-CV-PY-0001
CABLE TRENCH AND DUCT BANK LAYOUT	BK-GCS-PEDCO-120-CV-PY-0002
ELECTRICAL CABLE ROUTE & SECTION LAYOUT FOR BUILDING & SHED	BK-GCS-PEDCO-120-EL-PY-0006
FOUNDATION DRAWING FOR EXTENSION OF EXISTING ELECT. BUILDING	BK-GCS-PEDCO-120-ST-DW-0003
STRUCTURAL DRAWING FOR EXTENSION OF EXISTING ELECT. BUILDING	BK-GCS-PEDCO-120-ST-DW-0004
STANDARD DETAILS FOR LADDER & SAFETY CAGE	BK-GNRL-PEDCO-000-ST-DW-0009
ELECTRICAL EQUIPMENT ARRANGEMENT LAYOUT FOR BUILDING	BK-GCS-PEDCO-120-ST-BL-PY-0008
UNIT LAYOUT PLAN DRAWING	BK-GCS-PEDCO-120-PI-PY-0001

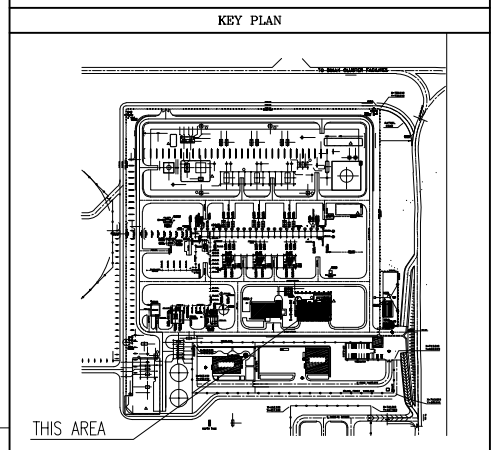


D07	MAR.2024	APC	R.BERLOUBE	M.PAKHARIAN	S.Parmarapour	** **
D06	NOV.2023	APC	R.BERLOUBE	M.PAKHARIAN	S.Parmarapour	** **
D05	SEP.2023	APC	R.BERLOUBE	M.PAKHARIAN	A.M.MOHSSENI	** **
D04	AUG.2023	IPA	R.BERLOUBE	M.PAKHARIAN	A.M.MOHSSENI	** **
D03	MAY.2023	IPA	R.BERLOUBE	M.PAKHARIAN	A.M.MOHSSENI	** **
D02	AUG.2022	IPA	R.BERLOUBE	M.PAKHARIAN	M.MEHRSHAD	** **
D01	APR.2022	IPA	R.BERLOUBE	M.PAKHARIAN	M.MEHRSHAD	** **
D00	JAN.2022	IPC	R.BERLOUBE	M.PAKHARIAN	M.MEHRSHAD	** **
REV.	DATE	P.O.I.S	PREP.	CHK.	APP.	AUT.
PROJECT NAME: BINAK OILFIELD DEVELOPMENT/SURFACE FACILITIES GAS COMPRESSOR STATION						
PROJECT NO.: 971020						
EPC CONTRACTOR:			EPD/EPC CONTRACTOR (GC):			
  HIRGAN ENERGY - DESIGN & INSPECTION COMPANIES			 PETROIRAN DEVELOPMENT COMPANY			
DRAWING TITLE: ARCHITECTURAL DETAIL DRAWING FOR EXTENSION OF EXISTING ELECT. BUILDING SECTIONS						
SCALE	SIZE	DRAWING NO.			SHEET NO.	REV.
AS SHOWN	A1	BK-GCS-PEDCO-120-AR-DW-0002			09 OF 15	D07

																																																																																																																																																																																																																																																																																																																																																																																																																																																																																																																																																																																																																																																																																																																																																																																																																																																																																																																																																																																																																																																																																																																																																																																																																																																																																																																																																																																																																					</
--	--	----

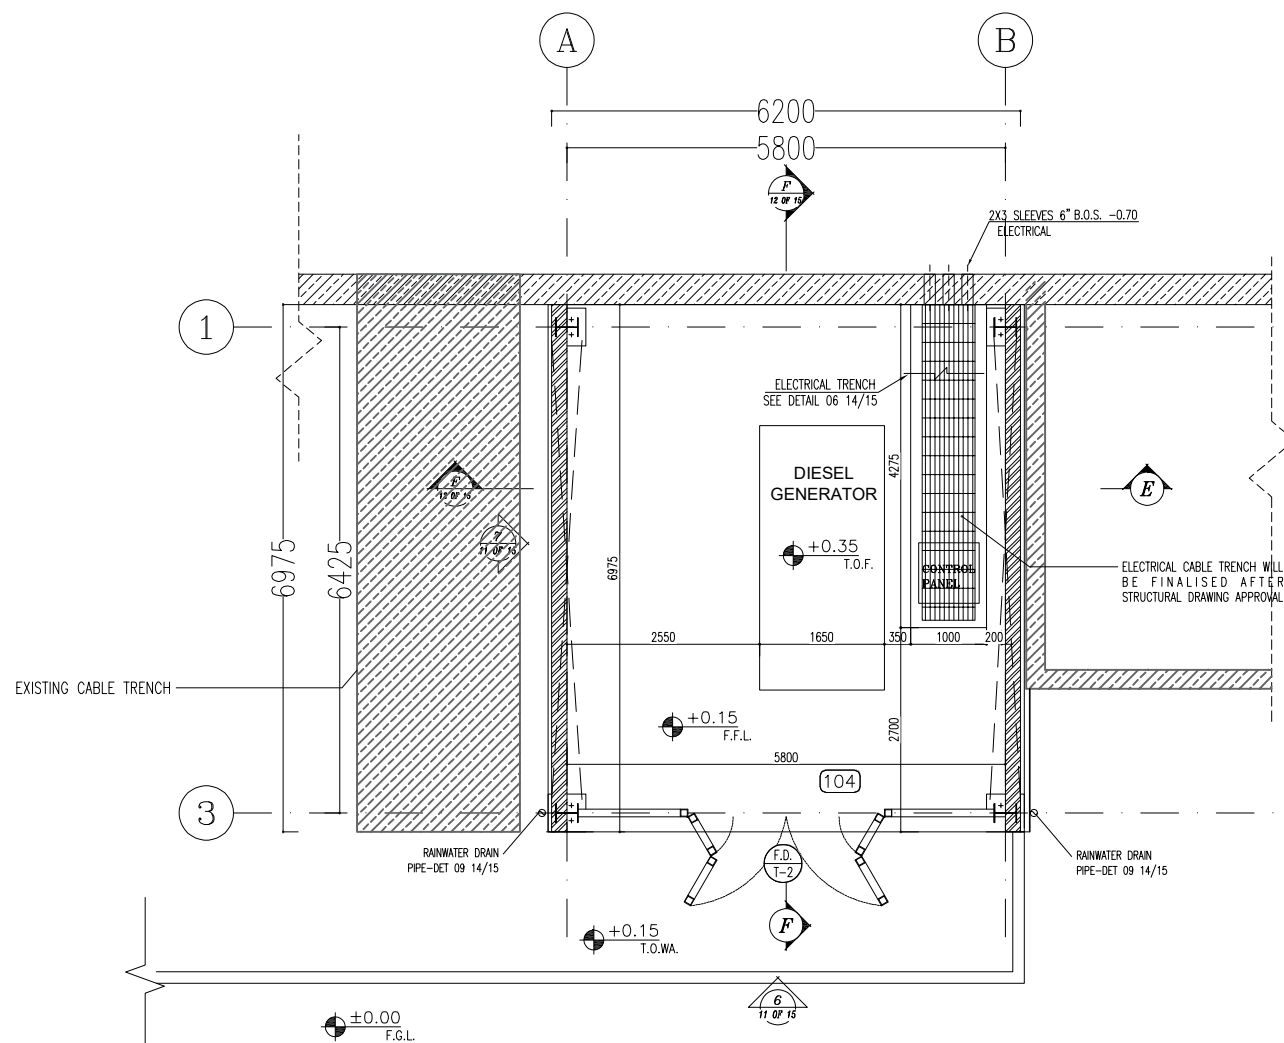 

SC.1:50 6 DIESEL ROOM PLAN

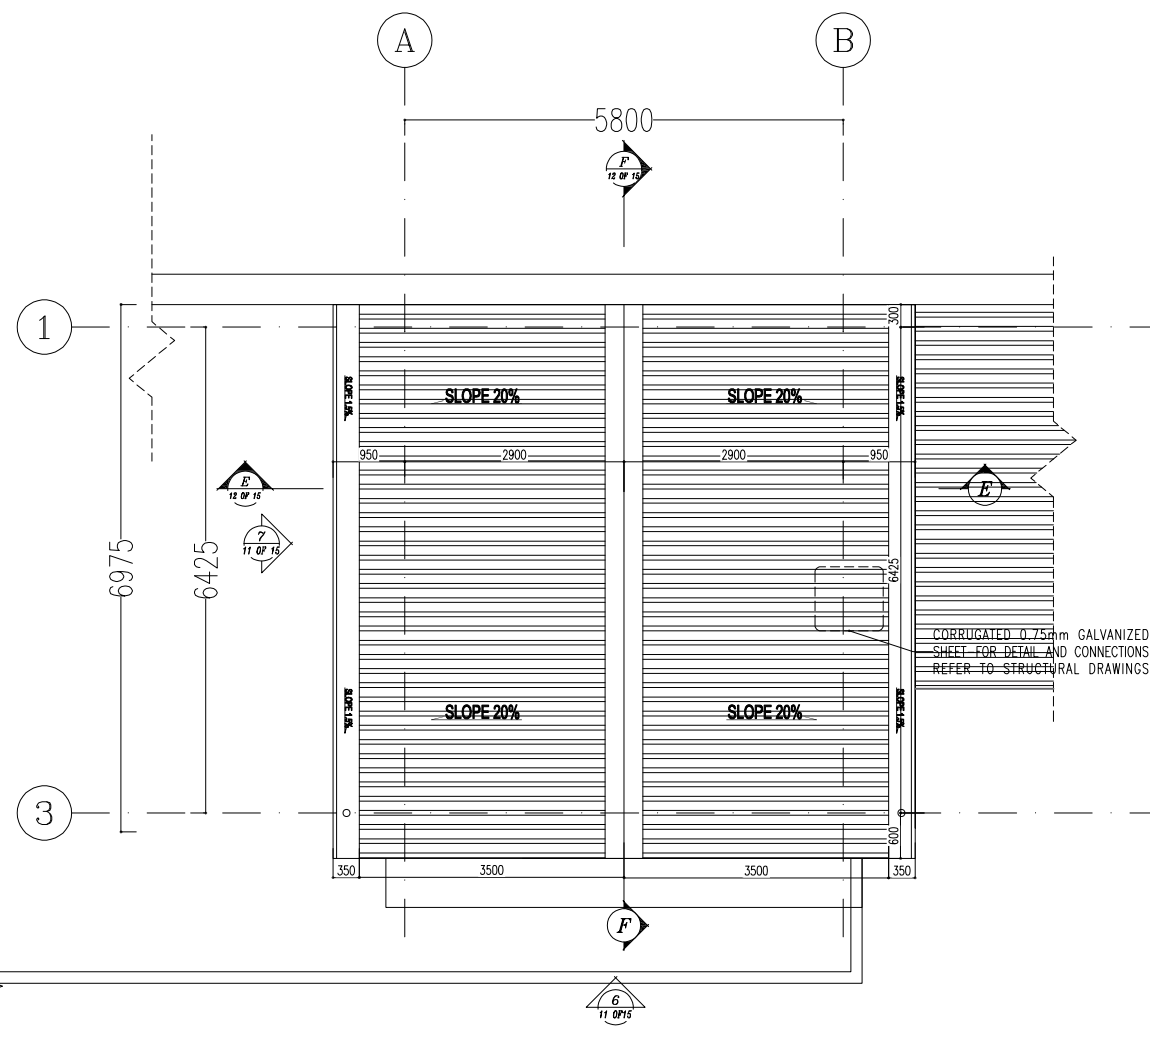


SC.1:50 7 DIESEL ROOM ROOF PLAN

- NOTES
1. ALL DIMENSIONS ARE IN CENTIMETER & ALL ELEVATIONS ARE IN METER.
 2. ALL DIMENSIONS AND ELEVATIONS SHALL BE CHECKED BY THE CONTRACTOR PRIOR TO CONSTRUCTION.
 3. CONTRACTOR SHALL COMPARE ALL ARCHITECTURAL, MECHANICAL, ELECTRICAL, PIPING AND STRUCTURAL DRAWINGS AND IN CASE OF ANY CONFLICTS OR DISCREPANCY, INFORM THE ENGINEER.
 4. ALL MATERIALS ARE SELECTED FROM THE HIGHEST QUALITY AND MUST BE APPROVED BY THE CLIENT.
 5. ALL OPENINGS FOR PIPING/CABLES AND HVAC OPENINGS SHALL BE CONSIDERED AS PER RELATED DRAWINGS BEFORE CONSTRUCTION.
 6. ARCHITECTURAL DETAIL DESIGN WILL BE REVISED BASED ON APPROVED STRUCTURAL DRAWINGS.
 7. ELEVATION CODE : LOCAL ±0.0m CORRESPONDS TO GLOBAL +11.10m

LEGEND			
LEAN CONCRETE			
REINFORCED CONCRETE			
PRESSED BRICK			
STONE			
EXPANSION JOINT FILLER (PLASTOFOAM)			
TERRAZZO TILES FOR ROOF - 30x30cm			
BLOCKAGE			
F.F.L.	FINISHED FLOOR	B.O.P.	BOTTOM OF PIT
T.O.WA	TOP OF WALKWAY	F.G.L.	FINISH GRADING LEVEL
T.O.P.	TOP OF PARAPET	T.O.T.	TOP OF TRENCH
T.O.FOU.	TOP OF FOUNDATION	C.O.S.	CENTER OF SLEEVE
M.D	METAL DOOR	B.O.S.	BOTTOM OF SLEEVE
T.O.R.	TOP OF ROOF	B.O.O.	BOTTOM OF OPENING
T.O.D.	TOP OF DOOR	B.O.T.	BOTTOM OF TRENCH
B.O.Cg.	BOTTOM OF CAGE	B.O.P.	BOTTOM OF PIT
T.O.Cg.	TOP OF CAGE	R.H.P.	ROOF HIGHEST POINT
B.O.G.	BOTTOM OF GUTTER	R.L.P.	ROOF LOWEST POINT
T.O.Cg.	TOP OF CAGE	N.G.R.	NEUTRAL GROUND RESISTOR
M.D.	METAL DOOR	B.P.D.	BLAST-PROOF DOOR
T.O.S.	TOP OF SLAB	F.D.	FENCE DOOR

REFERENCE DRAWING	DRG. No.
STANDARD DRAWING FOR ARCHITECTURAL DETAILS	BK-GNRL-PEDCO-000-AR-DW-0001
SITE SEWAGE SYSTEM LAYOUT & DETAILS	BK-GCS-PEDCO-120-CV-PY-0001
CABLE TRENCH AND DUCT BANK LAYOUT	BK-GCS-PEDCO-120-CV-PY-0002
ELECTRICAL CABLE ROUTE & SECTION LAYOUT FOR BUILDING & SHED	BK-GCS-PEDCO-120-EL-PY-0006
FOUNDATION DRAWING FOR EXTENSION OF EXISTING ELECT. BUILDING	BK-GCS-PEDCO-120-ST-DW-0003
STRUCTURAL DRAWING FOR EXTENSION OF EXISTING ELECT. BUILDING	BK-GCS-PEDCO-120-ST-DW-0004
STANDARD DETAILS FOR LADDER & SAFETY CAGE	BK-GNRL-PEDCO-000-ST-DW-0009
ELECTRICAL EQUIPMENT ARRANGEMENT LAYOUT FOR BUILDING	BK-GCS-PEDCO-120-ST-BE-PY-0008
UNIT FLOOR PLAN DRAWING	BK-GCS-PEDCO-120-PI-PY-0001

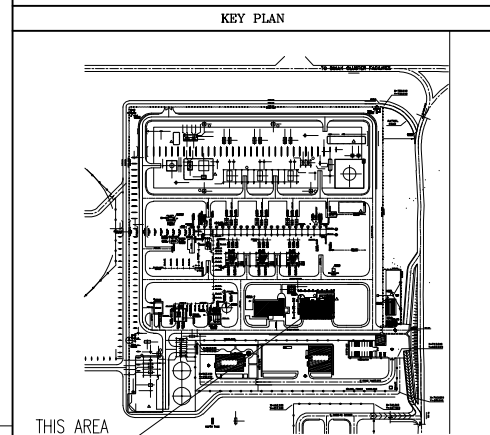



D07	MAR. 2024	APC	R.BERLOUB	M.PAKHARIAN	S.Parmarapour	** **
D06	NOV. 2023	APC	R.BERLOUB	M.PAKHARIAN	S.Parmarapour	** **
D05	SEP. 2023	APC	R.BERLOUB	M.PAKHARIAN	A.M.MOHSENI	** **
D04	AUG. 2023	IPA	R.BERLOUB	M.PAKHARIAN	A.M.MOHSENI	** **
D03	MAY. 2023	IPA	R.BERLOUB	M.PAKHARIAN	A.M.MOHSENI	** **
D02	AUG. 2022	IPA	R.BERLOUB	M.PAKHARIAN	M.MEHRSHAD	** **
D01	APR. 2022	IPA	R.BERLOUB	M.PAKHARIAN	M.MEHRSHAD	** **
D00	JAN. 2022	IPC	R.BERLOUB	M.PAKHARIAN	M.MEHRSHAD	** **

PROJECT NAME:		BINAK OILFIELD DEVELOPMENT/SURFACE FACILITIES GAS COMPRESSOR STATION	
PROJECT NO.:		971020	
EPC CONTRACTOR:		EPD/EPC CONTRACTOR (GC):	
 HIRGAN ENERGY - DESIGN & INSPECTION COMPANIES		 PETROIRAN DEVELOPMENT COMPANY	
DRAWING TITLE:		ARCHITECTURAL DETAIL DRAWING FOR EXTENSION OF EXISTING ELECT. BUILDING P L A N S	
SCALE	SIZE	DRAWING NO.	SHEET NO.
AS SHOWN	A1	BK-GCS-PEDCO-120-AR-DW-0002	10 OF 15

BINAK OILFIELD DEVELOPMENT SURFACE FACILITIES GAS COMPRESSOR STATION					
DATE	SCALE	DRAWING BY	CHECKED BY	PROJECT ENG.	
NO CONSTRUCTION PERMITTED UNLESS DRAWING APPROVED					
APPROVED FOR CONSTRUCTION			BY:	DATE:	
BUDGET REF.	LOCATION	SIZE CLASS	SERIAL NO.	SHEET	REVISION
AS SHOWN	A1	BK-GCS-PEDCO-120-AR-DW-0002	10 OF 15	D07	


SPACE TAG NUMBER

- 100 CAPACITOR BANK
- 101 CO2 ROOM
- 102 TRANSFORMER ROOM
- 103 FIRE-FIGHTING PUMP TRANSFORMER ROOM
- 104 DIESEL ROOM

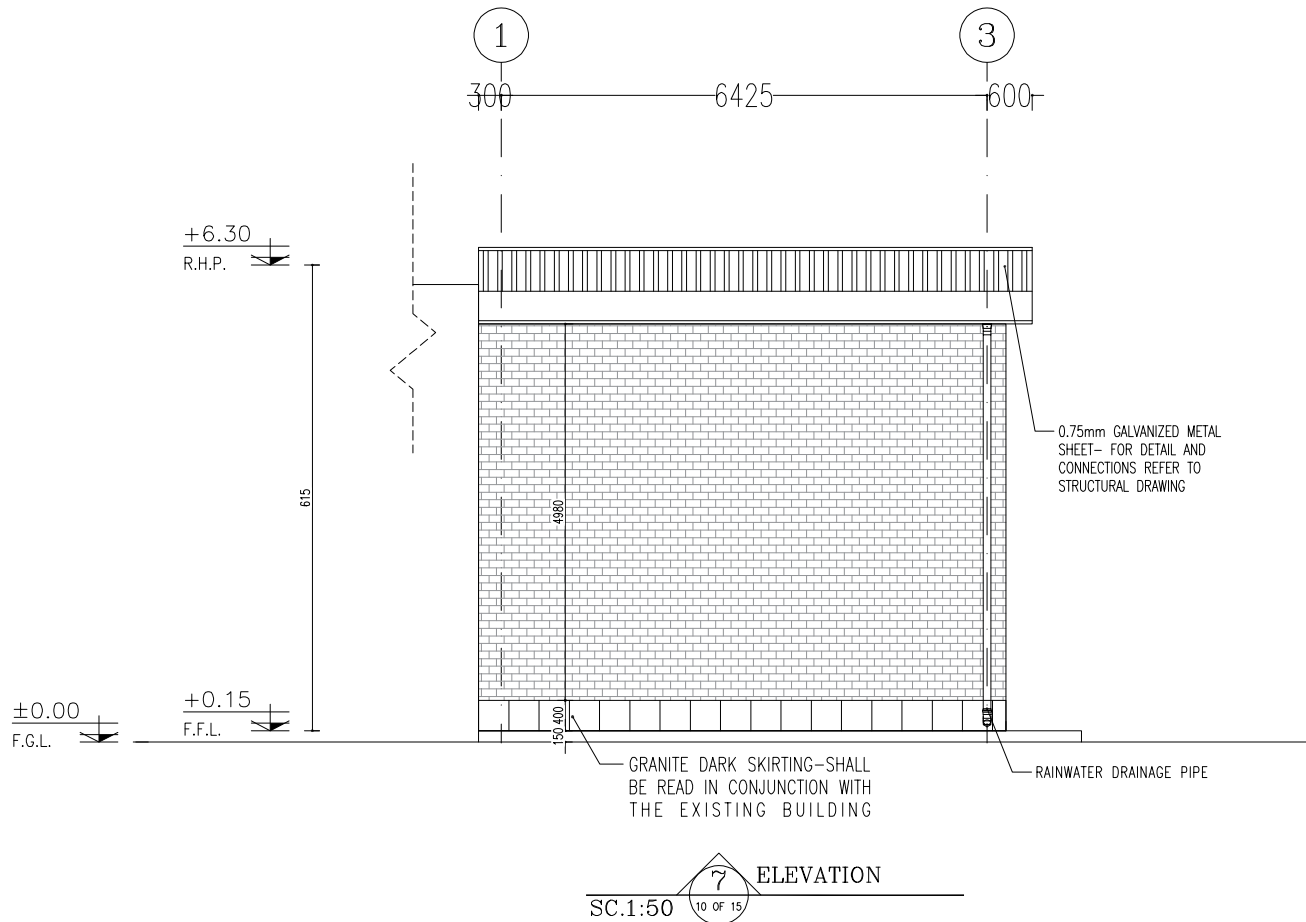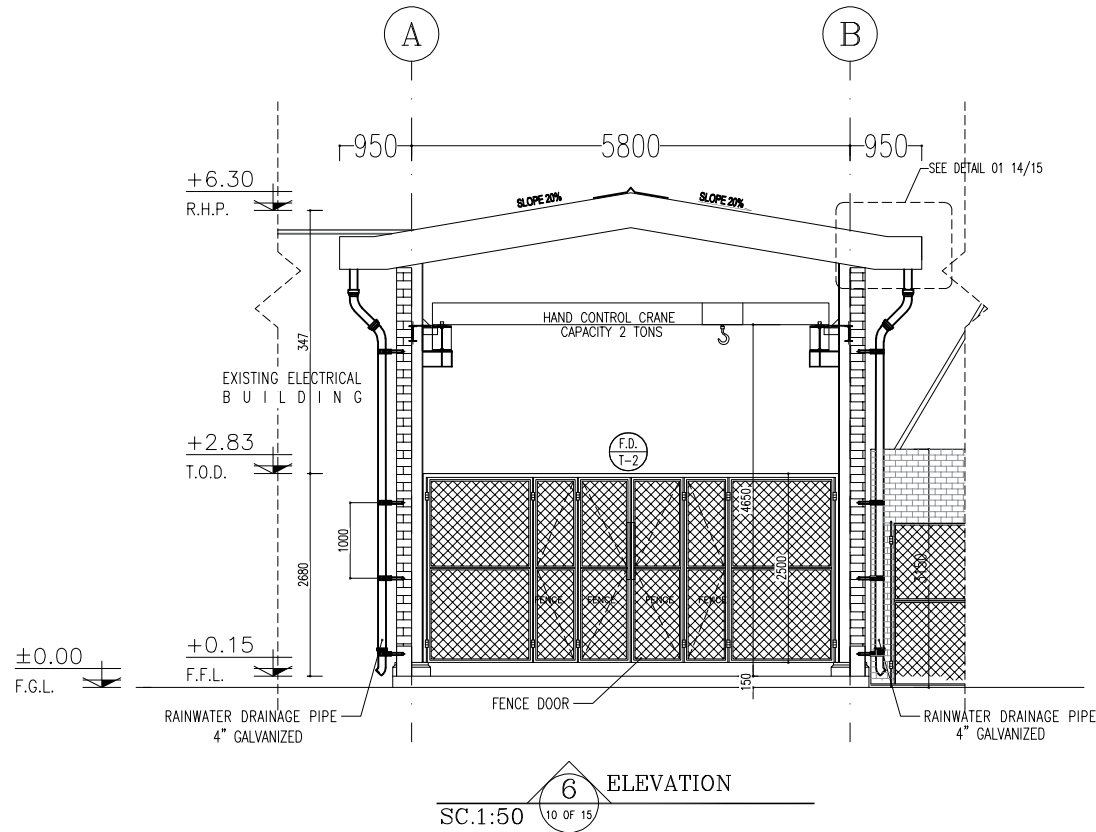

NOTES			
1. ALL DIMENSIONS ARE IN CENTIMETER & ALL ELEVATIONS ARE IN METER.			
2. ALL DIMENSIONS AND ELEVATIONS SHALL BE CHECKED BY THE CONTRACTOR PRIOR TO CONSTRUCTION.			
3. CONTRACTOR SHALL COMPARE ALL ARCHITECTURAL, MECHANICAL, ELECTRICAL, PIPING AND STRUCTURAL DRAWINGS AND IN CASE OF ANY CONFLICTS OR DISCREPANCY, INFORM THE ENGINEER.			
4. ALL MATERIALS ARE SELECTED FROM THE HIGHEST QUALITY AND MUST BE APPROVED BY THE CLIENT.			
5. ALL OPENINGS FOR PIPING/CABLING AND HVAC OPENINGS SHALL BE CONSIDERED AS PER RELATED DRAWINGS BEFORE CONSTRUCTION.			
6. ARCHITECTURAL DETAIL DESIGN WILL BE REVISED BASED ON APPROVED STRUCTURAL DRAWINGS.			
7. ELEVATION CODE : LOCAL ±0.0m CORRESPONDS TO GLOBAL +11.10m			
LEGEND			
LEAN CONCRETE			
REINFORCED CONCRETE			
PRESSED BRICK			
STONE			
EXPANSION JOINT FILLER (PLASTOFOAM)			
TERRAZZO TILES FOR ROOF - 30x30cm			
BLOCKAGE			
F.F.L.	FINISHED FLOOR	B.O.P.	BOTTOM OF PIT
T.O.WA	TOP OF WALKWAY	F.G.L.	FINISH GRADING LEVEL
T.O.P.	TOP OF PARAPET	T.O.T.	TOP OF TRENCH
T.O.FOU.	TOP OF FOUNDATION	C.O.S.	CENTER OF SLEEVE
M.D	METAL DOOR	B.O.S.	BOTTOM OF SLEEVE
T.O.R.	TOP OF ROOF	B.O.O.	BOTTOM OF OPENING
T.O.D.	TOP OF DOOR	B.O.T.	BOTTOM OF TRENCH
B.O.Co.	BOTTOM OF CAGE	B.O.P.	BOTTOM OF PIT
T.O.Co.	TOP OF CAGE	R.H.P.	ROOF HIGHEST POINT
B.O.G.	BOTTOM OF GUTTER	R.L.P.	ROOF LOWEST POINT
T.O.Co.	TOP OF CAGE	N.G.R.	NEUTRAL GROUND RESISTOR
M.D.	METAL DOOR	B.P.D.	BLAST-PROOF DOOR
T.O.S.	TOP OF SLAB	F.D.	FENCE DOOR

REFERENCE DRAWING	DRG. No.
STANDARD DRAWING FOR ARCHITECTURAL DETAILS	BK-GNRL-PEDCO-000-AR-DW-0001
SITE SEWAGE SYSTEM LAYOUT & DETAILS	BK-GCS-PEDCO-120-CV-PY-0001
CABLE TRENCH AND DUCT BANK LAYOUT	BK-GCS-PEDCO-120-CV-PY-0002
ELECTRICAL CABLE ROUTE & SECTION LAYOUT FOR BUILDING & SHED	BK-GCS-PEDCO-120-EL-PY-0006
FOUNDATION DRAWING FOR EXTENSION OF EXISTING ELECT. BUILDING	BK-GCS-PEDCO-120-ST-DW-0003
STRUCTURAL DRAWING FOR EXTENSION OF EXISTING ELECT. BUILDING	BK-GCS-PEDCO-120-ST-DW-0004
STANDARD DETAILS FOR LADDER & SAFETY CAGE	BK-GNRL-PEDCO-000-ST-DW-0009
ELECTRICAL EQUIPMENT ARRANGEMENT LAYOUT FOR BUILDING	BK-GCS-PEDCO-120-ST-BL-PY-0008
UNIT PLOT PLAN DRAWING	BK-GCS-PEDCO-120-PI-PY-0001

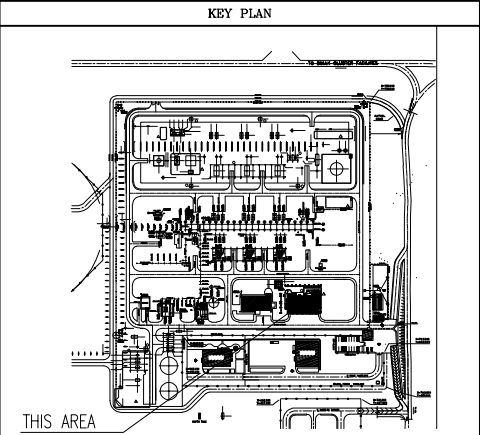



D07	MAR. 2024	APC	R.BERLOUB	M.PAKHARIAN	S.Parmarapour	** **
D06	NOV. 2023	APC	R.BERLOUB	M.PAKHARIAN	S.Parmarapour	** **
D05	SEP. 2023	APC	R.BERLOUB	M.PAKHARIAN	A.M.MOHSSENI	** **
D04	AUG. 2023	IPA	R.BERLOUB	M.PAKHARIAN	A.M.MOHSSENI	** **
D03	MAY. 2023	IPA	R.BERLOUB	M.PAKHARIAN	A.M.MOHSSENI	** **
D02	AUG. 2022	IPA	R.BERLOUB	M.PAKHARIAN	M.MEHRSHAD	** **
D01	APR. 2022	IPA	R.BERLOUB	M.PAKHARIAN	M.MEHRSHAD	** **
D00	JAN. 2022	IPC	R.BERLOUB	M.PAKHARIAN	M.MEHRSHAD	** **

PROJECT NAME:		BINAK OILFIELD DEVELOPMENT/SURFACE FACILITIES GAS COMPRESSOR STATION			
PROJECT NO.:		971020			
EPC CONTRACTOR:		EPD/EPC CONTRACTOR (GC):			
					
HIRGAN ENERGY - DESIGN & INQUIRY COMPANIES		PEDCO		PETROIRAN DEVELOPMENT COMPANY	
DRAWING TITLE:		ARCHITECTURAL DETAIL DRAWING FOR EXTENSION OF EXISTING ELECT. BUILDING ELEVATIONS			
SCALE	SIZE	DRAWING NO.		SHEET NO.	REV.
AS SHOWN	A1	BK-GCS-PEDCO-120-AR-DW-0002		11 OF 15	D07

اصل و کليه نسخ اين نقشه و حق اقباض متعلق به شرکت ملی مناطق نفت خيز جنوب مي باشد.

THE ORIGINAL AND ALL COPIES OF THIS DRAWING TOGETHER WITH THE COPYRIGHT THEREIN ARE THE SOLE PROPERTY OF N.I.S.O.C./ FIELDS

BINAK OILFIELD DEVELOPMENT SURFACE FACILITIES GAS COMPRESSOR STATION					
DATE	SCALE	DRAWING BY	CHECKED BY	PROJECT ENG.	
NO CONSTRUCTION PERMITTED UNLESS DRAWING APPROVED					
APPROVED FOR CONSTRUCTION			BY:	DATE:	
BUDGET REF.	LOCATION	SIZE CLASS	SERIAL NO.	SHEET	REVISION
053-073-9184	F	4 B	709100	11 OF 15	D07

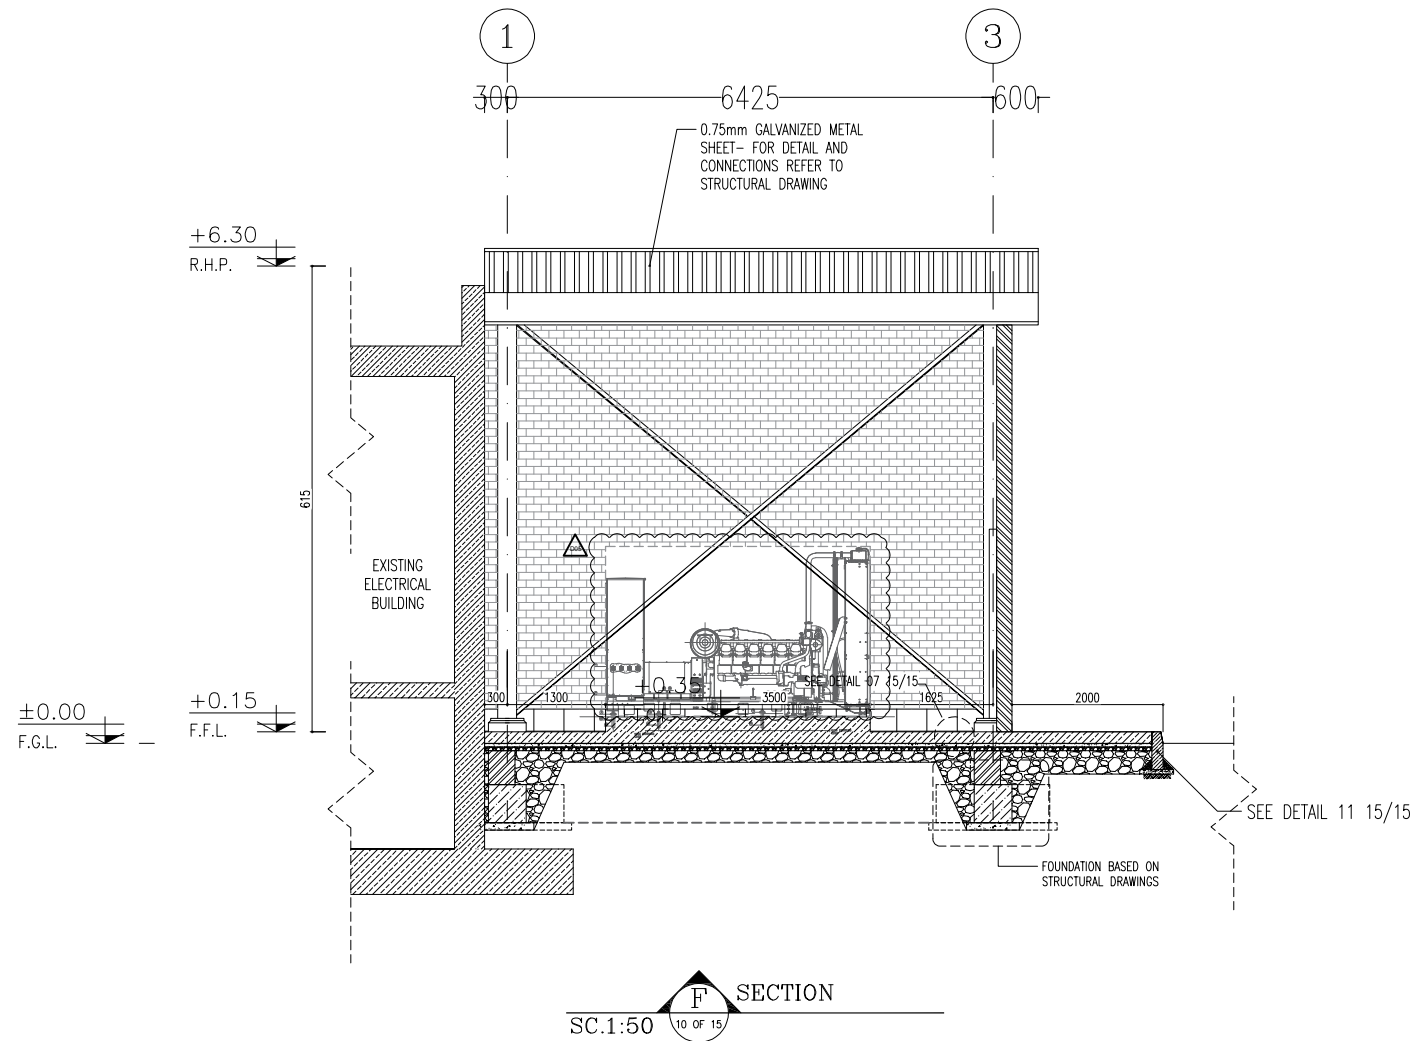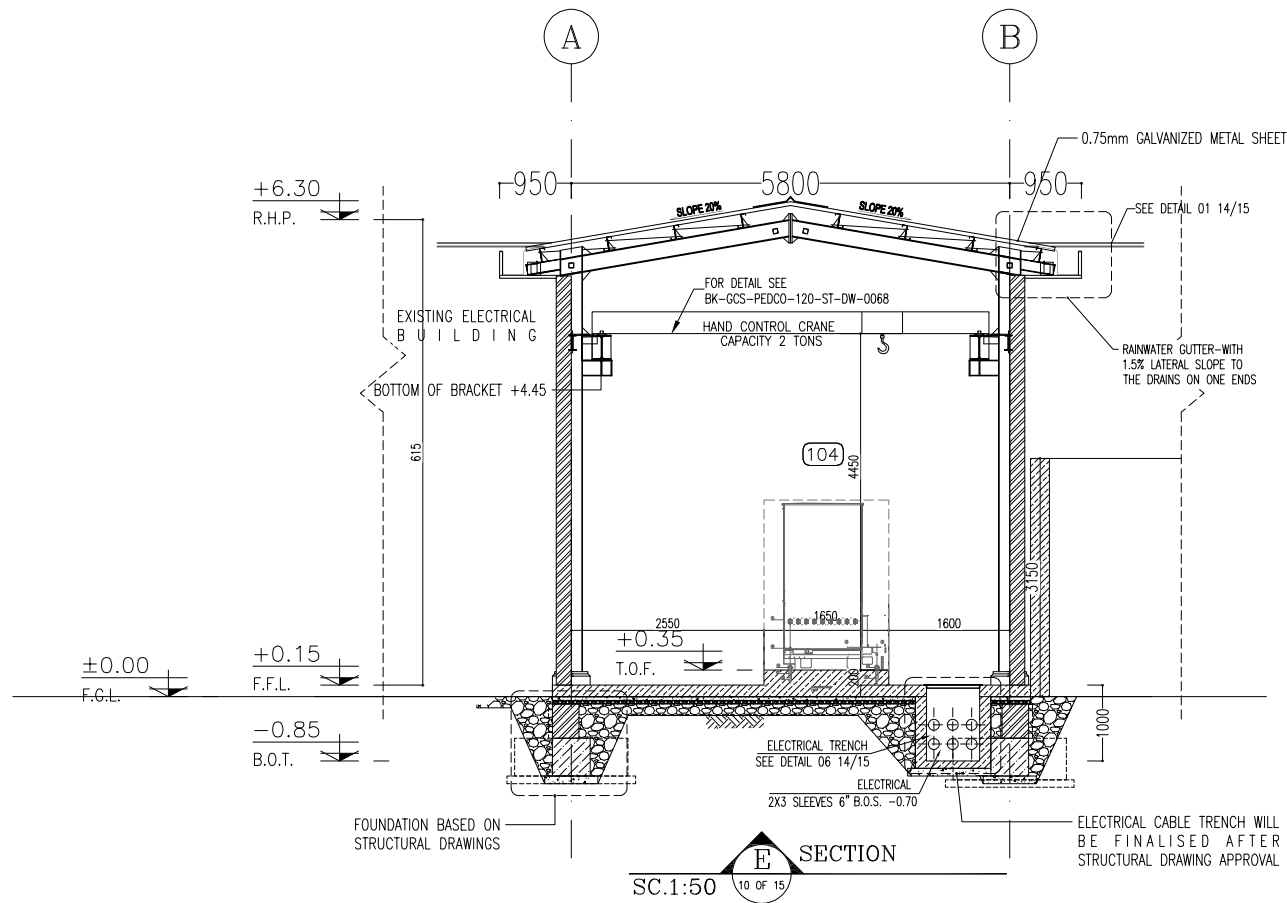

NOTES

1. ALL DIMENSIONS ARE IN CENTIMETER & ALL ELEVATIONS ARE IN METER.

2. ALL DIMENSIONS AND ELEVATIONS SHALL BE CHECKED BY THE CONTRACTOR PRIOR TO CONSTRUCTION.

3. CONTRACTOR SHALL COMPARE ALL ARCHITECTURAL, MECHANICAL, ELECTRICAL, PIPING AND STRUCTURAL DRAWINGS AND IN CASE OF ANY CONFLICTS OR DISCREPANCY, INFORM THE ENGINEER.

4. ALL MATERIALS ARE SELECTED FROM THE HIGHEST QUALITY AND MUST BE APPROVED BY THE CLIENT.


5. ALL OPENINGS FOR PIPING/CABLES AND HVAC OPENINGS SHALL BE CONSIDERED AS PER RELATED DRAWINGS BEFORE CONSTRUCTION.

6. ARCHITECTURAL DETAIL DESIGN WILL BE REVISED BASED ON APPROVED STRUCTURAL DRAWINGS.


7. ELEVATION CODE : LOCAL ±0.0m CORRESPONDS TO GLOBAL +11.10m

LEGEND			
LEAN CONCRETE			
REINFORCED CONCRETE			
PRESSED BRICK			
STONE			
EXPANSION JOINT FILLER (PLASTOFOAM)			
TERRAZZO TILES FOR ROOF - 30x30cm			
BLOCKAGE			
F.F.L.	FINISHED FLOOR	B.O.P.	BOTTOM OF PIT
T.O.WA	TOP OF WALKWAY	F.G.L.	FINISH GRADING LEVEL
T.O.P.	TOP OF PARAPET	T.O.T.	TOP OF TRENCH
T.O.FOU.	TOP OF FOUNDATION	C.O.S.	CENTER OF SLEEVE
M.D	METAL DOOR	B.O.S.	BOTTOM OF SLEEVE
T.O.R.	TOP OF ROOF	B.O.O.	BOTTOM OF OPENING
T.O.D.	TOP OF DOOR	B.O.T.	BOTTOM OF TRENCH
B.O.Cg.	BOTTOM OF CAGE	B.O.P.	BOTTOM OF PIT
T.O.Cg.	TOP OF CAGE	R.H.P.	ROOF HIGHEST POINT
B.O.G.	BOTTOM OF GUTTER	R.L.P.	ROOF LOWEST POINT
T.O.Cg.	TOP OF CAGE	N.G.R.	NEUTRAL GROUND RESISTOR
M.D.	METAL DOOR	B.P.D.	BLAST-PROOF DOOR
T.O.S.	TOP OF SLAB	F.D.	FENCE DOOR

REFERENCE DRAWING	DRG. No.
STANDARD DRAWING FOR ARCHITECTURAL DETAILS	BK-GNRL-PEDCO-000-AR-DW-0001
SITE SEWAGE SYSTEM LAYOUT & DETAILS	BK-GCS-PEDCO-120-CV-PY-0001
CABLE TRENCH AND DUCT BANK LAYOUT	BK-GCS-PEDCO-120-CV-PY-0002
ELECTRICAL CABLE ROUTE & SECTION LAYOUT FOR BUILDING & SHED	BK-GCS-PEDCO-120-EL-PY-0006
FOUNDATION DRAWING FOR EXTENSION OF EXISTING ELECT. BUILDING	BK-GCS-PEDCO-120-ST-DW-0003
STRUCTURAL DRAWING FOR EXTENSION OF EXISTING ELECT. BUILDING	BK-GCS-PEDCO-120-ST-DW-0004
STANDARD DETAILS FOR LADDER & SAFETY CAGE	BK-GNRL-PEDCO-000-ST-DW-0009
ELECTRICAL EQUIPMENT ARRANGEMENT LAYOUT FOR BUILDING	BK-GCS-PEDCO-120-ST-BE-PY-0008
UNIT FLOOR PLAN DRAWING	BK-GCS-PEDCO-120-PI-PY-0001

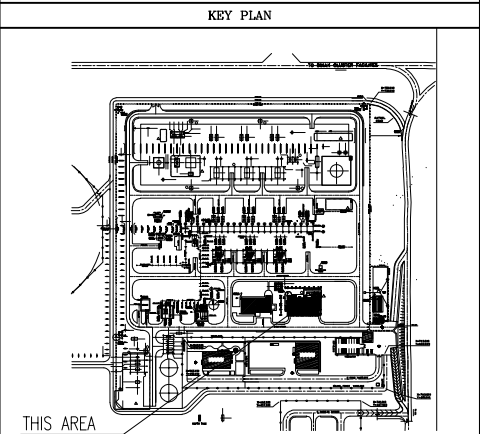


D07	MAR. 2024	APC	R.BERLOUIR	M.PAKHARIAN	S.Parmarspour	** **	THIS AREA						
D06	NOV. 2023	APC	R.BERLOUIR	M.PAKHARIAN	S.Parmarspour	** **							
D05	SEP. 2023	APC	R.BERLOUIR	M.PAKHARIAN	A.M.MOHSENI	** **							
D04	AUG. 2023	IPA	R.BERLOUIR	M.PAKHARIAN	A.M.MOHSENI	** **							
D03	MAY. 2023	IPA	R.BERLOUIR	M.PAKHARIAN	A.M.MOHSENI	** **							
D02	AUG. 2022	IPA	R.BERLOUIR	M.PAKHARIAN	M.MEHRSHAD	** **	***	*****	** **	*** ****	** ** *** ****		
D01	APR. 2022	IPA	R.BERLOUIR	M.PAKHARIAN	M.MEHRSHAD	** **	REV.	DESCRIPTION	BY	DATE	BY	DATE	
D00	JAN. 2022	IPC	R.BERLOUIR	M.PAKHARIAN	M.MEHRSHAD	** **			CHECKED		REV. APPR.		
REV.	DATE	P.O.I.S	PREP.	CHK.	APP.	AUT.	اصل و کلیه نسخ این نقشه و حق اقتباس متعلق به شرکت ملی مناطق نفت خیز جنوب میباشد.						
PROJECT NAME: BINAK OILFIELD DEVELOPMENT/SURFACE FACILITIES GAS COMPRESSOR STATION							 THE ORIGINAL AND ALL COPIES OF THIS DRAWING TOGETHER WITH THE COPYRIGHT THEREIN ARE THE SOLE PROPERTY OF N.I.S.O.C./ FIELDS						
EPC CONTRACTOR:			EPD/EPC CONTRACTOR (GC):				BINAK OILFIELD DEVELOPMENT SURFACE FACILITIES GAS COMPRESSOR STATION						
 HIRGAN ENERGY - DESIGN & INSPECTION COMPANIES			 PETROIRAN DEVELOPMENT COMPANY				DATE SCALE DRAWING BY CHECKED BY PROJECT ENG.						
DRAWING TITLE: ARCHITECTURAL DETAIL DRAWING FOR EXTENSION OF EXISTING ELECT. BUILDING SECTIONS							NO CONSTRUCTION PERMITTED UNLESS DRAWING APPROVED						
							APPROVED FOR CONSTRUCTION			BY:		DATE:	
SCALE	SIZE	DRAWING NO.			SHEET NO.	REV.	BUDGET REF.	LOCATION	SIZE	CLASS	SERIAL NO.	SHEET	REVISION
AS SHOWN	A1	BK-GCS-PEDCO-120-AR-DW-0002			12 OF 15	D07	053-073-9184	F	4	B	709100	12 OF 15	D07

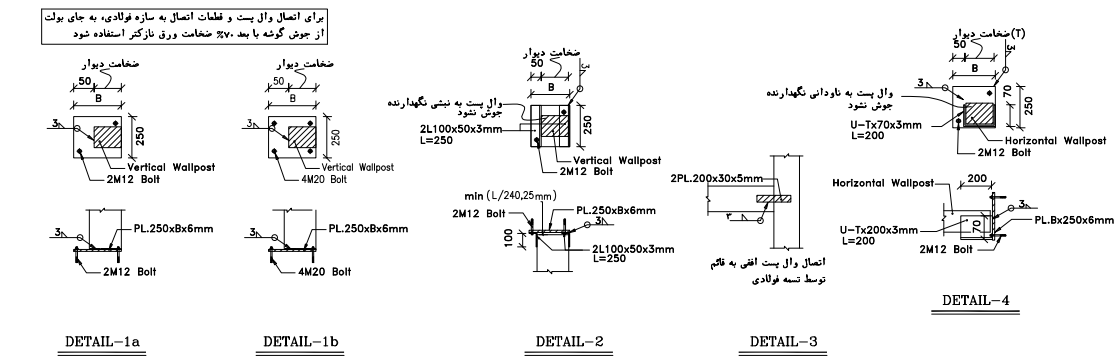

	AREA	FLOOR	INTERNAL SKIRTING	EXTERNAL SKIRTING	INTERNAL WALL	EXTERNAL WALL	CEILING
100	CAPACITOR BANK	TERRAZZO TILE	DARK GRANITE STONE 100cm	DARK GRANITE STONE 40cm	2 CM CEMENT PLASTER+GYPSUM PLASTER+OIL PAINT FINISH	BRICK FACING	2 CM CEMENT PLASTER+GYPSUM PLASTER+OIL PAINT FINISH
101	CO2 ROOM	TERRAZZO TILE	DARK GRANITE STONE 100cm	DARK GRANITE STONE 40cm	2 CM CEMENT PLASTER+GYPSUM PLASTER+OIL PAINT FINISH	BRICK FACING	2 CM CEMENT PLASTER+GYPSUM PLASTER+OIL PAINT FINISH
102	TRANSFORMER ROOM	CONCRETE	DARK GRANITE STONE 30cm	—	WHITE CEMENT PLASTER	DARK GRANITE STONE	0.75mm CORRUGATED GALVANIZED SHEET
103	FIRE-FIGHTING PUMP TRANSFORMER ROOM	CONCRETE	DARK GRANITE STONE 30cm	—	WHITE CEMENT PLASTER	DARK GRANITE STONE	0.75mm CORRUGATED GALVANIZED SHEET
104	DIESEL ROOM	CONCRETE	DARK GRANITE STONE 30cm	DARK GRANITE STONE 40cm	BRICK FACING	BRICK FACING	0.75mm CORRUGATED GALVANIZED SHEET
105	ROOF	TERRAZZO TILE	TERRAZZO TILE	—	CEMENT PLASTER	—	—

8 FINISHING SCHEDULE

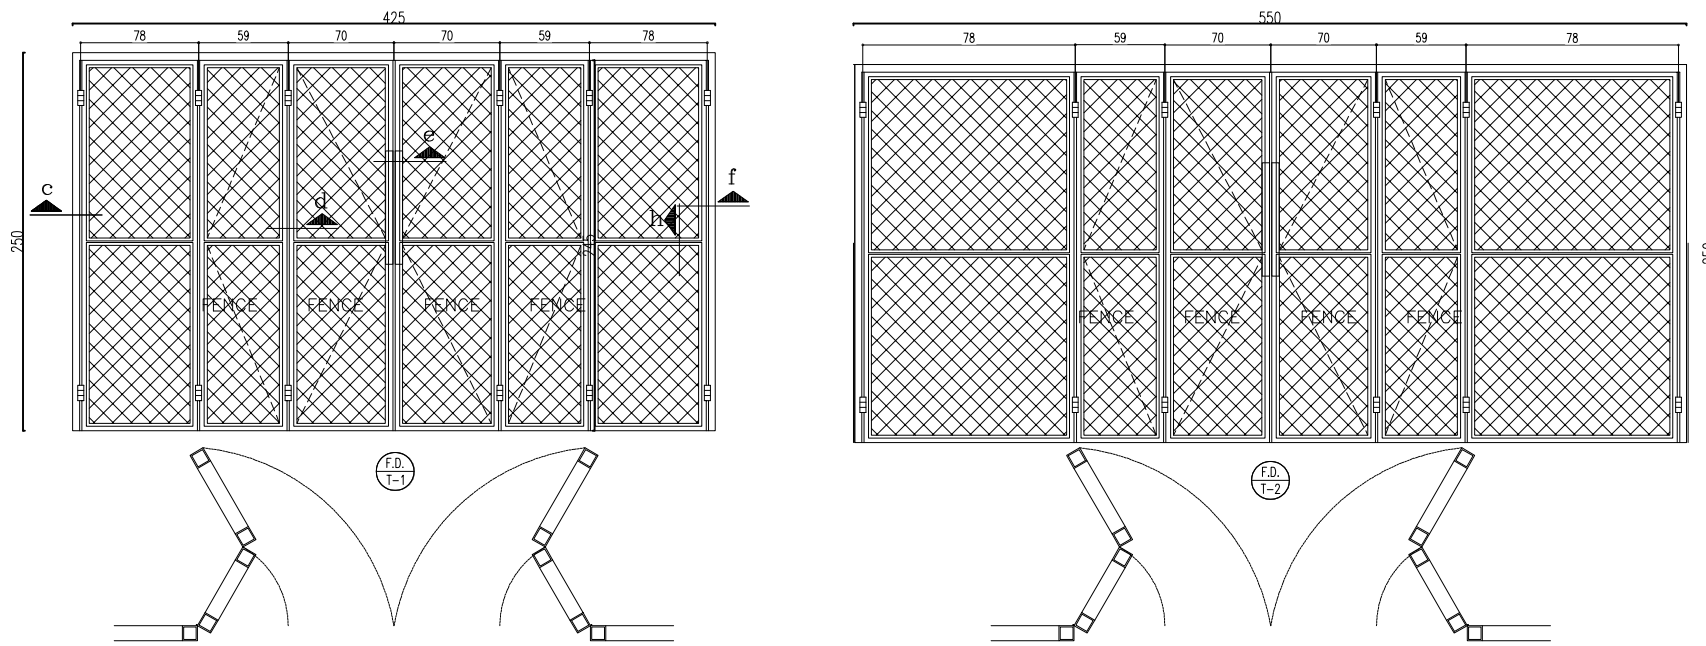


TOTAL: 3

Sc:1/25


TOTAL: 1

Sc:1/25

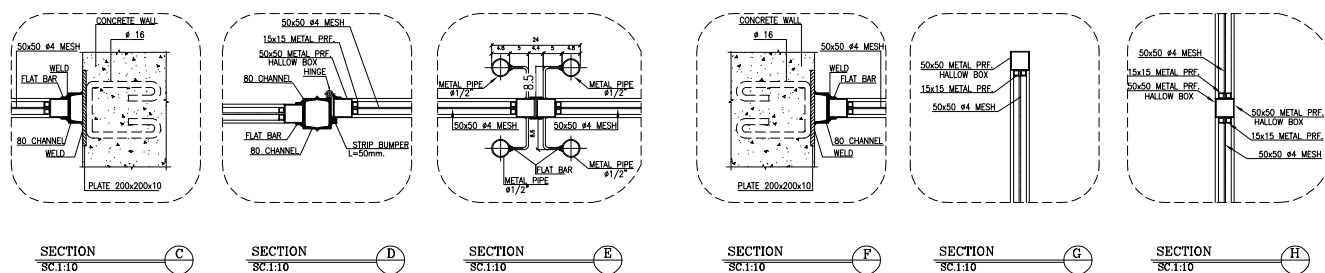

F.F.L.	FINISHED FLOOR	B.O.P.	BOTTOM OF PIT
T.O.WA	TOP OF WALKWAY	F.G.L.	FINISH GRADING LEVEL
T.O.P.	TOP OF PARAPET	T.O.T.	TOP OF TRENCH
T.O.FOU.	TOP OF FOUNDATION	C.O.S.	CENTER OF SLEEVE
M.D.	METAL DOOR	B.O.S.	BOTTOM OF SLEEVE
T.O.R.	TOP OF ROOF	B.O.O.	BOTTOM OF OPENING
T.O.D.	TOP OF DOOR	B.O.T.	BOTTOM OF TRENCH
B.O.Ca.	BOTTOM OF CAGE	B.O.P.	BOTTOM OF PIT
T.O.Ca.	TOP OF CAGE	R.H.P.	ROOF HIGHEST POINT
B.O.G.	BOTTOM OF GUTTER	R.L.P.	ROOF LOWEST POINT
T.O.Ca.	TOP OF CAGE	N.G.R.	NEUTRAL GROUND RESISTOR
M.D.	METAL DOOR	B.P.D.	BLAST-PROOF DOOR
T.O.S.	TOP OF SLAB	F.D.	FENCE DOOR

REFERENCE DRAWING	DRG. No.
STANDARD DRAWING FOR ARCHITECTURAL DETAILS	BK-GNRL-PEDCO-000-AR-DW-0001
SITE SEWAGE SYSTEM LAYOUT & DETAILS	BK-GCS-PEDCO-120-CV-PY-PY-0001
CABLE TRENCH AND DUCT BANK LAYOUT	BK-GCS-PEDCO-120-CV-PY-PY-0002
ELECTRICAL CABLE ROUTE & SECTION LAYOUT FOR BUILDING & SHEDDAR	BK-GCS-PEDCO-120-EL-PY-PY-0006
FOUNDATION DRAWING FOR EXTENSION OF EXISTING BLDG. BUILDING	BK-GCS-PEDCO-120-ST-DW-0063
STRUCTURAL DRAWING FOR EXTENSION OF EXISTING BLDG. BUILDING	BK-GCS-PEDCO-120-ST-DW-0064
STANDARD DETAILS FOR LADDER & SAFETY CAGE	BK-GNRL-PEDCO-000-ST-DW-0009
ELECTRICAL EQUIPMENT ARRANGEMENT LAYOUT FOR BUILDING	BK-GCS-PEDCO-180-ST-BL-PY-0008
UNIT PLOT PLAN DRAWING	BK-GCS-PEDCO-120-PI-PY-PY-0001

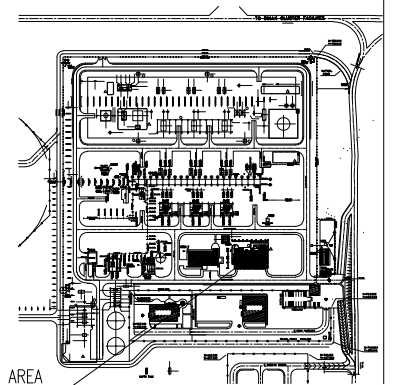


***	*****	00.00	000.0000	00.00	000.0000		
REV.	DESCRIPTION	BY	DATE	BY	DATE		
		CHECKED		REV. APPR.			

اصل و کلبه نسخ این نقشه و حق اقتباس متعلق به شرکت ملی مناطق نفت خیز جنوب میباشد.

THE ORIGINAL AND ALL COPIES OF THIS DRAWING TOGETHER WITH
THE COPYRIGHT THEREIN ARE THE SOLE PROPERTY OF
N.I.S.O.C./ FIELDS


PROJECT NAME:		BINK OILFIELD DEVELOPMENT/SURFACE FACILITIES GAS COMPRESSOR STATION	
PROJECT NO.:		971020	
EPC CONTRACTOR:		EPD/EPC CONTRACTOR (GC):	
 			
HIRGAN ENERGY - DESIGN & INSPECTION COMPANIES		PETROIRAN DEVELOPMENT COMPANY	
DRAWING TITLE:		ARCHITECTURAL DETAIL DRAWING FOR EXTENSION OF EXISTING ELECT. BUILDING DETAILS AND SCHEDULES	
SCALE	SIZE	DRAWING NO.	SHEET NO.
AS SHOWN	A1	BK-GCS-PEDCO-120-AR-DW-0002	13 OF 15

BINAK OILFIELD DEVELOPMENT SURFACE FACILITIES GAS COMPRESSOR STATION									
DATE		SCALE		DRAWING BY		CHECKED BY		PROJECT ENG.	
NO CONSTRUCTION PERMITTED UNLESS DRAWING APPROVED									
APPROVED FOR CONSTRUCTION					BY:		DATE:		
DRAWING REF	LOCATION	SIZE	CLASS	SERIAL NO.	SHEET		REVISION		
063-073-9184	F	4	B	709100	13 OF 15		D07		

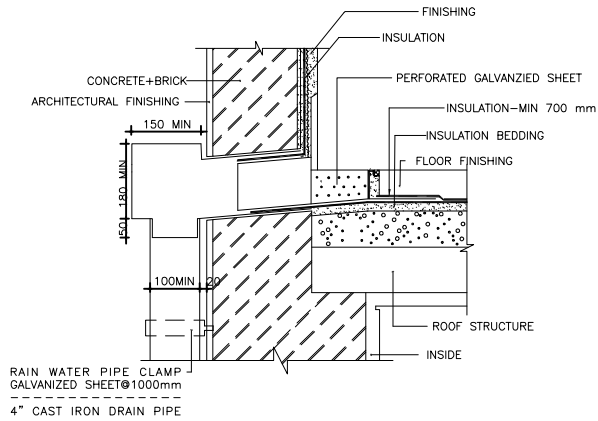


DETAIL 08 -RAIN WATER DISPOSAL

Sc:1/10

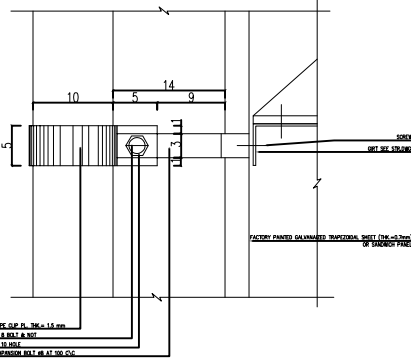


DETAIL 09-TYPICAL PIPE CLIP ON TRAPEZOIDAL SHEET

Sc:1/20

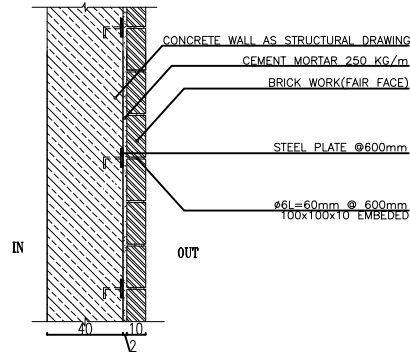


DETAIL 13- CONNECTING BRICK FACE TO CONCRETE WALL

Sc:1/20

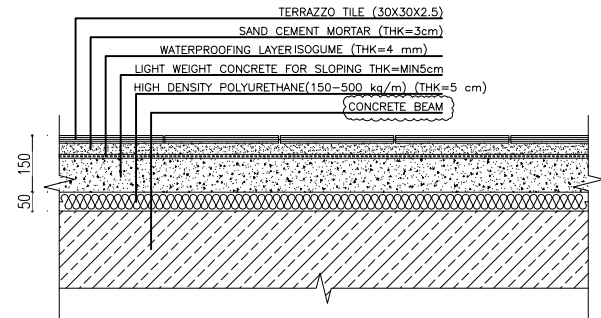


DETAIL 14 (ROOF)

Sc:1/10

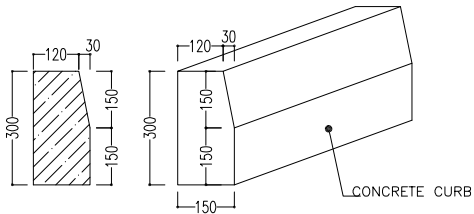


DETAIL 11CONCRETE CURB

Sc:1/10

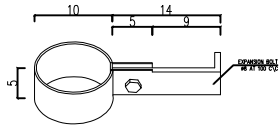


DETAIL 09-TYPICAL PIPE CLIP ON TRAPEZOIDAL SHEET

Sc:1/20

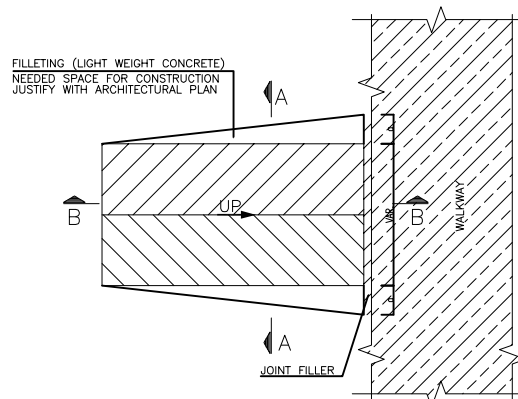


DETAIL 12-RAMP


Sc:1/20

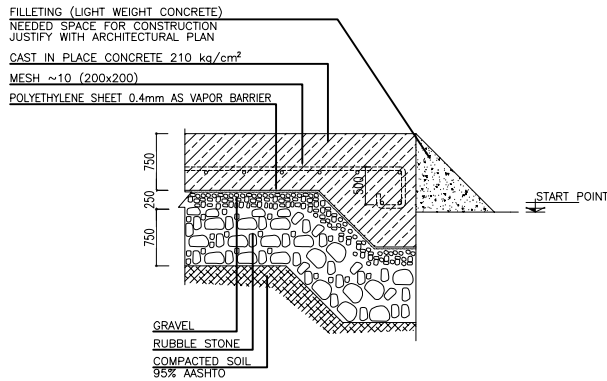

SC.1:10

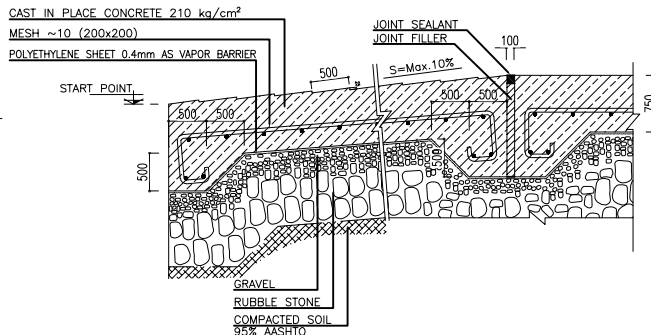

SC.1:10

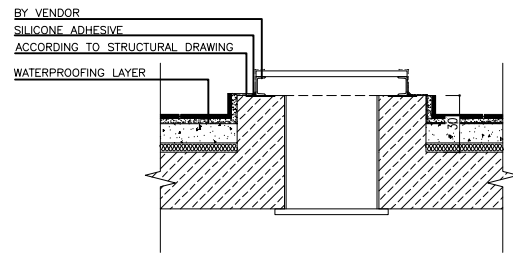


DETAIL 15 (VENTILATION FAN ON ROOF)

Sc:1/20

- NOTES
1. ALL DIMENSIONS ARE IN CENTIMETER & ALL ELEVATIONS ARE IN METER.
 2. ALL DIMENSIONS AND ELEVATIONS SHALL BE CHECKED BY THE CONTRACTOR PRIOR TO CONSTRUCTION.
 3. CONTRACTOR SHALL COMPARE ALL ARCHITECTURAL, MECHANICAL, ELECTRICAL, PIPING AND STRUCTURAL DRAWINGS AND IN CASE OF ANY CONFLICTS OR DISCREPANCY, INFORM THE ENGINEER.
 4. ALL MATERIALS ARE SELECTED FROM THE HIGHEST QUALITY AND MUST BE APPROVED BY THE CLIENT.
 5. ALL OPENINGS FOR PIPING/CABLING AND HVAC OPENINGS SHALL BE CONSIDERED AS PER RELATED DRAWINGS BEFORE CONSTRUCTION.
 6. ARCHITECTURAL DETAIL DESIGN WILL BE REVISED BASED ON APPROVED STRUCTURAL DRAWINGS.
 7. ELEVATION CODE : LOCAL ±0.0m CORRESPONDS TO GLOBAL +11.10m

LEGEND			
LEAN CONCRETE			
REINFORCED CONCRETE			
PRESSED BRICK			
STONE			
EXPANSION JOINT FILLER (PLASTOFOAM)			
TERRAZZO TILES FOR ROOF - 30x30cm			
BLOCKAGE			
F.F.L.	FINISHED FLOOR	B.O.P.	BOTTOM OF PIT
T.O.WA	TOP OF WALKWAY	F.G.L.	FINISH GRADING LEVEL
T.O.P.	TOP OF PARAPET	T.O.T.	TOP OF TRENCH
T.O.FOU.	TOP OF FOUNDATION	C.O.S.	CENTER OF SLEEVE
M.D	METAL DOOR	B.O.S.	BOTTOM OF SLEEVE
T.O.R.	TOP OF ROOF	B.O.O.	BOTTOM OF OPENING
T.O.D.	TOP OF DOOR	B.O.T.	BOTTOM OF TRENCH
B.O.Co.	BOTTOM OF CAGE	B.O.P.	BOTTOM OF PIT
T.O.Co.	TOP OF CAGE	R.H.P.	ROOF HIGHEST POINT
B.O.G.	BOTTOM OF GUTTER	R.L.P.	ROOF LOWEST POINT
T.O.Co.	TOP OF CAGE	N.G.R.	NEUTRAL GROUND RESISTOR
M.D.	METAL DOOR	B.P.D.	BLAST-PROOF DOOR
T.O.S.	TOP OF SLAB	F.D.	FENCE DOOR

REFERENCE DRAWING	DRG. No.
STANDARD DRAWING FOR ARCHITECTURAL DETAILS	BK-GNRL-PEDCO-000-AR-DW-0001
SITE SEWAGE SYSTEM LAYOUT & DETAILS	BK-GCS-PEDCO-120-CV-PY-0001
CABLE TRENCH AND DUCT BANK LAYOUT	BK-GCS-PEDCO-120-CV-PY-0002
ELECTRICAL CABLE ROUTE & SECTION LAYOUT FOR BUILDING & SHED	BK-GCS-PEDCO-120-EL-PY-0006
FOUNDATION DRAWING FOR EXTENSION OF EXISTING ELECT. BUILDING	BK-GCS-PEDCO-120-ST-DW-0003
STRUCTURAL DRAWING FOR EXTENSION OF EXISTING ELECT. BUILDING	BK-GCS-PEDCO-120-ST-DW-0004
STANDARD DETAILS FOR LADDER & SAFETY CAGE	BK-GNRL-PEDCO-000-ST-DW-0009
ELECTRICAL EQUIPMENT ARRANGEMENT LAYOUT FOR BUILDING	BK-GCS-PEDCO-120-ST-BE-PY-0008
UNIT PLOT PLAN DRAWING	BK-GCS-PEDCO-120-PI-PY-0001

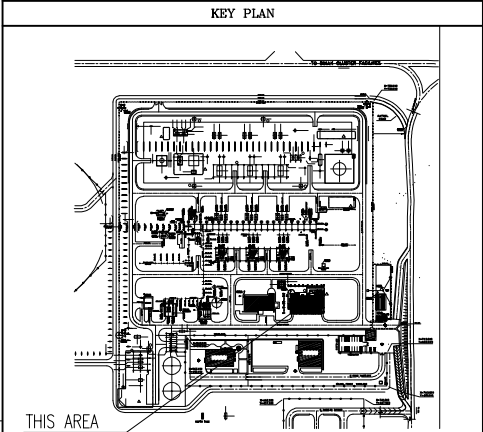

REV.	DESCRIPTION	BY	DATE	BY	DATE
***	*****	**	*****	**	*****

اسم و کلیه نسخ این نقشه و حق اقتباس متعلق به شرکت ملی مناطق نفت خیز جنوب میباشند.
THE ORIGINAL AND ALL COPIES OF THIS DRAWING TOGETHER WITH THE COPYRIGHT THEREIN ARE THE SOLE PROPERTY OF N.I.S.O.C./ FIELDS

D07	MAR. 2024	APC	R.BERLOUBI	M.PAKHARIAN	S.Parmarapour	** **
D06	NOV. 2023	APC	R.BERLOUBI	M.PAKHARIAN	S.Parmarapour	** **
D05	SEP. 2023	APC	R.BERLOUBI	M.PAKHARIAN	A.M.MOHSSENI	** **
D04	AUG. 2023	IPA	R.BERLOUBI	M.PAKHARIAN	A.M.MOHSSENI	** **
D03	MAY. 2023	IPA	R.BERLOUBI	M.PAKHARIAN	A.M.MOHSSENI	** **
D02	AUG. 2022	IPA	R.BERLOUBI	M.PAKHARIAN	M.MEHRSHAD	** **
D01	APR. 2022	IPA	R.BERLOUBI	M.PAKHARIAN	M.MEHRSHAD	** **
D00	JAN. 2022	IPC	R.BERLOUBI	M.PAKHARIAN	M.MEHRSHAD	** **
REV.	DATE	P.O.I.S	PREP.	CHK.	APP.	AUT.
PROJECT NAME: BINAK OILFIELD DEVELOPMENT/SURFACE FACILITIES GAS COMPRESSOR STATION						
PROJECT NO.: 971020						
EPC CONTRACTOR:			EPD/EPC CONTRACTOR (GC):			
 HIRGAN ENERGY - DESIGN & INSPECTION COMPANIES			 PETROIRAN DEVELOPMENT COMPANY			
DRAWING TITLE: ARCHITECTURAL DETAIL DRAWING FOR EXTENSION OF EXISTING ELECT. BUILDING DETAILS						
SCALE	SIZE	DRAWING NO.			SHEET NO.	REV.
AS SHOWN	A1	BK-GCS-PEDCO-120-AR-DW-0002			15 OF 15	D07

BINAK OILFIELD DEVELOPMENT SURFACE FACILITIES GAS COMPRESSOR STATION					
DATE	SCALE	DRAWING BY	CHECKED BY	PROJECT ENG.	
NO CONSTRUCTION PERMITTED UNLESS DRAWING APPROVED					
APPROVED FOR CONSTRUCTION			BY:	DATE:	
BUDGET REF.	LOCATION	SIZE CLASS	SERIAL NO.	SHEET	REVISION
053-073-9184	F	4 B	709100	15 OF 15	D07