

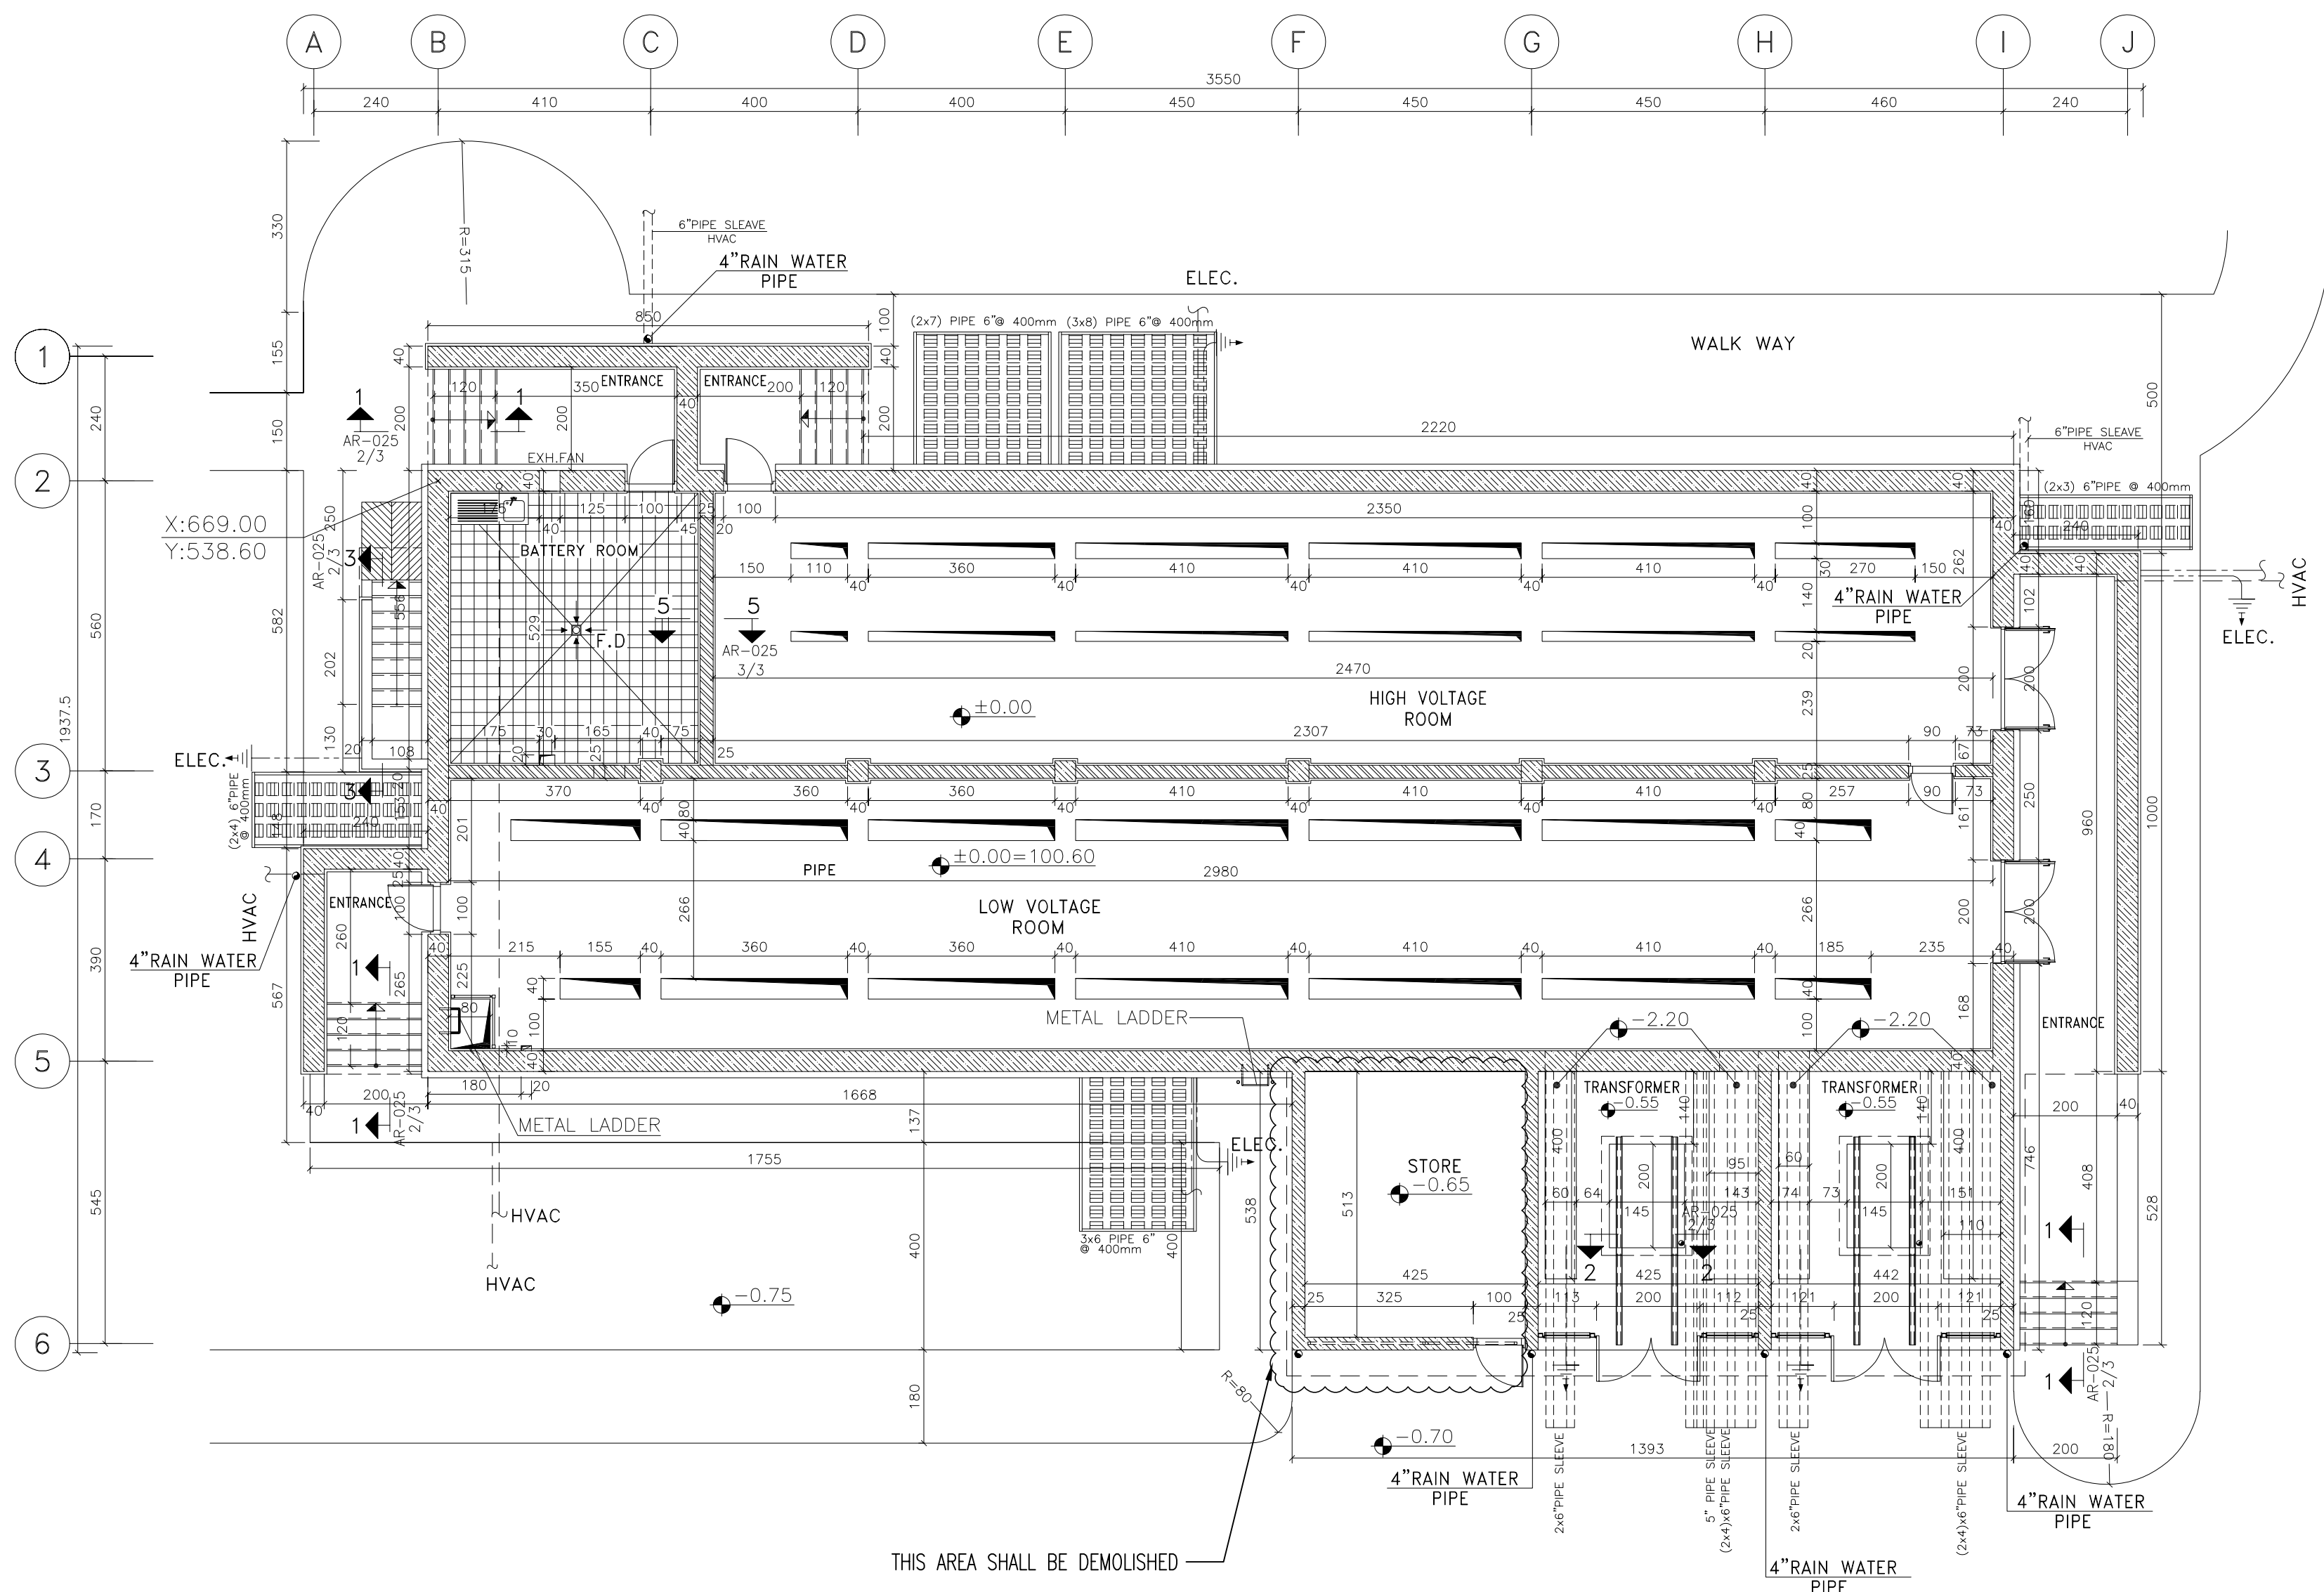


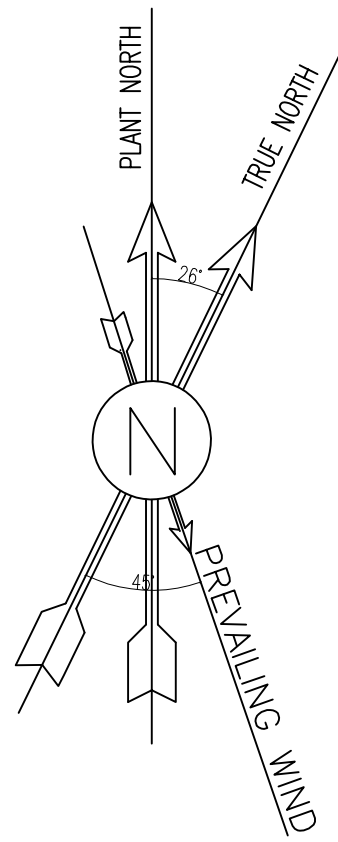

SC:1:100 1 EXISTING PLAN



NOTES			
1. ALL DIMENSIONS ARE IN CENTIMETER & ALL ELEVATIONS ARE IN METER.			
2. ALL DIMENSIONS AND ELEVATIONS SHALL BE CHECKED BY THE CONTRACTOR PRIOR TO CONSTRUCTION.			
3. CONTRACTOR SHALL COMPLY ALL ARCHITECTURAL, MECHANICAL, ELECTRICAL, PIPING AND STRUCTURAL DRAWINGS AND IN CASE OF ANY CONFLICTS OR DISCREPANCY, INFORM THE ENGINEER.			
4. ALL MATERIALS ARE SELECTED FROM THE HIGHEST QUALITY AND MUST BE APPROVED BY THE CLIENT.			
5. ALL OPENINGS FOR PIPING, CABLEING AND HVAC OPENINGS SHALL BE CONSIDERED AS PER RELATED DRAWINGS BEFORE CONSTRUCTION.			
6. ARCHITECTURAL DETAIL DESIGN WILL BE REVISED BASED ON APPROVED STRUCTURAL DRAWINGS.			
7. ELEVATION CODE : LOCAL ±0.0m CORRESPONDS TO GLOBAL +11.10m			
LEGEND			
LEAN CONCRETE			
REINFORCED CONCRETE			
PRESSED BRICK			
STONE			
EXPANSION JOINT FILLER (PLASTOFOAM)			
TERRAZZO TILES FOR ROOF - 30x30cm			
BLOCKAGE			
F.F.L.	FINISHED FLOOR	B.O.P.	BOTTOM OF PIT
T.O.WA	TOP OF WALKWAY	F.G.L.	FINISH GRADING LEVEL
T.O.P.	TOP OF PARAPET	T.O.T.	TOP OF TRENCH
T.O.FOU.	TOP OF FOUNDATION	C.O.S.	CENTER OF SLEEVE
M.D	METAL DOOR	B.O.S.	BOTTOM OF SLEEVE
T.O.R.	TOP OF ROOF	B.O.O.	BOTTOM OF OPENING
T.O.D.	TOP OF DOOR	B.O.T.	BOTTOM OF TRENCH
B.O.Co.	BOTTOM OF CAGE	B.O.P.	BOTTOM OF PIT
T.O.Co.	TOP OF CAGE	R.H.P.	ROOF HIGHEST POINT
B.O.G.	BOTTOM OF GUTTER	R.L.P.	ROOF LOWEST POINT
T.O.Co.	TOP OF CAGE	N.G.R.	NEUTRAL GROUND RESISTOR
M.D.	METAL DOOR	B.P.D.	BLAST-PROOF DOOR
T.O.S.	TOP OF SLAB	F.D.	FENCE DOOR

REFERENCE DRAWING	DRG. No.
STANDARD DRAWING FOR ARCHITECTURAL DETAILS	BK-GNRL-PEDCO-000-AR-DW-0001
SITE SEWAGE SYSTEM LAYOUT & DETAILS	BK-GCS-PEDCO-120-CY-PY-0001
CABLE TRENCH AND DUCT BANK LAYOUT	BK-GCS-PEDCO-120-CY-PY-0002
ROAD, PAVING AND PLANT FINISH GRADING LAYOUT & SECTIONS	BK-GCS-PEDCO-120-CY-PY-0005
ELECTRICAL CABLE ROUTE & SECTION LAYOUT FOR BUILDING & SHED	BK-GCS-PEDCO-120-EL-PY-0006
FOUNDATION DRAWING FOR EXTENSION OF EXISTING ELECT. BUILDING	BK-GCS-PEDCO-120-ST-DW-0063
STRUCTURAL DRAWING FOR EXTENSION OF EXISTING ELECT. BUILDING	BK-GCS-PEDCO-120-ST-DW-0064
STANDARD DETAILS FOR LADDER & SAFETY CAGE	BK-GNRL-PEDCO-000-ST-DW-0009
ELECTRICAL EQUIPMENT ARRANGEMENT LAYOUT FOR BUILDING	BK-GCS-PEDCO-120-ST-EL-PY-0008
Unit Plot Plan Drawing	BK-GCS-PEDCO-120-PI-PY-0001

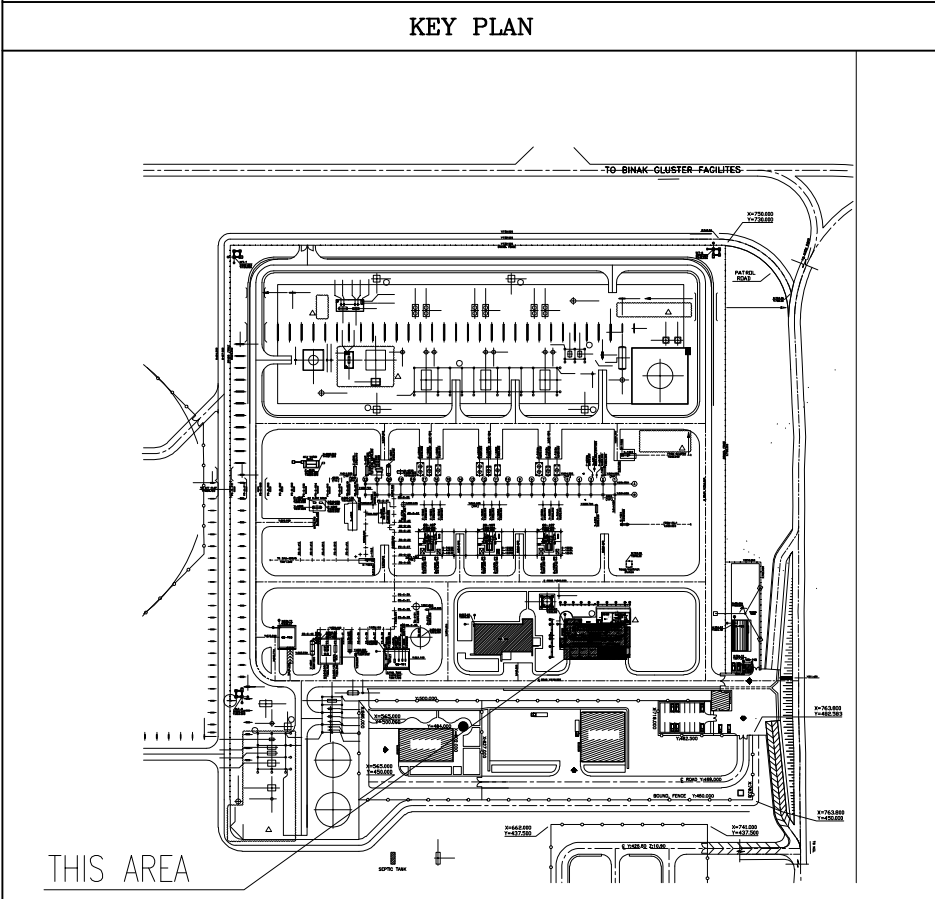

D05	SEP.2023	AFC	R.BERLOUIE	M.PAKHARIAN	A.M.MOHSSENI	***													
D04	AUG.2023	IFA	R.BERLOUIE	M.PAKHARIAN	A.M.MOHSSENI	***													
D03	MAY.2023	IFA	R.BERLOUIE	M.PAKHARIAN	A.M.MOHSSENI	***													
D02	AUG.2022	IFA	R.BERLOUIE	M.PAKHARIAN	M.MEHRSHAD	***	***	*****	***	*****	***	*****	***	*****	***	*****	***	*****	***
D01	APR.2022	IFA	R.BERLOUIE	M.PAKHARIAN	M.MEHRSHAD	***													
D00	JAN.2022	IPC	R.BERLOUIE	M.PAKHARIAN	M.MEHRSHAD	***													
REV.	DATE	P.O.I.S	PREP.	CHK.	APP.	AUT.													
PROJECT NAME:							BINAK OILFIELD DEVELOPMENT/SURFACE FACILITIES GAS COMPRESSOR STATION												
PROJECT NO.:							971020												
EPC CONTRACTOR:							EPD/EPC CONTRACTOR (GC):												
 HIRGAN ENERGY - DESIGN & INSPECTION COMPANIES							 PETROIRAN DEVELOPMENT COMPANY												
DRAWING TITLE:							ARCHITECTURAL DETAIL DRAWING FOR EXTENSION OF EXISTING ELECT. BUILDING EXISTING PLAN												
NO CONSTRUCTION PERMITTED UNLESS DRAWING APPROVED																			
APPROVED FOR CONSTRUCTION							BY:			DATE:									
SCALE	SIZE	DRAWING NO.			SHEET NO.	REV.	BUDGET REF.	LOCATION	SIZE	CLASS	SERIAL NO.	SHEET	REVISION						
AS SHOWN	A1	BK-GCS-PEDCO-120-AR-DW-0002			01 OF 15	D05	053-073-0184	F	4	B	709100	01 OF 15	D05						



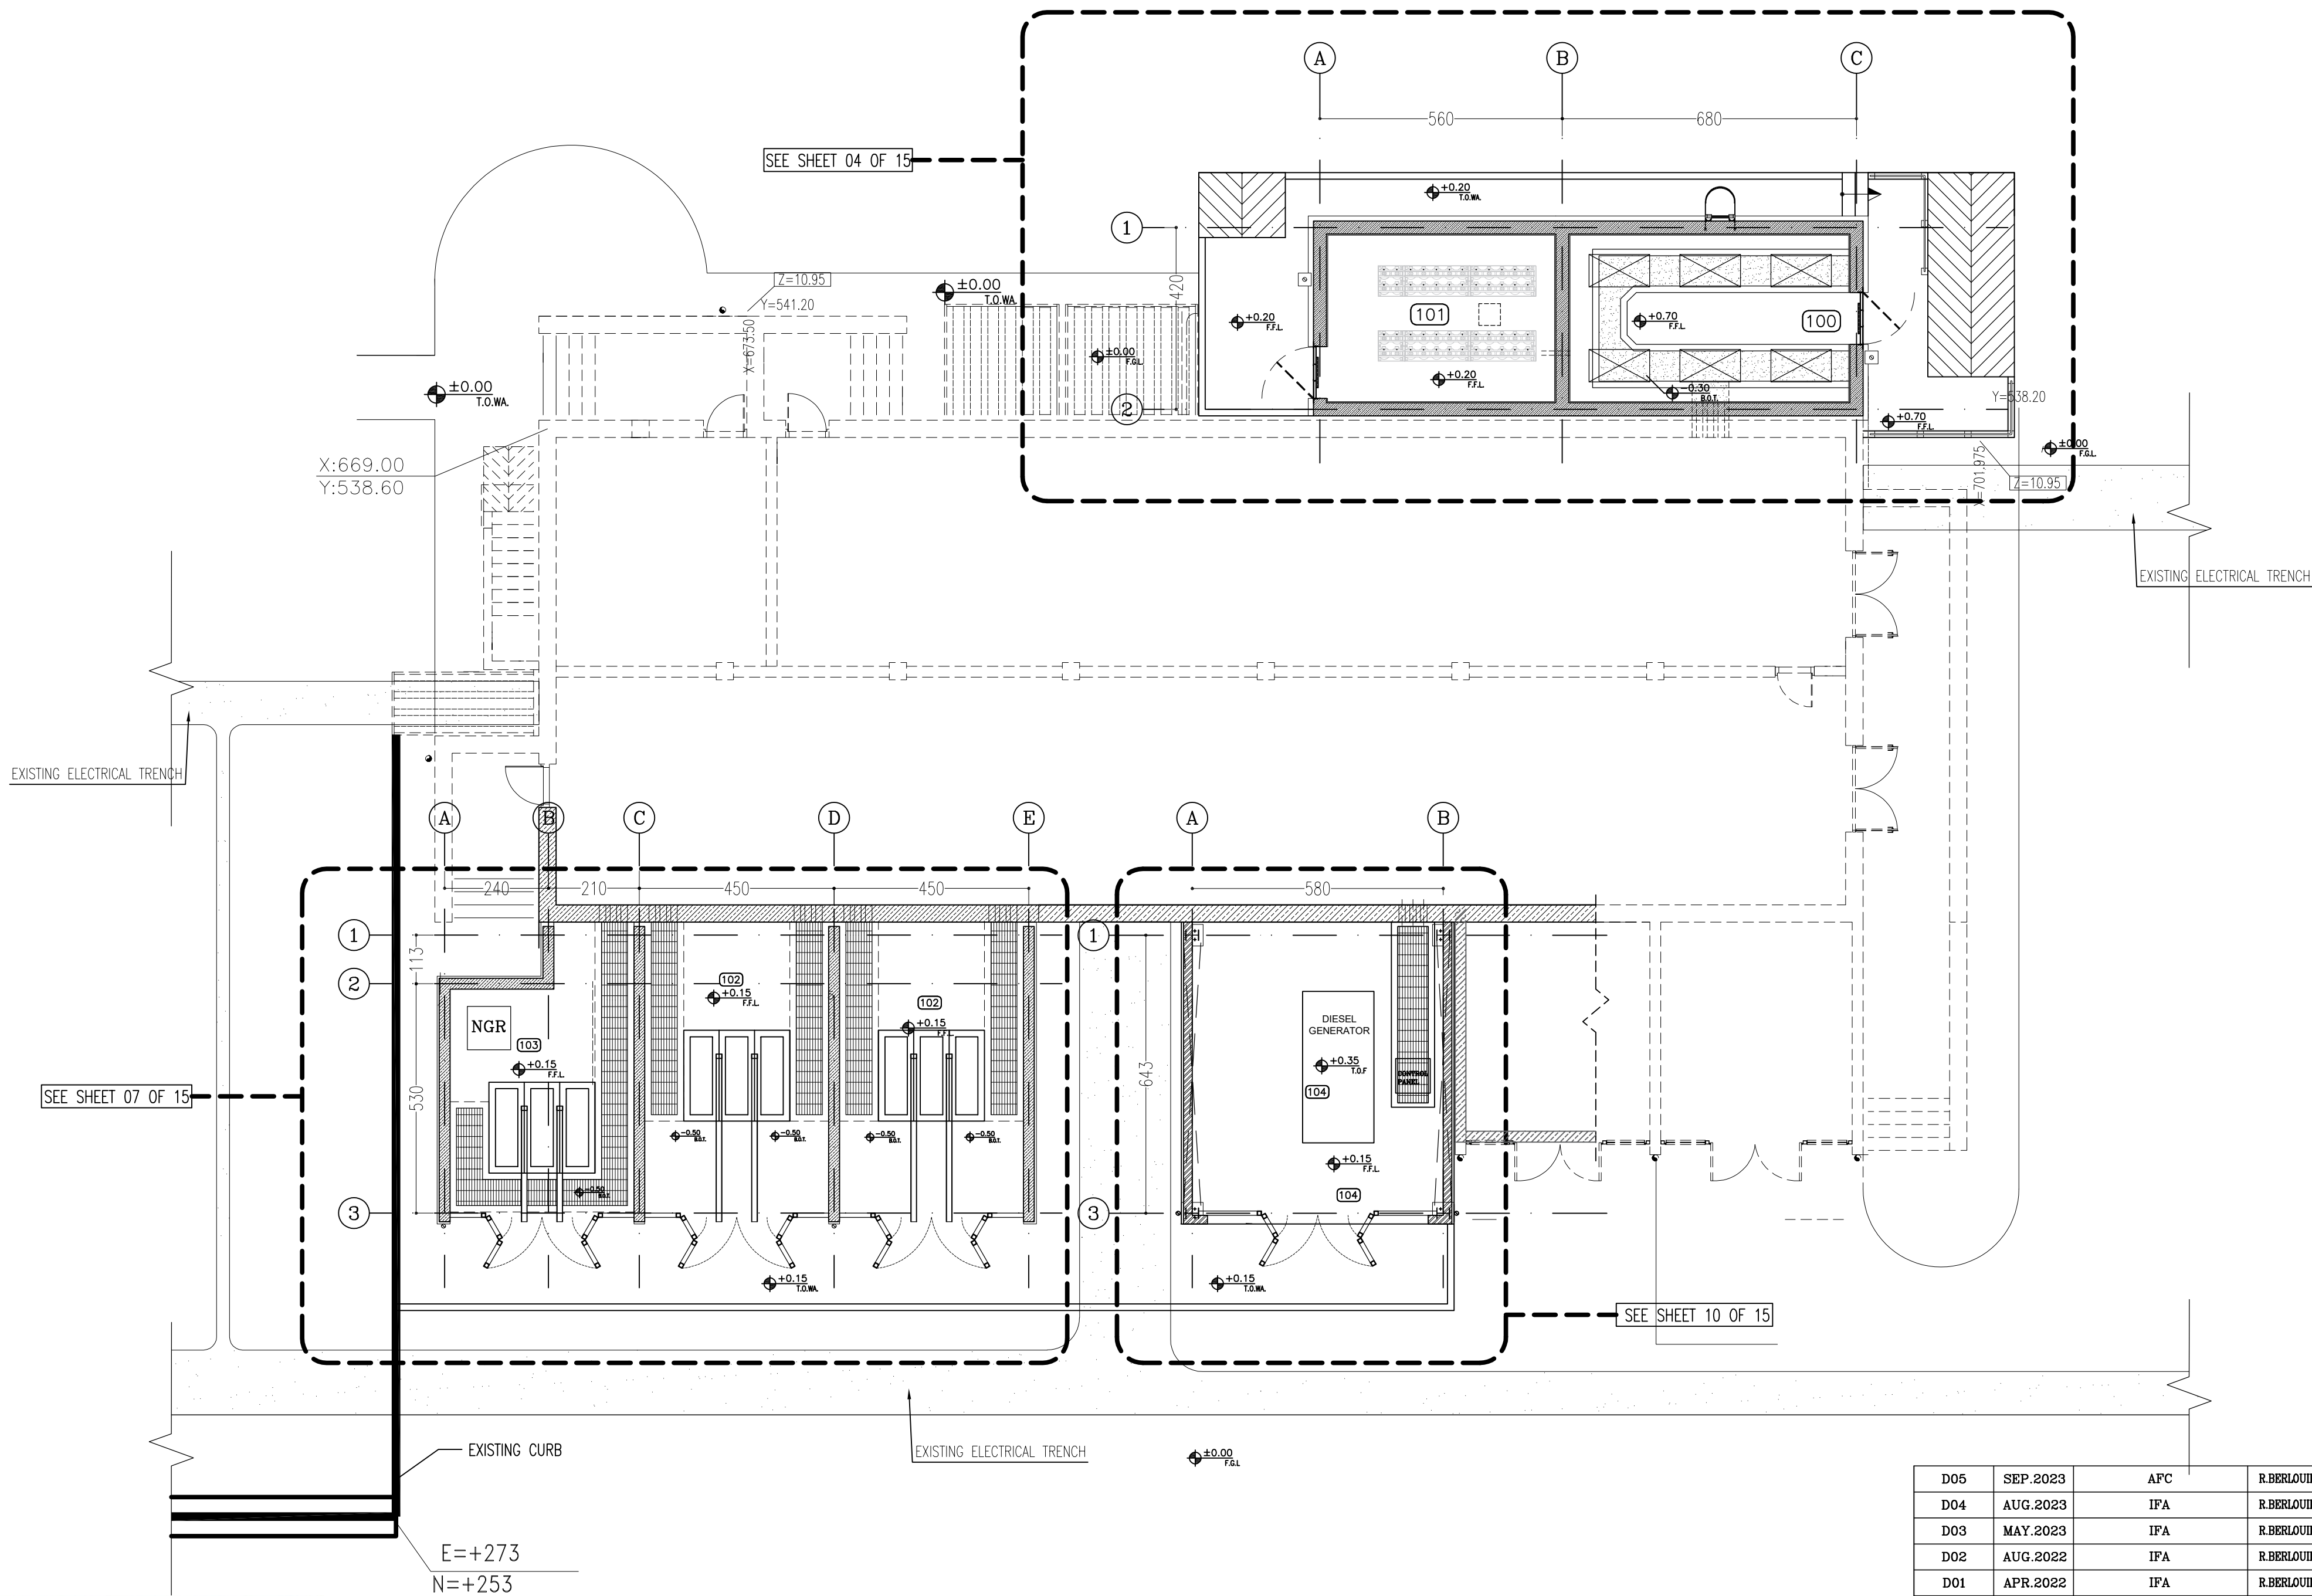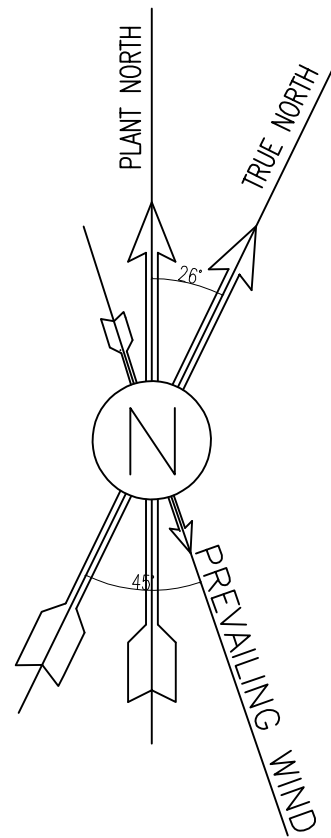

2 PLAN
SC.1:100

NOTES


1. ALL DIMENSIONS ARE IN CENTIMETER & ALL ELEVATIONS ARE IN METER.
2. ALL DIMENSIONS AND ELEVATIONS SHALL BE CHECKED BY THE CONTRACTOR PRIOR TO CONSTRUCTION.
3. CONTRACTOR SHALL COMPLY ALL ARCHITECTURAL, MECHANICAL, ELECTRICAL, PIPING AND STRUCTURAL DRAWINGS AND IN CASE OF ANY CONFLICTS OR DISCREPANCY, INFORM THE ENGINEER.
4. ALL MATERIALS ARE SELECTED FROM THE HIGHEST QUALITY AND MUST BE APPROVED BY THE CLIENT.
5. ALL OPENINGS FOR PIPING, CABLING AND HVAC OPENINGS SHALL BE CONSIDERED AS PER RELATED DRAWINGS BEFORE CONSTRUCTION.
6. ARCHITECTURAL DETAIL DESIGN WILL BE REVISED BASED ON APPROVED STRUCTURAL DRAWINGS.
7. ELEVATION CODE : LOCAL ±0.0m CORRESPONDS TO GLOBAL +11.10m

LEGEND



LEAN CONCRETE	
REINFORCED CONCRETE	
PRESSED BRICK	
STONE	
EXPANSION JOINT FILLER (PLASTOFOAM)	
TERRAZZO TILES FOR ROOF - 30x30cm	
BLOCKAGE	
F.F.L. FINISHED FLOOR	B.O.P. BOTTOM OF PIT
T.O.WA. TOP OF WALKWAY	F.G.L. FINISH GRADING LEVEL
T.O.P. TOP OF PARAPET	T.O.T. TOP OF TRENCH
T.O.FOU. TOP OF FOUNDATION	C.O.S. CENTER OF SLEEVE
M.D. METAL DOOR	B.O.S. BOTTOM OF SLEEVE
T.O.R. TOP OF ROOF	B.O.O. BOTTOM OF OPENING
T.O.D. TOP OF DOOR	B.O.T. BOTTOM OF TRENCH
B.O.Co. BOTTOM OF CAGE	B.O.P. BOTTOM OF PIT
T.O.Co. TOP OF CAGE	R.H.P. ROOF HIGHEST POINT
B.O.G. BOTTOM OF GUTTER	R.L.P. ROOF LOWEST POINT
T.O.Co. TOP OF CAGE	N.G.R. NEUTRAL GROUND RESISTOR
M.D. METAL DOOR	B.P.D. BLAST-PROOF DOOR
T.O.S. TOP OF SLAB	F.D. FENCE DOOR

REFERENCE DRAWING	DRG. No.
STANDARD DRAWING FOR ARCHITECTURAL DETAILS	BK-GNRL-PEDCO-000-AR-DW-0001
SITE SEWAGEAGE SYSTEM LAYOUT & DETAILS	BK-GCS-PEDCO-120-CY-PY-0001
CABLE TRENCH AND DUCT BANK LAYOUT	BK-GCS-PEDCO-120-CY-PY-0002
ROAD, PAVING AND PLANT FINISH GRADING LAYOUT & SECTIONS	BK-GCS-PEDCO-120-CY-PY-0005
ELECTRICAL CABLE ROUTE & SECTION LAYOUT FOR BUILDING & SHELTER	BK-GCS-PEDCO-120-EL-PY-0006
FOUNDATION DRAWING FOR EXTENSION OF EXISTING ELECT. BUILDING	BK-GCS-PEDCO-120-ST-DW-0063
STRUCTURAL DRAWING FOR EXTENSION OF EXISTING ELECT. BUILDING	BK-GCS-PEDCO-120-ST-DW-0064
STANDARD DETAILS FOR LADDER & SAFETY CAGE	BK-GNRL-PEDCO-000-ST-DW-0009
ELECTRICAL EQUIPMENT ARRANGEMENT LAYOUT FOR BUILDING	BK-GCS-PEDCO-120-ST-EL-PY-0008
Unit Plot Plan Drawing	BK-GCS-PEDCO-120-PI-PY-0001

KEY PLAN

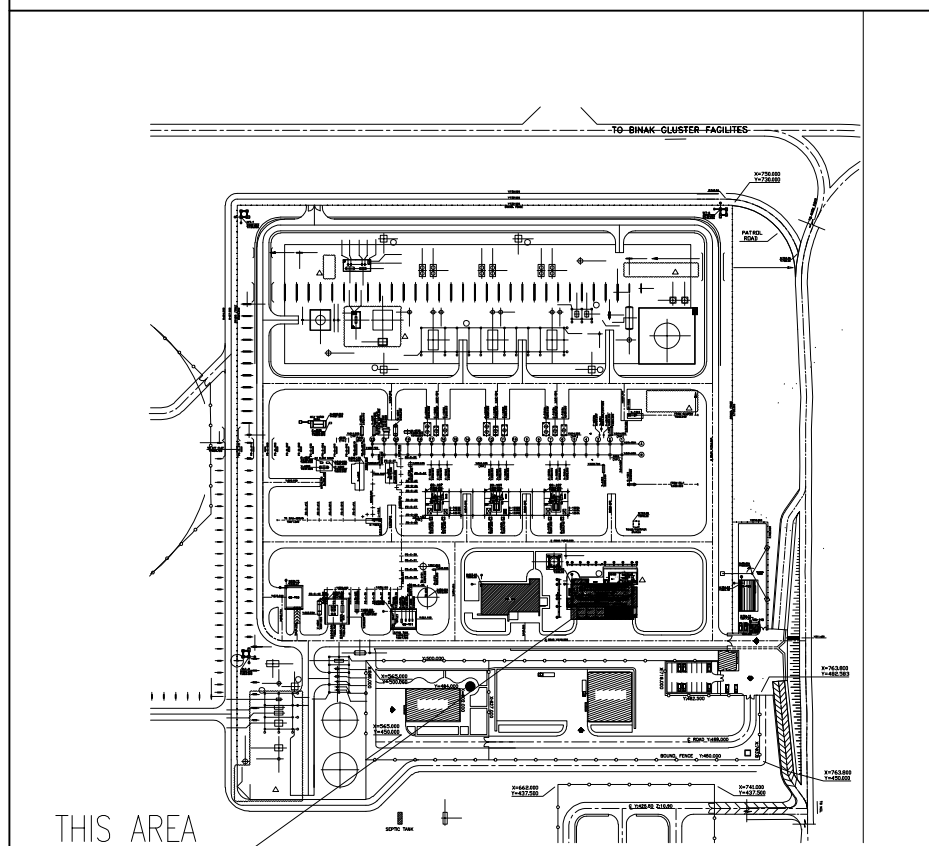



D05	SEP.2023	APC	R.BERLOUIE	M.PAKHARIAN	A.M.MOHSSENI	***												
D04	AUG.2023	IFA	R.BERLOUIE	M.PAKHARIAN	A.M.MOHSSENI	***												
D03	MAY.2023	IFA	R.BERLOUIE	M.PAKHARIAN	A.M.MOHSSENI	***												
D02	AUG.2022	IFA	R.BERLOUIE	M.PAKHARIAN	M.MEHRSHAD	***	***	*****	***	***	***	***	***	***	***			
D01	APR.2022	IFA	R.BERLOUIE	M.PAKHARIAN	M.MEHRSHAD	***	REV.	DESCRIPTION	BY	DATE	BY	DATE						
D00	JAN.2022	IPC	R.BERLOUIE	M.PAKHARIAN	M.MEHRSHAD	***			CHECKED		REV. APPR.							
REV.	DATE	P.O.I.S	PREP.	CHK.	APP.	AUT.	اصل و کلیه نسخ این نقشه و حق اقتباسی متعلق به شرکت ملی مناطق نفت خیز جنوب میباشد.											
PROJECT NAME:							BINAK OILFIELD DEVELOPMENT/SURFACE FACILITIES GAS COMPRESSOR STATION									 THE ORIGINAL AND ALL COPIES OF THIS DRAWING TOGETHER WITH THE COPYRIGHT THEREIN ARE THE SOLE PROPERTY OF N.I.S.O.C./ FIELDS		
PROJECT NO.:							971020											
EPC CONTRACTOR:			EPD/EPC CONTRACTOR (GC):				BINAK OILFIELD DEVELOPMENT SURFACE FACILITIES GAS COMPRESSOR STATION											
 HIRGAN ENERGY - DESIGN & INSPECTION COMPANIES			 PETROIRAN DEVELOPMENT COMPANY															
DRAWING TITLE:							NO CONSTRUCTION PERMITTED UNLESS DRAWING APPROVED											
ARCHITECTURAL DETAIL DRAWING FOR EXTENSION OF EXISTING ELECT. BUILDING PLANS							APPROVED FOR CONSTRUCTION			BY:		DATE:						
SCALE	SIZE	DRAWING NO.			SHEET NO.	REV.	BUDGET REF.	LOCATION	SIZE	CLASS	SERIAL NO.	SHEET	REVISION					
AS SHOWN	A1	BK-GCS-PEDCO-120-AR-DW-0002			02 OF 15	D05	053-073-0184	F	4	B	709100	02 OF 15	D05					

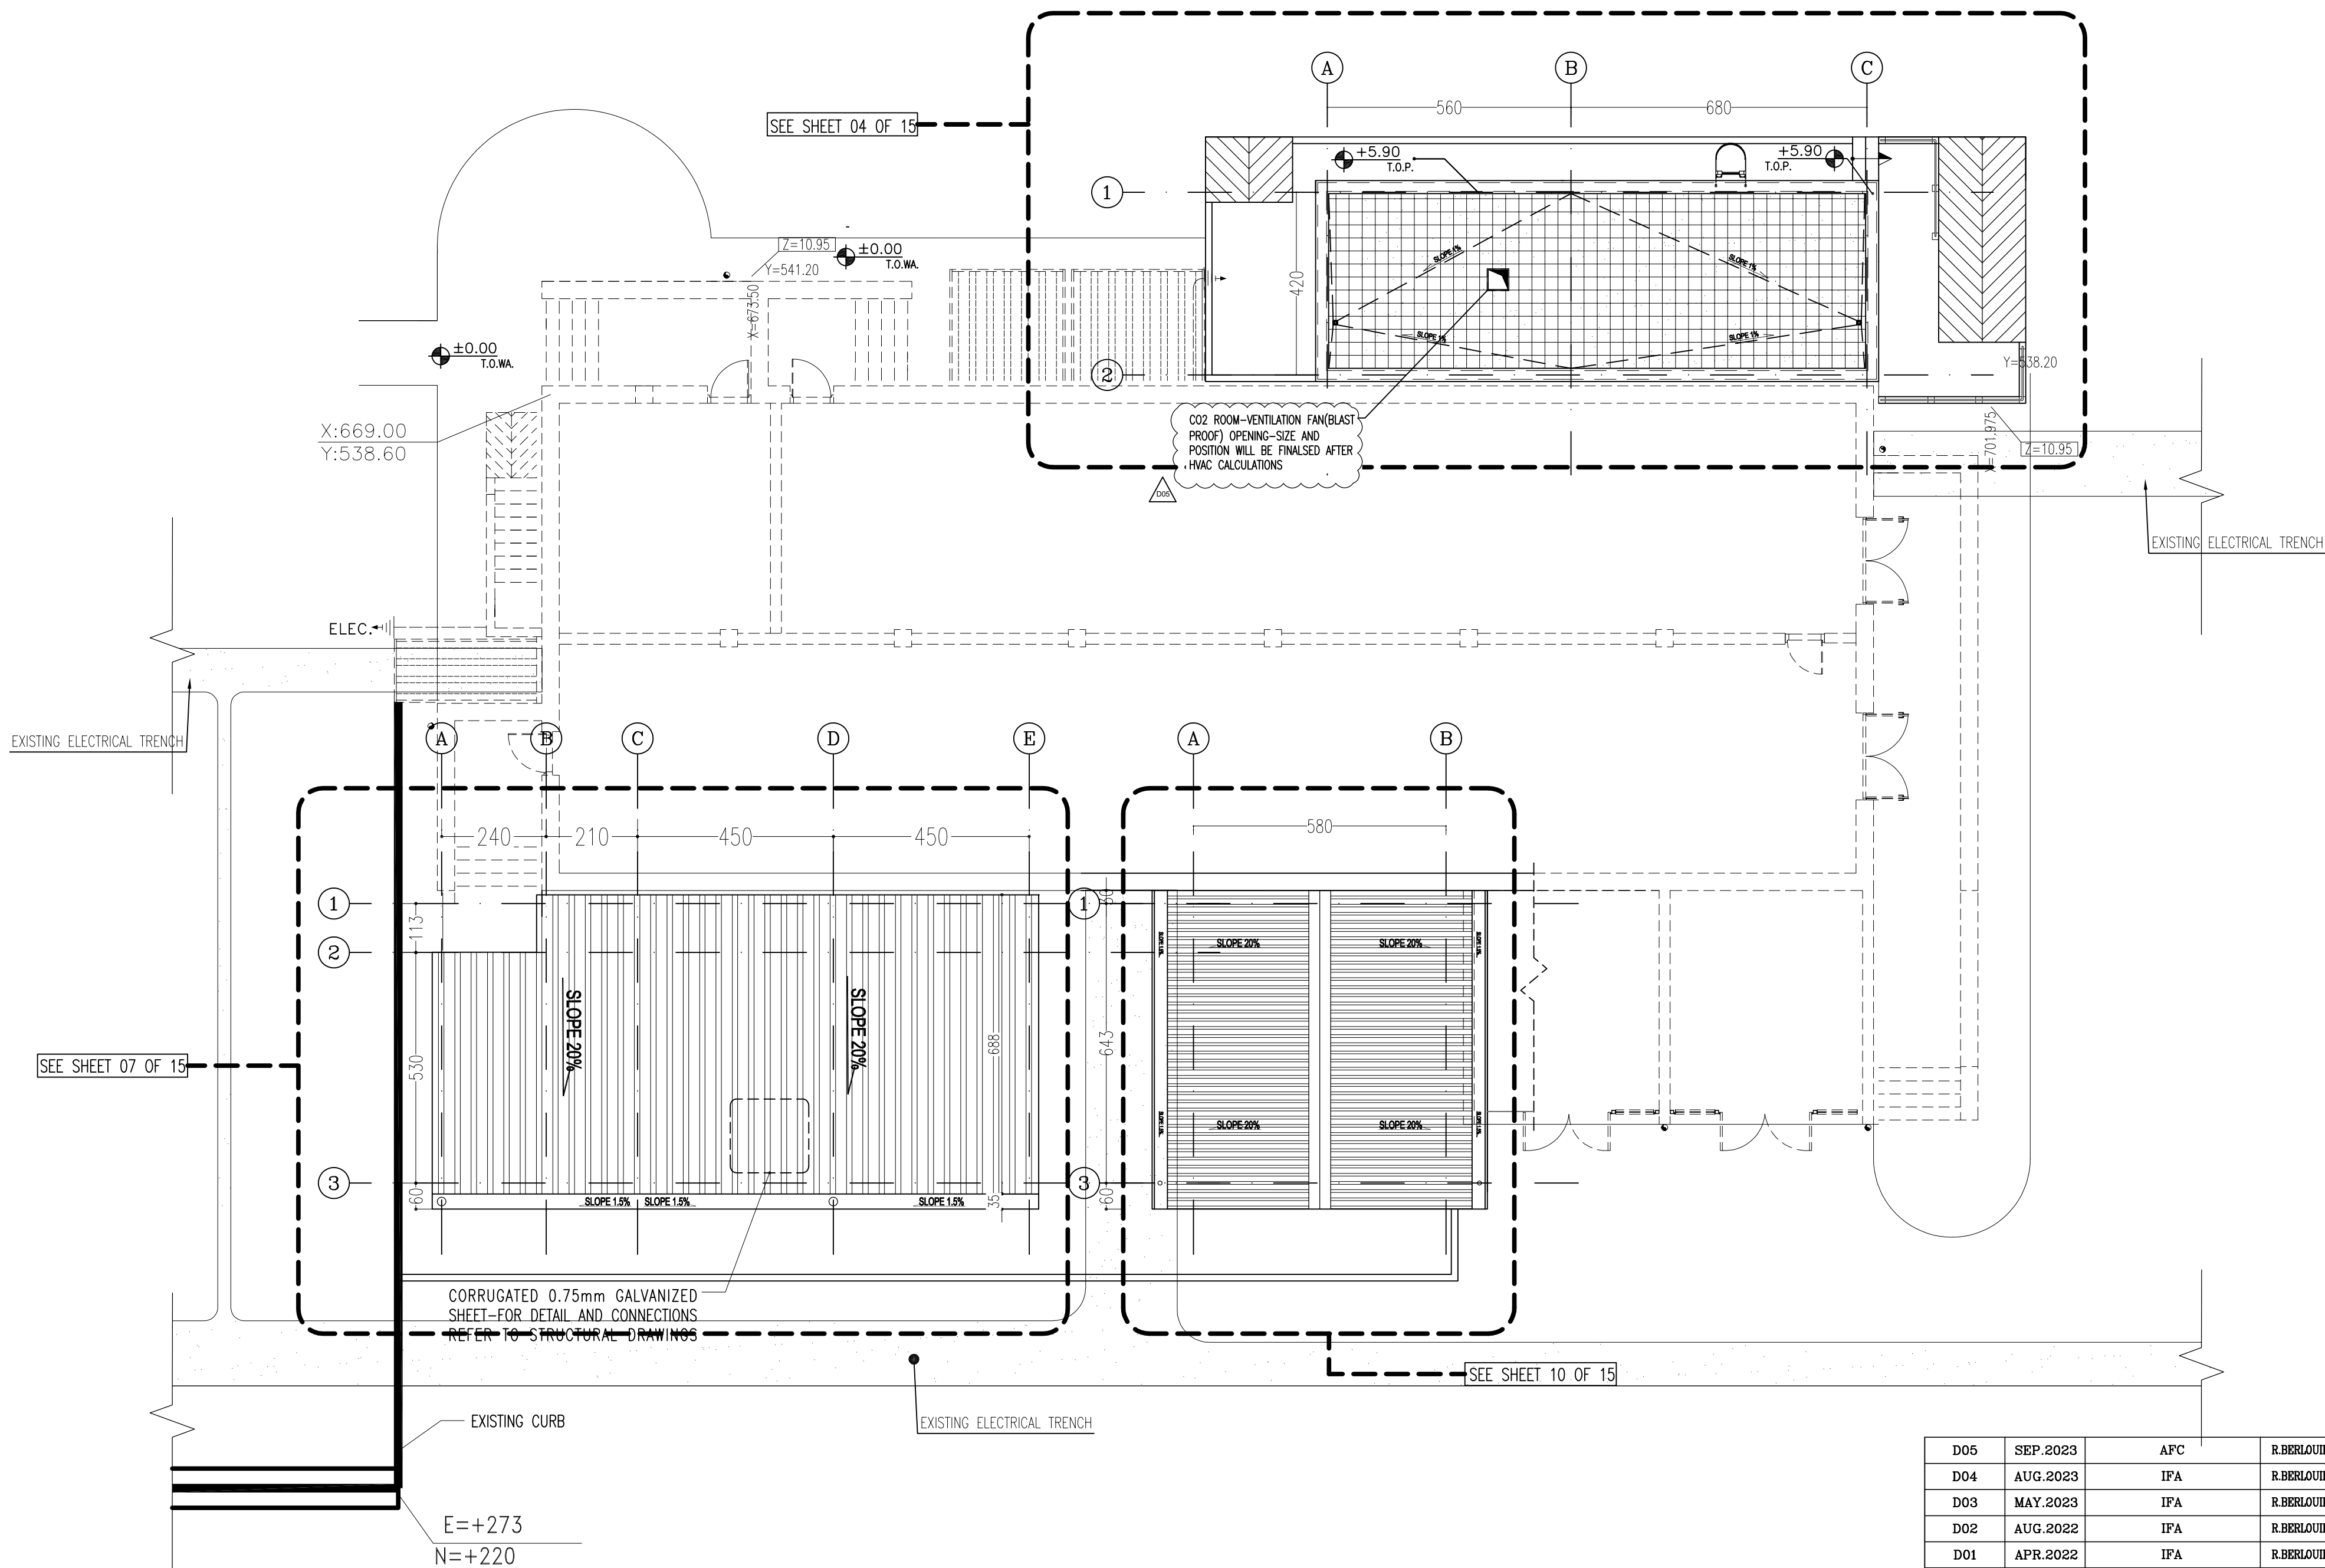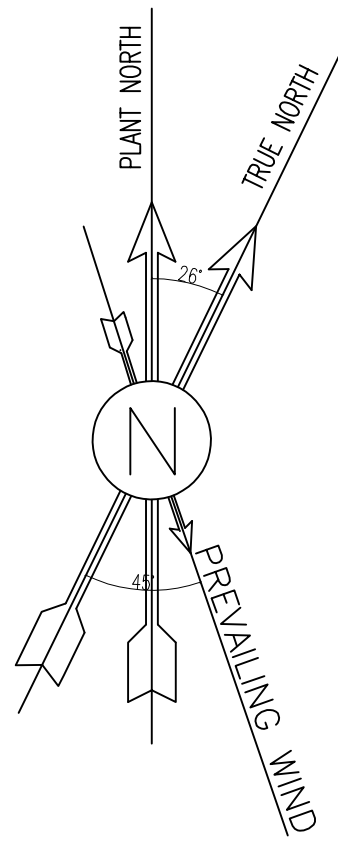

SC.1:100 3 ROOF PLAN


- NOTES
1. ALL DIMENSIONS ARE IN CENTIMETER & ALL ELEVATIONS ARE IN METER.
 2. ALL DIMENSIONS AND ELEVATIONS SHALL BE CHECKED BY THE CONTRACTOR PRIOR TO CONSTRUCTION.
 3. CONTRACTOR SHALL COMPILE ALL ARCHITECTURAL, MECHANICAL, ELECTRICAL, PIPING AND STRUCTURAL DRAWINGS AND IN CASE OF ANY CONFLICTS OR DISCREPANCY, INFORM THE ENGINEER.
 4. ALL MATERIALS ARE SELECTED FROM THE HIGHEST QUALITY AND MUST BE APPROVED BY THE CLIENT.
 5. ALL OPENINGS FOR PIPING, CABLEING AND HVAC OPENINGS SHALL BE CONSIDERED AS PER RELATED DRAWINGS BEFORE CONSTRUCTION.
 6. ARCHITECTURAL DETAIL DESIGN WILL BE REVISED BASED ON APPROVED STRUCTURAL DRAWINGS.
 7. ELEVATION CODE : LOCAL ±0.0m CORRESPONDS TO GLOBAL +11.10m

  LEGEND

LEAN CONCRETE			
REINFORCED CONCRETE			
PRESSED BRICK			
STONE			
EXPANSION JOINT FILLER (PLASTOFOAM)			
TERRAZZO TILES FOR ROOF - 30x30cm			
BLOCKAGE			
F.F.L.	FINISHED FLOOR	B.O.P.	BOTTOM OF PIT
T.O.WA	TOP OF WALKWAY	F.G.L.	FINISH GRADING LEVEL
T.O.P.	TOP OF PARAPET	T.O.T.	TOP OF TRENCH
T.O.FOU.	TOP OF FOUNDATION	C.O.S.	CENTER OF SLEEVE
M.D	METAL DOOR	B.O.S.	BOTTOM OF SLEEVE
T.O.R.	TOP OF ROOF	B.O.O.	BOTTOM OF OPENING
T.O.D.	TOP OF DOOR	B.O.T.	BOTTOM OF TRENCH
B.O.Co.	BOTTOM OF CAGE	B.O.P.	BOTTOM OF PIT
T.O.Co.	TOP OF CAGE	R.H.P.	ROOF HIGHEST POINT
B.O.G.	BOTTOM OF GUTTER	R.L.P.	ROOF LOWEST POINT
T.O.Co.	TOP OF CAGE	N.G.R.	NEUTRAL GROUND RESISTOR
M.D.	METAL DOOR	B.P.D.	BLAST-PROOF DOOR
T.O.S.	TOP OF SLAB	F.D.	FENCE DOOR

REFERENCE DRAWING	DRG. No.
STANDARD DRAWING FOR ARCHITECTURAL DETAILS	BK-GNRL-PEDCO-000-AR-DW-0001
SITE SEWAGEAGE SYSTEM LAYOUT & DETAILS	BK-GCS-PEDCO-120-CY-PY-0001
CABLE TRENCH AND DUCT BANK LAYOUT	BK-GCS-PEDCO-120-CY-PY-0002
ROAD, PAVING AND PLANT FINISH GRADING LAYOUT & SECTIONS	BK-GCS-PEDCO-120-CY-PY-0005
ELECTRICAL CABLE ROUTE & SECTION LAYOUT FOR BUILDING & SHELTER	BK-GCS-PEDCO-120-EL-PY-0006
FOUNDATION DRAWING FOR EXTENSION OF EXISTING ELECT. BUILDING	BK-GCS-PEDCO-120-ST-DW-0063
STRUCTURAL DRAWING FOR EXTENSION OF EXISTING ELECT. BUILDING	BK-GCS-PEDCO-120-ST-DW-0064
STANDARD DETAILS FOR LADDER & SAFETY CAGE	BK-GNRL-PEDCO-000-ST-DW-0009
ELECTRICAL EQUIPMENT ARRANGEMENT LAYOUT FOR BUILDING	BK-GCS-PEDCO-120-ST-EL-PY-0008
Unit Plot Plan Drawing	BK-GCS-PEDCO-120-PI-PY-0001

KEY PLAN

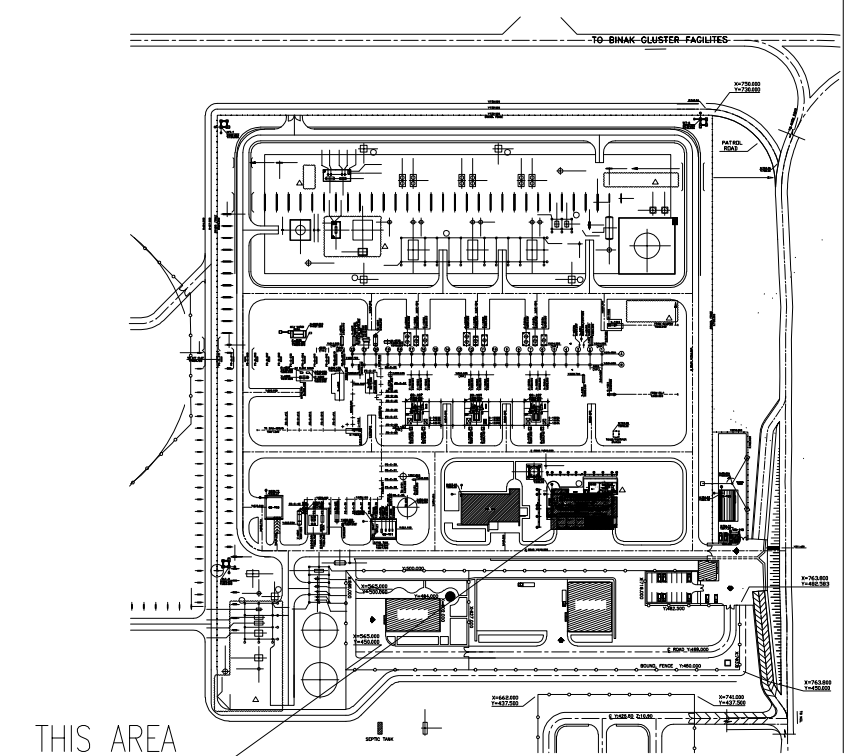

D05	SEP.2023	APC	R.BERLOUIE	M.PAKHARIAN	A.M.MOHSSENI	***																											
D04	AUG.2023	IFA	R.BERLOUIE	M.PAKHARIAN	A.M.MOHSSENI	***																											
D03	MAY.2023	IFA	R.BERLOUIE	M.PAKHARIAN	A.M.MOHSSENI	***																											
D02	AUG.2022	IFA	R.BERLOUIE	M.PAKHARIAN	M.MEHRSHAD	***	***	*****	***	***	*****	***	*****	***	*****	***	*****	***	*****														
D01	APR.2022	IFA	R.BERLOUIE	M.PAKHARIAN	M.MEHRSHAD	***	REV.	DESCRIPTION	BY	DATE	BY	DATE	REV.	APPR.																			
D00	JAN.2022	IPC	R.BERLOUIE	M.PAKHARIAN	M.MEHRSHAD	***			CHECKED																								
REV.	DATE	P.O.I.S	PREP.	CHK.	APP.	AUT.	اصل و کلیه نسخ این نقشه و حق اقتباس متعلق به شرکت ملی مناطق نفت خیز جنوب می باشد.																										
PROJECT NAME:						BINAK OILFIELD DEVELOPMENT/SURFACE FACILITIES GAS COMPRESSOR STATION																											
PROJECT NO.:						971020																											
EPC CONTRACTOR:						EPD/EPC CONTRACTOR (GC):																											
 HIRGAN ENERGY - DESIGN & INSPECTION COMPANIES												 PETROIRAN DEVELOPMENT COMPANY						BINAK OILFIELD DEVELOPMENT SURFACE FACILITIES GAS COMPRESSOR STATION															
																		DATE	SCALE	DRAWING BY	CHECKED BY	PROJECT ENG.											
DRAWING TITLE:						ARCHITECTURAL DETAIL DRAWING FOR EXTENSION OF EXISTING ELECT. BUILDING ROOF PLANS													NO CONSTRUCTION PERMITTED UNLESS DRAWING APPROVED														
SCALE						SIZE						DRAWING NO.						SHEET NO.		REV.	APPROVED FOR CONSTRUCTION				BY:		DATE:						
AS SHOWN		A1		BK-GCS-PEDCO-120-AR-DW-0002		03 OF 15		D05		053-073-0184		F		4		B		709100		03 OF 15		D05											

اصل و کلیه نسخ این نقشه و حق اقتباس متعلق به شرکت ملی مناطق نفت خیز جنوب می باشد.



THE ORIGINAL AND ALL COPIES OF THIS DRAWING TOGETHER WITH THE COPYRIGHT THEREIN ARE THE SOLE PROPERTY OF N.I.S.O.C./ FIELDS

BINAK OILFIELD DEVELOPMENT SURFACE FACILITIES GAS COMPRESSOR STATION

DATE	SCALE	DRAWING BY	CHECKED BY	PROJECT ENG.
------	-------	------------	------------	--------------

NO CONSTRUCTION PERMITTED UNLESS DRAWING APPROVED

APPROVED FOR CONSTRUCTION	BY:	DATE:
---------------------------	-----	-------

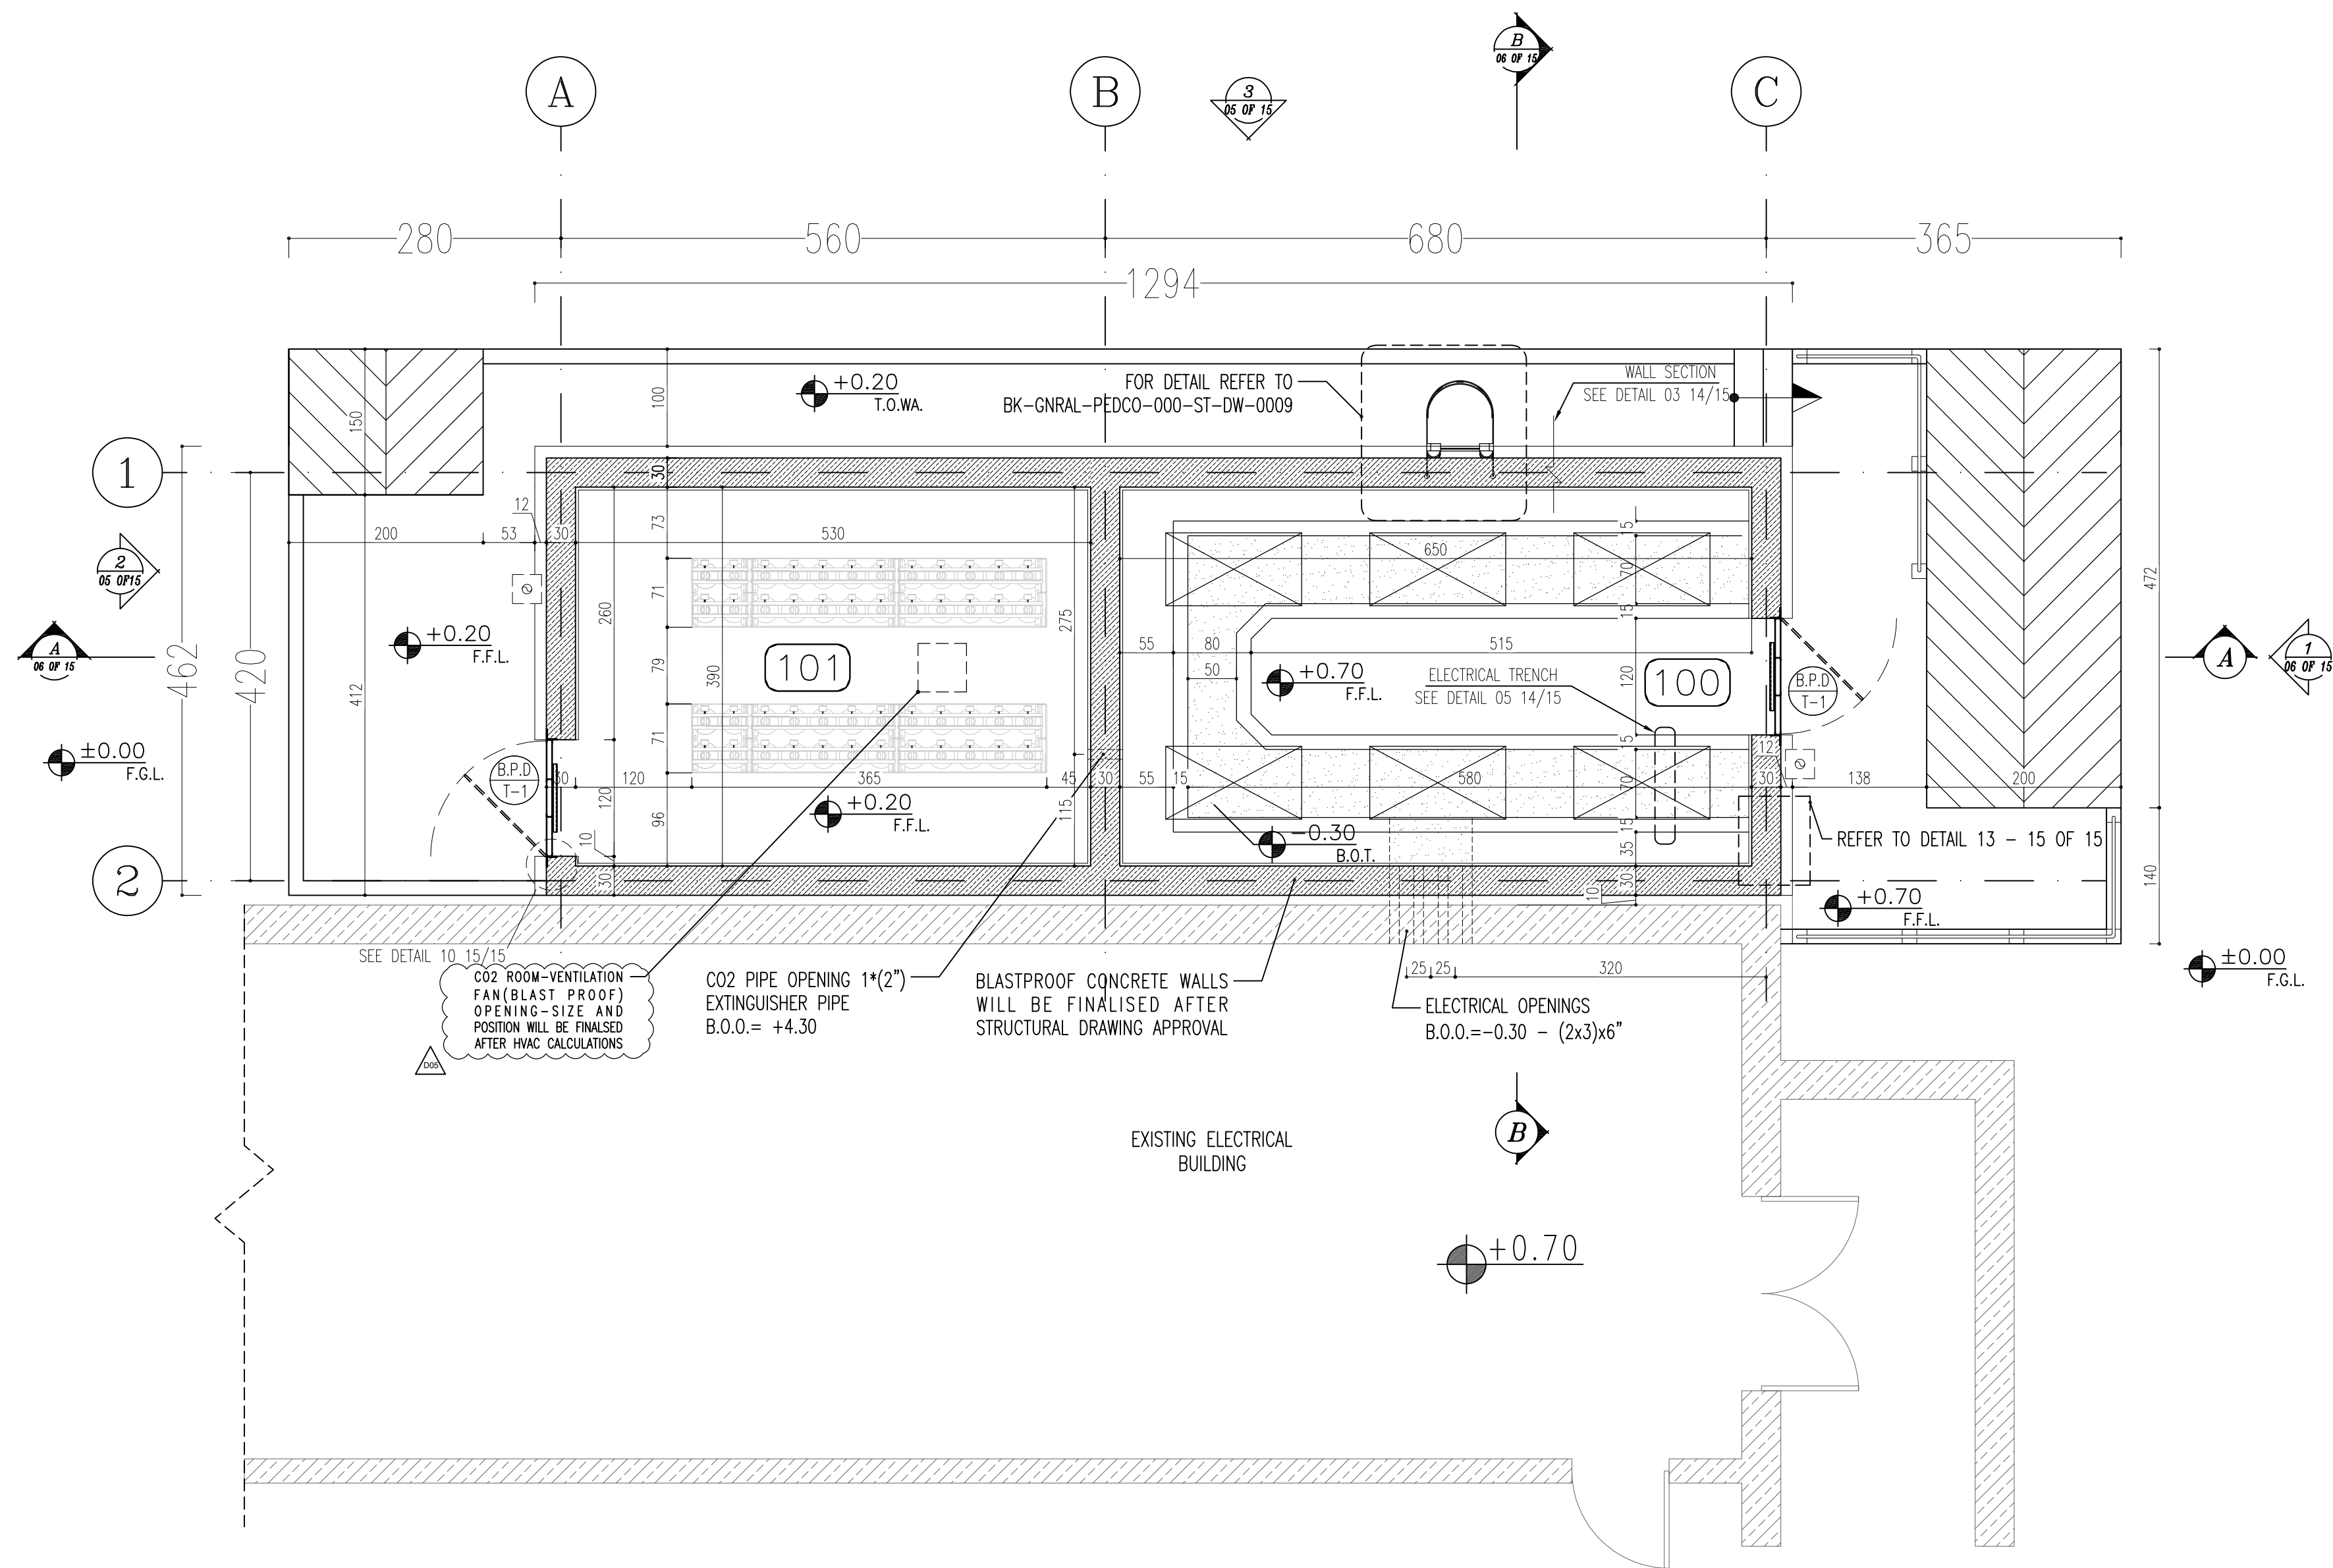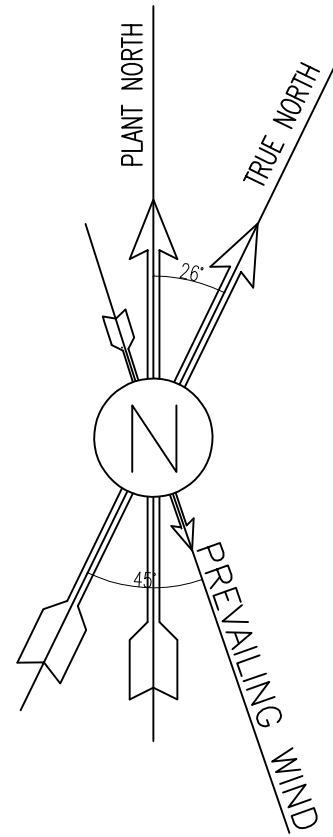

SC.1:50 4 CAPACITOR BANK AND CO2 ROOM PLAN

SPACE TAG	AREA
100	32m ²
101	25m ²
102	32m ² + 32m ²
103	29m ²
104	27m ²
TOTAL	174m ²


SPACE TAG NUMBER

- 100 CAPACITOR BANK
- 101 CO2 ROOM
- 102 TRANSFORMER ROOM
- 103 FIRE-FIGHTING PUMP TRANSFORMER ROOM
- 104 DIESEL ROOM




NOTES			
1. ALL DIMENSIONS ARE IN CENTIMETER & ALL ELEVATIONS ARE IN METER. 2. ALL DIMENSIONS AND ELEVATIONS SHALL BE CHECKED BY THE CONTRACTOR PRIOR TO CONSTRUCTION. 3. CONTRACTOR SHALL COMPLY ALL ARCHITECTURAL, MECHANICAL, ELECTRICAL, PIPING AND STRUCTURAL DRAWINGS AND IN CASE OF ANY CONFLICTS OR DISCREPANCY, INFORM THE ENGINEER. 4. ALL MATERIALS ARE SELECTED FROM THE HIGHEST QUALITY AND MUST BE APPROVED BY THE CLIENT. 5. ALL OPENINGS FOR PIPING, CABLEING AND HVAC OPENINGS SHALL BE CONSIDERED AS PER RELATED DRAWINGS BEFORE CONSTRUCTION. 6. ARCHITECTURAL DETAIL DESIGN WILL BE REVISED BASED ON APPROVED STRUCTURAL DRAWINGS. 7. ELEVATION CODE : LOCAL ±0.0m CORRESPONDS TO GLOBAL +11.10m			
LEGEND			
LEAN CONCRETE			
REINFORCED CONCRETE			
PRESSED BRICK			
STONE			
EXPANSION JOINT FILLER (PLASTOFOAM)			
TERRAZZO TILES FOR ROOF - 30x30cm			
BLOCKAGE			
F.F.L.	FINISHED FLOOR	B.O.P.	BOTTOM OF PIT
T.O.WA	TOP OF WALKWAY	F.G.L.	FINISH GRADING LEVEL
T.O.P.	TOP OF PARAPET	T.O.T.	TOP OF TRENCH
T.O.FOU.	TOP OF FOUNDATION	C.O.S.	CENTER OF SLEEVE
M.D	METAL DOOR	B.O.S.	BOTTOM OF SLEEVE
T.O.R.	TOP OF ROOF	B.O.O.	BOTTOM OF OPENING
T.O.D.	TOP OF DOOR	B.O.T.	BOTTOM OF TRENCH
B.O.Co.	BOTTOM OF CAGE	B.O.P.	BOTTOM OF PIT
T.O.Co.	TOP OF CAGE	R.H.P.	ROOF HIGHEST POINT
B.O.G.	BOTTOM OF GUTTER	R.L.P.	ROOF LOWEST POINT
T.O.Co.	TOP OF CAGE	N.G.R.	NEUTRAL GROUND RESISTOR
M.D.	METAL DOOR	B.P.D.	BLAST-PROOF DOOR
T.O.S.	TOP OF SLAB	F.D.	FENCE DOOR

REFERENCE DRAWING	DRG. No.
STANDARD DRAWING FOR ARCHITECTURAL DETAILS	BK-GNRL-PEDCO-000-AR-DW-0001
SITE SEWAGEAGE SYSTEM LAYOUT & DETAILS	BK-GCS-PEDCO-120-CV-PY-0001
CABLE TRENCH AND DUCT BANK LAYOUT	BK-GCS-PEDCO-120-CV-PY-0002
ROAD, PAVING AND PLANT FINISH GRADING LAYOUT & SECTIONS	BK-GCS-PEDCO-120-CV-PY-0005
ELECTRICAL CABLE ROUTE & SECTION LAYOUT FOR BUILDING & SHELTER	BK-GCS-PEDCO-120-EL-PY-0006
FOUNDATION DRAWING FOR EXTENSION OF EXISTING ELECT. BUILDING	BK-GCS-PEDCO-120-ST-DW-0063
STRUCTURAL DRAWING FOR EXTENSION OF EXISTING ELECT. BUILDING	BK-GCS-PEDCO-120-ST-DW-0064
STANDARD DETAILS FOR LADDER & SAFETY CAGE	BK-GNRL-PEDCO-000-ST-DW-0009
ELECTRICAL EQUIPMENT ARRANGEMENT LAYOUT FOR BUILDING	BK-GCS-PEDCO-120-ST-EL-PY-0008
Unit Plot Plan Drawing	BK-GCS-PEDCO-120-PI-PY-0001

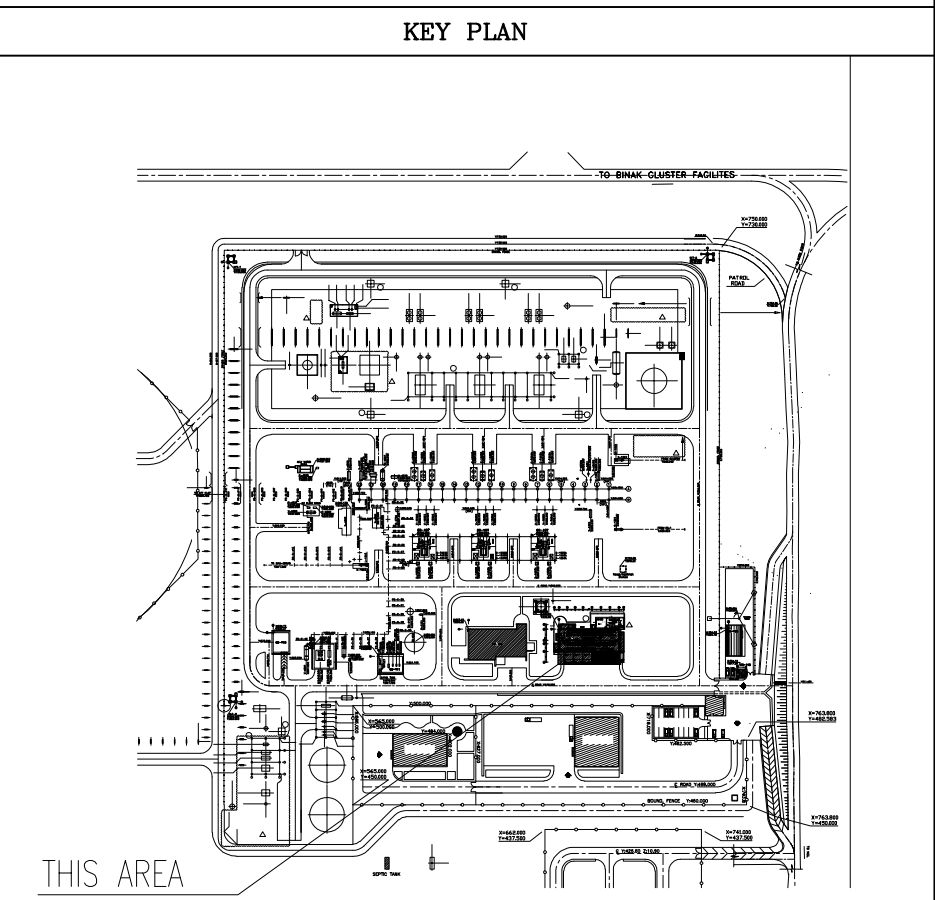

D05	SEP.2023	APC	R.BERLOUIE	M.PAKHARIAN	A.M.MOHSSENI	***													
D04	AUG.2023	IFA	R.BERLOUIE	M.PAKHARIAN	A.M.MOHSSENI	***													
D03	MAY.2023	IFA	R.BERLOUIE	M.PAKHARIAN	A.M.MOHSSENI	***													
D02	AUG.2022	IFA	R.BERLOUIE	M.PAKHARIAN	M.MEHRSHAD	***	***	*****	***	*****	***	*****	***	*****	***	*****	***	*****	***
D01	APR.2022	IFA	R.BERLOUIE	M.PAKHARIAN	M.MEHRSHAD	***													
D00	JAN.2022	IPC	R.BERLOUIE	M.PAKHARIAN	M.MEHRSHAD	***													
REV.	DATE	P.O.I.S	PREP.	CHK.	APP.	AUT.	اسم و کلیه نسخ این نقشه و حق افشای متعلق به شرکت ملی مناطق نفت خیز جنوب میباشد.												
PROJECT NAME:							THE ORIGINAL AND ALL COPIES OF THIS DRAWING TOGETHER WITH THE COPYRIGHT THEREIN ARE THE SOLE PROPERTY OF N.I.S.O.C./ FIELDS												
PROJECT NO.:							971020												
EPC CONTRACTOR:							EPD/EPC CONTRACTOR (GC):							BINAK OILFIELD DEVELOPMENT SURFACE FACILITIES GAS COMPRESSOR STATION					
 HIRGAN ENERGY - DESIGN & INSPECTION COMPANIES							 PETROIRAN DEVELOPMENT COMPANY							DATE	SCALE	DRAWING BY	CHECKED BY	PROJECT ENG.	
DRAWING TITLE:							NO CONSTRUCTION PERMITTED UNLESS DRAWING APPROVED												
ARCHITECTURAL DETAIL DRAWING FOR EXTENSION OF EXISTING ELECT. BUILDING PLAN							APPROVED FOR CONSTRUCTION												
SCALE	SIZE	DRAWING NO.			SHEET NO.	REV.	BUDGET REF.	LOCATION	SIZE	CLASS	SERIAL NO.	SHEET	REVISION						
AS SHOWN	A1	BK-GCS-PEDCO-120-AR-DW-0002			04 OF 15	D05	053-073-0184	F	4	B	709100	04 OF 15	D05						

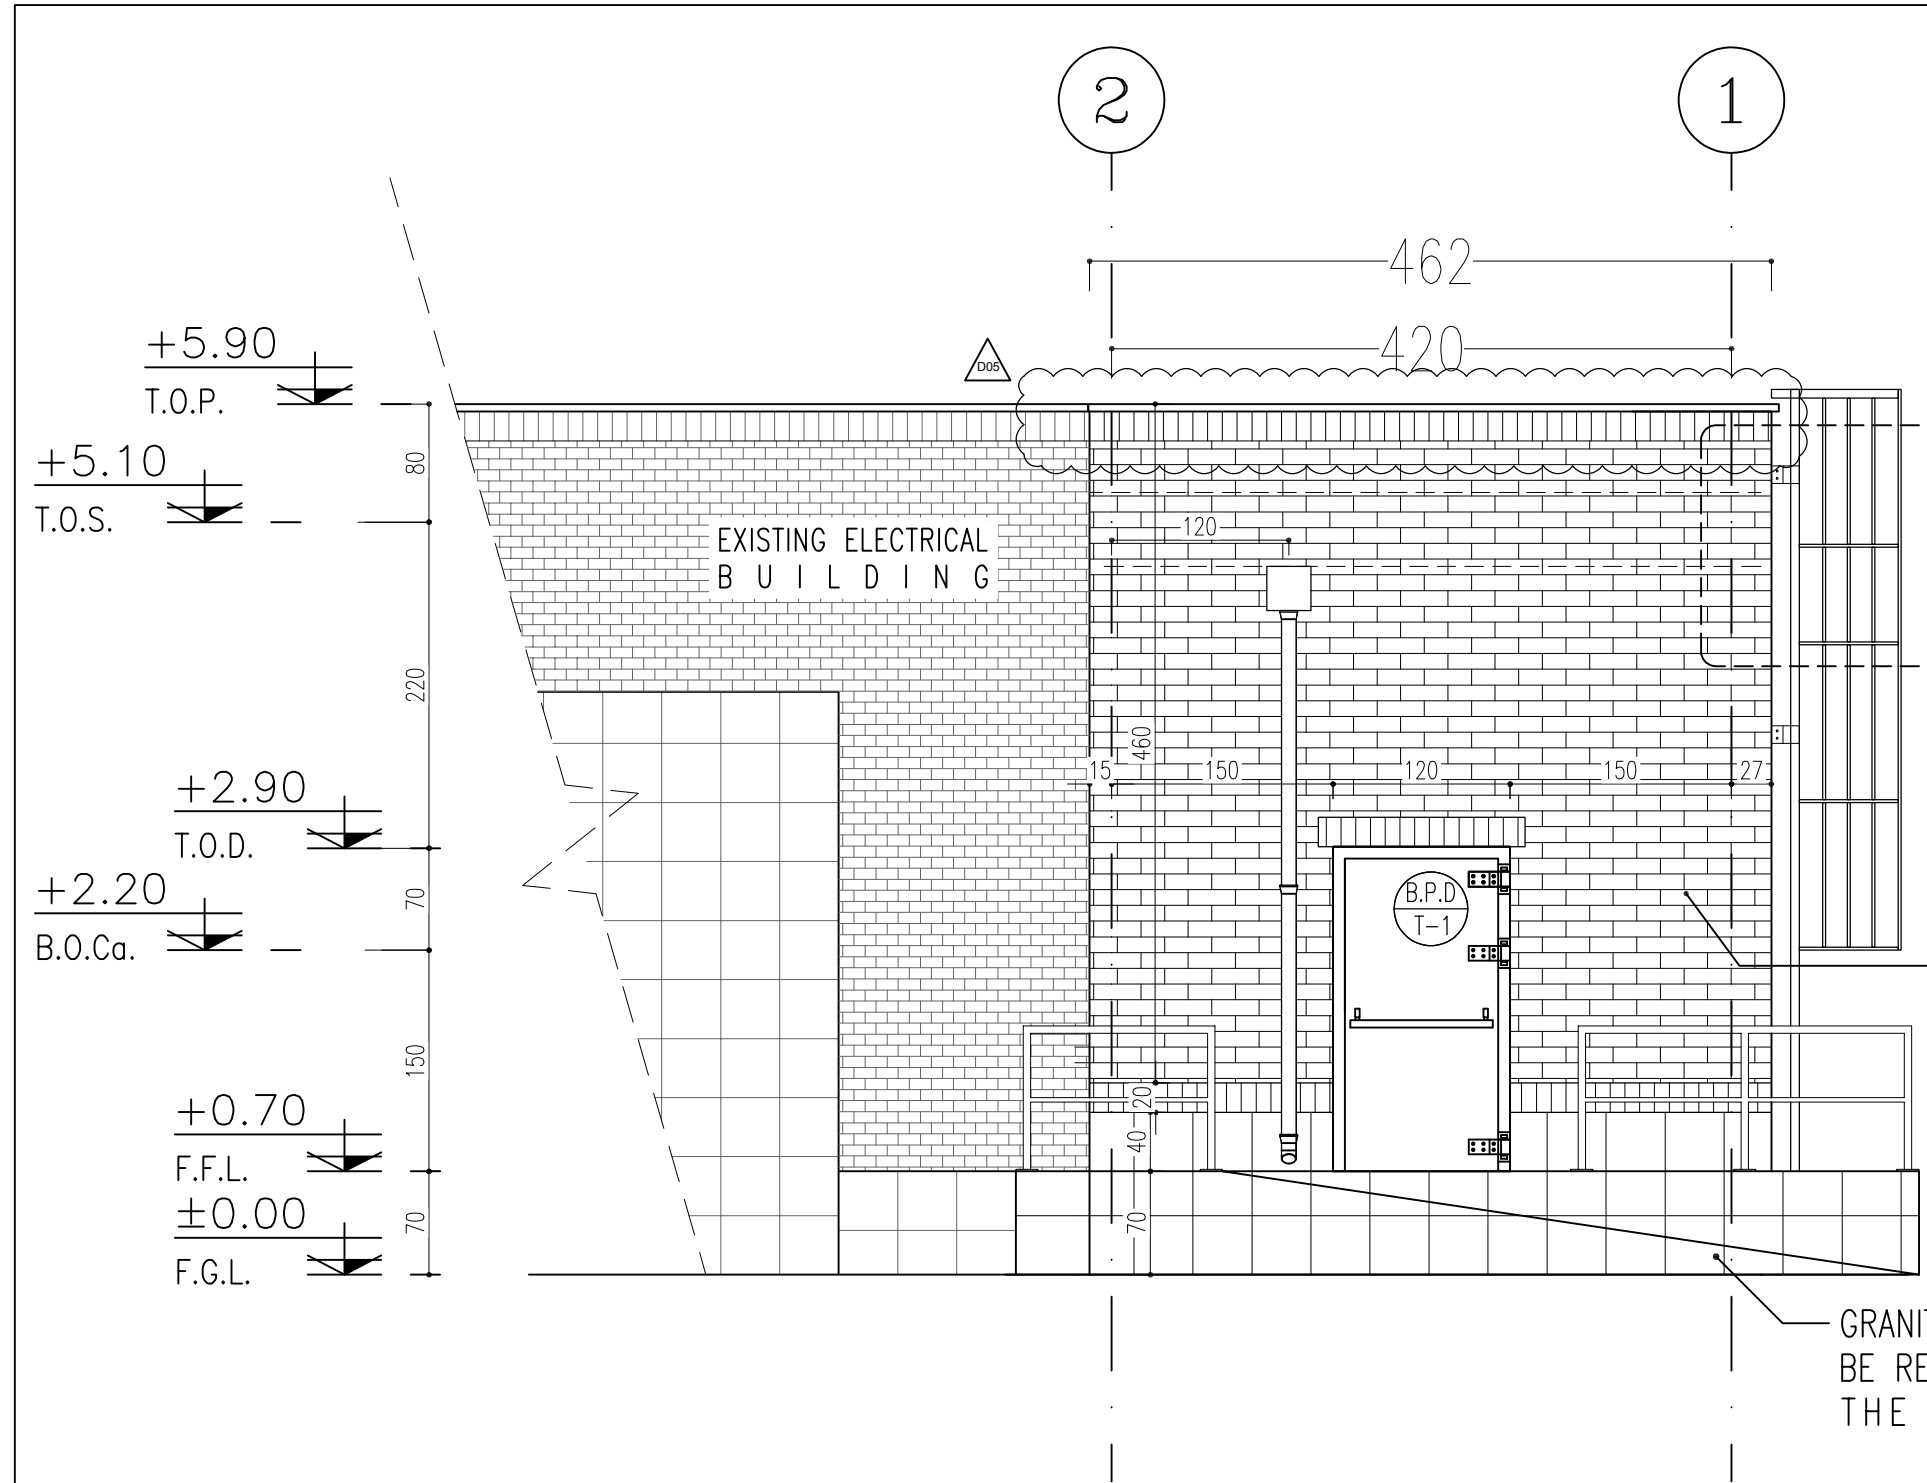


1 ELEVATION
SC.1:50 04 OF 15

REFER TO STANDARD
DRAWING FOR LADDER
AND SAFETY CAGE
BK-GNRL-PEDCO-000-ST-DW-0009-D02

REFER TO STANDARD
DRAWING FOR LADDER
AND SAFETY CAGE
BK-GNRL-PEDCO-000-ST-DW-0009-D02

FACADE FINE BRICK-SHALL
BE READ IN CONJUNCTION
WITH EXISTING BUILDING


GRANITE DARK SKIRTING-SHALL
BE READ IN CONJUNCTION WITH
THE EXISTING BUILDING

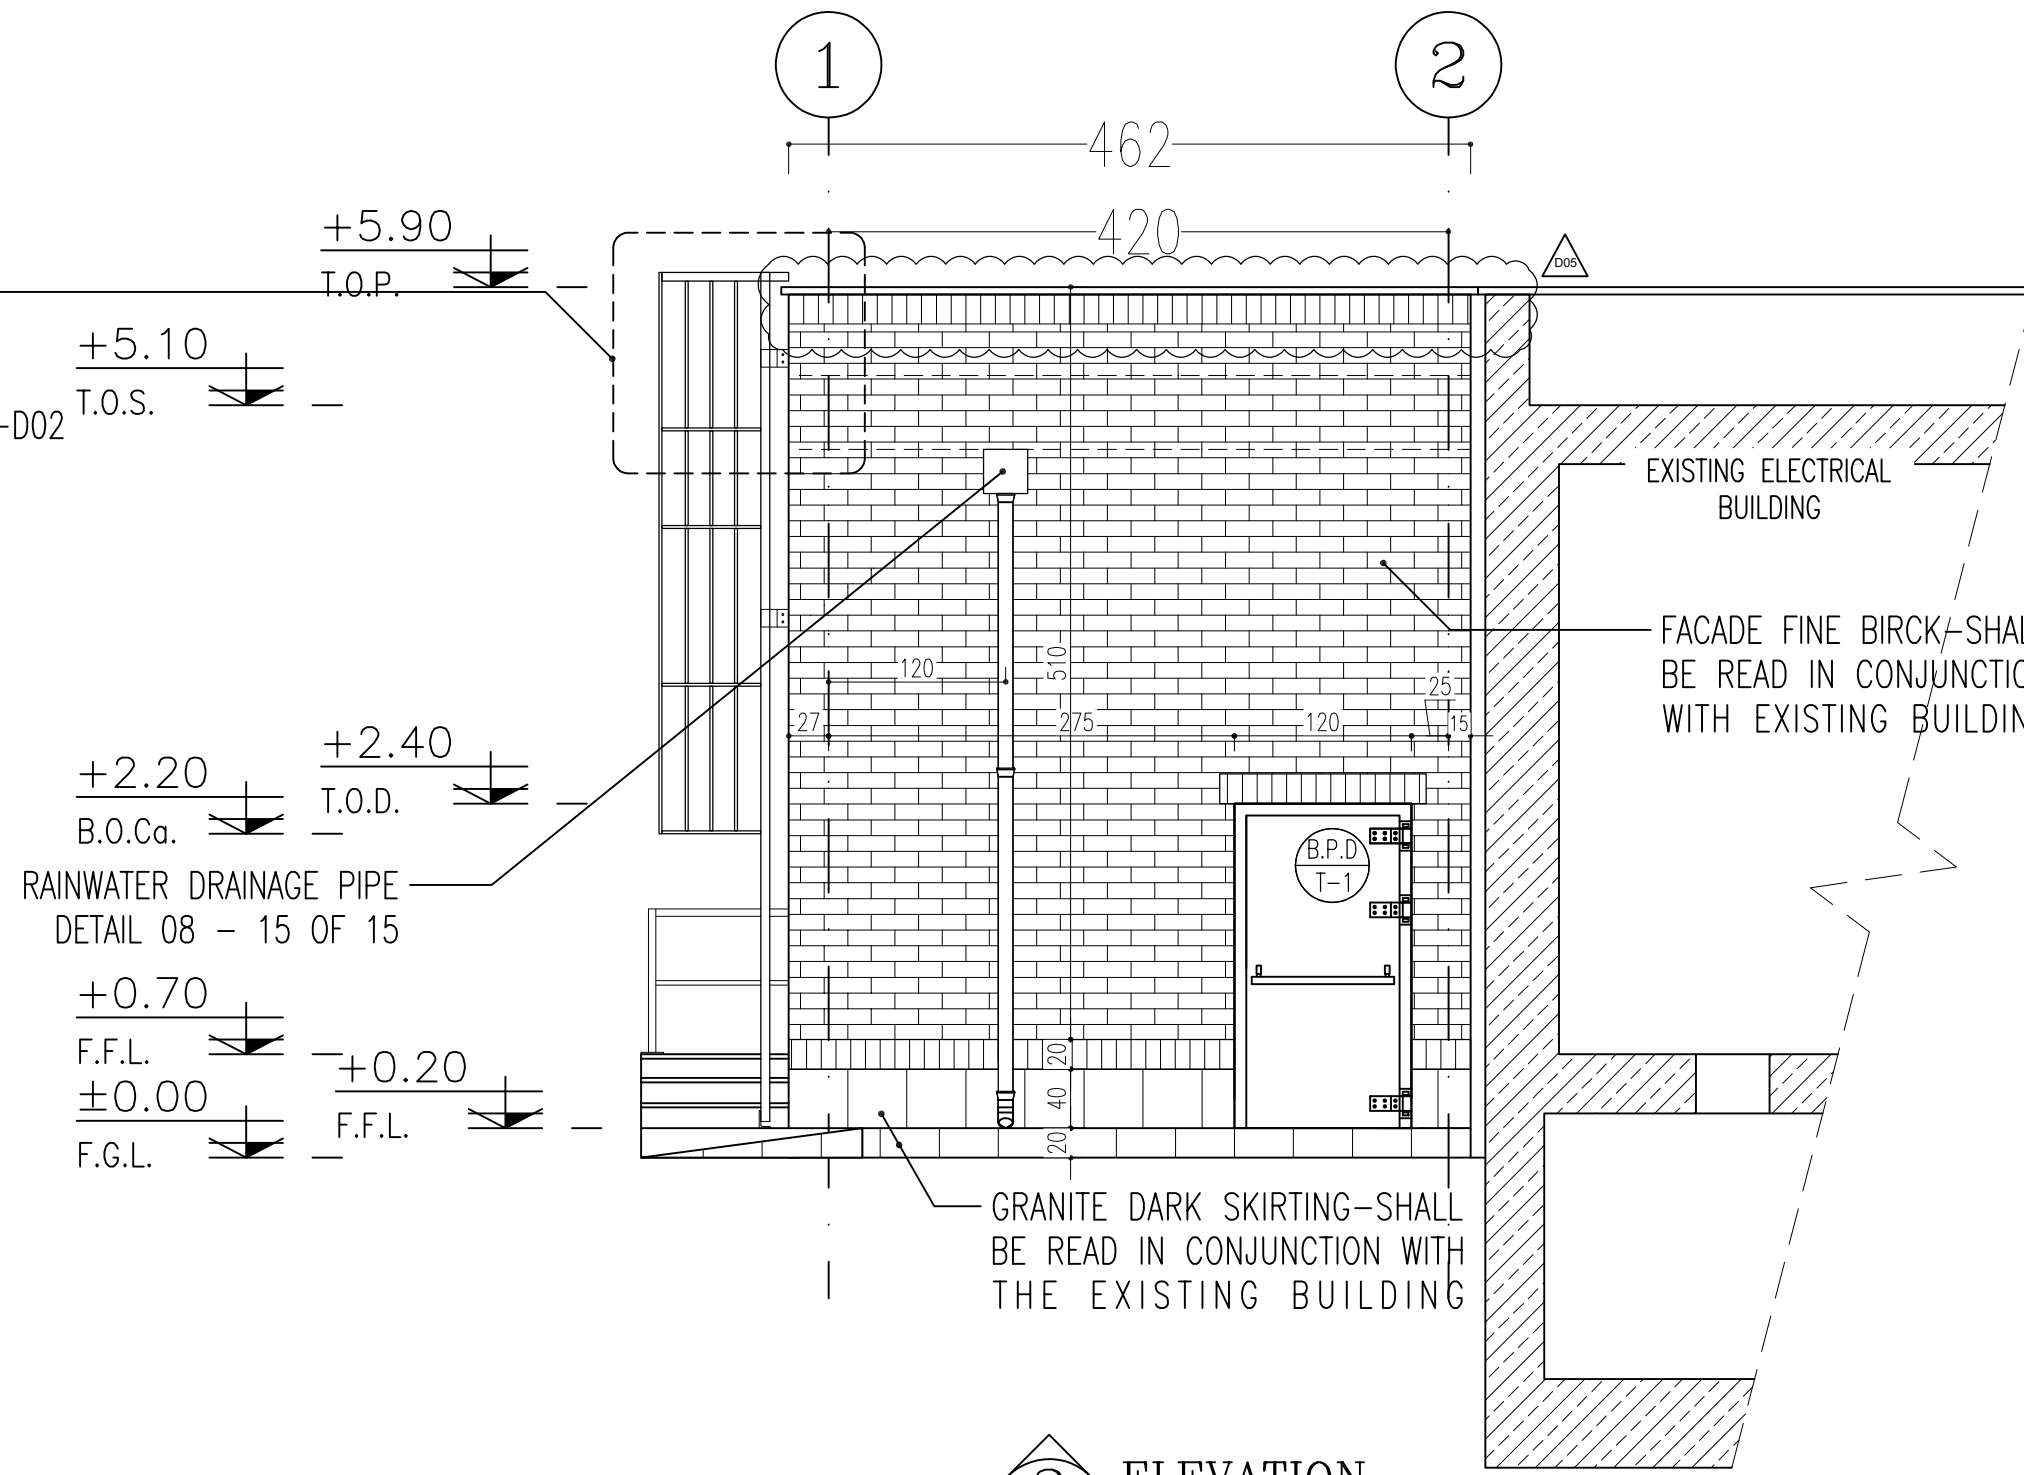

2 ELEVATION
SC.1:50 04 OF 15

+2.20
B.O.Ca.
+2.40
T.O.D.
+0.70
F.F.L.
±0.00
F.G.L.

GRANITE DARK SKIRTING-SHALL
BE READ IN CONJUNCTION WITH
THE EXISTING BUILDING

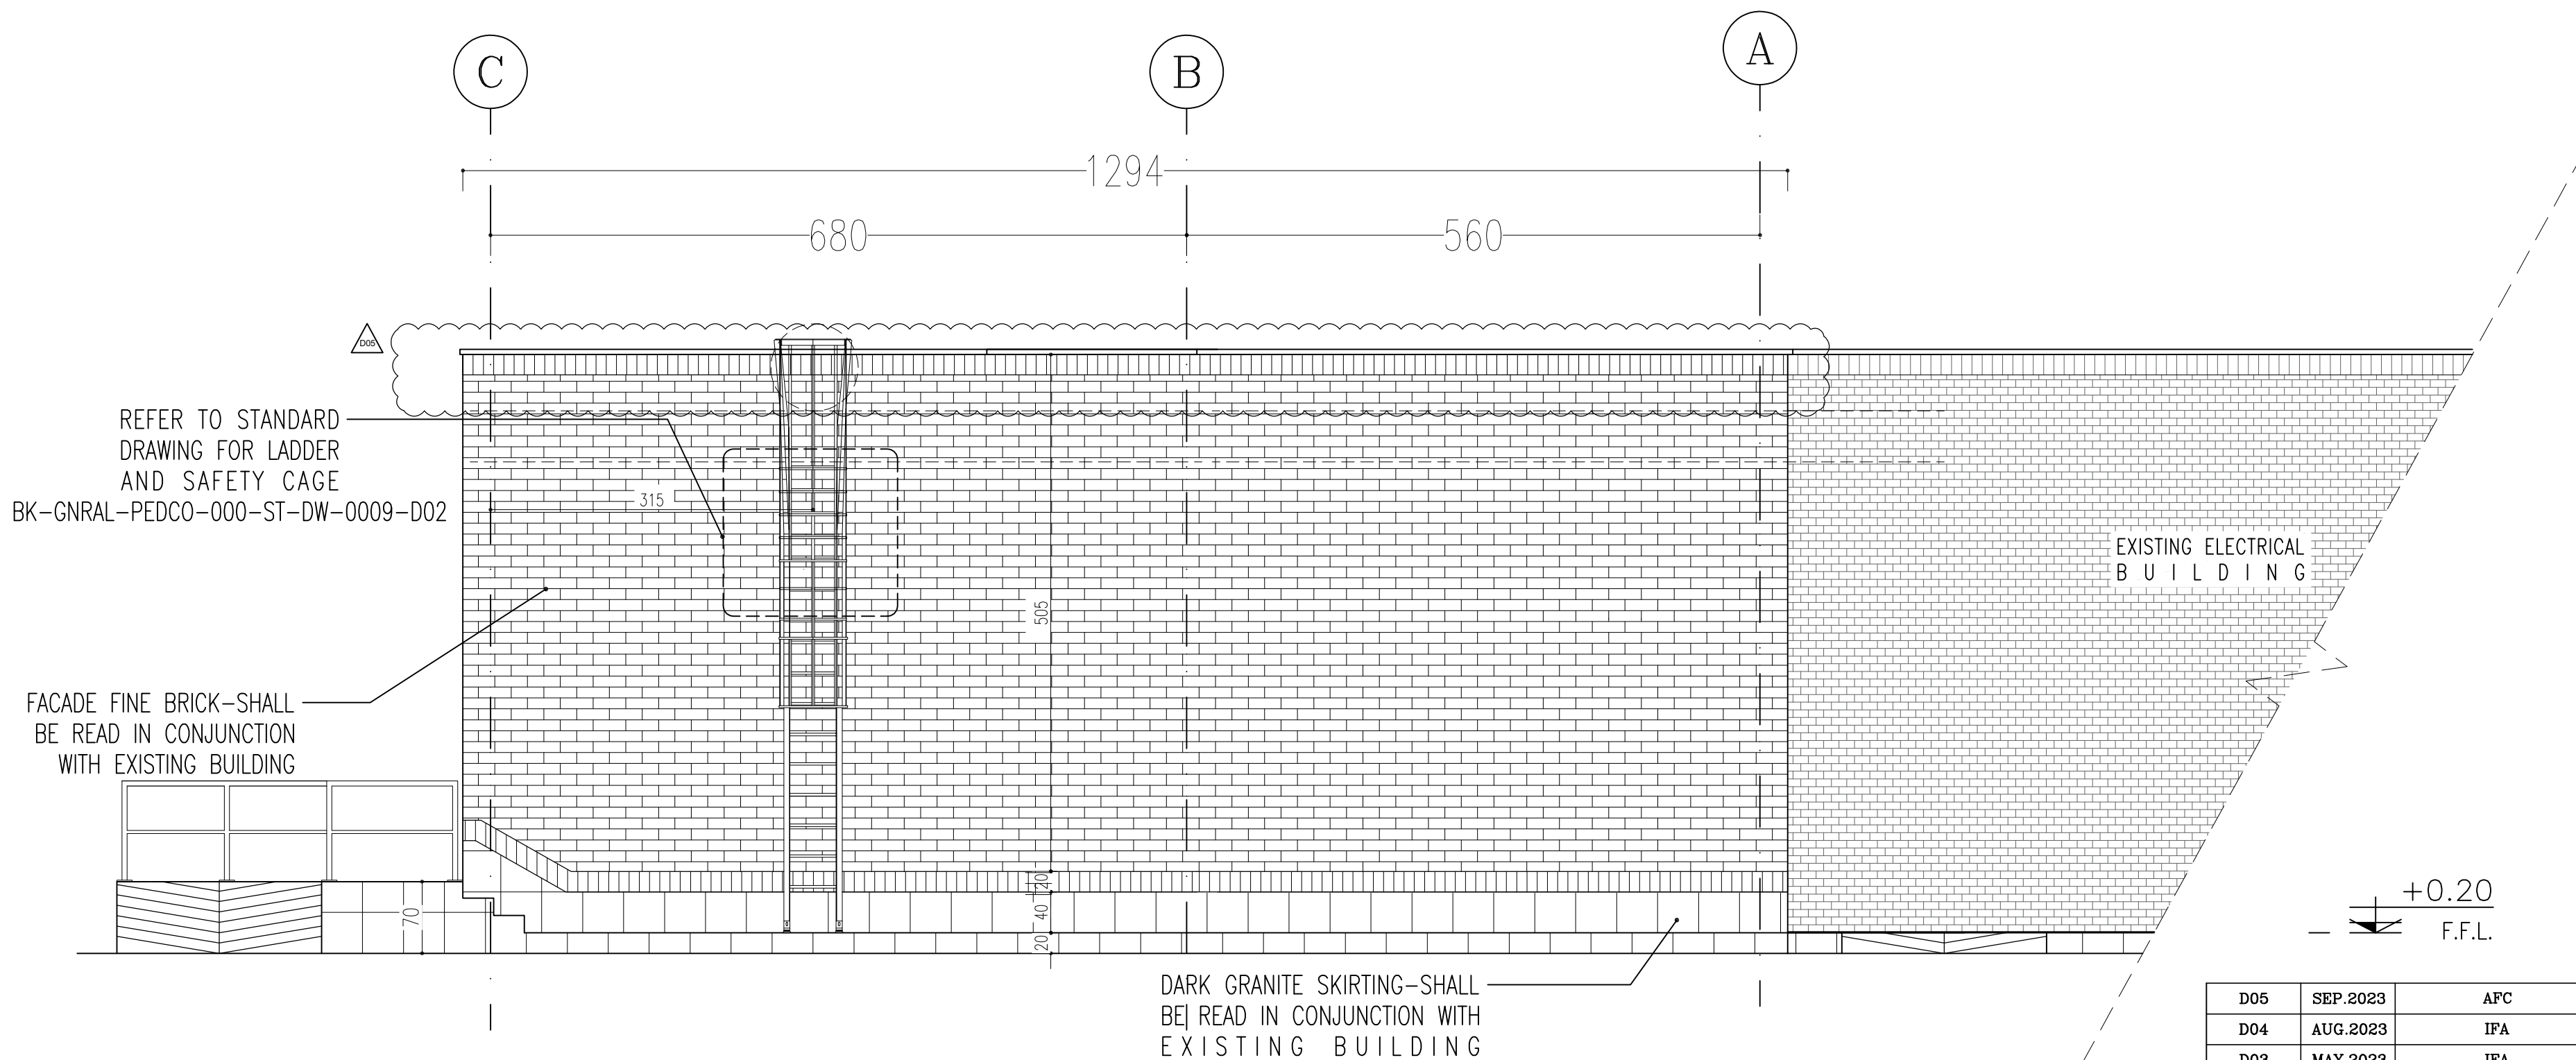


3 ELEVATION
SC.1:50 04 OF 15





NOTES			
1. ALL DIMENSIONS ARE IN CENTIMETER & ALL ELEVATIONS ARE IN METER. 2. ALL DIMENSIONS AND ELEVATIONS SHALL BE CHECKED BY THE CONTRACTOR PRIOR TO CONSTRUCTION. 3. CONTRACTOR SHALL COMPLY ALL ARCHITECTURAL, MECHANICAL, ELECTRICAL, PIPING AND STRUCTURAL DRAWINGS AND IN CASE OF ANY CONFLICTS OR DISCREPANCY, INFORM THE ENGINEER. 4. ALL MATERIALS ARE SELECTED FROM THE HIGHEST QUALITY AND MUST BE APPROVED BY THE CLIENT. 5. ALL OPENINGS FOR PIPING, CABLEING AND HVAC OPENINGS SHALL BE CONSIDERED AS PER RELATED DRAWINGS BEFORE CONSTRUCTION. 6. ARCHITECTURAL DETAIL DESIGN WILL BE REVISED BASED ON APPROVED STRUCTURAL DRAWINGS. 7. ELEVATION CODE : LOCAL 20.0m CORRESPONDS TO GLOBAL +11.10m			
LEGEND			
LEAN CONCRETE			
REINFORCED CONCRETE			
PRESSED BRICK			
STONE			
EXPANSION JOINT FILLER (PLASTOFOAM)			
TERRAZZO TILES FOR ROOF - 30x30cm			
BLOCKAGE			
F.F.L.	FINISHED FLOOR	B.O.P.	BOTTOM OF PIT
T.O.WA	TOP OF WALKWAY	F.G.L.	FINISH GRADING LEVEL
T.O.P.	TOP OF PARAPET	T.O.T.	TOP OF TRENCH
T.O.FOU.	TOP OF FOUNDATION	C.O.S.	CENTER OF SLEEVE
M.D	METAL DOOR	B.O.S.	BOTTOM OF SLEEVE
T.O.R.	TOP OF ROOF	B.O.O.	BOTTOM OF OPENING
T.O.D.	TOP OF DOOR	B.O.T.	BOTTOM OF TRENCH
B.O.Ca.	BOTTOM OF CAGE	B.O.P.	BOTTOM OF PIT
T.O.Ca.	TOP OF CAGE	R.H.P.	ROOF HIGHEST POINT
B.O.G.	BOTTOM OF GUTTER	R.L.P.	ROOF LOWEST POINT
T.O.Ca.	TOP OF CAGE	N.G.R.	NEUTRAL GROUND RESISTOR
M.D.	METAL DOOR	B.P.D.	BLAST-PROOF DOOR
T.O.S.	TOP OF SLAB	F.D.	FENCE DOOR

REFERENCE DRAWING	DRG. No.
STANDARD DRAWING FOR ARCHITECTURAL DETAILS	BK-GNRL-PEDCO-000-AR-DW-0001
SITE SEWAGEAGE SYSTEM LAYOUT & DETAILS	BK-GCS-PEDCO-120-CY-PY-0001
CABLE TRENCH AND DUCT BANK LAYOUT	BK-GCS-PEDCO-120-CY-PY-0002
ROAD, PAVING AND PLANT FINISH GRADING LAYOUT & SECTIONS	BK-GCS-PEDCO-120-CY-PY-0005
ELECTRICAL CABLE ROUTE & SECTION LAYOUT FOR BUILDING & SHELTER	BK-GCS-PEDCO-120-EL-PY-0006
FOUNDATION DRAWING FOR EXTENSION OF EXISTING ELECT. BUILDING	BK-GCS-PEDCO-120-ST-DW-0063
STRUCTURAL DRAWING FOR EXTENSION OF EXISTING ELECT. BUILDING	BK-GCS-PEDCO-120-ST-DW-0064
STANDARD DETAILS FOR LADDER & SAFETY CAGE	BK-GNRL-PEDCO-000-ST-DW-0009
ELECTRICAL EQUIPMENT ARRANGEMENT LAYOUT FOR BUILDING	BK-GCS-PEDCO-120-ST-EL-PY-0008
Unit Plot Plan Drawing	BK-GCS-PEDCO-120-PI-PY-0001

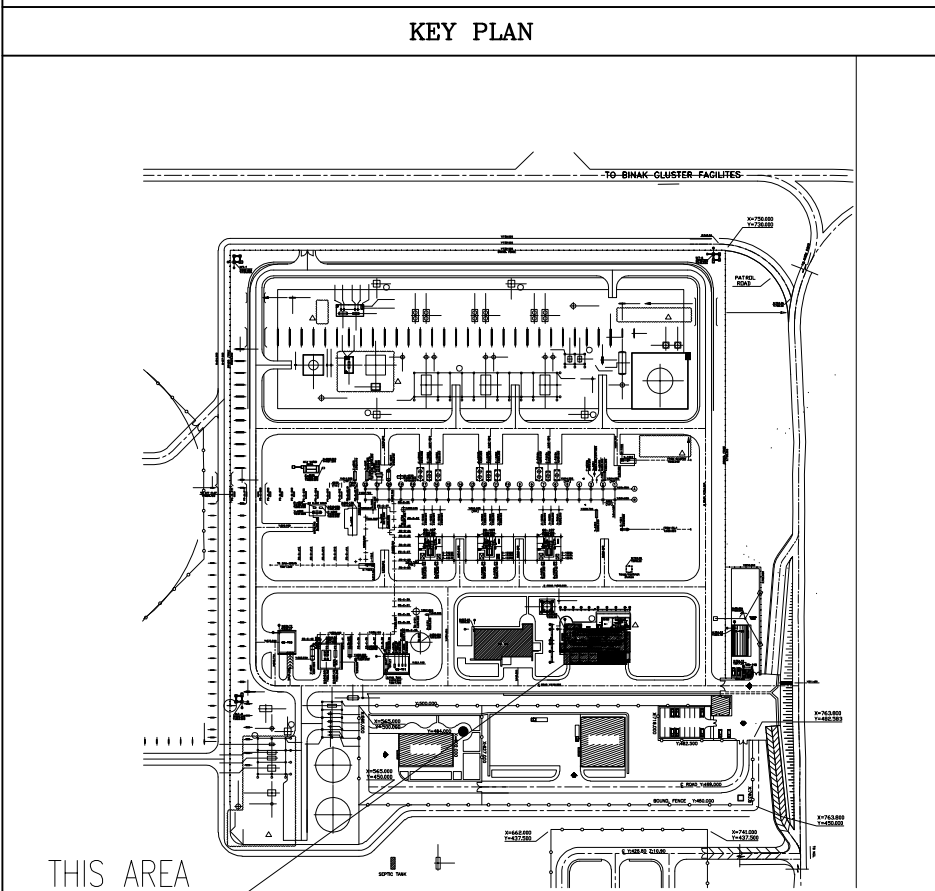


D05	SEP.2023	APC	R.BERLOUIE	M.PAKHARIAN	A.M.MOHSSENI	***
D04	AUG.2023	IFA	R.BERLOUIE	M.PAKHARIAN	A.M.MOHSSENI	***
D03	MAY.2023	IFA	R.BERLOUIE	M.PAKHARIAN	A.M.MOHSSENI	***
D02	AUG.2022	IFA	R.BERLOUIE	M.PAKHARIAN	M.MEHRSHAD	***
D01	APR.2022	IFA	R.BERLOUIE	M.PAKHARIAN	M.MEHRSHAD	***
D00	JAN.2022	IPC	R.BERLOUIE	M.PAKHARIAN	M.MEHRSHAD	***
REV.	DATE	P.O.I.S	PREP	CHK	APP.	AUT.
PROJECT NAME: BINAK OILFIELD DEVELOPMENT/SURFACE FACILITIES GAS COMPRESSOR STATION						
PROJECT NO.:			971020			
EPC CONTRACTOR:			EPD/EPC CONTRACTOR (GC):			
 HIRGAN ENERGY - DESIGN & INSPECTION COMPANIES			 PETROIRAN DEVELOPMENT COMPANY			
DRAWING TITLE: ARCHITECTURAL DETAIL DRAWING FOR EXTENSION OF EXISTING ELECT. BUILDING ELEVATIONS						
SCALE	SIZE	DRAWING NO.			SHEET NO.	REV.
AS SHOWN	A1	BK-GCS-PEDCO-120-AR-DW-0002			05 OF 15	D05

REV.	DESCRIPTION	BY	DATE	BY	DATE
***	*****	***	*****	***	*****
اصل و کلیه نسخ این نقشه و حق افشای متعلق به شرکت ملی مناطق نفت خیز جنوب می باشد.					
THE ORIGINAL AND ALL COPIES OF THIS DRAWING TOGETHER WITH THE COPYRIGHT THEREIN ARE THE SOLE PROPERTY OF N.I.S.O.C./ FIELDS					
BINAK OILFIELD DEVELOPMENT SURFACE FACILITIES GAS COMPRESSOR STATION					
DATE	SCALE	DRAWING BY	CHECKED BY	PROJECT ENG.	
NO CONSTRUCTION PERMITTED UNLESS DRAWING APPROVED					
APPROVED FOR CONSTRUCTION			BY:	DATE:	
SCALE	SIZE	CLASS	SERIAL NO.	SHEET	REVISION
053-073-0184	F	4	B	709100	05 OF 15

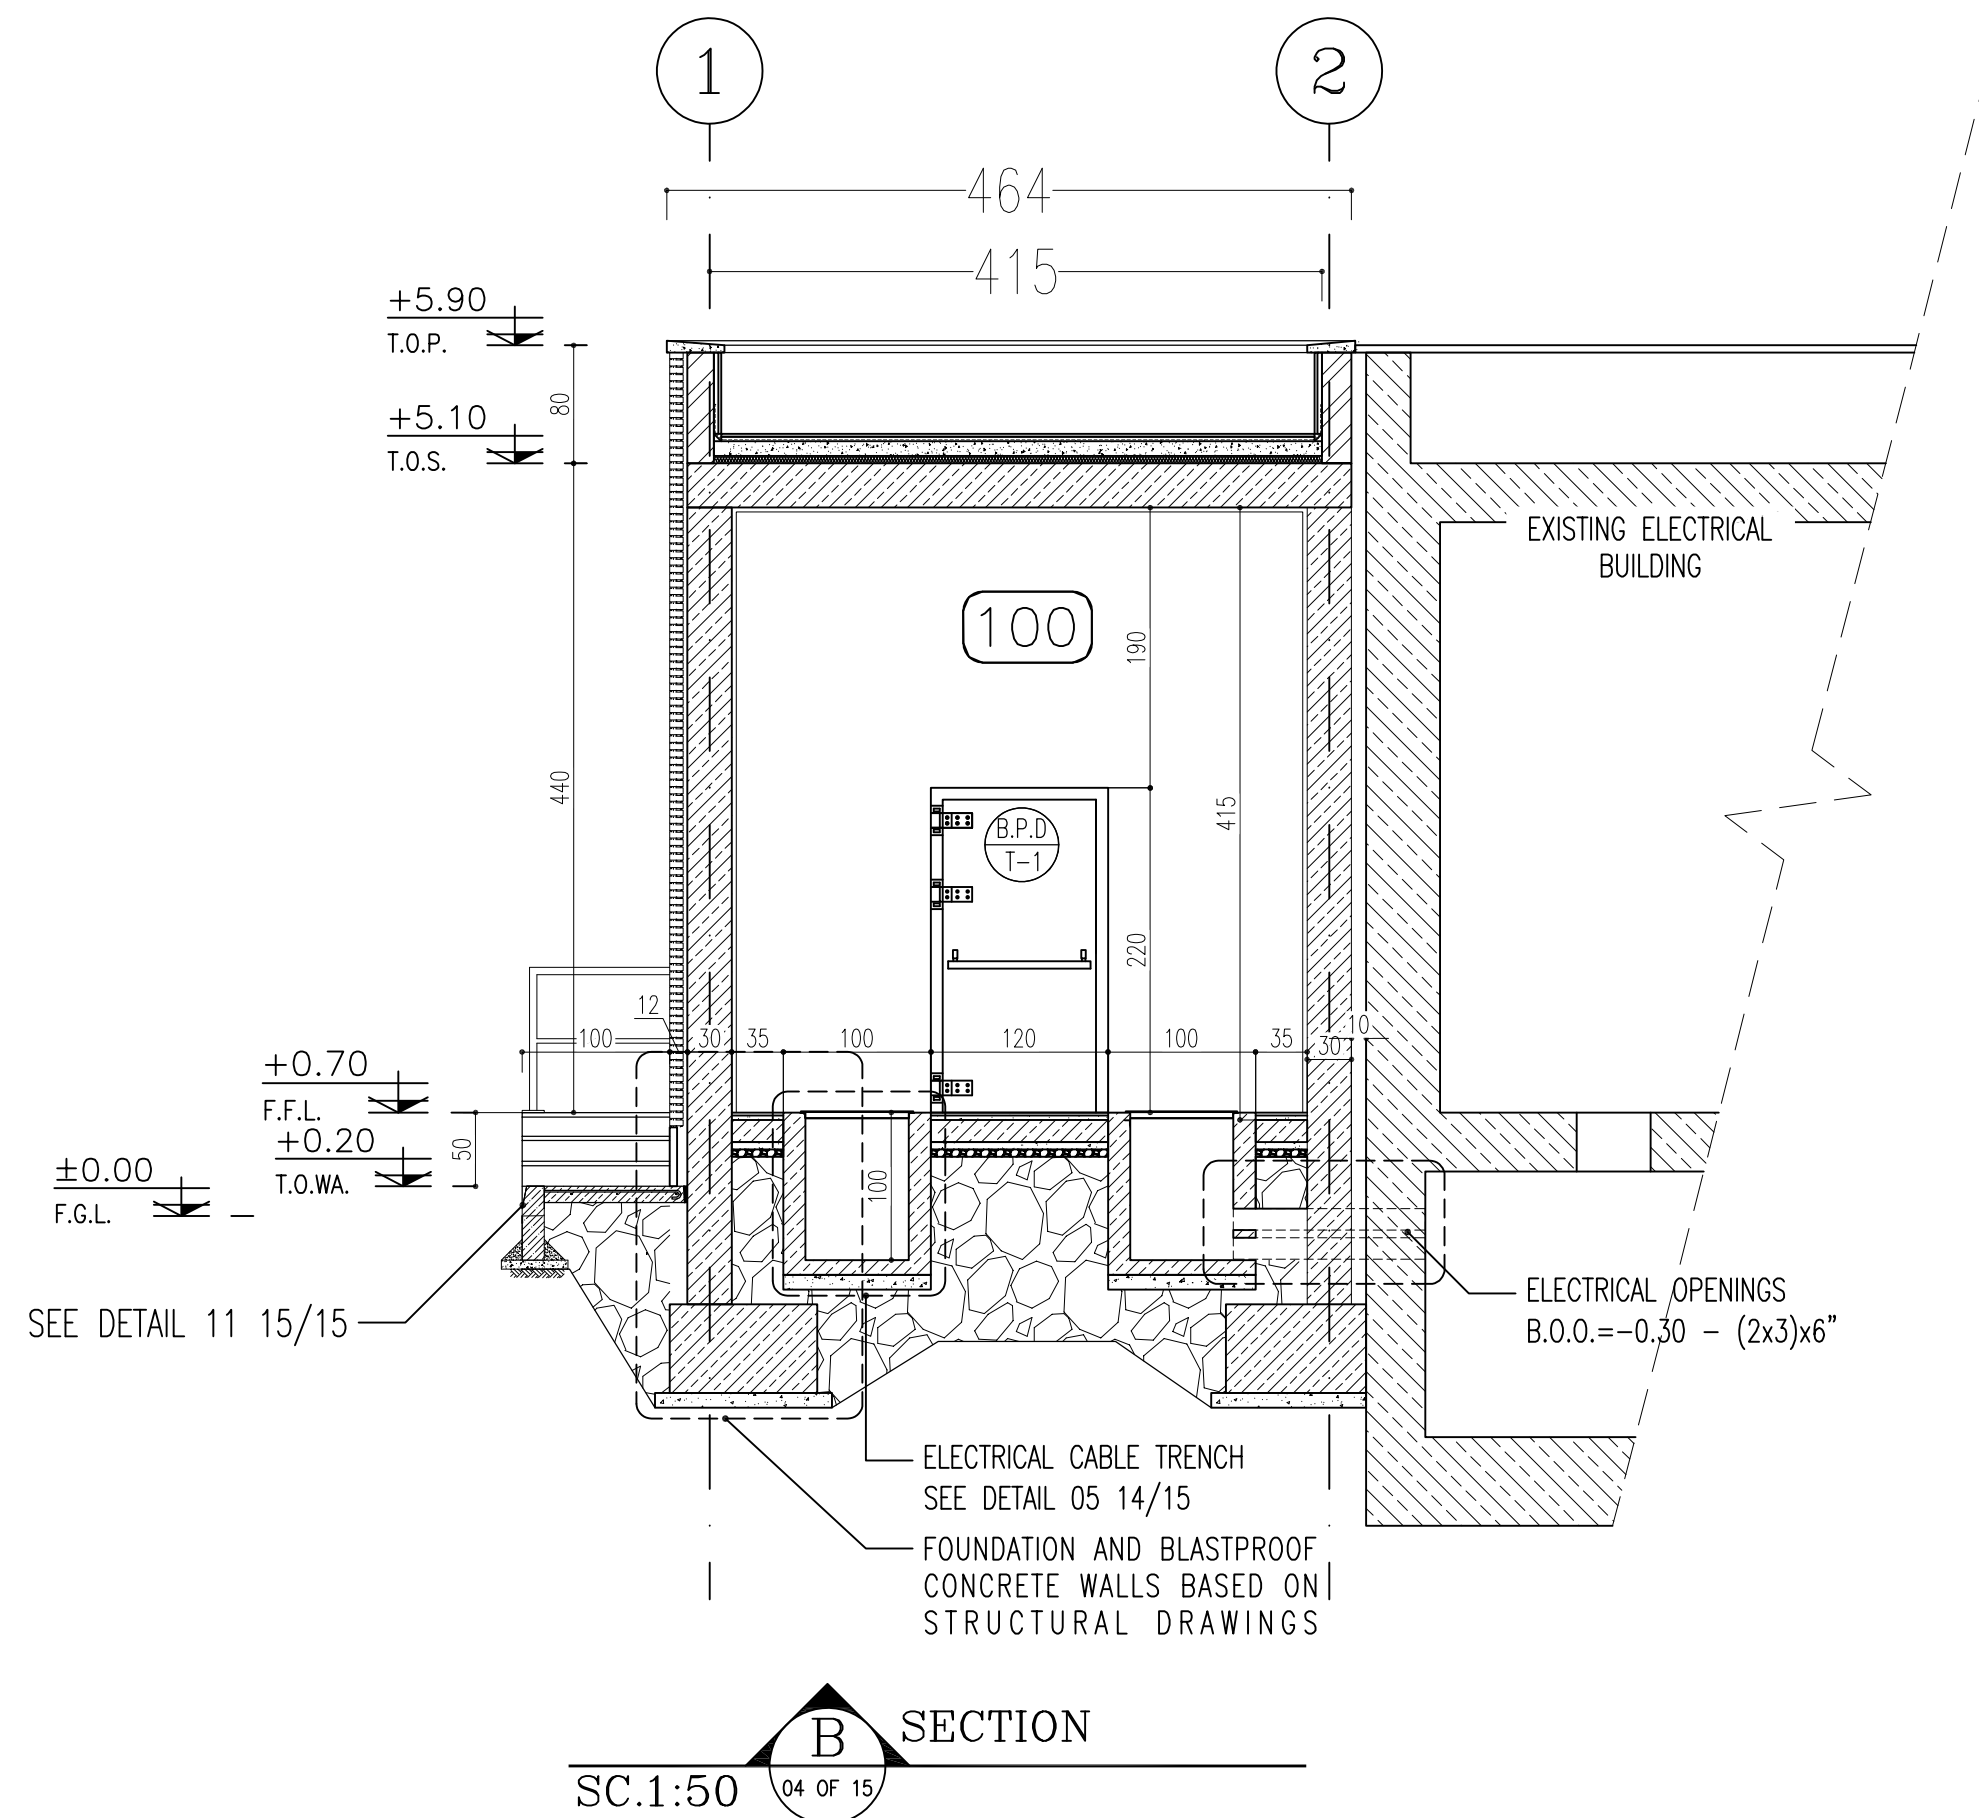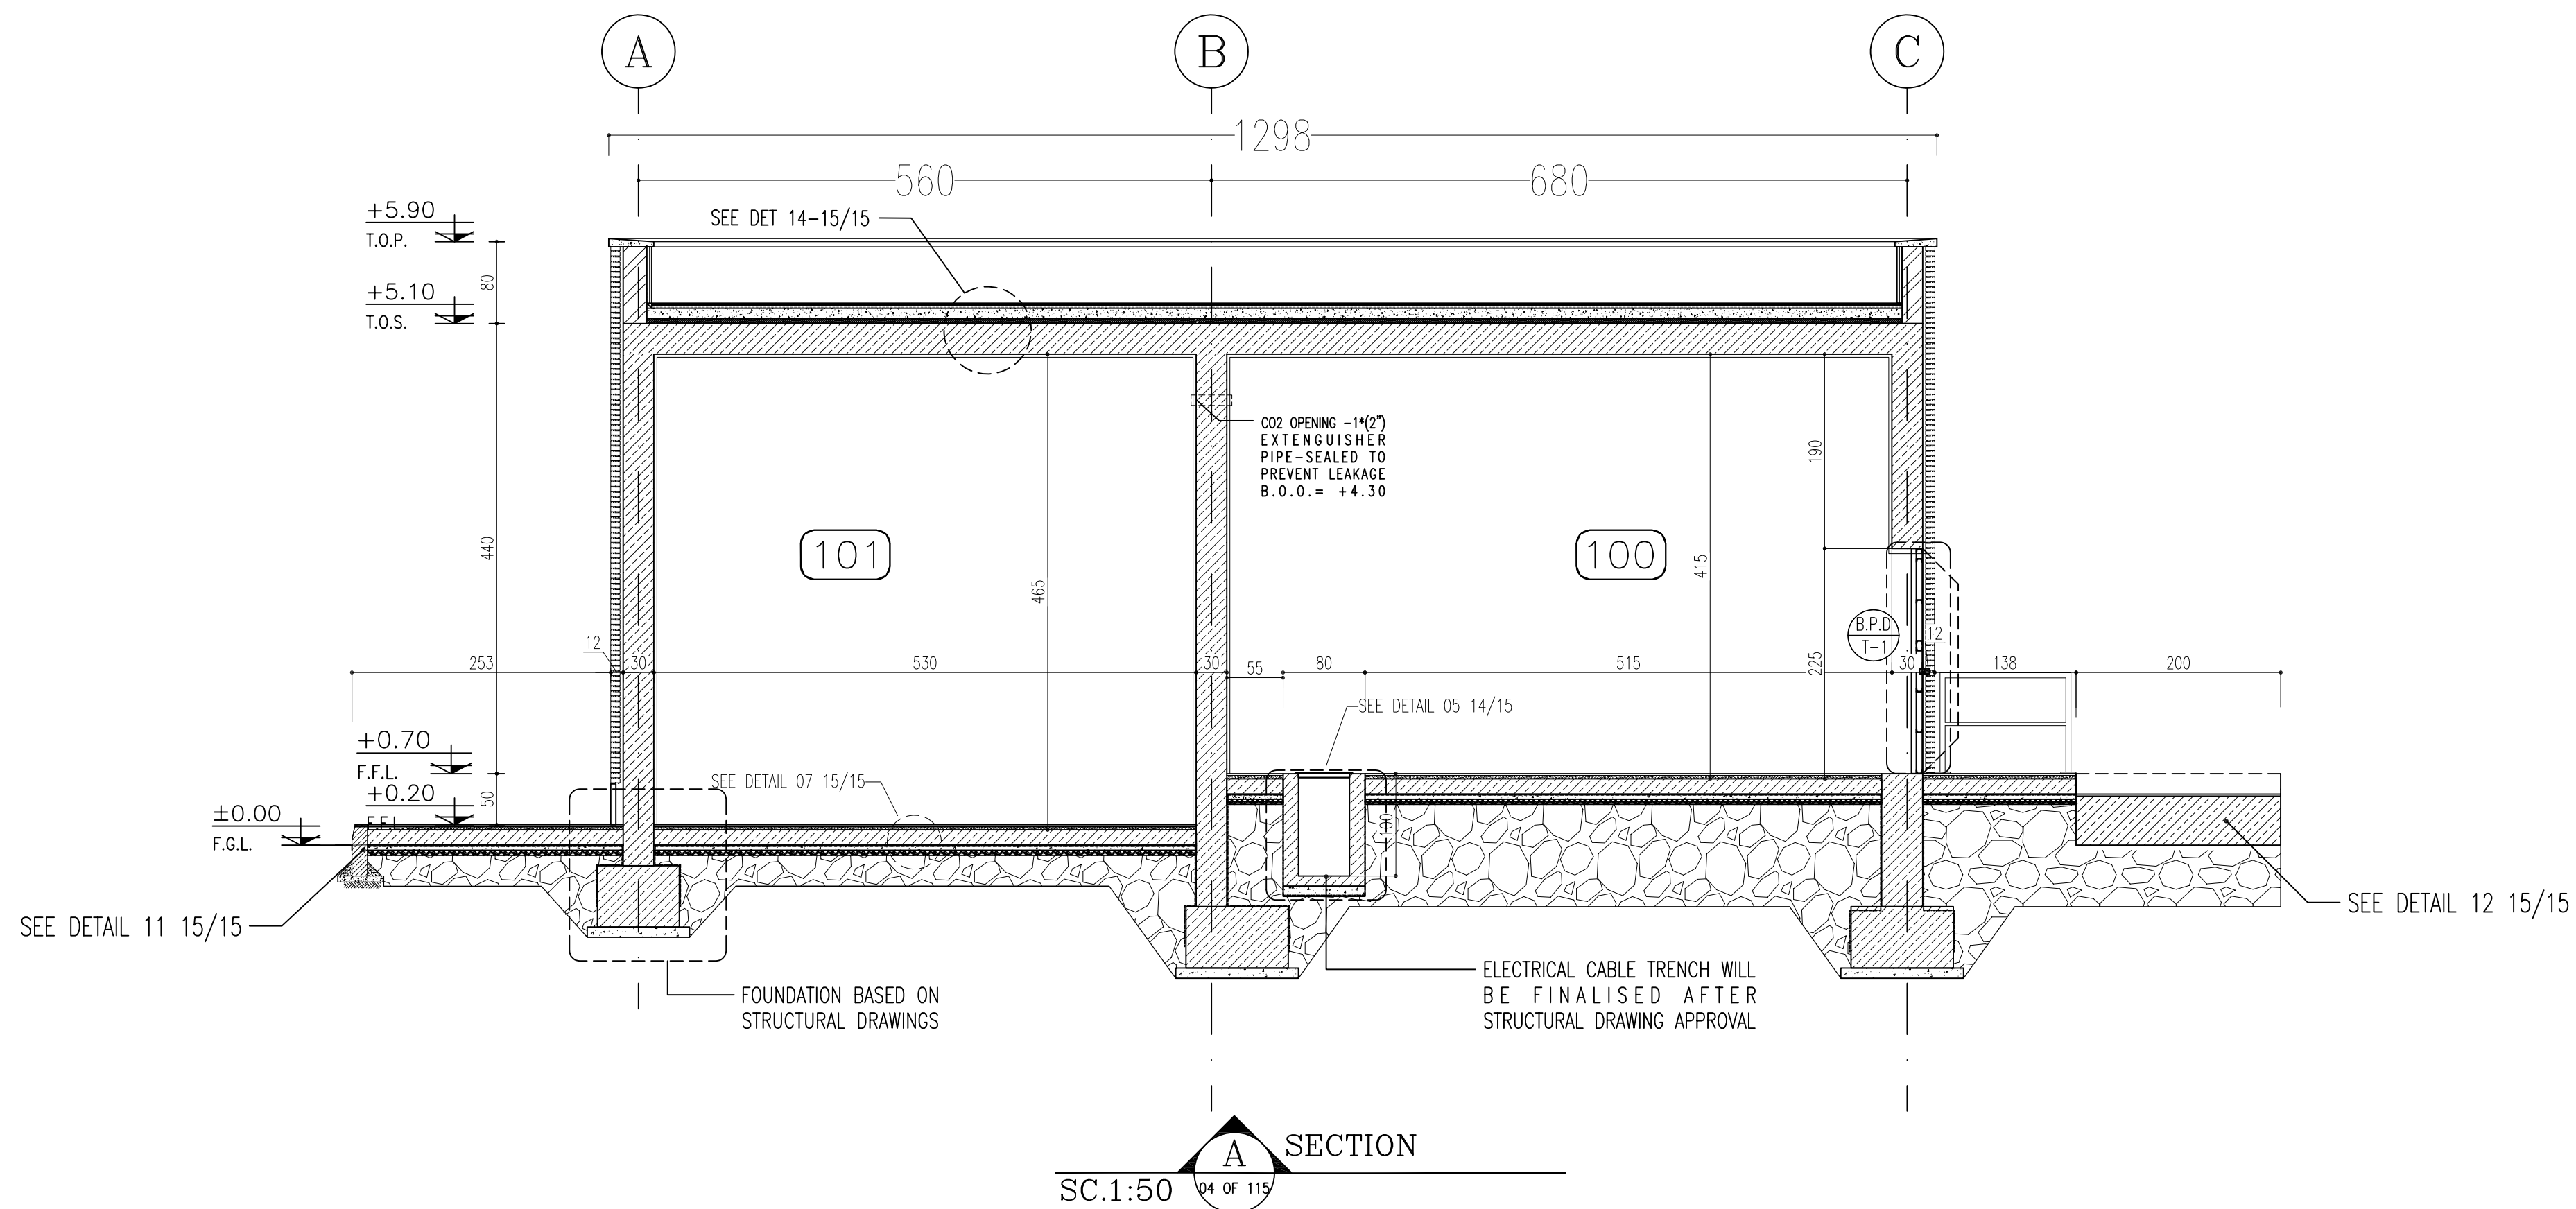



NOTES			
1. ALL DIMENSIONS ARE IN CENTIMETER & ALL ELEVATIONS ARE IN METER. 2. ALL DIMENSIONS AND ELEVATIONS SHALL BE CHECKED BY THE CONTRACTOR PRIOR TO CONSTRUCTION. 3. CONTRACTOR SHALL COMPLY ALL ARCHITECTURAL, MECHANICAL, ELECTRICAL, PIPING AND STRUCTURAL DRAWINGS AND IN CASE OF ANY CONFLICTS OR DISCREPANCY, INFORM THE ENGINEER. 4. ALL MATERIALS ARE SELECTED FROM THE HIGHEST QUALITY AND MUST BE APPROVED BY THE CLIENT. 5. ALL OPENINGS FOR PIPING, CABLEING AND HVAC OPENINGS SHALL BE CONSIDERED AS PER RELATED DRAWINGS BEFORE CONSTRUCTION. 6. ARCHITECTURAL DETAIL DESIGN WILL BE REVISED BASED ON APPROVED STRUCTURAL DRAWINGS. 7. ELEVATION CODE : LOCAL ±0.0m CORRESPONDS TO GLOBAL +11.10m			
LEGEND			
LEAN CONCRETE			
REINFORCED CONCRETE			
PRESSED BRICK			
STONE			
EXPANSION JOINT FILLER (PLASTOFOAM)			
TERRAZZO TILES FOR ROOF - 30x30cm			
BLOCKAGE			
F.F.L.	FINISHED FLOOR	B.O.P.	BOTTOM OF PIT
T.O.WA	TOP OF WALKWAY	F.G.L.	FINISH GRADING LEVEL
T.O.P.	TOP OF PARAPET	T.O.T.	TOP OF TRENCH
T.O.FOU.	TOP OF FOUNDATION	C.O.S.	CENTER OF SLEEVE
M.D	METAL DOOR	B.O.S.	BOTTOM OF SLEEVE
T.O.R.	TOP OF ROOF	B.O.O.	BOTTOM OF OPENING
T.O.D.	TOP OF DOOR	B.O.T.	BOTTOM OF TRENCH
B.O.Co.	BOTTOM OF CAGE	B.O.P.	BOTTOM OF PIT
T.O.Co.	TOP OF CAGE	R.H.P.	ROOF HIGHEST POINT
B.O.G.	BOTTOM OF GUTTER	R.L.P.	ROOF LOWEST POINT
T.O.Co.	TOP OF CAGE	N.G.R.	NEUTRAL GROUND RESISTOR
M.D.	METAL DOOR	B.P.D.	BLAST-PROOF DOOR
T.O.S.	TOP OF SLAB	F.D.	FENCE DOOR

REFERENCE DRAWING	DRG. No.
STANDARD DRAWING FOR ARCHITECTURAL DETAILS	BK-GNRL-PEDCO-000-AR-DW-0001
SITE SEWAGE SYSTEM LAYOUT & DETAILS	BK-GCS-PEDCO-120-CY-PY-0001
CABLE TRENCH AND DUCT BANK LAYOUT	BK-GCS-PEDCO-120-CY-PY-0002
ROAD, PAVING AND PLANT FINISH GRADING LAYOUT & SECTIONS	BK-GCS-PEDCO-120-CY-PY-0005
ELECTRICAL CABLE ROUTE & SECTION LAYOUT FOR BUILDING & SHELTER	BK-GCS-PEDCO-120-EL-PY-0006
FOUNDATION DRAWING FOR EXTENSION OF EXISTING ELECT. BUILDING	BK-GCS-PEDCO-120-ST-DW-0063
STRUCTURAL DRAWING FOR EXTENSION OF EXISTING ELECT. BUILDING	BK-GCS-PEDCO-120-ST-DW-0064
STANDARD DETAILS FOR LADDER & SAFETY CAGE	BK-GNRL-PEDCO-000-ST-DW-0009
ELECTRICAL EQUIPMENT ARRANGEMENT LAYOUT FOR BUILDING	BK-GCS-PEDCO-120-ST-EL-PY-0008
Unit Plot Plan Drawing	BK-GCS-PEDCO-120-PI-PY-0001

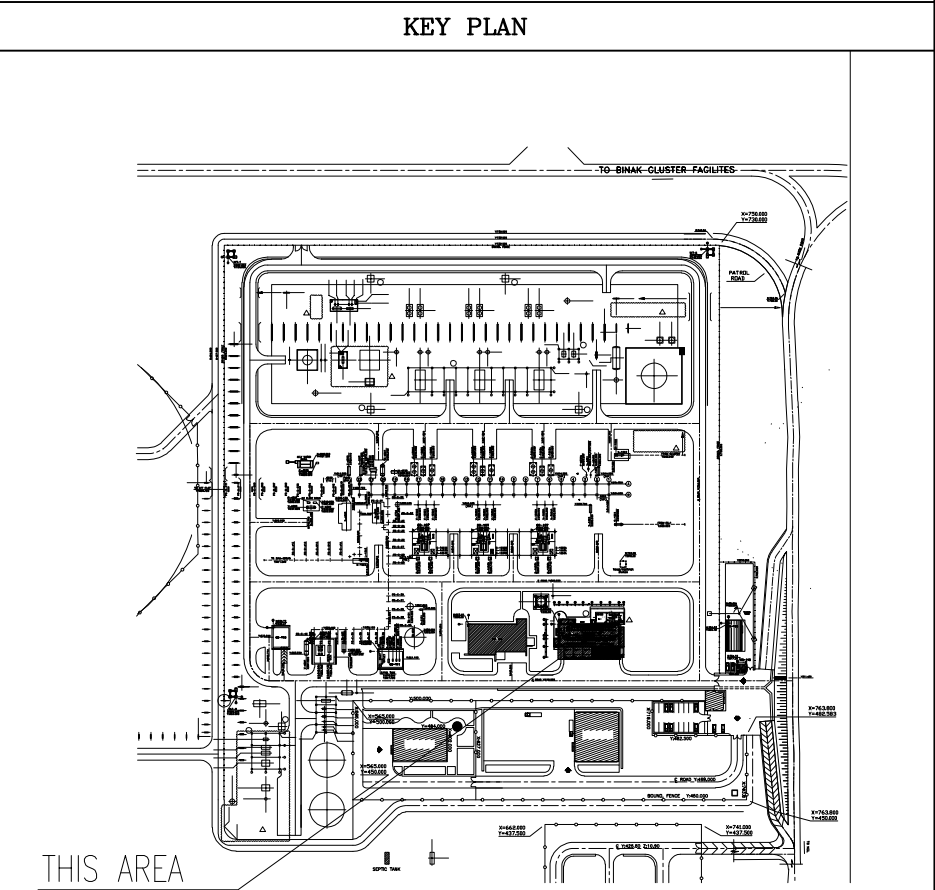

D05	SEP.2023	APC	R.BERLOUIE	M.PAKHARIAN	A.M.MOHSSENI	***																	
D04	AUG.2023	IFA	R.BERLOUIE	M.PAKHARIAN	A.M.MOHSSENI	***																	
D03	MAY.2023	IFA	R.BERLOUIE	M.PAKHARIAN	A.M.MOHSSENI	***																	
D02	AUG.2022	IFA	R.BERLOUIE	M.PAKHARIAN	M.MEHRSHAD	***	***	*****	***	*****	***	*****	***	*****	***	*****	***	*****	***				
D01	APR.2022	IFA	R.BERLOUIE	M.PAKHARIAN	M.MEHRSHAD	***	REV.	DESCRIPTION	BY	DATE	BY	DATE											
D00	JAN.2022	IPC	R.BERLOUIE	M.PAKHARIAN	M.MEHRSHAD	***				CHECKED		REV.	APPR.										
REV.	DATE	P.O.I.S	PREP.	CHK.	APP.	AUT.	اصل و کلیه نسخ این نقشه و حق اقتباس متعلق به شرکت ملی مناطق نفت خیز جنوب میباشند.																
PROJECT NAME:							BINAK OILFIELD DEVELOPMENT/SURFACE FACILITIES GAS COMPRESSOR STATION							 THE ORIGINAL AND ALL COPIES OF THIS DRAWING TOGETHER WITH THE COPYRIGHT THEREIN ARE THE SOLE PROPERTY OF N.I.S.O.C./ FIELDS									
PROJECT NO.:							971020																
EPC CONTRACTOR:			EPD/EPC CONTRACTOR (GC):				BINAK OILFIELD DEVELOPMENT SURFACE FACILITIES GAS COMPRESSOR STATION																
 HIRGAN ENERGY - DESIGN & INSPECTION COMPANIES			 PETROIRAN DEVELOPMENT COMPANY																				
DATE			SCALE		DRAWING BY		CHECKED BY		PROJECT ENG.														
DRAWING TITLE:							NO CONSTRUCTION PERMITTED UNLESS DRAWING APPROVED																
ARCHITECTURAL DETAIL DRAWING FOR EXTENSION OF EXISTING ELECT. BUILDING SECTIONS							APPROVED FOR CONSTRUCTION													BY:		DATE:	
SCALE	SIZE	DRAWING NO.				SHEET NO.	REV.	BUDGET REF.	LOCATION	SIZE	CLASS	SERIAL NO.	SHEET	REVISION									
AS SHOWN	A1	BK-GCS-PEDCO-120-AR-DW-0002				06 OF 15	D05	053-073-0184	F	4	B	709100	06 OF 15	D05									



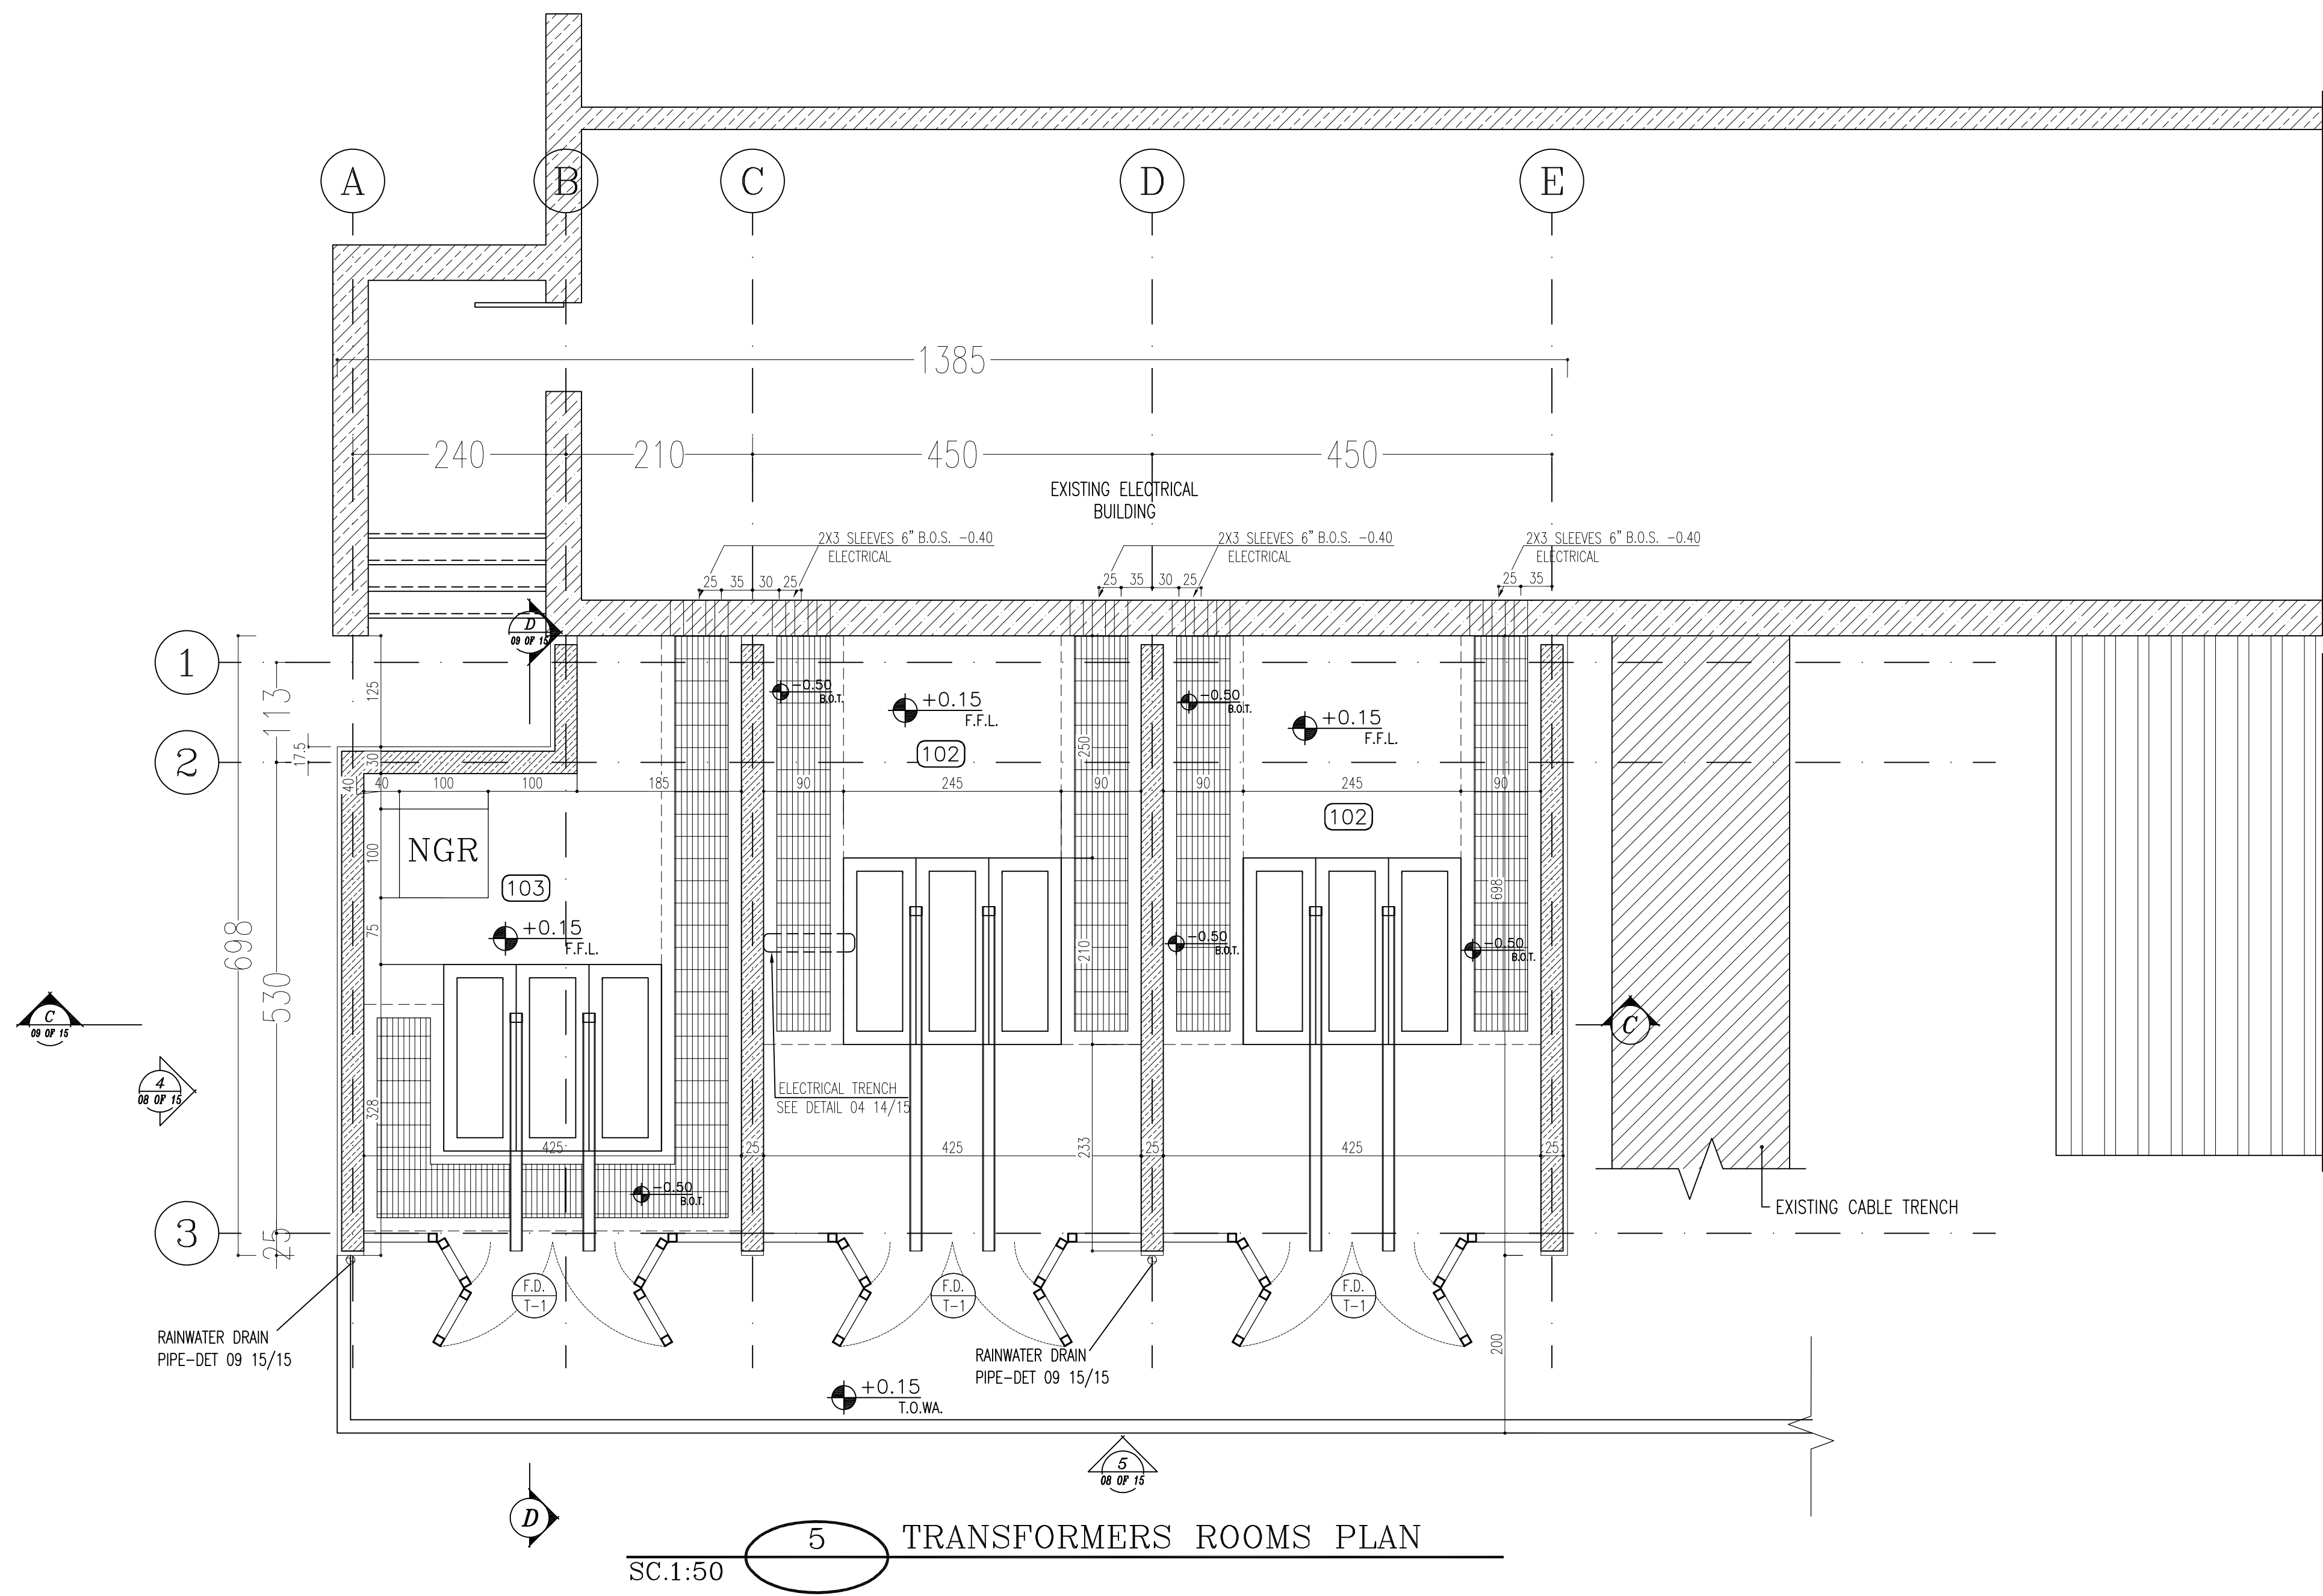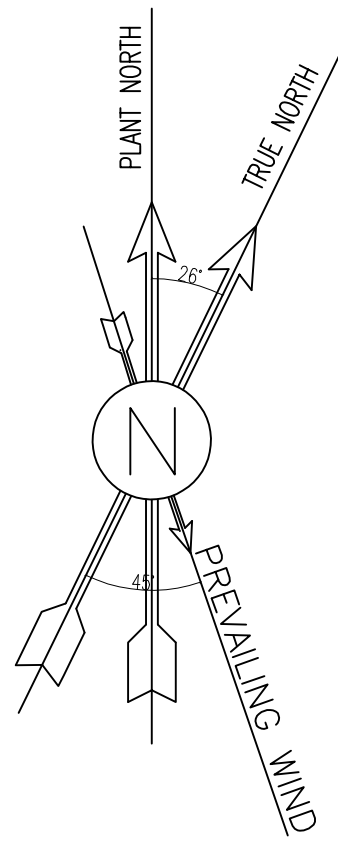

SPACE TAG NUMBER

- 100 CAPACITOR BANK
- 101 CO2 ROOM
- 102 TRANSFORMER ROOM
- 103 FIRE-FIGHTING PUMP TRANSFORMER ROOM
- 104 DIESEL ROOM




NOTES	
1. ALL DIMENSIONS ARE IN CENTIMETER & ALL ELEVATIONS ARE IN METER.	
2. ALL DIMENSIONS AND ELEVATIONS SHALL BE CHECKED BY THE CONTRACTOR PRIOR TO CONSTRUCTION.	
3. CONTRACTOR SHALL COMPLY ALL ARCHITECTURAL, MECHANICAL, ELECTRICAL, PIPING AND STRUCTURAL DRAWINGS AND IN CASE OF ANY CONFLICTS OR DISCREPANCY, INFORM THE ENGINEER.	
4. ALL MATERIALS ARE SELECTED FROM THE HIGHEST QUALITY AND MUST BE APPROVED BY THE CLIENT.	
5. ALL OPENINGS FOR PIPING, CABLEING AND HVAC OPENINGS SHALL BE CONSIDERED AS PER RELATED DRAWINGS BEFORE CONSTRUCTION.	
6. ARCHITECTURAL DETAIL DESIGN WILL BE REVISED BASED ON APPROVED STRUCTURAL DRAWINGS.	
7. ELEVATION CODE : LOCAL ±0.0m CORRESPONDS TO GLOBAL +11.10m	



LEGEND	
LEAN CONCRETE	
REINFORCED CONCRETE	
PRESSED BRICK	
STONE	
EXPANSION JOINT FILLER (PLASTOFOAM)	
TERRAZZO TILES FOR ROOF - 30x30cm	
BLOCKAGE	

F.F.L.	FINISHED FLOOR	B.O.P.	BOTTOM OF PIT
T.O.WA	TOP OF WALKWAY	F.G.L.	FINISH GRADING LEVEL
T.O.P.	TOP OF PARAPET	T.O.T.	TOP OF TRENCH
T.O.FOU.	TOP OF FOUNDATION	C.O.S.	CENTER OF SLEEVE
M.D	METAL DOOR	B.O.S.	BOTTOM OF SLEEVE
T.O.R.	TOP OF ROOF	B.O.O.	BOTTOM OF OPENING
T.O.D.	TOP OF DOOR	B.O.T.	BOTTOM OF TRENCH
B.O.Co.	BOTTOM OF CAGE	B.O.P.	BOTTOM OF PIT
T.O.Co.	TOP OF CAGE	R.H.P.	ROOF HIGHEST POINT
B.O.G.	BOTTOM OF GUTTER	R.L.P.	ROOF LOWEST POINT
T.O.Co.	TOP OF CAGE	N.G.R.	NEUTRAL GROUND RESISTOR
M.D.	METAL DOOR	B.P.D.	BLAST-PROOF DOOR
T.O.S.	TOP OF SLAB	F.D.	FENCE DOOR

REFERENCE DRAWING	DRG. No.
STANDARD DRAWING FOR ARCHITECTURAL DETAILS	BK-GNRL-PEDCO-000-AR-DW-0001
SITE SEWAGE SYSTEM LAYOUT & DETAILS	BK-GCS-PEDCO-120-CY-PY-0001
CABLE TRENCH AND DUCT BANK LAYOUT	BK-GCS-PEDCO-120-CY-PY-0002
ROAD, PAVING AND PLANT FINISH GRADING LAYOUT & SECTIONS	BK-GCS-PEDCO-120-CY-PY-0005
ELECTRICAL CABLE ROUTE & SECTION LAYOUT FOR BUILDING & SHELTER	BK-GCS-PEDCO-120-EL-PY-0006
FOUNDATION DRAWING FOR EXTENSION OF EXISTING ELECT. BUILDING	BK-GCS-PEDCO-120-ST-DW-0063
STRUCTURAL DRAWING FOR EXTENSION OF EXISTING ELECT. BUILDING	BK-GCS-PEDCO-120-ST-DW-0064
STANDARD DETAILS FOR LADDER & SAFETY CAGE	BK-GNRL-PEDCO-000-ST-DW-0009
ELECTRICAL EQUIPMENT ARRANGEMENT LAYOUT FOR BUILDING	BK-GCS-PEDCO-120-ST-EL-PY-0008
Unit Plot Plan Drawing	BK-GCS-PEDCO-120-PI-PY-0001

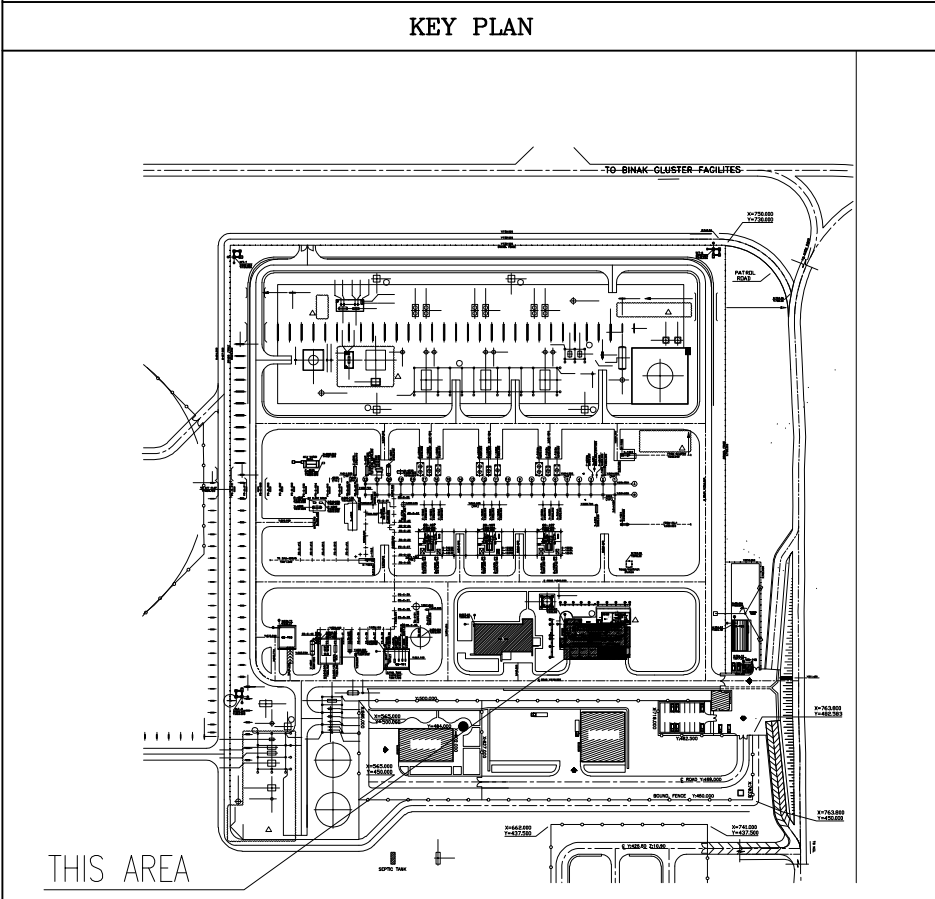

D05	SEP.2023	APC	R.BERLOUE	M.PAKHARIAN	A.M.MOHSSENI	***																		
D04	AUG.2023	IFA	R.BERLOUE	M.PAKHARIAN	A.M.MOHSSENI	***																		
D03	MAY.2023	IFA	R.BERLOUE	M.PAKHARIAN	A.M.MOHSSENI	***																		
D02	AUG.2022	IFA	R.BERLOUE	M.PAKHARIAN	M.MEHRSHAD	***	***	*****	***	***	*****	***	***	*****	***									
D01	APR.2022	IFA	R.BERLOUE	M.PAKHARIAN	M.MEHRSHAD	***	REV.	DESCRIPTION	BY	DATE	BY	DATE												
D00	JAN.2022	IFC	R.BERLOUE	M.PAKHARIAN	M.MEHRSHAD	***				CHECKED		REV. APPR.												
REV.	DATE	P.O.I.S	PREP.	CHK.	APP.	AUT.	اصل و کليه نسخ این نقشه و حق اقتباس متعلق به شرکت ملی مناطق نفت خیز جنوب میباشد.																	
PROJECT NAME:							BINAK OILFIELD DEVELOPMENT/SURFACE FACILITIES GAS COMPRESSOR STATION									 THE ORIGINAL AND ALL COPIES OF THIS DRAWING TOGETHER WITH THE COPYRIGHT THEREON ARE THE SOLE PROPERTY OF N.I.S.O.C. / FIELDS								
PROJECT NO.:							971020																	
EPC CONTRACTOR:			EPD/EPC CONTRACTOR (GC):				BINAK OILFIELD DEVELOPMENT SURFACE FACILITIES GAS COMPRESSOR STATION																	
 HIRGAN ENERGY - DESIGN & INSPECTION COMPANIES			 PETROIRAN DEVELOPMENT COMPANY				 THE ORIGINAL AND ALL COPIES OF THIS DRAWING TOGETHER WITH THE COPYRIGHT THEREON ARE THE SOLE PROPERTY OF N.I.S.O.C. / FIELDS																	
																DATE			SCALE		DRAWING BY		CHECKED BY	
DRAWING TITLE:							ARCHITECTURAL DETAIL DRAWING FOR EXTENSION OF EXISTING ELECT. BUILDING PLAN									NO CONSTRUCTION PERMITTED UNLESS DRAWING APPROVED								
							APPROVED FOR CONSTRUCTION						BY:		DATE:									
SCALE	SIZE	DRAWING NO.			SHEET NO.	REV.	BUDGET REF.	LOCATION	SIZE	CLASS	SERIAL NO.	SHEET	REVISION											
AS SHOWN	A1	BK-GCS-PEDCO-120-AR-DW-0002			07 OF 15	D05	053-073-0184	F	4	B	709100	07 OF 15	D05											

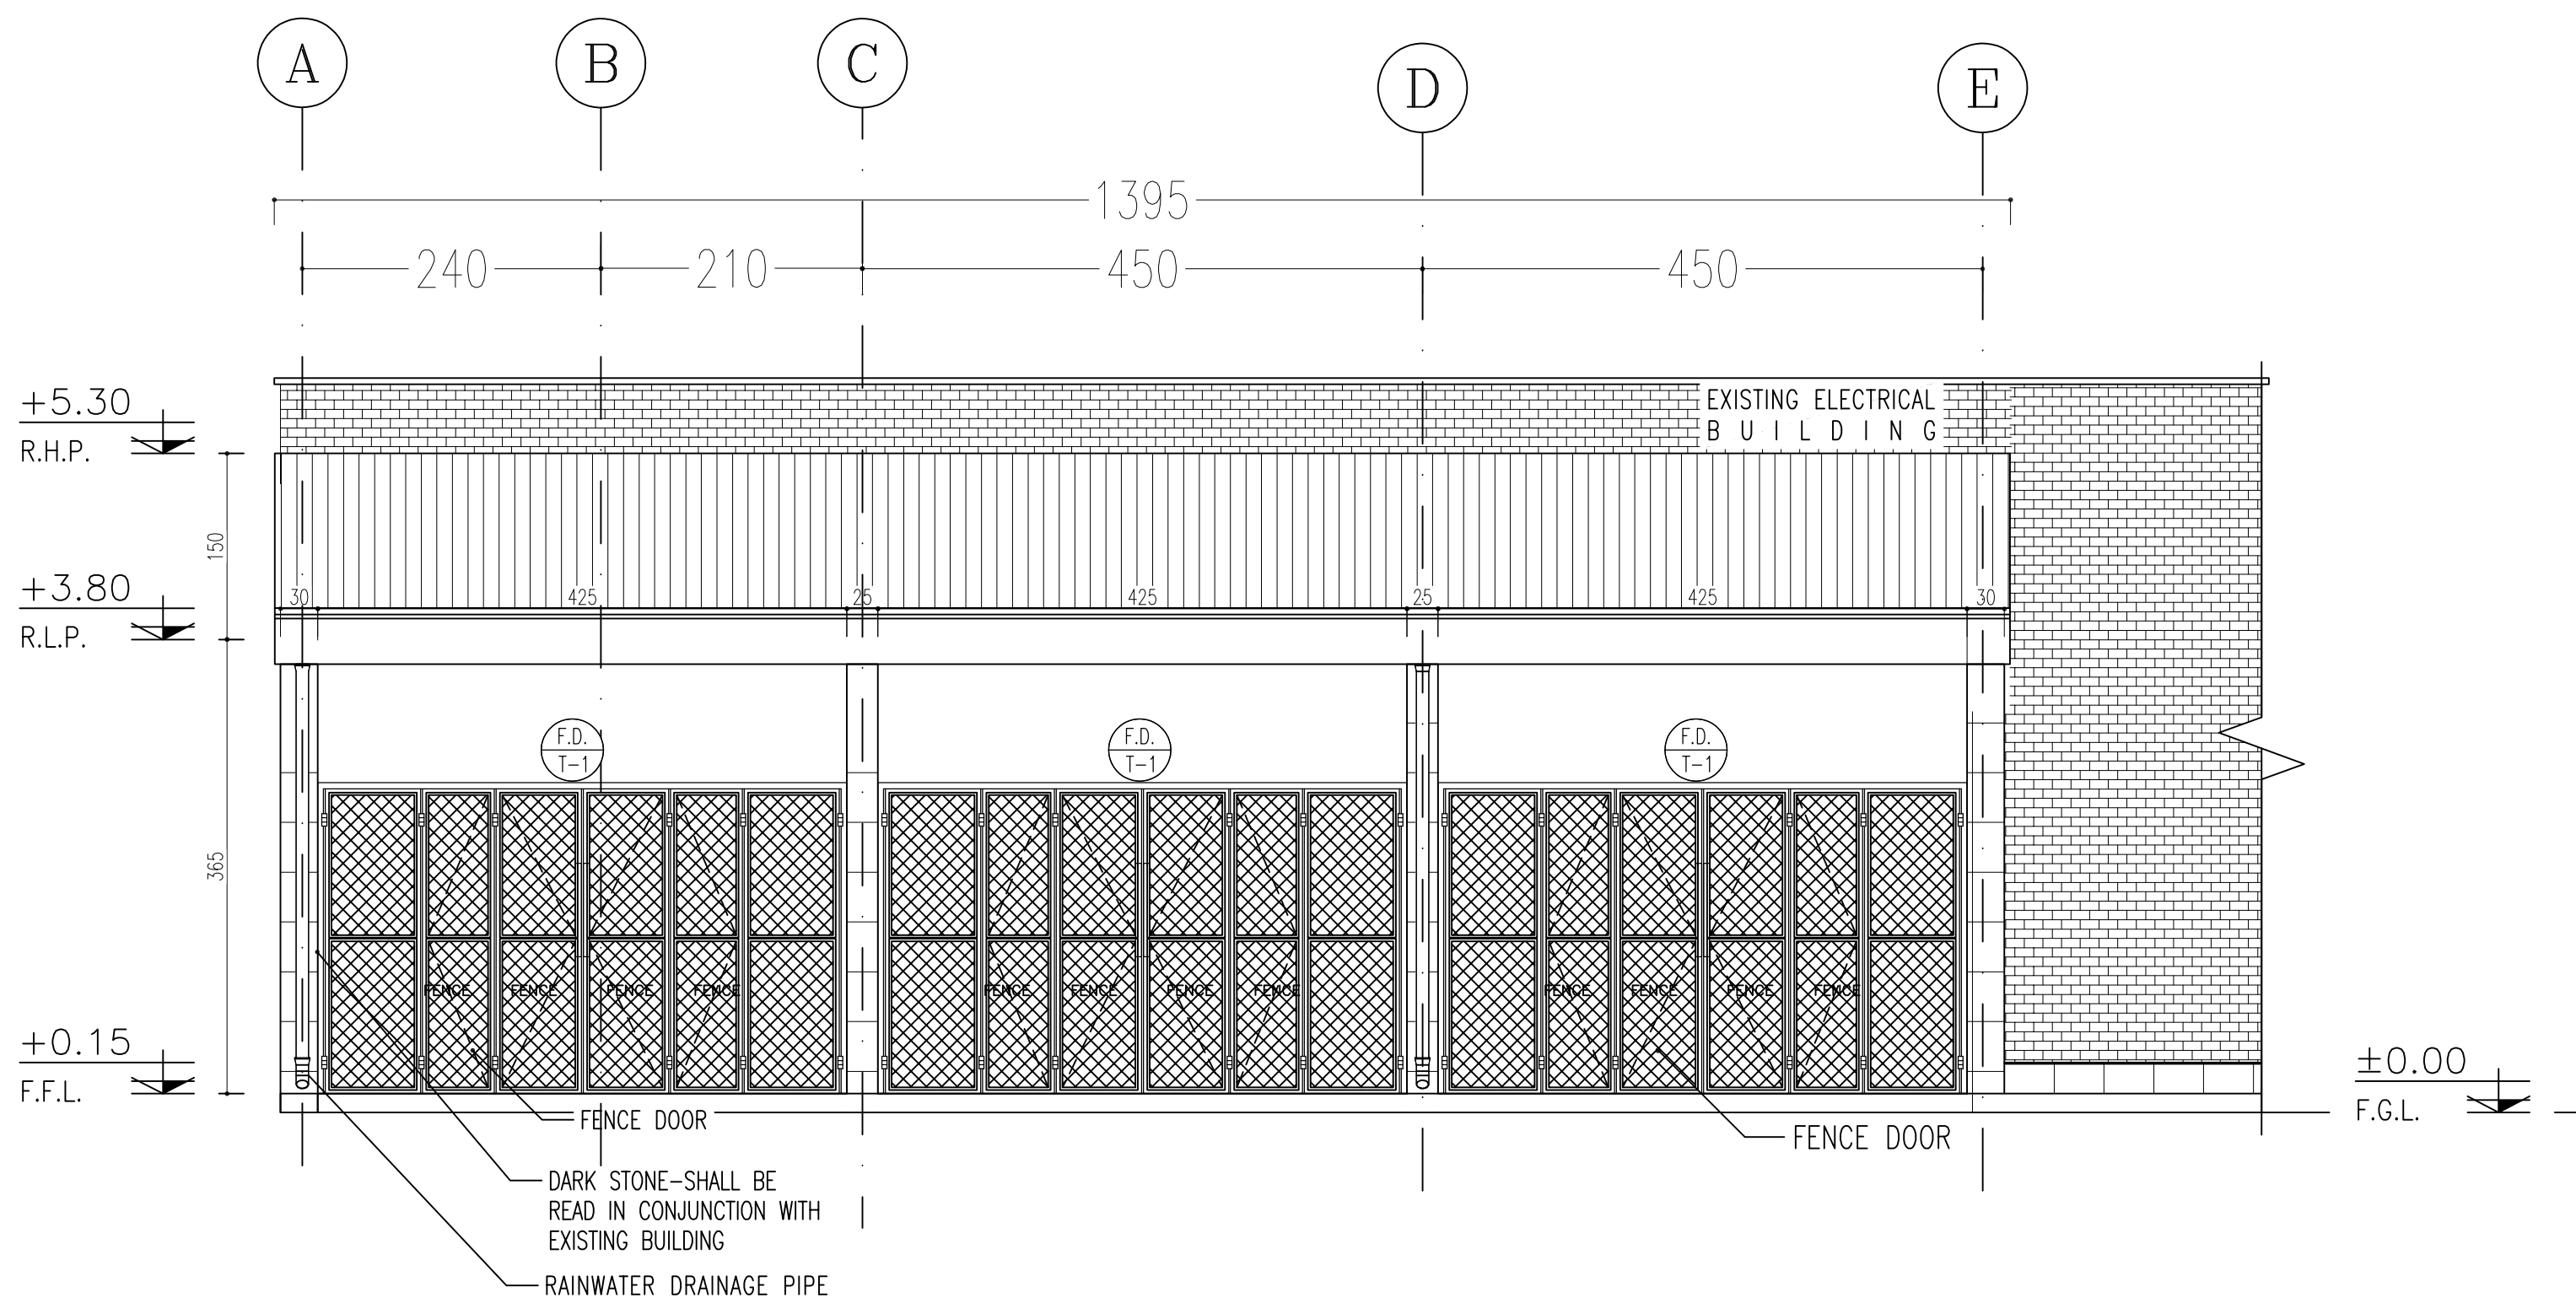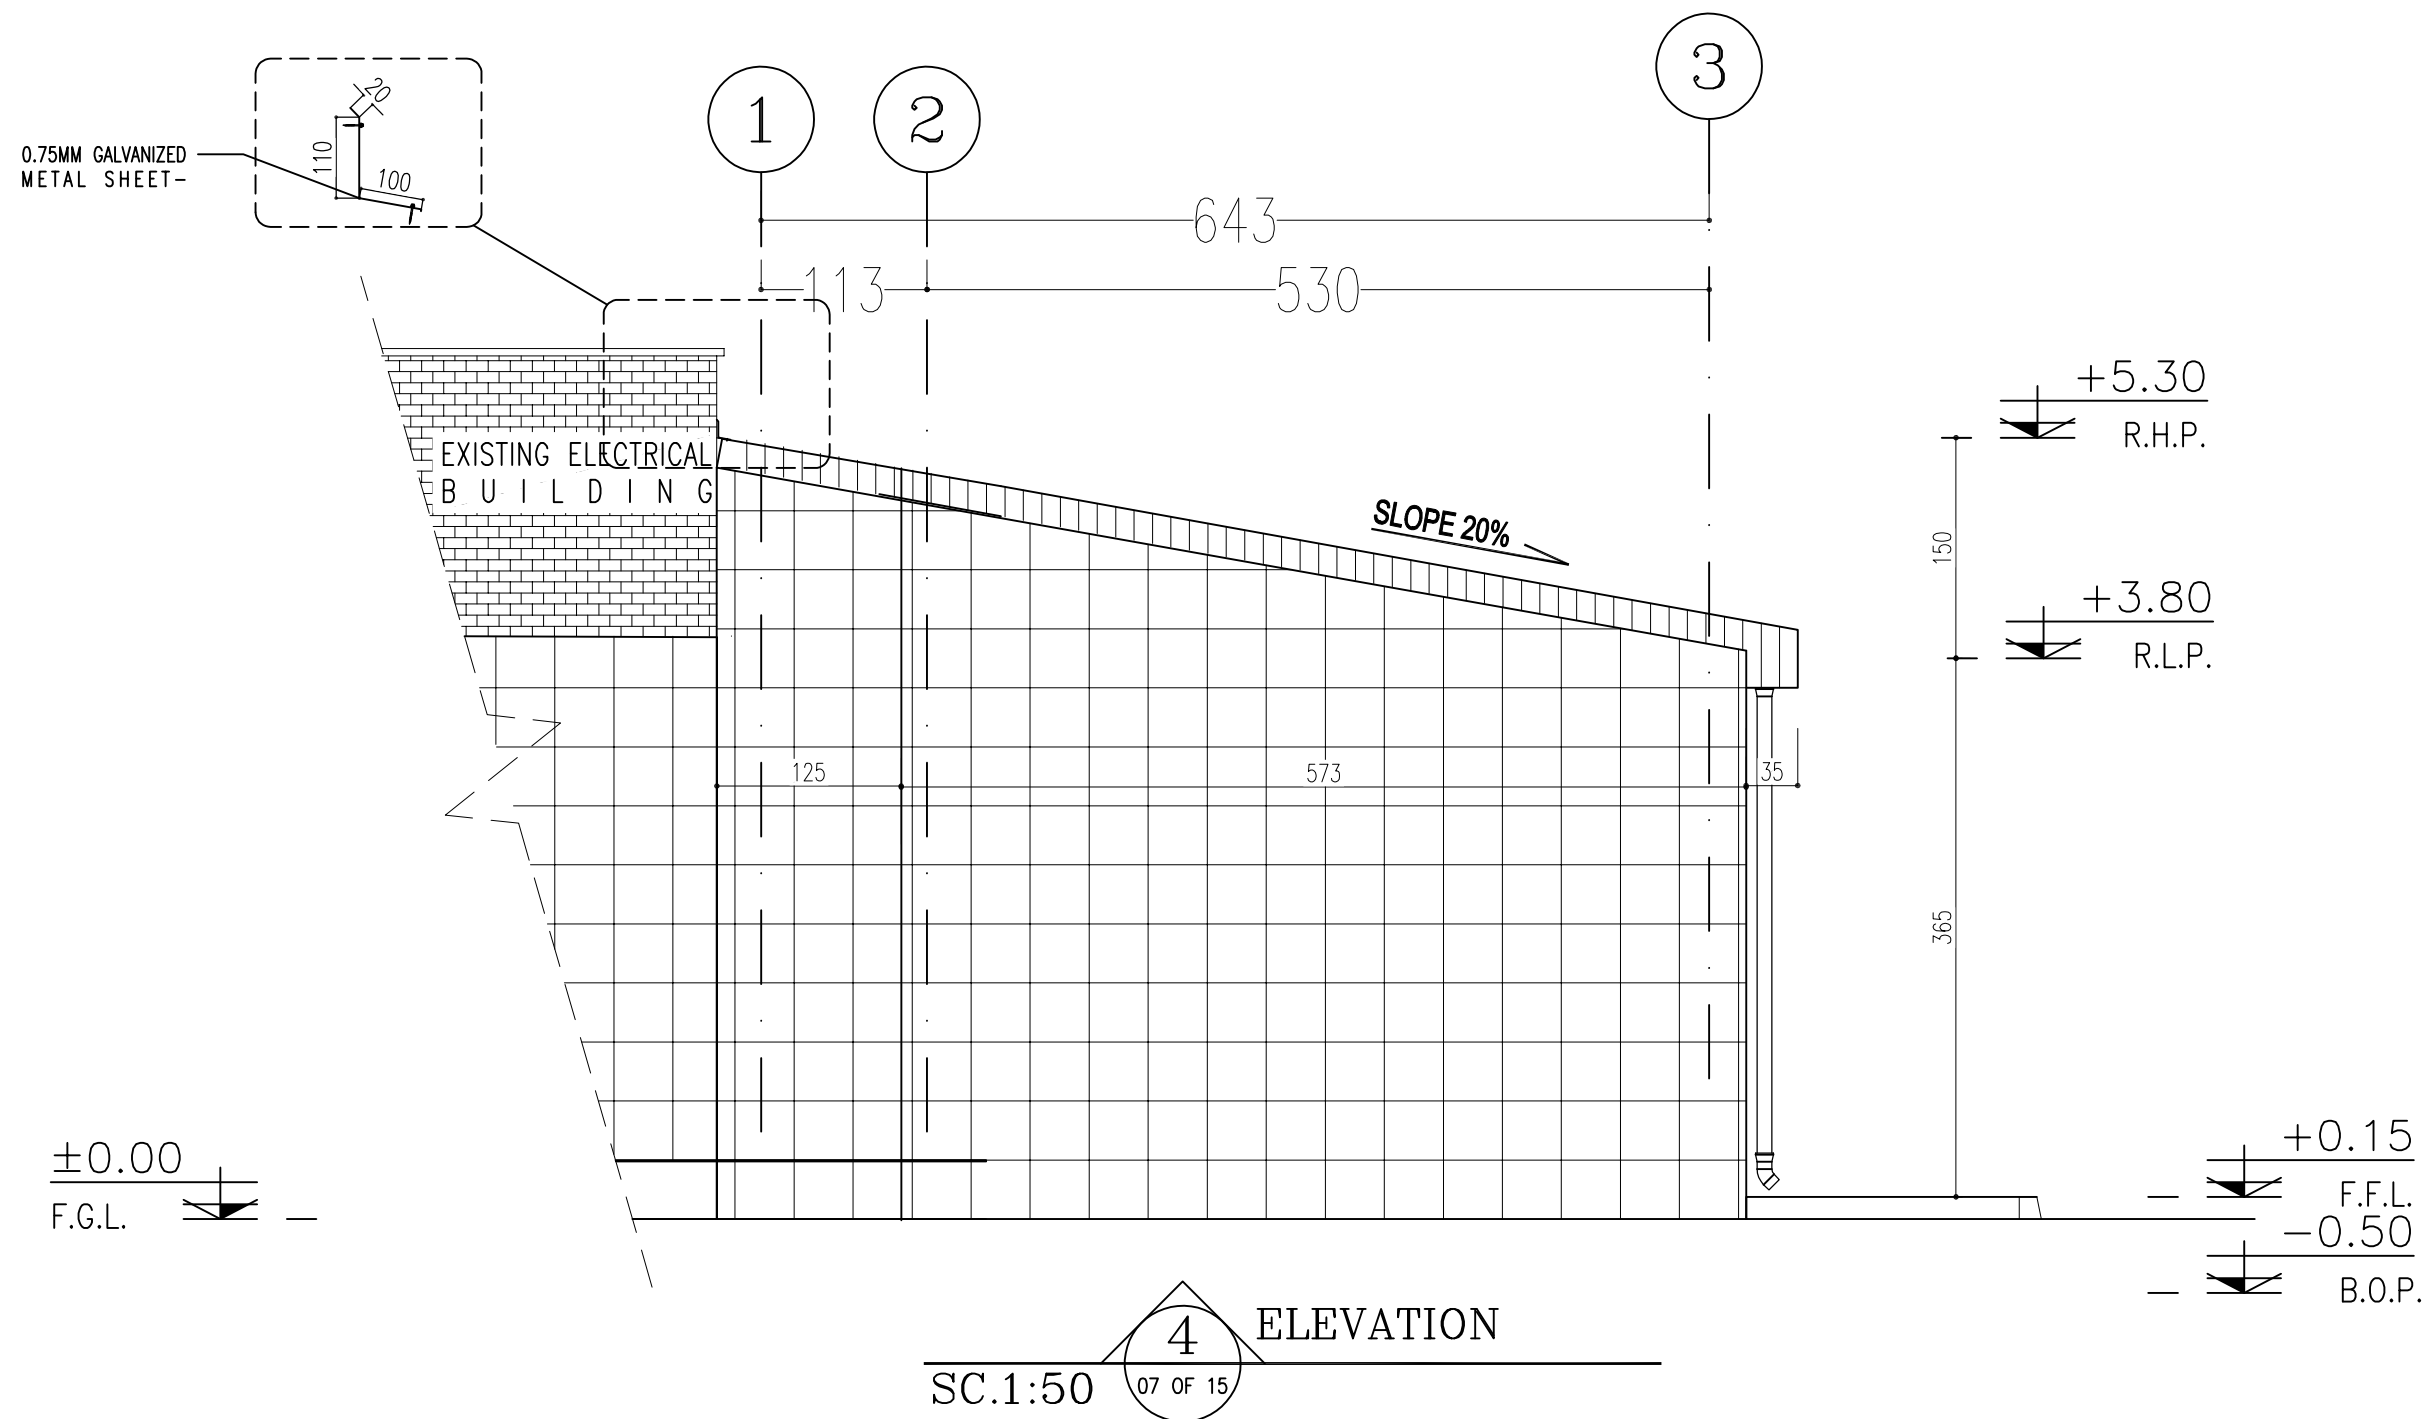


SPACE TAG NUMBER

- 100 CAPACITOR BANK
- 101 CO2 ROOM
- 102 TRANSFORMER ROOM
- 103 FIRE-FIGHTING PUMP TRANSFORMER ROOM
- 104 DIESEL ROOM




NOTES			
1. ALL DIMENSIONS ARE IN CENTIMETER & ALL ELEVATIONS ARE IN METER. 2. ALL DIMENSIONS AND ELEVATIONS SHALL BE CHECKED BY THE CONTRACTOR PRIOR TO CONSTRUCTION. 3. CONTRACTOR SHALL COMPILE ALL ARCHITECTURAL, MECHANICAL, ELECTRICAL, PIPING AND STRUCTURAL DRAWINGS AND IN CASE OF ANY CONFLICTS OR DISCREPANCY, INFORM THE ENGINEER. 4. ALL MATERIALS ARE SELECTED FROM THE HIGHEST QUALITY AND MUST BE APPROVED BY THE CLIENT. 5. ALL OPENINGS FOR PIPING, CABLEING AND HVAC OPENINGS SHALL BE CONSIDERED AS PER RELATED DRAWINGS BEFORE CONSTRUCTION. 6. ARCHITECTURAL DETAIL DESIGN WILL BE REVISED BASED ON APPROVED STRUCTURAL DRAWINGS. 7. ELEVATION CODE : LOCAL 20.0m CORRESPONDS TO GLOBAL +11.10m			
LEGEND			
LEAN CONCRETE			
REINFORCED CONCRETE			
PRESSED BRICK			
STONE			
EXPANSION JOINT FILLER (PLASTOFOAM)			
TERRAZZO TILES FOR ROOF - 30x30cm			
BLOCKAGE			
F.F.L.	FINISHED FLOOR	B.O.P.	BOTTOM OF PIT
T.O.WA	TOP OF WALKWAY	F.G.L.	FINISH GRADING LEVEL
T.O.P.	TOP OF PARAPET	T.O.T.	TOP OF TRENCH
T.O.FOU.	TOP OF FOUNDATION	C.O.S.	CENTER OF SLEEVE
M.D	METAL DOOR	B.O.S.	BOTTOM OF SLEEVE
T.O.R.	TOP OF ROOF	B.O.O.	BOTTOM OF OPENING
T.O.D.	TOP OF DOOR	B.O.T.	BOTTOM OF TRENCH
B.O.Co.	BOTTOM OF CAGE	B.O.P.	BOTTOM OF PIT
T.O.Co.	TOP OF CAGE	R.H.P.	ROOF HIGHEST POINT
B.O.G.	BOTTOM OF GUTTER	R.L.P.	ROOF LOWEST POINT
T.O.Co.	TOP OF CAGE	N.G.R.	NEUTRAL GROUND RESISTOR
M.D.	METAL DOOR	B.P.D.	BLAST-PROOF DOOR
T.O.S.	TOP OF SLAB	F.D.	FENCE DOOR


REFERENCE DRAWING	DRG. No.
STANDARD DRAWING FOR ARCHITECTURAL DETAILS	BK-GNRL-PEDCO-000-AR-DW-0001
SITE SEWORAGE SYSTEM LAYOUT & DETAILS	BK-GCS-PEDCO-120-CY-PY-0001
CABLE TRENCH AND DUCT BANK LAYOUT	BK-GCS-PEDCO-120-CY-PY-0002
ROAD, PAVING AND PLANT FINISH GRADING LAYOUT & SECTIONS	BK-GCS-PEDCO-120-CY-PY-0005
ELECTRICAL CABLE ROUTE & SECTION LAYOUT FOR BUILDING & SHELTER	BK-GCS-PEDCO-120-EL-PY-0006
FOUNDATION DRAWING FOR EXTENSION OF EXISTING ELECT. BUILDING	BK-GCS-PEDCO-120-ST-DW-0063
STRUCTURAL DRAWING FOR EXTENSION OF EXISTING ELECT. BUILDING	BK-GCS-PEDCO-120-ST-DW-0064
STANDARD DETAILS FOR LADDER & SAFETY CAGE	BK-GNRL-PEDCO-000-ST-DW-0009
ELECTRICAL EQUIPMENT ARRANGEMENT LAYOUT FOR BUILDING	BK-GCS-PEDCO-120-ST-EL-PY-0008
Unit Plot Plan Drawing	BK-GCS-PEDCO-120-PI-PY-0001

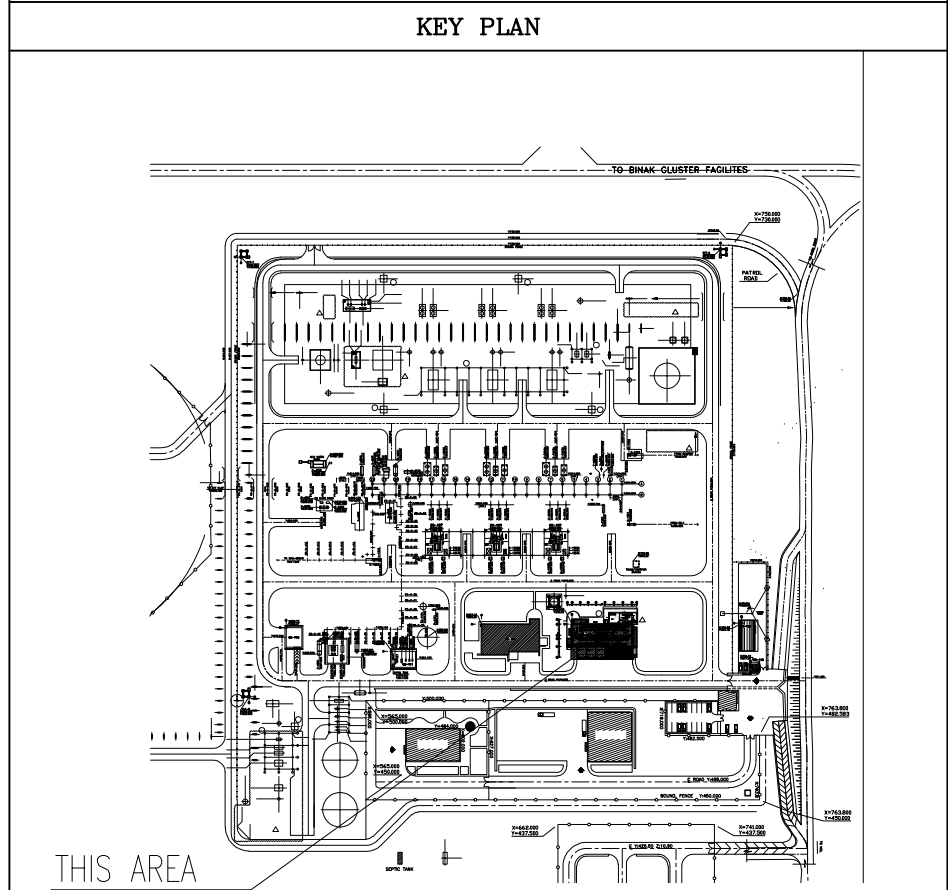

D05	SEP.2023	AFC	R.BERLOUIE	M.PAKHARIAN	A.M.MOHSSENI	***														
D04	AUG.2023	IFA	R.BERLOUIE	M.PAKHARIAN	A.M.MOHSSENI	***														
D03	MAY.2023	IFA	R.BERLOUIE	M.PAKHARIAN	A.M.MOHSSENI	***														
D02	AUG.2022	IFA	R.BERLOUIE	M.PAKHARIAN	M.MEHRSHAD	***	***	*****	***	*****	***	*****	***	*****	***	*****	***	*****	***	
D01	APR.2022	IFA	R.BERLOUIE	M.PAKHARIAN	M.MEHRSHAD	***	REV.	DESCRIPTION	BY	DATE	BY	DATE								
D00	JAN.2022	IPC	R.BERLOUIE	M.PAKHARIAN	M.MEHRSHAD	***			CHECKED		REV.	APPR.								
REV.	DATE	P.O.I.S	PREP.	CHK.	APP.	AUT.														
PROJECT NAME:							BINAK OILFIELD DEVELOPMENT/SURFACE FACILITIES GAS COMPRESSOR STATION													
PROJECT NO.:							971020													
EPC CONTRACTOR:							EPD/EPC CONTRACTOR (GC):							 THE ORIGINAL AND ALL COPIES OF THIS DRAWING TOGETHER WITH THE COPYRIGHT THEREIN ARE THE SOLE PROPERTY OF N.I.S.O.C./ FIELDS						
 HIRGAN ENERGY - DESIGN & INSPECTION COMPANIES							 PETROIRAN DEVELOPMENT COMPANY													
 HIRGAN ENERGY - DESIGN & INSPECTION COMPANIES							 PETROIRAN DEVELOPMENT COMPANY													
DRAWING TITLE:							ARCHITECTURAL DETAIL DRAWING FOR EXTENSION OF EXISTING ELECT. BUILDING ELEVATIONS							NO CONSTRUCTION PERMITTED UNLESS DRAWING APPROVED						
							APPROVED FOR CONSTRUCTION				BY:		DATE:							
							BUDGET REF.				LOCATION	SIZE	CLASS	SERIAL NO.	SHEET	REVISION				
AS SHOWN		A1		BK-GCS-PEDCO-120-AR-DW-0002			08 OF 15		D05		053-073-9184		F 4 B		709100		08 OF 15		D05	

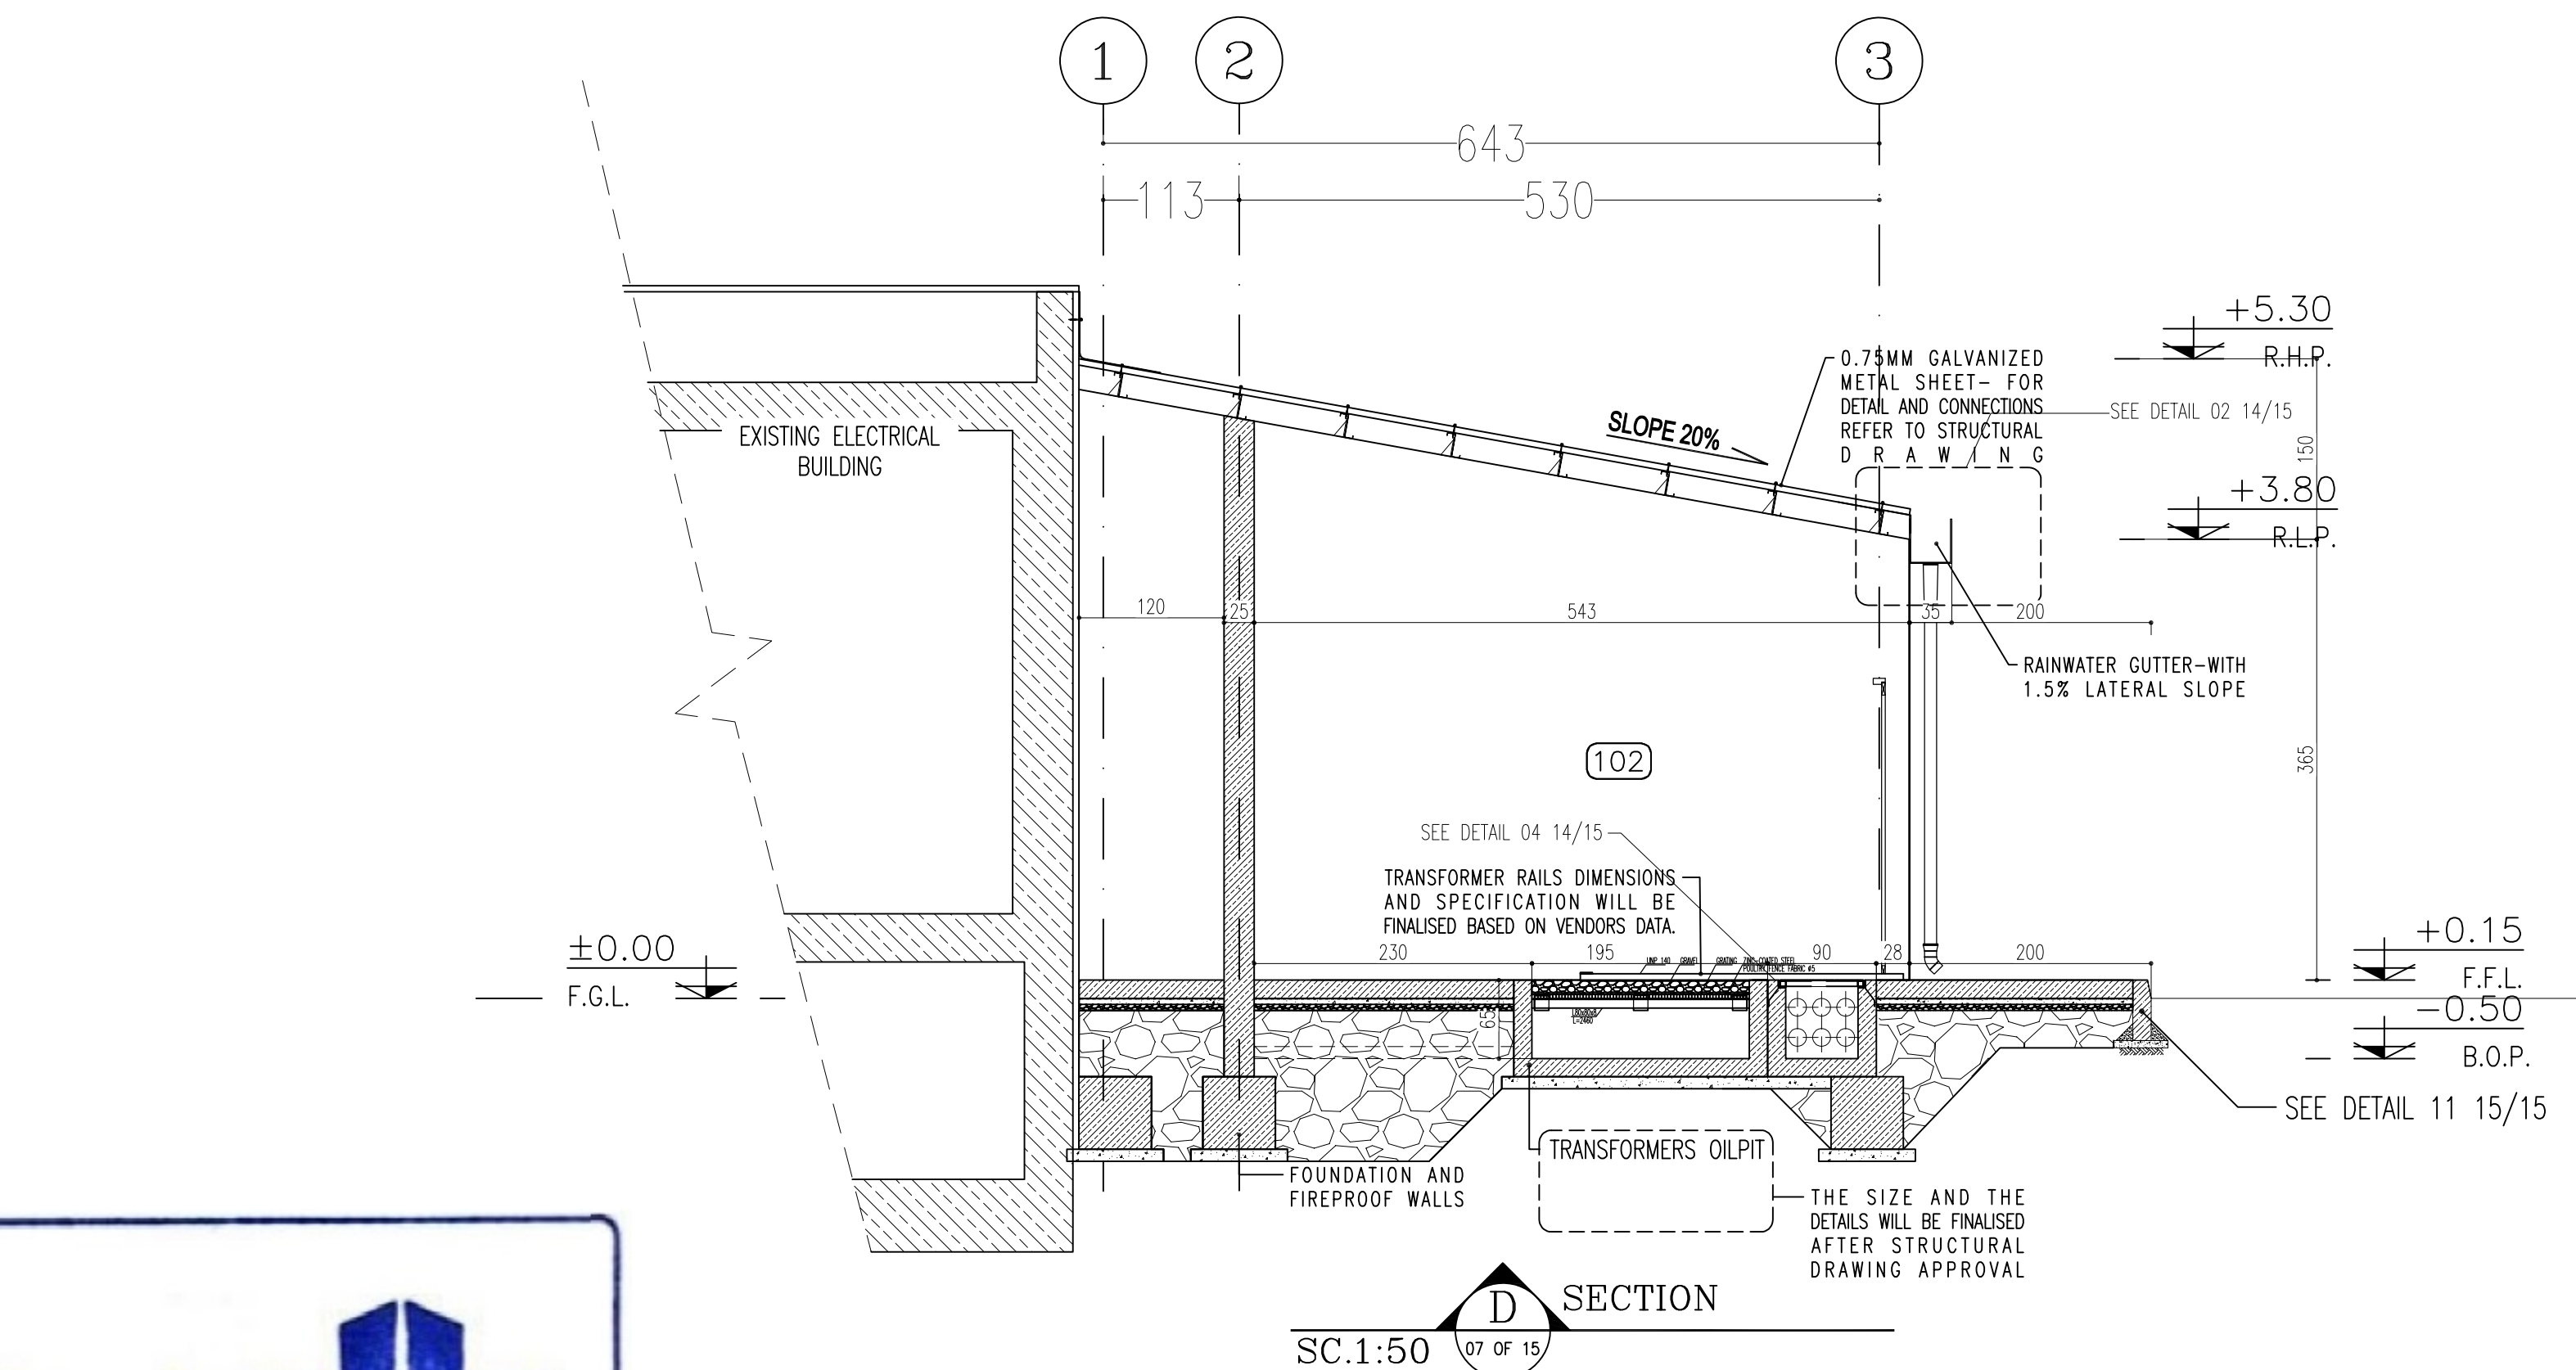

REFERENCE DRAWING	DRG. No.
STANDARD DRAWING FOR ARCHITECTURAL DETAILS	BK-GNRAI-PEDCO-000-AR-DW-0001
SITE SEWAGEAGE SYSTEM LAYOUT & DETAILS	BK-GCS-PEDCO-120-CV-PY-0001
CABLE TRENCH AND DUCT BANK LAYOUT	BK-GCS-PEDCO-120-CV-PY-0002
ROAD, PAVING AND PLANT FINISH GRADING LAYOUT & SECTIONS	BK-GCS-PEDCO-120-CV-PY-0003
ELECTRICAL CABLE ROUTE & SECTION LAYOUT FOR BUILDING & SHELTER	BK-GCS-PEDCO-120-EL-PY-0006
FOUNDATION DRAWING FOR EXTENSION OF EXISTING ELEC. BUILDING	BK-GCS-PEDCO-120-ST-DW-0063
STRUCTURAL DRAWING FOR EXTENSION OF EXISTING ELEC. BUILDING	BK-GCS-PEDCO-120-ST-DW-0064
STANDARD DETAILS FOR LADDER & SAFETY CAGE	BK-GNRAI-PEDCO-000-ST-DW-0001
ELECTRICAL EQUIPMENT ARRANGEMENT LAYOUT FOR BUILDING	BK-GCS-PEDCO-120-ST-EL-PY-0008
Unit Plot Plan Drawing	BK-GCS-PEDCO-120-PI-PY-0001

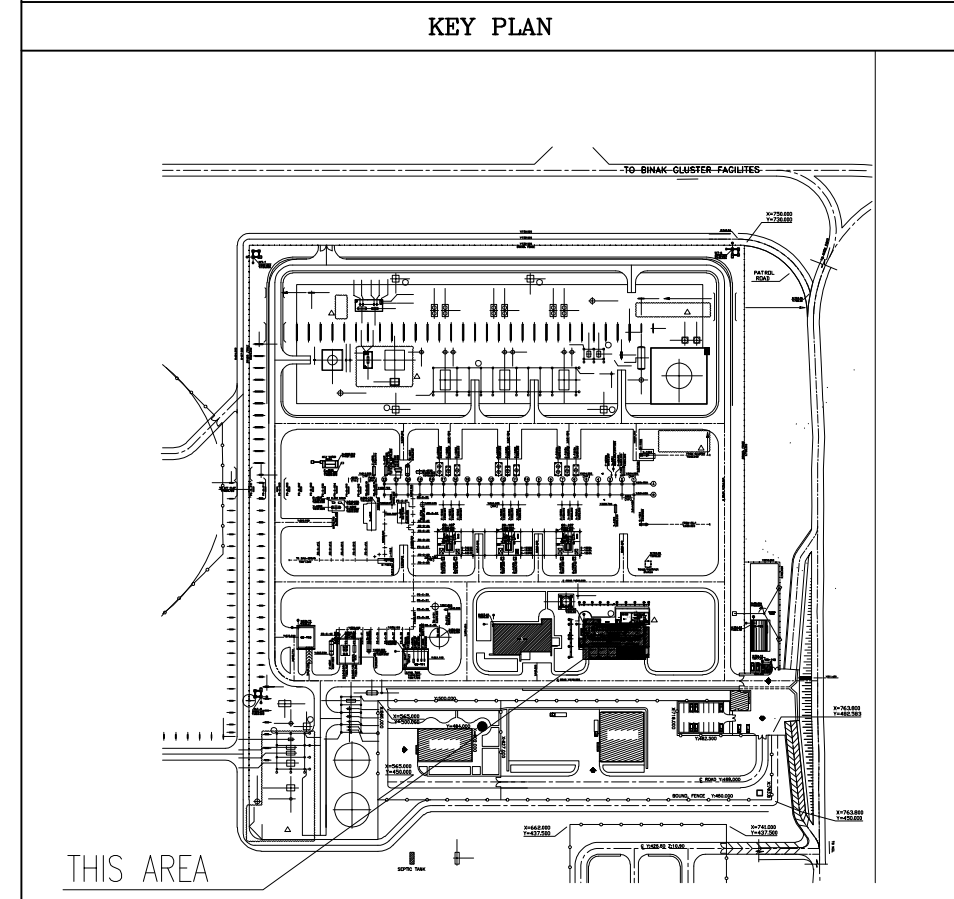[illegible]

- NOTES
1. ALL DIMENSIONS ARE IN CENTIMETER & ALL ELEVATIONS ARE IN METER.
 2. ALL DIMENSIONS AND ELEVATIONS SHALL BE CHECKED BY THE CONTRACTOR PRIOR TO CONSTRUCTION.
 3. CONTRACTOR SHALL COMPARE ALL ARCHITECTURAL, MECHANICAL, ELECTRICAL, PIPING AND STRUCTURAL DRAWINGS AND IN CASE OF ANY CONFLICTS OR DISCREPANCY, INFORM THE ENGINEER.
 4. ALL MATERIALS ARE SELECTED FROM THE HIGHEST QUALITY AND MUST BE APPROVED BY THE CLIENT.
 5. ALL OPENINGS FOR PIPING/CABLEING AND HVAC OPENINGS SHALL BE CONSIDERED AS PER RELATED DRAWINGS BEFORE CONSTRUCTION.
 6. ARCHITECTURAL DETAIL DESIGN WILL BE REVISED BASED ON APPROVED STRUCTURAL DRAWINGS.
 7. ELEVATION CODE : LOCAL ±0.0m CORRESPONDS TO GLOBAL ±11.10m


LEGEND

- LEAN CONCRETE
- REINFORCED CONCRETE
- PRESSED BRICK
- STONE
- EXPANSION JOINT FILLER (PLASTOFOAM)
- TERRAZZO TILES FOR ROOF - 30x30cm
- BLOCKAGE

- F.F.L. FINISHED FLOOR B.O.P. BOTTOM OF PIT
- T.O.WA TOP OF WALKWAY F.G.L. FINISH GRADING LEVEL
- T.O.P. TOP OF PARAPET T.O.T. TOP OF TRENCH
- T.O.FOU. TOP OF FOUNDATION C.O.S. CENTER OF SLEEVE
- M.D. METAL DOOR B.O.S. BOTTOM OF SLEEVE
- T.O.R. TOP OF ROOF B.O.O. BOTTOM OF OPENING
- T.O.D. TOP OF DOOR B.O.T. BOTTOM OF TRENCH
- B.O.Co. BOTTOM OF CAGE B.O.P. BOTTOM OF PIT
- T.O.Co. TOP OF CAGE R.H.P. ROOF HIGHEST POINT
- B.O.G. BOTTOM OF GUTTER R.L.P. ROOF LOWEST POINT
- T.O.Co. TOP OF CAGE N.G.R. NEUTRAL GROUND RESISTOR
- M.D. METAL DOOR B.P.D. BLAST-PROOF DOOR
- T.O.S. TOP OF SLAB F.D. FENCE DOOR

REFERENCE DRAWING	DRG. No.
STANDARD DRAWING FOR ARCHITECTURAL DETAILS	BK-GNRL-PEDCO-000-AR-DW-0001
SITE SEWORAGE SYSTEM LAYOUT & DETAILS	BK-GCS-PEDCO-120-CV-PY-0001
CABLE TRENCH AND DUCT BANK LAYOUT	BK-GCS-PEDCO-120-CV-PY-0002
ROAD, PAVING AND PLANT FINISH GRADING LAYOUT & SECTIONS	BK-GCS-PEDCO-120-CV-PY-0005
ELECTRICAL CABLE ROUTE & SECTION LAYOUT FOR BUILDING & SHEDS	BK-GCS-PEDCO-120-EL-PY-0006
FOUNDATION DRAWING FOR EXTENSION OF EXISTING ELECT. BUILDING	BK-GCS-PEDCO-120-ST-DW-0063
STRUCTURAL DRAWING FOR EXTENSION OF EXISTING ELECT. BUILDING	BK-GCS-PEDCO-120-ST-DW-0064
STANDARD DETAILS FOR LADDER & SAFETY CAGE	BK-GNRL-PEDCO-000-ST-DW-0009
ELECTRICAL EQUIPMENT ARRANGEMENT LAYOUT FOR BUILDING	BK-GCS-PEDCO-120-ST-EL-PY-0008
Unit Plot Plan Drawing	BK-GCS-PEDCO-120-PI-PY-0001

KEY PLAN

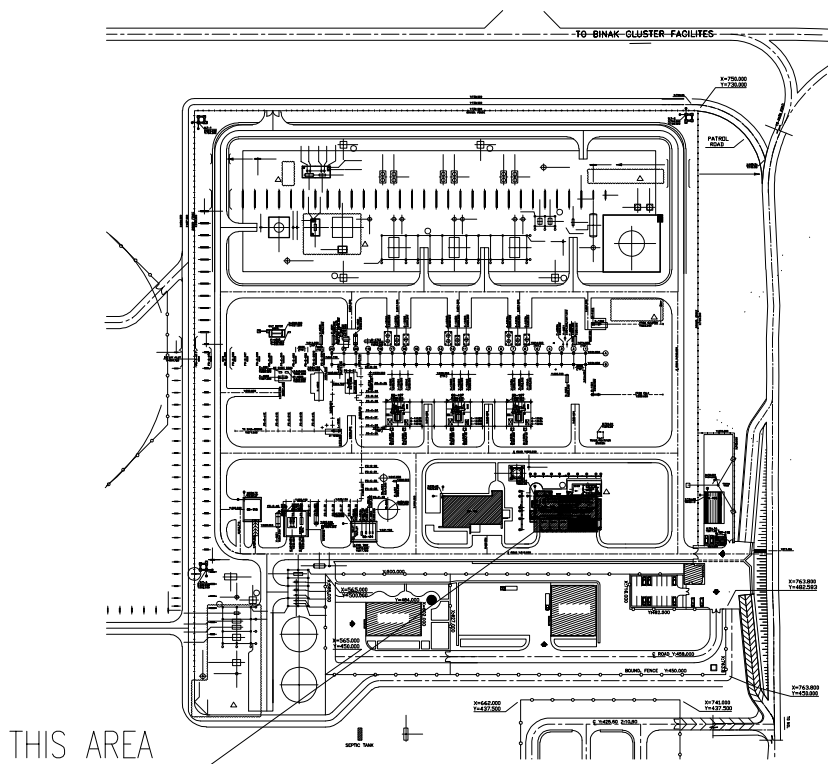


D05	SEP.2023	AFC	R.BERLOUE	M.PAKHARIAN	A.M.MOHSSENI	***
D04	AUG.2023	IFA	R.BERLOUE	M.PAKHARIAN	A.M.MOHSSENI	***
D03	MAY.2023	IFA	R.BERLOUE	M.PAKHARIAN	A.M.MOHSSENI	***
D02	AUG.2022	IFA	R.BERLOUE	M.PAKHARIAN	M.MEHRSHAD	***
D01	APR.2022	IFA	R.BERLOUE	M.PAKHARIAN	M.MEHRSHAD	***
D00	JAN.2022	IFC	R.BERLOUE	M.PAKHARIAN	M.MEHRSHAD	***
REV.	DATE	P.O.I.S	PREP.	CHK.	APP.	AUT.
PROJECT NAME: BINAK OILFIELD DEVELOPMENT/SURFACE FACILITIES GAS COMPRESSOR STATION						
PROJECT NO.:			971020			
EPC CONTRACTOR:			EPD/EPC CONTRACTOR (GC):			
 HIRGAN ENERGY - DESIGN & INSPECTION COMPANIES			 PETROIRAN DEVELOPMENT COMPANY			
DRAWING TITLE: ARCHITECTURAL DETAIL DRAWING FOR EXTENSION OF EXISTING ELECT. BUILDING PLANS						
SCALE	SIZE	DRAWING NO.			SHEET NO.	REV.
AS SHOWN	A1	BK-GCS-PEDCO-120-AR-DW-0002			10 OF 15	D05


REV.	DESCRIPTION	BY	DATE	BY	DATE
		CHECKED		REV. APPR.	
اصل و کلیه نسخ این نقشه و حق اقتباس متعلق به شرکت ملی مناطق نفت خیز جنوب می باشد.					
THE ORIGINAL AND ALL COPIES OF THIS DRAWING TOGETHER WITH THE COPYRIGHT THEREIN ARE THE SOLE PROPERTY OF N.I.S.O.C./ FIELDS					
BINAK OILFIELD DEVELOPMENT SURFACE FACILITIES GAS COMPRESSOR STATION					
DATE	SCALE	DRAWING BY	CHECKED BY	PROJECT ENG.	
NO CONSTRUCTION PERMITTED UNLESS DRAWING APPROVED					
APPROVED FOR CONSTRUCTION			BY:	DATE:	
SCALE	SIZE	DRAWING NO.	SHEET NO.	REV.	BUDGET REF.
AS SHOWN	A1	BK-GCS-PEDCO-120-AR-DW-0002	10 OF 15	D05	053-073-9184

SPACE TAG NUMBER



- 100 CAPACITOR BANK
- 101 CO2 ROOM
- 102 TRANSFORMER ROOM
- 103 FIRE-FIGHTING PUMP TRANSFORMER ROOM
- 104 DIESEL ROOM

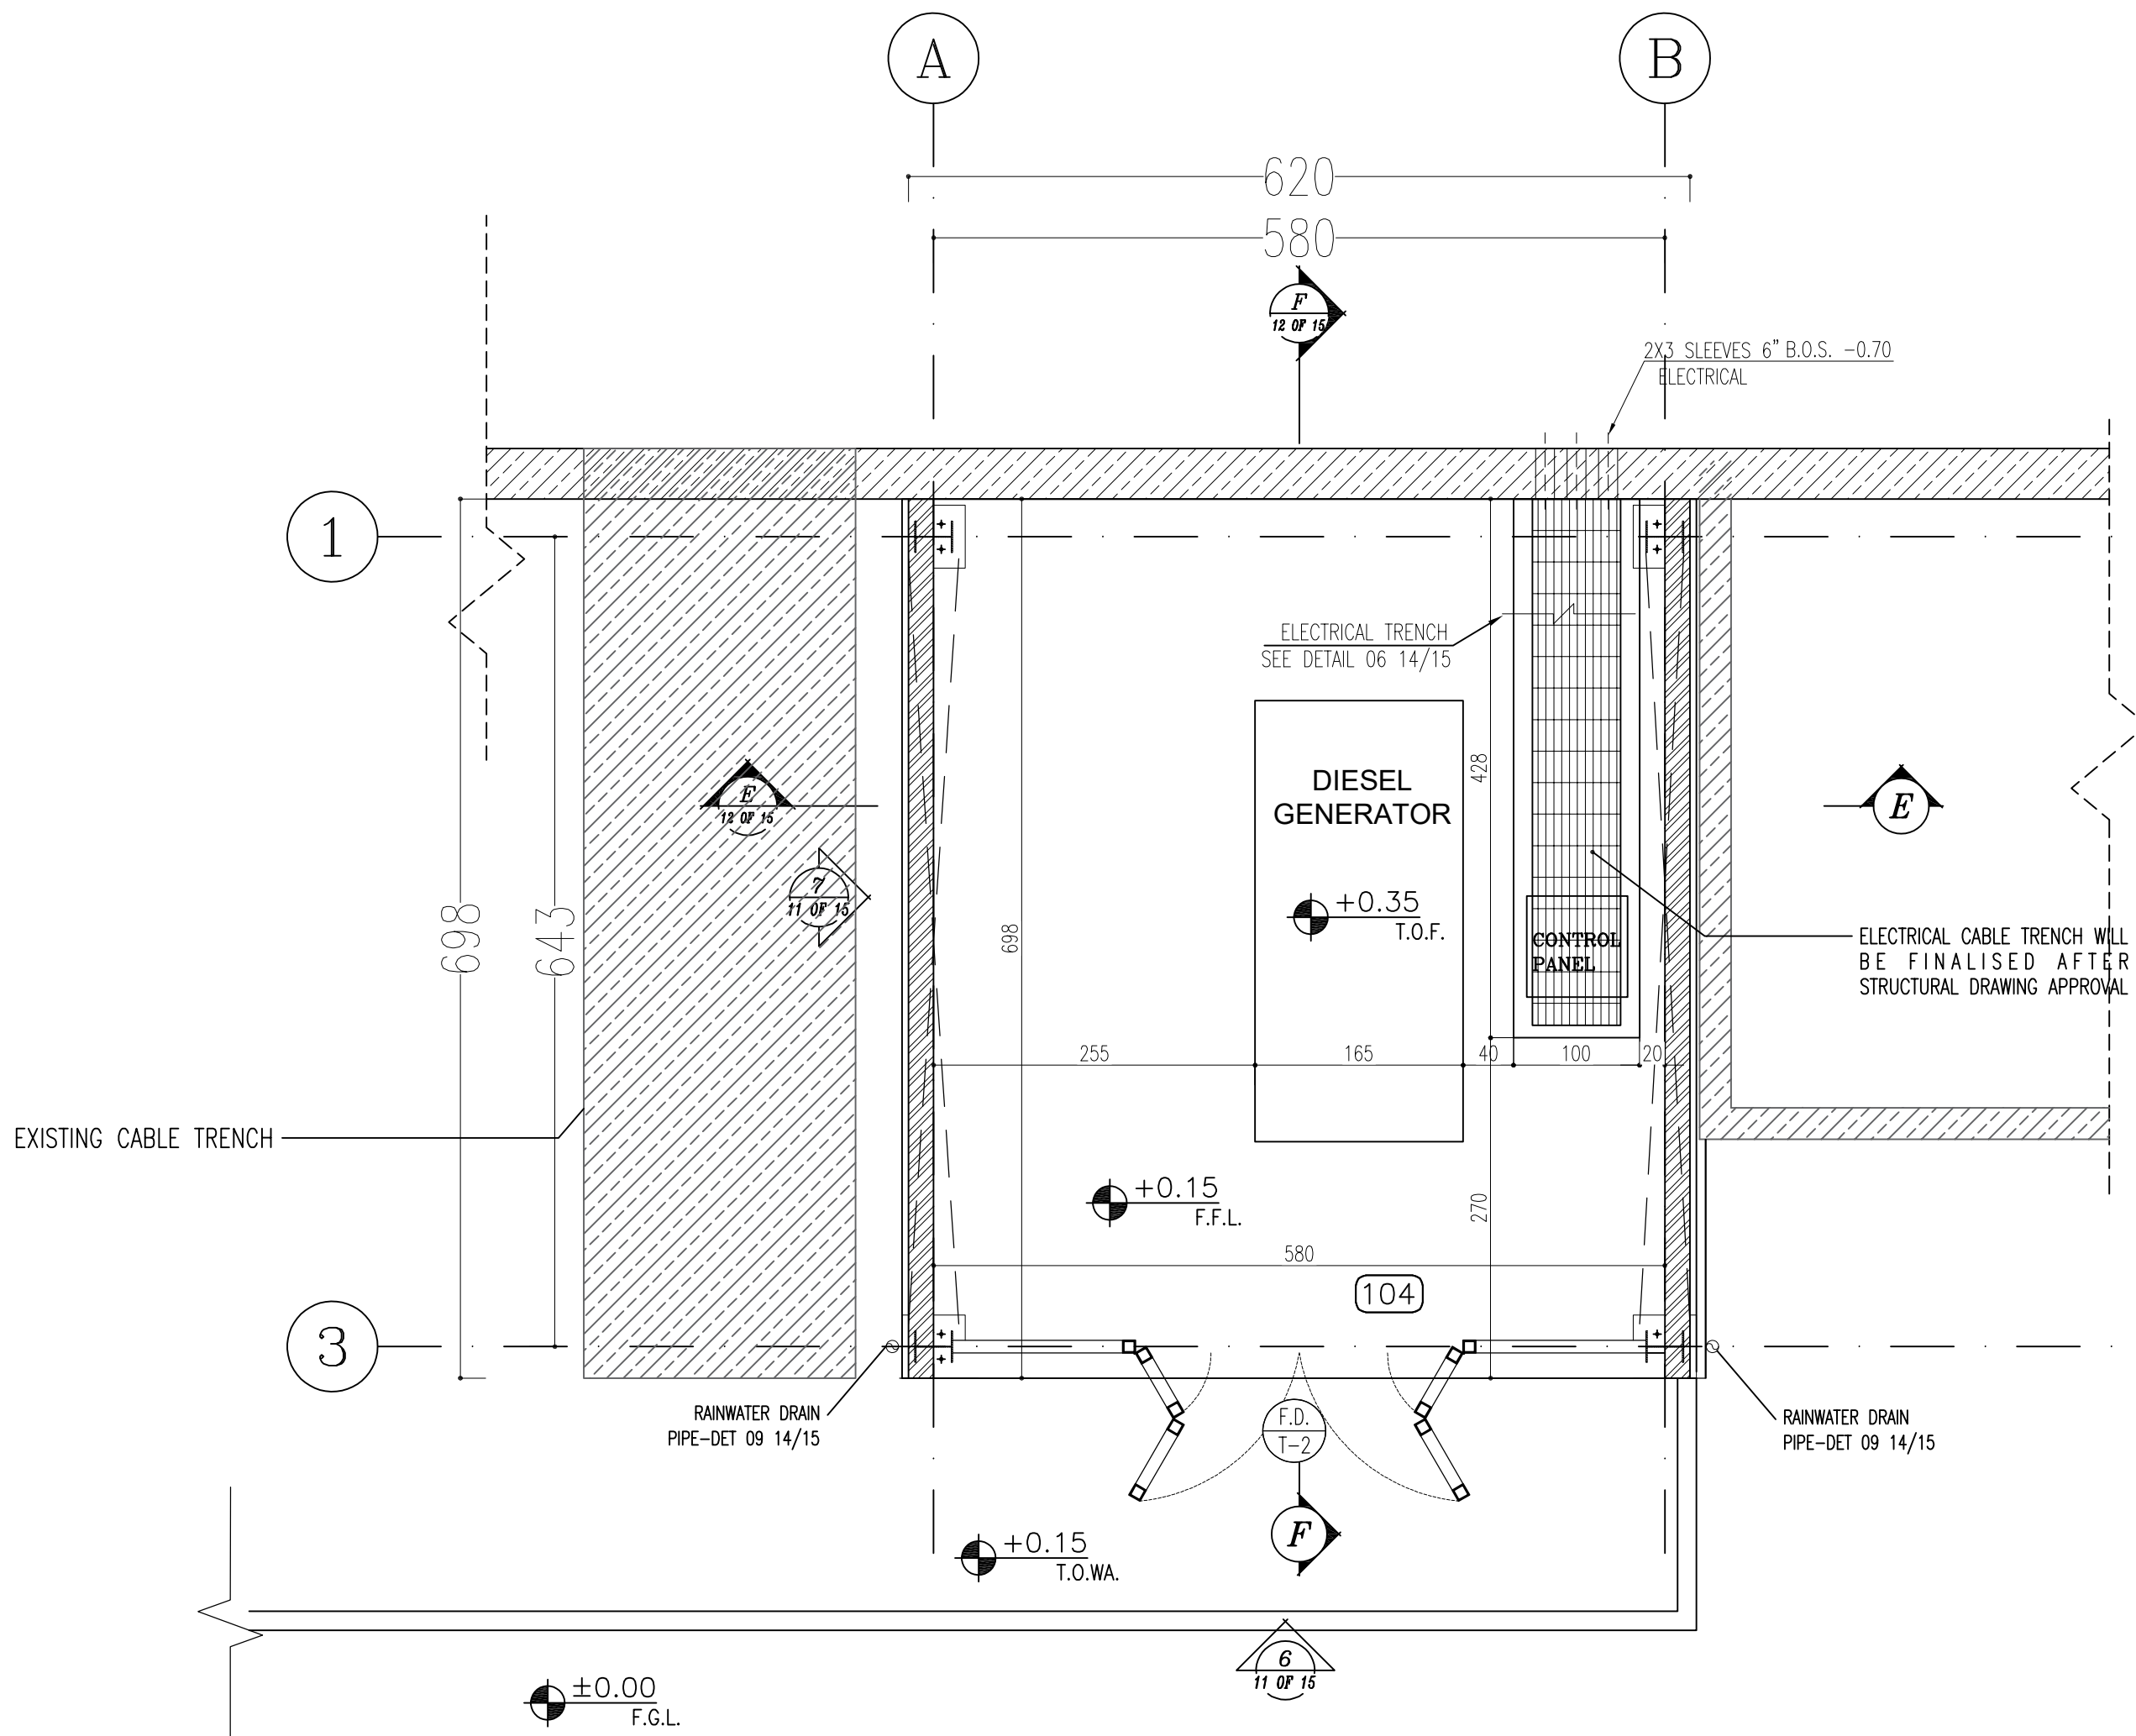

6 DIESEL ROOM PLAN

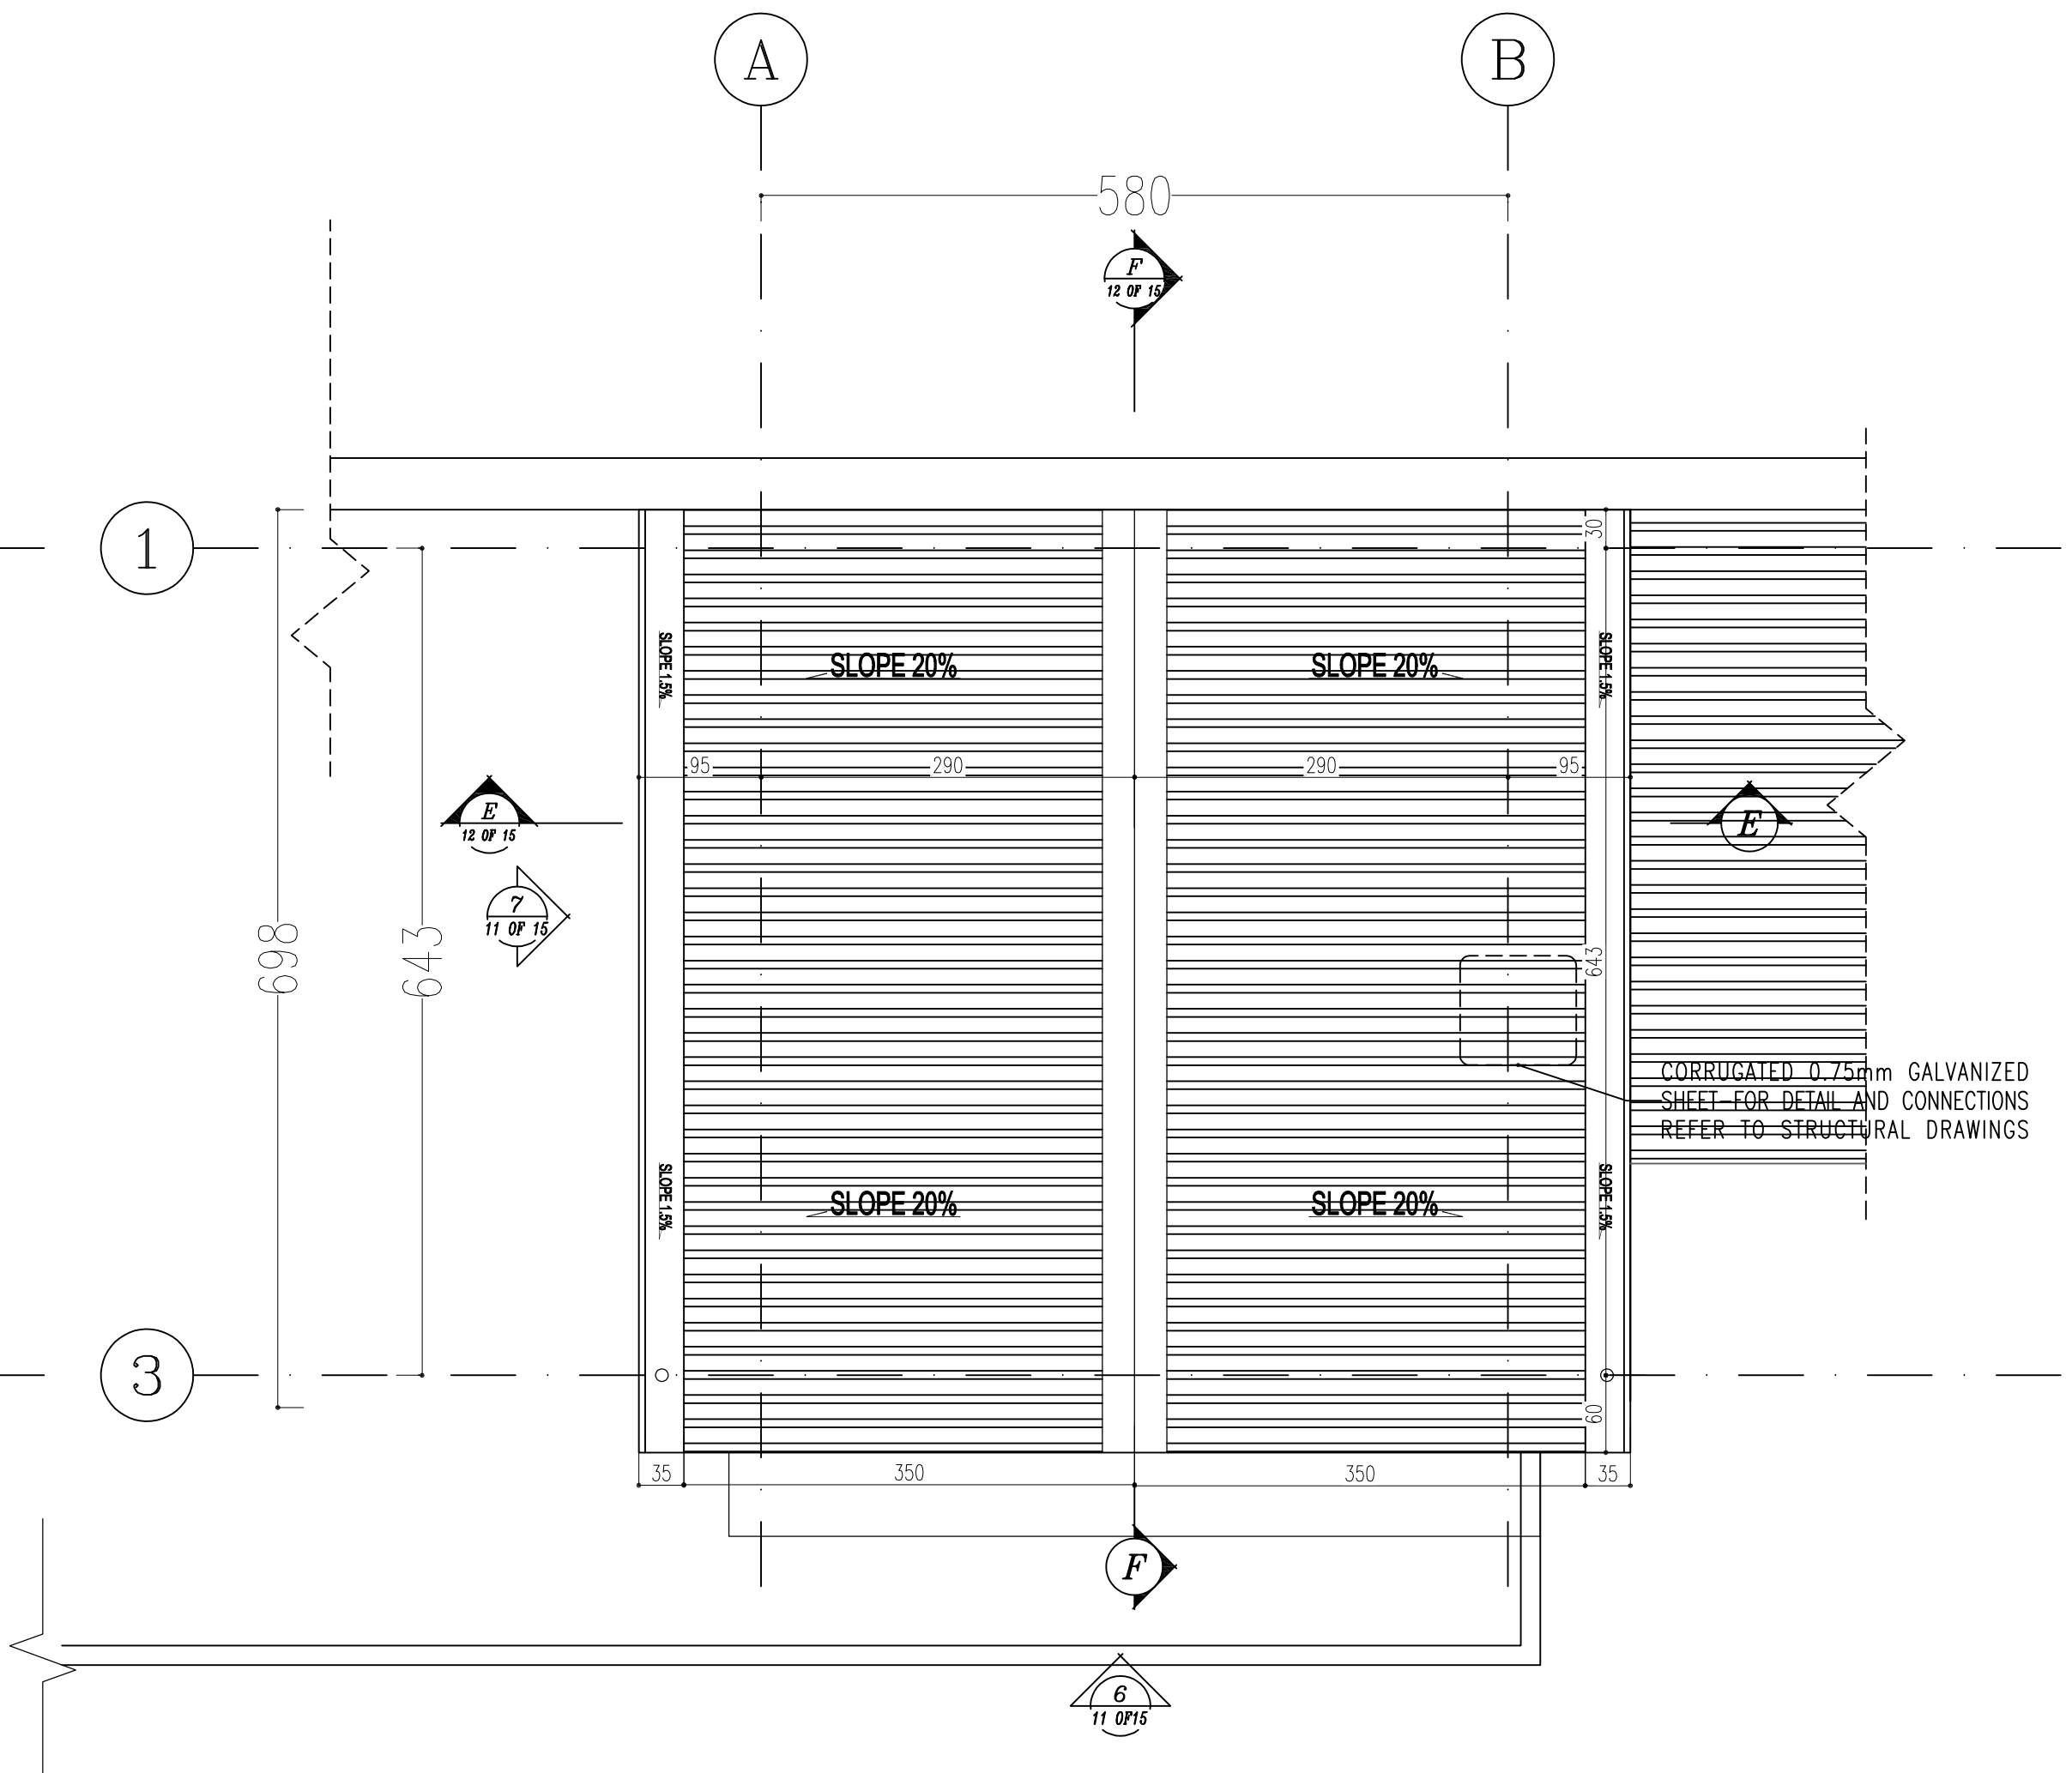


7 DIESEL ROOM ROOF PLAN

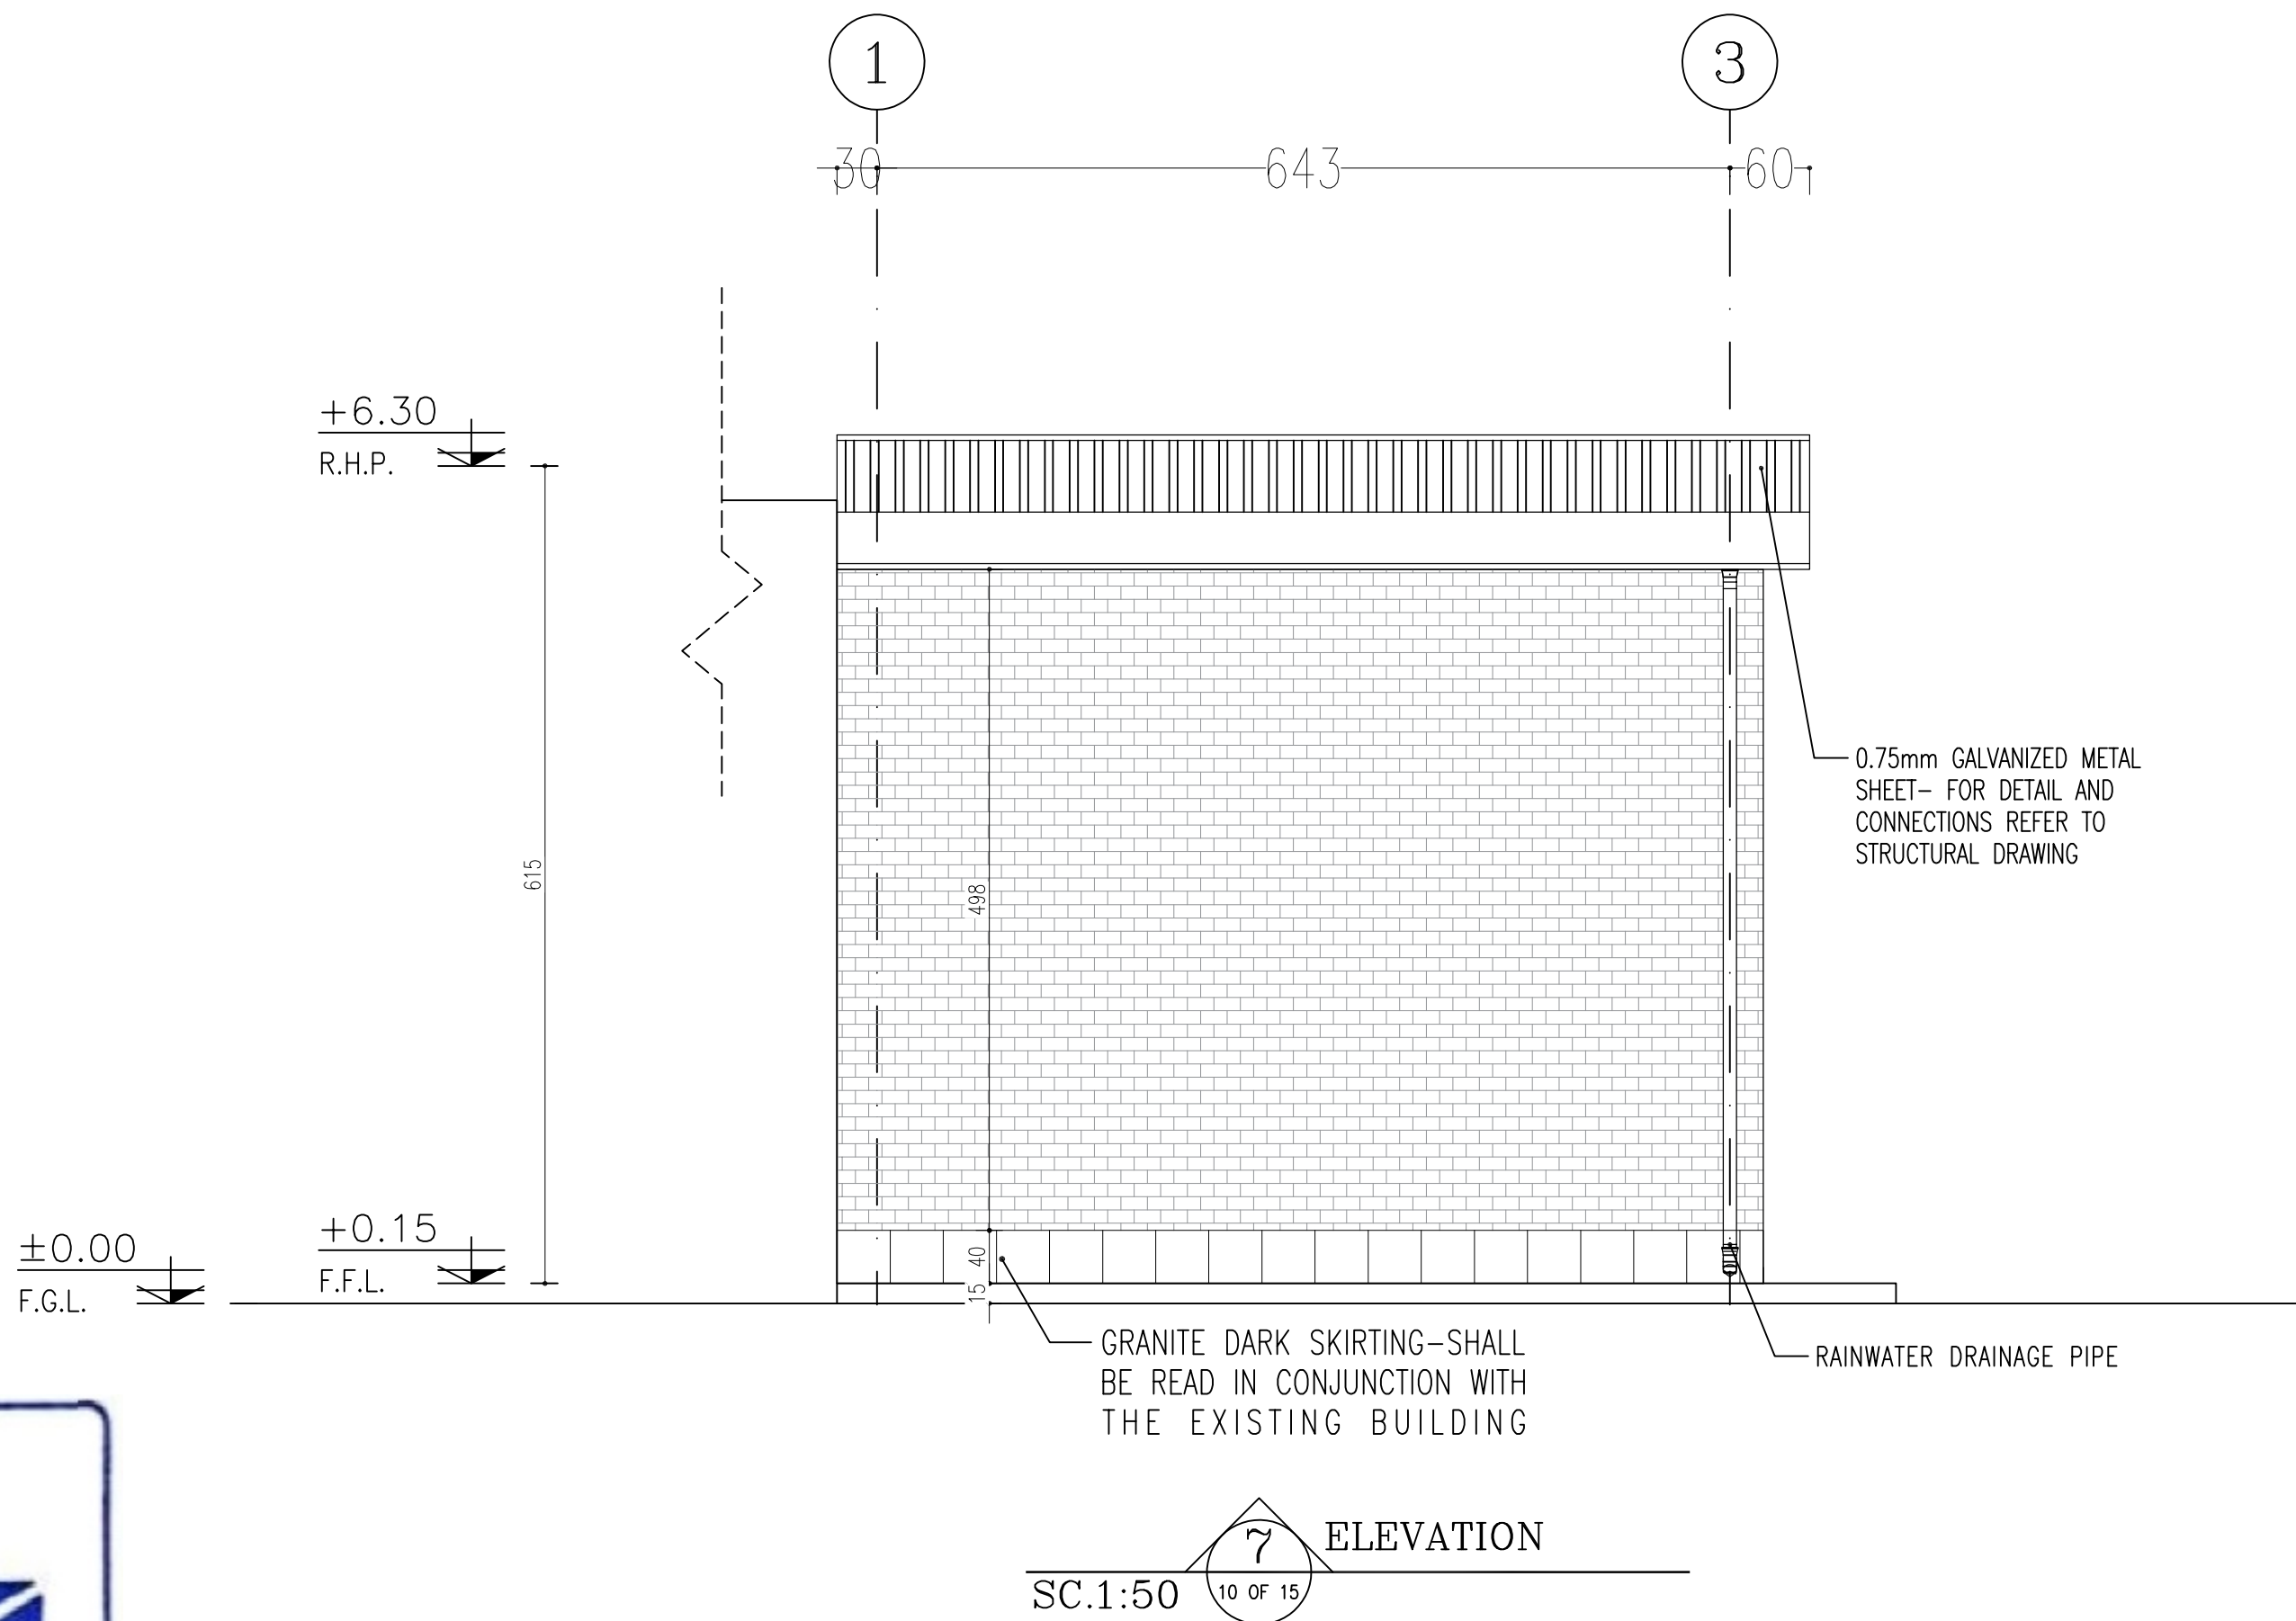
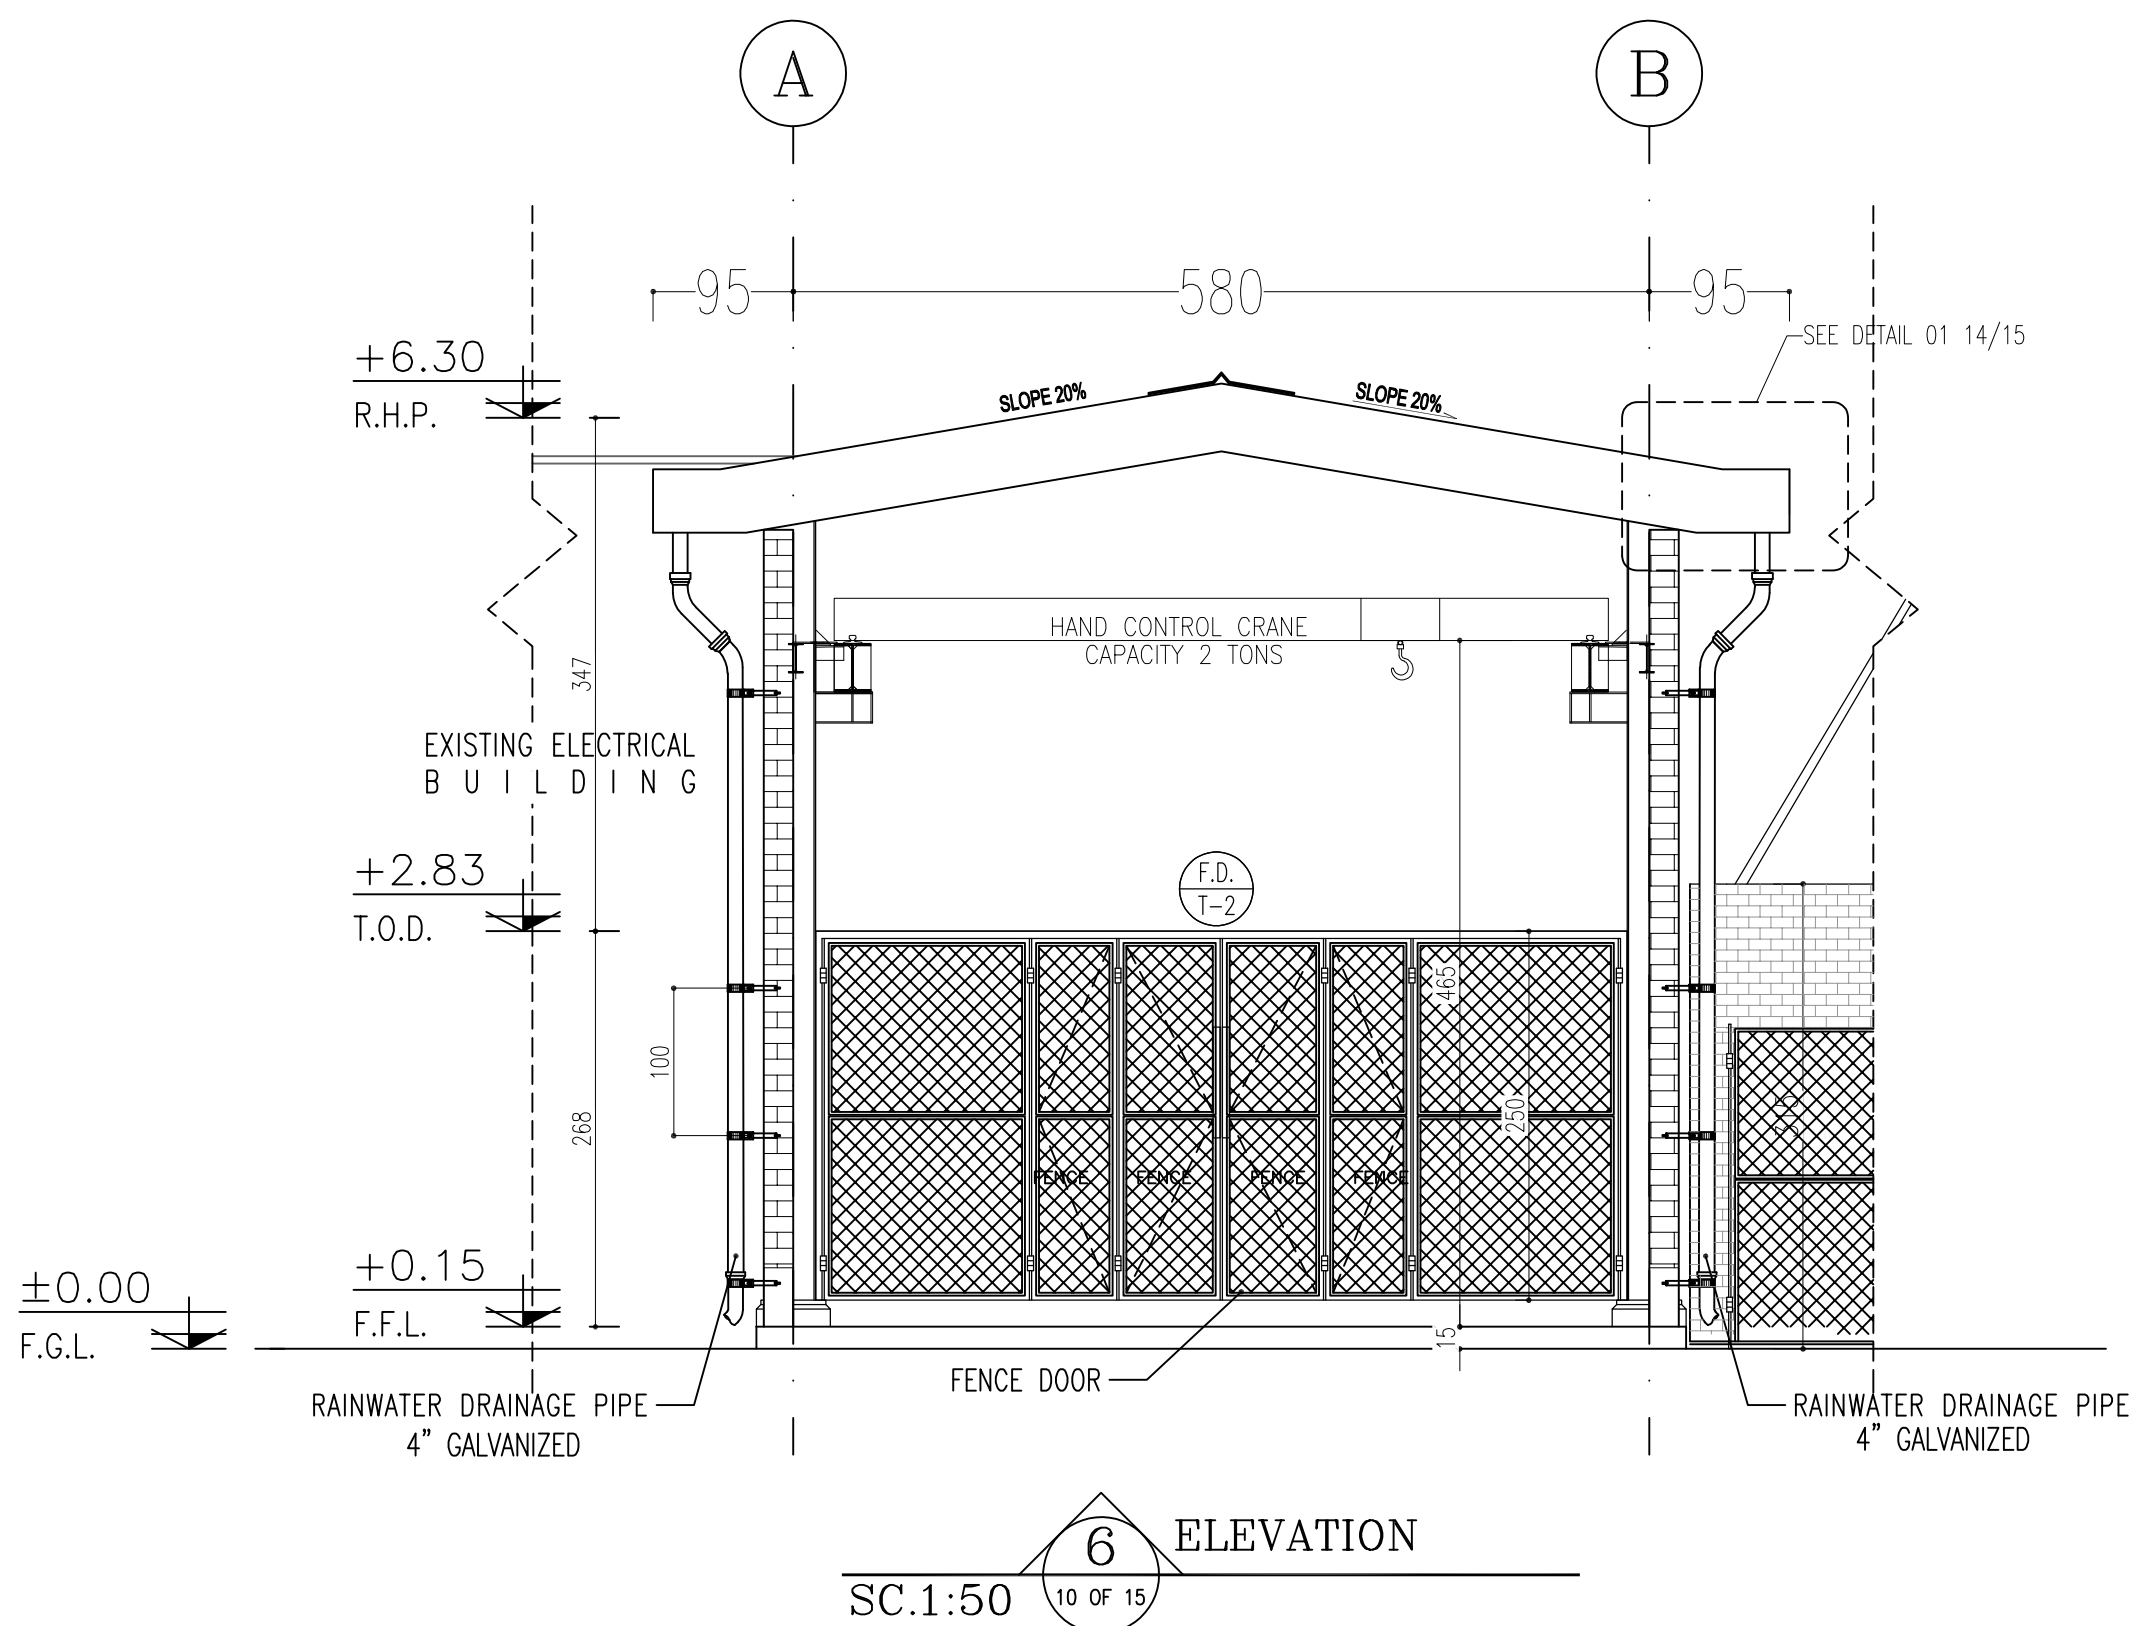


NOTES			
1. ALL DIMENSIONS ARE IN CENTIMETER & ALL ELEVATIONS ARE IN METER. 2. ALL DIMENSIONS AND ELEVATIONS SHALL BE CHECKED BY THE CONTRACTOR PRIOR TO CONSTRUCTION. 3. CONTRACTOR SHALL COMPILE ALL ARCHITECTURAL, MECHANICAL, ELECTRICAL, PIPING AND STRUCTURAL DRAWINGS AND IN CASE OF ANY CONFLICTS OR DISCREPANCY, INFORM THE ENGINEER. 4. ALL MATERIALS ARE SELECTED FROM THE HIGHEST QUALITY AND MUST BE APPROVED BY THE CLIENT. 5. ALL OPENINGS FOR PIPING, CABLEING AND HVAC OPENINGS SHALL BE CONSIDERED AS PER RELATED DRAWINGS BEFORE CONSTRUCTION. 6. ARCHITECTURAL DETAIL DESIGN WILL BE REVISED BASED ON APPROVED STRUCTURAL DRAWINGS. 7. ELEVATION CODE : LOCAL ±0.0m CORRESPONDS TO GLOBAL +11.10m			
LEGEND			
LEAN CONCRETE			
REINFORCED CONCRETE			
PRESSED BRICK			
STONE			
EXPANSION JOINT FILLER (PLASTOFOAM)			
TERRAZZO TILES FOR ROOF - 30x30cm			
BLOCKAGE			
F.F.L.	FINISHED FLOOR	B.O.P.	BOTTOM OF PIT
T.O.WA	TOP OF WALKWAY	F.G.L.	FINISH GRADING LEVEL
T.O.P.	TOP OF PARAPET	T.O.T.	TOP OF TRENCH
T.O.FOU.	TOP OF FOUNDATION	C.O.S.	CENTER OF SLEEVE
M.D	METAL DOOR	B.O.S.	BOTTOM OF SLEEVE
T.O.R.	TOP OF ROOF	B.O.O.	BOTTOM OF OPENING
T.O.D.	TOP OF DOOR	B.O.T.	BOTTOM OF TRENCH
B.O.Co.	BOTTOM OF CAGE	B.O.P.	BOTTOM OF PIT
T.O.Co.	TOP OF CAGE	R.H.P.	ROOF HIGHEST POINT
B.O.G.	BOTTOM OF GUTTER	R.L.P.	ROOF LOWEST POINT
T.O.Co.	TOP OF CAGE	N.G.R.	NEUTRAL GROUND RESISTOR
M.D.	METAL DOOR	B.P.D.	BLAST-PROOF DOOR
T.O.S.	TOP OF SLAB	F.D.	FENCE DOOR

REFERENCE DRAWING	DRG. No.
STANDARD DRAWING FOR ARCHITECTURAL DETAILS	BK-GNRL-PEDCO-000-AR-DW-0001
SITE SEWORAGE SYSTEM LAYOUT & DETAILS	BK-GCS-PEDCO-120-CY-PY-0001
CABLE TRENCH AND DUCT BANK LAYOUT	BK-GCS-PEDCO-120-CY-PY-0002
ROAD, PAVING AND PLANT FINISH GRADING LAYOUT & SECTIONS	BK-GCS-PEDCO-120-CY-PY-0005
ELECTRICAL CABLE ROUTE & SECTION LAYOUT FOR BUILDING & SHELTER	BK-GCS-PEDCO-120-EL-PY-0006
FOUNDATION DRAWING FOR EXTENSION OF EXISTING ELECT. BUILDING	BK-GCS-PEDCO-120-ST-DW-0063
STRUCTURAL DRAWING FOR EXTENSION OF EXISTING ELECT. BUILDING	BK-GCS-PEDCO-120-ST-DW-0064
STANDARD DETAILS FOR LADDER & SAFETY CAGE	BK-GNRL-PEDCO-000-ST-DW-0009
ELECTRICAL EQUIPMENT ARRANGEMENT LAYOUT FOR BUILDING	BK-GCS-PEDCO-120-ST-EL-PY-0008
Unit Plot Plan Drawing	BK-GCS-PEDCO-120-PI-PY-0001

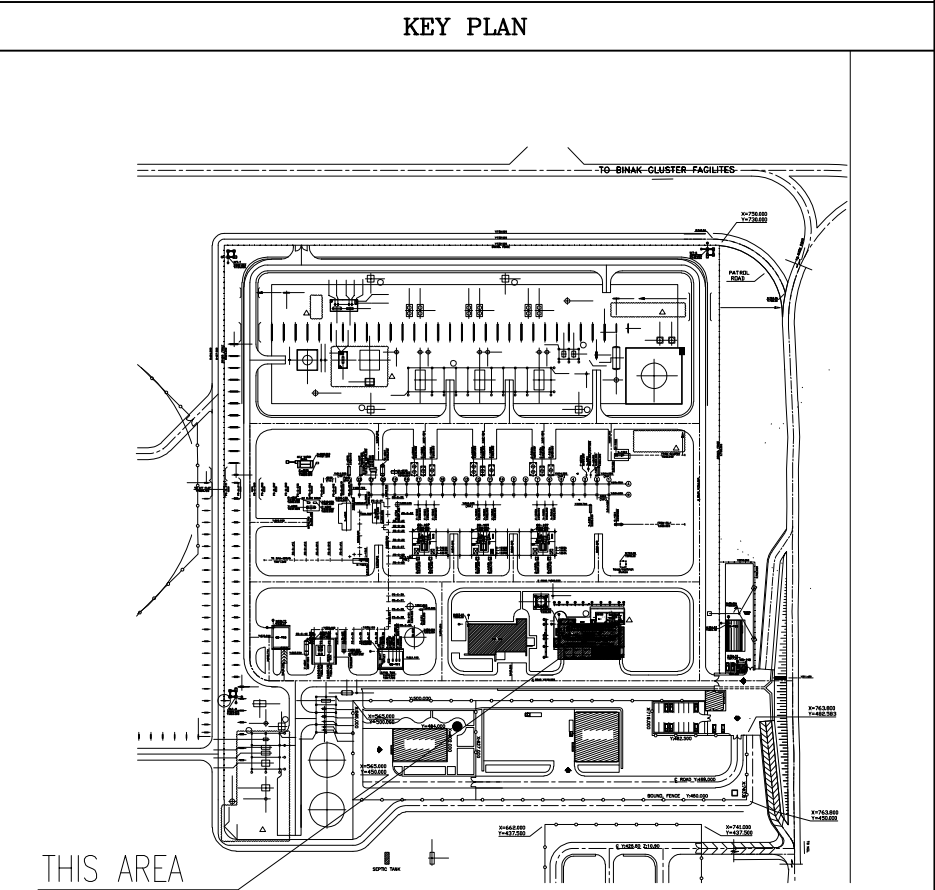


D05	SEP.2023	AFC	R.BERLOUIE	M.PAKHARIAN	A.M.MOHSSENI	***																	
D04	AUG.2023	IFA	R.BERLOUIE	M.PAKHARIAN	A.M.MOHSSENI	***																	
D03	MAY.2023	IFA	R.BERLOUIE	M.PAKHARIAN	A.M.MOHSSENI	***																	
D02	AUG.2022	IFA	R.BERLOUIE	M.PAKHARIAN	M.MEHRSHAD	***	***	*****		***	*****	***	*****	***	*****	***	*****	***	*****				
D01	APR.2022	IFA	R.BERLOUIE	M.PAKHARIAN	M.MEHRSHAD	***	REV.	DESCRIPTION		BY	DATE	BY	DATE										
D00	JAN.2022	IFC	R.BERLOUIE	M.PAKHARIAN	M.MEHRSHAD	***				CHECKED	REV. APPR.												
REV.	DATE	P.O.I.S	PREP.	CHK.	APP.	AUT.														اصل و کلیه نسخ این نقشه و حق اقتباس متعلق به شرکت ملی مناطق نفت خیز جنوب می باشد.			
PROJECT NAME:							BINAK OILFIELD DEVELOPMENT/SURFACE FACILITIES GAS COMPRESSOR STATION													THE ORIGINAL AND ALL COPIES OF THIS DRAWING TOGETHER WITH THE COPYRIGHT THEREIN ARE THE SOLE PROPERTY OF N.I.S.O.C./ FIELDS			
PROJECT NO.:							971020																
EPC CONTRACTOR:			EPD/EPC CONTRACTOR (GC):				BINAK OILFIELD DEVELOPMENT SURFACE FACILITIES GAS COMPRESSOR STATION																
 HIRGAN ENERGY - DESIGN & INSPECTION COMPANIES			 PETROIRAN DEVELOPMENT COMPANY																				
DRAWING TITLE:			ARCHITECTURAL DETAIL DRAWING FOR EXTENSION OF EXISTING ELECT. BUILDING ELEVATIONS																				
							NO CONSTRUCTION PERMITTED UNLESS DRAWING APPROVED																
							APPROVED FOR CONSTRUCTION				BY:		DATE:										
SCALE	SIZE	DRAWING NO.			SHEET NO.	REV.	BUDGET REF.	LOCATION	SIZE	CLASS	SERIAL NO.	SHEET	REVISION										
AS SHOWN	A1	BK-GCS-PEDCO-120-AR-DW-0002			11 OF 15	D05	053-073-0184	F	4	B	709100	11 OF 15	D05										

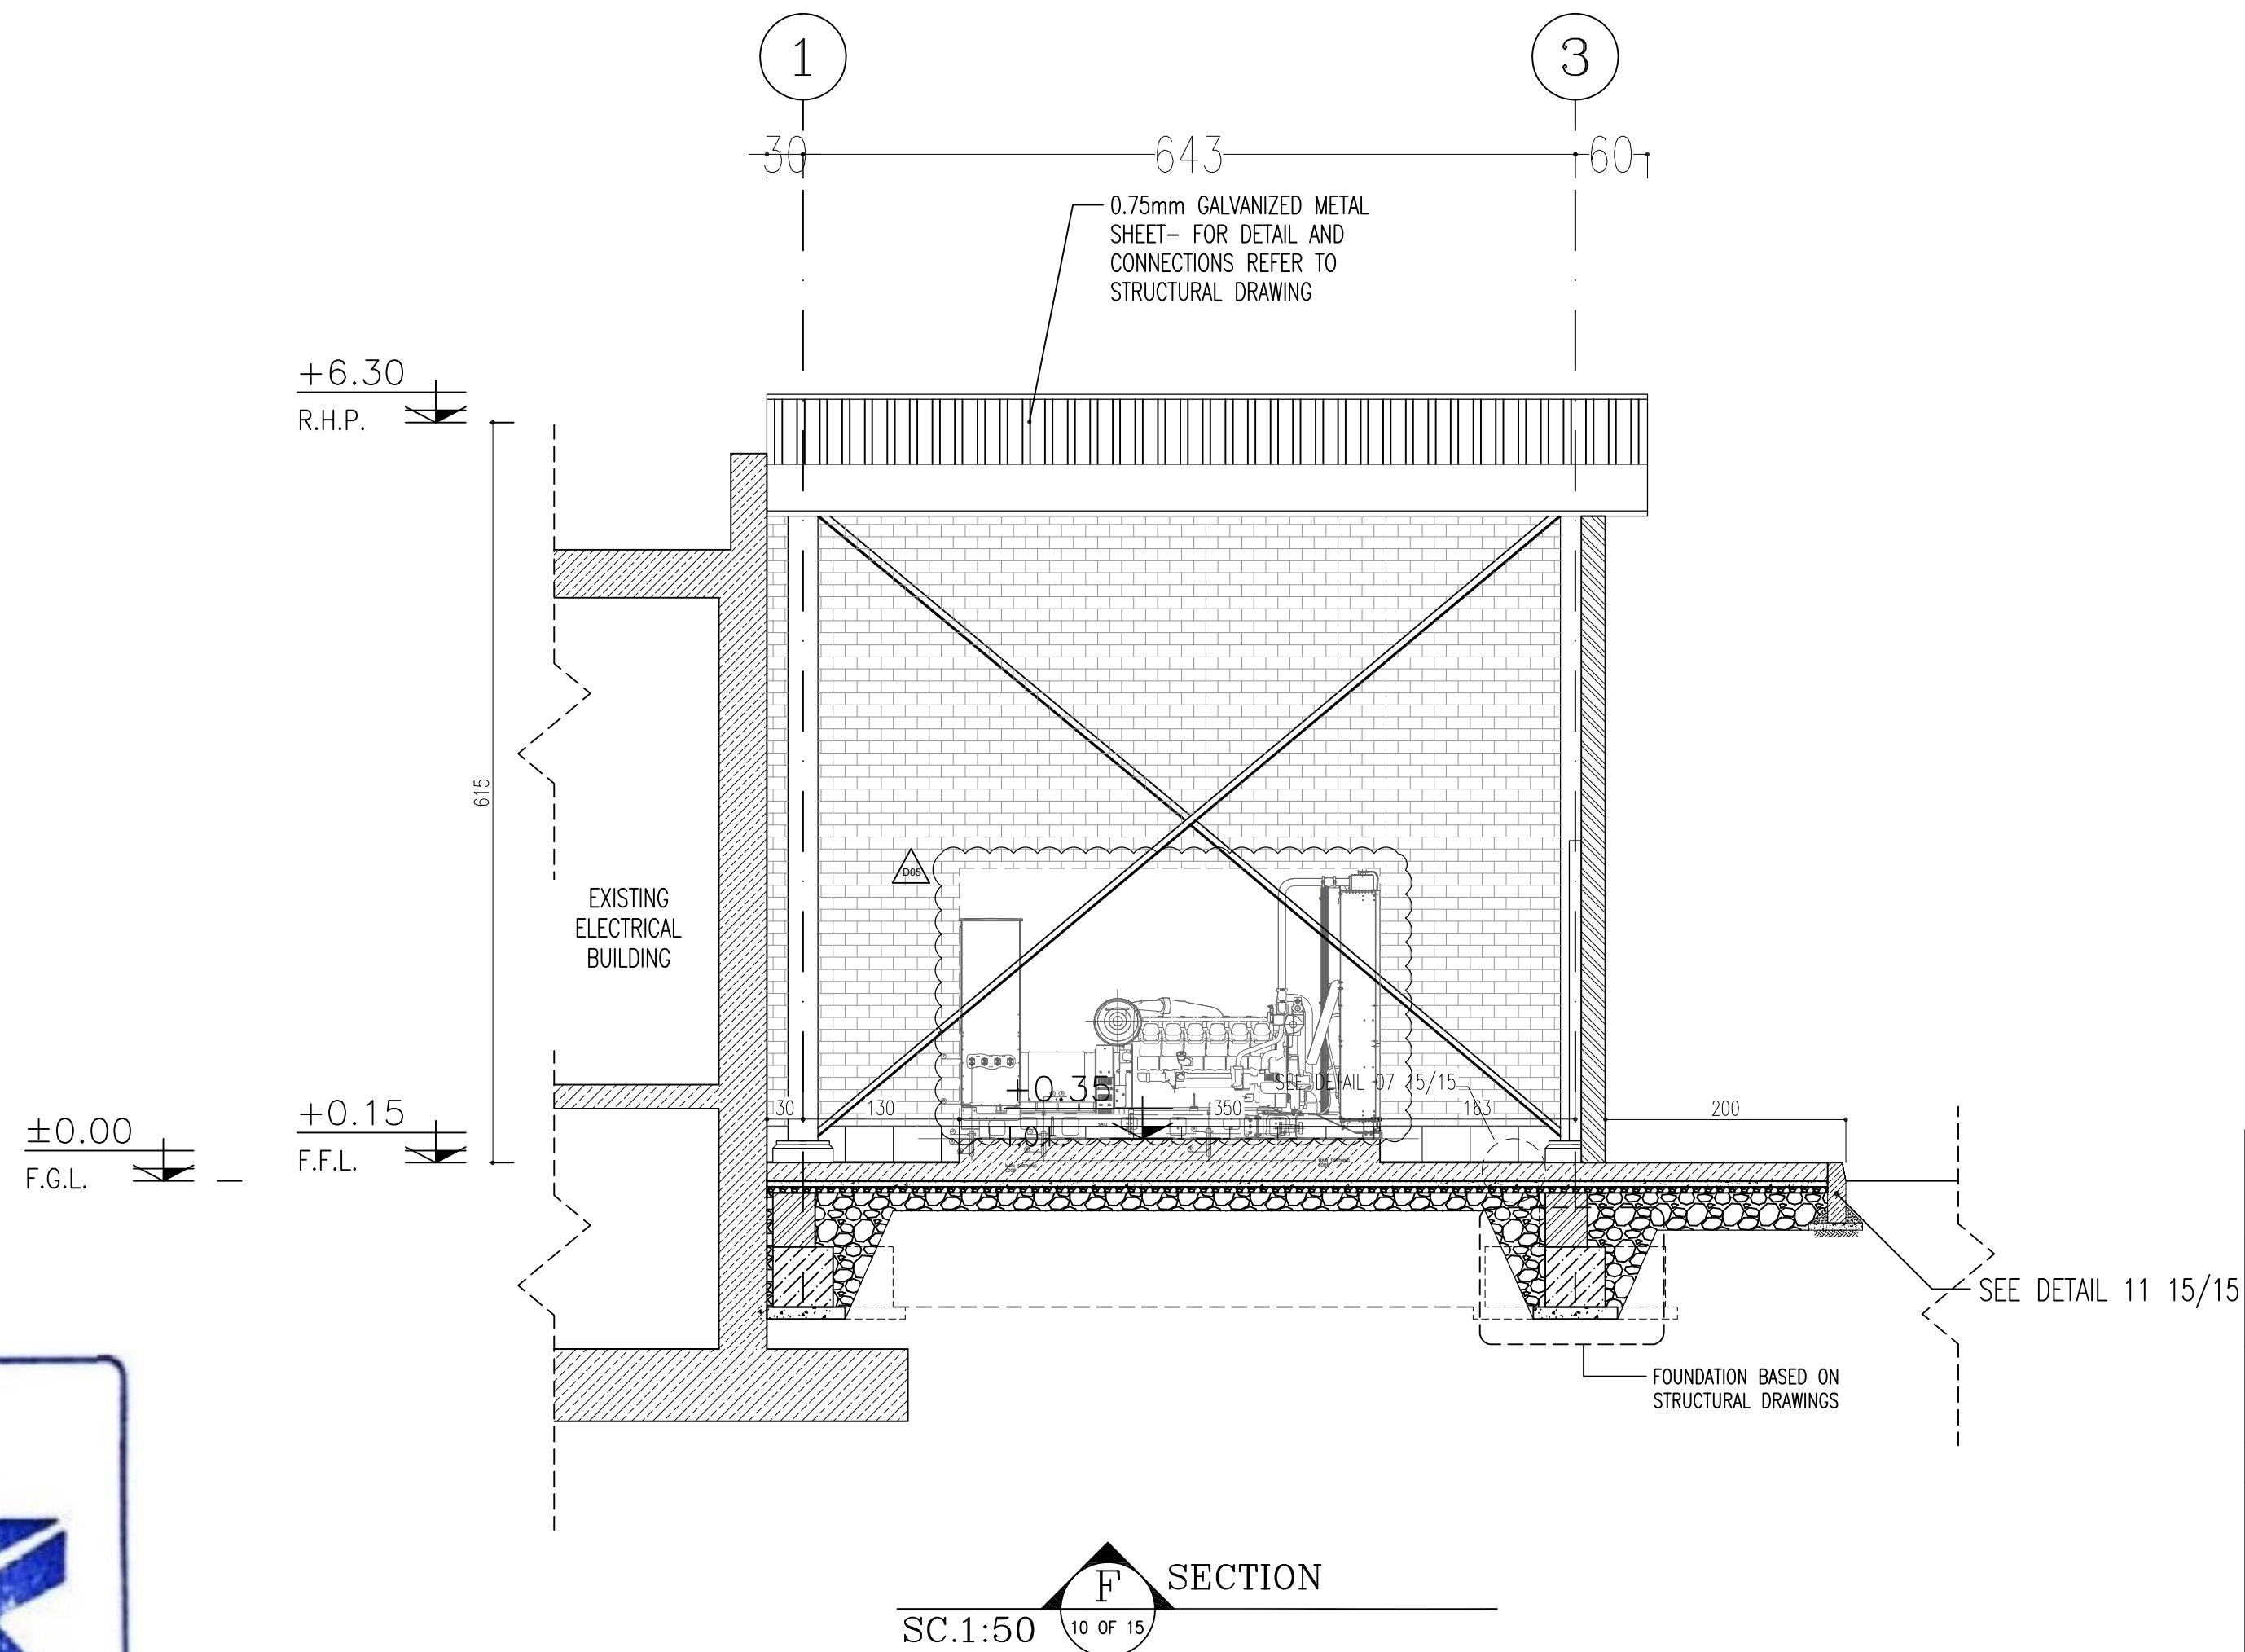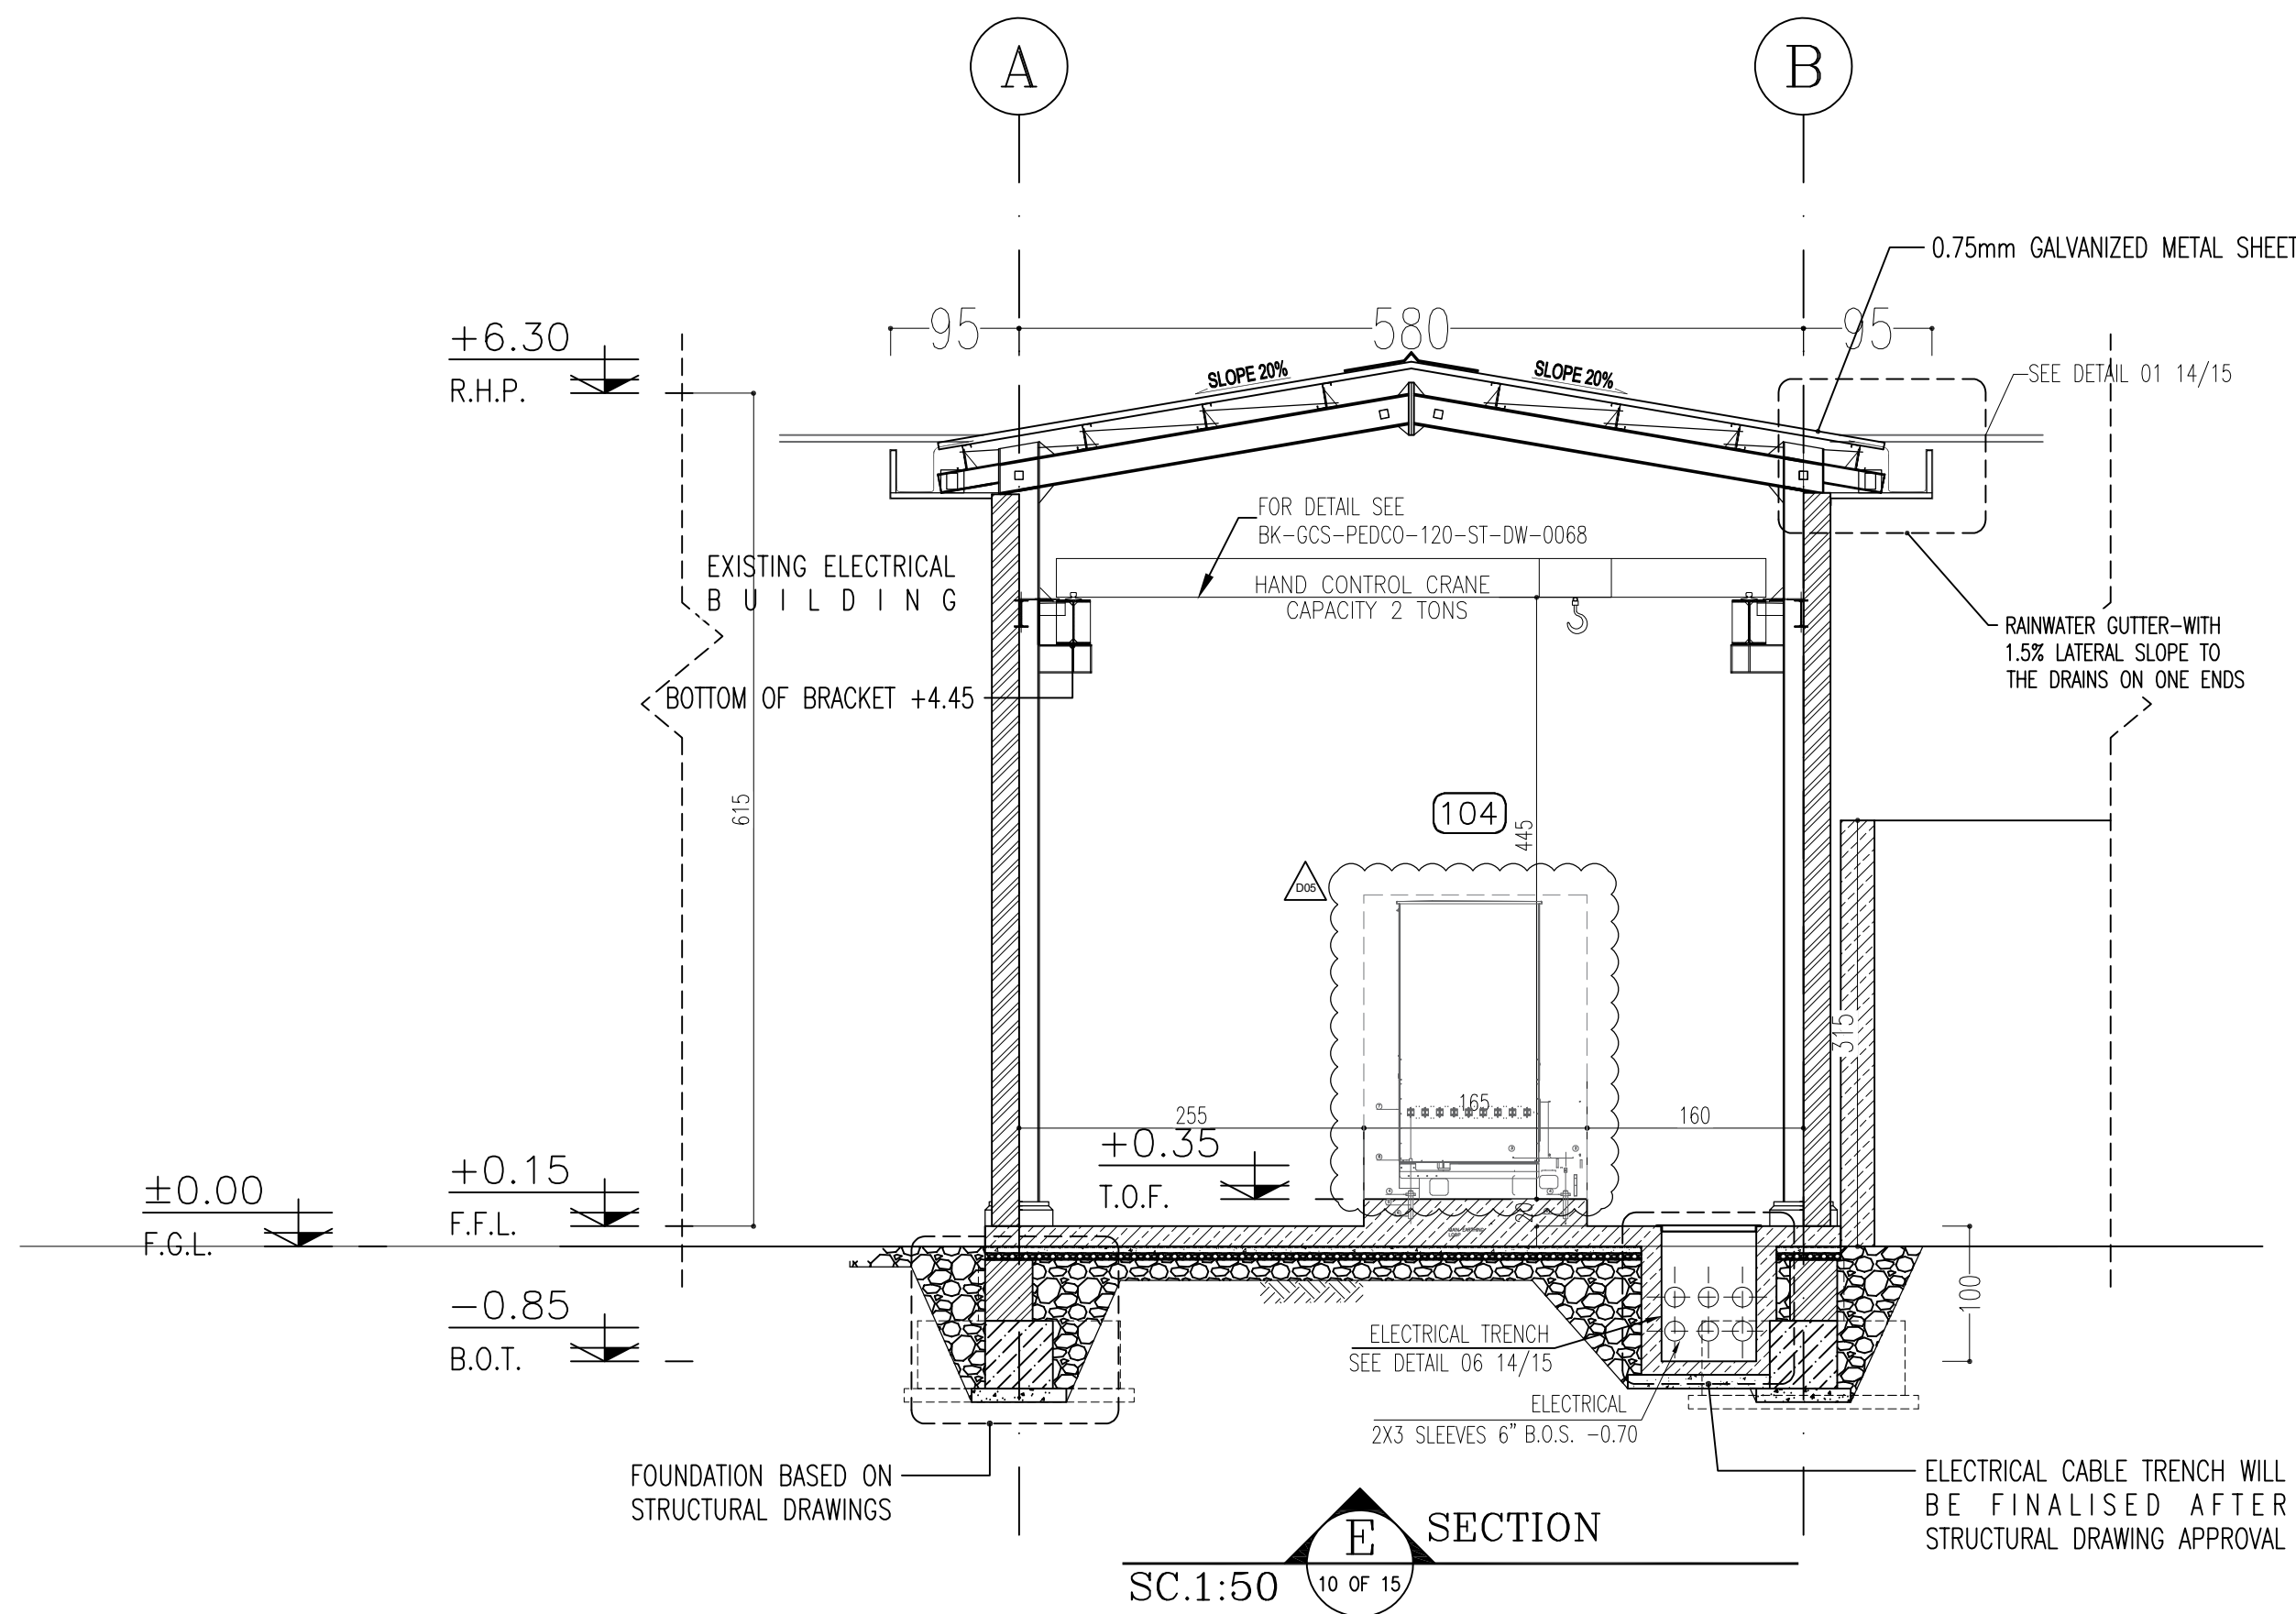


NOTES			
1. ALL DIMENSIONS ARE IN CENTIMETER & ALL ELEVATIONS ARE IN METER. 2. ALL DIMENSIONS AND ELEVATIONS SHALL BE CHECKED BY THE CONTRACTOR PRIOR TO CONSTRUCTION. 3. CONTRACTOR SHALL COMPLY ALL ARCHITECTURAL, MECHANICAL, ELECTRICAL, PIPING AND STRUCTURAL DRAWINGS AND IN CASE OF ANY CONFLICTS OR DISCREPANCY, INFORM THE ENGINEER. 4. ALL MATERIALS ARE SELECTED FROM THE HIGHEST QUALITY AND MUST BE APPROVED BY THE CLIENT. 5. ALL OPENINGS FOR PIPING, CABLEING AND HVAC OPENINGS SHALL BE CONSIDERED AS PER RELATED DRAWINGS BEFORE CONSTRUCTION. 6. ARCHITECTURAL DETAIL DESIGN WILL BE REVISED BASED ON APPROVED STRUCTURAL DRAWINGS. 7. ELEVATION CODE : LOCAL ±0.0m CORRESPONDS TO GLOBAL +11.10m			
LEGEND			
LEAN CONCRETE			
REINFORCED CONCRETE			
PRESSED BRICK			
STONE			
EXPANSION JOINT FILLER (PLASTOFOAM)			
TERRAZZO TILES FOR ROOF - 30x30cm			
BLOCKAGE			
F.F.L.	FINISHED FLOOR	B.O.P.	BOTTOM OF PIT
T.O.WA	TOP OF WALKWAY	F.G.L.	FINISH GRADING LEVEL
T.O.P.	TOP OF PARAPET	T.O.T.	TOP OF TRENCH
T.O.FOU.	TOP OF FOUNDATION	C.O.S.	CENTER OF SLEEVE
M.D	METAL DOOR	B.O.S.	BOTTOM OF SLEEVE
T.O.R.	TOP OF ROOF	B.O.O.	BOTTOM OF OPENING
T.O.D.	TOP OF DOOR	B.O.T.	BOTTOM OF TRENCH
B.O.Co.	BOTTOM OF CAGE	B.O.P.	BOTTOM OF PIT
T.O.Co.	TOP OF CAGE	R.H.P.	ROOF HIGHEST POINT
B.O.G.	BOTTOM OF GUTTER	R.L.P.	ROOF LOWEST POINT
T.O.Co.	TOP OF CAGE	N.G.R.	NEUTRAL GROUND RESISTOR
M.D.	METAL DOOR	B.P.D.	BLAST-PROOF DOOR
T.O.S.	TOP OF SLAB	F.D.	FENCE DOOR

REFERENCE DRAWING	DRG. No.
STANDARD DRAWING FOR ARCHITECTURAL DETAILS	BK-GNRL-PEDCO-000-AR-DW-0001
SITE SEWAGE SYSTEM LAYOUT & DETAILS	BK-GCS-PEDCO-120-CY-PY-0001
CABLE TRENCH AND DUCT BANK LAYOUT	BK-GCS-PEDCO-120-CY-PY-0002
ROAD, PAVING AND PLANT FINISH GRADING LAYOUT & SECTIONS	BK-GCS-PEDCO-120-CY-PY-0005
ELECTRICAL CABLE ROUTE & SECTION LAYOUT FOR BUILDING & SHELTER	BK-GCS-PEDCO-120-EL-PY-0006
FOUNDATION DRAWING FOR EXTENSION OF EXISTING ELECT. BUILDING	BK-GCS-PEDCO-120-ST-DW-0063
STRUCTURAL DRAWING FOR EXTENSION OF EXISTING ELECT. BUILDING	BK-GCS-PEDCO-120-ST-DW-0064
STANDARD DETAILS FOR LADDER & SAFETY CAGE	BK-GNRL-PEDCO-000-ST-DW-0009
ELECTRICAL EQUIPMENT ARRANGEMENT LAYOUT FOR BUILDING	BK-GCS-PEDCO-120-ST-EL-PY-0008
Unit Plot Plan Drawing	BK-GCS-PEDCO-120-PI-PY-0001

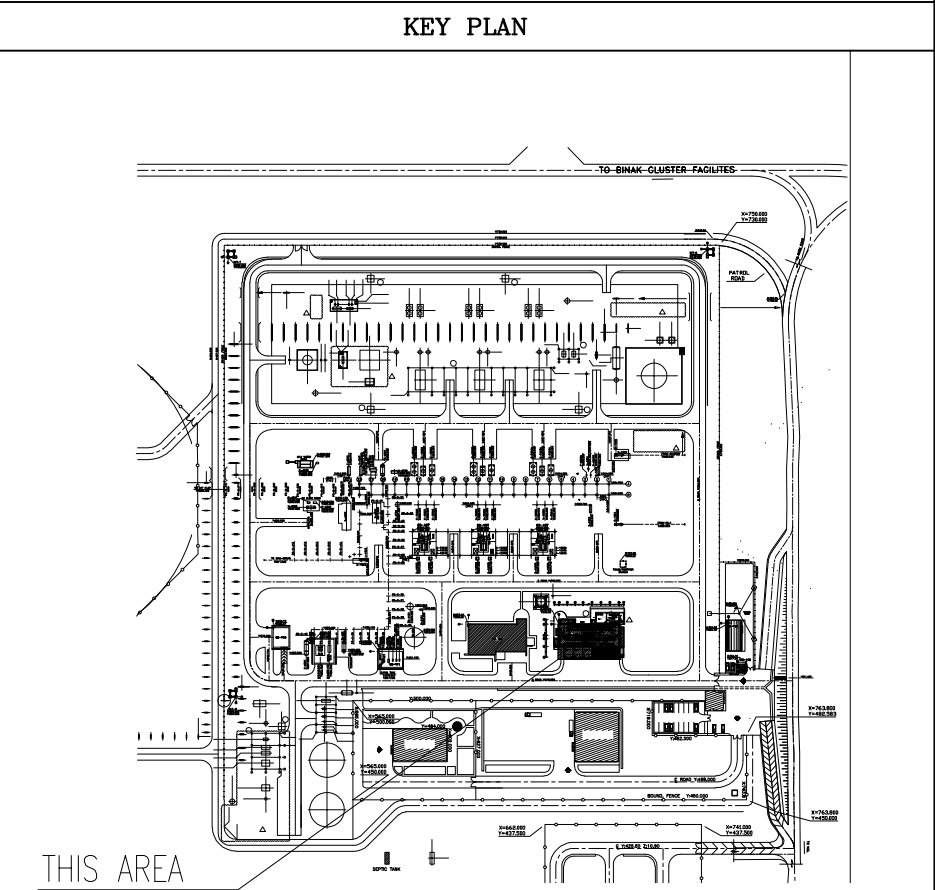

D05	SEP.2023	AFC	R.BERLOUIE	M.PAKHARIAN	A.M.MOHSSENI	***													
D04	AUG.2023	IFA	R.BERLOUIE	M.PAKHARIAN	A.M.MOHSSENI	***													
D03	MAY.2023	IFA	R.BERLOUIE	M.PAKHARIAN	A.M.MOHSSENI	***													
D02	AUG.2022	IFA	R.BERLOUIE	M.PAKHARIAN	M.MEHRSHAD	***	***	*****	***	*****	***	*****	***	*****	***				
D01	APR.2022	IFA	R.BERLOUIE	M.PAKHARIAN	M.MEHRSHAD	***	REV.	DESCRIPTION	BY	DATE	BY	DATE							
D00	JAN.2022	IPC	R.BERLOUIE	M.PAKHARIAN	M.MEHRSHAD	***			CHECKED	REV.	APPR.								
REV.	DATE	P.O.I.S	PREP.	CHK.	APP.	AUT.	اصل و کليه نسخ اين نقشه و حق اقتباس متعلق به شرکت ملی مناطق نفت خيز جنوب ميباشد.												
PROJECT NAME:							BINAK OILFIELD DEVELOPMENT/SURFACE FACILITIES GAS COMPRESSOR STATION									 THE ORIGINAL AND ALL COPIES OF THIS DRAWING TOGETHER WITH THE COPYRIGHT THEREIN ARE THE SOLE PROPERTY OF N.I.S.O.C. / FIELDS			
PROJECT NO.:			971020																
EPC CONTRACTOR:			EPD/EPC CONTRACTOR (GC):																
 HIRGAN ENERGY - DESIGN & INSPECTION COMPANIES			 PEDCO			PETROIRAN DEVELOPMENT COMPANY			BINAK OILFIELD DEVELOPMENT SURFACE FACILITIES GAS COMPRESSOR STATION										
									DATE	SCALE	DRAWING BY	CHECKED BY	PROJECT ENG.						
DRAWING TITLE:							ARCHITECTURAL DETAIL DRAWING FOR EXTENSION OF EXISTING ELECT. BUILDING SECTIONS									NO CONSTRUCTION PERMITTED UNLESS DRAWING APPROVED			
SCALE			SIZE		DRAWING NO.		SHEET NO.		REV.		APPROVED FOR CONSTRUCTION			BY:		DATE:			
AS SHOWN			A1		BK-GCS-PEDCO-120-AR-DW-0002		12 OF 15		D05		053-073-0184			F 4 B		709100 12 OF 15 D05			



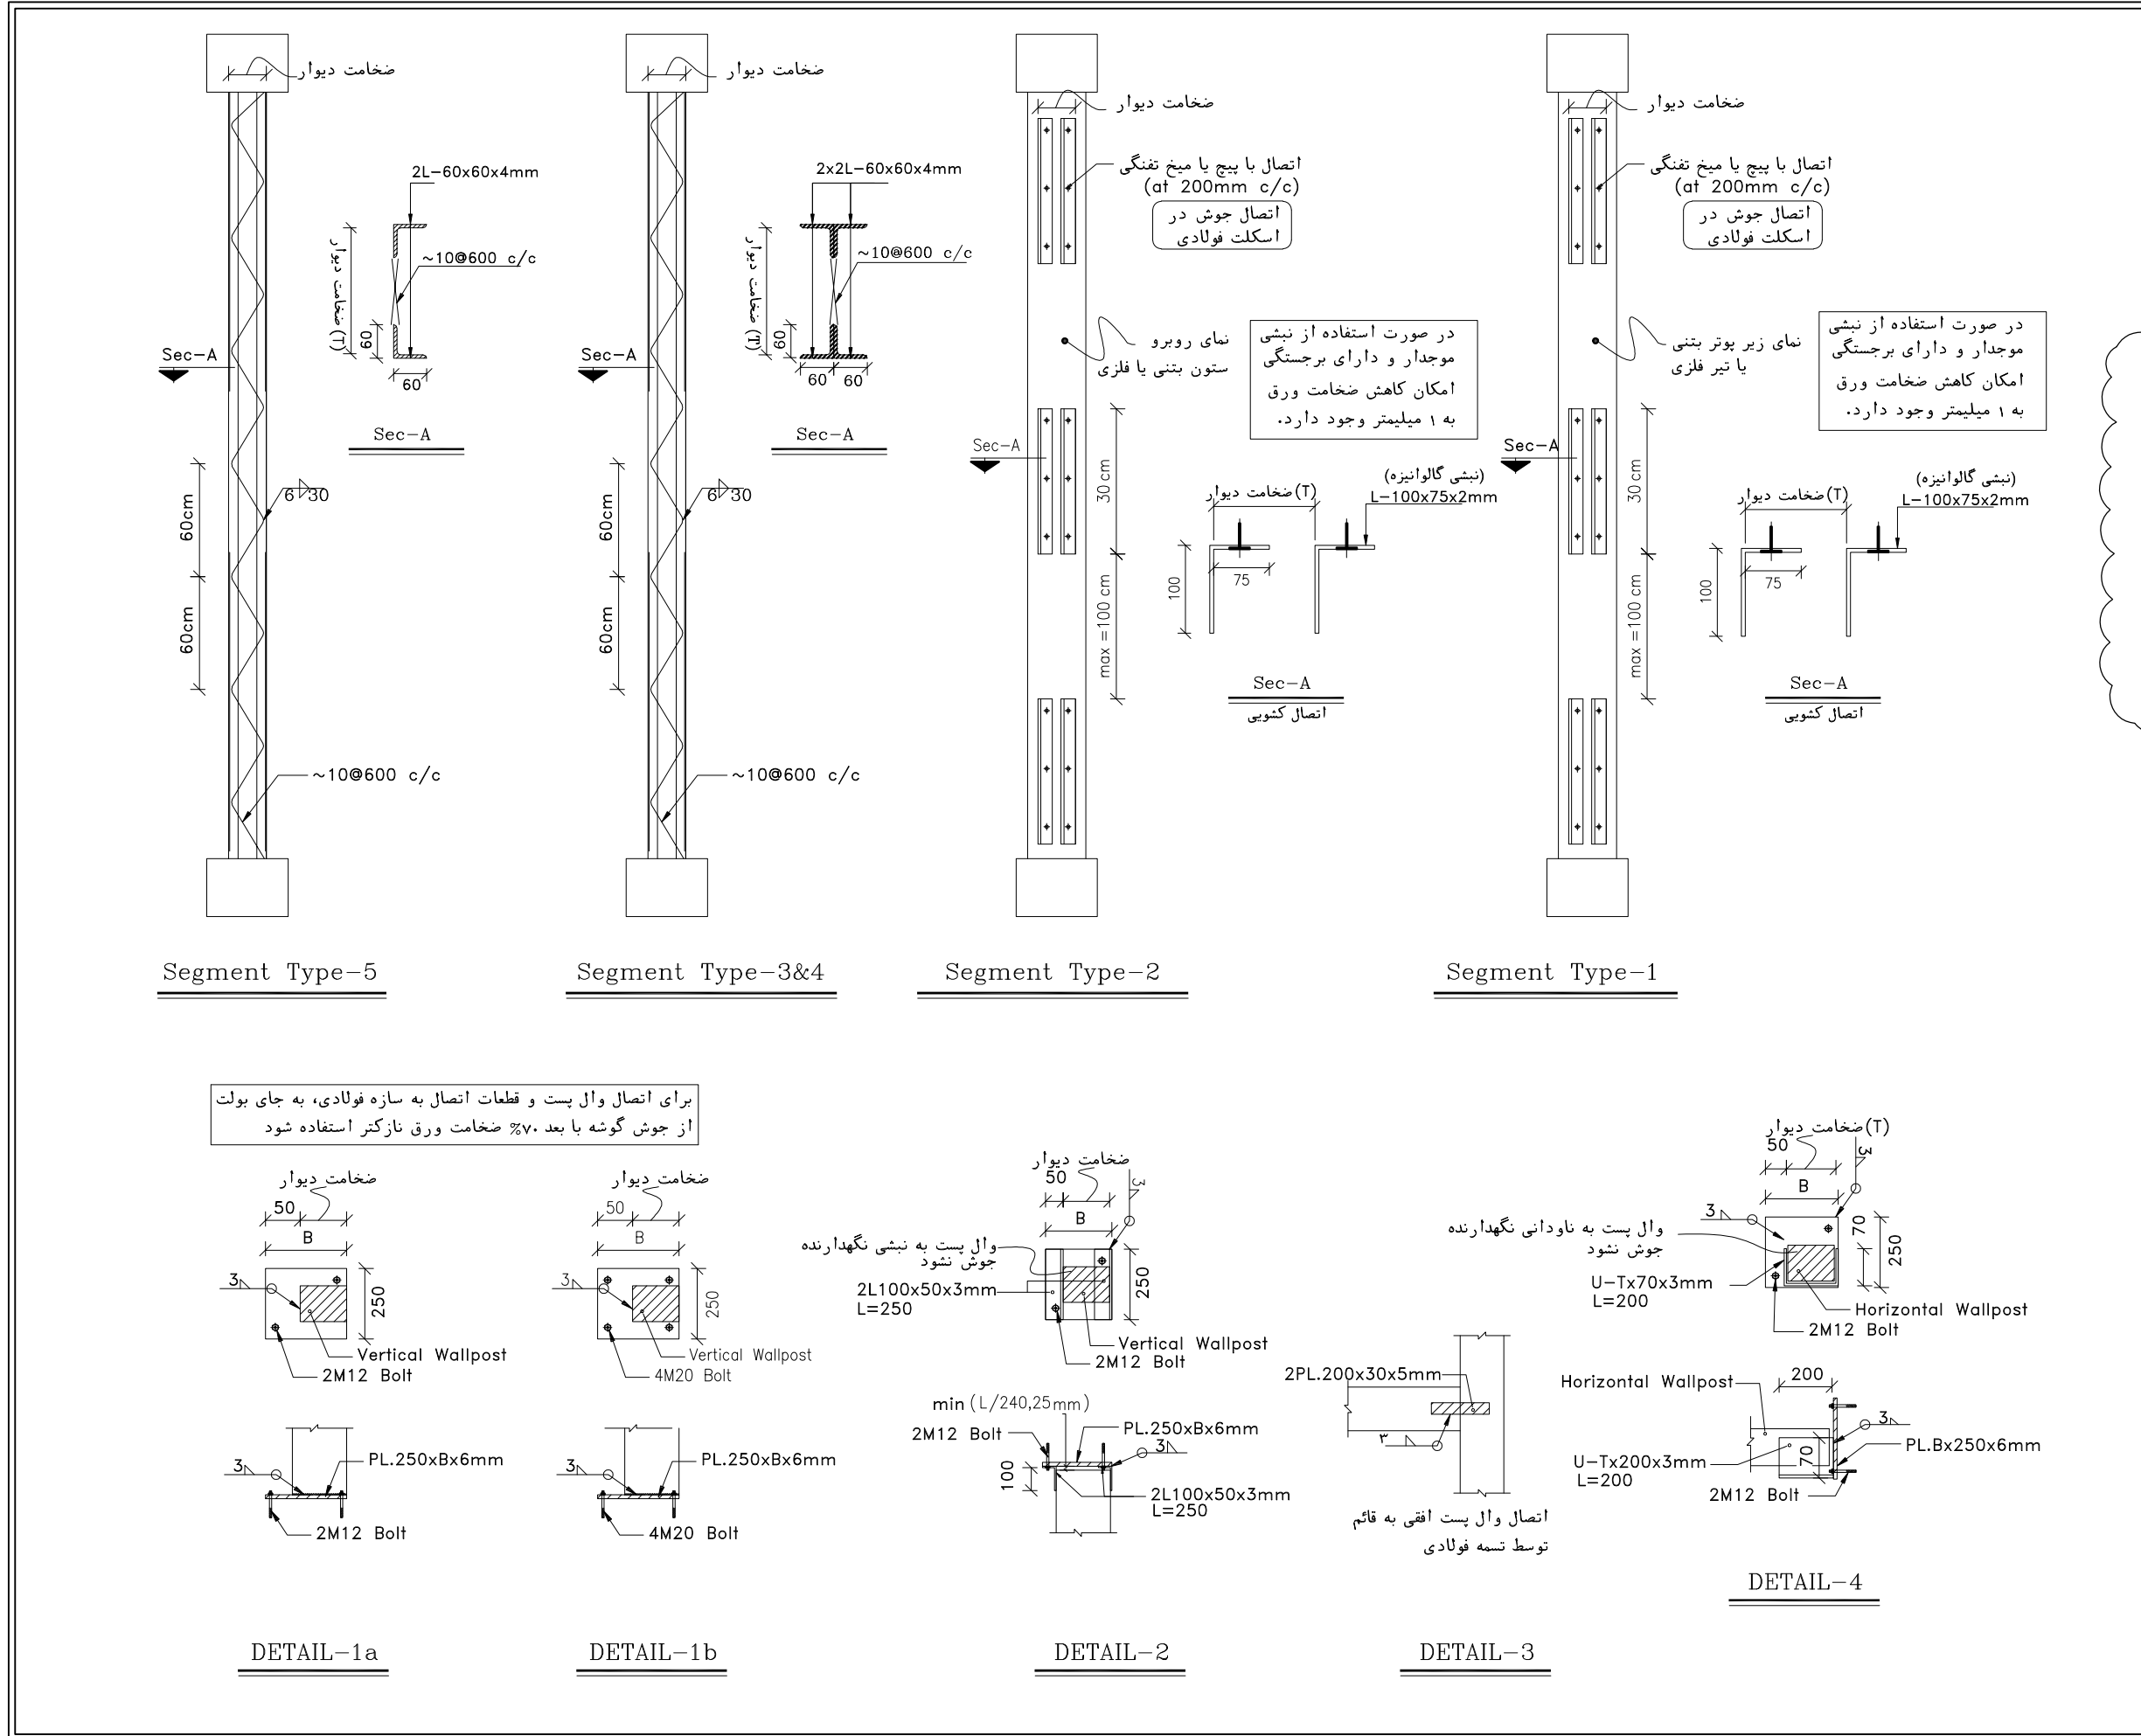

FINISHING SCHEDULE

	AREA	FLOOR	INTERNAL SKIRTING	EXTERNAL SKIRTING	INTERNAL WALL	EXTERNAL WALL	CEILING
100	CAPACITOR BANK	TERRAZZO TILE	DARK GRANITE STONE 100cm	DARK GRANITE STONE 40cm	2 CM CEMENT PLASTER+GYPSUM PLASTER+OIL PAINT FINISH	BRICK FACING	2 CM CEMENT PLASTER+GYPSUM PLASTER+OIL PAINT FINISH
101	CO2 ROOM	TERRAZZO TILE	DARK GRANITE STONE 100cm	DARK GRANITE STONE 40cm	2 CM CEMENT PLASTER+GYPSUM PLASTER+OIL PAINT FINISH	BRICK FACING	2 CM CEMENT PLASTER+GYPSUM PLASTER+OIL PAINT FINISH
102	TRANSFORMER ROOM	CONCRETE	DARK GRANITE STONE 30cm	—	WHITE CEMENT PLASTER	DARK GRANITE STONE	0.75mm CORRUGATED GALVANIZED SHEET
103	FIRE-FIGHTING PUMP TRANSFORMER ROOM	CONCRETE	DARK GRANITE STONE 30cm	—	WHITE CEMENT PLASTER	DARK GRANITE STONE	0.75mm CORRUGATED GALVANIZED SHEET
104	DIESEL ROOM	CONCRETE	DARK GRANITE STONE 30cm	DARK GRANITE STONE 40cm	BRICK FACING	BRICK FACING	0.75mm CORRUGATED GALVANIZED SHEET

8

FINISHING SCHEDULE

NOTES

1. ALL DIMENSIONS ARE IN CENTIMETER & ALL ELEVATIONS ARE IN METER.
2. ALL DIMENSIONS AND ELEVATIONS SHALL BE CHECKED BY THE CONTRACTOR PRIOR TO CONSTRUCTION.
3. CONTRACTOR SHALL COMPLY ALL ARCHITECTURAL, MECHANICAL, ELECTRICAL, PIPING AND STRUCTURAL DRAWINGS AND IN CASE OF ANY CONFLICTS OR DISCREPANCY, INFORM THE ENGINEER.
4. ALL MATERIALS ARE SELECTED FROM THE HIGHEST QUALITY AND MUST BE APPROVED BY THE CLIENT.
5. ALL OPENINGS FOR PIPING, CABLEING AND HVAC OPENINGS SHALL BE CONSIDERED AS PER RELATED DRAWINGS BEFORE CONSTRUCTION.
6. ARCHITECTURAL DETAIL DESIGN WILL BE REVISED BASED ON APPROVED STRUCTURAL DRAWINGS.
7. ELEVATION CODE : LOCAL 20.0m CORRESPONDS TO GLOBAL +11.10m

LEGEND

LEAN CONCRETE

REINFORCED CONCRETE

PRESSED BRICK

STONE

EXPANSION JOINT FILLER (PLASTOFOAM)

TERRAZZO TILES FOR ROOF - 30x30cm

BLOCKAGE

F.F.L. FINISHED FLOOR

T.O.WA TOP OF WALKWAY

T.O.P. TOP OF PARAPET

T.O.FOU. TOP OF FOUNDATION

M.D METAL DOOR

T.O.R. TOP OF ROOF

T.O.D. TOP OF DOOR

B.O.Co. BOTTOM OF CAGE

T.O.Co. TOP OF CAGE

B.O.G. BOTTOM OF GUTTER

T.O.Co. TOP OF CAGE

M.D. METAL DOOR

T.O.S. TOP OF SLAB

B.O.P. BOTTOM OF PIT

F.G.L. FINISH GRADING LEVEL

T.O.T. TOP OF TRENCH

C.O.S. CENTER OF SLEEVE

B.O.S. BOTTOM OF SLEEVE

B.O.O. BOTTOM OF OPENING

B.O.T. BOTTOM OF TRENCH

B.O.P. BOTTOM OF PIT

R.H.P. ROOF HIGHEST POINT

R.L.P. ROOF LOWEST POINT



N.G.R. NEUTRAL GROUND RESISTOR

B.P.D. BLAST-PROOF DOOR

F.D. FENCE DOOR

REFERENCE DRAWING	DRG. No.
STANDARD DRAWING FOR ARCHITECTURAL DETAILS	BK-GNRL-PEDCO-000-AR-DW-0001
SITE SEWAGE SYSTEM LAYOUT & DETAILS	BK-GCS-PEDCO-120-CY-PY-0001
CABLE TRENCH AND DUCT BANK LAYOUT	BK-GCS-PEDCO-120-CY-PY-0002
ROAD, PAVING AND PLANT FINISH GRADING LAYOUT & SECTIONS	BK-GCS-PEDCO-120-CY-PY-0005
ELECTRICAL CABLE ROUTE & SECTION LAYOUT FOR BUILDING & SHED	BK-GCS-PEDCO-120-EL-PY-0006
FOUNDATION DRAWING FOR EXTENSION OF EXISTING ELECT. BUILDING	BK-GCS-PEDCO-120-ST-DW-0063
STRUCTURAL DRAWING FOR EXTENSION OF EXISTING ELECT. BUILDING	BK-GCS-PEDCO-120-ST-DW-0064
STANDARD DETAILS FOR LADDER & SAFETY CAGE	BK-GNRL-PEDCO-000-ST-DW-0009
ELECTRICAL EQUIPMENT ARRANGEMENT LAYOUT FOR BUILDING	BK-GCS-PEDCO-120-ST-EL-PY-0008
Unit Plot Plan Drawing	BK-GCS-PEDCO-120-PI-PY-0001


KEY PLAN

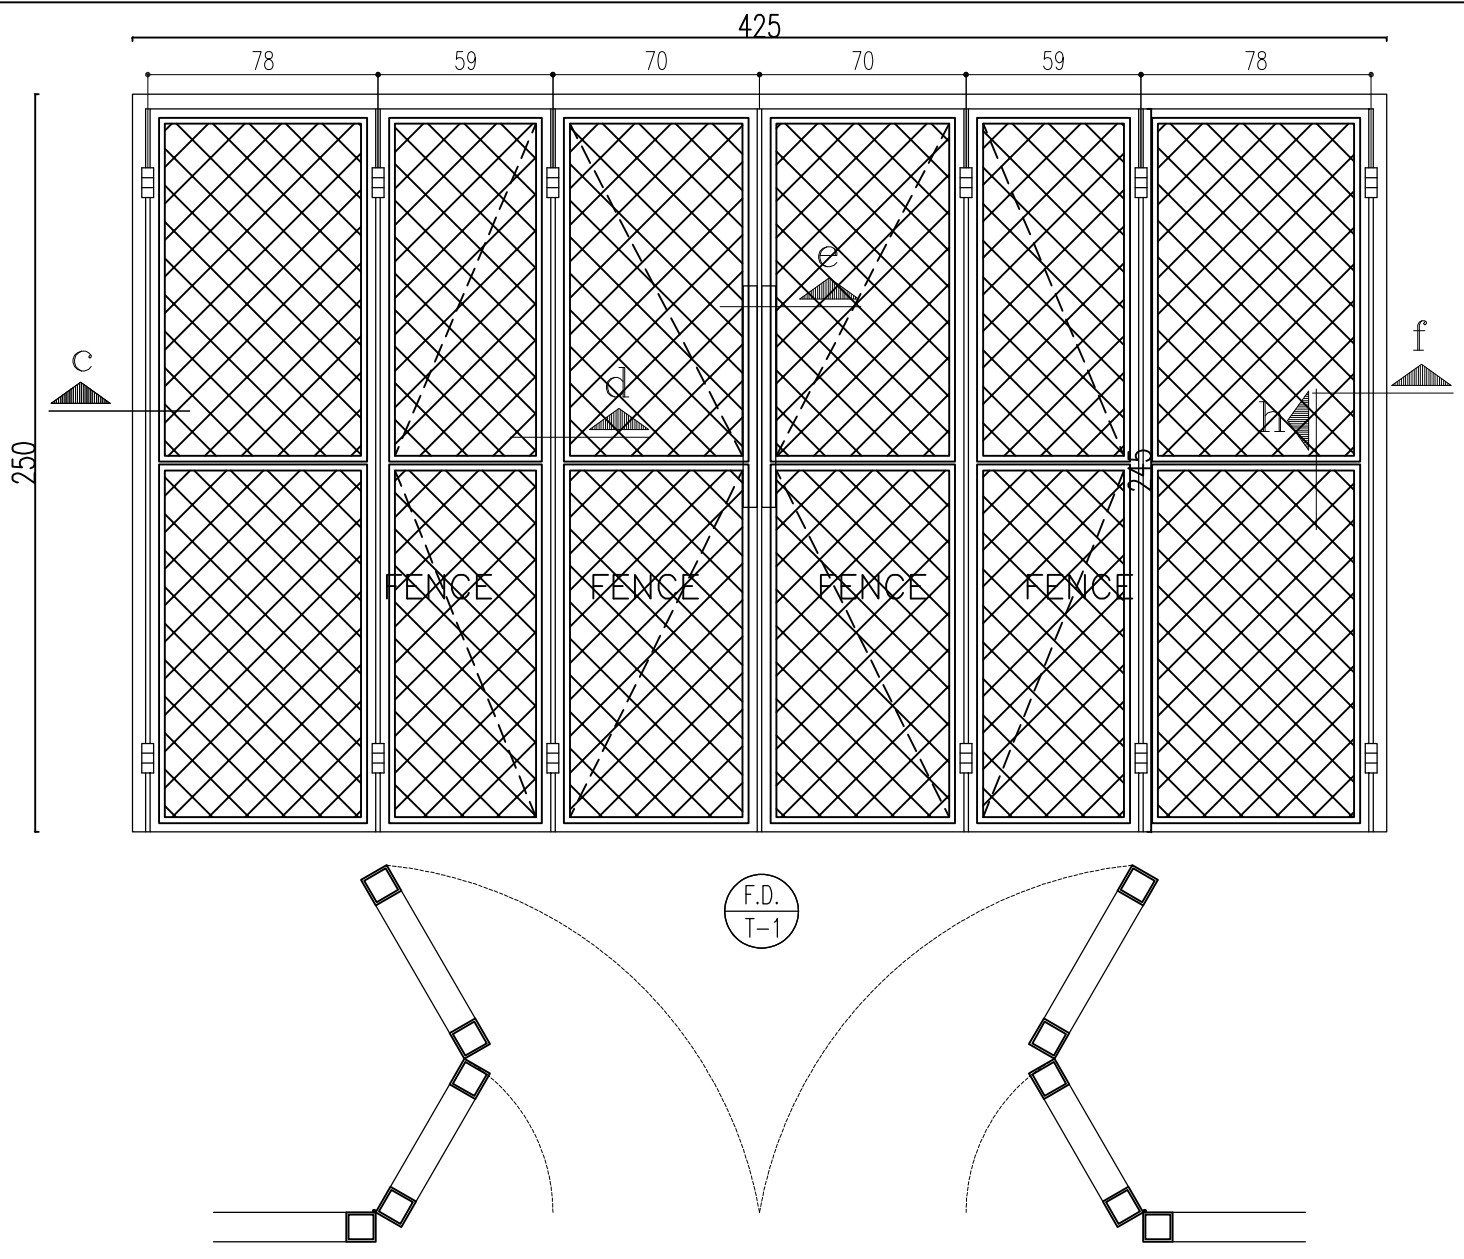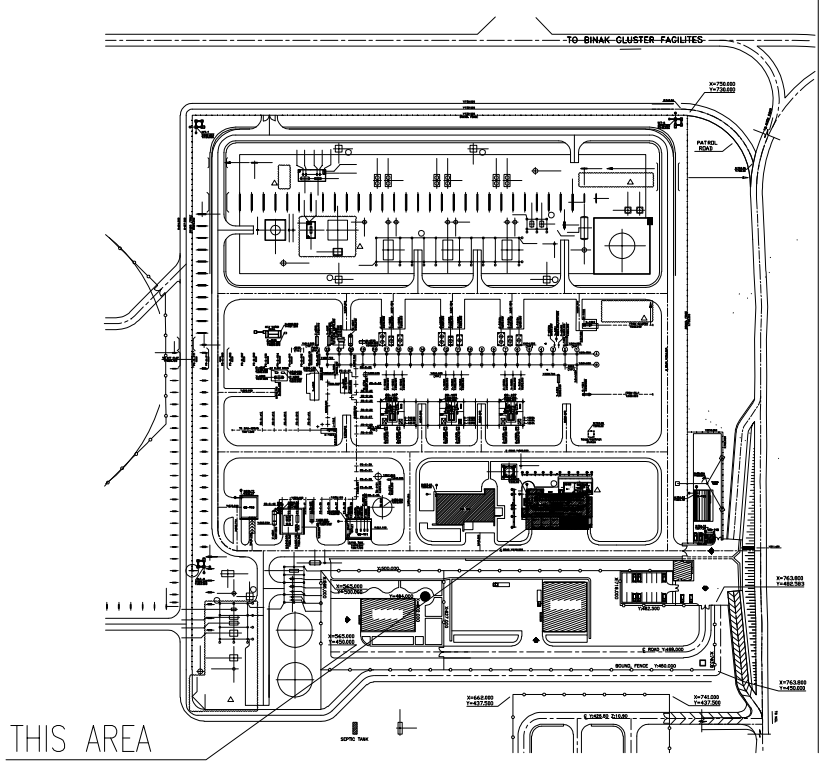

FENCE DOOR(F.D.) - TYPE1

TOTAL: 3


Sc:1/25

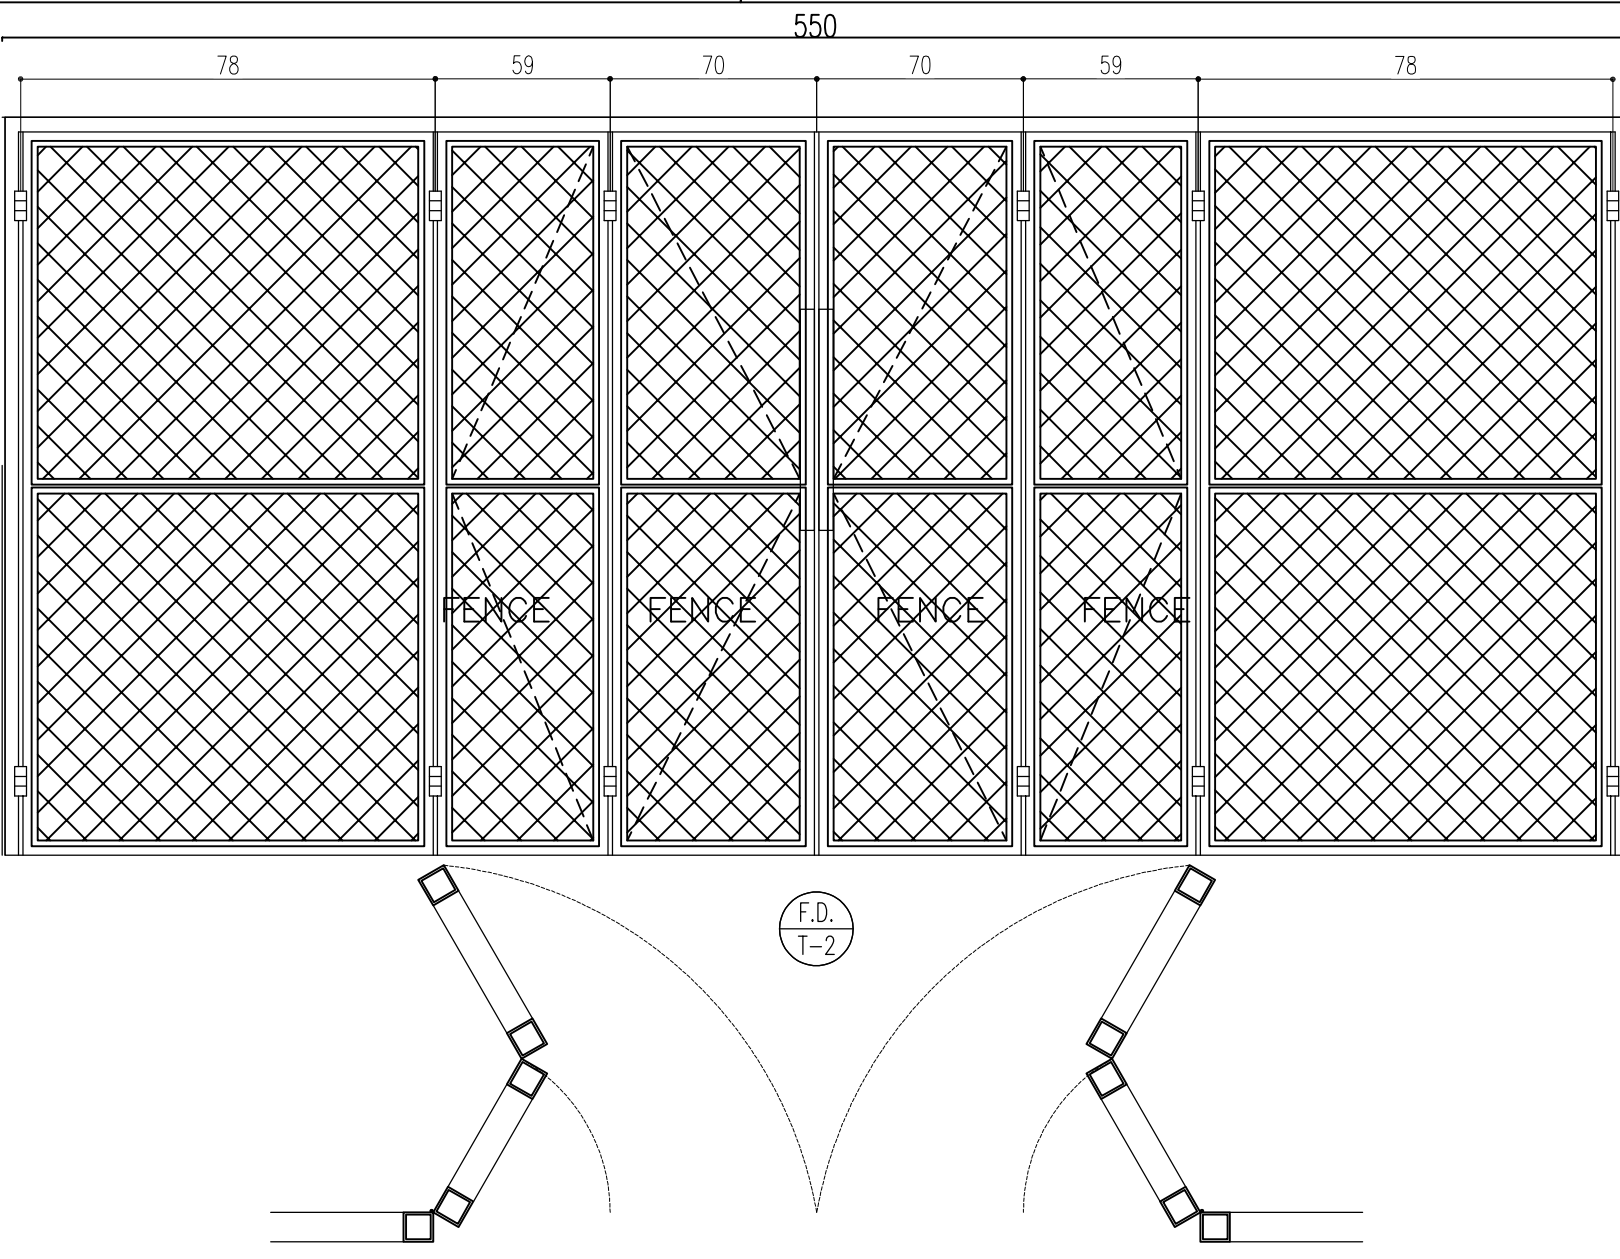

FENCE DOOR(F.D.) - TYPE2

TOTAL: 1

Sc:1/25

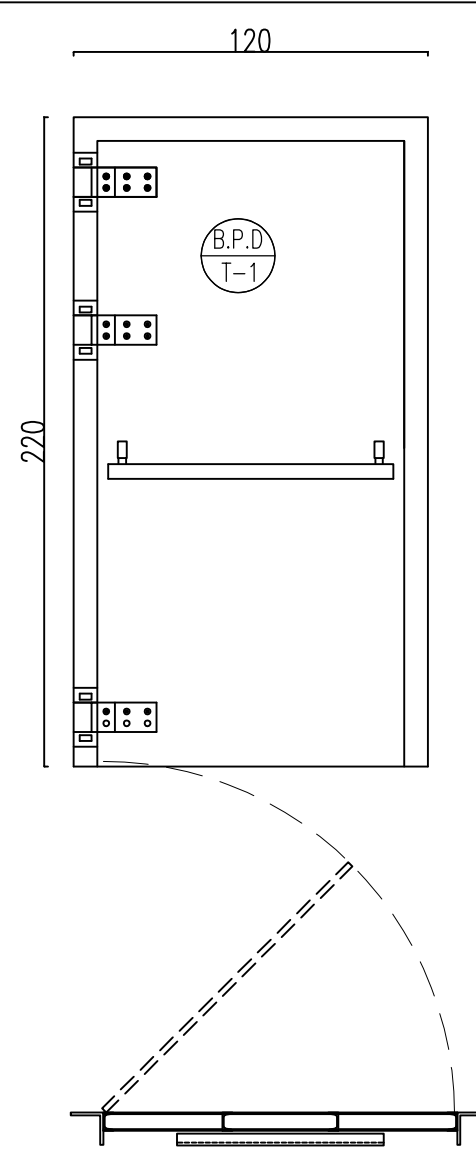

BLAST PROOF DOOR(B.P.D.) - TYPE1

LEFT HAND: 2
TOTAL: 2

Sc:1/25

REV.	DATE	P.O.I.S	PREP.	CHK.	APP.	AUT.
D05	SEP.2023	APC	R.BERLOUIE	M.PAKHARIAN	A.M.MOHSSENI	***
D04	AUG.2023	IFA	R.BERLOUIE	M.PAKHARIAN	A.M.MOHSSENI	***
D03	MAY.2023	IFA	R.BERLOUIE	M.PAKHARIAN	A.M.MOHSSENI	***
D02	AUG.2022	IFA	R.BERLOUIE	M.PAKHARIAN	M.MEHRSHAD	***
D01	APR.2022	IFA	R.BERLOUIE	M.PAKHARIAN	M.MEHRSHAD	***
D00	JAN.2022	IPC	R.BERLOUIE	M.PAKHARIAN	M.MEHRSHAD	***

PROJECT NAME: BINAK OILFIELD DEVELOPMENT/SURFACE FACILITIES GAS COMPRESSOR STATION

PROJECT NO.: 971020

EPC CONTRACTOR:



DRAWING TITLE: ARCHITECTURAL DETAIL DRAWING FOR EXTENSION OF EXISTING ELECT. BUILDING DETAILS AND SCHEDULES

SCALE	SIZE	DRAWING NO.	SHEET NO.	REV.
AS SHOWN	A1	BK-GCS-PEDCO-120-AR-DW-0002	13 OF 15	D05

EPD/EPC CONTRACTOR (GC):



NO CONSTRUCTION PERMITTED UNLESS DRAWING APPROVED

APPROVED FOR CONSTRUCTION	BY:	DATE:





THE ORIGINAL AND ALL COPIES OF THIS DRAWING TOGETHER WITH THE COPYRIGHT THEREIN ARE THE SOLE PROPERTY OF N.I.S.O.C./ FIELDS

BINAK OILFIELD DEVELOPMENT SURFACE FACILITIES GAS COMPRESSOR STATION


DATE	SCALE	DRAWING BY	CHECKED BY	PROJECT ENG.

NO CONSTRUCTION PERMITTED UNLESS DRAWING APPROVED

APPROVED FOR CONSTRUCTION	BY:	DATE:

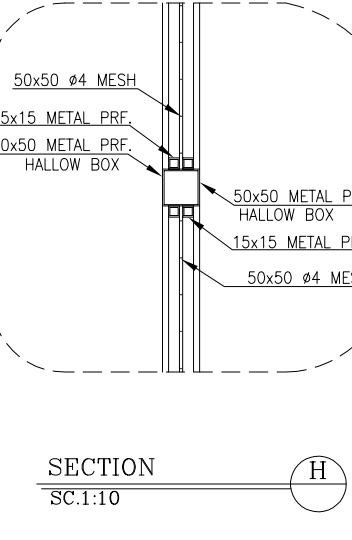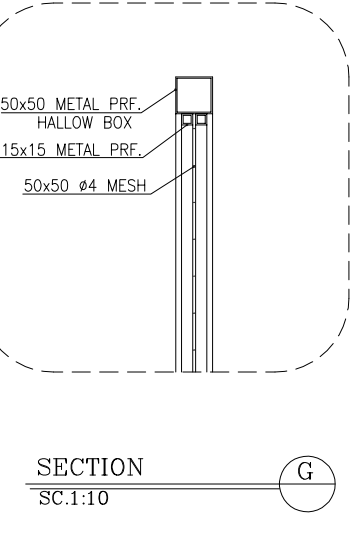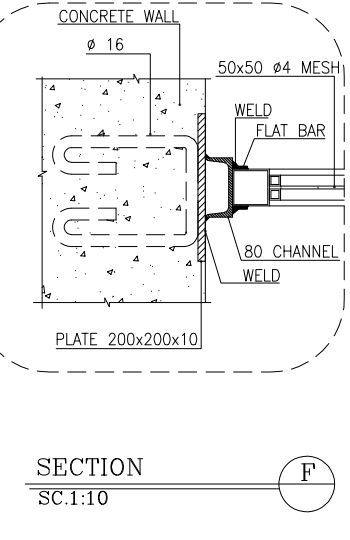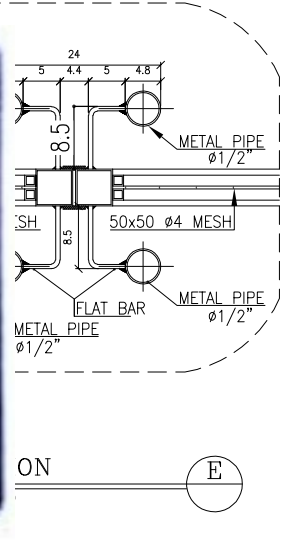

DOOR TYPES

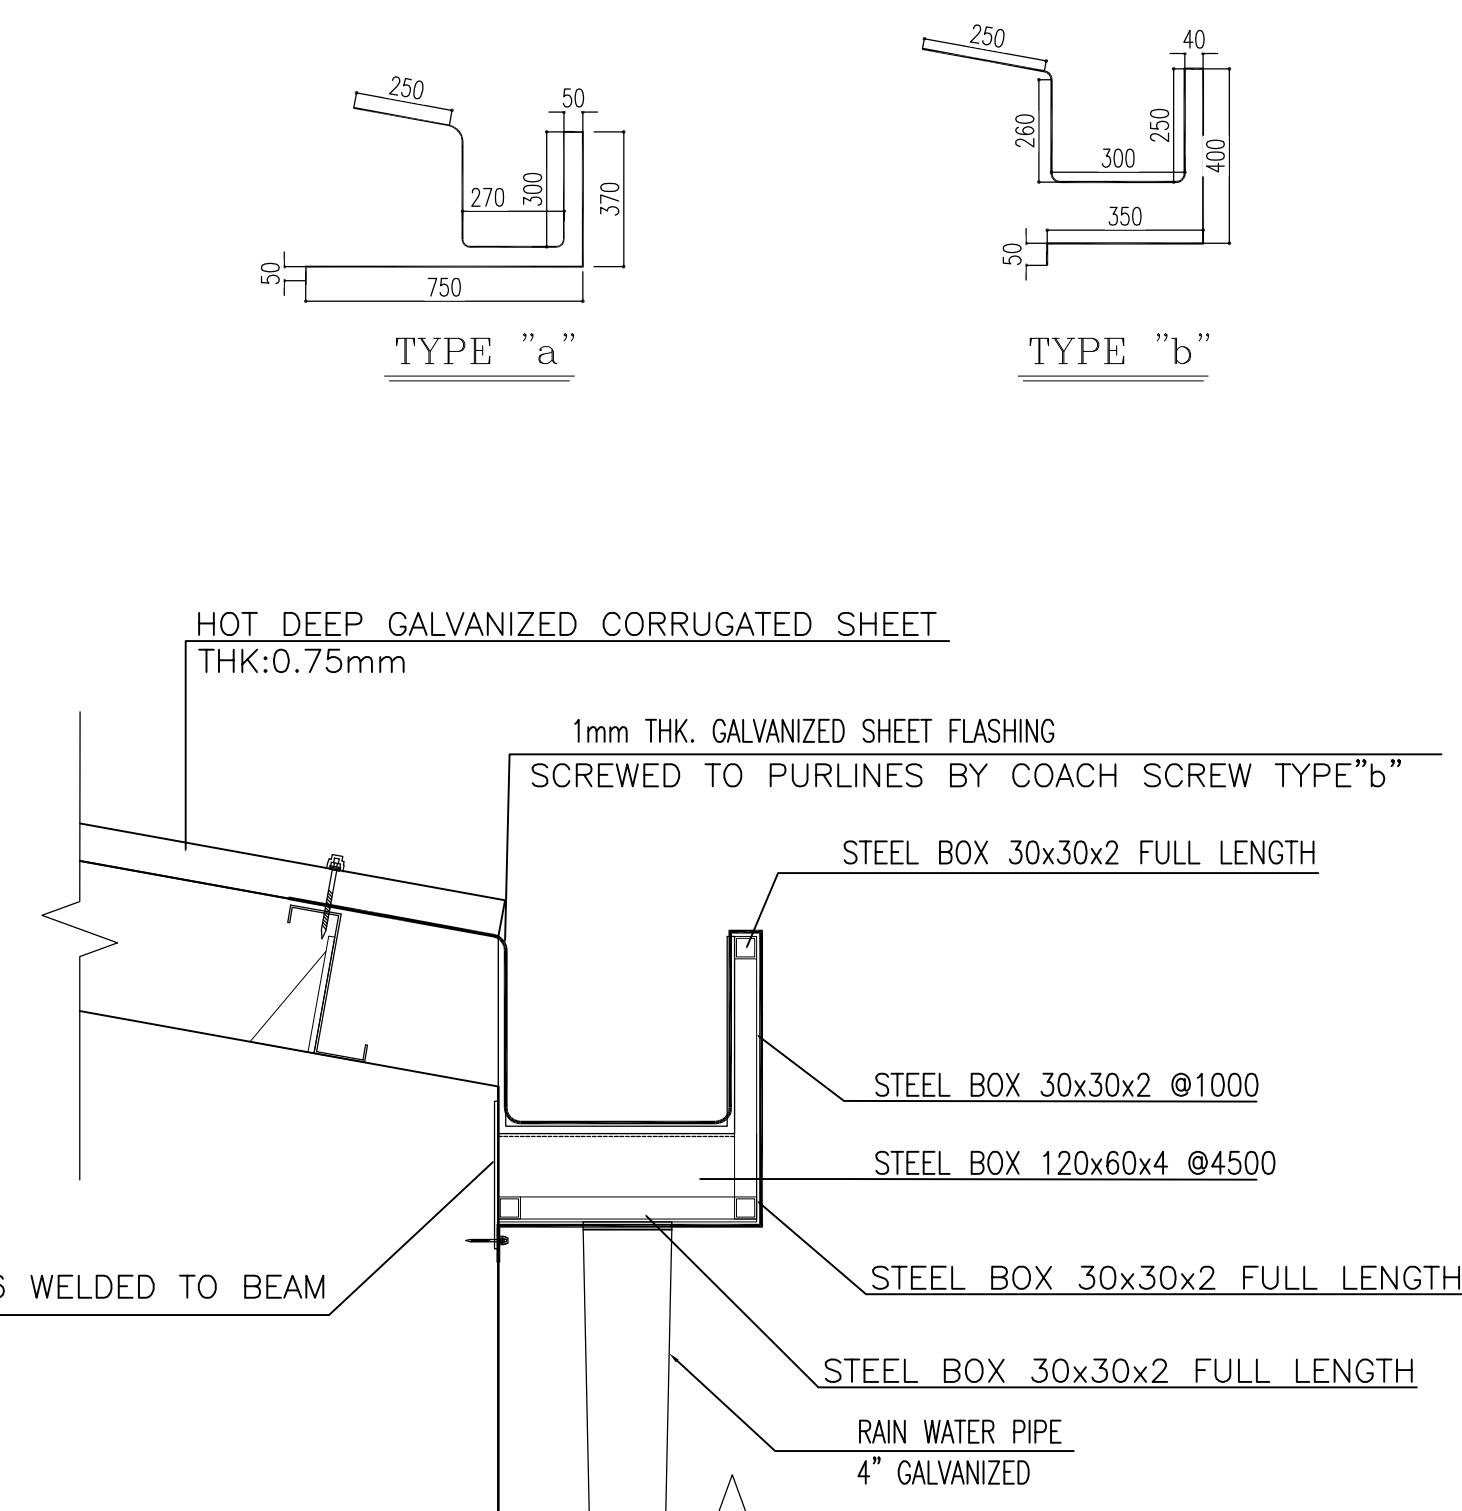

DETAIL 02
Sc:1/10

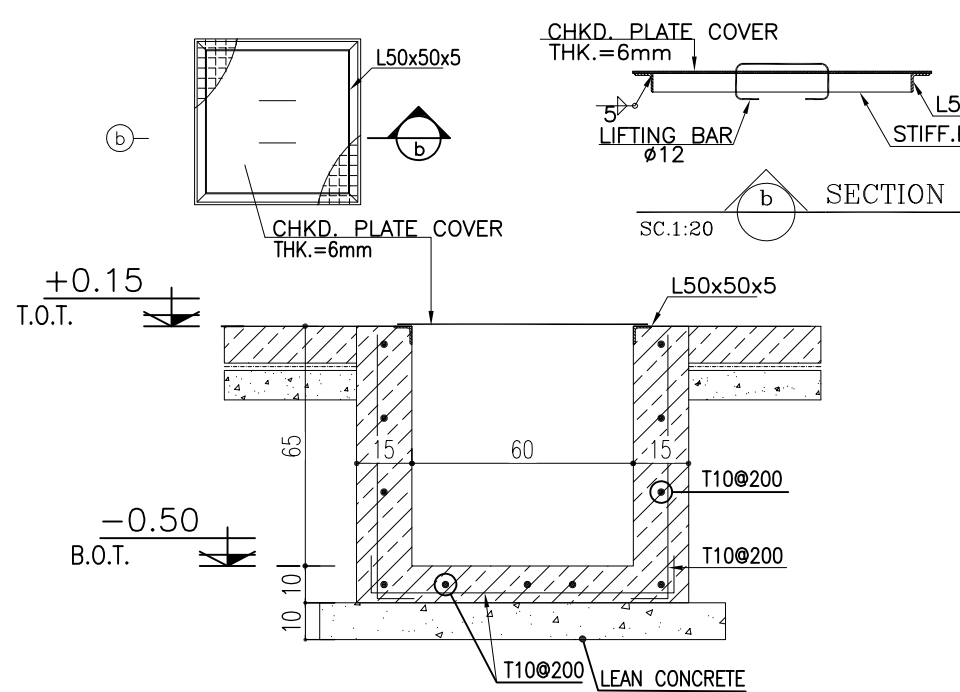


Figure 1 consists of two detailed views of the test specimen. View (a) is a top view of the specimen, showing a square cross-section with dimensions 150x50x5. It includes a central square hole with a side length of 70. The top view also shows the location of the lifting bar (LIFTING BAR $\phi 12$) and the stiff (STIFF) bar. View (b) is a section view of the specimen, showing the vertical dimensions and reinforcement details. The total height is 100, with a central hole of height 70. The section view shows the reinforcement details, including T10@200 bars and lean concrete. The section view also shows the levels +0.70 and -0.30. The section view includes a detail of the lifting bar and stiff bar, and a note about the CHKD. PLATE COVER THK.=6mm.

Figure 10.10 shows the details of a square column. The figure includes a plan view (top left), a section view (top right), and a detailed elevation view (bottom). The plan view shows a square column with a side length of 700 mm, with dimensions 150x50x5 mm for the top and bottom reinforcement. The section view shows the column with a height of 1000 mm, with dimensions 150x50x5 mm for the top and bottom reinforcement. The elevation view shows the column with a height of 1000 mm, with dimensions 150x50x5 mm for the top and bottom reinforcement. The column is shown with reinforcement bars (T10@200) and a concrete core (LEAN CONCRETE). The column is shown with a height of 1000 mm, with dimensions 150x50x5 mm for the top and bottom reinforcement. The column is shown with a height of 1000 mm, with dimensions 150x50x5 mm for the top and bottom reinforcement.

The diagram illustrates the vertical build-up of a ground floor. The layers, from top to bottom, are:

- FLOORING ACCORDING TO FINISHING SCHEDULE
- SAND CEMENT MORTAR
- FINISHED CONCRETE (300 Kg/m³) SLAB
- REINFORCING MESH $\phi 8 @ 200$ (A-II ISIRI 3132)
- POLYETHYLENE SHEET 0.4mm AS VAPOR BARRIER
- LEAN CONCRETE
- GRAVEL
- RUBBLE
- TOVENAN COURSE
- COMPACTED SOIL ASHTO 95% TO TOP OF SUBGRADE LEVEL

Dimensions are indicated on the left side of the diagram:

- 5 (for the topmost thin layer)
- 15 (for the concrete slab and mesh layer)
- 10 (for the lean concrete layer)
- 30 (for the gravel and rubble layers)

Horizontal dimensions 'd' are shown for the gravel and rubble layers, indicating the spacing between reinforcement or mesh.

DETAIL 07-FLOORING (GROUND FLOOR)

Sc:1/10

DETAIL 07-FLOORING (GROUND FLOOR)
Sc:1/10

2L-60x60x6mm
OR 2L-80x80x6mm
OR 2L-100x100x10mm

PL a-40x80x6 mm
@ 500 mm c/c

300mm

b

300mm

1

1

PL a-40x80x6 mm
@ 500 mm c/c
TOP & BOTTOM

a-40 mm

2IPE-140
2IPE-180

WELD

300mm

b

300mm

2

2

2 IPE-140 &/OR
2 IPE-180

PL a-40x80x6 mm
@ 500 mm c/c
TOP & BOTTOM

300mm

b

 
 
 
 
 
300mm

2


2


TYP. SECTION 1-1
Sc: 1:5

TYP. SECTION 2-2
Sc: 1:10

NOTES			
1.	ALL DIMENSIONS ARE IN CENTIMETER & ALL ELEVATIONS ARE IN METER.		
2.	ALL DIMENSIONS AND ELEVATIONS SHALL BE CHECKED BY THE CONTRACTOR PRIOR TO CONSTRUCTION.		
3.	CONTRACTOR SHALL COMPARE ALL ARCHITECTURAL, MECHANICAL, ELECTRICAL, PIPING AND STRUCTURAL DRAWINGS AND IN CASE OF ANY CONFLICTS OR DISCREPANCY, INFORM THE ENGINEER.		
4.	ALL MATERIALS ARE SELECTED FROM THE HIGHEST QUALITY AND MUST BE APPROVED BY THE CLIENT.		
5.	ALL OPENINGS FOR PIPING/CABLING AND HVAC OPENINGS SHALL BE CONSIDERED AS PER RELATED DRAWINGS BEFORE CONSTRUCTION.		
6.	ARCHITECTURAL DETAIL DESIGN WILL BE REVISED BASED ON APPROVED STRUCTURAL DRAWINGS.		
7.	ELEVATION CODE : LOCAL $\pm 0.0m$ CORRESPONDS TO GLOBAL $+11.10m$		
LEGEND			
LEAN CONCRETE			
REINFORCED CONCRETE			
PRESSED BRICK			
STONE			
EXPANSION JOINT FILLER (PLASTOFOAM)			
TERRAZZO TILES FOR ROOF – 30x30cm			
BLOCKAGE			
F.F.L.	FINISHED FLOOR	B.O.P.	BOTTOM OF PIT
T.O.WA	TOP OF WAIKWAY	F.G.L.	FINISH GRADING LEVEL
T.O.P.	TOP OF PARAPET	T.O.T.	TOP OF TRENCH
T.O.FOU.	TOP OF FOUNDATION	C.O.S.	CENTER OF SLEEVE
M.D	METAL DOOR	B.O.S.	BOTTOM OF SLEEVE
T.O.R.	TOP OF ROOF	B.O.O.	BOTTOM OF OPENING
T.O.D.	TOP OF DOOR	B.O.T.	BOTTOM OF TRENCH
T.O.Ca.	BOTTOM OF CAGE	B.O.P.	BOTTOM OF PIT
T.O.Ca.	TOP OF CAGE	R.H.P.	ROOF HIGHEST POINT
B.O.G.	BOTTOM OF GUTTER	R.L.P.	ROOF LOWEST POINT
T.O.Ca.	TOP OF CAGE	N.G.R.	NEUTRAL GROUND RESISTOR
M.D.	METAL DOOR	B.P.D.	BLAST–PROOF DOOR
T.O.S.	TOP OF SLAB	F.D.	FENCE DOOR


REFERENCE DRAWING	DRG. No.
STANDARD DRAWING FOR ARCHITECTURAL DETAILS	BK-GNRL-PEDCO-000-AR-DW-0001
SITE SEWAGEAGE SYSTEM LAYOUT & DETAILS	BK-GCS-PEDCO-120-CV-PY-0001
CABLE TRENCH AND DUCT BANK LAYOUT	BK-GCS-PEDCO-120-CV-PY-0002
ROAD, PAVING AND PLANT FINISH GRADING LAYOUT & SECTIONS	BK-GCS-PEDCO-120-CV-PY-0005
ELECTRICAL CABLE ROUTE & SECTION LAYOUT FOR BUILDING & SHELTER	BK-GCS-PEDCO-120-EL-PY-0001
FOUNDATION DRAWING FOR EXTENSION OF EXISTING ELECT. BUILDING	BK-GCS-PEDCO-120-ST-DW-0063
STRUCTURAL DRAWING FOR EXTENSION OF EXISTING ELECT. BUILDING	BK-GCS-PEDCO-120-ST-DW-0064
STANDARD DETAILS FOR LADDER & SAFETY CAGE	BK-GNRL-PEDCO-000-ST-DW-0009
ELECTRICAL EQUIPMENT ARRANGEMENT LAYOUT FOR BUILDING	BK-GCS-PEDCO-120-ST-EL-PY-0008
Unit Plot Plan Drawing	BK-GCS-PEDCO-120-PI-PY-0001

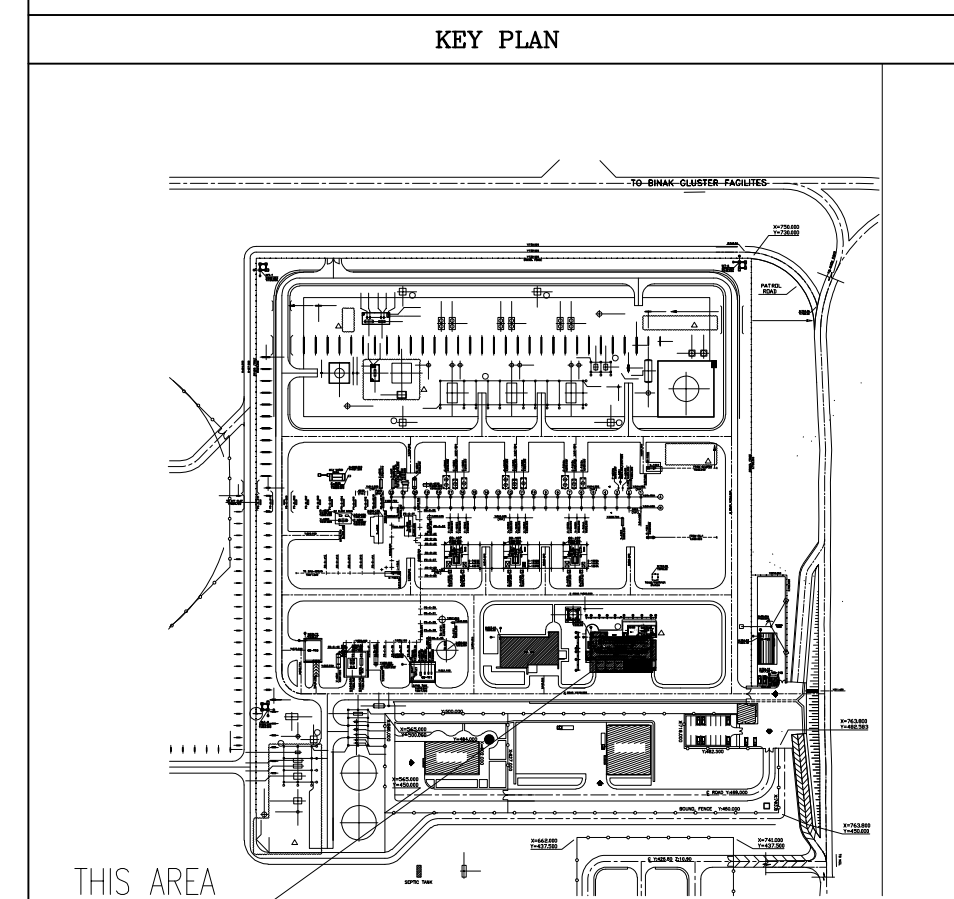[illegible]

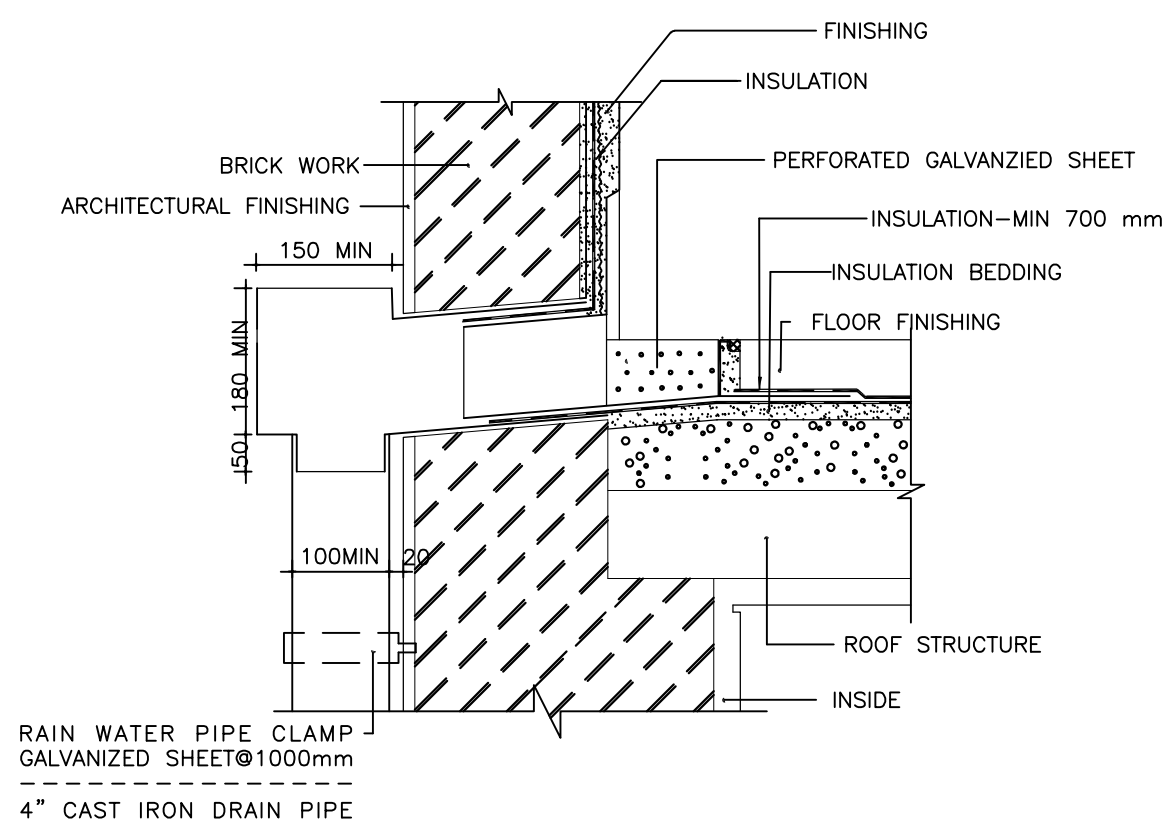


DETAIL 08 -RAIN WATER DISPOSAL

Sc:1/10

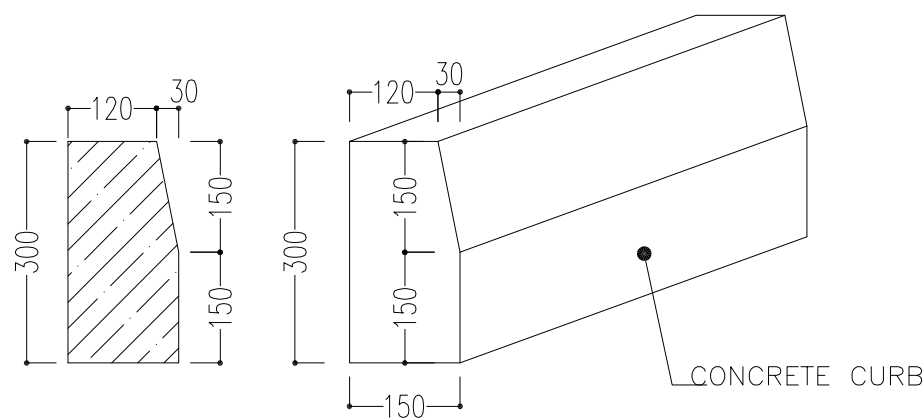


DETAIL 11 CONCRETE CURB

Sc:1/10

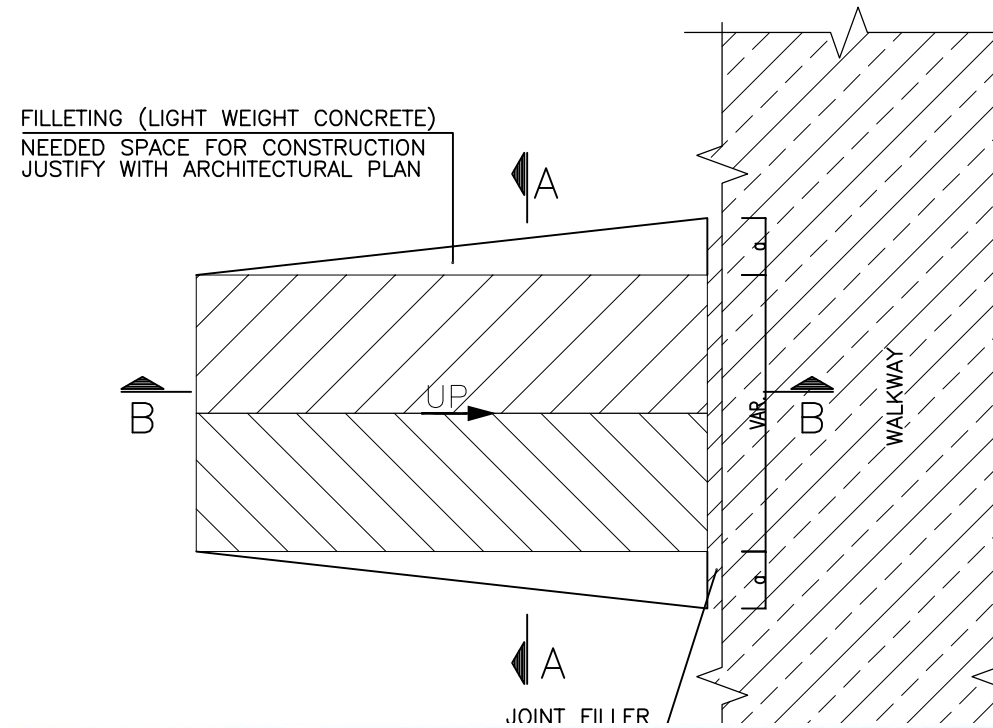


DETAIL 09-TYPICAL PIPE CLIP ON TRAPEZOIDAL SHEET

Sc:1/20

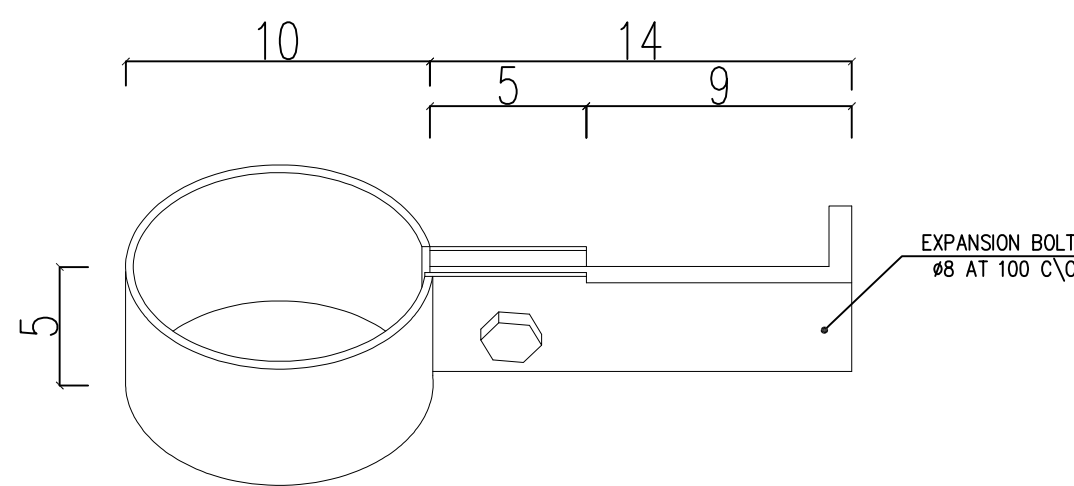


DETAIL 09-TYPICAL PIPE CLIP ON TRAPEZOIDAL SHEET



Sc:1/20

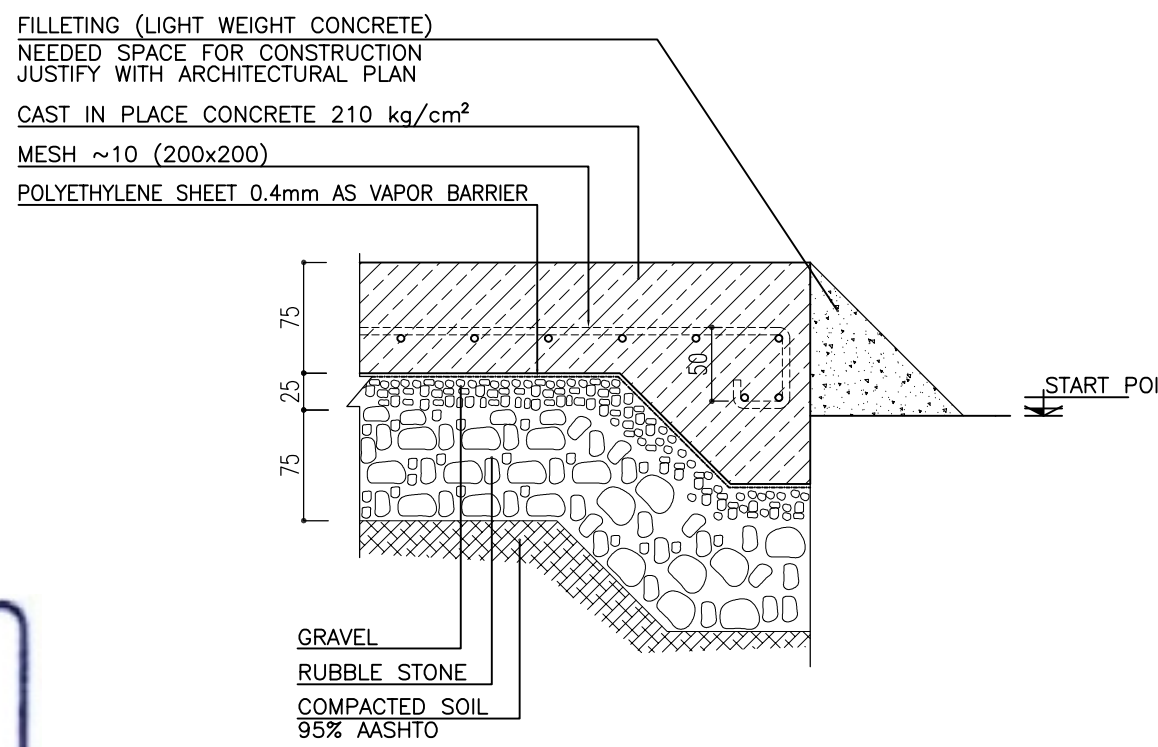



SC.1:10

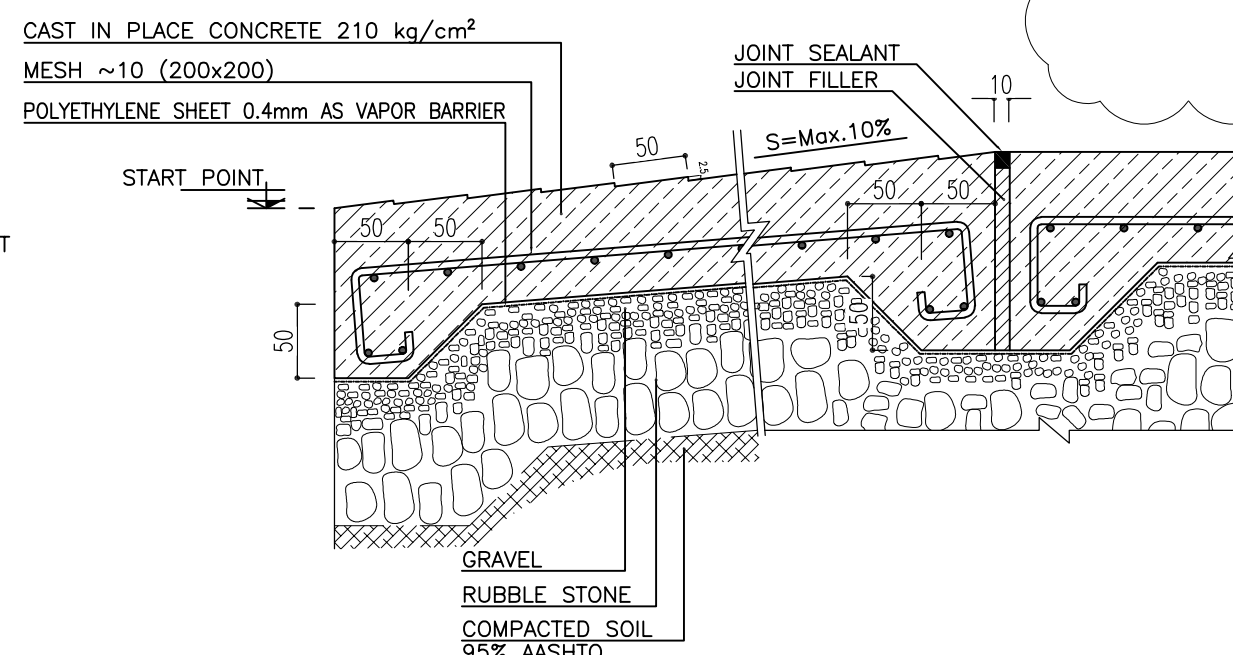



SC.1:10

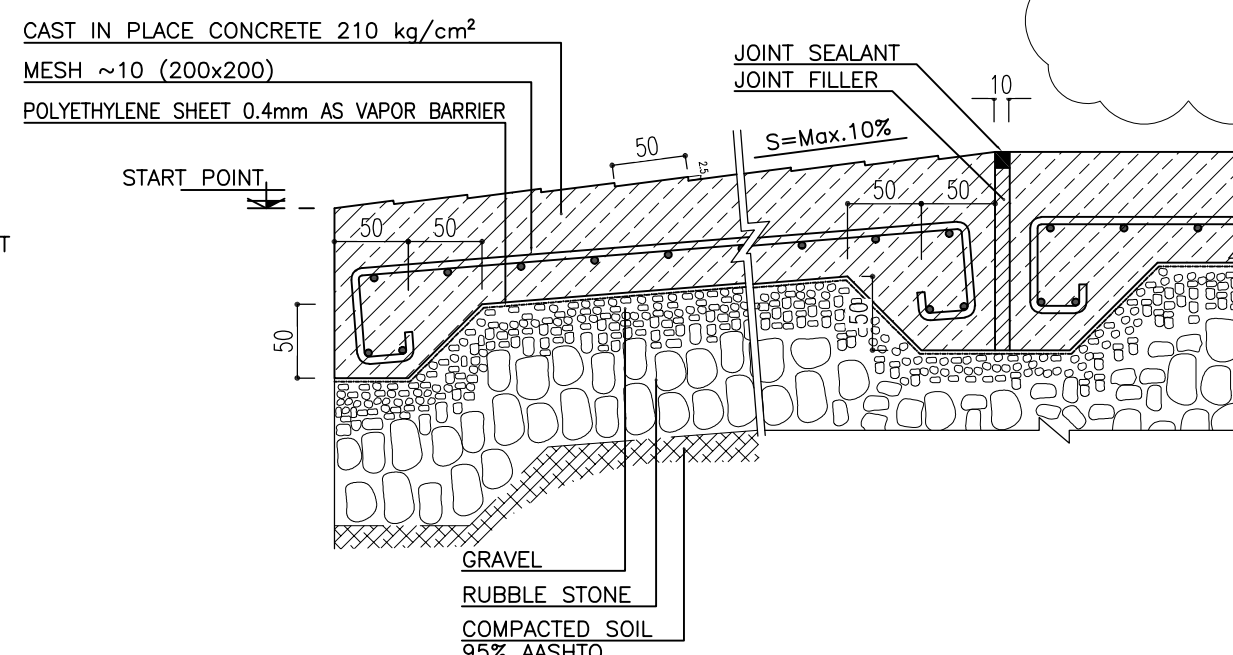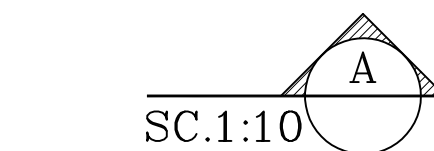



SC.1:10

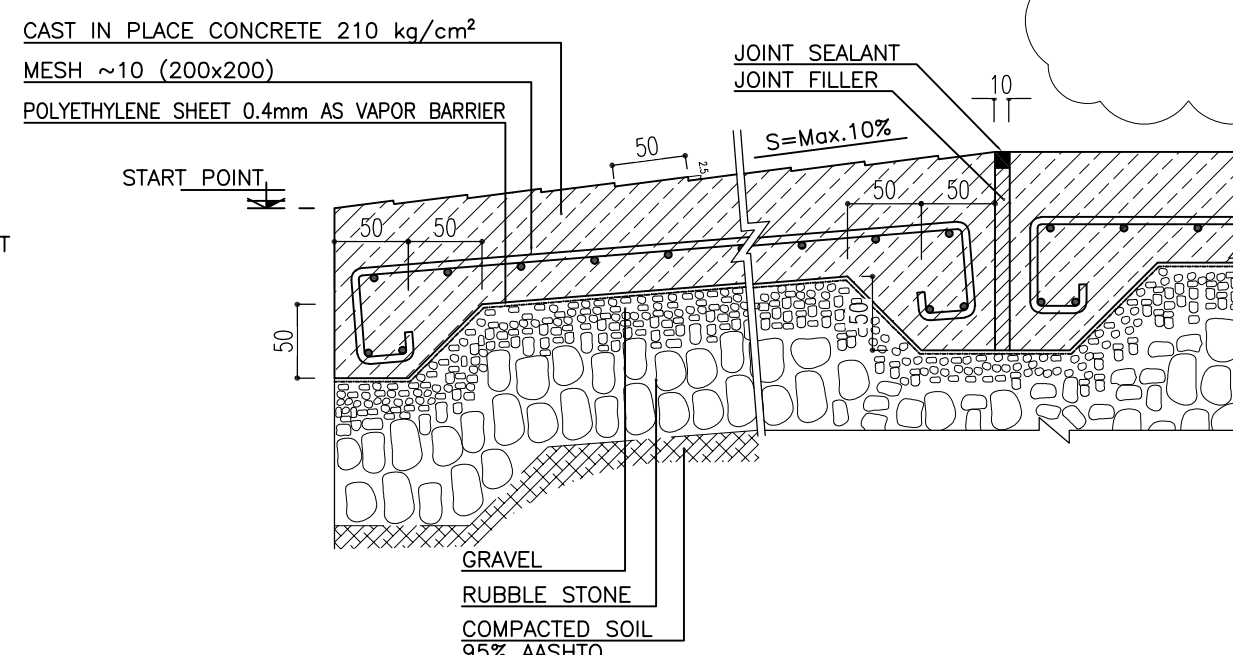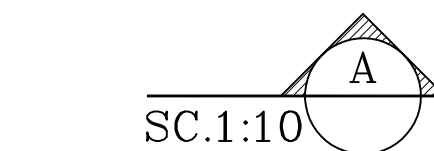



SC.1:10

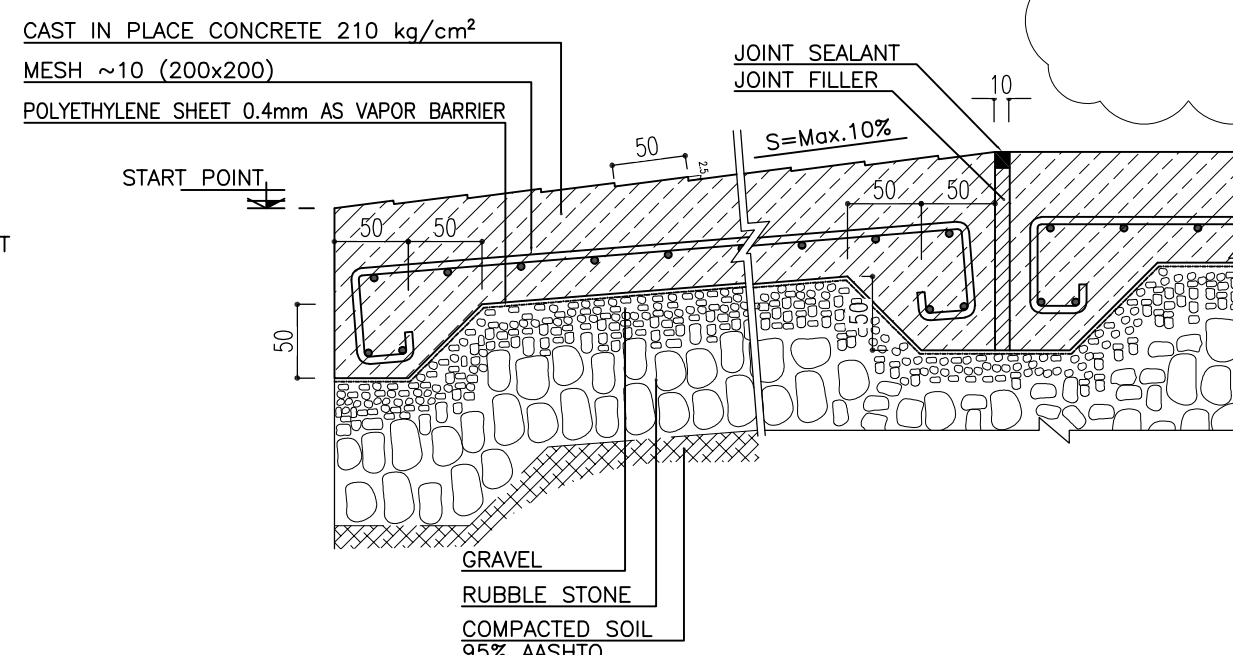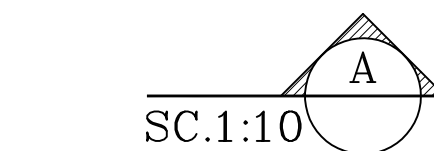



SC.1:10

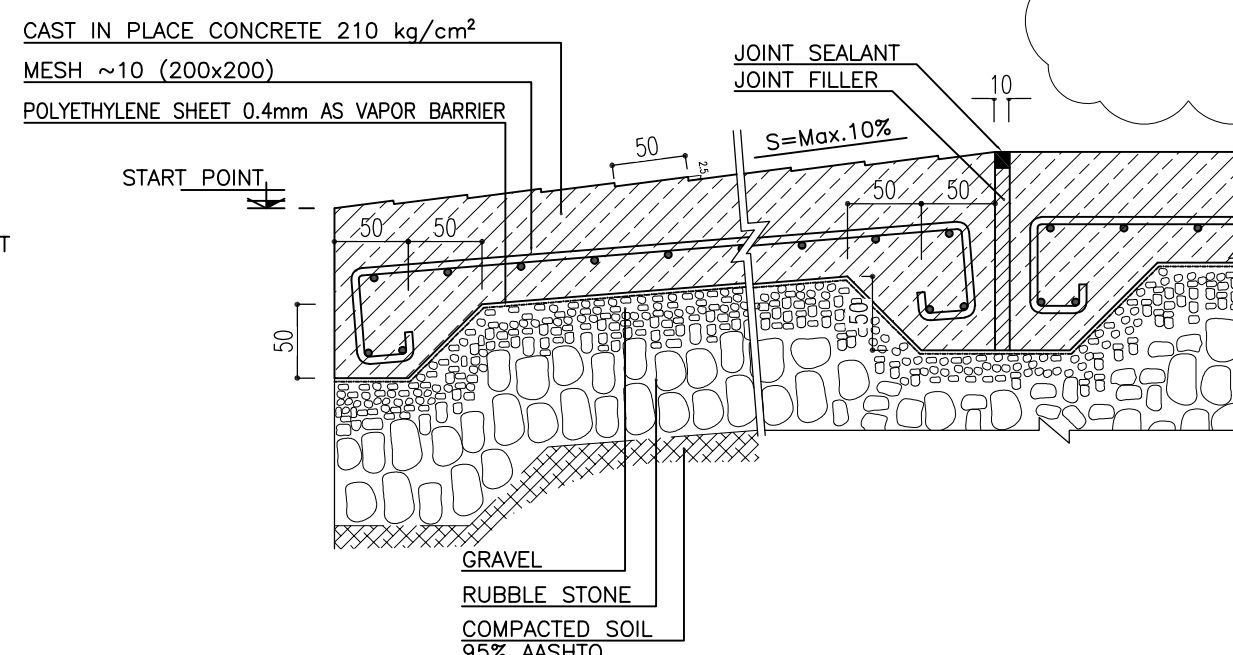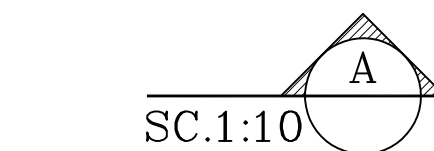



SC.1:10

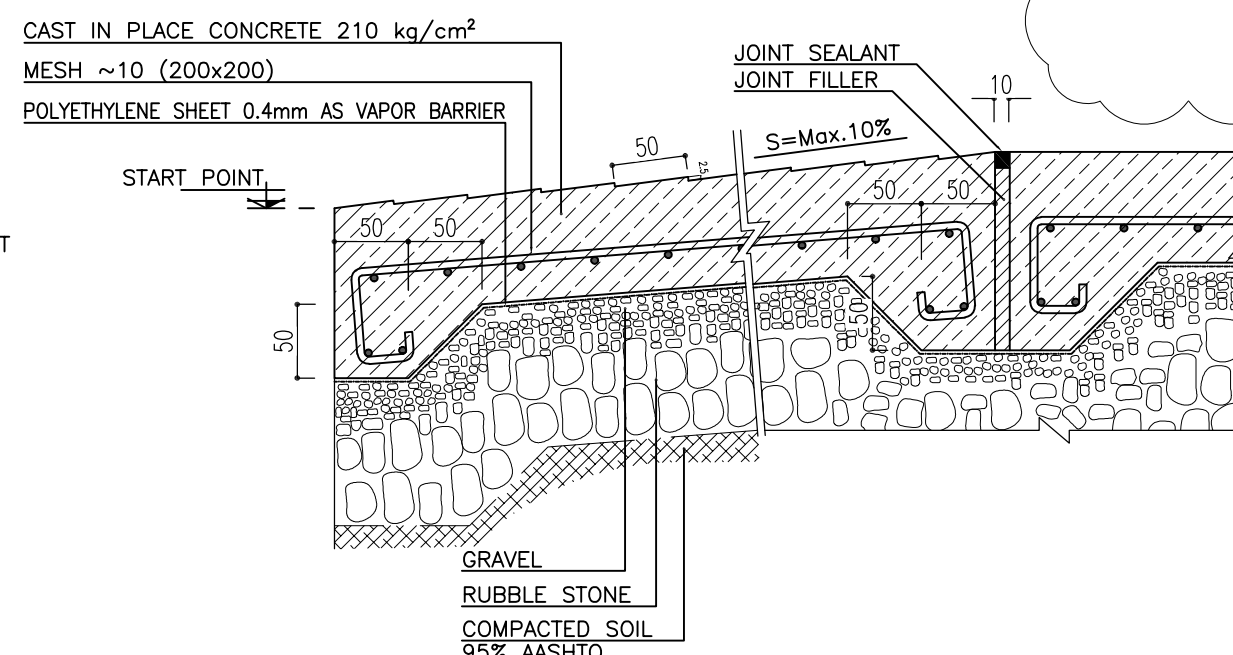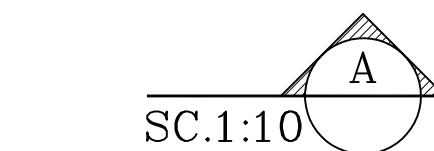



SC.1:10

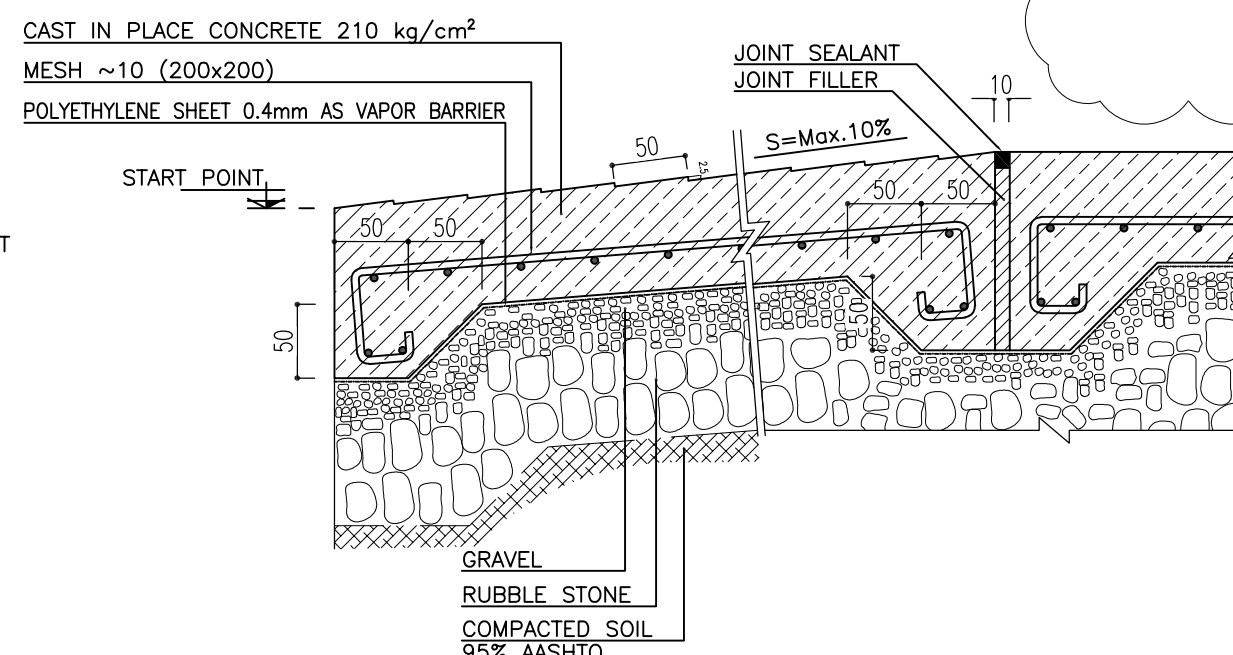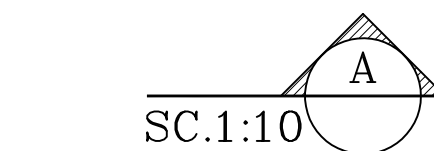



SC.1:10

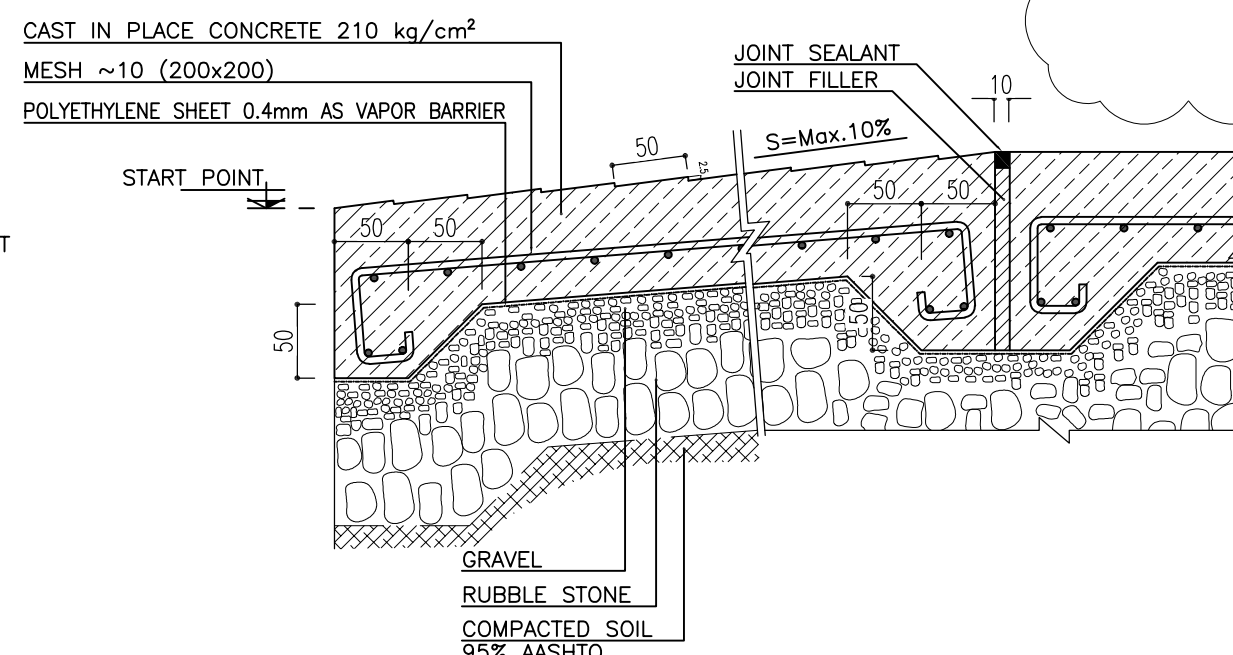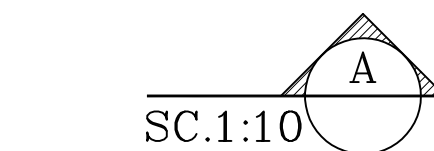



SC.1:10

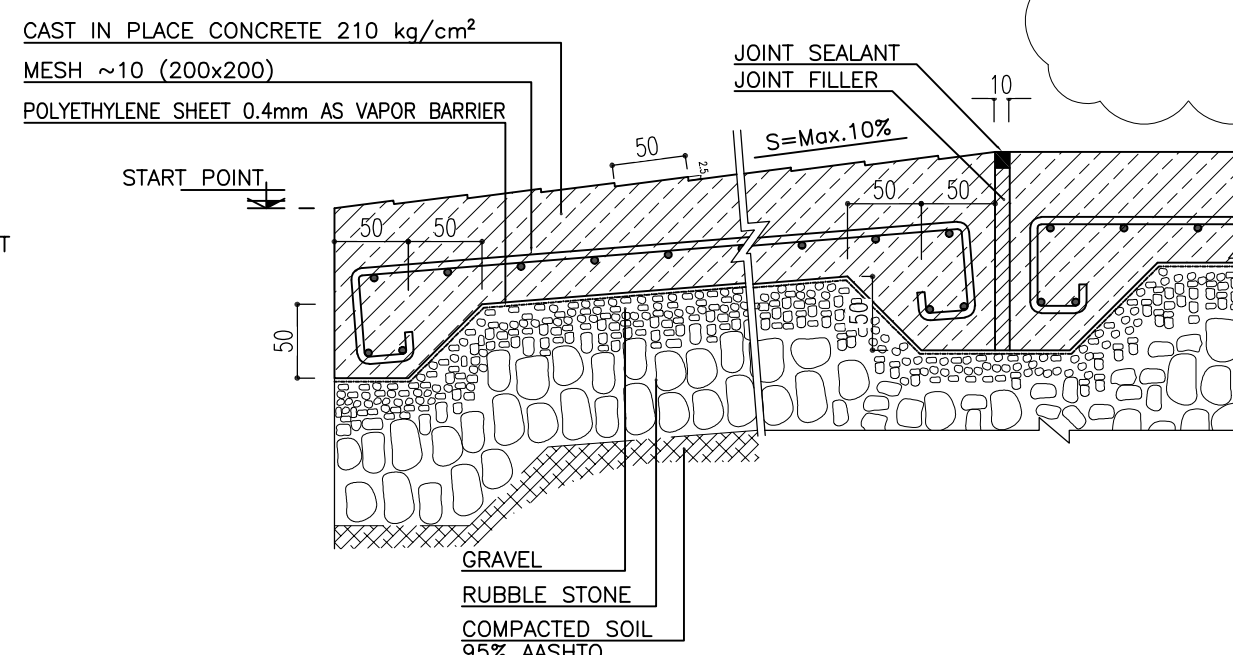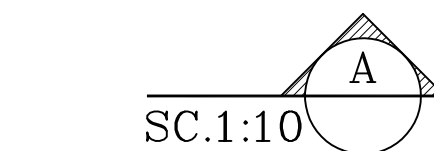



SC.1:10

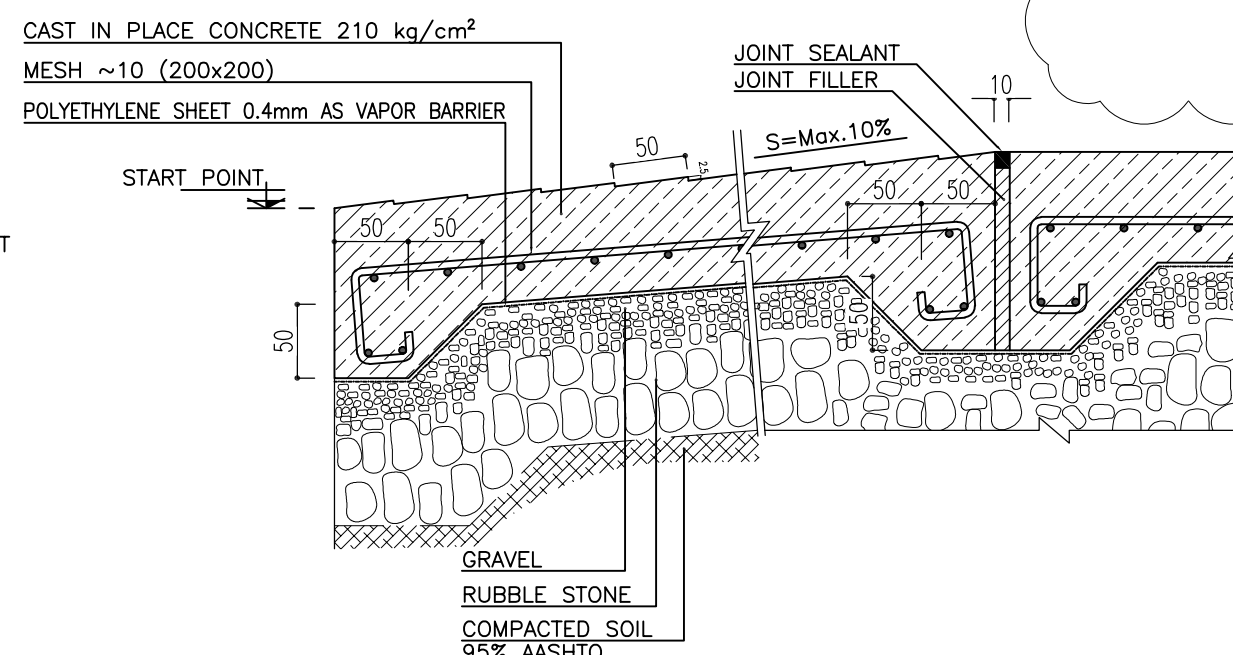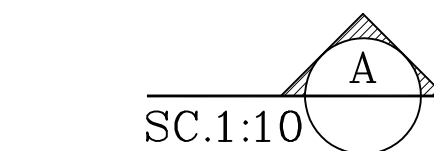



SC.1:10

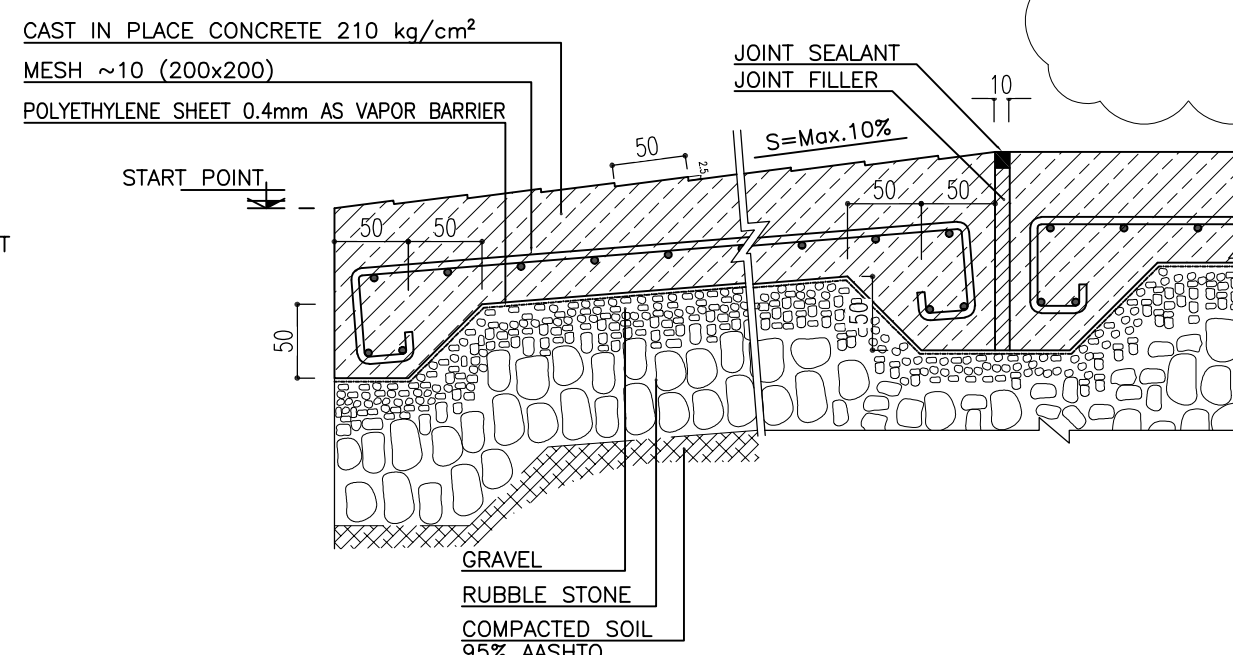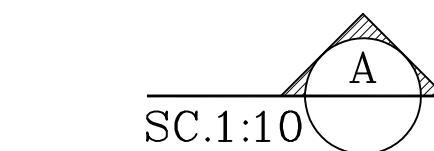



SC.1:10

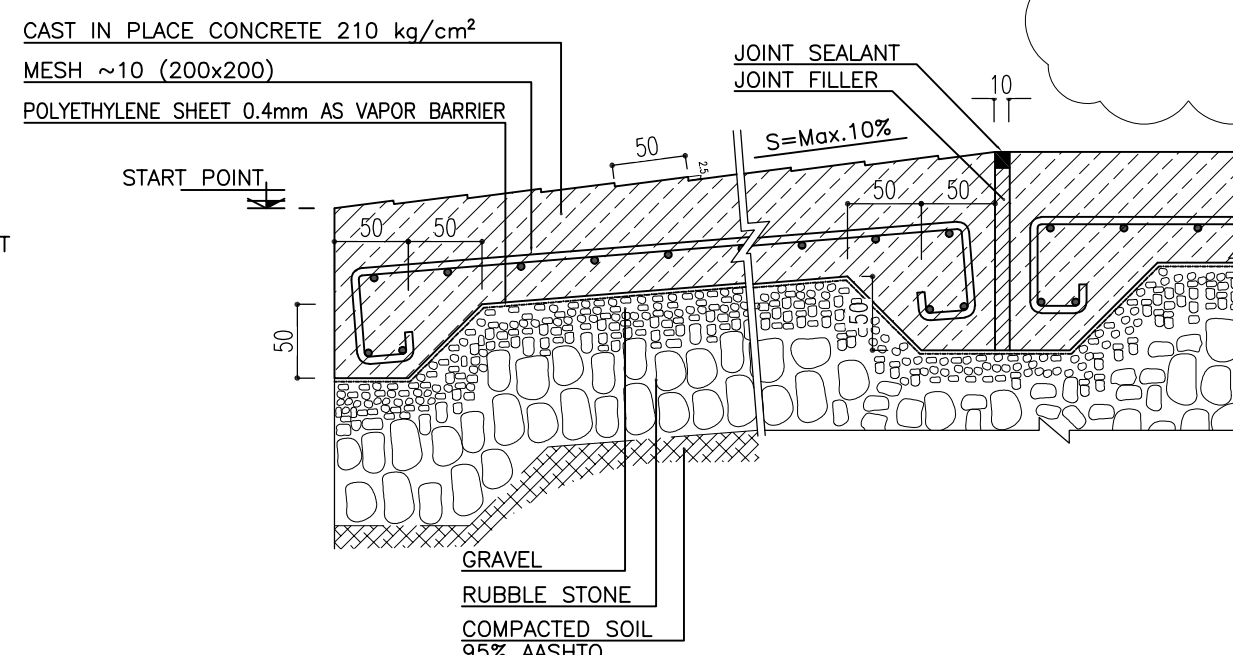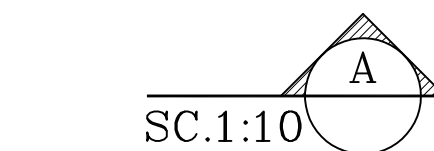



SC.1:10

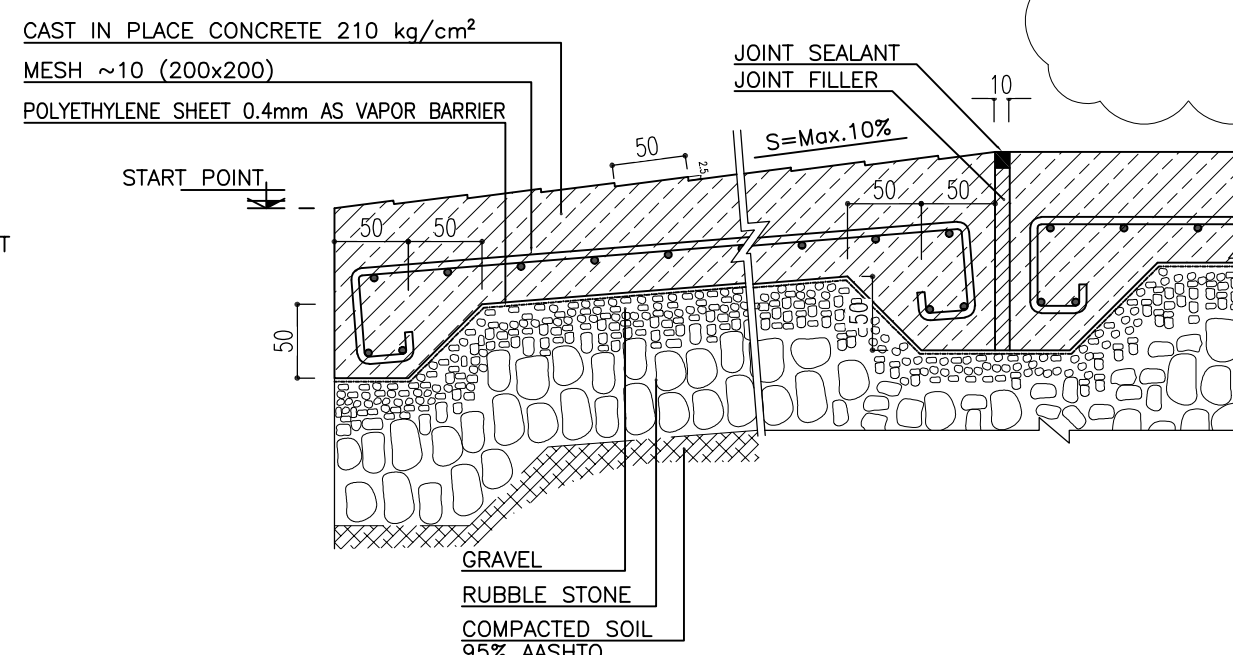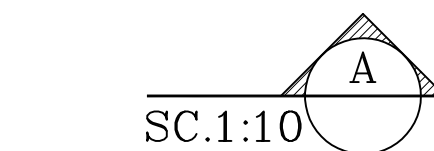



SC.1:10

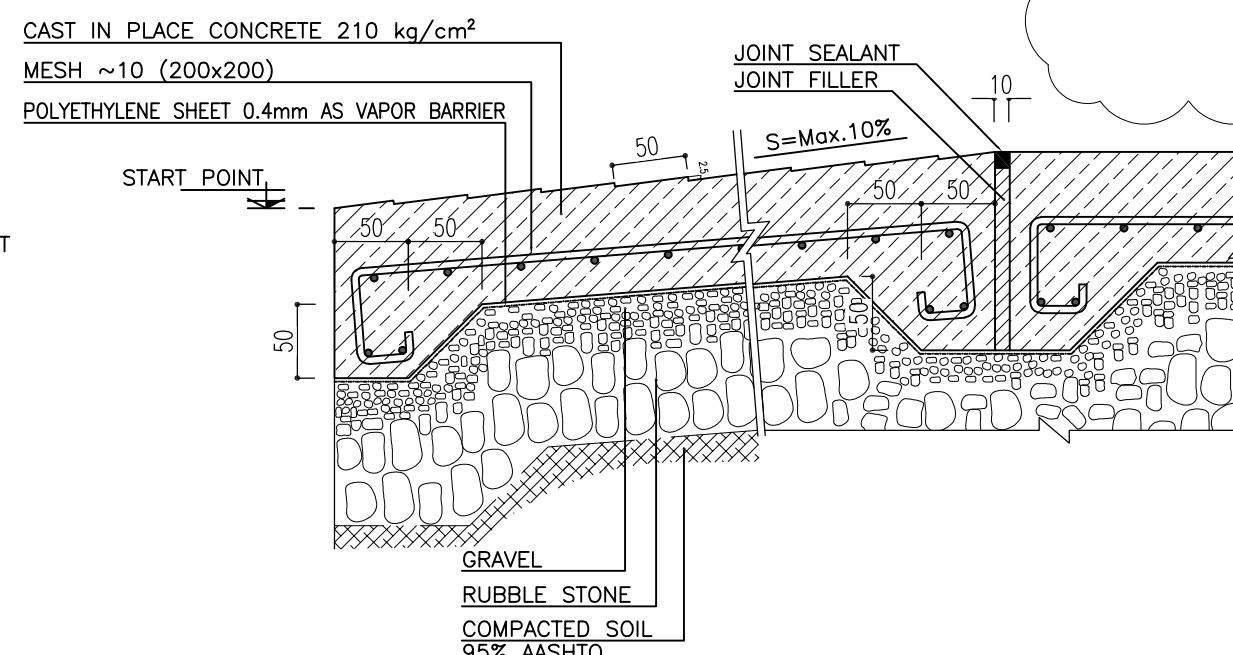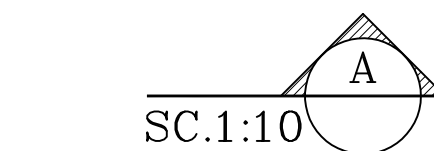



SC.1:10

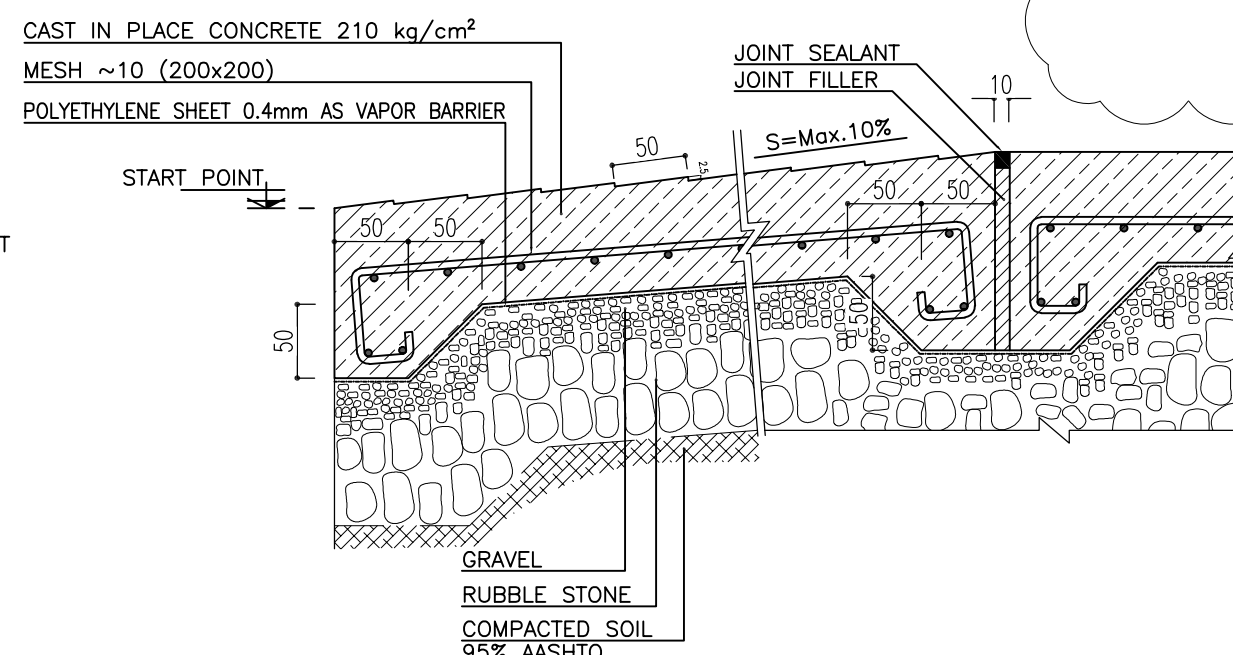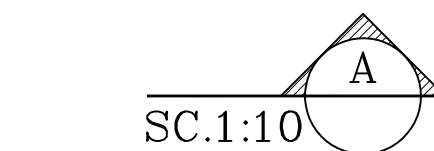



SC.1:10

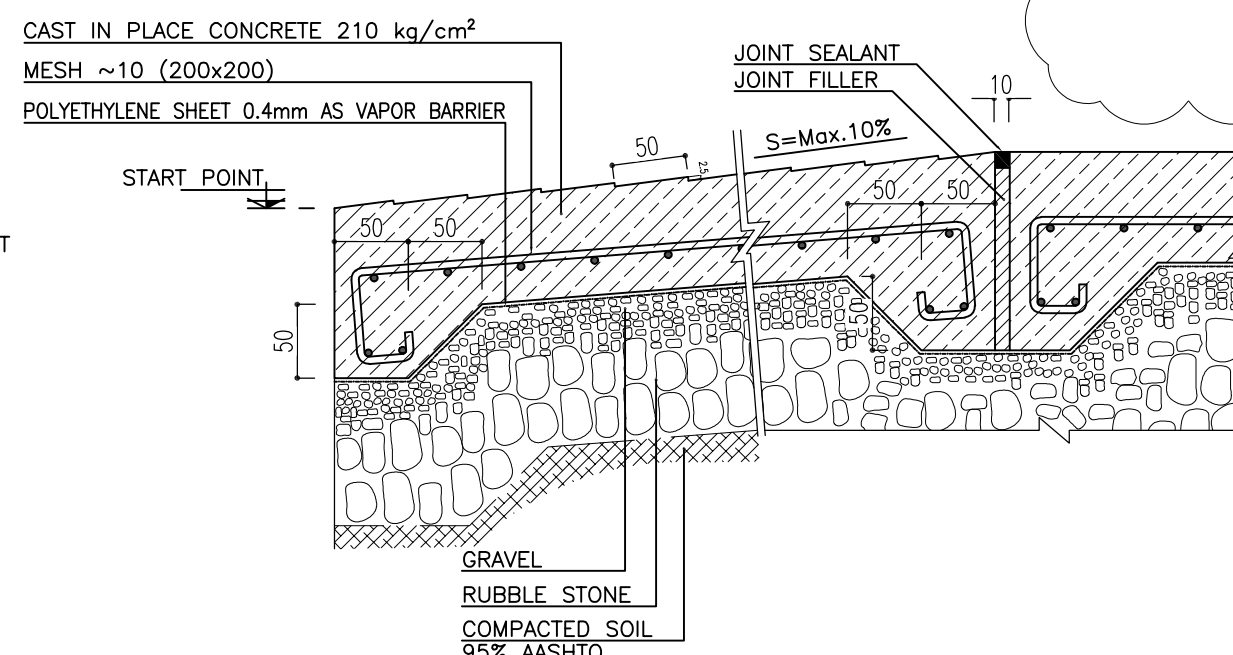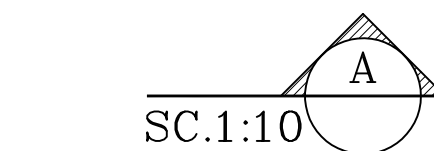



SC.1:10

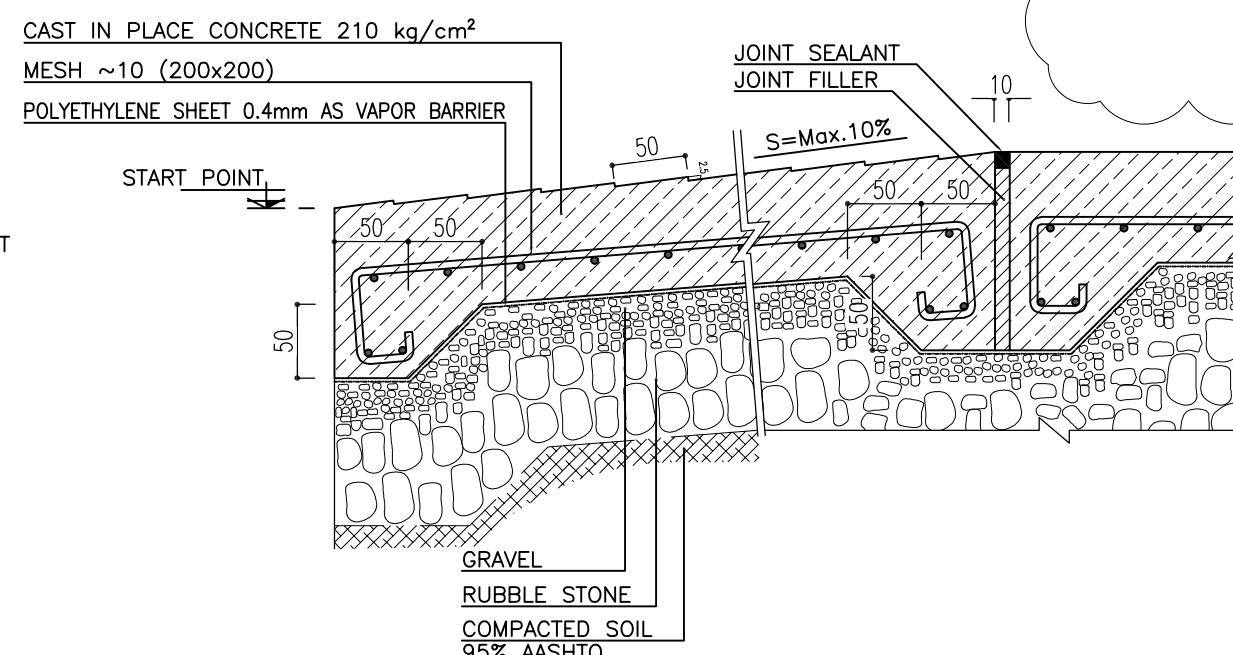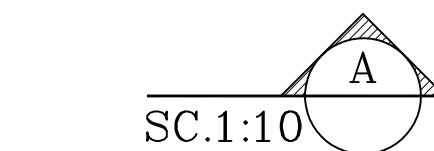



SC.1:10

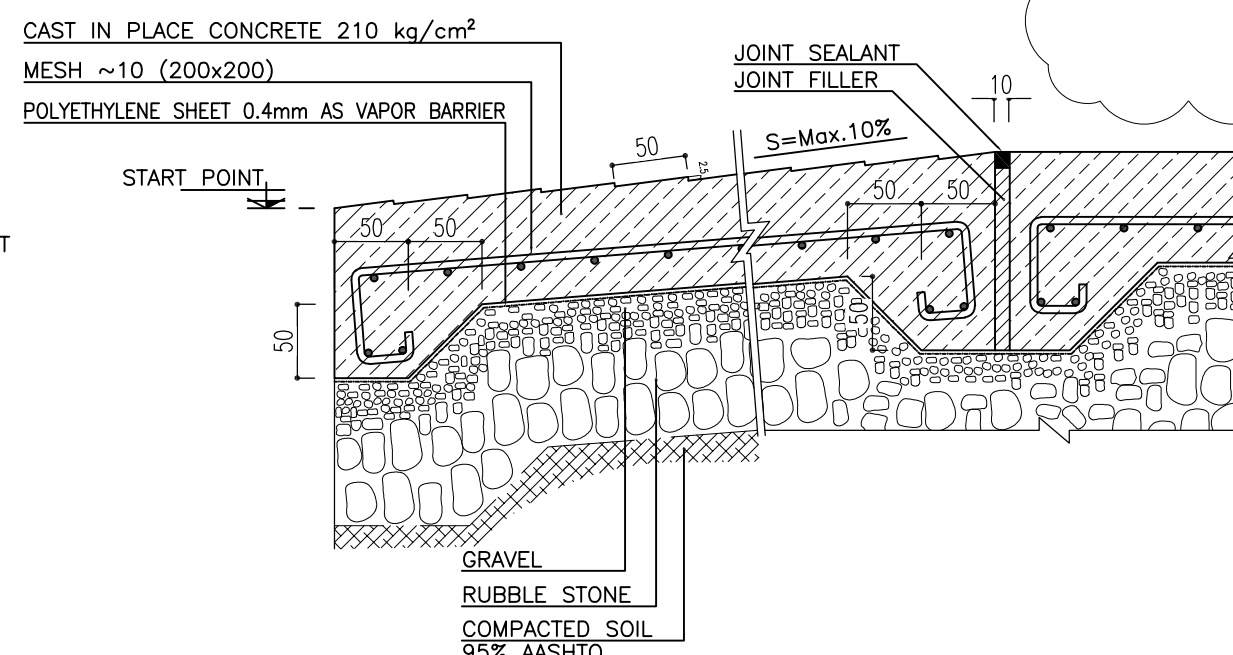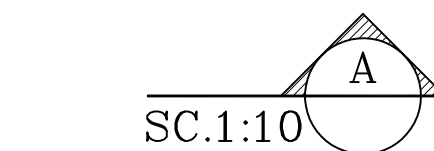



SC.1:10

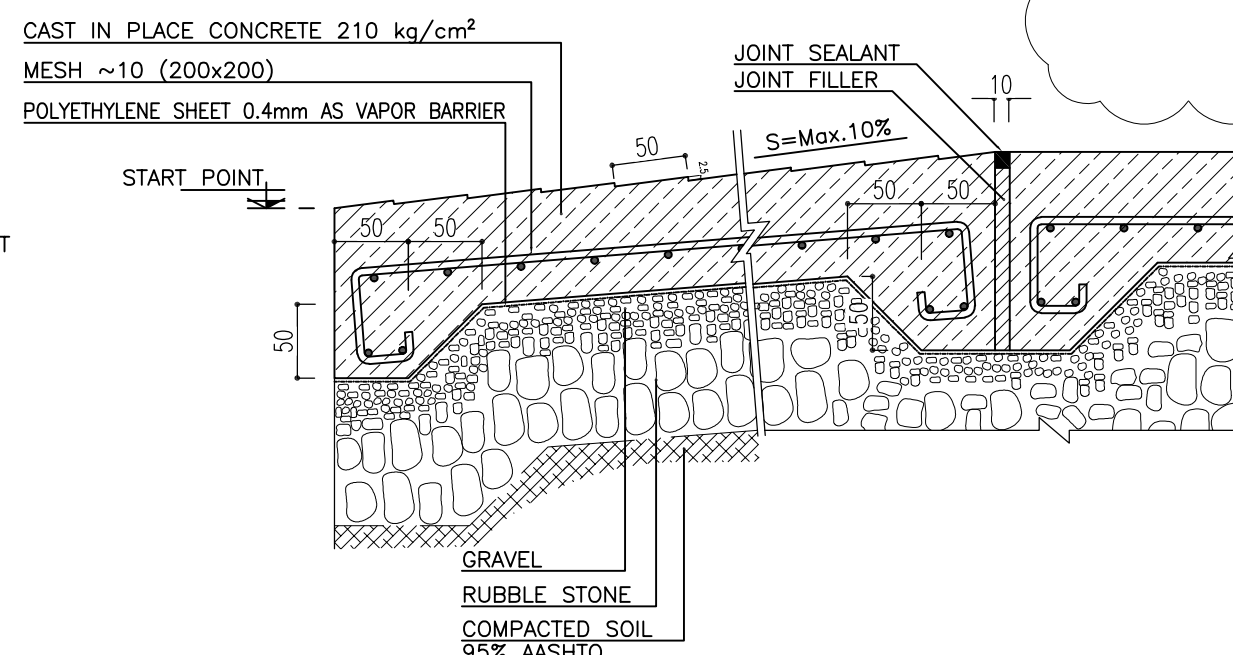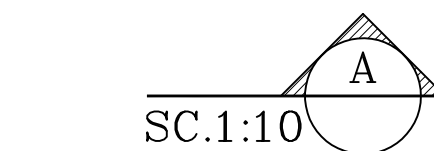



SC.1:10

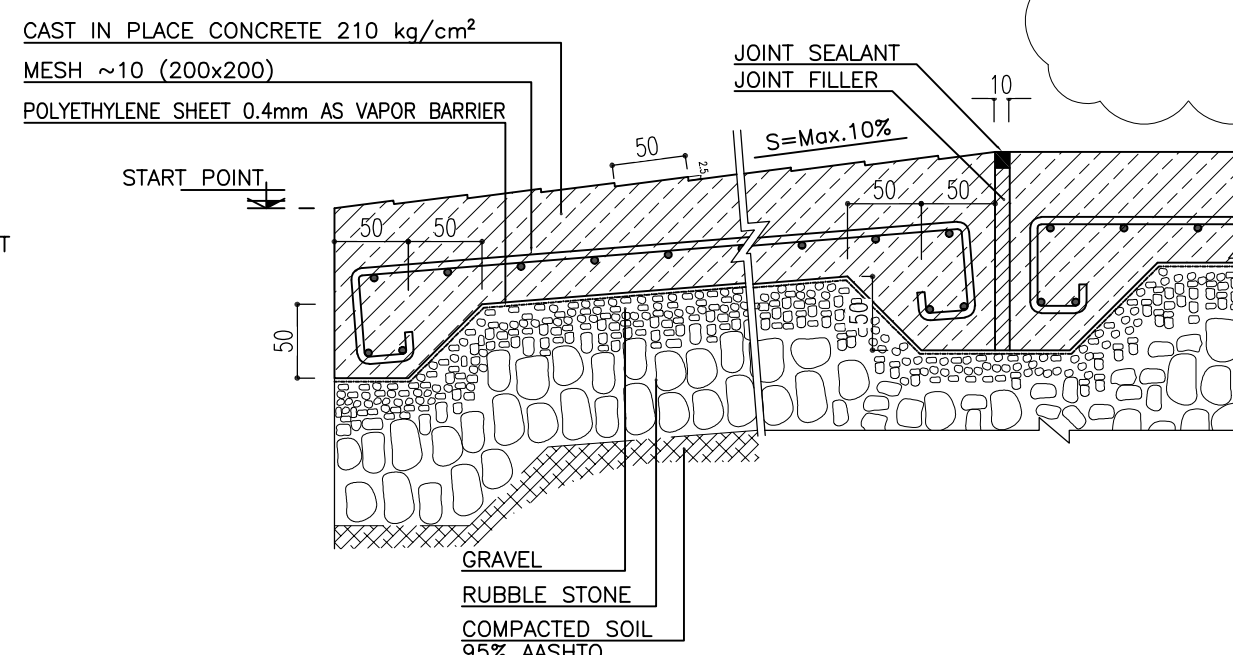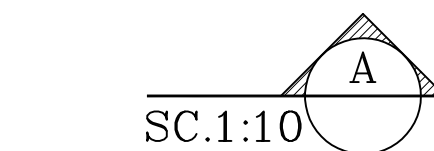



SC.1:10

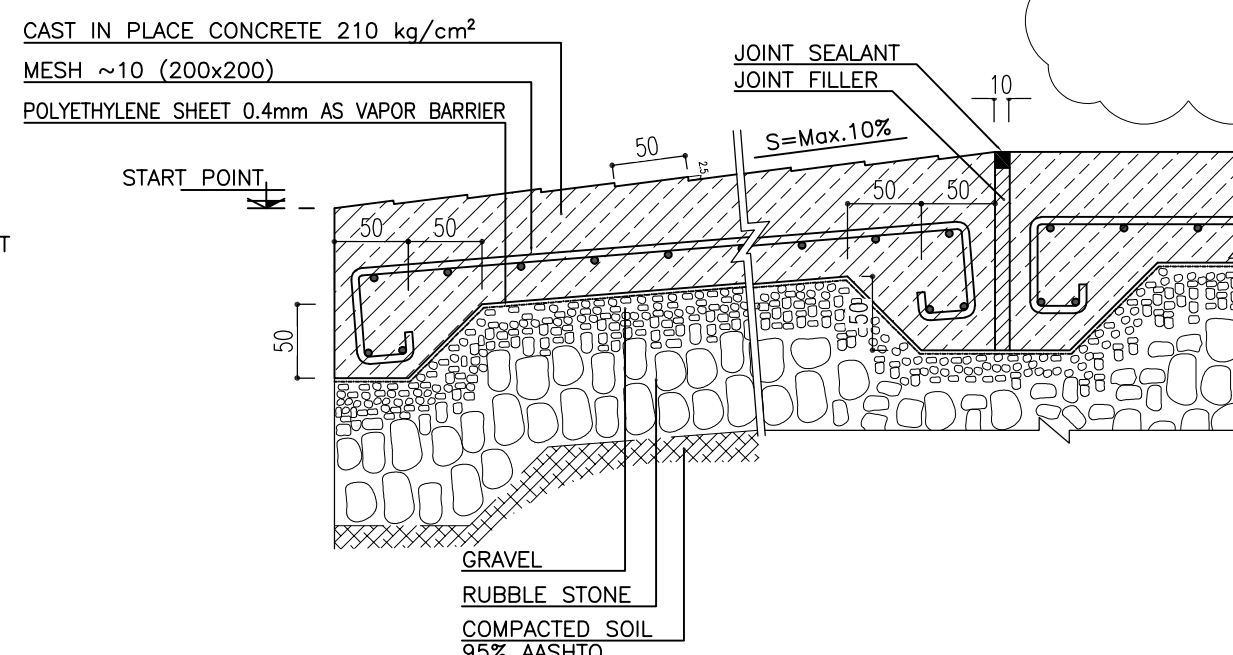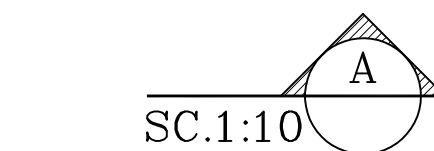



SC.1:10

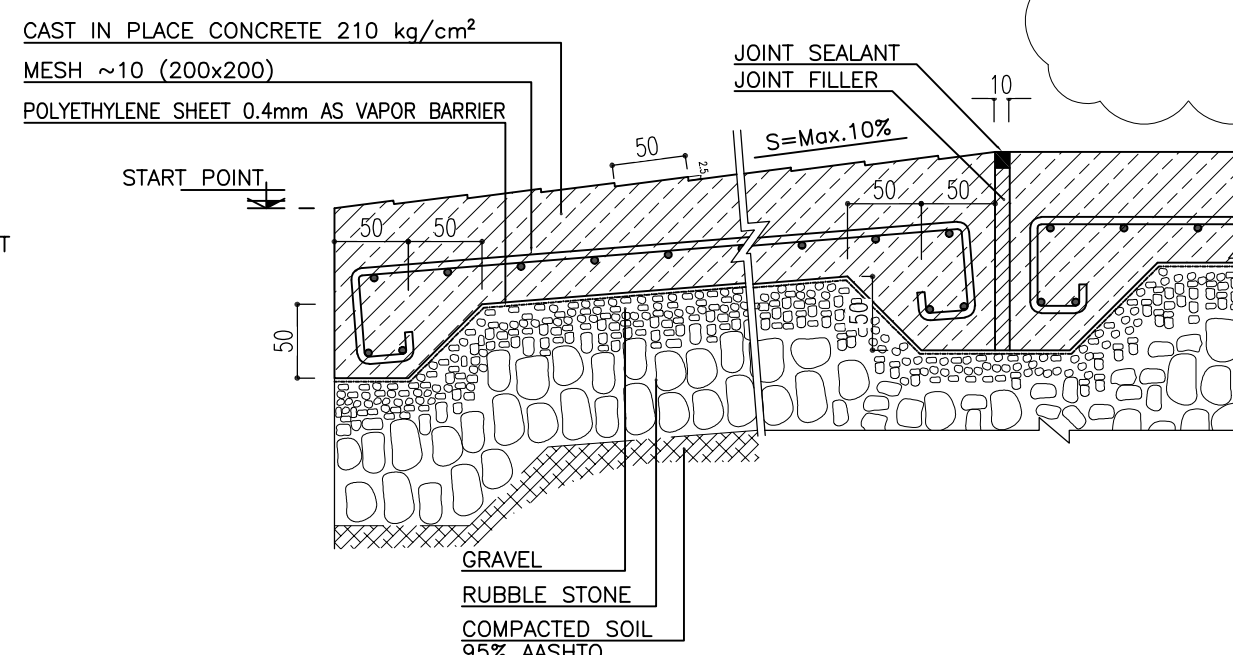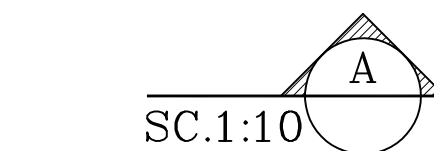



SC.1:10

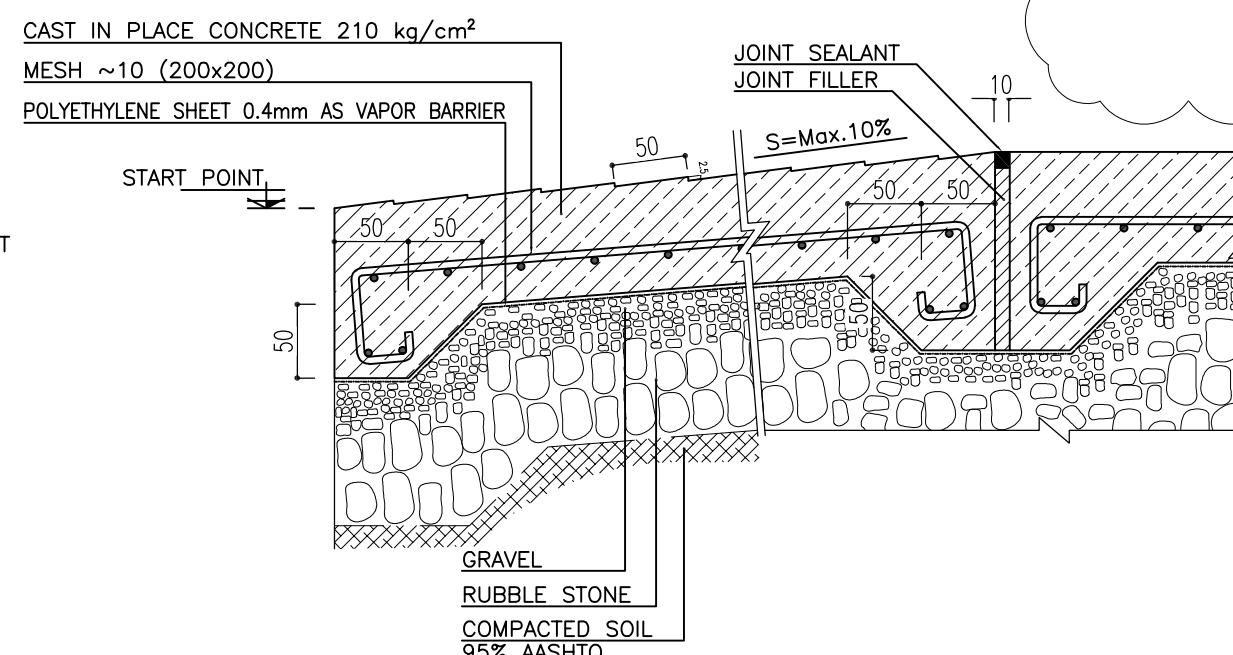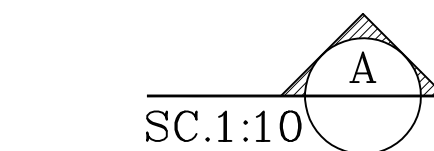



SC.1:10

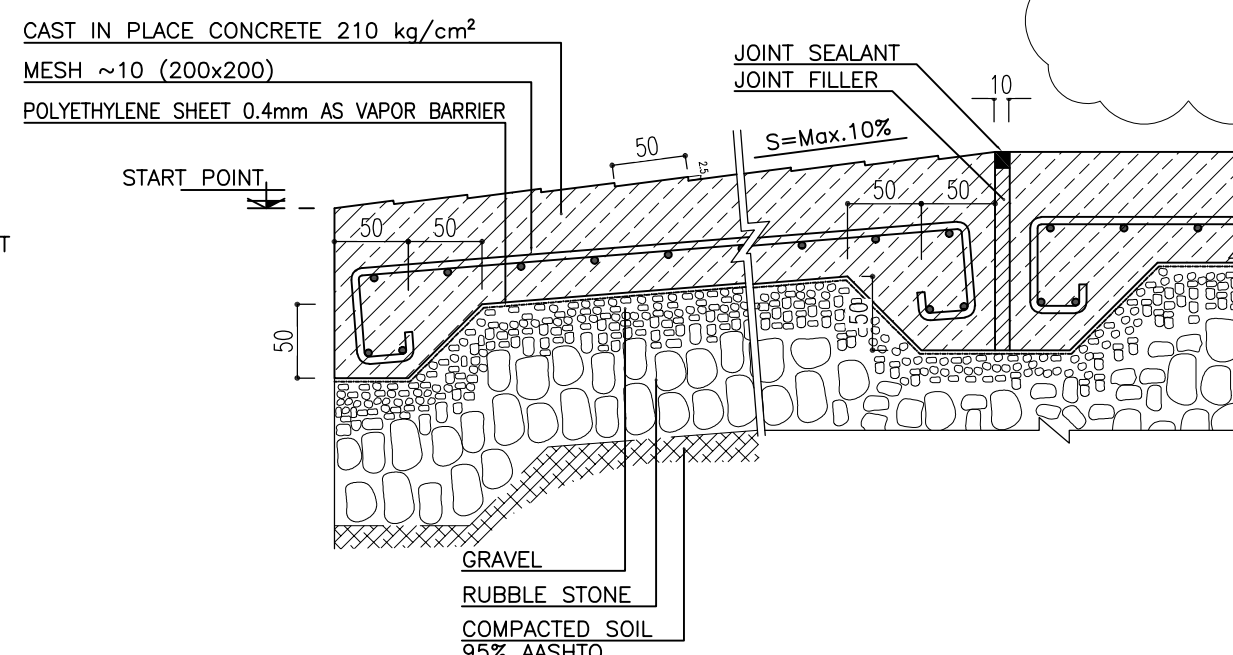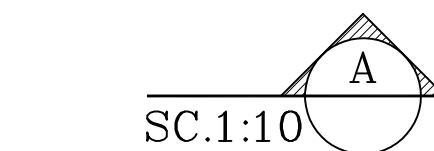

SC.1:10

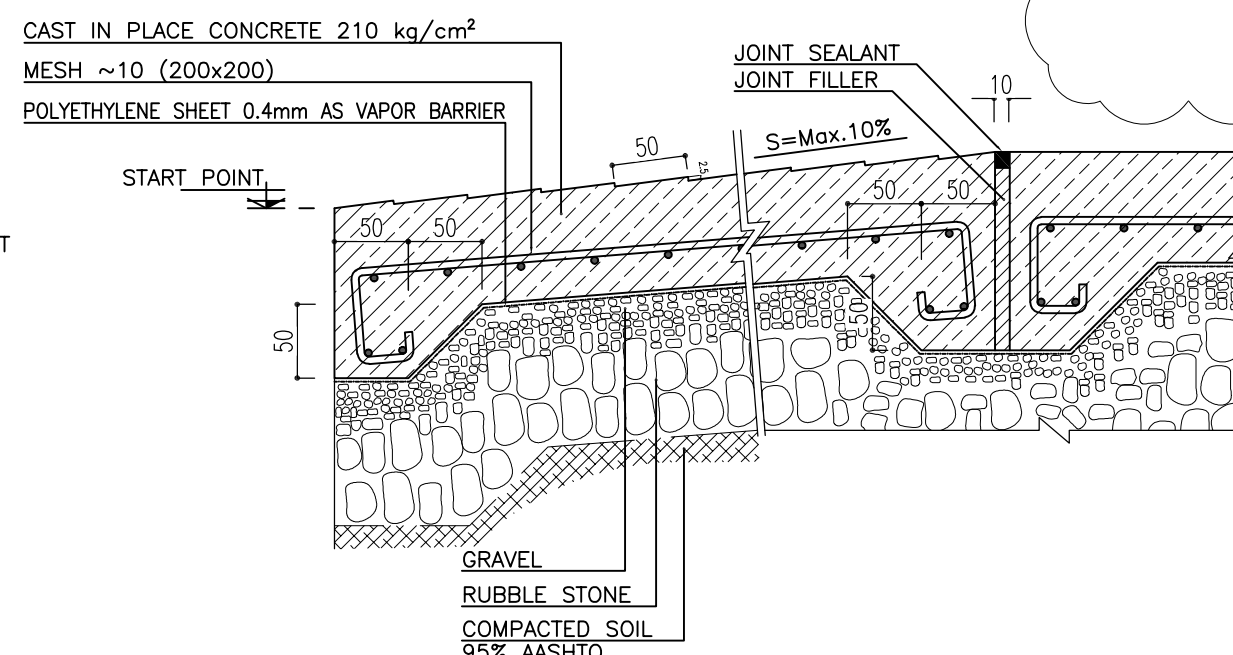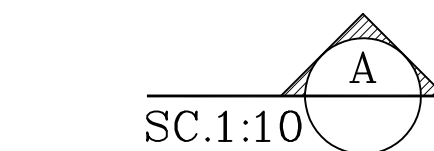

SC.1:10

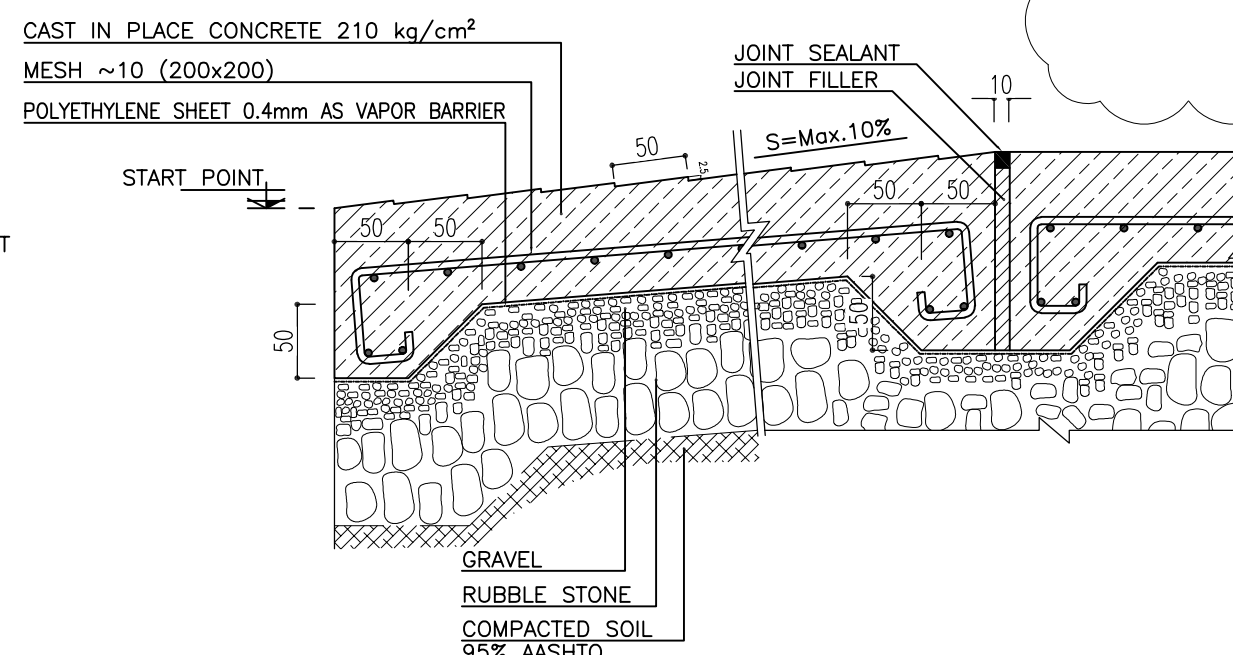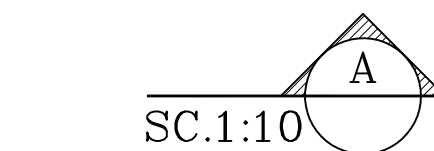

SC.1:10

