


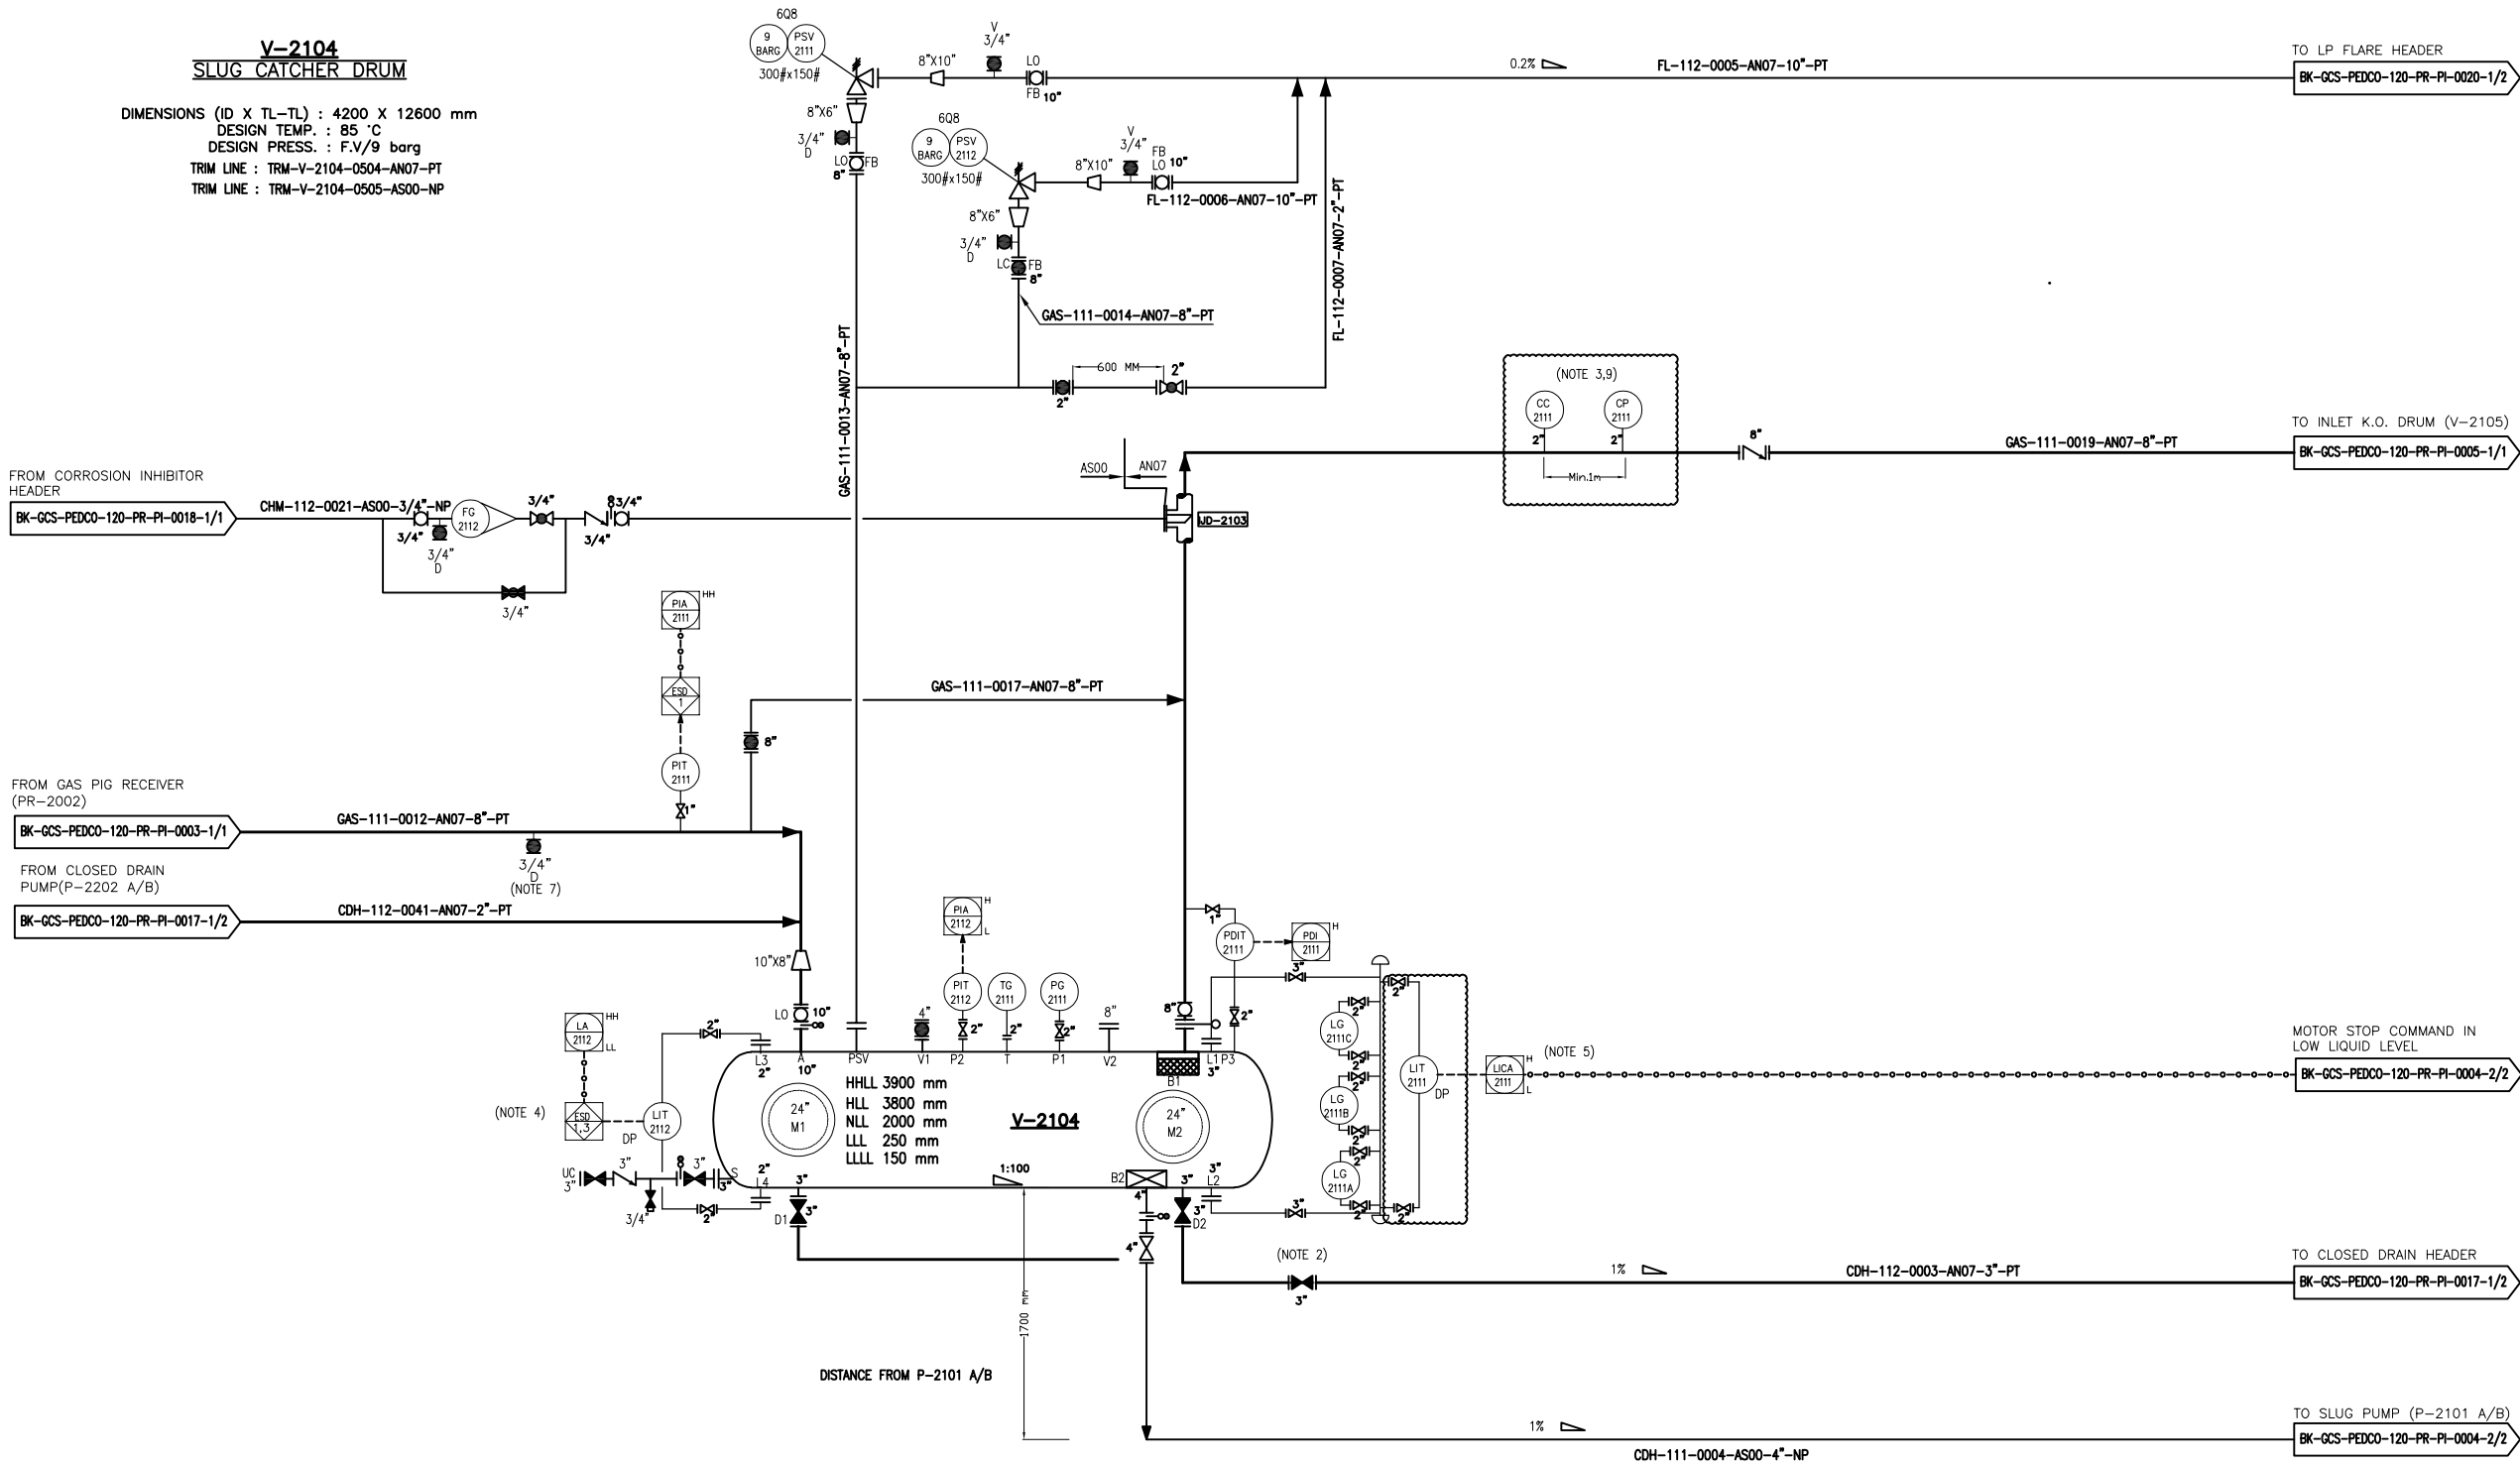

- NOTES**
- 1- DELETED.
 - 2- LOW POINT.
 - 3- ONE PORTABLE METER FOR CORROSION PROBES TO BE PROVIDE PER SITE TO RECOVERY MONITOR CORROSION DATA.
 - 4- ESD LEVEL 1 FOR HH AND 3 FOR LL OF LIQUID LEVEL.
 - 5- IT SHALL BE SPECIFIED IN COMPRESSOR STATION OPERATING MANUAL THAT IN CASE OF HIGH LIQUID LEVEL OF V-2104, OPERATOR SHALL START P-2101 A/B.
 - 6- PARTIAL STROK DEVICE TO BE CONSIDERED FOR ALL ESDV'S ACTVATED BY ESD 1.0.
 - 7- DRAIN CONNECTION SHALL BE CONSIDER ON LOW POINT OF LINES AND EQUIPMENT.
 - 8- ALL DRAIN LINE SHALL BE CONNECTED TO CLOSED DRAIN HEADER AND ALL VENTS SHALL BE CONNECTED TO FLARE HEADER.
 - 9- ACCESS SHALL BE PROVIDED.

LEGEND


REFERENCE DRAWING	DRG. No.
Process Flow Diagram	BK-GCS-PEDCO-120-PR-PF-0001
Symbol & Legend For PFD and P&ID	BK-GCS-PEDCO-120-PR-PI-0001

KEY PLAN

D09	AUG.2024	APC	MARTAPAR	M.PAKHARHAN	M.MOHRSHAD	00.00
D08	MAR.2024	IFA	MARTAPAR	M.PAKHARHAN	S.PARAMAKHPOUR	00.00
D07	SEP.2023	IFA	MARTAPAR	M.PAKHARHAN	A.M.MOHRSHAD	00.00
D06	APR.2023	IFA	MARTAPAR	M.PAKHARHAN	M.MOHRSHAD	00.00
D05	DEC.2022	IFA	MARTAPAR	M.PAKHARHAN	M.MOHRSHAD	00.00
D04	AUG.2022	IFA	MARTAPAR	M.PAKHARHAN	M.MOHRSHAD	00.00
D03	JUN.2022	IFA	MARTAPAR	M.PAKHARHAN	M.MOHRSHAD	00.00
D02	MAR.2022	IFA	MARTAPAR	M.PAKHARHAN	M.MOHRSHAD	00.00
D01	JAN.2022	IFA	MARTAPAR	M.PAKHARHAN	M.MOHRSHAD	00.00
D00	SEP.2021	IPC	MARTAPAR	M.PAKHARHAN	M.MOHRSHAD	00.00

PROJECT NAME:		BINAK OILFIELD DEVELOPMENT/SURFACE FACILITIES GAS COMPRESSOR STATION			
PROJECT NO.:		971020			
EPC CONTRACTOR:		EPD/EPC CONTRACTOR (GC):			
 HURGAN ENERGY - DESIGN & INSPECTION COMPANIES		  PEDCO		PETROIRAN DEVELOPMENT COMPANY	
DRAWING TITLE:		P&ID - SLUG CATCHER SYSTEM			
SCALE	SIZE	DRAWING NO.		SHEET NO.	REV.
NS	A3	BK-GCS-PEDCO-120-PR-PI-0004		1 OF 2	D09

BINAK OILFIELD DEVELOPMENT SURFACE FACILITIES GAS COMPRESSOR STATION					
DATE	SCALE	DRAWING BY	CHECKED BY	PROJECT ENG.	
NO CONSTRUCTION PERMITTED UNLESS DRAWING APPROVED					
APPROVED FOR CONSTRUCTION			BY:	DATE:	
BUDGET REF.	SHEET	CLASS	SERIAL NO.	REVISION	
053-073-9184	F	2	A	708782	1 OF 2

 

RATED CAPACITY : 11 m³/hr
DEFF. PRESS. : 14 bar
TRIM LINE : TRM-P-2101-0508-CN05-PT
TRIM LINE : TRM-P-2101-0505-AS00-NF

000	0000000000	00_00	000_0000	00_00	000_0000
REV.	DESCRIPTION	BY	DATE	BY	DATE
		CHECKED		REV. APPR.	



BINAK OILFIELD DEVELOPMENT SURFACE FACILITIES GAS COMPRESSOR STATION				
DATE	SCALE	DRAWING BY	CHECKED BY	PROJECT ENG.

NO CONSTRUCTION PERMITTED UNLESS DRAWING APPROVED						
APPROVED FOR CONSTRUCTION				BY:	DATE:	
BUDGET REF.	LOCATION	SIZE	CLASS	SERIAL NO.	SHEET	REVISION
063-073-9184	F	2	A	708762	2 OF 2	D09