


V-2205
FUEL GAS K.O. DRUM

DIMENSION (ID X TL-TL): 438 X 2950 mm
DESIGN TEMP.: 85 °C
DESIGN PRESS.: FV/9 barg
TRIM LINE: TRM-V-2205-0504-AN07-PT

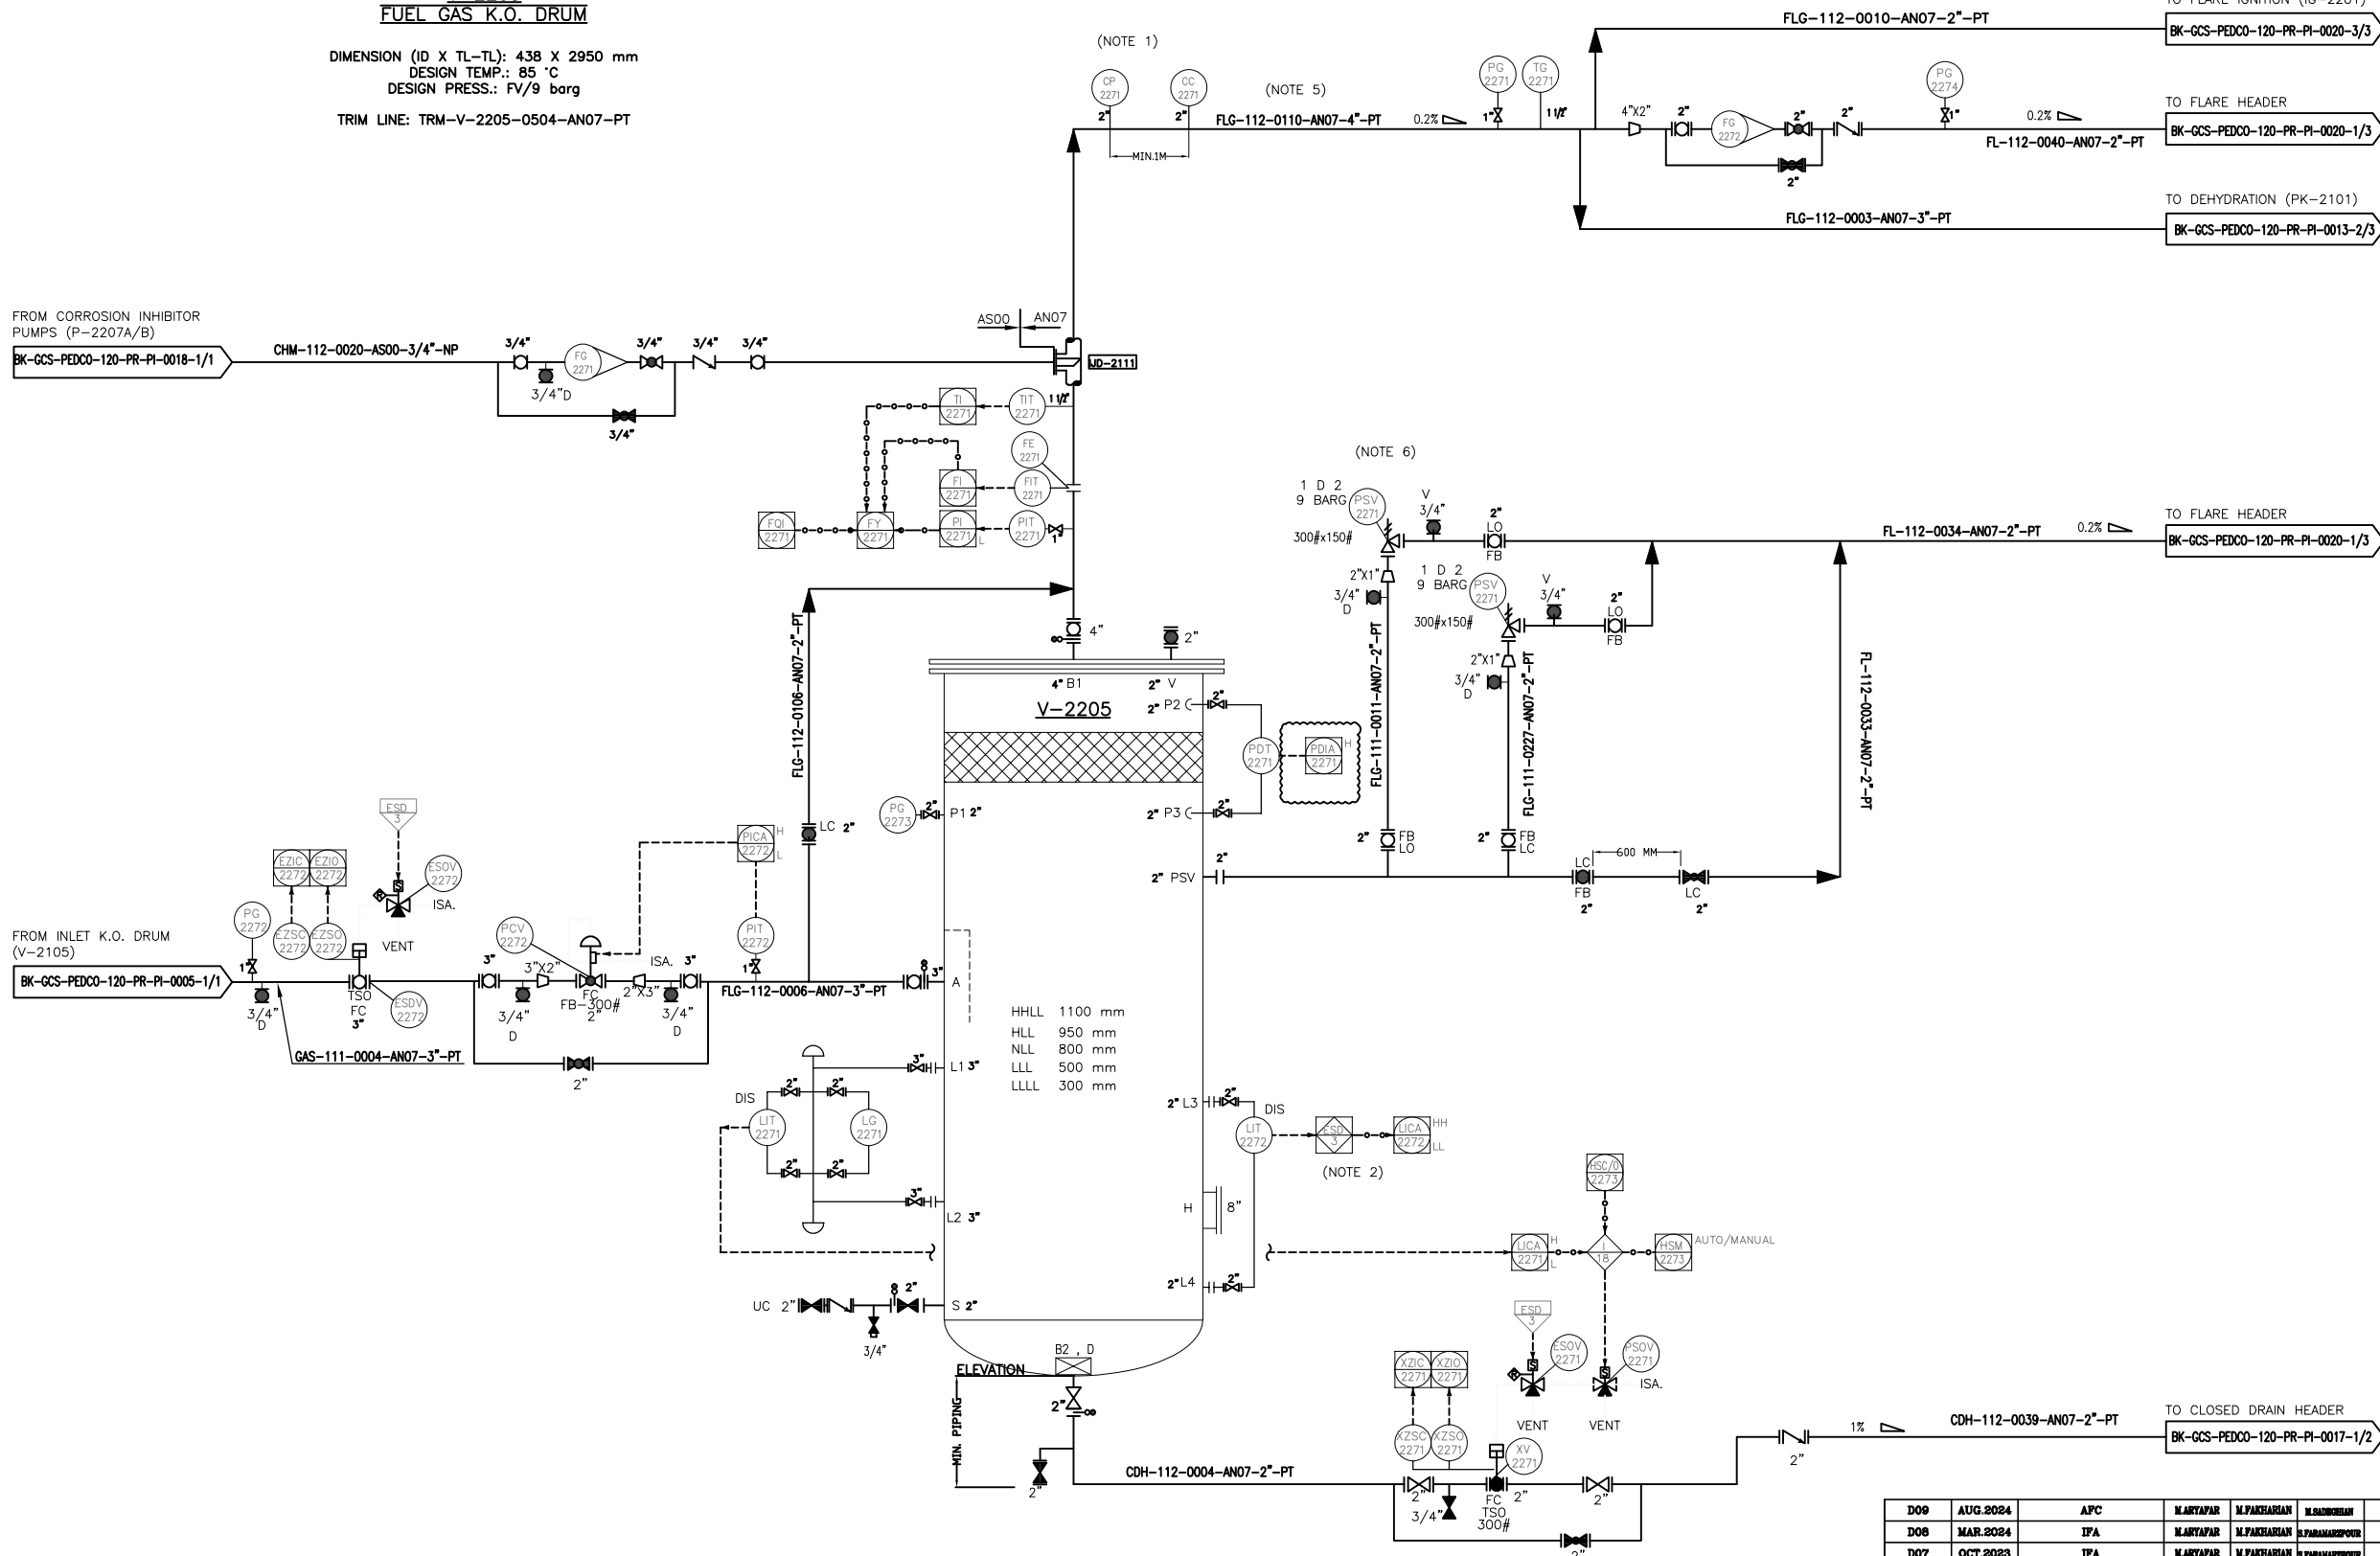

- NOTES**
- 1- ONE PORTABLE METER FOR CORROSION PROBES TO BE PROVIDE PER SITE TO RECOVERY MONITOR CORROSION DATA.
 - 2- ESD LEVEL 3 FOR HH & LL ALARM LIQUID LEVEL.
 - 3- CONTROL VALVE SIZING WILL BE FINALIZED BY VENDOR.
 - 4- PARTIAL STROKE DEVICE TO BE CONSIDERED FOR ALL ESDV'S ACTIVATED BY ESD 1.0.
 - 5- LINE SHALL BE EXPANDED TO MINIMUM 4" FOE CC INSTALLATION.
 - 6- DELETED.
 - 7- ALL DRAIN LINE SHALL BE CONNECTED TO CLOSED DRAIN HEADER AND ALL VENT LINES SHALL BE CONNECTED TO THE FLARE HEADER.

GENERAL NOTE

LEGEND

KEY PLAN

REFERENCE DRAWING	DRG. No.
Utility Flow Diagram	BK-GCS-PEDCO-120-PR-UF-0001
Symbol & Legend For PFD & P&ID	BK-GCS-PEDCO-120-PR-PI-0001

DO9	AUG.2024	APC	MARTAPAR	M.PAKHARIAN	M.MEHRESHAD	00.00
DO8	MAR.2024	IFA	MARTAPAR	M.PAKHARIAN	SPAHAMARPOUR	00.00
DO7	OCT.2023	IFA	MARTAPAR	M.PAKHARIAN	SPAHAMARPOUR	00.00
DO6	APR.2023	IFA	MARTAPAR	M.PAKHARIAN	M.MEHRESHAD	00.00
DO5	DEC.2022	IFA	MARTAPAR	M.PAKHARIAN	M.MEHRESHAD	00.00
DO4	AUG.2022	IFA	MARTAPAR	M.PAKHARIAN	M.MEHRESHAD	00.00
DO3	JUN.2022	IFA	MARTAPAR	M.PAKHARIAN	M.MEHRESHAD	00.00
DO2	FEB.2022	IFA	MARTAPAR	M.PAKHARIAN	M.MEHRESHAD	00.00
DO1	JAN.2022	IFA	MARTAPAR	M.PAKHARIAN	M.MEHRESHAD	00.00
DO0	OCT.2021	IPC	MARTAPAR	M.PAKHARIAN	M.MEHRESHAD	00.00

REV.	DATE	P.O.I.S	PREP.	CHK.	APP.	AUT.
REV.	DATE	P.O.I.S	PREP.	CHK.	APP.	AUT.
SCALE	SIZE	DRAWING NO.	SHEET NO.	REV.	BUDGET REF.	LOCATION	SIZE CLASS	SERIAL NO.	SHEET	REVISION
NS	A3	BK-GCS-PEDCO-120-PR-PI-0022	1 OF 1	DO9	053-073-8194	F	2	A	708800	1 OF 1 DO9

DATE	SCALE	DRAWING BY	CHECKED BY	PROJECT ENG.
DATE	SCALE	DRAWING BY	CHECKED BY	PROJECT ENG.
(VENDOR TITLE BLOCK)**