



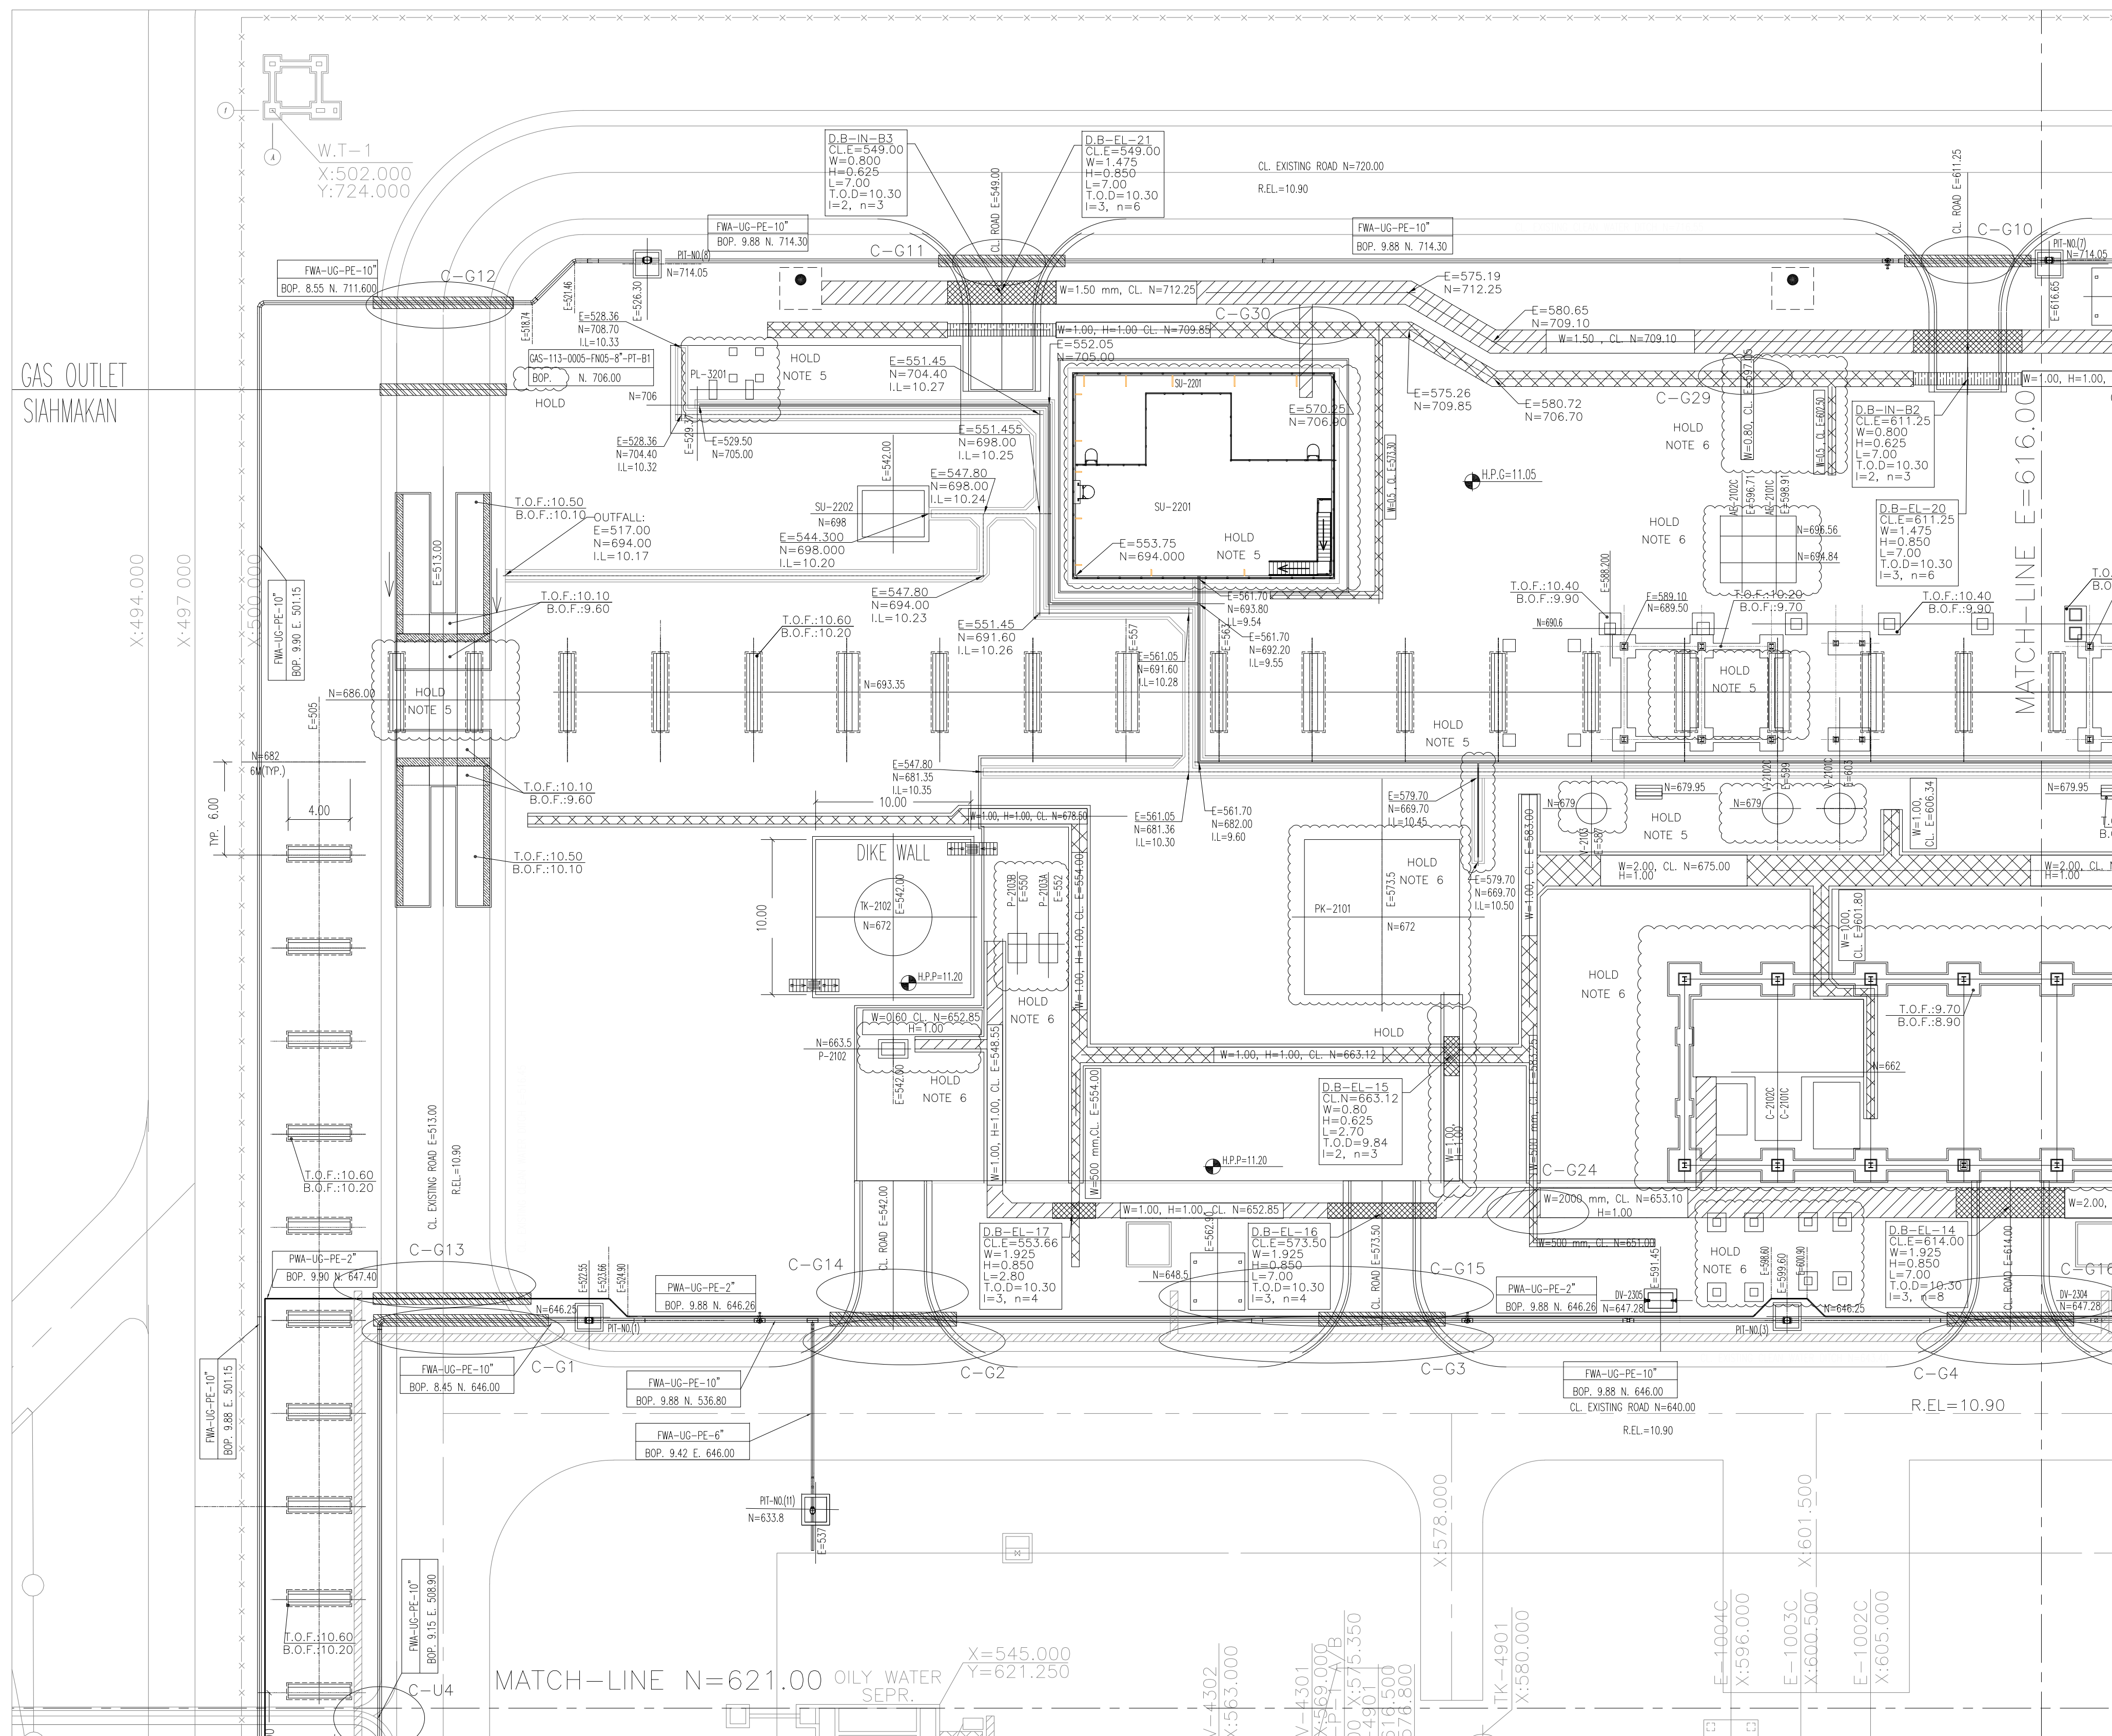


SC.1:250

[illegible]

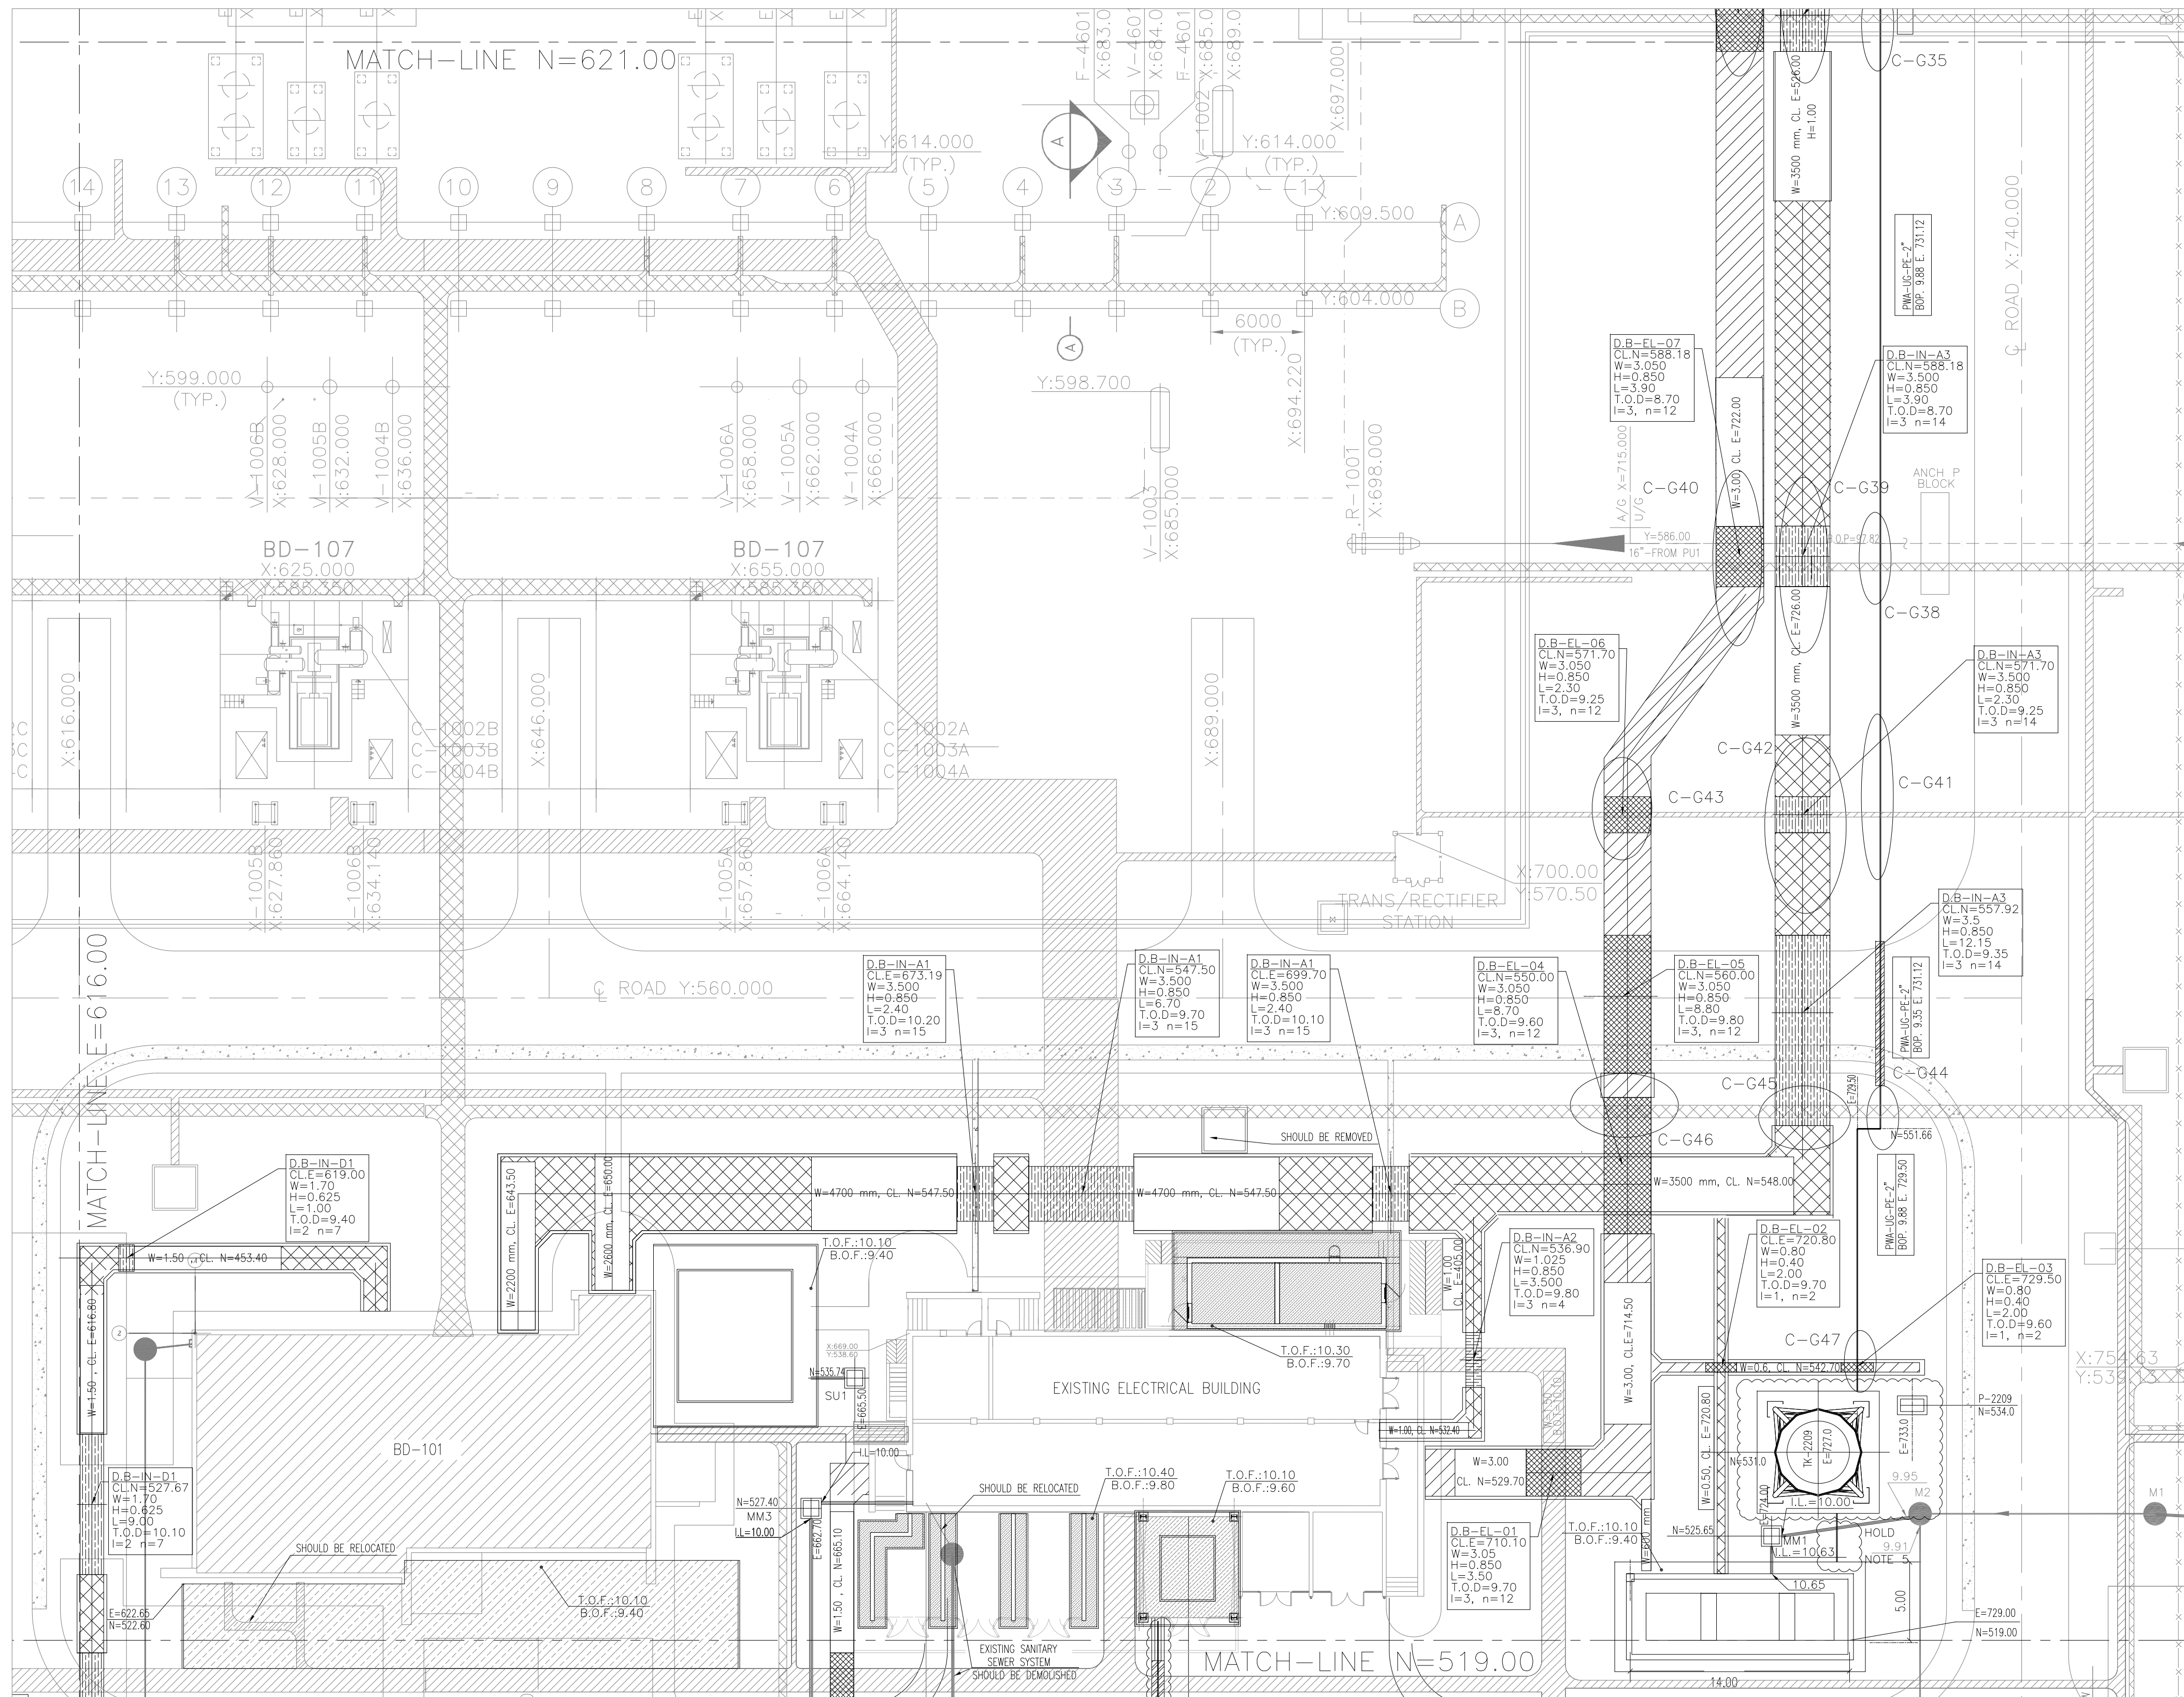



 
SC.1:250

NOTES	
1. ALL COORDINATES AND ELEVATIONS ARE IN METERS.	
2. ALL COORDINATES ARE IN LOCAL SYSTEM., WITH REFERENCE TO SITE LOCAL DATUM POINT.	
LOCAL	UTM
A E=500.000 N=500.000	E=437384.709 N=3289737.469
B1 E=485.337 N=788.941 Z=12.170	E=437245.830 N=3289991.269 ELEV.=12.17
B2 E=798.452 N=382.283 Z=13.410	E=437704.660 N=3289761.280 ELEV.=13.41
3. ALL ELEVATION REFERENCES IS MEAN SEA LEVEL.	
4. ALL DIMENSIONS ARE IN MILLIMETERS UNLESS STATED OTHERWISE.	
5. SHALL BE FINALIZED LATER.	
6. SHALL BE FINALIZED AFTER RECEIVING APPROVED VENDOR DATA	
LEGEND	
 FIRE SHED	 GRAVITY PIPE SLOPE DIRECTION
 DUCT BANK	 NEW PIPE
 BERRIED ELECTRICAL TRENCH	 DELUGE VALVE
 BERRIED INSTRUMENT TRENCH	 BEARING SLAB
 CONCRETE ELECTRICAL TRENCH	 NEW ELECTROLCEL DUCT BANK
 CONCRETE INSTRUMENT TRENCH	 NEW INSTRUMENT DUCT BANK
 EXISTING ELECTRICAL TRENCH	 FOUNDATION
 EXISTING INSTRUMENT TRENCH	 CROSSING POINTS
 MAT FOUNDATION	 SANITARY MANHOLE
 EXISTING LIGHTING FOUNDATION	 VALVE PIT
	 NEW LIGHTING TOWER
	 EXISTING FENCE
	 NEW FENCE
B.O.P B.O.T T.O.D B.O.F H.P.P H.P.G R.E.L	GRA IN EL FWA LIC PE UC D.B F.B D.G
BOTTOM OF PIPE BOTTOM OF TRENCH TOP OF DUCT BANK BOTTOM OF FOUNDATION HIGH POINT OF PAVING HIGH POINT OF GRAVEL ROAD ELEVATION	GRAVITY PIPE INSTRUMENT ELECTRICAL FIRE WATER UNDER GROUND POLYETHYLENE SANITARY PIPE DUCT BANK FINISHED GRADE

REFERENCE DRAWING	DRG. No.
SPECIFICATION FOR ROAD & PAVING	BK-GNRL-PEDCO-000-CV-SP-0002
STANDARD DRAWING FOR ROADS	BK-GNRL-PEDCO-000-CV-DW-0003
STANDARD DRAWING FOR PAVINGS	BK-GNRL-PEDCO-000-CV-DW-0035
UNIT PLOT PLAN DRAWING	BK-GCS-PEDCO-120-PI-PY-0001
ROUGH GRADING PLAN & DETAILS	BK-GCS-PEDCO-120-CV-PY-0007
SHAK NEW COMPRESSOR GAS STATION PLOT PLAN (BASIC PACKAGE)	1560-BK-NCS-PI-DWG-0001
FOUR WALL DRAWING FOR LEAN GLYCOL STORAGE TANK (TK-2102)	BK-GCS-PEDCO-120-ST-DW-0033
POUNDAGE DRAWING FOR GLYCOL SUMP PIT (SU-2101)	BK-GCS-PEDCO-120-ST-DW-0035
AREA ELECTRICAL CABLE ROUTE & SECTION LAYOUT	BK-GCS-PEDCO-120-EL-PY-0005
INSTRUMENT/F&G CABLE TRENCH/ROUTE LAYOUT DRAWING	BK-GCS-PEDCO-120-IN-PY-0004
UG PIPING PLAN	BK-GCS-PEDCO-120-PI-DW-0005
ROAD, PAVING AND PLANT FINISH GRADING LAYOUT & SECTIONS	BK-GCS-PEDCO-120-CV-PY-0005
OIL CONTAMINATED WATER SYSTEM LAYOUT	BK-GCS-PEDCO-120-CV-PY-0003
PLANT CLEAN WATER DRAINAGE SYSTEM LAYOUT & DETAILS	BK-GCS-PEDCO-120-CV-PY-0004
STANDARD DRAWING FOR ELECTRICAL CABLE TRENCH	BK-GNRL-PEDCO-000-CV-DW-0004
STANDARD DRAWING FOR SEWERAGE & DRAINAGE DETAILS	BK-GNRL-PEDCO-000-CV-DW-0007
STANDARD DRAWING FOR CIVIL UNDERGROUND CROSSING	BK-GNRL-PEDCO-000-CV-DW-0006
PIPELINE STANDARD DRAWING FOR COVER SLABS AND SET-ON-WEIGHT	BK-GNRL-PEDCO-000-PL-DW-0013

KEY PLAN

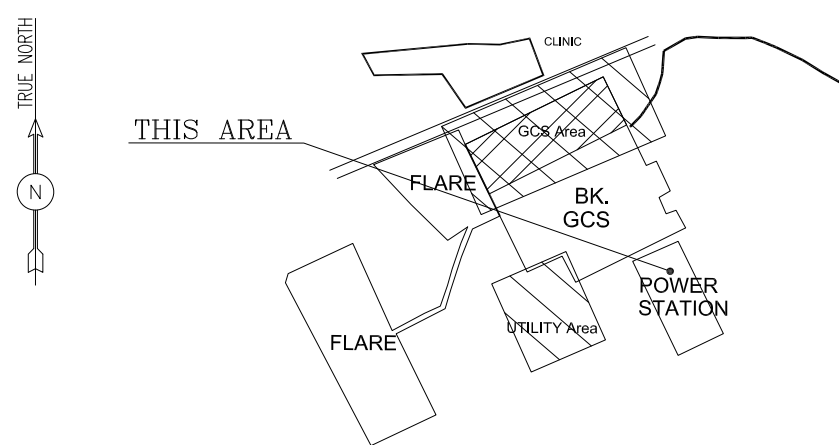
[illegible]

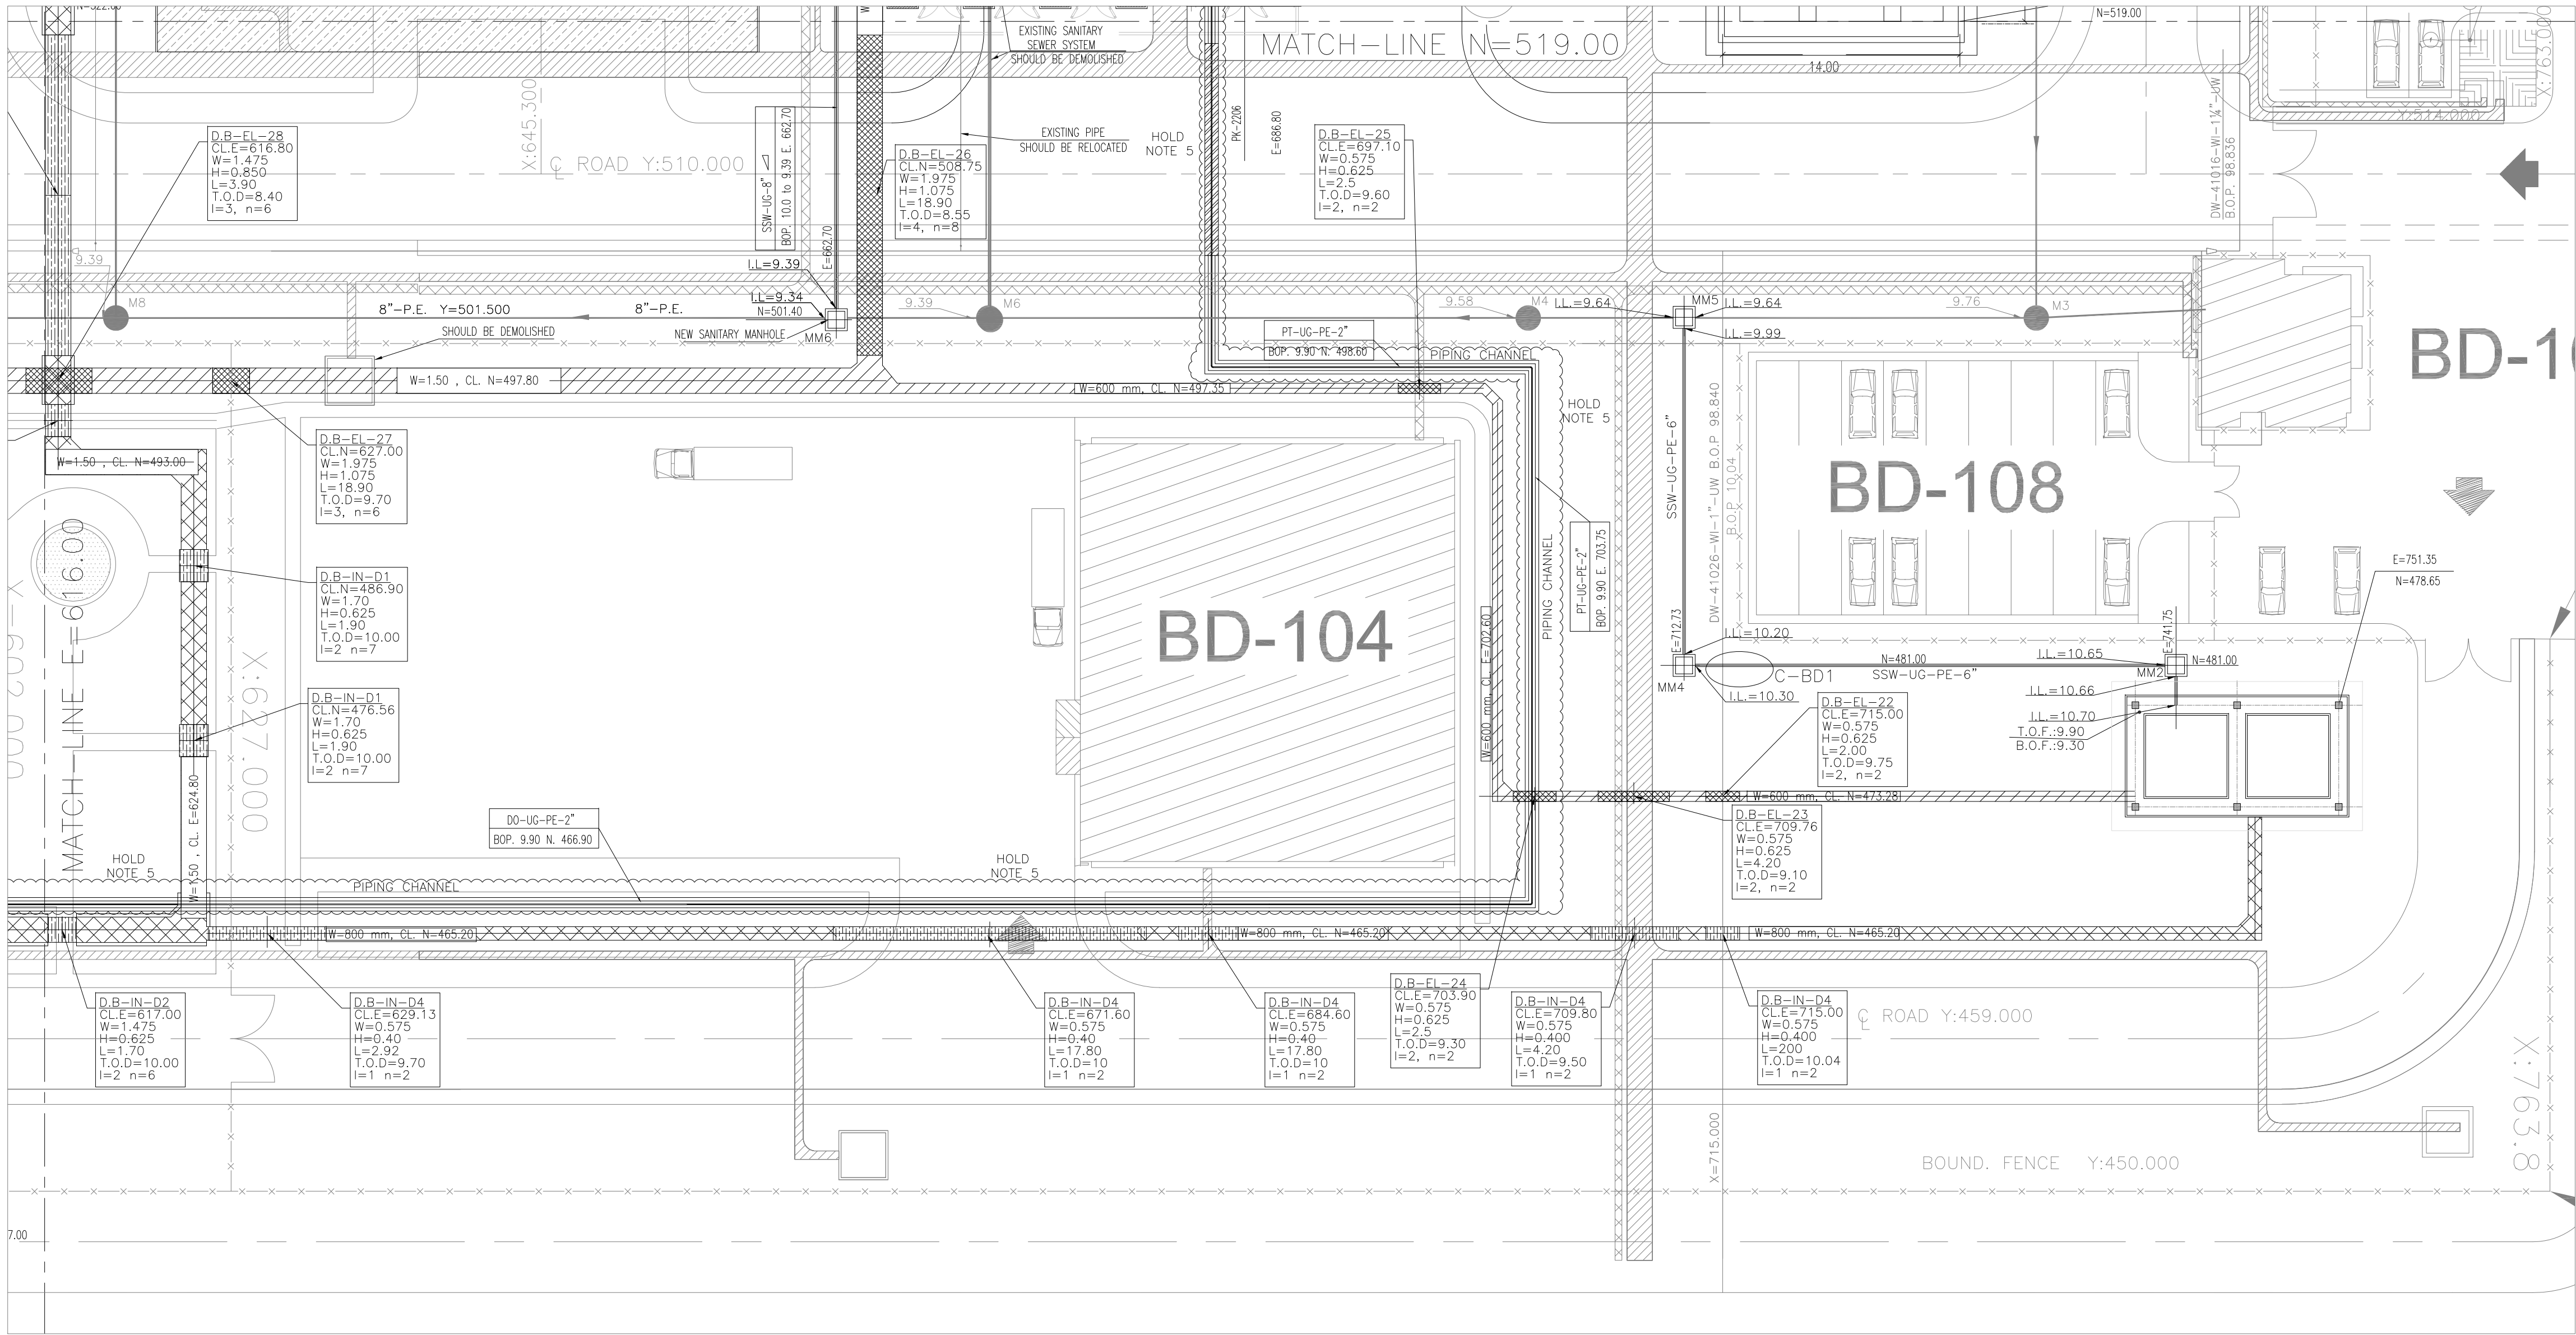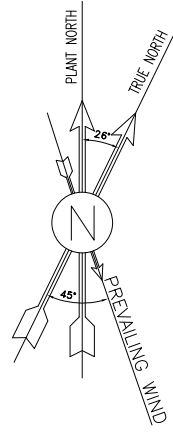

NOTES			
1. ALL COORDINATES AND ELEVATIONS ARE IN METERS.			
2. ALL COORDINATES ARE IN LOCAL SYSTEM., WITH REFERENCE TO SITE LOCAL DATUM POINT.			
	LOCAL	UTM	
A	E=500.000	E=437384.709	
	N=500.000	N=3289737.469	
B1	E=485.337	E=437245.830	
	N=788.941	N=3289991.269	
	Z=12.170	ELEV.=12.17	
B2	E=798.452	E=437704.660	
	N=382.283	N=3289761.280	
	Z=13.410	ELEV.=13.41	
3. ALL ELEVATION REFERENCES IS MEAN SEA LEVEL.			
4. ALL DIMENSIONS ARE IN MILLIMETERS UNLESS STATED OTHERWISE.			
5. SHALL BE FINALIZED LATER.			
6. SHALL BE FINALIZED AFTER RECEIVING APPROVED VENDOR DATA			

LEGEND			
	FIRE SHED		GRAVITY PIPE SLOPE DIRECTION
	DUCT BANK		NEW PIPE
	DELUGE VALVE		BEARING SLAB
	BERRIED ELECTRICAL TRENCH		NEW ELECTRICAL DUCT BANK
	BERRIED INSTRUMENT TRENCH		NEW INSTRUMENT DUCT BANK
	CONCRETE ELECTRICAL TRENCH		FOUNDATION
	CONCRETE INSTRUMENT TRENCH		CROSSING POINTS
	EXISTING ELECTRICAL TRENCH		SANITARY MANHOLE
	EXISTING INSTRUMENT TRENCH		VALVE PIT
	MAT FOUNDATION		NEW LIGHTING TOWER
	EXISTING LIGHTING FOUNDATION		EXISTING FENCE
	NEW FENCE		GRAVITY PIPE INSTRUMENT ELECTRICAL FIRE WATER UNDER GROUND POLYETHYLENE SANITARY PIPE DUCT BANK FINISHED GRADE
B.O.P	BOTTOM OF PIPE	GRA	GRAVITY PIPE
B.O.T	BOTTOM OF TRENCH	IN	INSTRUMENT
T.O.D	TOP OF DUCT BANK	EL	ELECTRICAL
B.O.F	BOTTOM OF FOUNDATION	FWA	FIRE WATER
H.P.P	HIGH POINT OF PAVING	UG	UNDER GROUND
H.P.G	HIGH POINT OF GRAVEL	PE	POLYETHYLENE
REL	ROAD ELEVATION	SA	SANITARY PIPE
		D.B	DUCT BANK
		F.G	FINISHED GRADE



REFERENCE DRAWING	DRG. No.
SPECIFICATION FOR ROAD & PAVING	BK-GNRL-PEDCO-000-CV-SP-0002
STANDARD DRAWING FOR ROADS	BK-GNRL-PEDCO-000-CV-DW-0003
STANDARD DRAWING FOR PAVINGS	BK-GNRL-PEDCO-000-CV-DW-0035
UNIT PLOT PLAN DRAWING	BK-GCS-PEDCO-120-PI-PY-0001
ROUGH GRADING PLAN & DETAILS	BK-GCS-PEDCO-120-CV-PY-0007
BINAK NEW COMPRESSOR GAS STATION PLOT PLAN (BASIC PACKAGE)	1560-BK-KCS-PI-DWG-0001
DIRE WALL DRAWING FOR LEAN GLYCOL STORAGE TANK (TK-2102)	BK-GCS-PEDCO-120-ST-DW-0033
FOUNDATION DRAWING FOR GLYCOL SUMP PIT (SU-2101)	BK-GCS-PEDCO-120-ST-DW-0035
AREA ELECTRICAL CABLE ROUTE & SECTION LAYOUT	BK-GCS-PEDCO-120-EL-PY-0005
INSTRUMENT/F&G CABLE TRENCH/ROUTE LAYOUT DRAWING	BK-GCS-PEDCO-120-IN-PY-0004
UG PIPING PLAN	BK-GCS-PEDCO-120-PI-DW-0005
ROAD, PAVING AND PLANT FINISH GRADING LAYOUT & SECTIONS	BK-GCS-PEDCO-120-CV-PY-0005
OIL CONTAMINATED WATER SYSTEM LAYOUT	BK-GCS-PEDCO-120-CV-PY-0003
PLANT CLEAN WATER DRAINAGE SYSTEM LAYOUT & DETAILS	BK-GCS-PEDCO-120-CV-PY-0004
STANDARD DRAWING FOR ELECTRICAL CABLE TRENCH	BK-GNRL-PEDCO-000-CV-DW-0004
STANDARD DRAWING FOR SEWERAGE & DRAINAGE DETAILS	BK-GNRL-PEDCO-000-CV-DW-0007
STANDARD DRAWING FOR CIVIL UNDERGROUND CROSSING	BK-GNRL-PEDCO-000-CV-DW-0008
PIPELINE STANDARD DRAWING FOR COVER SLABS AND SET-ON-WEIGHT	BK-GNRL-PEDCO-000-PL-DW-0013

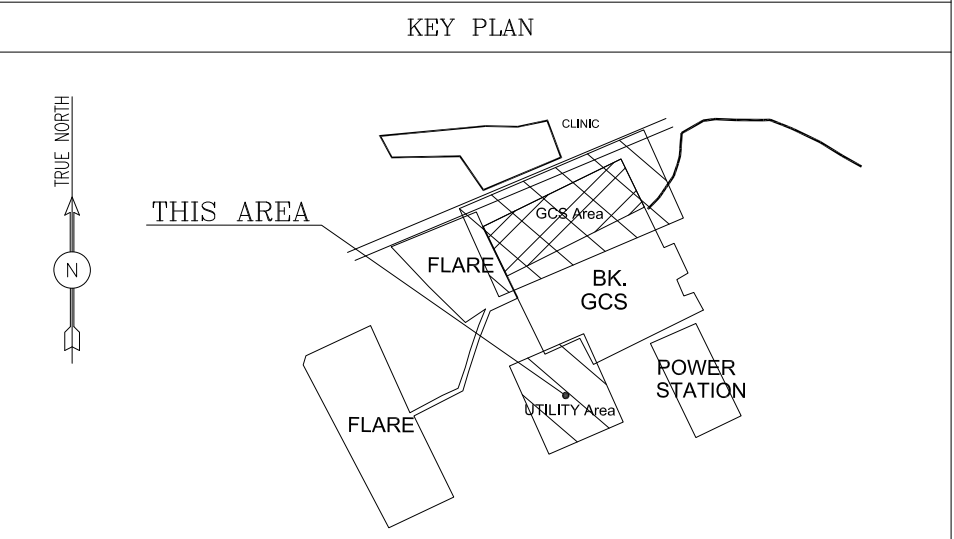

NEW CCTV ROOM

SC.1:250

D03	NOV.2024	IPA	R.BERLOUIE	M.PAKHARIAN	M.SADIGHIAN	***							
D02	FEB.2024	IPA	R.BERLOUIE	M.PAKHARIAN	S.PARAMARZPOUR	***	***	*****	***	***	*****		
D01	OCT.2023	IPC	R.BERLOUIE	M.PAKHARIAN	S.PARAMARZPOUR	***	REV.	DESCRIPTION	BY	DATE	BY	DATE	
D00	FEB.2023	IPC	M.ASHGHARIZAD	M.PAKHARIAN	SH.GHALIKAR	***			CHECKED		REV. APPR.		
REV.	DATE	P.O.I.S	PREP.	CHK.	APP.	AUT.	اصل و کلیه نسخ این نقشه و هر اقتباس متعلق به شرکت ملی مناطق نفت خیز جنوب می باشد.						
PROJECT NAME:			BINAK OILFIELD DEVELOPMENT GENERAL					THE ORIGINAL AND ALL COPIES OF THIS DRAWING TOGETHER WITH THE COPYRIGHT THEREIN ARE THE SOLE PROPERTY OF N.I.S.O.C./ FIELDS					
PROJECT NO.:			971020										
EPC CONTRACTOR:			EPD/EPC CONTRACTOR (GC):				BINAK OILFIELD DEVELOPMENT GENERAL						
 			 PETROIRAN DEVELOPMENT COMPANY										
HIRGAN ENERGY – DESIGN & INSPECTION COMPANIES			PEDCO										
							DATE	SCALE	DRAWING BY	CHECKED BY	PROJECT ENG.		
DRAWING TITLE:							NO CONSTRUCTION PERMITTED UNLESS DRAWING APPROVED						
PLANT UNDERGROUND COMPOSITE LAYOUT							APPROVED FOR CONSTRUCTION					BY:	DATE:
SCALE	SIZE	DRAWING NO.			SHEET NO.	REV.	BUDGET REF.	LOCATION	SIZE	CLASS	SERIAL NO.	SHEET	REVISION
1/250	A1	BK-GCS-PEDCO-120-CV-PY-0006			04 OF 06	D03	053-073-9184	F	4	S	709113	4	D03

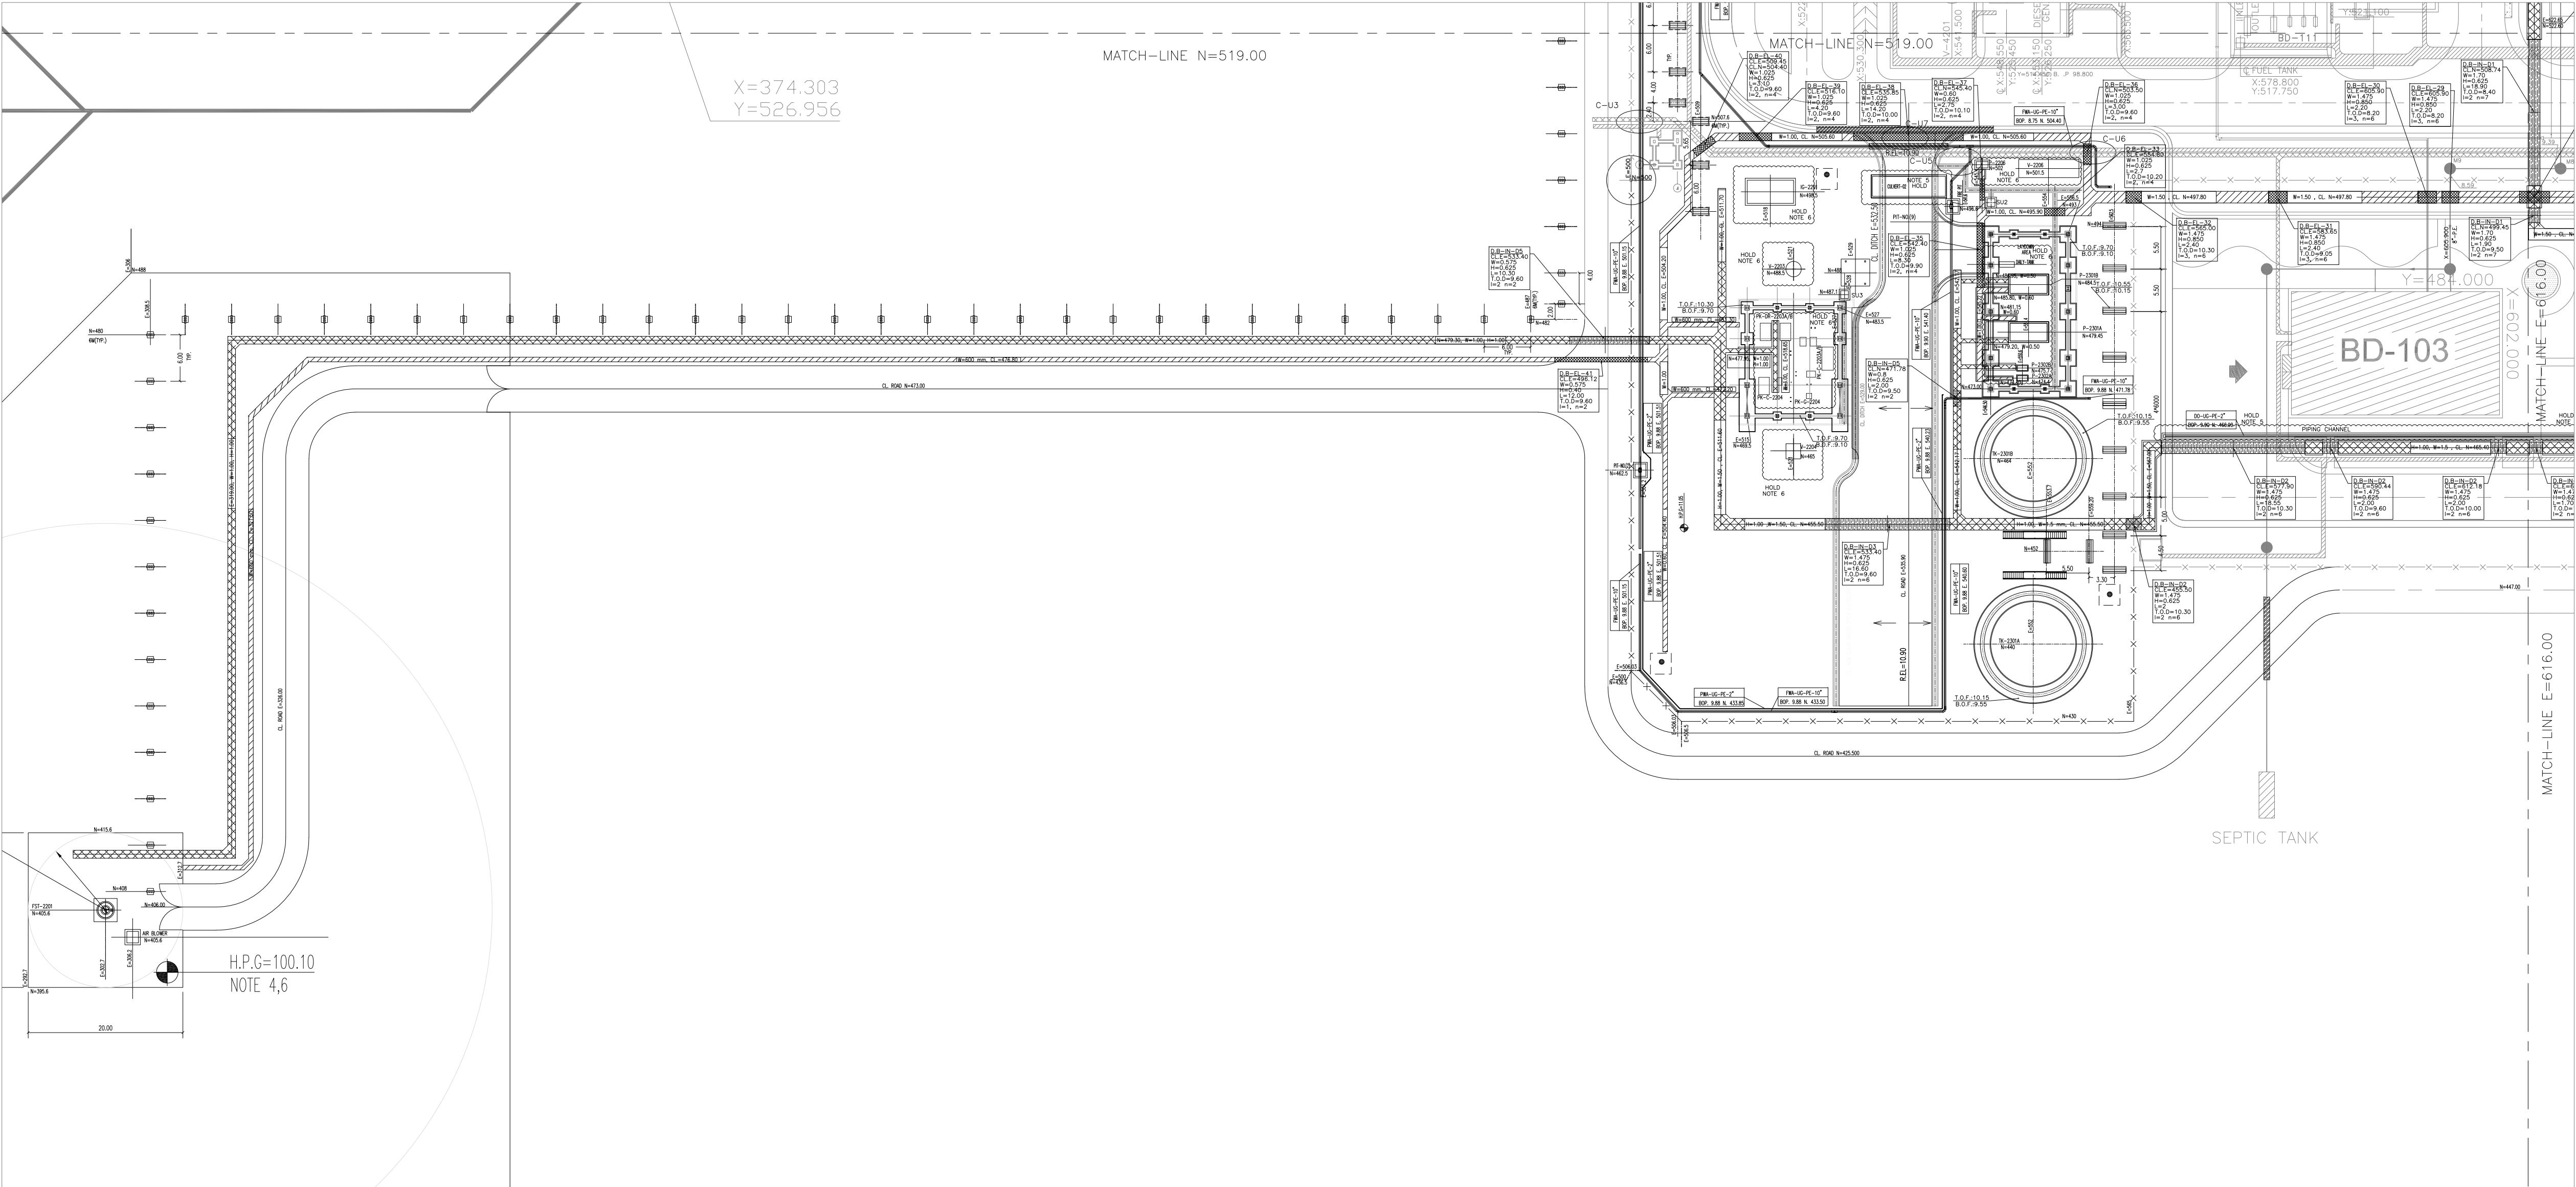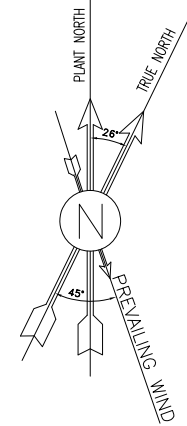

UTILITY AREA
SC.1:250

- NOTES
1. ALL COORDINATES AND ELEVATIONS ARE IN METERS.
 2. ALL COORDINATES ARE IN LOCAL SYSTEM., WITH REFERENCE TO SITE LOCAL DATUM POINT.
- | | LOCAL | UTM |
|--------------|---------------|-----|
| E=500.000 | E=437384.709 | |
| A N=500.000 | N=3289737.469 | |
| E=485.337 | E=437245.830 | |
| B1 N=788.941 | N=3289991.269 | |
| Z=12.170 | ELEV.=12.17 | |
| E=798.452 | E=437704.660 | |
| B2 N=382.283 | N=3289761.280 | |
| Z=13.410 | ELEV.=13.41 | |
3. ALL ELEVATION REFERENCES IS MEAN SEA LEVEL.
 4. ALL DIMENSIONS ARE IN MILLIMETERS UNLESS STATED OTHERWISE.
 5. SHALL BE FINALIZED LATER.
 6. SHALL BE FINALIZED AFTER RECEIVING APPROVED VENDOR DATA


LEGEND

B.O.P	GRA	GRA	GRA
B.O.T	EL	EL	EL
T.O.D	FWA	FWA	FWA
B.O.F	UG	UG	UG
H.P.P	PE	PE	PE
H.P.G	SA	SA	SA
REL	D.B	D.B	D.B
	F.G	F.G	F.G

BOTTOM OF PIPE
BOTTOM OF TRENCH
TOP OF DUCT BANK
BOTTOM OF FOUNDATION
HIGH POINT OF PAVING
HIGH POINT OF GRAVEL
ROAD ELEVATION

GRAVITY PIPE
INSTRUMENT
ELECTRICAL
FIRE WATER
UNDER GROUND
POLYETHYLENE
SANITARY PIPE
DUCT BANK
FINISHED GRADE

REFERENCE DRAWING	DRG. No.
SPECIFICATION FOR ROAD & PAVING	BK-GNRL-PEDCO-000-CV-SP-0002
STANDARD DRAWING FOR ROADS	BK-GNRL-PEDCO-000-CV-DW-0003
STANDARD DRAWING FOR PAVINGS	BK-GNRL-PEDCO-000-CV-DW-0035
UNIT PLOT PLAN DRAWING	BK-GCS-PEDCO-120-PI-PY-0001
ROUGH GRADING PLAN & DETAILS	BK-GCS-PEDCO-120-CV-PY-0007
BINAK NEW COMPRESSOR GAS STATION PLOT PLAN (BASIC PACKAGE)	1560-BK-NCS-PI-DWG-0001
DIKE WALL DRAWING FOR LEAN GLYCOL STORAGE TANK (TK-2102)	BK-GCS-PEDCO-120-ST-DW-0033
FOUNDATION DRAWING FOR GLYCOL SUMP PIT (SU-2101)	BK-GCS-PEDCO-120-ST-DW-0035
AREA ELECTRICAL CABLE ROUTE & SECTION LAYOUT	BK-GCS-PEDCO-120-EL-PY-0005
INSTRUMENT/F&G CABLE TRENCH/ROUTE LAYOUT DRAWING	BK-GCS-PEDCO-120-IN-PY-0004
UG PIPING PLAN	BK-GCS-PEDCO-120-PI-DW-0005
ROAD, PAVING AND PLANT FINISH GRADING LAYOUT & SECTIONS	BK-GCS-PEDCO-120-CV-PY-0005
OIL CONTAMINATED WATER SYSTEM LAYOUT	BK-GCS-PEDCO-120-CV-PY-0003
PLANT CLEAN WATER DRAINAGE SYSTEM LAYOUT & DETAILS	BK-GCS-PEDCO-120-CV-PY-0004
STANDARD DRAWING FOR ELECTRICAL CABLE TRENCH	BK-GNRL-PEDCO-000-CV-DW-0004
STANDARD DRAWING FOR SEWERAGE & DRAINAGE DETAILS	BK-GNRL-PEDCO-000-CV-DW-0007
STANDARD DRAWING FOR CIVIL UNDERGROUND CROSSING	BK-GNRL-PEDCO-000-CV-DW-0008
PIPELINE STANDARD DRAWING FOR COVER SLABS AND SET-ON-WEIGHT	BK-GNRL-PEDCO-000-PL-DW-0013

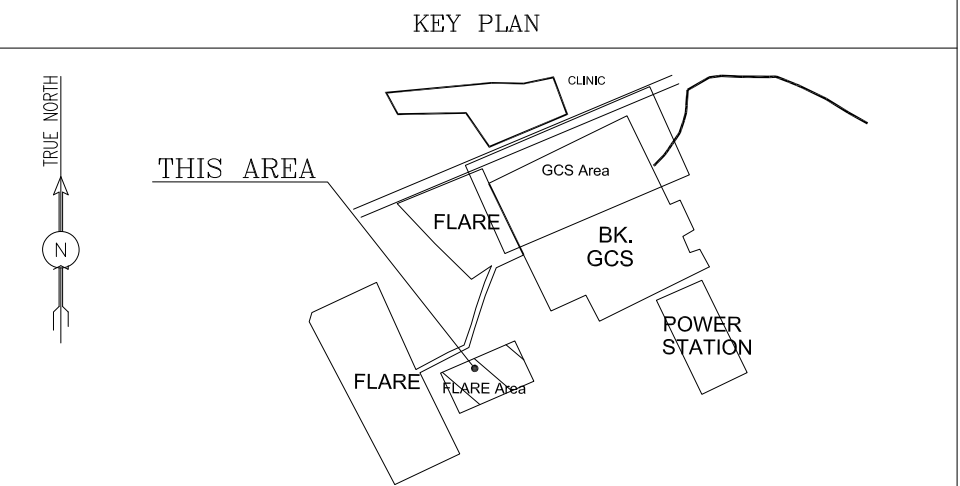

D03	NOV. 2024	IPA	R.BERLOUIE	M.PAKHARIAN	M.SADIGHIAN	***							
D02	FEB. 2024	IPA	R.BERLOUIE	M.PAKHARIAN	S.PARAMARZPOUR	***	***	*****	***	*****	***	*****	
D01	OCT. 2023	IPC	R.BERLOUIE	M.PAKHARIAN	S.PARAMARZPOUR	***	REV.	DESCRIPTION	BY	DATE	BY	DATE	
D00	FEB. 2023	IPC	M.ASHGARNEJAD	M.PAKHARIAN	SH.GHALIKAR	***			CHECKED		REV. APPR.		
REV.	DATE	P.O.I.S	PREP.	CHK.	APP.	AUT.	اصل و کلیه نسخ این نقشه و حق اقتباس متعلق به شرکت ملی مناطق نفت خیز جنوب میباشد.						
PROJECT NAME:			BINAK OILFIELD DEVELOPMENT GENERAL			 THE ORIGINAL AND ALL COPIES OF THIS DRAWING TOGETHER WITH THE COPYRIGHT THEREIN ARE THE SOLE PROPERTY OF N.I.S.O.C./ FIELDS							
PROJECT NO.:			971020										
EPC CONTRACTOR:			EPD/EPC CONTRACTOR (GC):			BINAK OILFIELD DEVELOPMENT GENERAL							
  HIRGAN ENERGY – DESIGN & INSPECTION COMPANIES			 PEDCO			PETROIRAN DEVELOPMENT COMPANY							
						DATE		SCALE	DRAWING BY	CHECKED BY	PROJECT ENG.		
DRAWING TITLE:						NO CONSTRUCTION PERMITTED UNLESS DRAWING APPROVED							
PLANT UNDERGROUND COMPOSITE LAYOUT						APPROVED FOR CONSTRUCTION		BY:		DATE:			
SCALE	SIZE	DRAWING NO.			SHEET NO.	REV.	BUDGET REF.	LOCATION	SIZE	CLASS	SERIAL NO.	SHEET	REVISION
1/250	A1	BK-GCS-PEDCO-120-CV-PY-0006			05 OF 06	D03	053-073-9184	F	4	S	709113	5	D03

No.	Crossing	F.G EL	NEW PIPE		NEW PIPE		ELE. TRENCH or ELE. Duct Bank			INS. TRENCH or INS.Duct Bank			CIVIL TRENCH			EXISTING PIPE			EXISTING PIPE			CIVIL TRENCH			ELE. TRENCH or ELE. Duct Ban			FOUNDATION			
			B.O.P	T.O.P	B.O.P	T.O.P	TOP	BOTTOM	TYPE	TOP	BOTTOM	TYPE	TOP	BOTTOM	TYPE	B.O.P	T.O.P	TYPE	B.O.P	T.O.P	TYPE	TOP	BOTTOM	TYPE	TOP	BOTTOM	TYPE	B.O.F	T.O.F		
1	C-U1	10.9	9.9	10.15	9.9	9.95	-	-	-	-	-	-	-	-	-	9.18	9.38	EXIST	-	-	-	-	-	-	-	-	-	-	-		
2	C-U2	10.9	9.9	10.15	-	-	-	-	-	-	-	-	-	-	-	9.18	9.38	EXIST	-	-	-	-	-	-	-	-	-	-	-		
3	C-U3	10.9	9.9	10.15	9.9	9.95	10.5	10.05	EXIST	10.05	9.8	EXIST	-	-	-	-	-	-	-	-	-	-	-	-	-	-	-	-	-		
6	C-U4	10.9	9.15	9.35	-	-	-	-	-	-	-	-	FG	9.65	EXIST	-	-	-	-	-	-	-	-	-	-	-	-	-	-		
8	C-U5	10.95	8.75	9	-	-	-	-	-	-	9.55	9.3	EXIST	FG	10.5	New	-	-	-	-	-	-	-	9.55	9.3	EXIST	-	-	-		
11	C-U6	11	8.75	9	-	-	-	-	-	-	9.55	9.3	Exist	-	-	-	-	-	-	-	-	-	-	9.55	9.3	Exist	-	-	-		
12	C-U7	10.9	9.4	9.7	-	-	-	-	-	-	-	-	-	FG	10.05	New	-	-	-	-	-	-	FG	9.9	NEW	-	-	-	-		
13	C-G1	10.9	9.9	10.15	-	-	-	-	-	-	-	-	-	FG	9.7	Exist	-	-	-	-	-	-	FG	9.74	Exist	9.55	9.2	Exist	-	-	
14	C-G2	10.9	9.9	10.15	-	-	-	-	-	-	-	-	-	10.84	10.4	New	-	-	-	-	-	-	10.84	10.4	New	-	-	-	-	-	
15	C-G3	10.9	9.9	10.15	-	-	-	-	-	-	-	-	-	10.84	10.4	New	-	-	-	-	-	-	10.84	10.4	New	10.5	10.25	Exist	-	-	
16	C-G4	10.9	9.9	10.15	-	-	-	-	-	-	-	-	-	10.84	10.4	New	-	-	-	-	-	-	10.84	10.4	New	10.5	10.25	Exist	-	-	
17	C-G5	10.9	9.9	10.15	-	-	-	-	-	-	-	-	-	10.84	10.4	New	-	-	-	-	-	-	10.84	10.4	New	-	-	-	-	-	
18	C-G6	10.9	9.9	10.15	-	-	-	-	-	-	-	-	-	10.84	10.4	New	-	-	-	-	-	-	10.84	10.4	New	10.5	10.25	Exist	-	-	
19	C-G7	10.9	9.9	10.15	-	-	9.6	8.525	New	9.6	8.525	New	-	-	-	-	-	-	-	-	-	-	-	-	-	10.5	10.25	Exist	-	-	
20	C-G8	10.9	9.9	10.15	9.3	9.35	-	-	-	-	-	-	-	-	-	-	-	-	-	-	-	11.05	10.46	Exist	10.02	9.7	Exist	-	-		
21	C-G9	10.9	9.9	10.15	-	-	-	-	-	-	-	-	-	10.84	10.4	New	-	-	-	-	-	-	10.84	10.4	New	-	-	-	-	-	
22	C-G10	10.9	9.9	10.15	-	-	-	-	-	-	-	-	-	10.84	10.4	New	-	-	-	-	-	-	10.84	10.4	New	-	-	-	-	-	
23	C-G11	10.9	9.9	10.15	-	-	-	-	-	-	-	-	-	10.84	10.4	New	-	-	-	-	-	-	10.84	10.4	New	-	-	-	-	-	
24	C-G12	10.9	9.9	10.15	-	-	-	-	-	-	-	-	-	11.05	9.93	Exist	-	-	-	-	-	-	11.05	9.96	Exist	-	-	-	-	-	
25	C-G13	10.9	-	-	9.9	9.95	-	-	-	-	-	-	-	FG	9.7	Exist	-	-	-	-	-	-	FG	9.74	Exist	9.55	9.2	Exist	-	-	
26	C-G14	10.9	-	-	9.9	9.95	-	-	-	-	-	-	-	10.84	10.4	New	-	-	-	-	-	-	-	-	-	-	-	-	-	-	
27	C-G15	10.9	-	-	9.9	9.95	-	-	-	-	-	-	-	10.84	10.4	New	-	-	-	-	-	-	-	New	-	-	10.5	10.25	Exist	-	-
28	C-G16	10.9	-	-	9.9	9.95	-	-	-	-	-	-	-	10.84	10.4	New	-	-	-	-	-	-	-	-	-	10.5	10.25	Exist	-	-	
29	C-G17	10.9	-	-	9.9	9.95	-	-	-	-	-	-	-	10.84	10.4	New	-	-	-	-	-	-	-	-	-	-	-	-	-	-	
30	C-G18	10.9	-	-	9.9	9.95	-	-	-	-	-	-	-	10.84	10.4	New	-	-	-	-	-	-	-	-	-	10.5	10.25	Exist	-	-	
31	C-G19	10.9	-	-	9.9	9.95	9.6	8.525	New	9.6	8.525	New	-	-	-	-	-	-	-	-	-	-	-	-	-	9.4	8.325	Exist	-	-	
33	C-G20	10.9	9.88	10.13	-	-	-	-	-	-	-	-	-	10.84	10.4	New	-	-	-	-	-	-	10.84	10.4	New	-	-	-	-	-	
35	C-G21	11.2	-	-	-	-	-	-	-	-	-	-	-	-	-	-	-	-	-	-	-	-	-	-	-	-	-	-	-	9.6	
36	C-G22	11.2	-	-	-	-	-	-	-	-	-	-	-	-	-	-	-	-	-	-	-	-	-	-	-	-	-	-	-	9.6	
37	C-G23	11.2	-	-	-	-	-	-	-	-	-	-	-	-	-	-	-	-	-	-	-	-	-	-	-	-	-	-	-	9.6	
38	C-G24	10.97	-	-	-	-	9.7	9.2	NEW	FG	10	NEW	-	-	-	-	-	-	-	-	-	-	-	-	-	-	-	-	-	-	
40	C-G25	10.95	-	-	-	-	9.65	9.15	NEW	FG	9.95	NEW	-	-	-	-	-	-	-	-	-	-	-	-	-	-	-	-	-	-	
42	C-G26	10.95	-	-	-	-	9.65	9.15	NEW	FG	9.95	NEW	-	-	-	-	-	-	-	-	-	-	-	-	-	-	-	-	-	-	
43	C-G27	10.95	-	-	-	-	9.65	9.15	NEW	FG	9.95	NEW	-	-	-	-	-	-	-	-	-	-	-	-	-	-	-	-	-	-	
44	C-G28	10.95	-	-	-	-	9.65	9.15	NEW	FG	9.95	NEW	-	-	-	-	-	-	-	-	-	-	-	-	-	-	-	-	-	-	
45	C-G29	10.95	-	-	-	-	9.65	9.15	NEW	FG	9.95	NEW	-	-	-	-	-	-	-	-	-	-	-	-	-	-	-	-	-	-	
45	C-G30	10.95	-	-	-	-	9.5	-	NEW	FG	9.95	NEW	-	-	-	-	-	-	-	-	-	-	-	-	-	-	-	-	-	-	
47	C-G31	11.13	-	-	-	-	10.35	9.73	NEW	-	-	-	11.13	10.45	NEW	-	-	-	-	-	-	-	-	-	-	-	-	-	-	9.6	
48	C-G32	11.13	-	-	-	-	10.35	9.73	NEW	-	-	-	11.13	10.5	NEW	-	-	-	-	-	-	-	-	-	-	-	-	-	-	9.6	
49	C-G33	11.13	-	-	-	-	10.35	9.73	NEW	-	-	-	11.13	10.55	NEW	-	-	-	-	-	-	-	-	-	-	-	-	-	-	9.6	
50	C-G34	11	-	-	-	-	9.7	9.2	NEW	FG	10	NEW	-	-	-	-	-	-	-	-	-	-	-	-	-	-	-	-	-	-	
51	C-G35	10.9	-	-	9.9	9.95	-	-	-	-	-	-	-	-	-	10.2	10	EXIST	9.28	9.18	EXIST	-	-	-	10.03	9.63	EXIST	-	-	-	
52	C-G36	10.9	-	-	-	-	-	-	-	9.1	-	NEW	-	-	-	10.2	10	EXIST	9.28	9.18	EXIST	-	-	-	10.03	9.63	EXIST	-	-	-	
53	C-G37	10.9	-	-	-	-	9.1	-	NEW	-	-	-	-	-	-	10.2	10	EXIST	9.28	9.18	EXIST	-	-	-	10.03	9.63	EXIST	-	-	-	
54	C-G38	10.87	-	-	9.9	9.95	-	-	-	-	-	-	-	-	-	9.42	9.02	EXIST	-	-	-	-	-	-	10.03	9.63	EXIST	-	-	-	
55	C-G39	10.87	-	-	-	-	-	-	-	8.9	-	NEW	-	-	-	9.42	9.02	EXIST	-	-	-	-	-	-	10.03	9.63	EXIST	-	-	-	
56	C-G40	10.87	-	-	-	-	8.9	-	NEW	-	-	-	-	-	-	9.42	9.02	EXIST	-	-	-	-	-	-	10.03	9.63	EXIST	-	-	-	
57	C-G41	10.9	-	-	9.9	9.95	-	-	-	-	-	-	-	-	-	-	-	-	-	-	-	-	-	10.8	10.55	EXIST	-	-	-		
58	C-G42	10.9	-	-	-	-	-	-	-	10.25	FG	NEW	-	-	-	-	-	-	-	-	-	-	-	10.8	10.55	EXIST	-	-	-		
59	C-G43	10.9	-	-	-	-	10.25	FG	NEW	-	-	-	-	-	-	-	-	-	-	-	-	-	-	10.8	10.55	EXIST	-	-	-		
60	C-G44	10.9	-	-	9.35	9.4	-	-	-	-	-	-	FG	10.2	EXIST	-	-	-	-	-	-	-	-	10.05	9.65	EXIST	-	-	-		
61	C-G45	10.9	-	-	-	-	9.55	FG	NEW	-	-	-	-	FG	10.2	EXIST	-	-	-	-	-	-	-	10.05	9.65	EXIST	-	-	-		
62	C-G46	10.9	-	-	-	-	-	-	-	9.55	FG	NEW	FG	10.2	EXIST	-	-	-	-	-	-	-	-	10.05	9.65	EXIST	-	-	-		
63	C-G47	10.9	-	-	9.9	9.95	9.3	8.8	NEW	-	-	-	-	-	-	-	-	-	-	-	-	-	-	-	-	-	-	-	-		
64	C-BD1	10.8	-	-	10.63	10.65										9.8	FG														
65	C-BD2	10.8	-	-	10.52	10.67										9.64	9.66	EXIST													
66	C-BD3	10.8	-	-	10.19	10.34										9.8	FG	EXIST													

NOTES

1. ALL COORDINATES AND ELEVATIONS ARE IN METERS.

2. ALL COORDINATES ARE IN LOCAL SYSTEM., WITH REFERENCE TO SITE LOCAL DATUM POINT.

	LOCAL	UTM
A	E=500.000 N=500.000	E=437384.709 N=3289737.469
B1	E=485.337 N=788.941 Z=12.170	E=437245.830 N=3289991.269 ELEV.=12.17
B2	E=798.452 N=382.283 Z=13.410	E=437704.660 N=3289761.280 ELEV.=13.41

3. ALL ELEVATION REFERENCES IS MEAN SEA LEVEL.

4. ALL DIMENSIONS ARE IN MILLIMETERS UNLESS STATED OTHERWISE.

5. SHALL BE FINALIZED LATER.

6. SHALL BE FINALIZED AFTER RECEIVING APPROVED VENDOR DATA

LEGEND

	FIRE SHED		GRAVITY PIPE SLOPE DIRECTION
	DUCT BANK		NEW PIPE
	BERRIED ELECTRICAL TRENCH		DELUGE VALVE
	BERRIED INSTRUMENT TRENCH		BEARING SLAB
	CONCRETE ELECTRICAL TRENCH		NEW ELECTRICAL DUCT BANK
	CONCRETE INSTRUMENT TRENCH		NEW INSTRUMENT DUCT BANK
	EXISTING ELECTRICAL TRENCH		FOUNDATION
	EXISTING INSTRUMENT TRENCH		CROSSING POINTS
	MAT FOUNDATION		SANITARY MANHOLE
	EXISTING LIGHTING FOUNDATION		VALVE PIT
			NEW LIGHTING TOWER
			EXISTING FENCE
			NEW FENCE

B.O.P.	BOTTOM OF PIPE	GRA	GRAVITY PIPE
B.O.T	BOTTOM OF TRENCH	IN	INSTRUMENT
T.O.D	TOP OF DUCT BANK	EL	ELECTRICAL
H.P.P	HIGH POINT OF FOUNDATION	FWA	FIRE WATER
H.P.P	HIGH POINT OF PAVING	UG	UNDER GROUND
H.P.P	HIGH POINT OF GRAVEL	PE	POLYETHYLENE
R.E.L	ROAD ELEVATION	SA	SANITARY PIPE
		D.B	DUCT BANK
		F.C.G	FINISHED GRADE

REFERENCE DRAWING	DRG. No
SPECIFICATION FOR ROAD & PAVING	BK-GRNAL-PEDCO-000-CV-SP-0002
STANDARD DRAWING FOR ROADS	BK-GRNAL-PEDCO-000-CV-DW-0003
STANDARD DRAWING FOR PAVINGS	BK-GRNAL-PEDCO-000-CV-DW-0035
UNIT PLOT PLAN DRAWING	BK-GCS-PEDCO-120-PI-PY-0001
ROUGH GRADING PLAN & DETAILS	BK-GCS-PEDCO-120-CV-PY-0007
BIHAR NEW COMPRESSOR GAS STATION PLOT PLAN (BASIC PACKAGE)	1560-BK-NCS-PI-DWG-0001
DIRE WALL DRAWING FOR LEAN GLYCOL STORAGE TANK (TK-2102)	BK-GCS-PEDCO-120-ST-DW-0033
FOUNDATION DRAWING FOR GLYCOL STORAGE PIT (SU-2101)	BK-GCS-PEDCO-120-ST-DW-0035
AREA ELECTRICAL CABLE ROUTE & SECTION LAYOUT	BK-GCS-PEDCO-120-EL-PY-0005
INSTRUMENT/F&G CABLE TRENCH/ROUTE LAYOUT DRAWING	BK-GCS-PEDCO-120-IN-PY-0004
UG PIPING PLAN	BK-GCS-PEDCO-120-PI-DW-0005
ROAD, PAVING AND PLANT FINISH GRADING LAYOUT & SECTIONS	BK-GCS-PEDCO-120-CV-PY-0005
OIL CONTAMINATED WATER SYSTEM LAYOUT	BK-GCS-PEDCO-120-CV-PY-0003
PLANT CLEAN WATER DRAINAGE SYSTEM LAYOUT & DETAILS	BK-GCS-PEDCO-120-CV-PY-0004
STANDARD DRAWING FOR ELECTRICAL CABLE TRENCH	BK-GRNAL-PEDCO-000-CV-DW-0004
STANDARD DRAWING FOR SEWERAGE & DRAINAGE DETAILS	BK-GRNAL-PEDCO-000-CV-DW-0007
STANDARD DRAWING FOR CIVIL UNDERGROUND SETTING	BK-GRNAL-PEDCO-000-CV-DW-0006
PIPELINE STANDARD DRAWING FOR COVER SLABS AND CREST-ON-WIDTH	BK-GRNAL-PEDCO-000-PL-DW-0013

KEY PLAN						
***	*****	** **	*** ****	** **	*** ****	
REV.	DESCRIPTION	BY	DATE	BY	DATE	
		CHECKED		REV. APPR.		
اصل و کليه نسخ اين نقشه و حق اقتباس متعلق به شرکت ملی مناطق نفت خيز جنوب ميباشد.  THE ORIGINAL AND ALL COPIES OF THIS DRAWING TOGETHER WITH THE COPYRIGHT THEREIN ARE THE SOLE PROPERTY OF N.I.S.O.C./ FIELDS						
BINAK OILFIELD DEVELOPMENT GENERAL						
DATE	SCALE	DRAWING BY	CHECKED BY	PROJECT ENG.		
NO CONSTRUCTION PERMITTED UNLESS DRAWING APPROVED						
APPROVED FOR CONSTRUCTION	BY:		DATE:			
BUDGET REF.	LOCATION	SIZE CLASS	SERIAL NO.	SHEET	REVISION	
053-073-9184	F	4 S	709113	6	D03	

[illegible]