




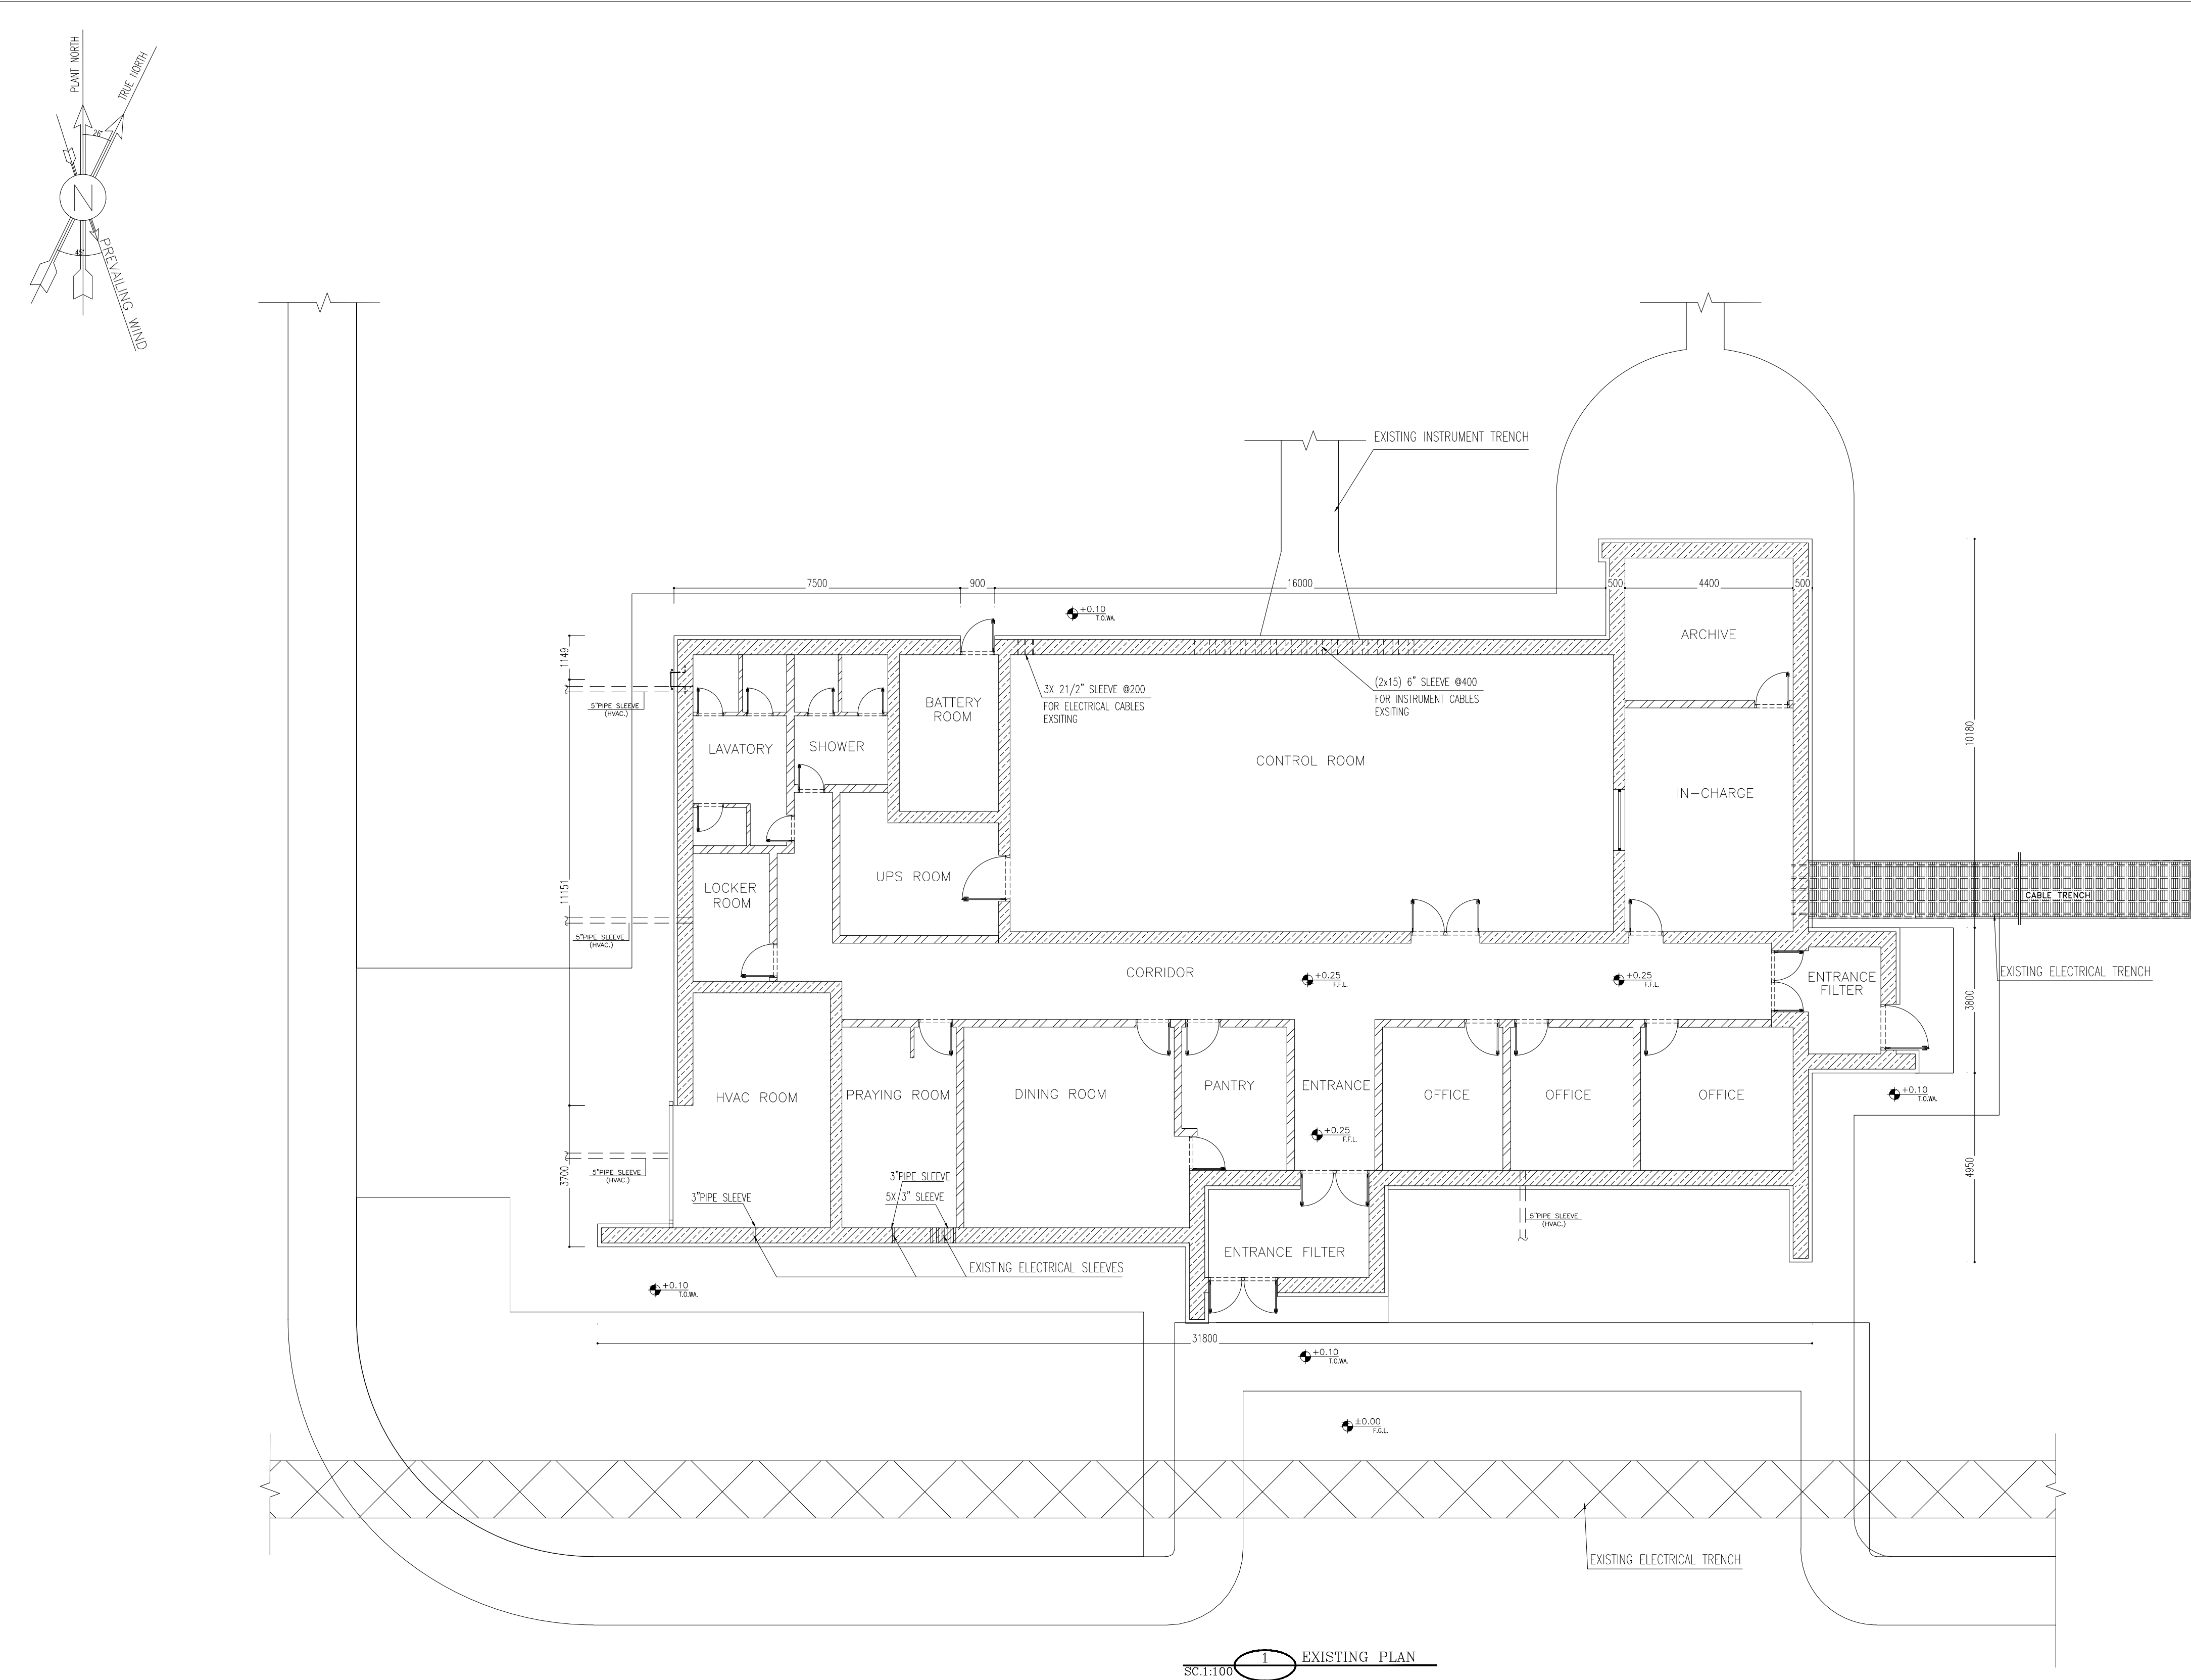


NOTES	
1. ALL DIMENSIONS ARE IN MILLIMETER & ALL ELEVATIONS ARE IN METER. 2. ALL DIMENSIONS AND ELEVATIONS SHALL BE CHECKED BY THE CONTRACTOR PRIOR TO CONSTRUCTION. 3. CONTRACTOR SHALL COMPARE ALL ARCHITECTURAL, MECHANICAL, ELECTRICAL, PIPING AND STRUCTURAL DRAWINGS AND IN CASE OF ANY CONFLICTS OR DISCREPANCY, INFORM THE ENGINEER. 4. ALL MATERIALS ARE SELECTED FROM THE HIGHEST QUALITY AND MUST BE APPROVED BY THE CLIENT. 5. ALL OPENINGS FOR PIPING/CABLING AND HVAC OPENINGS SHALL BE CONSIDERED AS PER RELATED DRAWINGS BEFORE CONSTRUCTION. 6. FINISH GRADING LEVEL (F.G.L.) : ±0.00 (LOCAL) = 99.70	
LEGEND	
F.F.L.	FINISHED FLOOR LEVEL
T.O.W.A.	TOP OF WALKWAY
T.O.P.	TOP OF PARAPET
T.O.S.	TOP OF SLAB
T.O.D.	TOP OF DOOR
T.O.W.	TOP OF WINDOW
B.O.W.	BOTTOM OF WINDOW
T.O.C.	TOP OF CAGE
B.O.C.	BOTTOM OF CAGE
B.O.F.	BOTTOM OF FALSE FLOOR
B.O.SU.	BOTTOM OF SUSPENDED
B.O.S.	BOTTOM OF SLEEVE
H.P.G.	HIGH POINT GRAVEL
	BRICK WORK
	REINFORCED CONCRETE

REFERENCE DRAWING	DRG. No.
STANDARD DRAWING FOR ARCHITECTURAL DETAILS	BK-GNRL-PEDCO-000-AR-DW-0001
SITE SEWAGEAGE SYSTEM LAYOUT & DETAILS	BK-GCS-PEDCO-120-CY-PY-0001
CONTROL ROOM LAYOUT & ARRANGEMENT DRAWING	BK-GCS-PEDCO-120-IN-PY-0001
ROAD, PAVING AND PLANT FINISH GRADING LAYOUT & SECTIONS	BK-GCS-PEDCO-120-CN-PY-0005
ELECTRICAL CABLE ROUTE & SECTION LAYOUT FOR BUILDING & SHELTER	BK-GCS-PEDCO-120-EL-PY-0006
FOUNDATION DRAWING FOR EXTENSION OF CONTROL BUILDING	BK-GNRL-PEDCO-220-ST-DW-0004
STRUCTURAL DRAWING FOR EXTENSION OF CONTROL BUILDING	BK-GNRL-PEDCO-220-ST-DW-0005
STANDARD DETAILS FOR LADDER & SAFETY CAGE	BK-GCS-PEDCO-000-ST-DW-0009
AREA ELECTRICAL CABLE ROUTE & SECTION LAYOUT	BK-GCS-PEDCO-120-EL-PY-0005
UNIT PLOT PLAN DRAWING	BK-PPL-PEDCO-120-PI-PY-0001
CONTROL ROOM CABLE ROUTE LAYOUT	BK-GCS-PEDCO-120-IN-PY-0002
INSTRUMENT/PAG CABLE TRENCH/ROUTE LAYOUT DRAWING	BK-GCS-PEDCO-120-IN-PY-0004
ELECTRICAL EQUIPMENT ARRANGEMENT LAYOUT FOR BUILDING	BK-GCS-PEDCO-120-EL-PY-0008

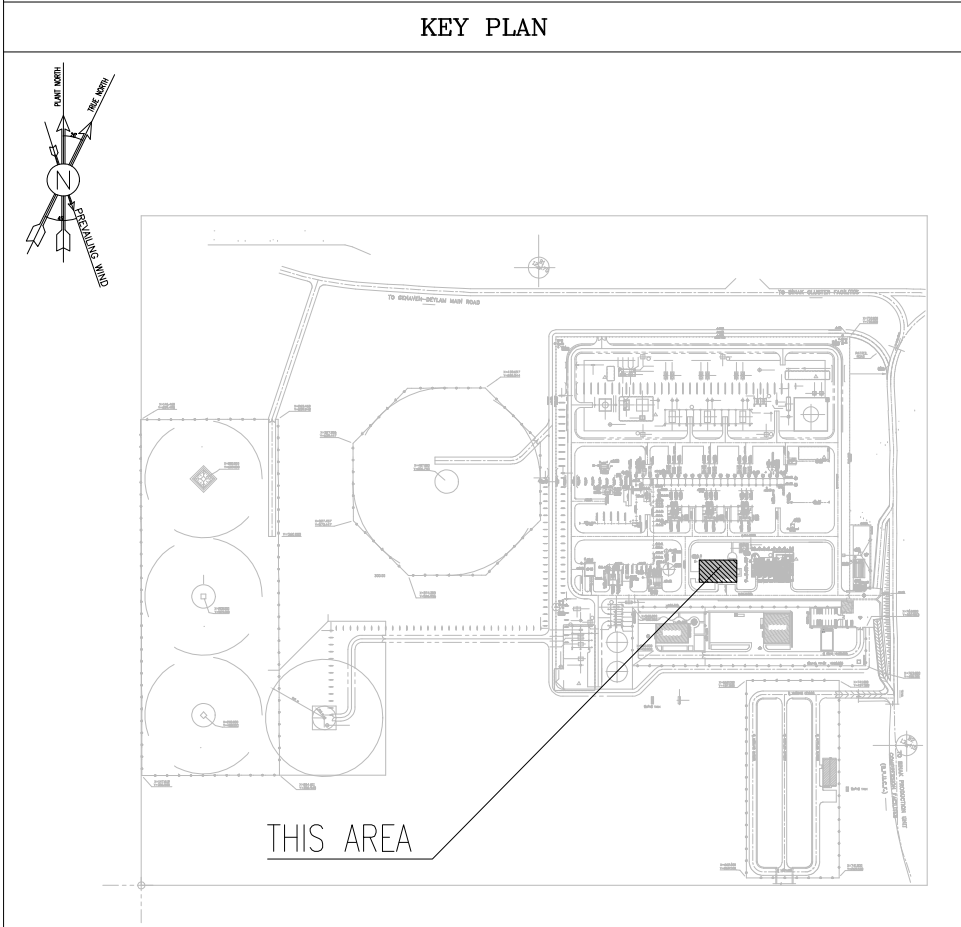

D04	NOV.2024	AFC	R.BERLOUIE	M.FAKHARIAN	M.SADDEGHAN	***									
D03	MAR.2024	AFC	R.BERLOUIE	M.FAKHARIAN	S.Paramarspour	***									
D02	NOV.2023	AFC	R.BERLOUIE	M.FAKHARIAN	S.Paramarspour	***									
D01	SEP.2023	IFA	R.BERLOUIE	M.FAKHARIAN	A.M.MOHSENI	***									
D00	JUN.2023	IPC	R.BERLOUIE	M.FAKHARIAN	A.M.MOHSENI	***									
REV.	DATE	P.O.I.S	PREP.	CHK.	APP.	AUT.									
PROJECT NAME:							BINAK OILFIELD DEVELOPMENT/SURFACE FACILITIES GAS COMPRESSOR STATION								
PROJECT NO.:							971020								
EPC CONTRACTOR:							EPD/EPC CONTRACTOR (GC):								
 HIRGAN ENERGY – DESIGN & INSPECTION COMPANIES							 PETROIRAN DEVELOPMENT COMPANY								
DRAWING TITLE:							BINAK OILFIELD DEVELOPMENT SURFACE FACILITIES GAS COMPRESSOR STATION								
Architectural Detail Drawing For Extension of EXISTING Control Building							NO CONSTRUCTION PERMITTED UNLESS DRAWING APPROVED								
EXISTING PLAN							APPROVED FOR CONSTRUCTION								
SCALE	SIZE	DRAWING NO.		SHEET NO.		REV.	BUDGET REF.	LOCATION	SIZE CLASS	SERIAL NO.		SHEET		REVISION	
AS SHOWN	A1	BK-GCS-PEDCO-120-AR-DW-0011		01 OF 13		D04	053-073-9184	F	4	B		709518		01 OF 13	

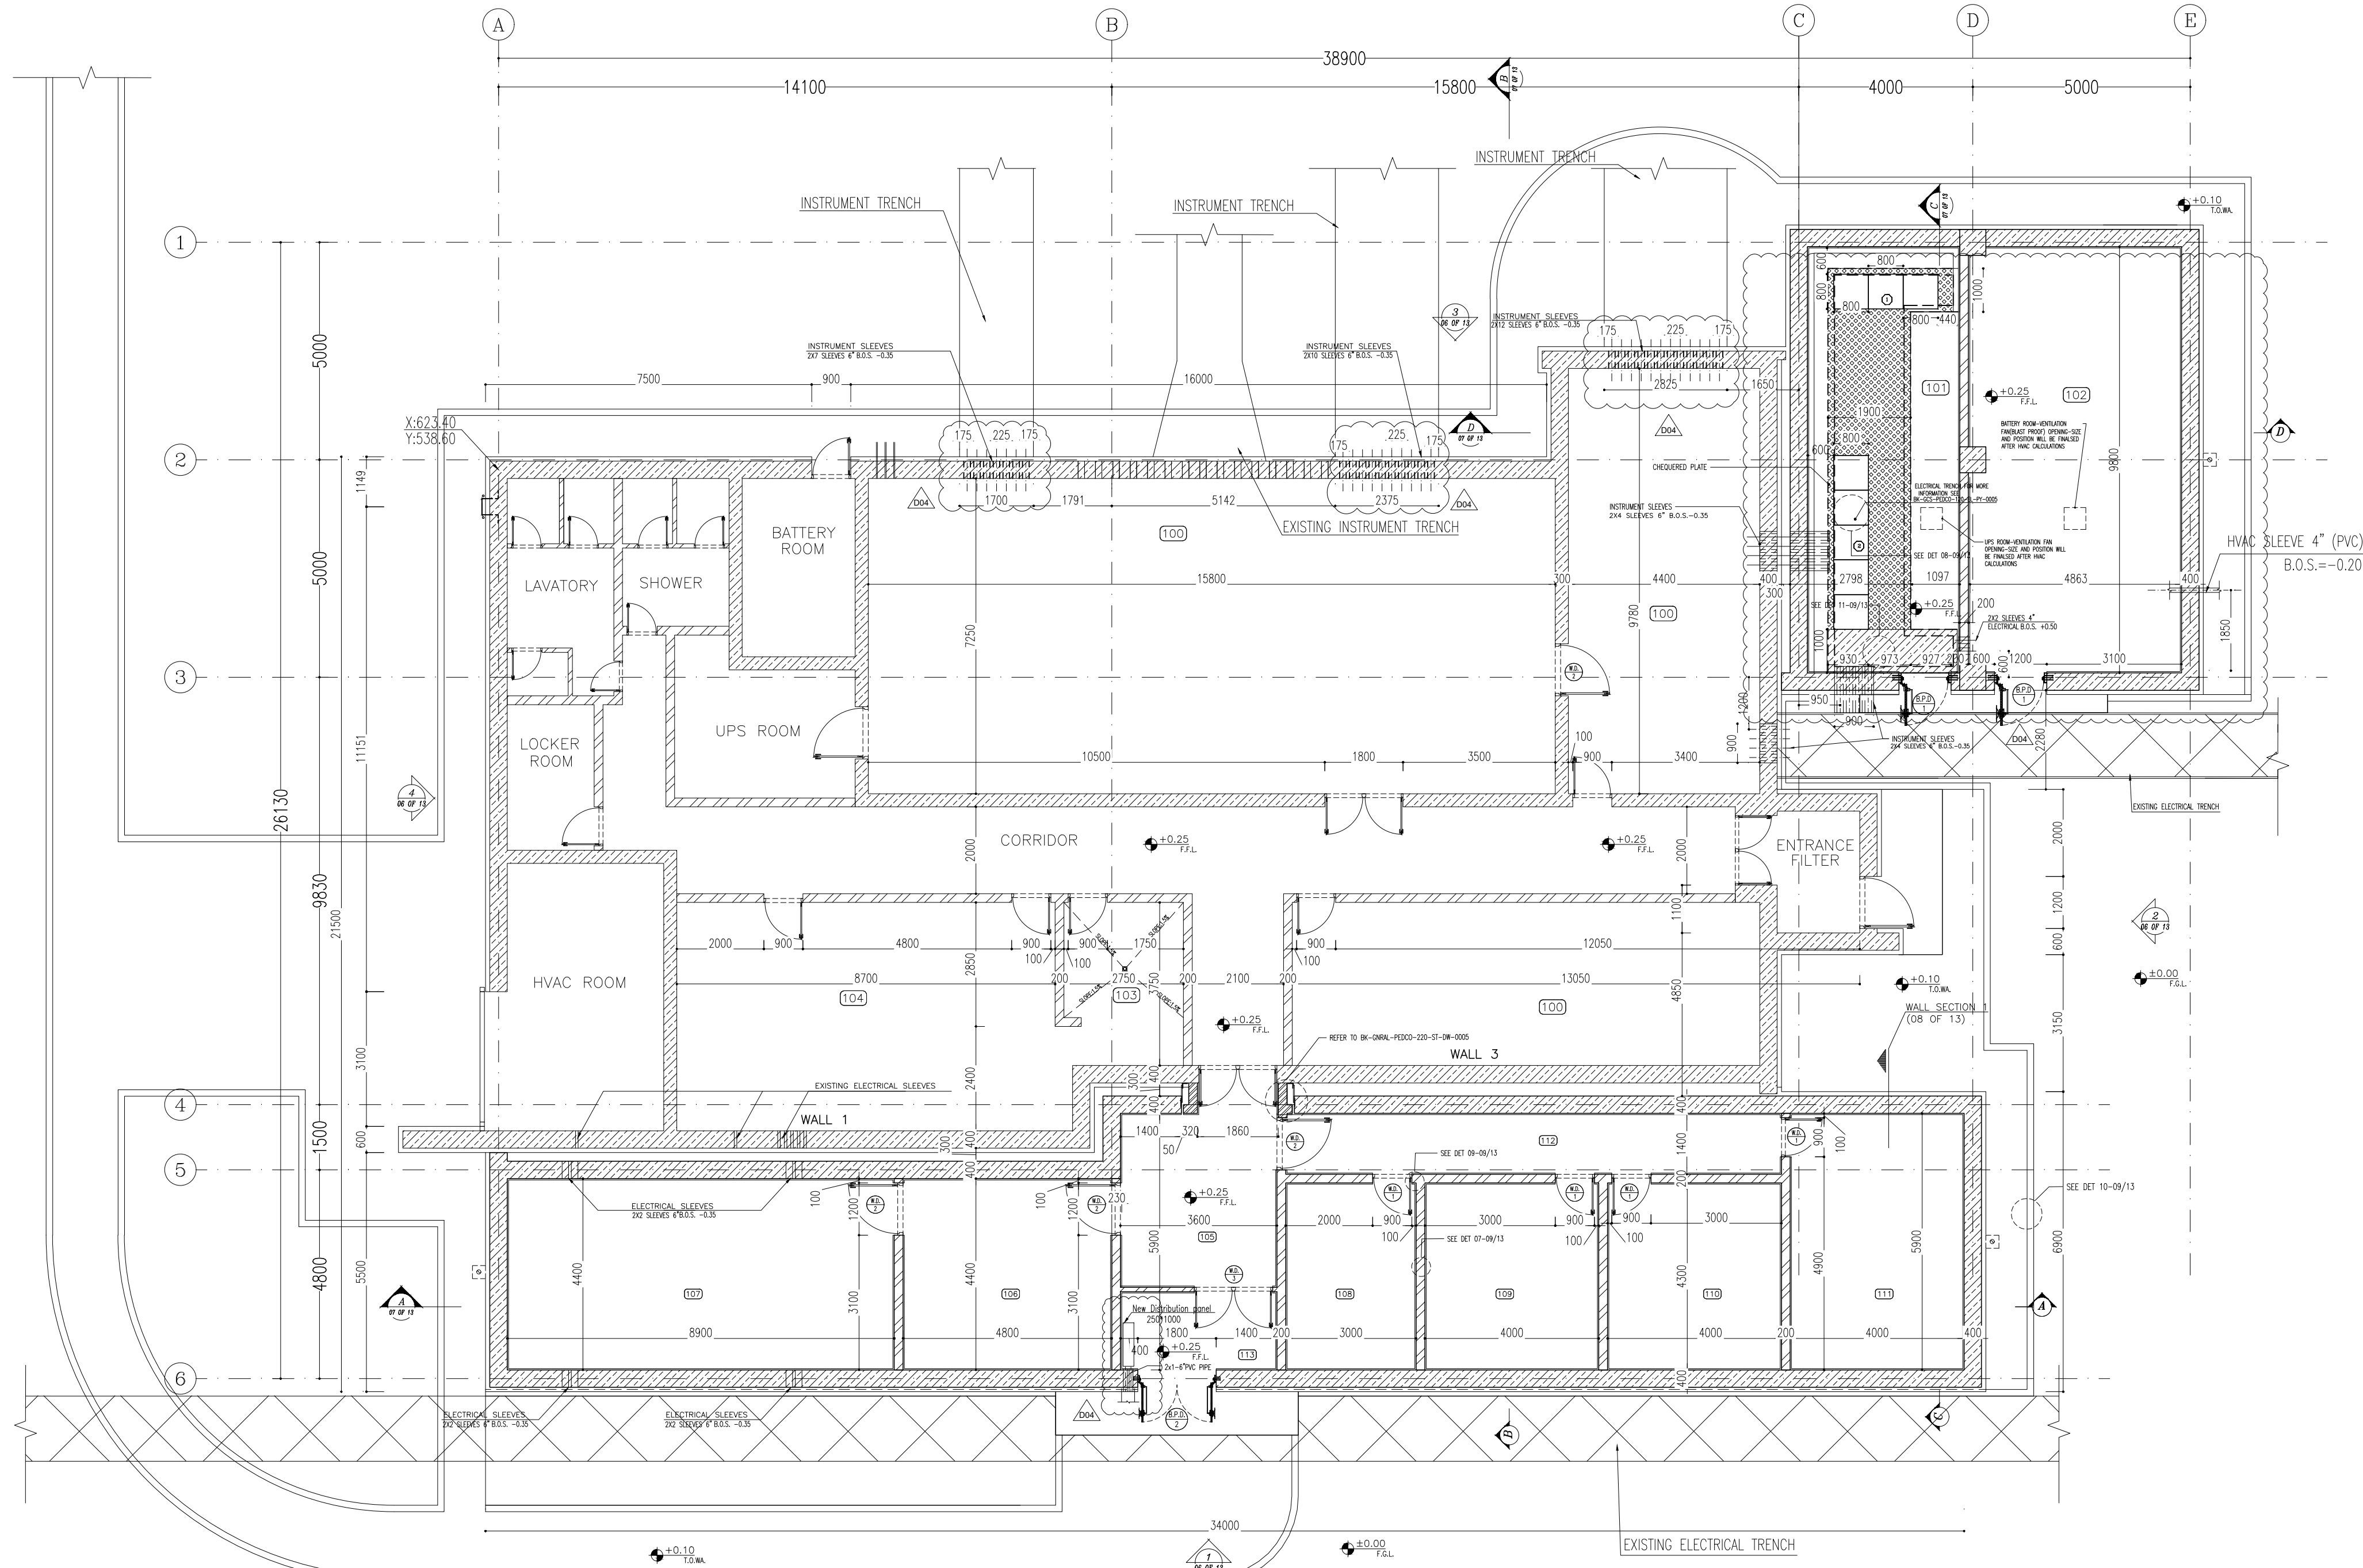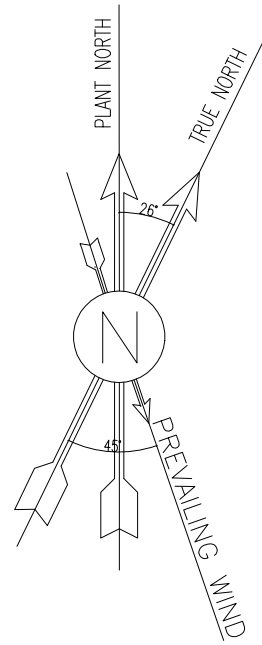

SC.1:100 2 DIMENSION PLAN

100	CONTROL ROOM
101	UPS
102	BATTERY ROOM
103	PANTRY
104	DINING ROOM
105	ENTRANCE
106	MANAGEMENT ROOM
107	CONFERENCE ROOM
108	ARCHIVE
109	LOCKER
110	PRAYER ROOM
111	STORE
112	CORRIDOR
113	AIR LOCK

NOTES

1. ALL DIMENSIONS ARE IN MILLIMETER & ALL ELEVATIONS ARE IN METER.
2. ALL DIMENSIONS AND ELEVATIONS SHALL BE CHECKED BY THE CONTRACTOR PRIOR TO CONSTRUCTION.
3. CONTRACTOR SHALL COMPARE ALL ARCHITECTURAL, MECHANICAL, ELECTRICAL, PIPING AND STRUCTURAL DRAWINGS AND IN CASE OF ANY CONFLICTS OR DISCREPANCY, INFORM THE ENGINEER.
4. ALL MATERIALS ARE SELECTED FROM THE HIGHEST QUALITY AND MUST BE APPROVED BY THE CLIENT.
5. ALL OPENINGS FOR PIPING/CABLING AND HVAC OPENINGS SHALL BE CONSIDERED AS PER RELATED DRAWINGS BEFORE CONSTRUCTION.
6. FINISH GRADING LEVEL (F.G.L.) : ± 0.00 (LOCAL) = 99.70


LEGEND

F.F.L.	FINISHED FLOOR LEVEL
T.O.W.A.	TOP OF WALKWAY
T.O.P.	TOP OF PARAPET
T.O.S.	TOP OF SLAB
T.O.D.	TOP OF DOOR
T.O.W.	TOP OF WINDOW
B.O.W.	BOTTOM OF WINDOW
T.O.C.	TOP OF CAGE
B.O.C.	BOTTOM OF CAGE
B.O.F.	BOTTOM OF FALSE FLOOR
B.O.SU.	BOTTOM OF SUSPENDED
B.O.S.	BOTTOM OF SLEEVE
H.P.G.	HIGH POINT GRAVEL

	BRICK WORK
	REINFORCED CONCRETE
	CHEQUERED PLATE

REFERENCE DRAWING	DRG. No.
STANDARD DRAWING FOR ARCHITECTURAL DETAILS	BK-GNRL-PEDCO-000-AR-DW-0001
SITE SEWAGE SYSTEM LAYOUT & DETAILS	BK-GCS-PEDCO-120-CY-PY-0001
CONTROL ROOM LAYOUT & ARRANGEMENT DRAWING	BK-GCS-PEDCO-120-IN-PY-0001
ROAD, PAVING AND PLANT FINISH GRADING LAYOUT & SECTIONS	BK-GCS-PEDCO-120-CY-PY-0005
ELECTRICAL CABLE ROUTE & SECTION LAYOUT FOR BUILDING & SHELTER	BK-GCS-PEDCO-120-EL-PY-0006
FOUNDATION DRAWING FOR EXTENSION OF CONTROL BUILDING	BK-GNRL-PEDCO-220-ST-DW-0004
STRUCTURAL DRAWING FOR EXTENSION OF CONTROL BUILDING	BK-GNRL-PEDCO-220-ST-DW-0005
STANDARD DETAILS FOR LADDER & SAFETY CAGE	BK-GNRL-PEDCO-000-ST-DW-0009
AREA ELECTRICAL CABLE ROUTE & SECTION LAYOUT	BK-GCS-PEDCO-120-EL-PY-0005
UNIT FLY PLAN DRAWING	BK-PPL-PEDCO-120-PI-PY-0001
CONTROL ROOM CABLE ROUTE LAYOUT	BK-GCS-PEDCO-120-IN-PY-0002
INSTRUMENT/PAG CABLE TRENCH/ROUTE LAYOUT DRAWING	BK-GCS-PEDCO-120-IN-PY-0004
ELECTRICAL EQUIPMENT ARRANGEMENT LAYOUT FOR BUILDING	BK-GCS-PEDCO-120-EL-PY-0008

KEY PLAN

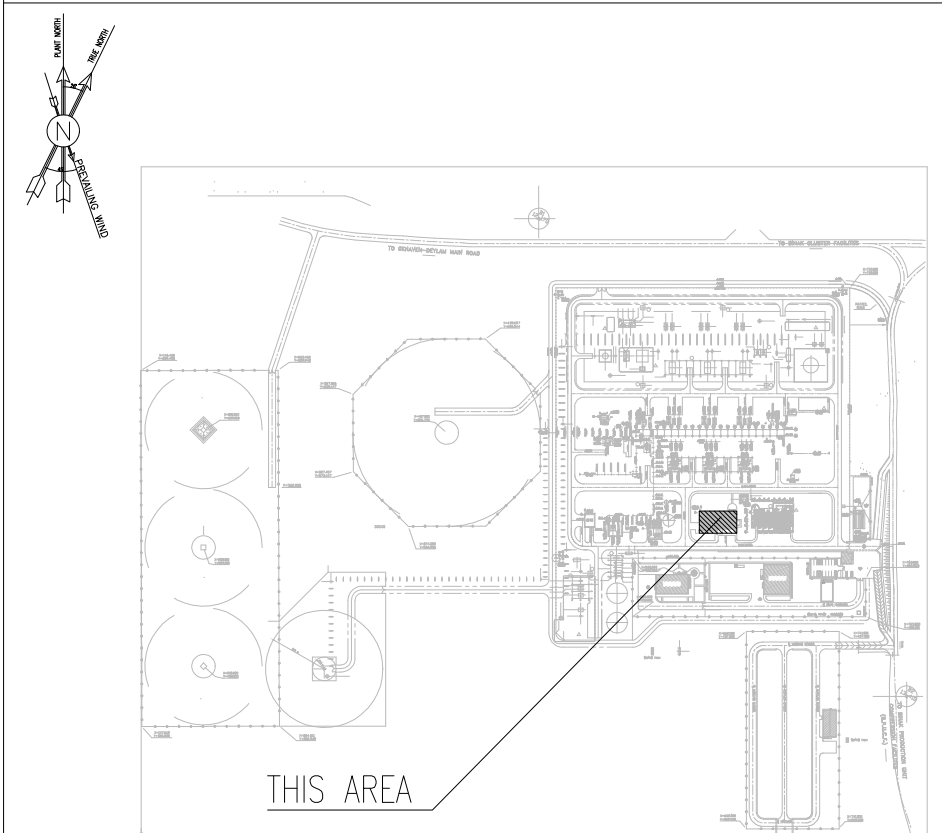

D04	NOV. 2024	AFC	R.BERLOUIE	M.FAKHARIAN	M.SABGHIAN	***
D03	MAR. 2024	AFC	R.BERLOUIE	M.FAKHARIAN	S.Paramarspour	***
D02	NOV. 2023	AFC	R.BERLOUIE	M.FAKHARIAN	S.Paramarspour	***
D01	SEP. 2023	IFA	R.BERLOUIE	M.FAKHARIAN	A.M.MOHSENI	***
D00	JUN. 2023	IPC	R.BERLOUIE	M.FAKHARIAN	A.M.MOHSENI	***

REV. DATE P.O.I.S PREP. CHK. APP. AUT.

PROJECT NAME: BINAK OILFIELD DEVELOPMENT/SURFACE FACILITIES GAS COMPRESSOR STATION

PROJECT NO.: 971020

EPC CONTRACTOR:	EPD/EPC CONTRACTOR (GC):
HIRGAN ENERGY - DESIGN & INSPECTION COMPANIES	PEDCO

DRAWING TITLE: Architectural Detail Drawing For Extension of EXISTING Control Building

DIMENSION PLAN

APPROVED FOR CONSTRUCTION BY: DATE:

BUDGET REF. LOCATION SIZE CLASS SERIAL NO. SHEET REVISION



AS SHOWN A1 BK-GCS-PEDCO-120-AR-DW-0011 02 OF 13 D04 053-073-9184 F 4 B 709518 02 OF 13 D04

اسل و کلیه نسخ این نقشه و حق اقتباس متعلق به شرکت ملی مناطق نفت خیز جنوب میباشد.
THE ORIGINAL AND ALL COPIES OF THIS DRAWING TOGETHER WITH THE COPYRIGHT THEREIN ARE THE SOLE PROPERTY OF N.I.S.O.C./ FIELDS

BINAK OILFIELD DEVELOPMENT SURFACE FACILITIES GAS COMPRESSOR STATION

DATE SCALE DRAWING BY CHECKED BY PROJECT ENG.

NO CONSTRUCTION PERMITTED UNLESS DRAWING APPROVED

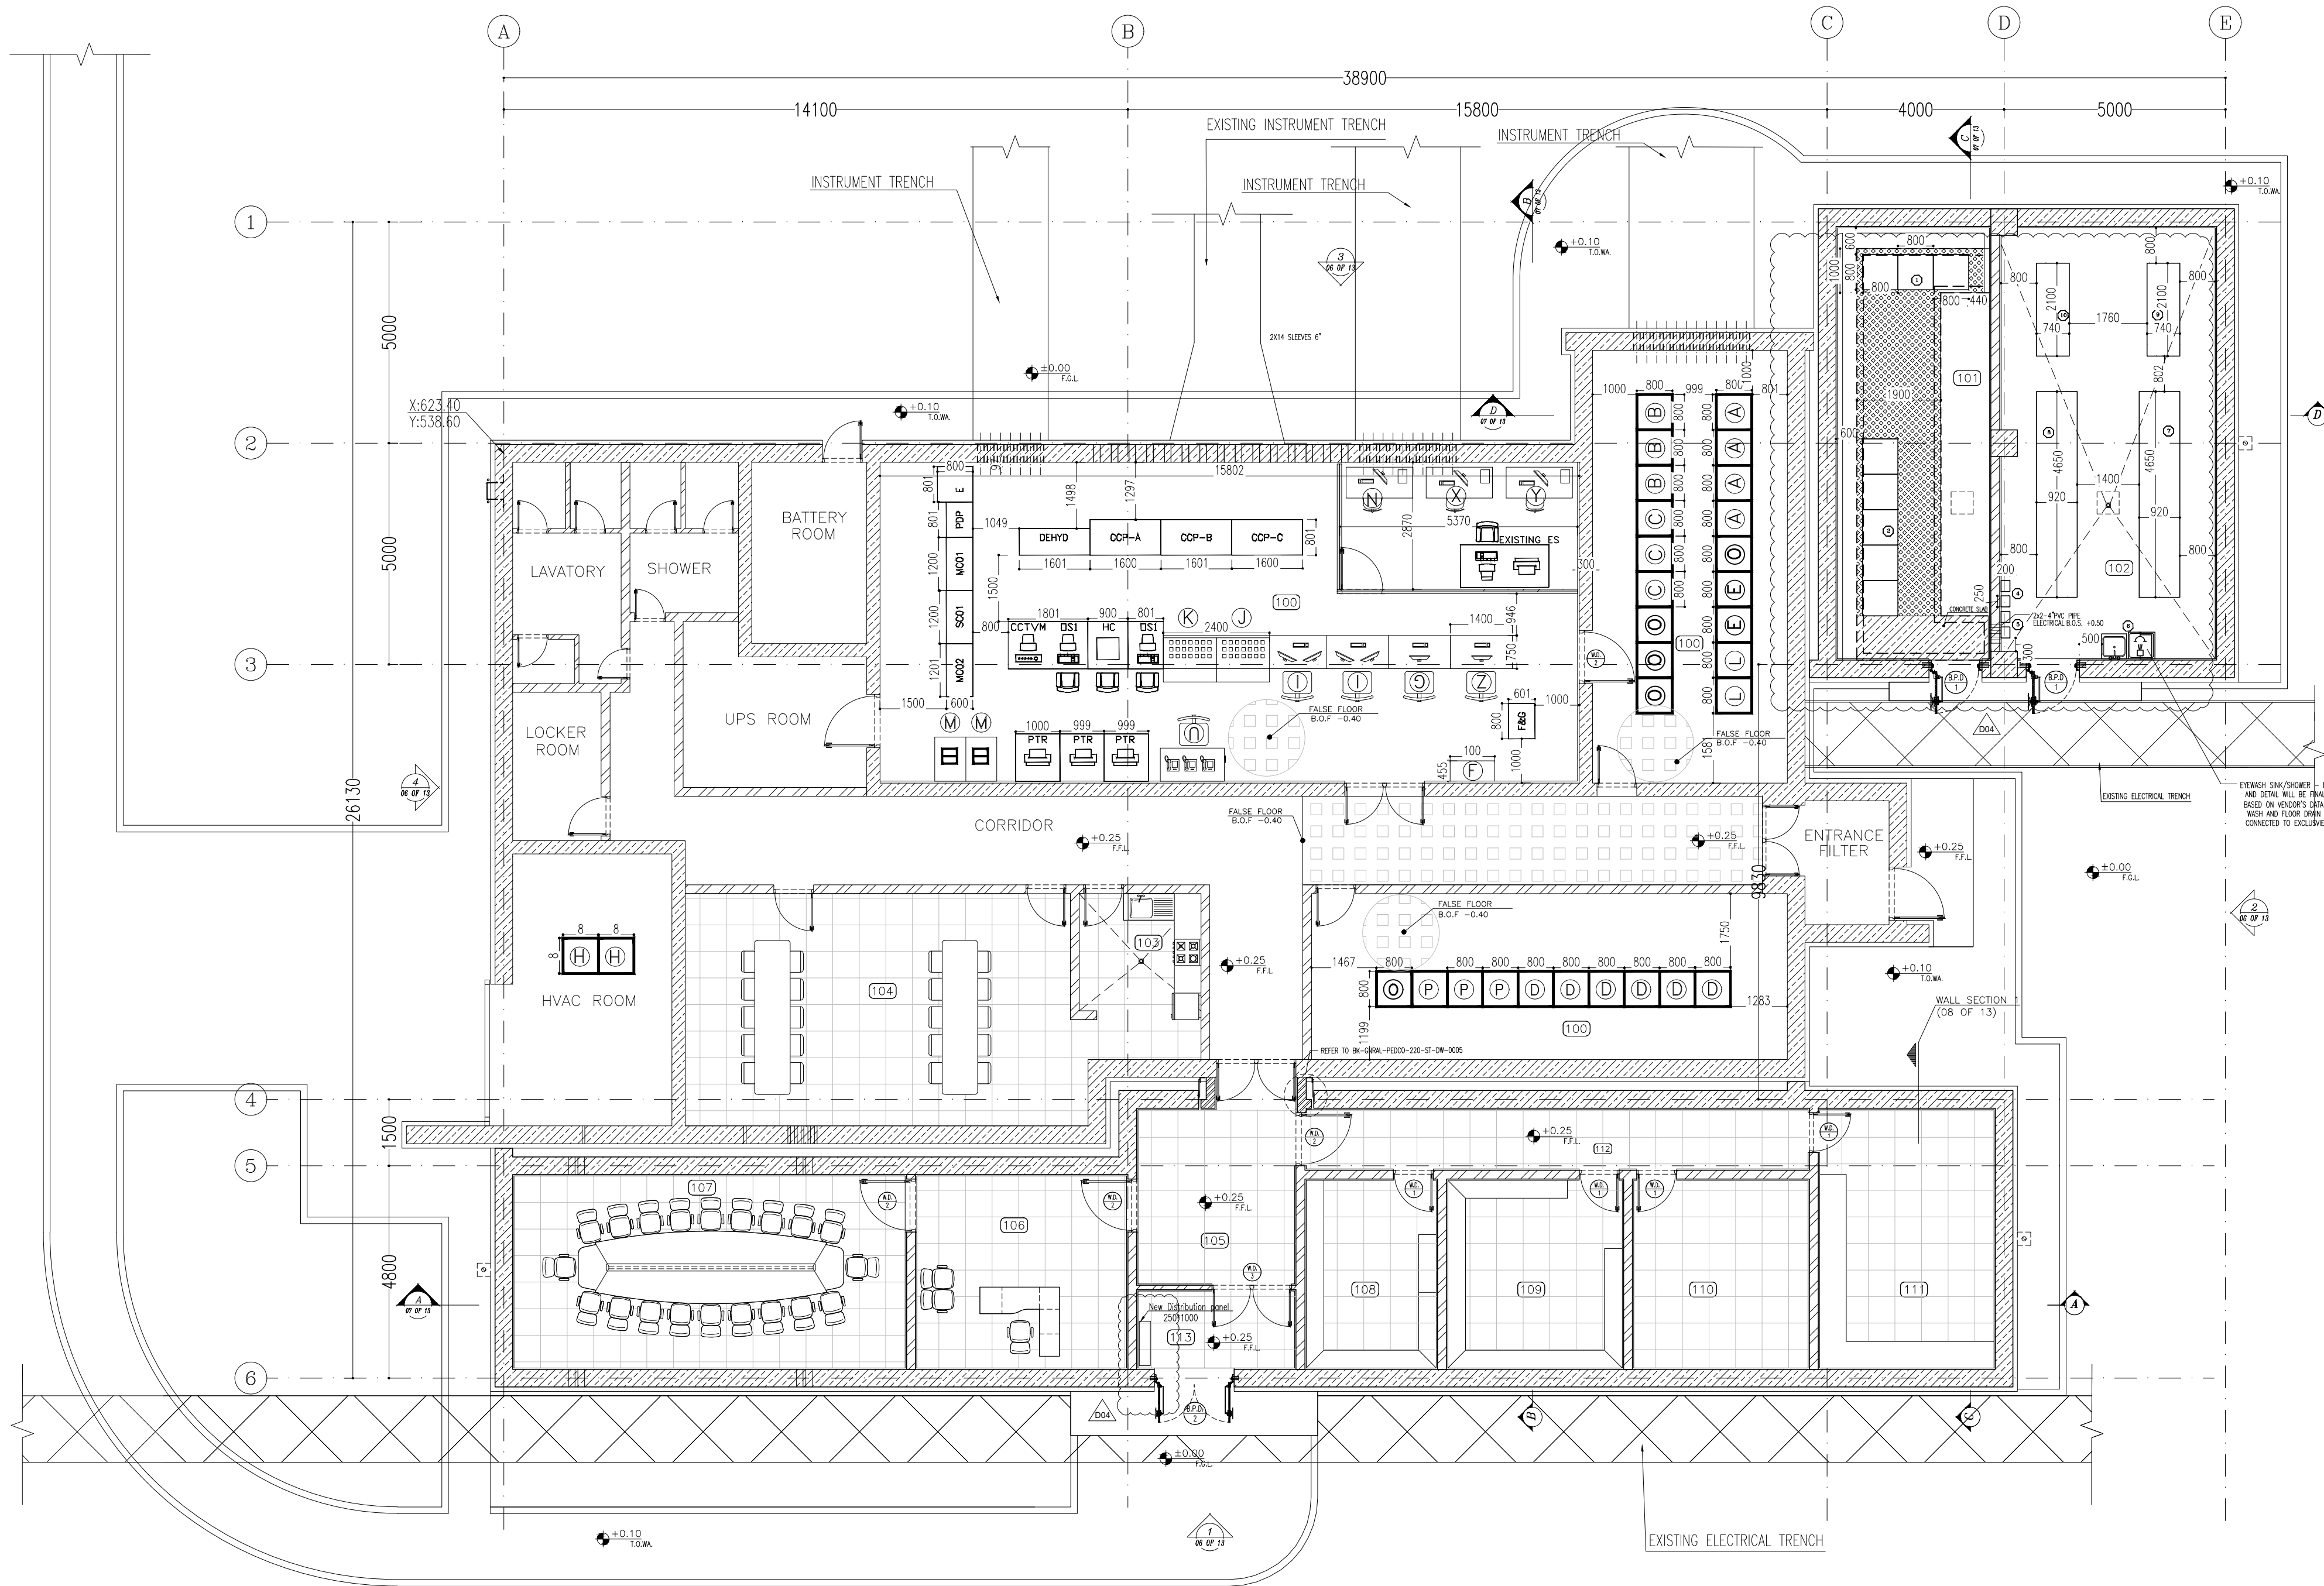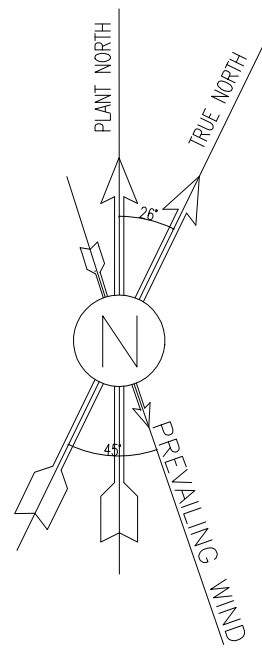

SC.1:100 3 FURNITURE & FLOORING PLAN

100	CONTROL ROOM
101	UPS
102	BATTERY ROOM
103	PANTRY
104	DINING ROOM
105	ENTRANCE
106	MANAGEMENT ROOM
107	CONFERENCE ROOM
108	ARCHIVE
109	LOCKER
110	PRAYER ROOM
111	STORE
112	CORRIDOR
113	AIR LOCK

NOTES

1. ALL DIMENSIONS ARE IN MILLIMETER & ALL ELEVATIONS ARE IN METER.
2. ALL DIMENSIONS AND ELEVATIONS SHALL BE CHECKED BY THE CONTRACTOR PRIOR TO CONSTRUCTION.
3. CONTRACTOR SHALL COMPARE ALL ARCHITECTURAL, MECHANICAL, ELECTRICAL, PIPING AND STRUCTURAL DRAWINGS AND IN CASE OF ANY CONFLICTS OR DISCREPANCY, INFORM THE ENGINEER.
4. ALL MATERIALS ARE SELECTED FROM THE HIGHEST QUALITY AND MUST BE APPROVED BY THE CLIENT.
5. ALL OPENINGS FOR PIPING/CABLING AND HVAC OPENINGS SHALL BE CONSIDERED AS PER RELATED DRAWINGS BEFORE CONSTRUCTION.
6. FINISH GRADING LEVEL (F.G.L.) : ± 0.00 (LOCAL) = 99.70

LEGEND


F.F.L.	FINISHED FLOOR LEVEL
T.O.W.A.	TOP OF WALKWAY
T.O.P.	TOP OF PARAPET
T.O.S.	TOP OF SLAB
T.O.D.	TOP OF DOOR
T.O.W.	TOP OF WINDOW
B.O.W.	BOTTOM OF WINDOW
T.O.C.	TOP OF CAGE
B.O.C.	BOTTOM OF CAGE
B.O.F.	BOTTOM OF FALSE FLOOR
B.O.SU.	BOTTOM OF SUSPENDED
B.O.S.	BOTTOM OF SLEEVE
H.P.G.	HIGH POINT GRAVEL

	BRICK WORK
	REINFORCED CONCRETE
	FALSE FLOOR
	STONE
	ANTI-ACID CERAMIC TILE
	CHEQUERED PLATE

REFERENCE DRAWING

REFERENCE DRAWING	DRG. No.
STANDARD DRAWING FOR ARCHITECTURAL DETAILS	BK-GNRL-PEDCO-000-AR-DW-0001
SITE SEWAGE SYSTEM LAYOUT & DETAILS	BK-GCS-PEDCO-120-CY-PY-0001
CONTROL ROOM LAYOUT & ARRANGEMENT DRAWING	BK-GCS-PEDCO-120-IN-PY-0001
ROAD, PAVING AND PLANT FINISH GRADING LAYOUT & SECTIONS	BK-GCS-PEDCO-120-CY-PY-0005
ELECTRICAL CABLE ROUTE & SECTION LAYOUT FOR BUILDING & SHELTER	BK-GCS-PEDCO-120-EL-PY-0006
FOUNDATION DRAWING FOR EXTENSION OF CONTROL BUILDING	BK-GNRL-PEDCO-220-ST-DW-0004
STRUCTURAL DRAWING FOR EXTENSION OF CONTROL BUILDING	BK-GNRL-PEDCO-220-ST-DW-0005
STANDARD DETAILS FOR LADDER & SAFETY CAGE	BK-GNRL-PEDCO-000-ST-DW-0009
AREA ELECTRICAL CABLE ROUTE & SECTION LAYOUT	BK-GCS-PEDCO-120-EL-PY-0005
UNIT PLAT PLAN DRAWING	BK-PPL-PEDCO-120-PI-PY-0001
CONTROL ROOM CABLE ROUTE LAYOUT	BK-GCS-PEDCO-120-IN-PY-0002
INSTRUMENT/PAG CABLE TRENCH/ROUTE LAYOUT DRAWING	BK-GCS-PEDCO-120-IN-PY-0004
ELECTRICAL EQUIPMENT ARRANGEMENT LAYOUT FOR BUILDING	BK-GCS-PEDCO-120-EL-PY-0008

KEY PLAN

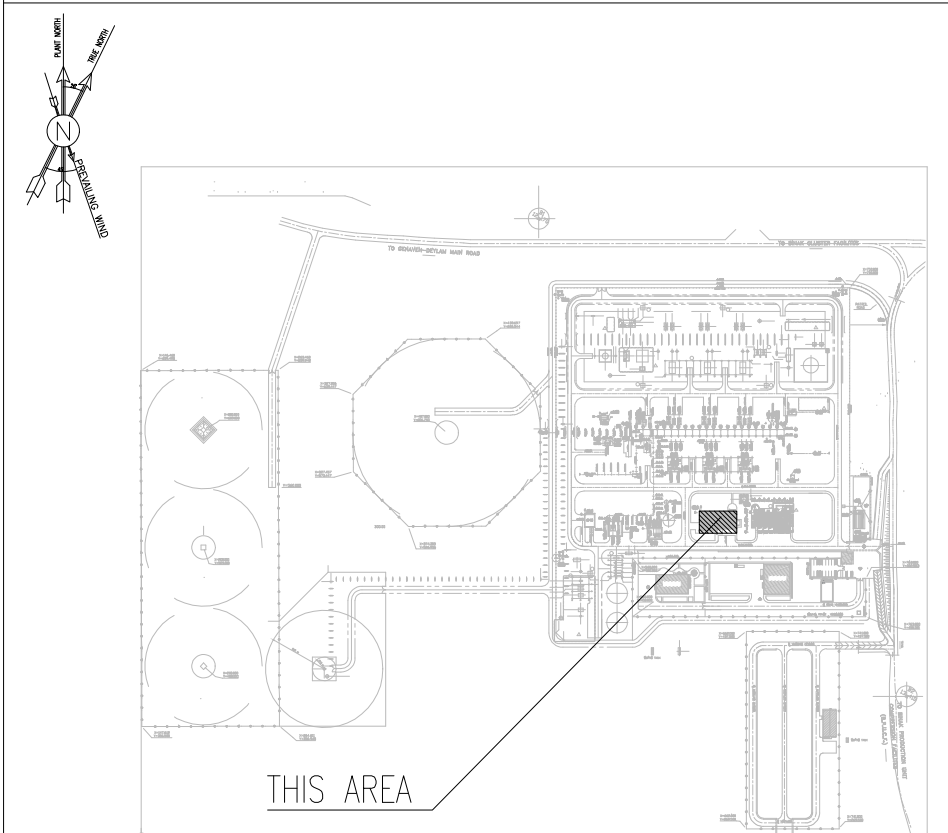

D04	NOV. 2024	AFC	R.BERLOUIE	M.FAKHARIAN	M.SADDEGHAN	***
D03	MAR. 2024	AFC	R.BERLOUIE	M.FAKHARIAN	S.Paramarspour	***
D02	NOV. 2023	AFC	R.BERLOUIE	M.FAKHARIAN	S.Paramarspour	***
D01	SEP. 2023	IPA	R.BERLOUIE	M.FAKHARIAN	A.M.MOHSENI	***
D00	JUN. 2023	IPC	R.BERLOUIE	M.FAKHARIAN	A.M.MOHSENI	***

PROJECT NAME: BINAK OILFIELD DEVELOPMENT/SURFACE FACILITIES GAS COMPRESSOR STATION

PROJECT NO.: 971020

EPC CONTRACTOR:	EPD/EPC CONTRACTOR (GC):
HIRGAN ENERGY - DESIGN & INSPECTION COMPANIES	PEDCO

DRAWING TITLE: Architectural Detail Drawing For Extension of EXISTING Control Building FURNITURE & FLOORING PLAN

SCALE	SIZE	DRAWING NO.	SHEET NO.	REV.
AS SHOWN	A1	BK-GCS-PEDCO-120-AR-DW-0011	03 OF 13	D04



THE ORIGINAL AND ALL COPIES OF THIS DRAWING TOGETHER WITH THE COPYRIGHT THEREIN ARE THE SOLE PROPERTY OF N.I.S.O.C./ FIELDS

BINAK OILFIELD DEVELOPMENT SURFACE FACILITIES GAS COMPRESSOR STATION

DATE	SCALE	DRAWING BY	CHECKED BY	PROJECT ENG.

NO CONSTRUCTION PERMITTED UNLESS DRAWING APPROVED

APPROVED FOR CONSTRUCTION				BY:	DATE:
BUDGET REF.	LOCATION	SIZE CLASS	SERIAL NO.	SHEET	REVISION
053-073-9184	F	4	B	709518	03 OF 13 D04

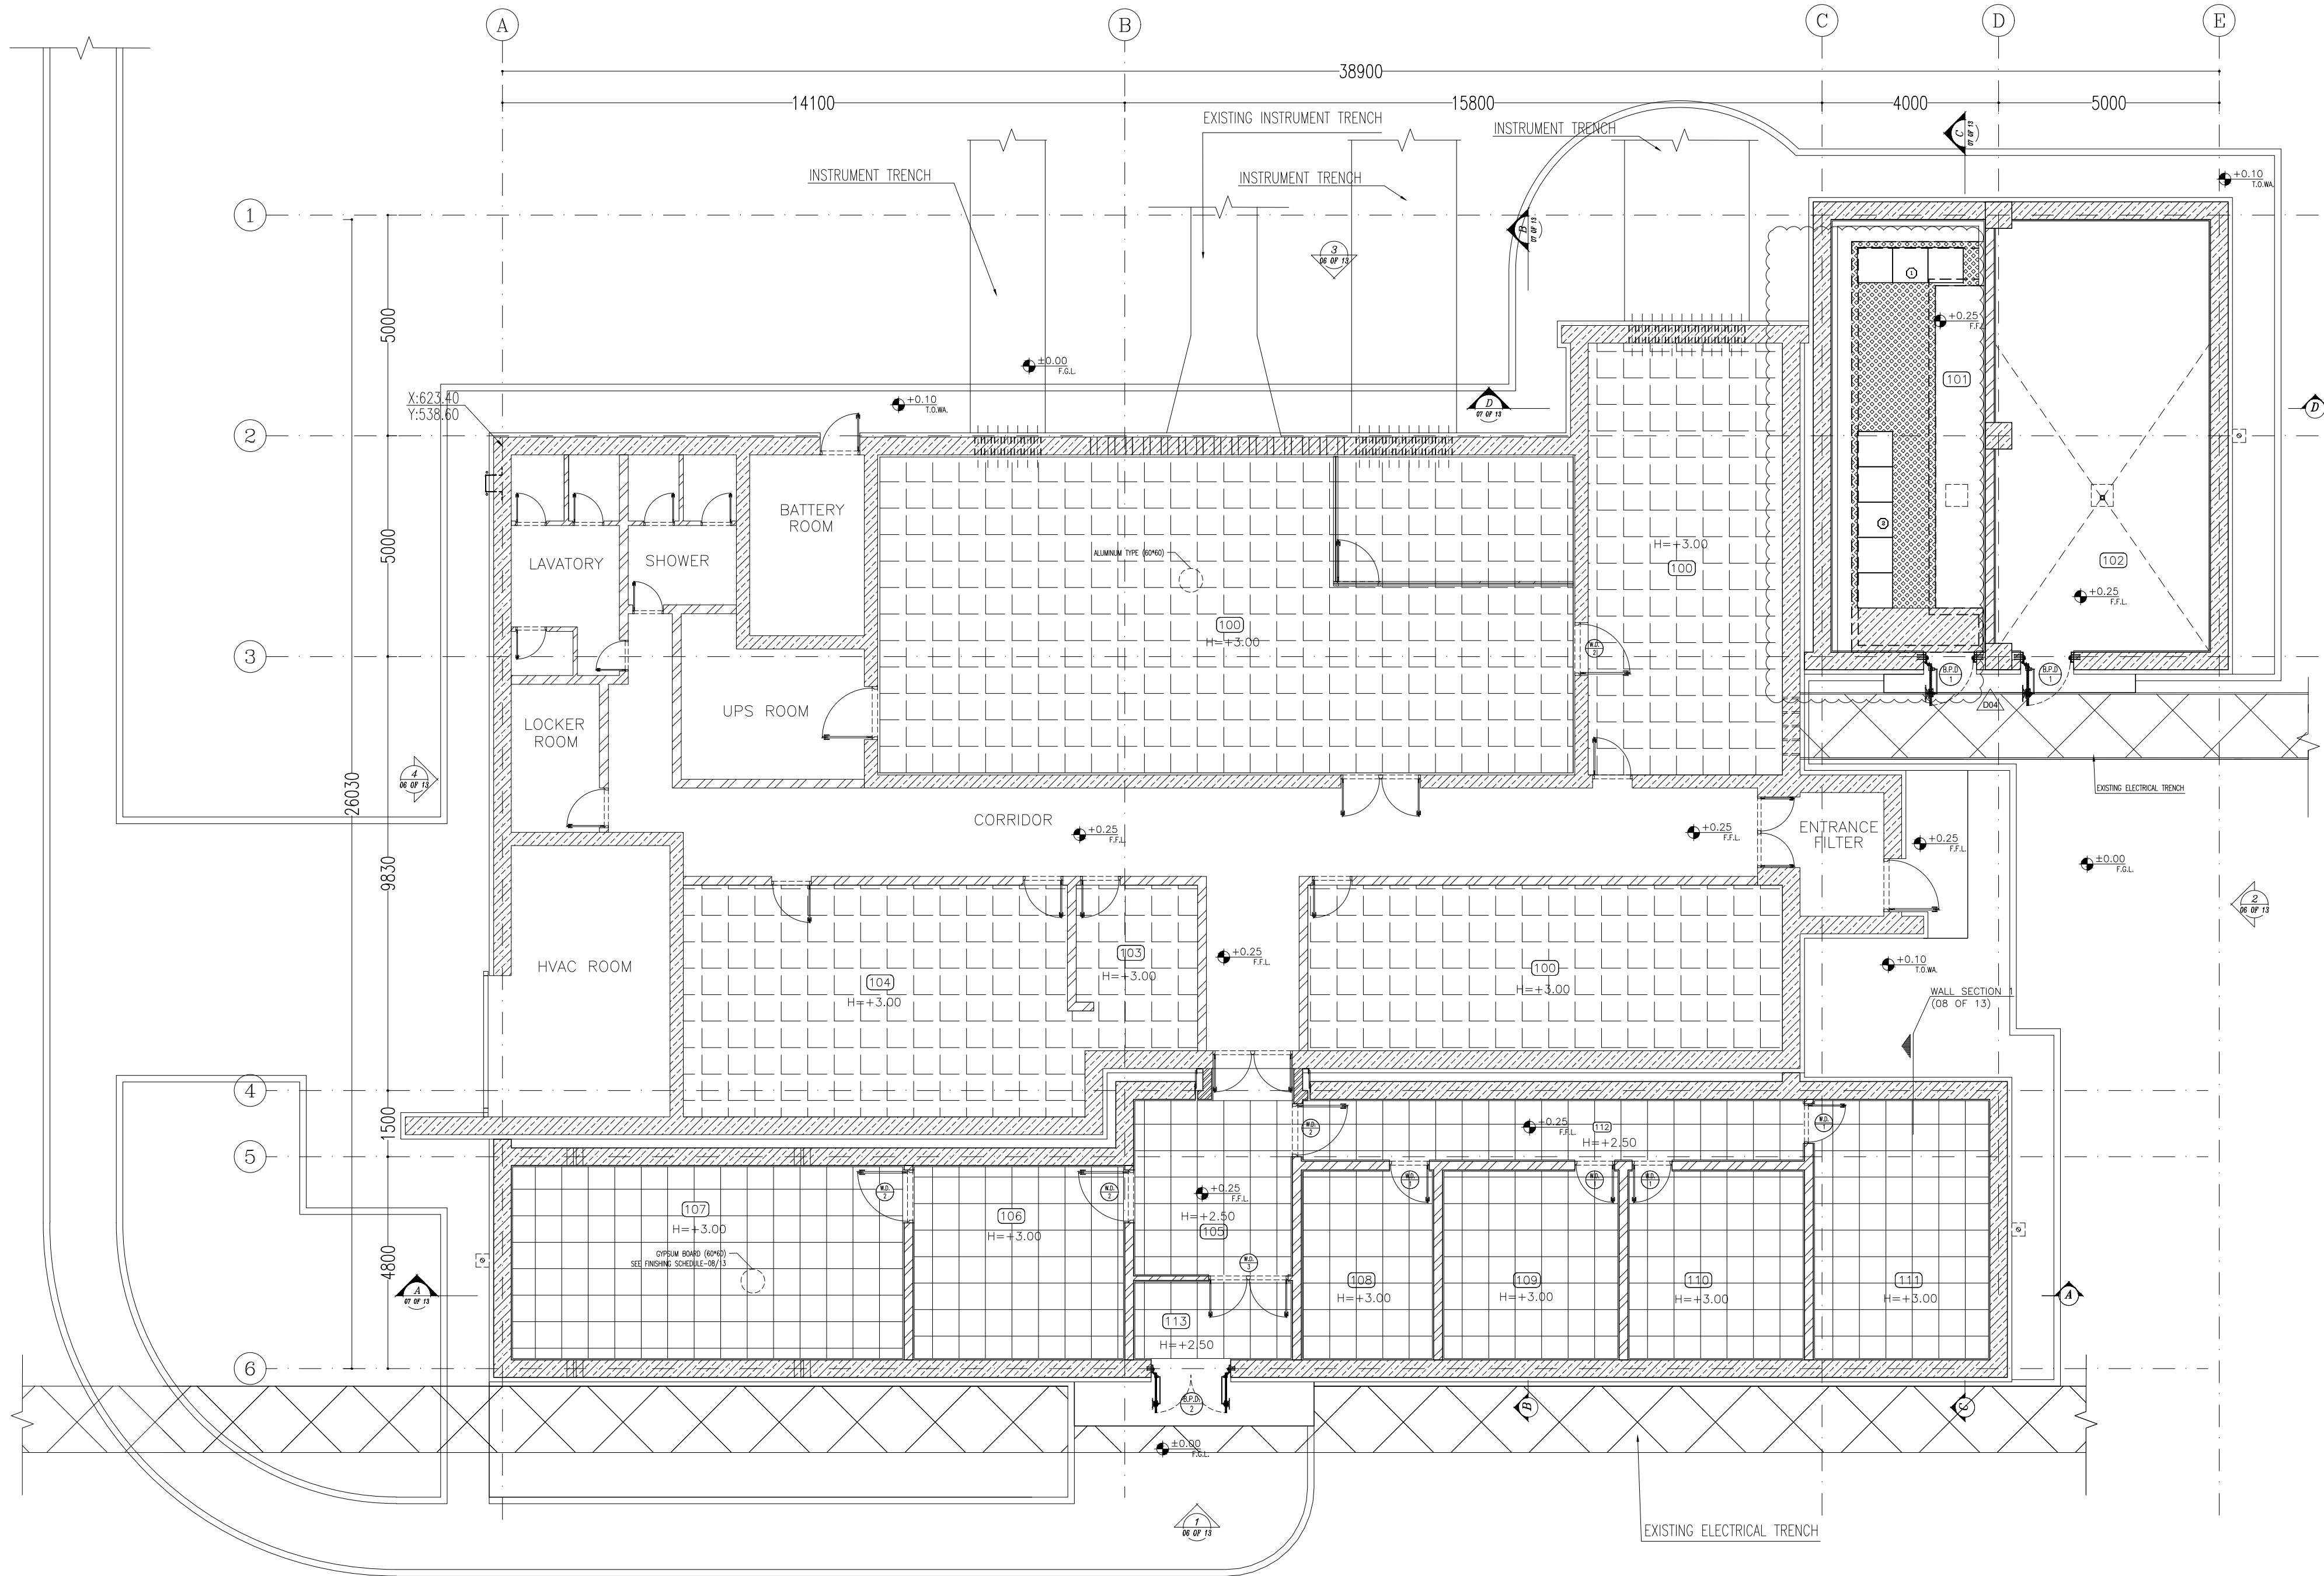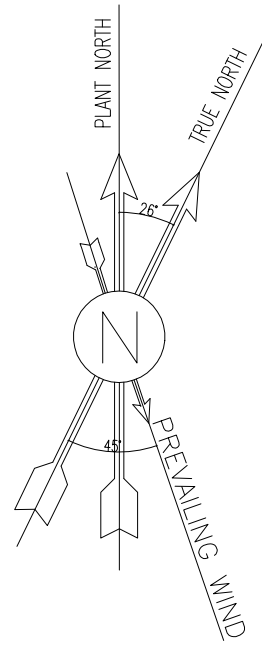

SC.1:100 4 SUSPENDED CEILING PLAN

100	CONTROL ROOM
101	UPS
102	BATTERY ROOM
103	PANTRY
104	DINING ROOM
105	ENTRANCE
106	MANAGEMENT ROOM
107	CONFERENCE ROOM
108	ARCHIVE
109	LOCKER
110	PRAYER ROOM
111	STORE
112	CORRIDOR
113	AIR LOCK

NOTES

1. ALL DIMENSIONS ARE IN MILLIMETER & ALL ELEVATIONS ARE IN METER.
2. ALL DIMENSIONS AND ELEVATIONS SHALL BE CHECKED BY THE CONTRACTOR PRIOR TO CONSTRUCTION.
3. CONTRACTOR SHALL COMPARE ALL ARCHITECTURAL, MECHANICAL, ELECTRICAL, PIPING AND STRUCTURAL DRAWINGS AND IN CASE OF ANY CONFLICTS OR DISCREPANCY, INFORM THE ENGINEER.
4. ALL MATERIALS ARE SELECTED FROM THE HIGHEST QUALITY AND MUST BE APPROVED BY THE CLIENT.
5. ALL OPENINGS FOR PIPING/CABLING AND HVAC OPENINGS SHALL BE CONSIDERED AS PER RELATED DRAWINGS BEFORE CONSTRUCTION.
6. FINISH GRADING LEVEL (F.G.L.) : ± 0.00 (LOCAL) = 99.70


LEGEND

F.F.L.	FINISHED FLOOR LEVEL
T.O.W.A.	TOP OF WALKWAY
T.O.P.	TOP OF PARAPET
T.O.S.	TOP OF SLAB
T.O.D.	TOP OF DOOR
T.O.W.	TOP OF WINDOW
B.O.W.	BOTTOM OF WINDOW
T.O.C.	TOP OF CAGE
B.O.C.	BOTTOM OF CAGE
B.O.F.	BOTTOM OF FALSE FLOOR
B.O.SU.	BOTTOM OF SUSPENDED
B.O.S.	BOTTOM OF SLEEVE
H.P.G.	HIGH POINT GRAVEL


	BRICK WORK
	REINFORCED CONCRETE
	SUSPENDED CEILING ALUMINUM TYPE
	SUSPENDED CEILING GYPSUM BOARD

REFERENCE DRAWING	DRG. No.
STANDARD DRAWING FOR ARCHITECTURAL DETAILS	BK-GNRL-PEDCO-000-AR-DW-0001
SITE SEWAGE SYSTEM LAYOUT & DETAILS	BK-GCS-PEDCO-120-CY-PY-0001
CONTROL ROOM LAYOUT & ARRANGEMENT DRAWING	BK-GCS-PEDCO-120-IN-PY-0001
ROAD, PAVING AND PLANT FINISH GRADING LAYOUT & SECTIONS	BK-GCS-PEDCO-120-CY-PY-0005
ELECTRICAL CABLE ROUTE & SECTION LAYOUT FOR BUILDING & SHELTER	BK-GCS-PEDCO-120-EL-PY-0006
FOUNDATION DRAWING FOR EXTENSION OF CONTROL BUILDING	BK-GNRL-PEDCO-220-ST-DW-0004
STRUCTURAL DRAWING FOR EXTENSION OF CONTROL BUILDING	BK-GNRL-PEDCO-220-ST-DW-0005
STANDARD DETAILS FOR LADDER & SAFETY CAGE	BK-GCS-PEDCO-120-EL-PY-0005
AREA ELECTRICAL CABLE ROUTE & SECTION LAYOUT	BK-GNRL-PEDCO-000-ST-DW-0009
UNIT FLOT PLAN DRAWING	BK-PPL-PEDCO-120-PI-PY-0001
CONTROL ROOM CABLE ROUTE LAYOUT	BK-GCS-PEDCO-120-IN-PY-0002
INSTRUMENT/PAG CABLE TRENCH/ROUTE LAYOUT DRAWING	BK-GCS-PEDCO-120-IN-PY-0004
ELECTRICAL EQUIPMENT ARRANGEMENT LAYOUT FOR BUILDING	BK-GCS-PEDCO-120-EL-PY-0008

KEY PLAN

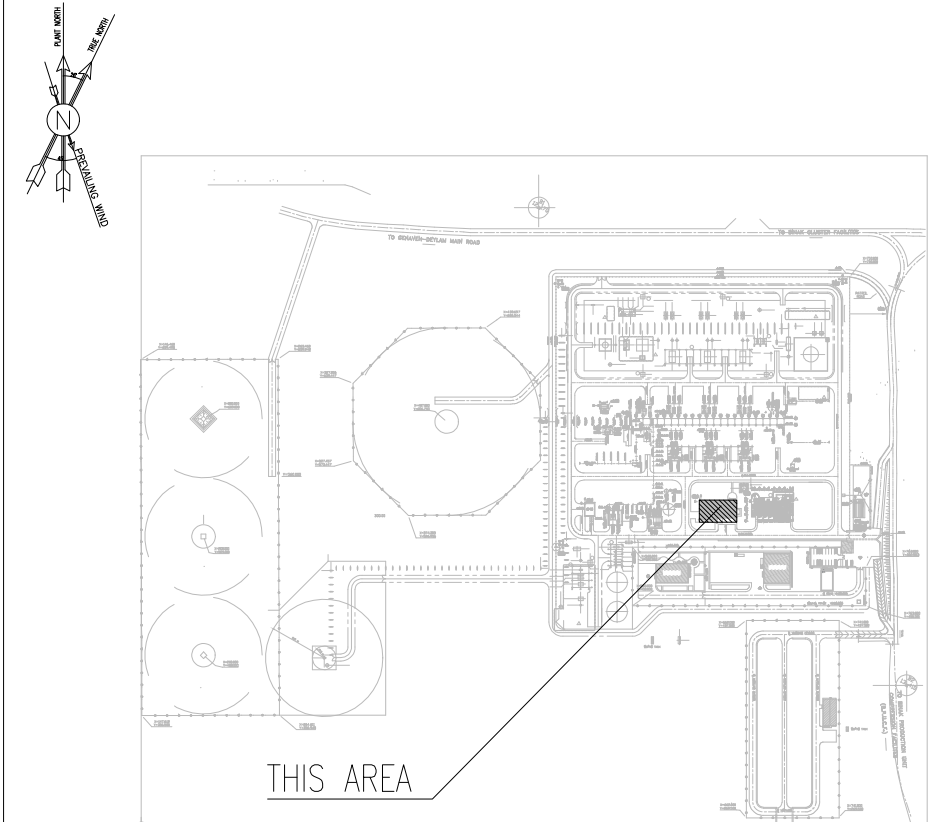


D04	NOV. 2024	AFC	R.BERLOUIE	M.FAKHARIAN	M.SADDEGHAN	***									
D03	MAR. 2024	AFC	R.BERLOUIE	M.FAKHARIAN	S.Paramarspour	***									
D02	NOV. 2023	AFC	R.BERLOUIE	M.FAKHARIAN	S.Paramarspour	***									
D01	SEP. 2023	IFA	R.BERLOUIE	M.FAKHARIAN	A.M.MOHSENI	***									
D00	JUN. 2023	IPC	R.BERLOUIE	M.FAKHARIAN	A.M.MOHSENI	***									
REV.	DATE	P.O.I.S	PREP.	CHK.	APP.	AUT.									
PROJECT NAME:							BINAK OILFIELD DEVELOPMENT/SURFACE FACILITIES GAS COMPRESSOR STATION								
PROJECT NO.:							971020								
EPC CONTRACTOR:							EPD/EPC CONTRACTOR (GC):								
HIRGAN ENERGY - DESIGN & INSPECTION COMPANIES							PETROIRAN DEVELOPMENT COMPANY								
DRAWING TITLE:							BINAK OILFIELD DEVELOPMENT SURFACE FACILITIES GAS COMPRESSOR STATION								
Architectural Detail Drawing For Extension of EXISTING Control Building SUSPENDED CEILING PLAN							NO CONSTRUCTION PERMITTED UNLESS DRAWING APPROVED								
APPROVED FOR CONSTRUCTION							BY:								
SCALE	SIZE	DRAWING NO.		SHEET NO.		REV.	BUDGET REF.	LOCATION	SIZE CLASS	SERIAL NO.		SHEET		REVISION	
AS SHOWN	A1	BK-GCS-PEDCO-120-AR-DW-0011		04 OF 13		D04	053-073-9184	F	4	B		709518		04 OF 13	

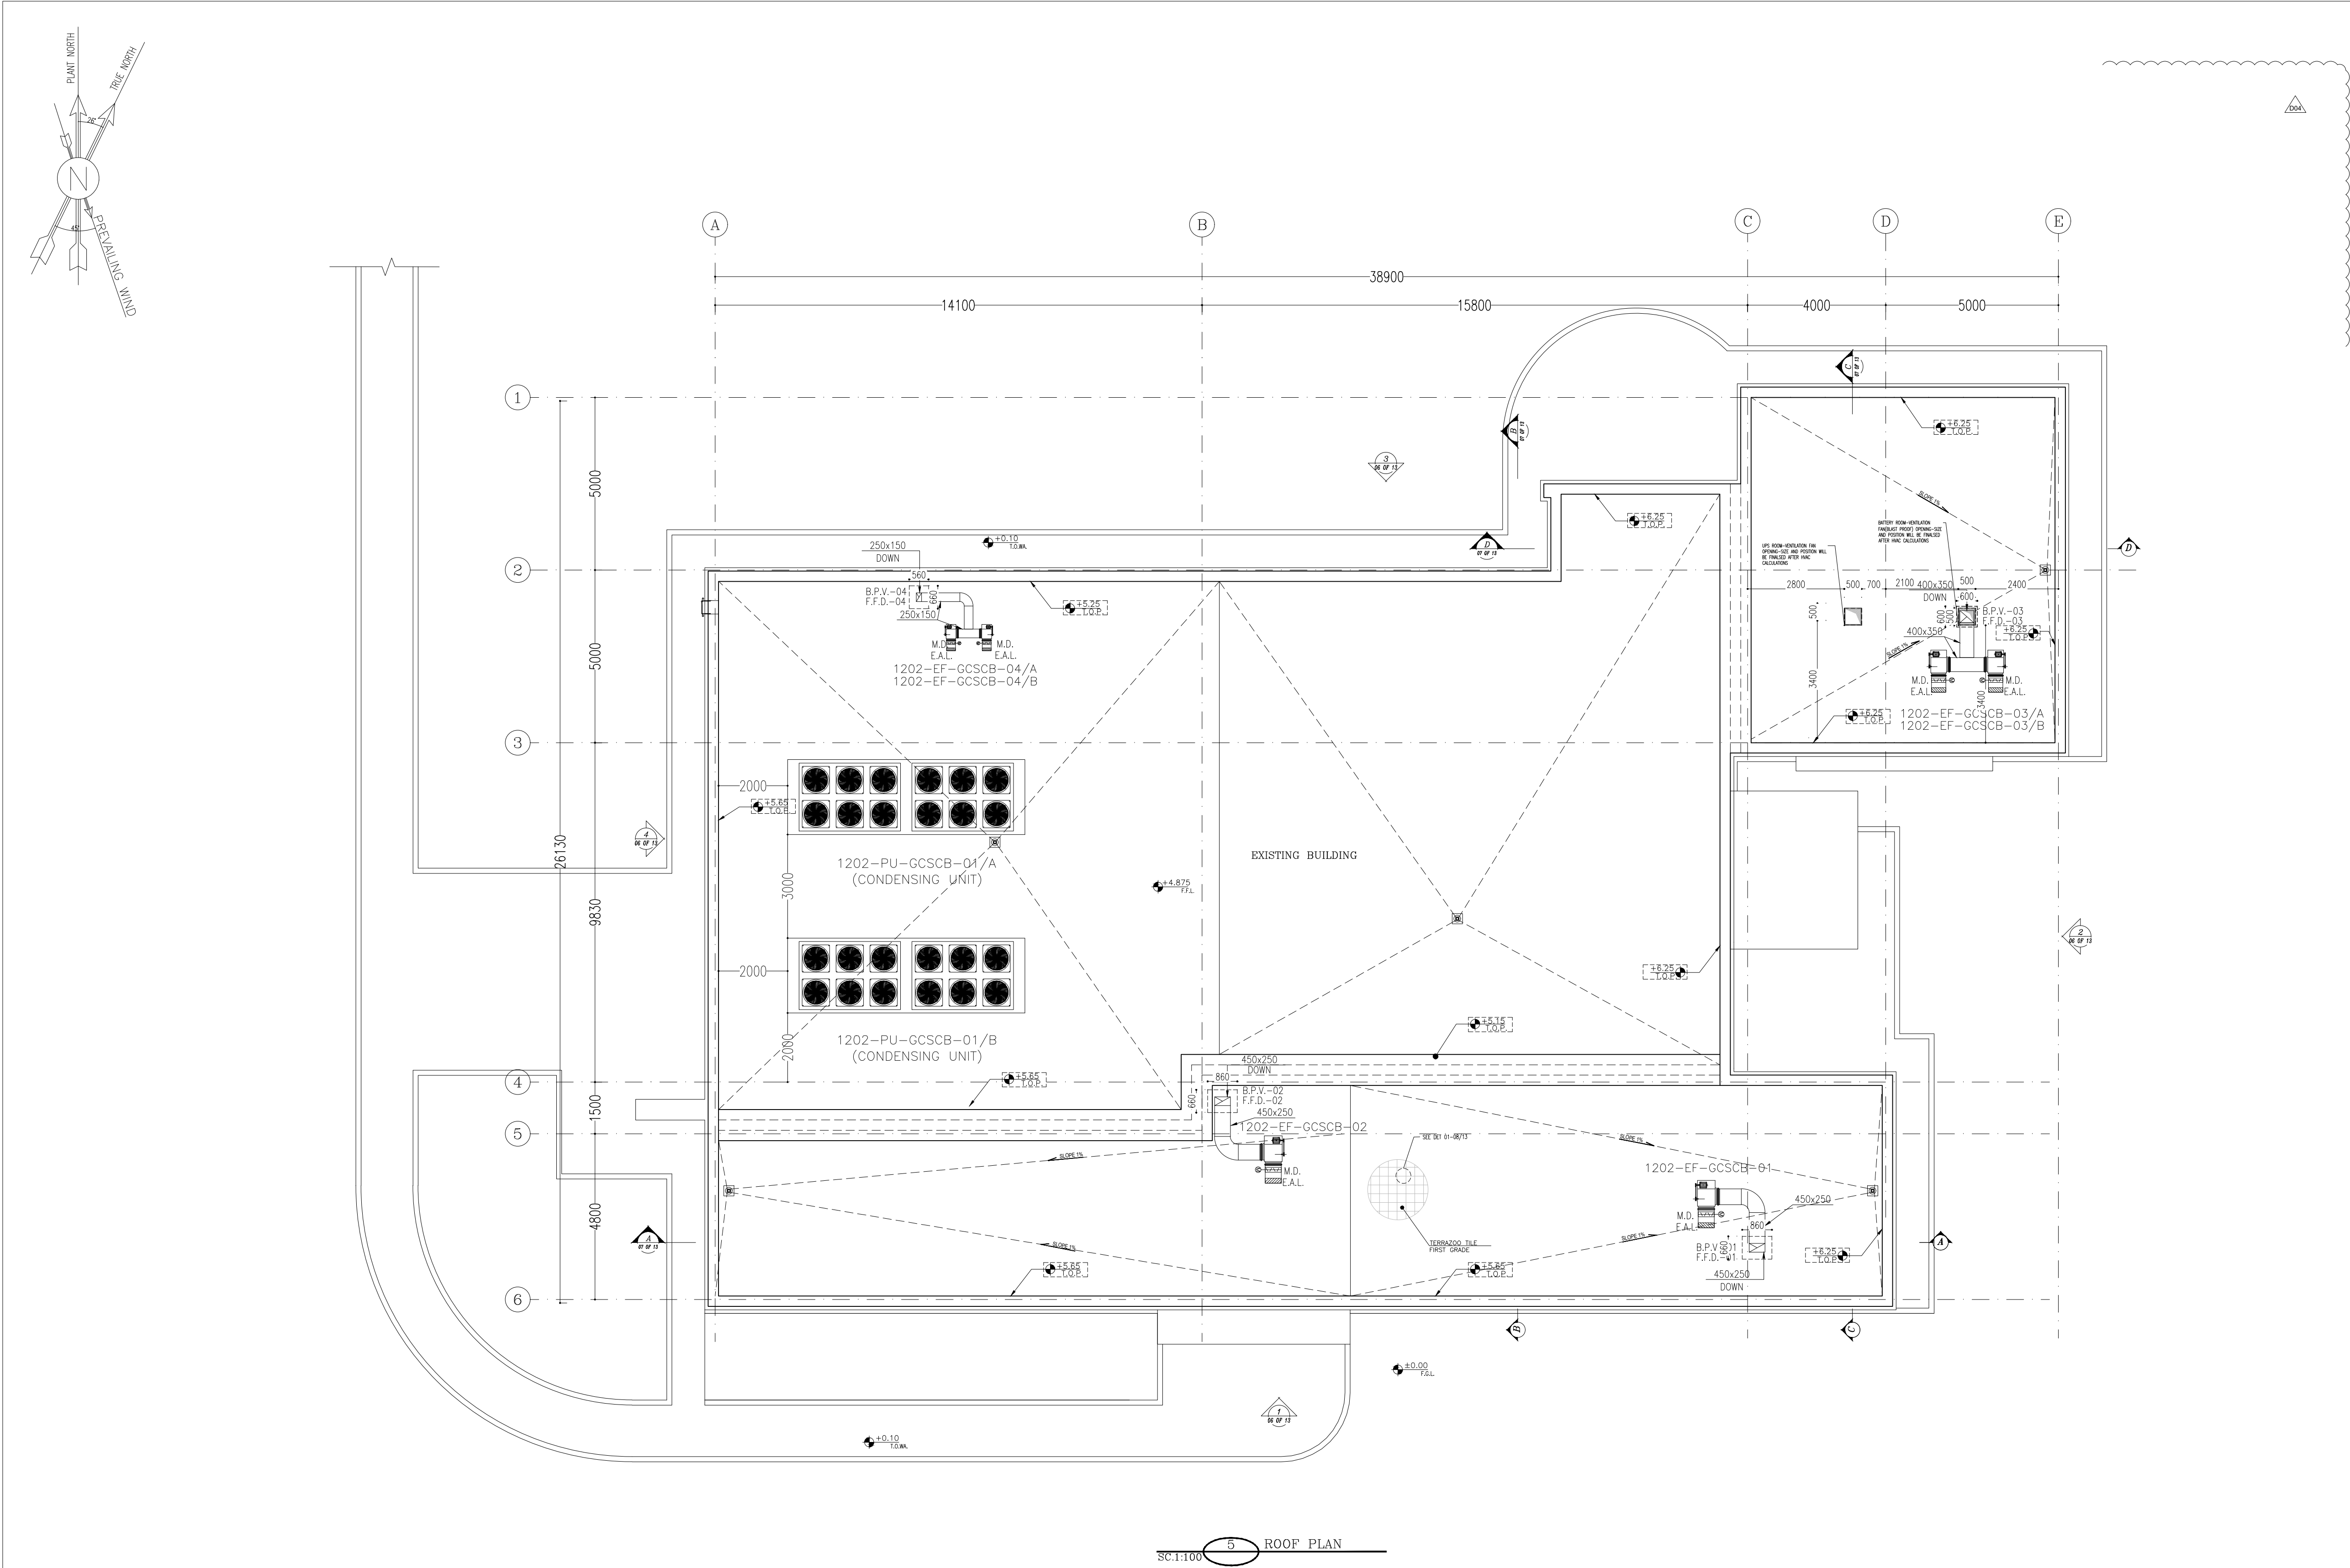

- NOTES**
1. ALL DIMENSIONS ARE IN MILLIMETER & ALL ELEVATIONS ARE IN METER.
 2. ALL DIMENSIONS AND ELEVATIONS SHALL BE CHECKED BY THE CONTRACTOR PRIOR TO CONSTRUCTION.
 3. CONTRACTOR SHALL COMPARE ALL ARCHITECTURAL, MECHANICAL, ELECTRICAL, PIPING AND STRUCTURAL DRAWINGS AND IN CASE OF ANY CONFLICTS OR DISCREPANCY, INFORM THE ENGINEER.
 4. ALL MATERIALS ARE SELECTED FROM THE HIGHEST QUALITY AND MUST BE APPROVED BY THE CLIENT.
 5. ALL OPENINGS FOR PIPING/CABLING AND HVAC OPENINGS SHALL BE CONSIDERED AS PER RELATED DRAWINGS BEFORE CONSTRUCTION.
 6. FINISH GRADING LEVEL (F.G.L.) : ± 0.00 (LOCAL) = 99.70
- LEGEND**
- F.F.L. FINISHED FLOOR LEVEL
T.O.WA. TOP OF WALKWAY
T.O.P. TOP OF PARAPET
T.O.S. TOP OF SLAB
T.O.D. TOP OF DOOR
T.O.W. TOP OF WINDOW
B.O.W. BOTTOM OF WINDOW
T.O.C. TOP OF CAGE
B.O.C. BOTTOM OF CAGE
B.O.F. BOTTOM OF FALSE FLOOR
B.O.SU. BOTTOM OF SUSPENDED
B.O.S. BOTTOM OF SLEEVE
H.P.G. HIGH POINT GRAVEL

TERRAZOO TILE

REFERENCE DRAWING	DRG. No.
STANDARD DRAWING FOR ARCHITECTURAL DETAILS	BK-GNRL-PEDCO-000-AR-DW-0001
SITE SEWORAGE SYSTEM LAYOUT & DETAILS	BK-GCS-PEDCO-120-CY-PY-0001
CONTROL ROOM LAYOUT & ARRANGEMENT DRAWING	BK-GCS-PEDCO-120-IN-PY-0001
ROAD, PAVING AND PLANT FINISH GRADING LAYOUT & SECTIONS	BK-GCS-PEDCO-120-CY-PY-0005
ELECTRICAL CABLE ROUTE & SECTION LAYOUT FOR BUILDING & SHELTER	BK-GCS-PEDCO-120-EL-PY-0006
FOUNDATION DRAWING FOR EXTENSION OF CONTROL BUILDING	BK-GNRL-PEDCO-220-ST-DW-0004
STRUCTURAL DRAWING FOR EXTENSION OF CONTROL BUILDING	BK-GNRL-PEDCO-220-ST-DW-0005
STANDARD DETAILS FOR LADDER & SAFETY CAGE	BK-GNRL-PEDCO-000-ST-DW-0009
AREA ELECTRICAL CABLE ROUTE & SECTION LAYOUT	BK-GCS-PEDCO-120-EL-PY-0005
UNIT PLAT PLAN DRAWING	BK-PPL-PEDCO-000-PI-PY-0001
CONTROL ROOM CABLE ROUTE LAYOUT	BK-GCS-PEDCO-120-IN-PY-0002
INSTRUMENT/PAG CABLE TRENCH/ROUTE LAYOUT DRAWING	BK-GCS-PEDCO-120-IN-PY-0004
ELECTRICAL EQUIPMENT ARRANGEMENT LAYOUT FOR BUILDING	BK-GCS-PEDCO-120-EL-PY-0008

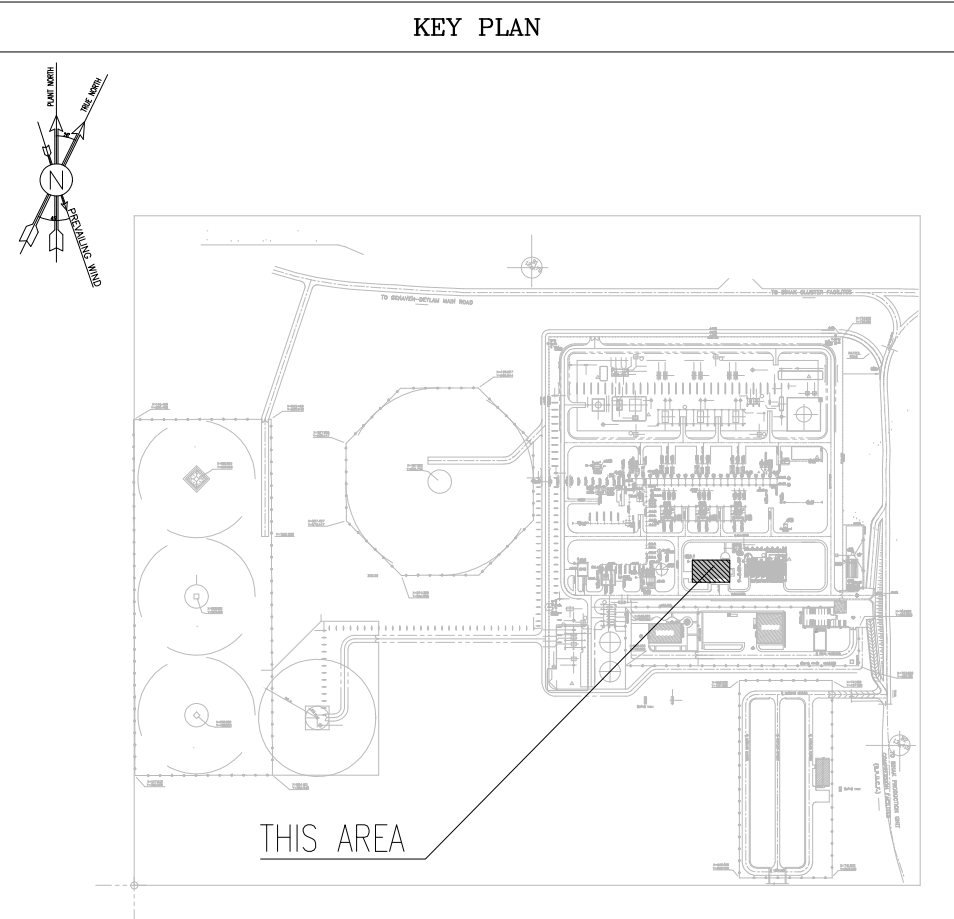

D04	NOV.2024	AFC	R.BERLOUIE	M.FAKHARIAN	M.SADDEGHAN	***									
D03	MAR.2024	AFC	R.BERLOUIE	M.FAKHARIAN	S.Paramarspour	***									
D02	NOV.2023	AFC	R.BERLOUIE	M.FAKHARIAN	S.Paramarspour	***									
D01	SEP.2023	IFA	R.BERLOUIE	M.FAKHARIAN	A.M.MOHSENI	***									
D00	JUN.2023	IPC	R.BERLOUIE	M.FAKHARIAN	A.M.MOHSENI	***									
REV.	DATE	P.O.I.S	PREP.	CHK.	APP.	AUT.									
PROJECT NAME:							BINAK OILFIELD DEVELOPMENT/SURFACE FACILITIES GAS COMPRESSOR STATION								
PROJECT NO.:							971020								
EPC CONTRACTOR:							EPD/EPC CONTRACTOR (GC):								
 HIRGAN ENERGY - DESIGN & INSPECTION COMPANIES							 PETROIRAN DEVELOPMENT COMPANY								
DRAWING TITLE:							BINAK OILFIELD DEVELOPMENT SURFACE FACILITIES GAS COMPRESSOR STATION								
Architectural Detail Drawing For Extension of EXISTING Control Building							NO CONSTRUCTION PERMITTED UNLESS DRAWING APPROVED								
Roof Plan							APPROVED FOR CONSTRUCTION								
SCALE	SIZE	DRAWING NO.			SHEET NO.	REV.	BUDGET REF.	LOCATION	SIZE CLASS	SERIAL NO.	SHEET	REVISION	DATE:		
AS SHOWN	A1	BK-GCS-PEDCO-120-AR-DW-0011			05 OF 13	D04	053-073-9184	F	4	B	709518	05 OF 13	D04		

- NOTES
1. ALL DIMENSIONS ARE IN MILLIMETER & ALL ELEVATIONS ARE IN METER.

2. ALL DIMENSIONS AND ELEVATIONS SHALL BE CHECKED BY THE CONTRACTOR PRIOR TO CONSTRUCTION.

3. CONTRACTOR SHALL COMPARE ALL ARCHITECTURAL, MECHANICAL, ELECTRICAL, PIPING AND STRUCTURAL DRAWINGS AND IN CASE OF ANY CONFLICTS OR DISCREPANCY, INFORM THE ENGINEER.

4. ALL MATERIALS ARE SELECTED FROM THE HIGHEST QUALITY AND MUST BE APPROVED BY THE CLIENT.

5. ALL OPENINGS FOR PIPING/CABLING AND HVAC OPENINGS SHALL BE CONSIDERED AS PER RELATED DRAWINGS BEFORE CONSTRUCTION.

6. FINISH GRADING LEVEL (F.G.L.) : ± 0.00 (LOCAL) = 99.70

- LEGEND
- F.F.L. FINISHED FLOOR LEVEL

T.O.WA. TOP OF WALKWAY

T.O.P. TOP OF PARAPET

T.O.S. TOP OF SLAB

T.O.D. TOP OF DOOR

T.O.W. TOP OF WINDOW

B.O.W. BOTTOM OF WINDOW

T.O.C. TOP OF CAGE

B.O.C. BOTTOM OF CAGE


B.O.F. BOTTOM OF FALSE FLOOR

B.O.SU. BOTTOM OF SUSPENDED

B.O.S. BOTTOM OF SLEEVE

H.P.G. HIGH POINT GRAVEL

REFERENCE DRAWING	DRG. No.
STANDARD DRAWING FOR ARCHITECTURAL DETAILS	BK-GNRL-PEDCO-000-AR-DW-0001
SITE SEWORAGE SYSTEM LAYOUT & DETAILS	BK-GCS-PEDCO-120-CY-PY-0001
CONTROL ROOM LAYOUT & ARRANGEMENT DRAWING	BK-GCS-PEDCO-120-IN-PY-0001
ROAD, PAVING AND PLANT FINISH GRADING LAYOUT & SECTIONS	BK-GCS-PEDCO-120-CY-PY-0005
ELECTRICAL CABLE ROUTE & SECTION LAYOUT FOR BUILDING & SHELTER	BK-GCS-PEDCO-120-EL-PY-0006
FOUNDATION DRAWING FOR EXTENSION OF CONTROL BUILDING	BK-GNRL-PEDCO-220-ST-DW-0004
STRUCTURAL DRAWING FOR EXTENSION OF CONTROL BUILDING	BK-GNRL-PEDCO-220-ST-DW-0005
STANDARD DETAILS FOR LADDER & SAFETY CAGE	BK-GNRL-PEDCO-000-ST-DW-0009
AREA ELECTRICAL CABLE ROUTE & SECTION LAYOUT	BK-GCS-PEDCO-120-EL-PY-0005
UNIT PLOT PLAN DRAWING	BK-PPL-PEDCO-120-PI-PY-0001
CONTROL ROOM CABLE ROUTE LAYOUT	BK-GCS-PEDCO-120-IN-PY-0002
INTRUMENT/PAG CABLE TRENCH/ROUTE LAYOUT DRAWING	BK-GCS-PEDCO-120-IN-PY-0004
ELECTRICAL EQUIPMENT ARRANGEMENT LAYOUT FOR BUILDING	BK-GCS-PEDCO-120-EL-PY-0008

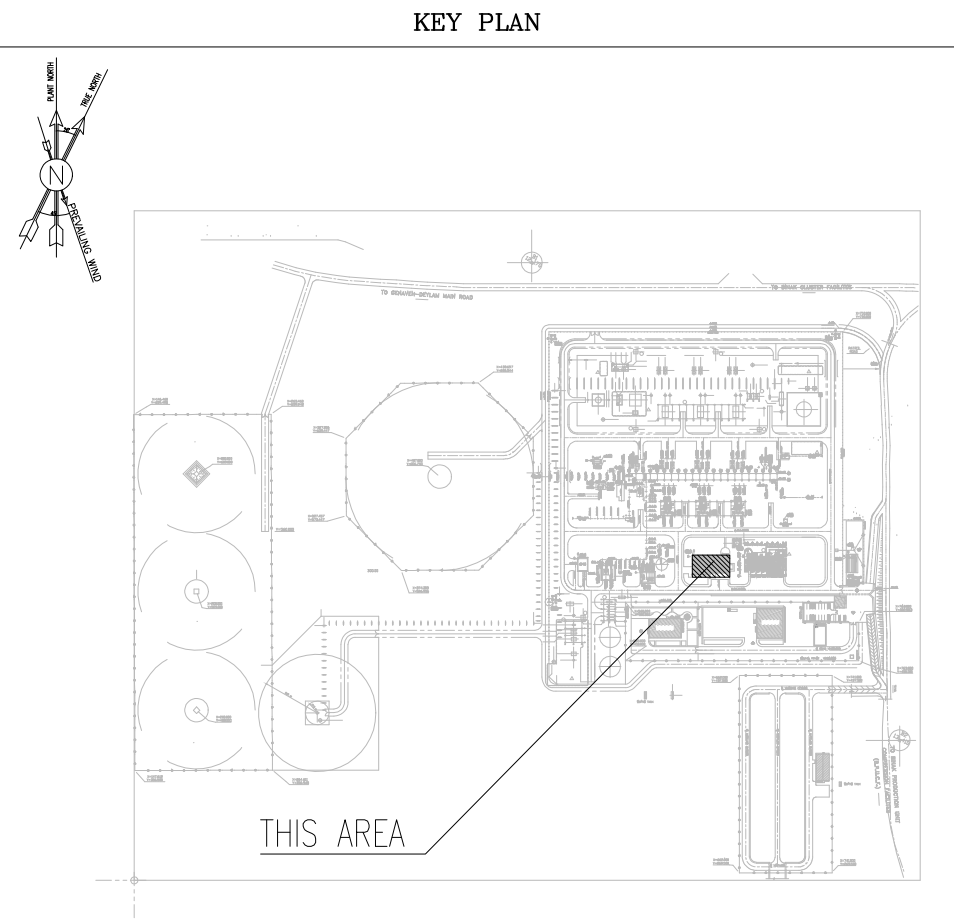


D04	NOV. 2024	AFC	R.BERLOUIE	M.FAKHARIAN	M.SADEGHIAN	***							
D03	MAR. 2024	AFC	R.BERLOUIE	M.FAKHARIAN	S.Paramarspour	***							
D02	NOV. 2023	AFC	R.BERLOUIE	M.FAKHARIAN	S.Paramarspour	***	***	*****	***	*****	***	*****	
D01	SEP. 2023	IFA	R.BERLOUIE	M.FAKHARIAN	A.M.MOHSENI	***	REV.	DESCRIPTION	BY	DATE	BY	DATE	
D00	JUN. 2023	IPC	R.BERLOUIE	M.FAKHARIAN	A.M.MOHSENI	***			CHECKED		REV. APPR.		
REV. DATE P.O.I.S PREP. CHK. APP. AUT.							اصل و کليه نسخ اين نقشه و اذن اقتباس متعلق به شرکت ملی مناطق نفت خيز جنوب ميباشد.						
PROJECT NAME: BINAK OILFIELD DEVELOPMENT/SURFACE FACILITIES GAS COMPRESSOR STATION								THE ORIGINAL AND ALL COPIES OF THIS DRAWING TOGETHER WITH THE COPYRIGHT THEREIN ARE THE SOLE PROPERTY OF N.I.S.O.C./ FIELDS					
PROJECT NO.: 971020													
EPC CONTRACTOR:			EPD/EPC CONTRACTOR (GC):				BINAK OILFIELD DEVELOPMENT SURFACE FACILITIES GAS COMPRESSOR STATION						
 HIRGAN ENERGY – DESIGN & INSPECTION COMPANIES			 PETROIRAN DEVELOPMENT COMPANY										
							DATE	SCALE	DRAWING BY	CHECKED BY	PROJECT ENG.		
DRAWING TITLE: Architectural Detail Drawing For Extension of EXISTING Control Building ELEVATIONS							NO CONSTRUCTION PERMITTED UNLESS DRAWING APPROVED						
							APPROVED FOR CONSTRUCTION			BY:		DATE:	
SCALE	SIZE	DRAWING NO.		SHEET NO.	REV.	BUDGET REF.	LOCATION	SIZE	CLASS	SERIAL NO.	SHEET	REVISION	
AS SHOWN	A1	BK-GCS-PEDCO-120-AR-DW-0011		06 OF 13	D04	053-073-9184	F	4	B	709518	06 OF 13	D04	

اصل و کلیه نسخ این نقشه و حق اقتباس متعلق به شرکت ملی مناطق نفت خیز جنوب میباشد.

THE ORIGINAL AND ALL COPIES OF THIS DRAWING TOGETHER WITH THE COPYRIGHT THEREIN ARE THE SOLE PROPERTY OF N.I.S.O.C./ FIELDS

100	CONTROL ROOM
101	UPS
102	BATTERY ROOM
103	PANTRY
104	DINING ROOM
105	ENTRANCE
106	MANAGEMENT ROOM
107	CONFERENCE ROOM
108	ARCHIVE
109	LOCKER
110	PRAYER ROOM
111	STORE
112	CORRIDOR
113	AIR LOCK

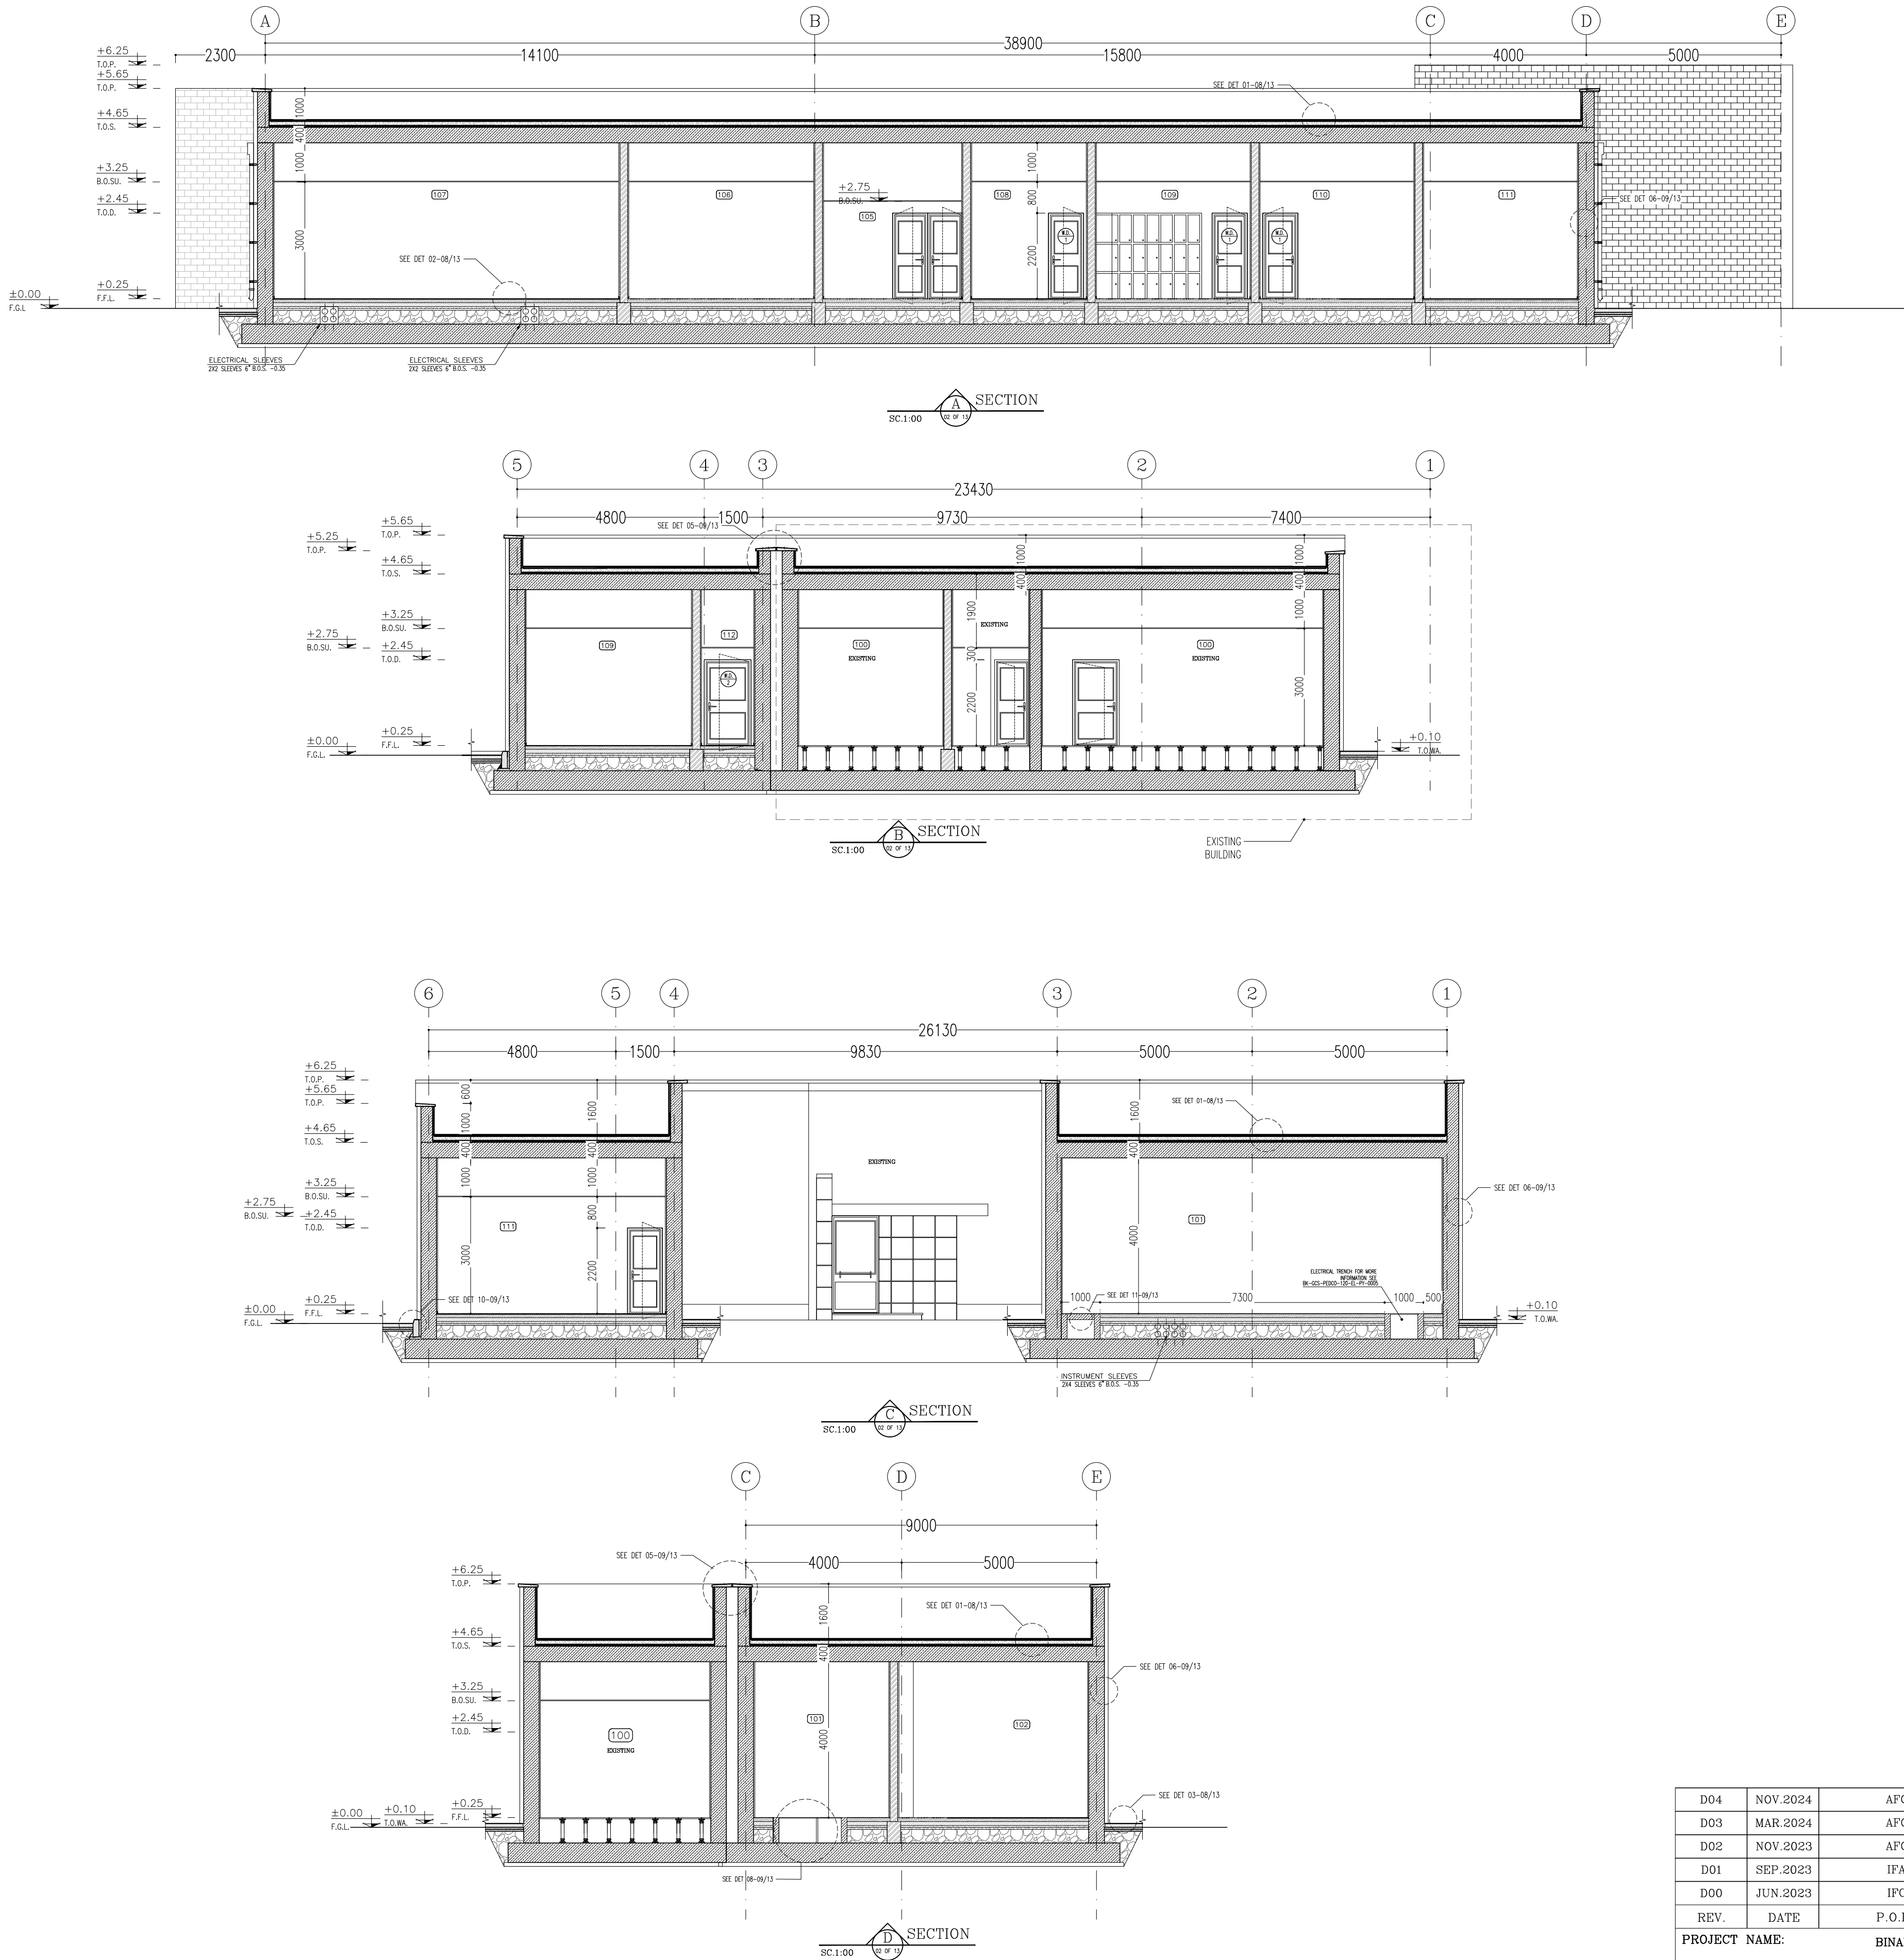


- NOTES
1. ALL DIMENSIONS ARE IN MILLIMETER & ALL ELEVATIONS ARE IN METER.
 2. ALL DIMENSIONS AND ELEVATIONS SHALL BE CHECKED BY THE CONTRACTOR PRIOR TO CONSTRUCTION.
 3. CONTRACTOR SHALL COMPARE ALL ARCHITECTURAL, MECHANICAL, ELECTRICAL, PIPING AND STRUCTURAL DRAWINGS AND IN CASE OF ANY CONFLICTS OR DISCREPANCY, INFORM THE ENGINEER.
 4. ALL MATERIALS ARE SELECTED FROM THE HIGHEST QUALITY AND MUST BE APPROVED BY THE CLIENT.
 5. ALL OPENINGS FOR PIPING/CABLING AND HVAC OPENINGS SHALL BE CONSIDERED AS PER RELATED DRAWINGS BEFORE CONSTRUCTION.
 6. FINISH GRADING LEVEL (F.G.L.) : ± 0.00 (LOCAL) = 99.70


- LEGEND
- F.F.L. FINISHED FLOOR LEVEL
T.O.W.A. TOP OF WALKWAY
T.O.P. TOP OF PARAPET
T.O.S. TOP OF SLAB
T.O.D. TOP OF DOOR
T.O.W. TOP OF WINDOW
B.O.W. BOTTOM OF WINDOW
T.O.C. TOP OF CAGE
B.O.C. BOTTOM OF CAGE
B.O.F. BOTTOM OF FALSE FLOOR
B.O.SU. BOTTOM OF SUSPENDED
B.O.S. BOTTOM OF SLEEVE
H.P.G. HIGH POINT GRAVEL

- BRICK WORK
REINFORCED CONCRETE
LEAN CONCRETE
SAND CEMENT MORTAR
BLOCKAGE

REFERENCE DRAWING	DRG. No.
STANDARD DRAWING FOR ARCHITECTURAL DETAILS	BK-GNRL-PEDCO-000-AR-DW-0001
SITE SEWAGE SYSTEM LAYOUT & DETAILS	BK-GCS-PEDCO-120-CY-PY-0001
CONTROL ROOM LAYOUT & ARRANGEMENT DRAWING	BK-GCS-PEDCO-120-IN-PY-0001
ROAD, PAVING AND PLANT FINISH GRADING LAYOUT & SECTIONS	BK-GCS-PEDCO-120-CY-PY-0005
ELECTRICAL CABLE ROUTE & SECTION LAYOUT FOR BUILDING & SHELTER	BK-GCS-PEDCO-120-EL-PY-0006
FOUNDATION DRAWING FOR EXTENSION OF CONTROL BUILDING	BK-GNRL-PEDCO-220-ST-DW-0004
STRUCTURAL DRAWING FOR EXTENSION OF CONTROL BUILDING	BK-GNRL-PEDCO-220-ST-DW-0005
STANDARD DETAILS FOR LADDER & SAFETY CAGE	BK-GNRL-PEDCO-000-ST-DW-0009
AREA ELECTRICAL CABLE ROUTE & SECTION LAYOUT	BK-GCS-PEDCO-120-EL-PY-0005
UNIT FLOOR PLAN DRAWING	BK-PPL-PEDCO-000-PI-PY-0001
CONTROL ROOM CABLE ROUTE LAYOUT	BK-GCS-PEDCO-120-IN-PY-0002
INSTRUMENT/PAG CABLE TRENCH/ROUTE LAYOUT DRAWING	BK-GCS-PEDCO-120-IN-PY-0004
ELECTRICAL EQUIPMENT ARRANGEMENT LAYOUT FOR BUILDING	BK-GCS-PEDCO-120-EL-PY-0008

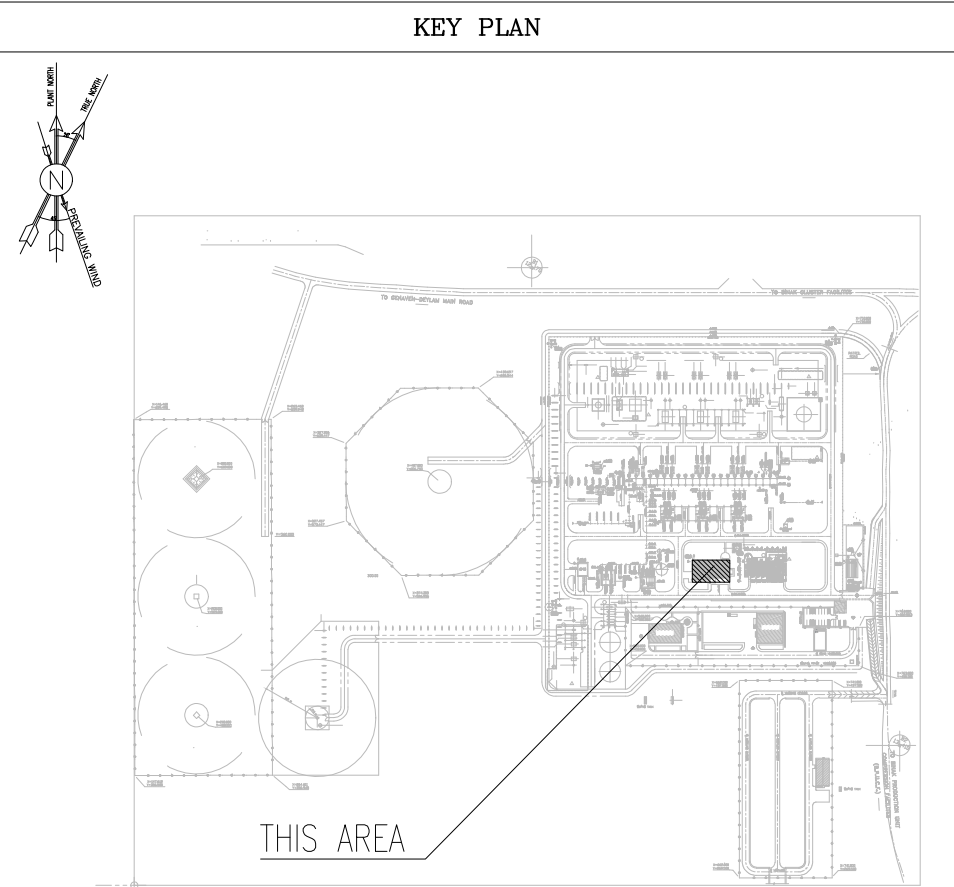


D04	NOV. 2024	AFC	R.BERLOUIE	M.FAKHARIAN	M.SADDEGHAN	***														
D03	MAR. 2024	AFC	R.BERLOUIE	M.FAKHARIAN	S.Paramarspour	***														
D02	NOV. 2023	AFC	R.BERLOUIE	M.FAKHARIAN	S.Paramarspour	***	***	*****	*** **	*** ****	*** **	*** ****								
D01	SEP. 2023	IFA	R.BERLOUIE	M.FAKHARIAN	A.M.MOHSENI	***														
D00	JUN. 2023	IFC	R.BERLOUIE	M.FAKHARIAN	A.M.MOHSENI	***	REV.	DESCRIPTION	BY	DATE	BY	DATE	BY	DATE	BY	DATE	BY	DATE	BY	
REV.	DATE	P.O.I.S	PREP.	CHK.	APP.	AUT.	اصل و کلیه نسخ این نقشه و حق اقتباسی متعلق به شرکت ملی مناطق نفت خیز جنوب می باشد.													
PROJECT NAME:							BINAK OILFIELD DEVELOPMENT/SURFACE FACILITIES GAS COMPRESSOR STATION													
PROJECT NO.:							971020													
EPC CONTRACTOR:							EPD/EPC CONTRACTOR (GC):							BINAK OILFIELD DEVELOPMENT SURFACE FACILITIES GAS COMPRESSOR STATION						
 HIRGAN ENERGY – DESIGN & INSPECTION COMPANIES							 PETROIRAN DEVELOPMENT COMPANY							 THE ORIGINAL AND ALL COPIES OF THIS DRAWING TOGETHER WITH THE COPYRIGHT THEREIN ARE THE SOLE PROPERTY OF N.I.S.O.C./ FIELDS						
DRAWING TITLE:							NO CONSTRUCTION PERMITTED UNLESS DRAWING APPROVED													
Architectural Detail Drawing For Extension of EXISTING Control Building SECTIONS							APPROVED FOR CONSTRUCTION													
SCALE	SIZE	DRAWING NO.			SHEET NO.		REV.	BUDGET REF.	LOCATION	SIZE	CLASS	SERIAL NO.		SHEET		REVISION				
AS SHOWN	A1	BK-GCS-PEDCO-120-AR-DW-0011			07 OF 13		D04	053-073-9184	F	4	B	709518		07 OF 13		D04				

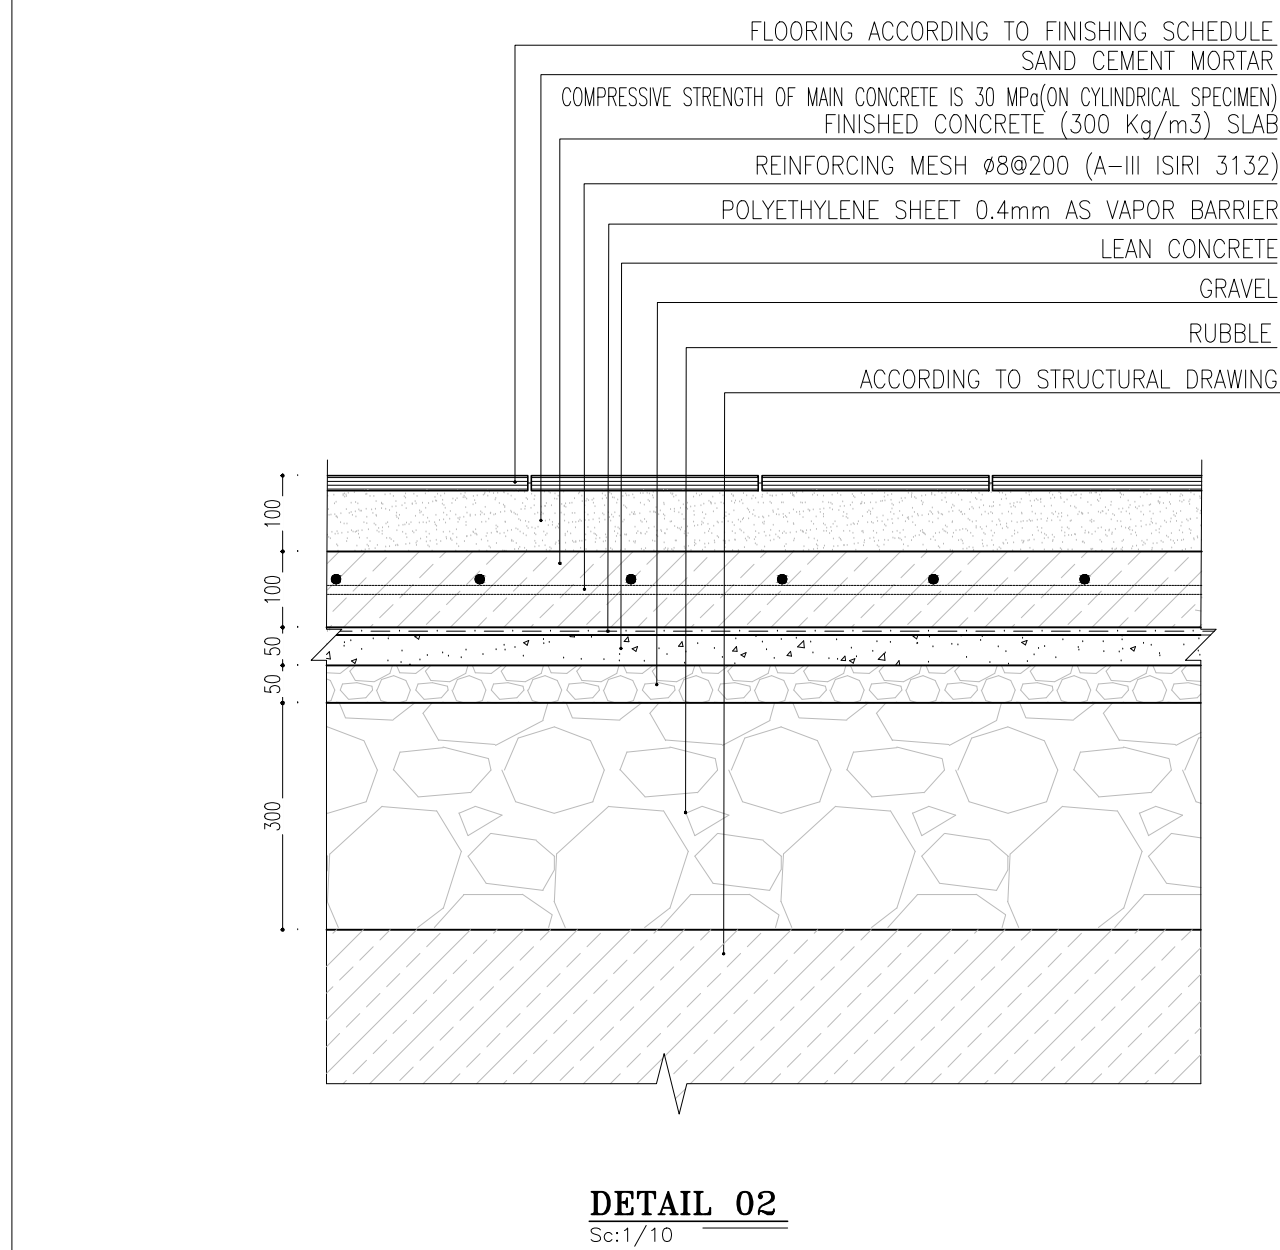

Sc:1/10

 6 FINISHING SCHEDULE

[illegible]


AS SHOWN	A1	BK-GCS-PEDCO-120-AR-DW-0011	08 OF 13	D04
----------	----	-----------------------------	----------	-----

	BRICK WORK
	REINFORCED CONCRETE
	LEAN CONCRETE
	SAND CEMENT MORTAR
	GRAVEL
	RUBBLE


KEY PLAN

 THE ORIGINAL AND ALL COPIES OF THIS DRAWING TOGETHER WITH
THE COPYRIGHT THEREIN ARE THE SOLE PROPERTY OF




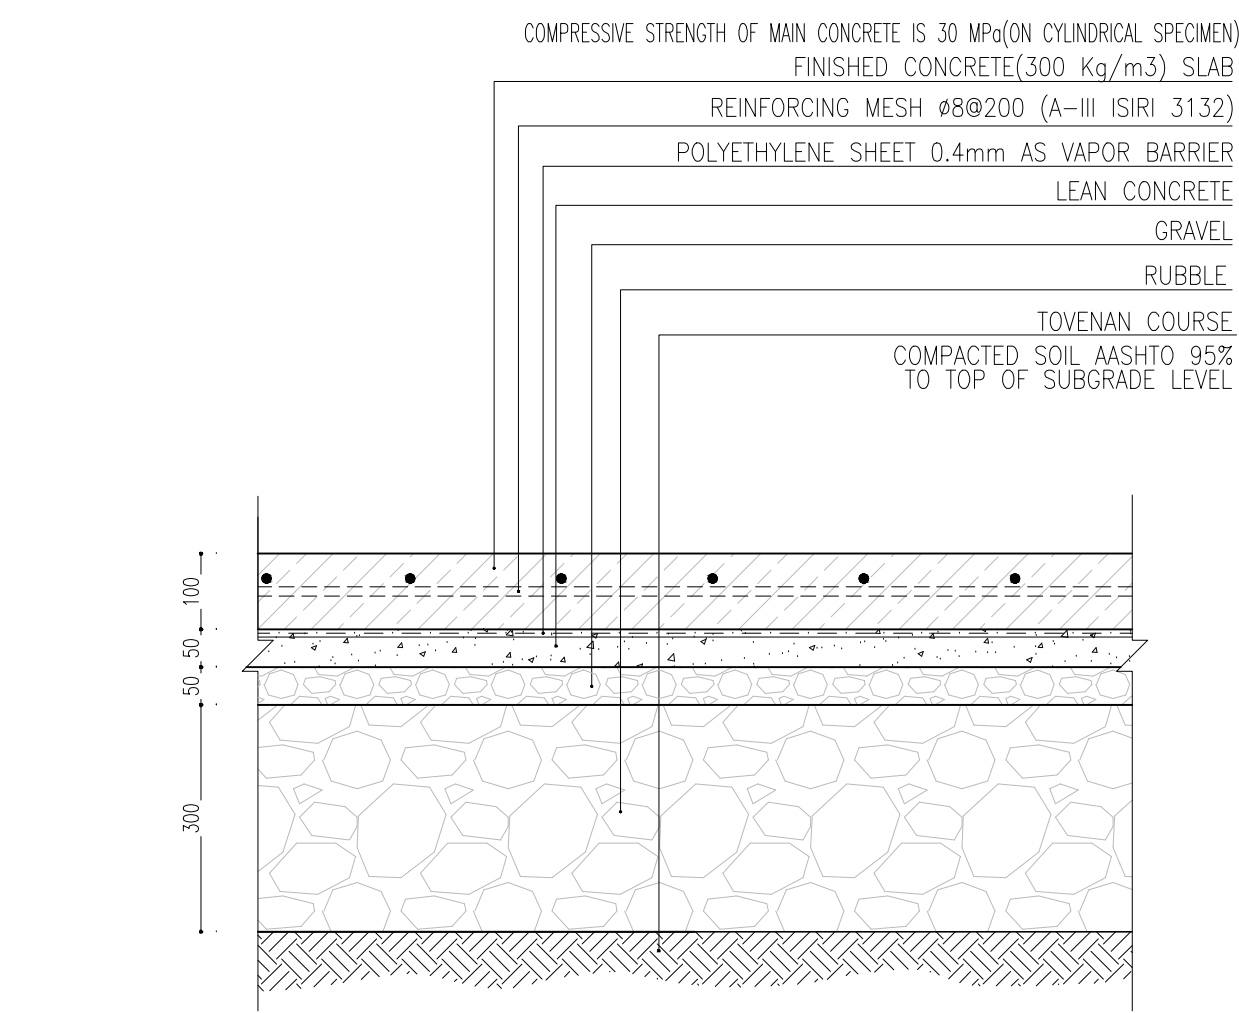


DETAIL 03
Sc:1/10

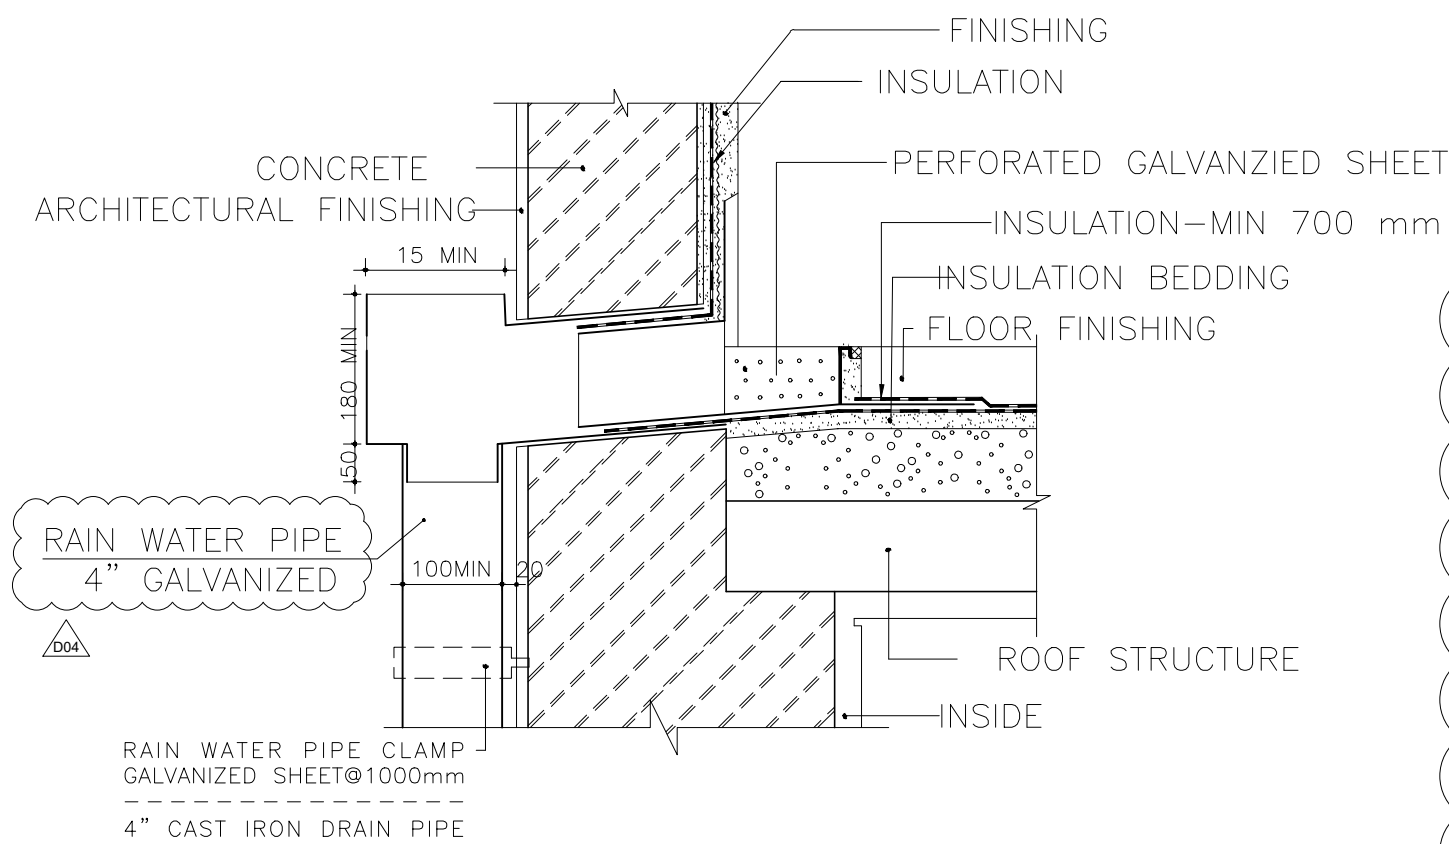


DETAIL 04 (RAIN WATER DISPOSAL DETAIL)
Sc:1/10

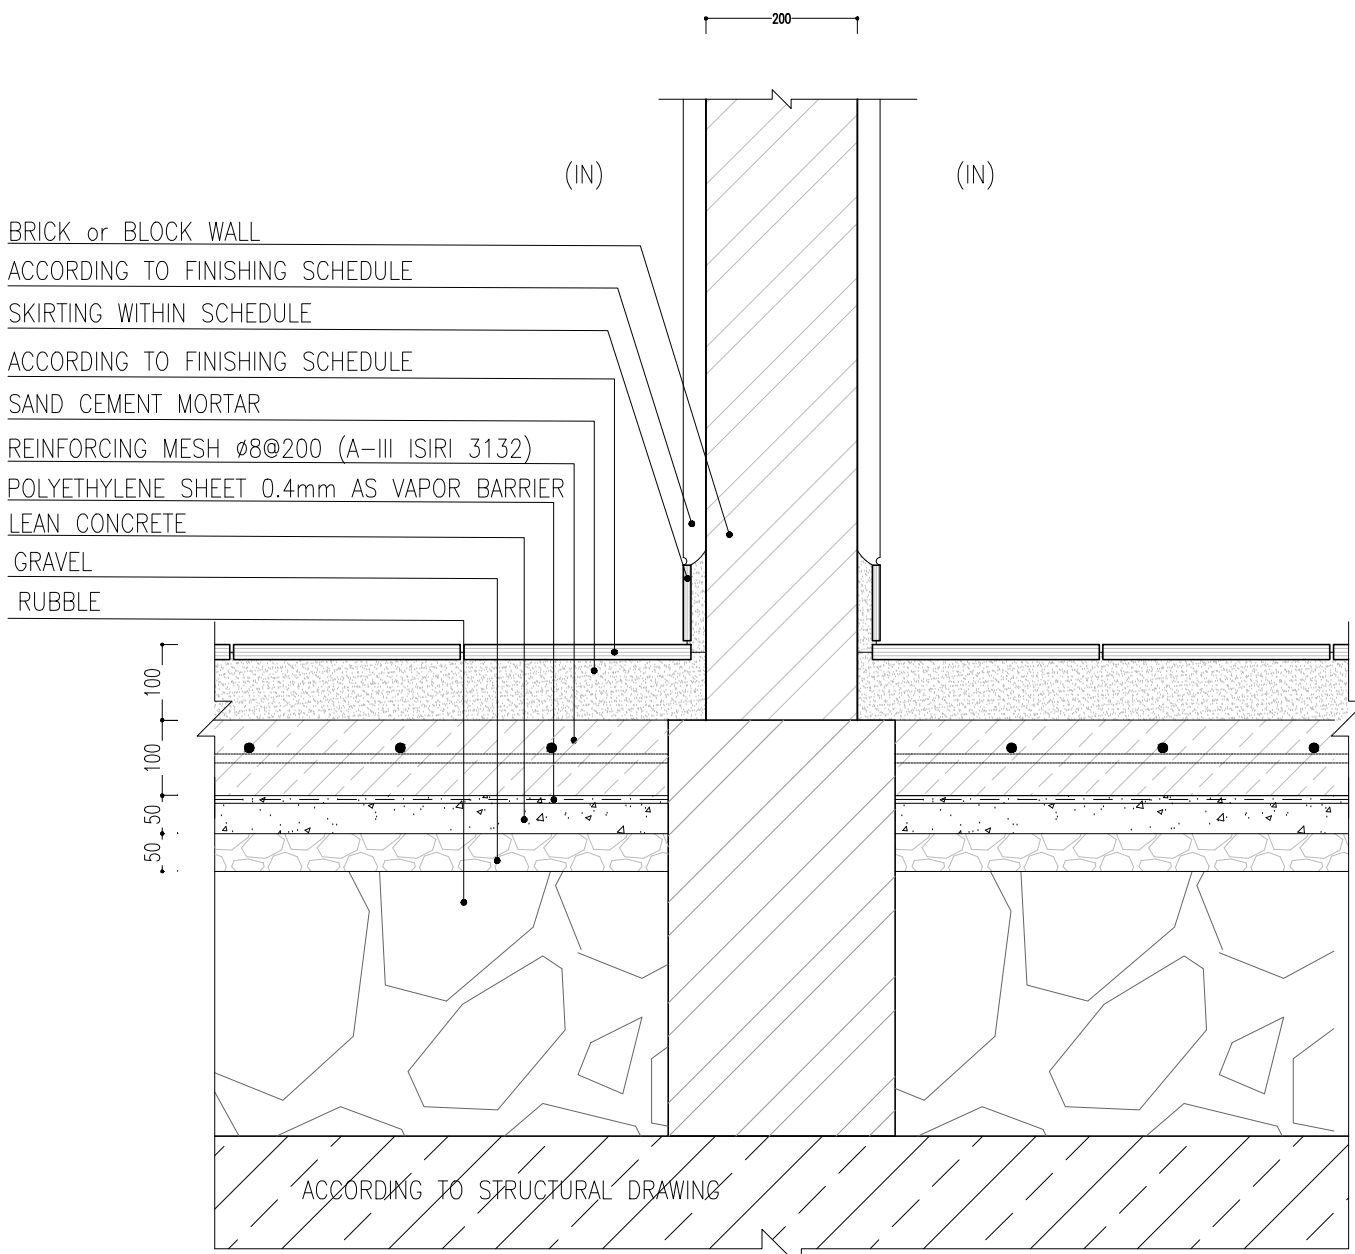


DETAIL 07
Sc:1/10

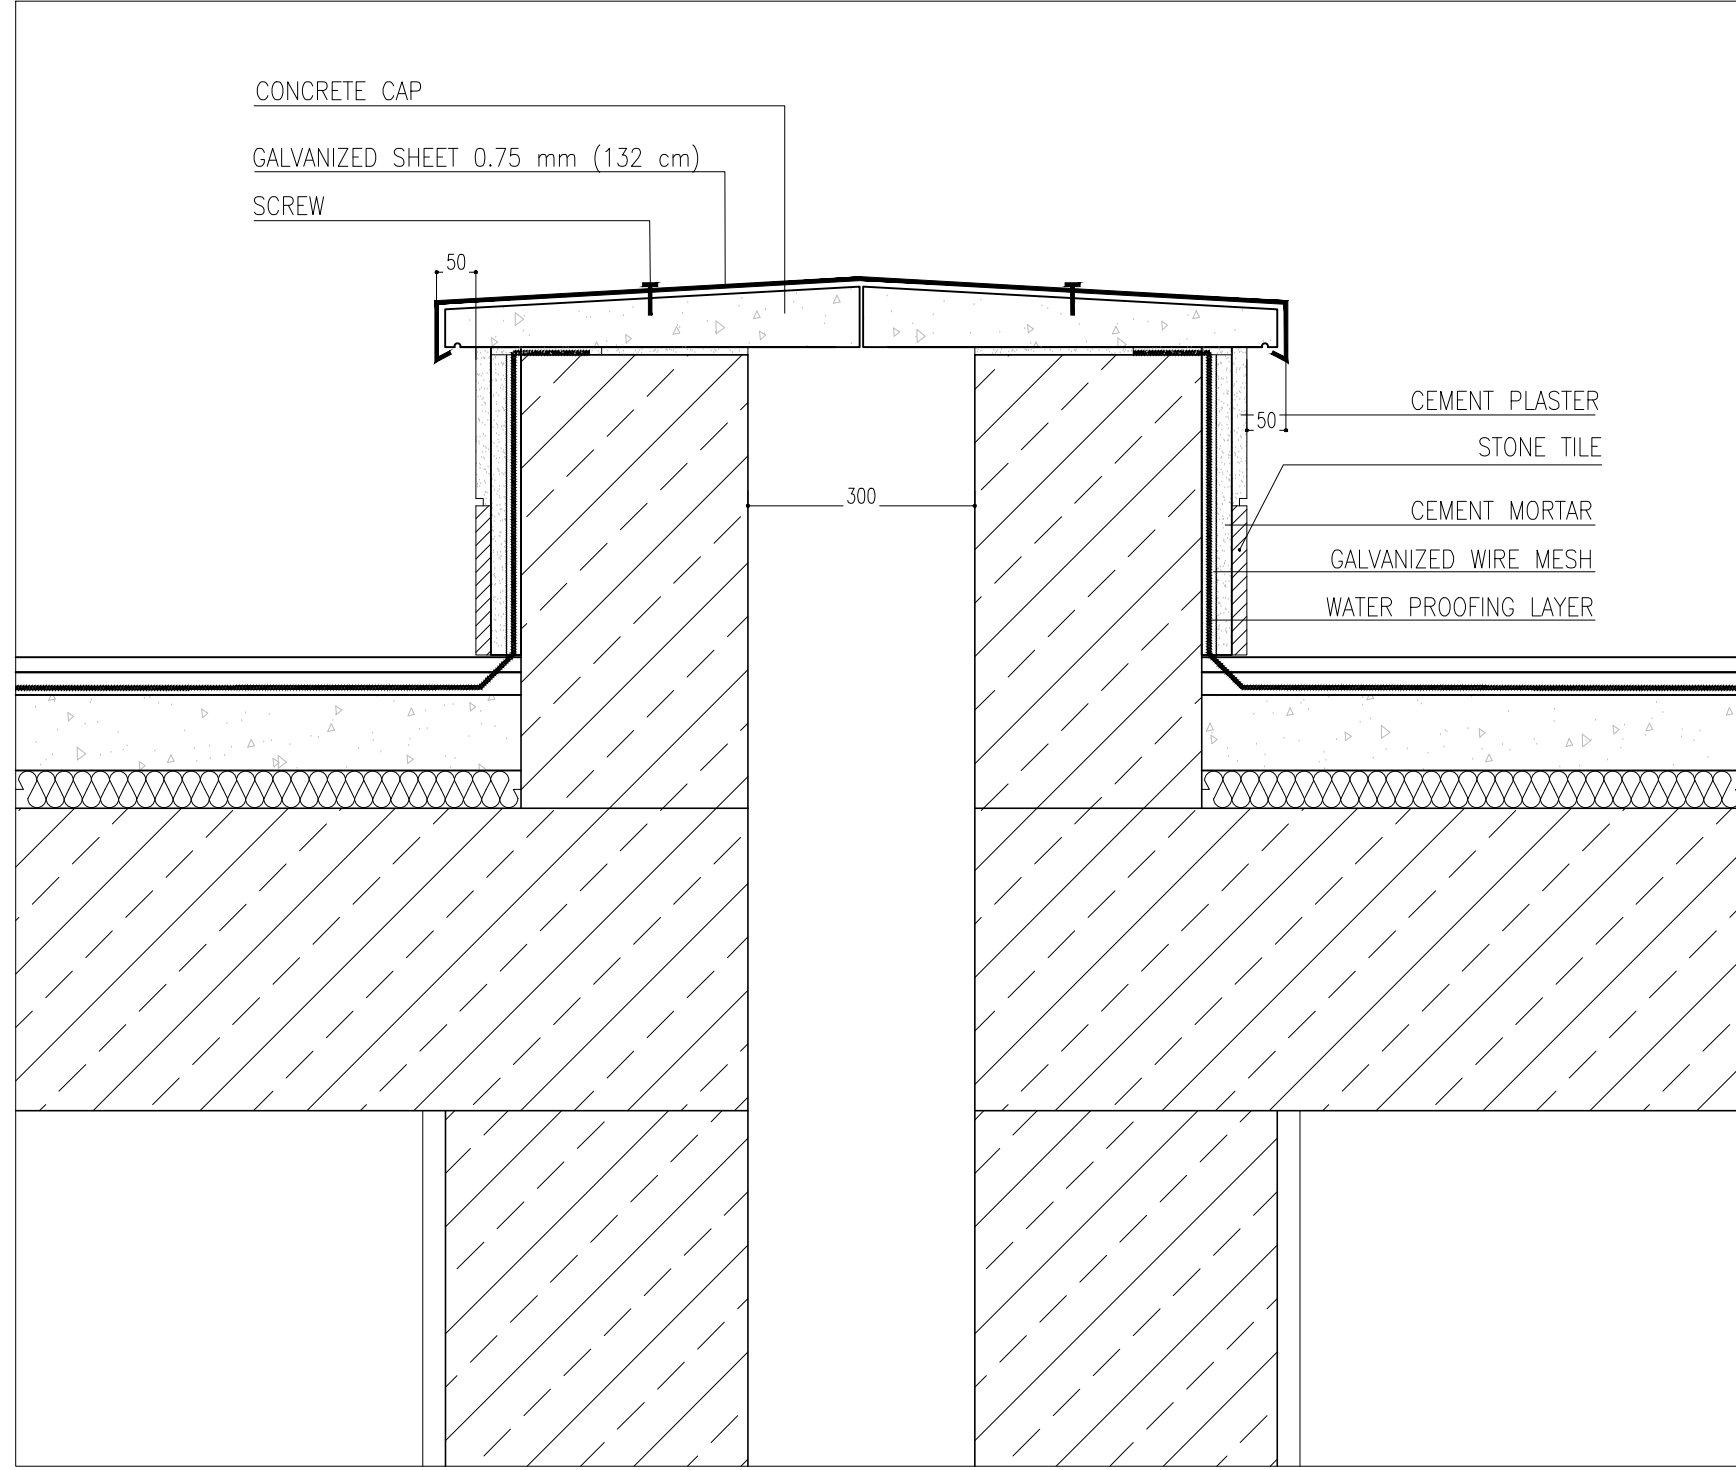


DETAIL 05
Sc:1/10

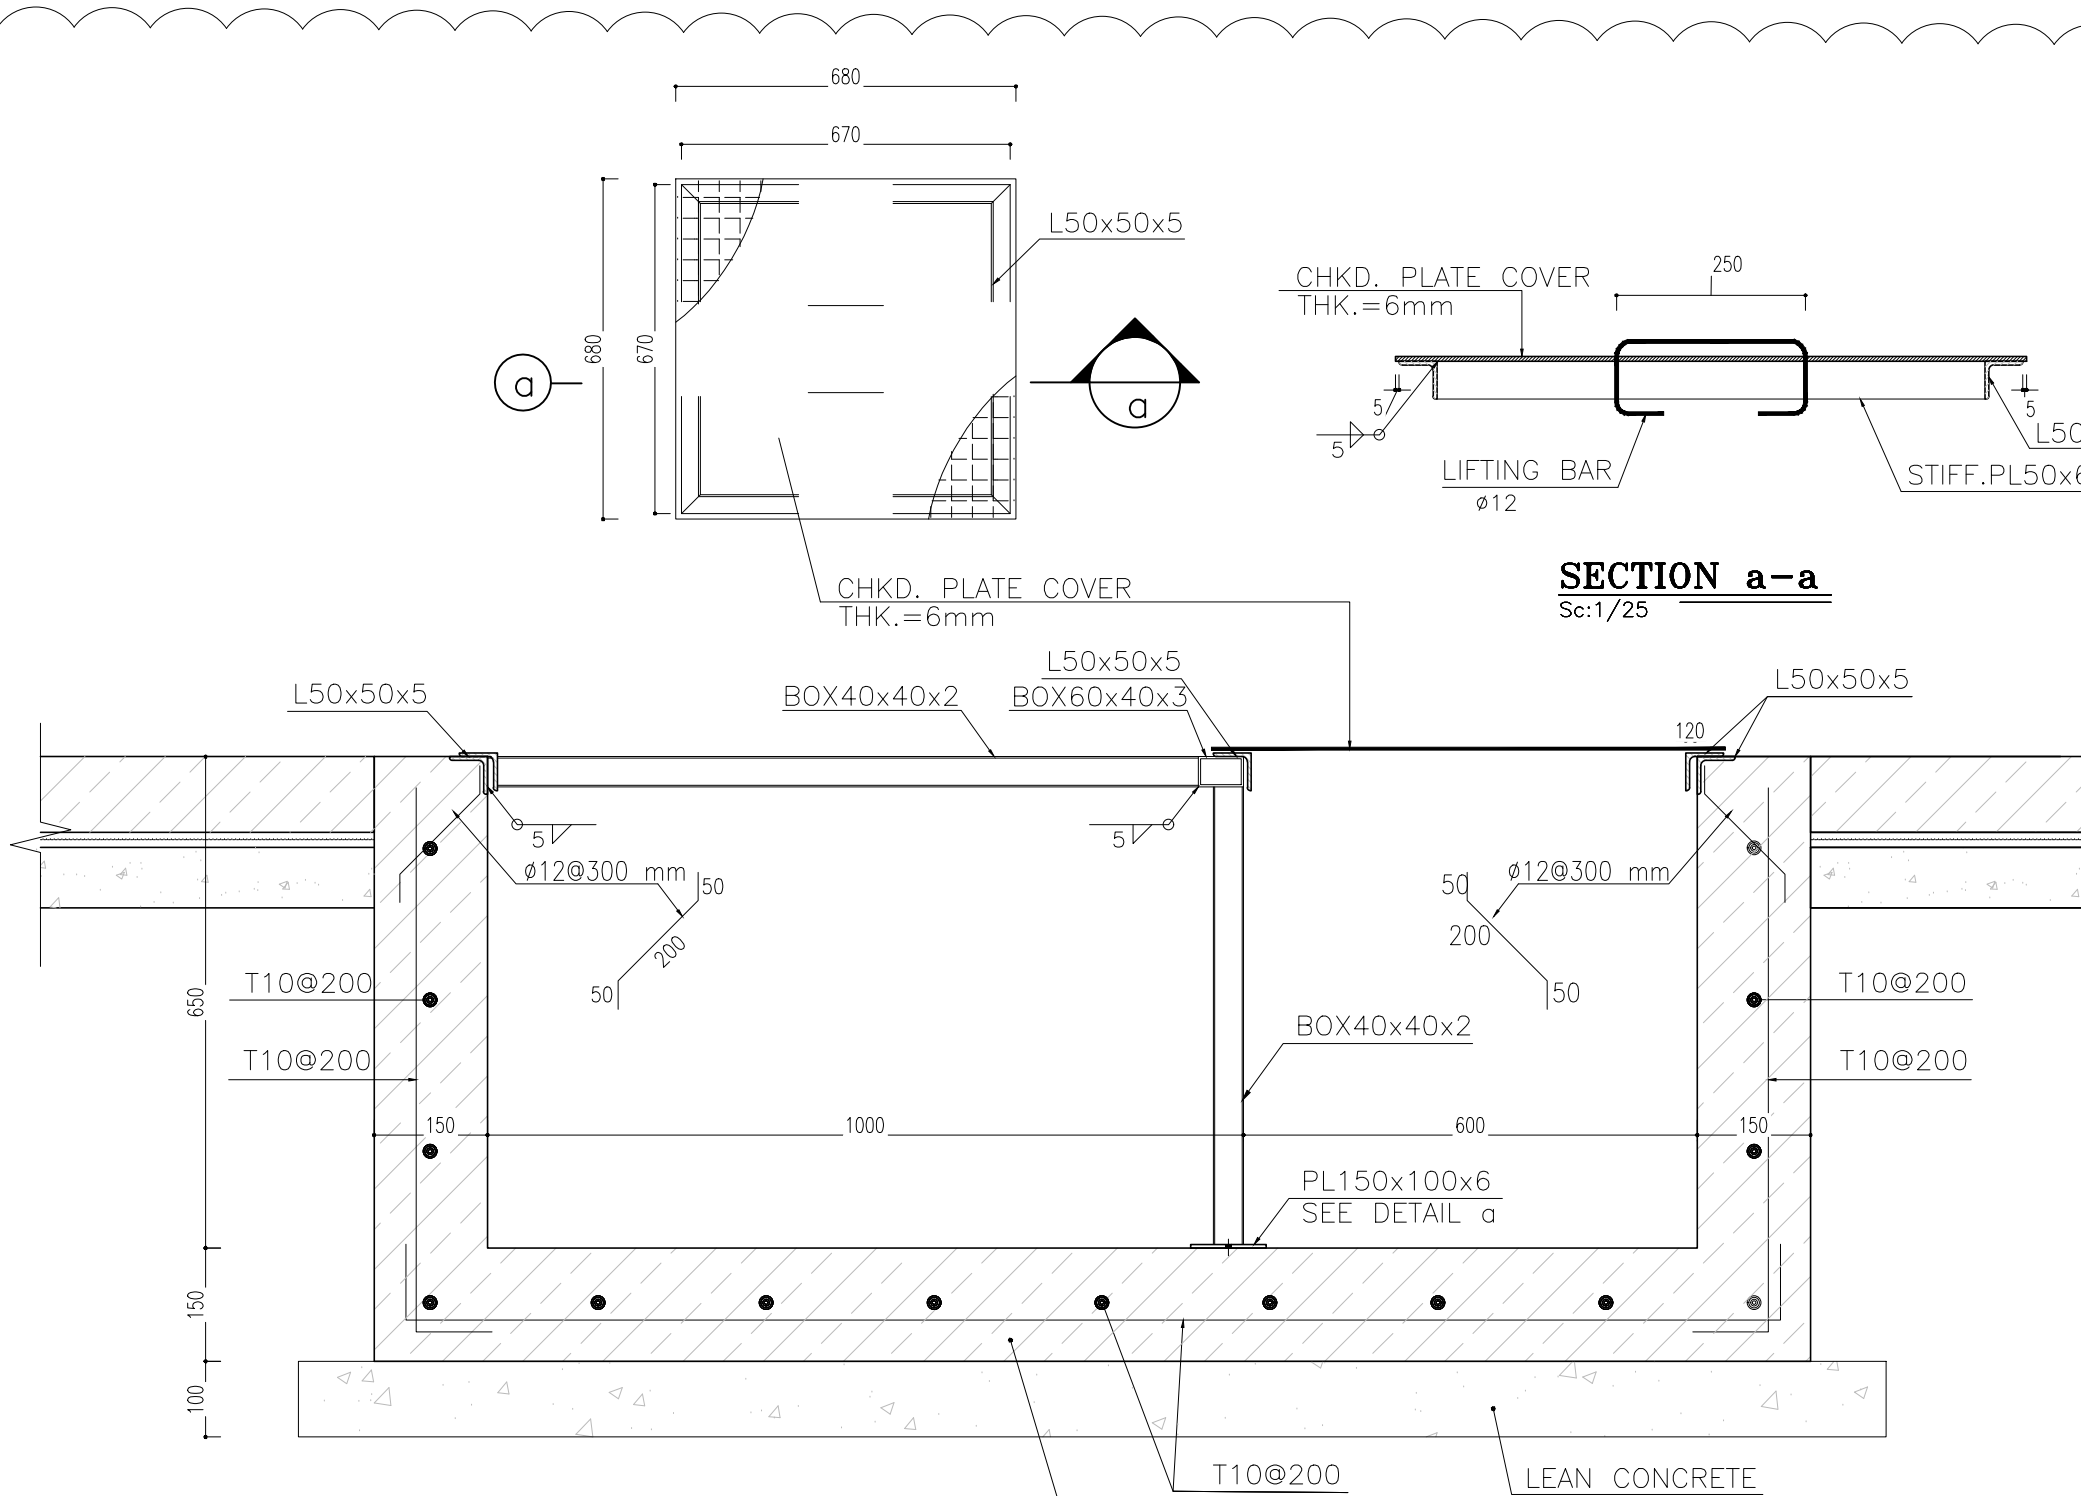


DETAIL 08
Sc:1/10

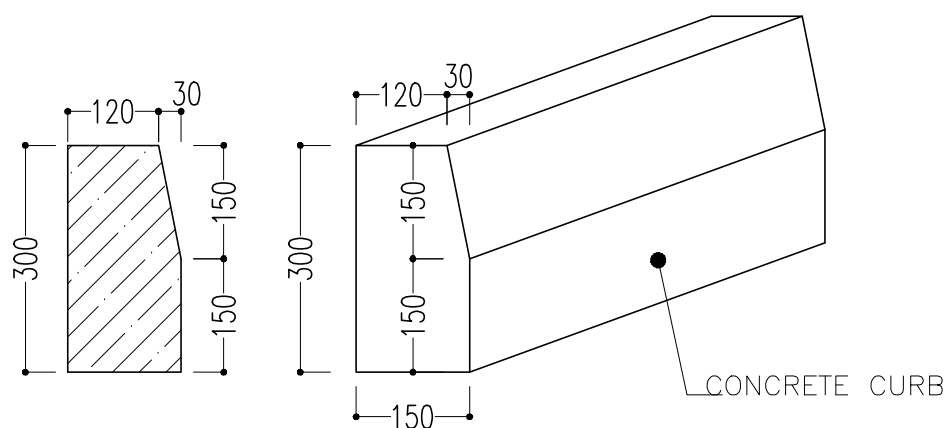


DETAIL 10 CONCRETE CURB
Sc:1/10

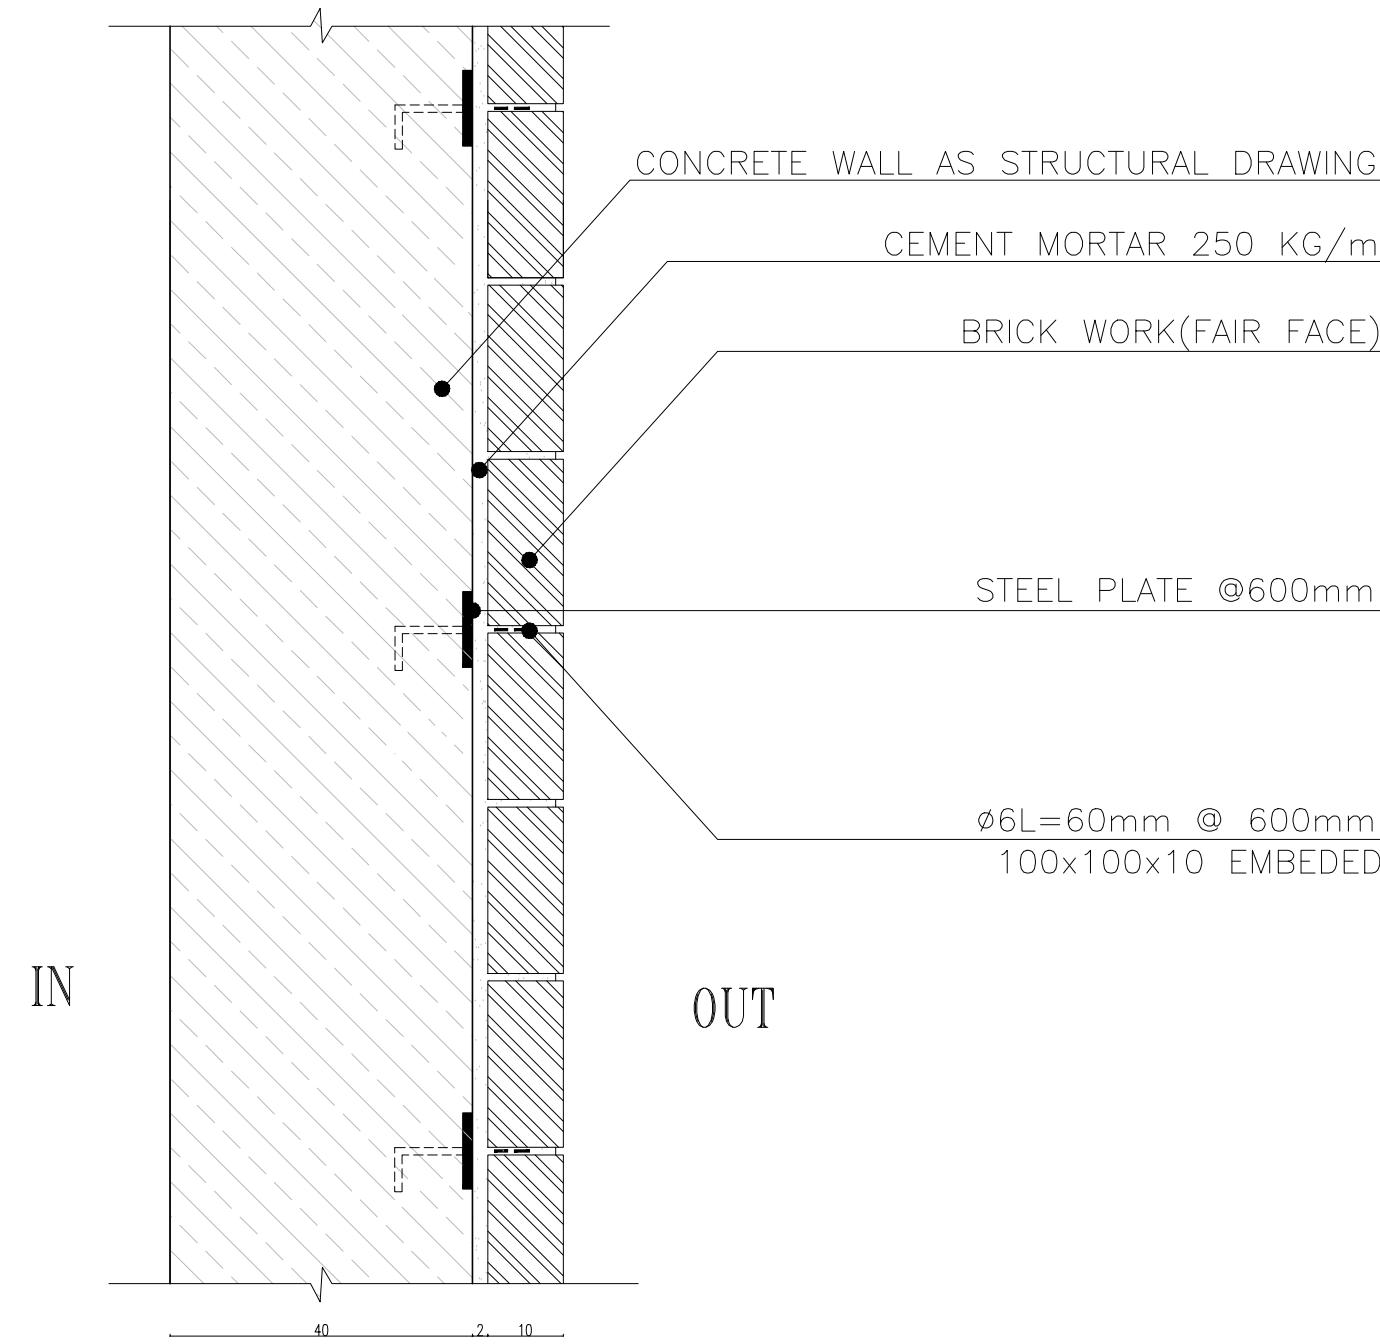

DETAIL 06 (CONNECTING BRICK FACE TO CONCRETE WALL)
Sc:1/10

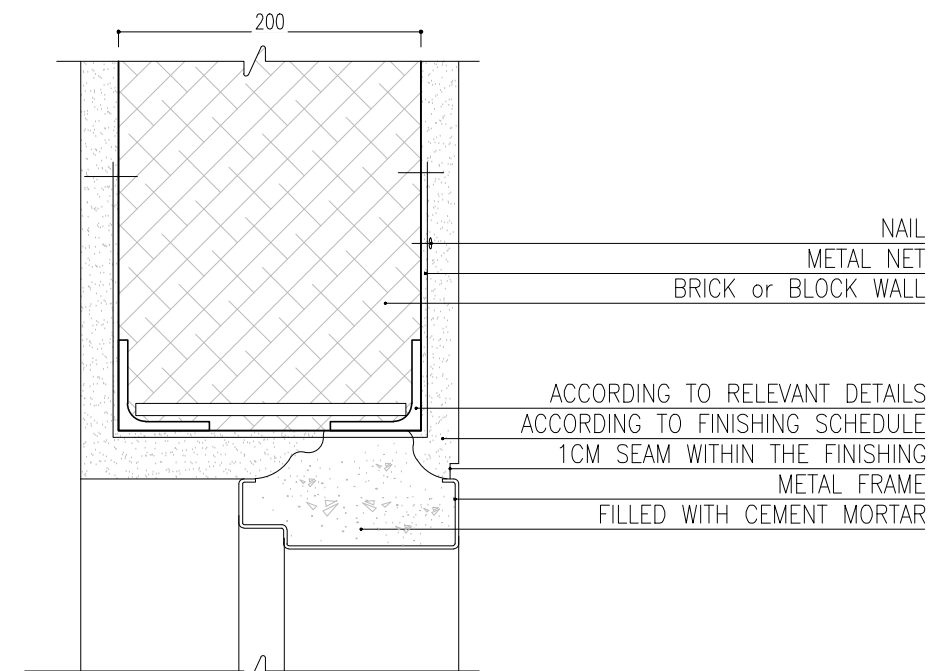

DETAIL 09
Sc:1/5

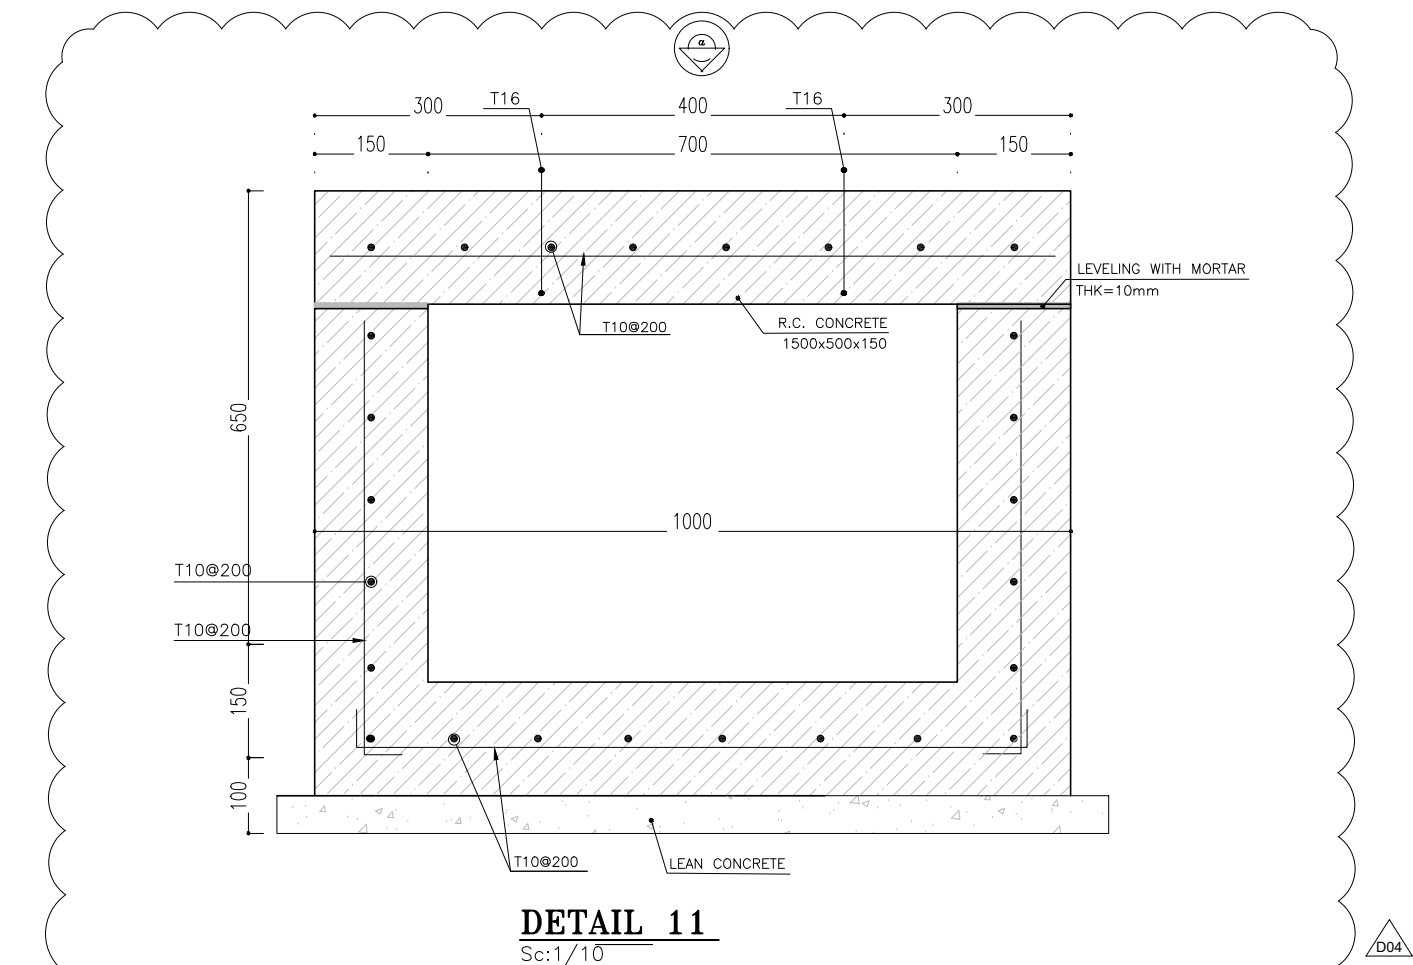

DETAIL 11
Sc:1/10

D04	NOV. 2024	AFC	R.BERLOUIE	M.FAKHARIAN	M.SADIGHIAN	***
D03	MAR. 2024	AFC	R.BERLOUIE	M.FAKHARIAN	S.Paramarspour	***
D02	NOV. 2023	AFC	R.BERLOUIE	M.FAKHARIAN	S.Paramarspour	***
D01	SEP. 2023	IFA	R.BERLOUIE	M.FAKHARIAN	A.M.MOHSSENI	***
D00	JUN. 2023	IPC	R.BERLOUIE	M.FAKHARIAN	A.M.MOHSSENI	***
REV.	DATE	P.O.I.S	PREP.	CHK.	APP.	AUT.

PROJECT NAME: BINAK OILFIELD DEVELOPMENT/SURFACE FACILITIES GAS COMPRESSOR STATION

PROJECT NO.: 971020

EPC CONTRACTOR:	EPD/EPC CONTRACTOR (GC):
 HIRGAN ENERGY – DESIGN & INSPECTION COMPANIES	 PETROIRAN DEVELOPMENT COMPANY

DRAWING TITLE: Architectural Detail Drawing For Extension of EXISTING Control Building DETAILS


SCALE	SIZE	DRAWING NO.	SHEET NO.	REV.
AS SHOWN	A1	BK-GCS-PEDCO-120-AR-DW-0011	09 OF 13	D04

NOTES					
1. ALL DIMENSIONS ARE IN MILLIMETER & ALL ELEVATIONS ARE IN METER. 2. ALL DIMENSIONS AND ELEVATIONS SHALL BE CHECKED BY THE CONTRACTOR PRIOR TO CONSTRUCTION. 3. CONTRACTOR SHALL COMPARE ALL ARCHITECTURAL, MECHANICAL, ELECTRICAL, PIPING AND STRUCTURAL DRAWINGS AND IN CASE OF ANY CONFLICTS OR DISCREPANCY, INFORM THE ENGINEER. 4. ALL MATERIALS ARE SELECTED FROM THE HIGHEST QUALITY AND MUST BE APPROVED BY THE CLIENT. 5. ALL OPENINGS FOR PIPING/CABLING AND HVAC OPENINGS SHALL BE CONSIDERED AS PER RELATED DRAWINGS BEFORE CONSTRUCTION. 6. FINISH GRADING LEVEL (F.G.L.) : ±0.00 (LOCAL) = 99.70					

LEGEND					
--------	--	--	--	--	--

REFERENCE DRAWING	DRG. No.
STANDARD DRAWING FOR ARCHITECTURAL DETAILS	BK-GNRL-PEDCO-000-AR-DW-0001
SITE SEWAGE SYSTEM LAYOUT & DETAILS	BK-GCS-PEDCO-120-CY-PY-0001
CONTROL ROOM LAYOUT & ARRANGEMENT DRAWING	BK-GCS-PEDCO-120-IN-PY-0001
ROAD, PAVING AND PLANT FINISH GRADING LAYOUT & SECTIONS	BK-GCS-PEDCO-120-CY-PY-0005
ELECTRICAL CABLE ROUTE & SECTION LAYOUT FOR BUILDING & SHELTER	BK-GCS-PEDCO-120-EL-PY-0006
FOUNDATION DRAWING FOR EXTENSION OF CONTROL BUILDING	BK-GNRL-PEDCO-220-ST-DW-0004
STRUCTURAL DRAWING FOR EXTENSION OF CONTROL BUILDING	BK-GNRL-PEDCO-220-ST-DW-0005
STANDARD DETAILS FOR LADDER & SAFETY CAGE	BK-GNRL-PEDCO-000-ST-DW-0009
AREA ELECTRICAL CABLE ROUTE & SECTION LAYOUT	BK-GCS-PEDCO-120-EL-PY-0005
UNIT PLOT PLAN DRAWING	BK-PPL-PEDCO-120-PI-PY-0001
CONTROL ROOM CABLE ROUTE LAYOUT	BK-GCS-PEDCO-120-IN-PY-0002
INSTRUMENT/PAG CABLE TRENCH/ROUTE LAYOUT DRAWING	BK-GCS-PEDCO-120-IN-PY-0004
ELECTRICAL EQUIPMENT ARRANGEMENT LAYOUT FOR BUILDING	BK-GCS-PEDCO-120-EL-PY-0008

KEY PLAN					
----------	--	--	--	--	--

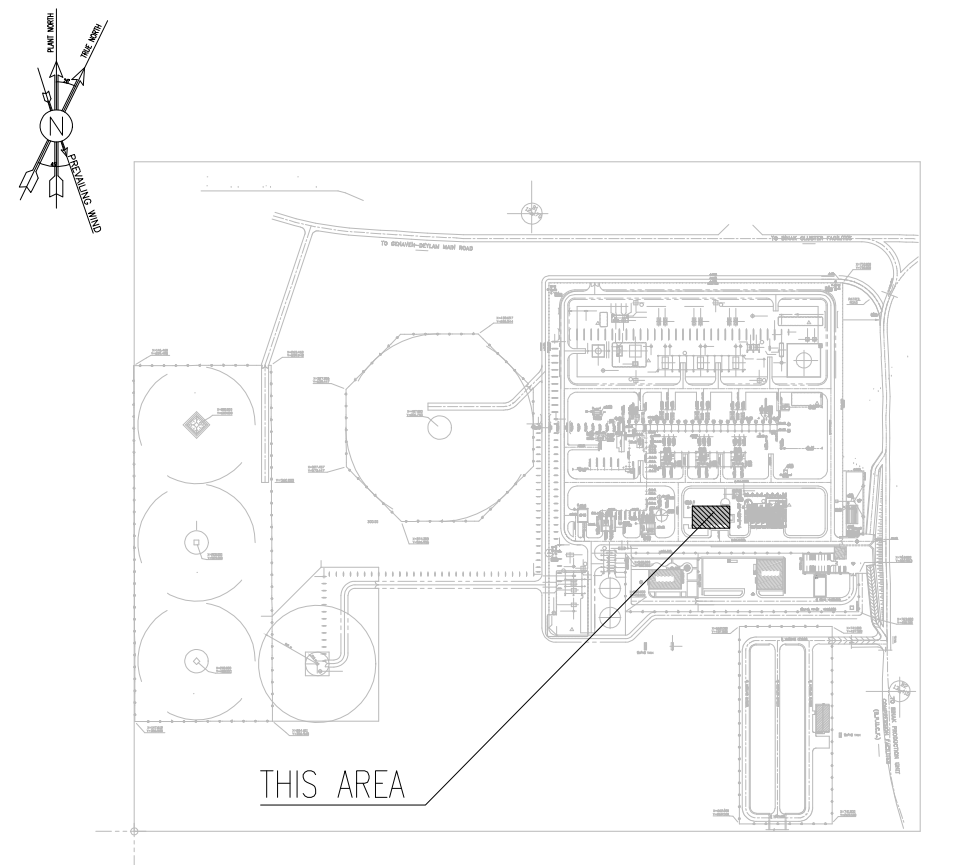

***	*****	***	*****	***	*****
REV.	DESCRIPTION	BY	DATE	BY	DATE
		CHECKED		REV. APPR.	

اصل و کلیه نسخ این نقشه و حق اقتباس متعلق به شرکت ملی مناطق نفت خیز جنوب میباشد.
THE ORIGINAL AND ALL COPIES OF THIS DRAWING TOGETHER WITH THE COPYRIGHT THEREIN ARE THE SOLE PROPERTY OF N.I.S.O.C./ FIELDS

BINAK OILFIELD DEVELOPMENT SURFACE FACILITIES GAS COMPRESSOR STATION					
DATE	SCALE	DRAWING BY	CHECKED BY	PROJECT ENG.	




NO CONSTRUCTION PERMITTED UNLESS DRAWING APPROVED					
APPROVED FOR CONSTRUCTION			BY:		DATE:

BUDGET REF.	LOCATION	SIZE	CLASS	SERIAL NO.	SHEET	REVISION
053-073-9184	F	4	B	709518	09 OF 13	D04

NOTES

1. ALL DIMENSIONS ARE IN MILLIMETER & ALL ELEVATIONS ARE IN METER.
2. ALL DIMENSIONS AND ELEVATIONS SHALL BE CHECKED BY THE CONTRACTOR PRIOR TO CONSTRUCTION.
3. CONTRACTOR SHALL COMPLY ALL ARCHITECTURAL, MECHANICAL, ELECTRICAL, PIPING & STRUCTURAL DRAWINGS AND IN CASE OF ANY CONFLICTS OR DISCREPANCY, INFORM THE ENGINEER.
4. ALL MATERIALS ARE SELECTED FROM THE HIGHEST QUALITY AND MUST BE APPROVED BY THE CLIENT.
5. ALL OPENINGS FOR PIPING/CABLING AND HVAC OPENINGS SHALL BE CONSIDERED AS PER RELATED DRAWINGS BEFORE CONSTRUCTION.
6. FINISH GRADING LEVEL (F.G.L.): ± 0.00 (LOCAL) = 99.70

LEGEND

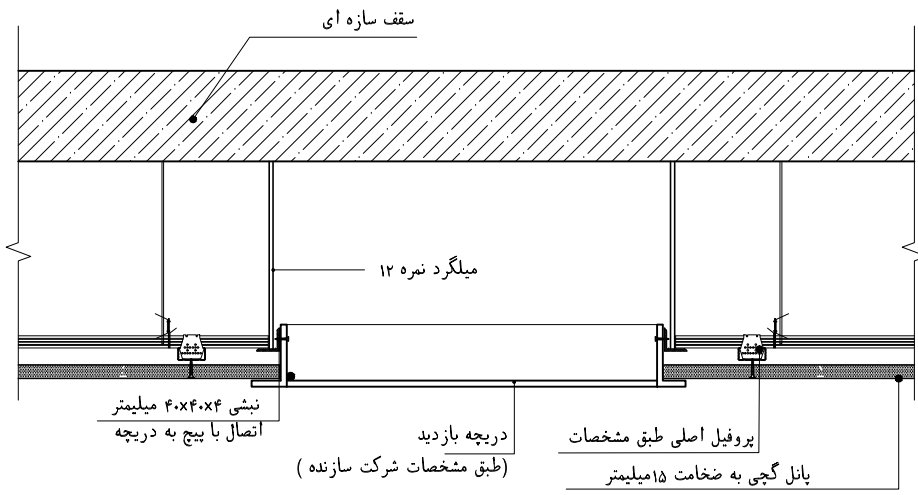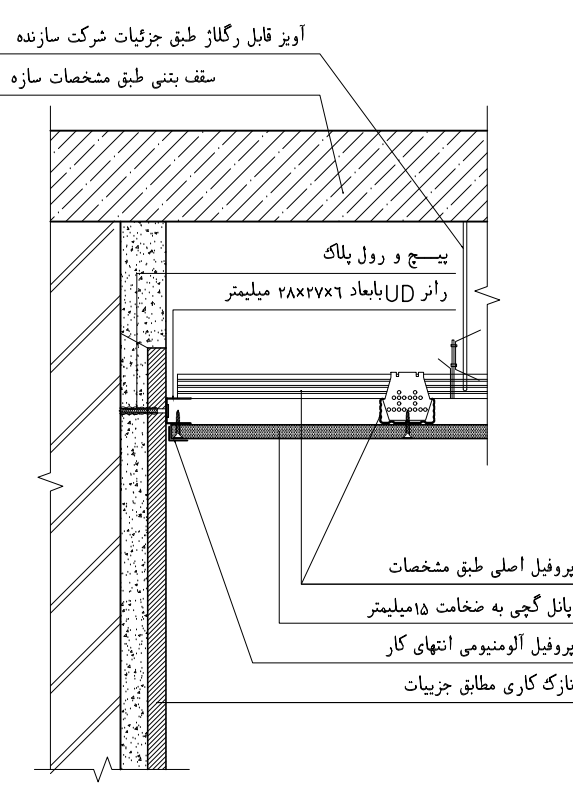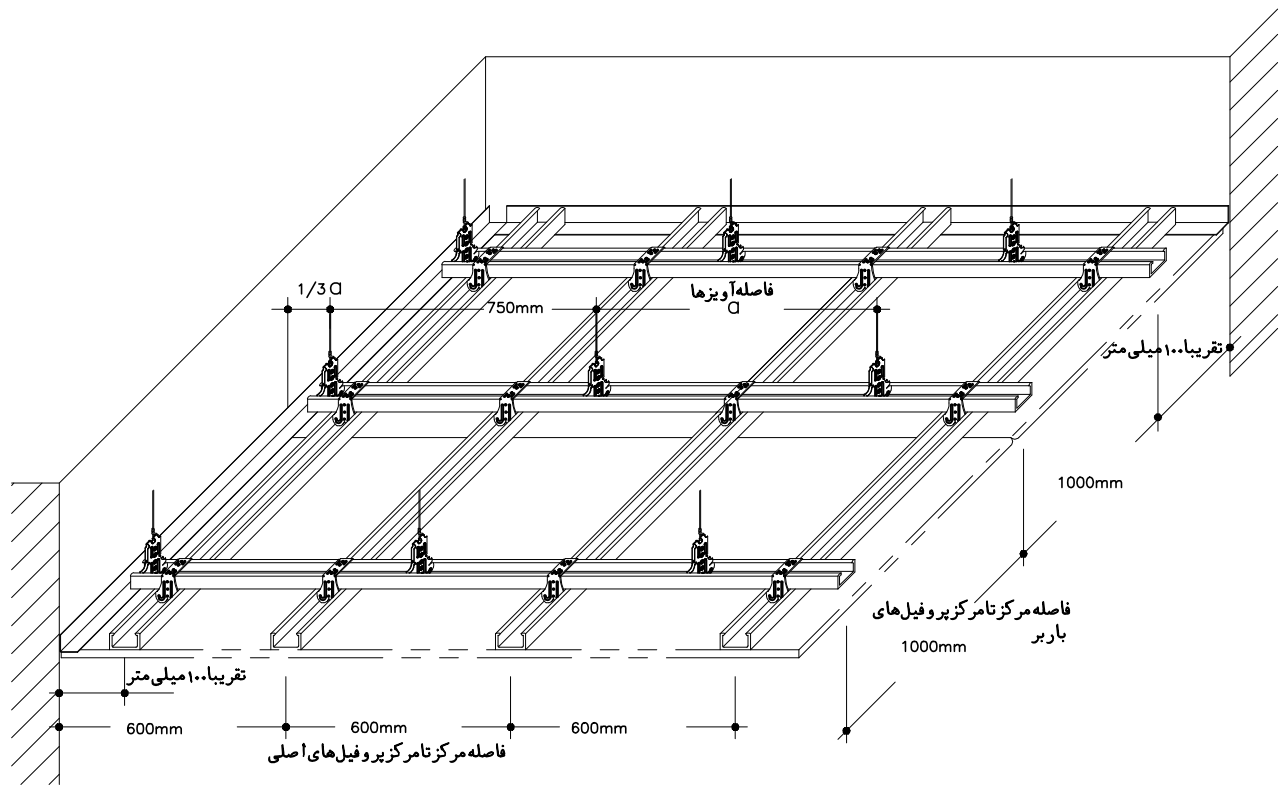




* ابعاد دریچه بازدید = ابعاد فن کوئل + ۲۰ سانتیمتر از هر طرف

جزئیات سقف کاذب (در محل دریچه بازدید)


کلیه فن کوئل ها دارای دریچه بازدید به فن کوئل میباشد.

جزئیات اتصال سقف کاذب پائل گچی به دیوار (سنگ)


جزئیات اجرائی سقفهای کاذب گچی روکشدار

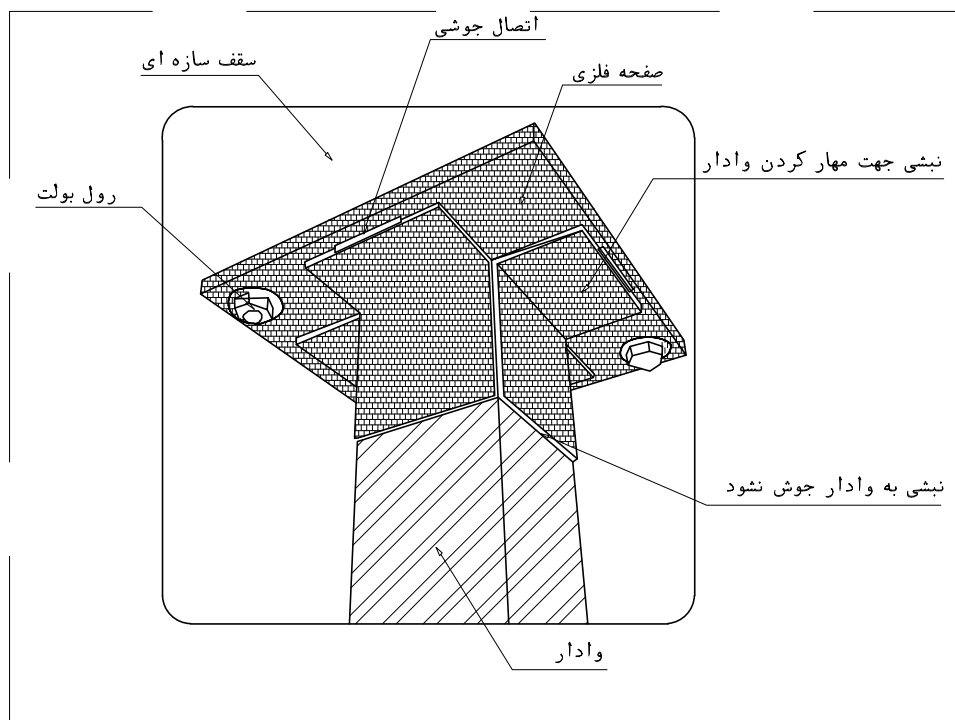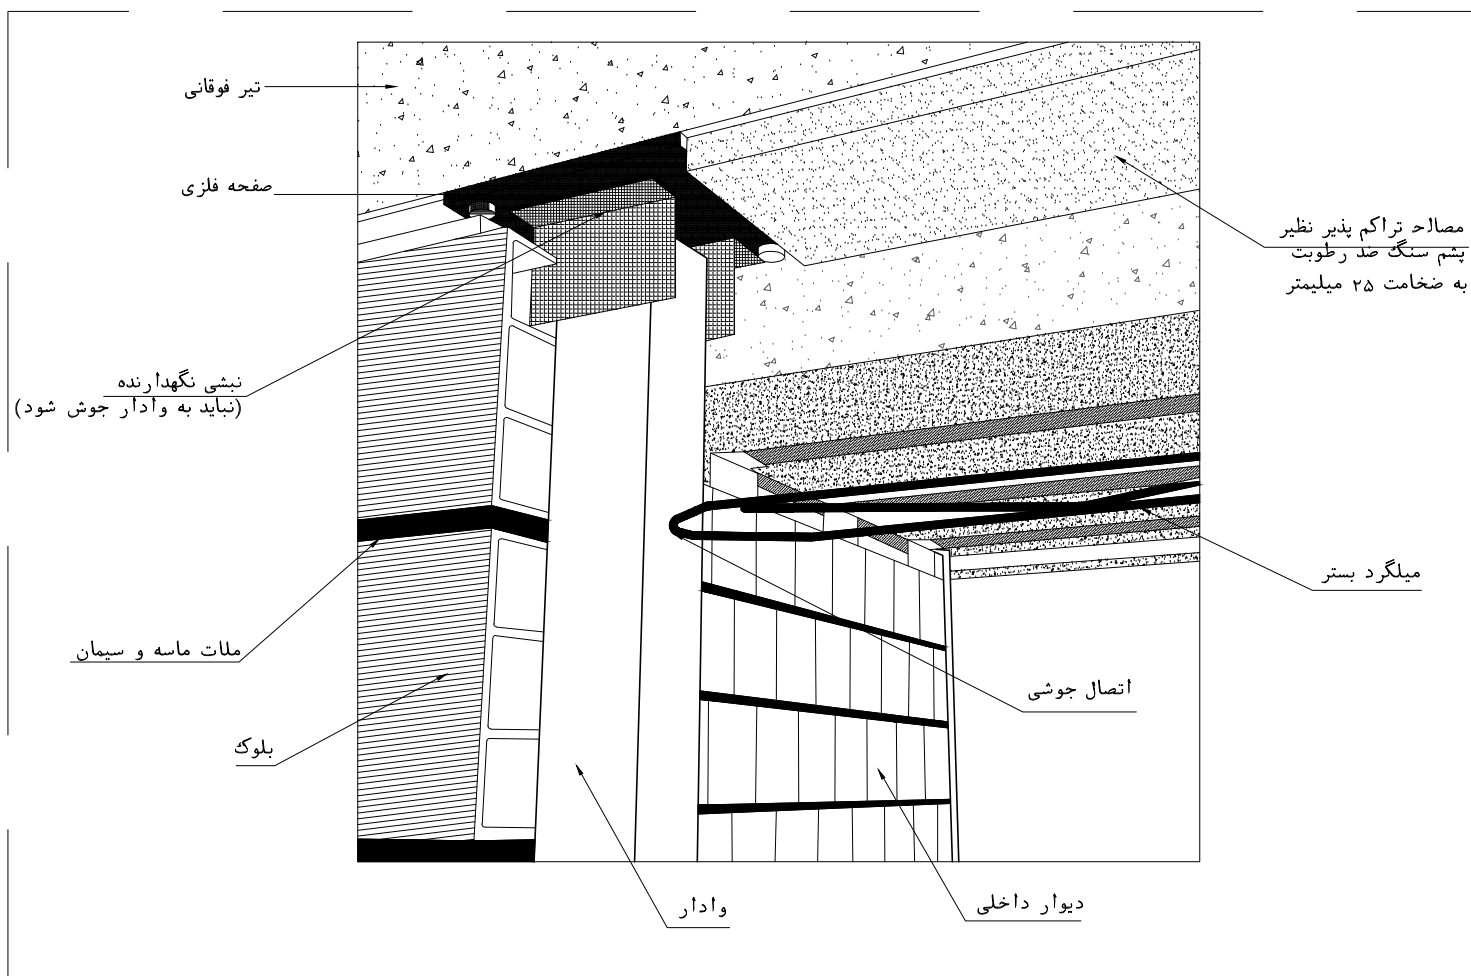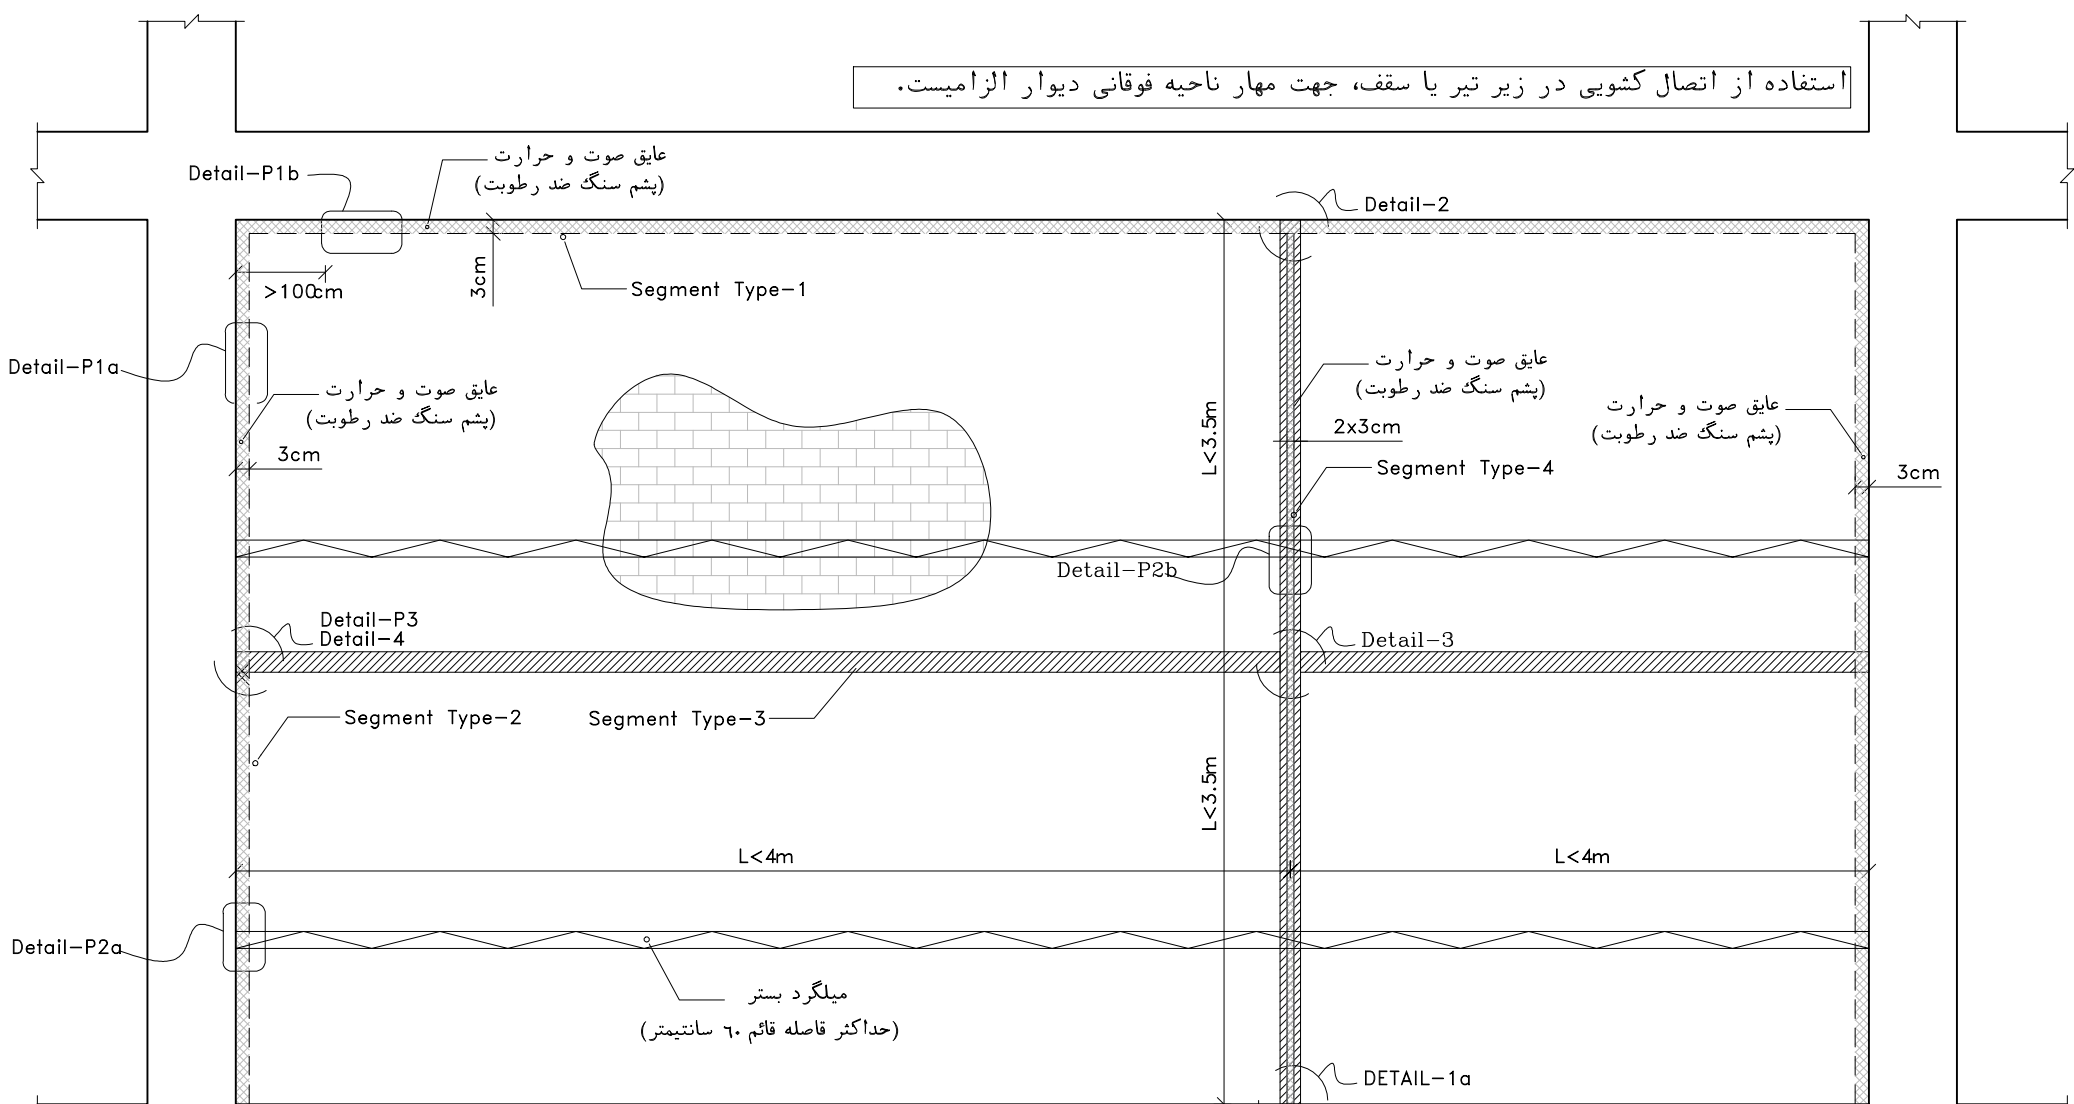

اتصال وادار انتهایی در دیوارهای خارج از قاب به صورت نل سکویی

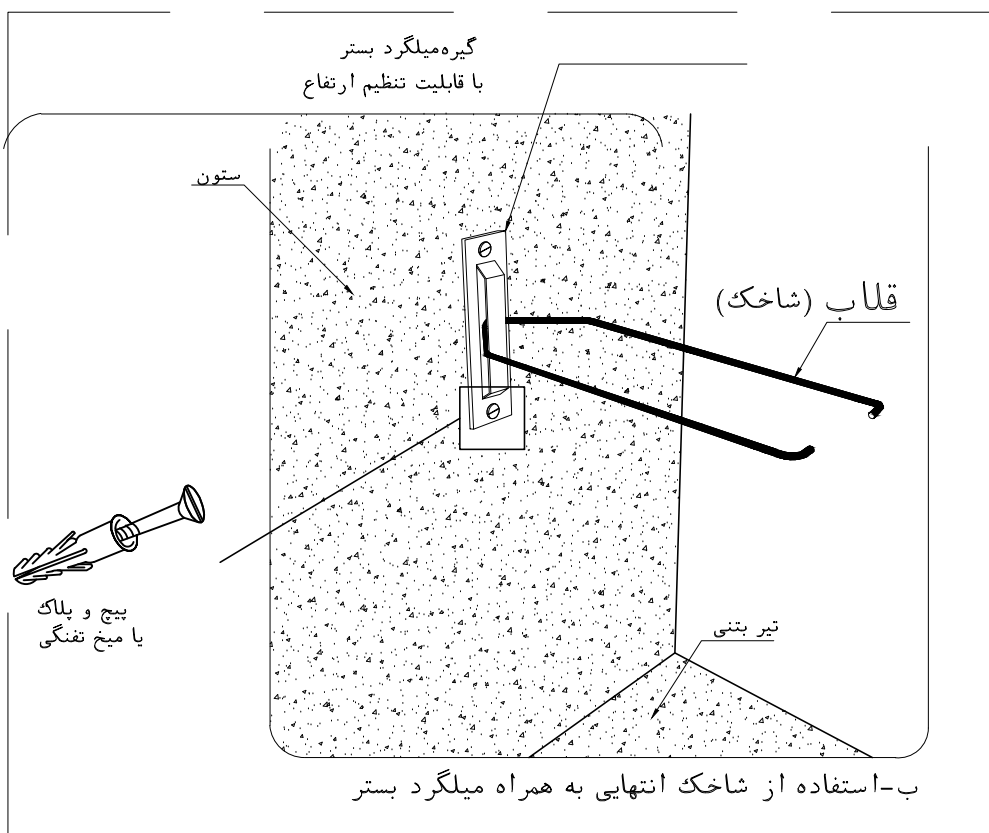


روش های مهار دیوار به ستون جهت نیروی خارج از صفحه

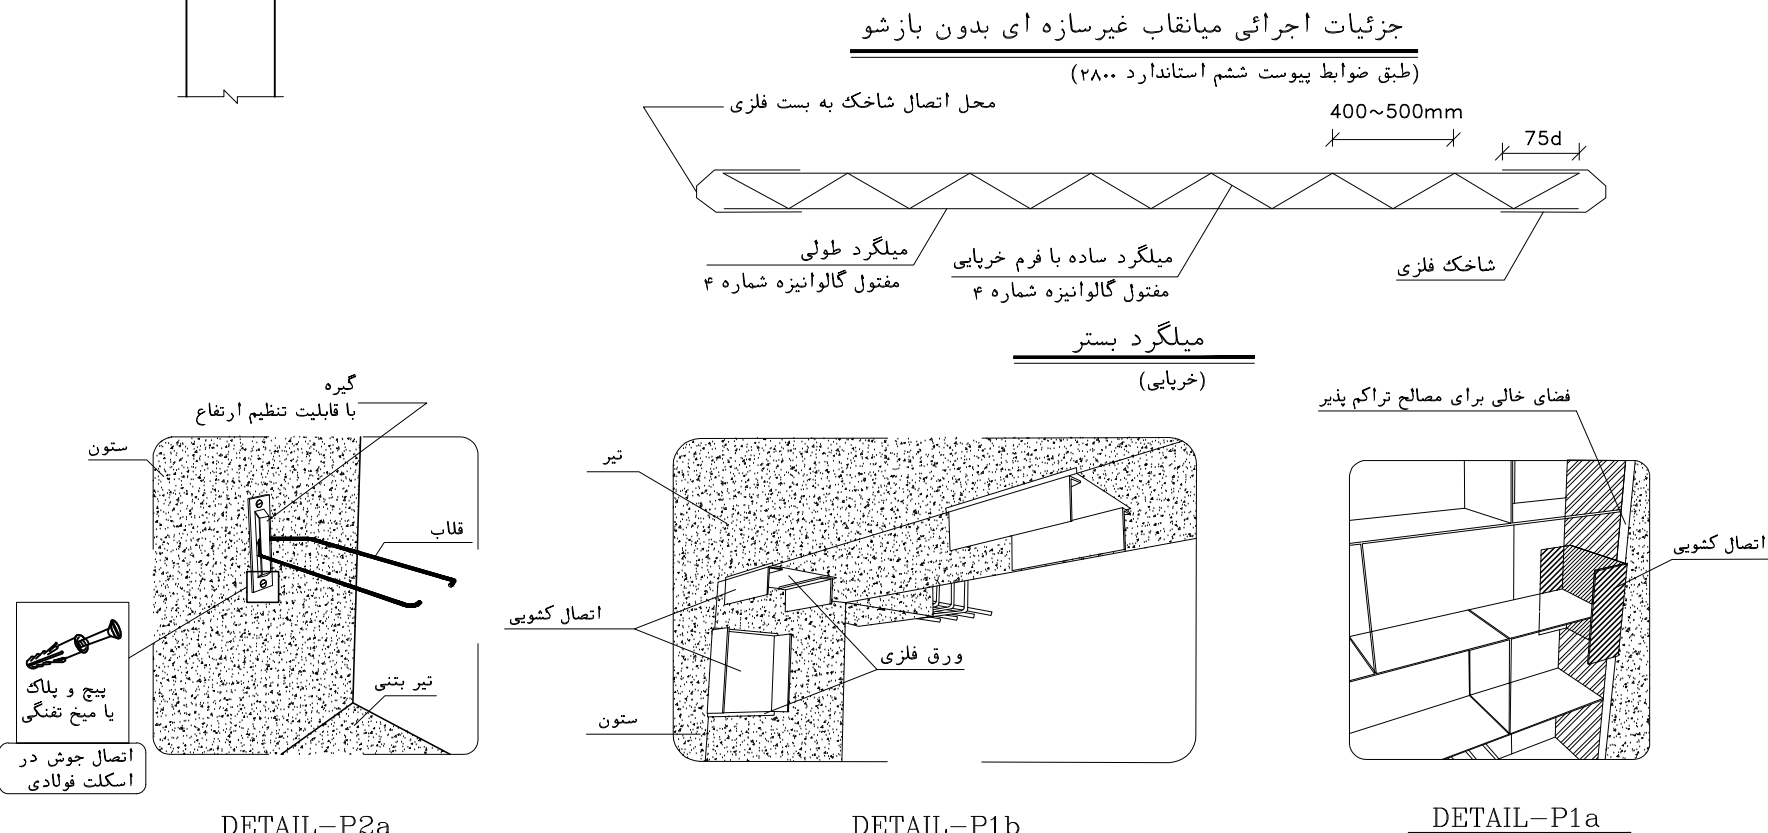

D04	NOV. 2024	AFc	R.BERLOUJE	M.FAKHARIAN	M.SADDEGHIAN	**
D03	MAR. 2024	AFc	R.BERLOUJE	M.FAKHARIAN	S.Faramarzpour	**
D02	NOV. 2023	AFc	R.BERLOUJE	M.FAKHARIAN	S.Faramarzpour	**
D01	SEP. 2023	IFa	R.BERLOUJE	M.FAKHARIAN	A.M.MOHSENI	**
D00	JUN. 2023	IFc	R.BERLOUJE	M.FAKHARIAN	A.M.MOHSENI	**
REV.	DATE	P.O.I.S	PREP.	CHK.	APP.	AUT.

اصل و کلیه نسخ این نقشه و حق اقتباس متعلق به شرکت ملی مناطق نفت خیز جنوب می باشد.




 
THE ORIGINAL AND ALL COPIES OF THIS DRAWING TOGETHER WITH
THE COPYRIGHT THEREIN ARE THE SOLE PROPERTY OF
N.I.S.O.C./ FIELDS

EPC CONTRACTOR:	EPD/EPC CONTRACTOR (GC):
 	
HIRGAN ENERGY – DESIGN & INSPECTION COMPANIES	PETROIRAN DEVELOPMENT COMPANY


BINAK OILFIELD DEVELOPMENT SURFACE FACILITIES GAS COMPRESSOR STATION				
DATE	SCALE	DRAWING BY	CHECKED BY	PROJECT ENG.

DRAWING TITLE:				
Architectural Detail Drawing For Extension of EXISTING Control Building				
DETAILS				
SCALE	SIZE	DRAWING NO.	SHEET NO.	REV.
AS SHOWN	A1	BK-GCS-PEDCO-120-AR-DW-0011	10 OF 13	D04

NO CONSTRUCTION PERMITTED UNLESS DRAWING APPROVED						
APPROVED FOR CONSTRUCTION				BY:	DATE:	
BUDGET REF.	LOCATION	SIZE	CLASS	SERIAL NO.	SHEET	REVISION
053-073-9184	F	4	B	709518	10 OF 13	D04

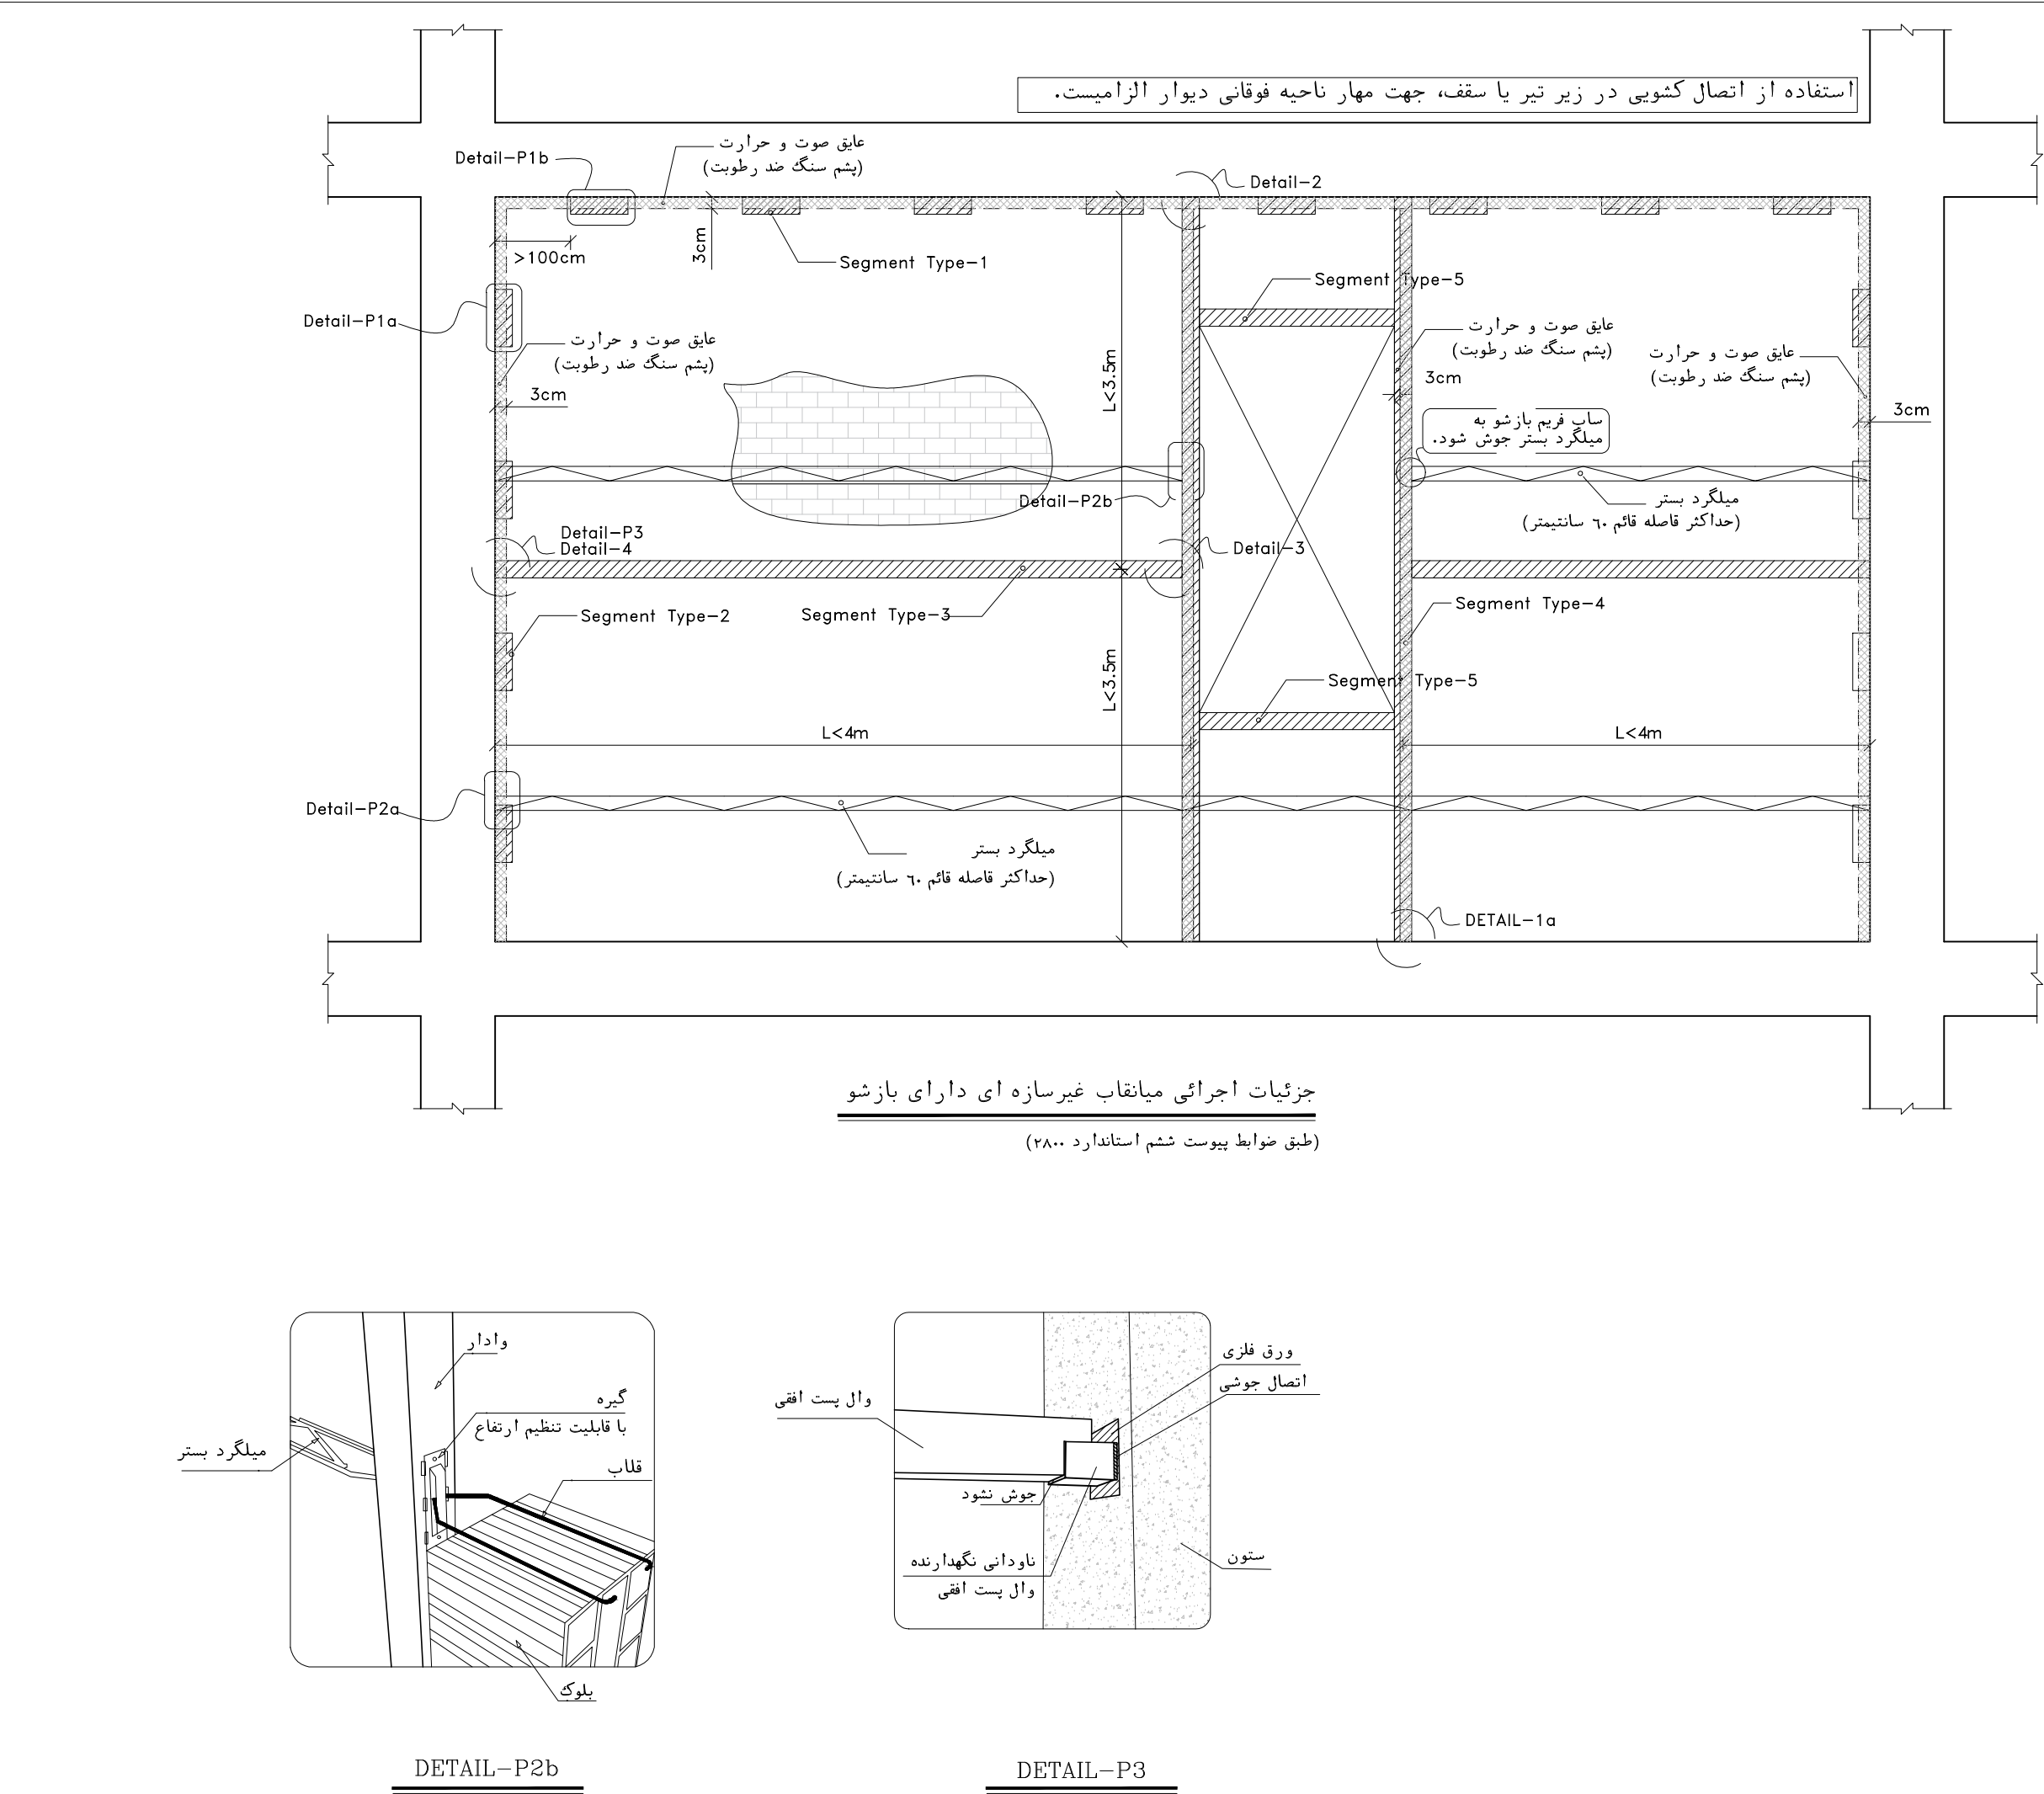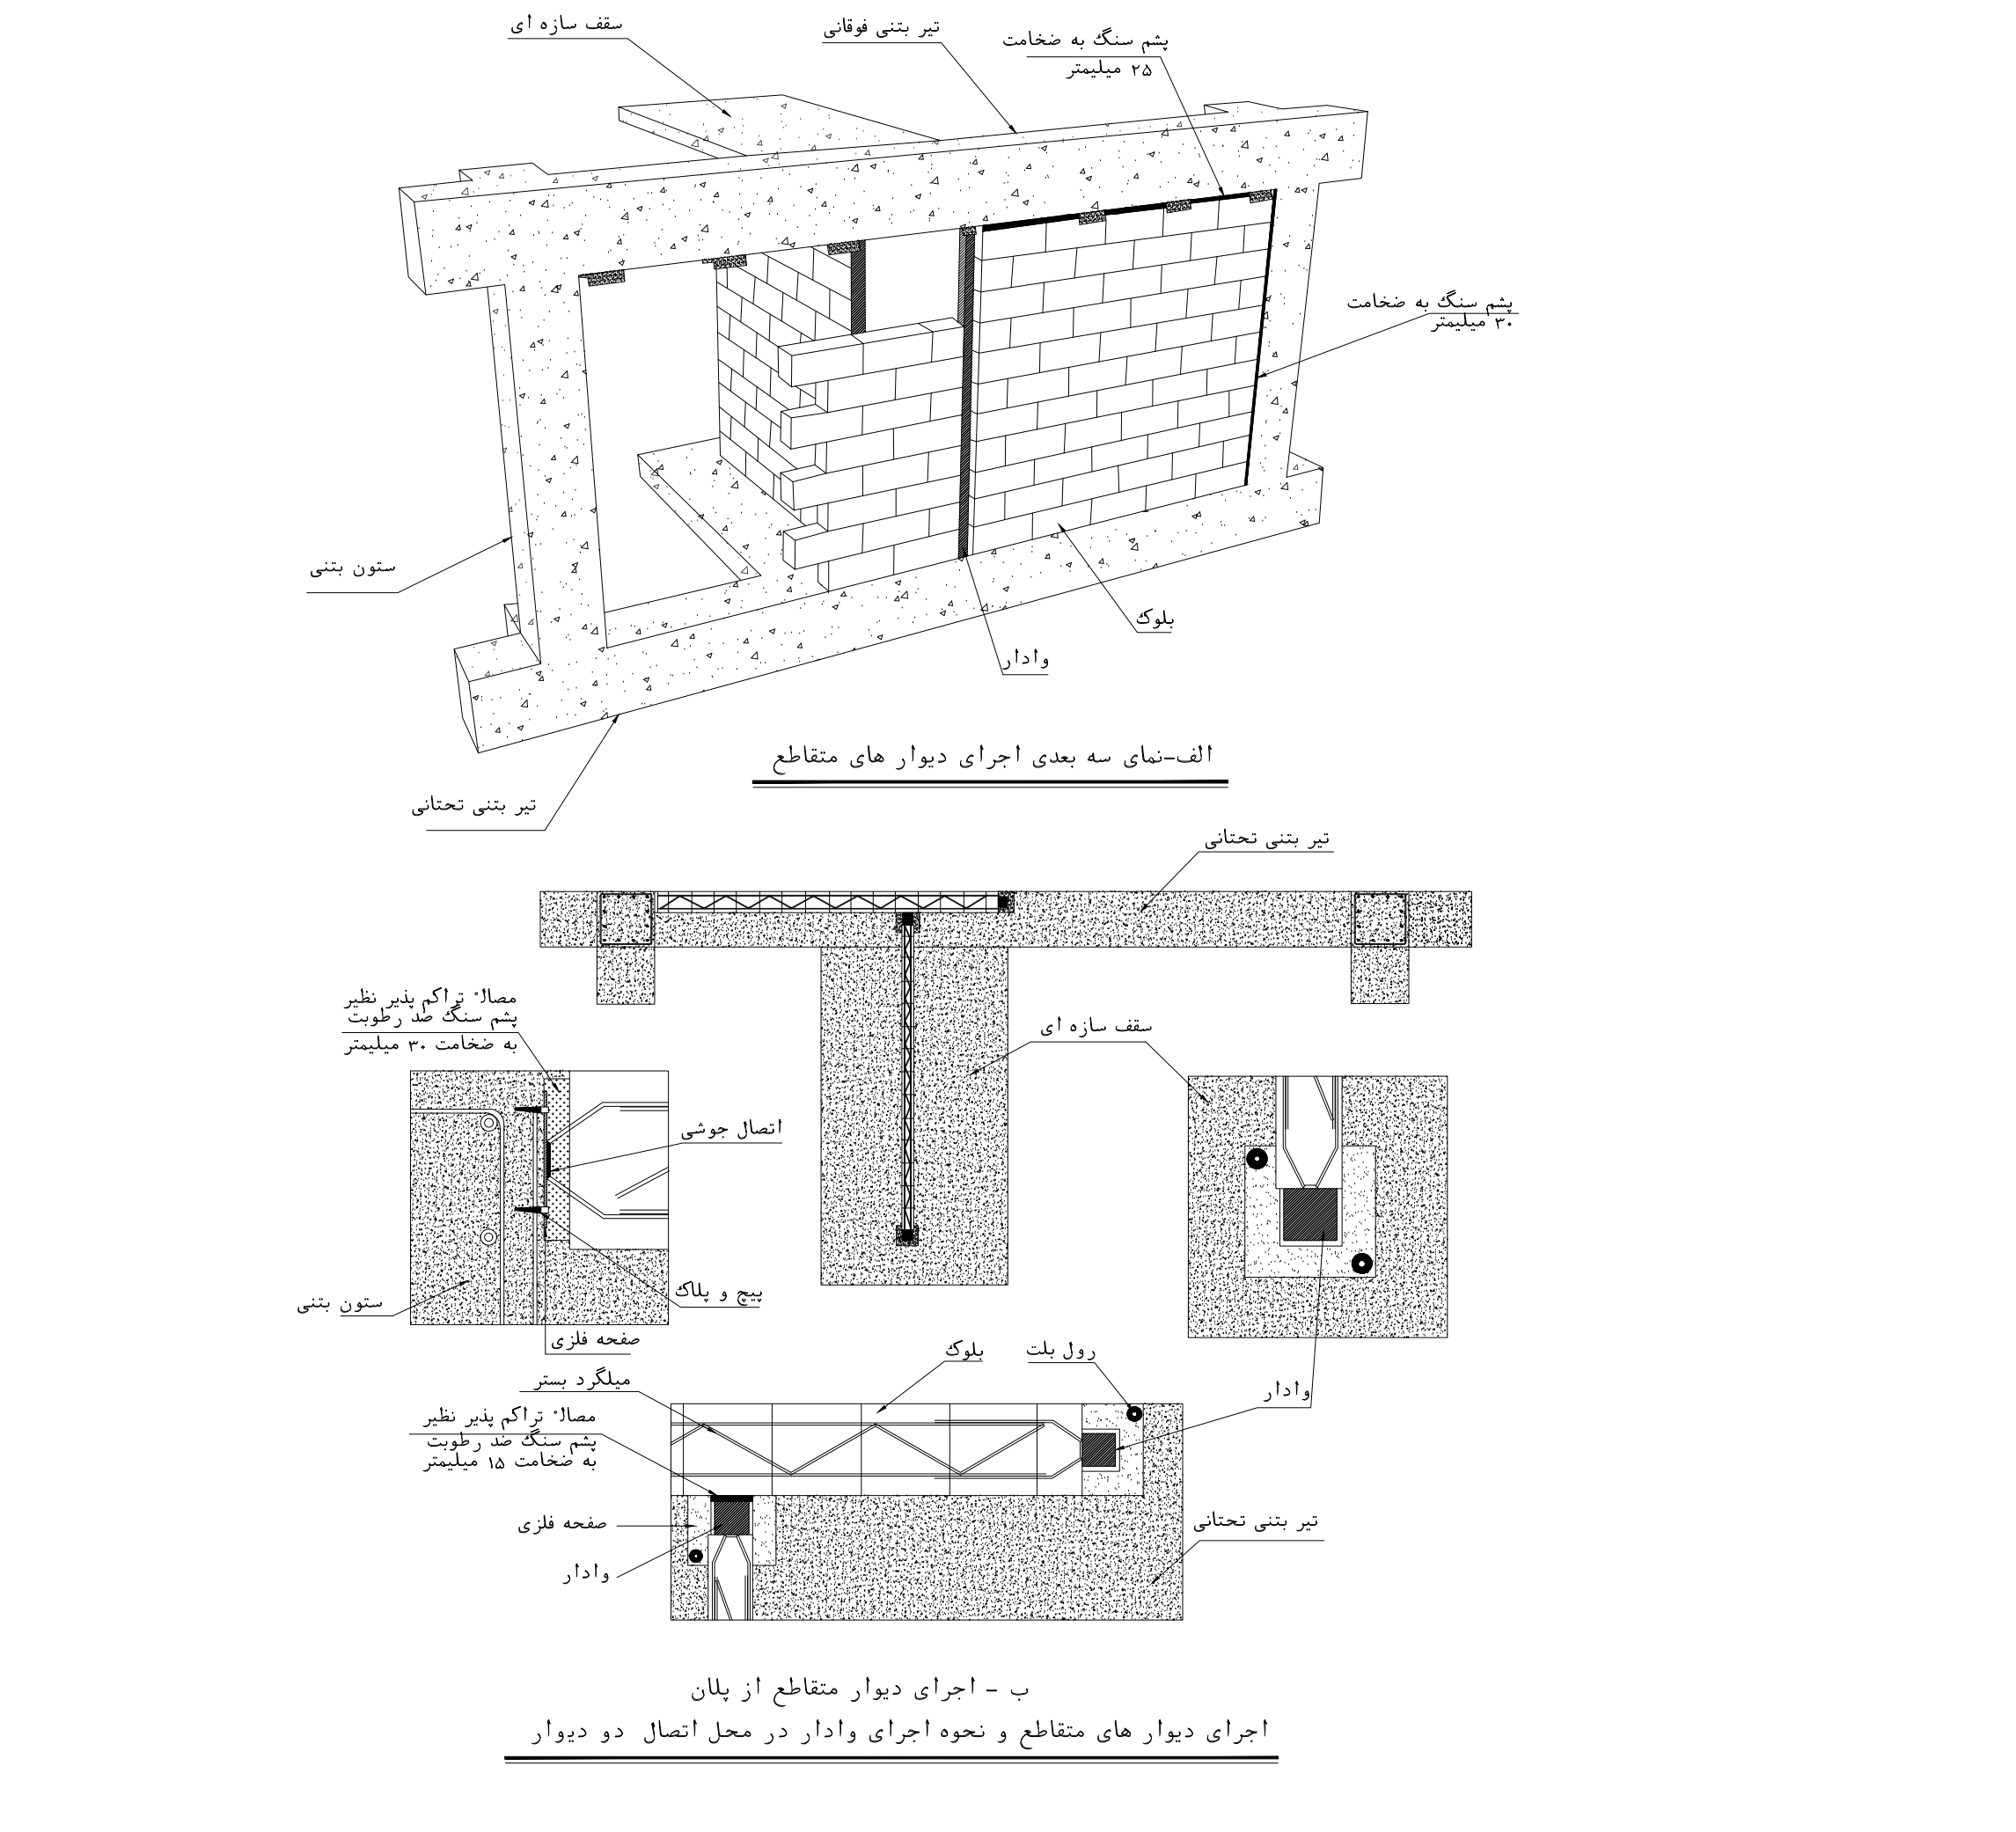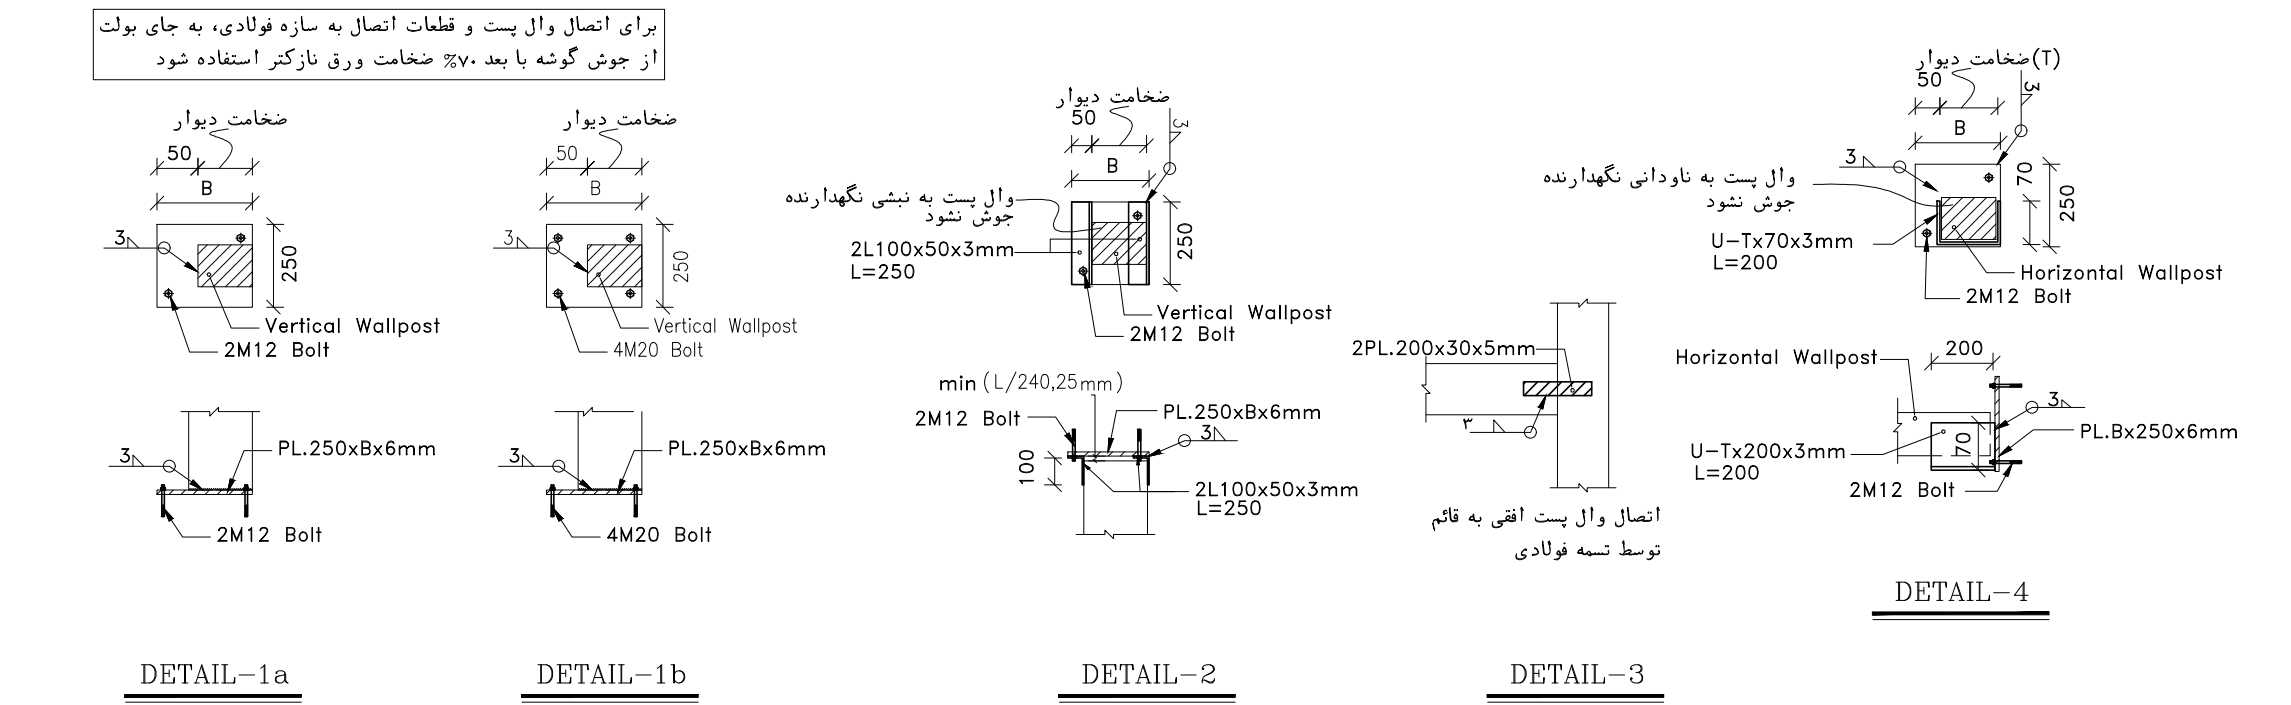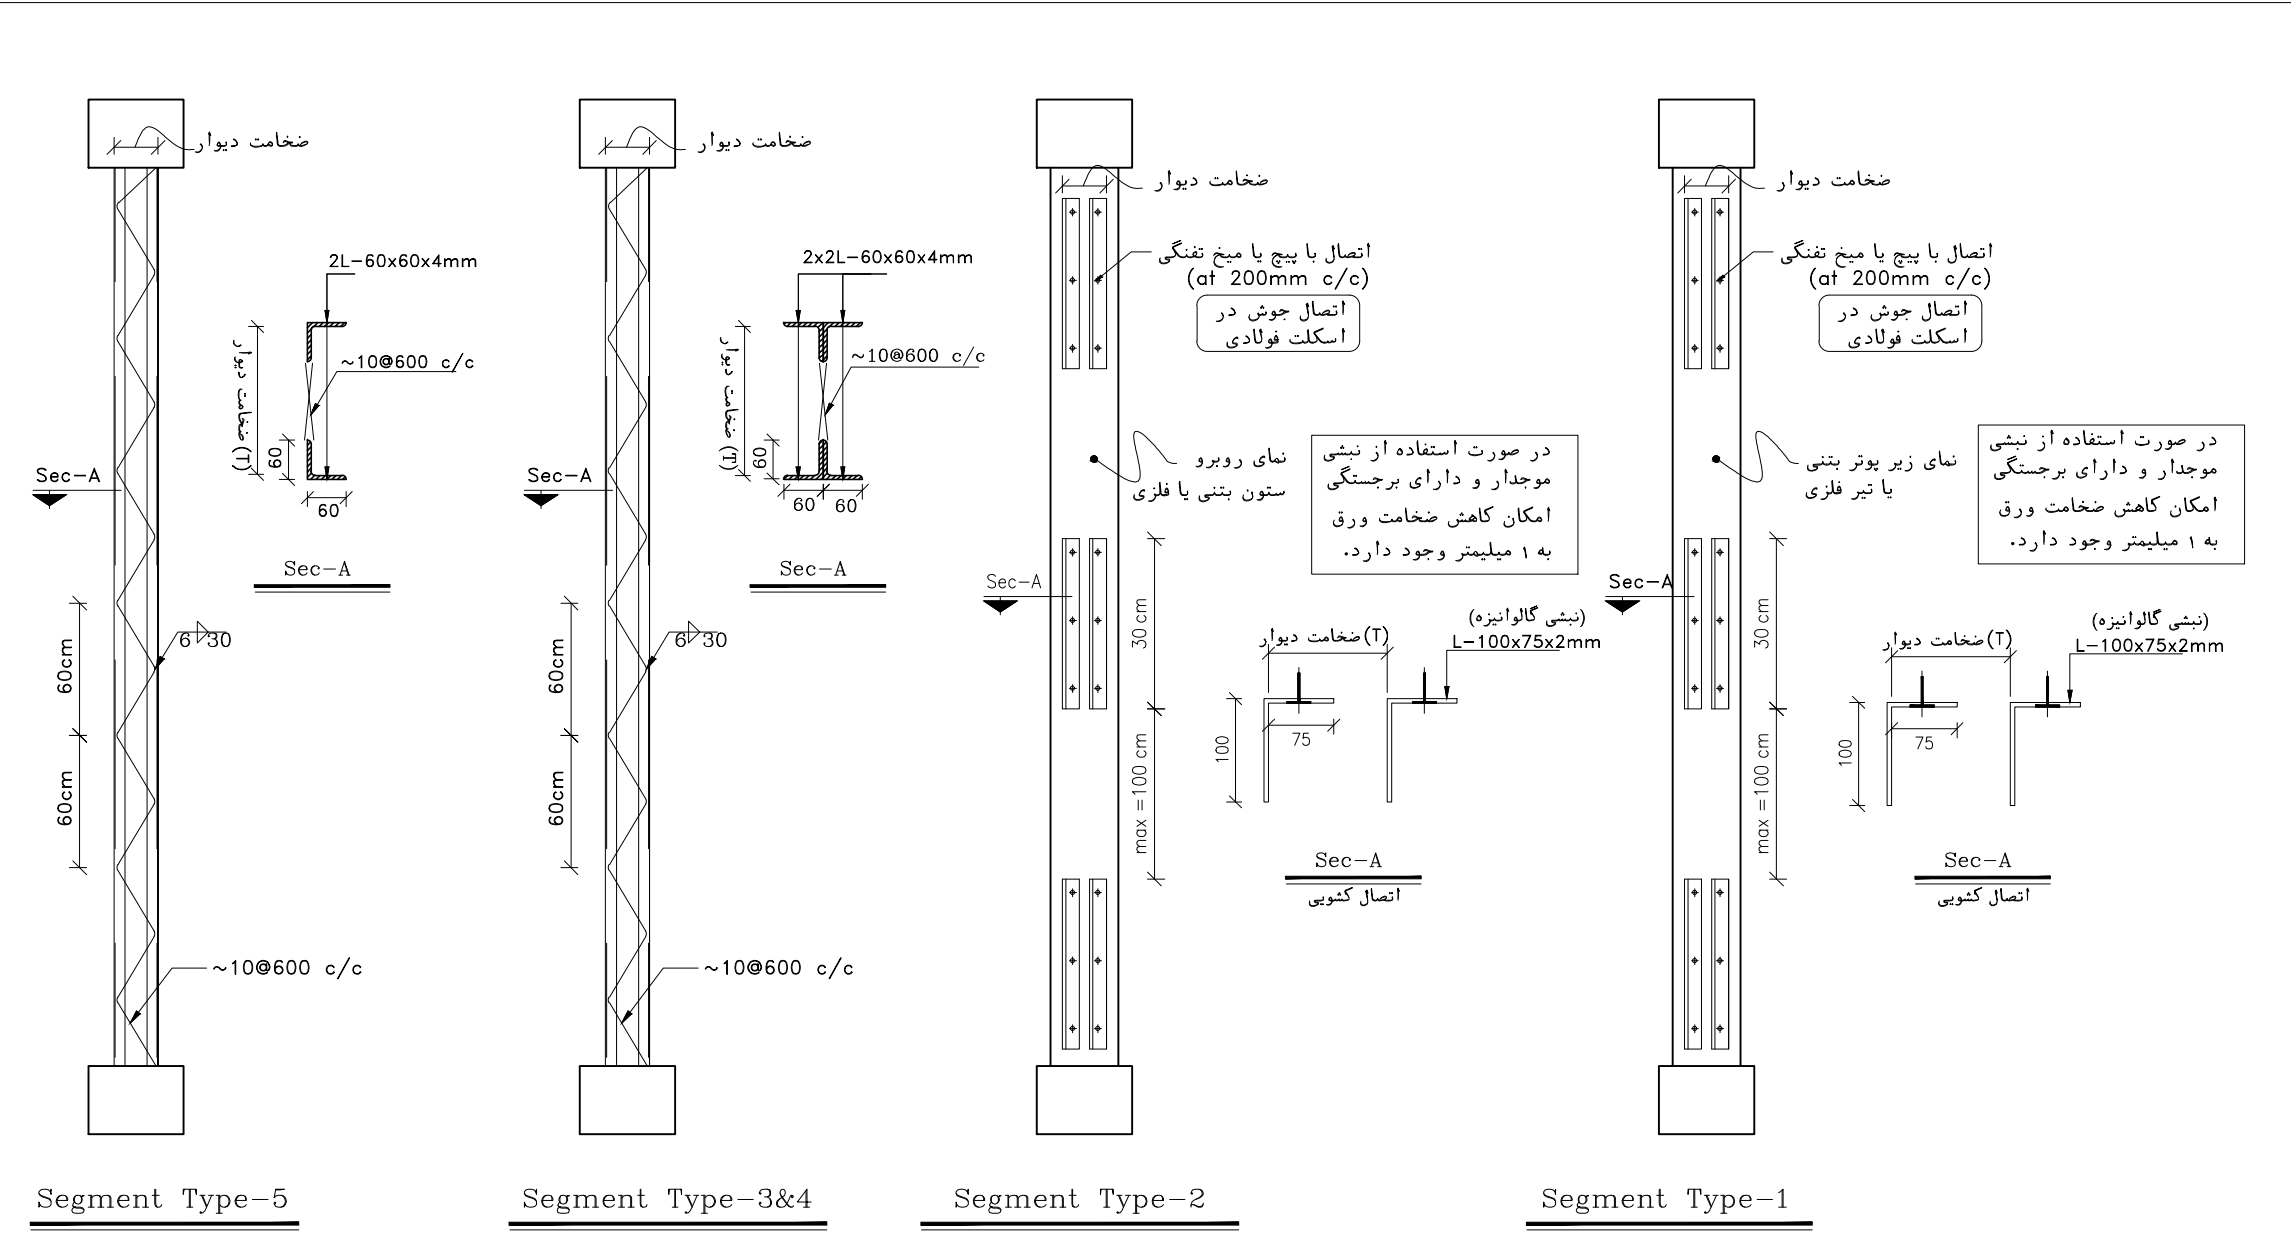

NOTES	
1. ALL DIMENSIONS ARE IN MILLIMETER & ALL ELEVATIONS ARE IN METER. 2. ALL DIMENSIONS AND ELEVATIONS SHALL BE CHECKED BY THE CONTRACTOR PRIOR TO CONSTRUCTION. 3. CONTRACTOR SHALL COMPARE ALL ARCHITECTURAL, MECHANICAL, ELECTRICAL, PIPING AND STRUCTURAL DRAWINGS AND IN CASE OF ANY CONFLICTS OR DISCREPANCY, INFORM THE ENGINEER. 4. ALL MATERIALS ARE SELECTED FROM THE HIGHEST QUALITY AND MUST BE APPROVED BY THE CLIENT. 5. ALL OPENINGS FOR PIPING/CABLING AND HVAC OPENINGS SHALL BE CONSIDERED AS PER RELATED DRAWINGS BEFORE CONSTRUCTION. 6. FINISH GRADING LEVEL (F.G.L.) : ±0.00 (LOCAL) = 99.70	
LEGEND	
REFERENCE DRAWING	DRG. No.
STANDARD DRAWING FOR ARCHITECTURAL DETAILS	BK-GNRL-PEDCO-000-AR-DW-0001
SITE SEWAGE SYSTEM LAYOUT & DETAILS	BK-GCS-PEDCO-120-CY-PY-0001
CONTROL ROOM LAYOUT & ARRANGEMENT DRAWING	BK-GCS-PEDCO-120-IN-PY-0001
ROAD, PAVING AND PLANT FINISH GRADING LAYOUT & SECTIONS	BK-GCS-PEDCO-120-CY-PY-0005
ELECTRICAL CABLE ROUTE & SECTION LAYOUT FOR BUILDING & SHELTER	BK-GCS-PEDCO-120-EL-PY-0006
FOUNDATION DRAWING FOR EXTENSION OF CONTROL BUILDING	BK-GNRL-PEDCO-220-ST-DW-0004
STRUCTURAL DRAWING FOR EXTENSION OF CONTROL BUILDING	BK-GNRL-PEDCO-220-ST-DW-0005
STANDARD DETAILS FOR LADDER & SAFETY CAGE	BK-GNRL-PEDCO-000-ST-DW-0009
AREA ELECTRICAL CABLE ROUTE & SECTION LAYOUT	BK-GCS-PEDCO-120-EL-PY-0005
UNIT FLOT PLAN DRAWING	BK-PPL-PEDCO-120-PI-PY-0001
CONTROL ROOM CABLE ROUTE LAYOUT	BK-GCS-PEDCO-120-IN-PY-0002
INSTRUMENT/PAG CABLE TRENCH/ROUTE LAYOUT DRAWING	BK-GCS-PEDCO-120-IN-PY-0004
ELECTRICAL EQUIPMENT ARRANGEMENT LAYOUT FOR BUILDING	BK-GCS-PEDCO-120-EL-PY-0008

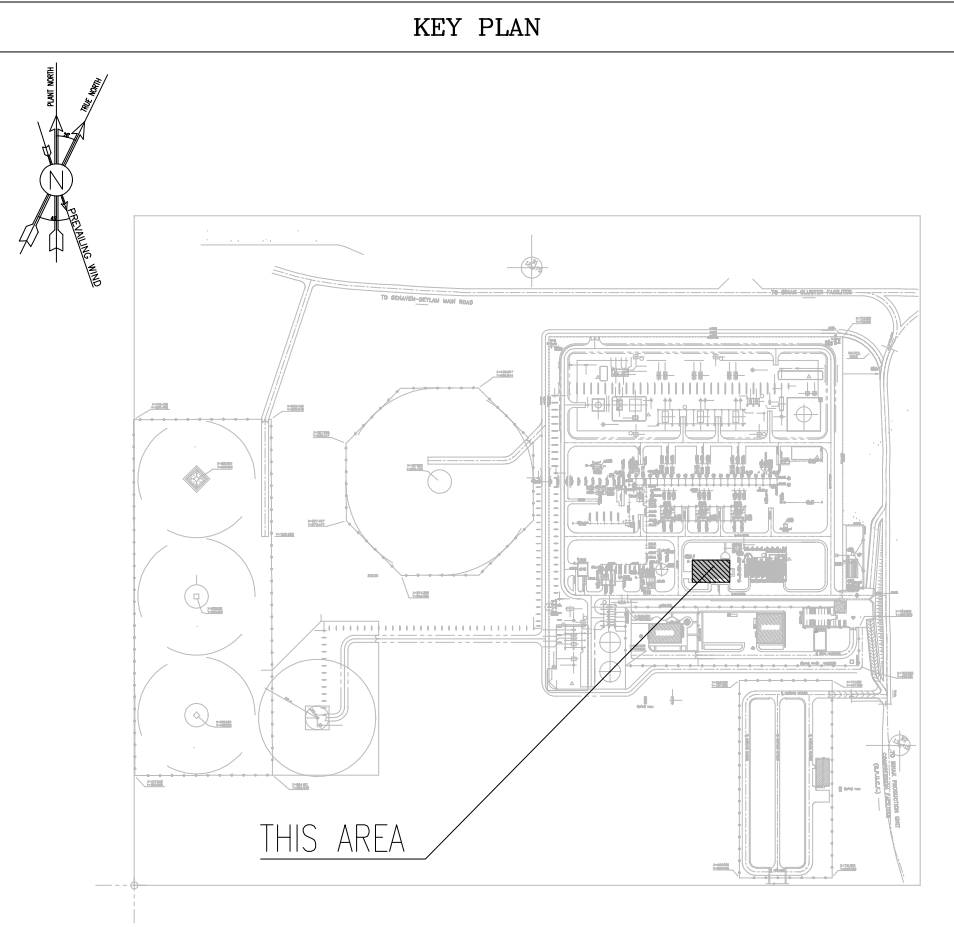

D04	NOV. 2024	AFC	R.BERLOUIE	M.FAKHARIAN	M.SABEGHAN	***
D03	MAR. 2024	AFC	R.BERLOUIE	M.FAKHARIAN	S.Paramarspour	***
D02	NOV. 2023	AFC	R.BERLOUIE	M.FAKHARIAN	S.Paramarspour	***
D01	SEP. 2023	IFA	R.BERLOUIE	M.FAKHARIAN	A.M.MOHSENI	***
D00	JUN. 2023	IPC	R.BERLOUIE	M.FAKHARIAN	A.M.MOHSENI	***
REV.	DATE	P.O.I.S	PREP.	CHK.	APP.	AUT.
PROJECT NAME: BINAK OILFIELD DEVELOPMENT/SURFACE FACILITIES GAS COMPRESSOR STATION						
PROJECT NO.:			971020			
EPC CONTRACTOR:			EPD/EPC CONTRACTOR (GC):			
 HIRGAN ENERGY – DESIGN & INSPECTION COMPANIES			 PETROIRAN DEVELOPMENT COMPANY			
DRAWING TITLE: Architectural Detail Drawing For Extension of EXISTING Control Building DETAILS						
SCALE	SIZE	DRAWING NO.			SHEET NO.	REV.
AS SHOWN	A1	BK-GCS-PEDCO-120-AR-DW-0011			12 OF 13	D04

