
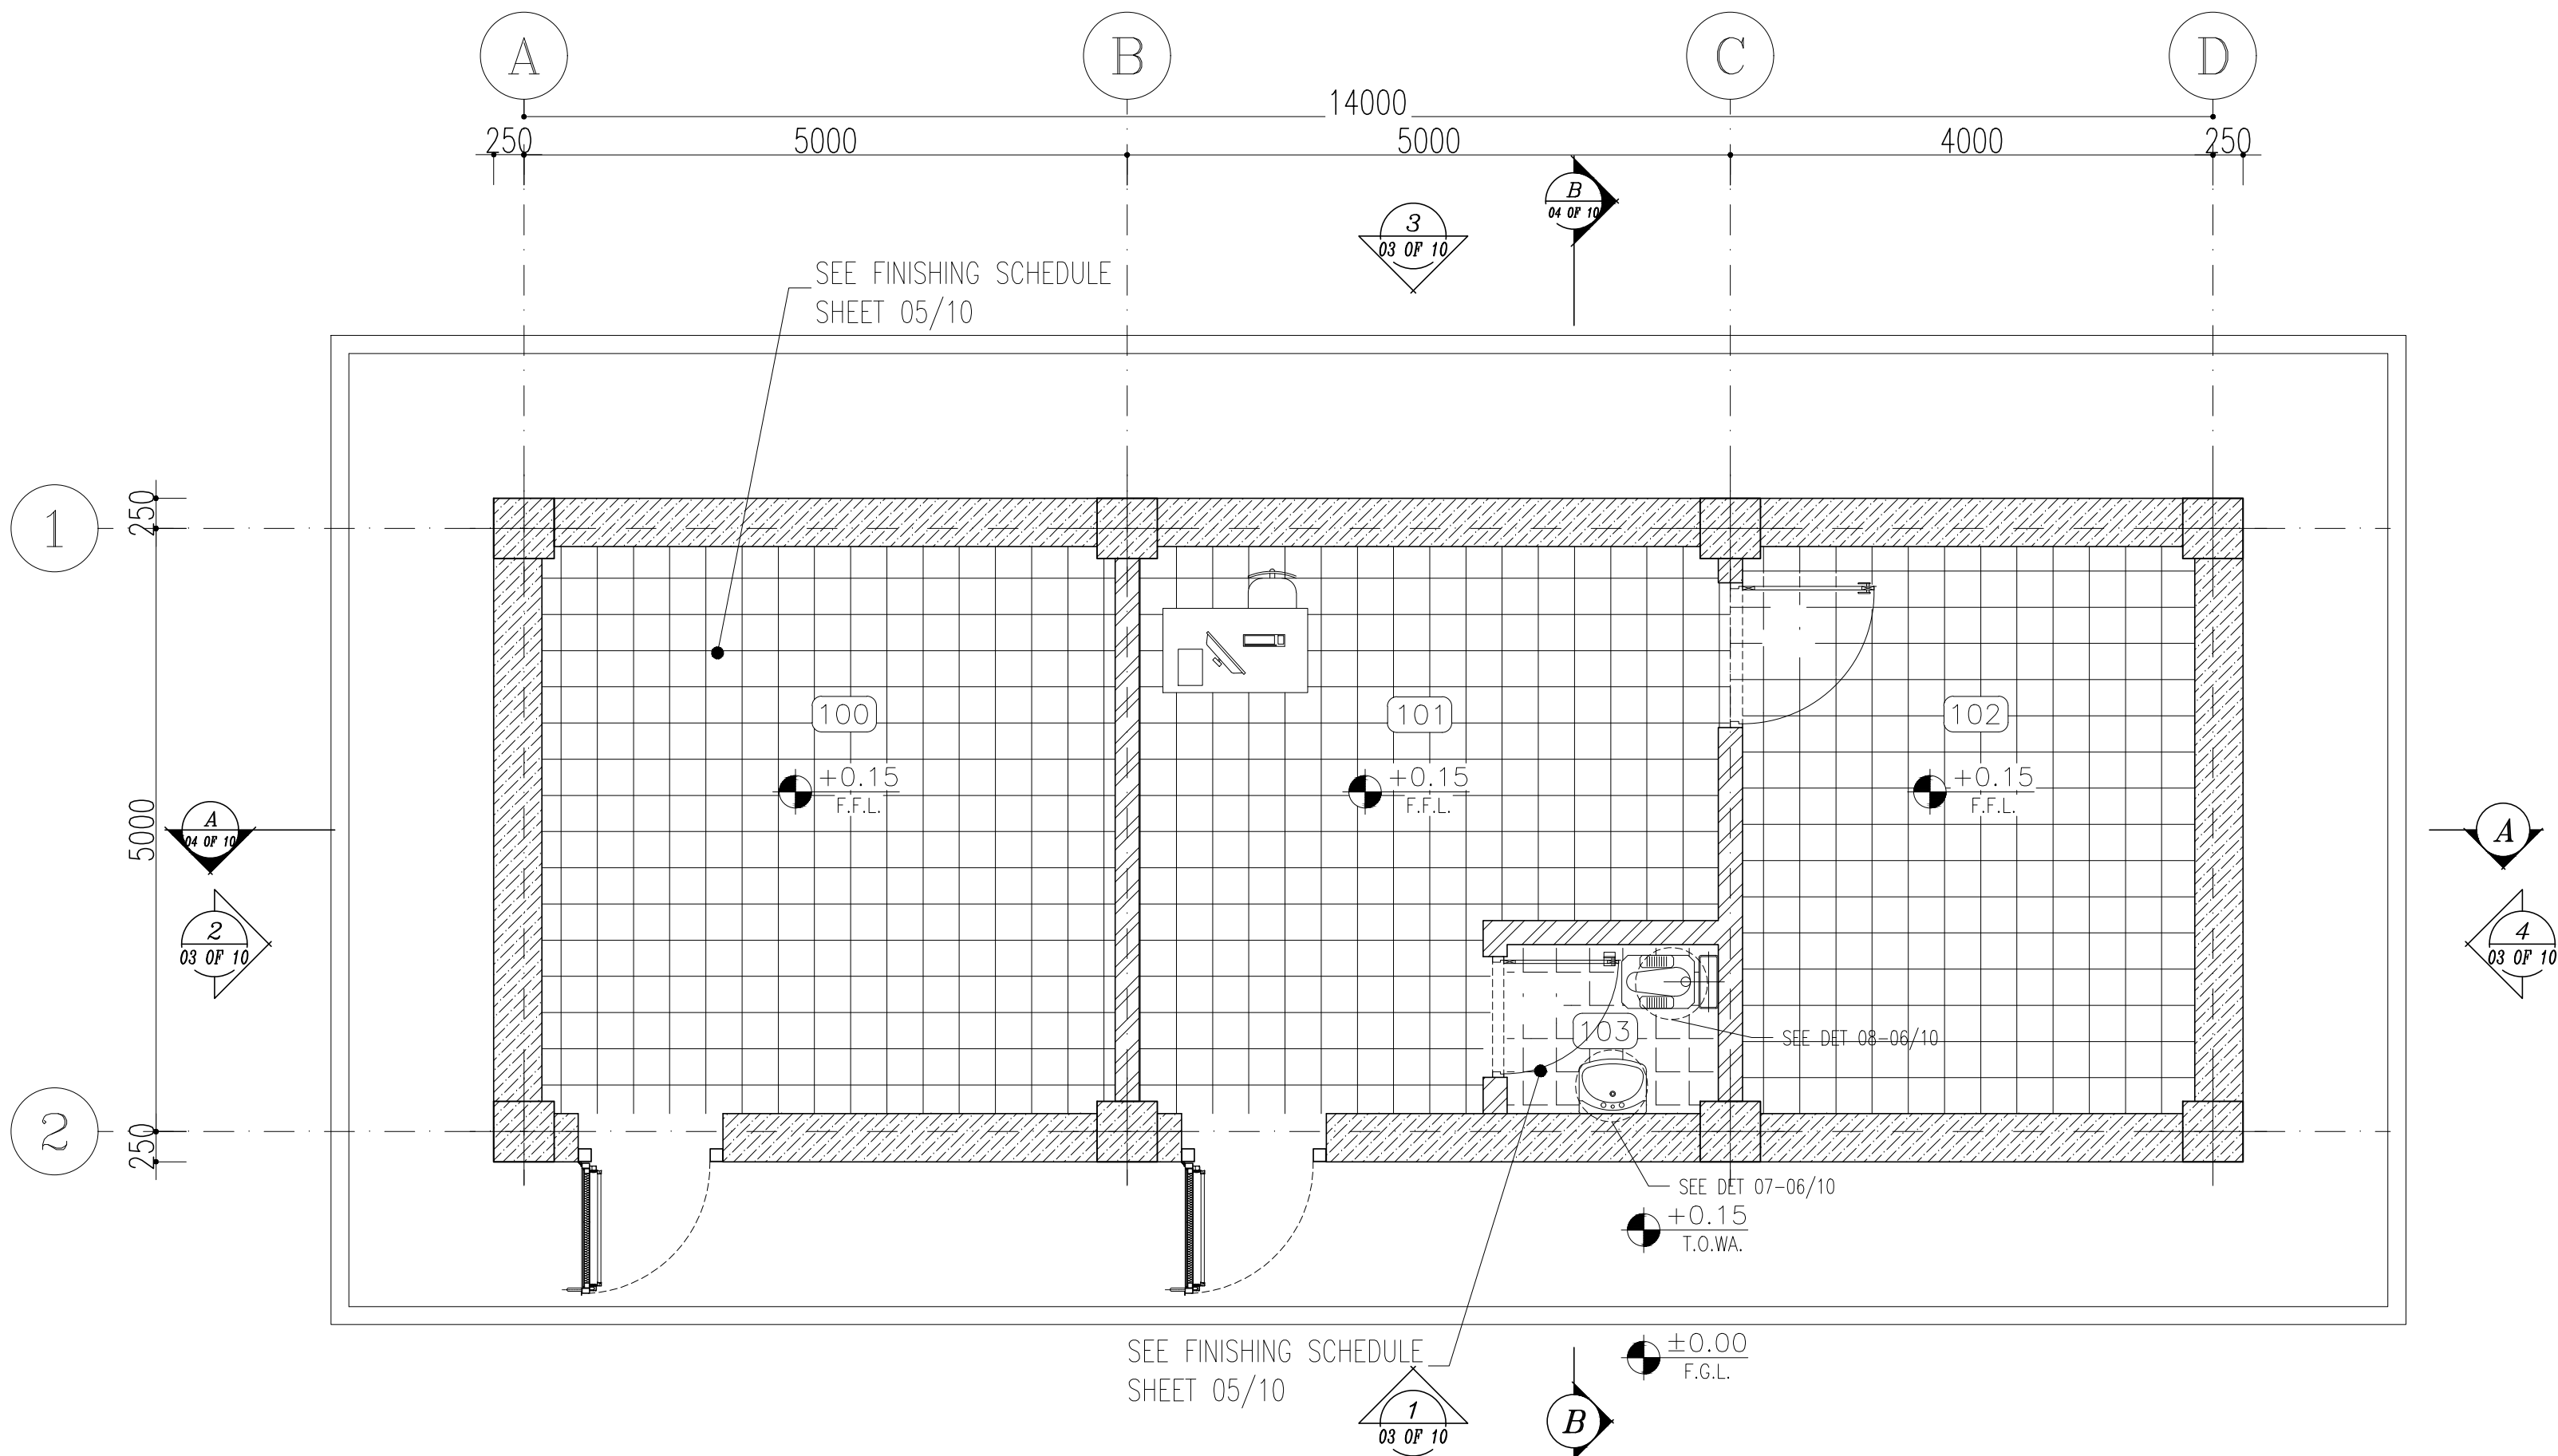


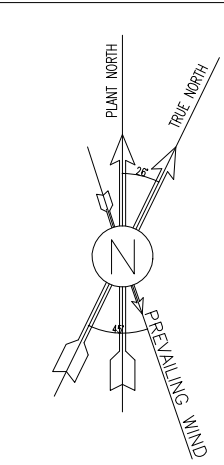





2 FLOORING PLAN
SC.1:50

100	STORAGE
101	INSTRUMENT WORKSHOP
102	INSTRUMENT STORAGE
103	TOILET
104	ROOF
105	WALKWAY


D03	NOV.2024	AFC	R.BERLOUIE	M.FAKHARIAN	M.SADDEGHIAN	***
D02	APR.2024	AFC	R.BERLOUIE	M.FAKHARIAN	S.PARAMARZPOUR	***
D01	MAR.2024	IFA	R.BERLOUIE	M.FAKHARIAN	S.PARAMARZPOUR	***
D00	NOV.2023	IPC	R.BERLOUIE	M.FAKHARIAN	S.PARAMARZPOUR	***
REV.	DATE	P.O.I.S	PREP.	CHK.	APP.	AUT.

PROJECT NAME:		BINAK OILFIELD DEVELOPMENT/SURFACE FACILITIES GAS COMPRESSOR STATION			
PROJECT NO.:		971020			
EPC CONTRACTOR:		EPD/EPC CONTRACTOR (GC):			
 HIRGAN ENERGY – DESIGN & INSPECTION COMPANIES		  PEDCO		 PETROIRAN DEVELOPMENT COMPANY	
DRAWING TITLE:		ARCHITECTURAL DETAIL DRAWING FOR GCS WAREHOUSE PLANS			
SCALE	SIZE	DRAWING NO.		SHEET NO.	REV.
AS SHOWN	A1	BK-GCS-PEDCO-120-AR-DW-0012		02 OF 10	D03

    - NOTES
1. ALL DIMENSIONS ARE IN MILLIMETER & ALL ELEVATIONS ARE IN METER.
 2. ALL DIMENSIONS AND ELEVATIONS SHALL BE CHECKED BY THE CONTRACTOR PRIOR TO CONSTRUCTION.
 3. CONTRACTOR SHALL COMPARE ALL ARCHITECTURAL, MECHANICAL, ELECTRICAL, PIPING AND STRUCTURAL DRAWINGS AND IN CASE OF ANY CONFLICTS OR DISCREPANCY, INFORM THE ENGINEER.
 4. ALL MATERIALS ARE SELECTED FROM THE HIGHEST QUALITY AND MUST BE APPROVED BY THE CLIENT.
 5. ALL OPENINGS FOR PIPING/CABLING AND HVAC OPENINGS SHALL BE CONSIDERED AS PER RELATED DRAWINGS BEFORE CONSTRUCTION.
 6. ARCHITECTURAL DETAIL DESIGN WILL BE REVISED BASED ON APPROVED STRUCTURAL DRAWINGS.
 7. FINISH GRADING LEVEL (F.G.L.) : +11.00 (M.S.L.) = ±0.00 (LOCAL).
 8. TO SEE THE COORDINATE OF THE BUILDING, PLEASE REFER TO THE STRUCTURAL DOCUMENTS.



LEGEND	
REINFORCED CONCRETE	
BRICK WORK	
CERAMIC TILE	
TERRAZZO TILES – 30x30cm	
GYPSUM BOARD 60x60 REMOVABLE SUSPENDED CEILING	
PVC SUSPENDED CEILING	
BRICK FACED	
F.F.L.	FINISHED FLOOR
T.O.WA	TOP OF WALKWAY
T.O.P.	TOP OF PARAPET
T.O.FOU.	TOP OF FOUNDATION
M.D	METAL DOOR
T.O.R.	TOP OF ROOF
T.O.D.	TOP OF DOOR
B.O.Co.	BOTTOM OF CAGE
T.O.Co.	TOP OF CAGE
M.D.	METAL DOOR
F.G.L.	FINISH GRADING LEVEL
B.O.S.	BOTTOM OF SLEEVE
B.O.O.	BOTTOM OF OPENING
B.O.T.	BOTTOM OF TRENCH
T.O.S.	TOP OF SLAB
B.P.D.	BLAST PROOF DOOR



REFERENCE DRAWING	DRG. No.
STANDARD DRAWING FOR ARCHITECTURAL DETAILS	BK-GNRL-PEDCO-000-AR-DW-0001
SITE SEWORAGE SYSTEM LAYOUT & DETAILS	BK-GCS-PEDCO-120-CV-PY-0001
AREA ELECTRICAL CABLE ROUTE & SECTION LAYOUT	BK-GCS-PEDCO-120-EL-PY-0005
ROAD, PAVING AND PLANT FINISH GRADING LAYOUT & SECTIONS	BK-GCS-PEDCO-120-CV-PY-0005
STANDARD DETAILS FOR LADDER & SAFETY CAGE	BK-GNRL-PEDCO-000-ST-DW-0009
ELECTRICAL EQUIPMENT ARRANGEMENT LAYOUT FOR BUILDING	BK-GCS-PEDCO-120-EL-PY-0008
UNIT PLOT PLAN DRAWING	BK-GCS-PEDCO-120-PI-PY-0001
FOUNDATION DRAWING FOR GCS WAREHOUSE	BK-GCS-PEDCO-120-ST-DW-0083
STRUCTURAL DRAWING FOR GCS WAREHOUSE	BK-GCS-PEDCO-120-ST-DW-0084
CABLE TRENCH AND DUCT BANK LAYOUT	BK-GCS-PEDCO-120-CV-PY-0002
STANDARD DRAWING FOR PAVINGS	BK-GNRL-PEDCO-000-CV-DW-0035
PLUMBING & SEWAGE PIPING LAYOUT FOR GCS WAREHOUSE	BK-GCS-PEDCO-120-HV-PY-0017

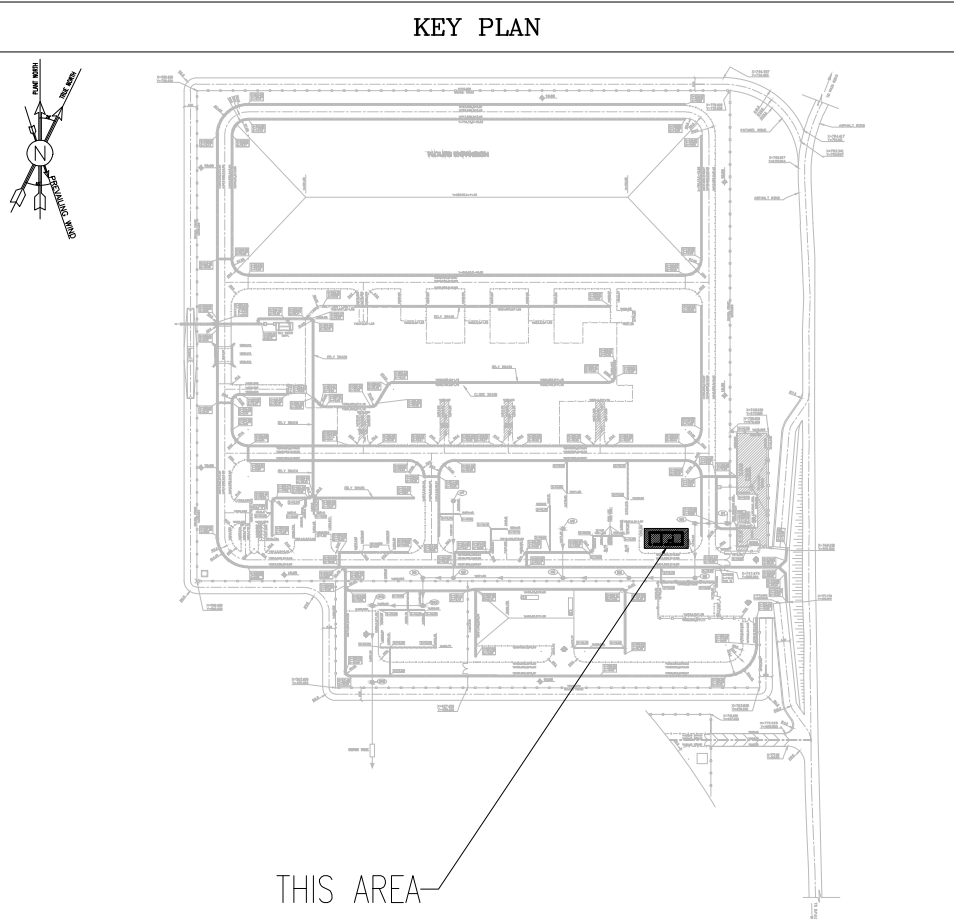

***	*****	*** **	*** ****	*** **	*** ****
REV.	DESCRIPTION	BY	DATE	BY	DATE
		CHECKED		REV. APPR.	
اصل و کليه نسخ اين نقشه و حق اقتباس متعلق به شرکت ملی مناطق نفت خيز جنوب مي باشد.					
THE ORIGINAL AND ALL COPIES OF THIS DRAWING TOGETHER WITH THE COPYRIGHT THEREIN ARE THE SOLE PROPERTY OF N.I.S.O.C./ FIELDS					

BINAK OILFIELD DEVELOPMENT SURFACE FACILITIES GAS COMPRESSOR STATION					
DATE	SCALE	DRAWING BY	CHECKED BY	PROJECT ENG.	
NO CONSTRUCTION PERMITTED UNLESS DRAWING APPROVED					
APPROVED FOR CONSTRUCTION			BY:	DATE:	
BUDGET REF.	LOCATION	SIZE CLASS	SERIAL NO.	SHEET	REVISION
053-073-9184	F	4 B	709522	02 OF 10	D03

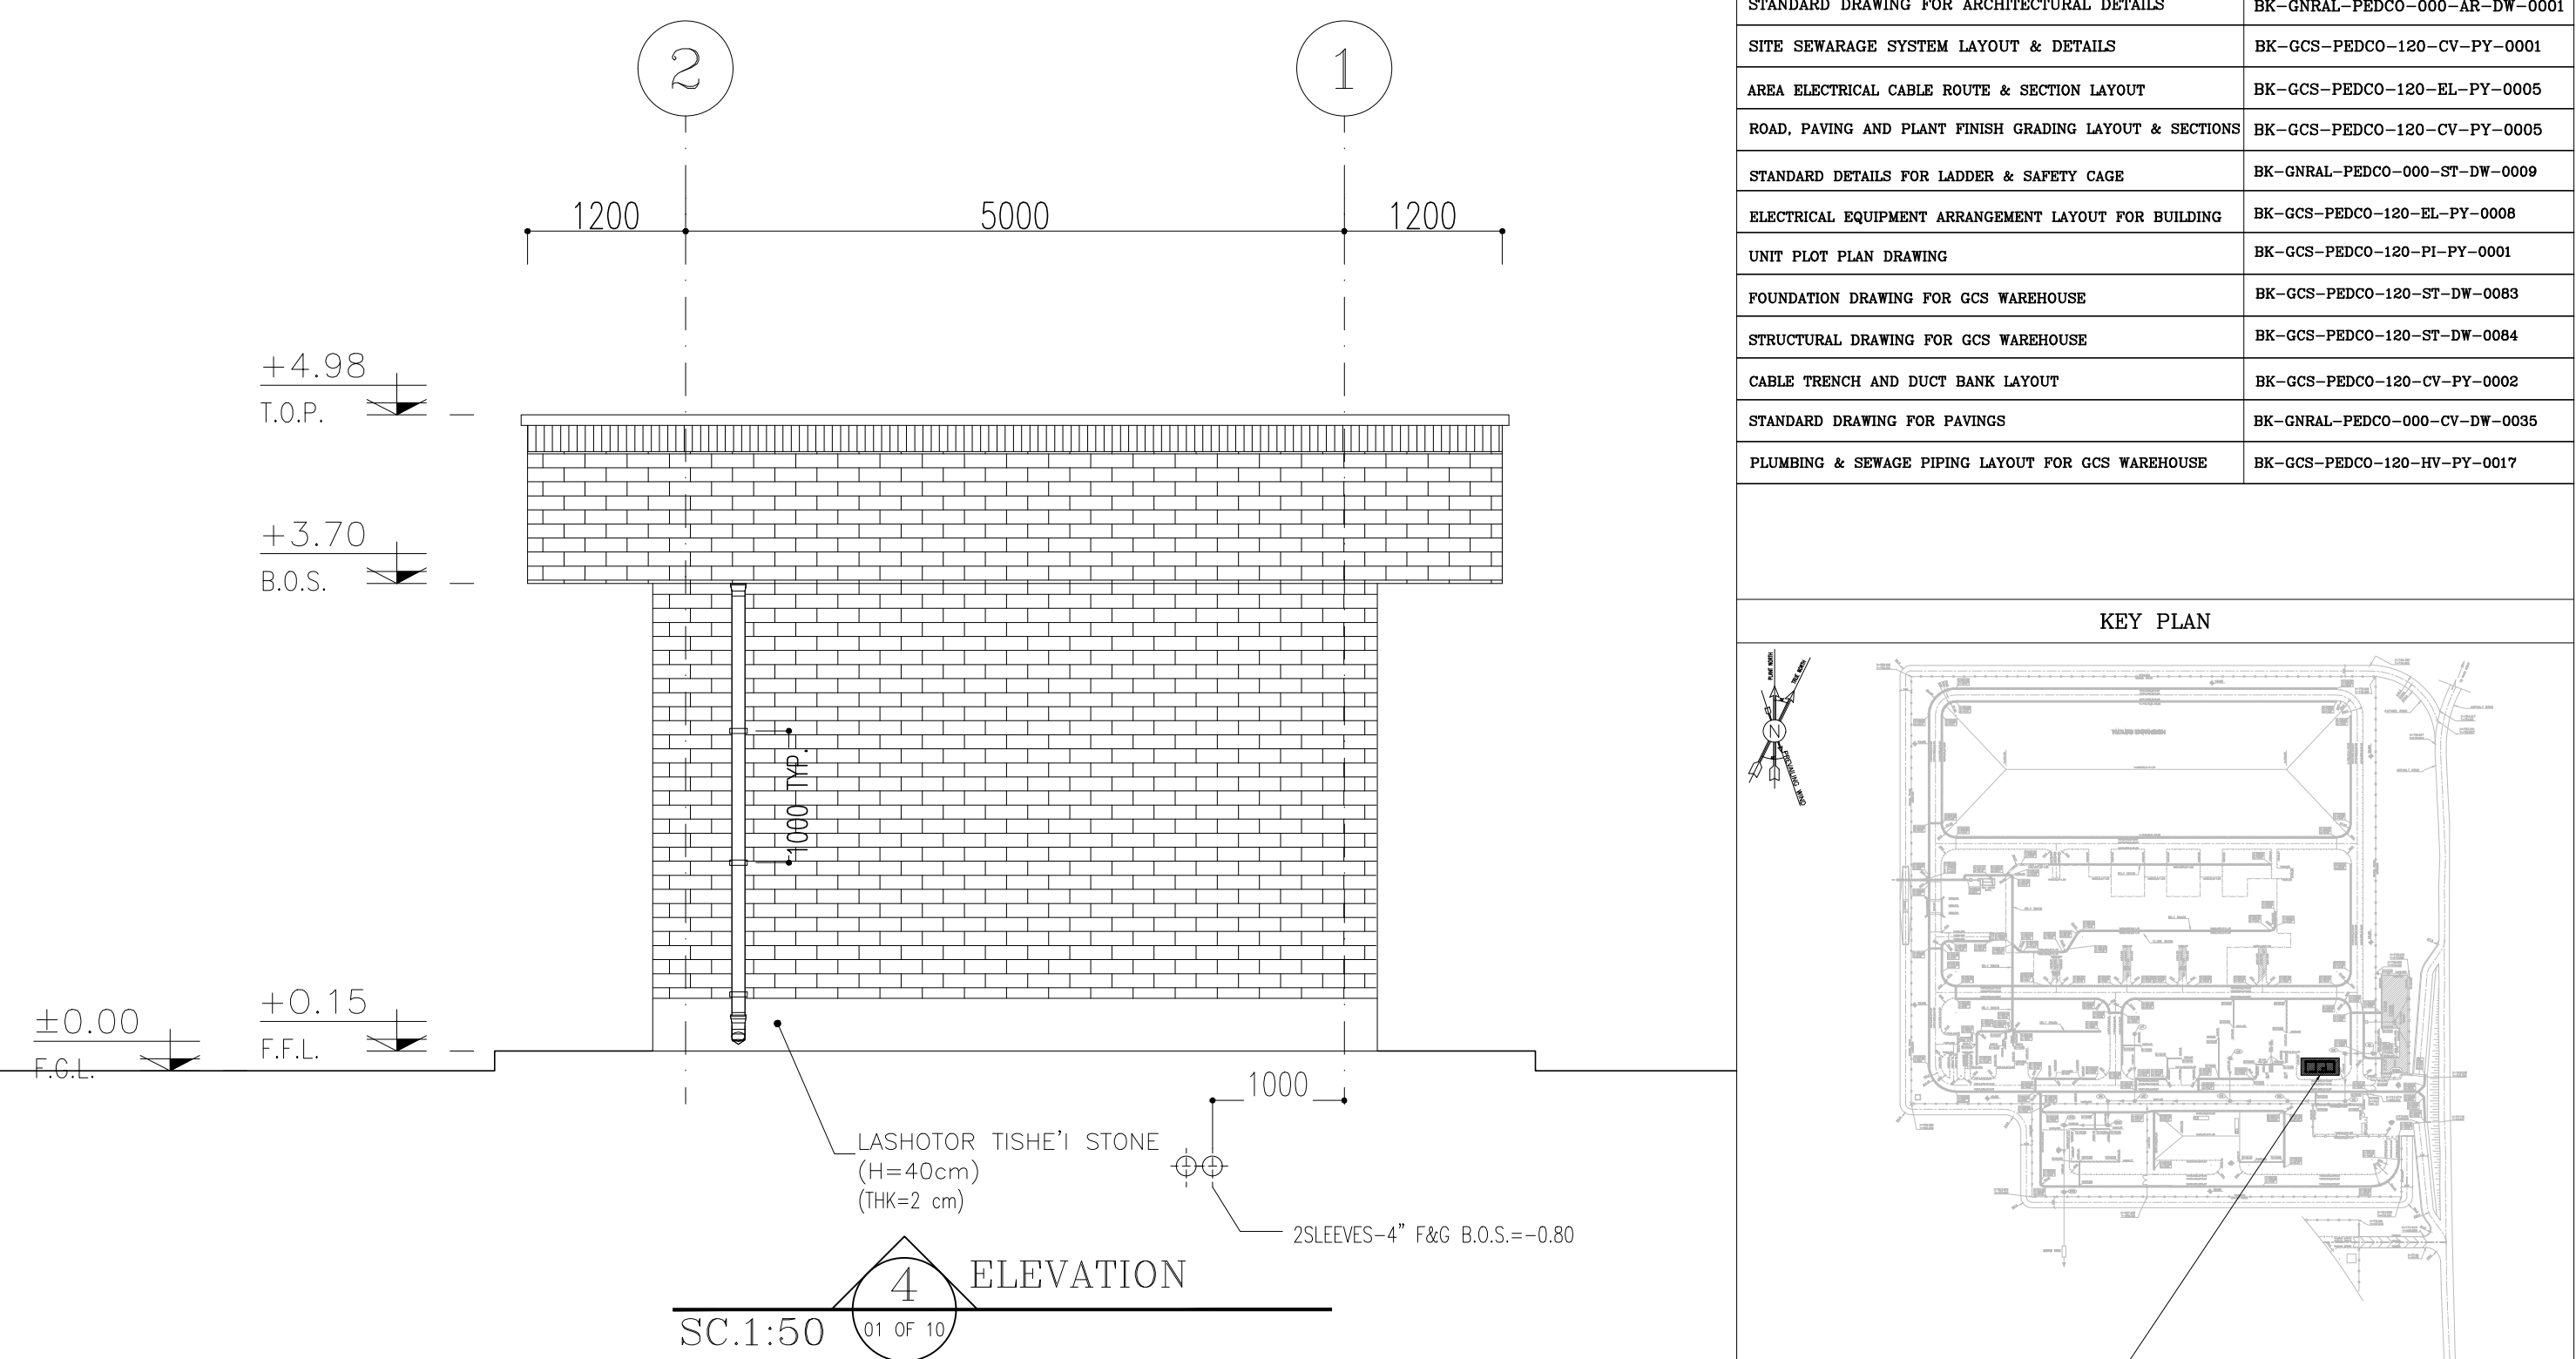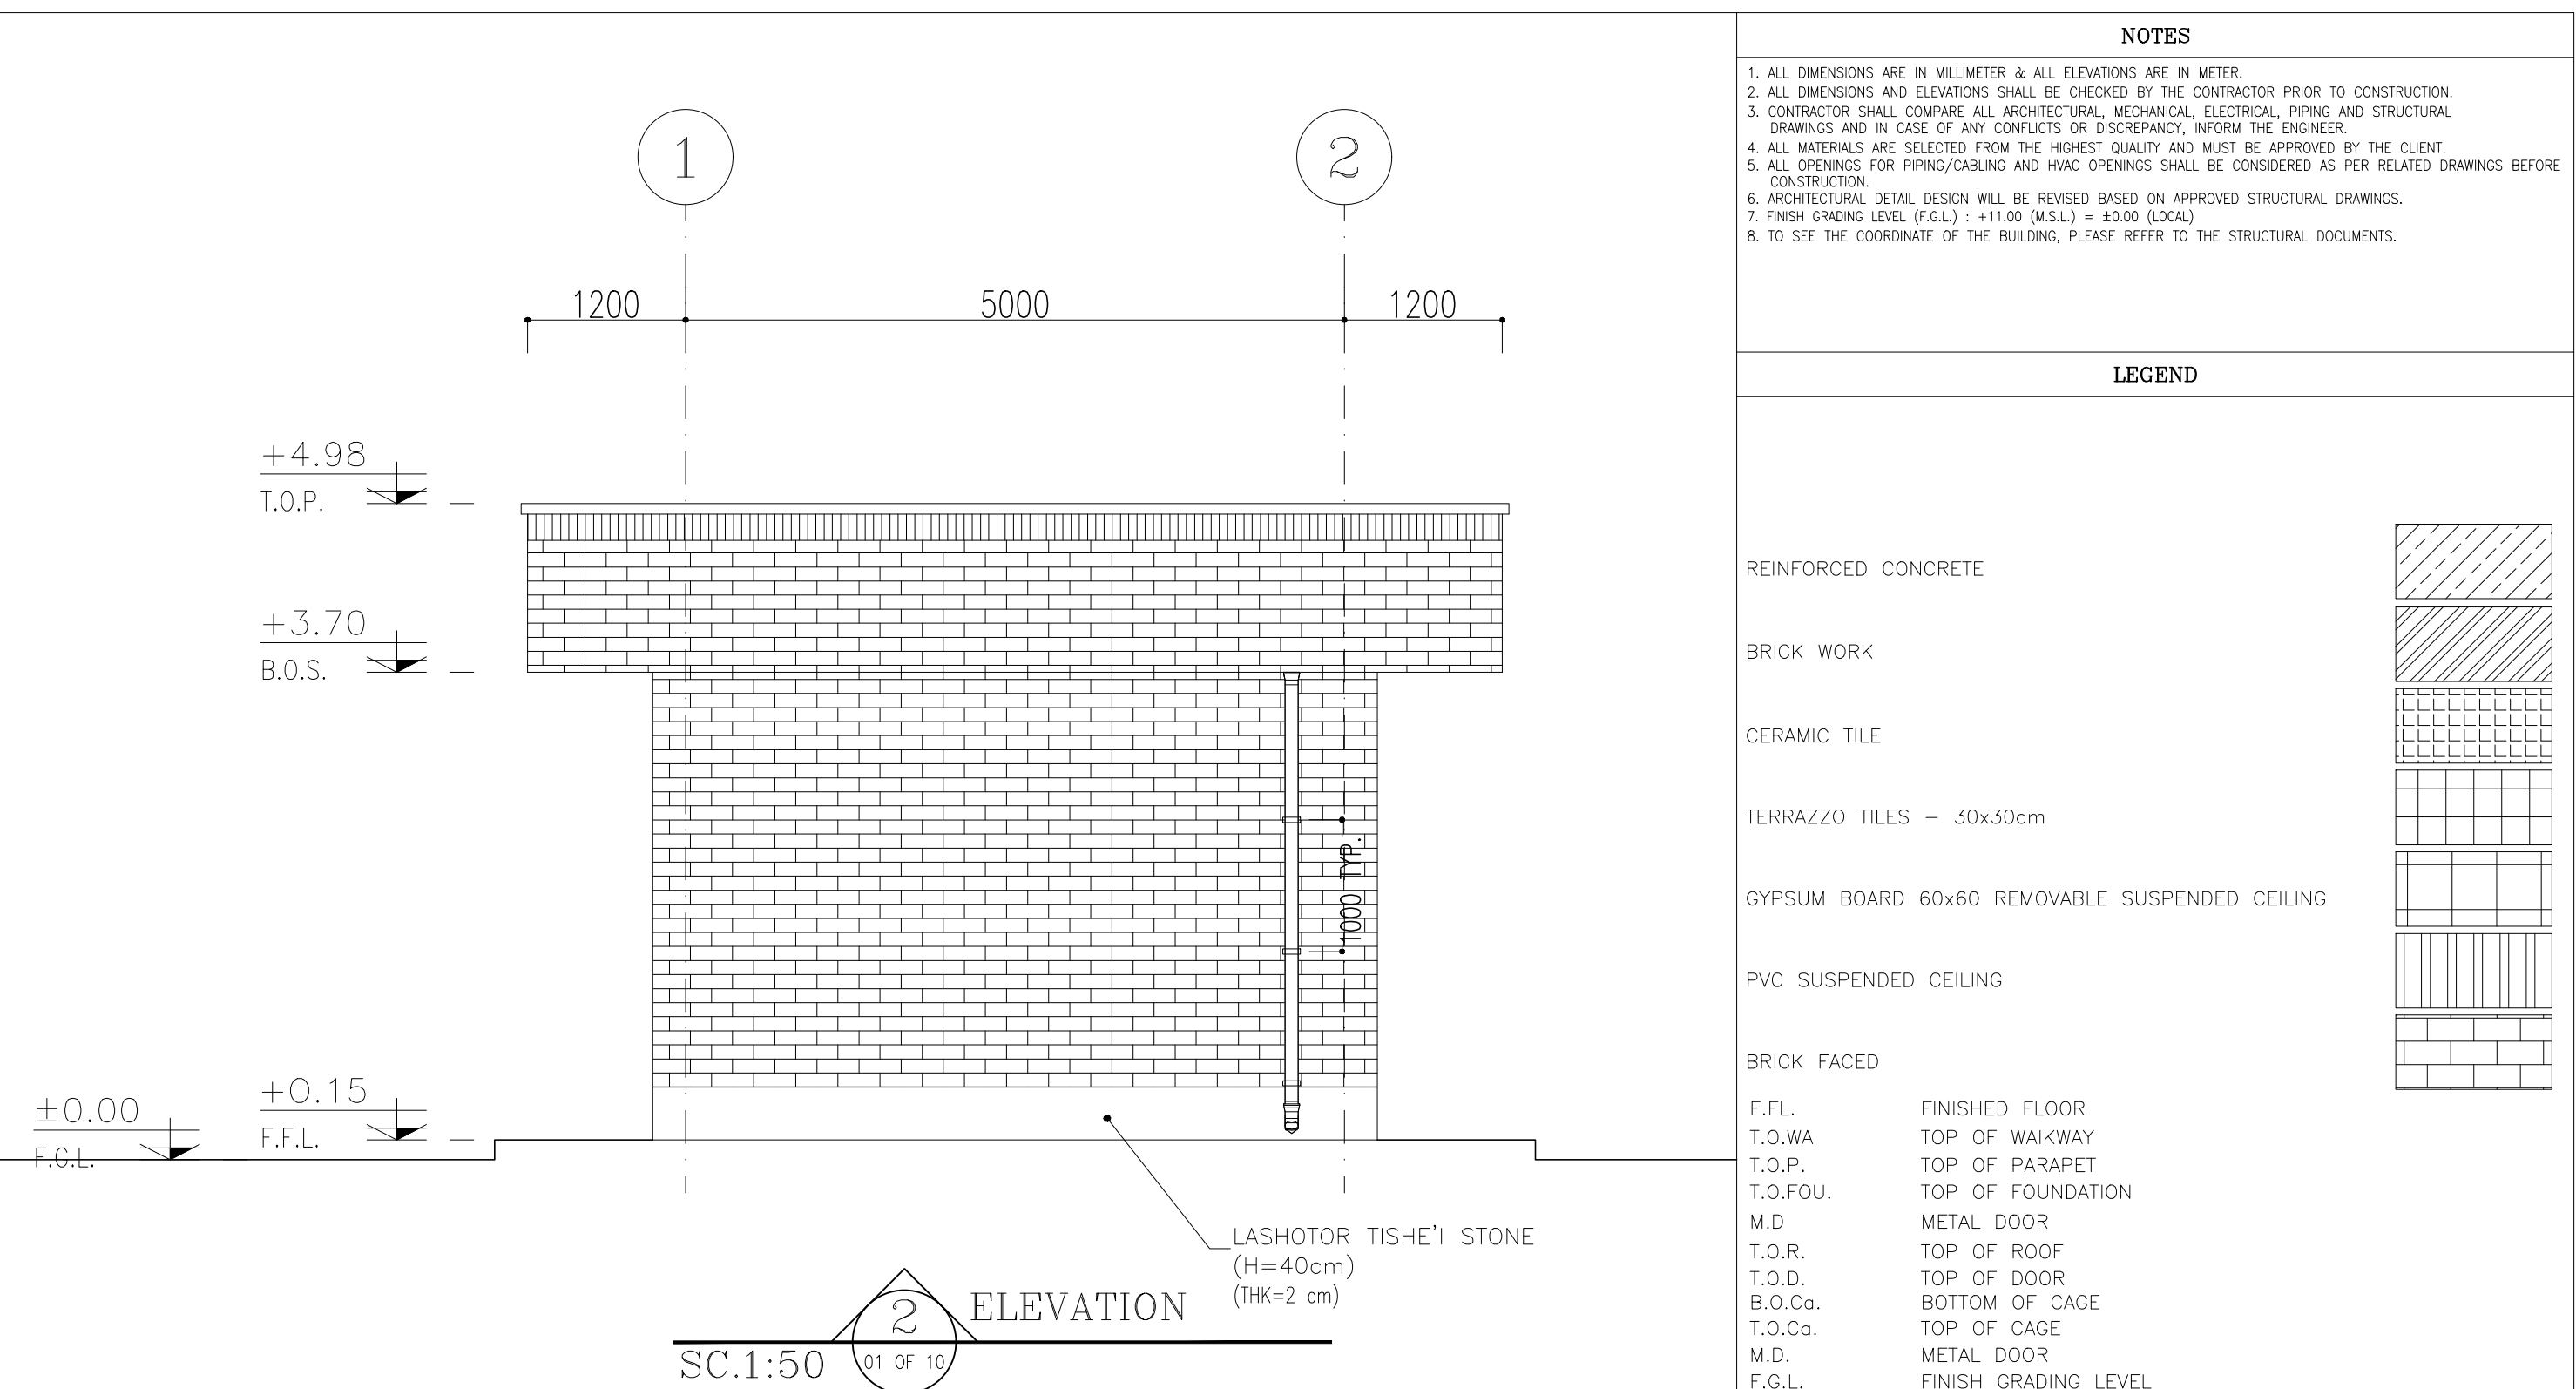[illegible]

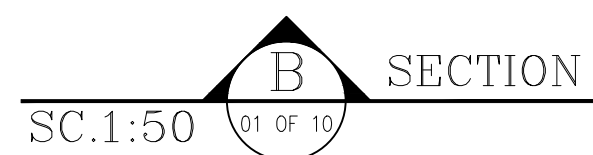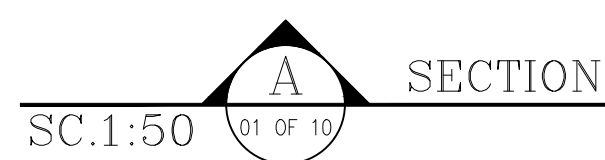

D03	NOV-2024	AFC	R.BERLOUIE	M.FAKHARIAN	M.SADIGHIAN	** *
D02	APR-2024	AFC	R.BERLOUIE	M.FAKHARIAN	S.FARAMARZPOUR	** **
D01	MAR-2024	IFA	R.BERLOUIE	M.FAKHARIAN	S.FARAMARZPOUR	** **
D00	NOV-2023	IFC	R.BERLOUIE	M.FAKHARIAN	S.FARAMARZPOUR	** **
REV.	DATE	P.O.I.S	PREP.	CHK.	APP.	AUT.
PROJECT NAME: BINKA OILFIELD DEVELOPMENT/SURFACE FACILITIES GAS COMPRESSOR STATION						
PROJECT NO.:			971020			
EPC CONTRACTOR:			EPD/EPC CONTRACTOR (GC):			
 HIRGAN ENERGY - DESIGN & INSPECTION COMPANIES			  PETROIRAN DEVELOPMENT COMPANY			
DRAWING TITLE: ARCHITECTURAL DETAIL DRAWING FOR GCS WAREHOUSE SECTIONS						
SCALE	SIZE	DRAWING NO.			SHEET No.	REV
AS SHOWN	A1	BK-GCS-PEDCO-120-AR-DW-0012			04 OF 10	DOS

NOTES

1. ALL DIMENSIONS ARE IN MILLIMETER & ALL ELEVATIONS ARE IN METER.

2. ALL DIMENSIONS AND ELEVATIONS SHALL BE CHECKED BY THE CONTRACTOR PRIOR TO CONSTRUCTION.

3. CONTRACTOR SHALL COMPARE ALL ARCHITECTURAL, MECHANICAL, ELECTRICAL, PIPING AND STRUCTURAL DRAWINGS AND IN CASE OF ANY CONFLICTS OR DISCREPANCY, INFORM THE ENGINEER.

4. ALL MATERIALS ARE SELECTED FROM THE HIGHEST QUALITY AND MUST BE APPROVED BY THE CLIENT.

5. ALL OPENINGS FOR PIPING/CABLING AND HVAC OPENINGS SHALL BE CONSIDERED AS PER RELATED DRAWINGS BEFORE CONSTRUCTION.

6. ARCHITECTURAL DETAIL DESIGN WILL BE REVISED BASED ON APPROVED STRUCTURAL DRAWINGS.

7. FINISH GRADING LEVEL (F.G.L.) - +11.00 (M.S.L.) = ±0.00 (LOCAL).

8. TO SEE THE COORDINATE OF THE BUILDING, PLEASE REFER TO THE STRUCTURAL DOCUMENTS.

LEGEND

REINFORCED CONCRETE

BRICK WORK

CERAMIC TILE


TERRAZZO TILES ~ 30x30cm

GYPSON BOARD 60x60 REMOVABLE SUSPENDED CEILING

PVC SUSPENDED CEILING

BRICK FACED

F.FL. FINISHED FLOOR
T.O.WA TOP OF WALKWAY
T.O.P. TOP OF PARAPET
T.O.FOU. TOP OF FOUNDATION
M.D METAL DOOR
T.O.R. TOP OF ROOF
T.O.D. TOP OF DOOR
B.O.Cg. BOTTOM OF CAGE
T.O.Cg. TOP OF CAGE
M.D. METAL DOOR
F.G.L. FINISH GRADING LEVEL
B.O.S. BOTTOM OF SLEEVE
B.O.O. BOTTOM OF OPENING
B.O.T. BOTTOM OF TRENCH
T.O.S. TOP OF SLAB
B.P.D. BLAST PROOF DOOR

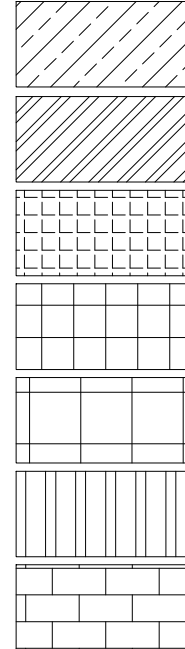

REFERENCE DRAWING

DRG. No.

STANDARD DRAWING FOR ARCHITECTURAL DETAILS

BK-GNRL-PEDCO-000-AR-DW-0001

SITE SEWORAGE SYSTEM LAYOUT & DETAILS

BK-GCS-PEDCO-120-CV-PY-0001

AREA ELECTRICAL CABLE ROUTE & SECTION LAYOUT

BK-GCS-PEDCO-120-EL-PY-0005

ROAD, PAVING AND PLANT FINISH GRADING LAYOUT & SECTIONS

BK-GCS-PEDCO-120-CV-PY-0005

STANDARD DETAILS FOR LADDER & SAFETY CAGE

BK-GNRL-PEDCO-000-ST-DW-0009

ELECTRICAL EQUIPMENT ARRANGEMENT LAYOUT FOR BUILDING

BK-GCS-PEDCO-120-EL-PY-0008

UNIT PLOT PLAN DRAWING

BK-GCS-PEDCO-120-PI-PY-0001

FOUNDATION DRAWING FOR GCS WAREHOUSE

BK-GCS-PEDCO-120-ST-DW-0083

STRUCTURAL DRAWING FOR GCS WAREHOUSE

BK-GCS-PEDCO-120-ST-DW-0084

CABLE TRENCH AND DUCT BANK LAYOUT

BK-GCS-PEDCO-120-CV-PY-0002


STANDARD DRAWING FOR PAYINGS

BK-GNRL-PEDCO-000-CY-DW-0035

PLUMBING & SEWAGE PIPING LAYOUT FOR GCS WAREHOUSE

BK-GCS-PEDCO-120-HV-PY-0017

KEY PLAN

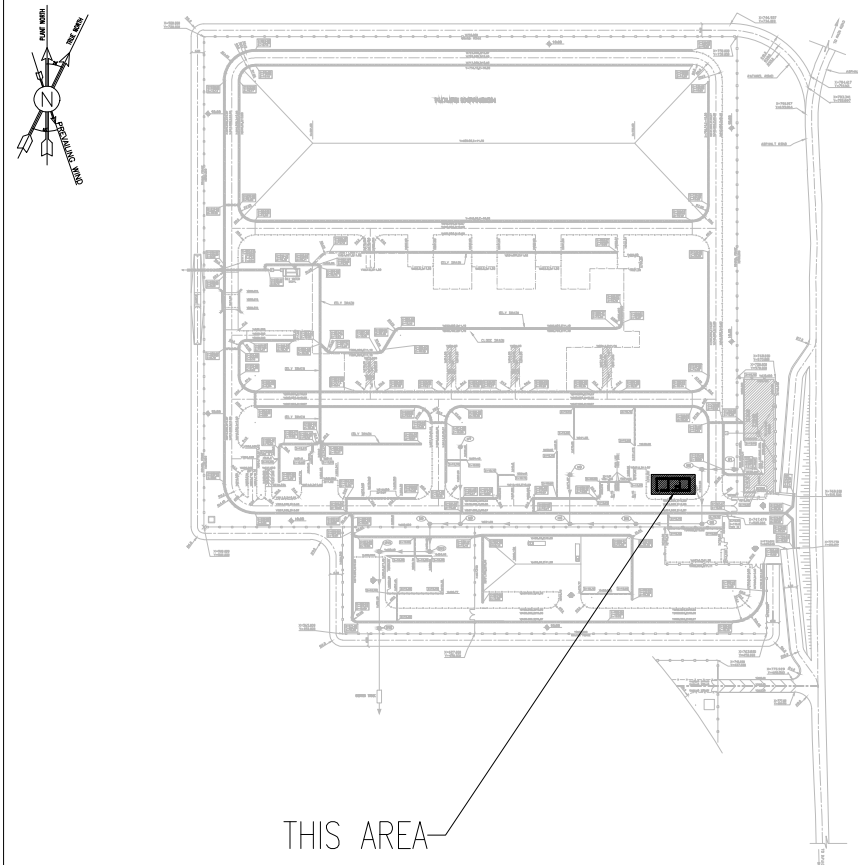

**

*** **

**

*** **

REV.

DESCRIPTION

BY

DATE

BY

DATE

CHECKED

REV. APPR.

اصل و کلیه نسخ این نقشه و حق اقتباس متعلق به شرکت ملی مناطق نفت خیز جنوب میباشد.



THE ORIGINAL AND ALL COPIES OF THIS DRAWING TOGETHER WITH THE COPYRIGHT THEREIN ARE THE SOLE PROPERTY OF
N.I.S.O.C./ FIELDS

BINAK OILFIELD DEVELOPMENT
SURFACE FACILITIES
GAS COMPRESSOR STATION

DATE

SCALE

DRAWING BY

CHECKED BY

PROJECT ENG.

NO CONSTRUCTION PERMITTED UNLESS DRAWING APPROVED

APPROVED FOR CONSTRUCTION

BY:

DATE:

BUDGET REP.

LOCATION

SIZE CLASS

SERIAL NO.

SHEET

REVISION

053-073-9184


F

4 B

709522


04 OF 10

D03

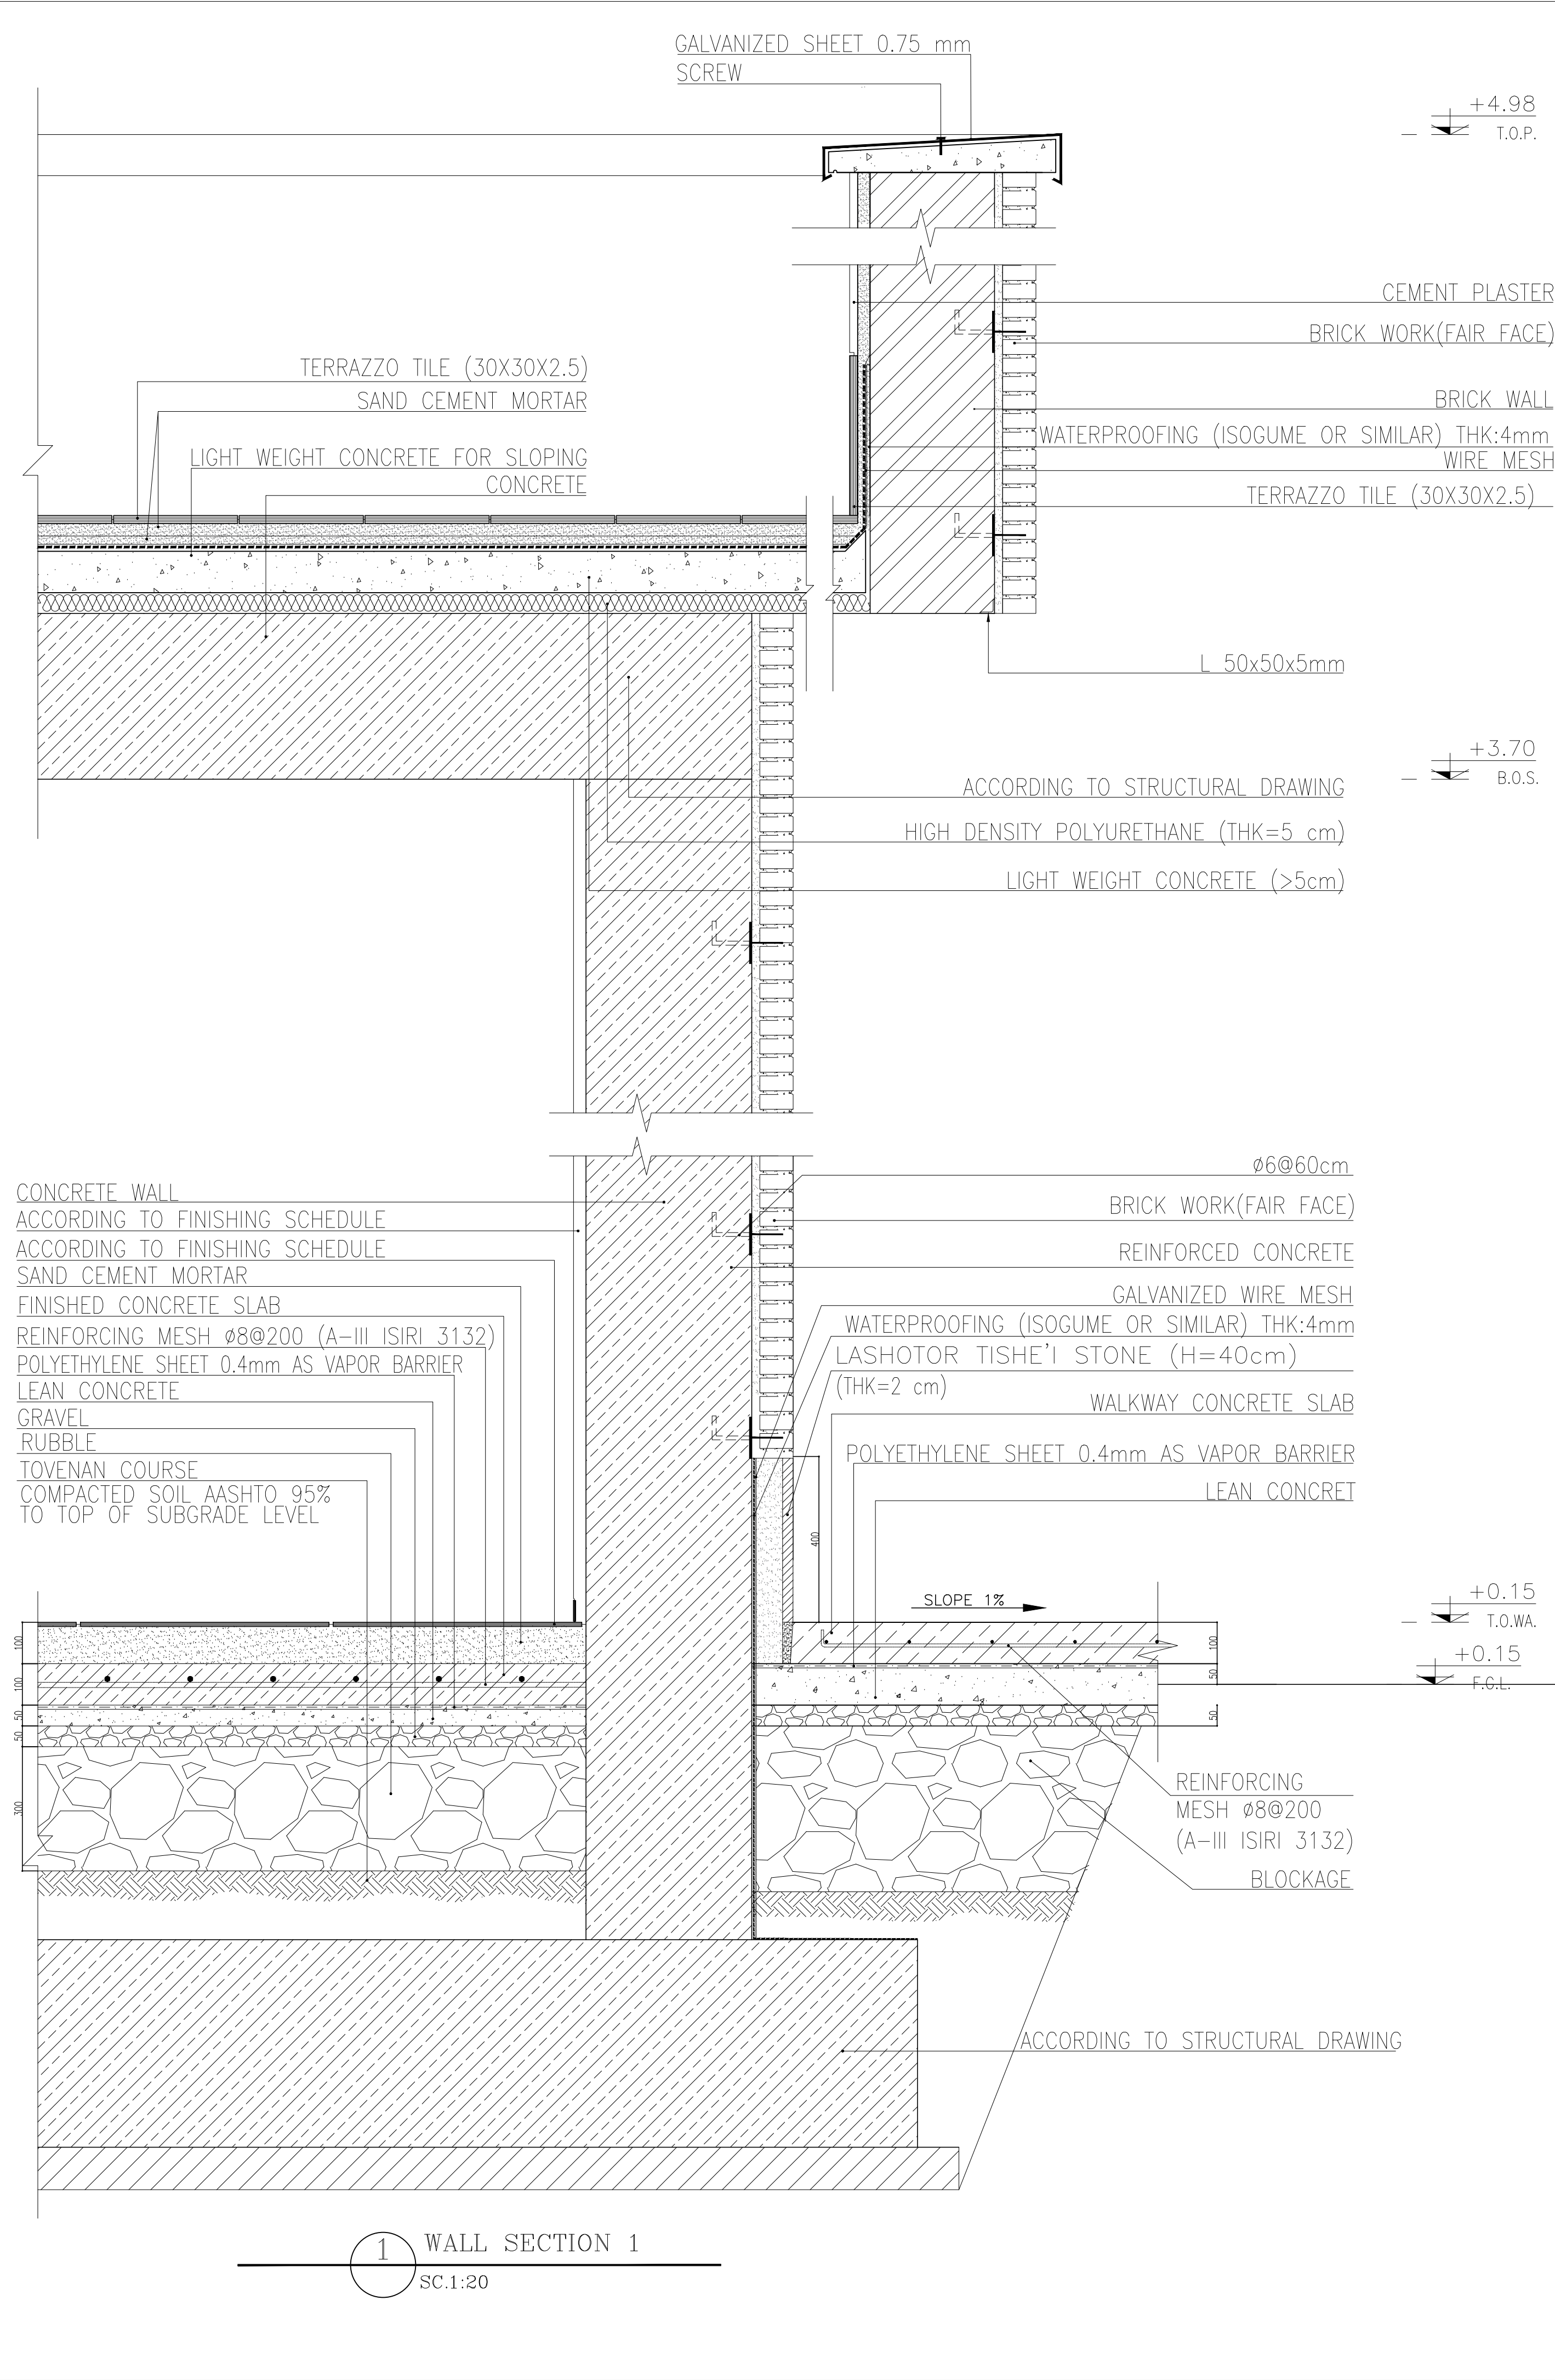

FINISHING SCHEDULE								
	AREA	FLOOR	MATERIAL DIMENSION	INTERNAL SKIRTING	EXTERNAL SKIRTING	INTERNAL WALL	EXTERNAL WALL	CEILING
100	STORAGE	TERRAZZO TILE	(60x60)	—	—	GYPSUM PLASTER + OIL PAINT + CEMENT PLASTER LAYER	BRICK FACING	—
101	INSTRUMENT WORKSHOP	TERRAZZO TILE	(60x60)	—	—	GYPSUM PLASTER + OIL PAINT + CEMENT PLASTER LAYER	BRICK FACING	—
102	INSTRUMENT STORAGE	TERRAZZO TILE	(60x60)	—	—	GYPSUM PLASTER + OIL PAINT + CEMENT PLASTER LAYER	BRICK FACING	—
103	TOILET	FIRST CLASS IRANIAN CERAMIC TILES	(30x30)	—	—	GLAZED TILE 25x30 UP TO +2.80	BRICK FACING	PVC SUSPENDED CEILING
104	ROOF	TERRAZOO TILE FIRST GRADE	(30x30)	TERRAZZO TILE (30x30X2.5)	—	CEMENT PLASTER	BRICK FACING	—

LINTEL SCHEDULE		
WIDTH a	SPAN b mm	PROFILE mm a≥200
VARIES— IT DEPENDS ON WALL THICKNESS AND IT'S FINISHING. REFER TO ARCHITECTURAL DWGS.	b≤1100	IPE 120
	1100<b≤1500	IPE 140
	1600<b≤2100	2IPE 120
	2100<b≤3000	2IPE 160
	3000<b≤3600	2IPE 180

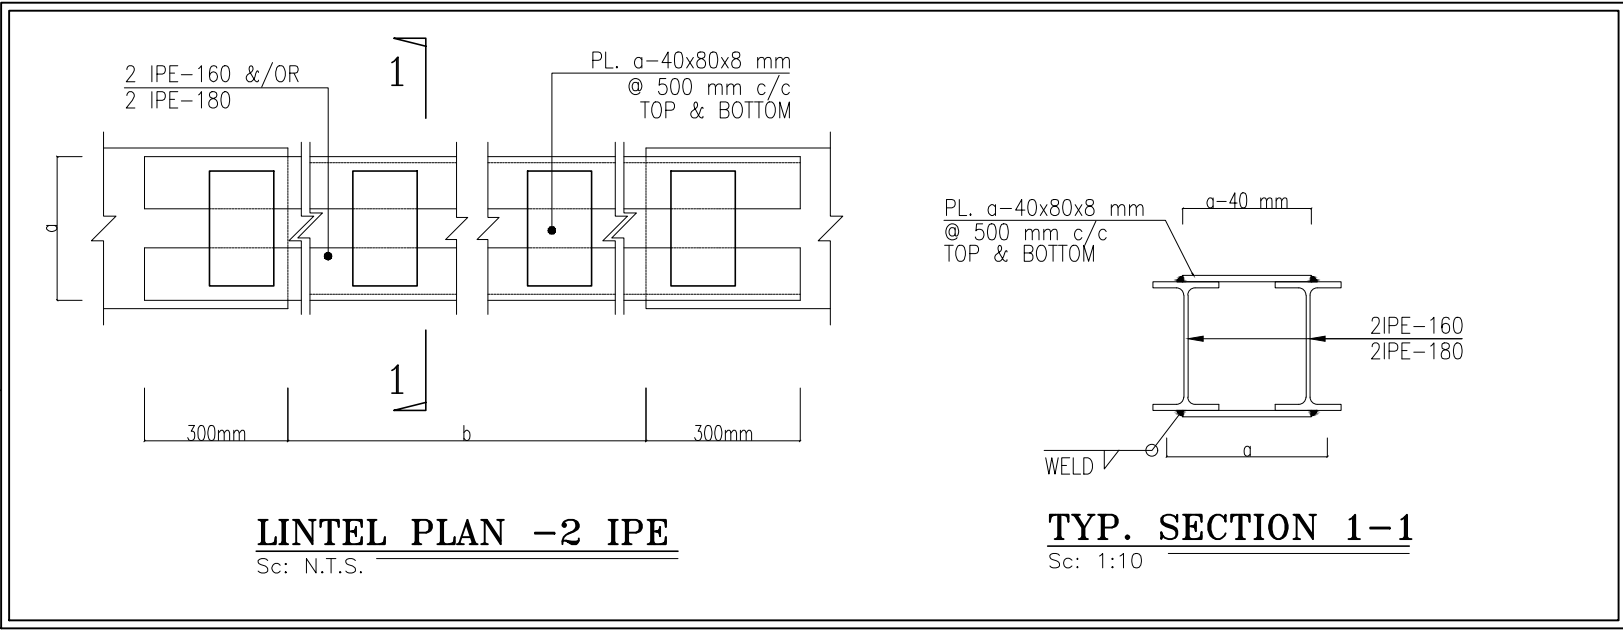

NOTES

1. ALL DIMENSIONS ARE IN MILLIMETER & ALL ELEVATIONS ARE IN METER.
2. ALL DIMENSIONS AND ELEVATIONS SHALL BE CHECKED BY THE CONTRACTOR PRIOR TO CONSTRUCTION.
3. CONTRACTOR SHALL COMPARE ALL ARCHITECTURAL, MECHANICAL, ELECTRICAL, PIPING AND STRUCTURAL DRAWINGS AND IN CASE OF ANY CONFLICTS OR DISCREPANCY, INFORM THE ENGINEER.
4. ALL MATERIALS ARE SELECTED FROM THE HIGHEST QUALITY AND MUST BE APPROVED BY THE CLIENT.
5. ALL OPENINGS FOR PIPING/CABLING AND HVAC OPENINGS SHALL BE CONSIDERED AS PER RELATED DRAWINGS BEFORE CONSTRUCTION.
6. ARCHITECTURAL DETAIL DESIGN WILL BE REVISED BASED ON APPROVED STRUCTURAL DRAWINGS.
7. FINISH GRADING LEVEL (F.G.L.) : +11.00 (M.S.L.) ± 30.00 (LOCAL)
8. TO SEE THE COORDINATE OF THE BUILDING, PLEASE REFER TO THE STRUCTURAL DOCUMENTS.

LEGEND

REINFORCED CONCRETE

BRICK WORK

CERAMIC TILE

TERRAZZO TILES - 30x30cm

GYPSUM BOARD 60x60 REMOVABLE SUSPENDED CEILING

PVC SUSPENDED CEILING

BRICK FACED

F.F.L. FINISHED FLOOR
T.O.WA TOP OF WALKWAY
T.O.P. TOP OF PARAPET
T.O.FOU. TOP OF FOUNDATION
M.D. METAL DOOR
T.O.R. TOP OF ROOF
T.O.D. TOP OF DOOR
B.O.Co. BOTTOM OF CAGE
T.O.Co. TOP OF CAGE
M.D. METAL DOOR
F.G.L. FINISH GRADING LEVEL
B.O.S. BOTTOM OF SLEEVE
B.O.O. BOTTOM OF OPENING
B.O.T. BOTTOM OF TRENCH
T.O.S. TOP OF SLAB
B.P.D. BLAST PROOF DOOR

REFERENCE DRAWING



DRG. No.

STANDARD DRAWING FOR ARCHITECTURAL DETAILS	BK-GNRL-PEDCO-000-AR-DW-0001
SITE SEWORAGE SYSTEM LAYOUT & DETAILS	BK-GCS-PEDCO-120-CV-PY-0001
AREA ELECTRICAL CABLE ROUTE & SECTION LAYOUT	BK-GCS-PEDCO-120-EL-PY-0005
ROAD, PAVING AND PLANT FINISH GRADING LAYOUT & SECTIONS	BK-GCS-PEDCO-120-CV-PY-0005
STANDARD DETAILS FOR LADDER & SAFETY CAGE	BK-GNRL-PEDCO-000-ST-DW-0009
ELECTRICAL EQUIPMENT ARRANGEMENT LAYOUT FOR BUILDING	BK-GCS-PEDCO-120-EL-PY-0008
UNIT PLOT PLAN DRAWING	BK-GCS-PEDCO-120-PI-PY-0001
FOUNDATION DRAWING FOR GCS WAREHOUSE	BK-GCS-PEDCO-120-ST-DW-0083
STRUCTURAL DRAWING FOR GCS WAREHOUSE	BK-GCS-PEDCO-120-ST-DW-0084
CABLE TRENCH AND DUCT BANK LAYOUT	BK-GCS-PEDCO-120-CV-PY-0002
STANDARD DRAWING FOR PAVINGS	BK-GNRL-PEDCO-000-CV-DW-0035
PLUMBING & SEWAGE PIPING LAYOUT FOR GCS WAREHOUSE	BK-GCS-PEDCO-120-HV-PY-0017

KEY PLAN

THIS AREA

D03	NOV.2024	AFC	R.BERLOUIE	M.FAKHARIAN	M.SADDEGHIAN	***
D02	APR.2024	AFC	R.BERLOUIE	M.FAKHARIAN	S.PARAMARZPOUR	***
D01	MAR.2024	IFA	R.BERLOUIE	M.FAKHARIAN	S.PARAMARZPOUR	***
D00	NOV.2023	IPC	R.BERLOUIE	M.FAKHARIAN	S.PARAMARZPOUR	***
REV.	DATE	P.O.I.S	PREP.	CHK.	APP.	AUT.
PROJECT NAME: BINAK OILFIELD DEVELOPMENT/SURFACE FACILITIES GAS COMPRESSOR STATION						
PROJECT NO.: 971020						
EPC CONTRACTOR:			EPD/EPC CONTRACTOR (GC):			
 HIRGAN ENERGY – DESIGN & INSPECTION COMPANIES			 PETROIRAN DEVELOPMENT COMPANY			
DRAWING TITLE: ARCHITECTURAL DETAIL DRAWING FOR GCS WAREHOUSE WALL SECTION AND FINISHING SCHEDULE						
SCALE	SIZE	DRAWING NO.	SHEET NO.	REV.	NO CONSTRUCTION PERMITTED UNLESS DRAWING APPROVED	
AS SHOWN	A1	BK-GCS-PEDCO-120-AR-DW-0012	05 OF 10	D03	APPROVED FOR CONSTRUCTION	BY: DATE:
					BUDGET REF.	LOCATION
					SIZE CLASS	SERIAL NO.
					SHEET	REVISION
					053-073-9184	F 4 B 709522 05 OF 10 D03

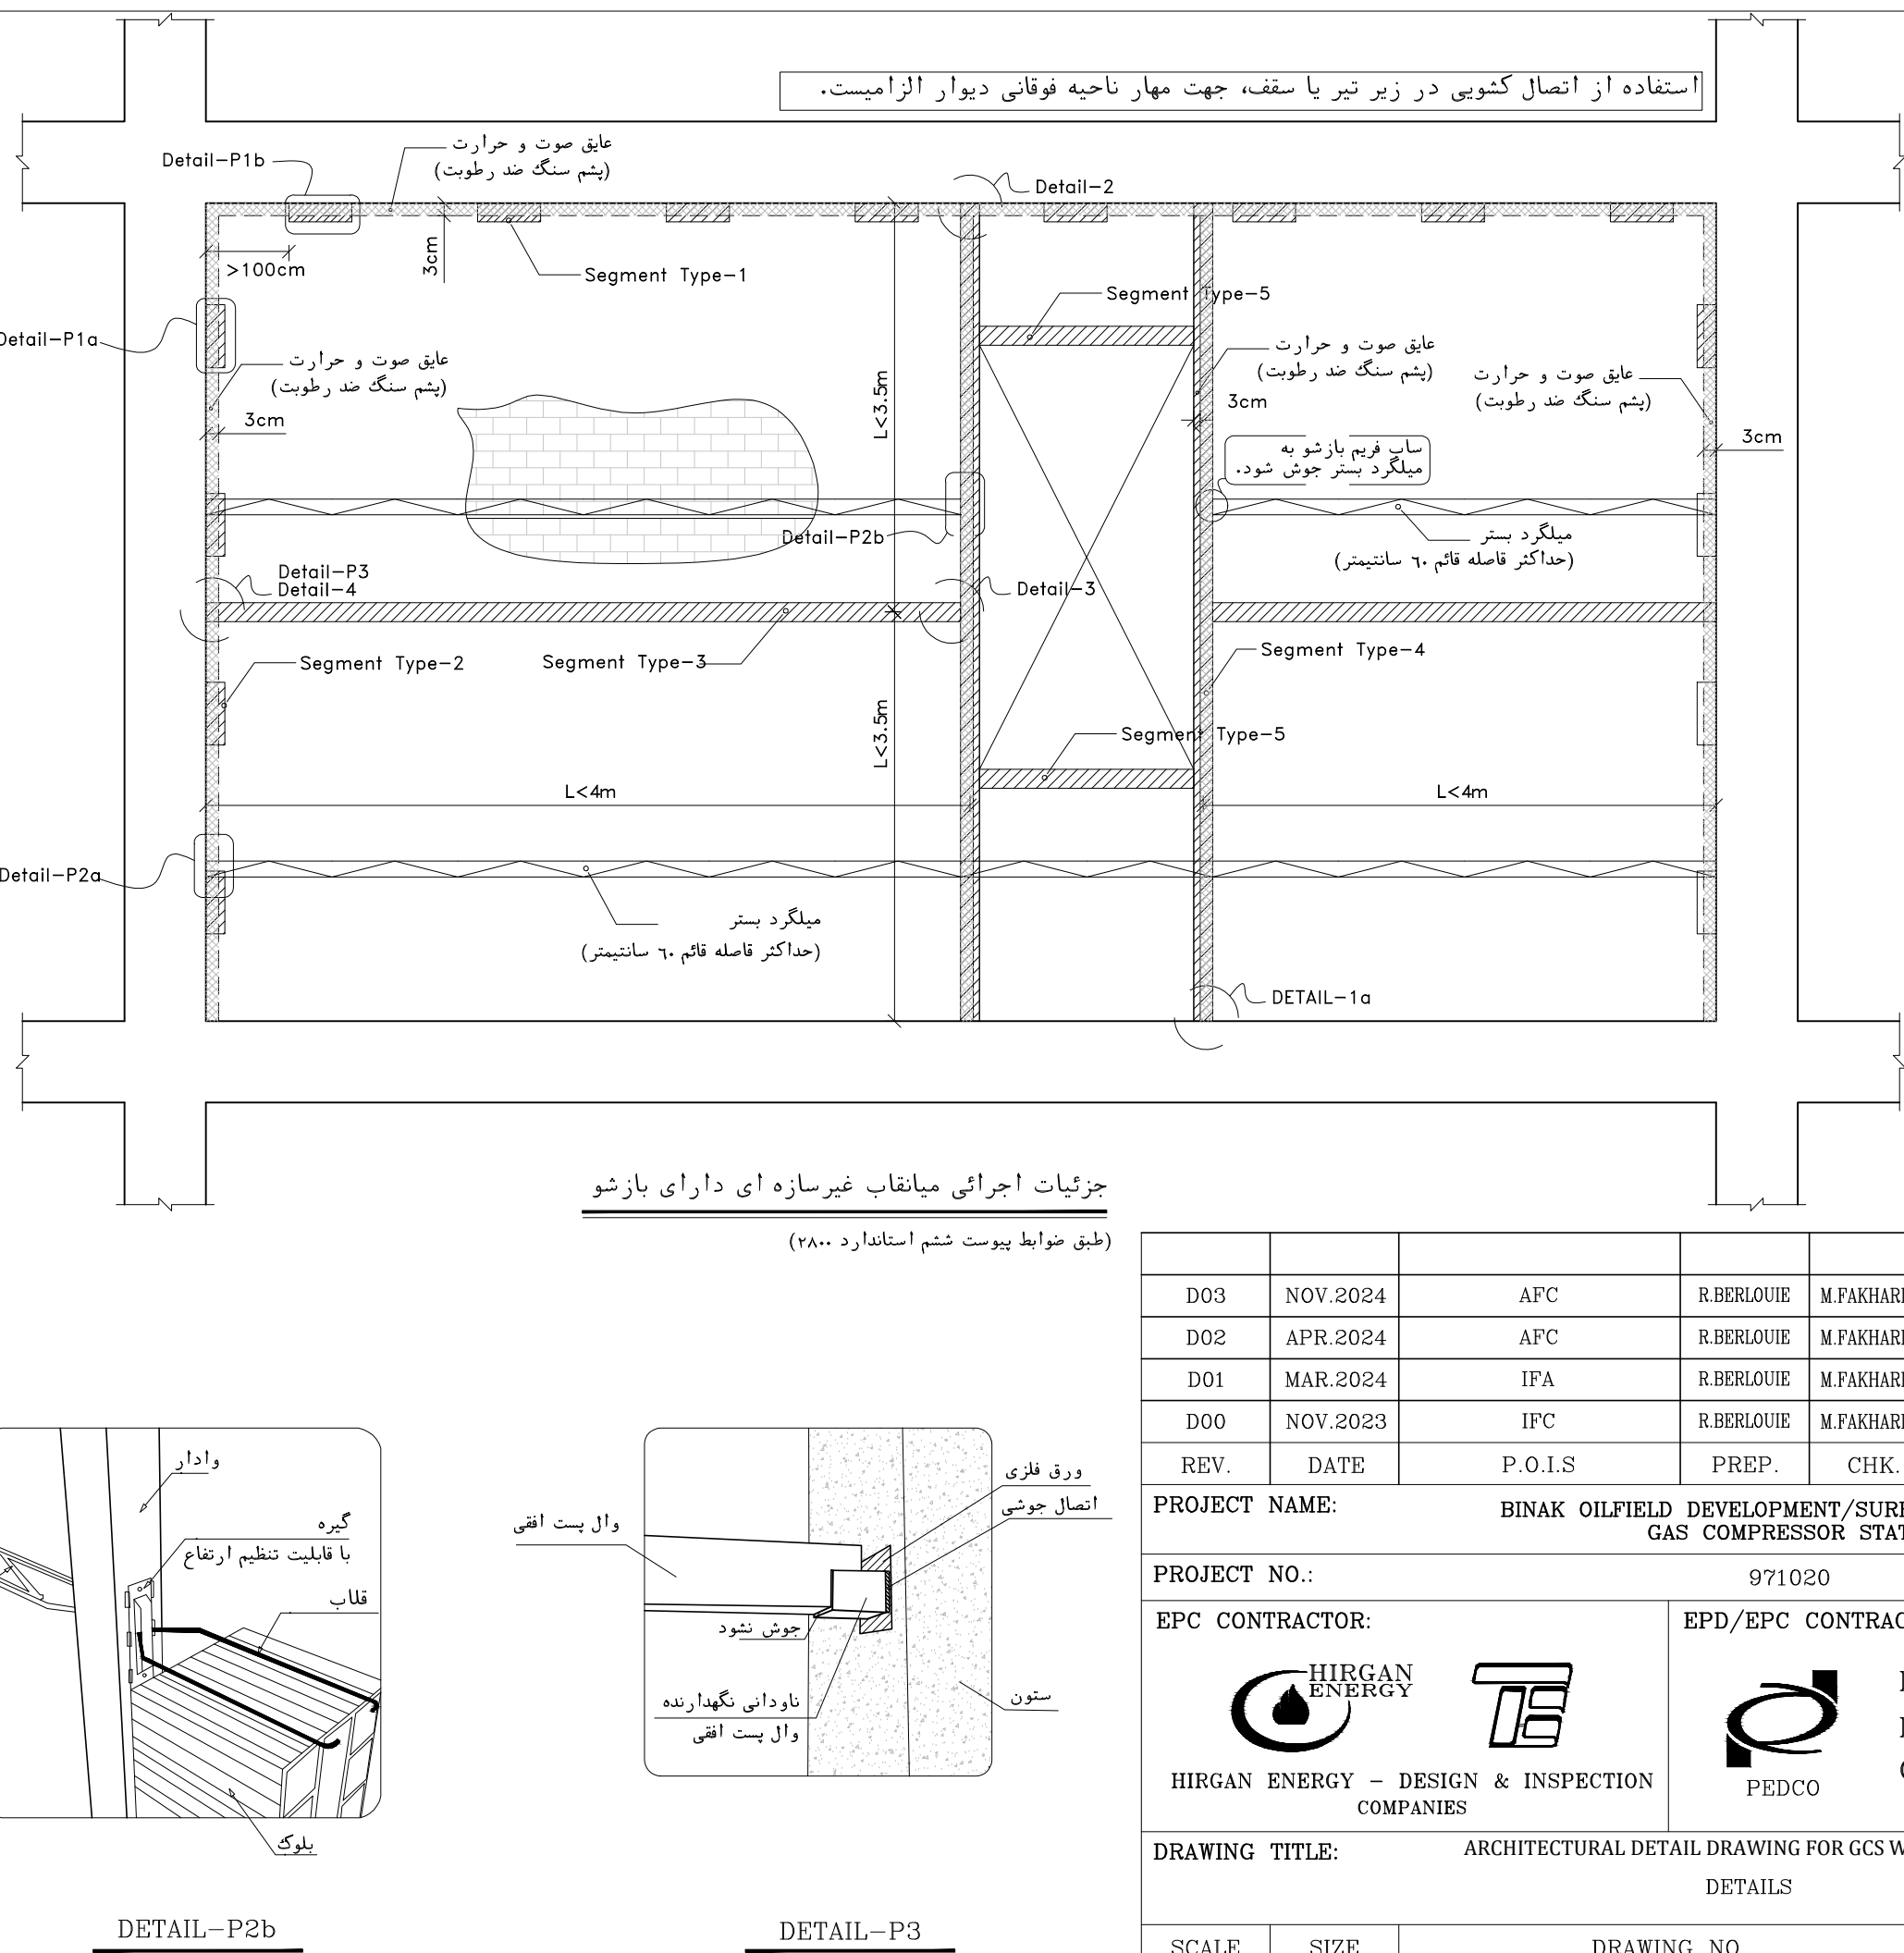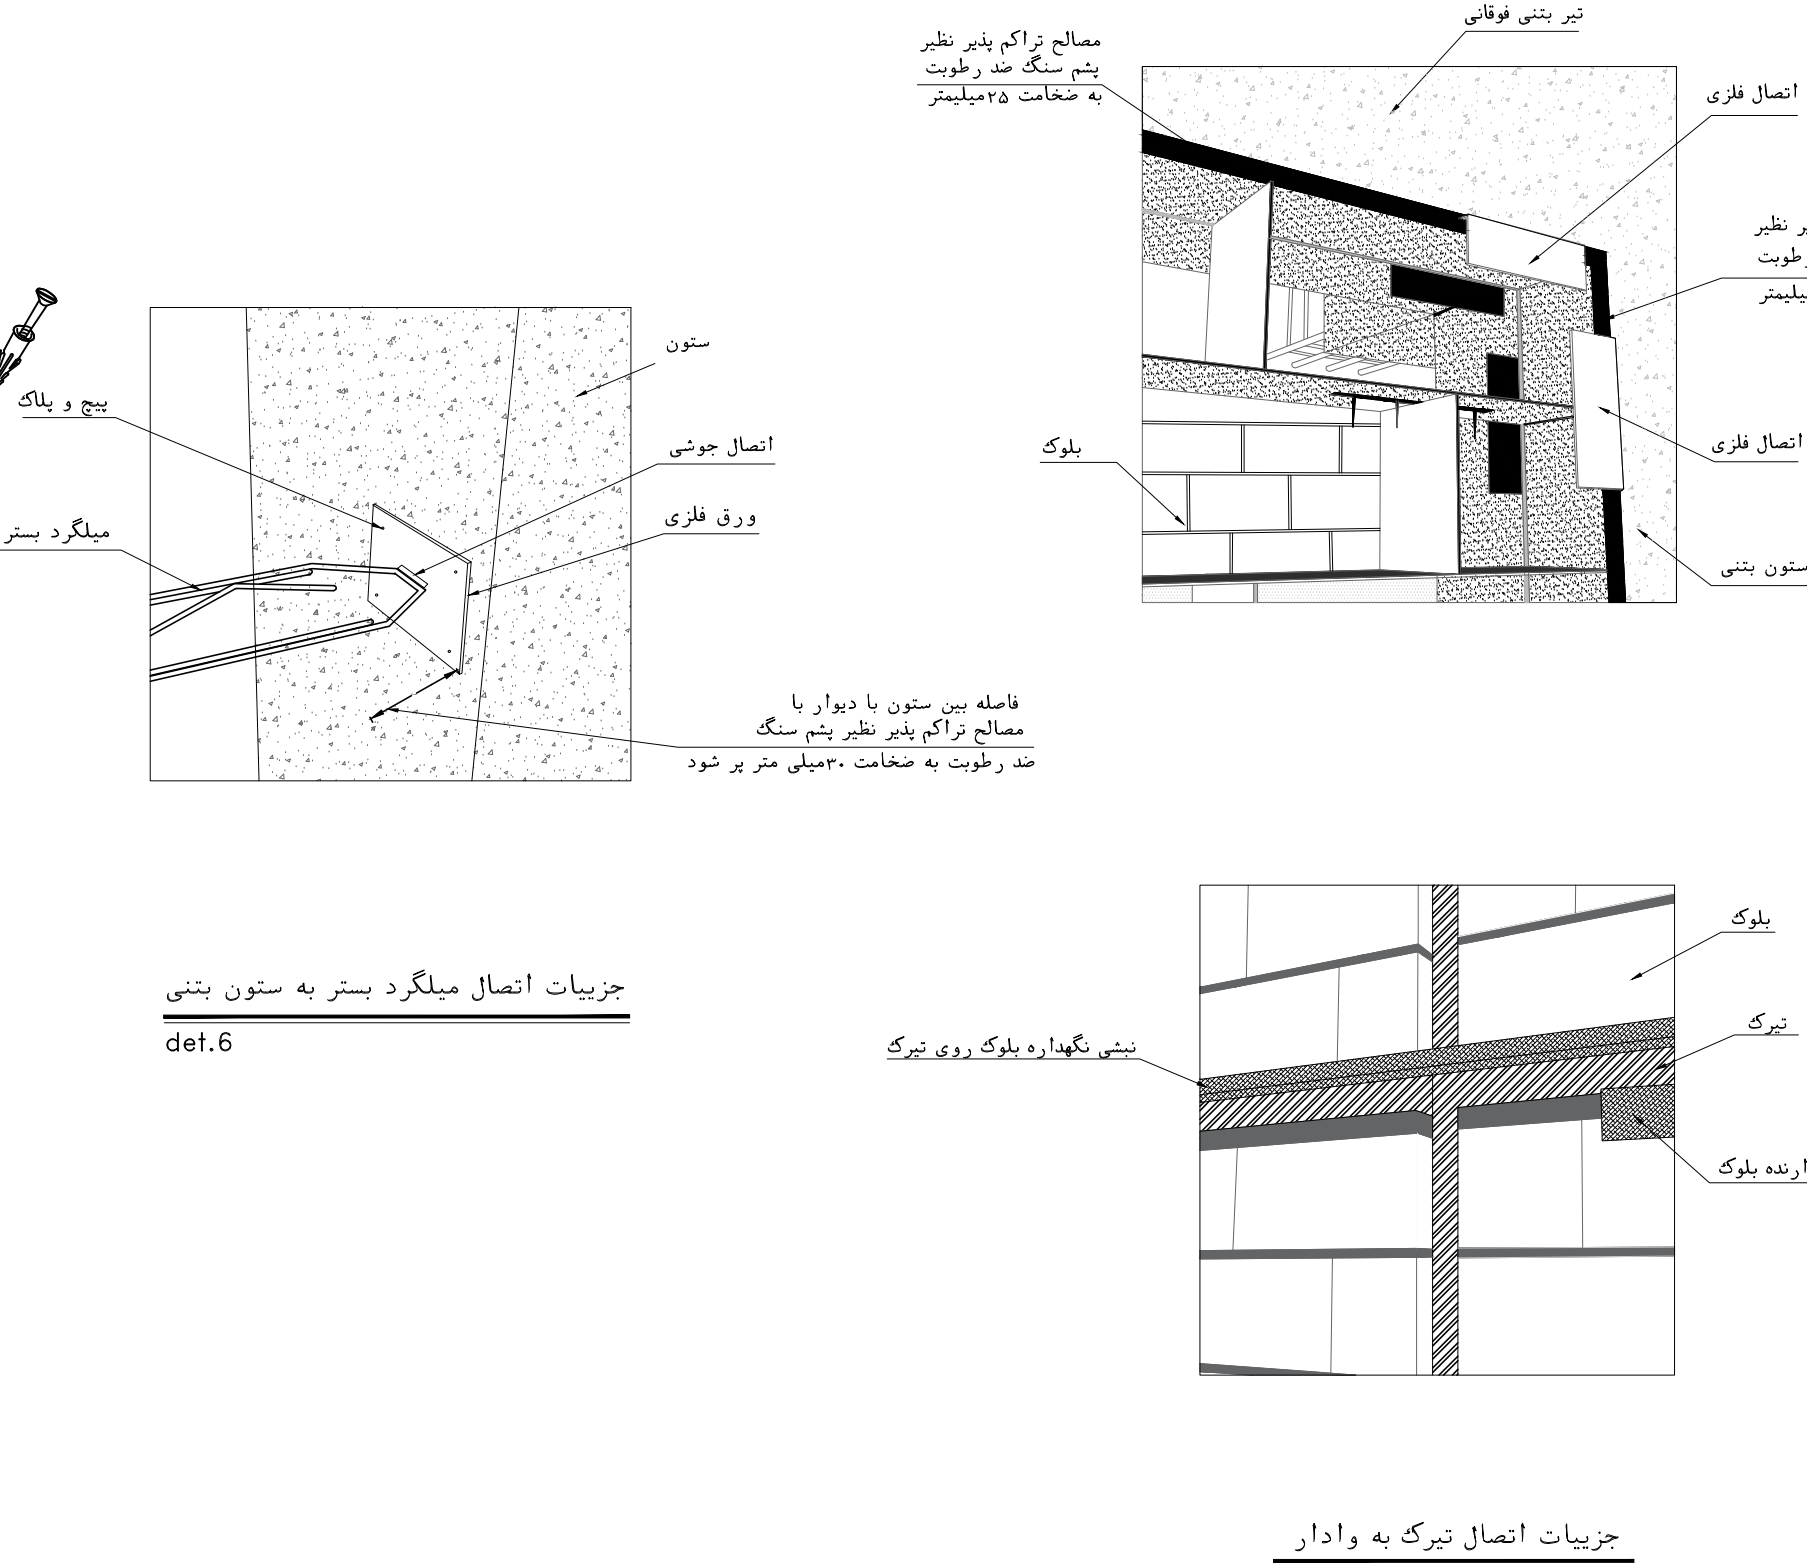

NOTES

1. ALL DIMENSIONS ARE IN MILLIMETER & ALL ELEVATIONS ARE IN METER.

2. ALL DIMENSIONS AND ELEVATIONS SHALL BE CHECKED BY THE CONTRACTOR PRIOR TO CONSTRUCTION.

3. CONTRACTOR SHALL COMPARE ALL ARCHITECTURAL, MECHANICAL, ELECTRICAL, PIPING AND STRUCTURAL DRAWINGS AND IN CASE OF ANY CONFLICTS OR DISCREPANCY, INFORM THE ENGINEER.

4. ALL MATERIALS ARE SELECTED FROM THE HIGHEST QUALITY AND MUST BE APPROVED BY THE CLIENT.

5. ALL OPENINGS FOR PIPING/CABLING AND HVAC OPENINGS SHALL BE CONSIDERED AS PER RELATED DRAWINGS BEFORE CONSTRUCTION.

6. ARCHITECTURAL DETAIL DESIGN WILL BE REVISED BASED ON APPROVED STRUCTURAL DRAWINGS.

7. FINISH GRADING LEVEL (F.G.L.) = +11.00 (M.S.L.) = +43.00 (LOCAL).

8. TO SEE THE COORDINATE OF THE BUILDING, PLEASE REFER TO THE STRUCTURAL DOCUMENTS.

LEGEND

REINFORCED CONCRETE

BRICK WORK

CERAMIC TILE

TERRAZZO TILES - 30x30cm

GYPSUM BOARD 60x60 REMOVABLE SUSPENDED CEILING

PVC SUSPENDED CEILING

BRICK FACED

F.F.L.

T.O.WA

T.O.P.

T.O.FOU.

M.D

T.O.R.

T.O.D.

B.O.Cg.

T.O.Cg.

M.D.

F.G.L.

B.O.S.

B.O.O.

B.O.T.

T.O.S.

B.P.D.

FINISHED FLOOR

TOP OF WALKWAY

TOP OF PARAPET

TOP OF FOUNDATION

METAL DOOR

TOP OF ROOF

TOP OF DOOR

BOTTOM OF CAGE

TOP OF CAGE

METAL DOOR

FINISH GRADING LEVEL

BOTTOM OF SLEEVE

BOTTOM OF OPENING




BOTTOM OF TRENCH

TOP OF SLAB


BLAST PROOF DOOR

REFERENCE DRAWING	DRG. No.
STANDARD DRAWING FOR ARCHITECTURAL DETAILS	BK-GNRL-PEDCO-000-AR-DW-0001
SITE SEWAGEAGE SYSTEM LAYOUT & DETAILS	BK-GCS-PEDCO-120-CV-PY-0001
AREA ELECTRICAL CABLE ROUTE & SECTION LAYOUT	BK-GCS-PEDCO-120-EL-PY-0005
ROAD, PAVING AND PLANT FINISH GRADING LAYOUT & SECTIONS	BK-GCS-PEDCO-120-CV-PY-0005
STANDARD DETAILS FOR LADDER & SAFETY CAGE	BK-GNRL-PEDCO-000-ST-DW-0009
ELECTRICAL EQUIPMENT ARRANGEMENT LAYOUT FOR BUILDING	BK-GCS-PEDCO-120-EL-PY-0008
UNIT PLOT PLAN DRAWING	BK-GCS-PEDCO-120-PI-PY-0001
FOUNDATION DRAWING FOR GCS WAREHOUSE	BK-GCS-PEDCO-120-ST-DW-0083
STRUCTURAL DRAWING FOR GCS WAREHOUSE	BK-GCS-PEDCO-120-ST-DW-0084
CABLE TRENCH AND DUCT BANK LAYOUT	BK-GCS-PEDCO-120-CV-PY-0002
STANDARD DRAWING FOR PAVINGS	BK-GNRL-PEDCO-000-CV-DW-0035
PLUMBING & SEWAGE PIPING LAYOUT FOR GCS WAREHOUSE	BK-GCS-PEDCO-120-HV-PY-0017



KEY PLAN

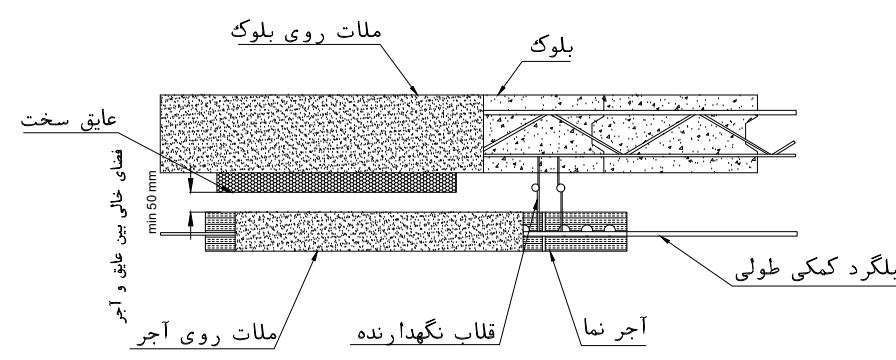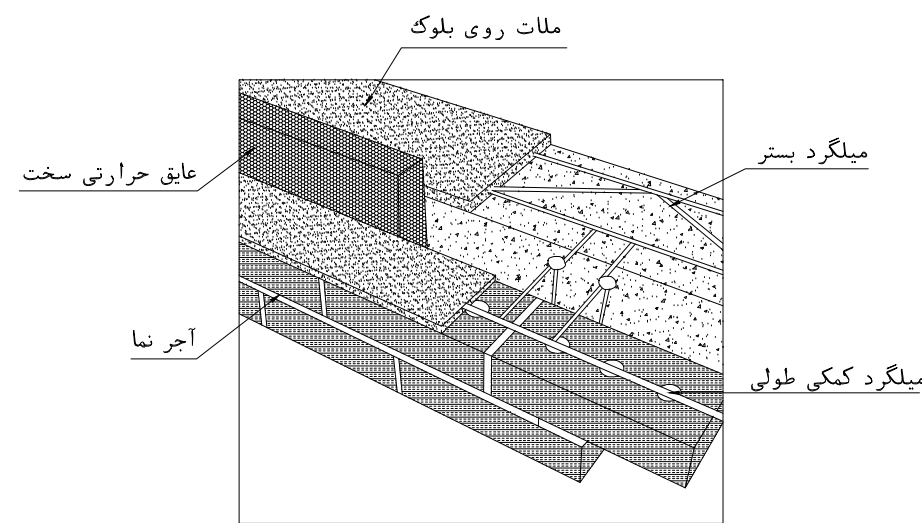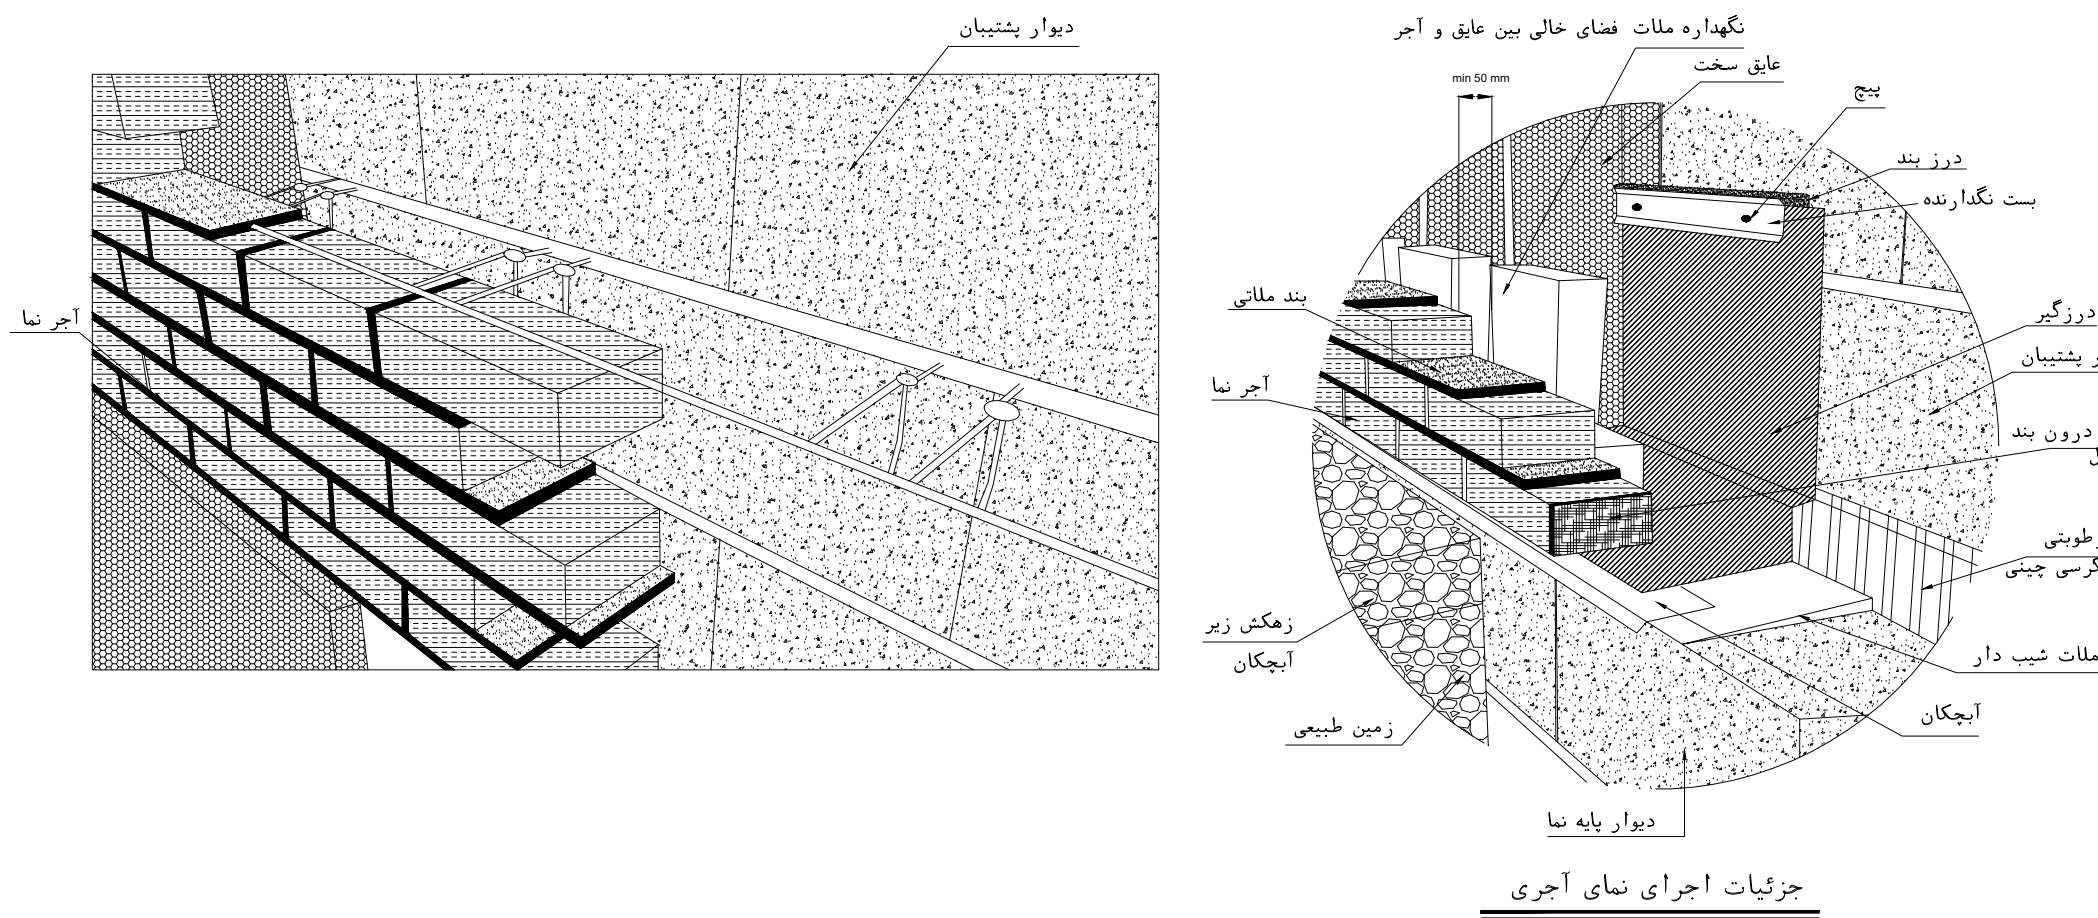


نحوه مهار نمای آجری به دیوار پشت

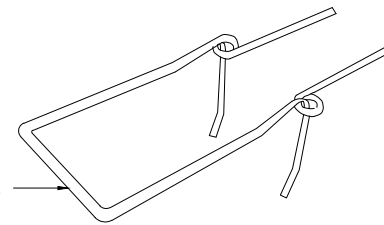

 
→ قلاب دو تکه نگهدارنده آجر با قابلیت تنظیم ارتفاع

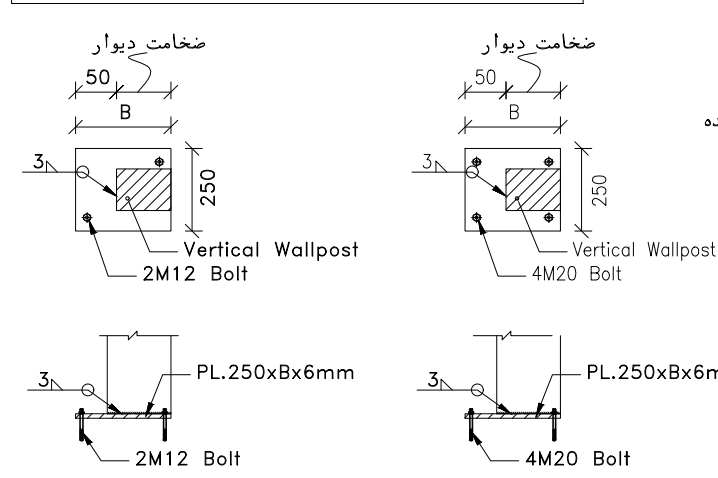


DETAIL-1a

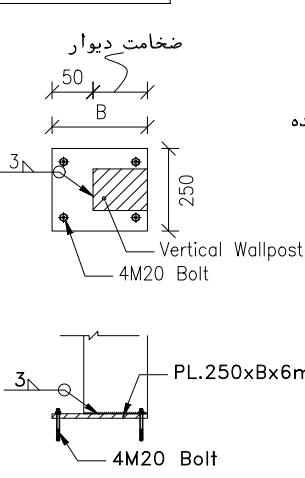


DETAIL-1b

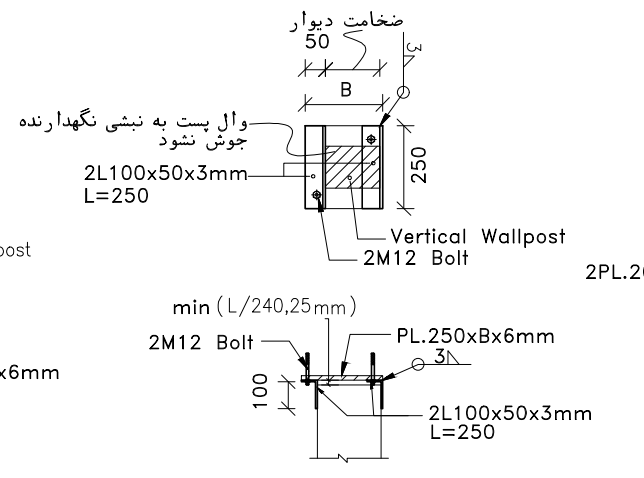



DETAIL-2

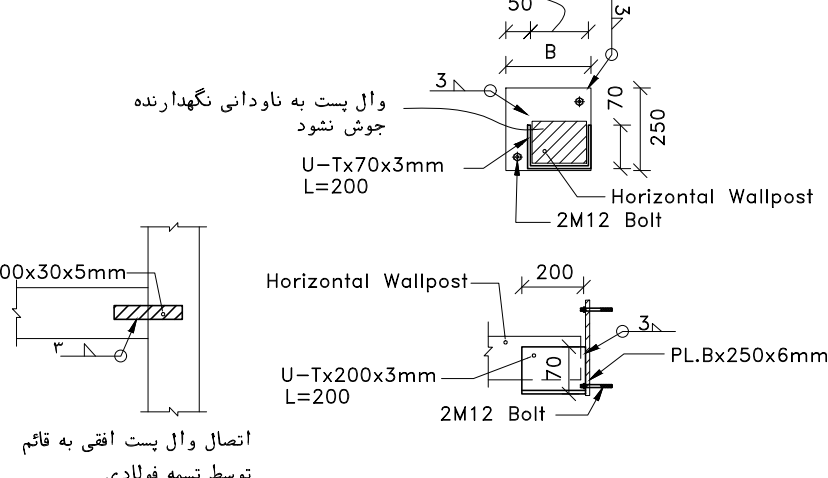



DETAIL-3

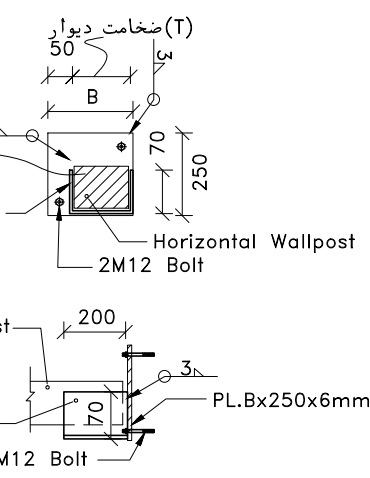





DETAIL-4

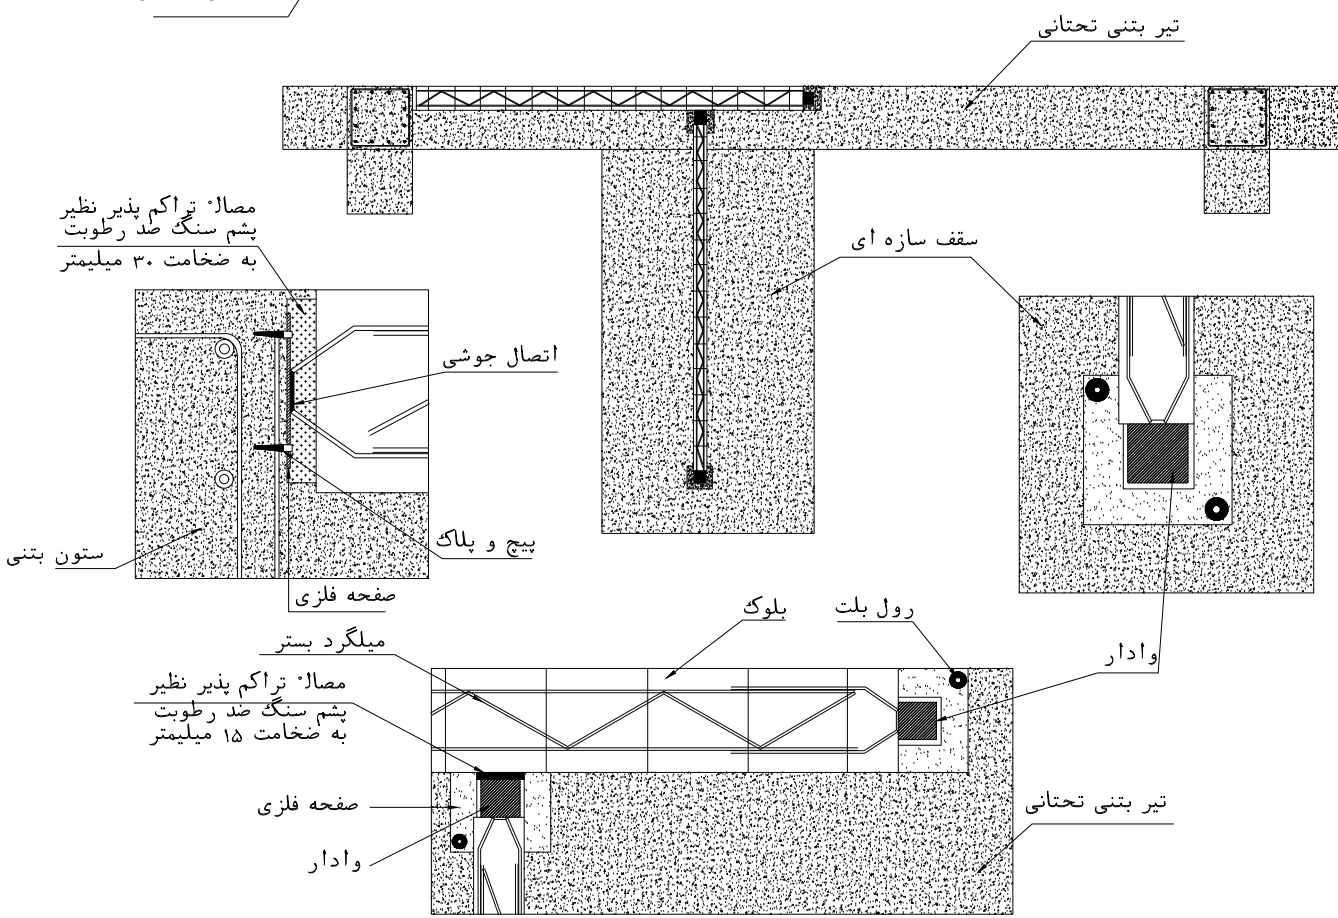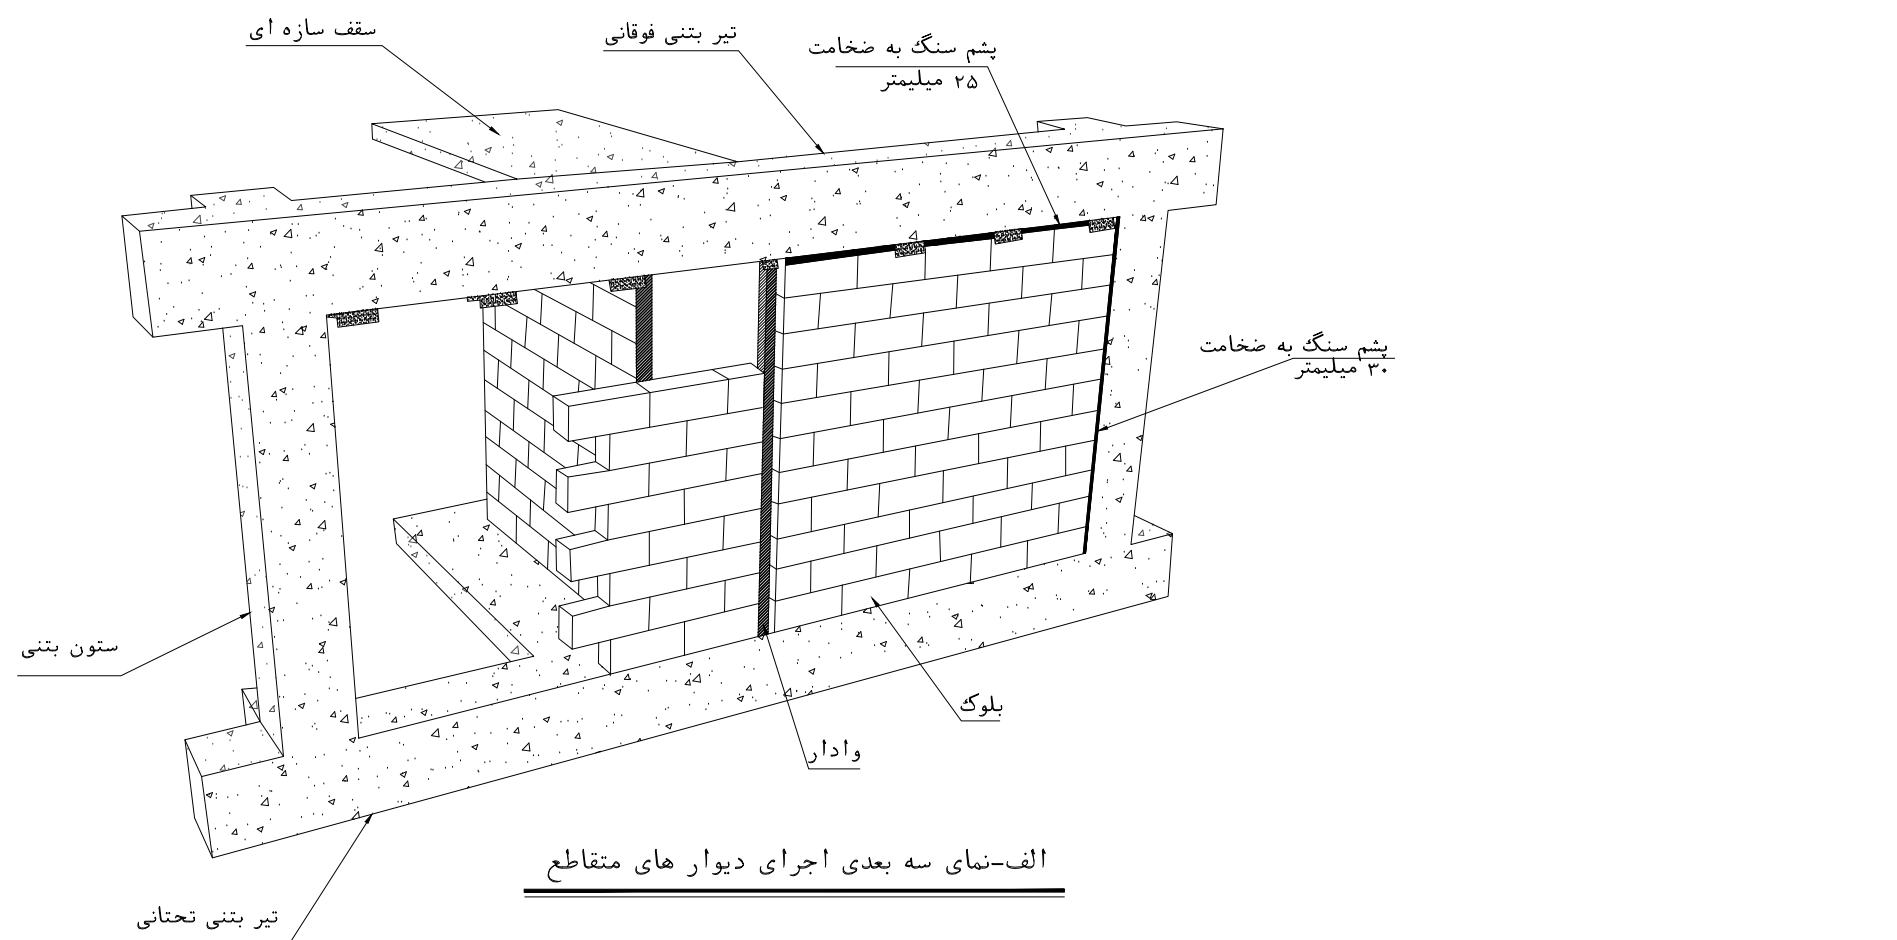

ب - اجرای دیوار متقاطع از پلان

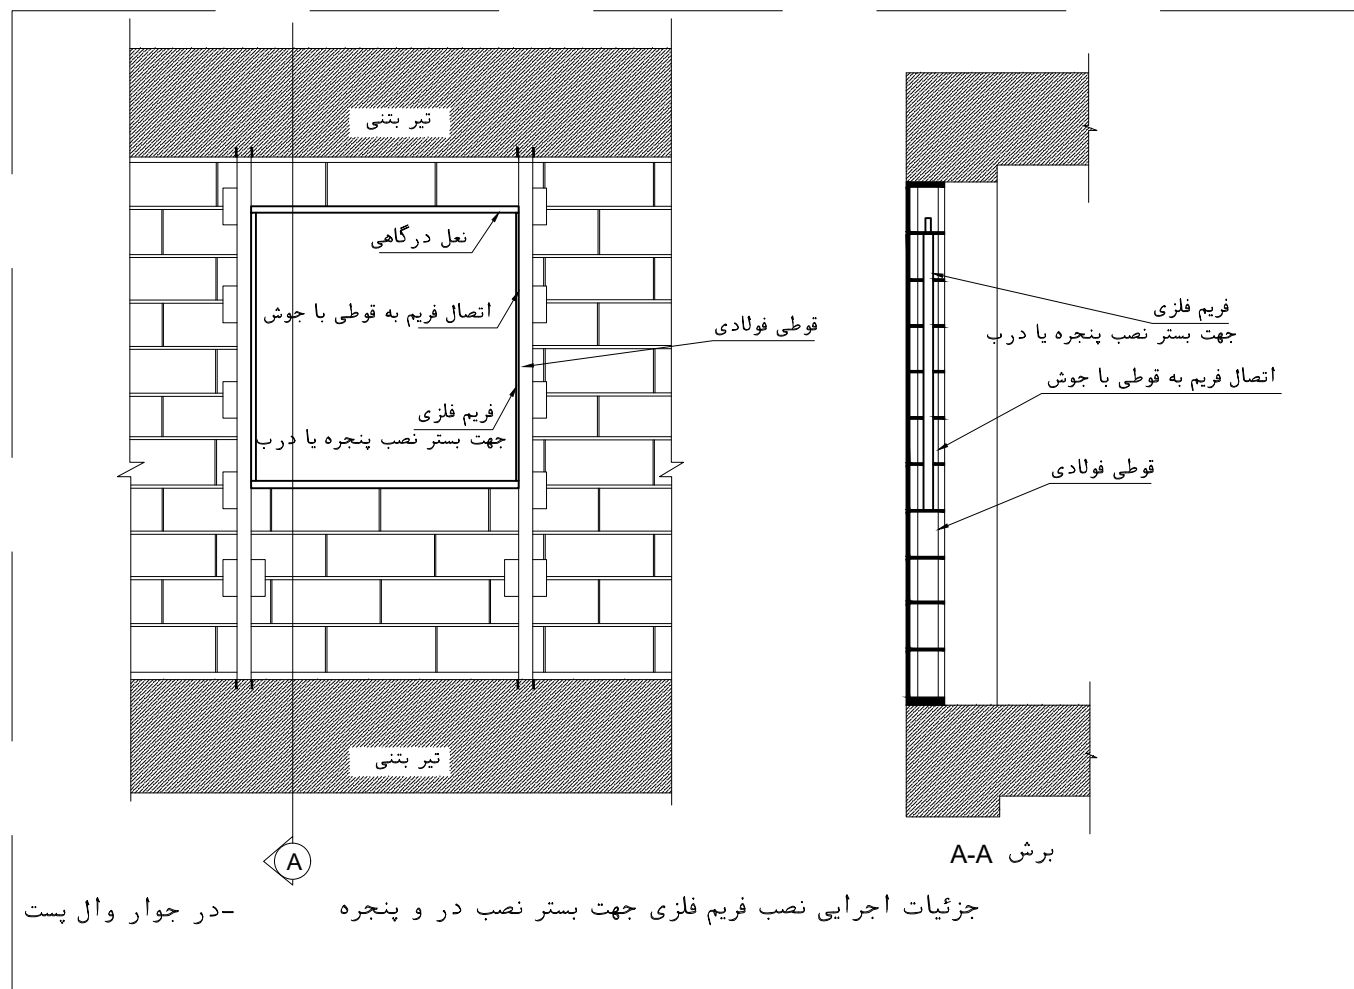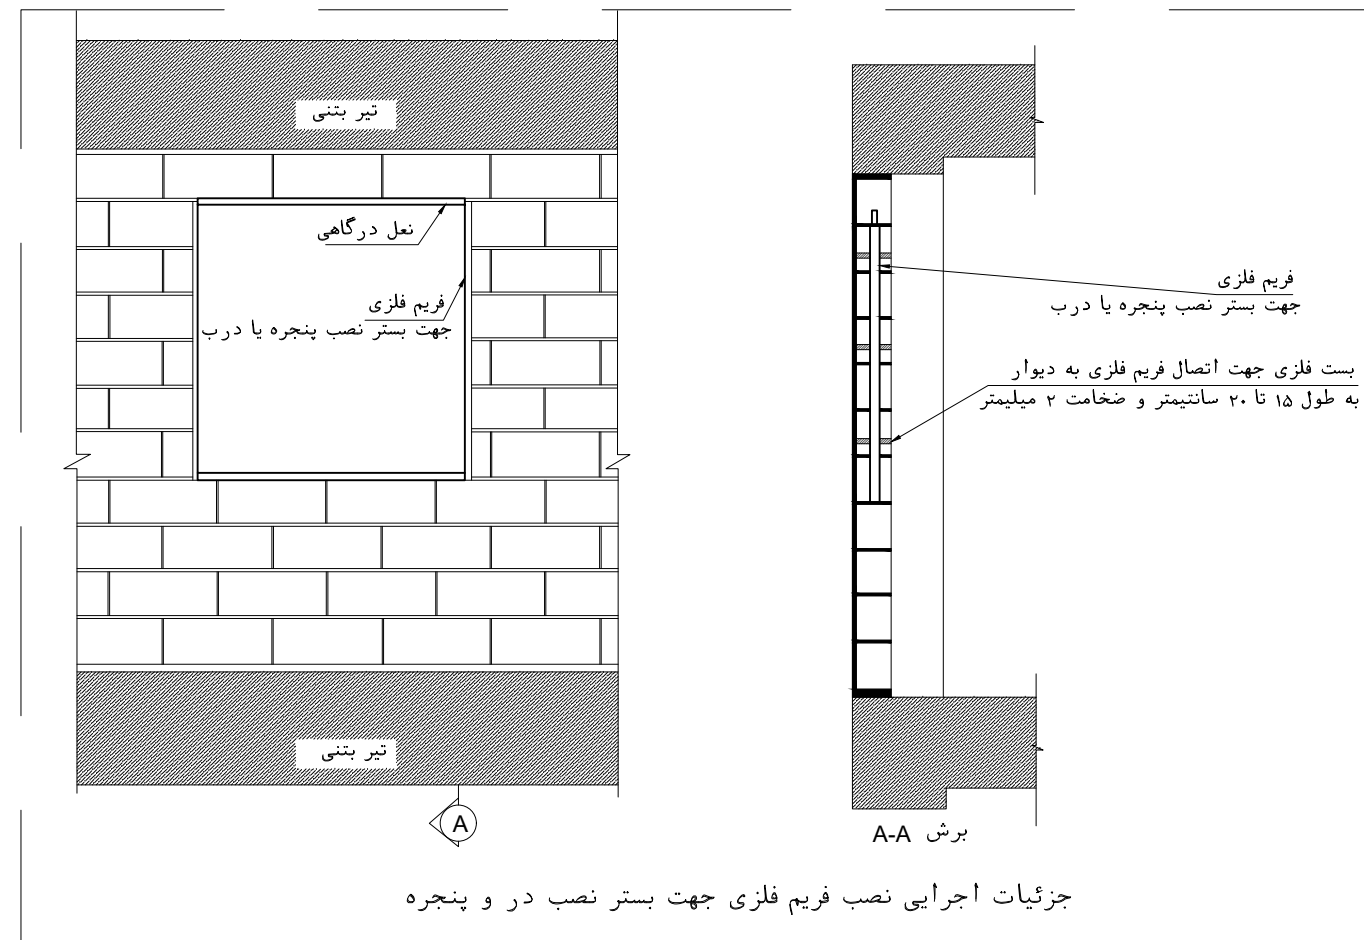


    نحوه اجرای وادار در دو طرف بازشو در صورت نیاز

NOTES	
1. ALL DIMENSIONS ARE IN MILLIMETER & ALL ELEVATIONS ARE IN METER.	
2. ALL DIMENSIONS AND ELEVATIONS SHALL BE CHECKED BY THE CONTRACTOR PRIOR TO CONSTRUCTION.	
3. CONTRACTOR SHALL COMPARE ALL ARCHITECTURAL, MECHANICAL, ELECTRICAL, PIPING AND STRUCTURAL DRAWINGS AND IN CASE OF ANY CONFLICTS OR DISCREPANCY, INFORM THE ENGINEER.	
4. ALL MATERIALS ARE SELECTED FROM THE HIGHEST QUALITY AND MUST BE APPROVED BY THE CLIENT.	
5. ALL OPENINGS FOR PIPING/CABLING AND HVAC OPENINGS SHALL BE CONSIDERED AS PER RELATED DRAWINGS BEFORE CONSTRUCTION.	
6. ARCHITECTURAL DETAIL DESIGN WILL BE REVISED BASED ON APPROVED STRUCTURAL DRAWINGS.	
7. FINISH GRADING LEVEL (F.G.L.) = +1.00 (M.S.L.) = +0.00 (LOCAL)	
8. TO SEE THE COORDINATE OF THE BUILDING, PLEASE REFER TO THE STRUCTURAL DOCUMENTS.	
LEGEND	
REINFORCED CONCRETE	
BRICK WORK	
CERAMIC TILE	
TERRAZZO TILES - 30x30cm	
GYPSON BOARD 60x60 REMOVABLE SUSPENDED CEILING	
PVC SUSPENDED CEILING	
BRICK FACED	
F.F.L.	FINISHED FLOOR
T.O.WA	TOP OF WALKWAY
T.O.P.	TOP OF PARAPET
T.O.FOU.	TOP OF FOUNDATION
M.D	METAL DOOR
T.O.R.	TOP OF ROOF
T.O.D.	TOP OF DOOR
B.O.Cg.	BOTTOM OF CAGE
T.O.Cg.	TOP OF CAGE
M.D.	METAL DOOR
F.G.L.	FINISH GRADING LEVEL
B.O.S.	BOTTOM OF SLEEVE
B.O.O.	BOTTOM OF OPENING
B.O.T.	BOTTOM OF TRENCH
T.O.S.	TOP OF SLAB
B.P.D.	BLAST PROOF DOOR

REFERENCE DRAWING	DRG. No.
STANDARD DRAWING FOR ARCHITECTURAL DETAILS	BK-GNRL-PEDCO-000-AR-DW-0001
SITE SEWAGE SYSTEM LAYOUT & DETAILS	BK-GCS-PEDCO-120-CV-PY-0001
AREA ELECTRICAL CABLE ROUTE & SECTION LAYOUT	BK-GCS-PEDCO-120-EL-PY-0005
ROAD, PAVING AND PLANT FINISH GRADING LAYOUT & SECTIONS	BK-GCS-PEDCO-120-CV-PY-0005
STANDARD DETAILS FOR LADDER & SAFETY CAGE	BK-GNRL-PEDCO-000-ST-DW-0009
ELECTRICAL EQUIPMENT ARRANGEMENT LAYOUT FOR BUILDING	BK-GCS-PEDCO-120-EL-PY-0008
UNIT PLOT PLAN DRAWING	BK-GCS-PEDCO-120-PI-PY-0001
FOUNDATION DRAWING FOR GCS WAREHOUSE	BK-GCS-PEDCO-120-ST-DW-0083
STRUCTURAL DRAWING FOR GCS WAREHOUSE	BK-GCS-PEDCO-120-ST-DW-0084
CABLE TRENCH AND DUCT BANK LAYOUT	BK-GCS-PEDCO-120-CV-PY-0001
STANDARD DRAWING FOR PAYINGS	BK-GNRL-PEDCO-000-CY-DW-0035
PLUMBING & SEWAGE PIPING LAYOUT FOR GCS WAREHOUSE	BK-GCS-PEDCO-120-HV-PY-0017

KEY PLAN

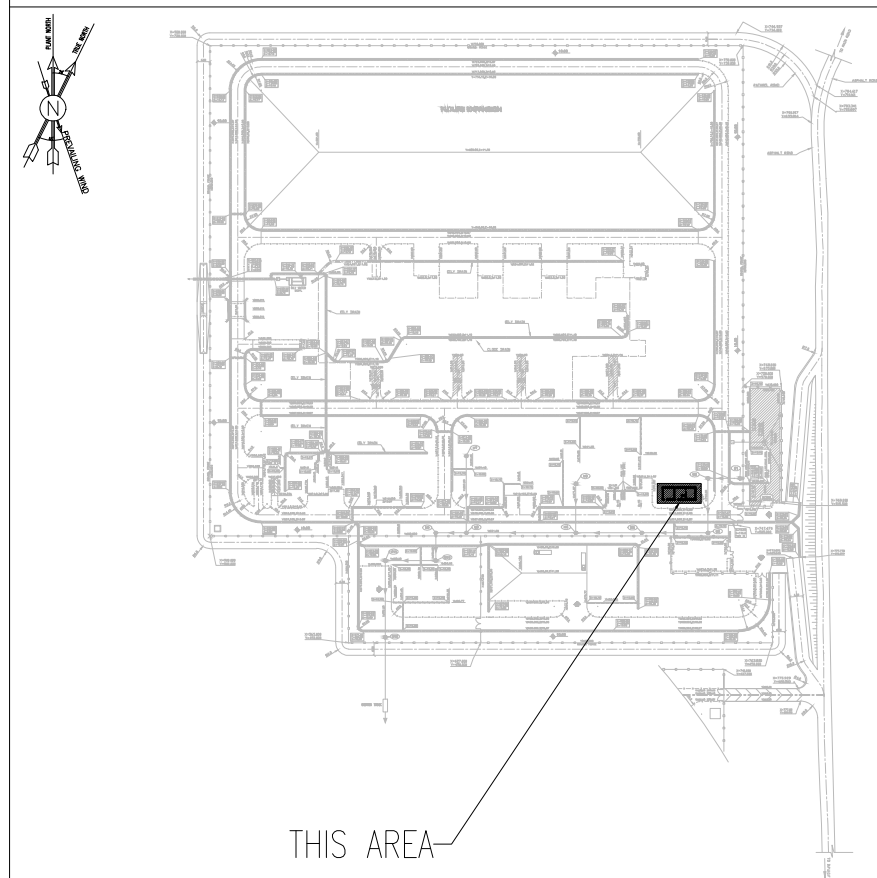[illegible]

APPROVED FOR CONSTRUCTION				BY:	DATE:	
BUDGET REF.	LOCATION	SIZE	CLASS	SERIAL NO.	SHEET	REVISION
053-073-9184	F	4	B	709522	10 OF 10	D03