


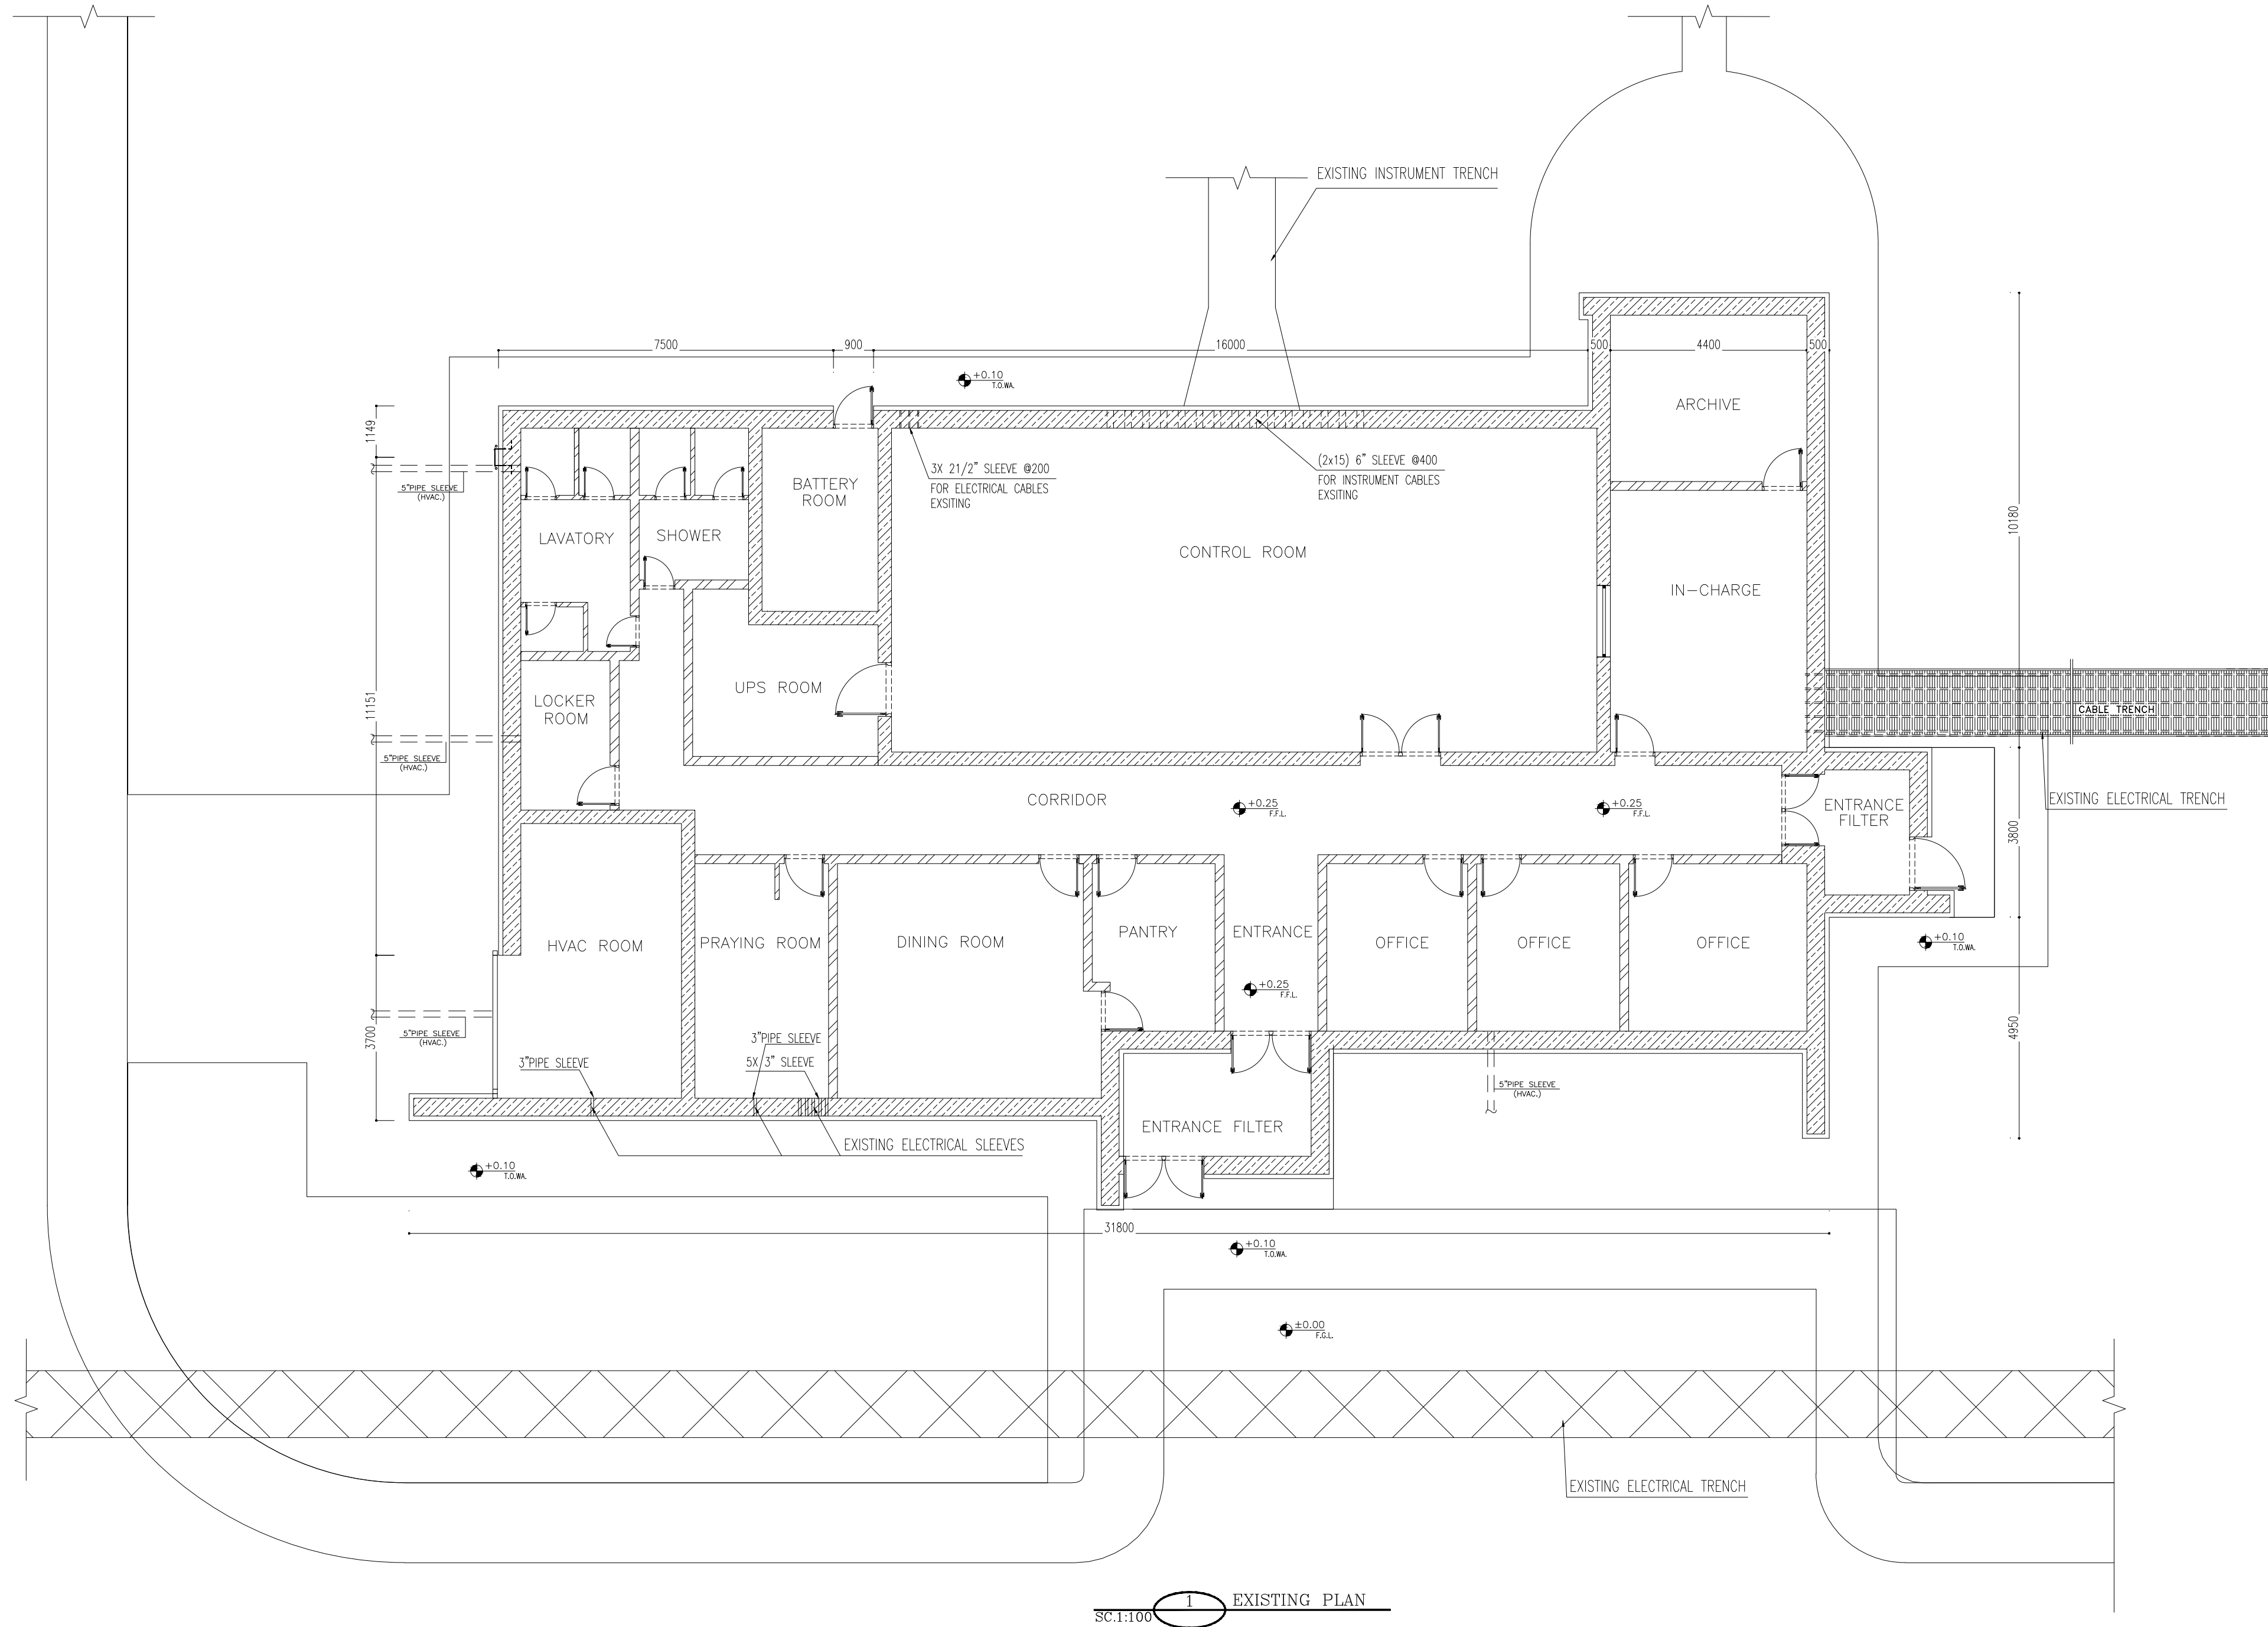

 BRICK WORK
 REINFORCED CONCRETE



REFERENCE DRAWING	DRG. No.
STANDARD DRAWING FOR ARCHITECTURAL DETAILS	BK-GNRL-PEDCO-000-AR-DW-0001
SITE SEWAGEAGE SYSTEM LAYOUT & DETAILS	BK-GCS-PEDCO-120-CV-PY-0001
CONTROL ROOM LAYOUT & ARRANGEMENT DRAWING	BK-GCS-PEDCO-120-IN-PY-0001
ROAD, PAVING AND PLANT FINISH GRADING LAYOUT & SECTIONS	BK-GCS-PEDCO-120-CV-PY-0005
ELECTRICAL CABLE ROUTE & SECTION LAYOUT FOR BUILDING & SHELTER	BK-GCS-PEDCO-120-EL-PY-0006
FOUNDATION DRAWING FOR EXTENSION OF CONTROL BUILDING	BK-GNRL-PEDCO-220-AR-DW-0004
STRUCTURAL DRAWING FOR EXTENSION OF CONTROL BUILDING	BK-GNRL-PEDCO-220-ST-DW-0005
STANDARD DETAILS FOR LADDER & SAFETY CAGE	BK-GNRL-PEDCO-000-ST-DW-0009
AREA ELECTRICAL CABLE ROUTE & SECTION LAYOUT	BK-GCS-PEDCO-120-EL-PY-0005
UNIT PLOT PLAN DRAWING	BK-PPL-PEDCO-120-PI-PY-0001
CONTROL ROOM CABLE ROUTE LAYOUT	BK-GCS-PEDCO-120-IN-PY-0002
INSTRUMENT, P&G CABLE TRENCH/ROUTE LAYOUT DRAWING	BK-GCS-PEDCO-120-IN-PY-0004
ELECTRICAL EQUIPMENT ARRANGEMENT LAYOUT FOR BUILDING	BK-GCS-PEDCO-120-EL-PY-0008

KEY PLAN

0 100' 200' 300' 400' 500' 600' 700' 800' 900' 1000'

THIS AREA

[illegible]

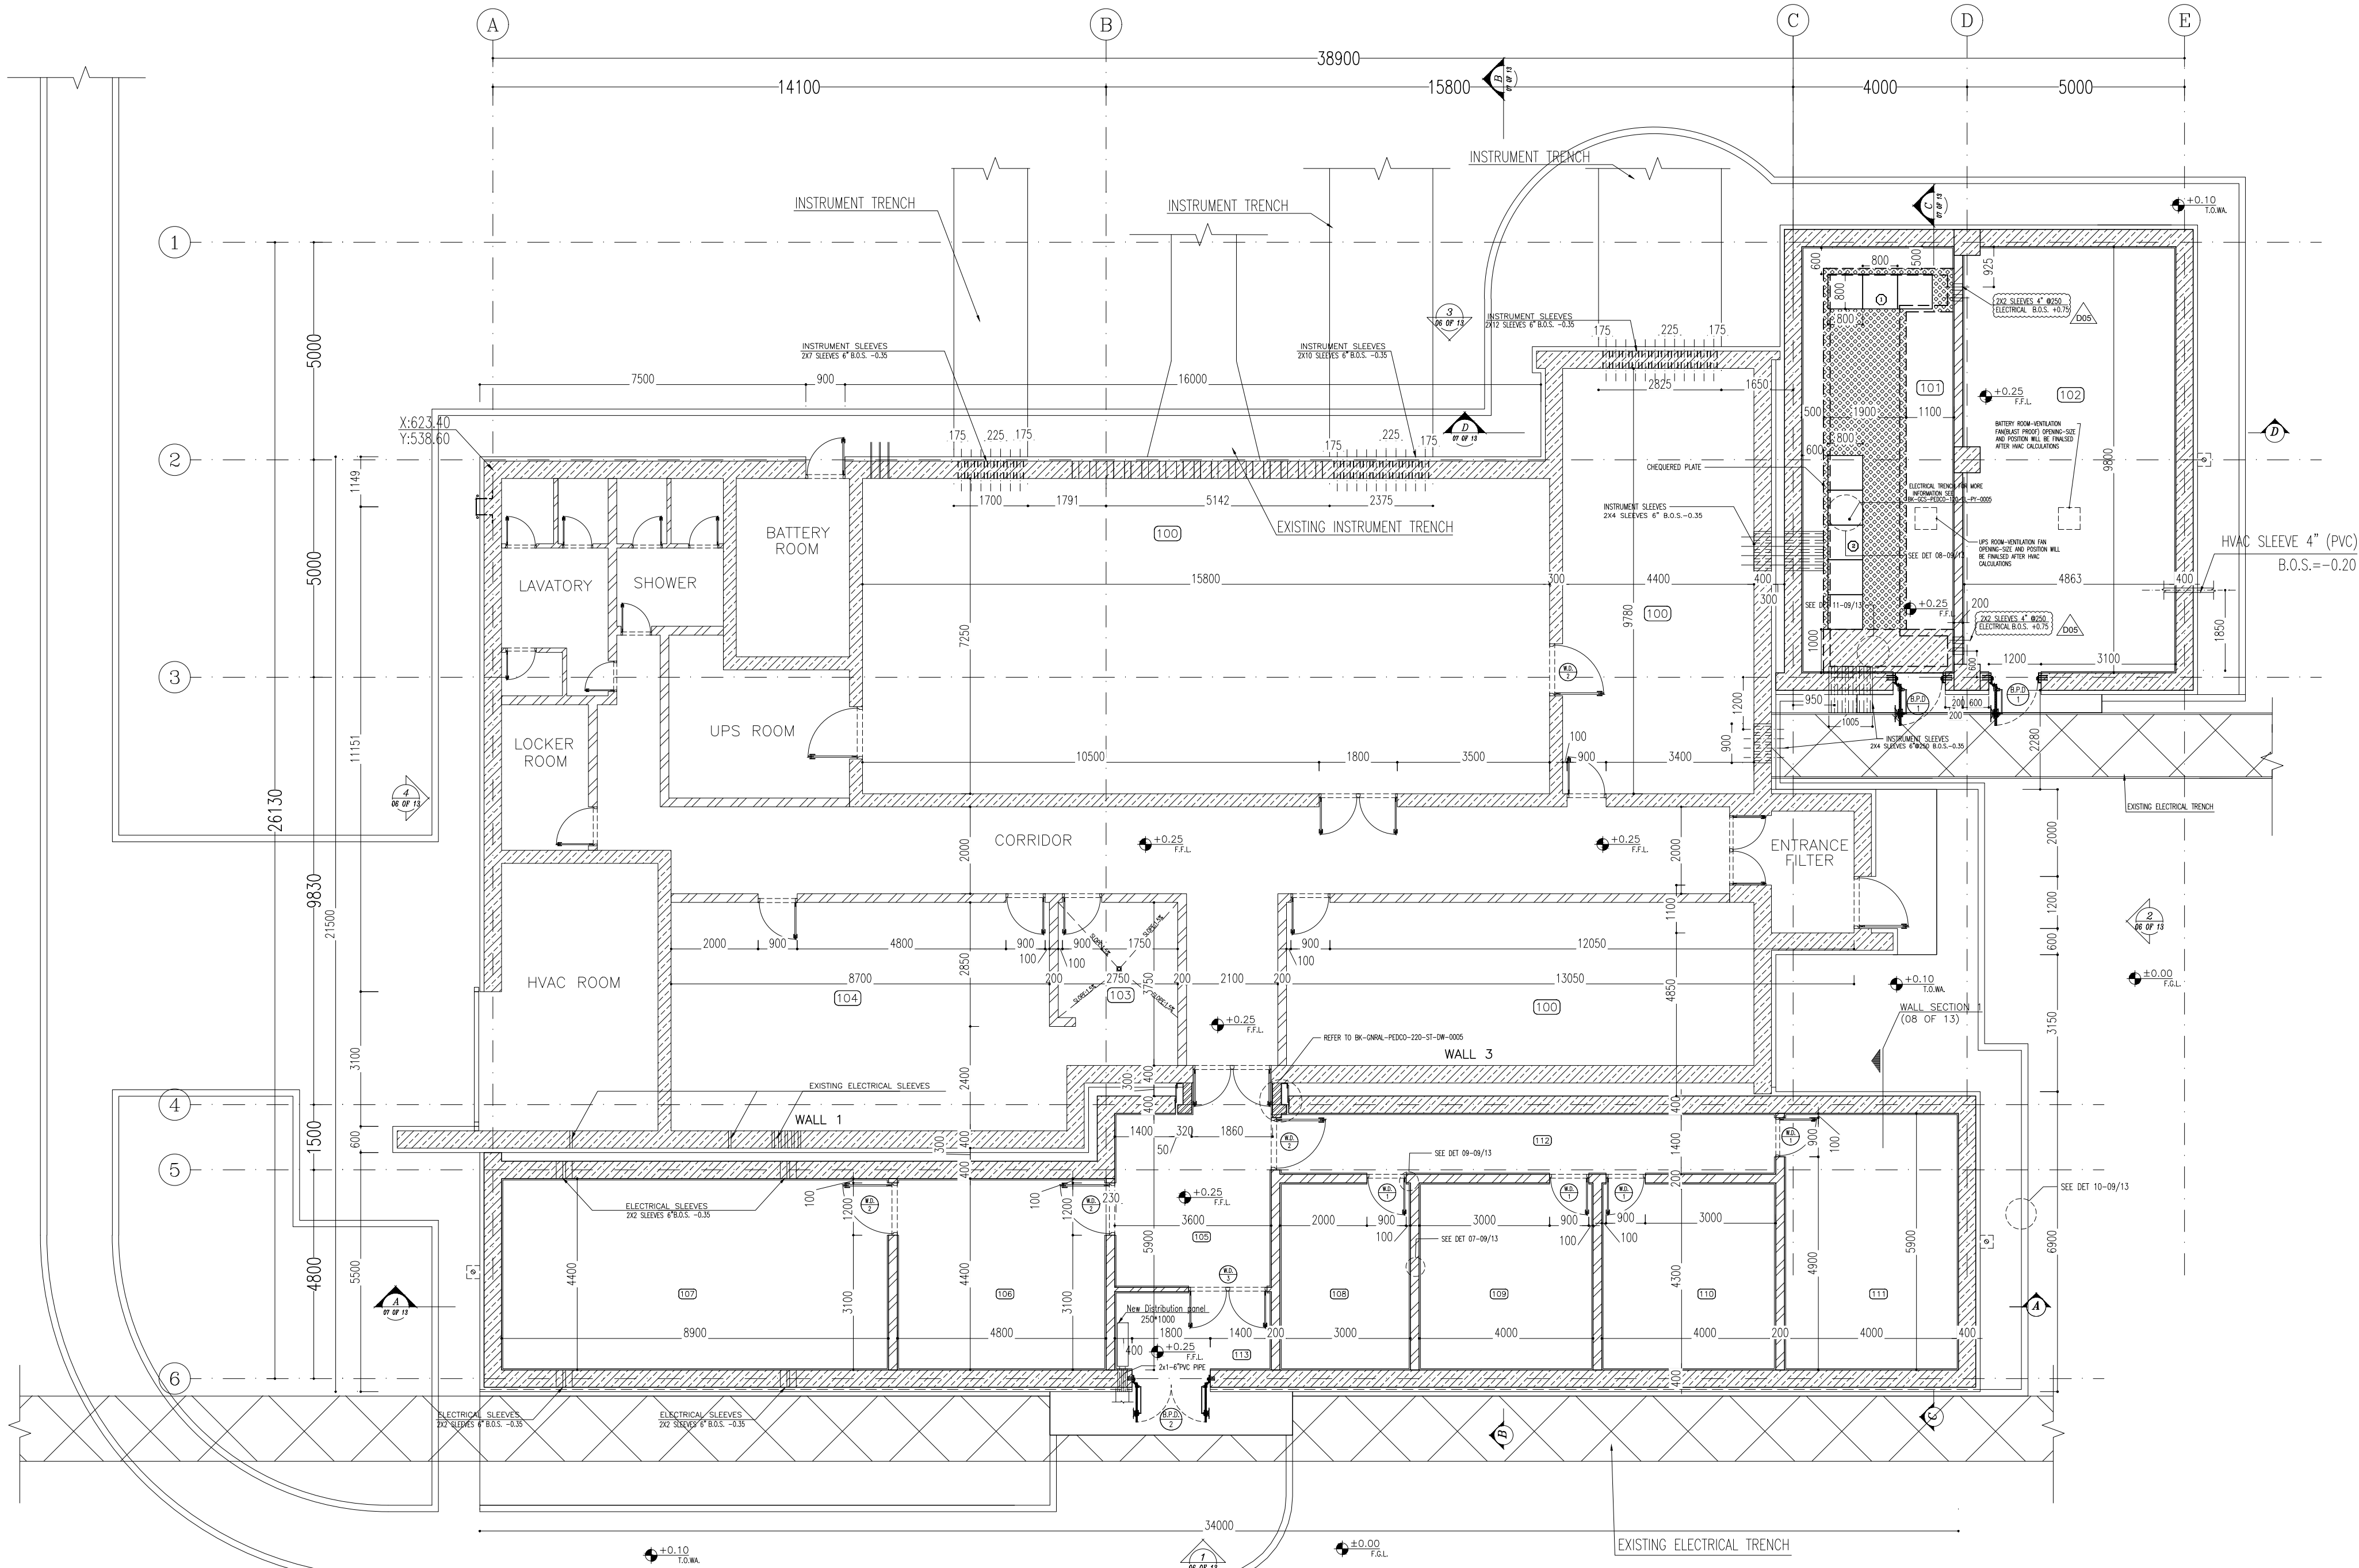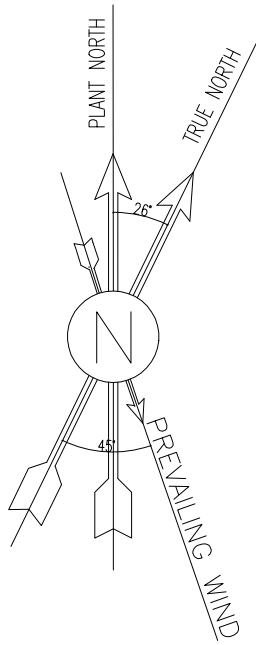

SC:1:100 2 DIMENSION PLAN

100	CONTROL ROOM
101	UPS
102	BATTERY ROOM
103	PANTRY
104	DINING ROOM
105	ENTRANCE
106	MANAGEMENT ROOM
107	CONFERENCE ROOM
108	ARCHIVE
109	LOCKER
110	PRAYER ROOM
111	STORE
112	CORRIDOR
113	AIR LOCK

NOTES

1. ALL DIMENSIONS ARE IN MILLIMETER & ALL ELEVATIONS ARE IN METER.
2. ALL DIMENSIONS AND ELEVATIONS SHALL BE CHECKED BY THE CONTRACTOR PRIOR TO CONSTRUCTION.
3. CONTRACTOR SHALL COMPARE ALL ARCHITECTURAL, MECHANICAL, ELECTRICAL, PIPING AND STRUCTURAL DRAWINGS AND IN CASE OF ANY CONFLICTS OR DISCREPANCY, INFORM THE ENGINEER.
4. ALL MATERIALS ARE SELECTED FROM THE HIGHEST QUALITY AND MUST BE APPROVED BY THE CLIENT.
5. ALL OPENINGS FOR PIPING/CABLING AND HVAC OPENINGS SHALL BE CONSIDERED AS PER RELATED DRAWINGS BEFORE CONSTRUCTION.
6. FINISH GRADING LEVEL (F.G.L.) : ± 0.00 (LOCAL) = 99.70


LEGEND

F.F.L.	FINISHED FLOOR LEVEL
T.O.W.A.	TOP OF WALKWAY
T.O.P.	TOP OF PARAPET
T.O.S.	TOP OF SLAB
T.O.D.	TOP OF DOOR
T.O.W.	TOP OF WINDOW
B.O.W.	BOTTOM OF WINDOW
T.O.C.	TOP OF CAGE
B.O.C.	BOTTOM OF CAGE
B.O.F.	BOTTOM OF FALSE FLOOR
B.O.SU.	BOTTOM OF SUSPENDED
B.O.S.	BOTTOM OF SLEEVE
H.P.G.	HIGH POINT GRAVEL


	BRICK WORK
	REINFORCED CONCRETE
	CHEQUERED PLATE

REFERENCE DRAWING	DRG. No.
STANDARD DRAWING FOR ARCHITECTURAL DETAILS	BK-GNRL-PEDCO-000-AR-DW-0001
SITE SEWAGE SYSTEM LAYOUT & DETAILS	BK-GCS-PEDCO-120-CY-PY-0001
CONTROL ROOM LAYOUT & ARRANGEMENT DRAWING	BK-GCS-PEDCO-120-IN-PY-0001
ROAD, PAVING AND PLANT FINISH GRADING LAYOUT & SECTIONS	BK-GCS-PEDCO-120-CY-PY-0005
ELECTRICAL CABLE ROUTE & SECTION LAYOUT FOR BUILDING & SHELTER	BK-GCS-PEDCO-120-EL-PY-0006
FOUNDATION DRAWING FOR EXTENSION OF CONTROL BUILDING	BK-GNRL-PEDCO-220-ST-DW-0004
STRUCTURAL DRAWING FOR EXTENSION OF CONTROL BUILDING	BK-GNRL-PEDCO-220-ST-DW-0005
STANDARD DETAILS FOR LADDER & SAFETY CAGE	BK-GCS-PEDCO-000-ST-DW-0009
AREA ELECTRICAL CABLE ROUTE & SECTION LAYOUT	BK-GCS-PEDCO-120-EL-PY-0005
UNIT FLY PLAN DRAWING	BK-PPL-PEDCO-120-PI-PY-0001
CONTROL ROOM CABLE ROUTE LAYOUT	BK-GCS-PEDCO-120-IN-PY-0002
INSTRUMENT/PAG CABLE TRENCH/ROUTE LAYOUT DRAWING	BK-GCS-PEDCO-120-IN-PY-0004
ELECTRICAL EQUIPMENT ARRANGEMENT LAYOUT FOR BUILDING	BK-GCS-PEDCO-120-EL-PY-0008

KEY PLAN

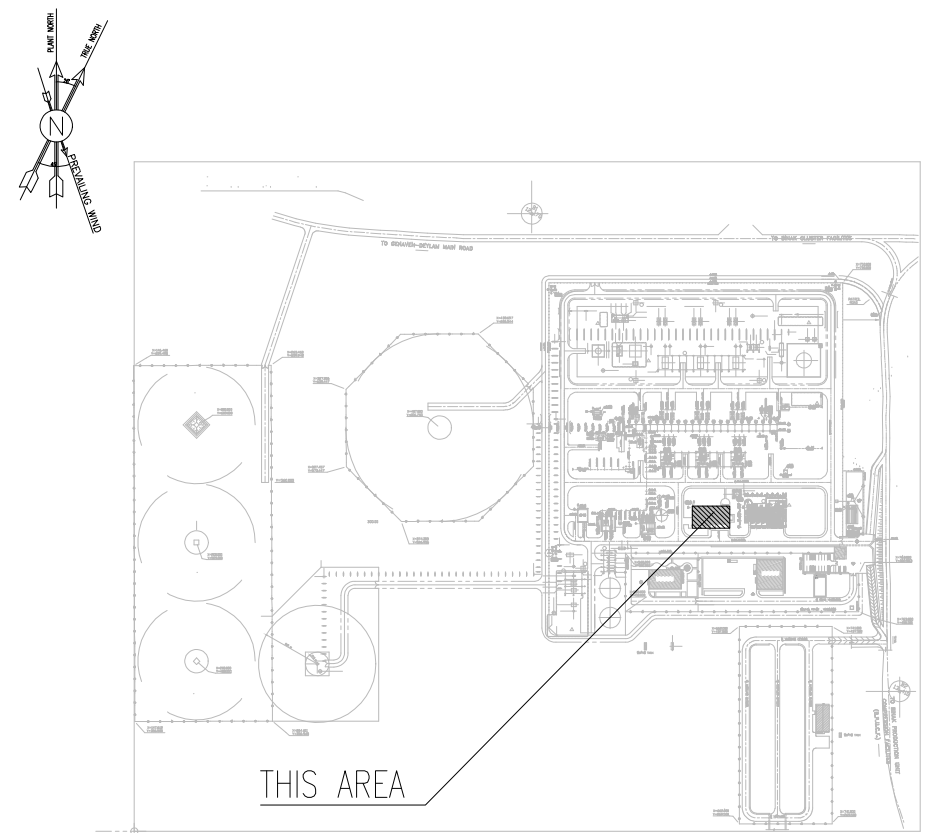

D05	JAN.2025	AFC	R.BERLOUIE	M.FAKHARIAN	S.Paramarspour	***
D04	NOV.2024	AFC	R.BERLOUIE	M.FAKHARIAN	S.Paramarspour	***
D03	MAR.2024	AFC	R.BERLOUIE	M.FAKHARIAN	S.Paramarspour	***
D02	NOV.2023	AFC	R.BERLOUIE	M.FAKHARIAN	S.Paramarspour	***
D01	SEP.2023	IFA	R.BERLOUIE	M.FAKHARIAN	A.M.MOHSSENI	***
D00	JUN.2023	IPC	R.BERLOUIE	M.FAKHARIAN	A.M.MOHSSENI	***
REV.	DATE	P.O.I.S	PREP.	CHK.	APP.	AUT.
PROJECT NAME: BINAK OILFIELD DEVELOPMENT/SURFACE FACILITIES GAS COMPRESSOR STATION						
PROJECT NO.:			971020			
EPC CONTRACTOR:			EPD/EPC CONTRACTOR (GC):			
 HIRGAN ENERGY - DESIGN & INSPECTION COMPANIES			 PETROIRAN DEVELOPMENT COMPANY			
DRAWING TITLE:						
Architectural Detail Drawing For Extension of EXISTING Control Building DIMENTION PLAN						
SCALE		SIZE	DRAWING NO.		SHEET NO.	REV.
AS SHOWN		A1	BK-GCS-PEDCO-120-AR-DW-001		02 OF 13	D05


 


اسل و کلیه نسخ این نقشه و حق اقتباس متعلق به شرکت ملی مناطق نفت خیز جنوب میباشد.

THE ORIGINAL AND ALL COPIES OF THIS DRAWING TOGETHER WITH THE COPYRIGHT THEREIN ARE THE SOLE PROPERTY OF N.I.S.O.C./ FIELDS

BINAK OILFIELD DEVELOPMENT
SURFACE FACILITIES
GAS COMPRESSOR STATION

DATE	SCALE	DRAWING BY	CHECKED BY	PROJECT ENG.	
NO CONSTRUCTION PERMITTED UNLESS DRAWING APPROVED					
APPROVED FOR CONSTRUCTION			BY:		
BUDGET REF.			DATE:		
053-073-9184	F	4	B	709518	02 OF 13
LOCATION			SHEET		
SIZE			REVISION		
CLASS			D05		
SERIAL NO.					

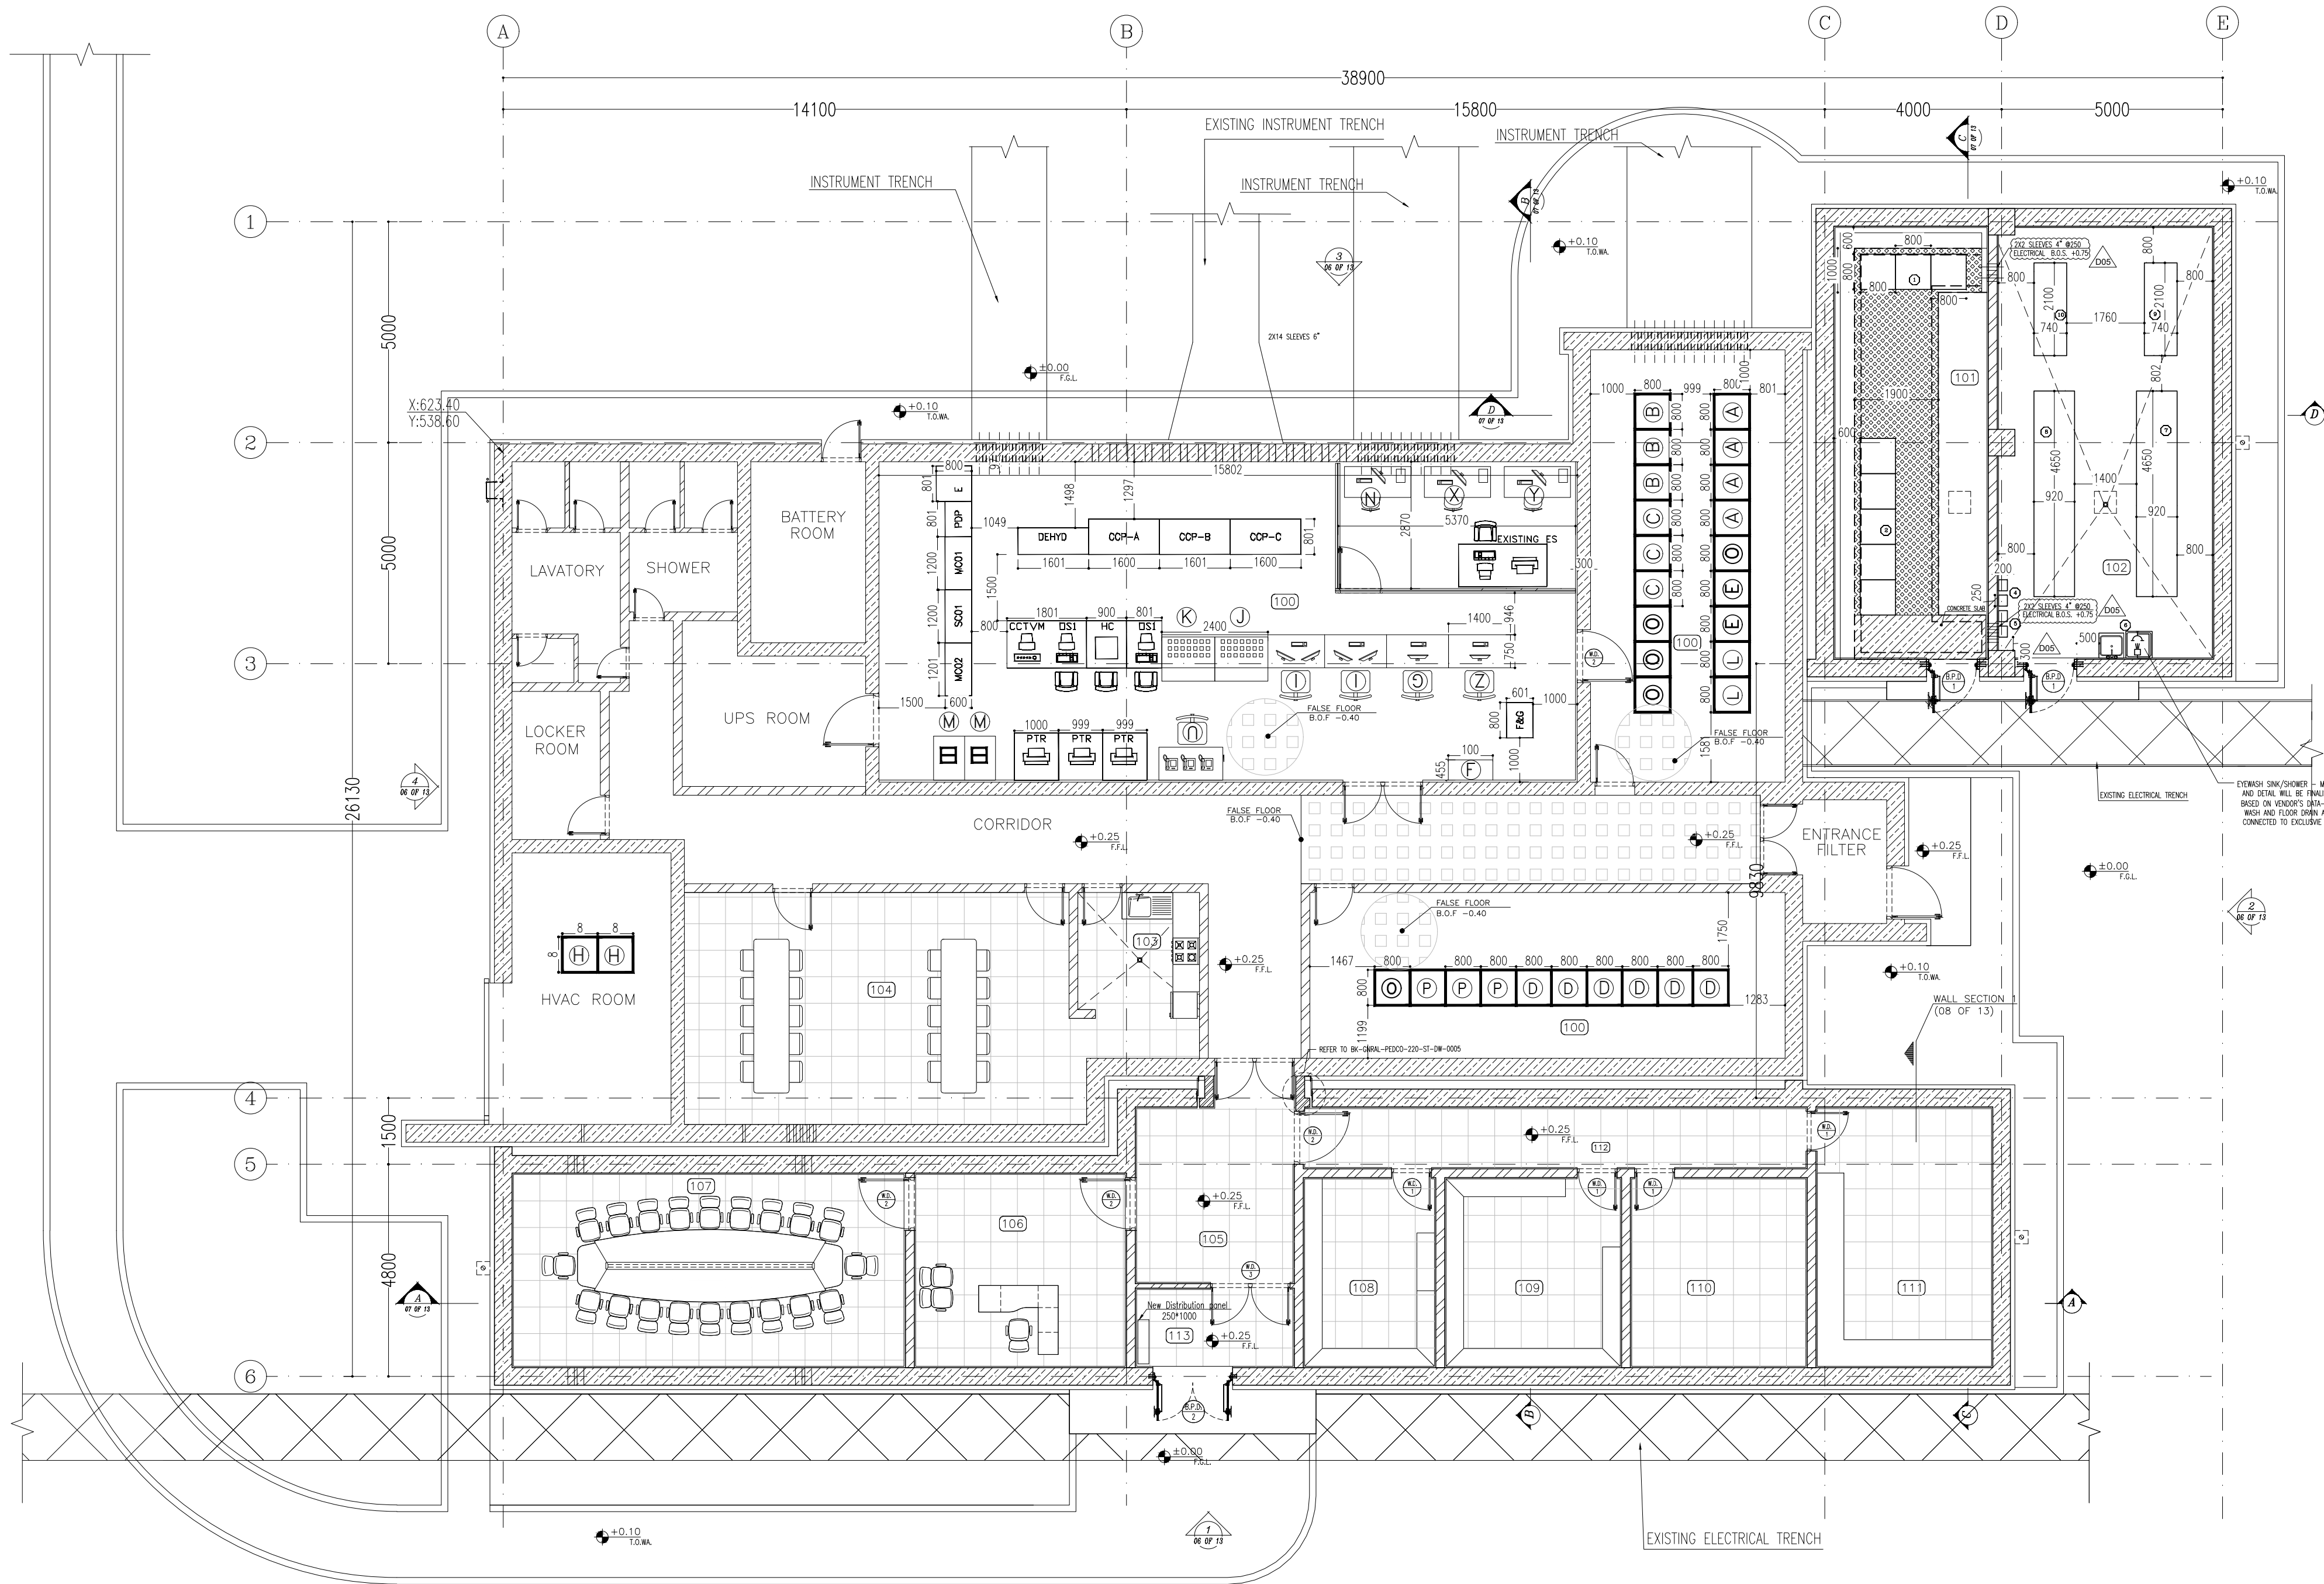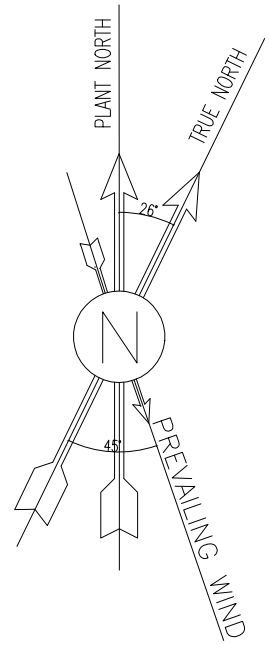

SC.1:100 3 FURNITURE & FLOORING PLAN

100	CONTROL ROOM
101	UPS
102	BATTERY ROOM
103	PANTRY
104	DINING ROOM
105	ENTRANCE
106	MANAGEMENT ROOM
107	CONFERENCE ROOM
108	ARCHIVE
109	LOCKER
110	PRAYER ROOM
111	STORE
112	CORRIDOR
113	AIR LOCK

D05	JAN.2025	AFC	R.BERLOUIE	M.FAKHARIAN	S.Paramarzpour	***
D04	NOV.2024	AFC	R.BERLOUIE	M.FAKHARIAN	S.Paramarzpour	**
D03	MAR.2024	AFC	R.BERLOUIE	M.FAKHARIAN	S.Paramarzpour	**
D02	NOV.2023	AFC	R.BERLOUIE	M.FAKHARIAN	S.Paramarzpour	***
D01	SEP.2023	IFA	R.BERLOUIE	M.FAKHARIAN	A.M.MOHSSENI	**
D00	JUN.2023	IPC	R.BERLOUIE	M.FAKHARIAN	A.M.MOHSSENI	**
REV.	DATE	P.O.I.S	PREP.	CHK.	APP.	AUT.

PROJECT NAME: BINAK OILFIELD DEVELOPMENT/SURFACE FACILITIES GAS COMPRESSOR STATION

PROJECT NO.: 971020

EPC CONTRACTOR:	EPD/EPC CONTRACTOR (GC):
 HIRGAN ENERGY - DESIGN & INSPECTION COMPANIES	 PETROIRAN DEVELOPMENT COMPANY

DRAWING TITLE: Architectural Detail Drawing For Extension of EXISTING Control Building FURNITURE & FLOORING PLAN


SCALE	SIZE	DRAWING NO.	SHEET NO.	REV.
AS SHOWN	A1	BK-GCS-PEDCO-120-AR-DW-0011	03 OF 13	D05

- NOTES
1. ALL DIMENSIONS ARE IN MILLIMETER & ALL ELEVATIONS ARE IN METER.
 2. ALL DIMENSIONS AND ELEVATIONS SHALL BE CHECKED BY THE CONTRACTOR PRIOR TO CONSTRUCTION.
 3. CONTRACTOR SHALL COMPARE ALL ARCHITECTURAL, MECHANICAL, ELECTRICAL, PIPING AND STRUCTURAL DRAWINGS AND IN CASE OF ANY CONFLICTS OR DISCREPANCY, INFORM THE ENGINEER.
 4. ALL MATERIALS ARE SELECTED FROM THE HIGHEST QUALITY AND MUST BE APPROVED BY THE CLIENT.
 5. ALL OPENINGS FOR PIPING/CABLING AND HVAC OPENINGS SHALL BE CONSIDERED AS PER RELATED DRAWINGS BEFORE CONSTRUCTION.
 6. FINISH GRADING LEVEL (F.G.L.) : ± 0.00 (LOCAL) = 99.70

- LEGEND
- F.F.L. FINISHED FLOOR LEVEL
T.O.W.A. TOP OF WALKWAY
T.O.P. TOP OF PARAPET
T.O.S. TOP OF SLAB
T.O.D. TOP OF DOOR
T.O.W. TOP OF WINDOW
B.O.W. BOTTOM OF WINDOW
T.O.C. TOP OF CAGE
B.O.C. BOTTOM OF CAGE
B.O.F. BOTTOM OF FALSE FLOOR
B.O.SU. BOTTOM OF SUSPENDED
B.O.S. BOTTOM OF SLEEVE
H.P.G. HIGH POINT GRAVEL

- BRICK WORK
REINFORCED CONCRETE
FALSE FLOOR
STONE
ANTI-ACID CERAMIC TILE
CHEQUERED PLATE

REFERENCE DRAWING	DRG. No.
STANDARD DRAWING FOR ARCHITECTURAL DETAILS	BK-GNRL-PEDCO-000-AR-DW-0001
SITE SEWAGE SYSTEM LAYOUT & DETAILS	BK-GCS-PEDCO-120-CY-PY-0001
CONTROL ROOM LAYOUT & ARRANGEMENT DRAWING	BK-GCS-PEDCO-120-IN-PY-0001
ROAD, PAVING AND PLANT FINISH GRADING LAYOUT & SECTIONS	BK-GCS-PEDCO-120-CY-PY-0005
ELECTRICAL CABLE ROUTE & SECTION LAYOUT FOR BUILDING & SHELTER	BK-GCS-PEDCO-120-EL-PY-0006
FOUNDATION DRAWING FOR EXTENSION OF CONTROL BUILDING	BK-GNRL-PEDCO-220-ST-DW-0004
STRUCTURAL DRAWING FOR EXTENSION OF CONTROL BUILDING	BK-GNRL-PEDCO-220-ST-DW-0005
STANDARD DETAILS FOR LADDER & SAFETY CAGE	BK-GNRL-PEDCO-000-ST-DW-0009
AREA ELECTRICAL CABLE ROUTE & SECTION LAYOUT	BK-GCS-PEDCO-120-EL-PY-0005
UNIT PLAT PLAN DRAWING	BK-PPL-PEDCO-120-PI-PY-0001
CONTROL ROOM CABLE ROUTE LAYOUT	BK-GCS-PEDCO-120-IN-PY-0002
INSTRUMENT/PAG CABLE TRENCH/ROUTE LAYOUT DRAWING	BK-GCS-PEDCO-120-IN-PY-0004
ELECTRICAL EQUIPMENT ARRANGEMENT LAYOUT FOR BUILDING	BK-GCS-PEDCO-120-EL-PY-0008


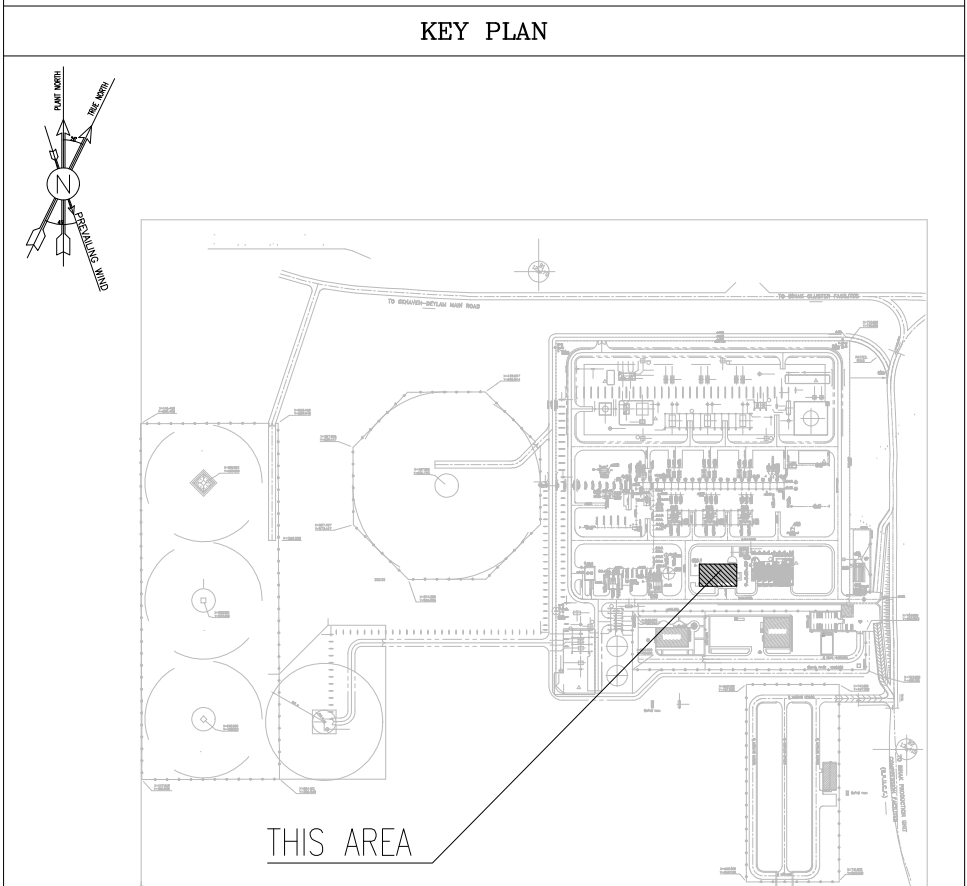


REV.	DESCRIPTION	BY	DATE	BY	DATE
REV.	DESCRIPTION	BY	DATE	BY	DATE

اسم و کلیه نسخ این نقشه و حق اقتباس متعلق به شرکت ملی مناطق نفت خیز جنوب میباشد.
THE ORIGINAL AND ALL COPIES OF THIS DRAWING TOGETHER WITH THE COPYRIGHT THEREIN ARE THE SOLE PROPERTY OF N.I.S.O.C./ FIELDS

BINAK OILFIELD DEVELOPMENT SURFACE FACILITIES GAS COMPRESSOR STATION				
DATE	SCALE	DRAWING BY	CHECKED BY	PROJECT ENG.

NO CONSTRUCTION PERMITTED UNLESS DRAWING APPROVED				
APPROVED FOR CONSTRUCTION		BY:	DATE:	
BUDGET REF.	LOCATION	SIZE CLASS	SERIAL NO.	SHEET REVISION
053-073-9184	F	4	B	709518 03 OF 13 D05

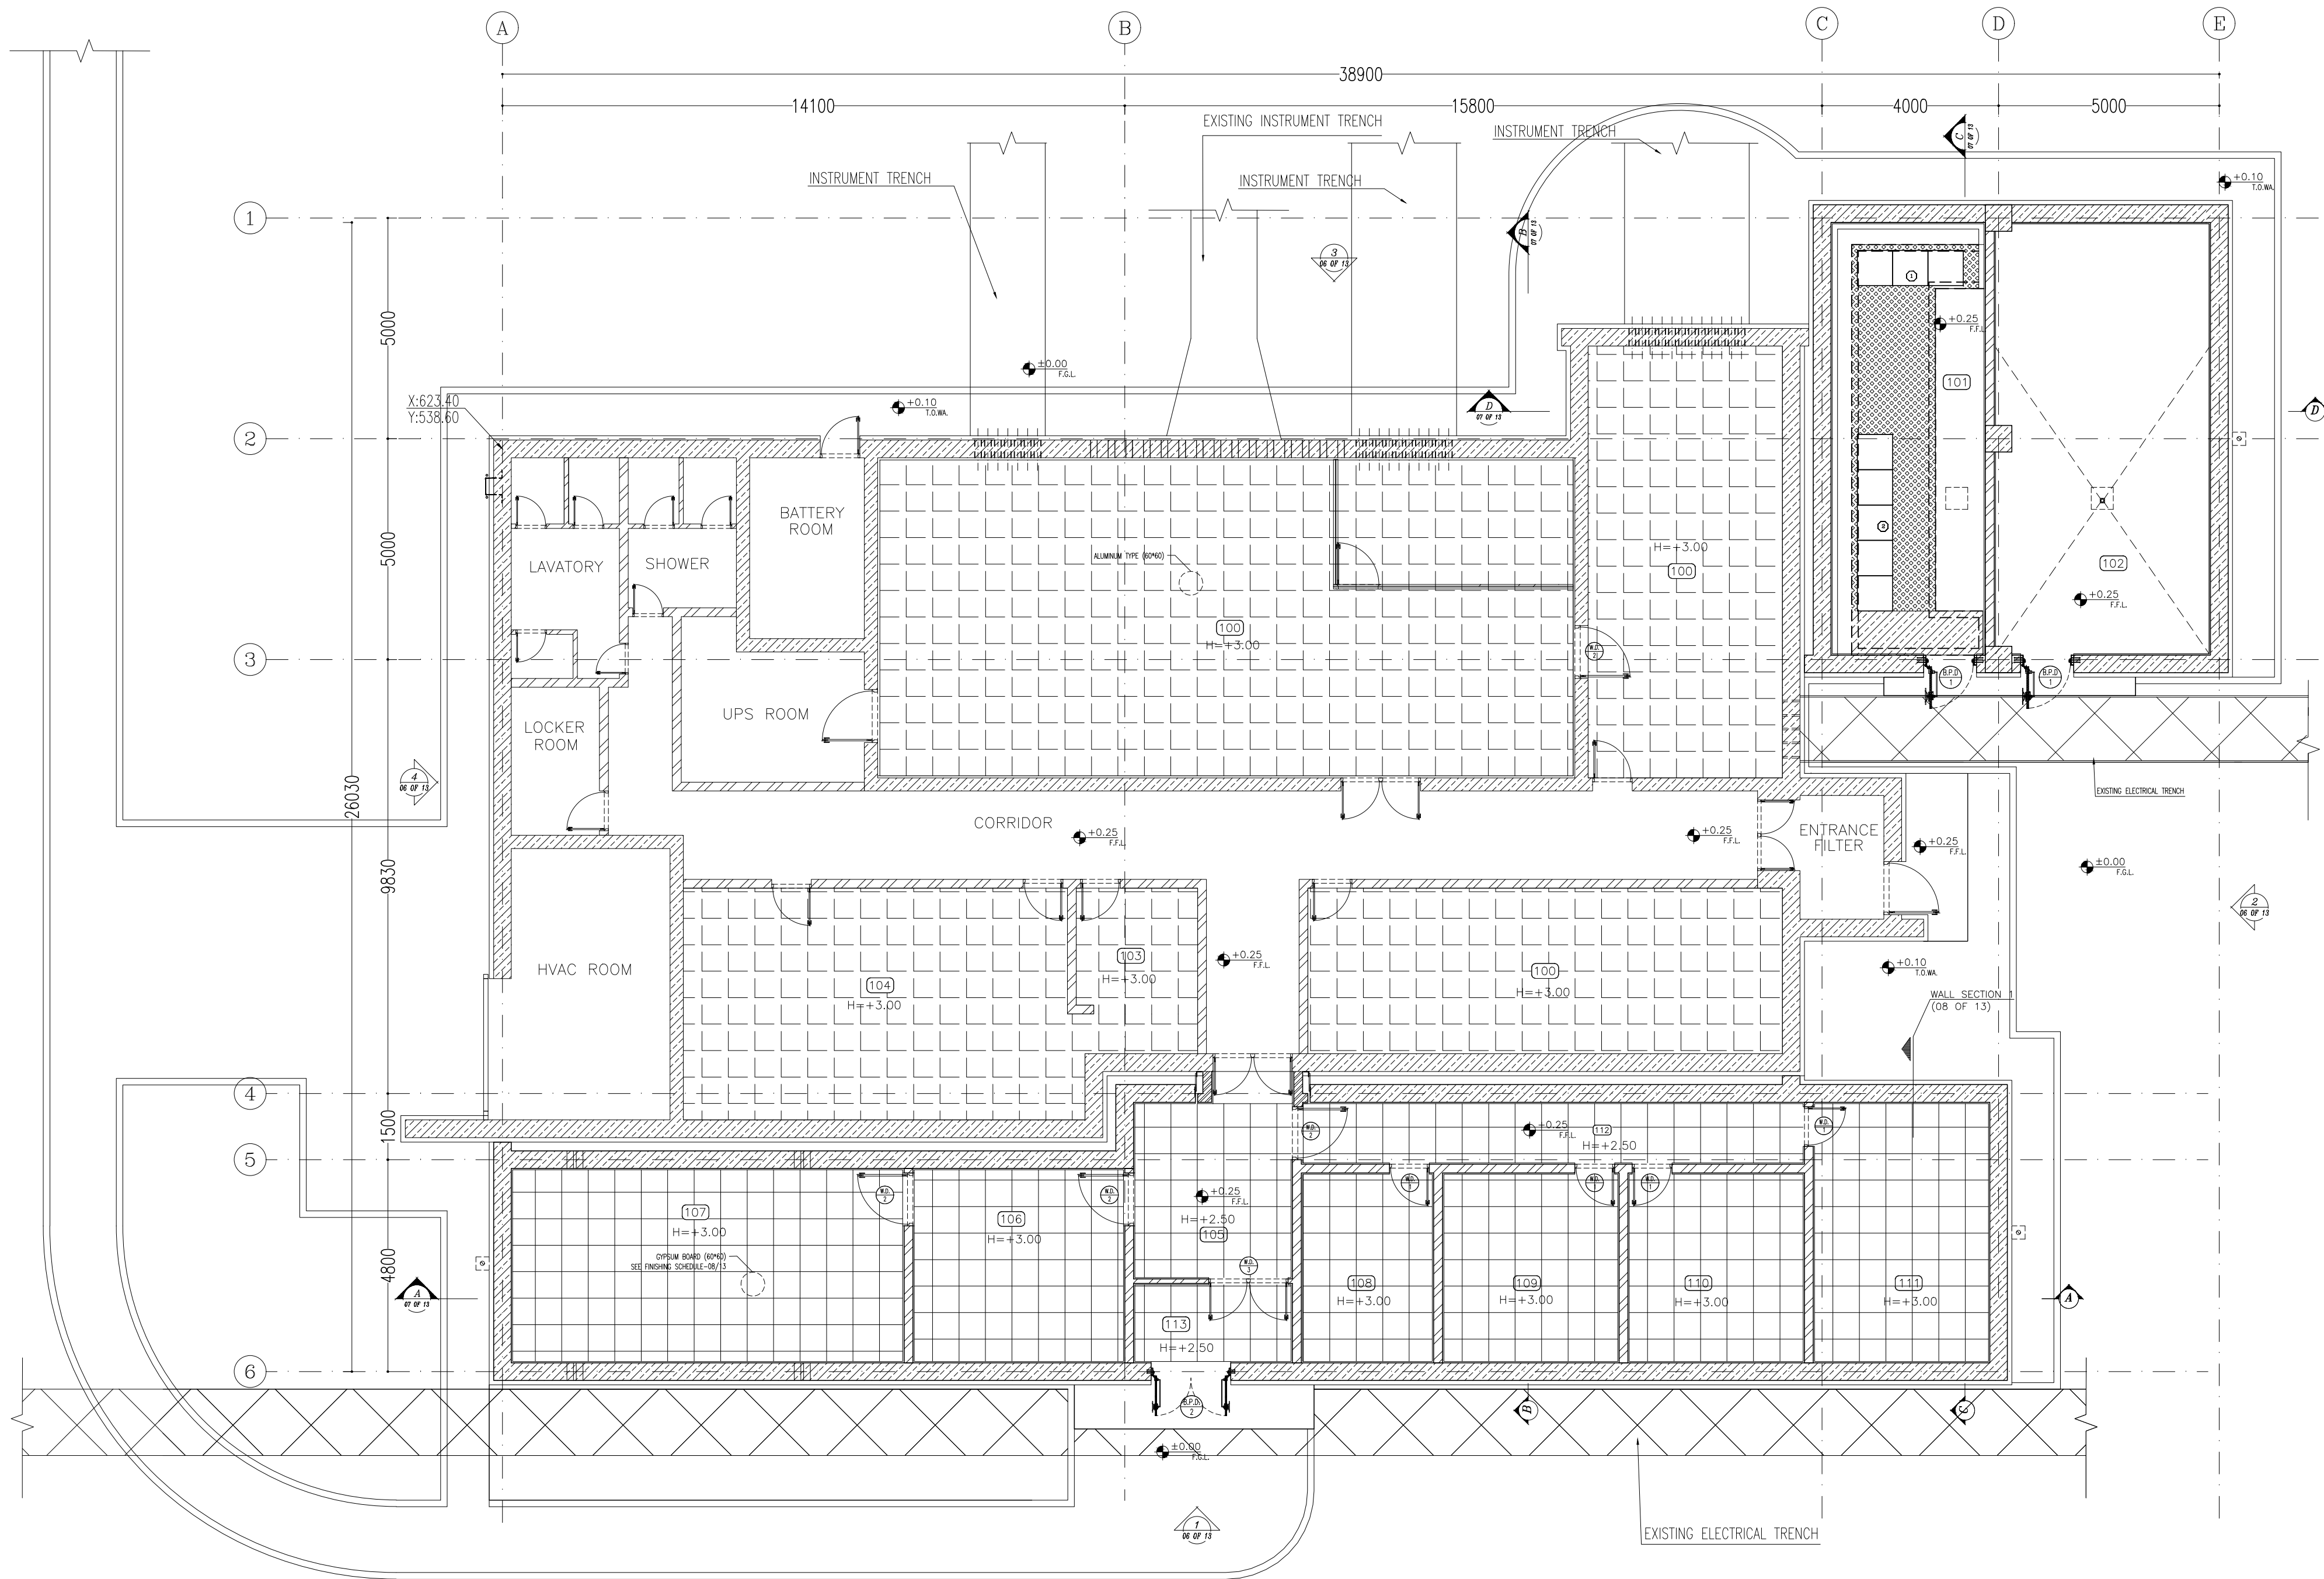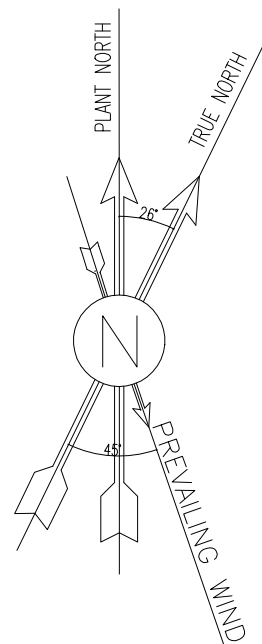

SC.1:100 4 SUSPENDED CEILING PLAN

100	CONTROL ROOM
101	UPS
102	BATTERY ROOM
103	PANTRY
104	DINING ROOM
105	ENTRANCE
106	MANAGEMENT ROOM
107	CONFERENCE ROOM
108	ARCHIVE
109	LOCKER
110	PRAYER ROOM
111	STORE
112	CORRIDOR
113	AIR LOCK

NOTES

1. ALL DIMENSIONS ARE IN MILLIMETER & ALL ELEVATIONS ARE IN METER.
2. ALL DIMENSIONS AND ELEVATIONS SHALL BE CHECKED BY THE CONTRACTOR PRIOR TO CONSTRUCTION.
3. CONTRACTOR SHALL COMPARE ALL ARCHITECTURAL, MECHANICAL, ELECTRICAL, PIPING AND STRUCTURAL DRAWINGS AND IN CASE OF ANY CONFLICTS OR DISCREPANCY, INFORM THE ENGINEER.
4. ALL MATERIALS ARE SELECTED FROM THE HIGHEST QUALITY AND MUST BE APPROVED BY THE CLIENT.
5. ALL OPENINGS FOR PIPING/CABLING AND HVAC OPENINGS SHALL BE CONSIDERED AS PER RELATED DRAWINGS BEFORE CONSTRUCTION.
6. FINISH GRADING LEVEL (F.G.L.) : ± 0.00 (LOCAL) = 99.70


LEGEND

F.F.L.	FINISHED FLOOR LEVEL
T.O.W.A.	TOP OF WALKWAY
T.O.P.	TOP OF PARAPET
T.O.S.	TOP OF SLAB
T.O.D.	TOP OF DOOR
T.O.W.	TOP OF WINDOW
B.O.W.	BOTTOM OF WINDOW
T.O.C.	TOP OF CAGE
B.O.C.	BOTTOM OF CAGE
B.O.F.	BOTTOM OF FALSE FLOOR
B.O.SU.	BOTTOM OF SUSPENDED
B.O.S.	BOTTOM OF SLEEVE
H.P.G.	HIGH POINT GRAVEL

	BRICK WORK
	REINFORCED CONCRETE
	SUSPENDED CEILING ALUMINUM TYPE
	SUSPENDED CEILING GYPSUM BOARD


REFERENCE DRAWING	DRG. No.
STANDARD DRAWING FOR ARCHITECTURAL DETAILS	BK-GNRL-PEDCO-000-AR-DW-0001
SITE SEWAGE SYSTEM LAYOUT & DETAILS	BK-GCS-PEDCO-120-CY-PY-0001
CONTROL ROOM LAYOUT & ARRANGEMENT DRAWING	BK-GCS-PEDCO-120-IN-PY-0001
ROAD, PAVING AND PLANT FINISH GRADING LAYOUT & SECTIONS	BK-GCS-PEDCO-120-CY-PY-0005
ELECTRICAL CABLE ROUTE & SECTION LAYOUT FOR BUILDING & SHELTER	BK-GCS-PEDCO-120-EL-PY-0006
FOUNDATION DRAWING FOR EXTENSION OF CONTROL BUILDING	BK-GNRL-PEDCO-220-ST-DW-0004
STRUCTURAL DRAWING FOR EXTENSION OF CONTROL BUILDING	BK-GNRL-PEDCO-220-ST-DW-0005
STANDARD DETAILS FOR LADDER & SAFETY CAGE	BK-GCS-PEDCO-120-EL-PY-0005
AREA ELECTRICAL CABLE ROUTE & SECTION LAYOUT	BK-GCS-PEDCO-000-ST-DW-0009
UNIT FLOT PLAN DRAWING	BK-PPL-PEDCO-120-PI-PY-0001
CONTROL ROOM CABLE ROUTE LAYOUT	BK-GCS-PEDCO-120-IN-PY-0002
INSTRUMENT/PAG CABLE TRENCH/ROUTE LAYOUT DRAWING	BK-GCS-PEDCO-120-IN-PY-0004
ELECTRICAL EQUIPMENT ARRANGEMENT LAYOUT FOR BUILDING	BK-GCS-PEDCO-120-EL-PY-0008

KEY PLAN

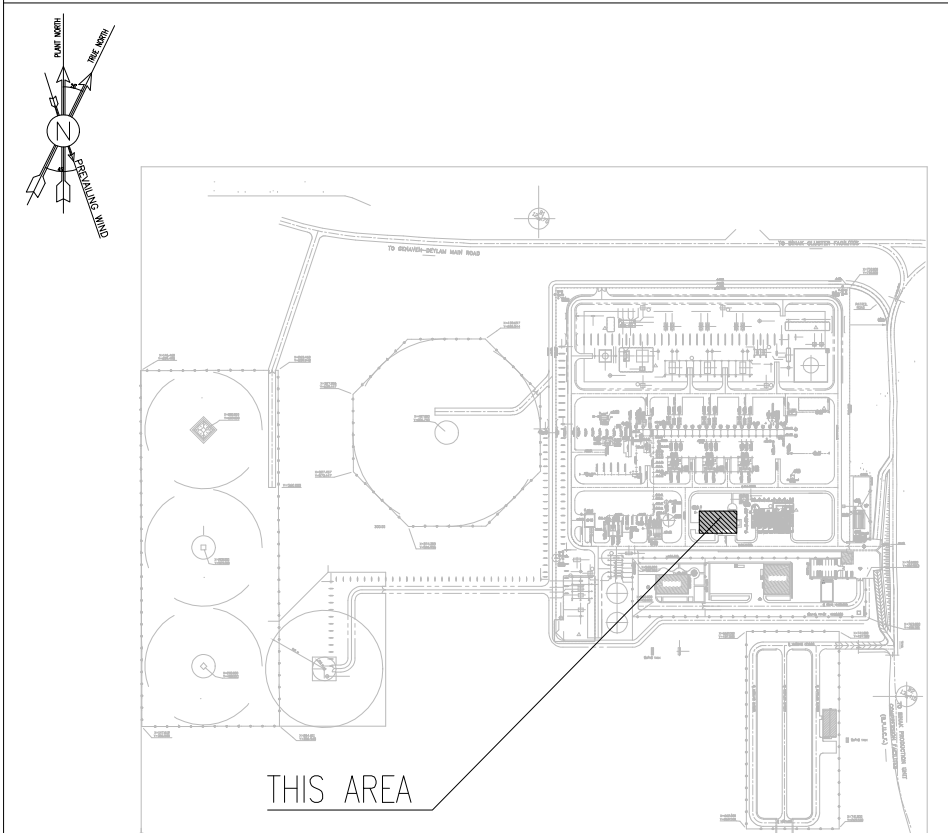

D05	JAN.2025	AFC	R.BERLOUIE	M.FAKHARIAN	S.Faramarzpour	***
D04	NOV.2024	AFC	R.BERLOUIE	M.FAKHARIAN	S.Faramarzpour	**
D03	MAR.2024	AFC	R.BERLOUIE	M.FAKHARIAN	S.Faramarzpour	**
D02	NOV.2023	AFC	R.BERLOUIE	M.FAKHARIAN	S.Faramarzpour	**
D01	SEP.2023	IFA	R.BERLOUIE	M.FAKHARIAN	A.M.MOHSSENI	**
D00	JUN.2023	IPC	R.BERLOUIE	M.FAKHARIAN	A.M.MOHSSENI	**
REV.	DATE	P.O.I.S	PREP.	CHK.	APP.	AUT.
PROJECT NAME: BINAK OILFIELD DEVELOPMENT/SURFACE FACILITIES GAS COMPRESSOR STATION						
PROJECT NO.:			971020			
EPC CONTRACTOR:			EPD/EPC CONTRACTOR (GC):			
 HIRGAN ENERGY - DESIGN & INSPECTION COMPANIES			 PETROIRAN DEVELOPMENT COMPANY			
DRAWING TITLE:						
Architectural Detail Drawing For Extension of EXISTING Control Building SUSPENDED CEILING PLAN						
SCALE	SIZE	DRAWING NO.			SHEET NO.	REV.
AS SHOWN	A1	BK-GCS-PEDCO-120-AR-DW-0011			04 OF 13	D05

***	*****	** **	*** ****	** **	*** ****
REV.	DESCRIPTION	BY	DATE	BY	DATE
		CHECKED		REV. APPR.	
اصل و کلیه نسخ این نقشه و حق اقتباس متعلق به شرکت ملی مناطق نفت خیز جنوب میباشد.					
 THE ORIGINAL AND ALL COPIES OF THIS DRAWING TOGETHER WITH THE COPYRIGHT THEREIN ARE THE SOLE PROPERTY OF N.I.S.O.C./ FIELDS					
BINAK OILFIELD DEVELOPMENT SURFACE FACILITIES GAS COMPRESSOR STATION					
DATE	SCALE	DRAWING BY	CHECKED BY	PROJECT ENG.	
NO CONSTRUCTION PERMITTED UNLESS DRAWING APPROVED					
APPROVED FOR CONSTRUCTION			BY:	DATE:	
BUDGET REF.	LOCATION	SIZE CLASS	SERIAL NO.	SHEET	REVISION
053-073-9184	F	4 B	709518	04 OF 13	D05

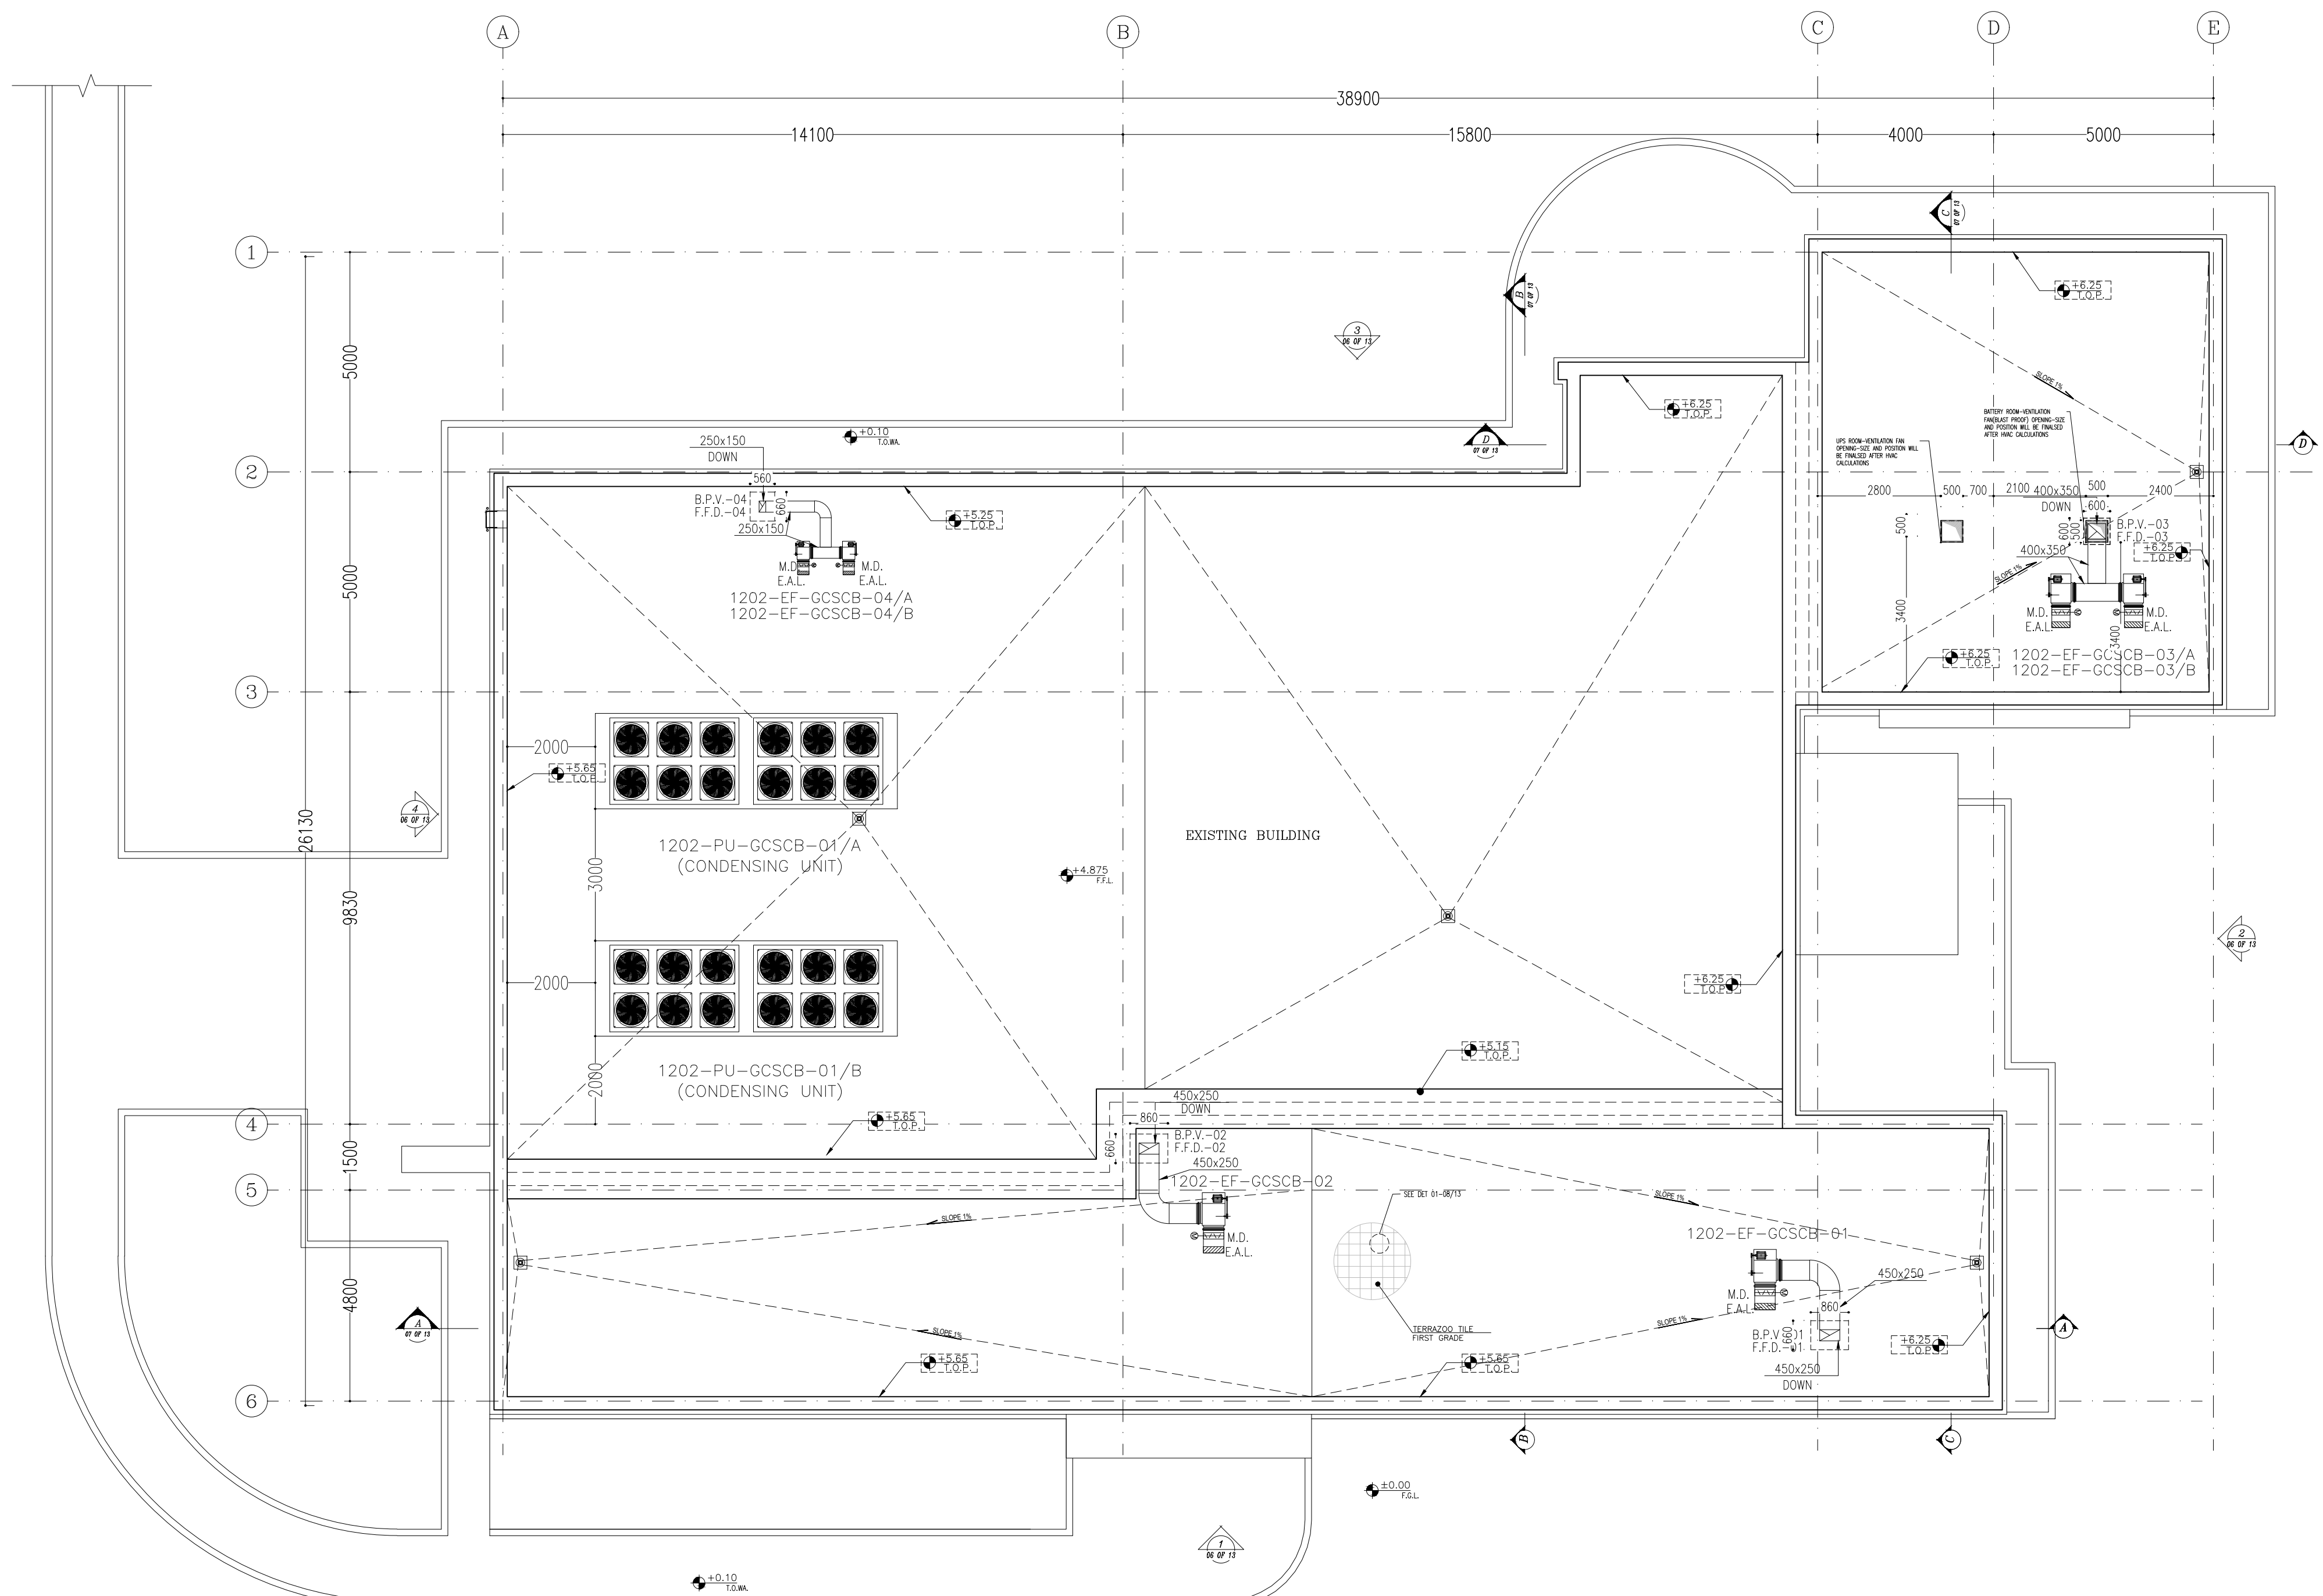


SC.1:100 5 ROOF PLAN

NOTES	
1.	ALL DIMENSIONS ARE IN MILLIMETER & ALL ELEVATIONS ARE IN METER.
2.	ALL DIMENSIONS AND ELEVATIONS SHALL BE CHECKED BY THE CONTRACTOR PRIOR TO CONSTRUCTION.
3.	CONTRACTOR SHALL COMPARE ALL ARCHITECTURAL, MECHANICAL, ELECTRICAL, PIPING AND STRUCTURAL DRAWINGS AND IN CASE OF ANY CONFLICTS OR DISCREPANCY, INFORM THE ENGINEER.
4.	ALL MATERIALS ARE SELECTED FROM THE HIGHEST QUALITY AND MUST BE PROVIDED BY THE CLIENT.
5.	ALL OPENINGS FOR PIPING/CABLING AND HVAC OPENINGS SHALL BE CONSIDERED AS PER RELATED DRAWINGS BEFORE CONSTRUCTION.
6.	FINISH GRAVEL LEVEL (F.G.L.) : ± 0.00 (LOCAL) = 99.70


LEGEND

F.F.L.	FINISHED FLOOR LEVEL
T.O.W.A.	TOP OF WALKWAY
T.O.P.	TOP OF PARAPET
T.O.S.	TOP OF SLAB
T.O.D.	TOP OF DOOR
T.O.W.	TOP OF WINDOW
B.O.W.	BOTTOM OF WINDOW
T.O.C.	TOP OF CAGE
B.O.C.	BOTTOM OF CAGE
B.O.F.	BOTTOM OF FALSE FLOOR
B.O.S.U.	BOTTOM OF SUSPENDED
B.O.S.	BOTTOM OF SLEEVE
H.P.G.	HIGH POINT GRAVEL

 

REFERENCE DRAWING	DRG. No.
STANDARD DRAWING FOR ARCHITECTURAL DETAILS	BK-GNRL-PEDCO-000-AR-DW-0001
SITE SEWAGEAGE SYSTEM LAYOUT & DETAILS	BK-GCS-PEDCO-120-CV-PY-0001
CONTROL ROOM LAYOUT & ARRANGEMENT DRAWING	BK-GCS-PEDCO-120-IN-PY-0001
ROAD, PAVING AND PLANT FINISH GRADING LAYOUT & SECTIONS	BK-GCS-PEDCO-120-CV-PY-0005
ELECTRICAL CABLE ROUTE & SECTION LAYOUT FOR BUILDING & SHELTER	BK-GCS-PEDCO-120-EL-PY-0006
FOUNDATION DRAWING FOR EXTENSION OF CONTROL BUILDING	BK-GNRL-PEDCO-220-ST-DW-0004
STRUCTURAL DRAWING FOR EXTENSION OF CONTROL BUILDING	BK-GNRL-PEDCO-220-ST-DW-0005
STANDARD DETAILS FOR LADDER & SAFETY CAGE	BK-GNRL-PEDCO-000-ST-PY-DW-0009
AREA ELECTRICAL CABLE ROUTE & SECTION LAYOUT	BK-GCS-PEDCO-120-EL-PY-0005
UNIT PLOT PLAIN DRAWING	BK-FPL-PEDCO-120-PI-PY-0001
CONTROL ROOM CABLE ROUTE LAYOUT	BK-GCS-PEDCO-120-IN-PY-0002
INSTRUMENT/P&G CABLE TRENCH/ROUTE LAYOUT DRAWING	BK-GCS-PEDCO-120-IN-PY-0004
ELECTRICAL EQUIPMENT ARRANGEMENT LAYOUT FOR BUILDING	BK-GCS-PEDCO-120-EL-PY-0008

KEY PLAN

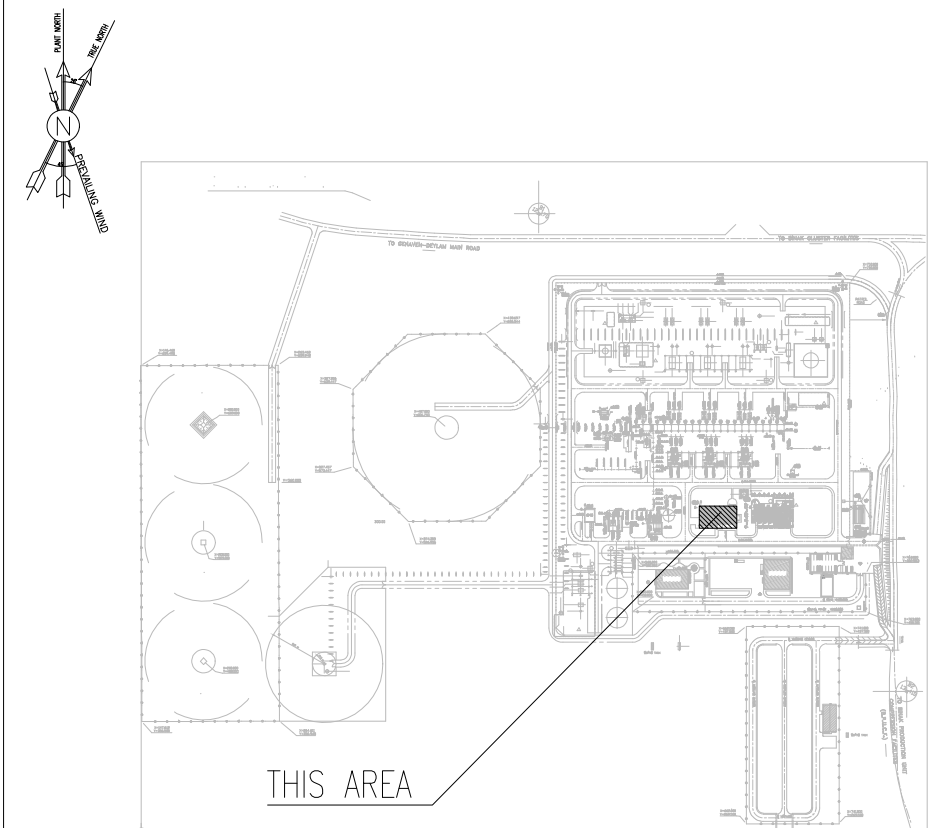

D05	JAN 2025	AFPC	R.BERLIOUJE	M.FAKHARIAN	S.Faramarzpour	**
D04	NOV 2024	AFPC	R.BERLIOUJE	M.FAKHARIAN	S.Faramarzpour	**
D03	MAR 2024	AFPC	R.BERLIOUJE	M.FAKHARIAN	S.Faramarzpour	**
D02	NOV 2023	AFPC	R.BERLIOUJE	M.FAKHARIAN	S.Faramarzpour	**
D01	SEP 2023	IFA	R.BERLIOUJE	M.FAKHARIAN	A.M.MOHSSENI	**
D00	JUN 2023	IFC	R.BERLIOUJE	M.FAKHARIAN	A.M.MOHSSENI	**
REV.	DATE	P.O.I.S	PREP.	CHK.	APP.	AUT.

PROJECT NAME:	BINAK OILFIELD DEVELOPMENT/SURFACE FACILITIES GAS COMPRESSOR STATION
---------------	---

EPD/EPC CONTRACTOR (GC):



Architectural Detail Drawing For Exterior
ROOF PLAN

BINAK OILFIELD DEVELOPMENT
SURFACE FACILITIES
GAS COMPRESSOR STATION


 HIRAN ENERGY – DESIGN & INSPECTION COMPANIES				 PEDCO COMPANY				DATE		SCALE		DRAWING BY		CHECKED BY		PROJECT ENG.							
DRAWING TITLE: Architectural Detail Drawing For Extension of Existing Control Building ROOF PLAN								NO CONSTRUCTION PERMITTED UNLESS DRAWING APPROVED															
APPROVED FOR CONSTRUCTION								BY:		DATE:													
SCALE		SIZE		DRAWING NO.		SHEET NO.		REV.		BUDGET REF.		LOCATION		SIZE		CLASS		SERIAL NO.		SHEET		REVISION	
AS SHOWN		A1		BK-GCS-PEDCO-120-AR-DW-0011		05 OF 13		D05		053-073-9184		F		4		B		709518		05 OF 13		D05	

NOTES


1. ALL DIMENSIONS ARE IN MILLIMETER & ALL ELEVATIONS ARE IN METER.
2. ALL DIMENSIONS AND ELEVATIONS SHALL BE CHECKED BY THE CONTRACTOR PRIOR TO CONSTRUCTION.
3. CONTRACTOR SHALL COMPARE ALL ARCHITECTURAL, MECHANICAL, ELECTRICAL, PIPING AND STRUCTURAL DRAWINGS AND IN CASE OF ANY CONFLICTS OR DISCREPANCY, INFORM THE ENGINEER.
4. ALL MATERIALS ARE SELECTED FROM THE HIGHEST QUALITY AND MUST BE APPROVED BY THE CLIENT.
5. ALL OPENINGS FOR PIPING/CABLING AND HVAC OPENINGS SHALL BE CONSIDERED AS PER RELATED DRAWINGS BEFORE CONSTRUCTION.
6. FINISH GRADING LEVEL (F.G.L.) : ± 0.00 (LOCAL) = 99.70

LEGEND

F.F.L. FINISHED FLOOR LEVEL
T.O.WA. TOP OF WALKWAY
T.O.P. TOP OF PARAPET
T.O.S. TOP OF SLAB
T.O.D. TOP OF DOOR
T.O.W. TOP OF WINDOW
B.O.W. BOTTOM OF WINDOW
T.O.C. TOP OF CAGE
B.O.C. BOTTOM OF CAGE
B.O.F. BOTTOM OF FALSE FLOOR
B.O.SU. BOTTOM OF SUSPENDED
B.O.S. BOTTOM OF SLEEVE
H.P.G. HIGH POINT GRAVEL

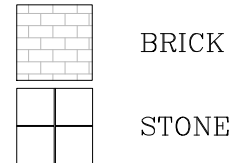

REFERENCE DRAWING	DRG. No.
STANDARD DRAWING FOR ARCHITECTURAL DETAILS	BK-GNRL-PEDCO-000-AR-DW-0001
SITE SEWORAGE SYSTEM LAYOUT & DETAILS	BK-GCS-PEDCO-120-CY-PY-0001
CONTROL ROOM LAYOUT & ARRANGEMENT DRAWING	BK-GCS-PEDCO-120-IN-PY-0001
ROAD, PAVING AND PLANT FINISH GRADING LAYOUT & SECTIONS	BK-GCS-PEDCO-120-CY-PY-0005
ELECTRICAL CABLE ROUTE & SECTION LAYOUT FOR BUILDING & SHELTER	BK-GCS-PEDCO-120-EL-PY-0006
FOUNDATION DRAWING FOR EXTENSION OF CONTROL BUILDING	BK-GNRL-PEDCO-220-ST-DW-0004
STRUCTURAL DRAWING FOR EXTENSION OF CONTROL BUILDING	BK-GNRL-PEDCO-220-ST-DW-0005
STANDARD DETAILS FOR LADDER & SAFETY CAGE	BK-GNRL-PEDCO-000-ST-DW-0009
AREA ELECTRICAL CABLE ROUTE & SECTION LAYOUT	BK-GCS-PEDCO-120-EL-PY-0005
UNIT PLOT PLAN DRAWING	BK-PPL-PEDCO-120-PI-PY-0001
CONTROL ROOM CABLE ROUTE LAYOUT	BK-GCS-PEDCO-120-IN-PY-0002
INTRUMENT/PAG CABLE TRENCH/ROUTE LAYOUT DRAWING	BK-GCS-PEDCO-120-IN-PY-0004
ELECTRICAL EQUIPMENT ARRANGEMENT LAYOUT FOR BUILDING	BK-GCS-PEDCO-120-EL-PY-0008

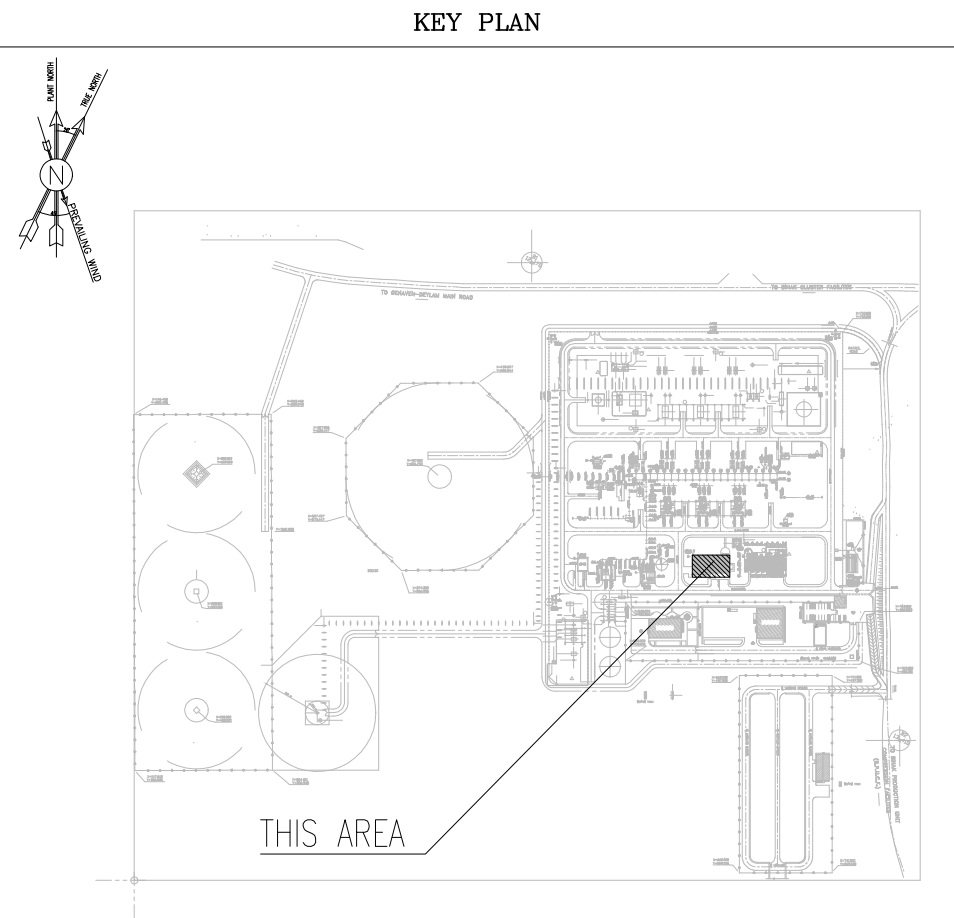


اسل و کلیه نسخ این نقشه و حق اقتباس متعلق به شرکت ملی مناطق نفت خیز جنوب میباشد.
THE ORIGINAL AND ALL COPIES OF THIS DRAWING TOGETHER WITH THE COPYRIGHT THEREIN ARE THE SOLE PROPERTY OF N.I.S.O.C./ FIELDS

BINAK OILFIELD DEVELOPMENT
SURFACE FACILITIES
GAS COMPRESSOR STATION

DATE	SCALE	DRAWING BY	CHECKED BY	PROJECT ENG.


NO CONSTRUCTION PERMITTED UNLESS DRAWING APPROVED

APPROVED FOR CONSTRUCTION				BY:	DATE:						
BUDGET REF.	LOCATION	SIZE	CLASS	SERIAL NO.	SHEET	REVISION					
AS SHOWN	A1	BK-GCS-PEDCO-120-AR-DW-0011	06 OF 13	D05	053-073-9184	F	4	B	709518	06 OF 13	D05

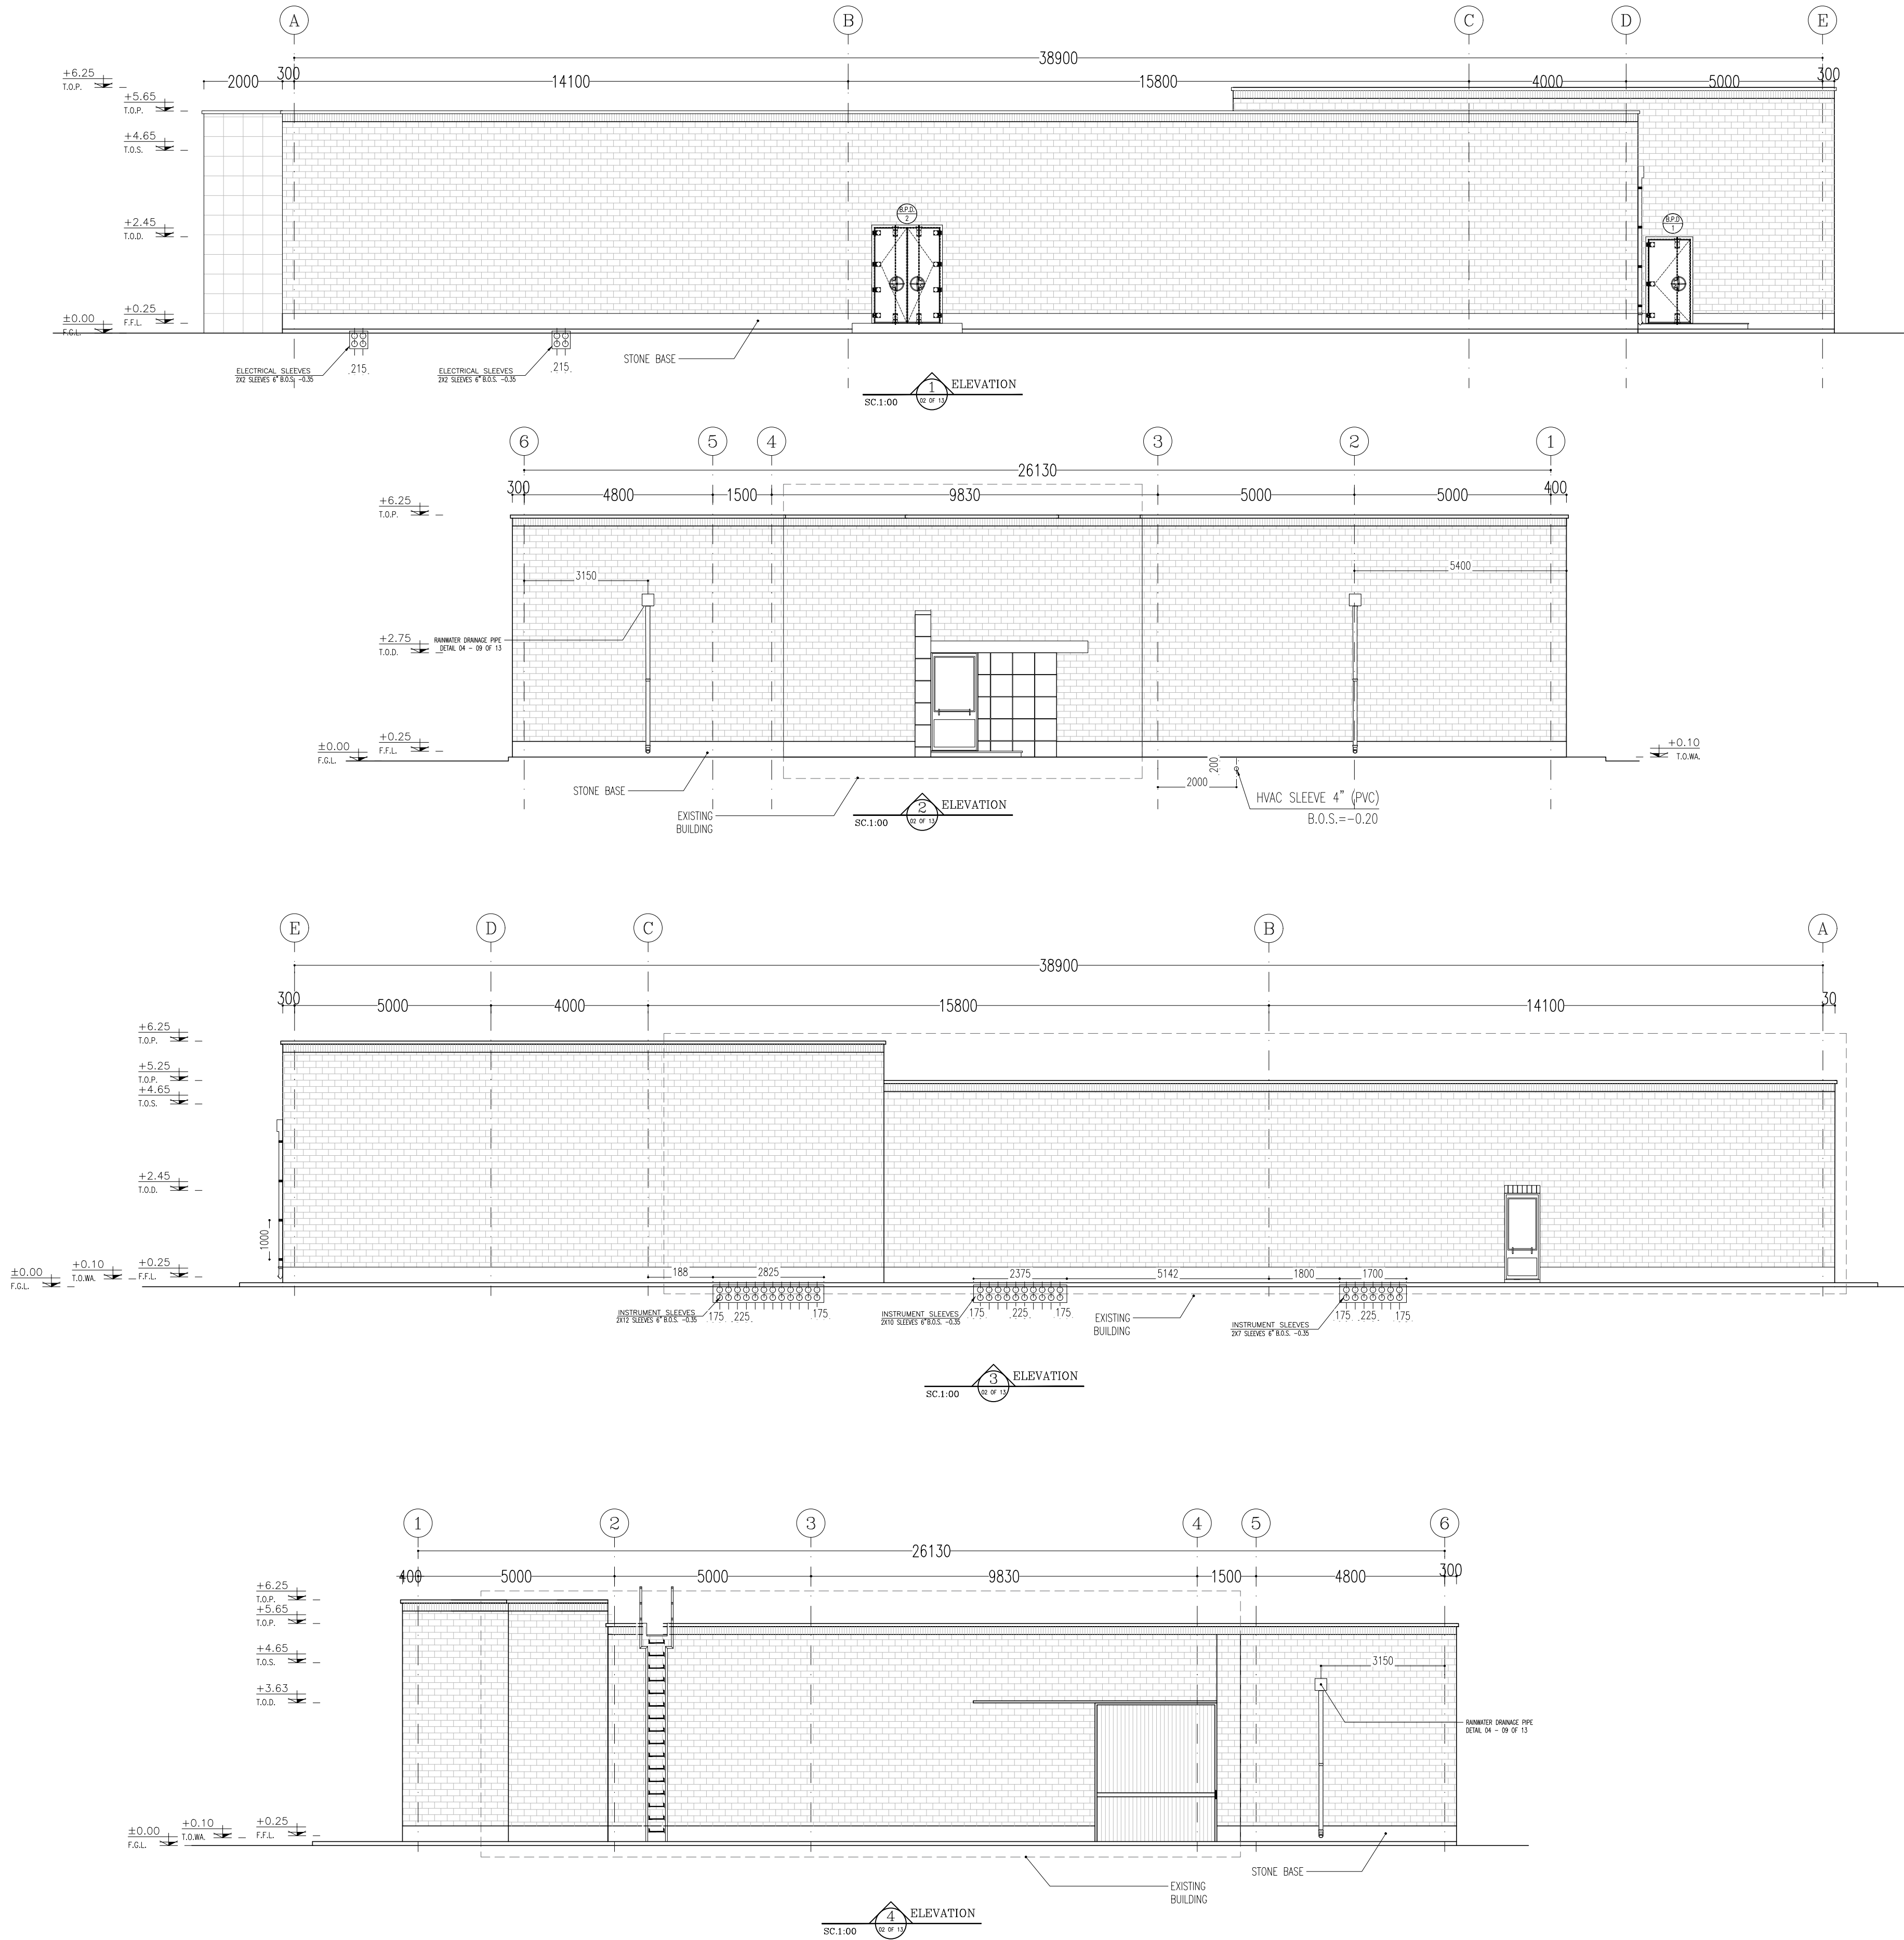



D05	JAN.2025	AFC	R.BERLOUIE	M.FAKHARIAN	S.Paramarspour	***
D04	NOV.2024	AFC	R.BERLOUIE	M.FAKHARIAN	S.Paramarspour	***
D03	MAR.2024	AFC	R.BERLOUIE	M.FAKHARIAN	S.Paramarspour	***
D02	NOV.2023	AFC	R.BERLOUIE	M.FAKHARIAN	S.Paramarspour	***
D01	SEP.2023	IFA	R.BERLOUIE	M.FAKHARIAN	A.M.MOHSENI	***
D00	JUN.2023	IPC	R.BERLOUIE	M.FAKHARIAN	A.M.MOHSENI	***
REV.	DATE	P.O.I.S	PREP.	CHK.	APP.	AUT.
PROJECT NAME: BINAK OILFIELD DEVELOPMENT/SURFACE FACILITIES GAS COMPRESSOR STATION						
PROJECT NO.:			971020			
EPC CONTRACTOR:			EPD/EPC CONTRACTOR (GC):			
 						
HIRGAN ENERGY – DESIGN & INSPECTION COMPANIES			PEDCO			
DRAWING TITLE:						
Architectural Detail Drawing For Extension of EXISTING Control Building ELEVATIONS						
SCALE	SIZE	DRAWING NO.			SHEET NO.	REV.
AS SHOWN	A1	BK-GCS-PEDCO-120-AR-DW-0011			06 OF 13	D05

100	CONTROL ROOM
101	UPS
102	BATTERY ROOM
103	PANTRY
104	DINING ROOM
105	ENTRANCE
106	MANAGEMENT ROOM
107	CONFERENCE ROOM
108	ARCHIVE
109	LOCKER
110	PRAYER ROOM
111	STORE
112	CORRIDOR
113	AIR LOCK

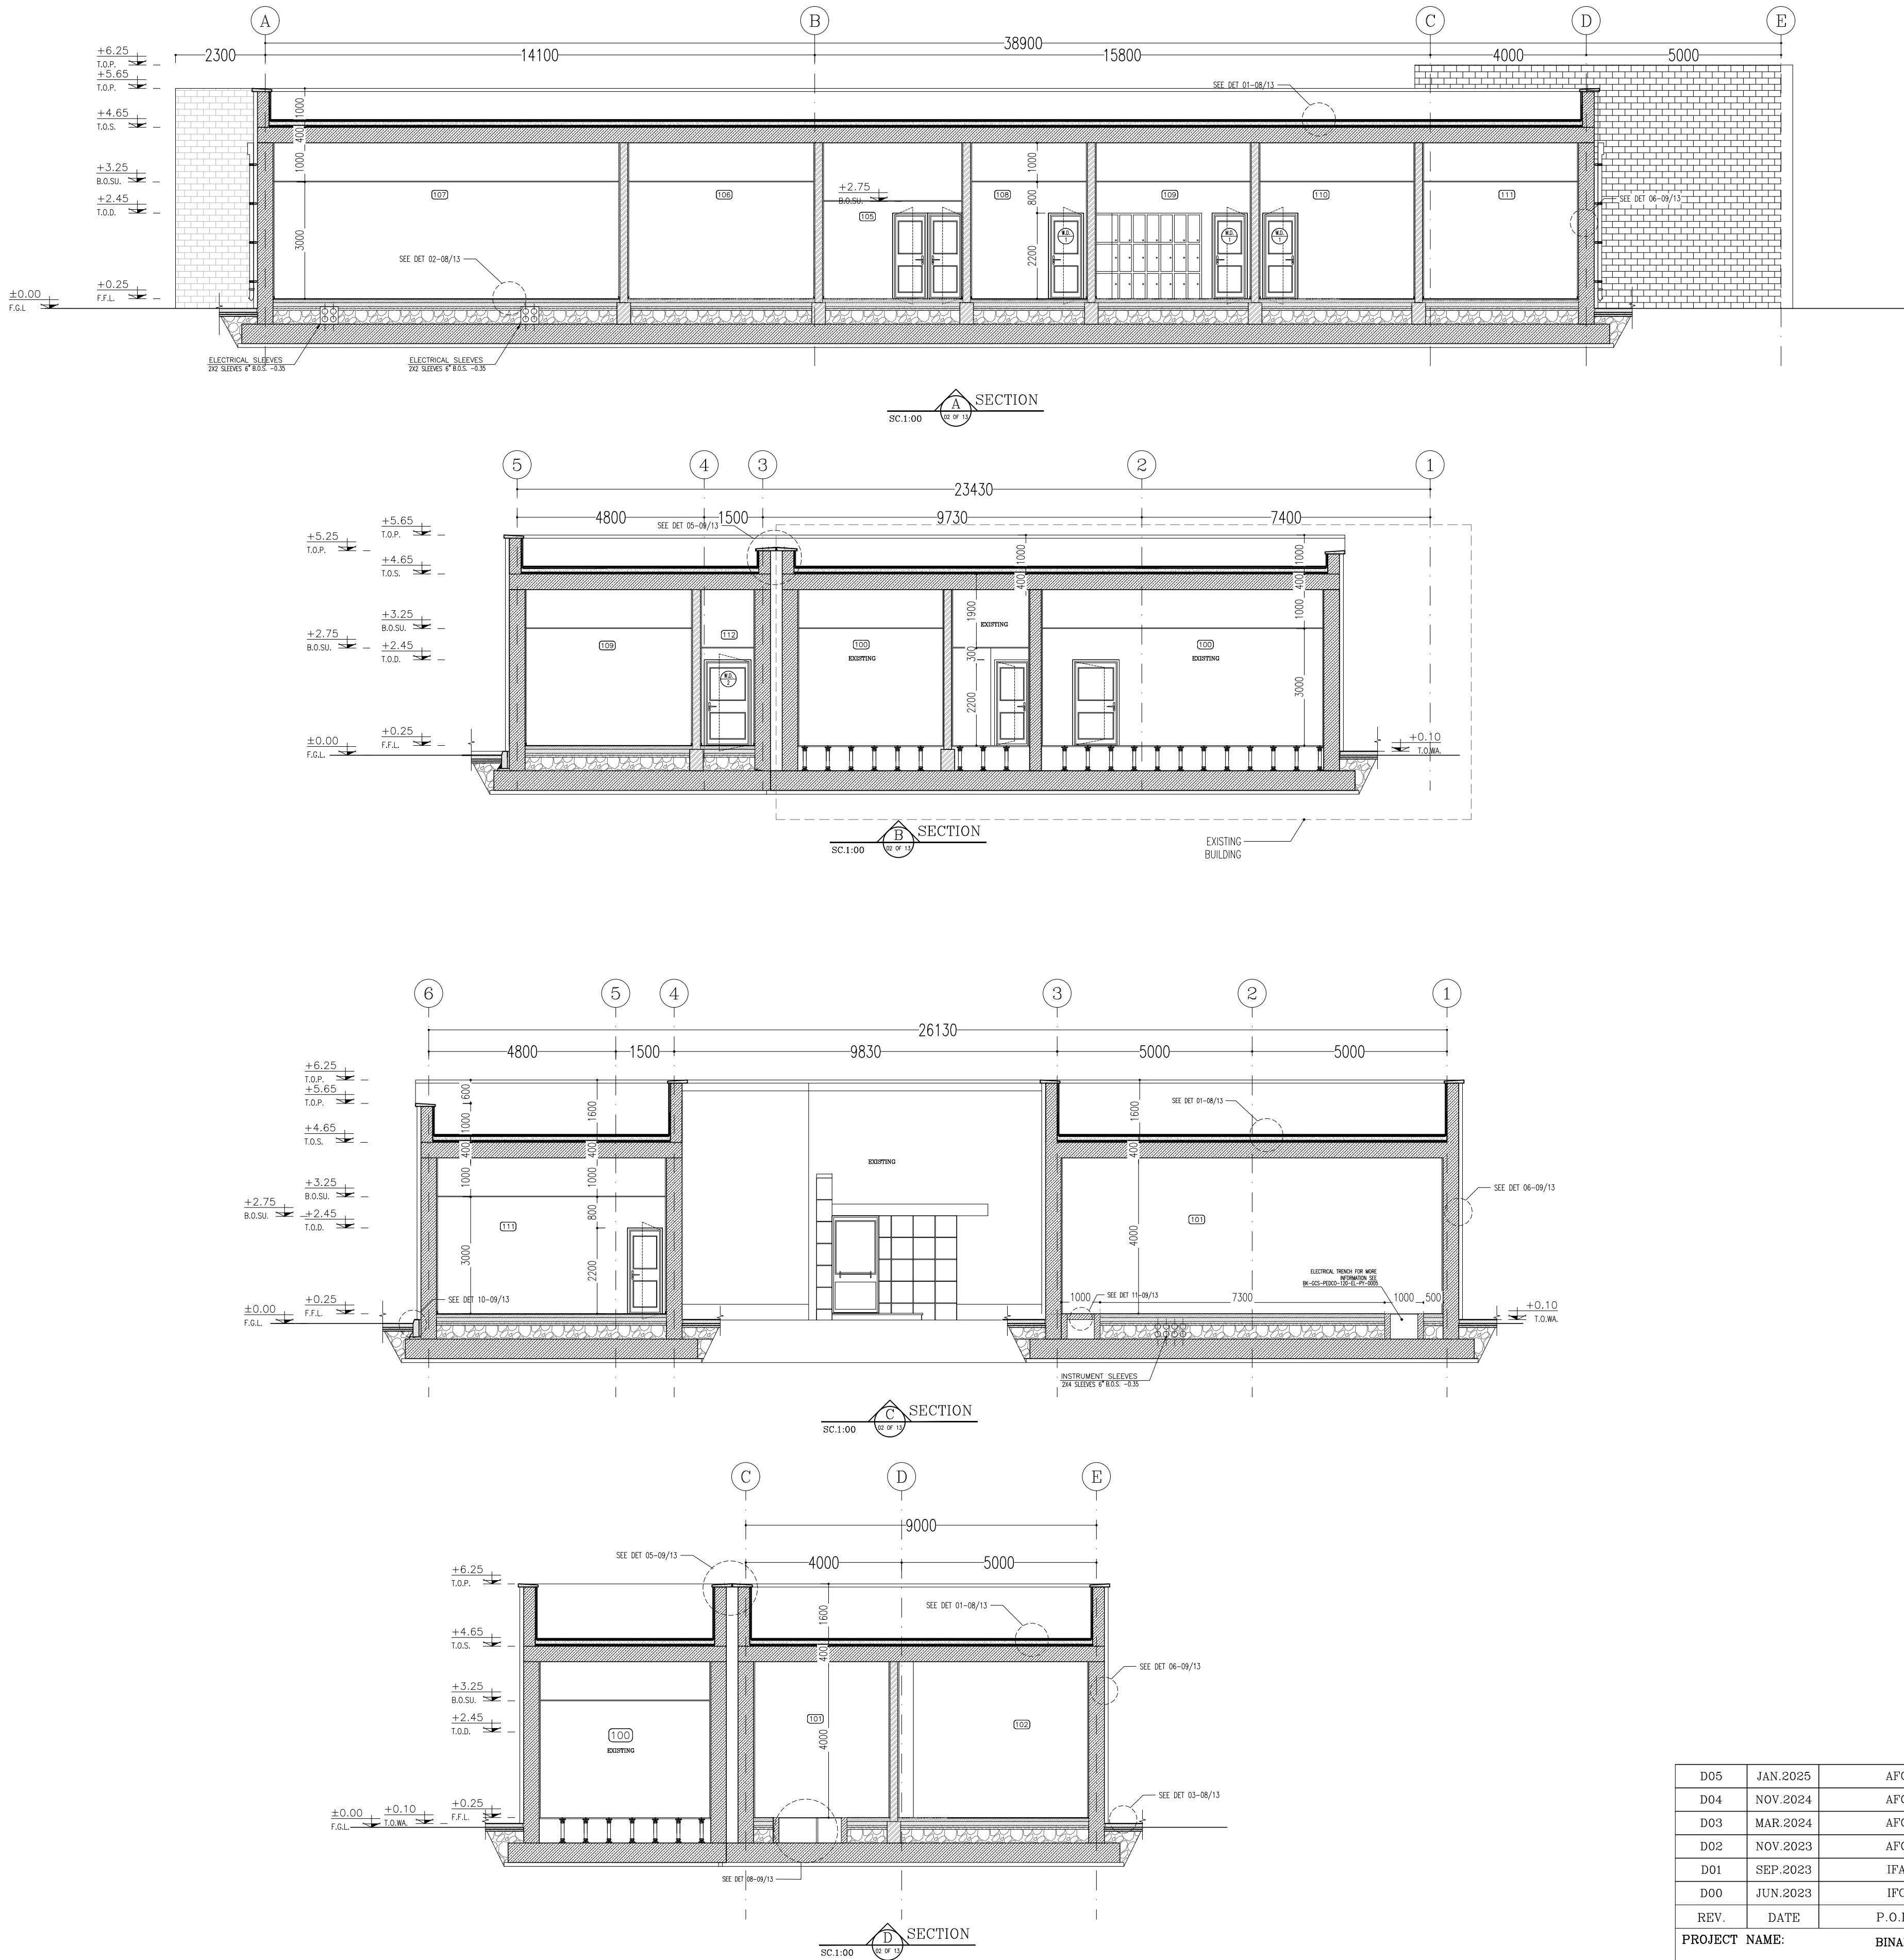

D05	JAN. 2025	AFC	R.BERLOUIE	M.FAKHARIAN	S.Faramarzpour	***
D04	NOV. 2024	AFC	R.BERLOUIE	M.FAKHARIAN	S.Faramarzpour	***
D03	MAR. 2024	AFC	R.BERLOUIE	M.FAKHARIAN	S.Faramarzpour	***
D02	NOV. 2023	AFC	R.BERLOUIE	M.FAKHARIAN	S.Faramarzpour	***
D01	SEP. 2023	IFA	R.BERLOUIE	M.FAKHARIAN	A.M.MOHSENI	***
D00	JUN. 2023	IPC	R.BERLOUIE	M.FAKHARIAN	A.M.MOHSENI	***
REV.	DATE	P.O.I.S	PREP.	CHK.	APP.	AUT.
PROJECT NAME: BINAK OILFIELD DEVELOPMENT/SURFACE FACILITIES GAS COMPRESSOR STATION						
PROJECT NO.:			971020			
EPC CONTRACTOR:			EPD/EPC CONTRACTOR (GC):			
 HIRGAN ENERGY – DESIGN & INSPECTION COMPANIES			 PETROIRAN DEVELOPMENT COMPANY			
DRAWING TITLE:						
Architectural Detail Drawing For Extension of EXISTING Control Building SECTIONS						
SCALE	SIZE	DRAWING NO.			SHEET NO.	REV.
AS SHOWN	A1	BK-GCS-PEDCO-120-AR-DW-0011			07 OF 13	D05

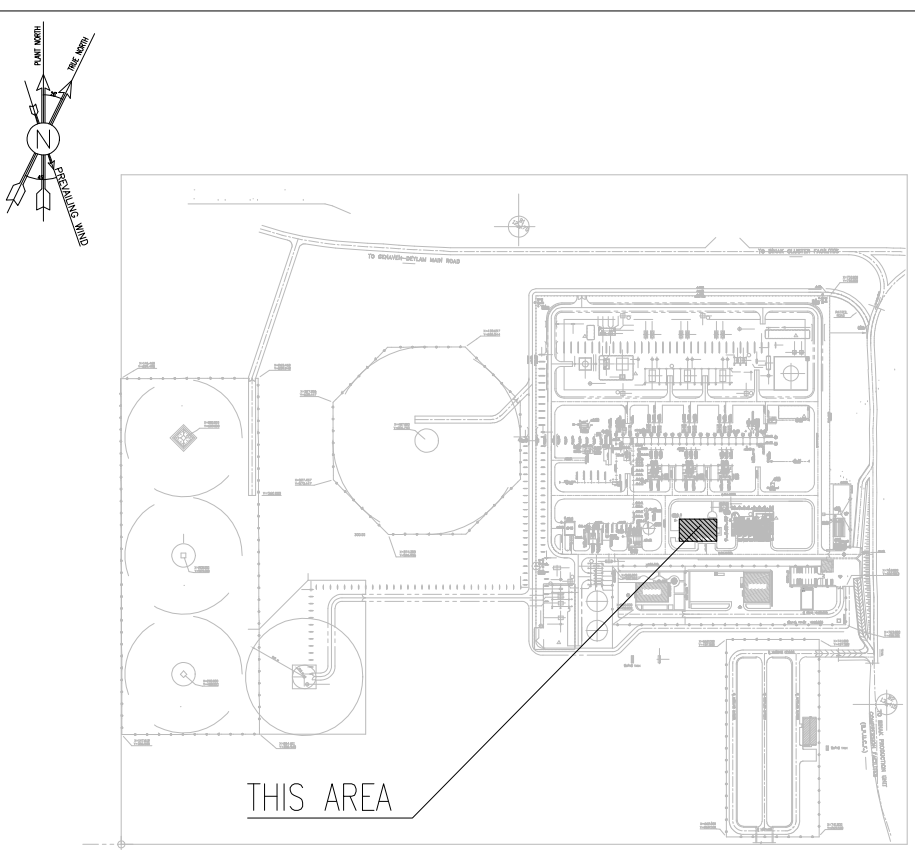
NOTES	
1. ALL DIMENSIONS ARE IN MILLIMETER & ALL ELEVATIONS ARE IN METER. 2. ALL DIMENSIONS AND ELEVATIONS SHALL BE CHECKED BY THE CONTRACTOR PRIOR TO CONSTRUCTION. 3. CONTRACTOR SHALL COMPARE ALL ARCHITECTURAL, MECHANICAL, ELECTRICAL, PIPING AND STRUCTURAL DRAWINGS AND IN CASE OF ANY CONFLICTS OR DISCREPANCY, INFORM THE ENGINEER. 4. ALL MATERIALS ARE SELECTED FROM THE HIGHEST QUALITY AND MUST BE APPROVED BY THE CLIENT. 5. ALL OPENINGS FOR PIPING/CABLING AND HVAC OPENINGS SHALL BE CONSIDERED AS PER RELATED DRAWINGS BEFORE CONSTRUCTION. 6. FINISH GRADING LEVEL (F.G.L.) : ± 0.00 (LOCAL) = 99.70	
LEGEND	
F.F.L.	FINISHED FLOOR LEVEL
T.O.W.A.	TOP OF WALKWAY
T.O.P.	TOP OF PARAPET
T.O.S.	TOP OF SLAB
T.O.D.	TOP OF DOOR
T.O.W.	TOP OF WINDOW
B.O.W.	BOTTOM OF WINDOW
T.O.C.	TOP OF CAGE
B.O.C.	BOTTOM OF CAGE
B.O.F.	BOTTOM OF FALSE FLOOR
B.O.SU.	BOTTOM OF SUSPENDED
B.O.S.	BOTTOM OF SLEEVE
H.P.G.	HIGH POINT GRAVEL
	BRICK WORK
	REINFORCED CONCRETE
	LEAN CONCRETE
	SAND CEMENT MORTAR
	BLOCKAGE
REFERENCE DRAWING	
DRG. No.	
STANDARD DRAWING FOR ARCHITECTURAL DETAILS	BK-GNRL-PEDCO-000-AR-DW-0001
SITE SEWAGE SYSTEM LAYOUT & DETAILS	BK-GCS-PEDCO-120-CV-PY-0001
CONTROL ROOM LAYOUT & ARRANGEMENT DRAWING	BK-GCS-PEDCO-120-IN-PY-0001
ROAD, PAVING AND PLANT FINISH GRADING LAYOUT & SECTIONS	BK-GCS-PEDCO-120-CV-PY-0005
ELECTRICAL CABLE ROUTE & SECTION LAYOUT FOR BUILDING & SHELTER	BK-GCS-PEDCO-120-EL-PY-0006
FOUNDATION DRAWING FOR EXTENSION OF CONTROL BUILDING	BK-GNRL-PEDCO-220-ST-DW-0004
STRUCTURAL DRAWING FOR EXTENSION OF CONTROL BUILDING	BK-GNRL-PEDCO-220-ST-DW-0005
STANDARD DETAILS FOR LADDER & SAFETY CAGE	BK-GNRL-PEDCO-000-ST-DW-0009
AREA ELECTRICAL CABLE ROUTE & SECTION LAYOUT	BK-GCS-PEDCO-120-EL-PY-0005
UNIT FLY PLAN DRAWING	BK-PPL-PEDCO-120-PI-PY-0001
CONTROL ROOM CABLE ROUTE LAYOUT	BK-GCS-PEDCO-120-IN-PY-0002
INSTRUMENT/P&G CABLE TRENCH/ROUTE LAYOUT DRAWING	BK-GCS-PEDCO-120-IN-PY-0004
ELECTRICAL EQUIPMENT ARRANGEMENT LAYOUT FOR BUILDING	BK-GCS-PEDCO-120-EL-PY-0008
KEY PLAN	
	
THIS AREA	
REV.	DESCRIPTION
BY	DATE
CHECKED	REV. APPR.
اسل و کلیه نسخ این نقشه و حق اقتباس متعلق به شرکت ملی مناطق نفت خیز جنوب میباشد.	
THE ORIGINAL AND ALL COPIES OF THIS DRAWING TOGETHER WITH THE COPYRIGHT THEREIN ARE THE SOLE PROPERTY OF N.I.S.O.C./ FIELDS	
BINAK OILFIELD DEVELOPMENT SURFACE FACILITIES GAS COMPRESSOR STATION	
DATE	SCALE
DRAWING BY	CHECKED BY
PROJECT ENG.	
NO CONSTRUCTION PERMITTED UNLESS DRAWING APPROVED	
APPROVED FOR CONSTRUCTION	BY:
DATE:	
BUDGET REF.	LOCATION
SIZE CLASS	SERIAL NO.
SHEET	REVISION
053-073-9184	F 4 B 709518 07 OF 13 D05

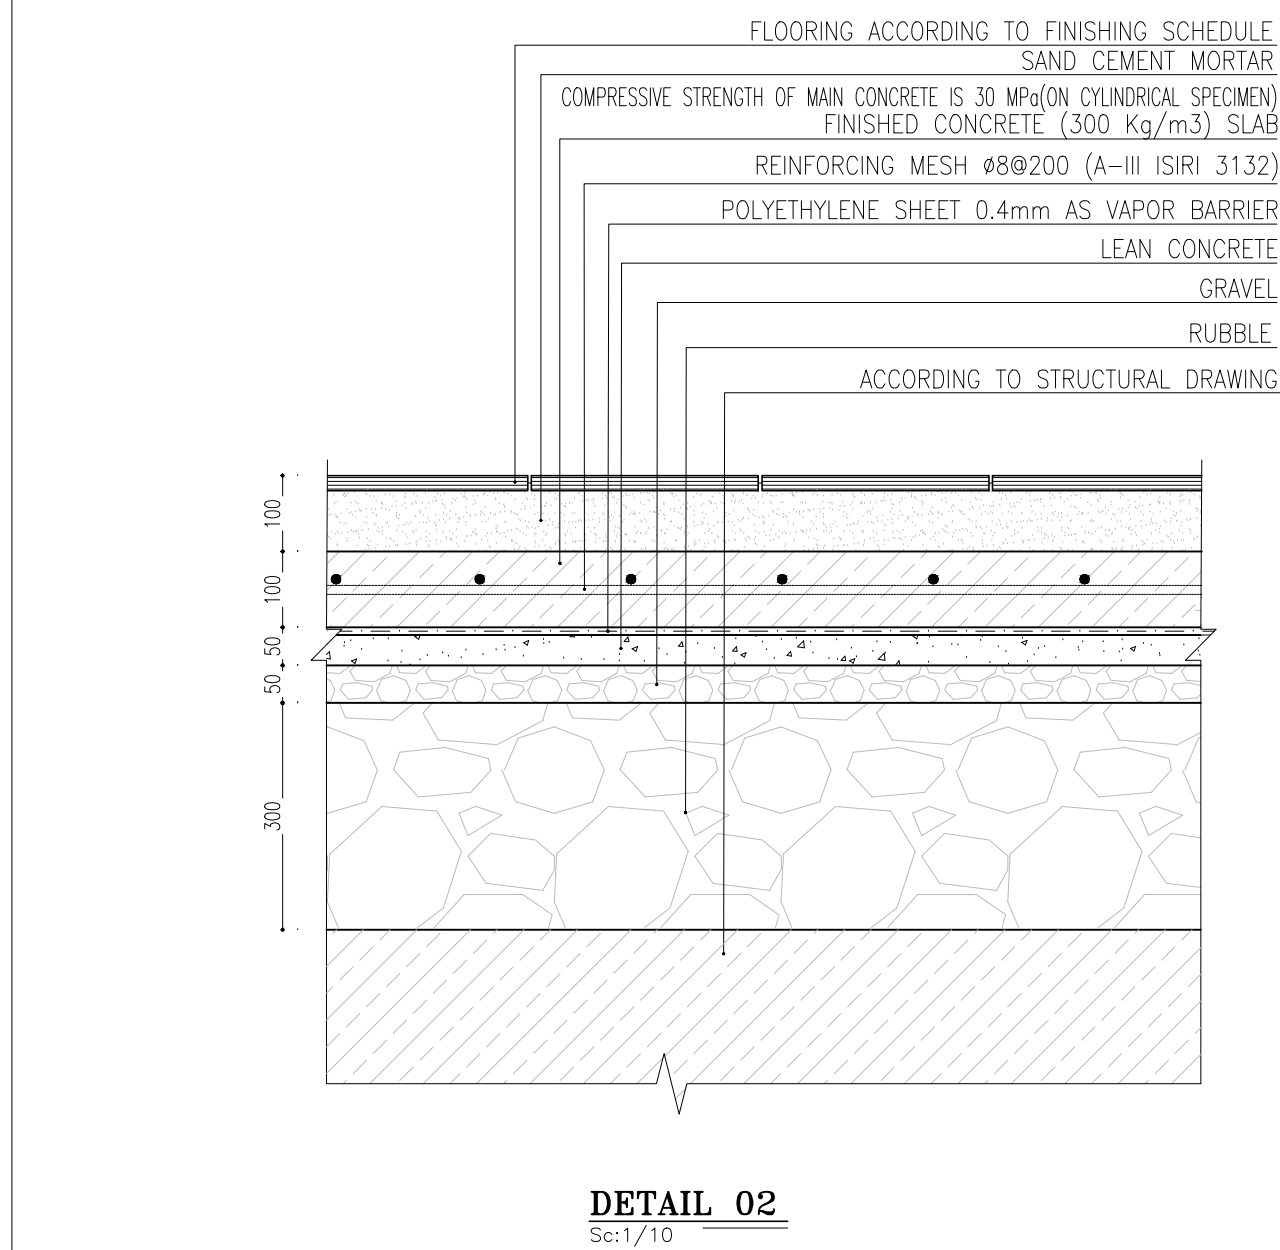

Sc:1/10

6 FINISHING SCHEDULE

 INTEL PLAN -2 IPE TYP. SECTION 1-1
 Sec: N.T.S. Sec: 1:10



PROJECT NAME:	BINAK OILFIELD DEVELOPMENT/SURFACE FACILITIES GAS COMPRESSOR STATION
---------------	---

EPC CONTRACTOR:   HIRGAN ENERGY – DESIGN & INSPECTION COMPANIES	EPD/EPC CONTRACTOR (GC):   PETROIRAN DEVELOPMENT COMPANY
---	--

SCALE	SIZE	DRAWING NO.	SHEET NO.	REV.
-------	------	-------------	-----------	------


AS SHOWN	A1	BK-GCS-PEDCO-120-AR-DW-0011	08 OF 13	D05
----------	----	-----------------------------	----------	-----

	BRICK WORK
	REINFORCED CONCRETE
	LEAN CONCRETE
	SAND CEMENT MORTAR
	GRAVEL
	RUBBLE

REFERENCE DRAWING	DRG. No.
STANDARD DRAWING FOR ARCHITECTURAL DETAILS	BK-GN-RL-PEDCO-000-AR-DW-0001
SITE SEWAGE SYSTEM LAYOUT & DETAILS	BK-GCS-PDCO-120-CV-PY-0001
CONTROL ROOM LAYOUT & ARRANGEMENT DRAWING	BK-GCS-PDCO-120-IN-PY-0001
ROAD, PAVING AND PLANT FINISH GRADING LAYOUT & SECTIONS	BK-GCS-PDCO-120-CV-PY-0005
ELECTRICAL CABLE ROUTE & SECTION LAYOUT FOR BUILDING & SHELTER	BK-GCS-PDCO-120-EL-PY-0006
FOUNDATION DRAWING FOR EXTENSION OF CONTROL BUILDING	BK-GN-RL-PEDCO-220-ST-DW-0004
STRUCTURAL DRAWING FOR EXTENSION OF CONTROL BUILDING	BK-GN-RL-PEDCO-220-ST-DW-0005
STANDARD DETAILS FOR LADDER & SAFETY CAGE	BK-GN-RL-PEDCO-000-ST-DW-0009
AREA ELECTRICAL CABLE ROUTE & SECTION LAYOUT	BK-GCS-PDCO-120-EL-PY-0005
UNIT PLOT PLAN DRAWING	BK-FPL-PEDCO-120-PI-PY-0001
CONTROL ROOM CABLE ROUTE LAYOUT	BK-GCS-PDCO-120-IN-PY-0002
INSTRUMENT, F&S CABLE TRENCH/ROUTE LAYOUT DRAWING	BK-GCS-PDCO-120-IN-PY-0004
ELECTRICAL EQUIPMENT ARRANGEMENT LAYOUT FOR BUILDING	BK-GCS-PDCO-120-EL-PY-0006



 
اصل و کلیه نسخ این نقشه و حق اقتباس متعلق به شرکت ملی مناطق نفت خیز جنوب میباشد.




DATE	SCALE	DRAWING BY	CHECKED BY	PROJECT ENG.

BUDGET REF.	LOCATION	SIZE	CLASS	SERIAL NO.	SHEET	REVISION
-------------	----------	------	-------	------------	-------	----------


053-073-9184	F	4	B	709518	08 OF 13	D05
--------------	---	---	---	--------	----------	-----

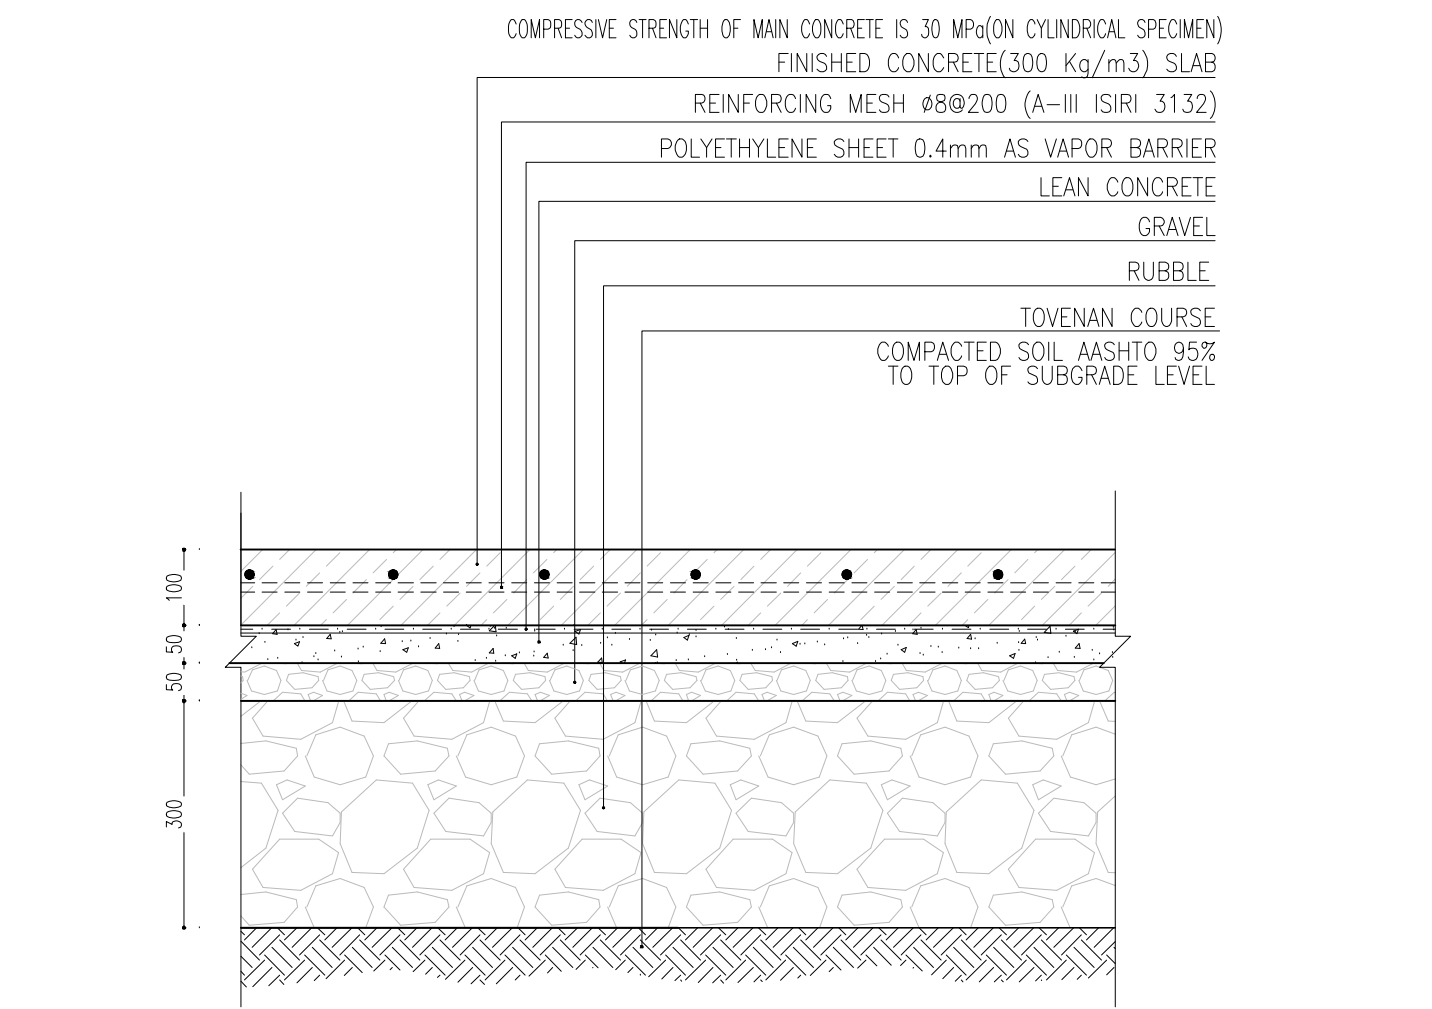


DETAIL 03
Sc:1/10

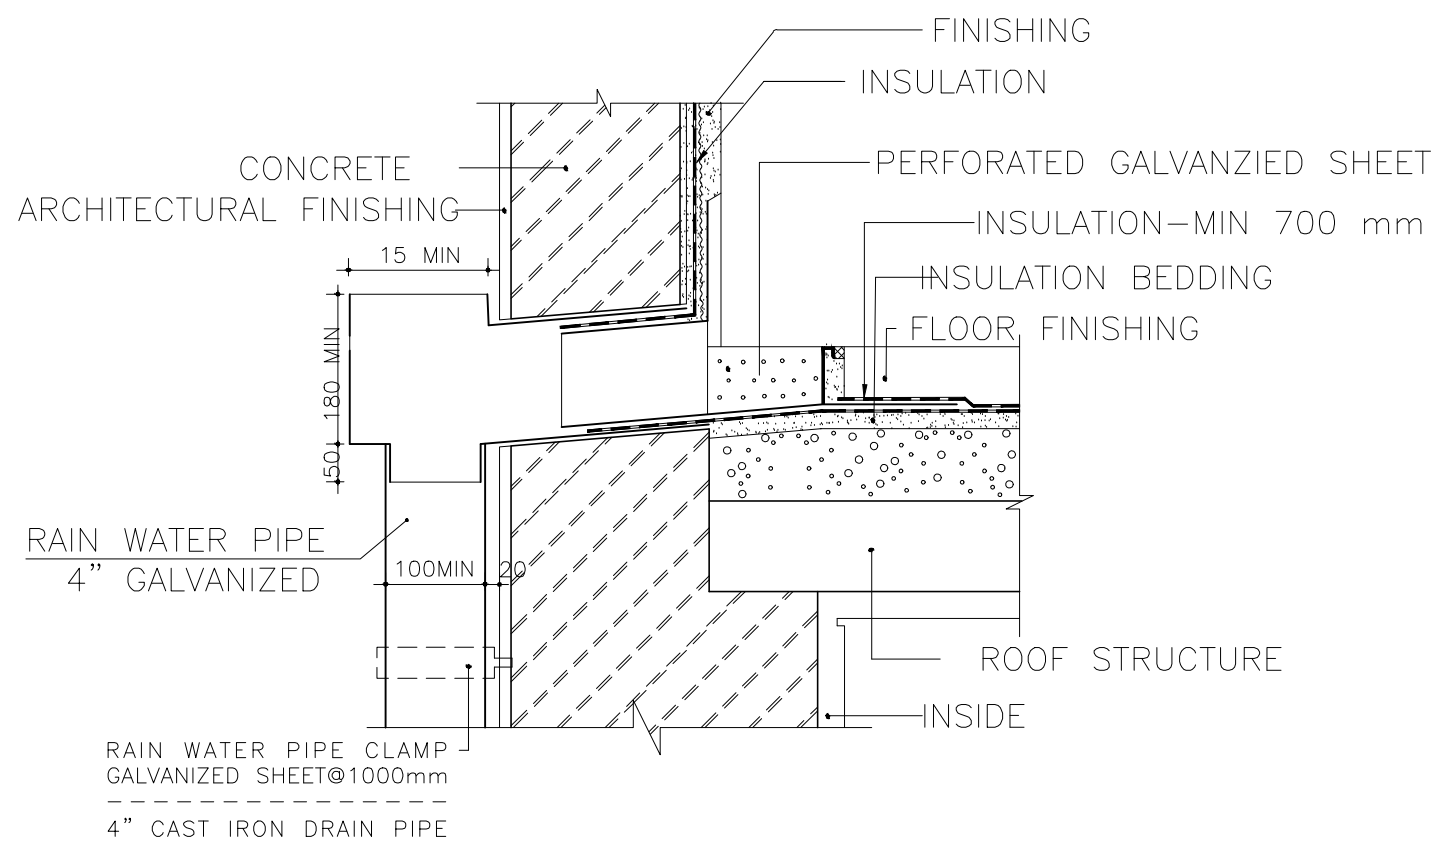


DETAIL 04 (RAIN WATER DISPOSAL DETAIL)
Sc:1/10

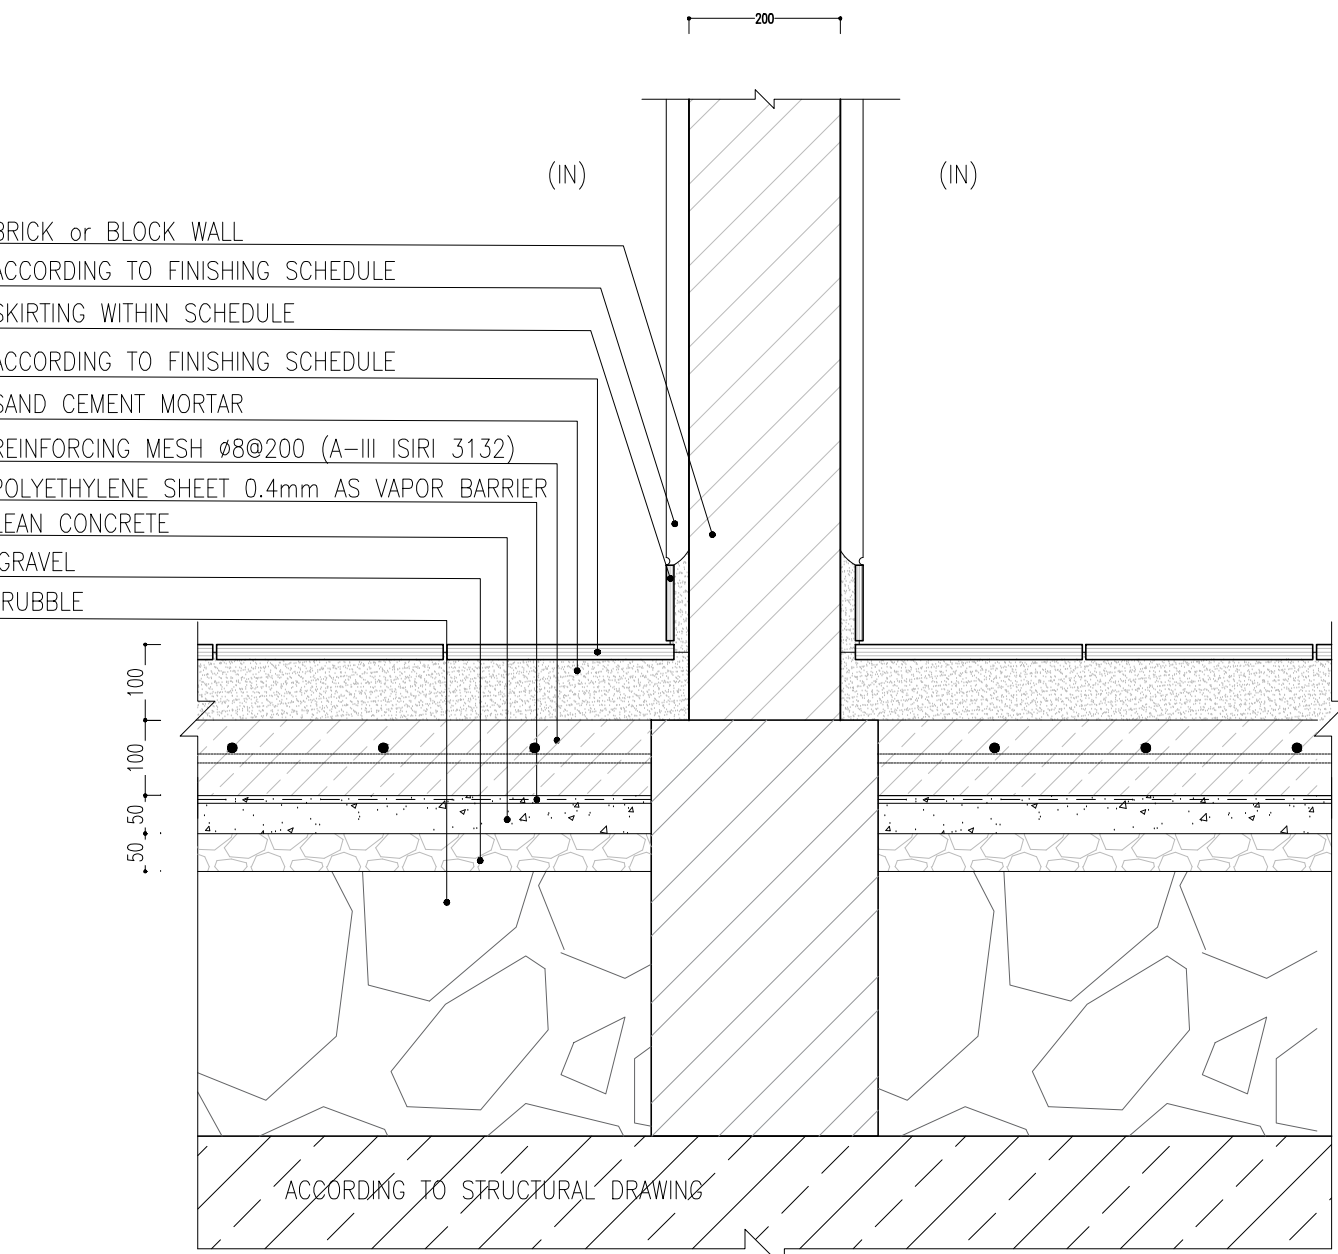


DETAIL 07
Sc:1/10

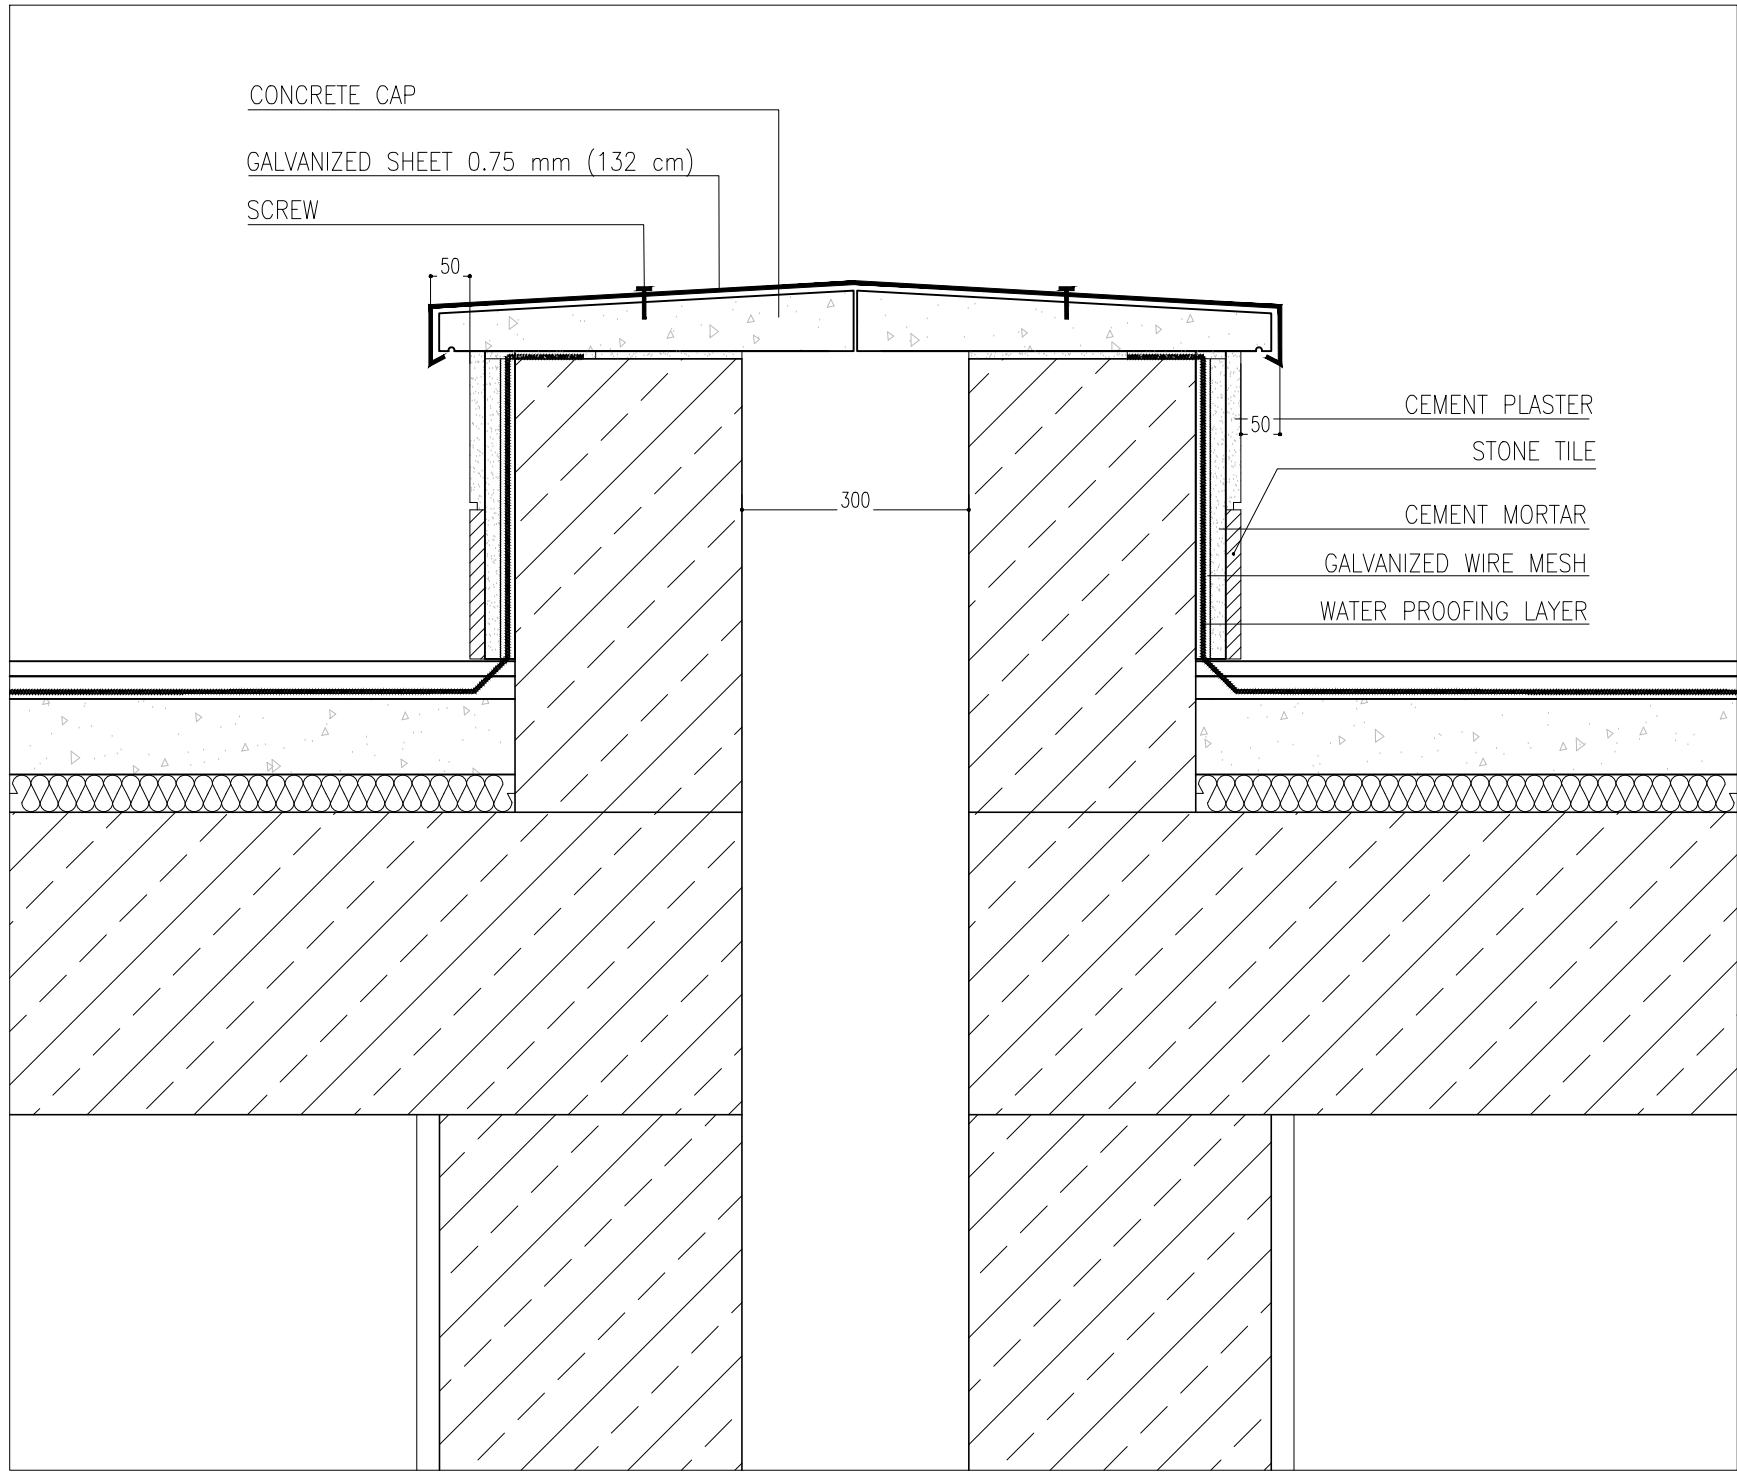


DETAIL 05
Sc:1/10

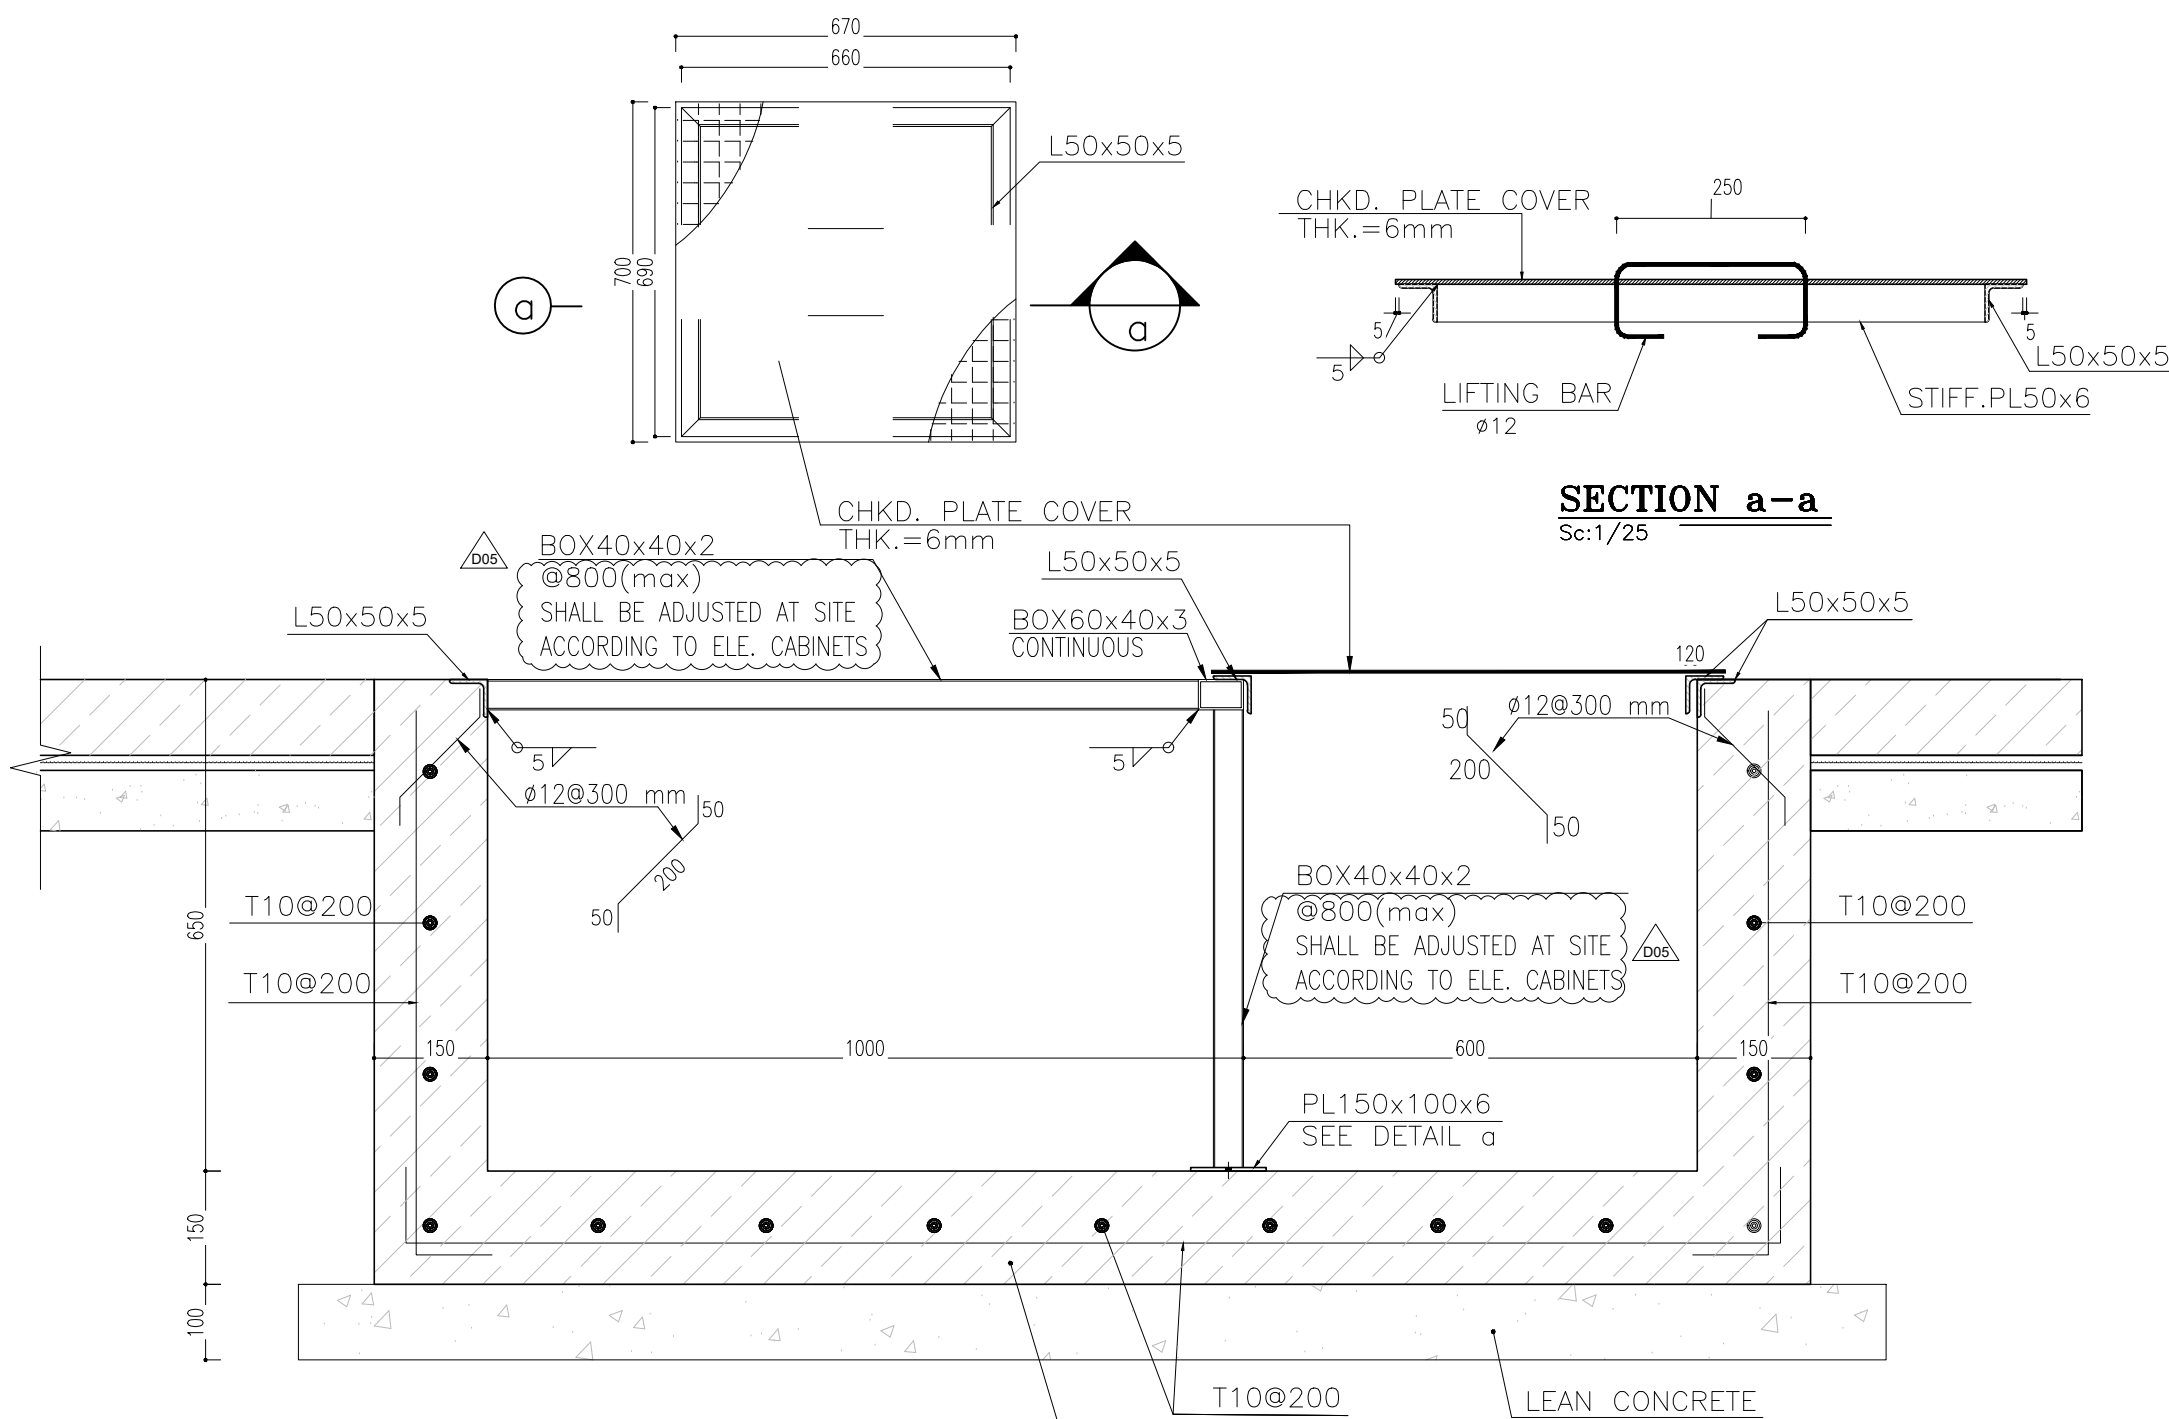


DETAIL 08
Sc:1/10

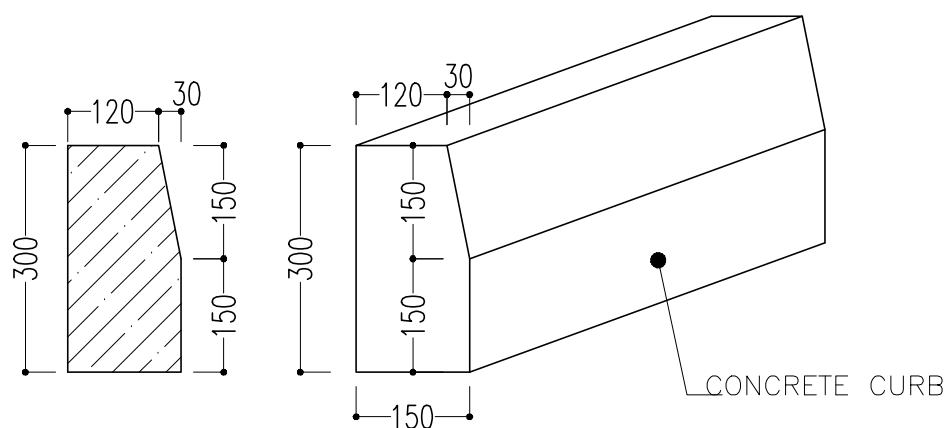


DETAIL 10 CONCRETE CURB
Sc:1/10

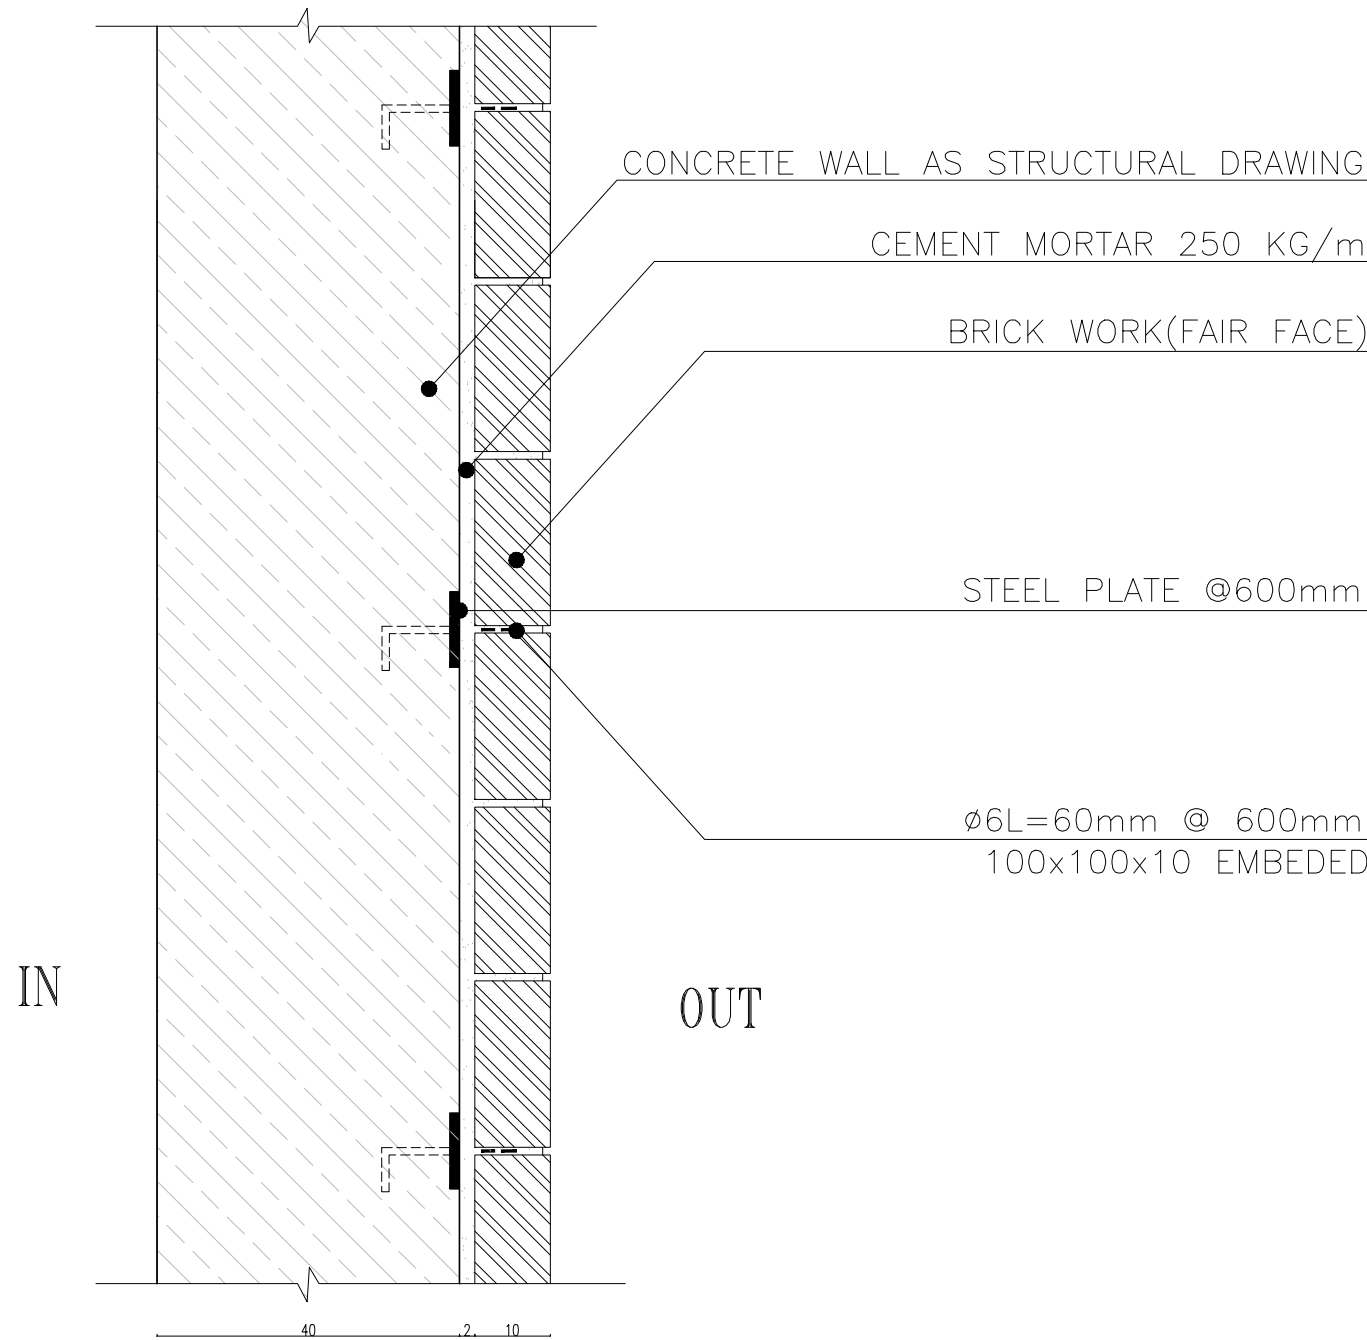

DETAIL 06 (CONNECTING BRICK FACE TO CONCRETE WALL)
Sc:1/10

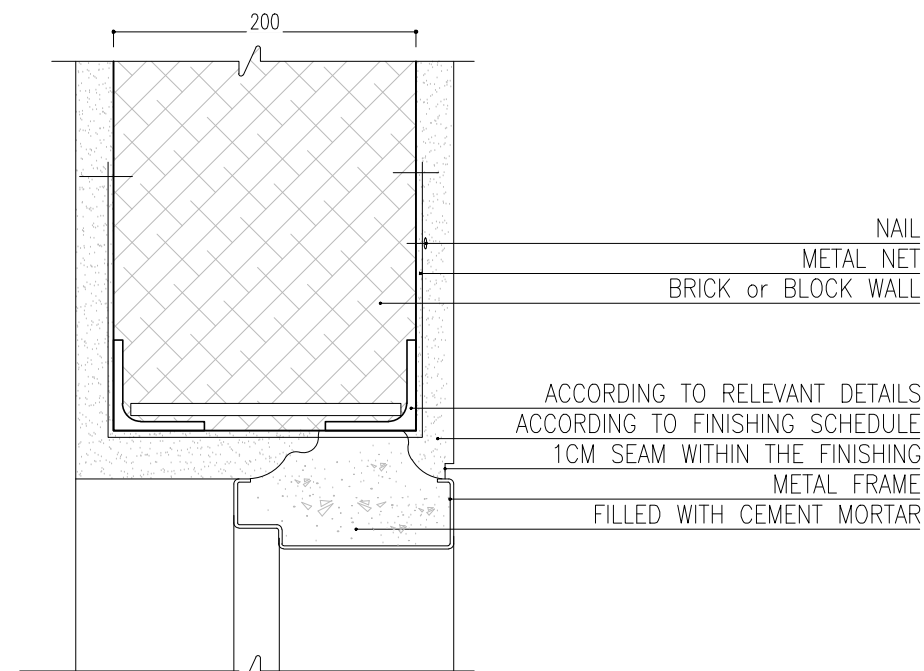

DETAIL 09
Sc:1/5

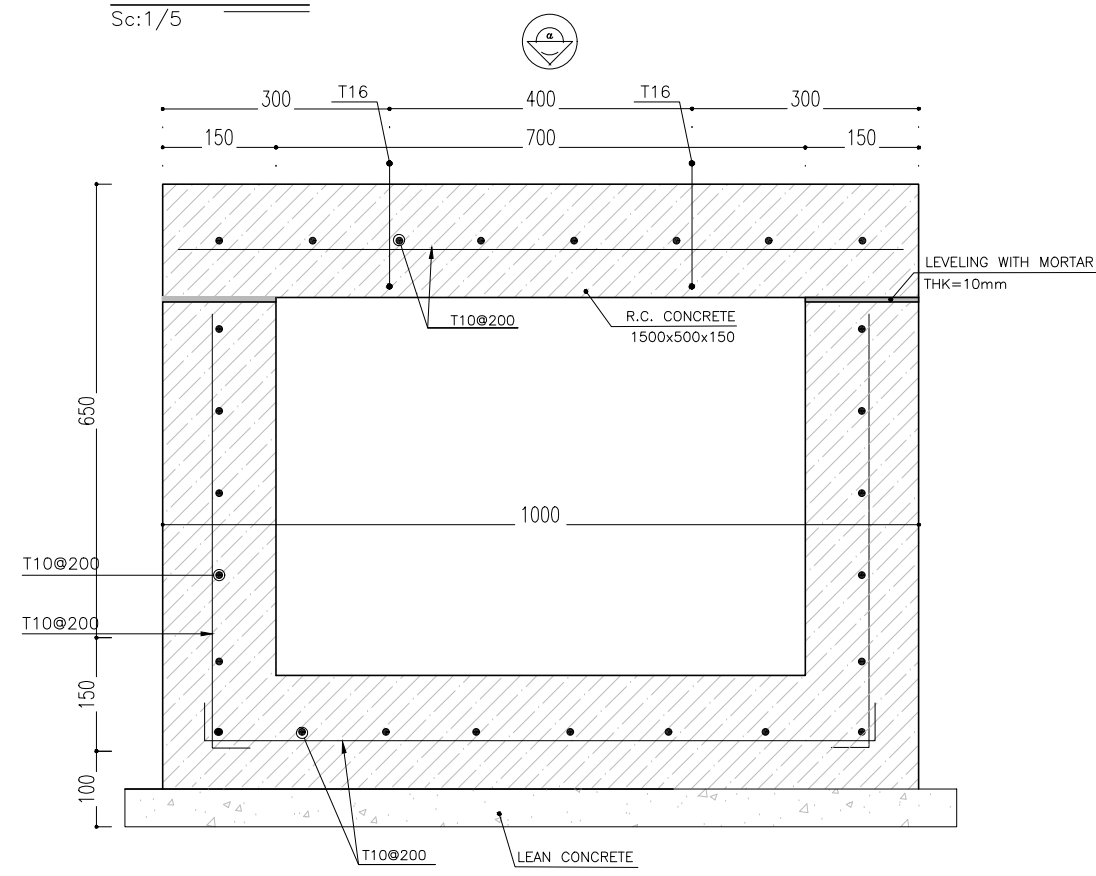

DETAIL 11
Sc:1/10

D05	JAN.2025	AFC	R.BERLOUIE	M.FAKHARIAN	S.Paramarzpour	***
D04	NOV.2024	AFC	R.BERLOUIE	M.FAKHARIAN	S.Paramarzpour	***
D03	MAR.2024	AFC	R.BERLOUIE	M.FAKHARIAN	S.Paramarzpour	***
D02	NOV.2023	AFC	R.BERLOUIE	M.FAKHARIAN	S.Paramarzpour	***
D01	SEP.2023	IFA	R.BERLOUIE	M.FAKHARIAN	A.M.MOHSSENI	***
D00	JUN.2023	IPC	R.BERLOUIE	M.FAKHARIAN	A.M.MOHSSENI	***
REV.	DATE	P.O.I.S	PREP.	CHK.	APP.	AUT.

PROJECT NAME: BINAK OILFIELD DEVELOPMENT/SURFACE FACILITIES GAS COMPRESSOR STATION

PROJECT NO.: 971020

EPC CONTRACTOR:	EPD/EPC CONTRACTOR (GC):
 HIRGAN ENERGY – DESIGN & INSPECTION COMPANIES	 PETROIRAN DEVELOPMENT COMPANY

DRAWING TITLE: Architectural Detail Drawing For Extension of EXISTING Control Building DETAILS


SCALE	SIZE	DRAWING NO.	SHEET NO.	REV.
AS SHOWN	A1	BK-GCS-PEDCO-120-AR-DW-0011	09 OF 13	D05

NOTES					
1. ALL DIMENSIONS ARE IN MILLIMETER & ALL ELEVATIONS ARE IN METER.					
2. ALL DIMENSIONS AND ELEVATIONS SHALL BE CHECKED BY THE CONTRACTOR PRIOR TO CONSTRUCTION.					
3. CONTRACTOR SHALL COMPARE ALL ARCHITECTURAL, MECHANICAL, ELECTRICAL, PIPING AND STRUCTURAL DRAWINGS AND IN CASE OF ANY CONFLICTS OR DISCREPANCY, INFORM THE ENGINEER.					
4. ALL MATERIALS ARE SELECTED FROM THE HIGHEST QUALITY AND MUST BE APPROVED BY THE CLIENT.					
5. ALL OPENINGS FOR PIPING/CABLING AND HVAC OPENINGS SHALL BE CONSIDERED AS PER RELATED DRAWINGS BEFORE CONSTRUCTION.					
6. FINISH GRADING LEVEL (F.G.L.) : ±0.00 (LOCAL) = 99.70					

LEGEND					
--------	--	--	--	--	--

REFERENCE DRAWING	DRG. No.
STANDARD DRAWING FOR ARCHITECTURAL DETAILS	BK-GNRL-PEDCO-000-AR-DW-0001
SITE SEWAGE SYSTEM LAYOUT & DETAILS	BK-GCS-PEDCO-120-CY-PY-0001
CONTROL ROOM LAYOUT & ARRANGEMENT DRAWING	BK-GCS-PEDCO-120-IN-PY-0001
ROAD, PAVING AND PLANT FINISH GRADING LAYOUT & SECTIONS	BK-GCS-PEDCO-120-CY-PY-0005
ELECTRICAL CABLE ROUTE & SECTION LAYOUT FOR BUILDING & SHELTER	BK-GCS-PEDCO-120-EL-PY-0006
FOUNDATION DRAWING FOR EXTENSION OF CONTROL BUILDING	BK-GNRL-PEDCO-220-ST-DW-0004
STRUCTURAL DRAWING FOR EXTENSION OF CONTROL BUILDING	BK-GNRL-PEDCO-220-ST-DW-0005
STANDARD DETAILS FOR LADDER & SAFETY CAGE	BK-GNRL-PEDCO-000-ST-DW-0009
AREA ELECTRICAL CABLE ROUTE & SECTION LAYOUT	BK-GCS-PEDCO-120-EL-PY-0005
UNIT PLOT PLAN DRAWING	BK-PPL-PEDCO-120-PI-PY-0001
CONTROL ROOM CABLE ROUTE LAYOUT	BK-GCS-PEDCO-120-IN-PY-0002
INSTRUMENT/PAG CABLE TRENCH/ROUTE LAYOUT DRAWING	BK-GCS-PEDCO-120-IN-PY-0004
ELECTRICAL EQUIPMENT ARRANGEMENT LAYOUT FOR BUILDING	BK-GCS-PEDCO-120-EL-PY-0008

KEY PLAN					
----------	--	--	--	--	--

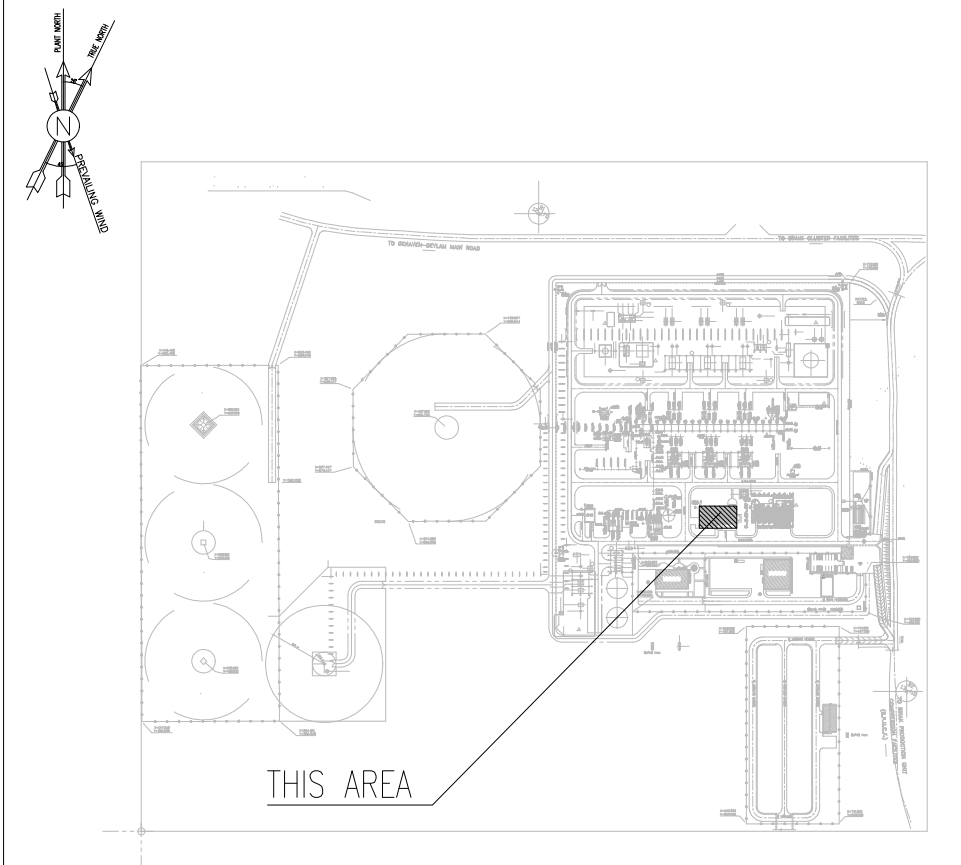

REV.	DESCRIPTION	BY	DATE	BY	DATE
***	*****	***	*****	***	*****

اسل و کله نسخ این نقشه و حق اقتباس متعلق به شرکت ملی مناطق نفت خیز جنوب میباشد.
THE ORIGINAL AND ALL COPIES OF THIS DRAWING TOGETHER WITH THE COPYRIGHT THEREIN ARE THE SOLE PROPERTY OF N.I.S.O.C./ FIELDS




BINAK OILFIELD DEVELOPMENT SURFACE FACILITIES GAS COMPRESSOR STATION					
DATE	SCALE	DRAWING BY	CHECKED BY	PROJECT ENG.	

NO CONSTRUCTION PERMITTED UNLESS DRAWING APPROVED					
---	--	--	--	--	--

APPROVED FOR CONSTRUCTION			BY:	DATE:
BUDGET REF.	LOCATION	SIZE CLASS	SERIAL NO.	SHEET REVISION
053-073-9184	F	4	B	709518 09 OF 13 D05

NOTES	
1.	ALL DIMENSIONS ARE IN MILLIMETER & ALL ELEVATIONS ARE IN METER.
2.	ALL DIMENSIONS AND ELEVATIONS SHALL BE CHECKED BY THE CONTRACTOR PRIOR TO CONSTRUCTION.
3.	CONTRACTOR SHALL COMPILE ALL ARCHITECTURAL, MECHANICAL, ELECTRICAL, PIPING AND STRUCTURAL DRAWINGS AND IN CASE OF ANY CONFLICTS OR DISCREPANCY, INFORM THE ENGINEER.
4.	ALL MATERIALS ARE SELECTED FROM THE HIGHEST QUALITY AND MUST BE APPROVED BY THE CLIENT.
5.	OPENINGS FOR PIPING/CABLES AND HVAC GROWTHS SHALL BE CONSIDERED AS PER RELATED DRAWINGS BEFORE CONSTRUCTION.
6.	FINISH GRADING LEVEL (F.G.L.) = ±0.00 (LOCAL) = 99.70

LEGEND

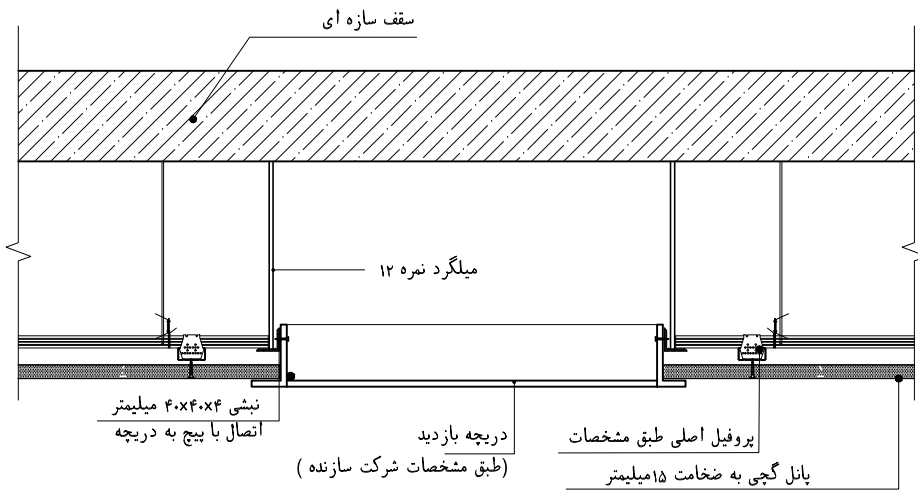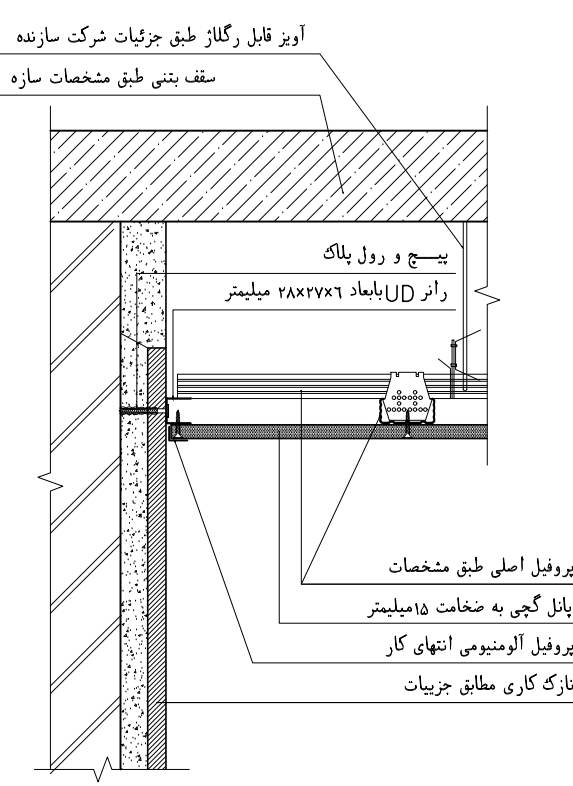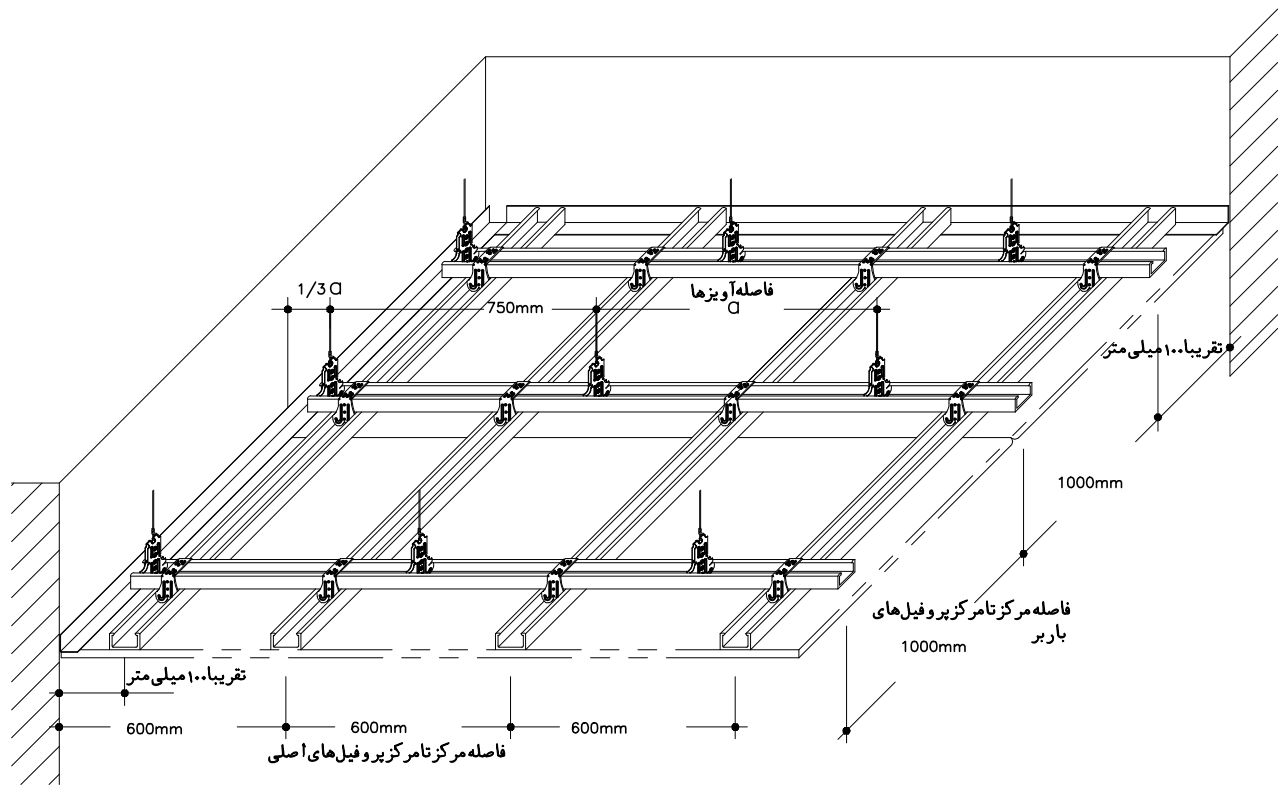

* ابعاد دریچه بازدید = ابعاد فن کوئل + ۳۰ سانتیمتر از هر طرف

جزئیات سقف کاذب (در محل دریچه بازدید)

کلبه فن کوئل ها دارای دریچه باز دید به فن کوئل میباشد.

DETAIL 11




Sc:N.T.S.

DETAIL 11


Sc:N.T.S.

DETAIL 11


Sc:1/20

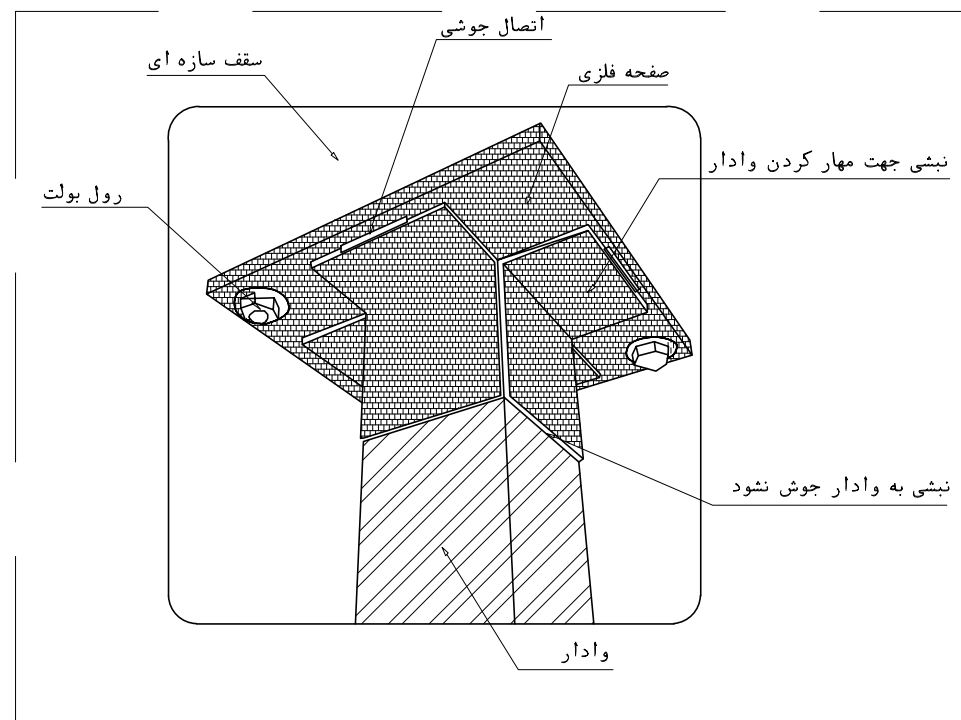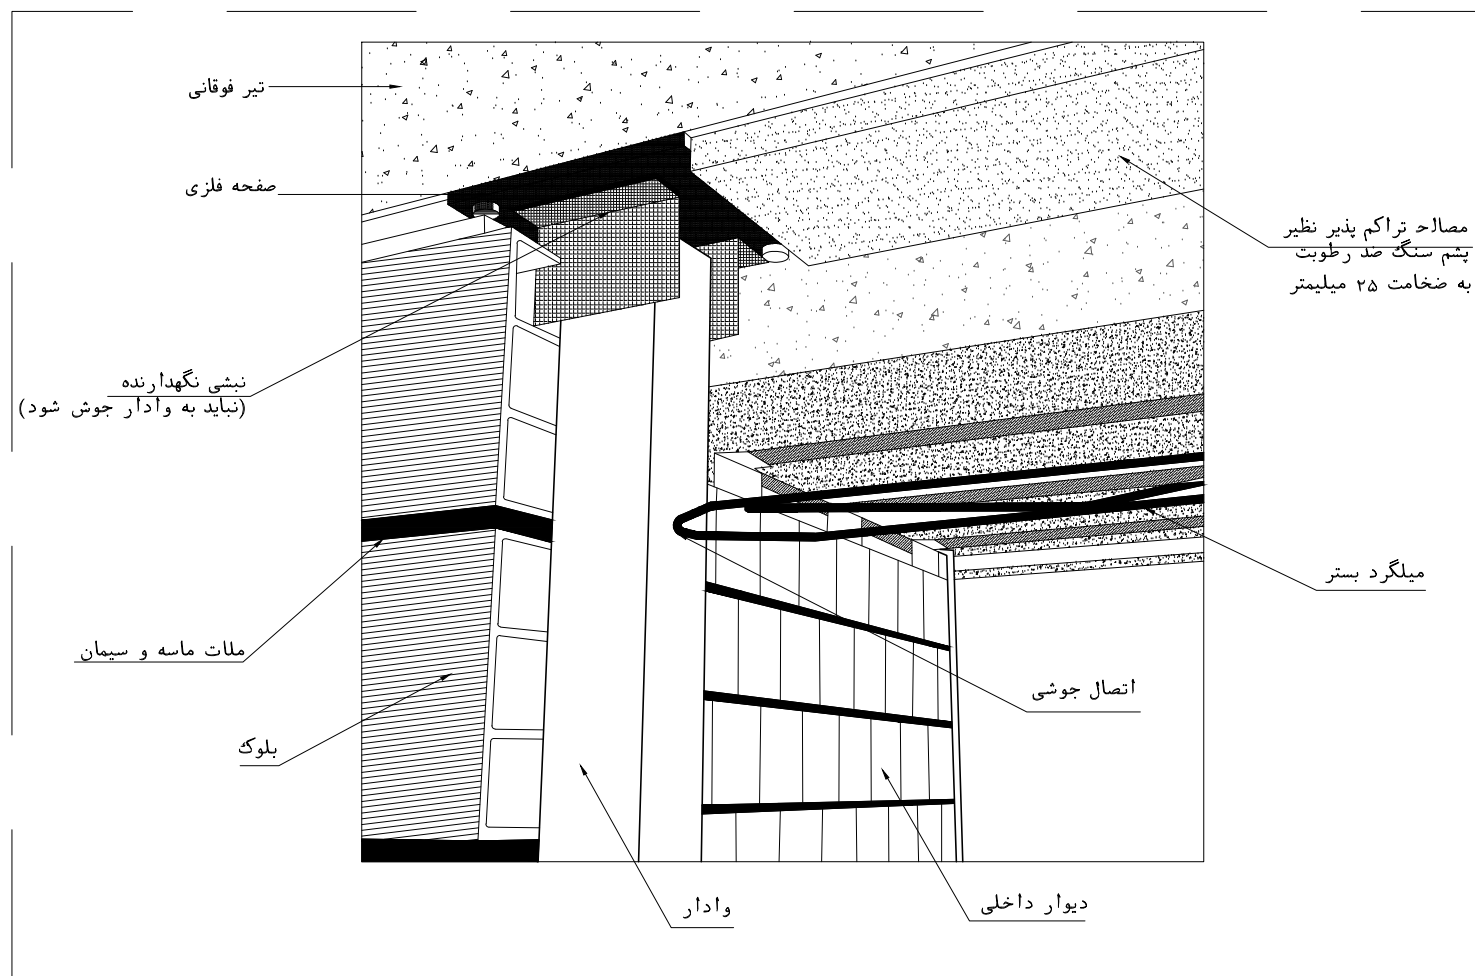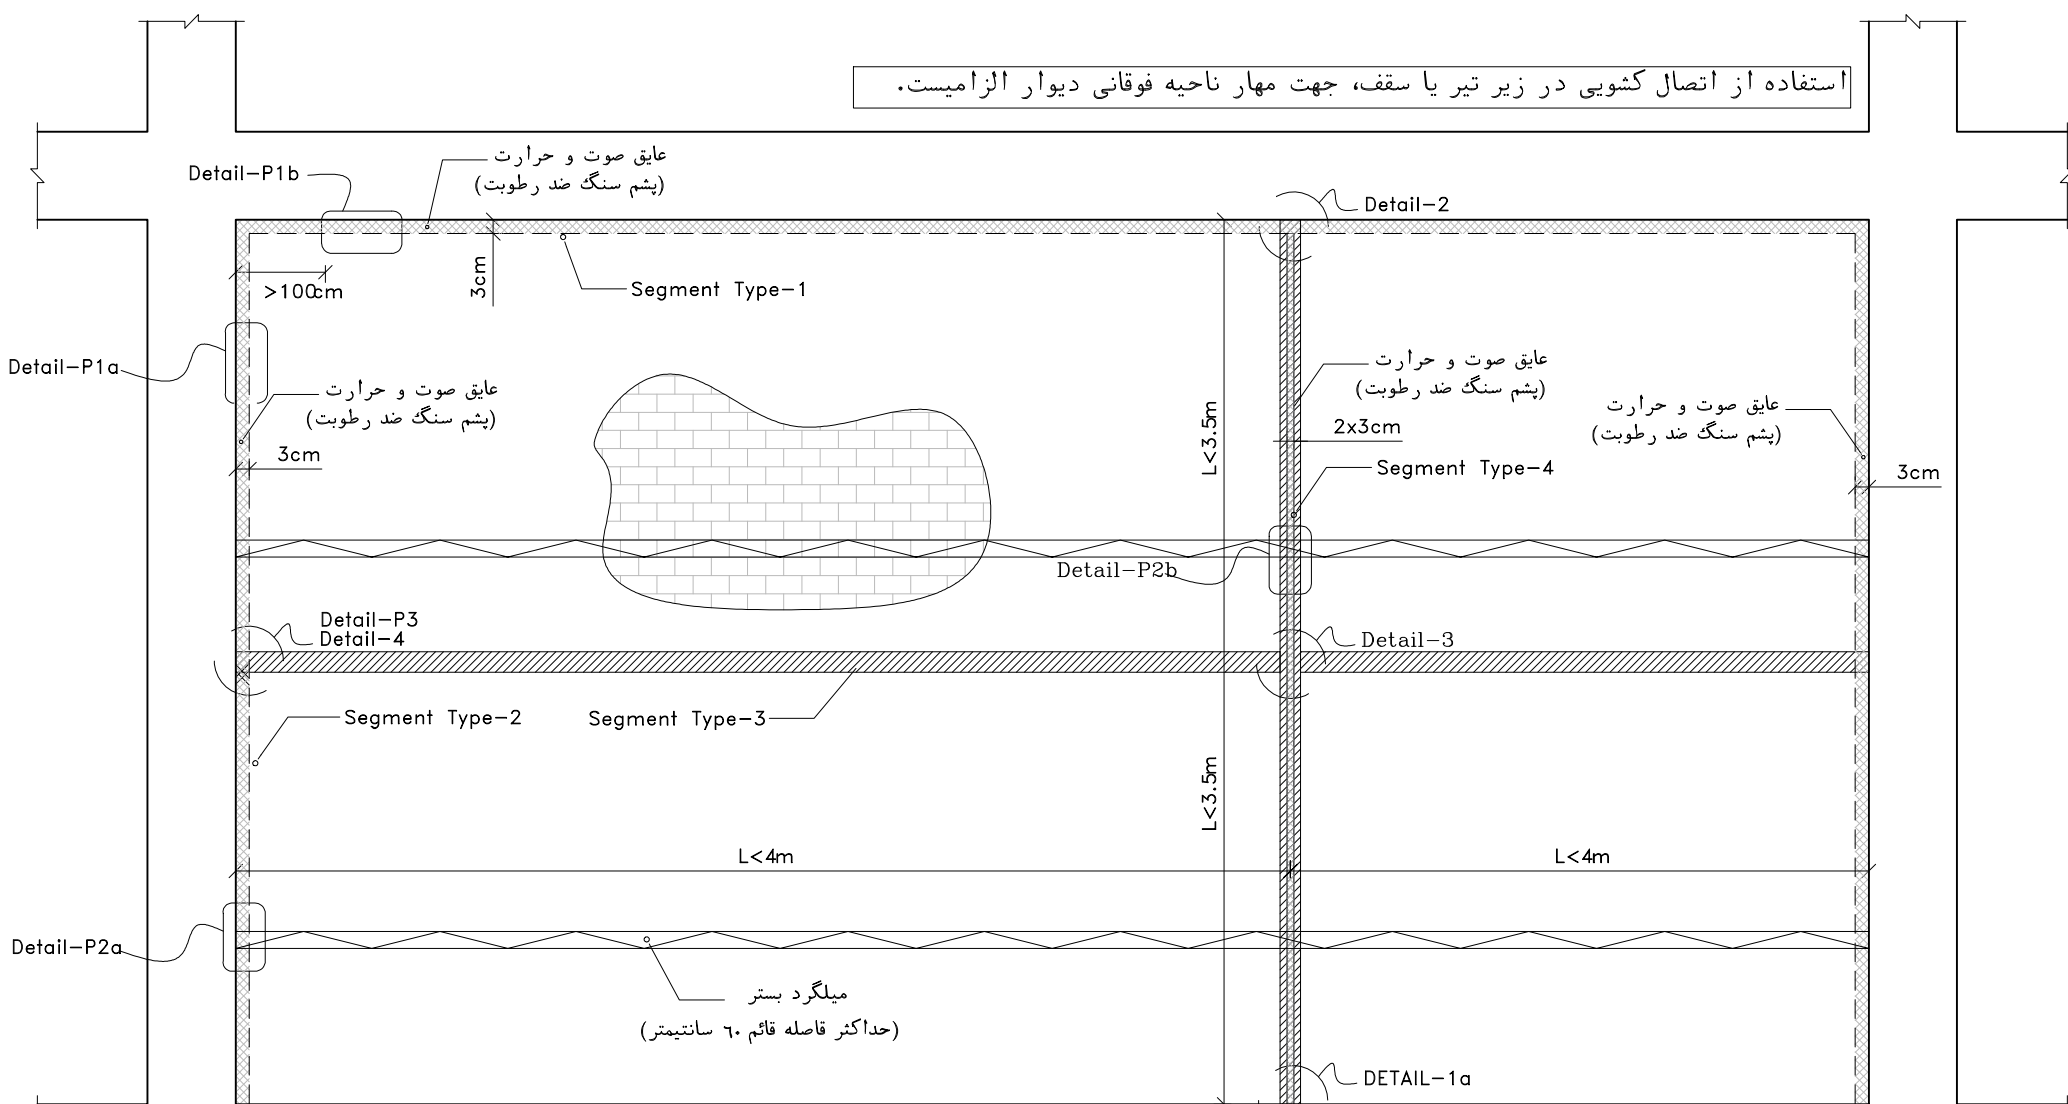

اتصال وادار انتهایی در دیوارهای خارج از قاب به صورت نل سکویی

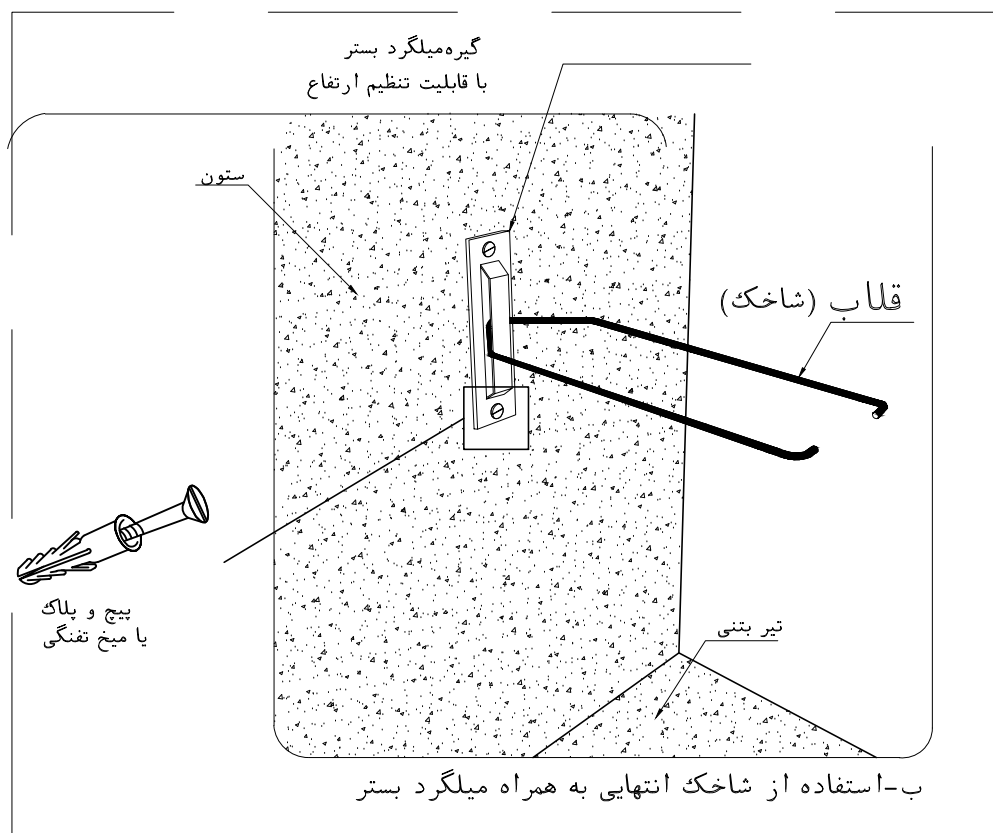

روش های مهار دیوار به ستون جهت نیروی خارج از صفحه

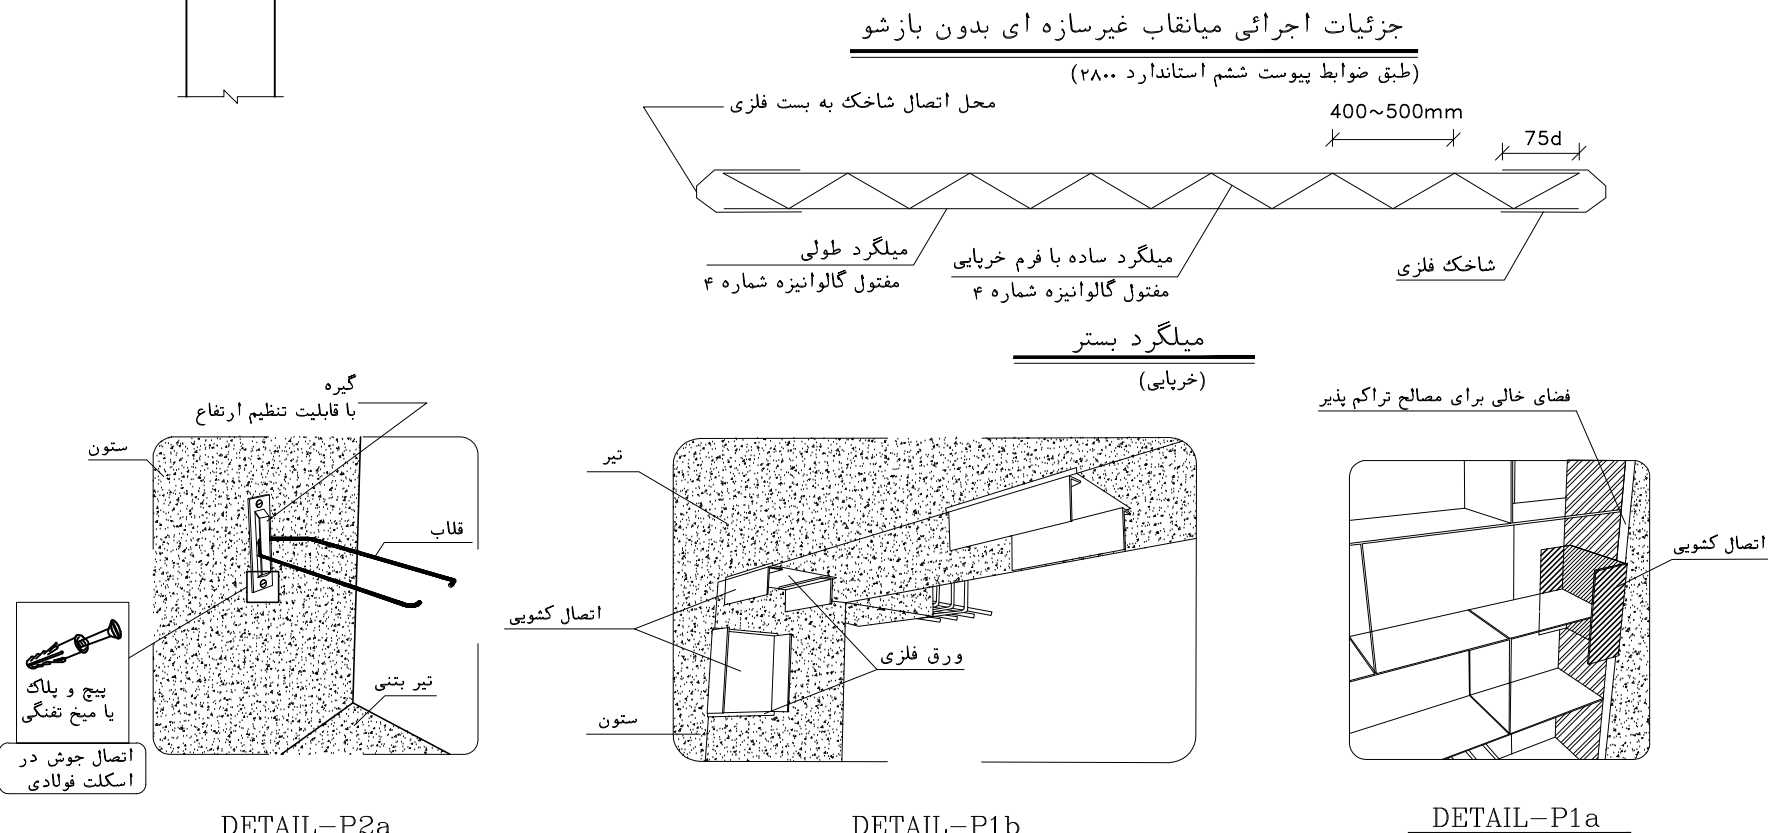

D05	JAN. 2025	APC	R.BERLOUJE	M.FAKHARIAN	S.Faramarzpour	**
D04	NOV. 2024	APC	R.BERLOUJE	M.FAKHARIAN	S.Faramarzpour	**
D03	MAR. 2024	APC	R.BERLOUJE	M.FAKHARIAN	S.Faramarzpour	**
D02	NOV. 2023	APC	R.BERLOUJE	M.FAKHARIAN	S.Faramarzpour	**
D01	SEP. 2023	IFA	R.BERLOUJE	M.FAKHARIAN	A.M. MOHSENI	**
D00	JUN. 2023	IFC	R.BERLOUJE	M.FAKHARIAN	A.M. MOHSENI	**
REV.	DATE	P.O.I.S	PREP.	CHK.	APP.	AUT.

PROJECT NAME: BINAK OILFIELD DEVELOPMENT/SURFACE FACILITIES
GAS COMPRESSOR STATION

PROJECT NO.:	971020
--------------	--------

EPC CONTRACTOR:



HIRGAN ENERGY - DESIGN & INSPECTION
COMPANIES

EPD/EPC CONTRACTOR (GC):



COMPANY

DRAWING TITLE

Architectural Detail Drawing For Extension of EXISTING Control Building
DETAILS

SCALE	SIZE	DRAWING NO.	SHEET NO.	REV.
AS SHOWN	A1	BK-GCS-PEDCO-120-AR-DW-0011	10 OF 13	D05

اصل و کلیه نسخ این نقشه و حق افزایش متعلق به شرکت ملی مناطق نفت خیز جنوب میباشد.

THE ORIGINAL AND ALL COPIES OF THIS DRAWING TOGETHER WITH
THE COPYRIGHT THEREIN ARE THE SOLE PROPERTY OF
N.I.S.O.C./ FIELDS



BINAK OILFIELD DEVELOPMENT
SURFACE FACILITIES
GAS COMPRESSOR STATION

DATE	SCALE	DRAWING BY	CHECKED BY	PROJECT ENG.




NO CONSTRUCTION PERMITTED UNLESS DRAWING APPROVED


APPROVED FOR CONSTRUCTION				BY:	DATE:	
BUDGET REF.	LOCATION	SIZE	CLASS	SERIAL NO.	SHEET	REVISION

053-073-9184	F	4	B	709518	10 OF 13	D05
--------------	---	---	---	--------	----------	-----

  

053-073-9184	F	4	B	709518	11 OF 13	D05
--------------	---	---	---	--------	----------	-----

 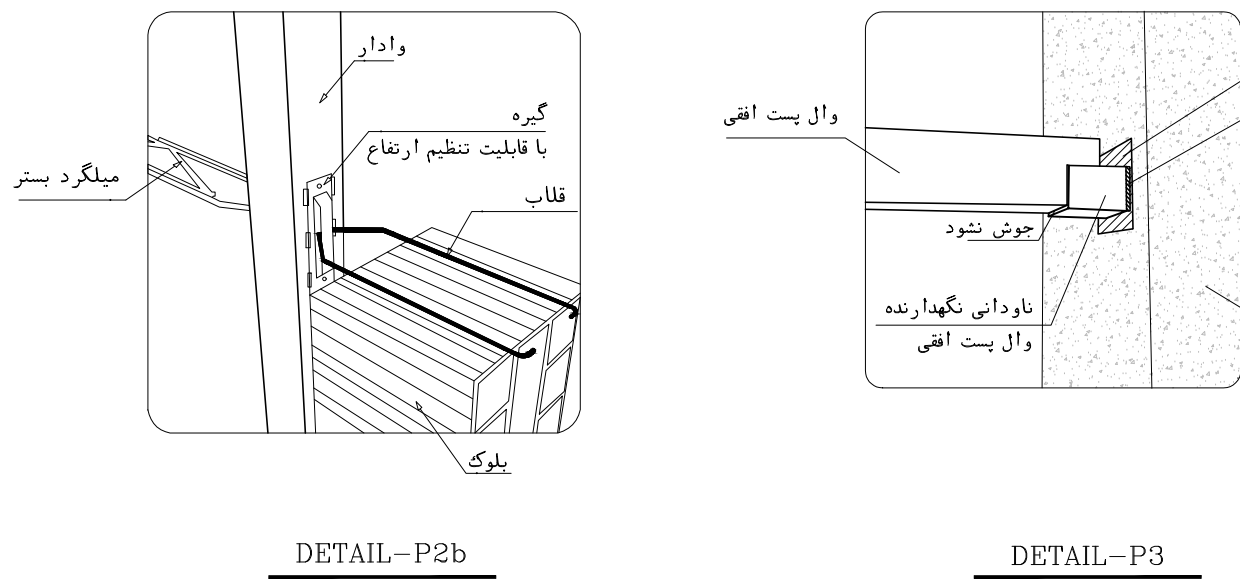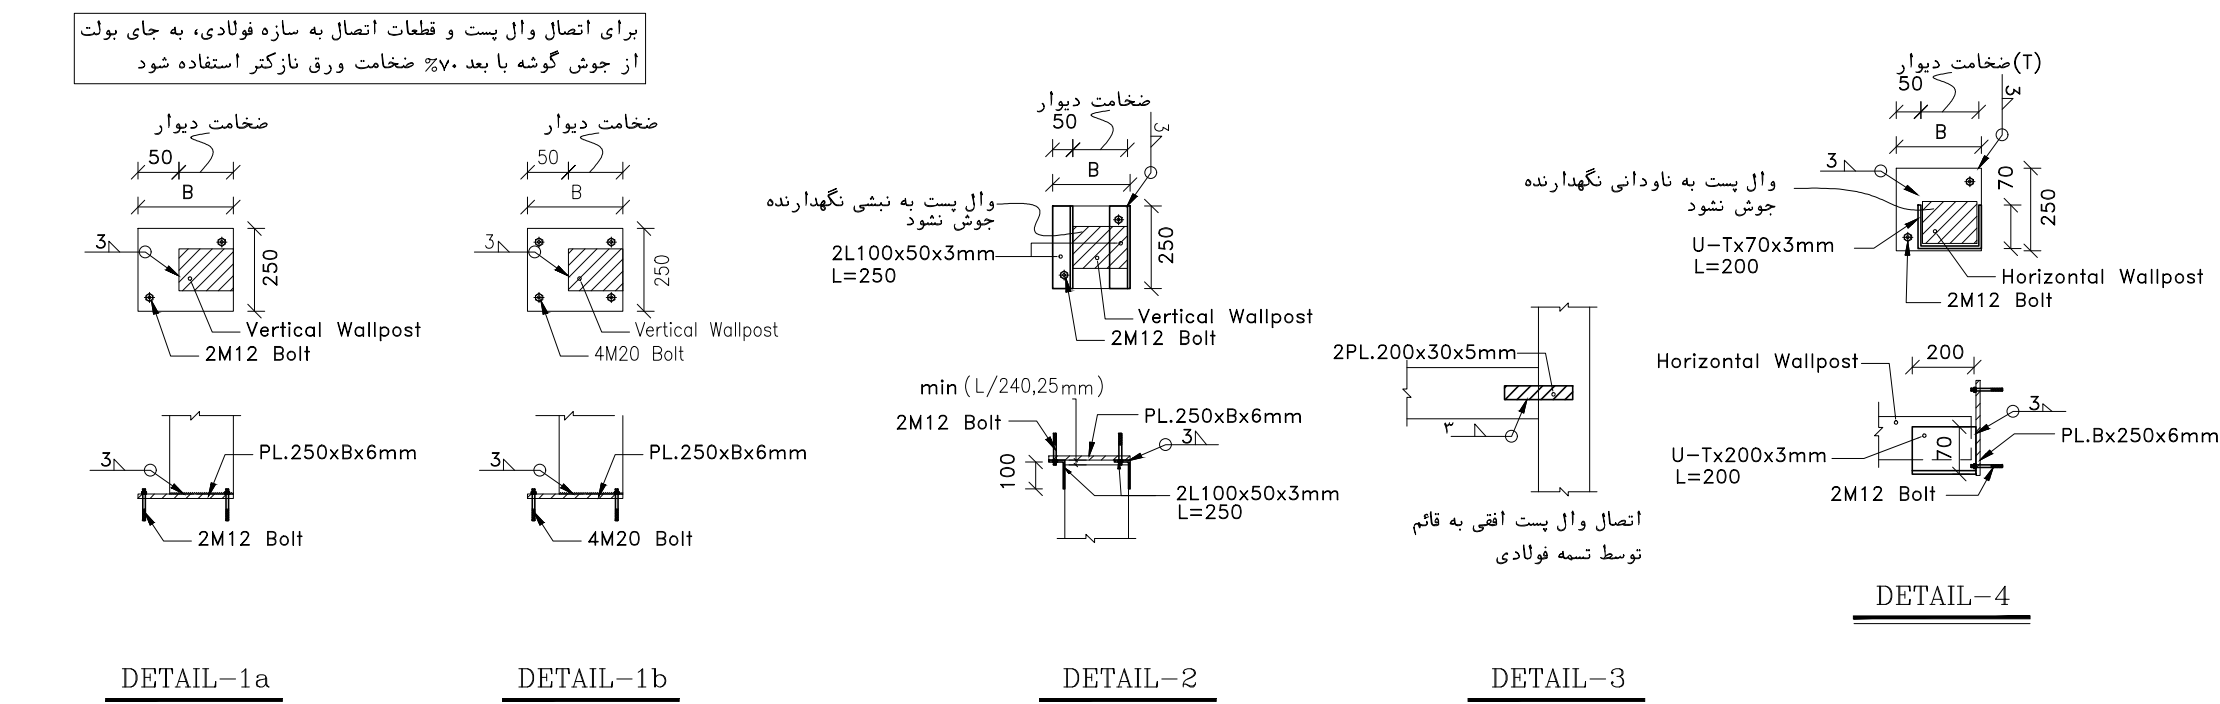

 EPC CONTRACTOR:   HIRGAN ENERGY – DESIGN & INSPECTION COMPANIES	EPD/EPC CONTRACTOR (GC):  PETROIRAN DEVELOPMENT COMPANY
---	---


NOTES

1. ALL DIMENSIONS ARE IN MILLIMETER & ALL ELEVATIONS ARE IN METER.
2. ALL DIMENSIONS AND ELEVATIONS SHALL BE CHECKED BY THE CONTRACTOR PRIOR TO CONSTRUCTION.
3. CONTRACTOR SHALL COMPARE ALL ARCHITECTURAL, MECHANICAL, ELECTRICAL, PIPING AND STRUCTURAL DRAWINGS AND IN CASE OF ANY CONFLICTS OR DISCREPANCY, INFORM THE ENGINEER.
4. ALL MATERIALS ARE SELECTED FROM THE HIGHEST QUALITY AND MUST BE APPROVED BY THE CLIENT.
5. ALL OPENINGS FOR PIPING/CABLING AND HVAC OPENINGS SHALL BE CONSIDERED AS PER RELATED DRAWINGS BEFORE CONSTRUCTION.
6. FINISH GRADING LEVEL (F.G.L.) : ± 0.00 (LOCAL) = 99.70


LEGEND

REFERENCE DRAWING	DRG. No.
STANDARD DRAWING FOR ARCHITECTURAL DETAILS	BK-GNRL-PEDCO-000-AR-DW-0001
SITE SEWAGEAGE SYSTEM LAYOUT & DETAILS	BK-GCS-PEDCO-120-CV-PY-0001
CONTROL ROOM LAYOUT & ARRANGEMENT DRAWING	BK-GCS-PEDCO-120-IN-PY-0001
ROAD, PAVING AND PLANT FINISH GRADING LAYOUT & SECTIONS	BK-GCS-PEDCO-120-CV-PY-0005
ELECTRICAL CABLE ROUTE & SECTION LAYOUT FOR BUILDING & SHELTER	BK-GCS-PEDCO-120-EL-PY-0006
FOUNDATION DRAWING FOR EXTENSION OF CONTROL BUILDING	BK-GNRL-PEDCO-220-ST-DW-0004
STRUCTURAL DRAWING FOR EXTENSION OF CONTROL BUILDING	BK-GNRL-PEDCO-220-ST-DW-0005
STANDARD DETAILS FOR LADDER & SAFETY CAGE	BK-GNRL-PEDCO-000-ST-DW-0009
AREA ELECTRICAL CABLE ROUTE & SECTION LAYOUT	BK-GCS-PEDCO-120-EL-PY-0005
UNIT PLOT PLAN DRAWING	BK-PPL-PEDCO-120-PI-PY-0001
CONTROL ROOM CABLE ROUTE LAYOUT	BK-GCS-PEDCO-120-IN-PY-0002
INSTRUMENT /F&G CABLE TRENCH/ROUTE LAYOUT DRAWING	BK-GCS-PEDCO-120-IN-PY-0004
ELECTRICAL EQUIPMENT ARRANGEMENT LAYOUT FOR BUILDING	BK-GCS-PEDCO-120-EL-PY-0008

KEY PLAN

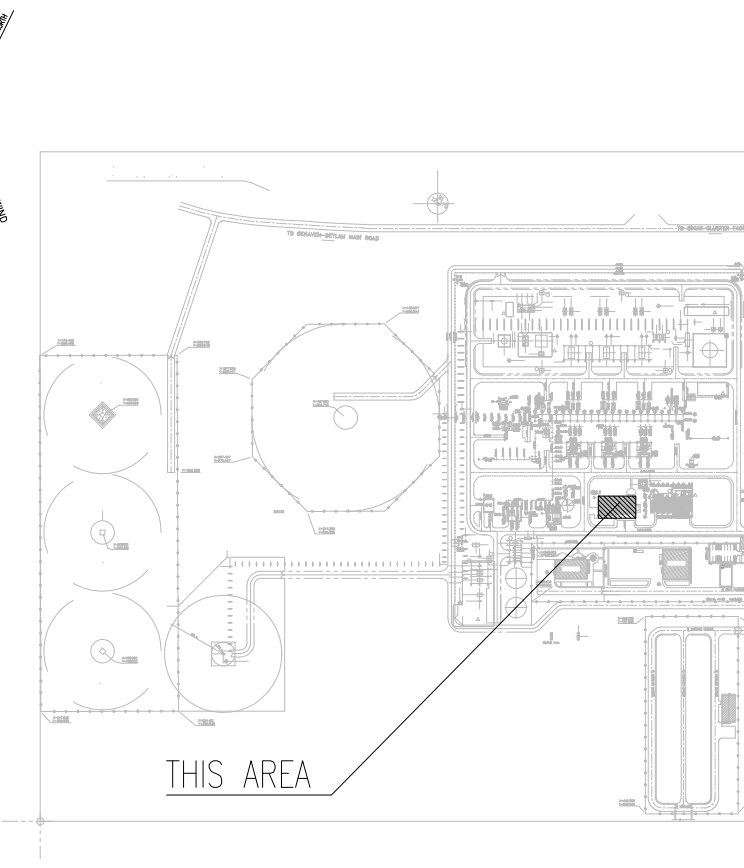

***	*****	** **	*** **	** **	*** **
REV.	DESCRIPTION	BY	DATE	BY	DATE
		CHECKED		REV. APPR.	
اصل و کلیه نسخ این نقشه و حق اقتباس متعلق به شرکت ملی مناطق نفت خیز جنوب میباشد.					
 THE ORIGINAL AND ALL COPIES OF THIS DRAWING TOGETHER WITH THE COPYRIGHT THEREIN ARE THE SOLE PROPERTY OF N.I.S.O.C./ FIELDS					
BINAK OILFIELD DEVELOPMENT SURFACE FACILITIES GAS COMPRESSOR STATION					
DATE	SCALE	DRAWING BY	CHECKED BY	PROJECT ENG.	
NO CONSTRUCTION PERMITTED UNLESS DRAWING APPROVED					
APPROVED FOR CONSTRUCTION			BY:	DATE:	
BUDGET REF.	LOCATION	SIZE	CLASS	SERIAL NO.	SHEET
053-073-9184	F	4	B	709518	12 OF 13
					D05

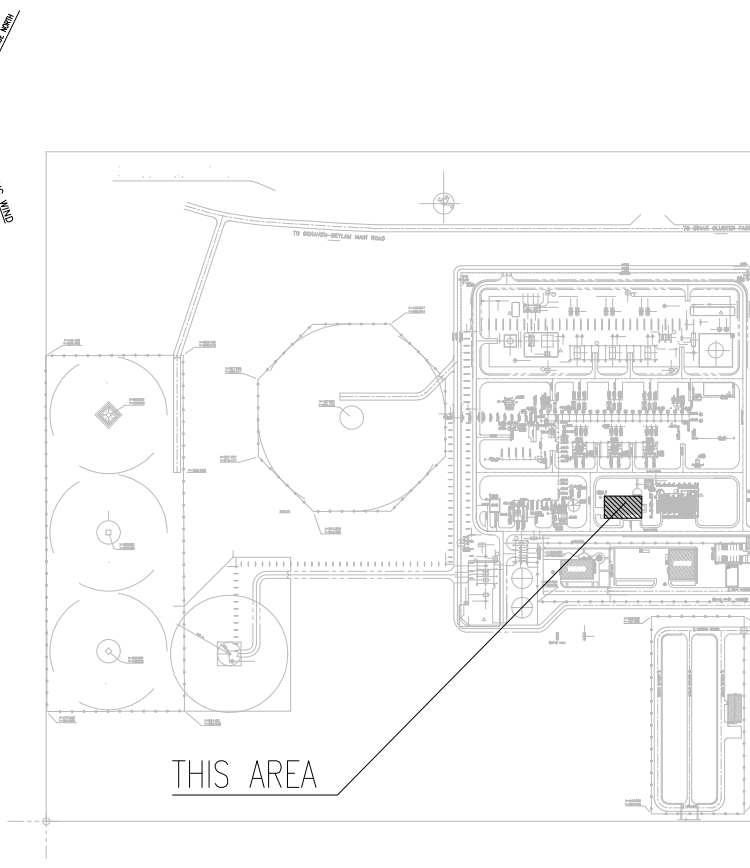NOTES					
1. ALL DIMENSIONS ARE IN MILLIMETER & ALL ELEVATIONS ARE IN METER.					
2. ALL DIMENSIONS AND ELEVATIONS SHALL BE CHECKED BY THE CONTRACTOR PRIOR TO CONSTRUCTION.					
3. CONTRACTOR SHALL COMPARE ALL ARCHITECTURAL, MECHANICAL, ELECTRICAL, PIPING AND STRUCTURAL DRAWINGS AND IN CASE OF ANY CONFLICTS OR DISCREPANCY, INFORM THE ENGINEER.					
4. ALL MATERIALS ARE SELECTED FROM THE HIGHEST QUALITY AND MUST BE APPROVED BY THE CLIENT.					
5. ALL OPENINGS FOR PIPING/CABLING AND HVAC OPENINGS SHALL BE CONSIDERED AS PER RELATED DRAWINGS BEFORE CONSTRUCTION.					
6. FINISH GRADING LEVEL (F.G.L.) : ± 0.00 (LOCAL) = 99.70					
LEGEND					
REFERENCE DRAWING			DRG. No.		
STANDARD DRAWING FOR ARCHITECTURAL DETAILS			BK-GNRAL-PEDCO-000-AR-DW-0001		
SITE SEWAGEAGE SYSTEM LAYOUT & DETAILS			BK-GCS-PEDCO-120-CV-PY-0001		
CONTROL ROOM LAYOUT & ARRANGEMENT DRAWING			BK-GCS-PEDCO-120-IN-PY-0001		
ROAD, PAVING AND PLANT FINISH GRADING LAYOUT & SECTIONS			BK-GCS-PEDCO-120-CV-PY-0005		
ELECTRICAL CABLE ROUTE & SECTION LAYOUT FOR BUILDING & SHELTER			BK-GCS-PEDCO-120-EL-PY-0006		
FOUNDATION DRAWING FOR EXTENSION OF CONTROL BUILDING			BK-GNRAL-PEDCO-220-ST-DW-0004		
STRUCTURAL DRAWING FOR EXTENSION OF CONTROL BUILDING			BK-GNRAL-PEDCO-220-ST-DW-0005		
STANDARD DETAILS FOR LADDER & SAFETY CAGE			BK-GNRAL-PEDCO-000-ST-DW-0009		
AREA ELECTRICAL CABLE ROUTE & SECTION LAYOUT			BK-GCS-PEDCO-120-EL-PY-0005		
UNIT PILOT PLAN DRAWING			BK-PPL-PEDCO-120-PI-PY-0001		
CONTROL ROOM CABLE ROUTE LAYOUT			BK-GCS-PEDCO-120-IN-PY-0002		
INSTRUMENT/P&ID CABLE TRENCH/ROUTE LAYOUT DRAWING			BK-GCS-PEDCO-120-IN-PY-0004		
ELECTRICAL EQUIPMENT ARRANGEMENT LAYOUT FOR BUILDING			BK-GCS-PEDCO-120-EL-PY-0008		
KEY PLAN					
					
***	*****	***	*** **	**	*** **
REV.	DESCRIPTION	BY	DATE	BY	DATE
		CHECKED		REV. APPR.	
اصل و کليه نسخ این نقشه و جز اقباس متعلق به شرکت ملی مناطق نفت خیز جنوب میباشد.					
 THE ORIGINAL AND ALL COPIES OF THIS DRAWING TOGETHER WITH THE COPYRIGHT THEREIN ARE THE SOLE PROPERTY OF N.I.S.O.C./ FIELDS					
BINAK OILFIELD DEVELOPMENT SURFACE FACILITIES GAS COMPRESSOR STATION					
DATE	SCALE	DRAWING BY	CHECKED BY	PROJECT ENG.	
NO CONSTRUCTION PERMITTED UNLESS DRAWING APPROVED					
APPROVED FOR CONSTRUCTION			BY:	DATE:	
BUDGET REF.	LOCATION	SIZE	CLASS	SERIAL NO.	SHEET
053-073-9184	F	4	B	709518	13 OF 13
					D05