 
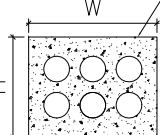
 
 
 
 






NOTES		
1.	ALL COORDINATES AND ELEVATIONS ARE IN METERS.	
2.	ALL COORDINATES ARE IN LOCAL SYSTEM., WITH REFERENCE TO SITE LOCAL DATUM POINT.	
	LOCAL	UTM
A	E=500,000 N=500,000	E=437384.709 N=3289737.469
B1	E=485.337 N=788.941 Z=12.170	E=437245.830 N=3289991.269 ELEV.=12.17
B2	E=798.452 N=382.283 Z=13.410	E=437704.660 N=3289761.280 ELEV.=13.41
3.	ALL ELEVATION REFERENCES IS MEAN SEA LEVEL.	
4.	ALL DIMENSIONS ARE IN MILLIMETERS UNLESS STATED OTHERWISE.	
5.	SHALL BE FINALIZED LATER.	
6.	SHALL BE FINALIZED AFTER RECEIVING APPROVED VENDOR DATA	

LEGEND

	FIRE SHED		GRAVITY PIPE SLOPE DIRECTION
	DUCT BANK		NEW PIPE
	DELUGE VALVE		BEARING SLAB
	BERRIED ELECTRICAL TRENCH		NEW ELECTRICAL DUCT BANK
	BERRIED INSTRUMENT TRENCH		NEW INSTRUMENT DUCT BANK
	CONCRETE ELECTRICAL TRENCH		FOUNDATION
	CONCRETE INSTRUMENT TRENCH		CROSSING POINTS
	EXISTING ELECTRICAL TRENCH		SANITARY MANHOLE
	EXISTING INSTRUMENT TRENCH		VALVE PIT
	MAT FOUNDATION		NEW LIGHTING TOWER
	EXISTING LIGHTING FOUNDATION		EXISTING FENCE
			NEW FENCE
B.O.P.	BOTTOM OF PIPE	GRA	GRAVITY PIPE
B.O.T.	BOTTOM OF TRENCH	IN	INSTRUMENT
T.O.D.	TOP OF DUCT BANK	EL	ELECTRICAL
B.O.F.	BOTTOM OF FOUNDATION	FWA	FIRE WATER
H.P.P.	HIGH POINT OF PAVING	US	UNDER GROUND
H.P.C	HIGH POINT OF GRAVEL	PE	POLYETHYLENE
R.L	ROAD ELEVATION	SA	SANITARY PIPE
		DCB	DUCT BANK
		FG	FINISHED GRADE

REFERENCE DRAWING	DRG. No.
SPECIFICATION FOR ROAD & PAVING	BK-GNRL-PEDCO-000-CV-SP-0002
STANDARD DRAWING FOR ROADS	BK-GNRL-PEDCO-000-CV-DW-0003
STANDARD DRAWING FOR PAVINGS	BK-GNRL-PEDCO-000-CV-DW-0035
UNIT PLOT PLAN DRAWING	BK-GCS-PEDCO-120-PI-PY-0001
ROUGH GRADING PLAN & DETAILS	BK-GCS-PEDCO-120-CV-PY-0007
BINAK NEW COMPRESSOR GAS STATION PLOT PLAN (BASIC PACKAGE)	1560-BK-NCS-PI-DWG-0001
DICK WALL DRAWING FOR LEAN GLYCOL STORAGE TANK (TK-2102)	BK-GCS-PEDCO-120-ST-DW-0033
FOUNDATION DRAWING FOR GLYCOL SUMP PIT (SU-2101)	BK-GCS-PEDCO-120-ST-DW-0035
AREA ELECTRICAL CABLE ROUTE & SECTION LAYOUT	BK-GCS-PEDCO-120-EL-PY-0005
INSTRUMENT/FA/C CABLE TRENCH/ROUTE LAYOUT DRAWING	BK-GCS-PEDCO-120-IN-PY-0004
UG PIPING PLAN	BK-GCS-PEDCO-120-PI-DW-0005
ROAD, PAVING AND PLANT FINISH GRADING LAYOUT & SECTIONS	BK-GCS-PEDCO-120-CV-PY-0006
PLANT CONTAMINATED WATER SYSTEM LAYOUT	BK-GCS-PEDCO-120-CV-PY-0003
PLANT CLEAN WATER DRAINAGE SYSTEM LAYOUT & DETAILS	BK-GCS-PEDCO-120-CV-PY-0004
STANDARD DRAWING FOR ELECTRICAL CABLE TRENCH	BK-GNRL-PEDCO-000-CV-DW-0004
STANDARD DRAWING FOR SEWERAGE & DRAINAGE DETAILS	BK-GNRL-PEDCO-000-CV-DW-0007
STANDARD DRAWING FOR CIVIL UNDERGROUND CROSSING	BK-GNRL-PEDCO-000-CV-DW-0008
PIPELINE STANDARD DRAWING FOR COVER SLABS AND SET-ON-WEIGHT	BK-GNRL-PEDCO-000-PL-DW-0013

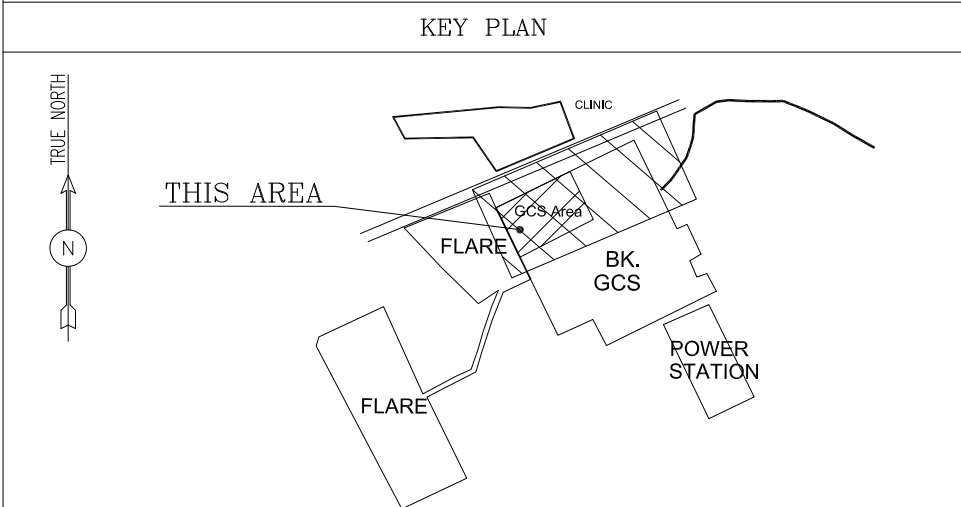[illegible]

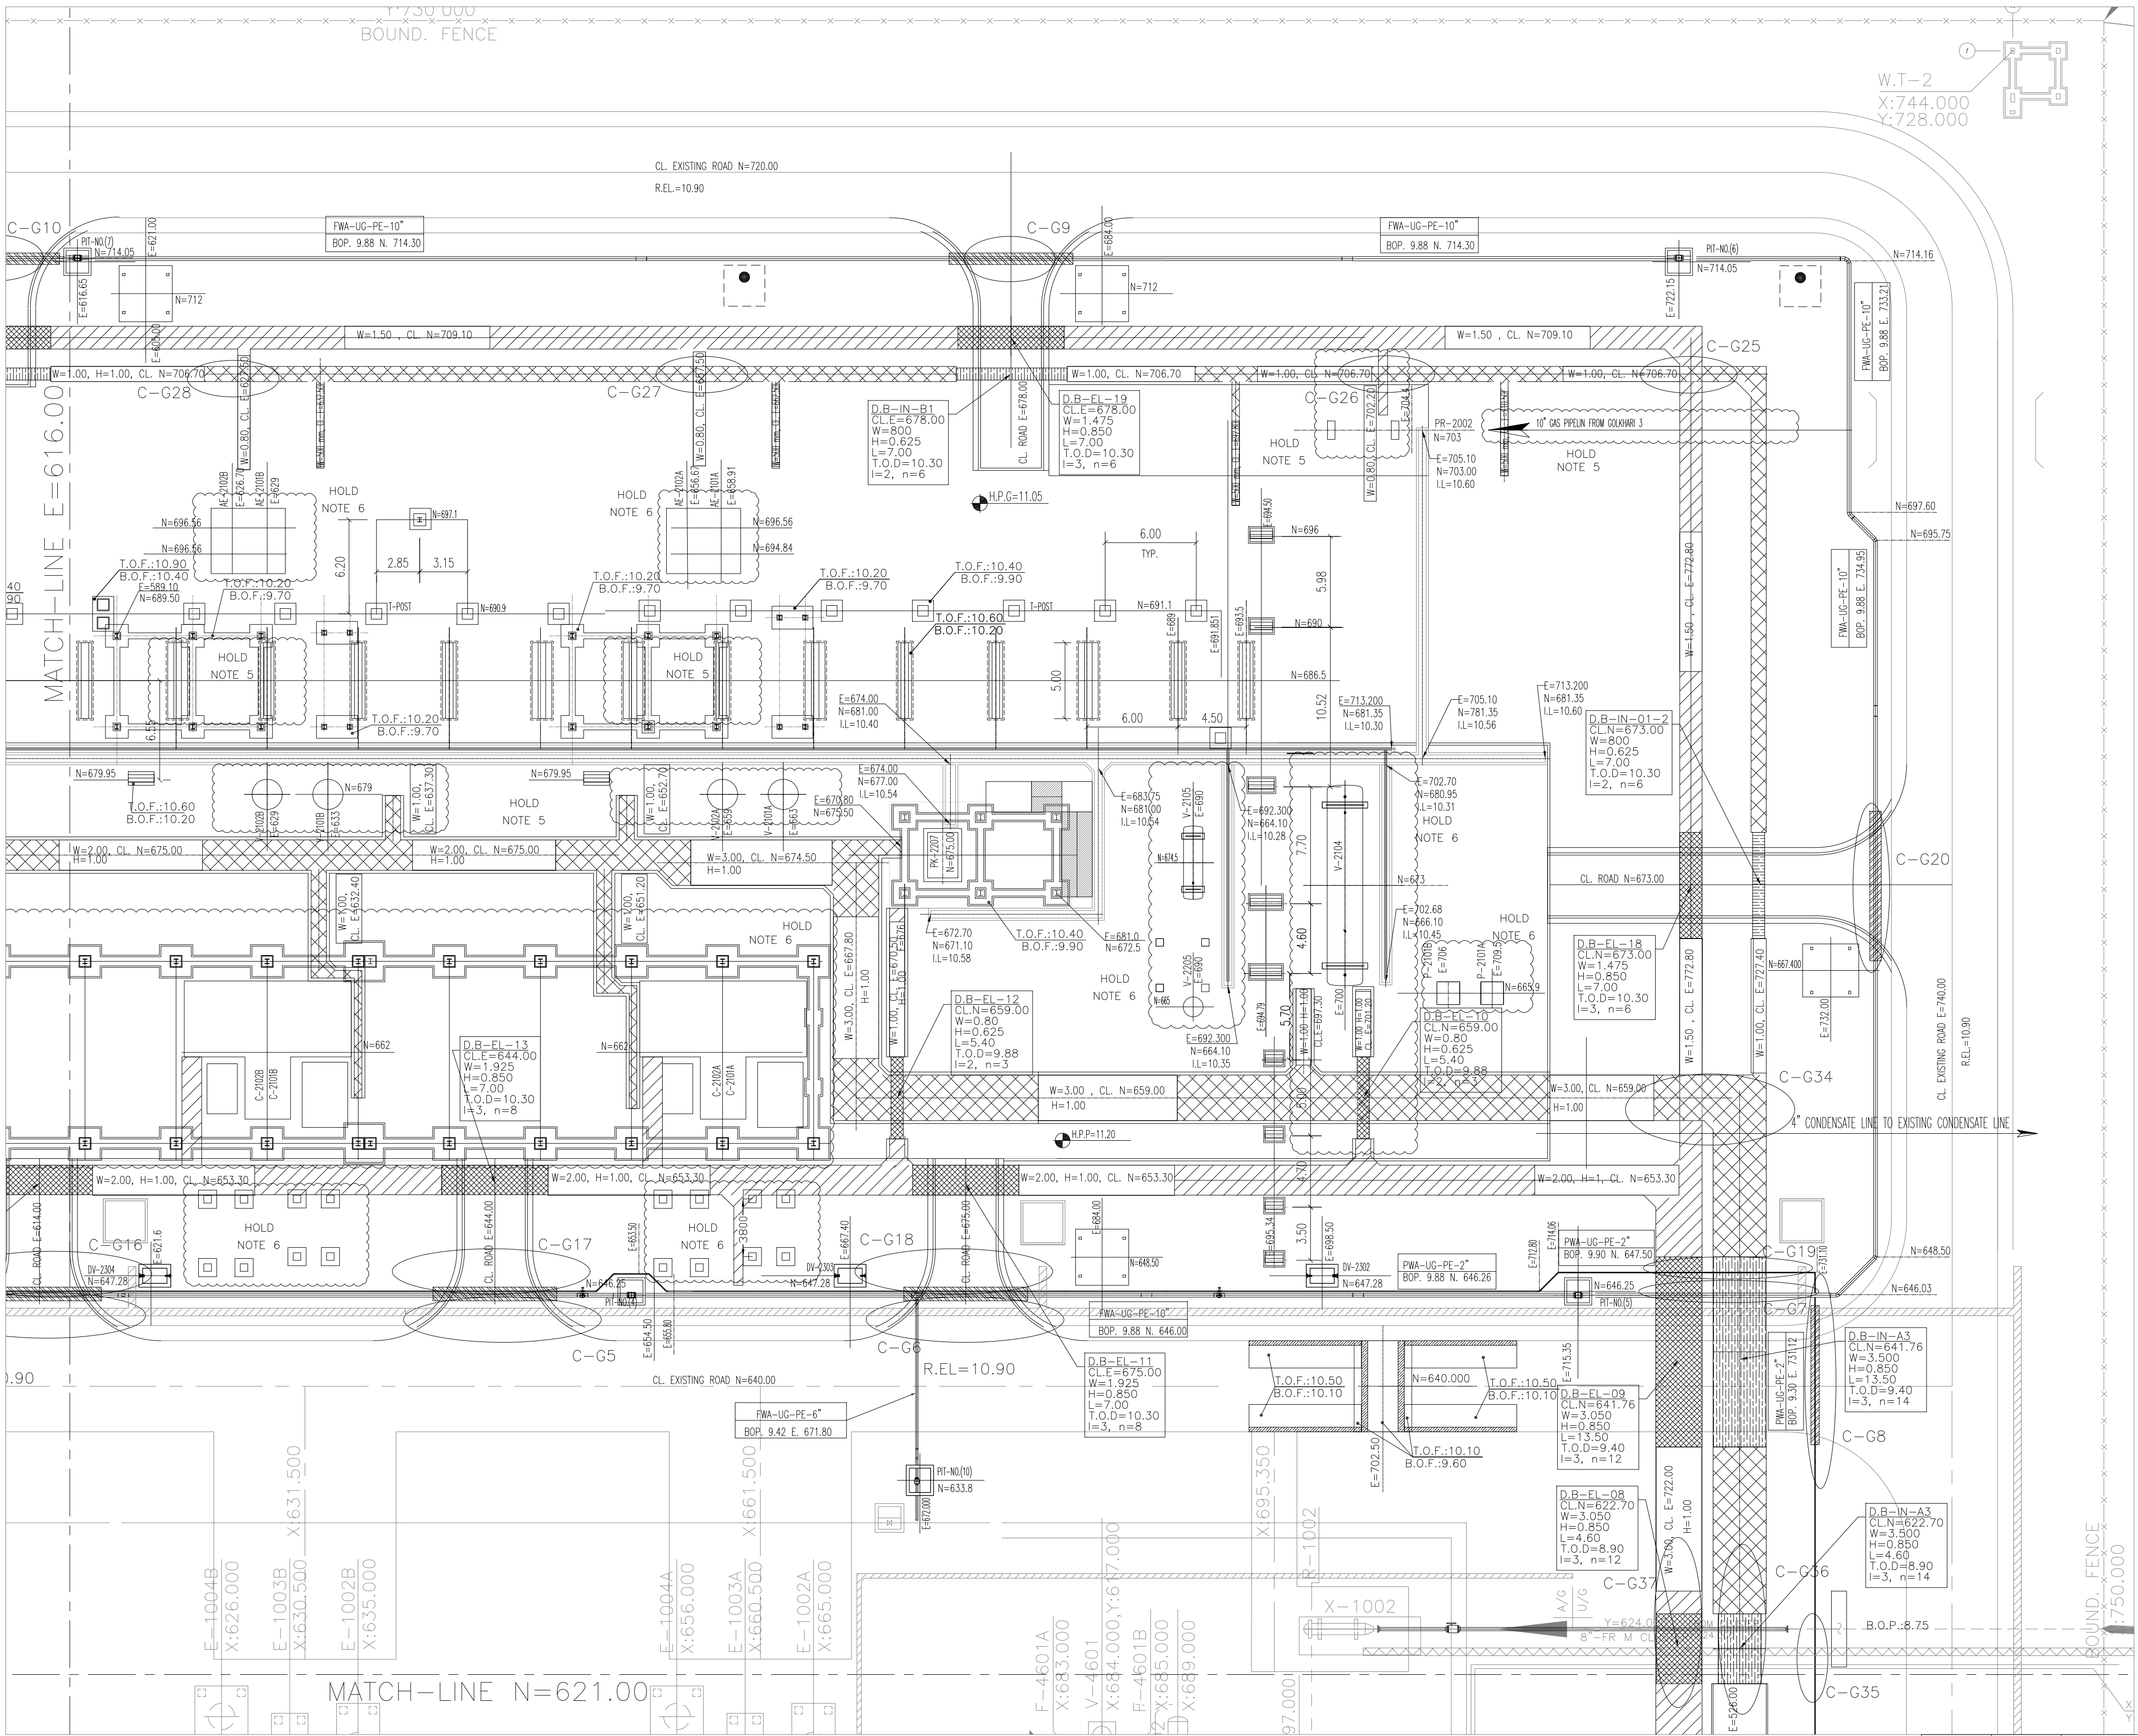


GCS
SC.1:250



- NOTES
- ALL COORDINATES AND ELEVATIONS ARE IN METERS.
 - ALL COORDINATES ARE IN LOCAL SYSTEM., WITH REFERENCE TO SITE LOCAL DATUM POINT.
 - ALL ELEVATION REFERENCES IS MEAN SEA LEVEL.
 - ALL DIMENSIONS ARE IN MILLIMETERS UNLESS STATED OTHERWISE.
 - SHALL BE FINALIZED AFTER RECEIVING APPROVED VENDOR DATA

LEGEND	
	FIRE SHED
	W.T.-2
	DUCT BANK
	BERRIED ELECTRICAL TRENCH
	BERRIED INSTRUMENT TRENCH
	CONCRETE ELECTRICAL TRENCH
	CONCRETE INSTRUMENT TRENCH
	EXISTING ELECTRICAL TRENCH
	EXISTING INSTRUMENT TRENCH
	MAT FOUNDATION
	EXISTING LIGHTING FOUNDATION
	GRAVITY PIPE SLOPE DIRECTION
	NEW PIPE
	DELUGE VALVE
	BEARING SLAB
	NEW ELECTRICAL DUCT BANK
	NEW INSTRUMENT DUCT BANK
	FOUNDATION
	CROSSING POINTS
	SANITARY MANHOLE
	VALVE PIT
	NEW LIGHTING TOWER
	EXISTING FENCE
	NEW FENCE
	B.O.P.
	B.O.T.
	T.O.D.
	H.P.P.
	REL.
	GRAVITY PIPE SLOPE DIRECTION
	NEW PIPE
	DELUGE VALVE
	BEARING SLAB
	NEW ELECTRICAL DUCT BANK
	NEW INSTRUMENT DUCT BANK
	FOUNDATION
	CROSSING POINTS
	SANITARY MANHOLE
	VALVE PIT
	NEW LIGHTING TOWER
	EXISTING FENCE
	NEW FENCE
	B.O.P.
	B.O.T.
	T.O.D.
	H.P.P.
	REL.

REFERENCE DRAWING	DRG. No.
SPECIFICATION FOR ROAD & PAVING	BK-GNRL-PEDCO-000-CV-SP-0002
STANDARD DRAWING FOR ROADS	BK-GNRL-PEDCO-000-CV-DW-0003
STANDARD DRAWING FOR PAVINGS	BK-GNRL-PEDCO-000-CV-DW-0035
UNIT PLOT PLAN DRAWING	BK-GCS-PEDCO-120-PI-PY-0001
ROUGH GRADING PLAN & DETAILS	BK-GCS-PEDCO-120-CV-PY-0007
BINAK NEW COMPRESSOR GAS STATION PLOT PLAN (BASIC PACKAGE)	1560-BK-NCS-PI-DWG-0001
DIRE WALL DRAWING FOR LEAN GLYCOL STORAGE TANK (TK-2102)	BK-GCS-PEDCO-120-ST-DW-0033
FOUNDATION DRAWING FOR GLYCOL SUMP PIT (SU-2101)	BK-GCS-PEDCO-120-ST-DW-0035
AREA ELECTRICAL CABLE ROUTE & SECTION LAYOUT	BK-GCS-PEDCO-120-EL-PY-0005
INSTRUMENT/F&G CABLE TRENCH/ROUTE LAYOUT DRAWING	BK-GCS-PEDCO-120-IN-PY-0004
UG PIPING PLAN	BK-GCS-PEDCO-120-PI-DW-0005
ROAD, PAVING AND PLANT FINISH GRADING LAYOUT & SECTIONS	BK-GCS-PEDCO-120-CV-PY-0005
OIL CONTAMINATED WATER SYSTEM LAYOUT	BK-GCS-PEDCO-120-CV-PY-0003
PLANT CLEAN WATER DRAINAGE SYSTEM LAYOUT & DETAILS	BK-GCS-PEDCO-120-CV-PY-0004
STANDARD DRAWING FOR SEWERAGE & DRAINAGE DETAILS	BK-GNRL-PEDCO-000-CV-DW-0007
STANDARD DRAWING FOR CIVIL UNDERGROUND CROSSING	BK-GNRL-PEDCO-000-CV-DW-0008
PIPELINE STANDARD DRAWING FOR COVER SLABS AND SET-ON-WEIGHT	BK-GNRL-PEDCO-000-PL-DW-0013


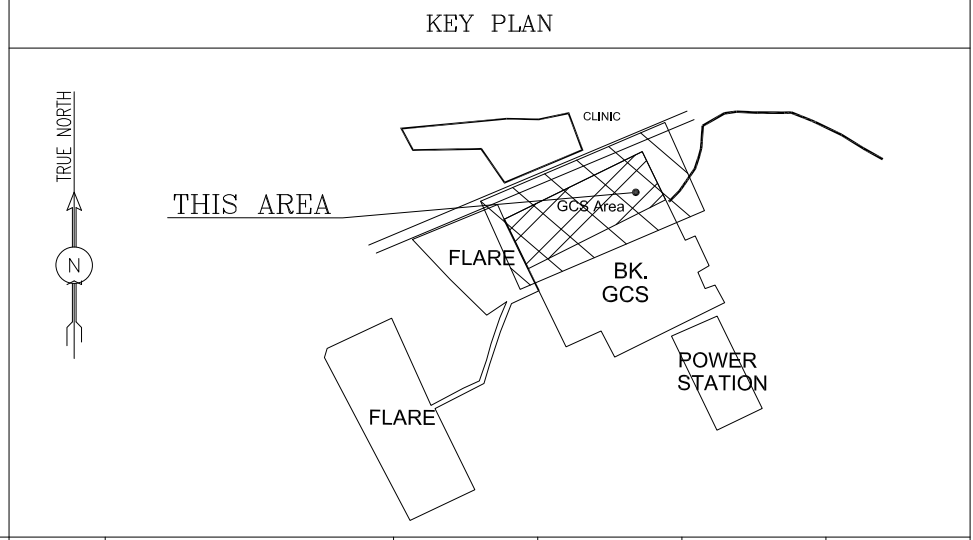


D03	NOV.2024	IFA	R.BERLOUIE	M.PAKHARIAN	M.SADIGHIAN	***																		
D02	FEB.2024	IFA	R.BERLOUIE	M.PAKHARIAN	S.PARAMARZPOUR	***	***	*****	** **	***.***	** **	***.***												
D01	OCT.2023	IFC	R.BERLOUIE	M.PAKHARIAN	S.PARAMARZPOUR	**	REV.	DESCRIPTION	BY	DATE	BY	DATE												
D00	FEB.2023	IFC	M.ASHARINIAZAD	M.PAKHARIAN	SH.GHALIKAR	**				CHECKED		REV. APPR.												
REV.	DATE	P.O.I.S	PREP.	CHK.	APP.	AUT.	اصل و کليه نسخ اين نقشه و حق اقتباس متعلق به شرکت ملی مناطق نفت خيز جنوب ميباشد.																	
PROJECT NAME:							BINAK OILFIELD DEVELOPMENT GENERAL																	
PROJECT NO.:							971020																	
EPC CONTRACTOR:							EPD/EPC CONTRACTOR (GC):																	
  HIRGAN ENERGY – DESIGN & INSPECTION COMPANIES							 PETROIRAN DEVELOPMENT COMPANY																	
							BINAK OILFIELD DEVELOPMENT GENERAL																	
							DATE		SCALE		DRAWING BY		CHECKED BY		PROJECT ENG.									
DRAWING TITLE:							NO CONSTRUCTION PERMITTED UNLESS DRAWING APPROVED																	
							APPROVED FOR CONSTRUCTION						BY:		DATE:									
SCALE		SIZE		DRAWING NO.			SHEET NO.		REV.		BUDGET REF.		LOCATION		SIZE		CLASS		SERIAL NO.		SHEET		REVISION	
1/250		A1		BK-GCS-PEDCO-120-CV-PY-0006			02 OF 06		D03		053-073-9184		F		4		S		709113		2		D03	

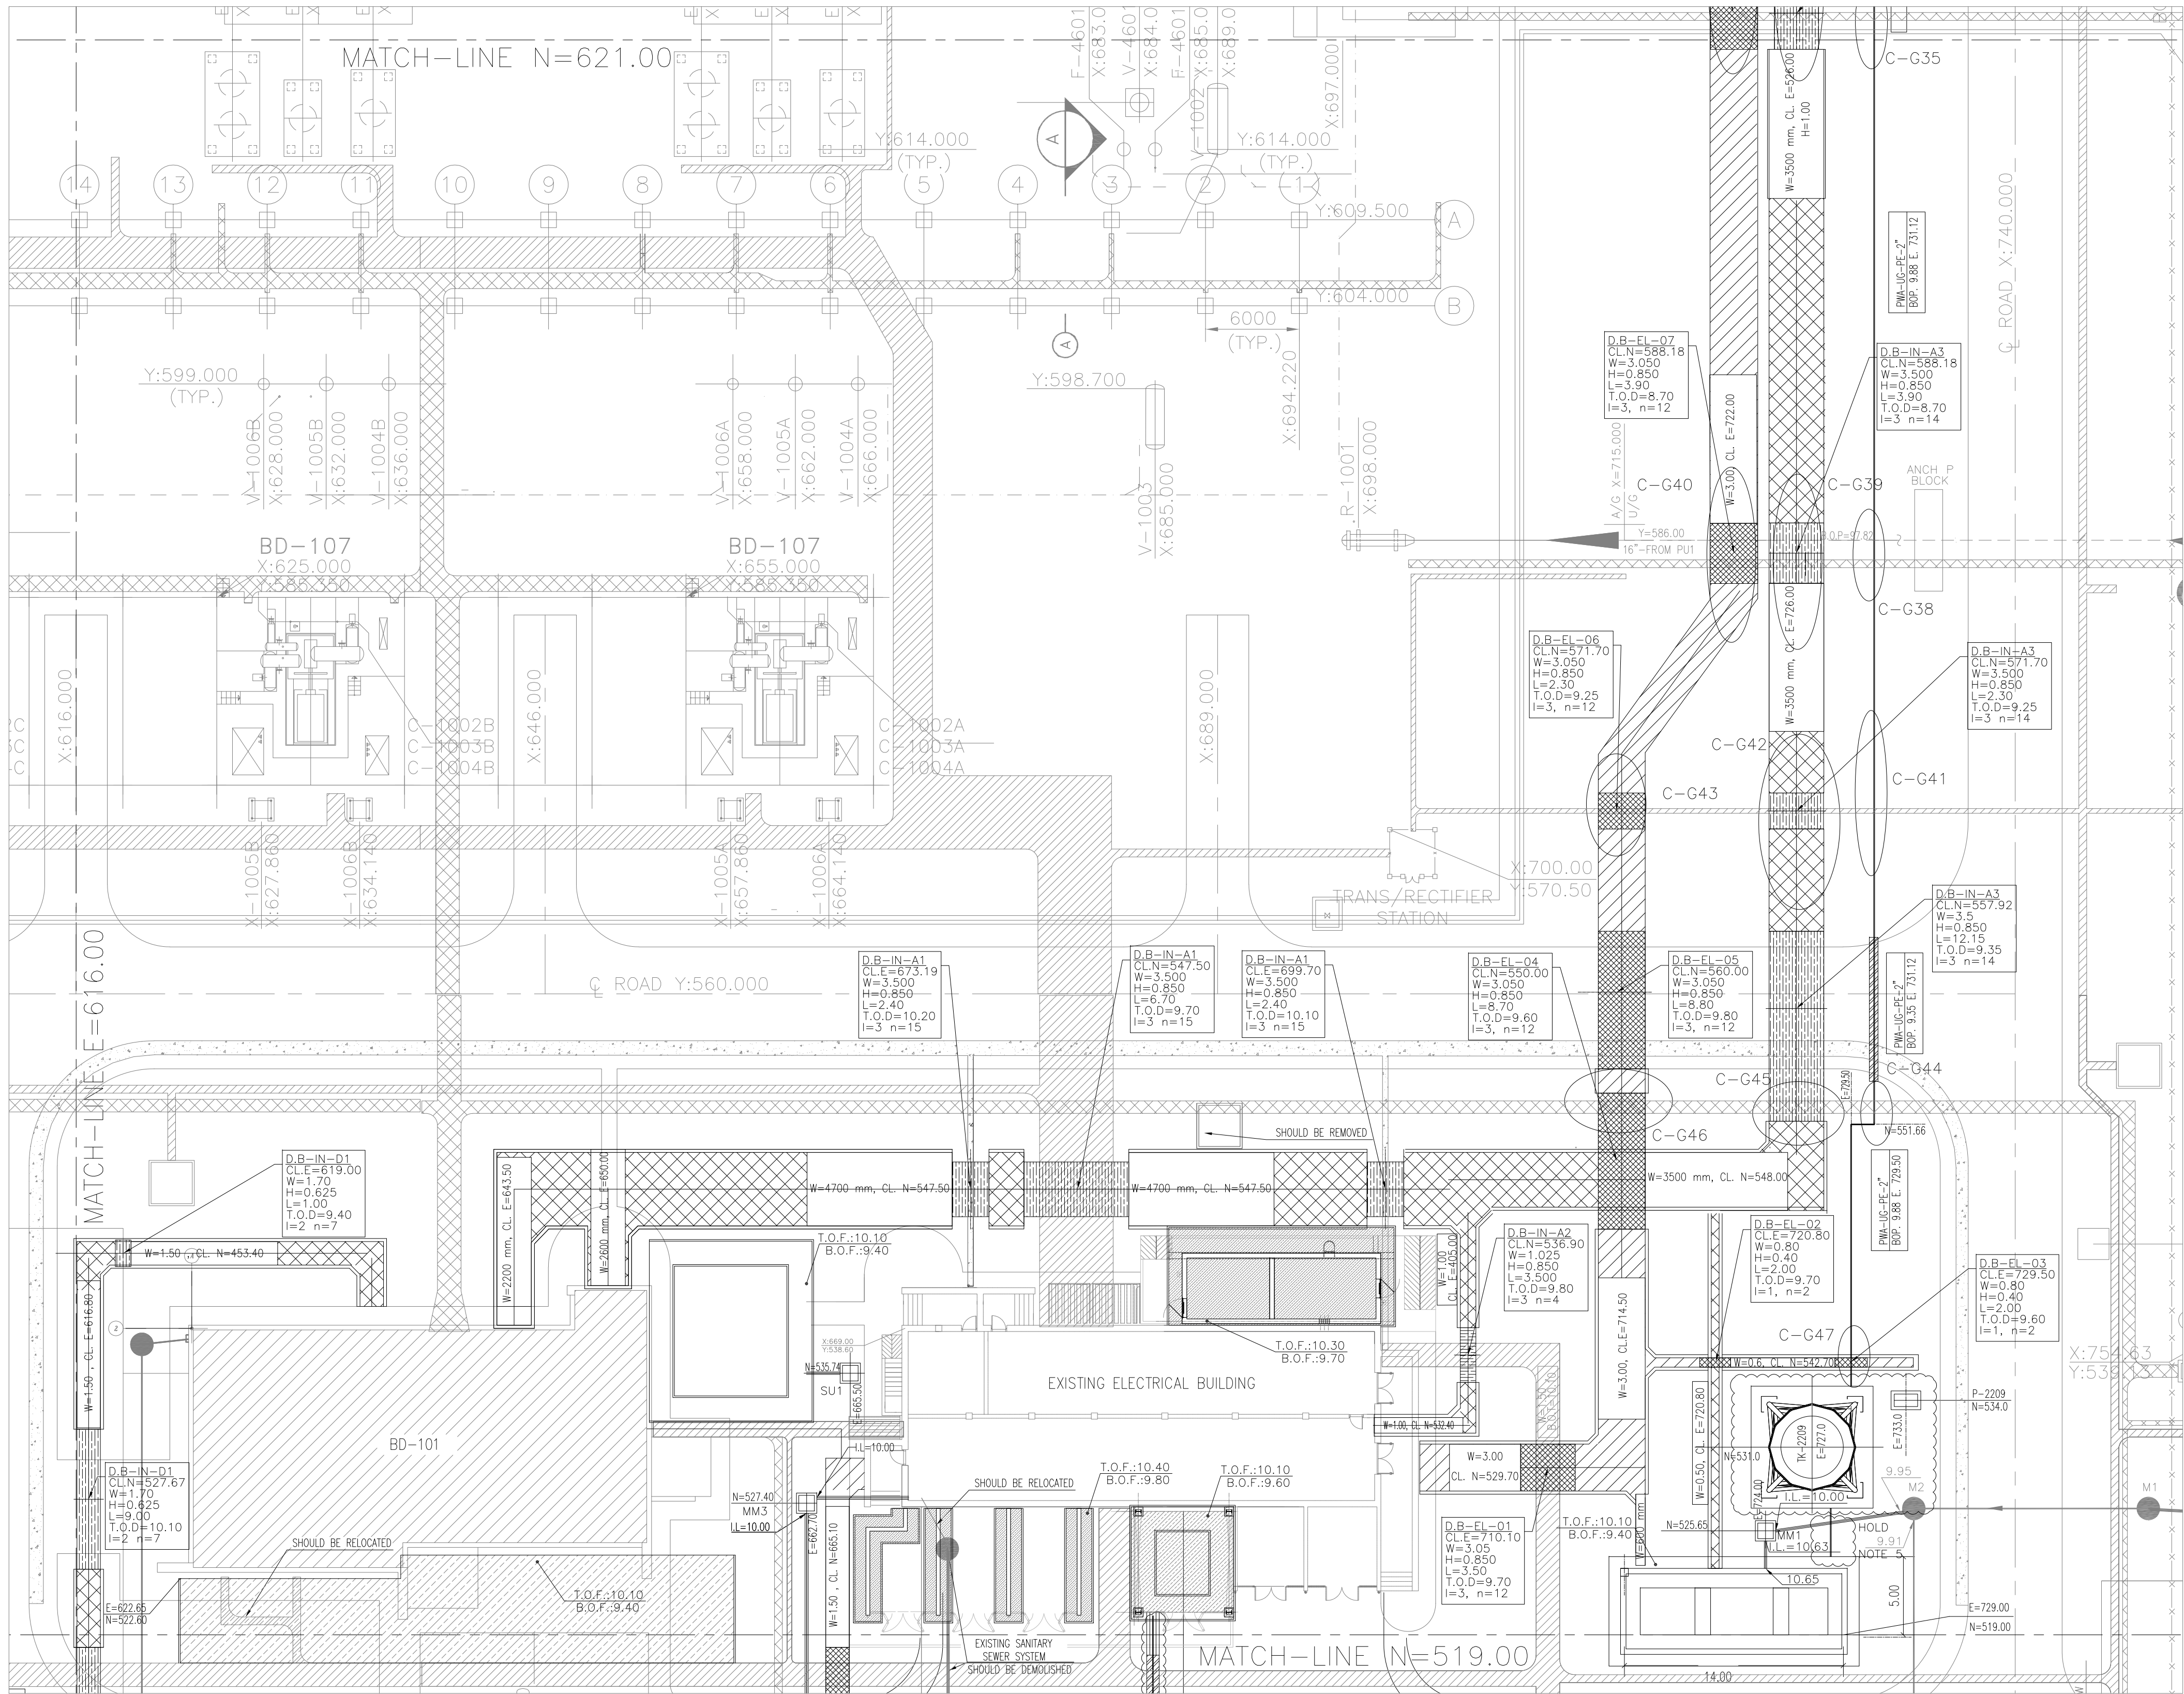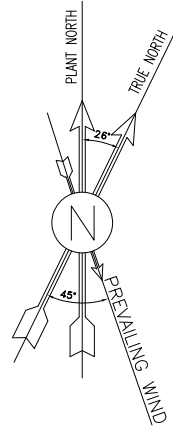

EXTENSION OF EXISTING BUILDINGS
SC.1:250


D03	NOV.2024	IPA	R.BERLOUIE	M.PAKHARIAN	M.SADIGHIAN	***						
D02	FEB.2024	IPA	R.BERLOUIE	M.PAKHARIAN	S.PARAMARZPOUR	***	***	*****	***	*****	***	
D01	OCT.2023	IPC	R.BERLOUIE	M.PAKHARIAN	S.PARAMARZPOUR	***	REV.	DESCRIPTION	BY	DATE	BY	
D00	FEB.2023	IPC	M.ASHARHIZAD	M.PAKHARIAN	SH.GHALIKAR	***					CHECKED	REV. APPR.
REV.	DATE	P.O.I.S	PREP.	CHK.	APP.	AUT.	اصل و کلیه نسخ این نقشه و حق اقتباس متعلق به شرکت ملی مناطق نفت خیز جنوب می باشد.					
PROJECT NAME:			BINAK OILFIELD DEVELOPMENT GENERAL			 THE ORIGINAL AND ALL COPIES OF THIS DRAWING TOGETHER WITH THE COPYRIGHT THEREIN ARE THE SOLE PROPERTY OF N.I.S.O.C./ FIELDS						
PROJECT NO.:			971020									
EPC CONTRACTOR:			EPD/EPC CONTRACTOR (GC):			BINAK OILFIELD DEVELOPMENT GENERAL						
 			 PETROIRAN DEVELOPMENT COMPANY									
HIRGAN ENERGY – DESIGN & INSPECTION COMPANIES			PEDCO			DATE SCALE DRAWING BY CHECKED BY PROJECT ENG.						
DRAWING TITLE:			PLANT UNDERGROUND COMPOSITE LAYOUT			NO CONSTRUCTION PERMITTED UNLESS DRAWING APPROVED						
						APPROVED FOR CONSTRUCTION BY: DATE:						
SCALE	SIZE	DRAWING NO.		SHEET NO.	REV.	BUDGET REF.	LOCATION	SIZE	CLASS	SERIAL NO.	SHEET	REVISION
1/250	A1	BK-GCS-PEDCO-120-CV-PY-0006		03 OF 06	D03	053-073-9184	F	4	S	709113	3	D03

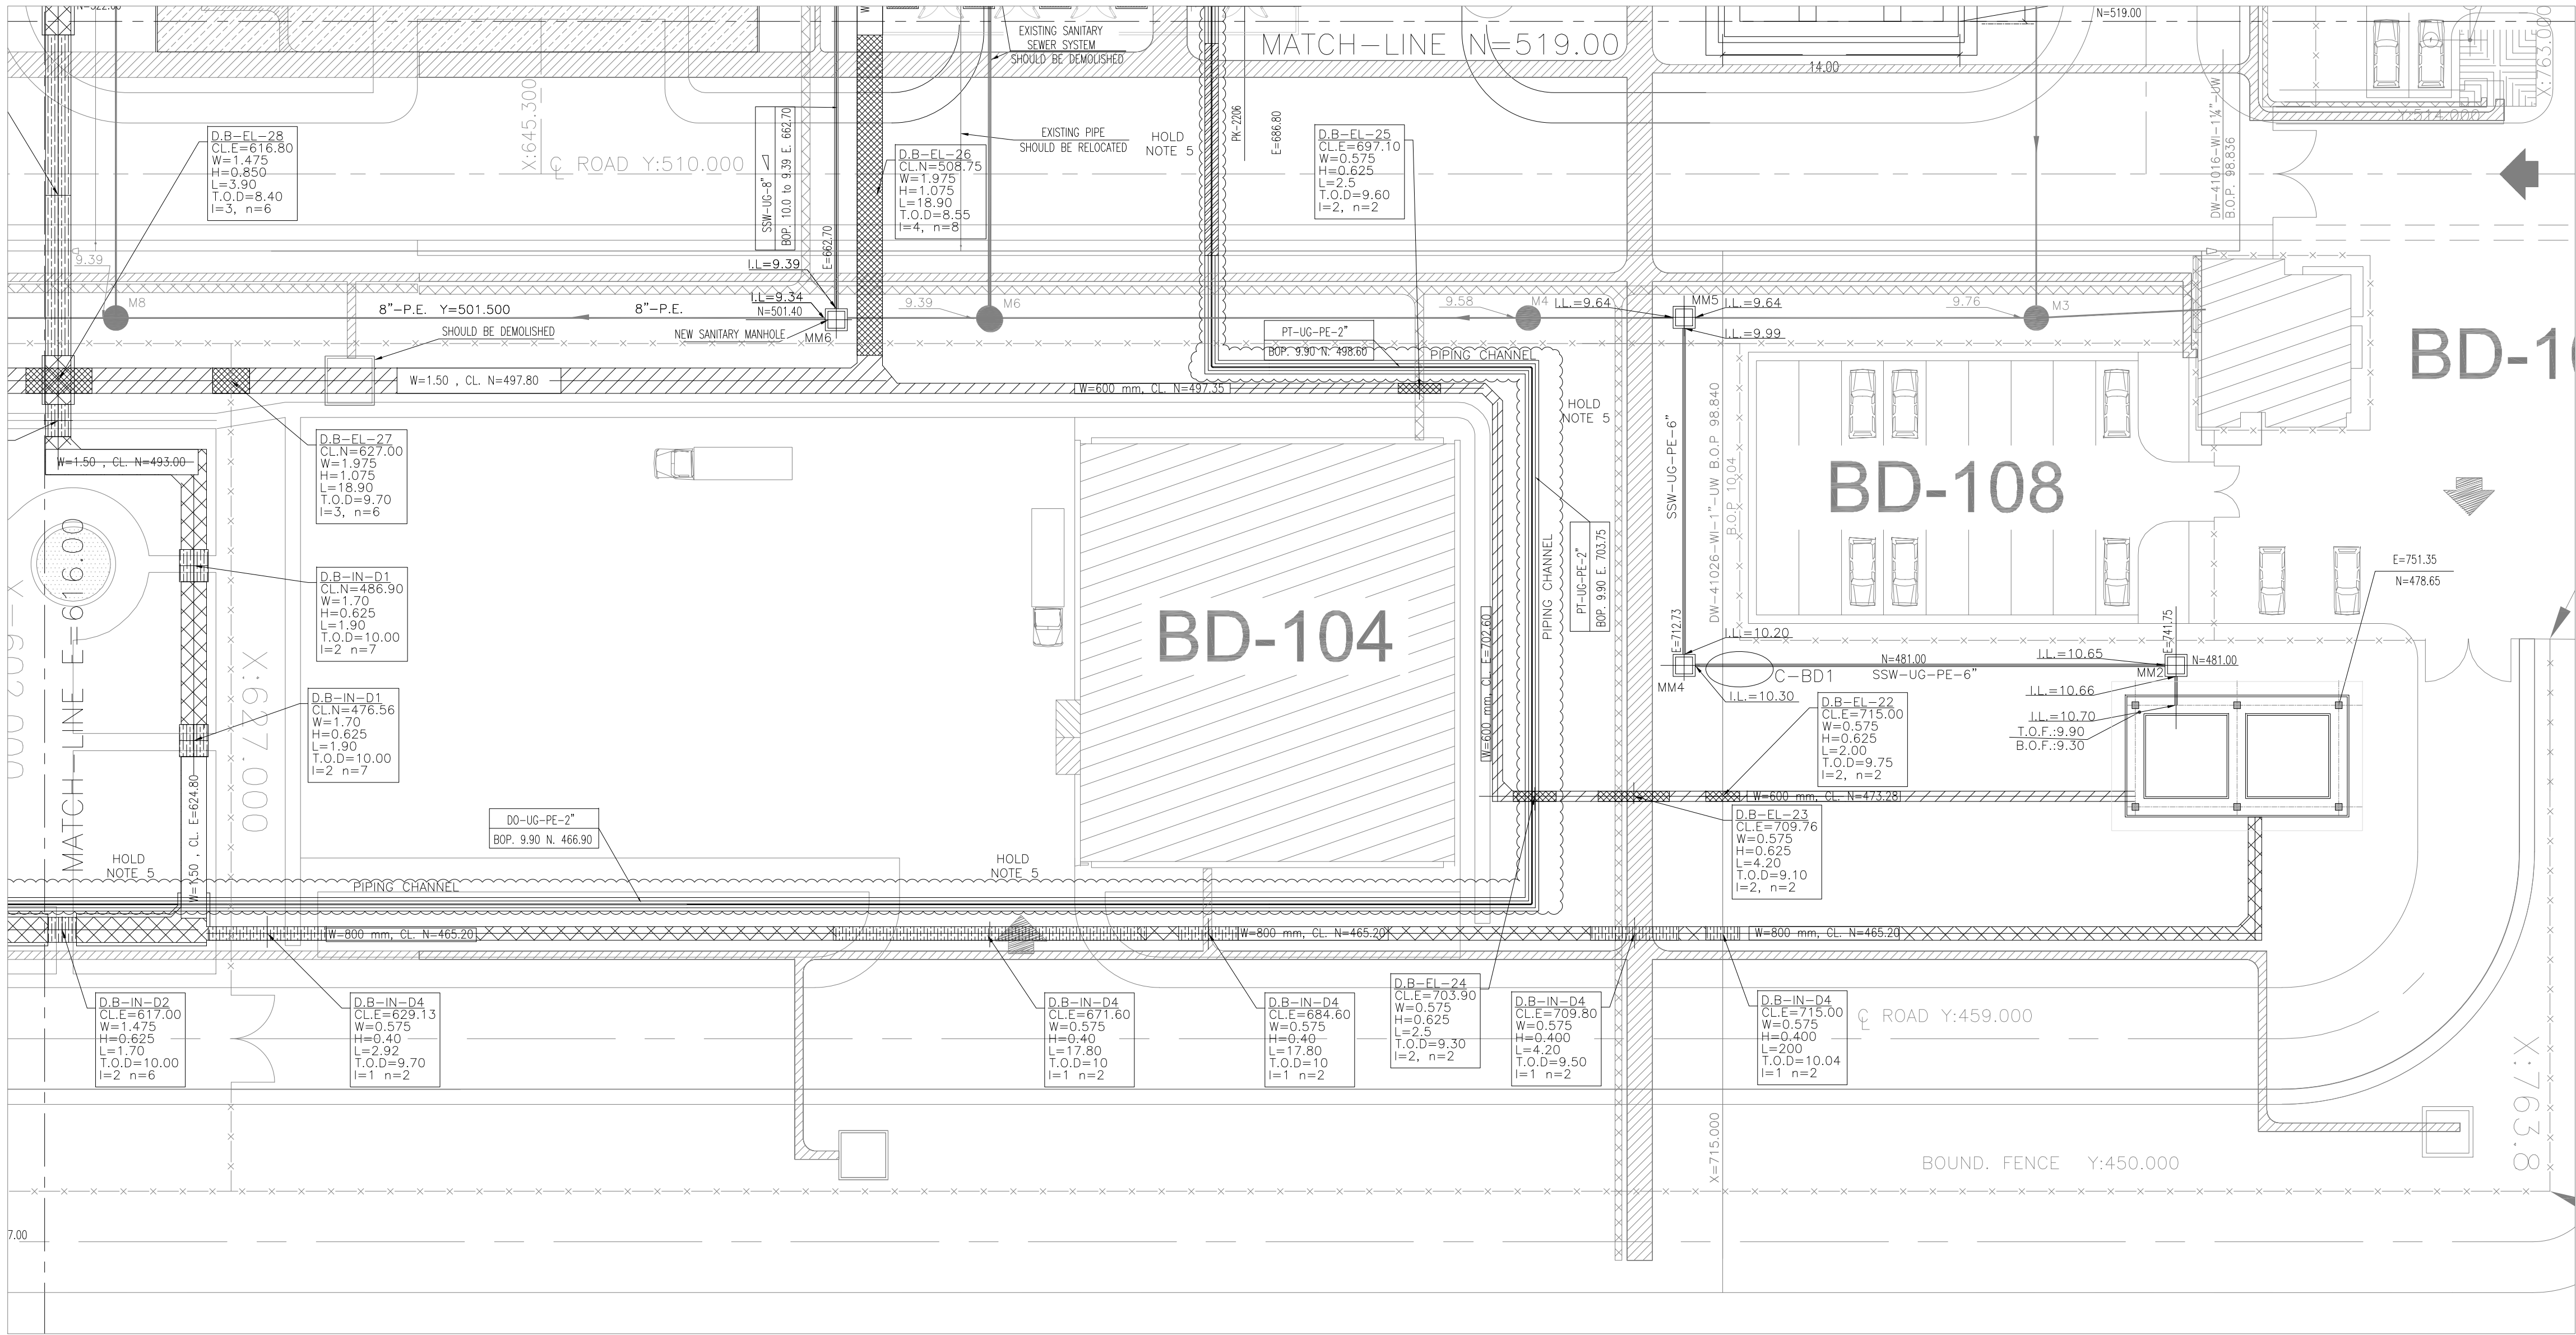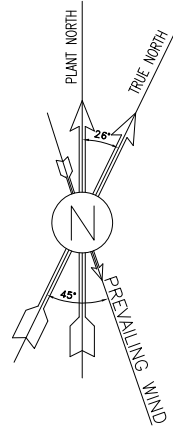

NOTES			
1. ALL COORDINATES AND ELEVATIONS ARE IN METERS.			
2. ALL COORDINATES ARE IN LOCAL SYSTEM., WITH REFERENCE TO SITE LOCAL DATUM POINT.			
	LOCAL	UTM	
A	E=500.000 N=500.000	E=437384.709 N=3289737.469	
B1	E=485.337 N=788.941 Z=12.170	E=437245.830 N=3289991.269 ELEV.=12.17	
B2	E=798.452 N=382.283 Z=13.410	E=437704.660 N=3289761.280 ELEV.=13.41	
3. ALL ELEVATION REFERENCES IS MEAN SEA LEVEL.			
4. ALL DIMENSIONS ARE IN MILLIMETERS UNLESS STATED OTHERWISE.			
5. SHALL BE FINALIZED LATER.			
6. SHALL BE FINALIZED AFTER RECEIVING APPROVED VENDOR DATA			

LEGEND			
	FIRE SHED		GRAVITY PIPE SLOPE DIRECTION
	DUCT BANK		NEW PIPE
	DELUGE VALVE		BEARING SLAB
	BERRIED ELECTRICAL TRENCH		NEW ELECTRICAL DUCT BANK
	BERRIED INSTRUMENT TRENCH		NEW INSTRUMENT DUCT BANK
	CONCRETE ELECTRICAL TRENCH		FOUNDATION
	CONCRETE INSTRUMENT TRENCH		CROSSING POINTS
	EXISTING ELECTRICAL TRENCH		SANITARY MANHOLE
	EXISTING INSTRUMENT TRENCH		VALVE PIT
	MAT FOUNDATION		NEW LIGHTING TOWER
	EXISTING LIGHTING FOUNDATION		EXISTING FENCE
	NEW FENCE		GRAVITY PIPE INSTRUMENT ELECTRICAL FIRE WATER UNDER GROUND POLYETHYLENE SANITARY PIPE DUCT BANK FINISHED GRADE
B.O.P.	BOTTOM OF PIPE	GRA	GRAVITY PIPE
B.O.T.	BOTTOM OF TRENCH	IN	INSTRUMENT
T.O.D.	TOP OF DUCT BANK	EL	ELECTRICAL
B.O.F.	BOTTOM OF FOUNDATION	FWA	FIRE WATER
H.P.P.	HIGH POINT OF PAVING	UG	UNDER GROUND
H.P.G.	HIGH POINT OF GRAVEL	PE	POLYETHYLENE
REL	ROAD ELEVATION	SA	SANITARY PIPE
		D.B.	DUCT BANK
		F.G.	FINISHED GRADE



REFERENCE DRAWING	DRG. No.
SPECIFICATION FOR ROAD & PAVING	BK-GNRL-PEDCO-000-CV-SP-0002
STANDARD DRAWING FOR ROADS	BK-GNRL-PEDCO-000-CV-DW-0003
STANDARD DRAWING FOR PAVINGS	BK-GNRL-PEDCO-000-CV-DW-0035
UNIT PLOT PLAN DRAWING	BK-GCS-PEDCO-120-PI-PY-0001
ROUGH GRADING PLAN & DETAILS	BK-GCS-PEDCO-120-CV-PY-0007
BINAK NEW COMPRESSOR GAS STATION PLOT PLAN (BASIC PACKAGE)	1560-BK-NCS-PI-DWG-0001
DIRE WALL DRAWING FOR LEAN GLYCOL STORAGE TANK (TK-2102)	BK-GCS-PEDCO-120-ST-DW-0033
FOUNDATION DRAWING FOR GLYCOL SUMP PIT (SU-2101)	BK-GCS-PEDCO-120-ST-DW-0035
AREA ELECTRICAL CABLE ROUTE & SECTION LAYOUT	BK-GCS-PEDCO-120-EL-PY-0005
INSTRUMENT/F&G CABLE TRENCH/ROUTE LAYOUT DRAWING	BK-GCS-PEDCO-120-IN-PY-0004
UG PIPING PLAN	BK-GCS-PEDCO-120-PI-DW-0005
ROAD, PAVING AND PLANT FINISH GRADING LAYOUT & SECTIONS	BK-GCS-PEDCO-120-CV-PY-0005
OIL CONTAMINATED WATER SYSTEM LAYOUT	BK-GCS-PEDCO-120-CV-PY-0003
PLANT CLEAN WATER DRAINAGE SYSTEM LAYOUT & DETAILS	BK-GCS-PEDCO-120-CV-PY-0004
STANDARD DRAWING FOR ELECTRICAL CABLE TRENCH	BK-GNRL-PEDCO-000-CV-DW-0004
STANDARD DRAWING FOR SEWERAGE & DRAINAGE DETAILS	BK-GNRL-PEDCO-000-CV-DW-0007
STANDARD DRAWING FOR CIVIL UNDERGROUND CROSSING	BK-GNRL-PEDCO-000-CV-DW-0008
PIPELINE STANDARD DRAWING FOR COVER SLABS AND SET-ON-WEIGHT	BK-GNRL-PEDCO-000-PL-DW-0013

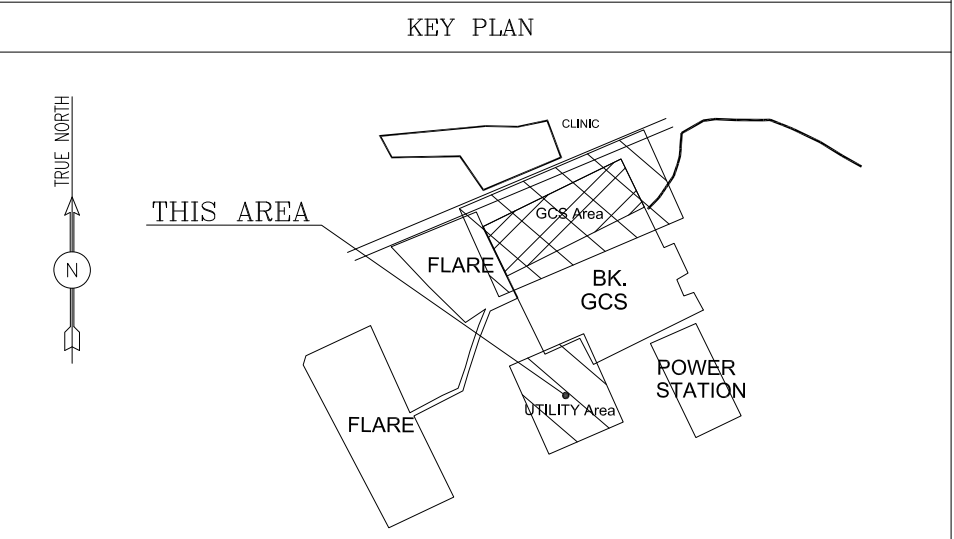


NEW CCTV ROOM

SC.1:250

D03	NOV.2024	IPA	R.BERLOUIE	M.PAKHARIAN	M.SADIGHIAN	***					
D02	FEB.2024	IPA	R.BERLOUIE	M.PAKHARIAN	S.PARAMARZPOUR	***					
D01	OCT.2023	IPC	R.BERLOUIE	M.PAKHARIAN	S.PARAMARZPOUR	***					
D00	FEB.2023	IPC	M.ASHGHARIZAD	M.PAKHARIAN	SH.GHALIKAR	***					
REV.	DATE	P.O.I.S	PREP.	CHK.	APP.	AUT.	DESCRIPTION	BY	DATE	BY	DATE
PROJECT NAME: BINAK OILFIELD DEVELOPMENT GENERAL							THE ORIGINAL AND ALL COPIES OF THIS DRAWING TOGETHER WITH THE COPYRIGHT THEREIN ARE THE SOLE PROPERTY OF N.I.S.O.C./ FIELDS				
PROJECT NO.: 971020							NO CONSTRUCTION PERMITTED UNLESS DRAWING APPROVED				
EPC CONTRACTOR: HIRGAN ENERGY							BINA OILFIELD DEVELOPMENT GENERAL				
EPD/EPC CONTRACTOR (GC): PETROIRAN DEVELOPMENT COMPANY							DATE	SCALE	DRAWING BY	CHECKED BY	PROJECT ENG.
DRAWING TITLE: PLANT UNDERGROUND COMPOSITE LAYOUT							APPROVED FOR CONSTRUCTION				
SCALE	SIZE	DRAWING NO.		SHEET NO.	REV.	BUDGET REF.	LOCATION	SIZE CLASS	SERIAL NO.	SHEET	REVISION
1/250	A1	BK-GCS-PEDCO-120-CV-PY-0006		04 OF 06	D03	053-073-9184	F	4	S	709113	D03

















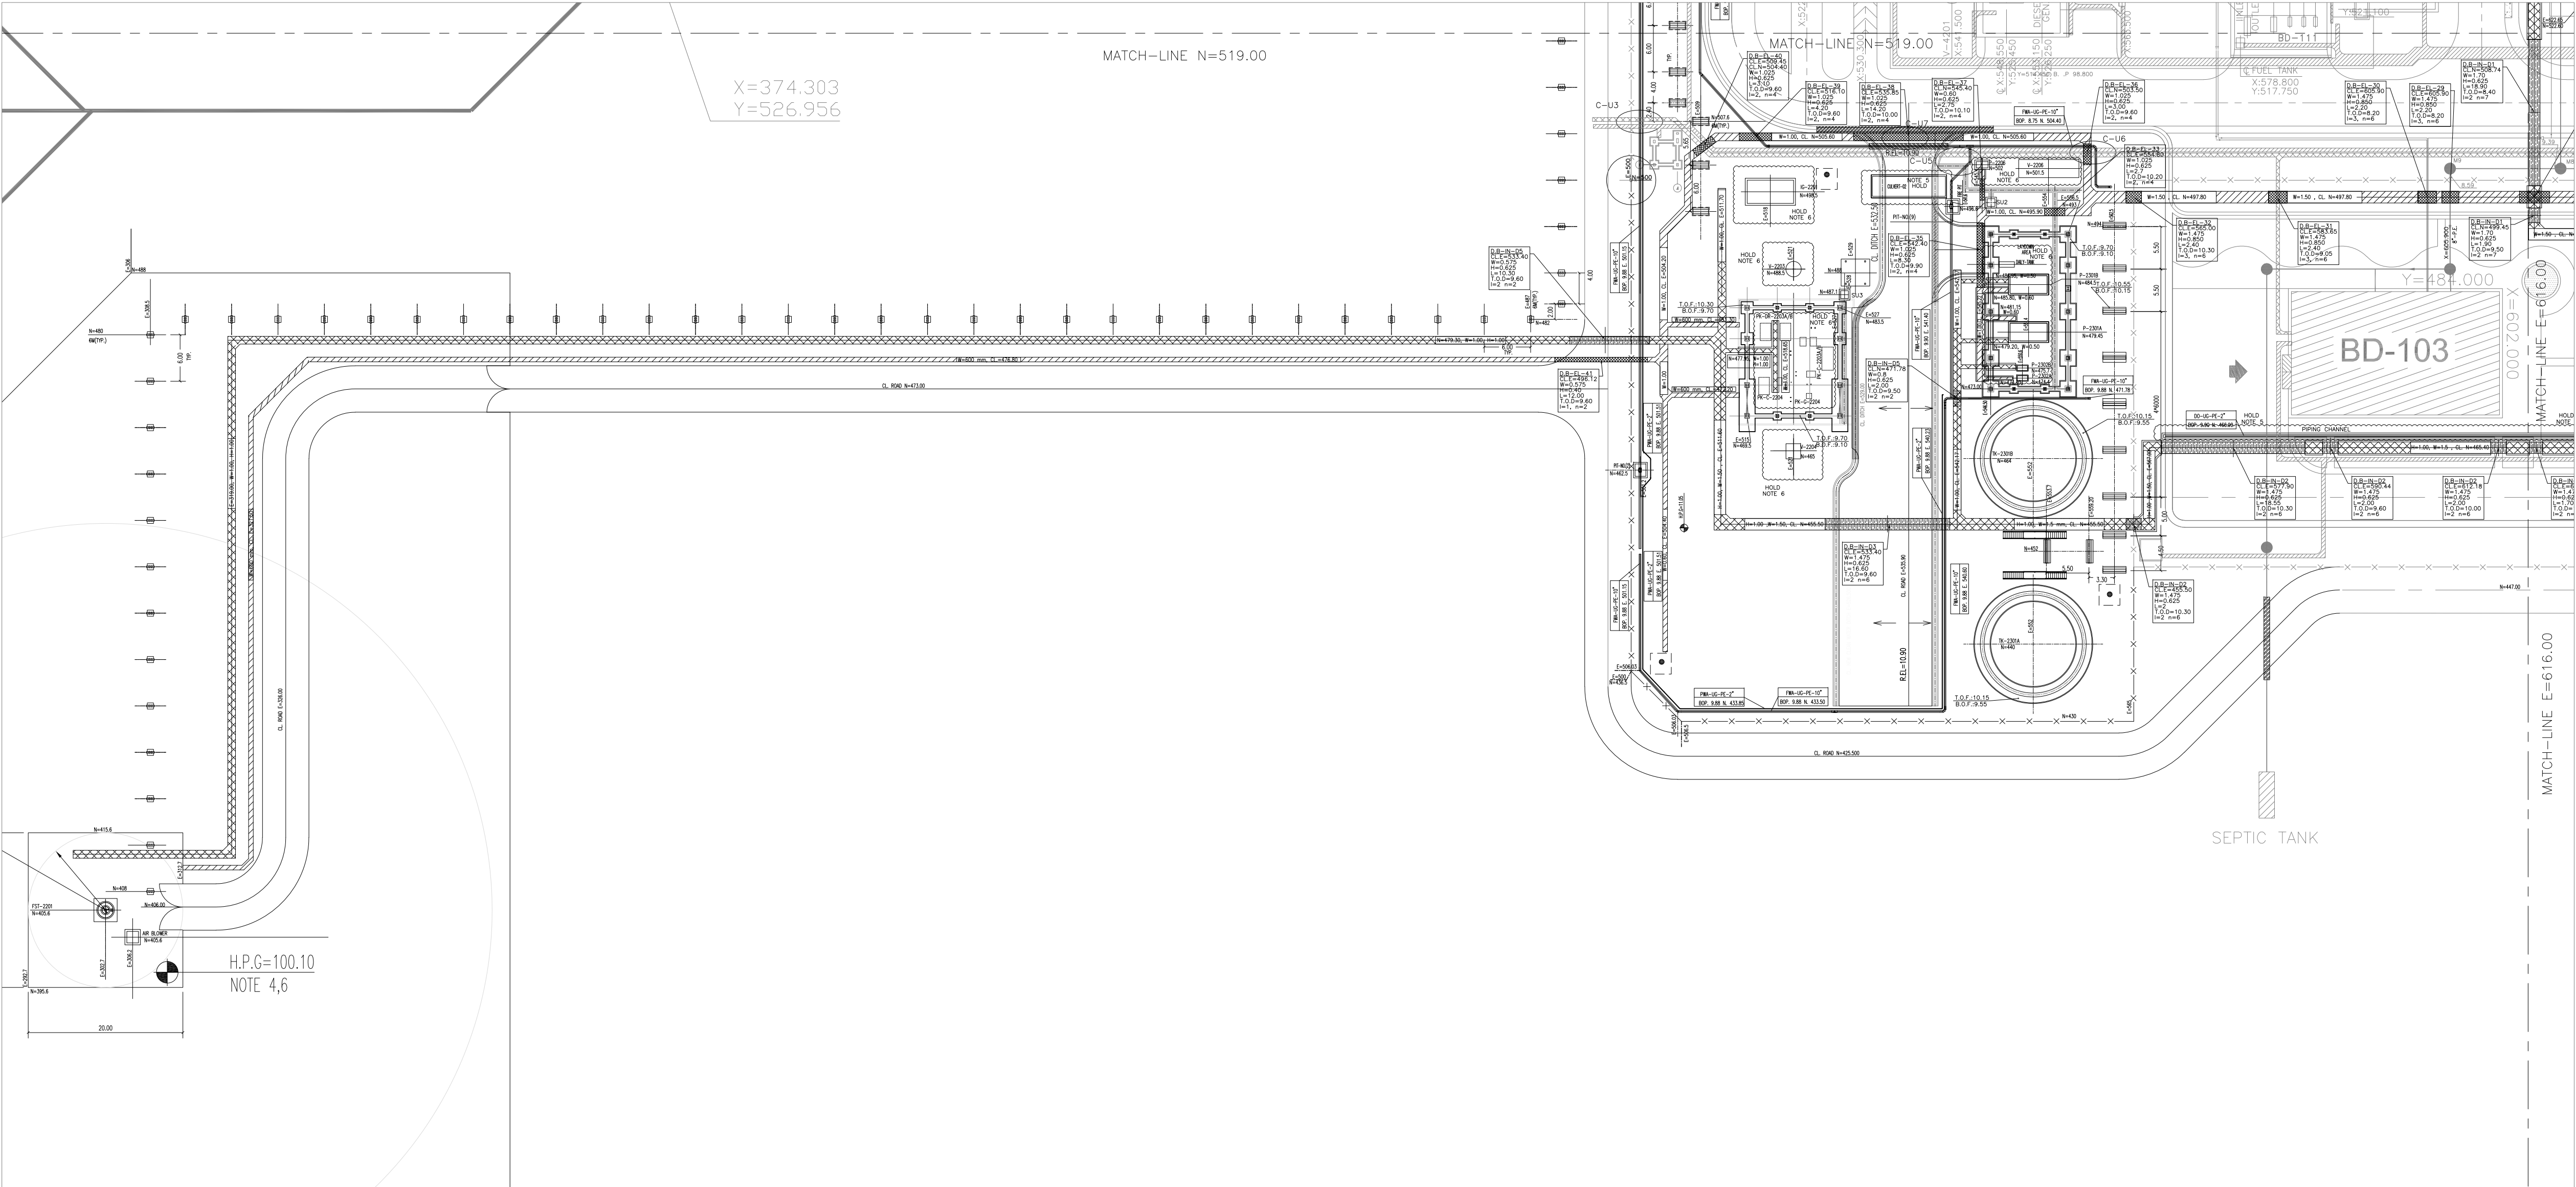
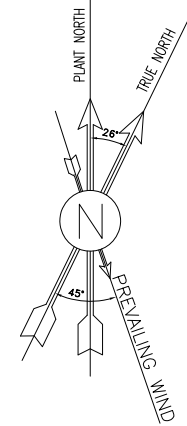


UTILITY AREA
SC.1:250

 D03	NOV. 2024	IFA	R.BERLOUIE	M.PAKHARIAN	M.SADIGHIAN	***							
D02	FEB. 2024	IFA	R.BERLOUIE	M.PAKHARIAN	S.PARAMARZPOUR	***	***	*****	***	*****	***	*****	*****
D01	OCT. 2023	IFC	R.BERLOUIE	M.PAKHARIAN	S.PARAMARZPOUR	***	REV.	DESCRIPTION	BY	DATE	BY	DATE	
D00	FEB. 2023	IFC	M.ASHGARNEJAD	M.PAKHARIAN	SH.GHALIKAR	***			CHECKED		REV. APPR.		
REV.	DATE	P.O.I.S	PREP.	CHK.	APP.	AUT.	اصل و کليه نسخ این نقشه و حق اقتباس متعلق به شرکت ملی مناطق نفت خیز جنوب می باشد.						
PROJECT NAME:			BINAK OILFIELD DEVELOPMENT GENERAL			 THE ORIGINAL AND ALL COPIES OF THIS DRAWING TOGETHER WITH THE COPYRIGHT THEREIN ARE THE SOLE PROPERTY OF N.I.S.O.C./ FIELDS							
PROJECT NO.:			971020										
EPC CONTRACTOR:			EPD/EPC CONTRACTOR (GC):			BINAK OILFIELD DEVELOPMENT GENERAL							
 HIRGAN ENERGY – DESIGN & INSPECTION COMPANIES			 PEDCO			 PETROIRAN DEVELOPMENT COMPANY							
						DATE		SCALE	DRAWING BY	CHECKED BY	PROJECT ENG.		
DRAWING TITLE:						NO CONSTRUCTION PERMITTED UNLESS DRAWING APPROVED							
PLANT UNDERGROUND COMPOSITE LAYOUT						APPROVED FOR CONSTRUCTION		BY:		DATE:			
SCALE	SIZE	DRAWING NO.			SHEET NO.	REV.	BUDGET REF.	LOCATION	SIZE	CLASS	SERIAL NO.	SHEET	REVISION
1/250	A1	BK-GCS-PEDCO-120-CV-PY-0006			05 OF 06	D03	053-073-9184	F	4	S	709113	5	D03


- NOTES
- ALL COORDINATES AND ELEVATIONS ARE IN METERS.
 - ALL COORDINATES ARE IN LOCAL SYSTEM., WITH REFERENCE TO SITE LOCAL DATUM POINT.

LOCAL	UTM
E=500.000 A N=500.000	E=437384.709 N=3289737.469
E=485.337 B1 N=788.941 Z=12.170	E=437245.830 N=3289991.269 ELEV.=12.17
E=798.452 B2 N=382.283 Z=13.410	E=437704.660 N=3289761.280 ELEV.=13.41
 - ALL ELEVATION REFERENCES IS MEAN SEA LEVEL.
 - ALL DIMENSIONS ARE IN MILLIMETERS UNLESS STATED OTHERWISE.
 - SHALL BE FINALIZED LATER.
 - SHALL BE FINALIZED AFTER RECEIVING APPROVED VENDOR DATA

                  LEGEND	
	
	
	
	
	
	
	
	
	
	
	
	
	

B.O.P	GRA	GRA	GRA
B.O.T	EL	EL	EL
T.O.D	FWA	FWA	FWA
B.O.F	UG	UG	UG
H.P.P	PE	PE	PE
H.P.G	SA	SA	SA
REL	D.B	D.B	D.B
	F.G	F.G	F.G

REFERENCE DRAWING	DRG. No.
SPECIFICATION FOR ROAD & PAVING	BK-GNRL-PEDCO-000-CV-SP-0002
STANDARD DRAWING FOR ROADS	BK-GNRL-PEDCO-000-CV-DW-0003
STANDARD DRAWING FOR PAVINGS	BK-GNRL-PEDCO-000-CV-DW-0035
UNIT PLOT PLAN DRAWING	BK-GCS-PEDCO-120-PI-PY-0001
ROUGH GRADING PLAN & DETAILS	BK-GCS-PEDCO-120-CV-PY-0007
BINAK NEW COMPRESSOR GAS STATION PLOT PLAN (BASIC PACKAGE)	1560-BK-NCS-PI-DWG-0001
DIKE WALL DRAWING FOR LEAN GLYCOL STORAGE TANK (TK-2102)	BK-GCS-PEDCO-120-ST-DW-0033
FOUNDATION DRAWING FOR GLYCOL SUMP PIT (SU-2101)	BK-GCS-PEDCO-120-ST-DW-0035
AREA ELECTRICAL CABLE ROUTE & SECTION LAYOUT	BK-GCS-PEDCO-120-EL-PY-0005
INSTRUMENT/F&G CABLE TRENCH/ROUTE LAYOUT DRAWING	BK-GCS-PEDCO-120-IN-PY-0004
UG PIPING PLAN	BK-GCS-PEDCO-120-PI-DW-0005
ROAD, PAVING AND PLANT FINISH GRADING LAYOUT & SECTIONS	BK-GCS-PEDCO-120-CV-PY-0005
OIL CONTAMINATED WATER SYSTEM LAYOUT	BK-GCS-PEDCO-120-CV-PY-0003
PLANT CLEAN WATER DRAINAGE SYSTEM LAYOUT & DETAILS	BK-GCS-PEDCO-120-CV-PY-0004
STANDARD DRAWING FOR ELECTRICAL CABLE TRENCH	BK-GNRL-PEDCO-000-CV-DW-0004
STANDARD DRAWING FOR SEWERAGE & DRAINAGE DETAILS	BK-GNRL-PEDCO-000-CV-DW-0007
STANDARD DRAWING FOR CIVIL UNDERGROUND CROSSING	BK-GNRL-PEDCO-000-CV-DW-0008
PIPELINE STANDARD DRAWING FOR COVER SLABS AND SET-ON-WEIGHT	BK-GNRL-PEDCO-000-PL-DW-0013

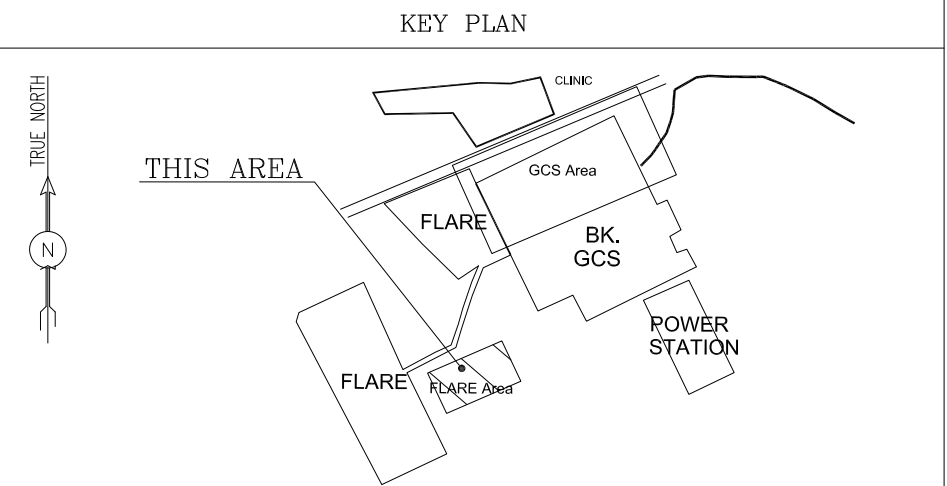

اصل و کلیه نسخ این نقشه و حق اقتباس متعلق به شرکت ملی مناطق نفت خیز جنوب میباشد.
THE ORIGINAL AND ALL COPIES OF THIS DRAWING TOGETHER WITH THE COPYRIGHT THEREIN ARE THE SOLE PROPERTY OF N.I.S.O.C./ FIELDS

BINAK OILFIELD DEVELOPMENT GENERAL				
DATE	SCALE	DRAWING BY	CHECKED BY	PROJECT ENG.
NO CONSTRUCTION PERMITTED UNLESS DRAWING APPROVED				
APPROVED FOR CONSTRUCTION		BY:	DATE:	
BUDGET REF.	LOCATION	SIZE CLASS	SERIAL NO.	SHEET REVISION

NOTES			
1.	ALL COORDINATES AND ELEVATIONS ARE IN METERS.		
2.	ALL COORDINATES ARE IN LOCAL SYSTEM., WITH REFERENCE TO SITE LOCAL DATUM POINT.		
	LOCAL	UTM	
A	E=500.000 N=500.000	E=437384.709 N=3289737.469	
B1	E=485.337 N=788.941 Z=12.170	E=437245.830 N=3289991.269 ELEV.=12.17	
B2	E=798.452 N=382.283 Z=13.410	E=437704.660 N=3289761.280 ELEV.=13.41	
3.	ALL ELEVATION REFERENCES IS MEAN SEA LEVEL.		
4.	ALL DIMENSIONS ARE IN MILLIMETERS UNLESS STATED OTHERWISE.		
5.	SHALL BE FINALIZED LATER.		
6.	SHALL BE FINALIZED AFTER RECEIVING APPROVED VENDOR DATA		

LEGEND

	FIRE SHED		GRAVITY PIPE SLOPE DIRECTION
	DUCT BANK		NEW PIPE
	BERRIED ELECTRICAL TRENCH		DELUGE VALVE
	BERRIED INSTRUMENT TRENCH		BEARING SLAB
	CONCRETE ELECTRICAL TRENCH		NEW ELECTRICAL DUCT BANK
	CONCRETE INSTRUMENT TRENCH		NEW INSTRUMENT DUCT BANK
	EXISTING ELECTRICAL TRENCH		FOUNDATION
	EXISTING INSTRUMENT TRENCH		CROSSING POINTS
	MAT FOUNDATION		SANITARY MANHOLE
	EXISTING LIGHTING FOUNDATION		VALVE PIT
			NEW LIGHTING TOWER
			EXISTING FENCE
			NEW FENCE
B.O.P	BOTTOM OF PIPE	GRA	GRAVITY PIPE
T.O.D	TOP OF DUCT BANK	IN	INSTRUMENT
B.O.F	BOTTOM OF FOUNDATION	EL	ELECTRICAL
H.P.P	HIGH POINT OF PAWING	FW	FIRE WATER
H.P.C	HIGH POINT OF GRAVEL	LWC	UNDER GROUND
R.E.L	ROAD ELEVATION	PE	POLYETHYLENE
		SA	SANITARY PIPE
		D.B	DUCT BANK
		F.G	FINISHED GRADE

REFERENCE DRAWING	DRG. No.
SPECIFICATION FOR ROAD & PAVING	BK-GNRL-PEDCO-000-CV-DP-0002
STANDARD DRAWING FOR ROADS	BK-GNRL-PEDCO-000-CV-DW-0003
STANDARD DRAWING FOR PAVINGS	BK-GNRL-PEDCO-000-CV-DW-0035
UNIT PLOT PLAN DRAWING	BK-GCS-PEDCO-120-PI-PY-0001
ROUGH GRADING PLAN & DETAILS	BK-GCS-PEDCO-120-CV-PY-0007
BIKAK NEW COMPRESSOR GAS STATION PLOT PLAN (BASIC PACKAGE)	1560-BK-NCS-PI-DWG-0001
FOUR WALL DRAWING FOR LEAN GLYCOL STORAGE TANK (TK-2102)	BK-GCS-PEDCO-120-ST-DW-0033
FOUNDATION DRAWING FOR LYLCO SUMP PIT (SU-2101)	BK-GCS-PEDCO-120-ST-DW-0035
AREA ELECTRICAL CABLE ROUTE & SECTION LAYOUT	BK-GCS-PEDCO-120-EL-PY-0005
INSTRUMENT/F&G CABLE TRENCH/ROUTE LAYOUT DRAWING	BK-GCS-PEDCO-120-IN-PY-0004
UG PIPING PLAN	BK-GCS-PEDCO-120-CV-DW-0005
ROAD, PAVING AND PLANT FINISH GRADING LAYOUT & SECTIONS	BK-GCS-PEDCO-120-CV-PY-0005
OIL CONTAMINATED WATER SYSTEM LAYOUT	BK-GCS-PEDCO-120-CV-PY-0003
PLANT CLEAN WATER DRAINAGE SYSTEM LAYOUT & DETAILS	BK-GCS-PEDCO-120-CV-PY-0004
STANDARD DRAWING FOR ELECTRICAL CABLE TRENCH	BK-GNRL-PEDCO-000-CV-DW-0004
STANDARD DRAWING FOR SEWERAGE & DRAINAGE DETAILS	BK-GNRL-PEDCO-000-CV-DW-0007
STANDARD DRAWING FOR CIVIL UNDERGROUND CROSSING	BK-GNRL-PEDCO-000-CV-DW-0006
PIPELINE STANDARD DRAWING FOR COVER SLABS AND SET-ON-WEIGHT	BK-GNRL-PEDCO-000-PL-DW-0013

KEY PLAN									
***	*****			***	****	***	***		***
REV.	DESCRIPTION			BY	DATE	BY	DATE		
				CHECKED		REV. APPR.			
اصل و کلیه نسخ این نقشه و حق اقتباس متعلق به شرکت ملی مناطق نفت خیز جنوب میباشد. THE ORIGINAL AND ALL COPIES OF THIS DRAWING TOGETHER WITH THE COPYRIGHT THEREIN ARE THE SOLE PROPERTY OF N.I.S.O.C./ FIELDS									
BINAK OILFIELD DEVELOPMENT GENERAL									
DATE		SCALE		DRAWING BY		CHECKED BY		PROJECT ENG.	
NO CONSTRUCTION PERMITTED UNLESS DRAWING APPROVED									
APPROVED FOR CONSTRUCTION				BY:		DATE:			
BUDGET REF.		LOCATION		SIZE CLASS		SERIAL NO.		SHEET REVISION	
053-073-9184		F		4 S		709113		6 D03	

[illegible]