


SU-2202
OILY WATER SUMP

DIMENSION (H X W X L) : 3000 X 4000 X 3000 mm
TRIM LINE : TRM-SU-2202-0501-AN01-PT

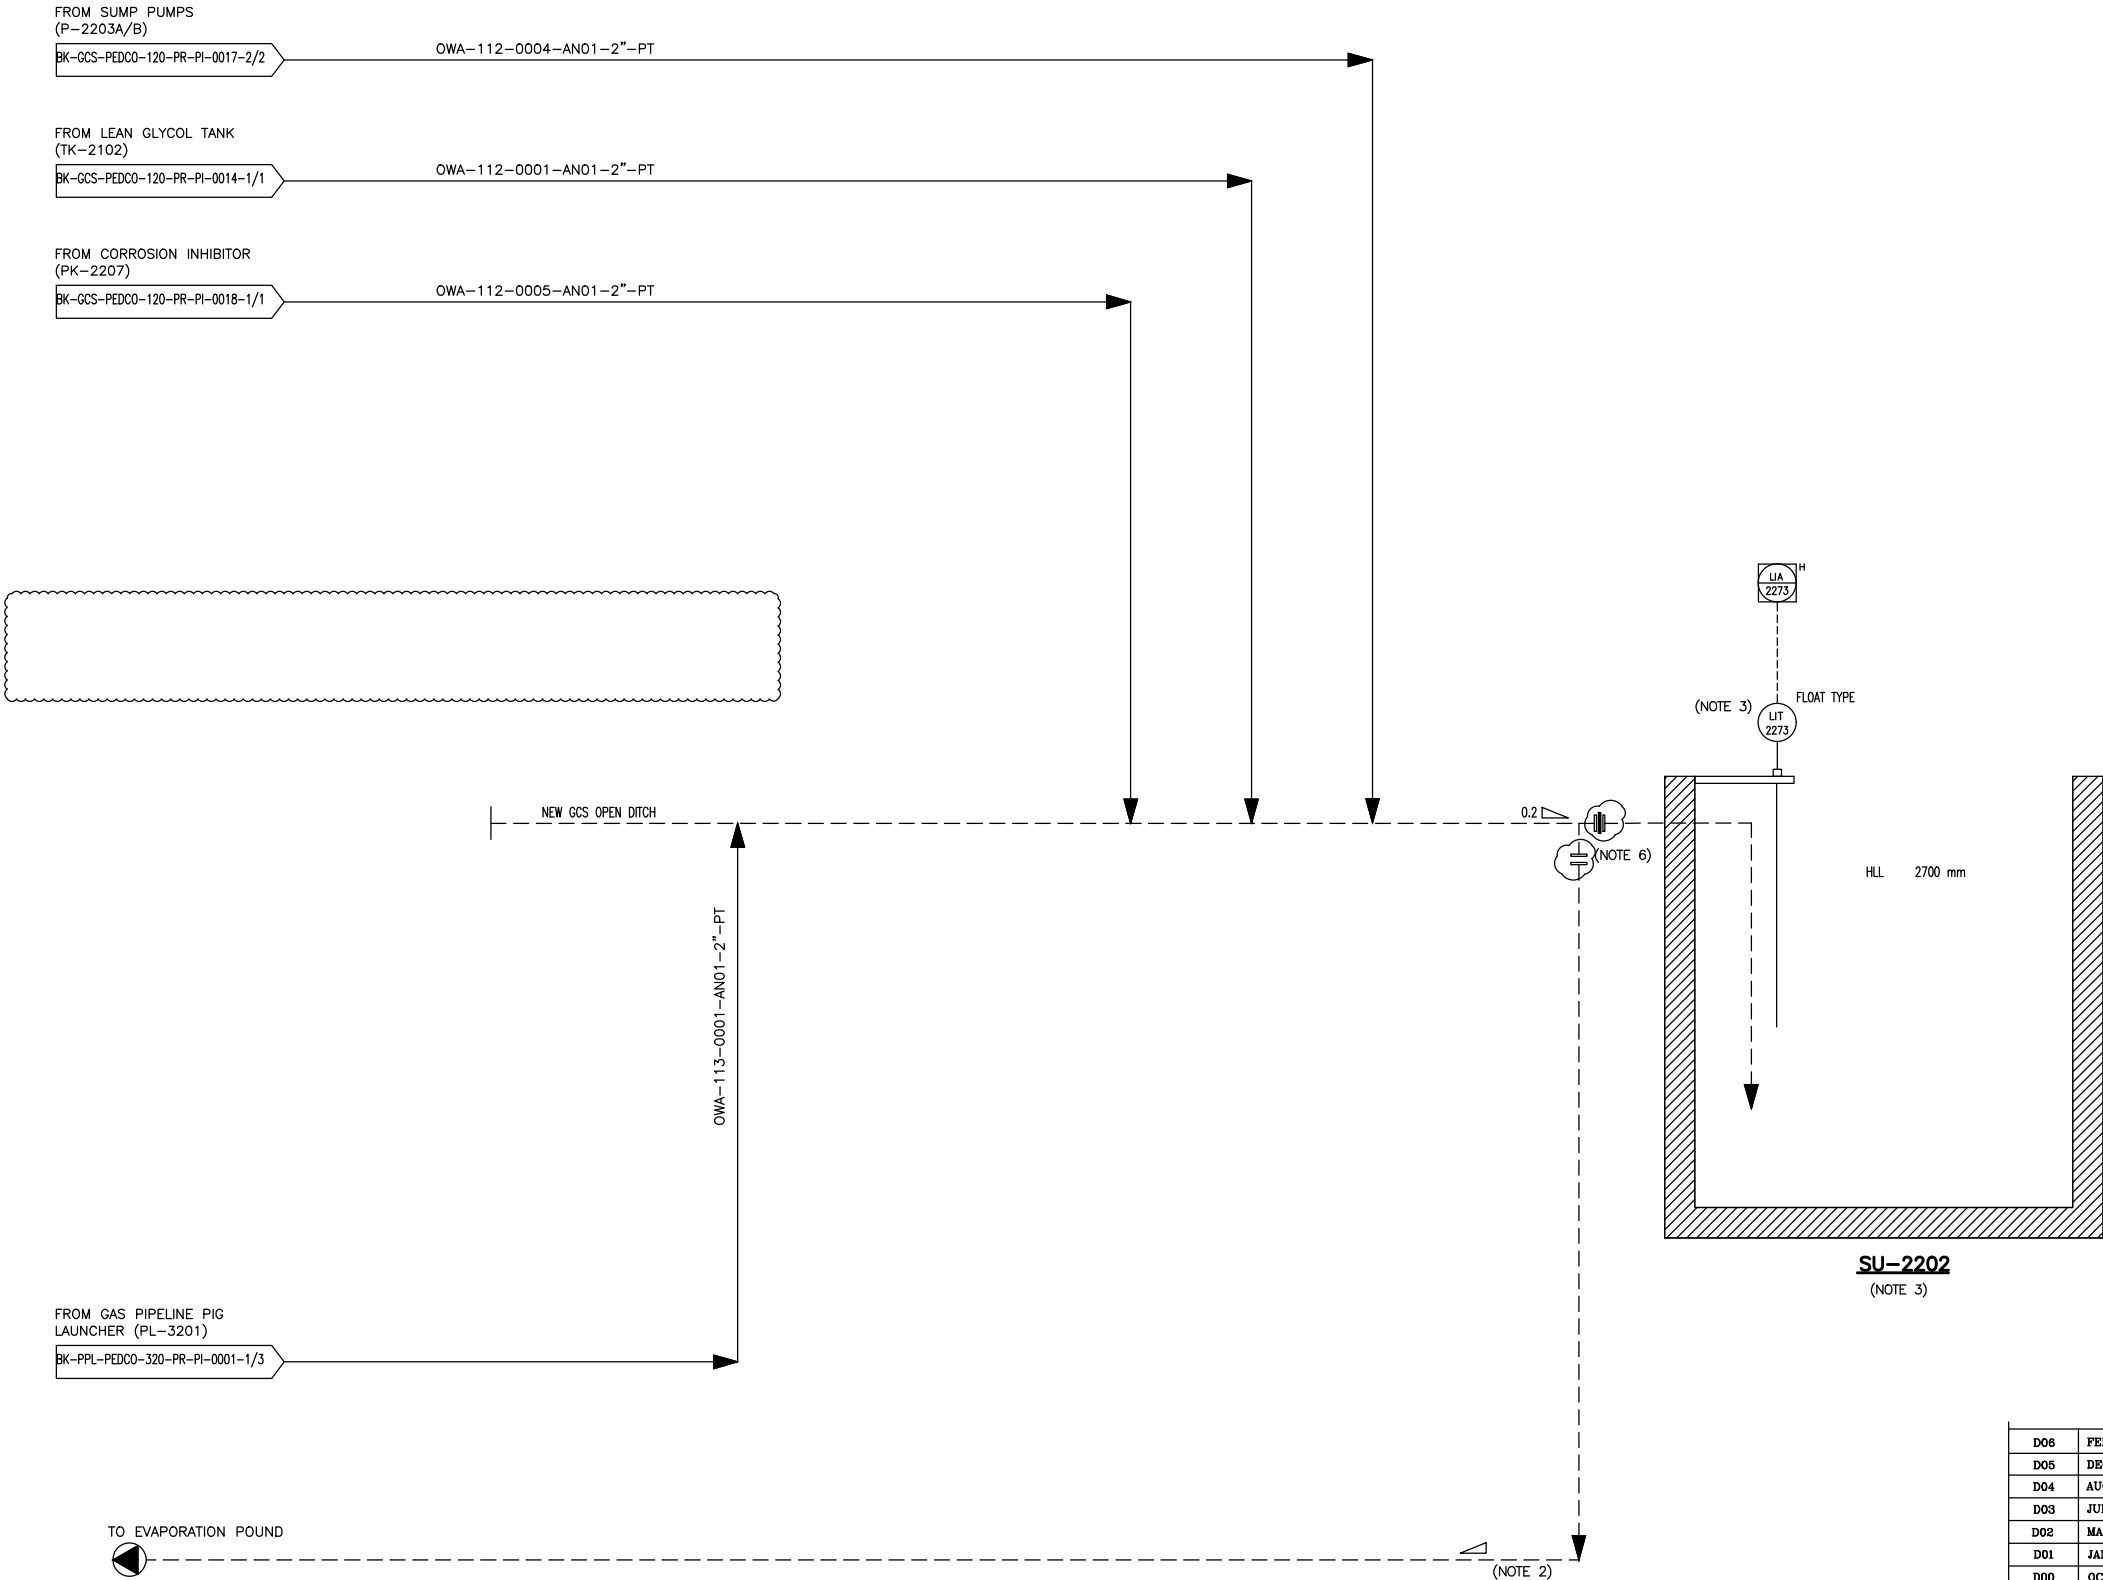

NOTES

- 1-DELETED.
- 2- IT IS ASSUMED THAT OILY WATER FROM PAVING AREA SHALL BE ROUTED TO NON-CONTAMINATED SEWER AFTER 15 MINUTES OF RAIN.
- 3- SU-2202 WILL BE UNLOADED BY PORTABLE PUMP (OUT OF SCOPE).
- 4- TOP MOUNTED FLOAT LEVEL TRANSMITTER WILL BE INSTALLED ON A PLATE AT SUMP GROUND LEVEL)NO PIPING CONNECTION REQUIRED.)
- 5-DELETED.
- 6- STOP GATE WILL BE CONSTRUCTED AT SITE

GENERAL NOTE

LEGEND

REFERENCE DRAWING	DRG. No.
Utility Flow Diagram	BK-GCS-PEDCO-120-PR-UP-0001
Symbol & Legend For PFD & P&ID	BK-GCS-PEDCO-120-PR-PI-0001

KEY PLAN

D06	FEB.2025	APC	M.ARYAPAR	M.PAKHARIAN	S.PARHAMZADEPOUR	** **
D05	DEC.2022	APC	M.ARYAPAR	M.PAKHARIAN	M.MEHRSHAD	** **
D04	AUG.2022	IPA	M.ARYAPAR	M.PAKHARIAN	M.MEHRSHAD	** **
D03	JUN.2022	IPA	M.ARYAPAR	M.PAKHARIAN	M.MEHRSHAD	** **
D02	MAR.2022	IPA	M.ARYAPAR	M.PAKHARIAN	M.MEHRSHAD	** **
D01	JAN.2022	IPA	M.ARYAPAR	M.PAKHARIAN	M.MEHRSHAD	** **
D00	OCT.2021	IPC	M.ARYAPAR	M.PAKHARIAN	M.MEHRSHAD	** **
REV.	DATE	P.O.I.S	PREP.	CHK.	APP.	AUT.

PROJECT NAME: BINAK OILFIELD DEVELOPMENT/SURFACE FACILITIES GAS COMPRESSOR STATION

PROJECT NO.: 971020

EPC CONTRACTOR:	EPD/EPC CONTRACTOR (GC):
 HURGAN ENERGY - DESIGN & INSPECTION COMPANIES	 PETROIRAN DEVELOPMENT COMPANY

DRAWING TITLE:					
P&ID - OILY WATER SEWER					
SCALE	SIZE	DRAWING NO.	SHEET NO.	REV.	
NS	A3	BK-GCS-PEDCO-120-PR-PI-0021	1 OF 1	D06	053-073-9184

اسم و کلیه نسخ این نقشه و حق اقتباس متعلق به شرکت ملی مناطق نفت خیز جنوب میباشد.

THE ORIGINAL AND ALL COPIES OF THIS DRAWING TOGETHER WITH THE COPYRIGHT THEREIN ARE THE SOLE PROPERTY OF N.I.S.O.C./ FIELDS



BINAK OILFIELD DEVELOPMENT SURFACE FACILITIES GAS COMPRESSOR STATION					
DATE	SCALE	DRAWING BY	CHECKED BY	PROJECT ENG.	
NO CONSTRUCTION PERMITTED UNLESS DRAWING APPROVED					
APPROVED FOR CONSTRUCTION			BY:	DATE:	
BUDGET REF.	LOCATION	SIZE CLASS	SERIAL NO.	SHEET	REVISION
053-073-9184	F	2	A	708799	1 OF 1 D06