

(NOTE 1,3)


IRP-1201

IRP-1201
SUCKER ROD PUMP (IRP)
(BY VENDOR)

ST-1201

ST-1201
STONE TRAP


DESIGN PRESS. : 3000 PSIA
DESIGN TEMP. : 105 °C

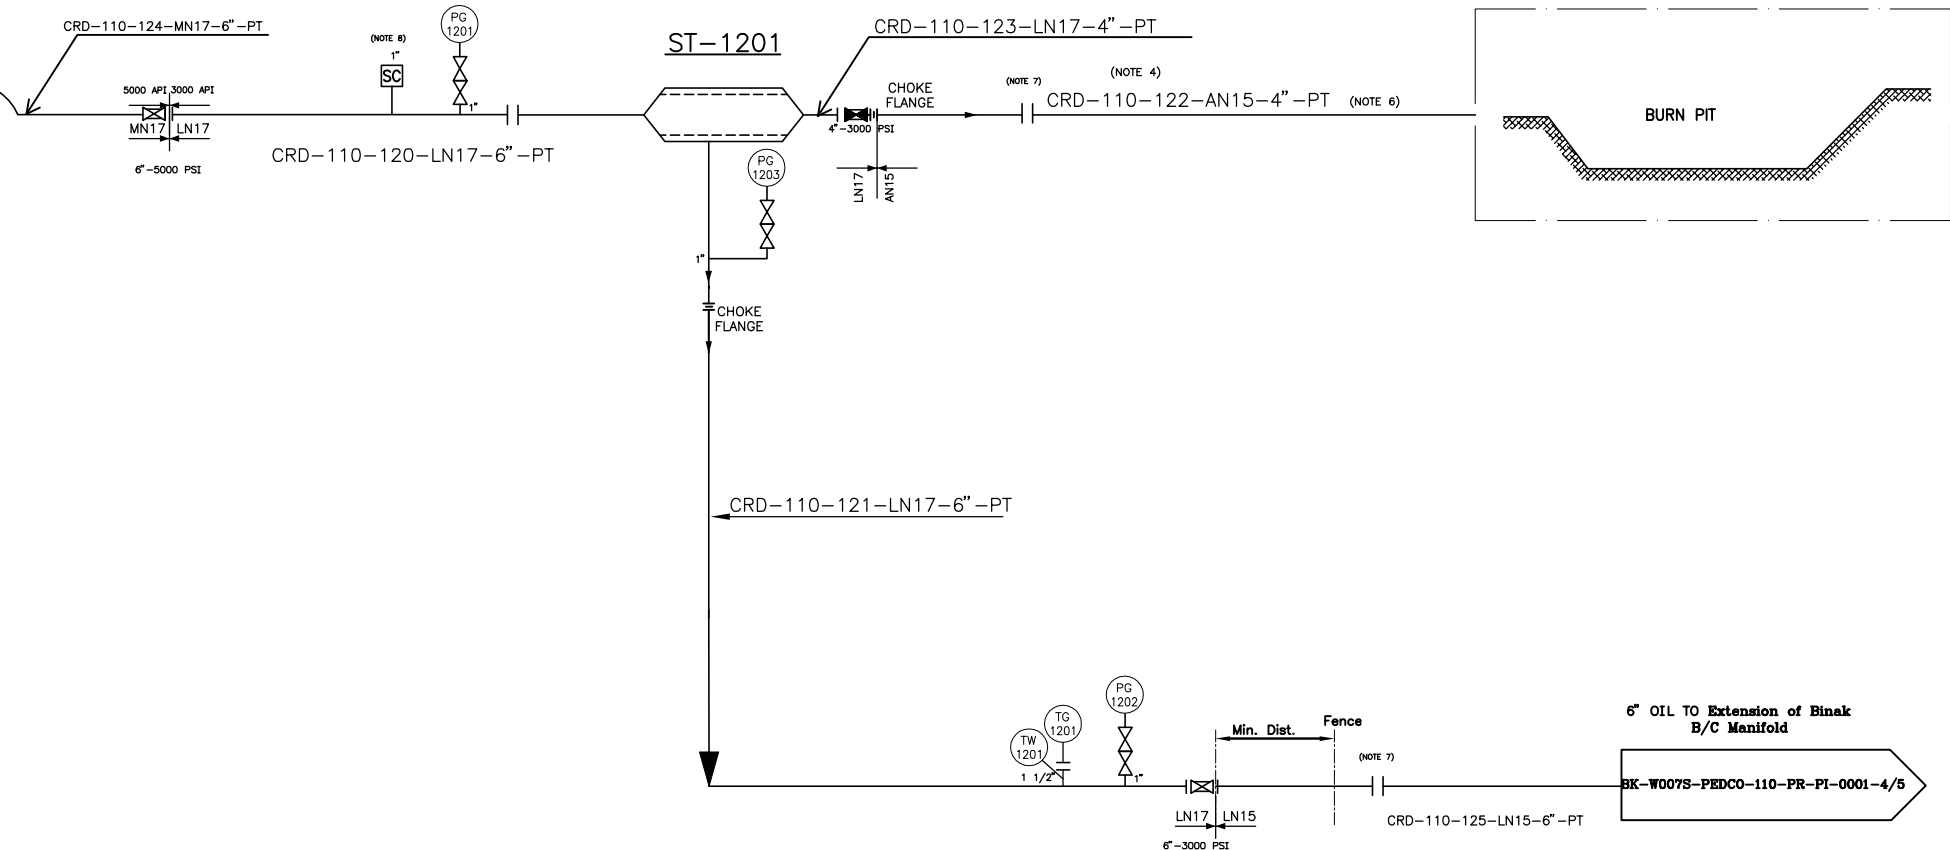

NOTES

1. EQUIPMENT & PACKAGES ARE TO BE INSTALLED OUTSIDE THE SAFETY RADIUS OF X-MASS TREE.
2. DELETED.
3. THE CONTROL AND PROTECTION OF WELLHEAD FACILITIES MUST BE CONSIDERED BY PUMP VENDOR.
4. PAINTING IS NOT NECESSARY FOR PIPES THAT LOCATED OUTSIDE OF FENCE.
5. FOR INSTRUMENT CONNECTION REFER TO INSTRUMENT HOOK UP DIAGRAM.
6. ACCORDING TO THE GRADIENT OF THE BURN PIT PIPELINE, IT IS CONSIDERED ONE LOCAL DRAIN IN THE WELL PAD AREA.
7. ACCORDING TO STANDARD DRAWING (SLS9002), THESE FLANGES ARE 3000 API.
8. A 1" BLIND CONNECTION SHOULD BE CONSIDERED ON SC.

LEGEND

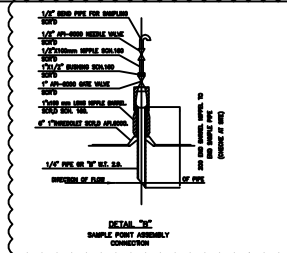

REFERENCE DRAWING

DRG. No.

Symbol & Legend For PFD and P&ID	BK-SSGR-PEDCO-110-PR-PI-000
Process Basis Of Design	BK-GNRL-PEDCO-000-PR-DB-000
Production Facilities Standard Drawing	SSL8002




KEY PLAN

D06	MAY.2023	IPA	M.ARYAFAR	M.PAKHARIAN	M.MEHRSHAD	00.00
D05	FEB.2023	IPA	M.ARYAFAR	M.PAKHARIAN	M.MEHRSHAD	00.00
D04	SEP.2022	IPA	M.ARYAFAR	M.PAKHARIAN	M.MEHRSHAD	00.00
D03	FEB.2022	IPA	M.ARYAFAR	M.PAKHARIAN	M.MEHRSHAD	00.00
D02	DEC.2021	IPA	M.ARYAFAR	M.PAKHARIAN	M.MEHRSHAD	00.00
D01	OCT.2021	IPC	M.ARYAFAR	M.PAKHARIAN	M.MEHRSHAD	00.00
D00	AUG.2021	IPC	M.ARGHARNEZIAN	M.PAKHARIAN	SH.CHAHRKAR	00.00
REV.	DATE	P.O.L	PREP.	CHK.	APP.	AUT.

اصل و کليه نسخ این نقشه و حق اقتباس متعلق به شرکت ملی مناطق نفت خیز جنوب میباشد.

THE ORIGINAL AND ALL COPIES OF THIS DRAWING TOGETHER WITH
THE COPYRIGHT THEREIN ARE THE SOLE PROPERTY OF
N.I.S.O.C./ FIELDS

PROJECT NAME:	BINAK OILFIELD DEVELOPMENT/SUB-SURFACE WORK PACKAGES W007S WHF & EXTENSION OF BINAK B/C
PROJECT NO.:	971020

<p>EPC CONTRACTOR:</p> <div style="display: flex; align-items: center; justify-content: center;">   </div> <p>HIRGAN ENERGY - DESIGN & INSPECTION COMPANIES</p>	<p>EPD/EPC CONTRACTOR (GC):</p> <div style="display: flex; align-items: center; justify-content: center;">  <div style="margin-left: 20px;"> <p>PETROIRAN DEVELOPMENT COMPANY</p> </div> </div> <p>PEDCO</p>
---	--

	BINAK OILFIELD DEVELOPMENT SUB-SURFACE WORK PACKAGES W007S WELLHEAD FACILITIES
--	--

DATE	SCALE	DRAWING BY	CHECKED BY	PROJECT ENG

NO CONSTRUCTION PERMITTED UNLESS DRAWING APPROVED		
APPROVED FOR CONSTRUCTION	BY:	DATE:

APPROVED FOR CONSTRUCTION				BT.	DATE.	
BUDGET REF.	LOCATION	SIZE	CLASS	SERIAL NO.	SHEET	REVISION

(VENDOR TITLE BLOCK)**

DRAWING TITLE:	P&ID - W007S
----------------	--------------

SCALE	SIZE	DRAWING NO.	SHEET NO.	REV.
AS SHOWN	A	10-11-12-13-99-100	1	1

F2A-707924	F	2	A	707924	1	D08
------------	---	---	---	--------	---	-----