


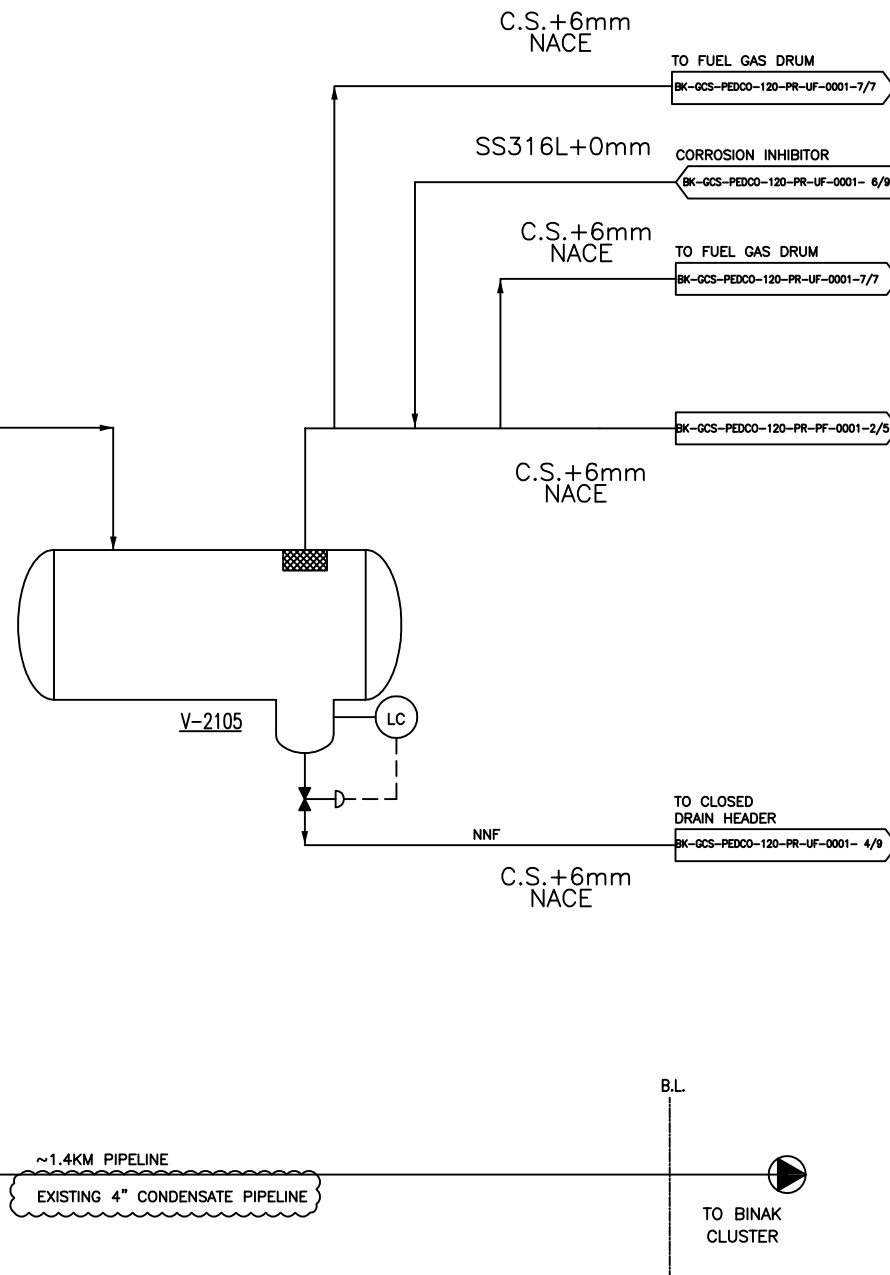


(VENDOR TITLE BLOCK)**

NOTES	
1- WALL THICKNESS SHALL BE IN ACCORDANCE WITH WALL THICKNESS CALCULATION REPORT.	
LEGEND	
REFERENCE DRAWING	DRG. No.
Symbol & Legend For PFD and P&ID	BK-GHRAI-PEDCO-000-FR-P1-0001
Piping Corrosion Study & Material Selection Report	BK-GCS-PEDCO-180-FR-RT-0001
Process Flow Diagram (PFD)	BK-GCS-PEDCO-180-FR-PF-0001
P&ID - BINAQ Gas Compression STATION	BK-GCS-PEDCO-180-FR-P1-0008-0019
P&ID - Fuel Gas System	BK-GCS-PEDCO-180-FR-P1-0028

NOTES

1 - WALL THICKNESS SHALL BE IN ACCORDANCE WITH WALL THICKNESS CALCULATION REPORT.

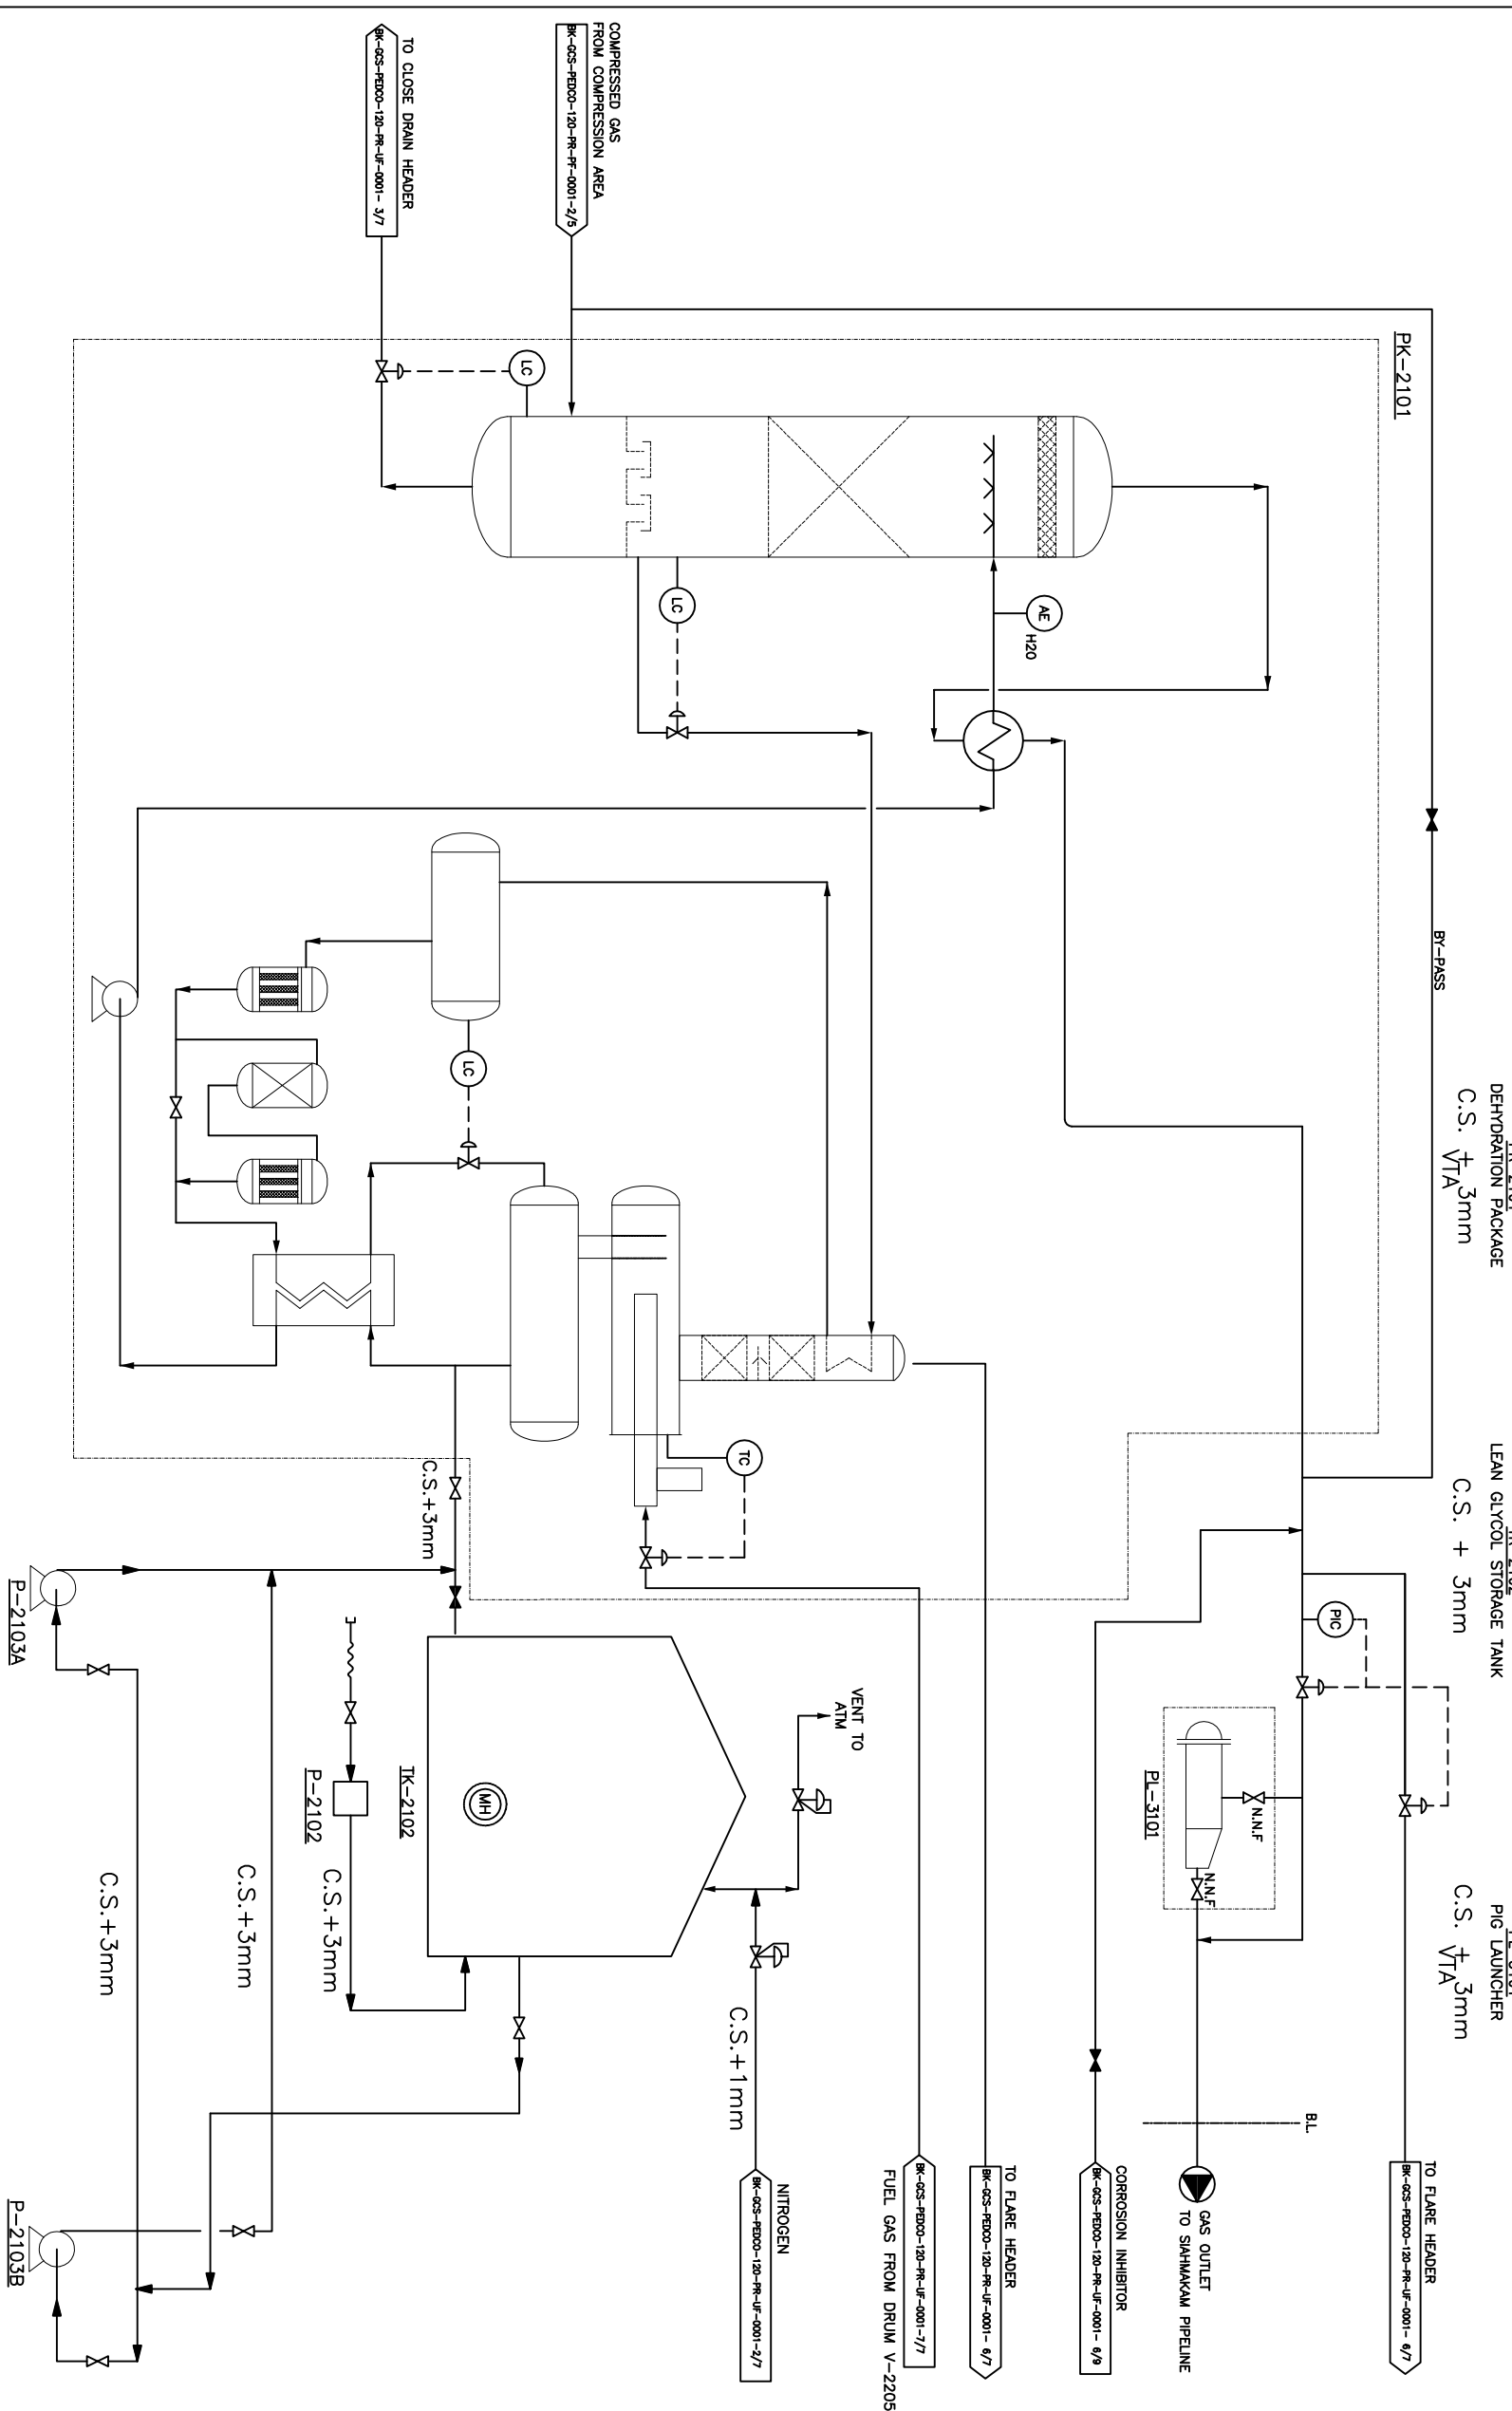

REFERENCE DRAWING	DWG. No.
Symbol & Layout for PFD and PAID	HC-008A-PS200-000-PS-PI-0001
Piping Corrosion Study & Material Selection Report	HC-020-PS200-100-PI-PI-0001
Process Flow Diagram (PFD)	HC-020-PS200-100-PI-PI-0001
PAID - INRAK Gas Compression STATION	HC-020-PS200-100-PI-PI-0000-0010
PAID - Puri Gas System	HC-020-PS200-100-PI-PI-0000

KEY PLAN

[illegible]

THE ORIGINAL AND ALL COPIES OF THIS DRAWING TOGETHER WITH
THE COPYRIGHT THEREIN ARE THE SOLE PROPERTY OF
N.I.S.O.C./ FIELDS

THE ORIGINAL AND ALL COPIES OF THIS DRAWING TOGETHER WITH
THE COPYRIGHT THEREIN ARE THE SOLE PROPERTY OF
N.I.S.O.C./ FIELDS

BINAK OILFIELD DEVELOPMENT

GAS COMPRESSOR STATION

BINAK OILFIELD DEVELOPMENT SURFACE FACILITIES GAS COMPRESSOR STATION				
DATE	SCALE	DRAWING BY	CHECKED BY	PROJECT ENG

NO CONSTRUCTION PERMITTED UNLESS DRAWING APPROVED

BUDGET REF.	LOCATION	SIZE	CLASS	SERIAL NO.	SHEET	REVISION
-------------	----------	------	-------	------------	-------	----------

0053-073-9184	F	2	A	706900	3 OF 4	D02
---------------	---	---	---	--------	--------	-----

(VENDOR TITLE BLOCK)**

EPC CONTRACTOR: **HIRSHAN ENERGY** 

HERCAN ENERGY - DESIGN & INSPECTION COMPANIES

DRAWING TITLE:

MATERIAL FLOW DIAGRAM

SCALE	S
-------	---

SCALE	S
-------	---


NS	
----	--

NOTES

1 - WALL THICKNESS SHALL BE IN ACCORDANCE WITH WALL THICKNESS CALCULATION REPORT.

Y-2205
FUEL GAS K.O. DRUM

OPERATING TEMP. : 48 °C
OPERATING PRESS. : 4.9 barg

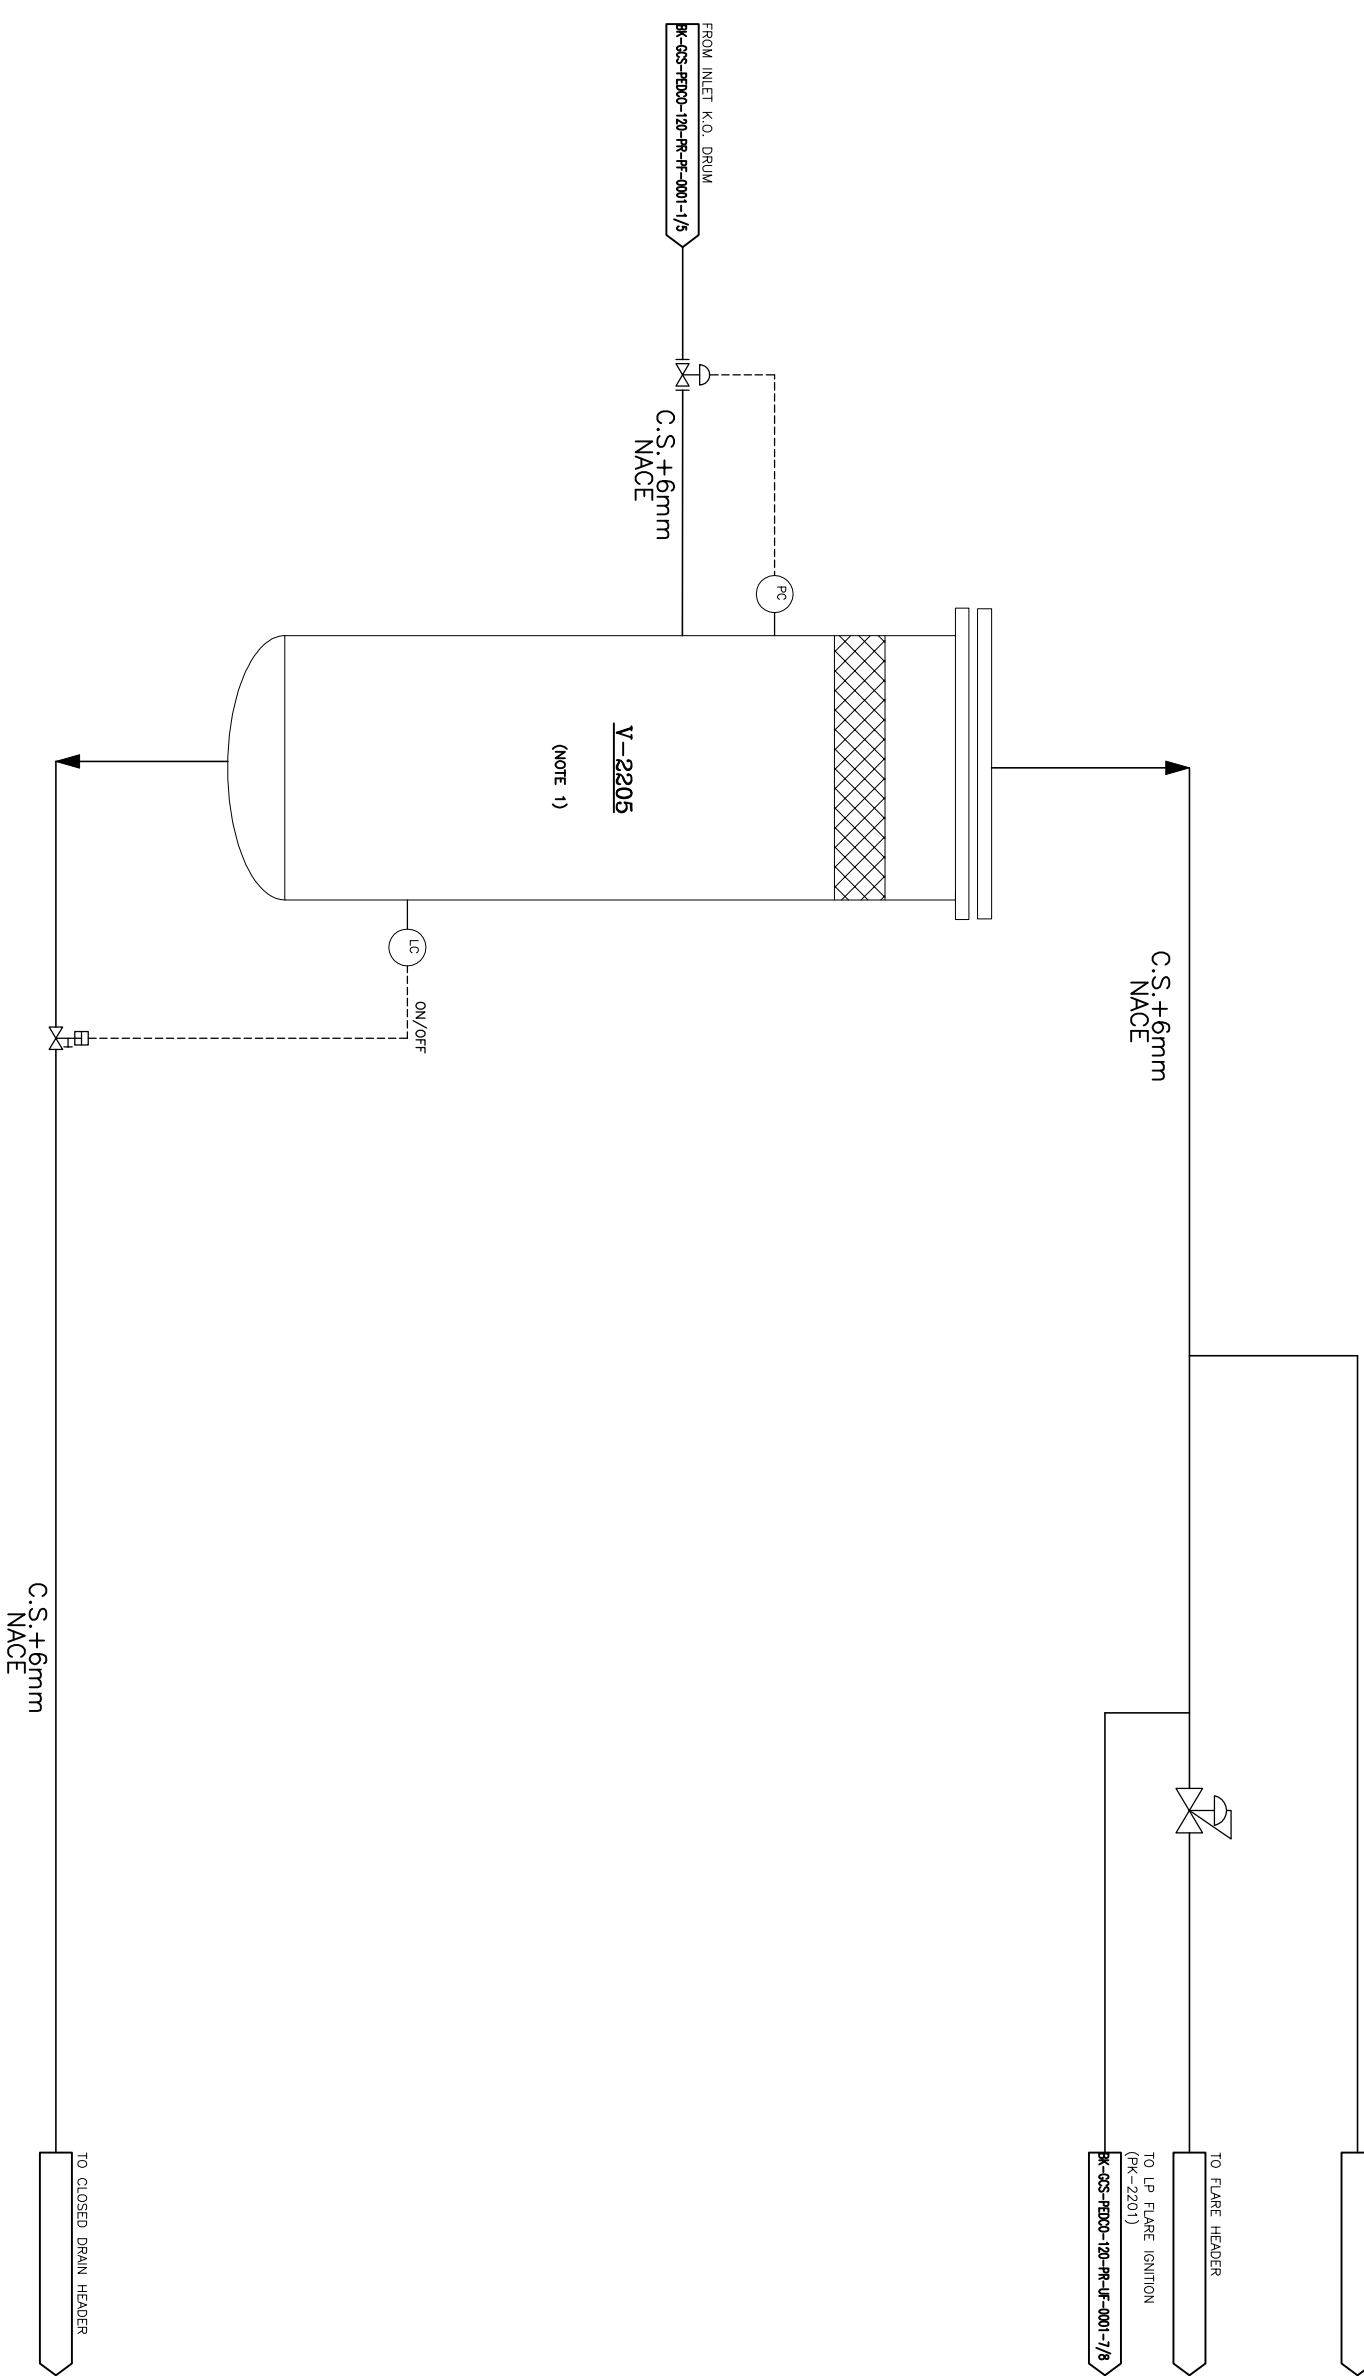

REFERENCE DRAWING	DRG. NO.
Symbol & Legend for PFD and P&ID	HC-028A-7800-100-PF-PF-0001
Corrosion Siting & Material Selection Report	HC-028-7800-100-PF-PF-0001
Process Flow Diagram (PFD)	HC-028-7800-100-PF-PF-0001
P&ID - SHANK Gas Compression STATION	HC-028-7800-100-PF-PF-0000-0015
P&ID - Fuel Gas System	HC-028-7800-100-PF-PF-0008

KEY PLAN

[illegible]

EPC CONTRACTOR:  HARBAN EXHAUST & INSULATION COMPANIES	EED/EPC CONTRACTOR (GC):  PETROBRAS DEVELOPMENT COMPANY	BUNAK OILFIELD DEVELOPMENT SURFACE FACILITIES GAS COMPRESSOR STATION									
		DATE		SCALE		DRAWING BY		CHECKED BY		PROJECT ENG	
		NO CONSTRUCTION PERMITTED UNLESS DRAWING APPROVED APPROVED FOR CONSTRUCTION BY: _____ DATE: _____ HARBAN REP. LOCATION SIZE CLASS SERIAL NO. SHEET REVISIONS 005-075-014 7 2 A 708800 4 OF 4 D02									
DRAWING TITLE: MATERIAL FLOW DIAGRAM											
SCALE	SIZE	DRAWING NO.		SHEET NO.		REV.					
NS	A3	BK-GCS-PRDCC-180-PI-DG-0001		4 OF 4		D02					
(VENDOR TITLE BLOCK)*											