

22		A0	
REFERENCE DRAWINGS		DWG. NUMBER	
P&I DIAGRAM		9K-GCS-HY-120-PR-P1-0001-V04	
INSTRUMENT DATASHEET/ CERTIFICATES		9K-GCS-HY-120-IN-DS-0001-V02	

Note :

Legend :	G
	H
	J
	K
	L
	M
	N

[illegible]

Contents

Description	Sheet NO.
1. Symbol and legends	3
2. Pressure Gauge	4~6
3. Pressure Transmitter & Switch	7~9
4. Temperature Gauge & Transmitter	10~11
5. Differential Pressure Transmitter	12
6. Differential Pressure Gauge & Flow Meter	13
7. Flow Transmitter	14
8. Level Transmitter	15
9. 9. On/ Off Valve & Control Valve	16
10. Vibration Switch & Rod drop	17
11. MTO Table	18




REFERENCE DRAWINGS	DWG. NUMBER
P&I DIAGRAM	BK-GCS-HY-120-PR-P1-0001-V04
INSTRUMENT DATASHEET/ CERTIFICATES	BK-GCS-HY-120-IN-GS-0001-V02


Note :

Legend :

REV.	DATE	BY	DATE	REV.	DATE	BY	DATE
V02	OCT 2024	IPR	HEAVYAIR Co.	M.FAKHREMAN	M.SADEGHIAN		
V01	MAY 2024	IPR	HEAVYAIR Co.	M.FAKHREMAN	M.SADEGHIAN		
V00	APR 2024	IPR	HEAVYAIR Co.	M.FAKHREMAN	A.M.NOCHSENI		
REV.	DATE	P.O.I.	PREP.	CHK.	APP.	AUT.	
PROJECT NAME: BINAK OILFIELD DEVELOPMENT SURFACE WORK PACKAGES							
PROJECT NO.: -----							
EPC CONTRACTOR: HURGAN ENERGY - DESIGN & INSPECTION COMPANIES				EPC/EPD CONTRACTOR: PETROIRAN DEVELOPMENT COMPANY			
DRAWING TITLE: HOOK UP DRAWING				NO CONSTRUCTION PERMITTED UNLESS DRAWING APPROVED			
SCALE: N.T.S.C. A3				DRAWING NO. BK-GCS-HY-120-IN-DW-0007			
SHEET NO. 02 OF 18				REV. V02			
BUDGET REP.				LOCATION			
SIZE CLASS				SERIAL NO.			
SHEET				REVISION			

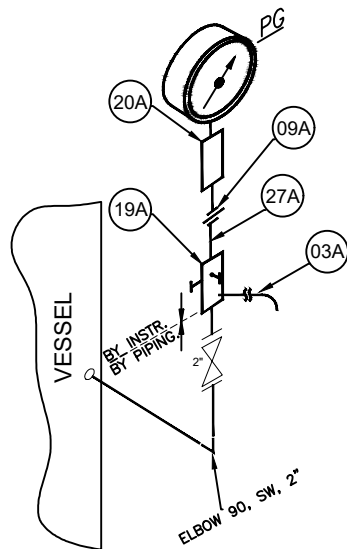


Tag Number	Quantity	REMARK
PG-2190A/B/C	3	FLUID: SOUR GAS
PG-2193A/B/C	3	FLUID: SOUR GAS

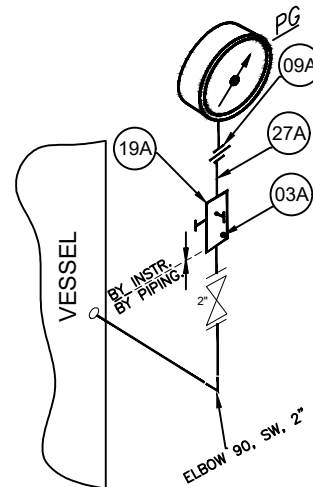


Tag Number	Quantity	REMARK
PG-2191A/B/C	3	FLUID: SOUR GAS

ITEM	QTY	SIZE OR CONNECTION	DESCRIPTION	Rating Class	MATERIAL	TOTAL QTY.	REMARK
03A	4	1/2" O.D	TUBING, SEAMLESS, WALL THICKNESS 0.065"	#6000	AISI 316SS	9	NACE MATERIAL
09A	1	1/2" O.D	STRAIGHT UNION COMPRESSION TYPE DOUBLE FERRULE	#6000	AISI 316SS	12	NACE MATERIAL
19A	1	2x1/2"NPTF + 1/4"NPTF	MANIFOLD, 3 WAY 2 VALVE	#6000	AISI 316SS	9	NACE MATERIAL
20A	1	1/2"NPTM x 1/2"NPTF	OVER RANGE PROTECTION	#6000	AISI 316SS	6	NACE MATERIAL
27A	1	1/2"NPTM x 1/2"NPTM	NIPPLE	#6000	AISI 316SS	9	NACE MATERIAL

REV.	DATE	DESCRIPTION	BY	DATE	BY	DATE
1	01/01/2024	ISSUED FOR CONSTRUCTION	ENGINEER	01/01/2024	CHECKED	01/01/2024
2	02/01/2024	REVISED	ENGINEER	02/01/2024	CHECKED	02/01/2024
3	03/01/2024	REVISED	ENGINEER	03/01/2024	CHECKED	03/01/2024
4	04/01/2024	REVISED	ENGINEER	04/01/2024	CHECKED	04/01/2024
5	05/01/2024	REVISED	ENGINEER	05/01/2024	CHECKED	05/01/2024
6	06/01/2024	REVISED	ENGINEER	06/01/2024	CHECKED	06/01/2024
7	07/01/2024	REVISED	ENGINEER	07/01/2024	CHECKED	07/01/2024
8	08/01/2024	REVISED	ENGINEER	08/01/2024	CHECKED	08/01/2024
9	09/01/2024	REVISED	ENGINEER	09/01/2024	CHECKED	09/01/2024
10	10/01/2024	REVISED	ENGINEER	10/01/2024	CHECKED	10/01/2024
11	11/01/2024	REVISED	ENGINEER	11/01/2024	CHECKED	11/01/2024
12	12/01/2024	REVISED	ENGINEER	12/01/2024	CHECKED	12/01/2024
13	01/01/2025	REVISED	ENGINEER	01/01/2025	CHECKED	01/01/2025
14	02/01/2025	REVISED	ENGINEER	02/01/2025	CHECKED	02/01/2025
15	03/01/2025	REVISED	ENGINEER	03/01/2025	CHECKED	03/01/2025
16	04/01/2025	REVISED	ENGINEER	04/01/2025	CHECKED	04/01/2025
17	05/01/2025	REVISED	ENGINEER	05/01/2025	CHECKED	05/01/2025
18	06/01/2025	REVISED	ENGINEER	06/01/2025	CHECKED	06/01/2025
19	07/01/2025	REVISED	ENGINEER	07/01/2025	CHECKED	07/01/2025
20	08/01/2025	REVISED	ENGINEER	08/01/2025	CHECKED	08/01/2025
21	09/01/2025	REVISED	ENGINEER	09/01/2025	CHECKED	09/01/2025
22	10/01/2025	REVISED	ENGINEER	10/01/2025	CHECKED	10/01/2025
23	11/01/2025	REVISED	ENGINEER	11/01/2025	CHECKED	11/01/2025
24	12/01/2025	REVISED	ENGINEER	12/01/2025	CHECKED	12/01/2025
25	01/01/2026	REVISED	ENGINEER	01/01/2026	CHECKED	01/01/2026
26	02/01/2026	REVISED	ENGINEER	02/01/2026	CHECKED	02/01/2026
27	03/01/2026	REVISED	ENGINEER	03/01/2026	CHECKED	03/01/2026
28	04/01/2026	REVISED	ENGINEER	04/01/2026	CHECKED	04/01/2026
29	05/01/2026	REVISED	ENGINEER	05/01/2026	CHECKED	05/01/2026
30	06/01/2026	REVISED	ENGINEER	06/01/2026	CHECKED	06/01/2026
31	07/01/2026	REVISED	ENGINEER	07/01/2026	CHECKED	07/01/2026
32	08/01/2026	REVISED	ENGINEER	08/01/2026	CHECKED	08/01/2026
33	09/01/2026	REVISED	ENGINEER	09/01/2026	CHECKED	09/01/2026
34	10/01/2026	REVISED	ENGINEER	10/01/2026	CHECKED	10/01/2026
35	11/01/2026	REVISED	ENGINEER	11/01/2026	CHECKED	11/01/2026
36	12/01/2026	REVISED	ENGINEER	12/01/2026	CHECKED	12/01/2026
37	01/01/2027	REVISED	ENGINEER	01/01/2027	CHECKED	01/01/2027
38	02/01/2027	REVISED	ENGINEER	02/01/2027	CHECKED	02/01/2027
39	03/01/2027	REVISED	ENGINEER	03/01/2027	CHECKED	03/01/2027
40	04/01/2027	REVISED	ENGINEER	04/01/2027	CHECKED	04/01/2027
41	05/01/2027	REVISED	ENGINEER	05/01/2027	CHECKED	05/01/2027
42	06/01/2027	REVISED	ENGINEER	06/01/2027	CHECKED	06/01/2027
43	07/01/2027	REVISED	ENGINEER	07/01/2027	CHECKED	07/01/2027
44	08/01/2027	REVISED	ENGINEER	08/01/2027	CHECKED	08/01/2027
45	09/01/2027	REVISED	ENGINEER	09/01/2027	CHECKED	09/01/2027
46	10/01/2027	REVISED	ENGINEER	10/01/2027	CHECKED	10/01/2027
47	11/01/2027	REVISED	ENGINEER	11/01/2027	CHECKED	11/01/2027
48	12/01/2027	REVISED	ENGINEER	12/01/2027	CHECKED	12/01/2027
49	01/01/2028	REVISED	ENGINEER	01/01/2028	CHECKED	01/01/2028
50	02/01/2028	REVISED	ENGINEER	02/01/2028	CHECKED	02/01/2028
51	03/01/2028	REVISED	ENGINEER	03/01/2028	CHECKED	03/01/2028
52	04/01/2028	REVISED	ENGINEER	04/01/2028	CHECKED	04/01/2028
53	05/01/2028	REVISED	ENGINEER	05/01/2028	CHECKED	05/01/2028
54	06/01/2028	REVISED	ENGINEER	06/01/2028	CHECKED	06/01/2028
55	07/01/2028	REVISED	ENGINEER	07/01/2028	CHECKED	07/01/2028
56	08/01/2028	REVISED	ENGINEER	08/01/2028	CHECKED	08/01/2028
57	09/01/2028	REVISED	ENGINEER	09/01/2028	CHECKED	09/01/2028
58	10/01/2028	REVISED	ENGINEER	10/01/2028	CHECKED	10/01/2028
59	11/01/2028	REVISED	ENGINEER	11/01/2028	CHECKED	11/01/2028
60	12/01/2028	REVISED	ENGINEER	12/01/2028	CHECKED	12/01/2028
61	01/01/2029	REVISED	ENGINEER	01/01/2029	CHECKED	01/01/2029
62	02/01/2029	REVISED	ENGINEER	02/01/2029	CHECKED	02/01/2029
63	03/01/2029	REVISED	ENGINEER	03/01/2029	CHECKED	03/01/2029
64	04/01/2029	REVISED	ENGINEER	04/01/2029	CHECKED	04/01/2029
65	05/01/2029	REVISED	ENGINEER	05/01/2029	CHECKED	05/01/2029
66	06/01/2029	REVISED	ENGINEER	06/01/2029	CHECKED	06/01/2029
67	07/01/2029	REVISED	ENGINEER	07/01/2029	CHECKED	07/01/2029
68	08/01/2029	REVISED	ENGINEER	08/01/2029	CHECKED	08/01/2029
69	09/01/2029	REVISED	ENGINEER	09/01/2029	CHECKED	09/01/2029
70	10/01/2029	REVISED	ENGINEER	10/01/2029	CHECKED	10/01/2029
71	11/01/2029	REVISED	ENGINEER	11/01/2029	CHECKED	11/01/2029
72	12/01/2029	REVISED	ENGINEER	12/01/2029	CHECKED	12/01/2029
73	01/01/2030	REVISED	ENGINEER	01/01/2030	CHECKED	01/01/2030
74	02/01/2030	REVISED	ENGINEER	02/01/2030	CHECKED	02/01/2030
75	03/01/2030	REVISED	ENGINEER	03/01/2030	CHECKED	03/01/2030
76	04/01/2030	REVISED	ENGINEER	04/01/2030	CHECKED	04/01/2030
77	05/01/2030	REVISED	ENGINEER	05/01/2030	CHECKED	05/01/2030
78	06/01/2030	REVISED	ENGINEER	06/01/2030	CHECKED	06/01/2030
79	07/01/2030	REVISED	ENGINEER	07/01/2030	CHECKED	07/01/2030
80	08/01/2030	REVISED	ENGINEER	08/01/2030	CHECKED	08/01/2030
81	09/01/2030	REVISED	ENGINEER	09/01/2030	CHECKED	09/01/2030
82	10/01/2030	REVISED	ENGINEER	10/01/2030	CHECKED	10/01/2030
83	11/01/2030	REVISED	ENGINEER	11/01/2030	CHECKED	11/01/2030
84	12/01/2030	REVISED	ENGINEER	12/01/2030	CHECKED	12/01/2030
85	01/01/2031	REVISED	ENGINEER	01/01/2031	CHECKED	01/01/2031
86	02/01/2031	REVISED	ENGINEER	02/01/2031	CHECKED	02/01/2031
87	03/01/2031	REVISED	ENGINEER	03/01/2031	CHECKED	03/01/2031
88	04/01/2031	REVISED	ENGINEER	04/01/2031	CHECKED	04/01/2031
89	05/01/2031	REVISED	ENGINEER	05/01/2031	CHECKED	05/01/2031
90	06/01/2031	REVISED	ENGINEER	06/01/2031	CHECKED	06/01/2031
91	07/01/2031	REVISED	ENGINEER	07/01/2031	CHECKED	07/01/2031
92	08/01/2031	REVISED	ENGINEER	08/01/2031	CHECKED	08/01/2031
93	09/01/2031	REVISED	ENGINEER	09/01/2031	CHECKED	09/01/2031
94	10/01/2031	REVISED	ENGINEER	10/01/2031	CHECKED	10/01/2031
95	11/01/2031	REVISED	ENGINEER	11/01/2031	CHECKED	11/01/2031
96	12/01/2031	REVISED	ENGINEER	12/01/2031	CHECKED	12/01/2031
97	01/01/2032	REVISED	ENGINEER	01/01/2032	CHECKED	01/01/2032
98	02/01/2032	REVISED	ENGINEER	02/01/2032	CHECKED	02/01/2032
99	03/01/2032	REVISED	ENGINEER	03/01/2032	CHECKED	03/01/2032
100	04/01/2032	REVISED	ENGINEER	04/01/2032	CHECKED	04/01/2032
101	05/01/2032	REVISED	ENGINEER	05/01/2032	CHECKED	05/01/2032
102	06/01/2032	REVISED	ENGINEER	06/01/2032	CHECKED	06/01/2032
103	07/01/2032	REVISED	ENGINEER	07/01/2032	CHECKED	07/01/2032
104	08/01/2032	REVISED	ENGINEER	08/01/2032	CHECKED	08/01/2032
105	09/01/2032	REVISED	ENGINEER	09/01/2032	CHECKED	09/01/2032
106	10/01/2032	REVISED	ENGINEER	10/01/2032	CHECKED	10/01/2032
107	11/01/2032	REVISED	ENGINEER	11/01/2032	CHECKED	11/01/2032
108	12/01/2032	REVISED	ENGINEER	12/01/2032	CHECKED	12/01/2032
109	01/01/2033	REVISED	ENGINEER	01/01/2033	CHECKED	01/01/2033
110	02/01/2033	REVISED	ENGINEER	02/01/2033	CHECKED	02/01/2033
111	03/01/2033	REVISED	ENGINEER	03/01/2033	CHECKED	03/01/2033
112	04/01/2033	REVISED	ENGINEER	04/01/2033	CHECKED	04/01/2033
113	05/01/2033	REVISED	ENGINEER	05/01/2033	CHECKED	05/01/2033
114	06/01/2033	REVISED	ENGINEER	06/01/2033	CHECKED	06/01/2033
115	07/01/2033	REVISED	ENGINEER	07/01/2033	CHECKED	07/01/2033
116	08/01/2033	REVISED	ENGINEER	08/01/2033	CHECKED	08/01/2033
117	09/01/2033	REVISED	ENGINEER	09/01/2033	CHECKED	09/01/2033
118	10/01/2033	REVISED	ENGINEER	10/01/2033	CHECKED	10/01/2033
119	11/01/2033	REVISED	ENGINEER	11/01/2033	CHECKED	11/01/2033
120	12/01/2033	REVISED	ENGINEER	12/01/2033	CHECKED	12/01/2033
121	01/01/2034	REVISED	ENGINEER	01/01/2034	CHECKED	01/01/2034
122	02/01/2034	REVISED	ENGINEER	02/01/2034	CHECKED	02/01/2034
123	03/01/2034	REVISED	ENGINEER	03/01/2034	CHECKED	03/01/2034
124	04/01/2034	REVISED	ENGINEER	04/01/2034	CHECKED	04/01/2034
125	05/01/2034	REVISED	ENGINEER	05/01/2034	CHECKED	05/01/2034
126	06/01/2034	REVISED	ENGINEER	06/01/2034	CHECKED	06/01/2034
127	07/01/2034	REVISED	ENGINEER	07/01/2034	CHECKED	07/01/2034
128	08/01/2034	REVISED	ENGINEER	08/01/2034	CHECKED	08/01/2034
129	09/01/2034	REVISED	ENGINEER	09/01/2034	CHECKED	09/01/2034
130	10/01/2034	REVISED	ENGINEER	10/01/2034	CHECKED	10/01/2034
131	11/01/2034	REVISED	ENGINEER	11/01/2034	CHECKED	11/01/2034
132	12/01/2034	REVISED	ENGINEER	12/01/2034	CHECKED	12/01/2034
133	01/01/2035	REVISED	ENGINEER	01/01/2035	CHECKED	01/01/2035
134	02/01/2035	REVISED	ENGINEER	02/01/2035	CHECKED	02/01/2035
135	03/01/2035	REVISED	ENGINEER	03/01/2035	CHECKED	03/01/2035
136	04/01/2035	REVISED	ENGINEER	04/01/2035	CHECKED	04/01/2035
137	05/01/2035	REVISED	ENGINEER	05/01/2035	CHECKED	05/01/2035
138	06/01/2035	REVISED	ENGINEER	06/01/2035	CHECKED	06/01/2035
139	07/01/2035	REVISED	ENGINEER	07/01/2035	CHECKED	07/01/2035
140	08/01/2035	REVISED	ENGINEER	08/01/2035	CHECKED	08/01/2035
141	09/01/2035	REVISED	ENGINEER	09/01/2035	CHECKED	09/01/2035
142	10/01/2035	REVISED	ENGINEER	10/01/2035		

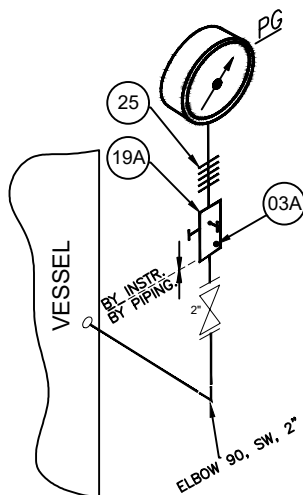

Tag Number	Quantity	Remark
PG-2194A/B/C	3	FLUID: SOUR GAS

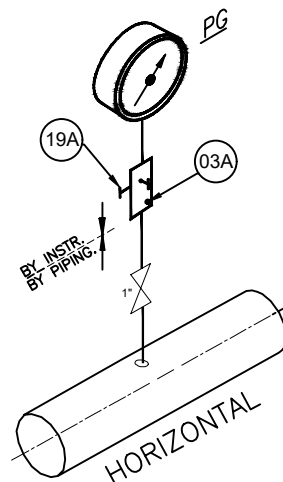

Tag Number	Quantity	Remark
PG-2205A/B/C	3	FLUID: SOUR GAS



ITEM	QTY	SIZE OR CONNECTION	DESCRIPTION	Rating Class	MATERIAL	TOTAL QTY.	REMARK
19A	1	2x1/2"NPTF + 1/4"NPTF	MANIFOLD, 3 WAY 2 VALVE	#6000	AISI 316SS	6	NACE MATERIAL
25	1	1/2" NPTF x 1/2" NPTM	COOLING ELEMENT	#6000	AISI 316SS	3	NACE MATERIAL
03A	1	1/4"NPTM	HEX HEAD PLUG	#6000	AISI 316SS	6	NACE MATERIAL



REV. DATE		P.O.I.		PREP.	CHK.	APP.	AUT.
V02 OCT 2024		IFR		IRSAVYAR Ch	MFARHAMAN	M SADEGHIAN	
V01 MAY 2024		IFR		IRSAVYAR Ch	MFARHAMAN	M SADEGHIAN	
V00 APR 2024		IFR		IRSAVYAR Ch	MFARHAMAN	A.M MOHSENI	
PROJECT NAME: HINAK OILFIELD DEVELOPMENT SURFACE WORK PACKAGES							
EPC CONTRACTOR:				EPC/BPD CONTRACTOR:			
 HIRGAN ENERGY - DESIGN & INSPECTION COMPANIES				 PETROIRAN DEVELOPMENT COMPANY			
DATE SCALE DRAWING BY CHECKED BY PROJECT ENG.							
NO CONSTRUCTION PERMITTED UNLESS DRAWING APPROVED							
APPROVED FOR CONSTRUCTION BY: DATE:							
SCALE		DRAWING NO.		SHEET NO.		REV.	
N.T.S.C. A3		BK-OCB-HY-120-IN-DW-0007		06 OF 18		V02	
BUDGET REF.		LOCATION		SIZE CLASS		SERIAL NO. SHEET	

REFERENCE DRAWINGS	DWG. NUMBER
P&ID DIAGRAM	BK-GCS-HY-120-PR-PI-0001-V04
INSTRUMENT DATASHEET/ CERTIFICATES	BK-GCS-HY-120-IN-DS-0001-V02

Note :

Legend :

THE ORIGINAL AND ALL COPIES OF THIS DRAWING TOGETHER WITH THE COPYRIGHT THEREIN ARE THE SOLE PROPERTY OF N.I.S.O.C./ FIELDS

HINAK OILFIELD DEVELOPMENT SURFACE WORK PACKAGES


DATE SCALE DRAWING BY CHECKED BY PROJECT ENG.

NO CONSTRUCTION PERMITTED UNLESS DRAWING APPROVED

APPROVED FOR CONSTRUCTION BY: DATE:


SCALE DRAWING NO. SHEET NO. REV. BUDGET REF. LOCATION SIZE CLASS SERIAL NO. SHEET REVISION

N.T.S.C. A3 BK-OCB-HY-120-IN-DW-0007 06 OF 18 V02

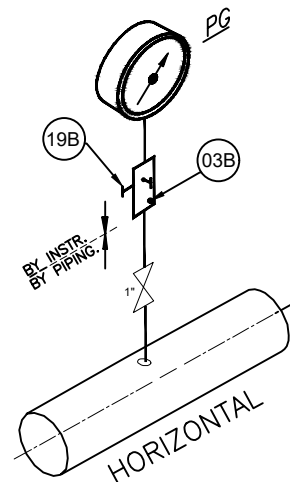


Tag Number	Quantity	Remark
PG-2200A/B/C	3	FLUID: AIR
PG-2201A/B/C	3	FLUID: OIL
PG-2202A/B/C	3	FLUID: OIL
PG-2204A/B/C	3	FLUID: OIL
PG-2208A/B/C	3	FLUID: WATER

[illegible]

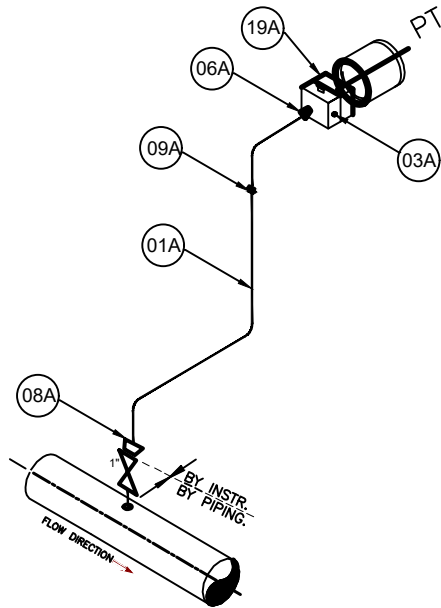

Tag Number	Quantity	Remark
PT-2123A/B/C	3	FLUID: SOUR GAS
PT-2124A/B/C	3	FLUID: SOUR GAS
PT-2133A/B/C	3	FLUID: SOUR GAS
PT-2132A/B/C	3	FLUID: SOUR GAS

V 02

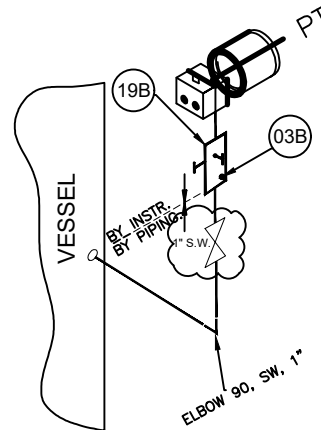

Tag Number	Quantity	Remark
PT-2200A/B/C	3	FLUID: OIL

ITEM	QTY	SIZE OR CONNECTION	DESCRIPTION	Rating Class	MATERIAL	TOTAL QTY.	REMARK
19A	1	2x1/2"NPTF + 1/4"NPTF	MANIFOLD,3 WAY 2 VALVE	#6000	ISI 316SS	12	NACE MATERIAL
08A	1	1/2" NPTFx 1/2" O.D.	DOUBLE FERRULE COMPRESSION TYPE FEMALE CONNECTOR	#6000	ISI 316SS	12	NACE MATERIAL
01A	4	1/2" O.D.	TUBING, SEAMLESS, WALL THICKNESS 0.065"	#6000	ISI 316SS	48m	NACE MATERIAL
09A	1	1/2" O.D.	STRAIGHT UNION COMPRESSION TYPE DOUBLE FERRULE	#6000	ISI 316SS	12	NACE MATERIAL
06A	1	1/2" NPTM x 1/2" O.D.	DOUBLE FERRULE COMPRESSION TYPE MALE CONNECTOR	#6000	ISI 316SS	12	NACE MATERIAL
03A	1	1/4"NPTM	HEX HEAD PLUG	#6000	ISI 316SS	12	NACE MATERIAL
19B	1	2x1/2"NPTF + 1/4"	MANIFOLD,3 WAY 2 VALVE	#6000	ISI 316SS	3	-
03B	1	1/4"NPTM	HEX HEAD PLUG	#6000	ISI 316SS	12	-


V 02

REV. DATE		P.O.I.		PREP.		CHK.		APP.		AUT.	
PROJECT NAME: BINAQ OILFIELD DEVELOPMENT SURFACE WORK PACKAGES											
PROJECT NO.: -----											
EPC CONTRACTOR:						EPC/RPD CONTRACTOR:					
 BINAQ ENERGY - DESIGN & INSPECTION COMPANIES						 PETROIRAN DEVELOPMENT COMPANY					
THE ORIGINAL AND ALL COPIES OF THIS DRAWING TOGETHER WITH THE COPYRIGHT THEREON ARE THE SOLE PROPERTY OF N.I.S.O.C./ FIELDS											
DATE		SCALE		DRAWING BY		CHECKED BY		PROJECT ENG.			
NO CONSTRUCTION PERMITTED UNLESS DRAWING APPROVED											
APPROVED FOR CONSTRUCTION				BY:				DATE:			
SCALE		SIZE		DRAWING NO.		SHEET NO.		REV.		BUDGET REF.	
N.T. REC.		AD		BK-GDS-HY-120-IR-DW-0007		07 OF 18		V02		21	

REFERENCE DRAWINGS
P&ID DIAGRAM
INSTRUMENT DATASHEET/ CERTIFICATES

Note :


Legend :

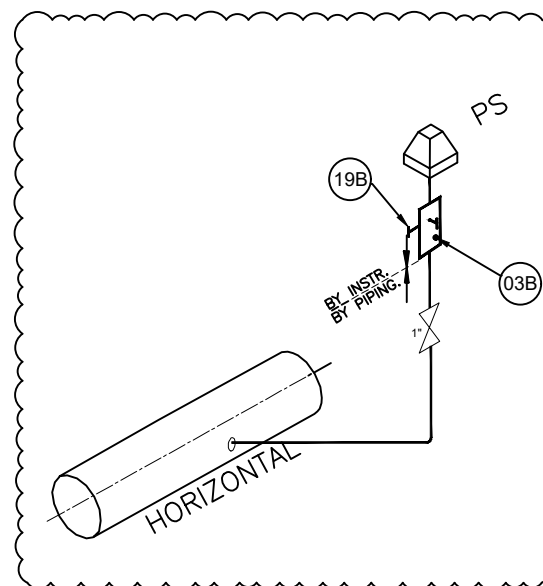


Tag Number	Quantity	Remark
PS-2204A/B/C	3	FLUID: OIL
PS-2220A/B/C	3	FLUID: WATER

/v 02

[illegible]

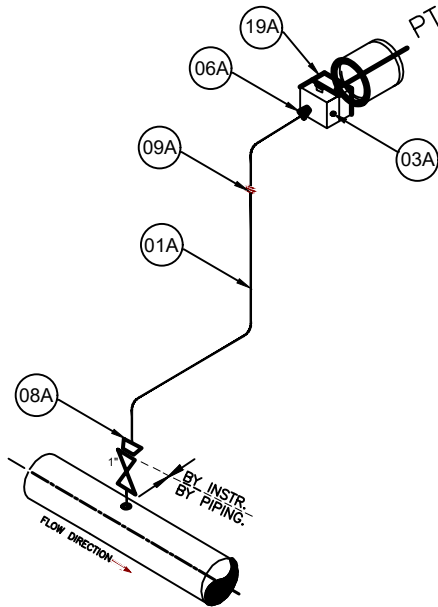

Tag Number	Quantity	Remark
PT-2204A/B/C	3	FLUID: SOUR GAS
PT-2211A/B/C	3	FLUID: SOUR GAS

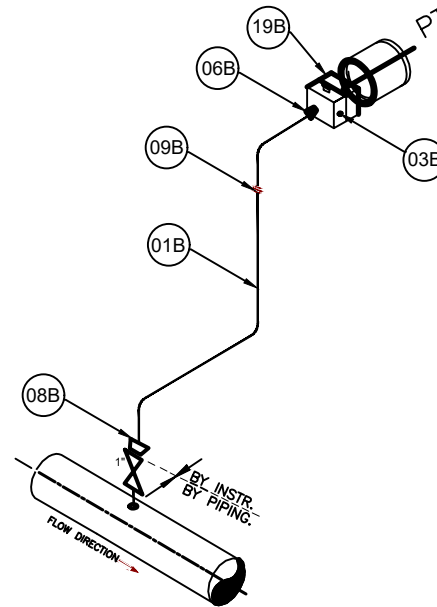



Tag Number	Quantity	Remark
PT-2220A/B/C	3	FLUID: WATER
PT-2221A/B/C	3	FLUID: WATER
PT-2210A/B/C	3	FLUID: OIL



ITEM	QTY	SIZE OR CONNECTION	DESCRIPTION	Rating Class	MATERIAL	TOTAL QTY.	REMARK
19A	1	2x1/2"NPTF + 1/4"NPTF	MANIFOLD,3 WAY 2 VALVE	#6000	ISI 316SS	6	-
08A	1	1/2" NPTF x 1/2" O.D	DOUBLE FERRULE COMPRESSION TYPE FEMALE CONNECTOR	#6000	ISI 316SS	6	-
01A	4	1/2" O.D	TUBING, SEAMLESS, WALL THICKNESS 0.065"	#6000	ISI 316SS	24m	-
09A	1	1/2" O.D	STRAIGHT UNION COMPRESSION TYPE DOUBLE FERRULE	#6000	ISI 316SS	6	-
06A	1	1/2" NPTM x 1/2" O.D	DOUBLE FERRULE COMPRESSION TYPE MALE CONNECTOR	#6000	ISI 316SS	6	-
03A	1	1/4"NPTM	HEX HEAD PLUG	#6000	ISI 316SS	6	-
19B	1	2x1/2"NPTF + 1/4"	MANIFOLD,3 WAY 2 VALVE	#6000	ISI 316SS	9	NACE MATERIAL
08B	1	1/2" NPTF x 1/2" O.D	DOUBLE FERRULE COMPRESSION TYPE FEMALE CONNECTOR	#6000	ISI 316SS	9	NACE MATERIAL
01B	4	1/2" O.D	TUBING, SEAMLESS, WALL THICKNESS 0.065"	#6000	ISI 316SS	36	NACE MATERIAL
09B	1	1/2" O.D	STRAIGHT UNION COMPRESSION TYPE DOUBLE FERRULE	#6000	ISI 316SS	9	NACE MATERIAL
06B	1	1/2" NPTM x 1/2" O.D	DOUBLE FERRULE COMPRESSION TYPE MALE CONNECTOR	#6000	ISI 316SS	9	NACE MATERIAL
03B	1	1/4"NPTM	HEX HEAD PLUG	#6000	ISI 316SS	9	NACE MATERIAL



REV.		DESCRIPTION		BY	DATE	BY	DATE
001	OCT 2024	002	MAY 2024	003	MAY 2024	004	MAY 2024
005	JULY 2024	006	JULY 2024	007	JULY 2024	008	JULY 2024
009	JULY 2024	010	JULY 2024	011	JULY 2024	012	JULY 2024
013	JULY 2024	014	JULY 2024	015	JULY 2024	016	JULY 2024
441	JULY 2024	442	JULY 2024	443	JULY 2024	444	JULY 2024
445	JULY 2024	446					

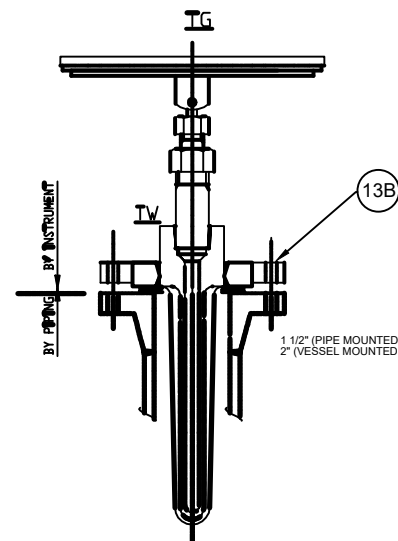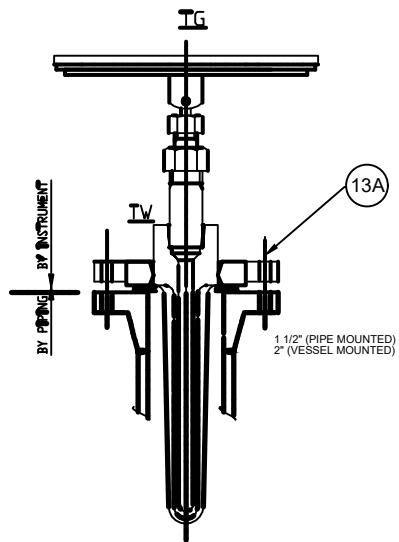

Tag Number	Quantity	REMARK
TG-2210A/B/C	3	PIPE MOUNTED / FLUID: SOUR GAS
TG-2211A/B/C	3	PIPE MOUNTED / FLUID: SOUR GAS
TG-2190A/B/C	3	VESSEL MOUNTED / FLUID: SOUR GAS
TG-2193A/B/C	3	VESSEL MOUNTED / FLUID: SOUR GAS

V 02

Tag Number	Quantity	REMARK
TG-2204A/B/C	3	PIPE MOUNTED / FLUID: WATER
TG-2205A/B/C	3	PIPE MOUNTED / FLUID: WATER
TG-2206A/B/C	3	PIPE MOUNTED / FLUID: WATER
TG-2221A/B/C	3	PIPE MOUNTED / FLUID: WATER
TG-2215A/B/C	3	PIPE MOUNTED / FLUID: WATER
TG-2216A/B/C	3	PIPE MOUNTED / FLUID: WATER
TG-2212A/B/C	3	PIPE MOUNTED / FLUID: WATER
TG-2213A/B/C	3	PIPE MOUNTED / FLUID: WATER
TG-2214A/B/C	3	PIPE MOUNTED / FLUID: WATER
TG-2217A/B/C	3	VESSEL MOUNTED / FLUID: SOUR GAS



V 02

ITEM	QTY	SIZE OR CONNECTION	DESCRIPTION	MATERIAL	TOTAL QTY.	REMARK
13A	1	1/2"NPTF x1/2"NPTF	THERMOWELL	AISI 316SS	15	NACE MATERIAL
13B	1	1/2"NPTF x1/2"NPTF	THERMOWELL	AISI 316SS	30	-

REFERENCE DRAWING		DWG. NUMBER	
P&I DIAGRAM		BK-GCS-HY-120-PR-PL-0001-V04	
INSTRUMENT DATASHEET/ CERTIFICATES		BK-GCS-HY-120-IN-DS-0001-V02	
Note :			
Legend :			
THE ORIGINAL AND ALL COPIES OF THIS DRAWING TOGETHER WITH THE COPYRIGHT THEREON ARE THE SOLE PROPERTY OF N.I.S.O.C./ FIELDS BINAK OILFIELD DEVELOPMENT SURFACE WORK PACKAGES EPC CONTRACTOR: HIRAN ENERGY - DESIGN & INSPECTION COMPANY EPC/EPD CONTRACTOR: PETROIRAN DEVELOPMENT COMPANY DRAWING TITLE: HOOK UP DRAWING SCALE: 1/4" = 1'-0" DRAWING NO. BK-GCS-HY-120-IN-DW-0007 SHEET NO. 10 OF 19 REV. 1 BUDGET REF. LOCATION SIZE CLASS DATE SCALE DRAWING BY CHECKED BY PROJECT ENG. NO CONSTRUCTION PERMITTED UNLESS DRAWING APPROVED APPROVED FOR CONSTRUCTION BY: DATE: SERIAL NO. SHEET REVISION			



REV.	DATE	BY	DATE	BY	DATE
1	10/10/2024	1	10/10/2024	1	10/10/2024
2	10/10/2024	2	10/10/2024	2	10/10/2024
3	10/10/2024	3	10/10/2024	3	10/10/2024
4	10/10/2024	4	10/10/2024	4	10/10/2024
5	10/10/2024	5	10/10/2024	5	10/10/2024
6	10/10/2024	6	10/10/2024	6	10/10/2024
7	10/10/2024	7	10/10/2024	7	10/10/2024
8	10/10/2024	8	10/10/2024	8	10/10/2024
9	10/10/2024	9	10/10/2024	9	10/10/2024
10	10/10/2024	10	10/10/2024	10	10/10/2024
11	10/10/2024	11	10/10/2024	11	10/10/2024
12	10/10/2024	12	10/10/2024	12	10/10/2024
13	10/10/2024	13	10/10/2024	13	10/10/2024
14	10/10/2024	14	10/10/2024	14	10/10/2024
15	10/10/2024	15	10/10/2024	15	10/10/2024
16	10/10/2024	16	10/10/2024	16	10/10/2024
17	10/10/2024	17	10/10/2024	17	10/10/2024
18	10/10/2024	18	10/10/2024	18	10/10/2024
19	10/10/2024	19	10/10/2024	19	10/10/2024
20	10/10/2024	20	10/10/2024	20	10/10/2024
21	10/10/2024	21	10/10/2024	21	10/10/2024
22	10/10/2024	22	10/10/2024	22	10/10/2024
23	10/10/2024	23	10/10/2024	23	10/10/2024
24	10/10/2024	24	10/10/2024	24	10/10/2024
25	10/10/2024	25	10/10/2024	25	10/10/2024
26	10/10/2024	26	10/10/2024	26	10/10/2024
27	10/10/2024	27	10/10/2024	27	10/10/2024
28	10/10/2024	28	10/10/2024	28	10/10/2024
29	10/10/2024	29	10/10/2024	29	10/10/2024
30	10/10/2024	30	10/10/2024	30	10/10/2024

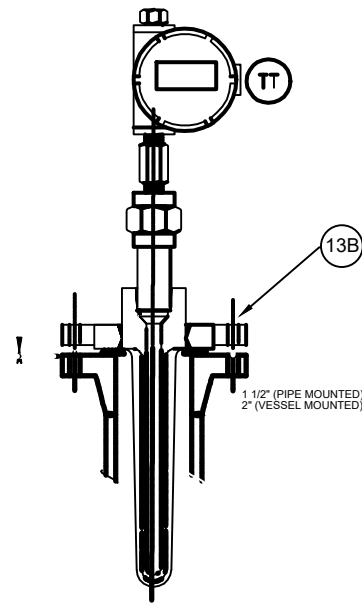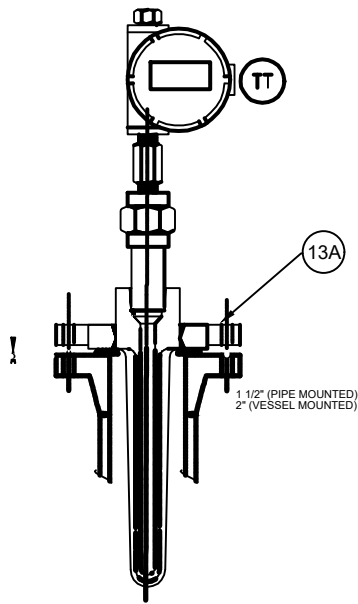


Tag Number	Quantity	REMARK
TT-2122A/B/C	3	FLUID: SOUR GAS
TT-2123A/B/C	3	FLUID: SOUR GAS
TT-2132A/B/C	3	FLUID: SOUR GAS
TT-2133A/B/C	3	FLUID: SOUR GAS
TT-2191A/B/C	3	FLUID: SOUR GAS
TT-2194A/B/C	3	FLUID: SOUR GAS

V 02


Tag Number	Quantity	REMARK
TT-2204A/B/C	3	FLUID: OIL
TT-2203A/B/C	3	FLUID: OIL
TT-2213A/B/C	3	FLUID: WATER
TT-2214A/B/C	3	-
TT-2215A/B/C	3	-
TT-2216A/B/C	3	-
TT-2217A/B/C	3	-
TT-2218A/B/C	3	-
TT-2219A/B/C	3	-
TT-2220A/B/C	3	-

ITEM	QTY	SIZE OR CONNECTION	DESCRIPTION	MATERIAL	TOTAL QTY.	REMARK
13A	1	1/2"NPTF x1/2"NPTF	18	SI 316SS	6	NACE MATERIAL
13B	1	1/2"NPTF x1/2"NPTF	30	SI 316SS	3	-

REV. DATE P.O.L. PREP. CHK. APP. AUT.		REV. DESCRIPTION		BY DATE	BY DATE
PROJECT NAME: BINAQ OILFIELD DEVELOPMENT SURFACE WORK PACKAGES		THE ORIGINAL AND ALL COPIES OF THIS DRAWING TOGETHER WITH THE COPYRIGHT THEREON ARE THE SOLE PROPERTY OF N.I.S.O.C./ FIELDS			
EPC CONTRACTOR: HIRGAN ENERGY - DESIGN & INSPECTION COMPANIES		EPC/EPD CONTRACTOR: PETROIRAN DEVELOPMENT COMPANY		BINAQ OILFIELD DEVELOPMENT SURFACE WORK PACKAGES	
DRAWING TITLE: HOOK UP DRAWING		DATE SCALE		DRAWING BY CHECKED BY PROJECT ENG.	
SCALE: N.T.S.C. A3		DRAWING NO. BK-OCB-HY-120-IN-DW-0007		SHEET NO. 11 OF 18	
NO CONSTRUCTION PERMITTED UNLESS DRAWING APPROVED		APPROVED FOR CONSTRUCTION		DATE	
BUDGET REF. LOCATION SIZE CLASS		SERIAL NO.		SHEET REVISION	

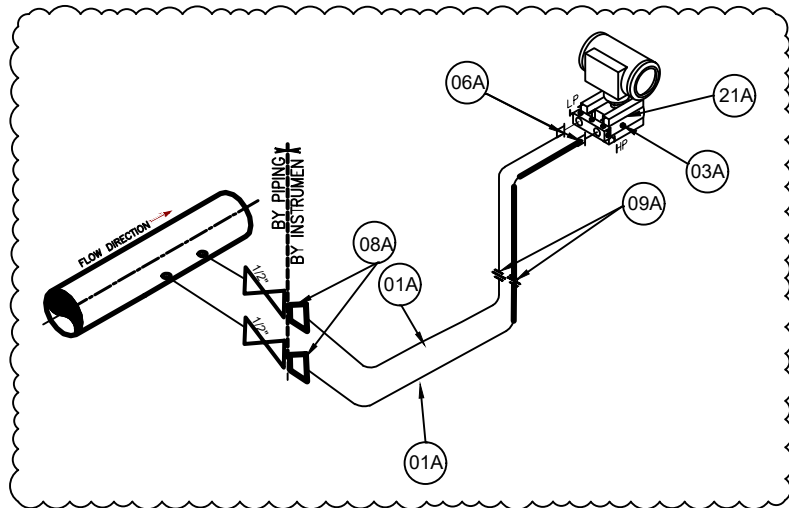

Tag Number	Quantity	REMARK
PDT-2122A/B/C	3	FLUID: SOUR GAS
PDT-2132A/B/C	3	FLUID: SOUR GAS


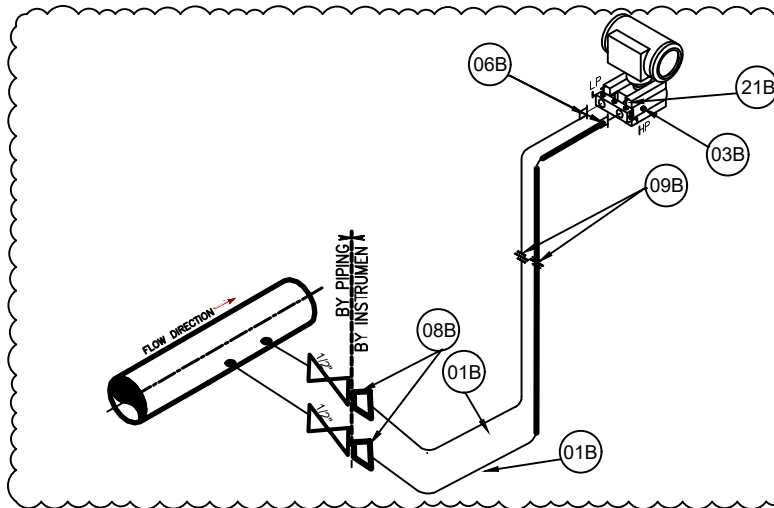


Tag Number	Quantity	REMARK
PDT-2204A/B/C	3	FLUID: OIL



ITEM	QTY	SIZE OR CONNECTION	DESCRIPTION	Rating Class	MATERIAL	TOTAL QTY.	REMARK
21A	1	2x1/2"NPTF + 1/4"	MANIFOLD, 5 WAY 3 VALVE	#6000	AISI 316SS	6	NACE MATERIAL
08A	2	1/2" NPTF x 1/2" O.D	DOUBLE FERRULE COMPRESSION TYPE FEMALE CONNECTOR	#6000	AISI 316SS	12	NACE MATERIAL
01A	8	1/2" O.D	TUBING, SEAMLESS, WALL THICKNESS 0.065"	#6000	AISI 316SS	48	NACE MATERIAL
09A	2	1/2" O.D	STRAIGHT UNION COMPRESSION TYPE DOUBLE FERRULE	#6000	AISI 316SS	12	NACE MATERIAL
06A	2	1/2" NPTM x 1/2" O.D	DOUBLE FERRULE COMPRESSION TYPE MALE CONNECTOR	#6000	AISI 316SS	12	NACE MATERIAL
03A	1	1/4"NPTM	HEX HEAD PLUG	#6000	AISI 316SS	6	NACE MATERIAL
21B	1	2x1/2"NPTF + 1/4"	MANIFOLD, 5 WAY 3 VALVE	#6000	AISI 316SS	3	-
08B	2	1/2" NPTF x 1/2" O.D	DOUBLE FERRULE COMPRESSION TYPE FEMALE CONNECTOR	#6000	AISI 316SS	6	-
01B	8	1/2" O.D	TUBING, SEAMLESS, WALL THICKNESS 0.065"	#6000	AISI 316SS	24	-
09B	2	1/2" O.D	STRAIGHT UNION COMPRESSION TYPE DOUBLE FERRULE	#6000	AISI 316SS	6	-
06B	2	1/2" NPTM x 1/2" O.D	DOUBLE FERRULE COMPRESSION TYPE MALE CONNECTOR	#6000	AISI 316SS	6	-
03B	1	1/4"NPTM	HEX HEAD PLUG	#6000	AISI 316SS	3	-

REV.	DESCRIPTION	BY	DATE	BY	DATE
100	OCT 2024	EPH	IRANIAN CO.	MAJID SHARI	
101	MAY 2024	EPH	IRANIAN CO.	MAJID SHARI	
102	APR 2024	EPH	IRANIAN CO.	MAJID SHARI	
REV.	DATE	P.O.I.	PREP.	CHK.	APP.
PROJECT NAME: BINAQ OILFIELD DEVELOPMENT SURFACE WORK PACKAGES					
EPC CONTRACTOR: IRANIAN ENERGY - DESIGN & INSPECTION COMPANY			EPC/EPD CONTRACTOR: PETROIRAN DEVELOPMENT COMPANY		
THE ORIGINAL AND ALL COPIES OF THIS DRAWING TOGETHER WITH THE COPYRIGHT THEREON ARE THE SOLE PROPERTY OF N.I.S.O.C./ FIELDS					
DATE	SCALE	DRAWING BY	CHECKED BY	PROJECT ENG.	
NO CONSTRUCTION PERMITTED UNLESS DRAWING APPROVED					
APPROVED FOR CONSTRUCTION BY: DATE:					
BUDGET REF.	LOCATION	SHEET CLASS	SERIAL NO.	SHEET	REVISION
12	18	100	12	18	100
DRAWING TITLE: HOOK UP DRAWING					
DRAWING NO. BK-GCP-HY-120-IN-DW-0007					
SHEET NO. 12 OF 18					
REV. 100					
FILE NO. BK-GCP-HY-120-N-DW-0007-02-1					

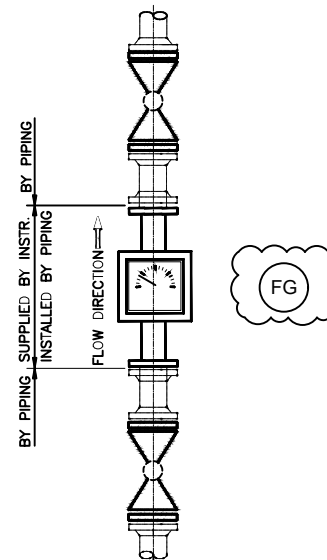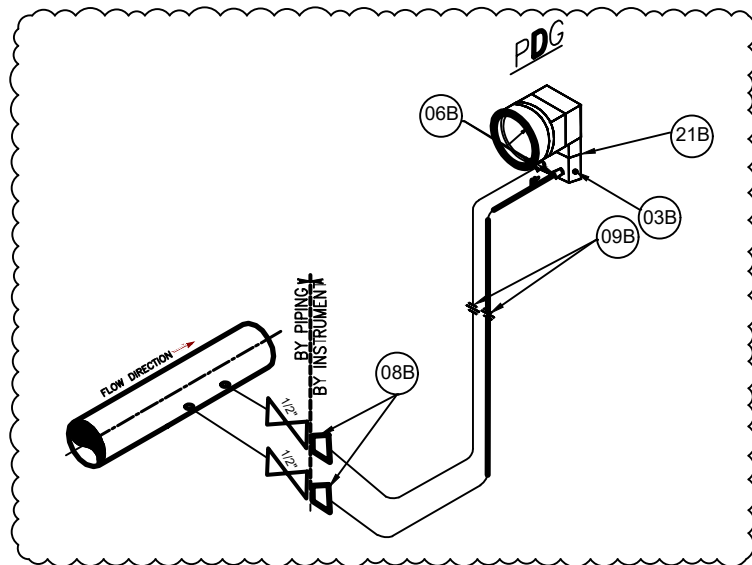

Tag Number	Quantity	REMARK
PDG-2200A/B/C	3	FLUID: OIL
PDG-2204A/B/C	3	FLUID: OIL
PDG-2205A/B/C	3	FLUID: WATER
PDG-2206A/B/C	3	FLUID: WATER

V 02

Tag Number	Quantity	REMARK
FI-2200A/B/C	3	FLUID: GAS(N2)
FI-2201A/B/C	3	FLUID: GAS(N2)
FI-2202A/B/C	3	FLUID: GAS(N2)
FI-2203A/B/C	3	FLUID: GAS(N2)

ITEM	QTY	SIZE OR CONNECTION	DESCRIPTION	Rating Class	MATERIAL	TOTAL QTY.	REMARK
21B	1	2x1/2"NPTF x 1/4"NPTF	MANIFOLD, 5 WAY 3 VALVE	#6000	AISI 316SS	12	-
08B	2	1/2" NPTF x 1/2" O.D	DOUBLE FERRULE COMPRESSION TYPE FEMALE CONNECTOR	#6000	AISI 316SS	24	-
01B	8	1/2" O.D	TUBING, SEAMLESS, WALL THICKNESS 0.065"	#6000	AISI 316SS	96	-
09B	2	1/2" O.D	STRAIGHT UNION COMPRESSION TYPE DOUBLE FERRULE	#6000	AISI 316SS	24	-
06B	2	1/2" NPTM x 1/2" O.D	DOUBLE FERRULE COMPRESSION TYPE MALE CONNECTOR	#6000	AISI 316SS	24	-
03B	1	1/4"NPTM	HEX HEAD PLUG	#6000	AISI 316SS	12	-

REV. DATE		BY	DATE	BY	DATE
1001 OCT 2024		IFR	HAUKYAR CA	M FARDHARAN	M SADIQSHAN
1002 MAY 2024		IFR	HAUKYAR CA	M FARDHARAN	M SADIQSHAN
1003 APR 2024		IFR	HAUKYAR CA	M FARDHARAN	A M MOHSENI
REV.	DATE	P.O.I.	PREP.	CHK.	APP.
PROJECT NAME: BINAK OILFIELD DEVELOPMENT SURFACE WORK PACKAGES					
PROJECT NO.:					
EPC CONTRACTOR:			EPC/RPD CONTRACTOR:		
 HIRGAN ENERGY - DESIGN & INSPECTION COMPANIES			 PETROIRAN DEVELOPMENT COMPANY		
DATE SCALE DRAWING BY CHECKED BY PROJECT ENG.					
NO CONSTRUCTION PERMITTED UNLESS DRAWING APPROVED					
APPROVED FOR CONSTRUCTION BY: DATE:					
SCALE	SIZE	DRAWING NO.	SHEET NO.	REV.	BUDGET REF.
N.T.S.C.	A3	BR-GCS-HY-120-IN-DW-0007	13 OF 18	1001	




REFERENCE DRAWINGS
P&ID DIAGRAM
INSTRUMENT DATASHEET/ CERTIFICATES

Note :

Legend :



THE ORIGINAL AND ALL COPIES OF THIS DRAWING TOGETHER WITH THE COPYRIGHT THEREON ARE THE SOLE PROPERTY OF N.I.S.O.C./ FIELDS

BINAK OILFIELD DEVELOPMENT SURFACE WORK PACKAGES

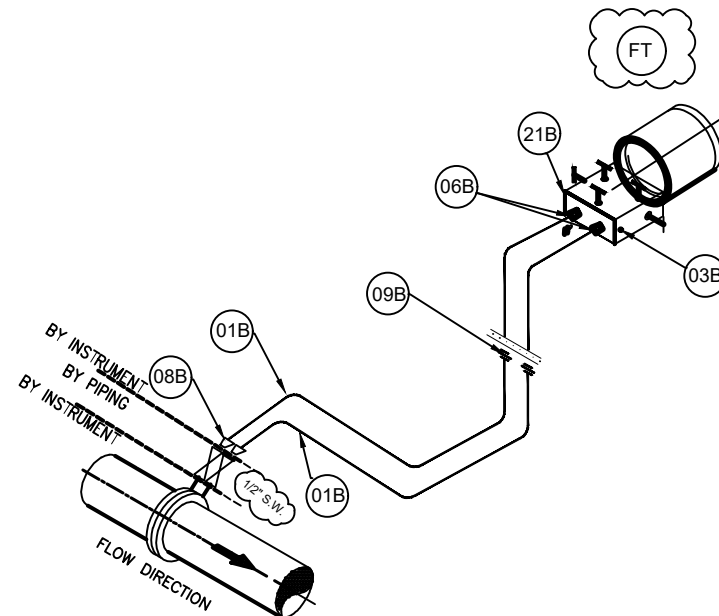

Tag Number	Quantity	REMARK
FT-2206A/B/C	3	FLUID: WATER

[illegible]

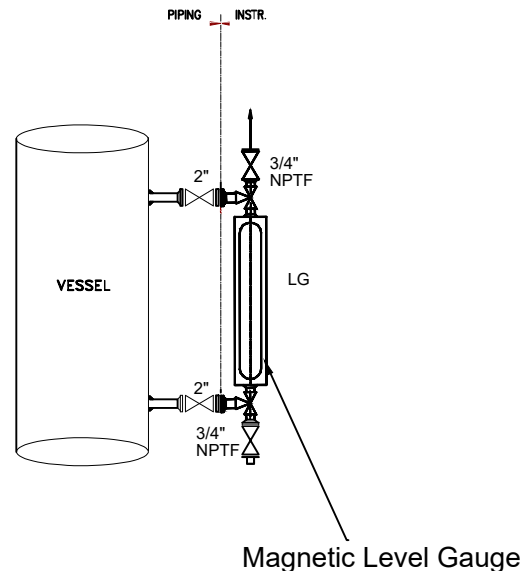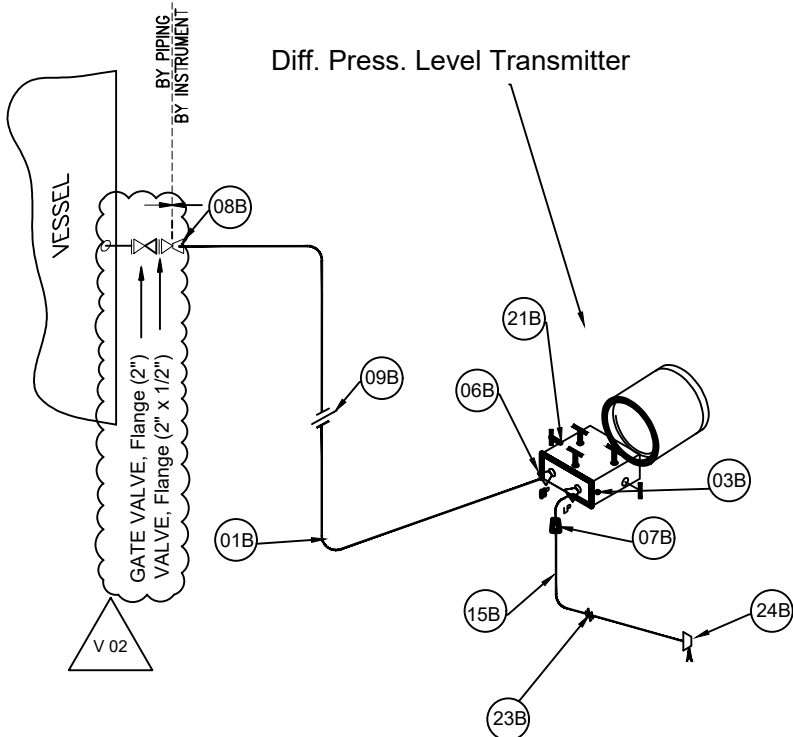

Tag Number	Quantity	REMARK
LT-2213A/B/C	3	FLUID: WATER
LT-2200A/B/C	3	FLUID: WATER

Tag Number	Quantity	REMARK
LG-2213A/B/C	3	FLUID: WATER


ITEM	QTY	SIZE OR CONNECTION	DESCRIPTION	Rating Class	MATERIAL	TOTAL QTY.	REMARK
21B	1	2x1/2"NPTF + 1/4"	MANIFOLD, 5 WAY 3 VALVE	#6000	AISI 316SS	6	-
08B	2	1/2" NPTFx 1/2" O.D	DOUBLE FERRULE COMPRESSION TYPE FEMALE CONNECTOR	#6000	AISI 316SS	12	-
01B	8m	1/2" O.D	TUBING, SEAMLESS, WALL THICKNESS 0.065"	#6000	AISI 316SS	48m	-
09B	2	1/2" O.D	STRAIGHT UNION COMPRESSION TYPE DOUBLE FERRULE	#6000	AISI 316SS	12	-
06B	2	1/2" NPTM x 1/2" O.D	DOUBLE FERRULE COMPRESSION TYPE MALE CONNECTOR	#6000	AISI 316SS	12	-
07B	1	1/4" NPTM x 1/4" O.D	DOUBLE FERRULE COMPRESSION TYPE MALE CONNECTOR	#6000	AISI 316SS	6	-
15B	3m	1/4" O.D	TUBING, SEAMLESS, WALL THICKNESS 0.049"	#6000	AISI 316SS	18m	-
23B	1	1/4" O.D	STRAIGHT UNION COMPRESSION TYPE DOUBLE FERRULE	#6000	AISI 316SS	6	-
24B	1	1/4" NPTFx 1/4" O.D	DOUBLE FERRULE COMPRESSION TYPE FEMALE CONNECTOR	#6000	AISI 316SS	6	-
03B	1	1/4"NPTM	HEX HEAD PLUG	#6000	AISI 316SS	6	-

REFERENCE DRAWINGS	DWG. NUMBER
P&ID DIAGRAM	BK-GCS-HY-120-PR-PA-0001-V04
INSTRUMENT DATASHEET/ CERTIFICATES	BK-GCS-HY-120-IN-DS-0001-V02

Note :

Legend :

REV.	DATE	DESCRIPTION	BY	CHECKED	DATE	BY	DATE
V02	OCT 2024		IFR	ISSUANCE	APR 2024	IFR	ISSUANCE
V01	MAY 2024		IFR	ISSUANCE	APR 2024	IFR	ISSUANCE
V00	APR 2024		IFR	ISSUANCE	APR 2024	IFR	ISSUANCE
REV.	DATE	P.O.I.	PREP.	CHK.	APP.	AUT.	
PROJECT NAME: HINAK OILFIELD DEVELOPMENT SURFACE WORK PACKAGES							
PROJECT NO.: HINAK OILFIELD DEVELOPMENT SURFACE WORK PACKAGES							
EPC CONTRACTOR:				EPC/EPD CONTRACTOR:			
HURGAN ENERGY - DESIGN & INFRACTION COMPANIES				PETROIRAN DEVELOPMENT COMPANY			
DATE SCALE DRAWING BY CHECKED BY PROJECT ENG.							
NO CONSTRUCTION PERMITTED UNLESS DRAWING APPROVED							
APPROVED FOR CONSTRUCTION BY: DATE:							
SCALE	SIZE	DRAWING NO.	SHEET NO.	REV.	BUDGET REF.	LOCATION	SIZE CLASS
N.T.S.C.	A3	BK-GCS-HY-120-IN-DW-0007	15 OF 18	V02			

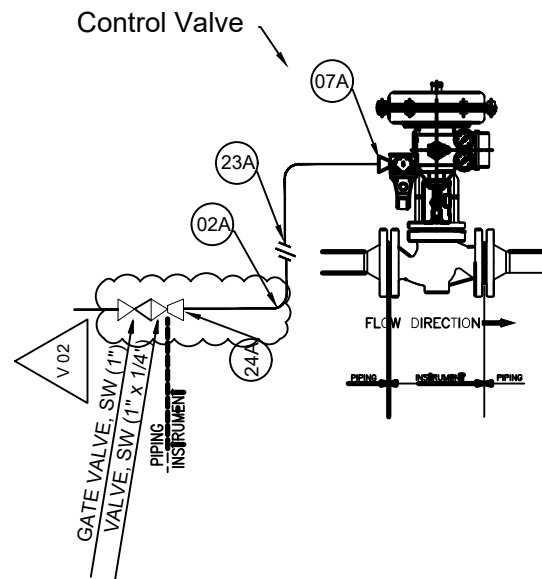


Tag Number	Quantity	REMARK
PCV-2123A/B/C	3	FLUID: SOUR GAS

ITEM	QTY	SIZE OR CONNECTION	DESCRIPTION	Rating Class	MATERIAL	TOTAL QTY.	REMARK
02A	5m	1/4" O.D	TUBING, SEAMLESS, WALL THICKNESS 0.065"	#6000	AISI 316SS	15m	NACE
07A	1	1/4" NPTMx 1/4" O.D	DOUBLE FERRULE COMPRESSION TYPE NUTLE CONNECTOR	#6000	AISI 316SS	3	NACE
23A	1	1/4" O.D	TUBING, SEAMLESS, WALL THICKNESS 0.065"	#6000	AISI 316SS	3	NACE
24A	1	1/4" NPTFx 1/4" O.D	STRAIGHT UNION COMPRESSION TYPE DOUBLE FERRULE	#6000	AISI 316SS	3	NACE



Tag Number	Quantity	REMARK
SG-2200A	3	FLUID: WATER
SG-2201A	3	FLUID: WATER
SG-2202A	3	FLUID: WATER
SG-2203A	3	FLUID: WATER

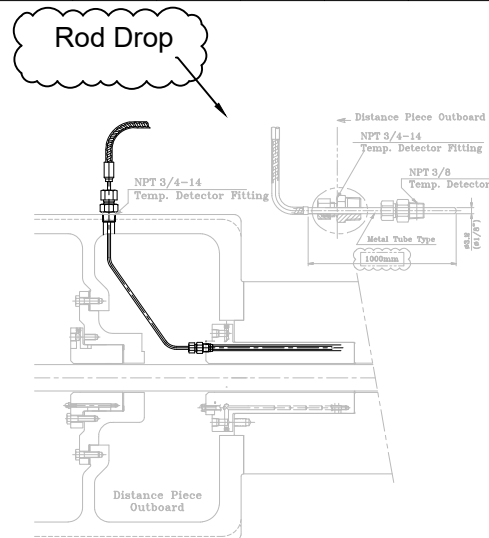

Tag Number	Quantity	REMARK
VE-2200A	3	-
VE-2201A	3	-
VE-2202A	3	-

Tag Number	Quantity	REMARK
C-ZE-2200A	3	-
C-ZE-2201A	3	-

[illegible]

ITEM	QTY	SIZE OR CONNECTION	DESCRIPTION	Rating Class	MATERIAL	TOTAL QTY.	REMARK
01A	4	1/2" O.D	TUBING, SEAMLESS, WALL THICKNESS 0.065"	#6000	AISI 316SS	146m	NACE MATERIAL
01B	4	1/2" O.D	TUBING, SEAMLESS, WALL THICKNESS 0.065"	#6000	AISI 316SS	264m	-
02A	5m	1/4" O.D	TUBING, SEAMLESS, WALL THICKNESS 0.065"	#6000	AISI 316SS	15m	NACE MATERIAL
02B	5m	1/4" O.D	TUBING, SEAMLESS, WALL THICKNESS 0.065"	#6000	AISI 316SS	75	-
03A	1	1/4"NPTM	HEX HEAD PLUG	#6000	AISI 316SS	6	NACE MATERIAL
03B	1	1/4"NPTM	HEX HEAD PLUG	#6000	AISI 316SS	6	-
06A	1	1/2" NPTM x 1/2" O.D	DOUBLE FERRULE COMPRESSION TYPE MALE CONNECTOR	#6000	AISI 316SS	8	NACE MATERIAL
06B	1	1/2" NPTM x 1/2" O.D	DOUBLE FERRULE COMPRESSION TYPE MALE CONNECTOR	#6000	AISI 316SS	84	-
07A	1	1/4" NPTMx 1/4" O.D	DOUBLE FERRULE COMPRESSION TYPE MALE CONNECTOR	#6000	AISI 316SS	3	NACE MATERIAL
07B	1	1/4" NPTM x 1/4" O.D	DOUBLE FERRULE COMPRESSION TYPE MALE CONNECTOR	#6000	AISI 316SS	21	-
08A	1	1/2" NPTFx 1/2" O.D	DOUBLE FERRULE COMPRESSION TYPE FEMALE CONNECTOR	#6000	AISI 316SS	36	NACE MATERIAL
08B	1	1/2" NPTFx 1/2" O.D	DOUBLE FERRULE COMPRESSION TYPE FEMALE CONNECTOR	#6000	AISI 316SS	66	-
09A	1	1/2" O.D	STRAIGHT UNION COMPRESSION TYPE DOUBLE FERRULE	#6000	AISI 316SS	39	NACE MATERIAL
09B	1	1/2" O.D	STRAIGHT UNION COMPRESSION TYPE DOUBLE FERRULE	#6000	AISI 316SS	84	-
13A	1	1/2"NPTF x1/2"NPTF	THERMOWELL - #300 - CON:1/2 NPT	#6000	AISI 316SS	33	NACE MATERIAL
13B	1	1/2"NPTF x1/2"NPTF	THERMOWELL - #300 - CON:1/2 NPT	#6000	AISI 316SS	60	-
19A	1	2x1/2"NPTF + 1/4"	MANIFOLD,3 WAY 2 VALVE	#6000	AISI 316SS	30	NACE MATERIAL
19B	1	2x1/2"NPTF + 1/4"	MANIFOLD,3 WAY 2 VALVE	#6000	AISI 316SS	60	-
20A	1	1/2"NPTM x 1/2"NPTF	OVER RANGE PROTECTION	#6000	AISI 316SS	6	NACE MATERIAL
21A	1	2x1/2"NPTF + 1/4"	MANIFOLD,5 WAY 3 VALVE	#6000	AISI 316SS	12	NACE MATERIAL
21B	1	2x1/2"NPTF + 1/4"	MANIFOLD,5 WAY 3 VALVE	#6000	AISI 316SS	24	-
23A	1	1/4" O.D	TUBING, SEAMLESS, WALL THICKNESS 0.065"	#6000	AISI 316SS	3	NACE MATERIAL
23B	1	1/4" O.D	STRAIGHT UNION COMPRESSION TYPE DOUBLE FERRULE	#6000	AISI 316SS	15	-
24A	1	1/4" NPTFx 1/4" O.D	STRAIGHT UNION COMPRESSION TYPE DOUBLE FERRULE	#6000	AISI 316SS	3	NACE MATERIAL
24B	1	1/4" NPTFx 1/4" O.D	DOUBLE FERRULE COMPRESSION TYPE FEMALE CONNECTOR	#6000	AISI 316SS	21	-
25	1	1/2" NPTM x 1/2" NPTM	COOLING ELEMENT	#6000	AISI 316SS	3	NACE MATERIAL
26	1	1/2"NPTF x 1/2"NPTM	SNUBER	#6000	AISI 316SS	6	-



REFERENCE DRAWINGS
P&ID DIAGRAM
INSTRUMENT DATASHEET/ CERTIFICATES

DWG. NUMBER
BK-GCS-HY-120-PR-PI-0001-V04
BK-GCS-HY-120-IN-DS-0001-V03

Note :

Legend :

REV.	DESCRIPTION	BY	DATE	BY	DATE	
V02	OCT 2024	IFR	FAHRIAN C. M. FARHANI	M. SADEGHIAN		
V01	MAY 2024	IFR	FAHRIAN C. M. FARHANI	M. SADEGHIAN		
V00	APR 2024	IFR	FAHRIAN C. M. FARHANI	A. M. MOHSEN		
REV.	DATE	P.O.I.	PREP.	CHK.	APP.	AUT.
PROJECT NAME: BINAQ OILFIELD DEVELOPMENT SURFACE WORK PACKAGES						
PROJECT NO.:						
EPC CONTRACTOR:			EPC/EPD CONTRACTOR:			
 BIRGAN ENERGY - DESIGN & INSPECTION COMPANIES			 PETROIRAN DEVELOPMENT COMPANY			
THE ORIGINAL AND ALL COPIES OF THIS DRAWING TOGETHER WITH THE COPYRIGHT THICKER AND THE SOLE PROPERTY OF N.I.S.O.C./ FIELDS						
DATE	SCALE	DRAWING BY	CHECKED BY	PROJECT ENG.		
NO CONSTRUCTION PERMITTED UNLESS DRAWING APPROVED						
APPROVED FOR CONSTRUCTION			BY:	DATE:		
SCALE	SIZE	DRAWING NO.	SHEET NO.	REV.	BUDGET	REV.
1:1	A3	BK-GCS-HY-120-IN-DW-0007	18 OF 18	V02		